



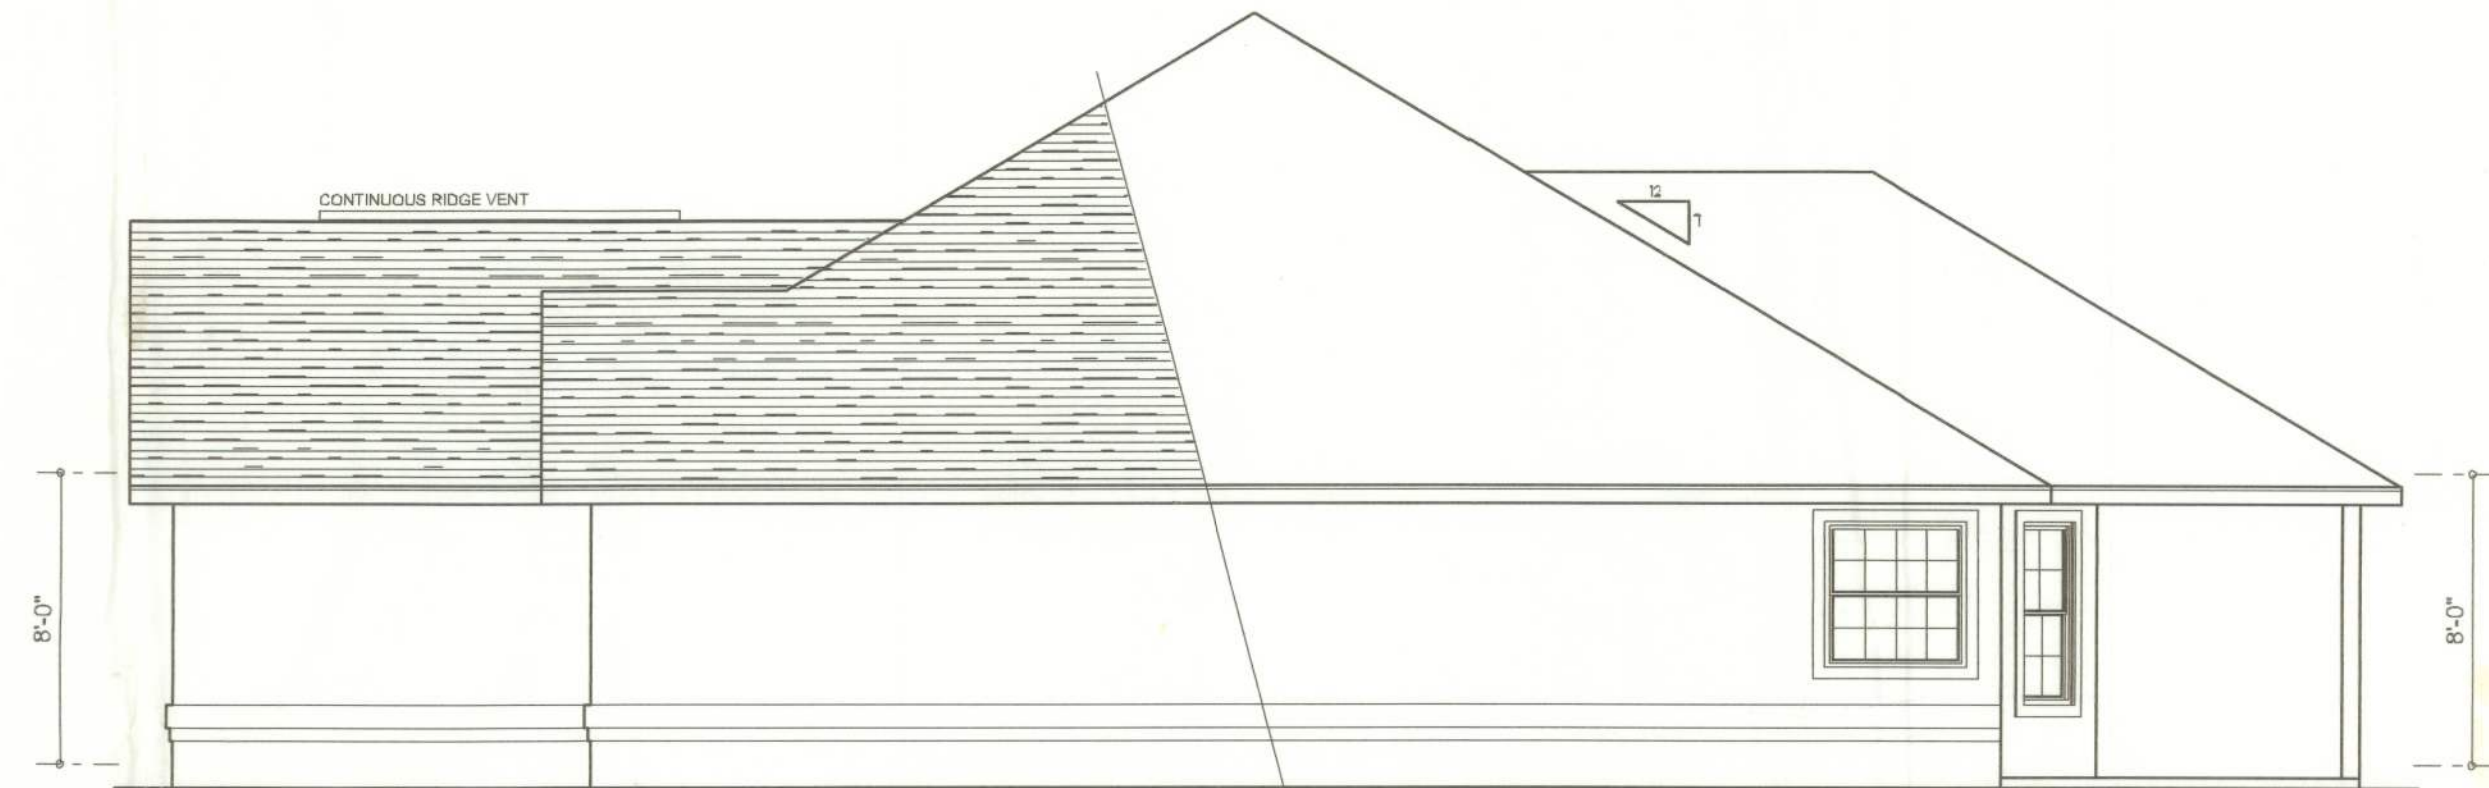

LEFT ELEVATION
SCALE: 3/16" = 1'-0"



RIGHT ELEVATION
SCALE: 3/16" = 1'-0"

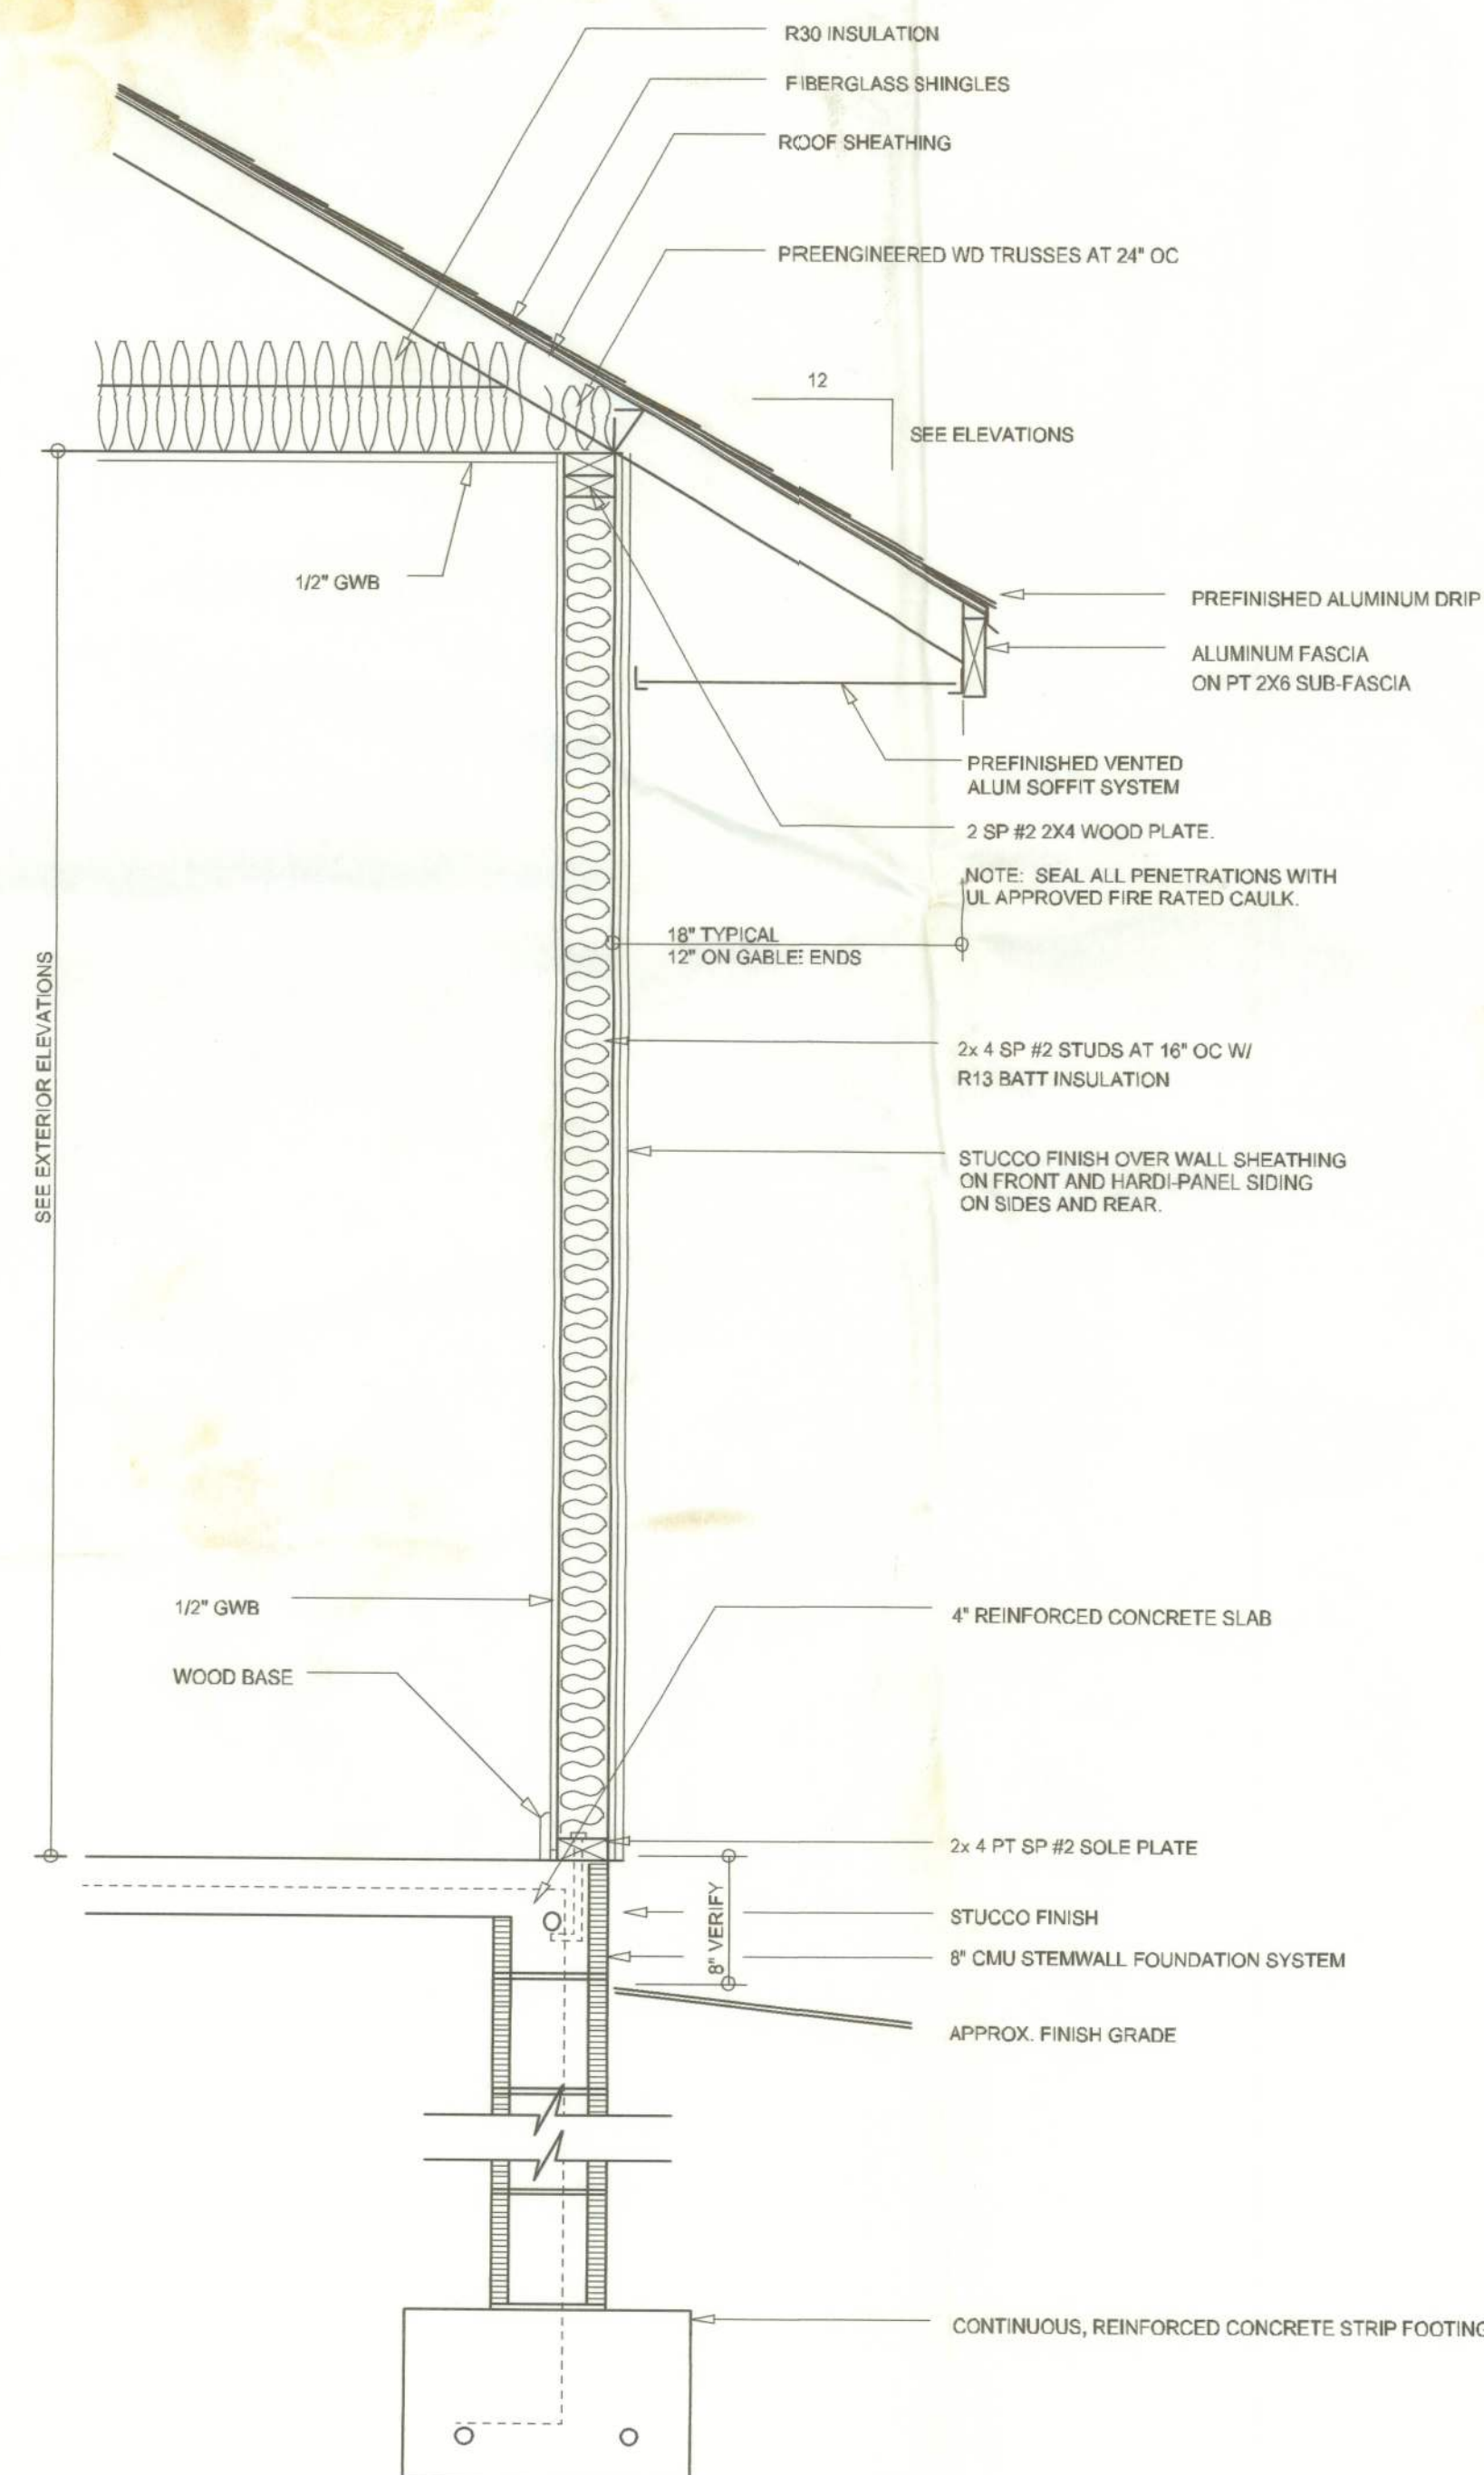

TYPICAL WALL SECTION
SCALE: 1" = 1'-0"



REAR ELEVATION
SCALE: 1/4" = 1'-0"



FRONT ELEVATION
SCALE: 1/4" = 1'-0"

Eugene Thomas
Robert Green at
Emerald Lakes
Lot 20
10/2005
23693

REVISIONS
August 18, 2005


SOFTPLAN
ARCHITECTURAL DESIGN SOFTWARE

EXTERIOR ELEVATIONS
SCALE: 1/4" = 1'-0"

TYPICAL WALL SECTION
SCALE: 1" = 1'-0"

A SPEC HOUSE FOR:
EUGENE THOMAS CONSTRUCTION
PROJECT ADDRESS: LOT 20, EMERALD LAKES, LAKE CITY, FLORIDA 32025

© WILLIAM MYERS
DESIGN
P.O. BOX 1513
LAKE CITY, FL 32056
(386) 758-8406
will@williamyers.net

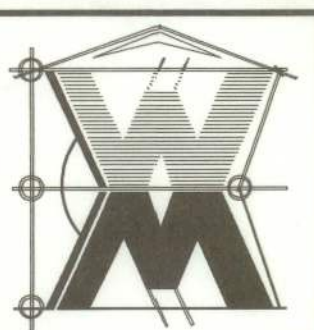


JOB NUMBER
050809

SHEET NUMBER
A.1
OF 4 SHEETS

W.M.C. Myers

OFFICE COPY

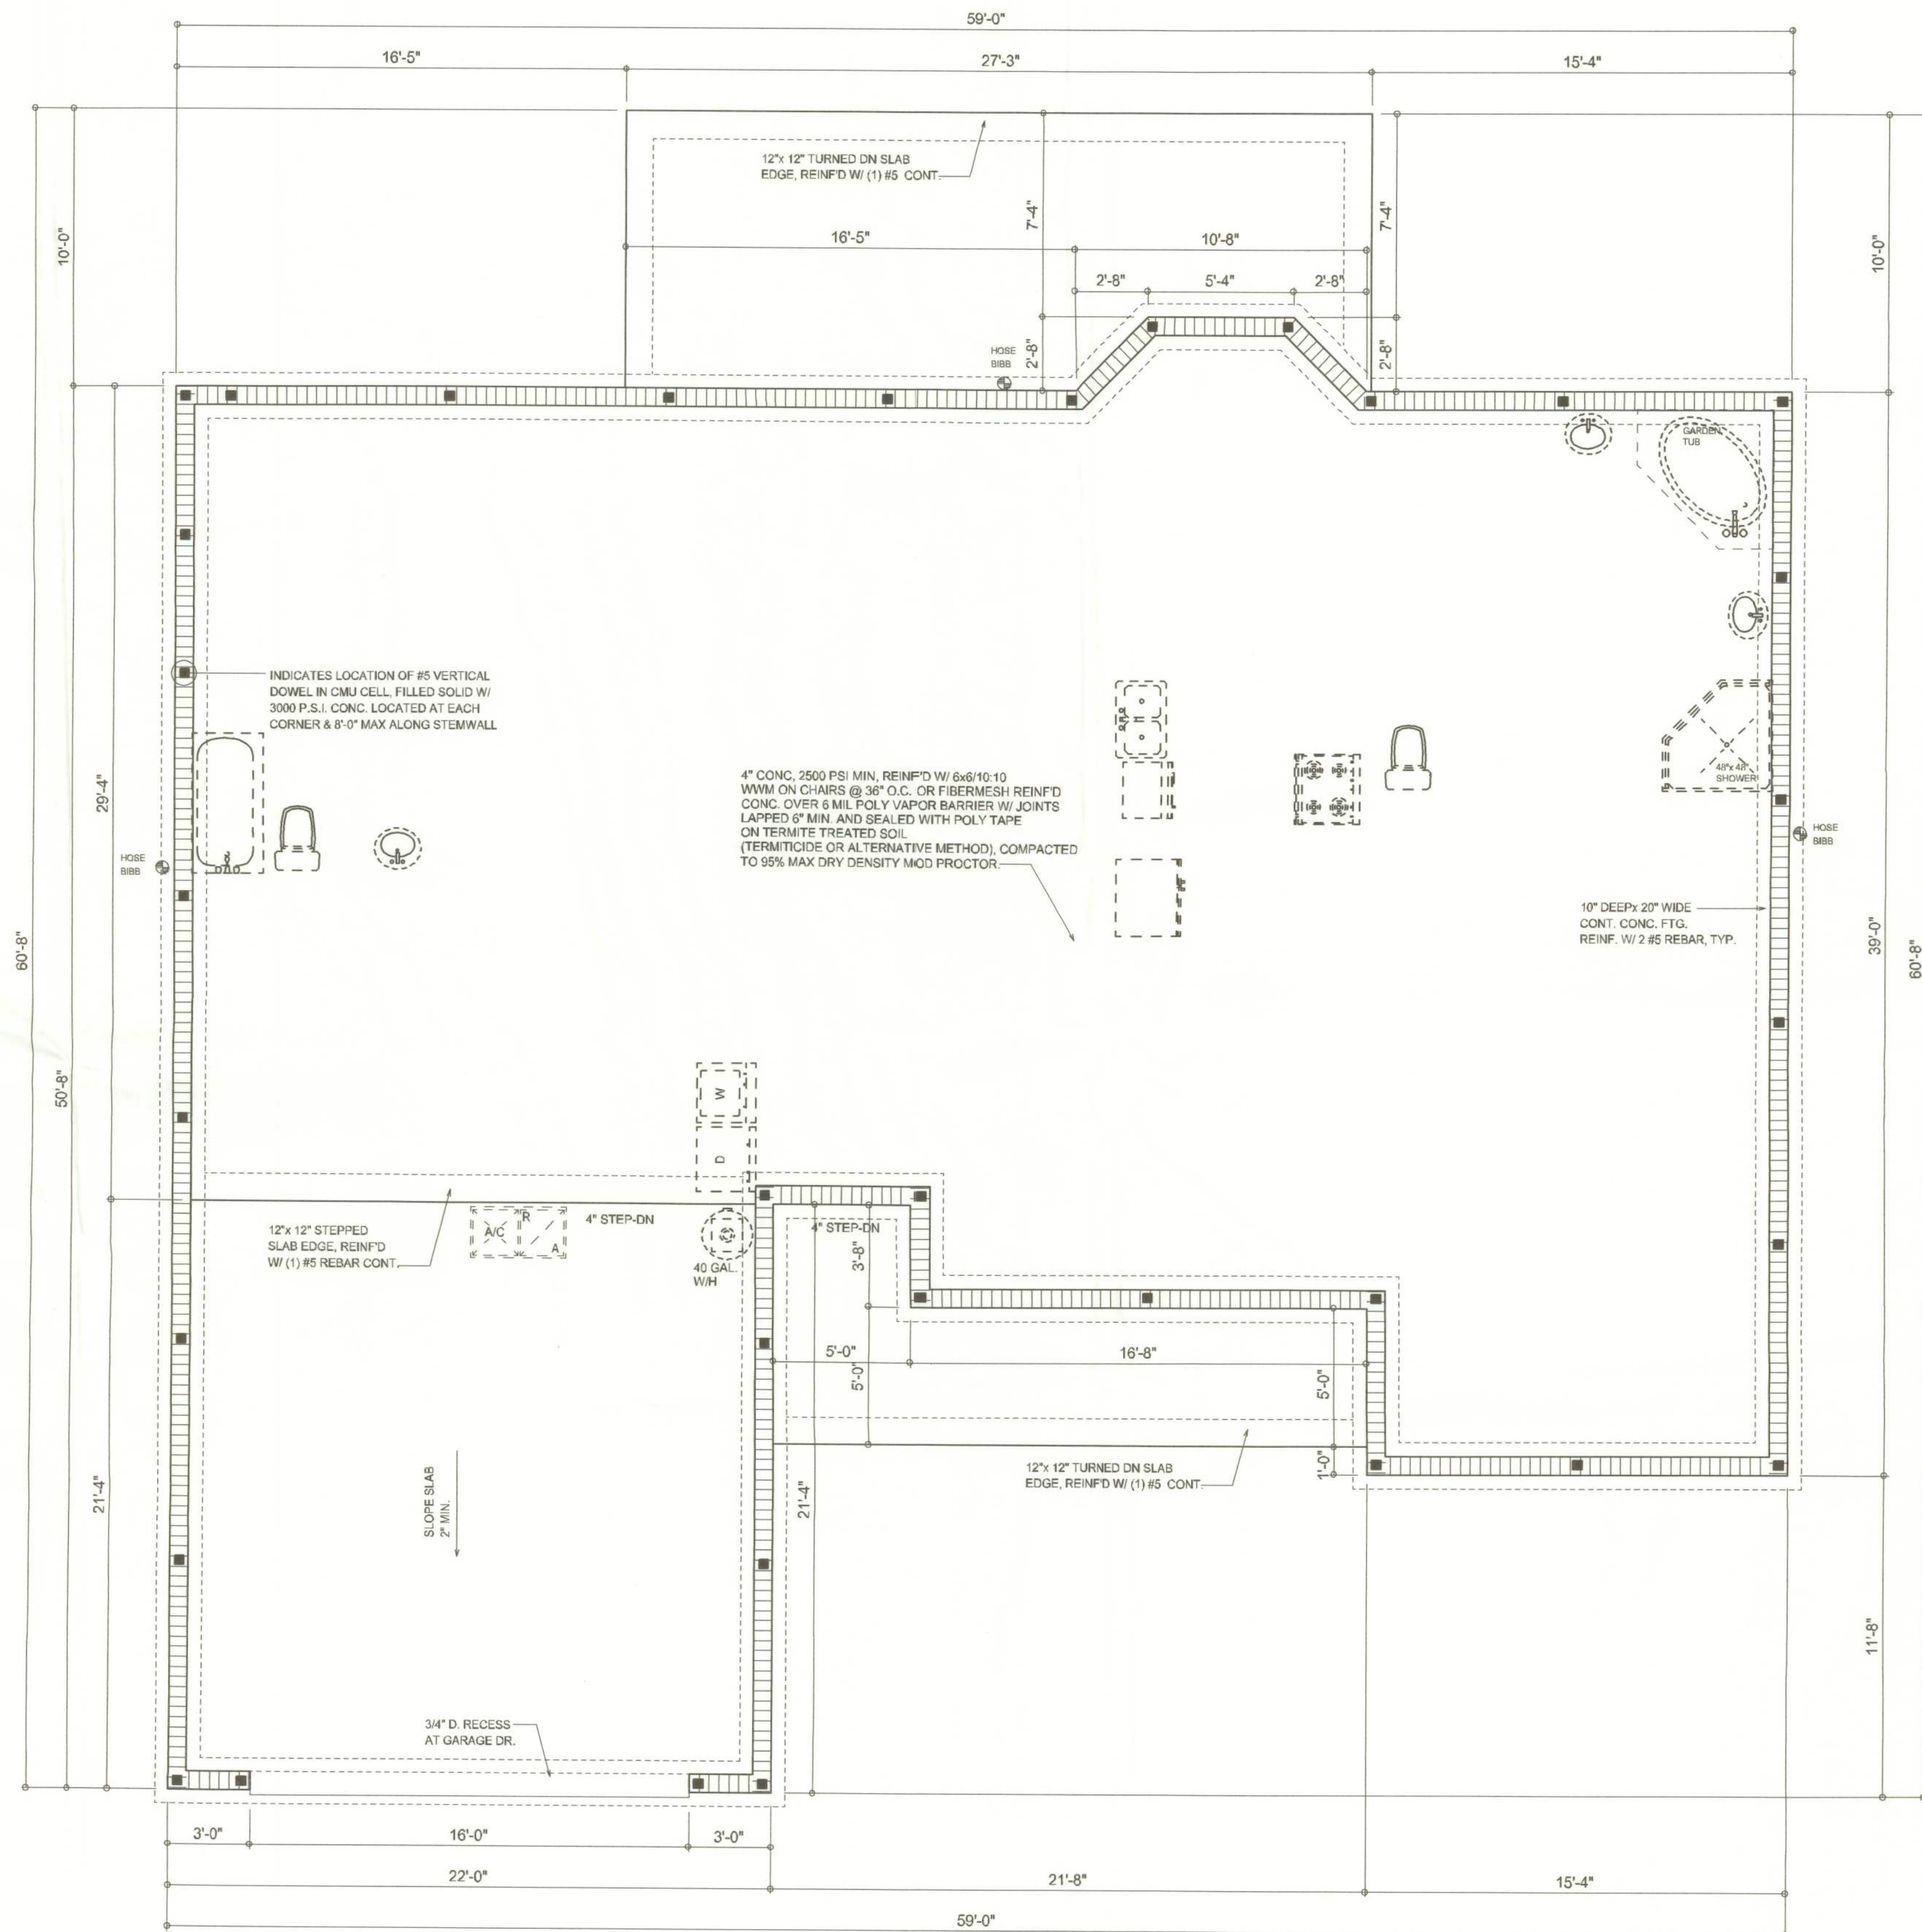

FOUNDATION PLAN
SCALE: 1/4" = 1'-0"


REVISIONS
August 18, 2005

SOFTPLAN
ARCHITECTURAL DESIGN SOFTWARE

FOUNDATION PLAN
SCALE: 1/4" = 1'-0"

A SPEC HOUSE FOR:
EUGENE THOMAS CONSTRUCTION
PROJECT ADDRESS: LO 20, EMERALD LAKES, LAKE CITY, FLORIDA 32025

© WILLIAM MYERS
DESIGN
P.O. BOX 1513
LAKE CITY, FL 32056
(386) 758-8406
will@willmyers.net

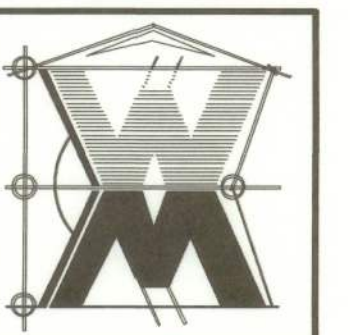


JOB NUMBER
050809

SHEET NUMBER

A.2
OF 4 SHEETS

W.M.C. My

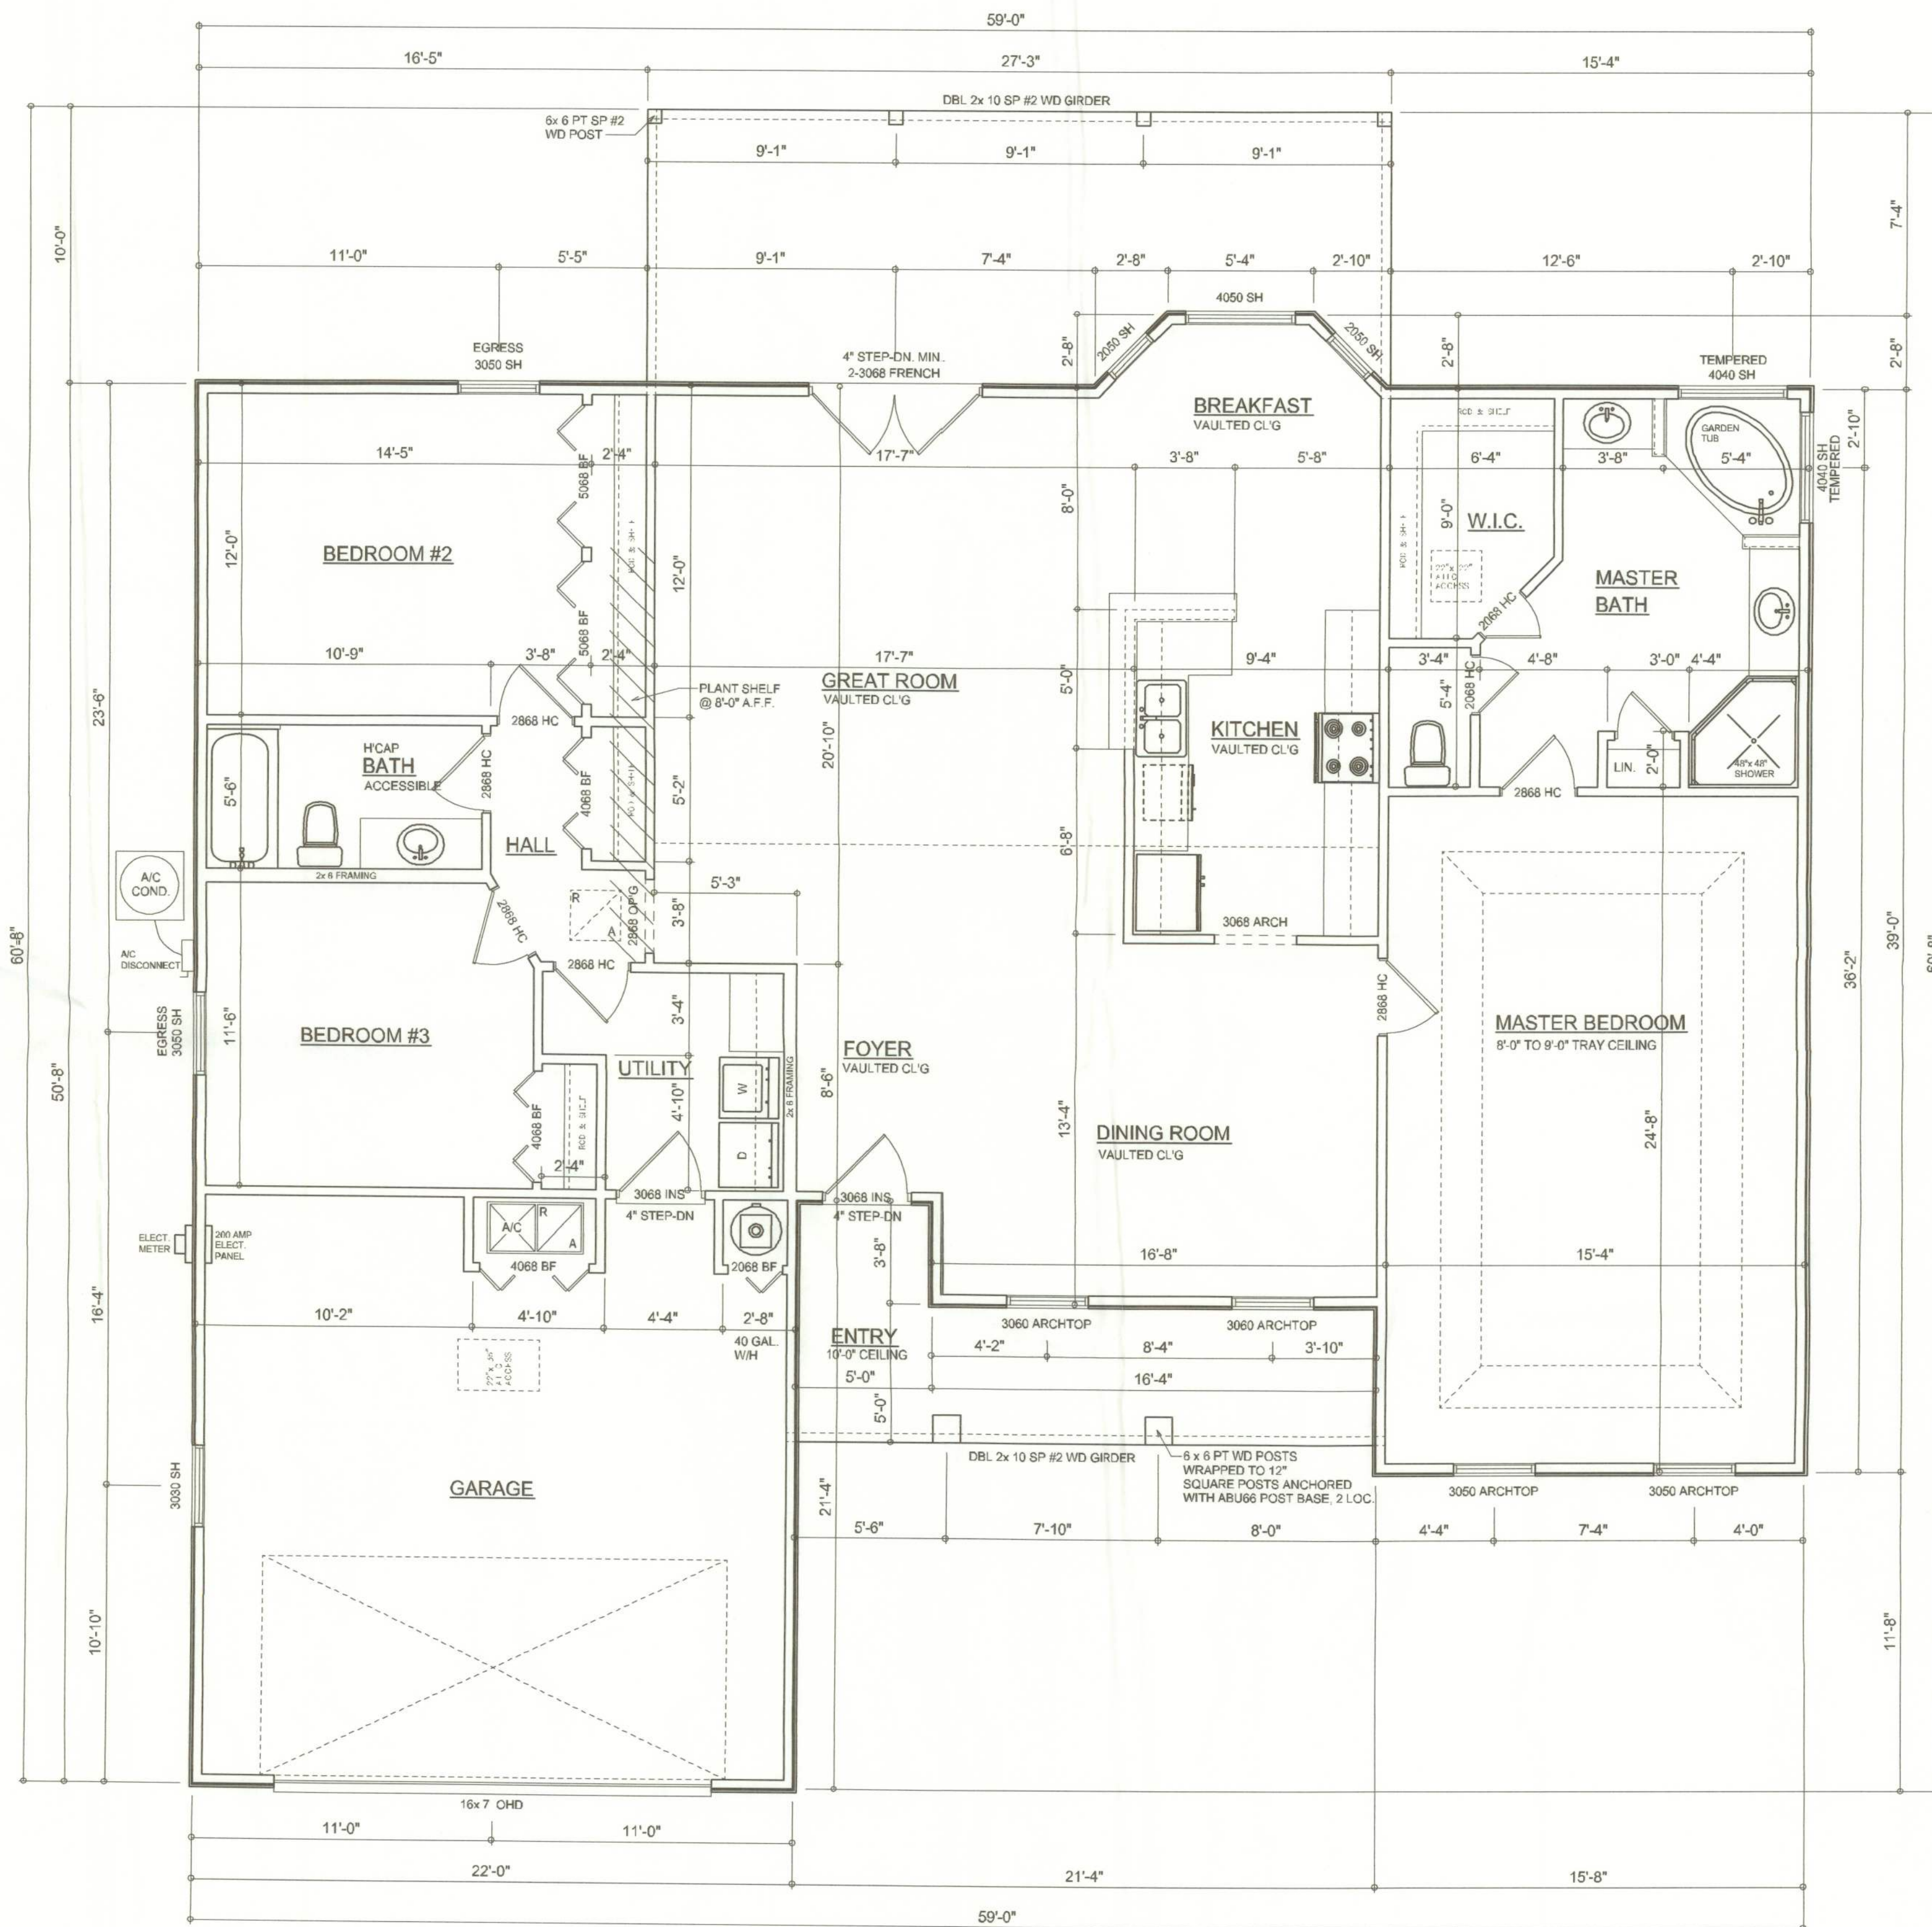

FLOOR PLAN

SCALE: 1/4" = 1'-0"

NOTE: ALL CEILING HEIGHTS SHALL BE 8'-0" UNLESS OTHERWISE NOTED

AREA SUMMARY

LIVING AREA	1966	S.F.
GARAGE AREA	477	S.F.
COVERED PORCH AREA	251	S.F.
ENTRY PORCH AREA	120	S.F.
TOTAL AREA	2814	S.F.


REVISIONS
August 18, 2005

SOFTPLAN
ARCHITECTURAL DESIGN SOFTWARE

FLOOR PLAN
SCALE: 1/4" = 1'-0"

A SPEC HOUSE FOR:
EUGENE THOMAS CONSTRUCTION
PROJECT ADDRESS: LO 20, EMERALD LAKES, LAKE CITY, FLORIDA 32025

© WILLIAM MYERS
DESIGN
P.O. BOX 1513
LAKE CITY, FL 32056
(386) 758-8406
will@willmyers.net

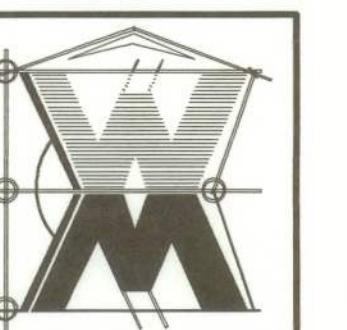


JOB NUMBER
050809

SHEET NUMBER


A.3
OF 4 SHEETS

William C. Myers

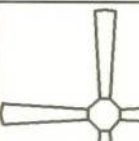ELECTRICAL LEGEND	
	CEILING FAN (PRE-WIRE FOR LIGHT KIT)
	DOUBLE SECURITY LIGHT
	RECESSED CAN LIGHT
	BATH EXHAUST FAN
	LIGHT FIXTURE
	DUPLEX OUTLET
	220v OUTLET
	GFI DUPLEX OUTLET
	SMOKE DETECTOR (see note below)
	WALL SWITCH
	3 WAY WALL SWITCH
	WATER PROOF GFI OUTLET
	2 OR 4 TUB FLUORESCENT FIXTURE

NOTE:
ALL BEDROOM RECEPTACLES SHALL BE AFCI
(ARC FAULT CIRCUIT INTERRUPT)

ALL SMOKE DETECTORS SHALL HAVE BATTERY BACKUP POWER
AND ALL WIRED TOGETHER SO IF ANY ONE UNIT IS ACTUATED THEY
ALL ACTIVATE.

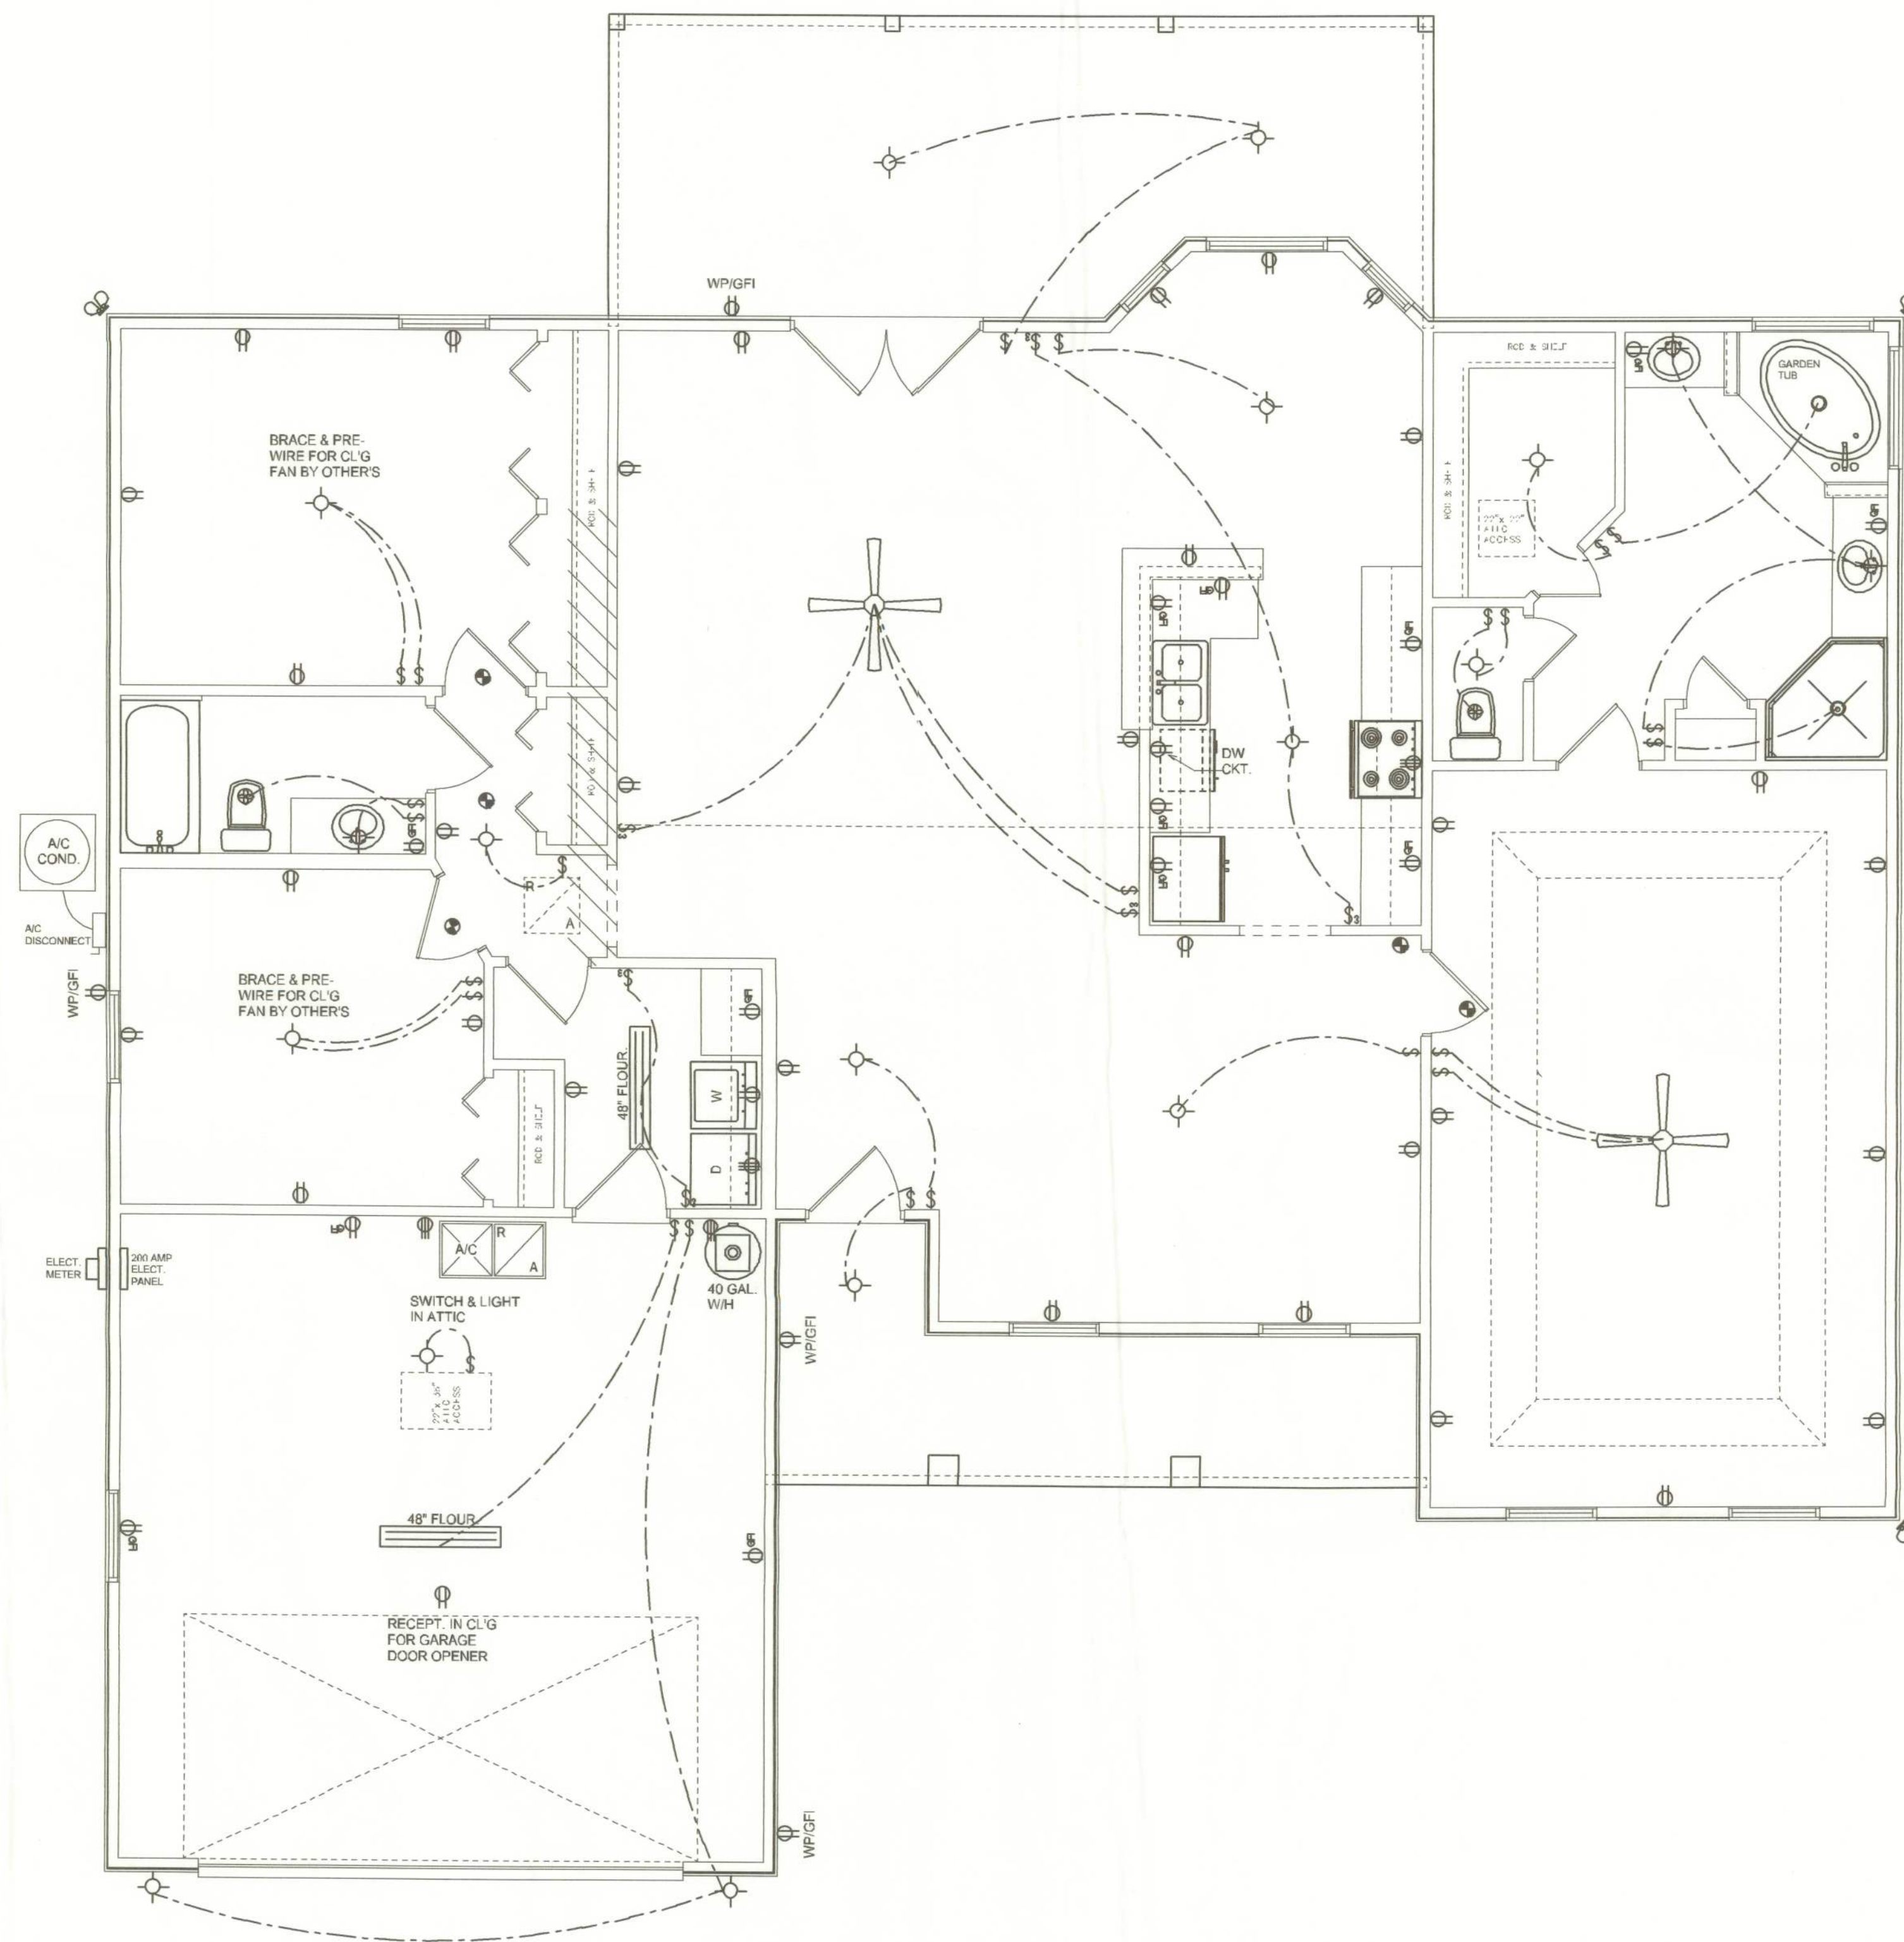

ELECTRICAL PLAN
SCALE: 1/4" = 1'-0"


REVISIONS	DATE	BY	APP
	August 18, 2005		

SOFTPLAN
ARCHITECTURAL DESIGN SOFTWARE

ELECTRICAL PLAN
SCALE: 1/4" = 1'-0"

A SPEC HOUSE FOR:
EUGENE THOMAS CONSTRUCTION
PROJECT ADDRESS: LO 20, EMERALD LAKES, LAKE CITY, FLORIDA 32025

© WILLIAM MYERS
DESIGN
P.O. BOX 1513
LAKE CITY, FL 32056
(386) 758-8406
will@willmyers.net


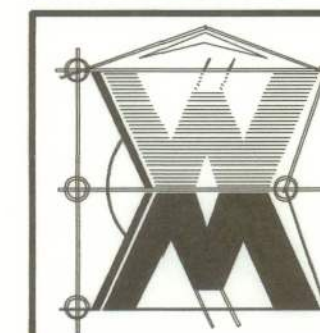


JOB NUMBER
050809

SHEET NUMBER

A.4
OF 4 SHEETS

Will C. Myers

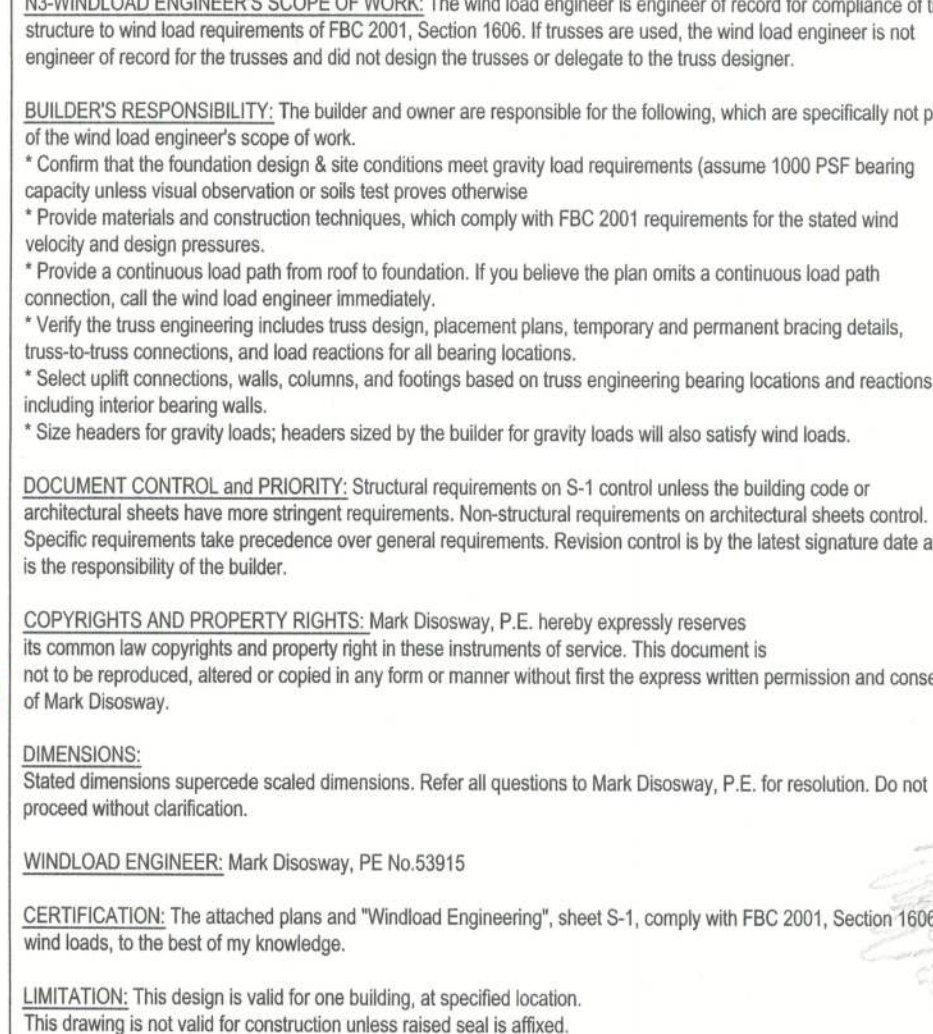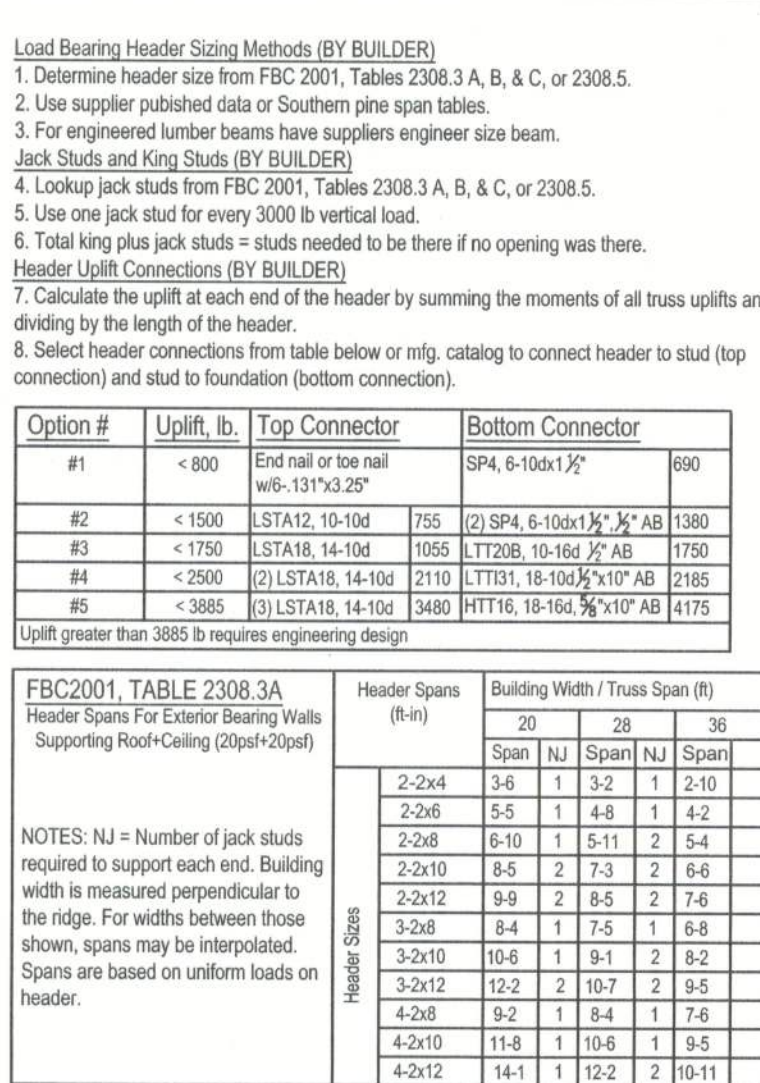

W12 - PORCH HEADER ANCHORS

