




REAR ELEVATION
SCALE: 1/4" = 1'-0"



FRONT ELEVATION
SCALE: 1/4" = 1'-0"

REVISIONS SCHEDULE			
Feb. 27th, 2020	PROPOSAL		
Mar. 19th, 2020	REVISIONS		
April 7th, 2020	REVISIONS		

BRENT & AMANDA HANDY RESIDENCE
LAKE CITY, FLORIDA

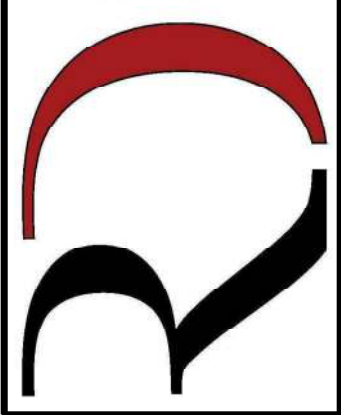

**RIDGEPOINT
DESIGN**
818 WEST DUVAL STREET, LAKE CITY, FLORIDA 32055
P: 386-288-1188
E: RIDGEPOINTDESIGN@GMAIL.COM

SHEET NUMBER
A.1
OF 4 SHEETS




RIGHT ELEVATION
SCALE: 1/4" = 1'-0"



LEFT ELEVATION
SCALE: 1/4" = 1'-0"

REVISIONS SCHEDULE			
Feb. 27th, 2020	PROPOSAL		
Mar. 19th, 2020	REVISIONS		
April 7th, 2020	REVISIONS		

BRENT & AMANDA HANDY RESIDENCE
LAKE CITY, FLORIDA

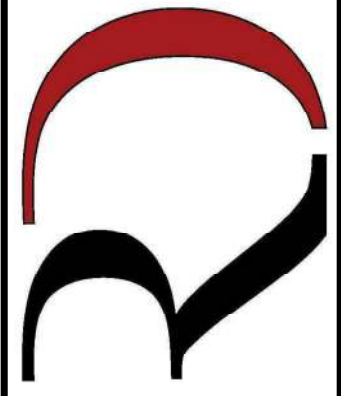

**RIDGEPOINT
DESIGN**
818 WEST DUVAL STREET, LAKE CITY, FLORIDA 32055
P: 386-288-1188
E: RIDGEPOINTDESIGN@GMAIL.COM

SHEET NUMBER
A.2
OF 4 SHEETS



SHEET NUMBER

A.3


OF 4 SHEETS

	Feb. 27th, 2020	PROPOSAL
	Mar. 19th, 2020	REVISIONS
	April 7th, 2020	REVISIONS

BRENT & AMANDA HANDY RESIDENCE


LAKE CITY, FLORIDA

**RIDGEPOINT
DESIGN**
818 WEST DUVAL STREET, LAKE CITY, FLORIDA 32055
P: 386-288-1138
E: RIDGEPOINTDESIGN@GMAIL.COM

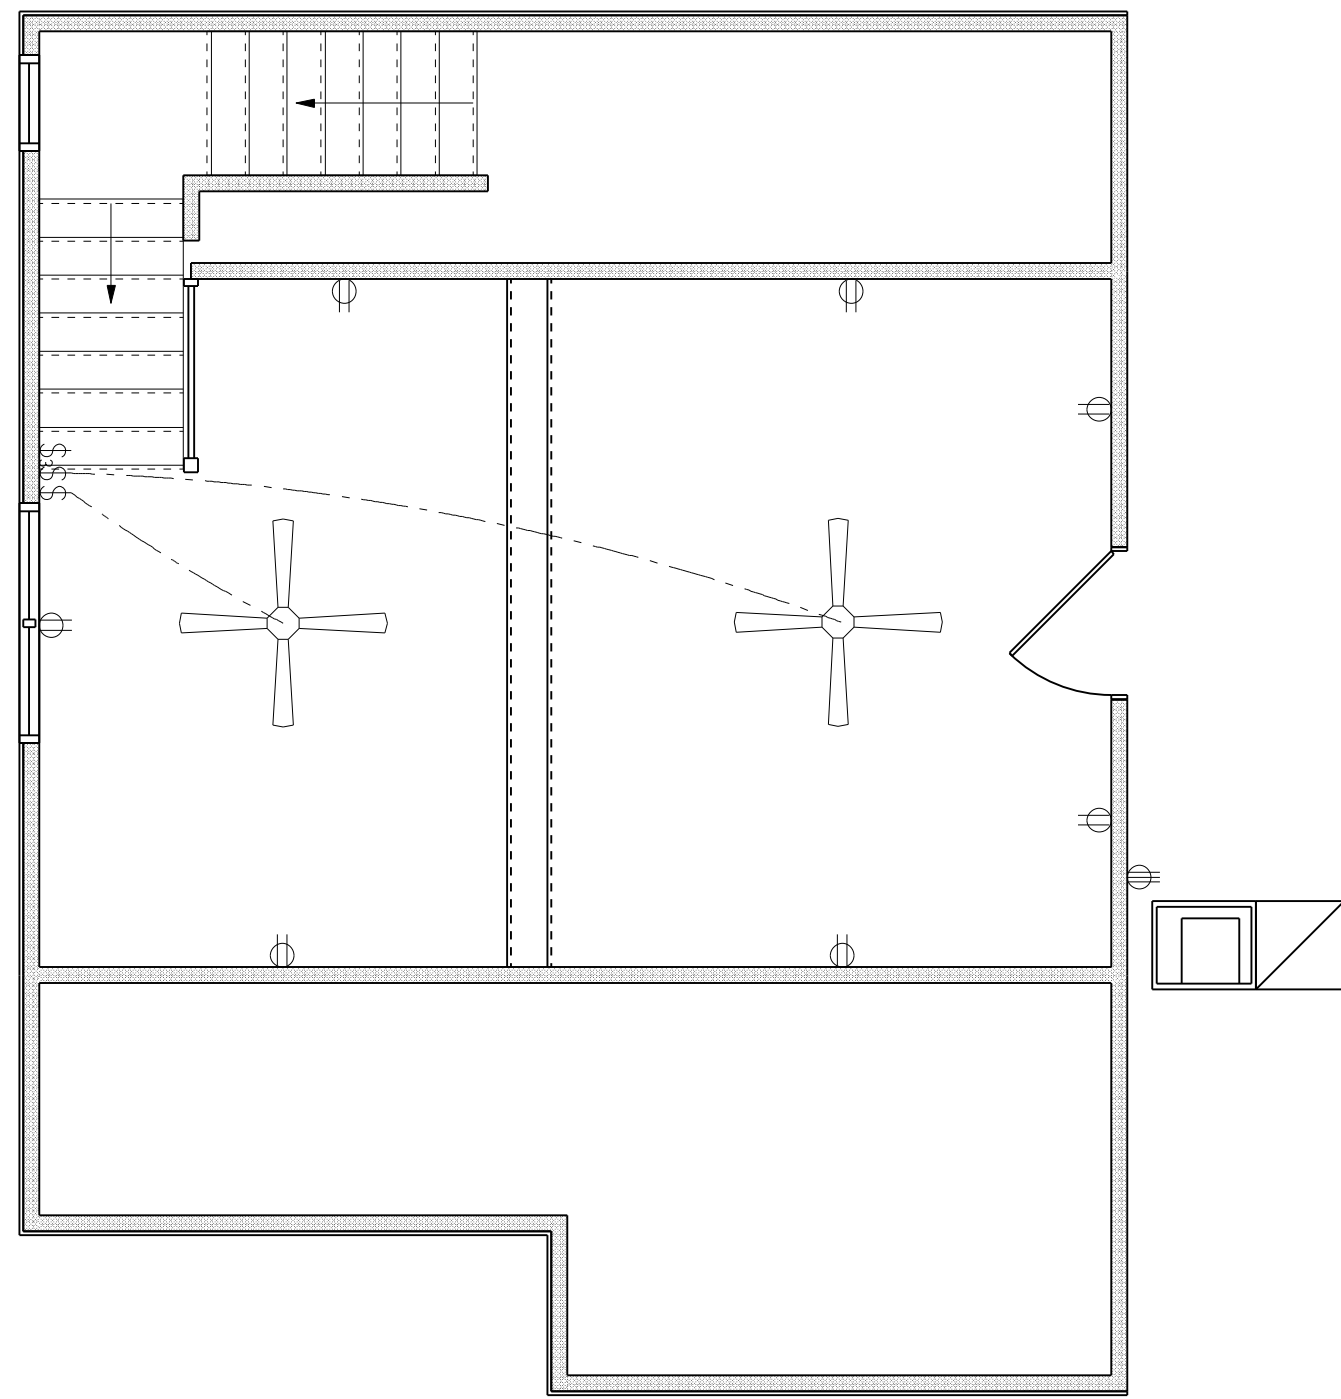

BONUS ROOM ELECTRIC
SCALE: 1/4" = 1'-0"

ELECTRICAL LEGEND		
ELECTRICAL	COUNT	SYMBOL
CEILING FAN	10	
CAN LIGHT 6inch	34	
CHANDELIER	1	
LED CEILING LIGHT 1x4	1	
PENDANT LIGHT	2	
EXTERIOR SCONCE	1	
MOTION SECURITY LIGHT	4	
ELECTRIC PANEL	2	
CABLE TV OUTLET	4	
EXHAUST FAN	4	
FLOOR OULET DUPLEX	2	
OUTLET	49	
OUTLET 220v	4	
OUTLET GFI	15	
OUTLET WP	6	
STANDARD LIGHT	9	
SWITCH	31	
SWITCH 3 WAY	24	
VANITY BAR LIGHT - SMALL	5	

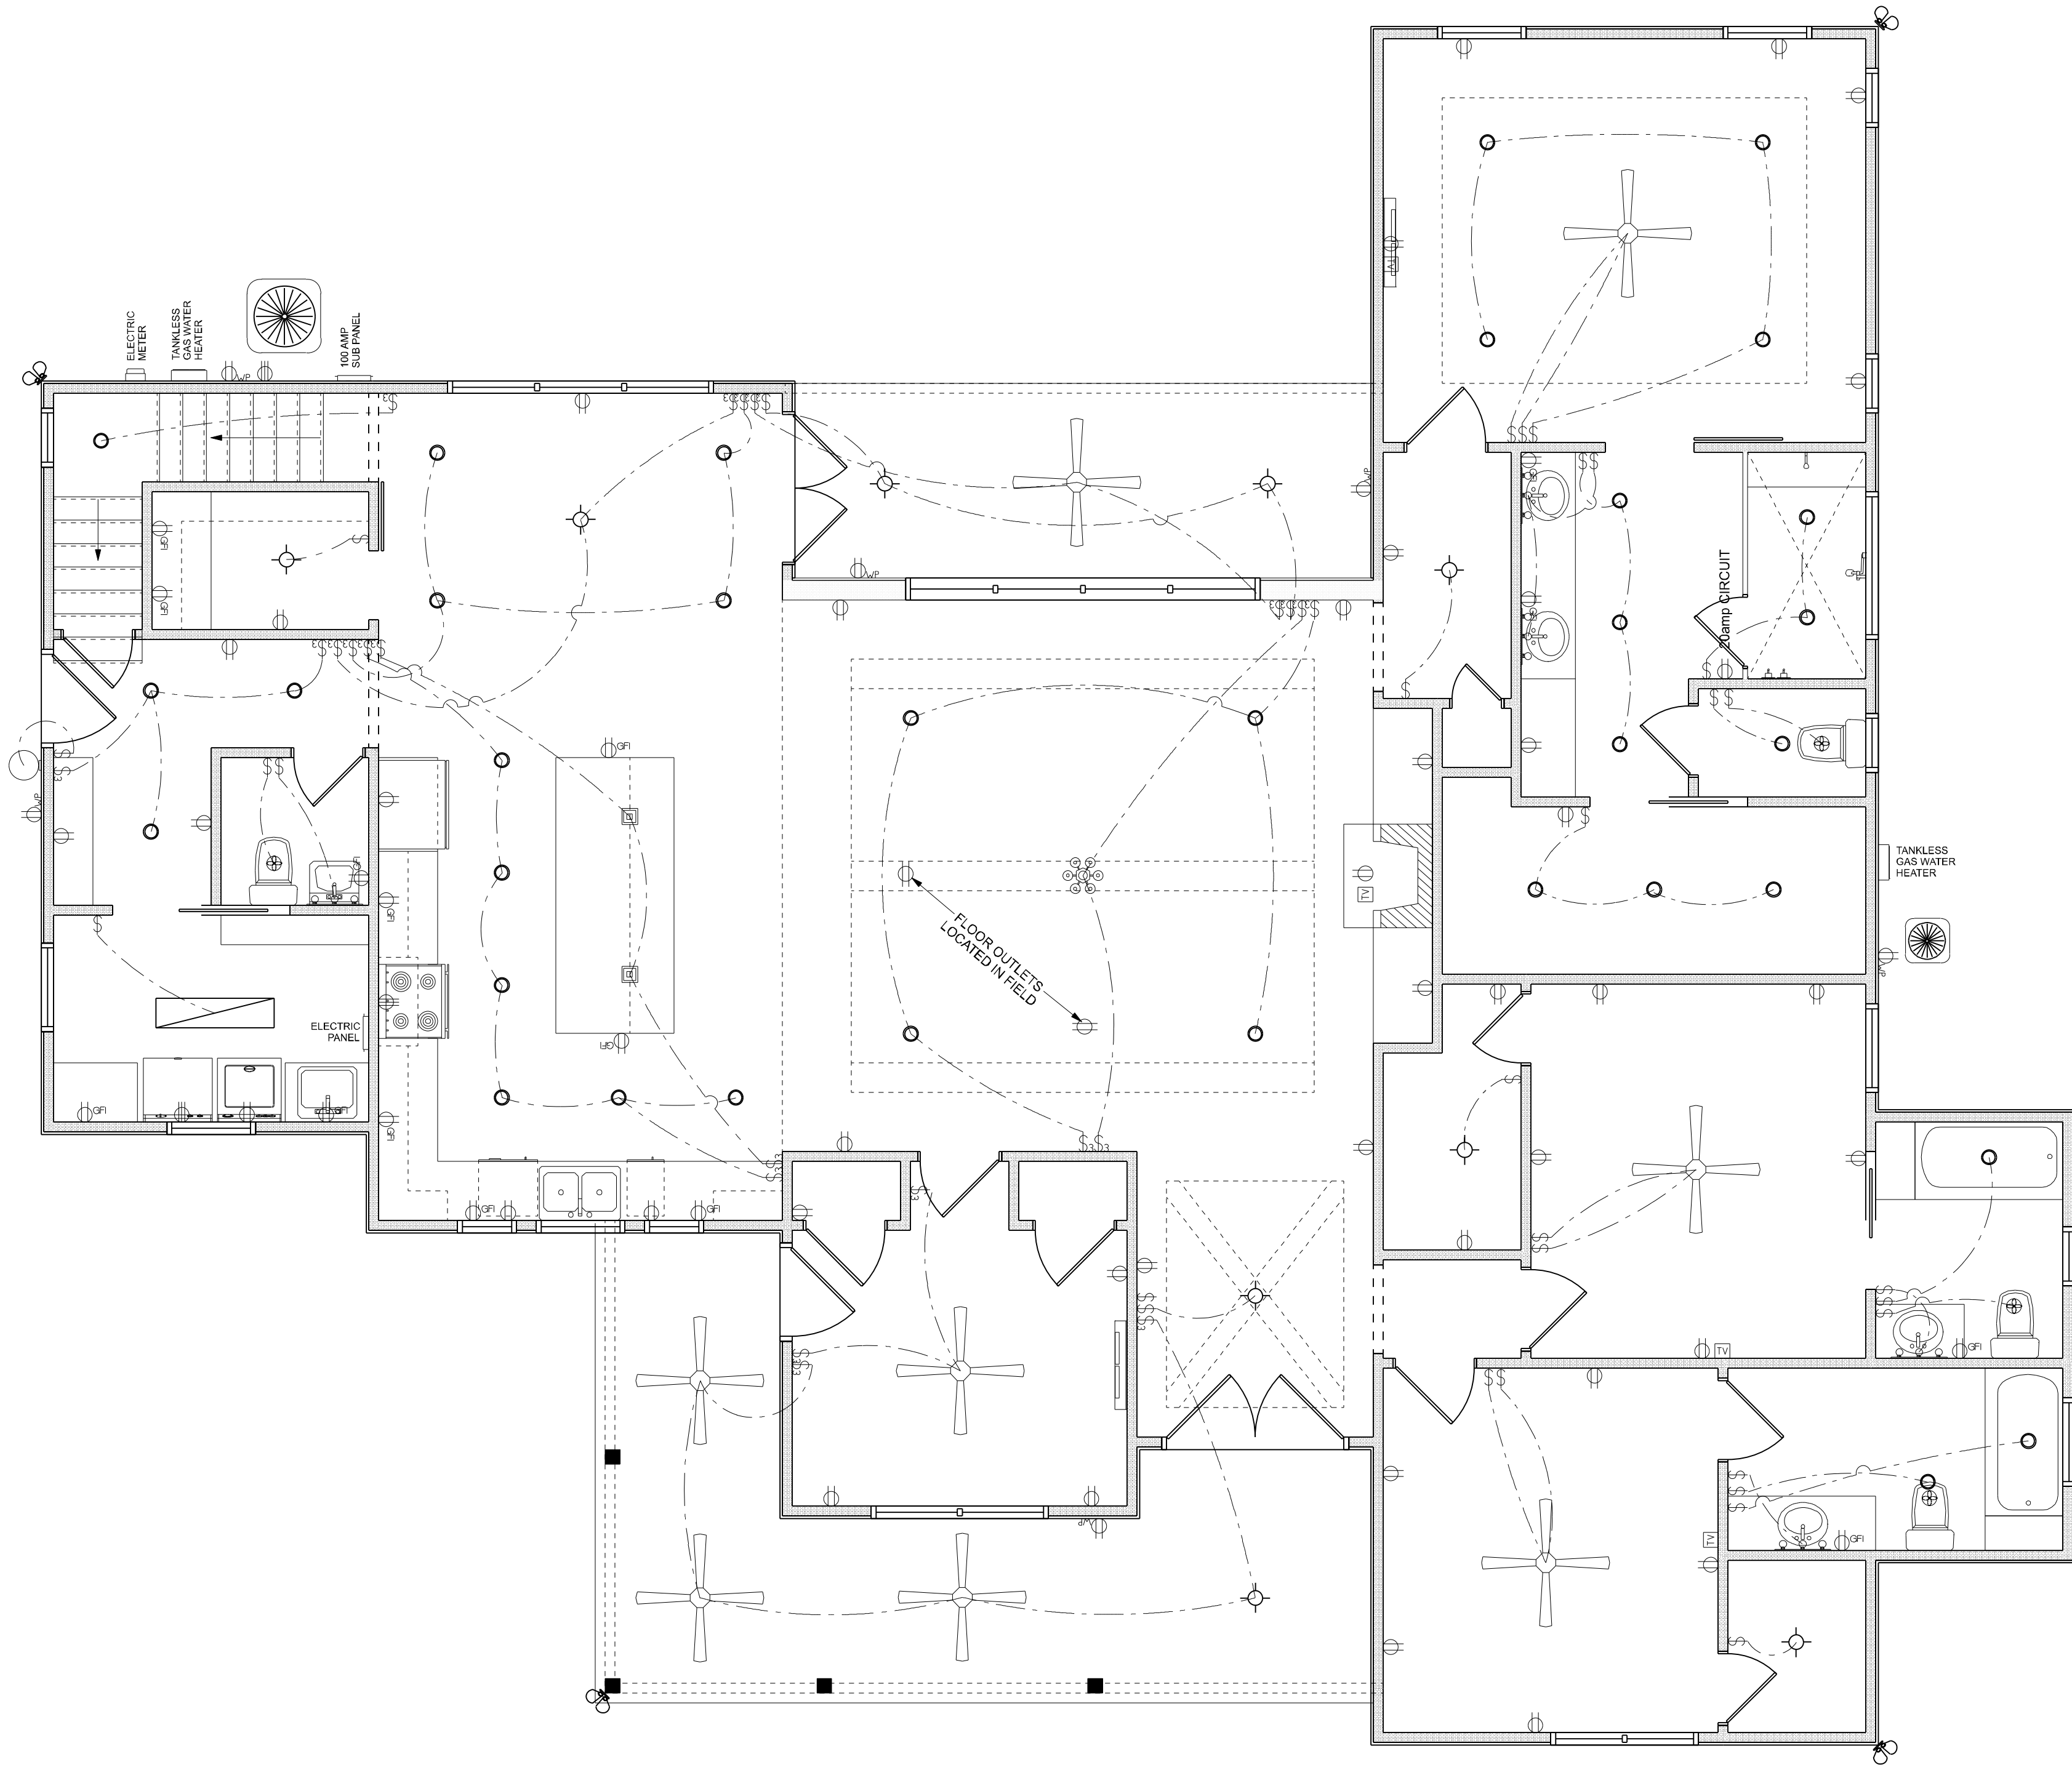

ELECTRICAL PLAN
SCALE: 1/4" = 1'-0"

REVISIONS SCHEDULE	
Feb. 27th, 2020	PROPOSAL
Mar. 19th, 2020	REVISIONS
April 7th, 2020	REVISIONS

BRENT & AMANDA HANDY RESIDENCE

LAKE CITY, FLORIDA

RIDGEPOINT

DESIGN

818 WEST DUVAL STREET, LAKE CITY, FLORIDA 32055
P: 386-288-1188
E: RIDGEPOINTDESIGN@GMAIL.COM

SHEET NUMBER

A.4

OF 4 SHEETS