


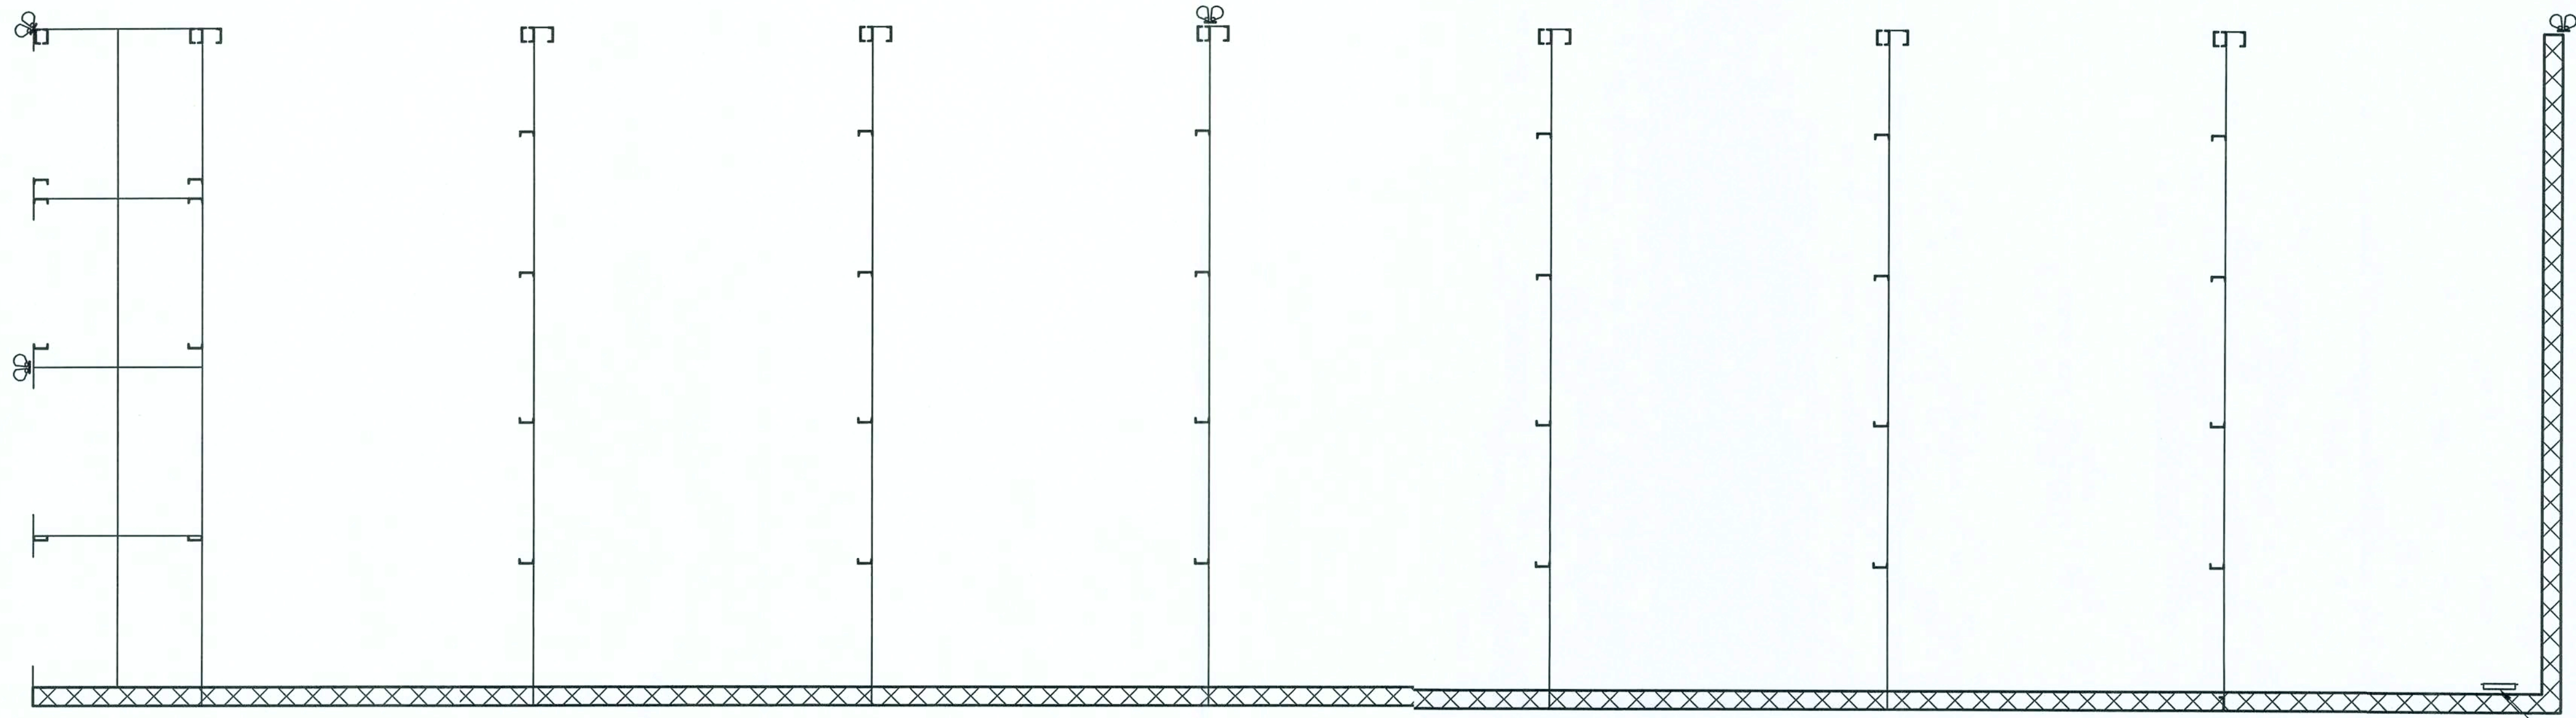

ELECTRICAL LEGEND		
SYMBOL	QUANTITY	DESCRIPTION
	4	EXTERIOR SECURITY LIGHT

ELECTRICAL PLAN
SCALE: 1/4" = 1'-0"

P.O. Box 187
130 West Howard Street
Live Oak FL 32064
Phone: (386) 362-3678
Fax: (386) 362-6133
GARY GILL, P.E.
AUTH. # 9461

COMMUNITY SELF STORAGE
OF COLUMBIA COUNTY
NEW BUILDINGS
COLUMBIA COUNTY, FLORIDA


BLDG. 001-06 ELECTRICAL

PROJECT NUMBER
PF05-338
DRAWN BY
D. PRICE
CHECKED BY
G.G.

E-1

REV #	DATE	REVISION NOTES
-	08-28-06	ISSUED FOR CONSTRUCTION

7/27/06

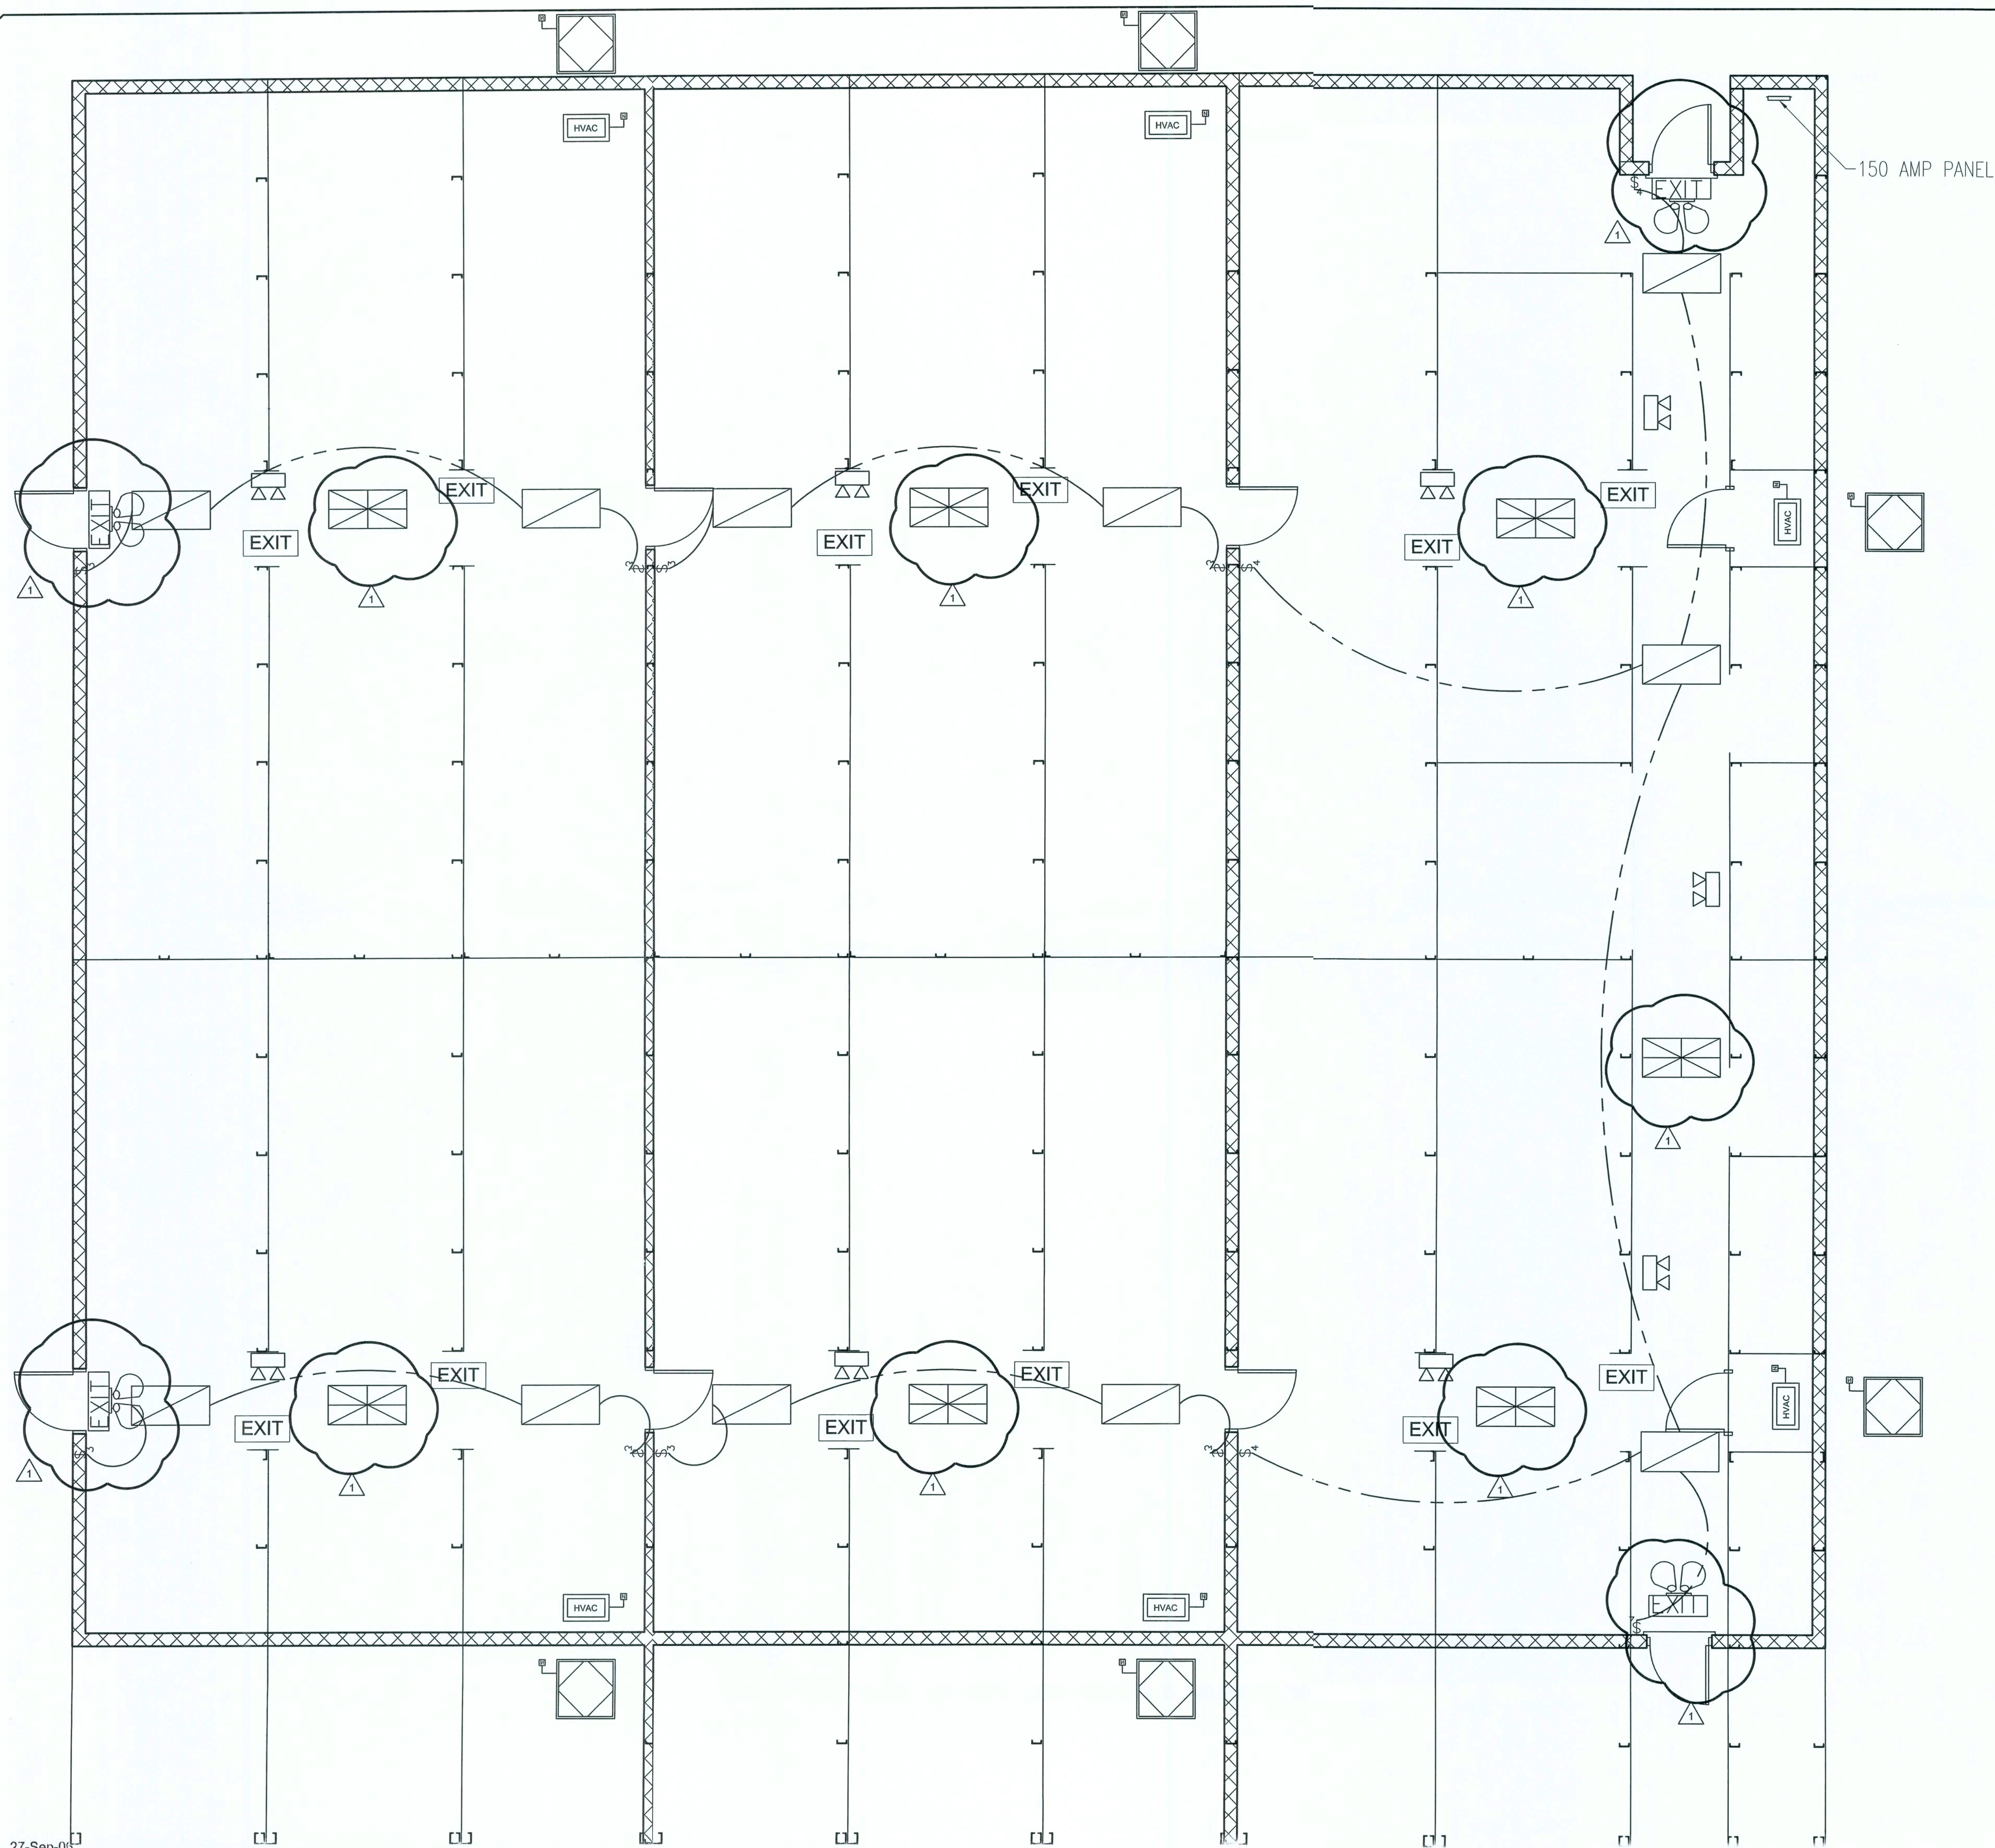

ELECTRICAL LEGEND		
SYMBOL	QUANTITY	DESCRIPTION
§	8	3 WAY LIGHT SWITCH
§	4	4 WAY LIGHT SWITCH
□	11	24" x 48" FLOURESCENT LIGHT
EXIT	12	EXIT SIGN
EXIT	4	EXIT SIGN WITH LIGHTS
□	7	HARD-WIRED LIGHT
□	9	BATTERY-POWERED EMERGENCY LIGHT

NOTES:
1.) ALL HARD-WIRED LIGHTS TO HAVE SWITCH AT PANEL.
2.) ALL DOORS LOCATED ON FIREWALLS TO HAVE A MIN. 1 1/2 HOUR FIRE RATING.

REVISION NOTES	
REV #	DATE
1	08-28-06
1	09-27-06

ISSUED FOR CONSTRUCTION
ADDED HARD-WIRED LIGHTS
FIRE DOOR NOTE, EXIT SIGN
WITH LIGHTS &
BATTERY-POWERED LIGHTS

P.O. Box 187
130 West Howard Street
Live Oak FL 32064
Phone: (386) 362-3678
Fax: (386) 362-6133
GARY GILL, PE 51012
Auth. # 9461

COMMUNITY SELF STORAGE
OF COLUMBIA COUNTY
NEW BUILDINGS
COLUMBIA COUNTY, FLORIDA


BLDG. 002-06 ELECTRICAL

PROJECT NUMBER
PF05-338
DRAWN BY
D. PRICE
CHECKED BY
G.G.

E-2

ELECTRICAL PLAN
SCALE: 1/8" = 1'-0"

9/27/06

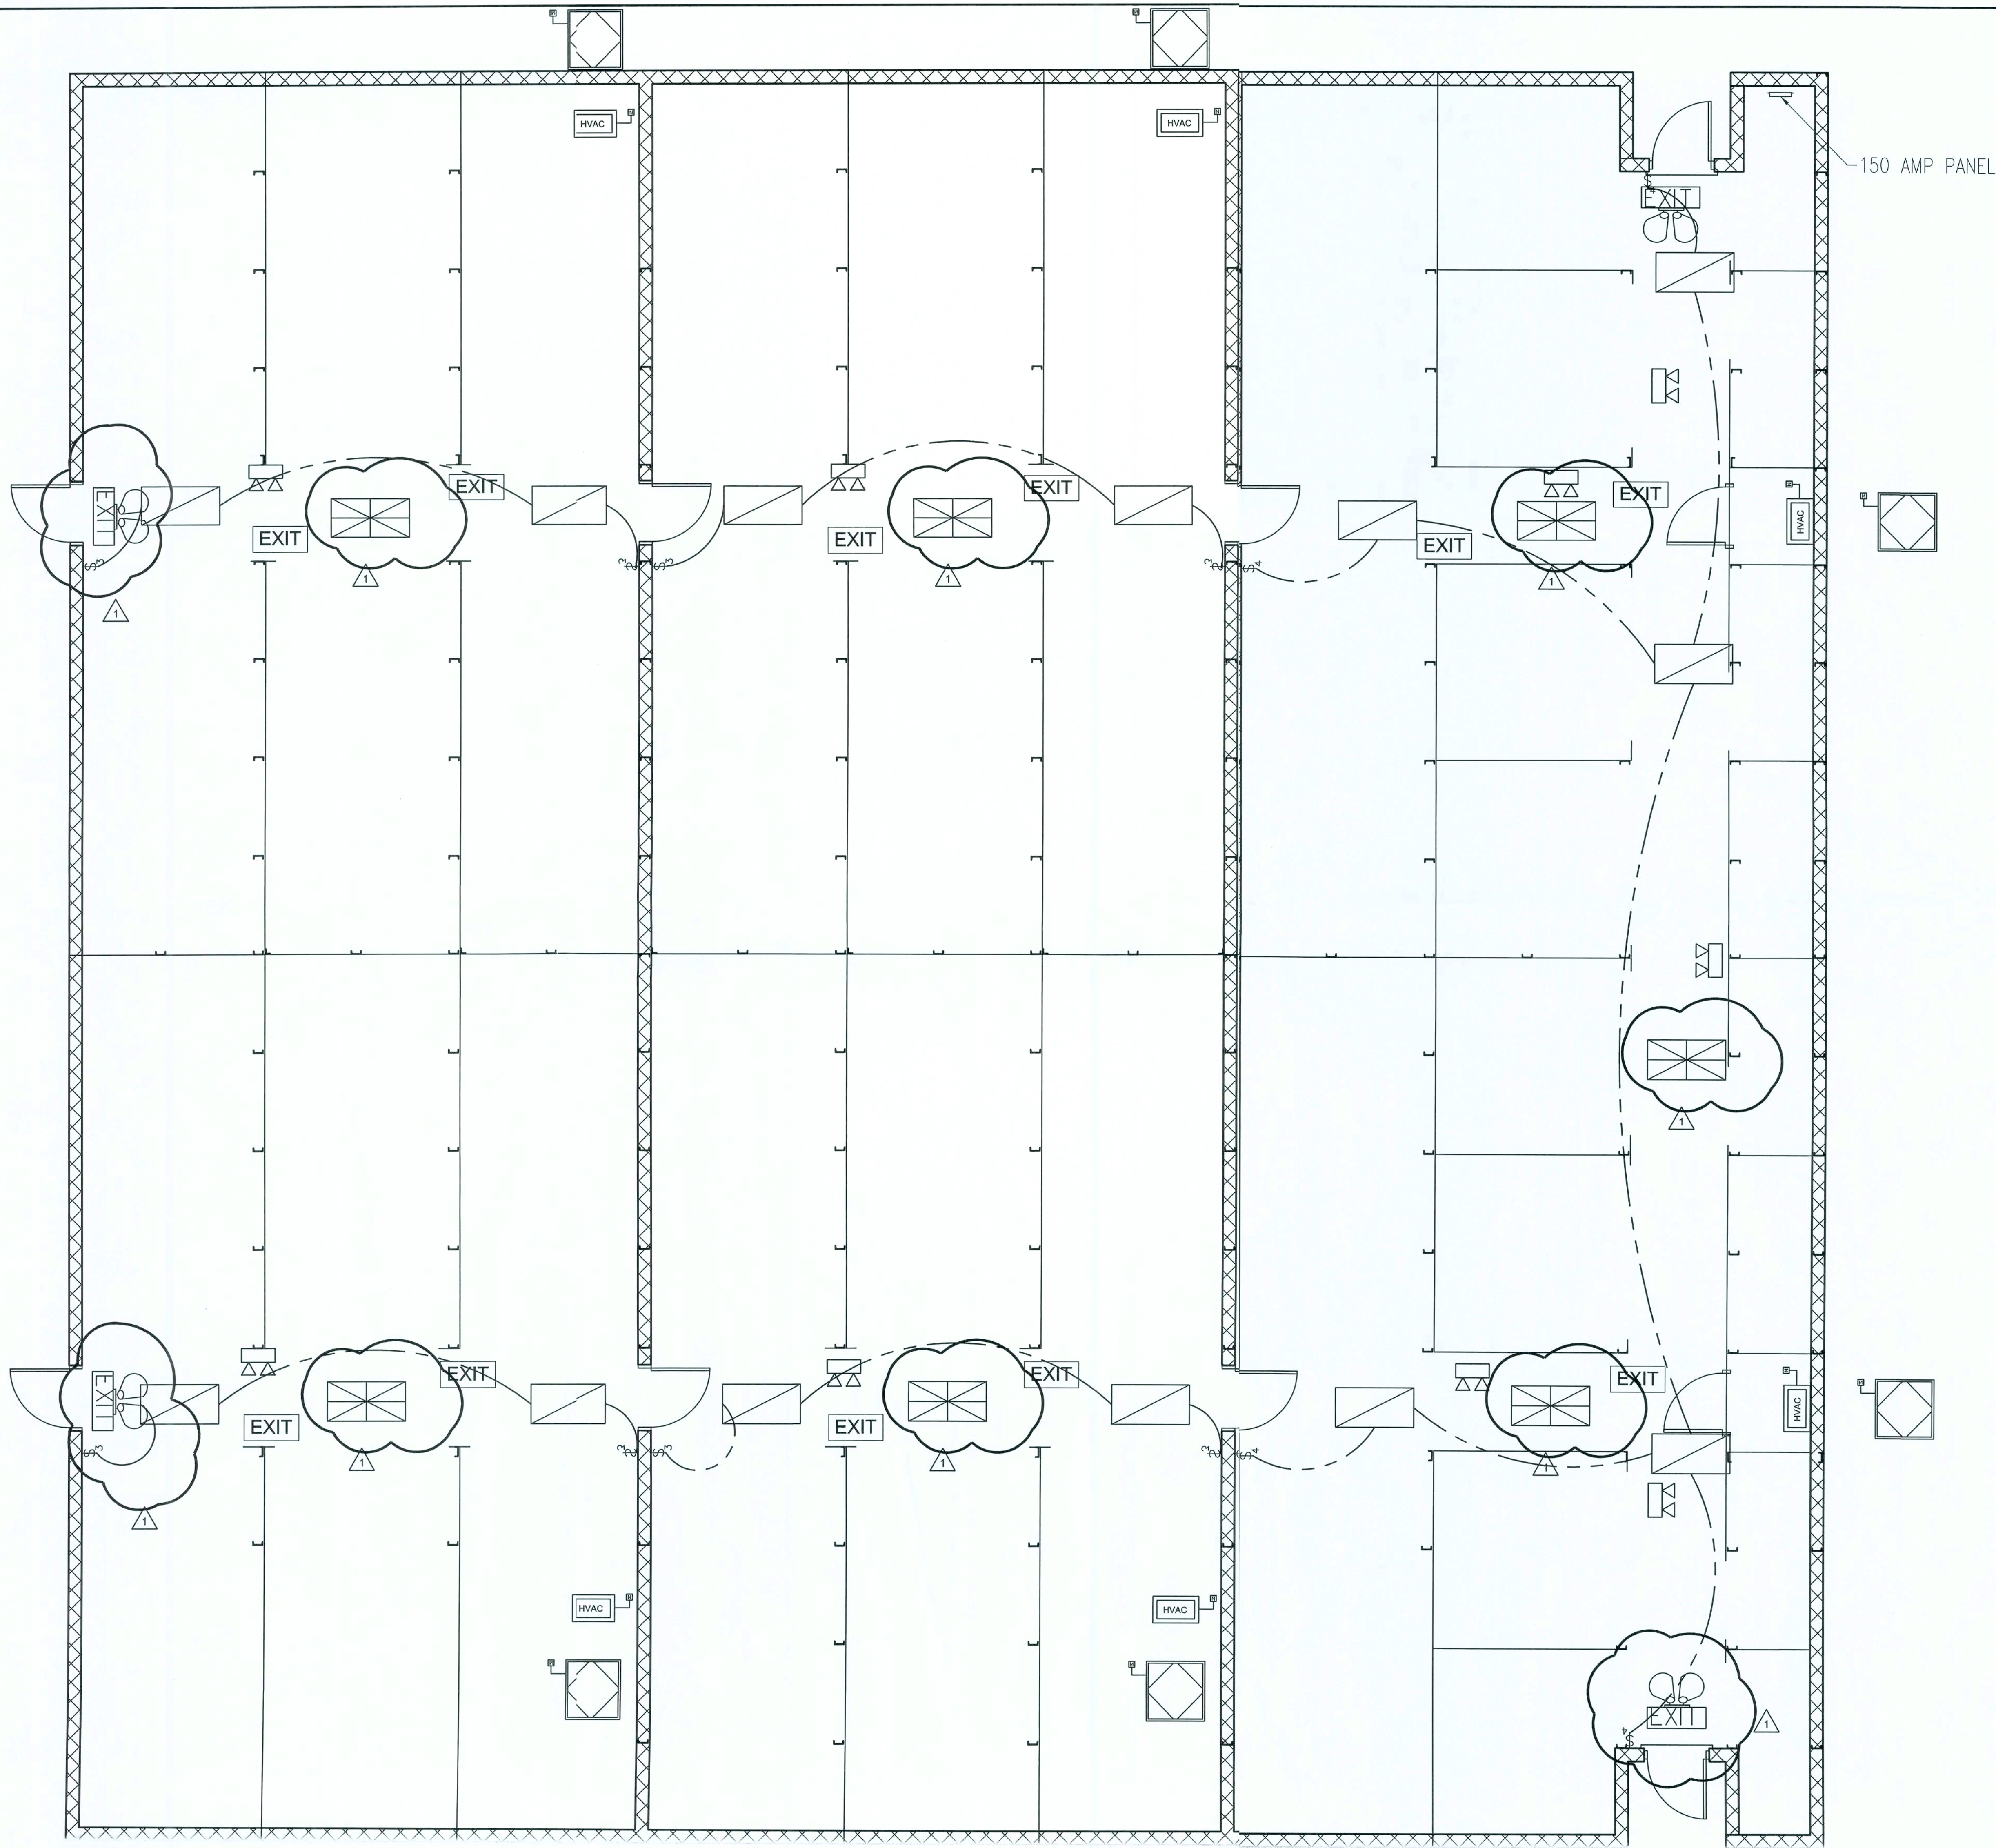

150 AMP PANEL

ELECTRICAL LEGEND		
SYMBOL	QUANTITY	DESCRIPTION
§	8	3 WAY LIGHT SWITCH
§	4	4 WAY LIGHT SWITCH
□	13	24" x 48" FLOURESCENT LIGHT
EXIT	11	EXIT SIGN
EXIT	4	EXIT SIGN WITH LIGHTS
□	7	HARD-WIRED LIGHT
□		BATTERY-POWERED EMERGENCY LIGHT

NOTES:

- 1.) ALL HARD-WIRED LIGHTS TO HAVE SWITCH AT PANEL.
- 2.) ALL DOORS LOCATED ON FIREWALLS TO HAVE A MIN. 1 1/2 HOUR FIRE RATING.

ELECTRICAL PLAN
SCALE: 1/4" = 1'-0"

9/27/06

REVISION NOTES	
REV #	DATE
1	08-28-06
2	09-27-06

P.O. Box 187
130 West Howard Street
Live Oak FL 32064
Phone: (386) 362-3678
Fax: (386) 362-6133
Gary Gill, PE 51942
Auth. # 9461




COMMUNITY SELF STORAGE
OF COLUMBIA COUNTY
NEW BUILDINGS
COLUMBIA COUNTY, FLORIDA

BLDG. 003-06 ELECTRICAL

PROJECT NUMBER
PF05-338
DRAWN BY
D. PRICE
CHECKED BY
G.G.

E-3

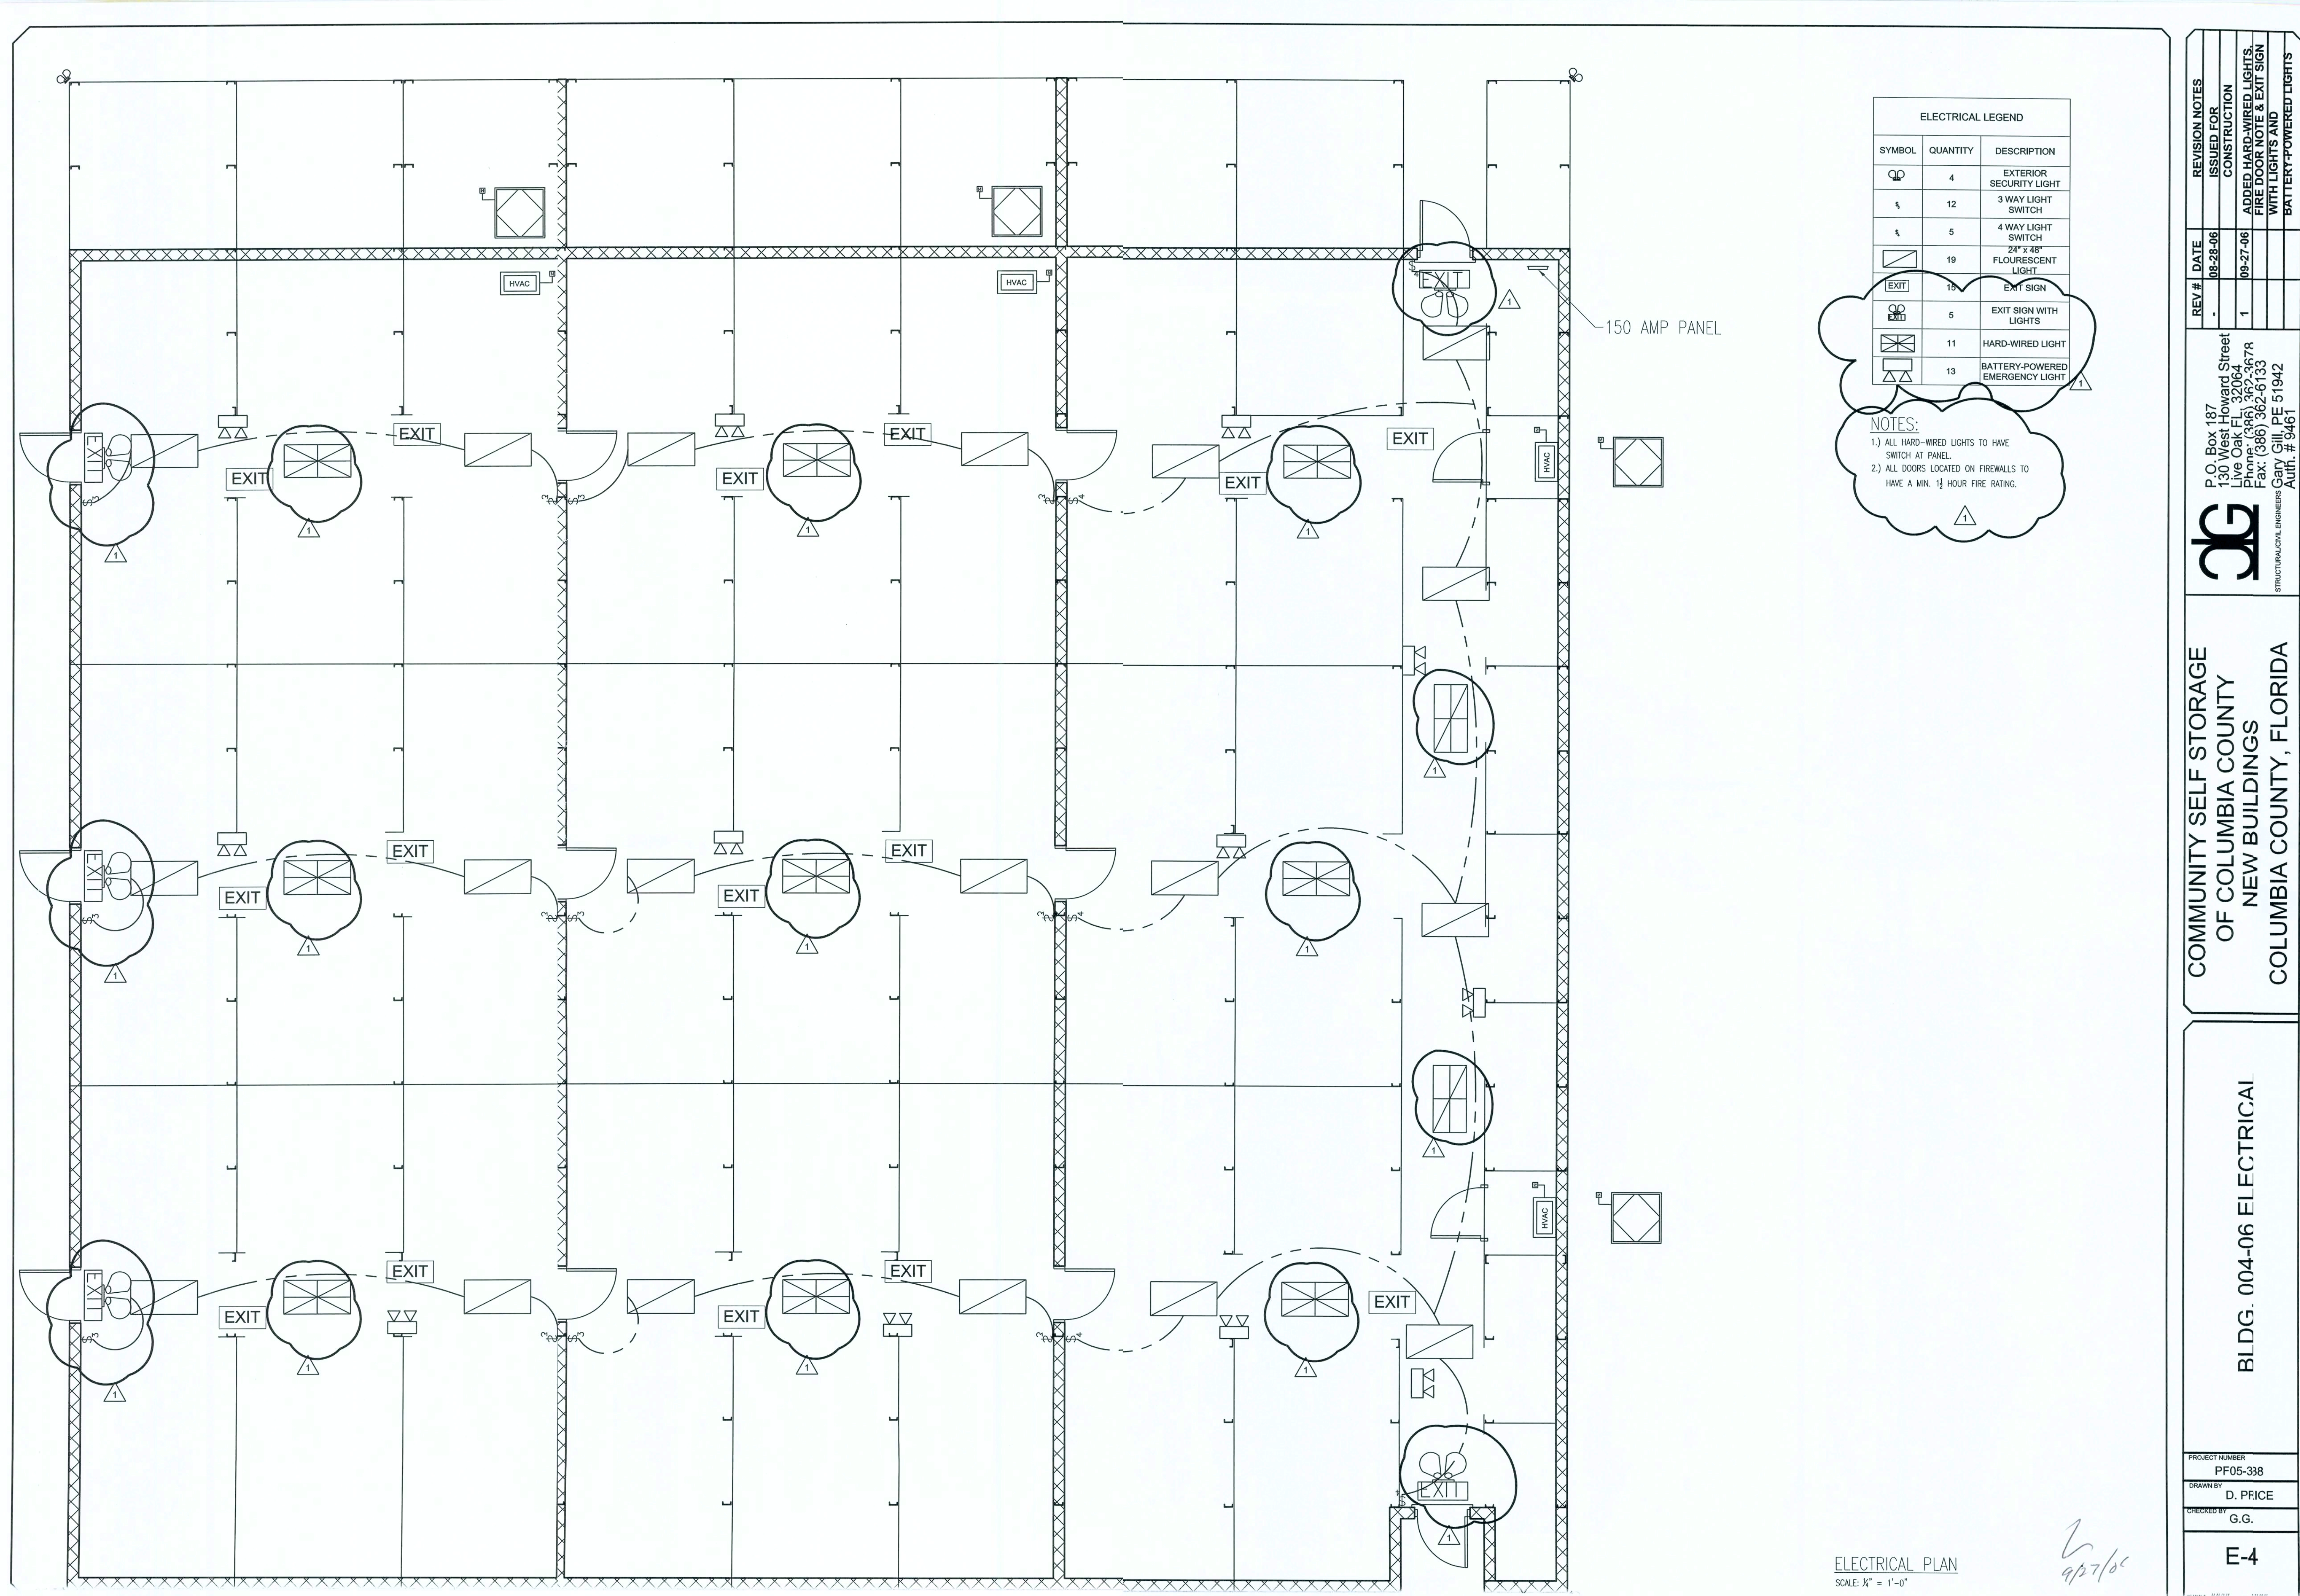

ELECTRICAL LEGEND		
SYMBOL	QUANTITY	DESCRIPTION
	4	EXTERIOR SECURITY LIGHT
	12	3 WAY LIGHT SWITCH
	5	4 WAY LIGHT SWITCH
	19	FLOURESCENT LIGHT
	15	EXIT SIGN
	5	EXIT SIGN WITH LIGHTS
	11	HARD-WIRED LIGHT
	13	BATTERY-POWERED EMERGENCY LIGHT

NOTES:
1.) ALL HARD-WIRED LIGHTS TO HAVE SWITCH AT PANEL.
2.) ALL DOORS LOCATED ON FIREWALLS TO HAVE A MIN. 1 1/2 HOUR FIRE RATING.

COMMUNITY SELF STORAGE
OF COLUMBIA COUNTY
NEW BUILDINGS
COLUMBIA COUNTY, FLORIDA


BLDG. 004-06 ELECTRICAL

PROJECT NUMBER
PF05-338
DRAWN BY
D. PFICE
CHECKED BY
G.G.
E-4

REVISION NOTES
ISSUED FOR
CONSTRUCTION
ADDED HARD-WIRED LIGHTS,
FIRE DOOR NOTE & EXIT SIGN
WITH LIGHTS AND
BATTERY-POWERED LIGHTS

REV # DATE
1 08-28-06
1 09-27-06

P.O. Box 187
130 West Howard Street
Live Oak FL 32064
Phone: (386) 362-3678
Fax: (386) 362-6133
STRUCTURAL/ENGINEERS Gary Gill, PE 51942
Auth. # 9461

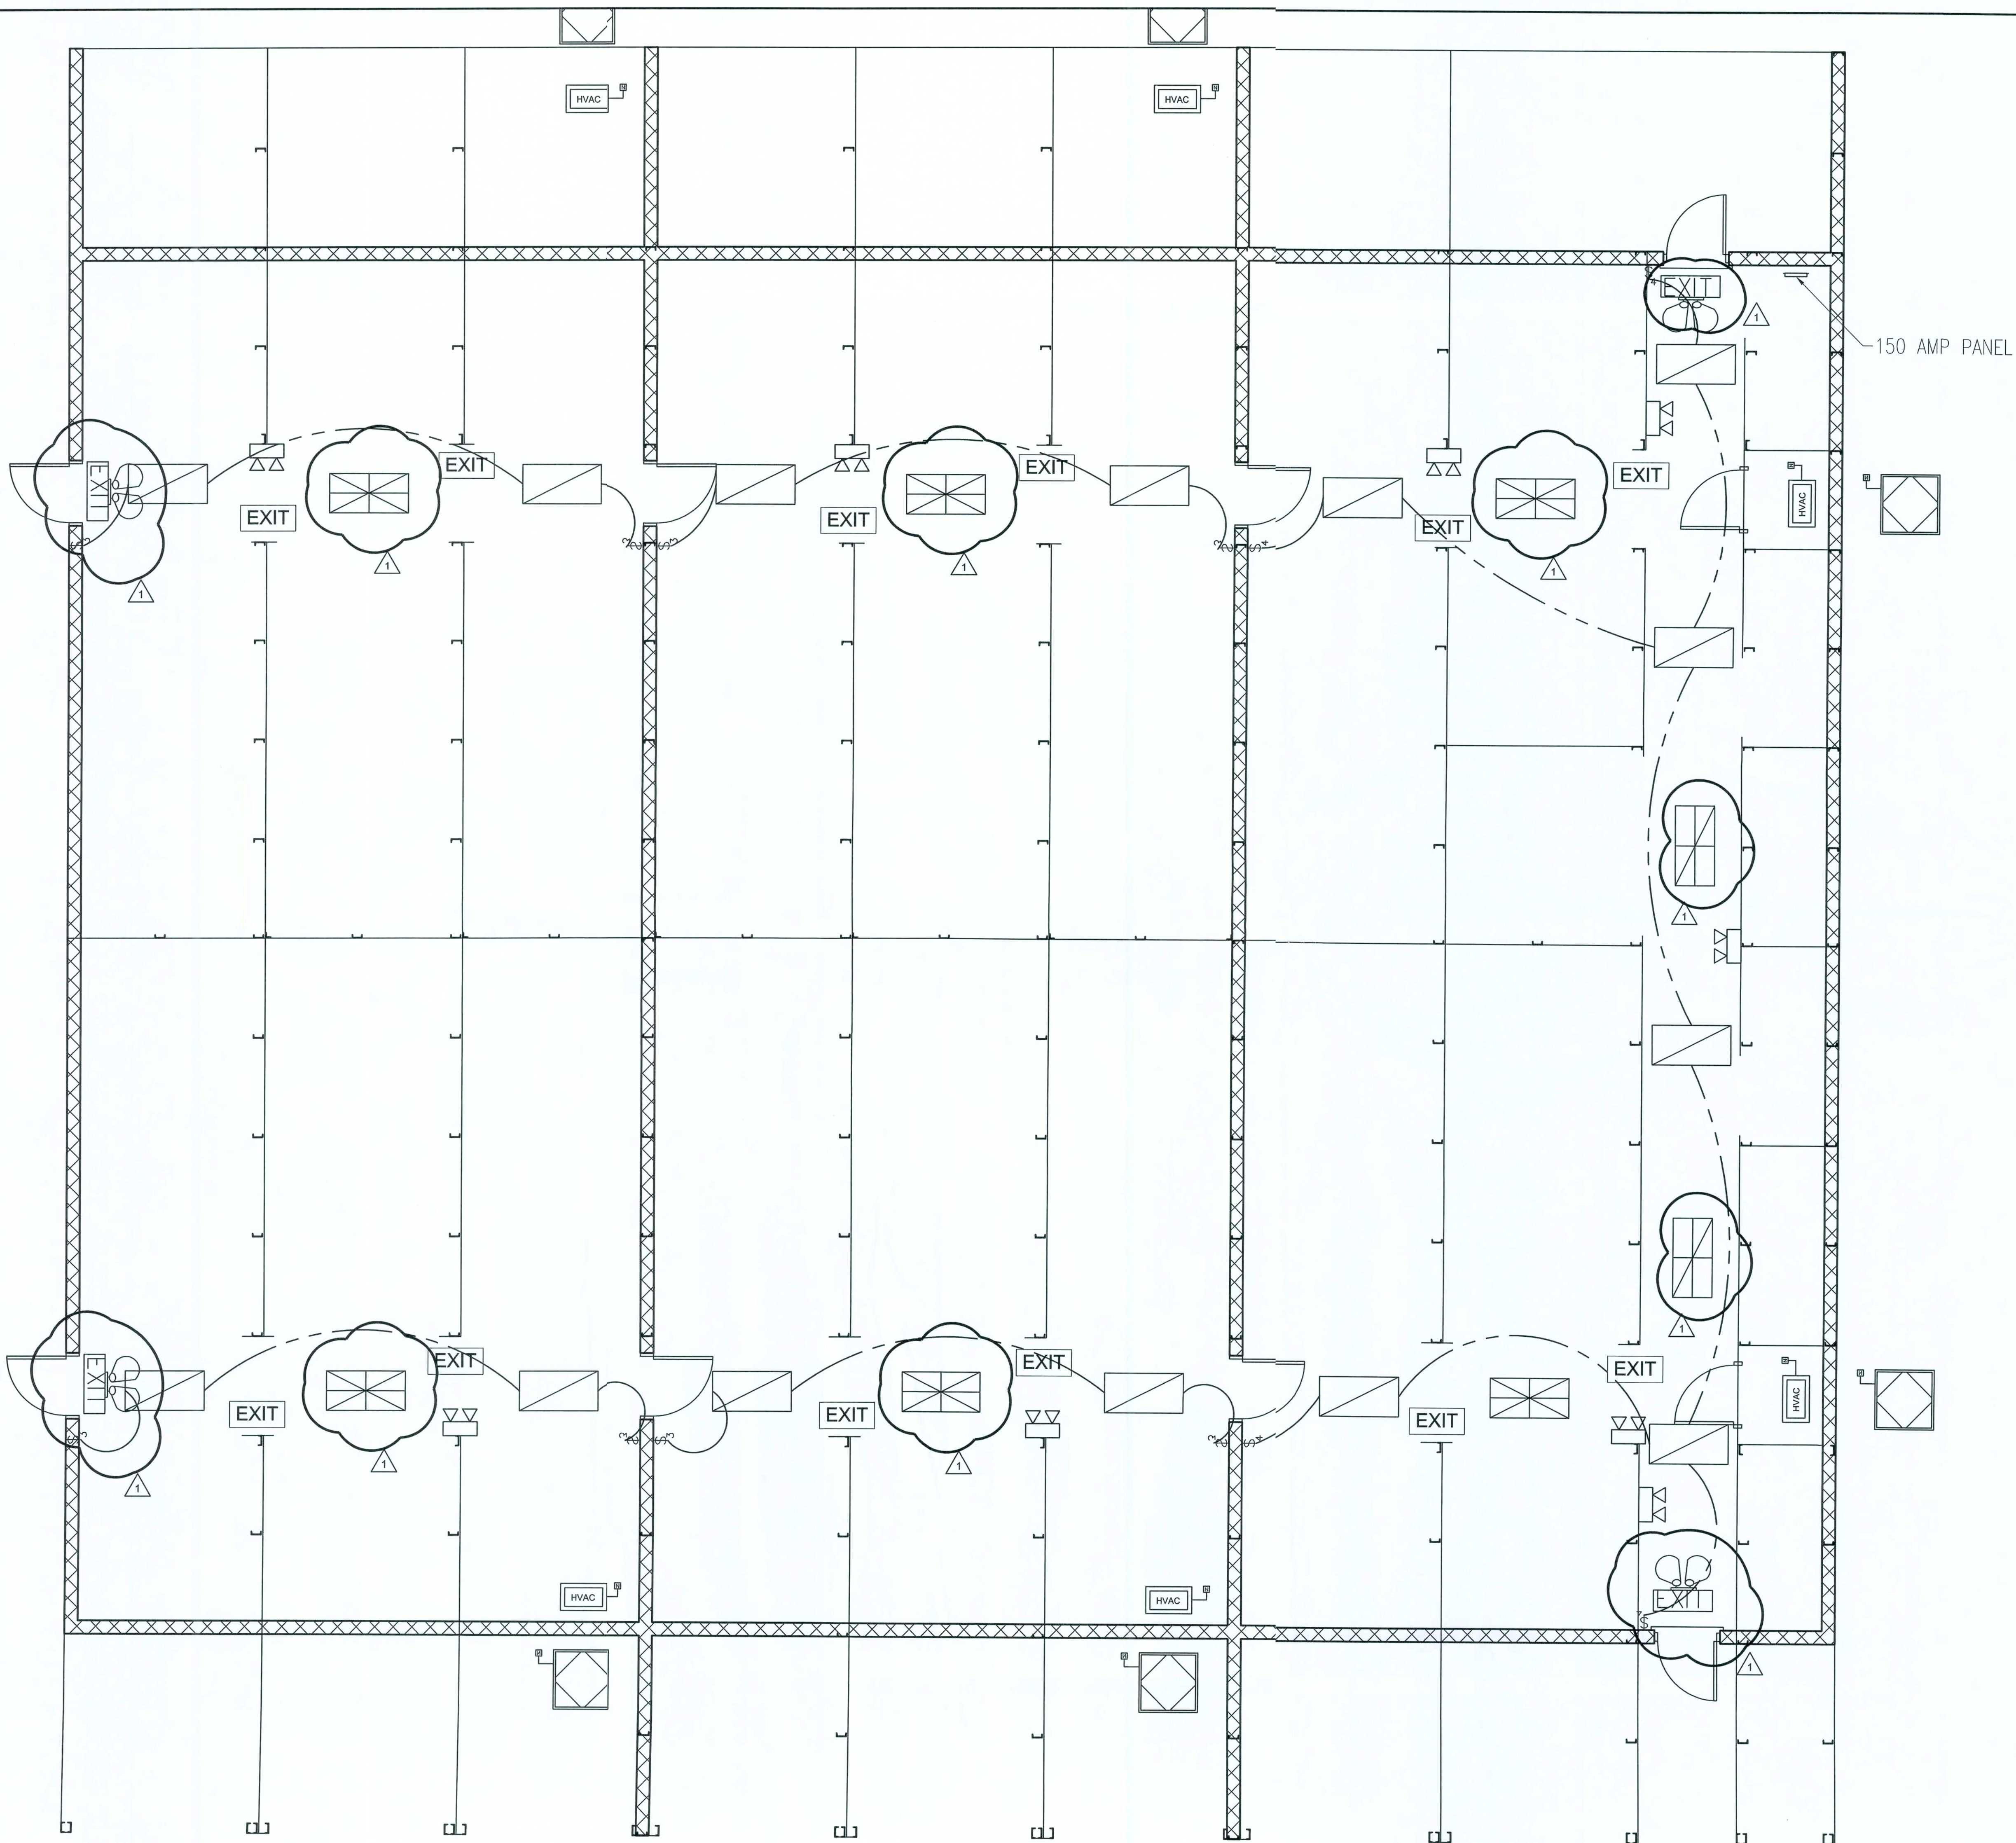

ELECTRICAL PLAN
SCALE: 1/4" = 1'-0"

ELECTRICAL LEGEND		
SYMBOL	QUANTITY	DESCRIPTION
§	8	3 WAY LIGHT SWITCH
§	4	4 WAY LIGHT SWITCH
□	14	24" x 48" FLOURESCENT LIGHT
EXIT	12	EXIT SIGN
EXIT	4	EXIT SIGN WITH LIGHTS
□	8	HARD-WIRED LIGHT
□	9	BATTERY-POWERED EMERGENCY LIGHT

NOTES:

- 1.) ALL HARD-WIRED LIGHTS TO HAVE SWITCH AT PANEL.
- 2.) ALL DOORS LOCATED ON FIREWALLS TO HAVE A MIN. 1 1/2 HOUR FIRE RATING.

REV #	DATE	REVISION NOTES
1	08-28-06	ISSUED FOR CONSTRUCTION
1	09-27-06	ADDED HARD-WIRED LIGHTS, FIRE DOOR NOTE & EXIT SIGN WITH LIGHTS & BATTERY-POWERED LIGHTS


P.O. Box 187
130 West Howard Street
Live Oak FL 32064
Phone: (386) 362-3678
Fax: (386) 362-6133
Auth. # 9461

COMMUNITY STORAGE
OF COLUMBIA COUNTY
NEW BUILDINGS
COLUMBIA COUNTY, FLORIDA

BLDG. 006-06 ELECTRICAL


PROJECT NUMBER
PF05-338
DRAWN BY
D. PRICE
CHECKED BY
G.G.

E-5

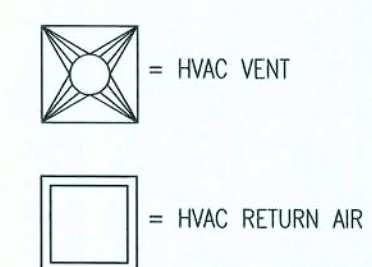


9/27/00

M-1	CHECKED BY G.G.	BLDG. 002-06 MECHANICAL	COMMUNITY STORAGE OF COLUMBIA COUNTY NEW BUILDINGS COLUMBIA COUNTY, FLORIDA	 P.O. Box 187 130 West Howard Street Live Oak FL 32064 Phone: (386) 362-3678 Fax: (386) 362-6133 STRUCTURAL/CIVIL ENGINEERS Gaty Gill, P.E. # 1942 Auth. # 9461	REV #	DATE	REVISION NOTES
	DRAWN BY D. PRICE				-	08-28-06	ISSUED FOR CONSTRUCTION
	PROJECT NUMBER PF05-338						

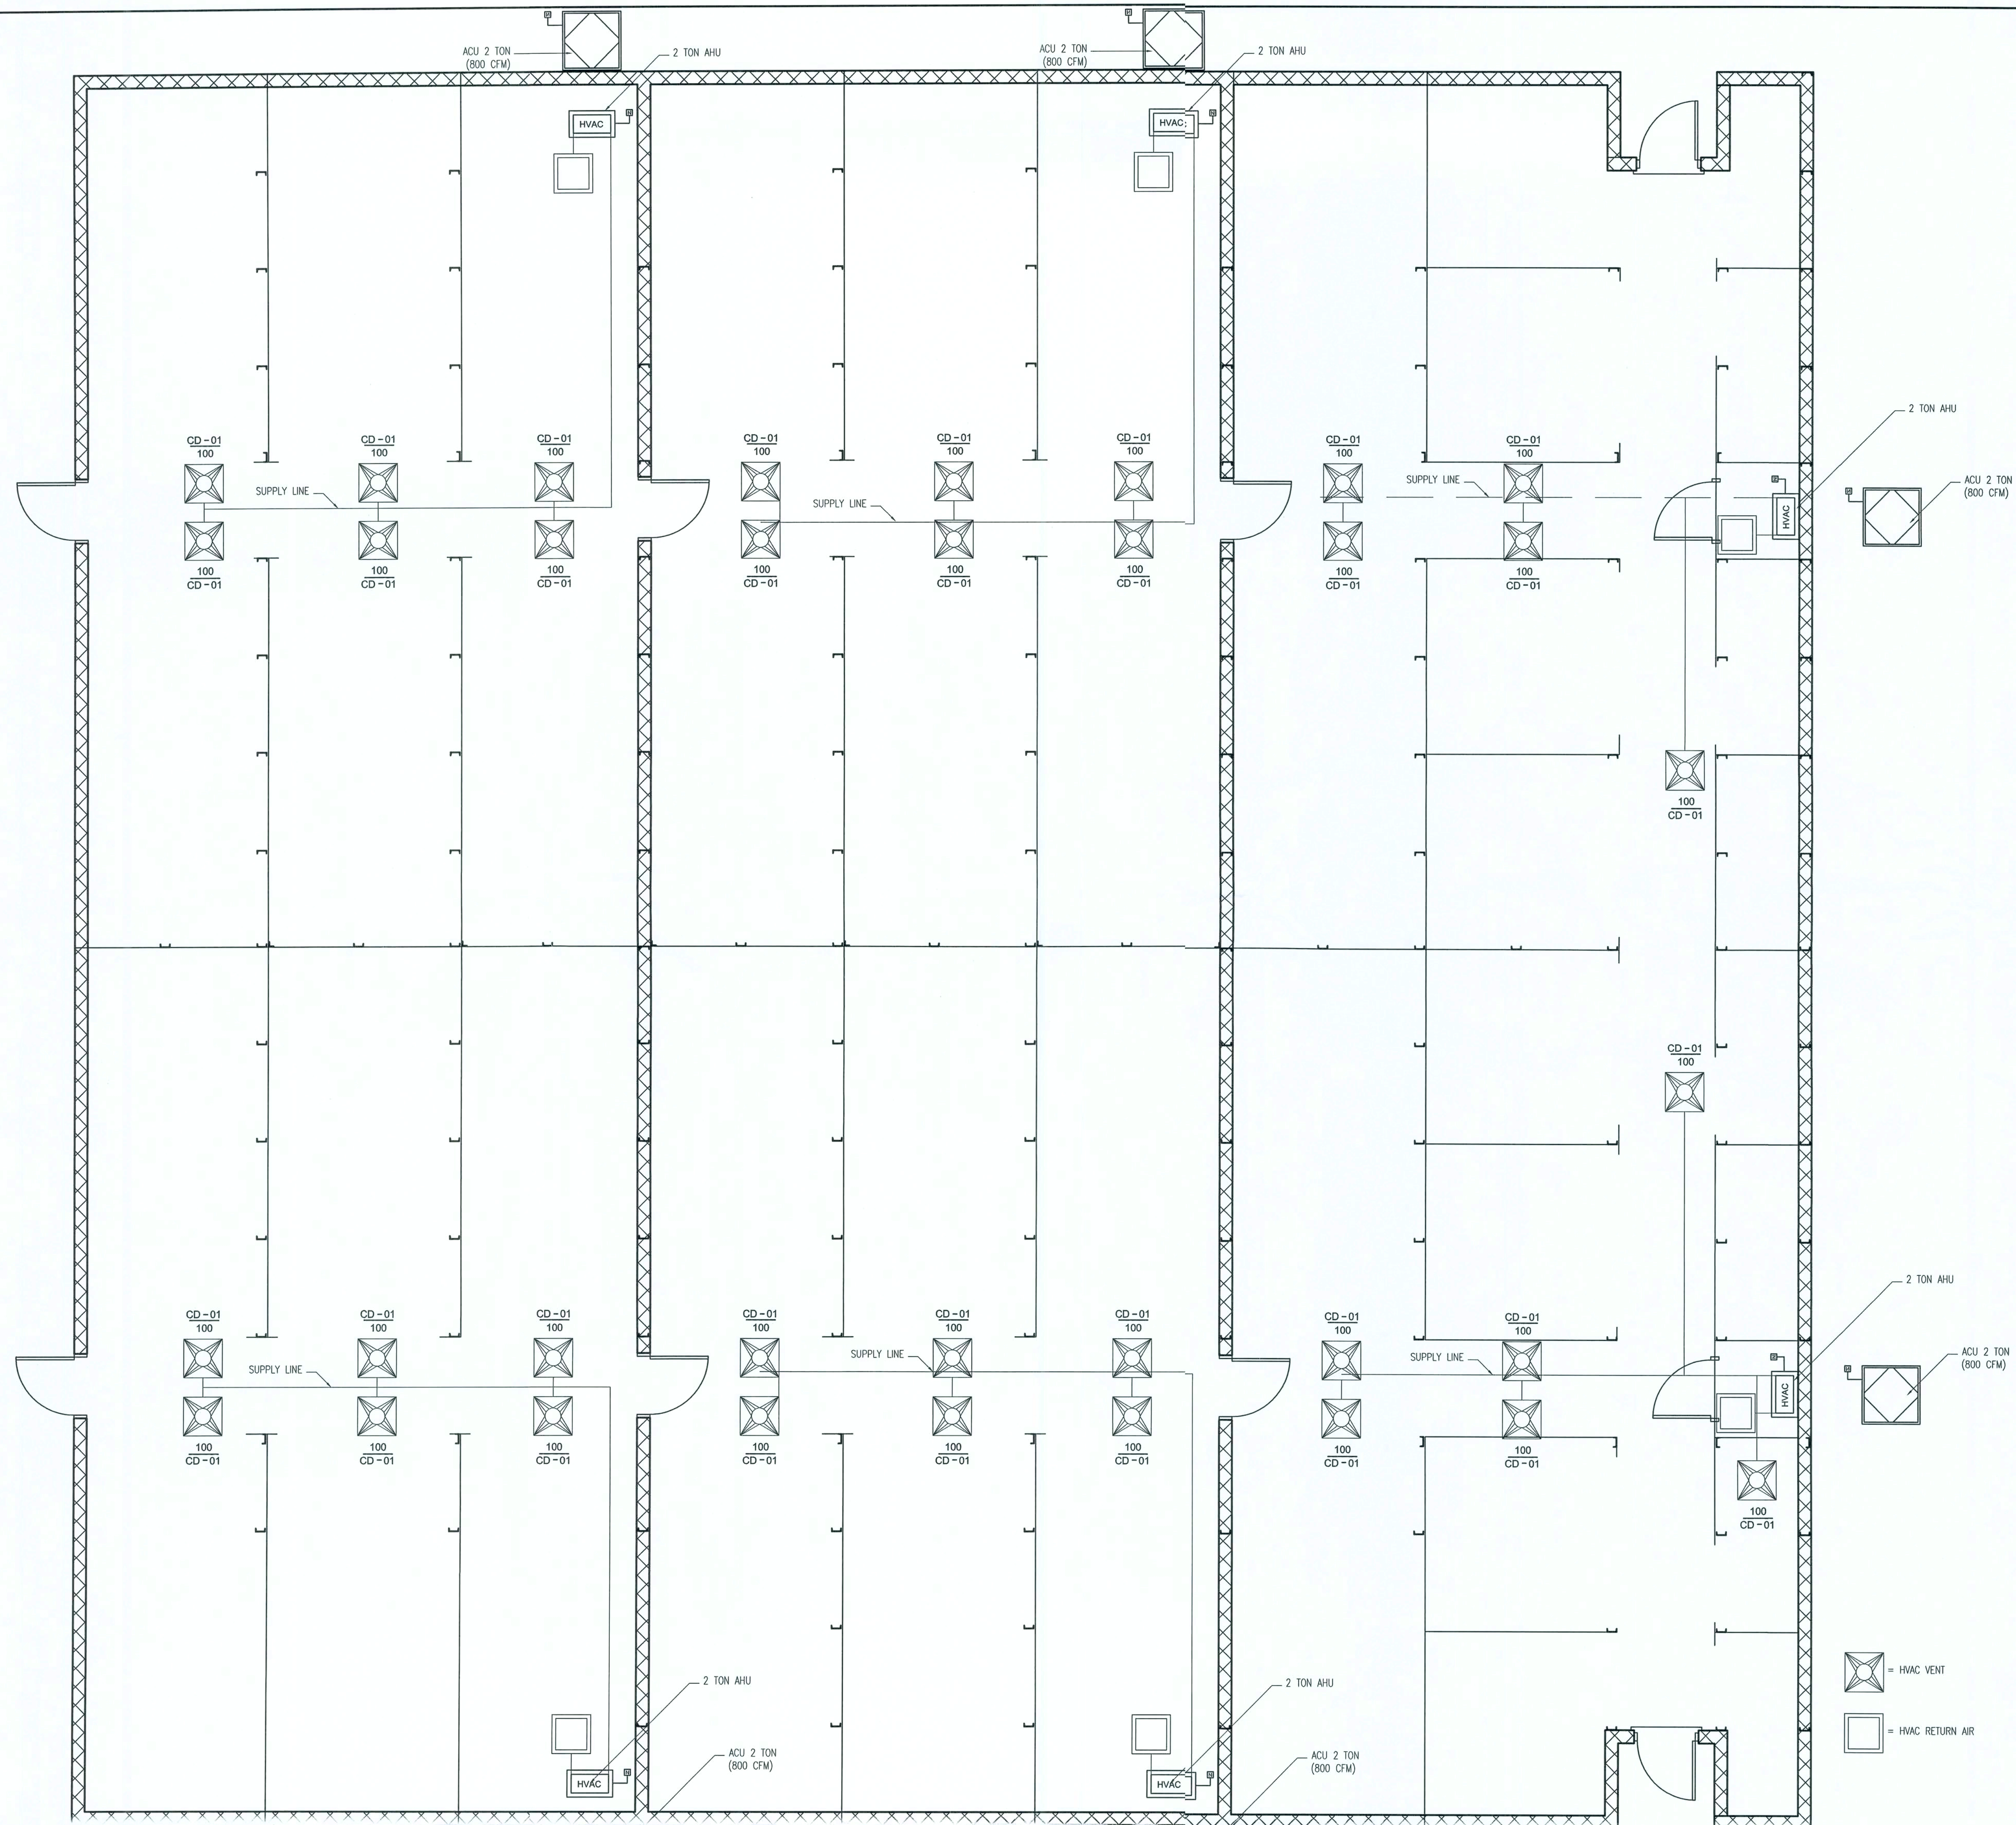

MECHANICAL PLAN
SCALE: $\frac{1}{4}" = 1'-0"$

M-2
CHECKED BY G.G.
DRAWN BY D.PRICE
PROJECT NUMBER PF05-338
COMMUNITY STORAGE OF COLUMBIA COUNTY NEW BUILDINGS COLUMBIA COUNTY, FLORIDA
 P.O. Box 187 130 West Howard Street Live Oak, FL 32064 Phone: (386) 362-6678 Fax: (386) 362-6133 Gary Gill, P.E. #19942 STRUCTURAL/CIVIL ENGINEERS Auth.# 9461
REV # -
DATE 08-28-06
REVISION NOTES ISSUED FOR CONSTRUCTION

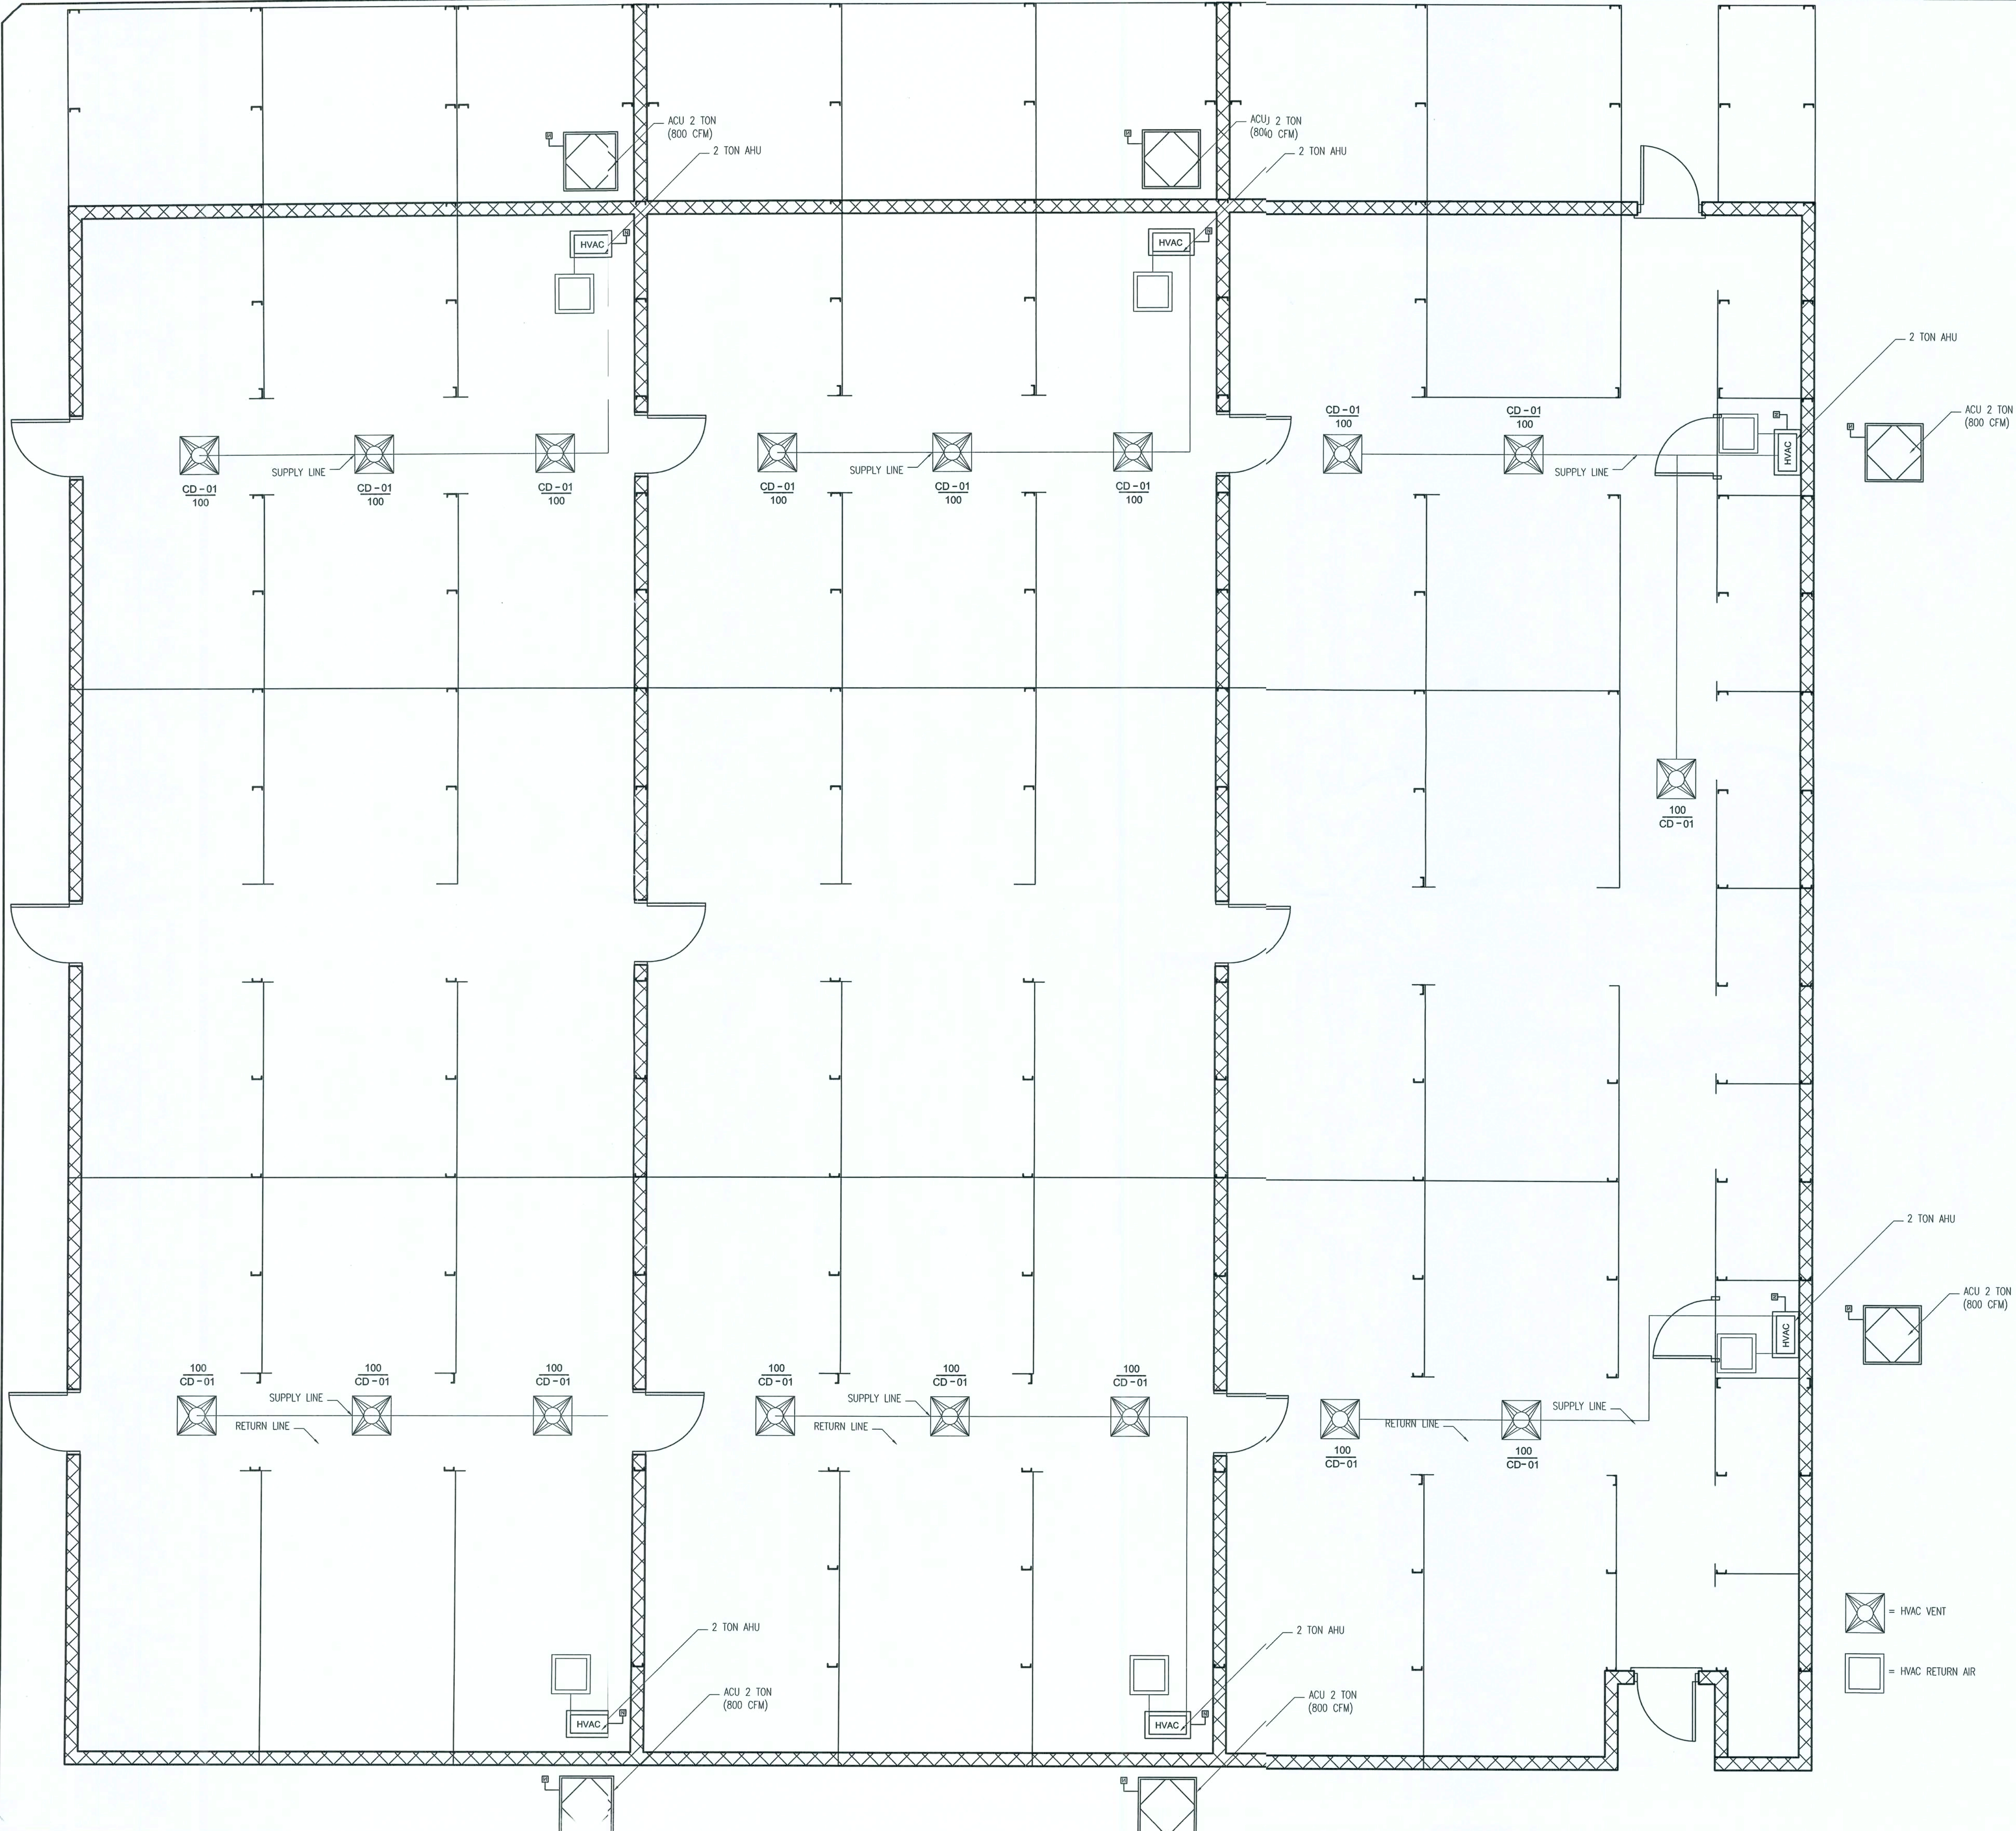

MECHANICAL PLAN
SCALE: 1/4" = 1'-0"

6/27/06


REVISION NOTES		ISSUED FOR	
REV #	DATE	CONSTRUCTION	
-	08-28-06		
PROJECT NUMBER			
PP05-338			
DRAWN BY			
D. PRICE			
CHECKED BY			
G.G.			
M-3			

COMMUNITY STORAGE
OF COLUMBIA COUNTY
NEW BUILDINGS
COLUMBIA COUNTY, FLORIDA

P.O. Box 187
130 West Howard Street
Live Oak FL 32064
Phone: (386) 362-3678
Fax: (386) 362-6133
Auth. # 9461


JG
STRUCTURAL/CIVIL ENGINEERS

BLDG. 004-06 MECHANICAL

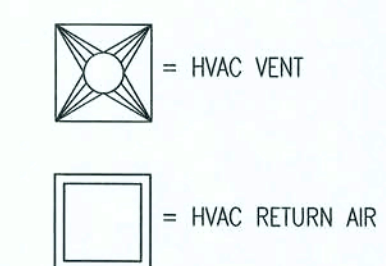

9/27/06

COMMUNITY STORAGE OF COLUMBIA COUNTY NEW BUILDINGS COLUMBIA COUNTY, FLORIDA BLDG. 006-06 MECHANICAL	 P.O. Box 187 130 West Howard Street Live Oak FL 32064 Phone: (386) 362-3678 Fax: (386) 362-6133 Gary Gill, PE 51942 Structural/Civil Engineers Auth. # 9461	REV #	DATE	REVISION NOTES
		-	08-28-06	ISSUED FOR CONSTRUCTION

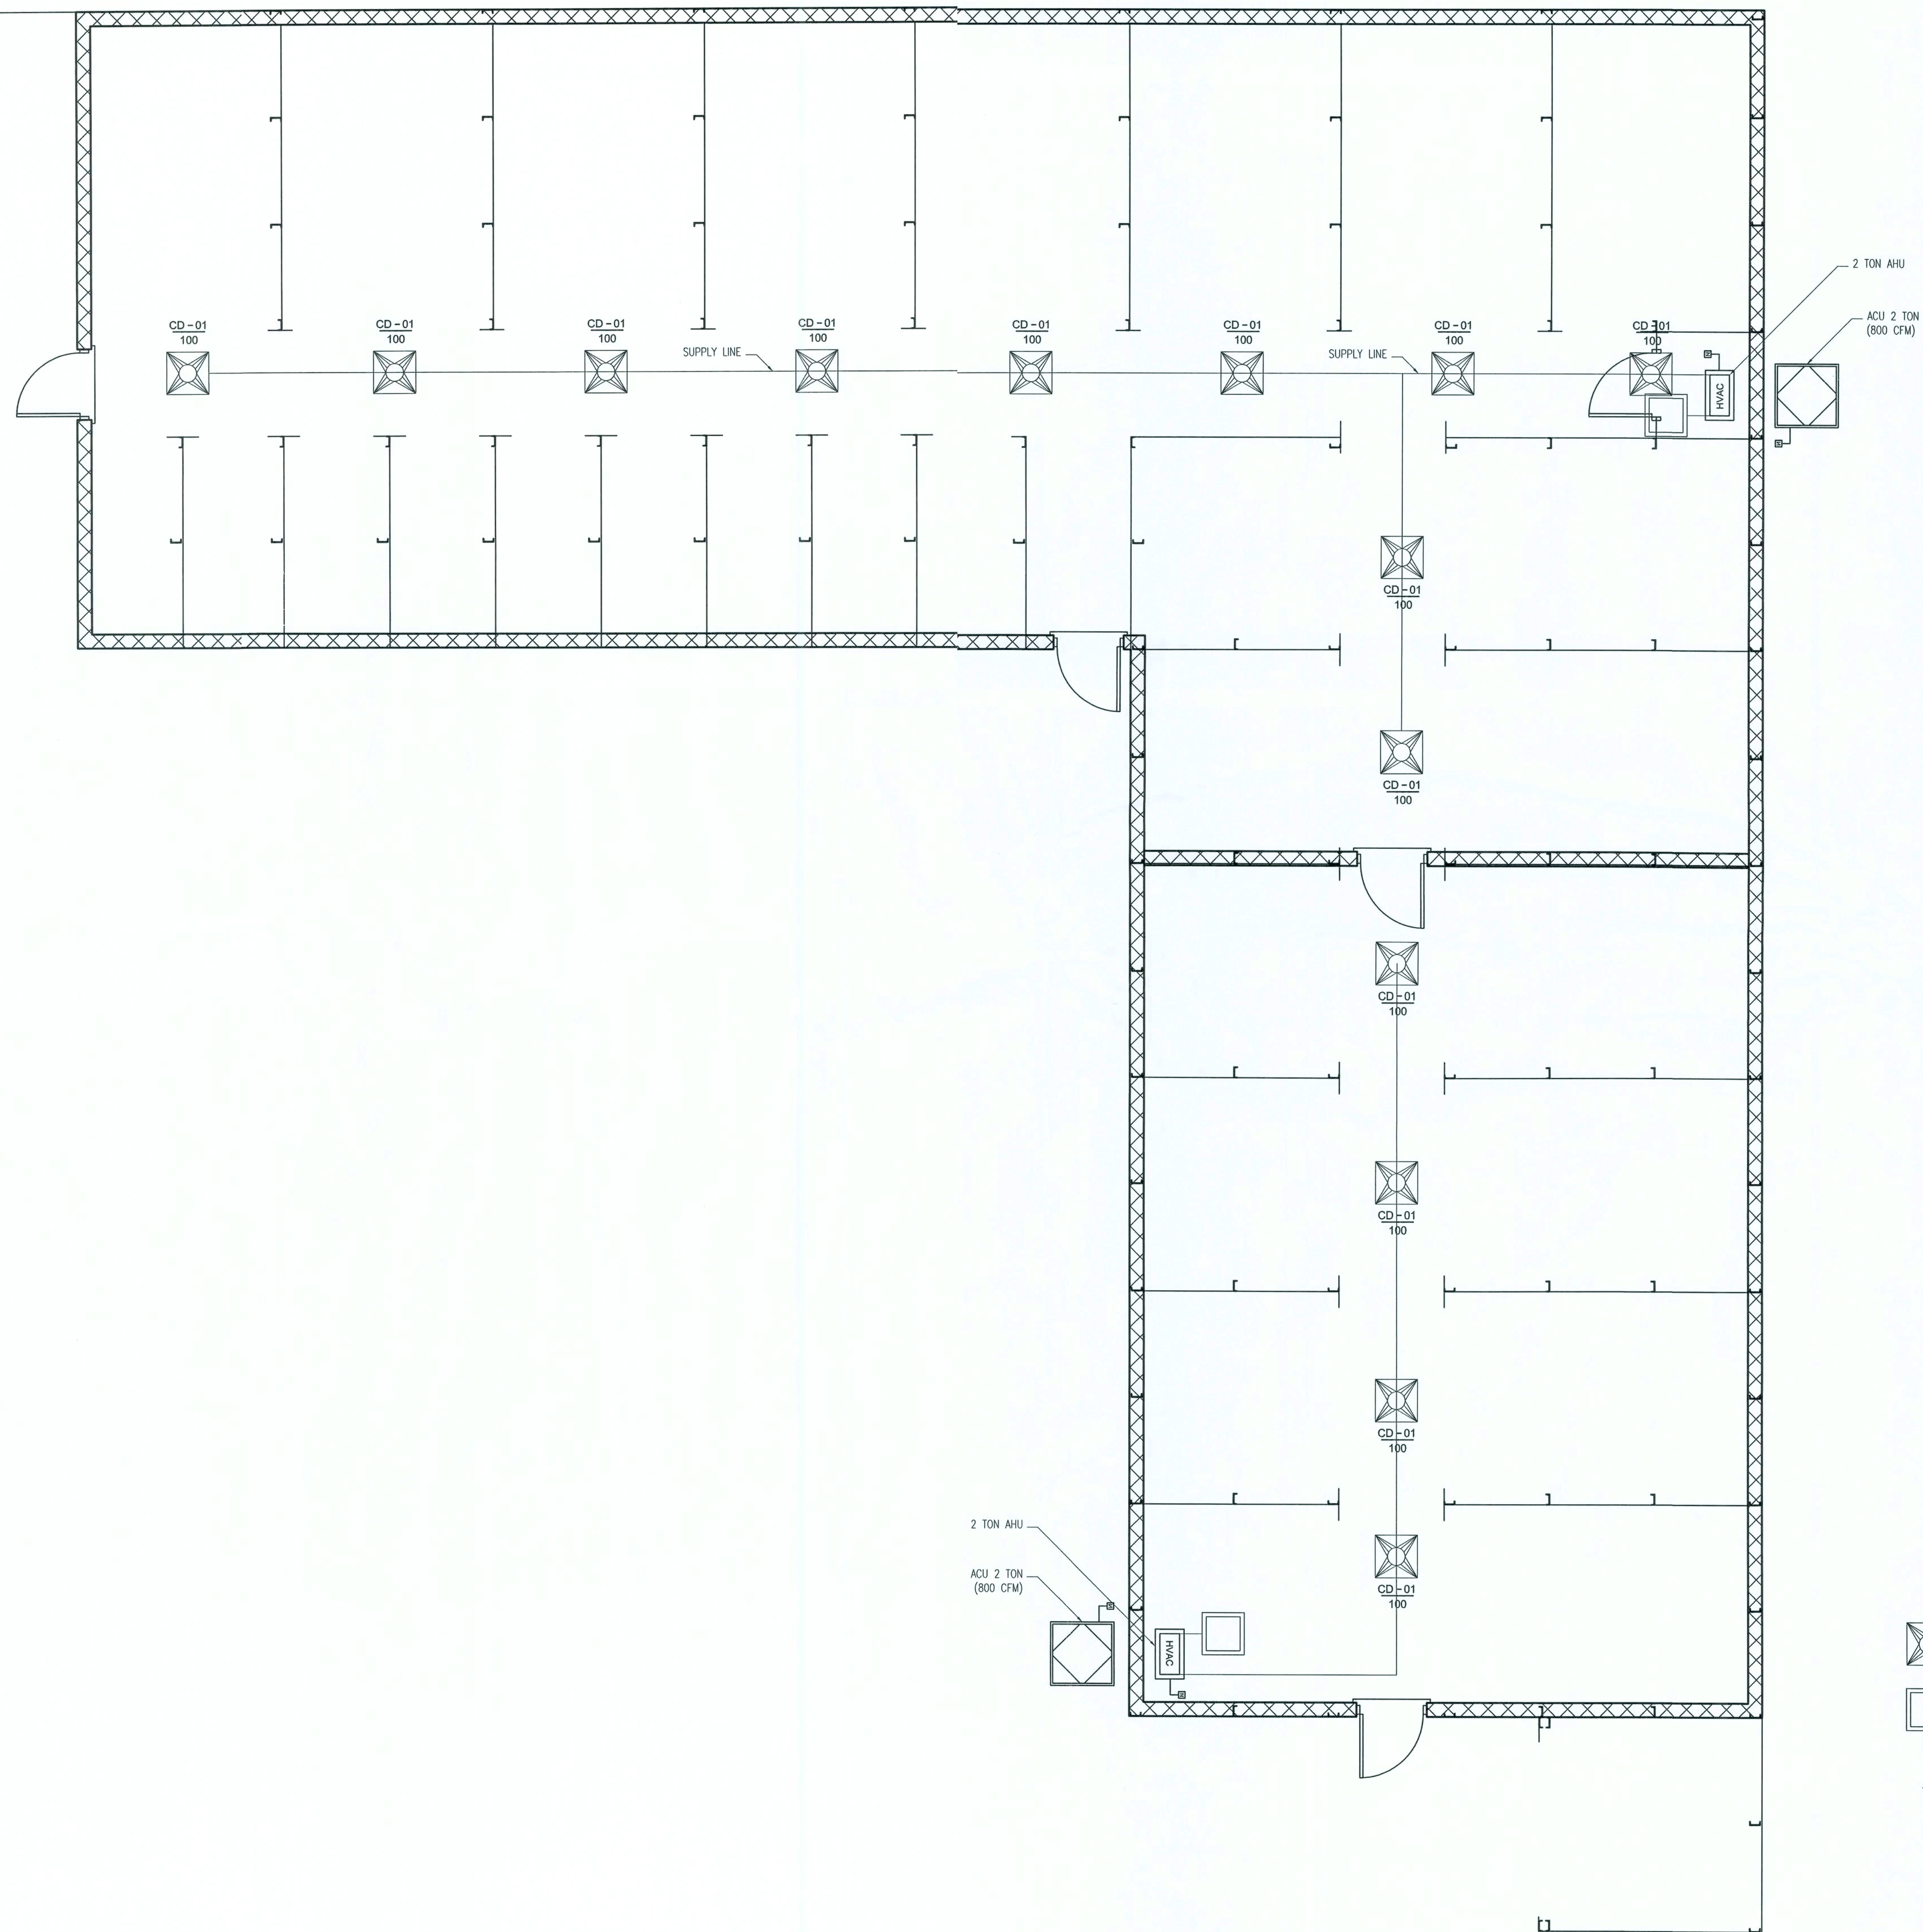

= HVAC VENT

 = HVAC RETURN AIR

MECHANICAL PLAN

SCALE: $\frac{1}{4}" = 1'-0"$

9/27/80

COMMUNITY STORAGE
OF COLUMBIA COUNTY
NEW BUILDINGS
COLUMBIA COUNTY, FLORIDA

BLDG. 007-06 MECHANICAL

M-5

PROJECT NUMBER	PF05-338
----------------	----------

DRAWN BY
D. PRICE

CHECKED BY **G.G.**

REVISION NOTES
 ISSUED FOR
 CONSTRUCTION

REV #	DATE
-	08 28 06

P.O. Box 187
130 West Howard Street
Live Oak FL 32064
Phone: (386) 362-3678
Fax: (386) 362-6133
Gary Gill, PE 51942
Auth. # 9461



STRUCTURAL/CIVIL ENGINEERS Gary Gill, PE 51942
Auth. # 9461
Fax: (386) 362-8133


GENERAL MECHANICAL NOTES

1. THE CONTRACTOR SHALL FURNISH ALL LABOR, MATERIALS, AND EQUIPMENT NECESSARY FOR THE INSTALLATION CODE AND ALL OPTION OF A COMPLETE SYSTEM IN WITH THESE DRAWINGS. THE APPLICABLE BUILDING CODE AND ALL OTHER APPLICABLE STATE, COUNTY AND LOCAL ORDINANCES AND THE LATEST ADDITION OF THE FOLLOWING PUBLICATIONS, ASHREA, NFIA 90A, 90B, 91, AND ANSI B-9.1 MECHANICAL REFRIGERATION.
2. THE CONTRACTOR SHALL PAY ALL COSTS OF PERMIT, INSPECTIONS, AND AL OTHER COSTS INCIDENTAL TO THE COMPLETION AND TESTING OF THIS WORK.
3. THE PLUMBING CONTRACTOR SHALL VISIT THE SITE AND THOROUGHLY FAMILIARIZE HIMSELF WITH ALL EXISTING CONDITIONS. ALL EXECUTION AND BACKFILL AS REQUIRED FOR THIS PHASE OF CONSTRUCTION SHALL BE A PART OF THIS CONTRACT.
4. THE CONTRACTOR SHALL SUPPLY THE ENGINEER/ARCHITECT WITH AS-BUILT DRAWINGS UPON COMPLETION OF THIS PROJECT.
5. CONTRACTOR SHALL SUBMIT FOR APPROVAL FIVE (5) COPIES OF MANUFACTURER'S DRAWING FOR EACH PIECE OF EQUIPMENT AND CONTROLS INCLUDED IN CONTRACT.
6. ALL MATERIAL SHALL BE NEW OF GOOD QUALITY. ALL WORK SHALL BE PERFORMED IN A WORKMANLIKE MANNER BY SKILLED WORKMAN.
7. ALL AIR CONDITIONING DUCT SHALL BE OF 1-1/2" STANDARD DUTY FOIL REINFORCED FIBERGLASS WITH MANUFACTURER'S LOGO PRINTED ON THE VAPOR BARRIER. ALL FLEX TO BE R-8.
8. ALL EXHAUST DUCTS AND OUTSIDE AIR DUCTS SHALL BE GALVANIZED SHEET METAL WITH SEALED SEAMS AND JOINTS.
9. DUCT SIZES SHOWN ARE INSIDE DIMENSIONS.
10. ALL AIR DEVICES (DIFFUSERS, REGISTERS, AND GRILLS) SHALL BE ALL ALUMINUM CONSTRUCTION WITH EXPOSED SURFACE OFF WHITE BAKED ENAMEL FINISH OR AS SPECIFIED BY ENGINEER/ARCHITECT. DEVICES SHALL BE TITUS, METALAIR, AND AIRGUIDE. PROVIDE OPPOSED BLADE DAMPERS AT ALL DIFFUSERS AND REGISTERS.
11. THERMOSTAT SHALL BE COMBINATION COOLING/HEATING, WITH SYSTEM "COIL-AUTO-HEAT-OFF" AND FAN "ON-AUTO" SELECTOR SWITCHES. PROVIDE PROGRAMMABLE TYPE, CARRIER OR EQUAL.
12. REFRIGERANT LINES SHALL BE COPPER, TYPE "L" HARD DRAWN WITH WROUGHT COOPER SOLDER-JOINT TYPE FITTINGS, USE 95/5 SOLDER. REFRIGERANT LINES SHALL BE SIZED AS PER MANUFACTURER RECOMMENDATIONS.
13. ARMAFLEX 3/4" INSULATION SHALL BE USED FOR SUCTION LINES, FILTER/RYER AND SIGHT GLASS SHALL BE PROVIDED AT LIQUID LINES.
14. ALL BRANCH TAKE-OFFS TO BE PROVIDED W/MANUAL VOLUME DAMPERS. ALL ELBOWS AND TEE'S MUST BE FURNISHED W/TURNING VANES. PROVIDE 45 DEGREES BRANCH TAKE-OFF AS PER BRANCH DUCT TAKE-OFF DETAIL.

15. PROVIDE NEW FILTERS FOR ALL AIR CONDITIONING EQUIPMENT BEFORE STARTING THEM. REPLACE THEM PRIOR TO ACCEPTANCE BY OWNER.
16. PROVIDE SMOKE DETECTORS WITH ACCESS DOORS IN ALL SUPPLY AIR DUCTS FOR FANS AND AHU'S SERVING A COMMON PLENUM OF 2000 CFM OR ABOVE. ALL SMOKE DETECTORS SHALL BE BY ONE MANUFACTURER, COORDINATE VOLTAGE ETC. WITH ELECTRICAL CONTRACTOR AND FIRE ALARM SYSTEM BEFORE ORDERING.
17. PROVIDE TYPE "B" FIRE DAMPERS IN ALL DUCTS OR OPENINGS PENETRATING FIRE RATED WALLS, MECHANICAL AND ELECTRICAL ROOMS, TENANT SEPARATION, PARTITIONS, FLOOR OR ROOF SLABS AND AT O/A INTAKES. PROVIDE RADIATION DAMPERS IN RATED CEILING FOR ALL CEILING OPENING, CEILING FANS, DIFFUSERS OR GRILLES RATED FOR USE IN THE CEILING ASSEMBLY.
18. HVAC CONTRACTOR SHALL PROVIDE AN INDEPENDENT TEST AND BALANCE REPORT FOR ALL MECHANICAL EQUIPMENT, AIR DEVICE, DAMPERS, AHU'S AND FANS. THE T&B SHALL BE IN ACCORDANCE WITH THE AIR BALANCE COUNCIL STANDARDS AND SHALL INCLUDE AIR QUANTITIES FOR ALL SUPPLY GRILLS, RETURN GRILLS, AND EXHAUST GRILLS AND LEAVING AND ENTERING AIR TEMPERATURE FROM THE; SUPPLY GRILLS AND EVAPORATORS.
19. THERMOSTAT LOCATION SHALL BE APPROVED BY OWNER AND ENGINEER/ARCHITECT BY INSTALLATION.
20. ALL INSULATION WILL HAVE FIRE/SMOKE RATING LESS THAN 50/50.
21. MECHANIC PLANS IN GENERAL, ARE DIAGRAMMATIC IN NATURE, AND ARE TO BE READ IN CONJUNCTION WITH ARCH., PLUMBING, ELECTRICAL, AND STRUCTURAL PLANS AND SHALL BE CONSIDERED AS ONE SET OF DOCUMENTS. DUCT AND PIPING OFFSETS, BENDS AND TRANSITIONS WILL BE REQUIRED TO PROVIDE AND INSTALL A COMPLETE FUNCTIONAL SYSTEM AND SHALL BE PROVIDED BY THE CONTRACTOR AT NO ADDITIONAL COST TO THE OWNER.
22. NO COMBUSTIBLE MATERIALS ARE ALLOWED IN RETURN AIR PLENUMS OR ABOVE CEILING'S USED AS RETURN AIR PLENUM. IF SPACE WITH RETURN AIR PLENUM HAS ANY DECK PARTITION, AIR TRANSFER DUCTS MUST BE INSTALLED.
23. REFER TO PLUMBING PLAN FOR CONDENSATE PIPING.
24. IF PROJECT IS A REMODEL OF AN EXISTING BUILDING, THE CONTRACTOR SHALL VISIT JOB SITE PRIOR TO CONSTRUCTION AND COORDINATE ALL FIELD CONDITIONS. ENGINEER AND/OR ARCHITECT SHALL BE NOTIFIED OF ANY DISCREPANCIES.
25. CONTRACTOR SHALL INSTALL ALL OUTDOOR EQUIPMENT TO WITHSTAND A SUSTAINED 200 MPH WIND WITH A GUST FACTOR OF 30%. PROVIDE A LISTED PRE-ENGINEERED ASSEMBLY, OR CONTRACTOR SHALL BE RESPONSIBLE FOR THE CERTIFICATION OF ROOF MOUNTING.
26. PROVIDE ALL NECESSARY CONTACTS, RELAYS, ETC., FOR A COMPLETE OPERATING A/C SYSTEM.

ELECTRICAL RISER DIAGRAM: 200A

SCALE: NONE

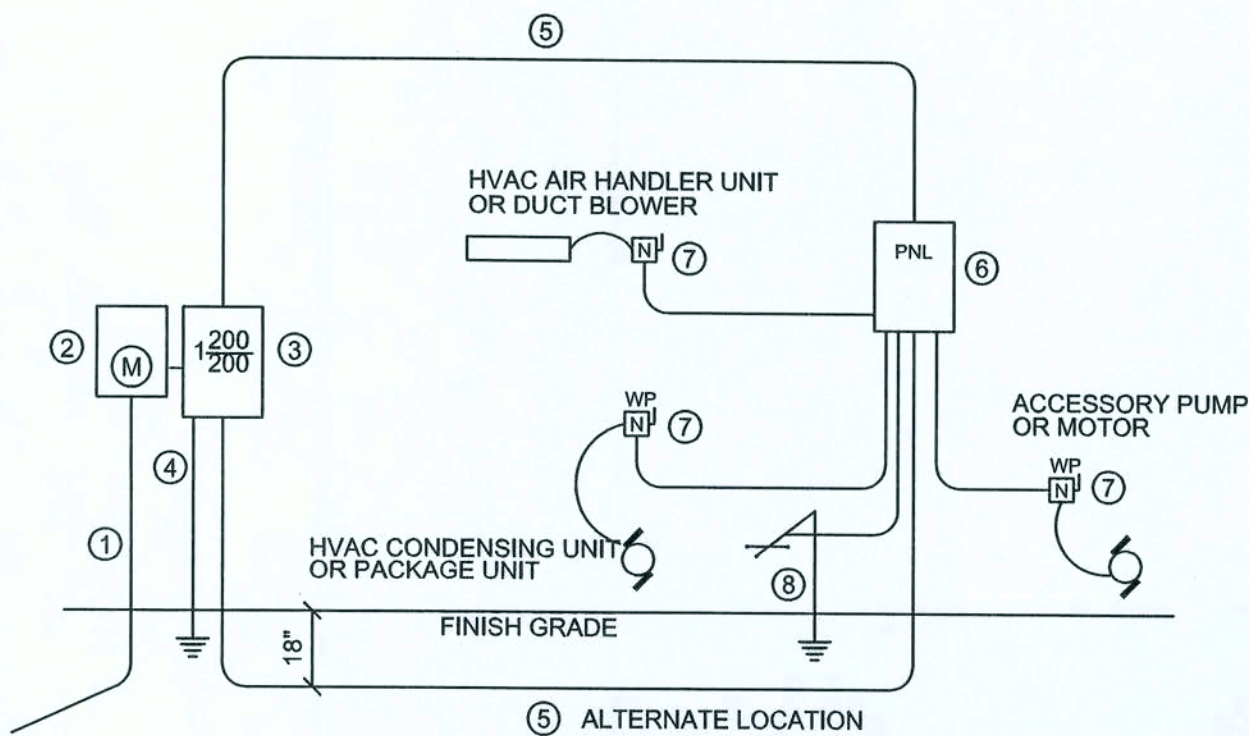

- ① SERVICE/FEEDER ENTRANCE CONDUCTORS: 2.5" RIGID CONDUIT, MIN. 18" DEEP, W/ CONTINUOUS GROUND BONDING CONDUCTOR. SERVICE/ENTRANCE CONDUCTORS SHALL NOT BE SPICED EXCEPT THAT BOLTED CONNECTIONS AT THE METER, DISCONNECTING DEVICES AND PANEL SHALL BE ALLOWED.
- ② METER ENCLOSURE, WEATHERPROOF, U.L. LISTED.
- ③ MAIN DISCONNECT SWITCH: FUSED OR MAIN BRKR, WEATHERPROOF, U.L. LISTED.
- ④ SERVICE ENTRANCE GROUND: 1" - IRON/STEEL ROD X 8'-0" LONG AND/OR CONCRETE ENCASED FOUNDATION STEEL REBAR X 20'-0" LONG. GROUNDING CONDUCTOR SHALL BE BONDED TO EACH PIECE OF SERVICE/ENTRANCE EQUIPMENT, AND SHALL BE SIZED PER ITEM #5, BELOW.
- ⑤ 150 AMPERE SERVICE: 3-#3/0-USE-CU, 1-#4-CU-GND, 2.5" CONDUIT.
- ⑥ SERVICE PANEL (PNL), U.L. LISED, SIZED PER SCHEDULE.
- ⑦ EQUIPMENT DISCONNECT SWITCH: NON-FUSED, IN WEATHERPROOF ENCLOSURE, SIZE ACCORDING TO PANEL SCHEDULE LOADS.
- ⑧ PROVIDE GROUND BOND WIRE TO METAL PIPING, SIZE IN ACCORDANCE WITH THE SERVICE GROUND CONDUCTOR.

NOTE!
THE MINIMUM AIC RATING FOR PANEL BOARDS, BRKRS
AND DISCONNECT SWITCHES SHALL BE 22,000 AIC.

ELECTRICAL COMPUTATIONS

Lighting @ 1.25 FACTOR
(600 x 3 x 3) 6750 VA
MOTOR (HVAC) 17,568 VA

Total Demand Load: 24,318 VA

SUB-PANEL
FEEDER SIZE: 24,318 w / 240 v = 101 amperes (150 AMP)

MIN. USE:
CONDUCTOR SIZE: 1 Cu
2/0 Al
NEUTRAL CONDUCTOR: 1 Cu
2/0 Al
GROUND: 6 Cu
4 Al

ELECTRICAL PANEL FOR BLDG. 001-06

PANEL									
10,000 AMPS. RMS. SYM. I.C. INTEGRATED EQUIPMENT RATING									
— / — VOLTS. — PHASE. — WIRE. 150 AMP. — MAIN BREAKER — FLUSH MOUNTED									
SERVES									
VA	TRIP	WIRE	VA	TRIP	WIRE	VA	TRIP	WIRE	SERVES
1	2	20	1	2	20	1	2	20	LIGHTS
3	4	20	3	4	20	3	4	20	LIGHTS
5	8	20	5	8	20	5	8	20	LIGHTS
7	8	20	7	8	20	7	8	20	LIGHTS
9	10	20	9	10	20	9	10	20	LIGHTS
11	12	20	11	12	20	11	12	20	LIGHTS
13	14	20	13	14	20	13	14	20	LIGHTS
15	16	20	15	16	20	15	16	20	LIGHTS
17	18	20	17	18	20	17	18	20	LIGHTS
19	20	20	19	20	20	19	20	20	LIGHTS
21	22	20	21	22	20	21	22	20	LIGHTS
23	24	20	23	24	20	23	24	20	LIGHTS
25	26	20	25	26	20	25	26	20	LIGHTS
27	28	20	27	28	20	27	28	20	LIGHTS
29	30	20	29	30	20	29	30	20	LIGHTS
31	32	20	31	32	20	31	32	20	LIGHTS
33	34	20	33	34	20	33	34	20	LIGHTS
35	36	20	35	36	20	35	36	20	LIGHTS
37	38	20	37	38	20	37	38	20	LIGHTS
39	40	20	39	40	20	39	40	20	LIGHTS
41	42	20	41	42	20	41	42	20	LIGHTS

ELECTRICAL PANEL FOR BLDGS. 002-06,
003-06, 004-06, & 006-06

PANEL									
10,000 AMPS. RMS. SYM. I.C. INTEGRATED EQUIPMENT RATING									
— / — VOLTS. — PHASE. — WIRE. 150 AMP. — MAIN BREAKER — FLUSH MOUNTED									
SERVES									
VA	TRIP	WIRE	VA	TRIP	WIRE	VA	TRIP	WIRE	SERVES
1	2	20	1	2	20	1	2	20	LIGHTS
3	4	20	3	4	20	3	4	20	LIGHTS
5	8	20	5	8	20	5	8	20	LIGHTS
7	8	20	7	8	20	7	8	20	LIGHTS
9	10	20	9	10	20	9	10	20	LIGHTS
11	12	20	11	12	20	11	12	20	LIGHTS
13	14	20	13	14	20	13	14	20	LIGHTS
15	16	20	15	16	20	15	16	20	LIGHTS
17	18	20	17	18	20	17	18	20	LIGHTS
19	20	20	19	20	20	19	20	20	LIGHTS
21	22	20	21	22	20	21	22	20	LIGHTS
23	24	20	23	24	20	23	24	20	LIGHTS
25	26	20	25	26	20	25	26	20	LIGHTS
27	28	20	27	28	20	27	28	20	LIGHTS
29	30	20	29	30	20	29	30	20	LIGHTS
31	32	20	31	32	20	31	32	20	LIGHTS
33	34	20	33	34	20	33	34	20	LIGHTS
35	36	20	35	36	20	35	36	20	LIGHTS
37	38	20	37	38	20	37	38	20	LIGHTS
39	40	20	39	40	20	39	40	20	LIGHTS
41	42	20	41	42	20	41	42	20	LIGHTS

ELECTRICAL PANEL FOR BLDG. 007-06

PANEL									
10,000 AMPS. RMS. SYM. I.C. INTEGRATED EQUIPMENT RATING									
— / — VOLTS. — PHASE. — WIRE. 150 AMP. — MAIN BREAKER — FLUSH MOUNTED									
SERVES									
VA	TRIP	WIRE	VA	TRIP	WIRE	VA	TRIP	WIRE	SERVES
1	2	20	1	2	20	1	2	20	LIGHTS
3	4	20	3	4	20	3	4	20	LIGHTS
5	8	20	5	8	20	5	8	20	LIGHTS
7	8	20	7	8	20	7	8	20	LIGHTS
9	10	20	9	10	20	9	10	20	LIGHTS
11	12	20	11	12	20	11	12	20	LIGHTS
13	14	20	13	14	20	13	14	20	LIGHTS
15	16	20	15	16	20	15	16	20	LIGHTS
17	18	20	17	18	20	17	18	20	LIGHTS
19	20	20	19	20	20	19	20	20	LIGHTS
21	22	20	21	22	20	21	22	20	LIGHTS
23	24	20	23	24	20	23	24	20	LIGHTS
25	26	20	25	26	20	25	26	20	LIGHTS
27	28	20	27	28	20	27	28	20	LIGHTS
29	30	20	29	30	20	29	30	20	LIGHTS
31	32	20	31	32	20	31	32	20	LIGHTS
33	34	20	33	34	20	33	34	20	LIGHTS
35	36	20	35	36	20	35	36	20	LIGHTS
37	38	20	37	38	20	37	38	20	LIGHTS
39	40	20	39	40	20	39	40	20	LIGHTS
41	42	20	41	42	20	41	42	20	LIGHTS

REVISION NOTES
ISSUED FOR
CONSTRUCTION

REV # DATE
- 08-28-06

P.O. Box 187
130 West Howard Street
Live Oak, FL 32064
Phone: (386) 362-3678
Fax: (386) 362-6133
STRUCTURAL/CIVIL ENGINEERS Gary Gill, PE 51942
Auth. # 9461



MINI STORAGE
OF COLUMBIA COUNTY
NEW BUILDINGS
COLUMBIA COUNTY, FLORIDA

MECHANICAL
& ELECTRICAL NOTES

PROJECT NUMBER
PF05-338
DRAWN BY
D. PRICE
CHECKED BY
G.G.

S-1