


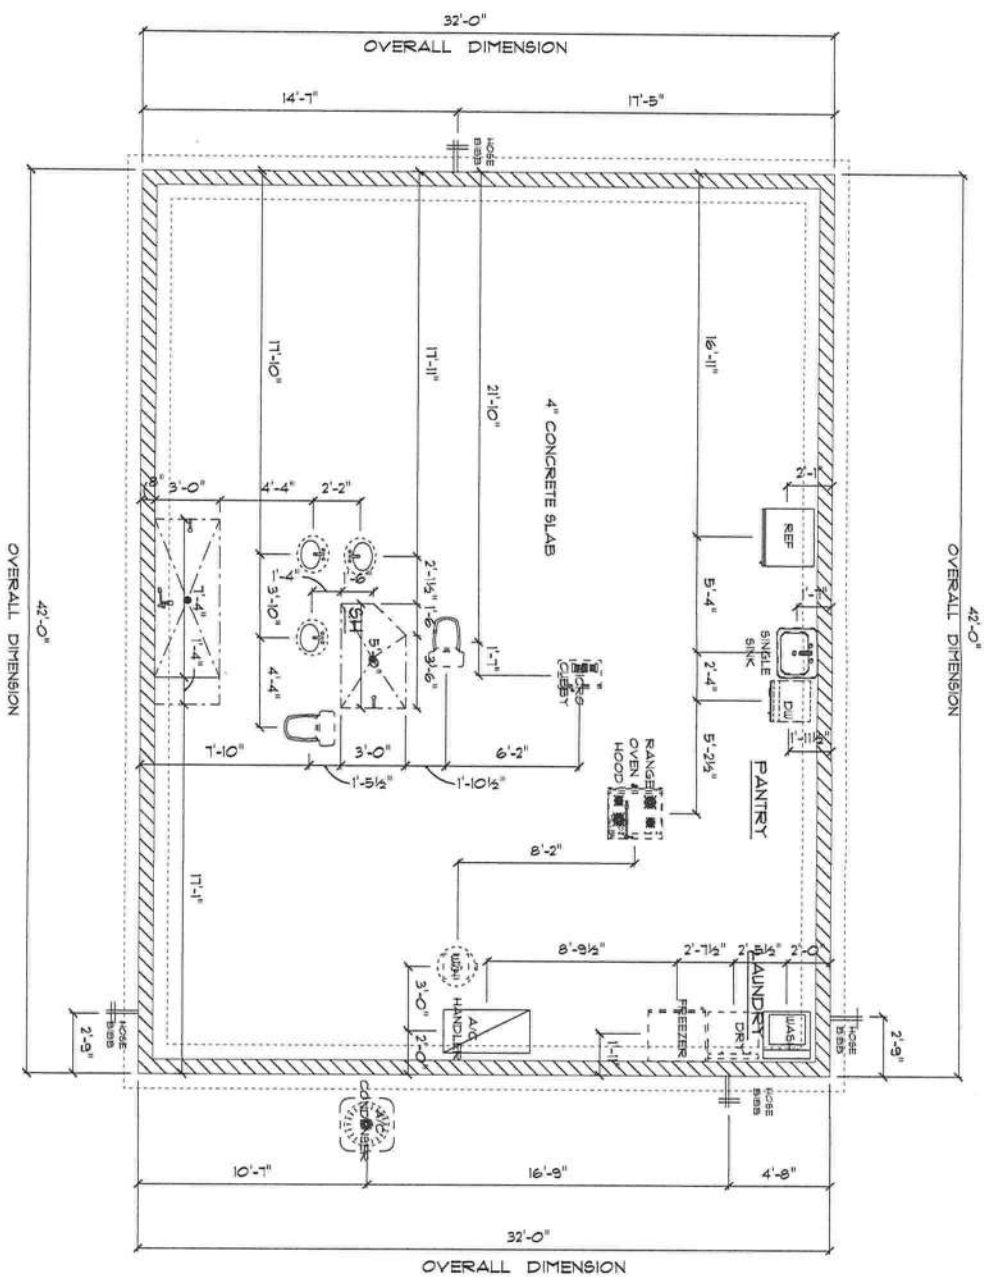

FOUNDATION / PLUMBING PLAN

SCALE : 1/4" = 1'-0"

IMPORTANT NOTES:
1. IT IS THE BUILDER'S RESPONSIBILITY TO VERIFY ALL GEOMETRY AND DIMENSIONS BEFORE ORDERING ANY MATERIALS OR BEGINNING CONSTRUCTION.
2. THESE PLANS ARE FOR LAYOUT AND DESIGN PURPOSES ONLY. ALL STRUCTURAL NOTES AND DETAILS TO BE PROVIDED BY AN ENGINEER.

RESIDENCE

for

CHRIS & WEIDUS

HOUSE

OAK HATPOCK

LOT #4

LAKE CITY, FLORIDA

Teresa M. Ruffo
2925 SW SR 41
Lake City, Florida 32025
Cell: (386) 867 - 1131
Email: tera@ruffo.com

PRINTED DATE:

Wednesday, June 22, 2022

DRAWN BY: T. RUFFO

CHECKED BY: T. RUFFO

BUILDING CONTRACTOR:

GLENNWOOD KING


FINAL DATE:

JOB NUMBER:

DRAWING NUMBER

A-2

OF 6 SHEETS

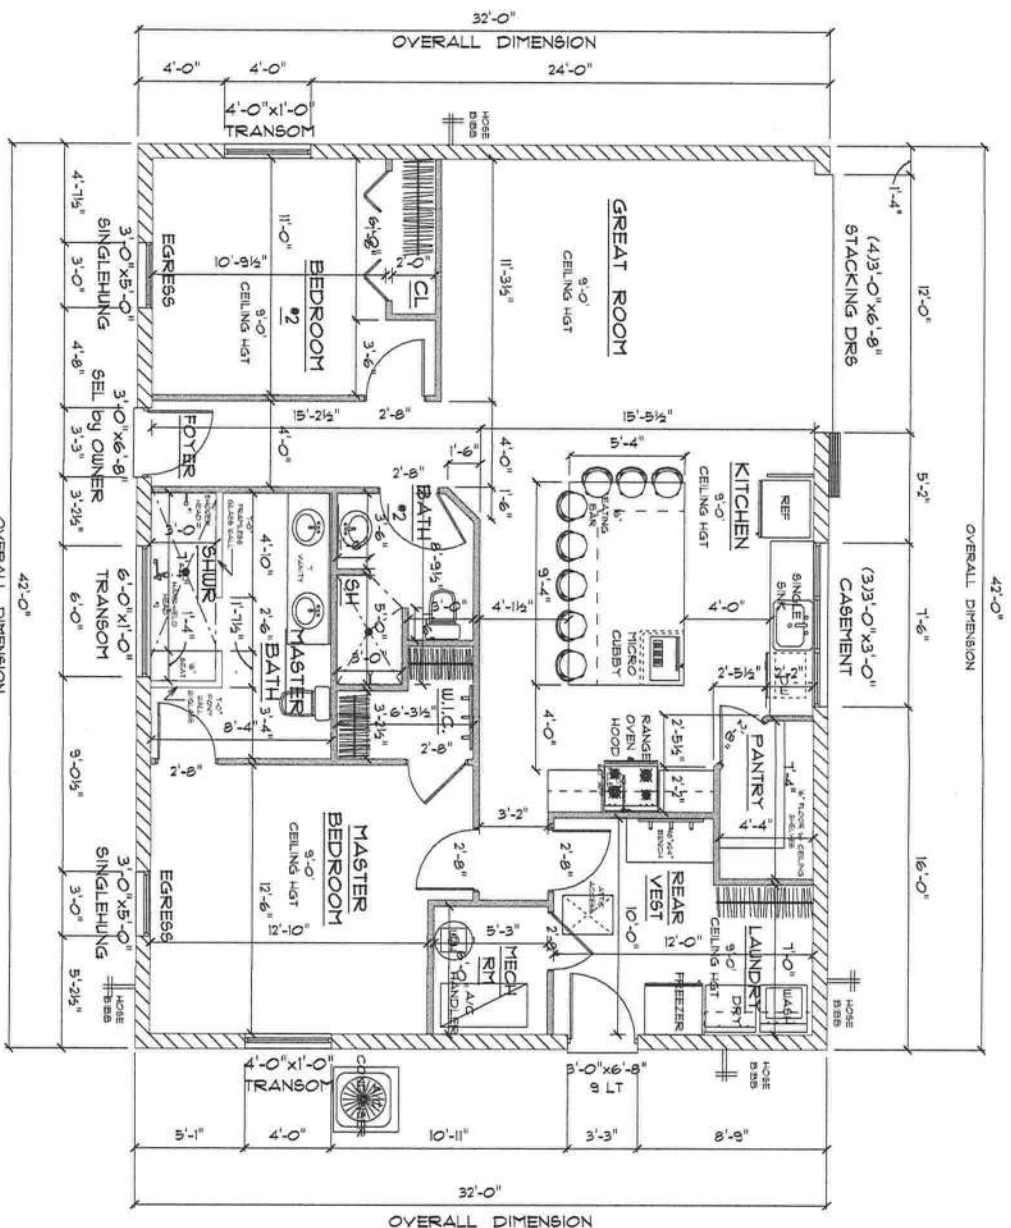


* FLOOR PLAN *

SCALE : 1/4" = 1'-0"

IMPORTANT NOTE:
1. IT IS THE BUILDER'S RESPONSIBILITY TO VERIFY ALL GEOMETRY AND DIMENSIONS BEFORE ORDERING ANY MATERIALS OR BEGINNING CONSTRUCTION.
2. THESE PLANS ARE FOR LAYOUT AND DESIGN PURPOSES ONLY. ALL STRUCTURAL NOTES AND DETAILS TO BE PROVIDED BY AN ENGINEER.


A/C LIVING AREA	= 1344 S.F.
TOTAL AREA UNDER ROOF	= 1,344 S.F.

RESIDENCE for CHRIS & WEIDUS SHOUSE	
OAK HARBOR LOT #2 LAKE CITY, FLORIDA	
TERRY M. RUFFO 2505 5th Ave. 4T Lake City Florida 33709 Call: (352) 867-1191 Email: terrymruffo@gmail.com	
PRINTED DATE: Wednesday, June 22, 2022	DRAWN BY: TERRY M. RUFFO
CHECKED BY: GLENNWOOD KING	DATE: JUN 22, 2022
JOB NUMBER: A-3	
DRAWING NUMBER: OF 6 SHEETS	

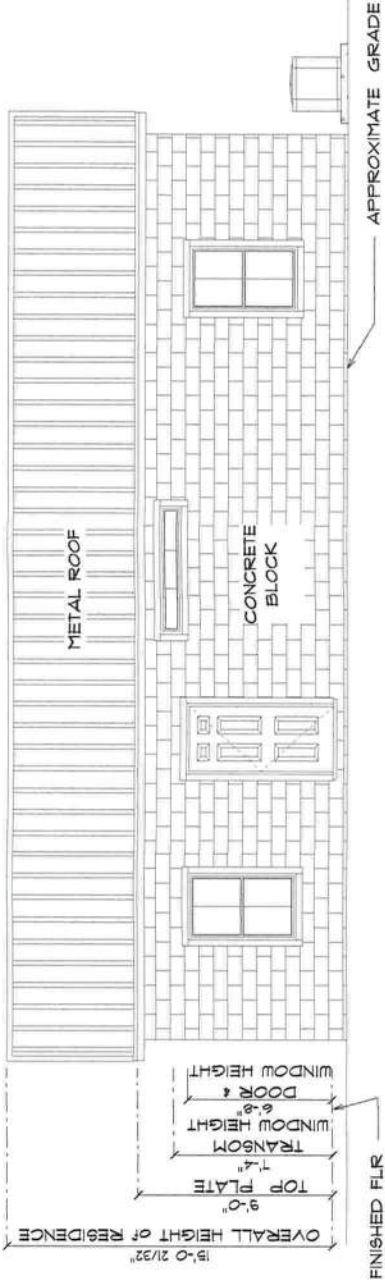

* FRONT ELEVATION *

SCALE : 1/4" = 1'-0"

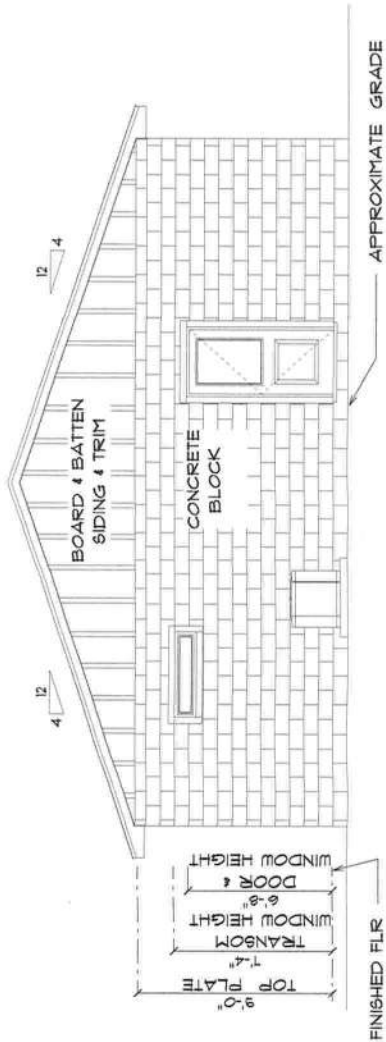

* RIGHT ELEVATION *

SCALE : 1/4" = 1'-0"

RESIDENCE
for
CHRIS & WEIDUS
SHOUSE
OAK HAMMOCK
LOT #4
LAKE CITY, FLORIDA

Teresa M. Ruffo
2835 6th St. SE
Lake City, Florida 33025
Cell: (386) 867-1191
Email: tsera@ruffo.com

PRINTED DATE:
Wednesday, June 22, 2022

DRAWN BY:
Teresa M. Ruffo


CHECKED BY:
Teresa M. Ruffo

ISSUED CONTRACTOR:
GLENWOOD KING

FINALS DATE:
JOB NUMBER:


DRAWING NUMBER:
A-4

OF 6 SHEETS

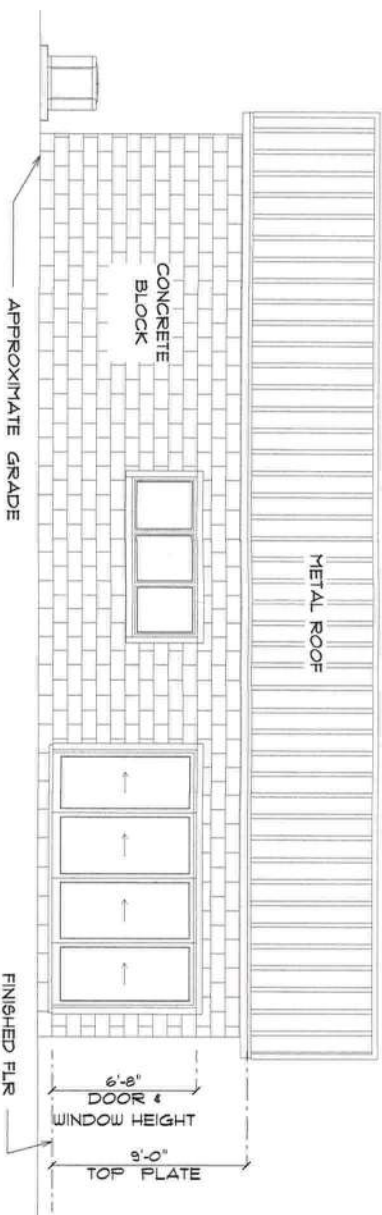

* REAR ELEVATION *

SCALE : 1/4" = 1'-0"

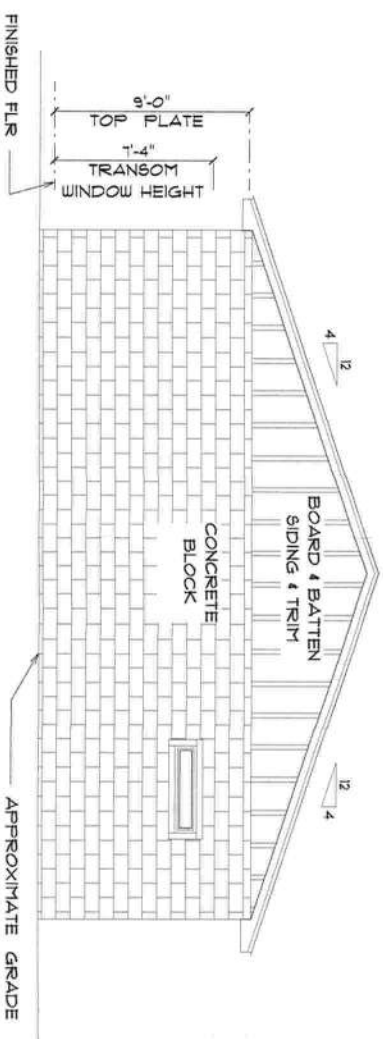


* LEFT ELEVATION *

SCALE : 1/4" = 1'-0"

RESIDENCE	
for	
CHRIS & WEIDIE	
SHOUSE	
OAK HAMMOCK	
LOT #4	
LAKE CITY, FLORIDA	
Teresa M. Ruffo	
20555 SW 11	
Lake City, Florida 32025	
Cell: (386) 867-1191	
Email: teresa@torgmail.com	
PROJECT DATE: Wednesday, June 22, 2022	
DRAWN BY: T.M. Ruffo	CHECKED BY:
SALING CONTRACTOR:	
GLENWOOD KING	
FINAL DATE:	
JOB NUMBER:	
DRAWING NUMBER	
A-5	
OF 6 SHEETS	

ELECTRICAL LEGEND		
ELECTRICAL	COUNT	SYMBOL
ceiling fan globe 01	3	
pendant large	5	
spotlight double	4	
wall mount savoy	2	
Smoke Detector	4	
dimmer switch	2	
light	10	
outlet	27	
outlet 220v	3	
outlet gfi	17	
outlet wp	7	
switch	20	
switch 3 way	4	
vent light combo	2	
vanity bar light 02	3	
Cable Ethernet Wall Plate	3	

- ELECTRICAL PLAN NOTES
- E-1 WIRE ALL APPLIANCES, HVAC UNITS AND OTHER EQUIPMENT PER MANUFACTURER'S SPECIFICATIONS.
- E-2 ALL INSTALLATIONS SHALL BE PER NATIONAL ELECTRIC CODE.
- E-3 ALL SMOKE /CARBON MONOXIDE DETECTORS SHALL BE BOW /BATTERY BACKUP OF THE PHOTOELECTRIC TYPE AND SHALL BE INTERLOCKED TOGETHER. INSTALL INSIDE AND NEAR ALL BEDROOMS AS PER CODE.
- E-4 TELEPHONE, TELEVISION AND OTHER LOW VOLTAGE DEVICES OR OUTLETS SHALL BE AS PER THE OWNER'S DIRECTION AND IN ACCORDANCE WITH APPLICABLE SECTIONS OF NATIONAL ELEC. CODE LATEST EDITION.
- E-5 ELECTRICAL CONTRACTOR SHALL BE RESPONSIBLE FOR THE DESIGN AND SIZING OF ELECTRICAL SERVICE AND CIRCUITS.
- E-6 ENTRY OF SERVICE UNDERGROUND OR OVERHEAD) IS TO BE DETERMINED BY THE POWER COMPANY.
- ALL BEDROOM RECEPTALS ARE TO BE AFCI (ARC FAULT CIRCUIT INTERRUPT)
- 75% OF ALL PERMANENT LIGHTS TO BE ENERGY EFFICIENT.

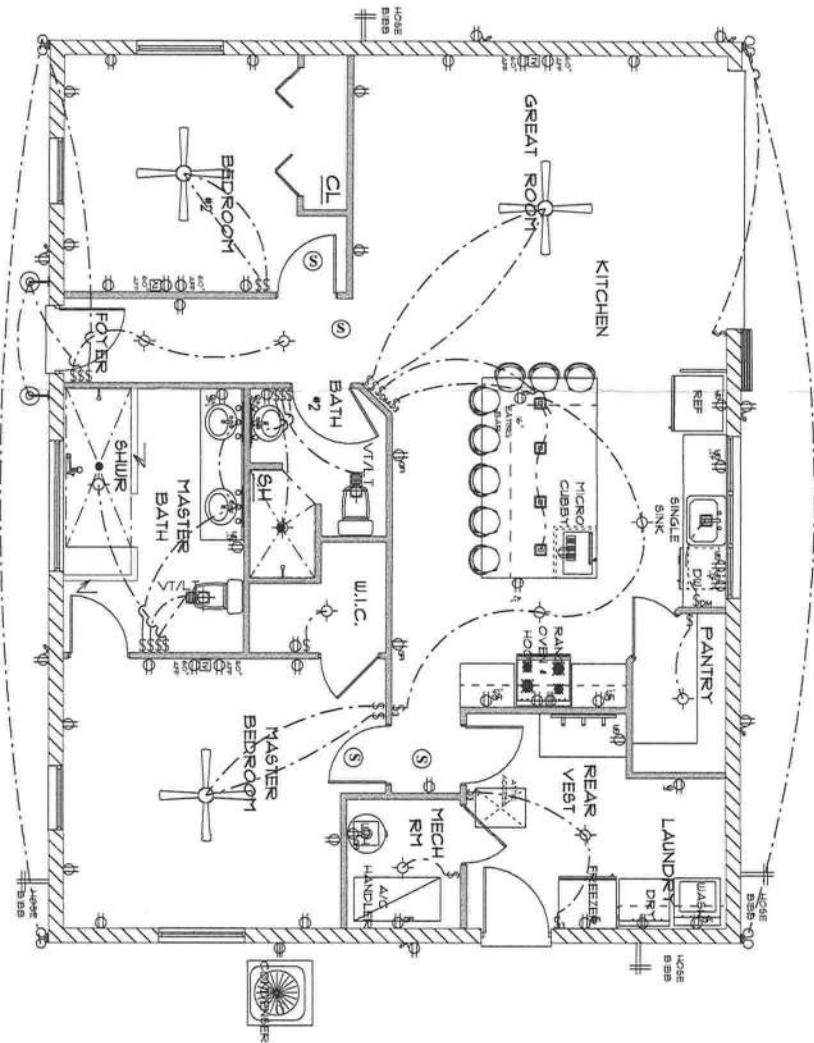

* ELECTRICAL PLAN *

SCALE : 1/4" = 1'-0"

RESIDENCE

for

CHRIS & WEIDUS

SHOUSE

OAK HARBORCK

LOT #4

LAKE CITY, FLORIDA

TERRY M. RUFFO

7200 S.W. 11TH AVE

LAKE CITY, FLORIDA 33505

Cell: (386) 867-1191

Email: terrymruffo@gmail.com

PRINTED DATE:

Wednesday, June 22, 2022

DRAWN BY:

CHRIS M. RUFFO

CHECKED BY:

GLENNWOOD KING

BUILDING CONTRACTOR:

GLENNWOOD KING

FINALS DATE:

JOB NUMBER:

DRAWING NUMBER:

A-6

OF 6 SHEETS

S 00°17'22" W 230.400'

S 88°35'08" W 928.530'

S 89°22'25" E 918.510'

N 02°01'46" E 243.430'

WESTER ROAD

* SITE PLAN *

SCALE: 1" = 30'-0"



RESIDENCE for CHRIS & WEIDUE SHOUSE	
OAK HARBORCK LOT #4 LAKE CITY, FLORIDA	
Teresa H. Ruffo 2825 SW SR 47 Lake City Florida, 32075 Cell: (386) 261-1191 Email: terraruffo@gmail.com	
PRINTED DATE: Wednesday, June 22, 2022	CHECKED BY: Berna H. Ruffo
BUILDING DEPARTMENT GLENNWOOD KING	
FINAL DATE:	
JOB NUMBER:	
DRAWING NUMBER: A-1	
OF 6 SHEETS	