



Office copy

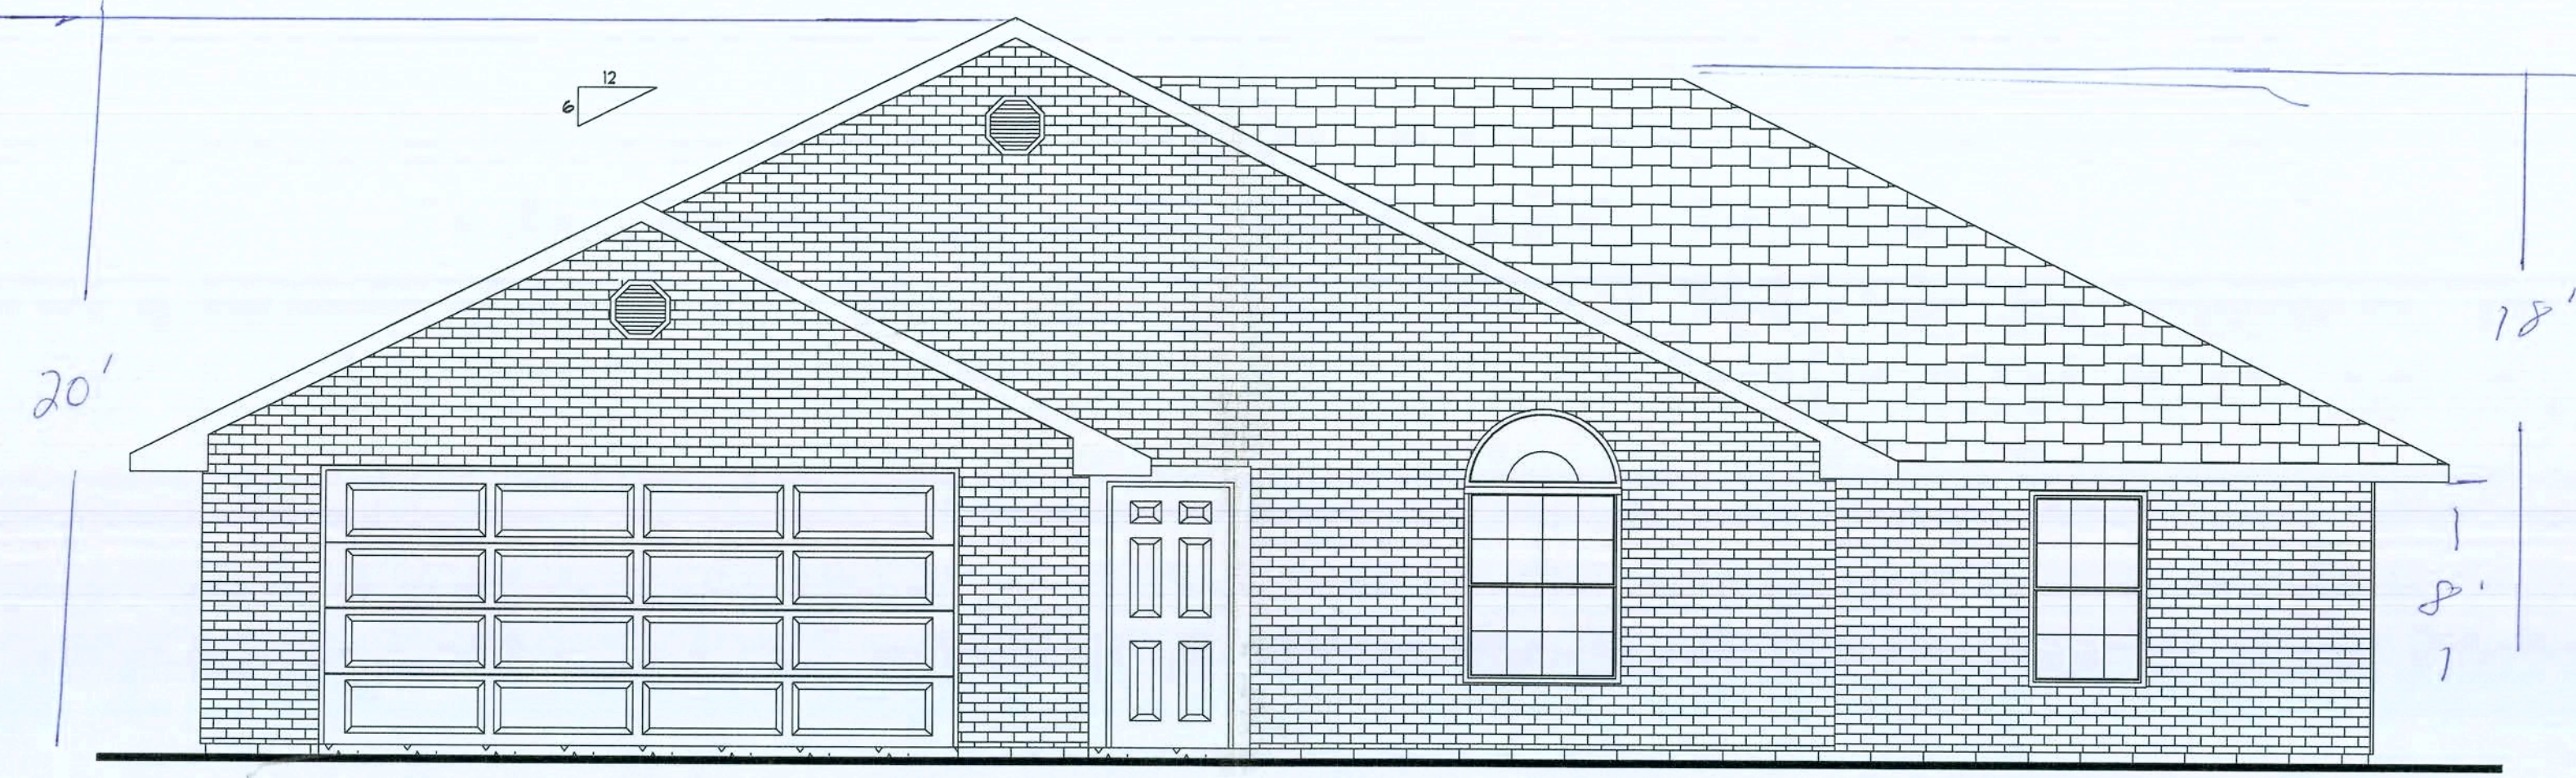


FRONT ELEVATION

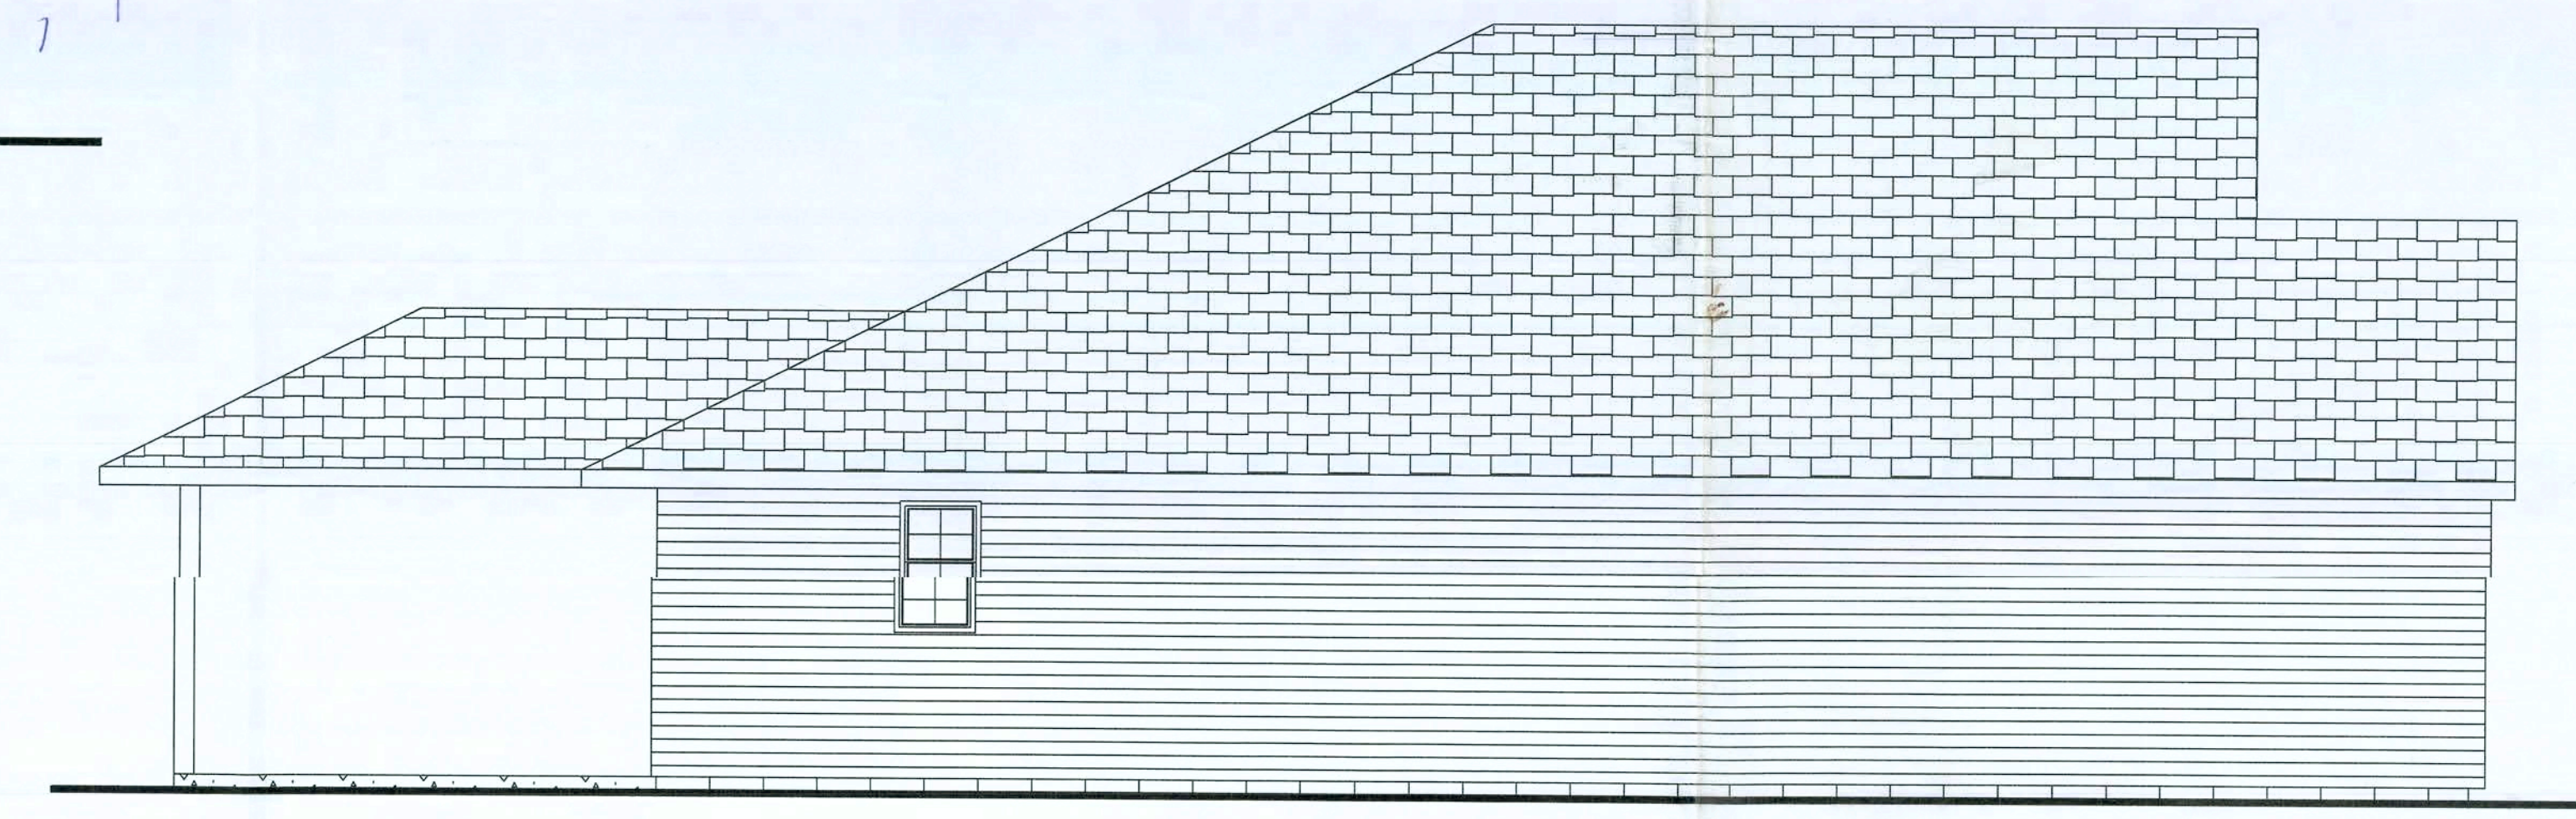

LEFT ELEVATION



REAR ELEVATION

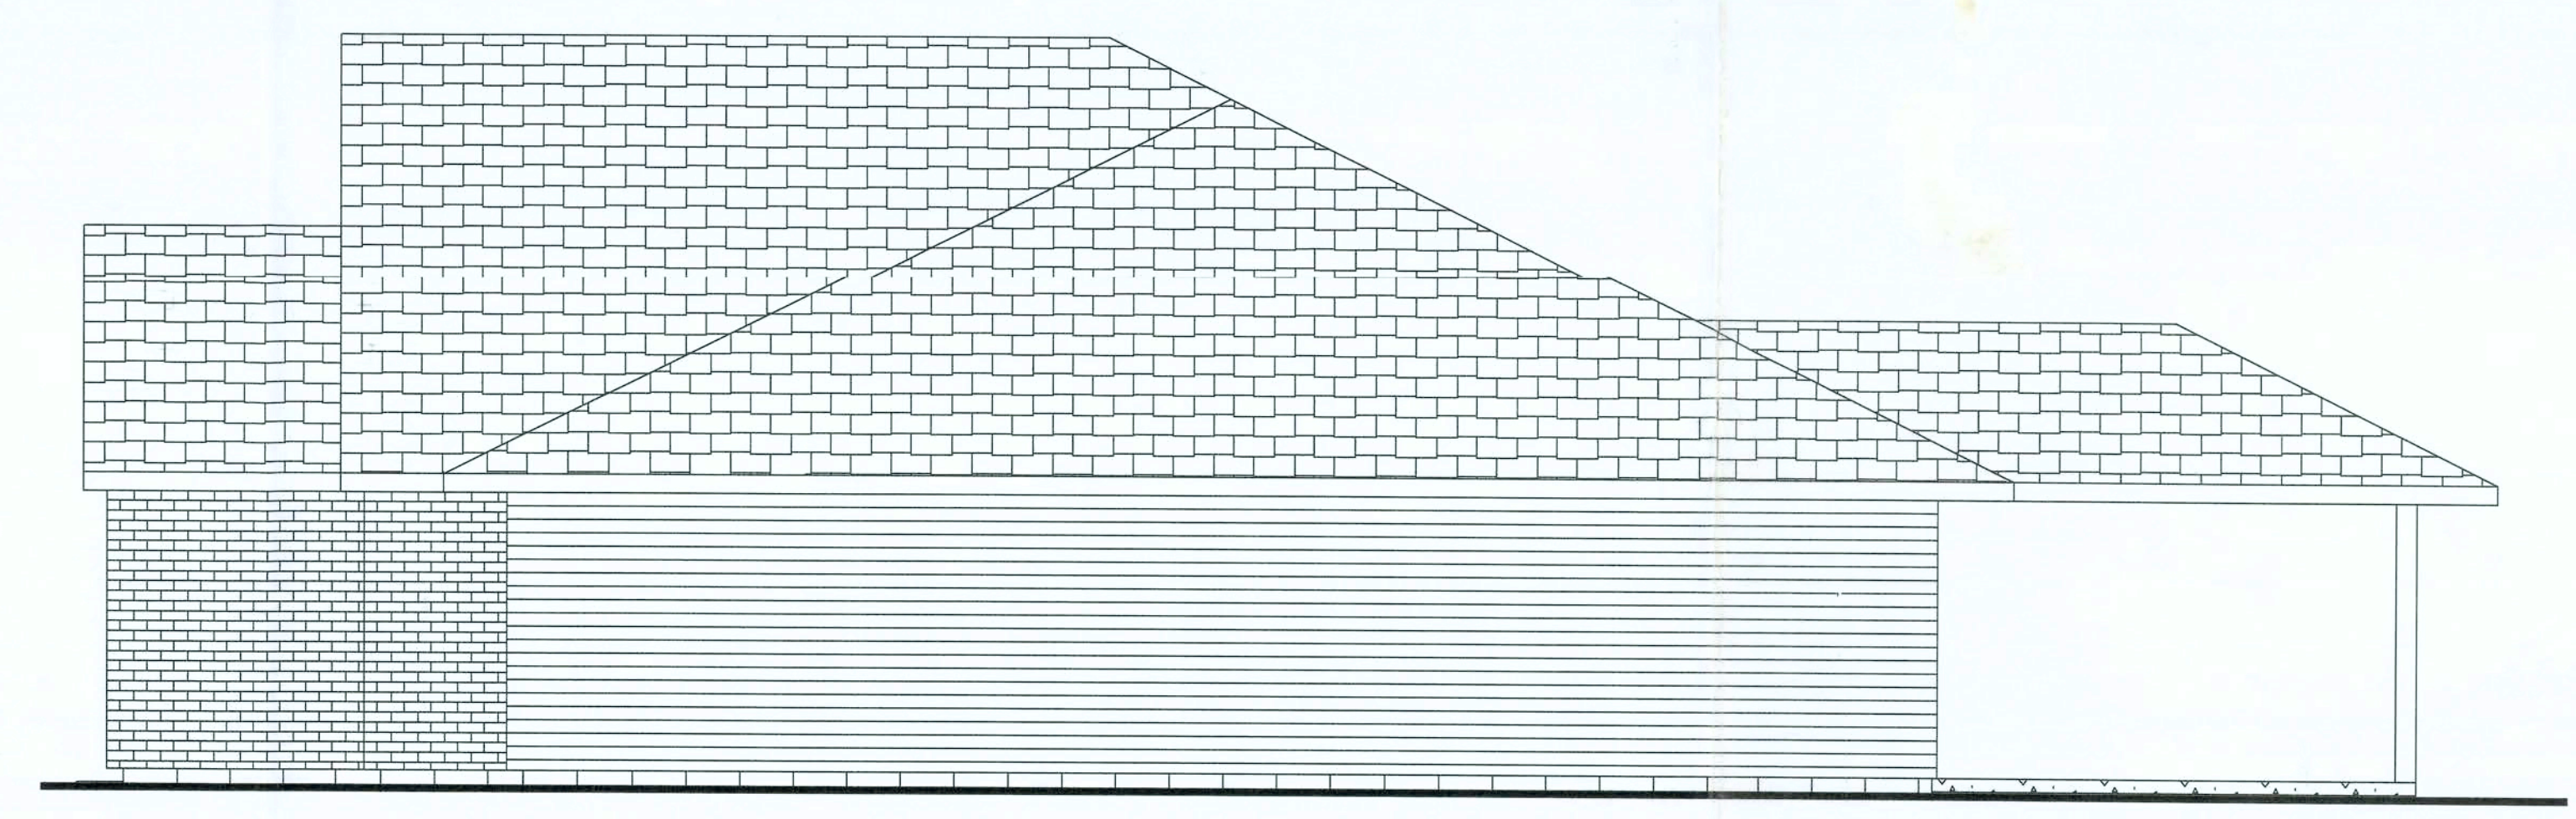

RIGHT ELEVATION

DRAWN BY:
JASON ELIXON CONSTRUCTION, LLC
4853 WEST SR. 238
LAKE BUTLER, FL. 32054
(386) 623-1741

Rolling Meadows Lot 30

GLEN KEEN

COLUMBIA COUNTY

DATE: 09-18-06

ELEVATIONS


SCALE: 1/4" = 1'-0"

PAGE


1

NAME	AREA
HEATED SPACE	1706 sq ft.
GARAGE	514 sq ft.
PORCH	144 sq ft.
ENTRANCE	18 sq ft.
TOTAL	2382 sq ft.


FLOOR PLAN

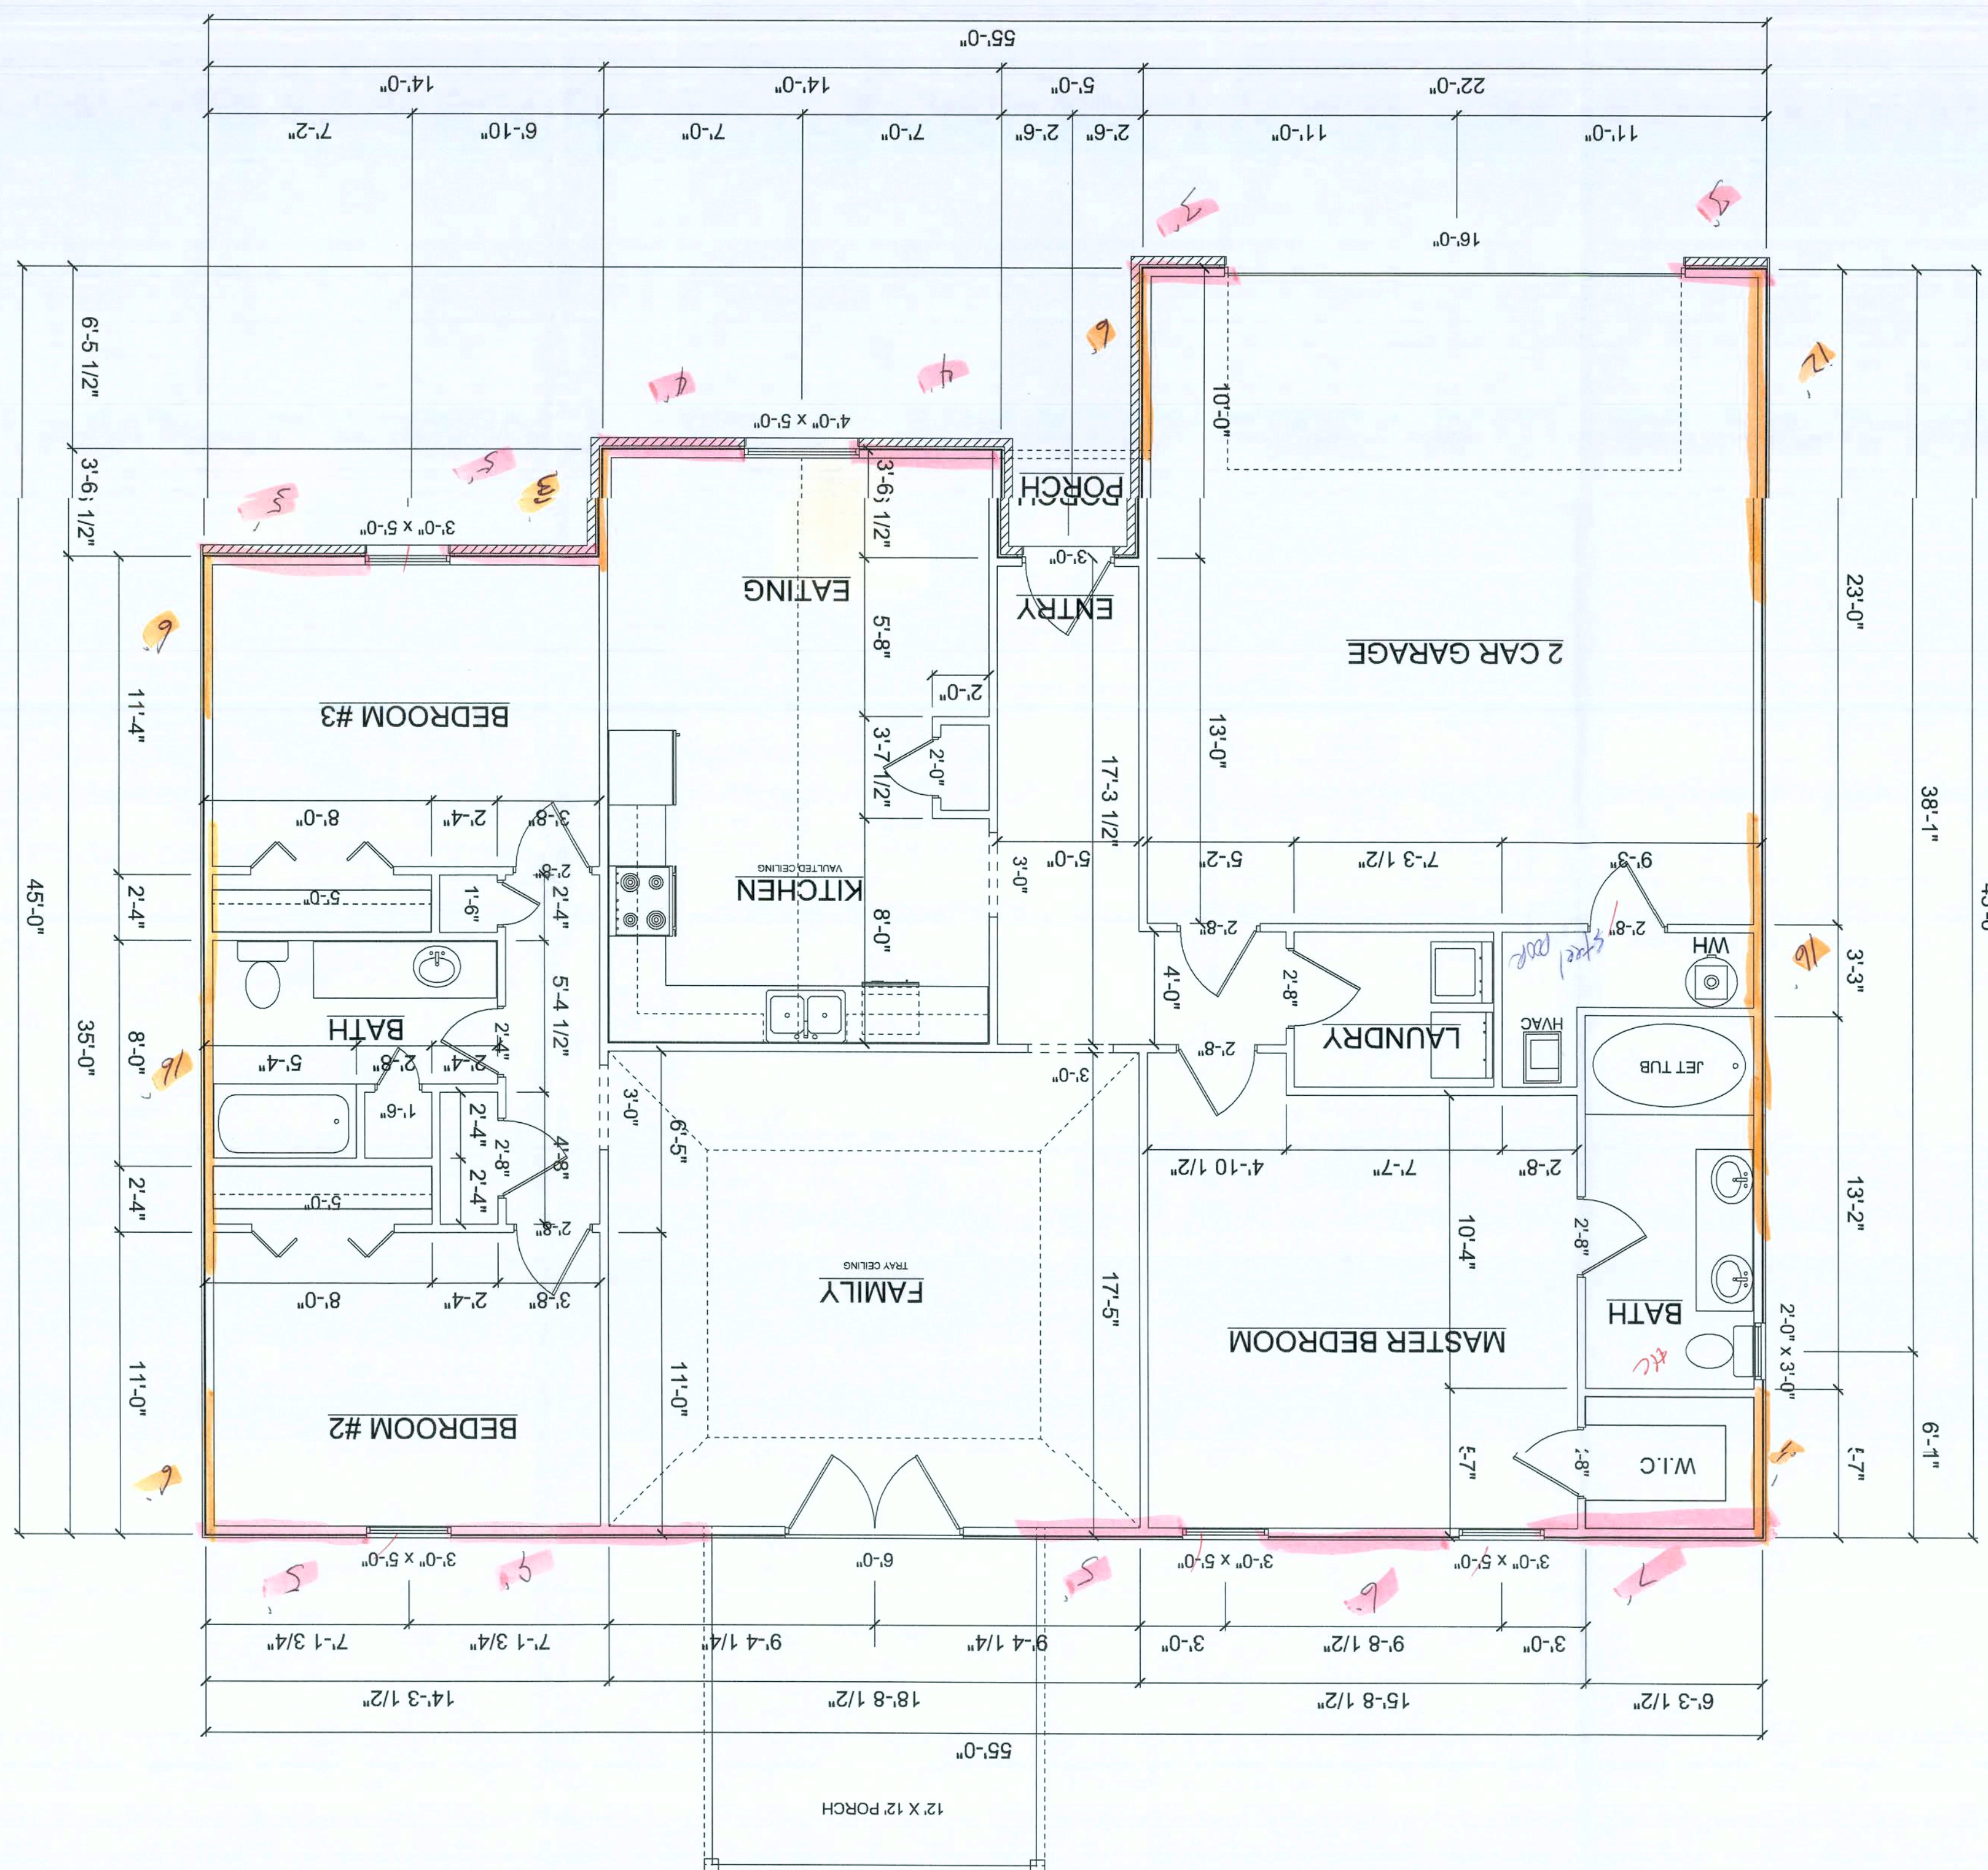

TYPICAL WALL SECTION

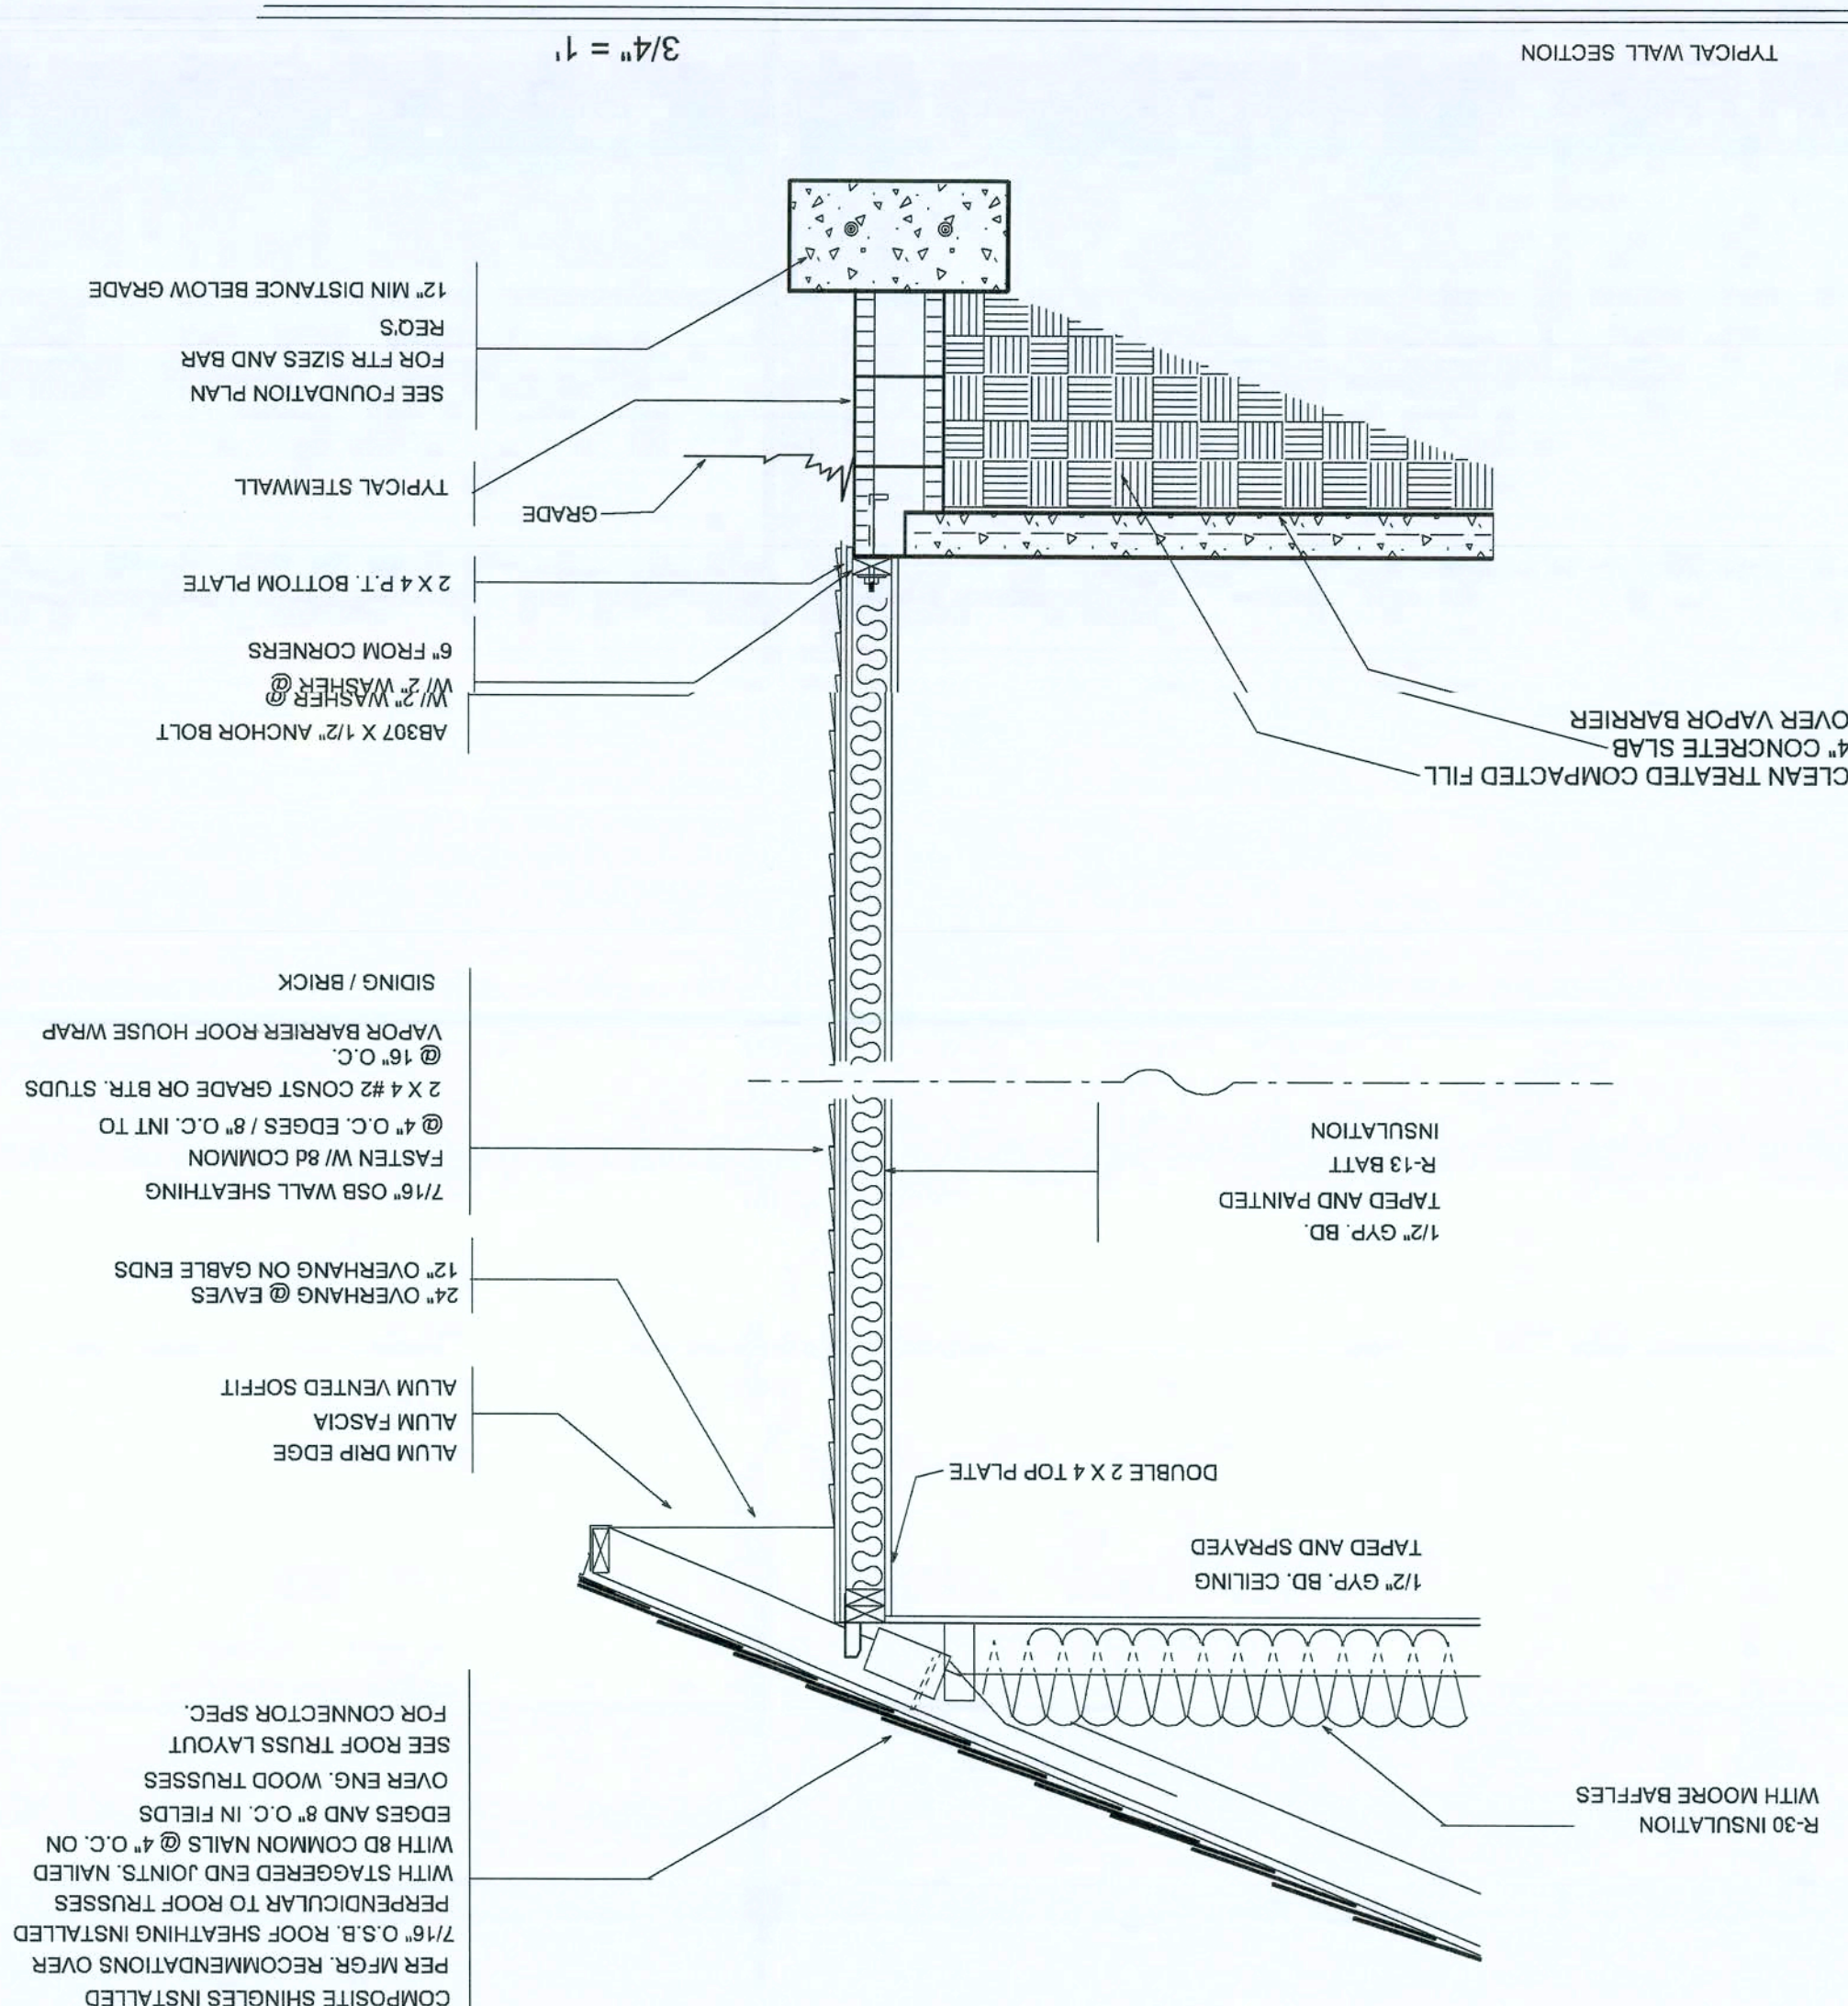

It is important that the Client and Contractor examine the drawings and documentation in detail. It shall be the final responsibility of the Contractor to review and double check the design for any errors or omissions. The Contractor agrees that it is its customer's responsibility to include details within the knowledge of licensed Contractor. If necessary, further clarification of these plans should be achieved before signing the construction contract and the Contractor should determine whether the Contractor assumes responsibility for the construction design. Methods of construction shall be determined by the Contractor.

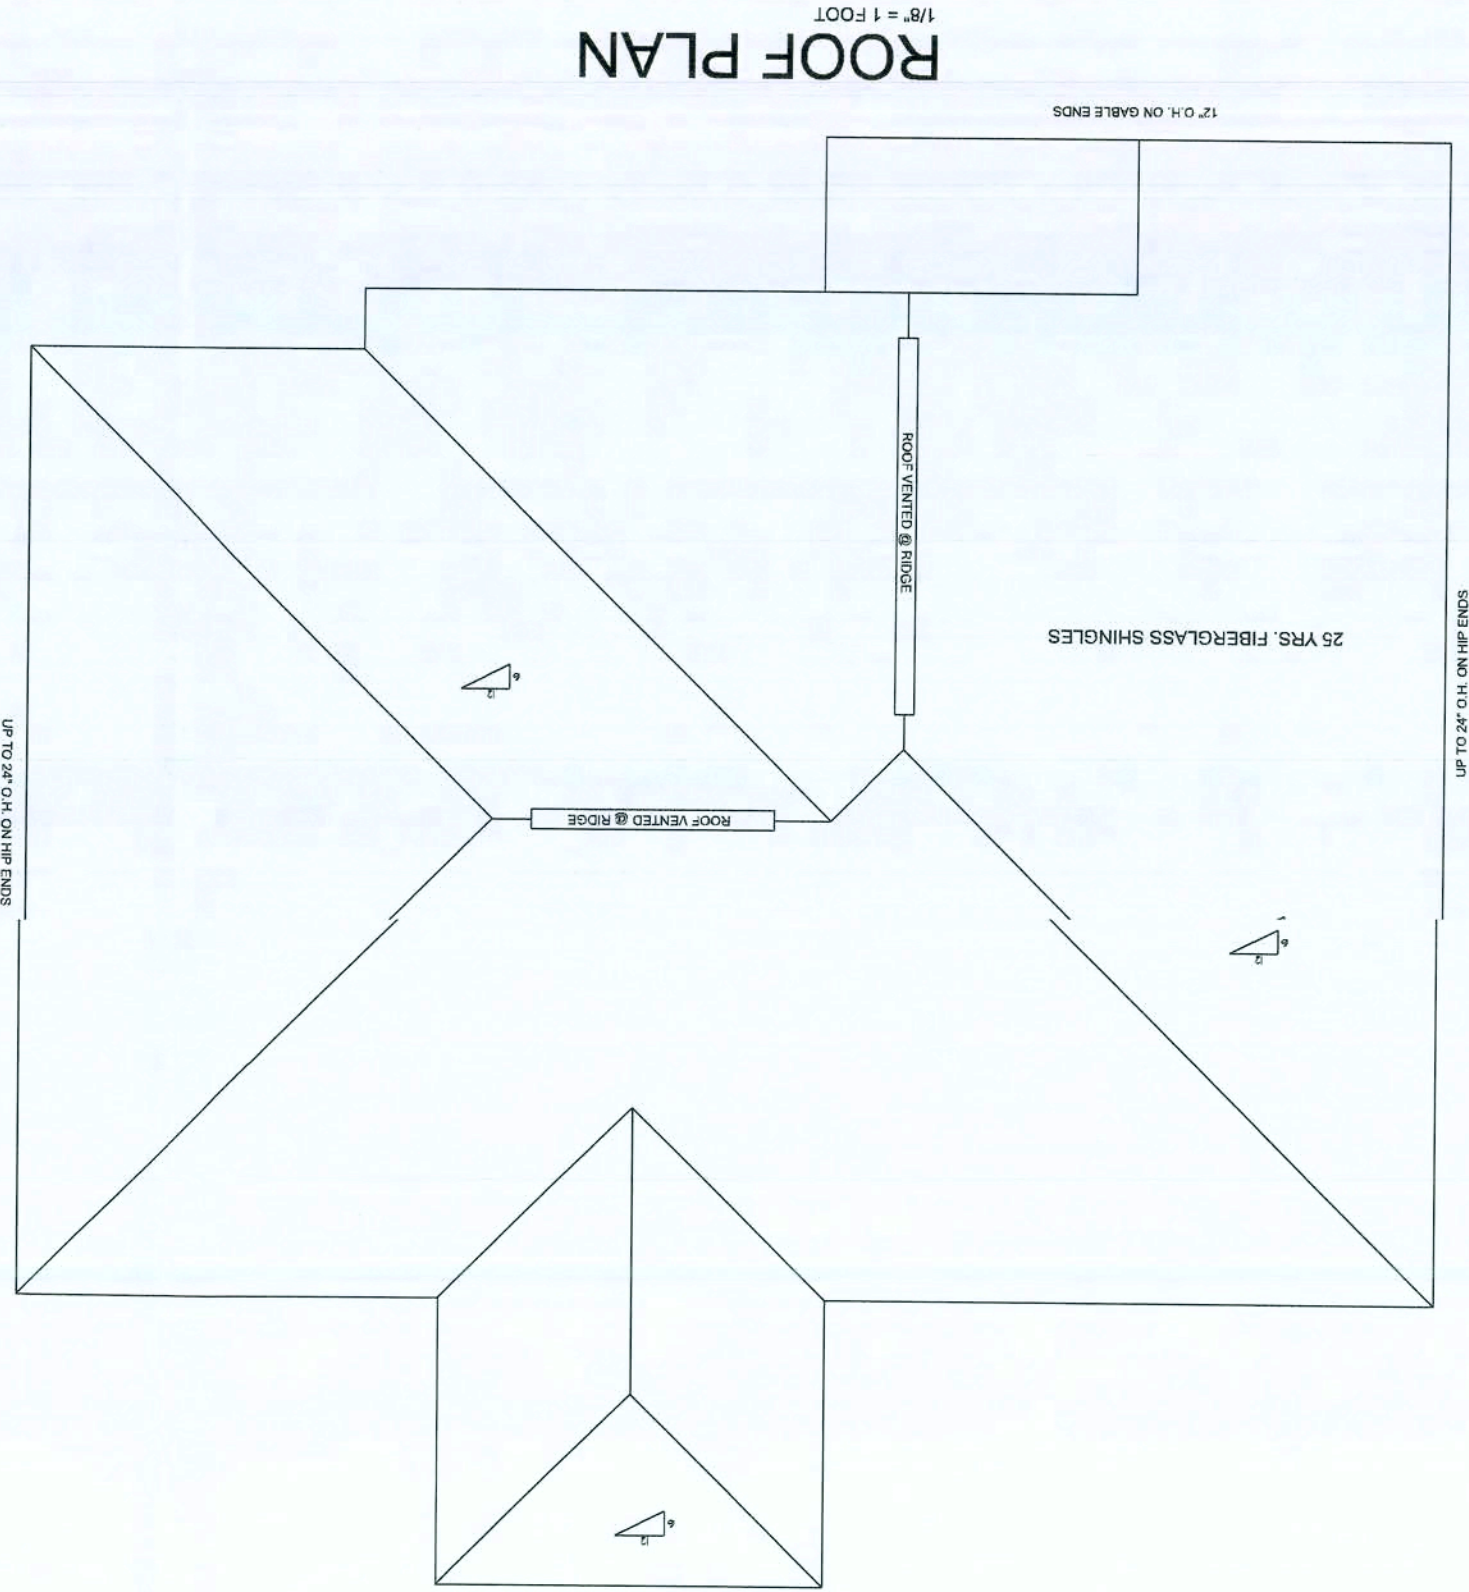

ELECTRICAL	SYMBOL
ceiling fan	
fluorescent fixture	
electrical panel	
fan	
light	
outlet	
outlet 220v	
outlet gfi	
smoke detector	
switch	
switch 3 way	
weather proof GFI	

WIRE ALL APPLIANCES, HVAC UNIT AND OTHER EQUIPMENT PER MANUFACTURER SPECS

INSTALLATION SHALL BE PER NATIONAL ELECTRIC CODE


TELEPHONE, T.V. AND OTHER LOW VOLTAGE DEVICES OR OUTLETS SHALL BE AS PER THE OWNERS DIRECTIONS AND IN ACCORDANCE WITH APPLICABLE SECTIONS OF NEC-LATEST EDITIONS

ALL SMOKE DETECTORS SHALL BE 120V WITH BATTERY BACKUP OF THE PHOTOELECTRIC TYPE, AND SHALL BE INTERLOCKED TOGETHER

ALL MATERIAL SHALL HAVE A UL LABEL OR LISTING

ALL BEDROOM OUTLETS TO BE ARC-FAULT BREAKERS OR GFI OUTLETS

ELECTRICAL PLAN NOTES

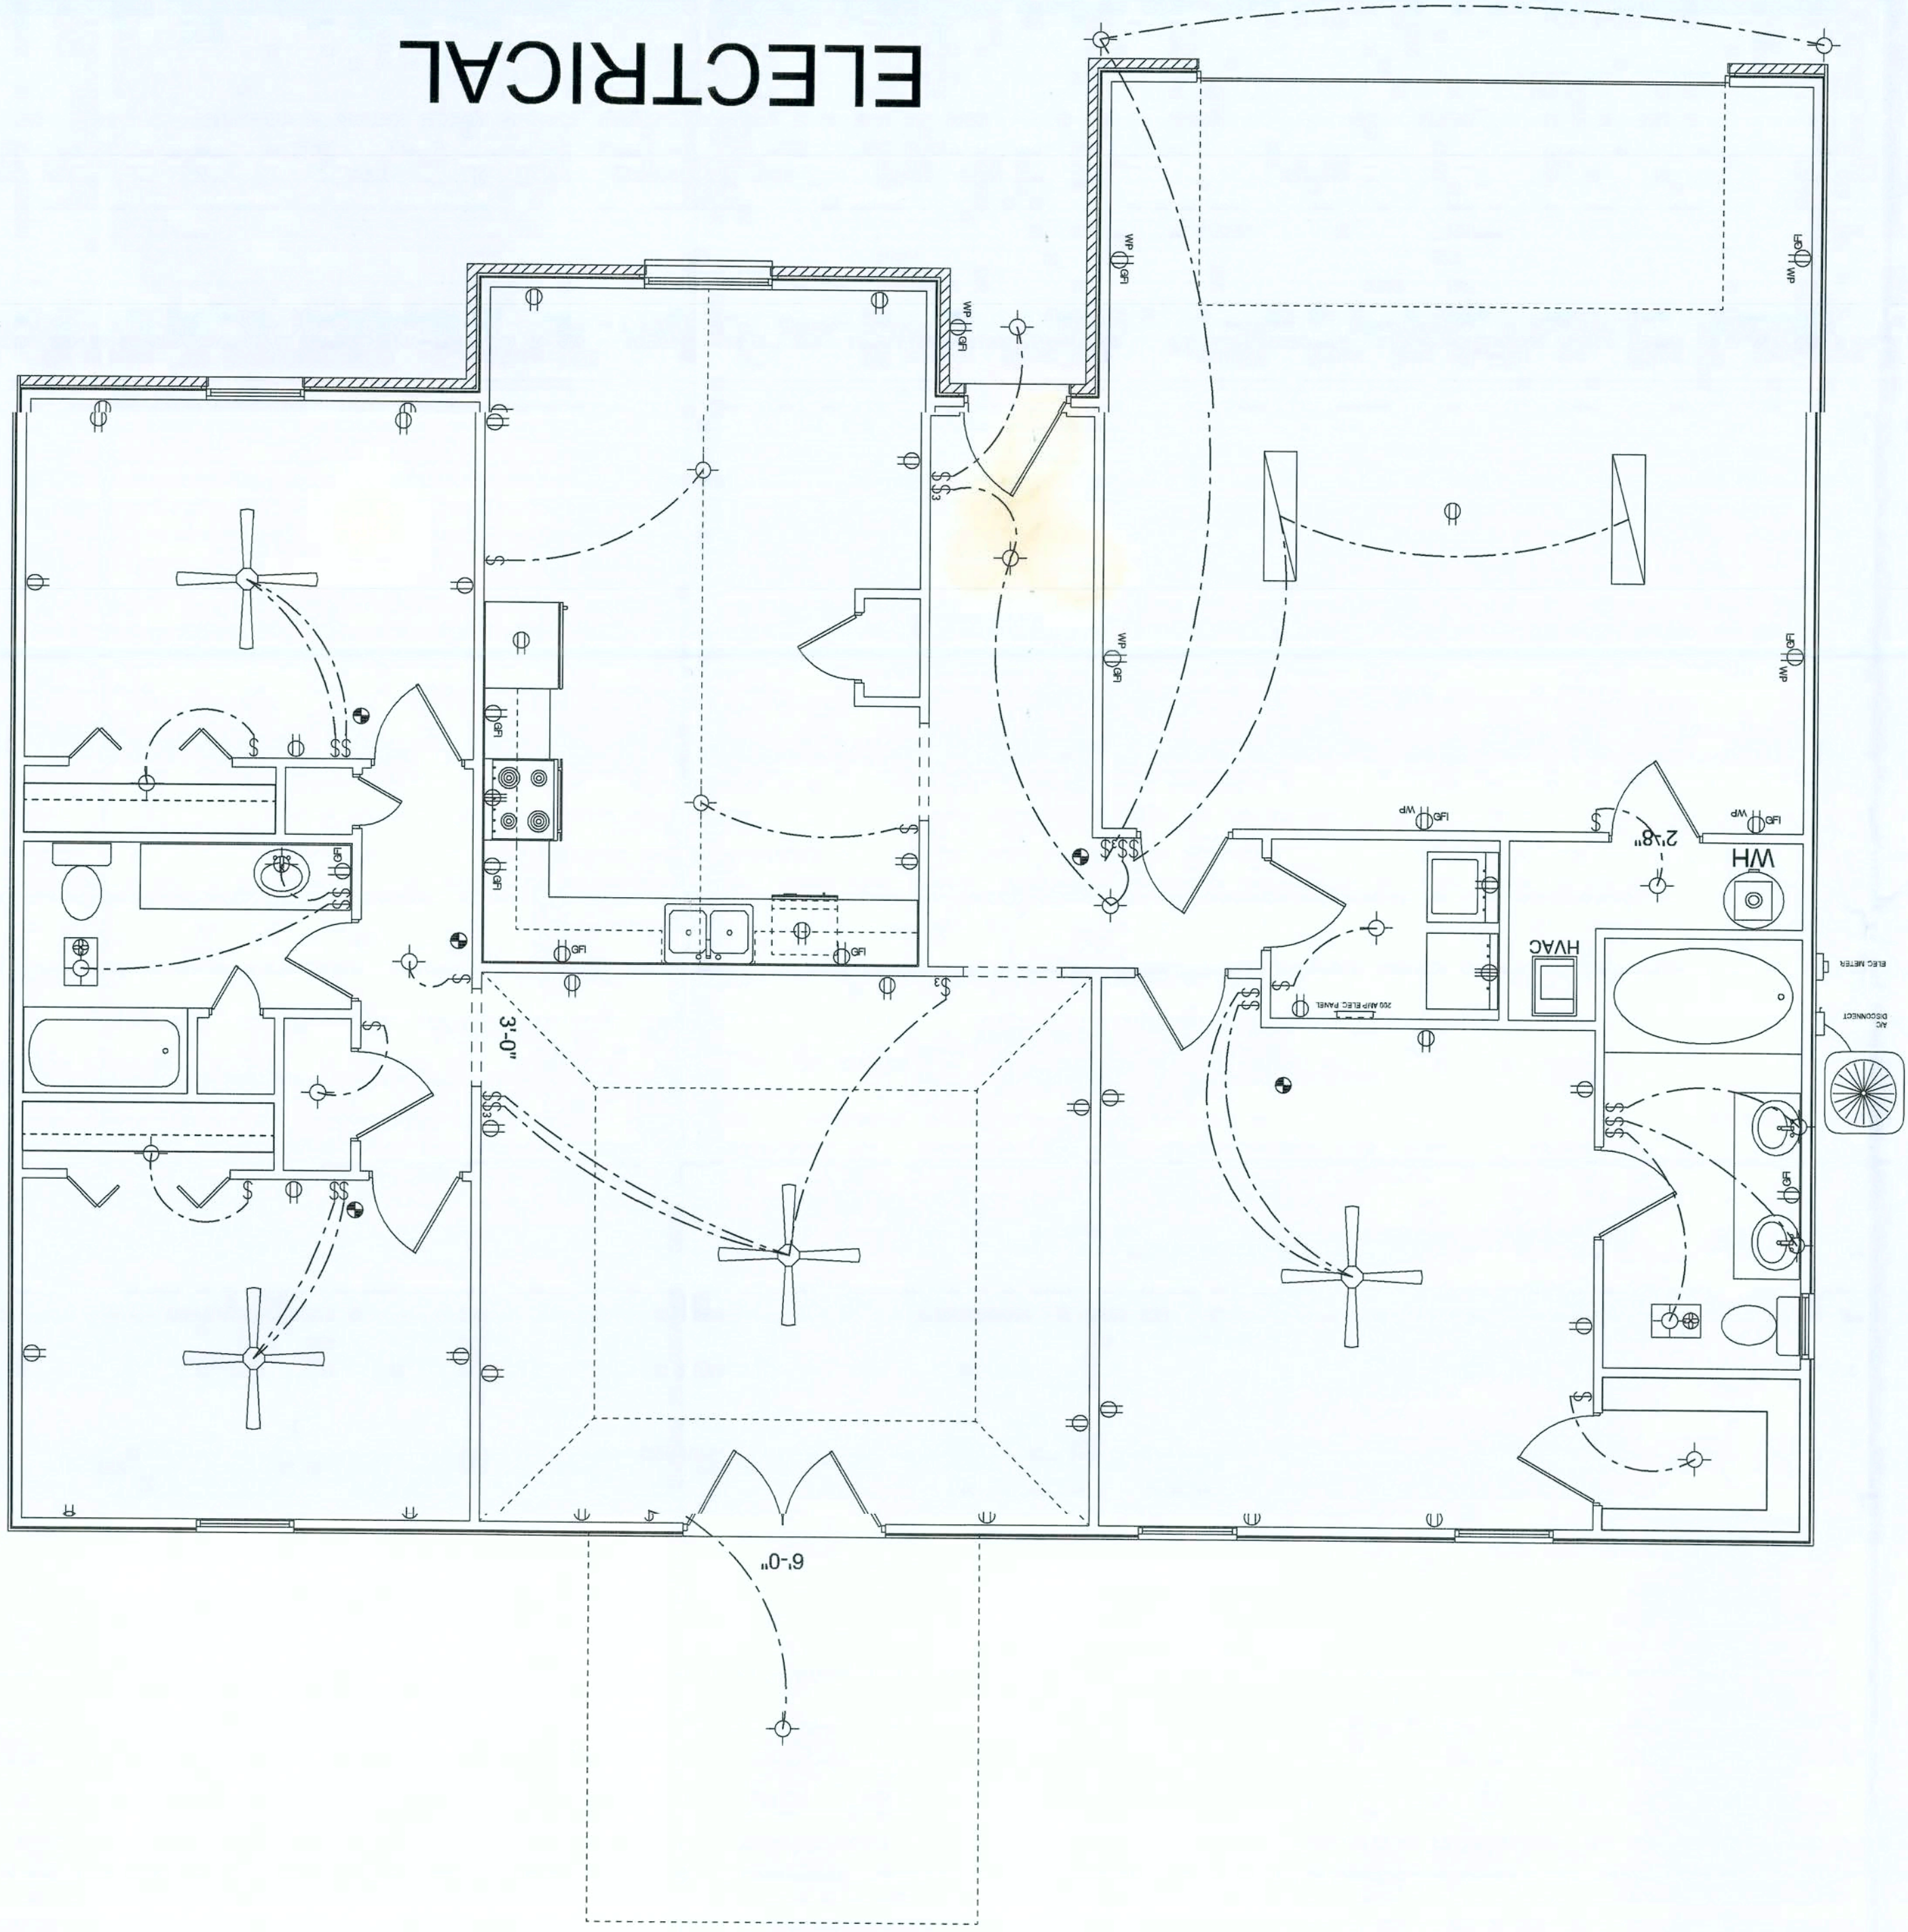

ELECTRICAL

GLEN KEEN

DRAWN BY:
JASON ELIXSON CONSTRUCTION, LLC
4853 WEST SR. 238
LAKE BUTLER, FL. 32054
(386) 623-1741

SCALE: 1/4" = 1 FOOT

DATE: 09-18-06

COLUMBIA COUNTY

