



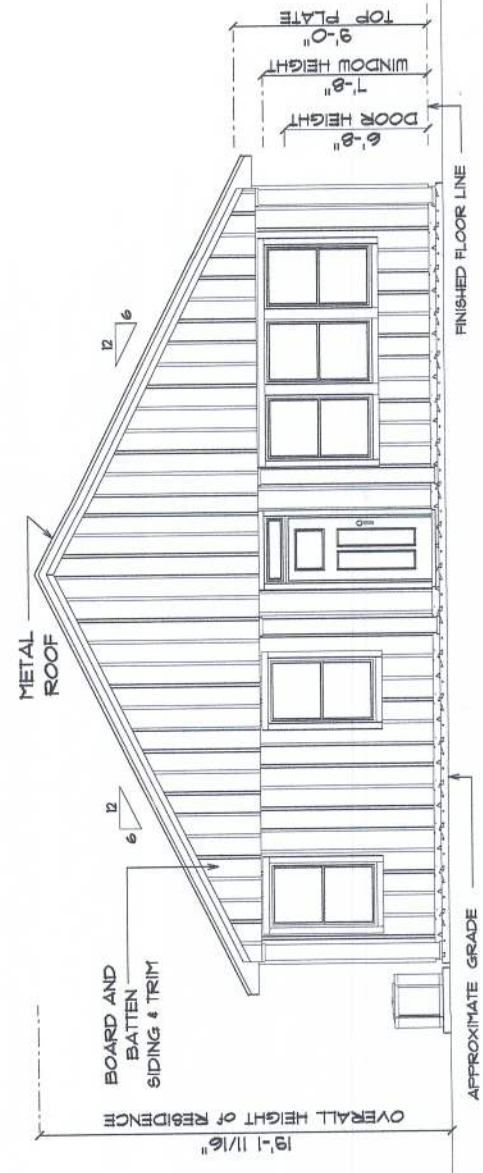


• FRONT ELEVATION •
SCALE : 1/4" = 1'-0"

12" OVERHANG ON GABLE ENDS,
ALL OTHER EAVES 18"

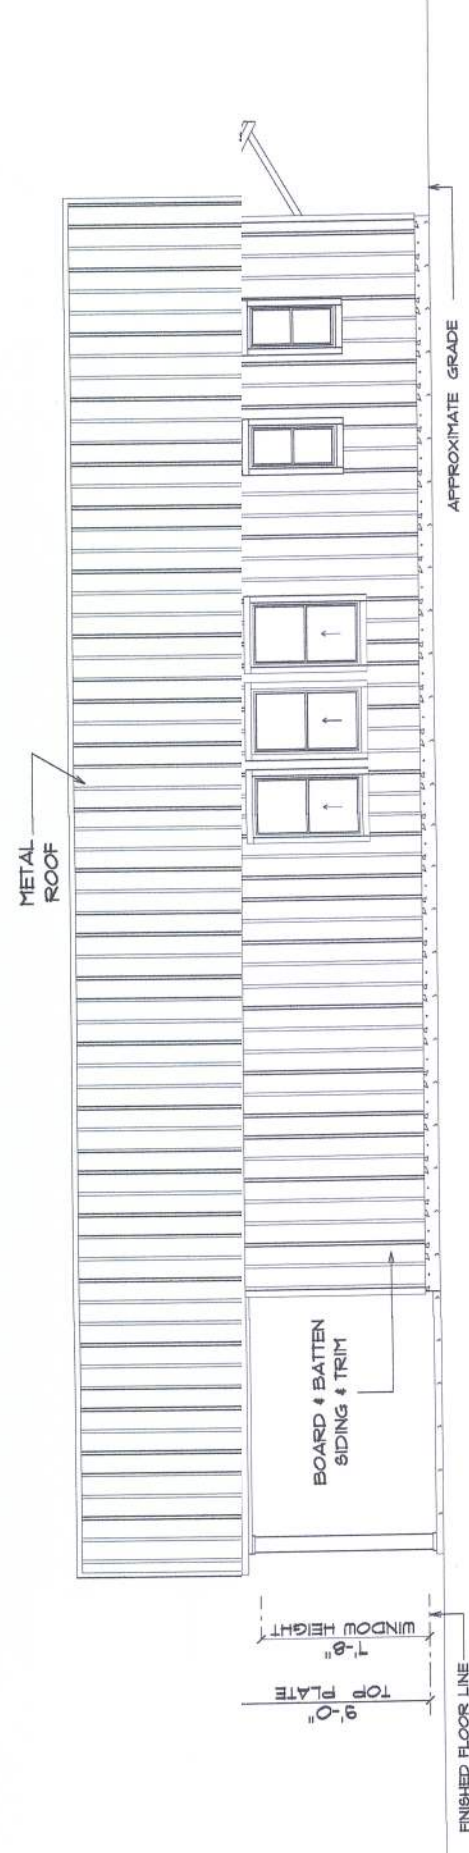


• RIGHT ELEVATION •
SCALE : 1/4" = 1'-0"

FOR
RACHEL RICE
NEW RESIDENCE
1000 N. 10TH AVE
LAKE CHARLES, LA 70601
PHONE: 504.233.1234
EMAIL: rachel@rachelrice.com
PROJECT NO.:
DATE: 01/15/2024
DRAWN BY: RACHEL RICE
CHECKED BY: RACHEL RICE
JOB NUMBER:
SHEET NUMBER:
A-4
OF 6 SHEETS

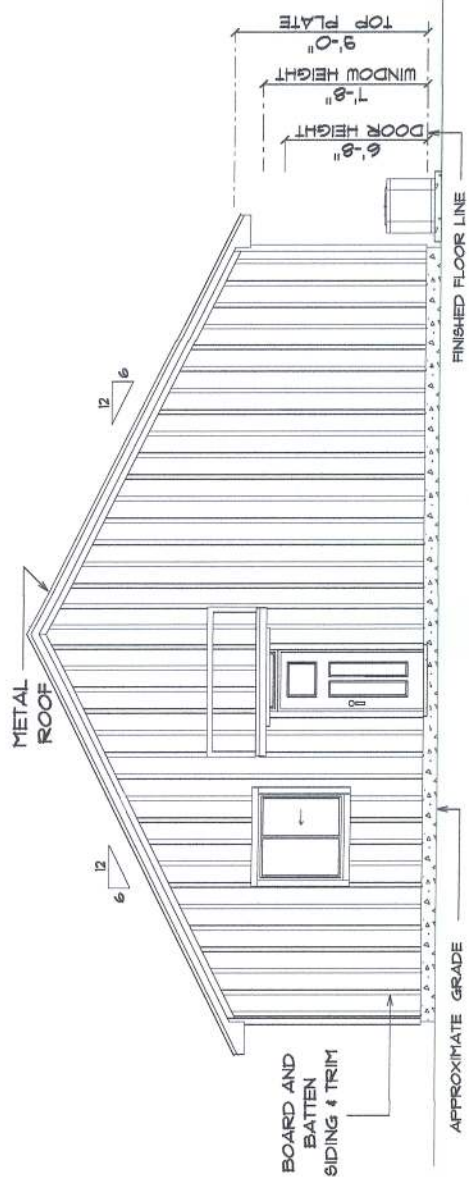


• REAR ELEVATION •
SCALE : 1/4" = 1'-0"

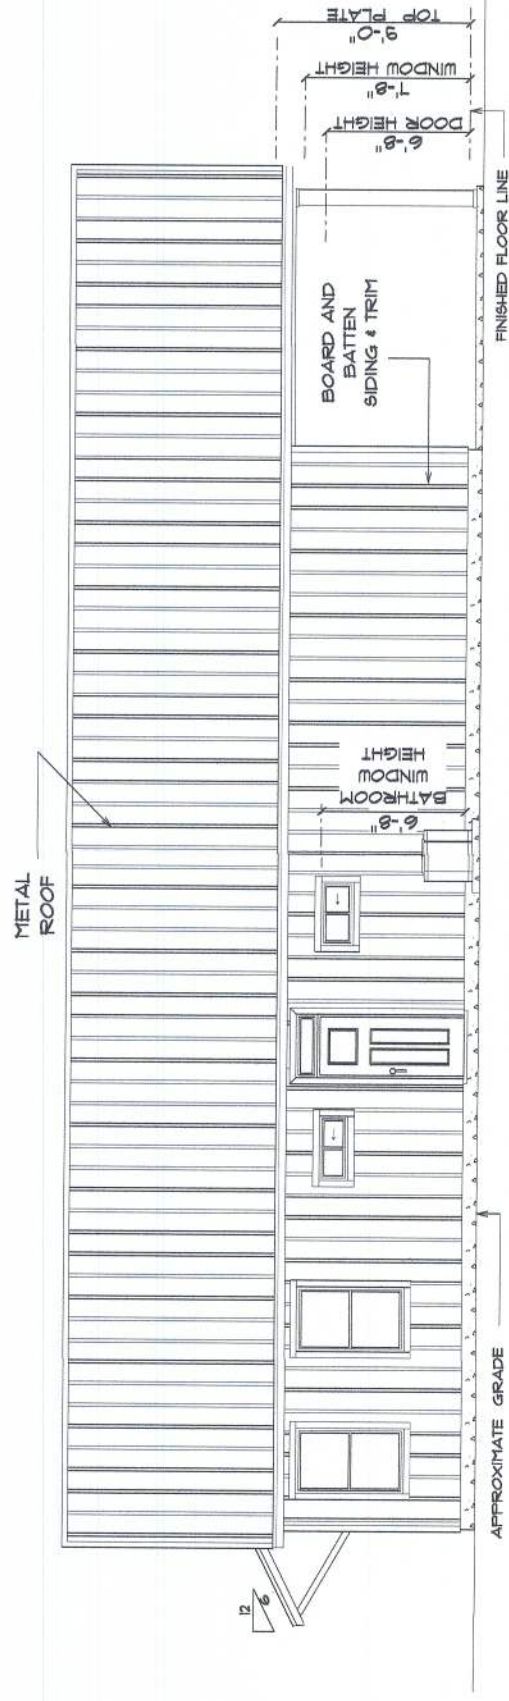

• LEFT ELEVATION •
SCALE : 1/4" = 1'-0"

NEW RESIDENCE
RACHEL RICE
1000 N. 10TH AVE
LAKE CHARLES, LA 70601
PHONE: 504.233.1234
EMAIL: rachel@rachelrice.com
PROJECT NO.:
DATE: 01/15/2024
DRAWN BY: RACHEL RICE
CHECKED BY: RACHEL RICE
JOB NUMBER:
SHEET NUMBER:
A-5
OF 6 SHEETS

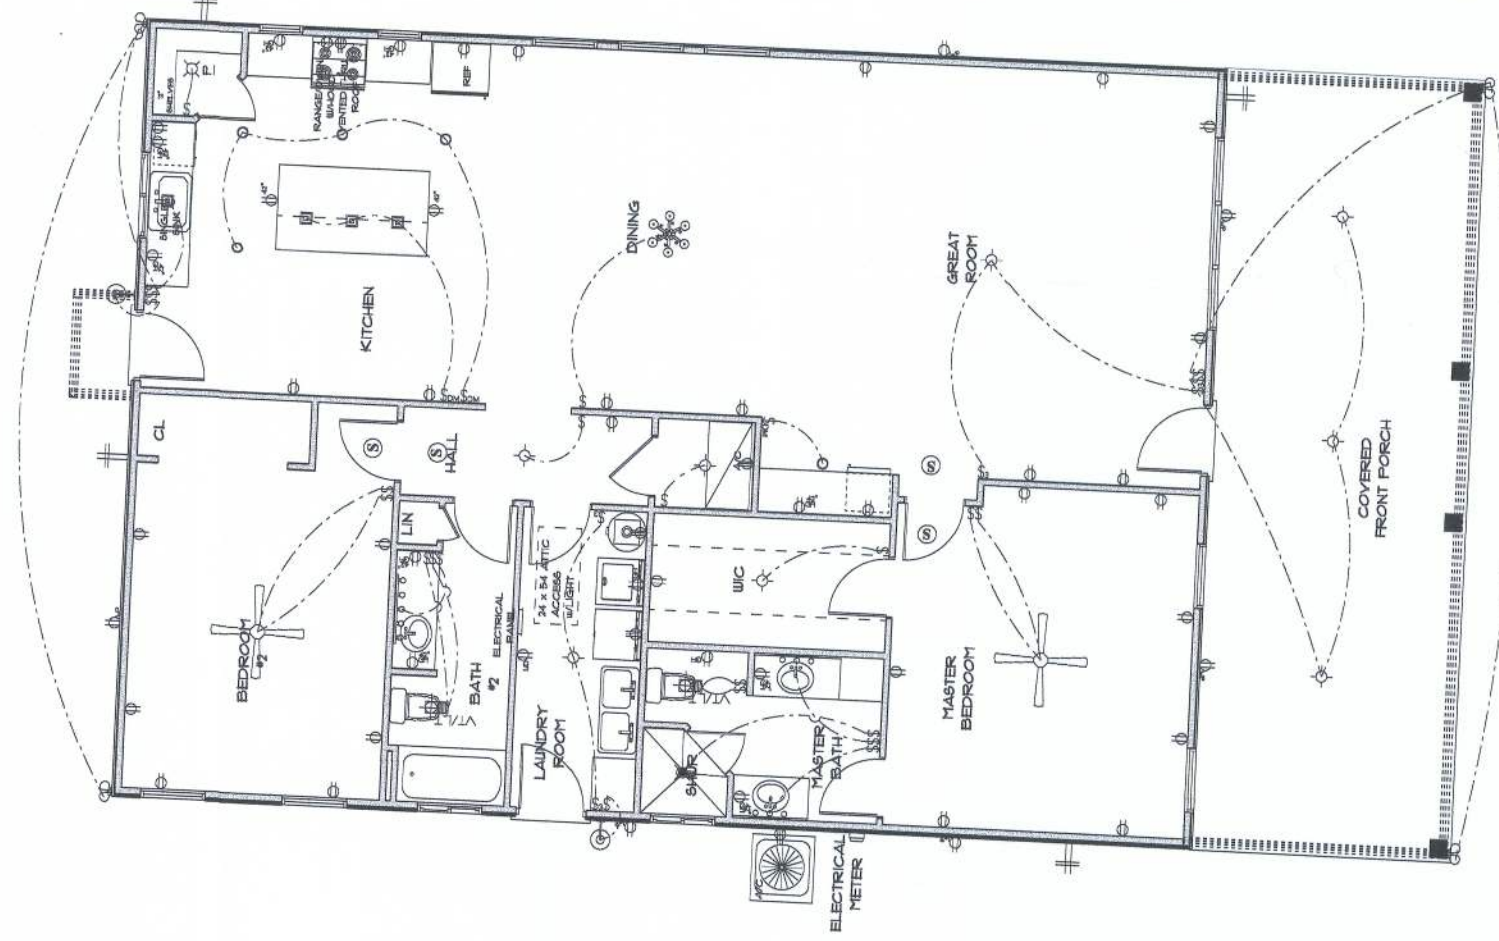

• ELECTRIC PLAN •
SCALE : 1/4" = 1'-0"


ELECTRICAL SYMBOL	SYMBOL
OUTLET	○
SWITCH	⬢
LIGHT	⬢
APPLIANCE	⬢
TELEPHONE	⬢
TELEVISION	⬢
STOVE	⬢
REF	⬢
WASHER	⬢
DRYER	⬢
WATER HEATER	⬢
BOILER	⬢
RADIATOR	⬢
HEAT PUMP	⬢
CLIMATE CONTROL	⬢
SMOKE DETECTOR	⬢
FIRE ALARM	⬢
SECURITY SYSTEM	⬢
DATA	⬢
VIDEO	⬢
TELEPHONE	⬢
TELEVISION	⬢
STOVE	⬢
REF	⬢
WASHER	⬢
DRYER	⬢
WATER HEATER	⬢
BOILER	⬢
RADIATOR	⬢
HEAT PUMP	⬢
CLIMATE CONTROL	⬢
SMOKE DETECTOR	⬢
FIRE ALARM	⬢
SECURITY SYSTEM	⬢
DATA	⬢
VIDEO	⬢

ELECTRICAL PLAN NOTES
1. ALL ELECTRICAL WORK SHALL BE IN ACCORDANCE WITH THE NATIONAL ELECTRICAL CODE (NEC) AND THE NATIONAL FIRE PROTECTION ASSOCIATION (NFPA) 70B.
2. ALL ELECTRICAL WORK SHALL BE IN ACCORDANCE WITH THE NATIONAL ELECTRICAL CODE (NEC) AND THE NATIONAL FIRE PROTECTION ASSOCIATION (NFPA) 70B.
3. ALL ELECTRICAL WORK SHALL BE IN ACCORDANCE WITH THE NATIONAL ELECTRICAL CODE (NEC) AND THE NATIONAL FIRE PROTECTION ASSOCIATION (NFPA) 70B.
4. ALL ELECTRICAL WORK SHALL BE IN ACCORDANCE WITH THE NATIONAL ELECTRICAL CODE (NEC) AND THE NATIONAL FIRE PROTECTION ASSOCIATION (NFPA) 70B.
5. ALL ELECTRICAL WORK SHALL BE IN ACCORDANCE WITH THE NATIONAL ELECTRICAL CODE (NEC) AND THE NATIONAL FIRE PROTECTION ASSOCIATION (NFPA) 70B.
6. ALL ELECTRICAL WORK SHALL BE IN ACCORDANCE WITH THE NATIONAL ELECTRICAL CODE (NEC) AND THE NATIONAL FIRE PROTECTION ASSOCIATION (NFPA) 70B.
7. ALL ELECTRICAL WORK SHALL BE IN ACCORDANCE WITH THE NATIONAL ELECTRICAL CODE (NEC) AND THE NATIONAL FIRE PROTECTION ASSOCIATION (NFPA) 70B.
8. ALL ELECTRICAL WORK SHALL BE IN ACCORDANCE WITH THE NATIONAL ELECTRICAL CODE (NEC) AND THE NATIONAL FIRE PROTECTION ASSOCIATION (NFPA) 70B.
9. ALL ELECTRICAL WORK SHALL BE IN ACCORDANCE WITH THE NATIONAL ELECTRICAL CODE (NEC) AND THE NATIONAL FIRE PROTECTION ASSOCIATION (NFPA) 70B.
10. ALL ELECTRICAL WORK SHALL BE IN ACCORDANCE WITH THE NATIONAL ELECTRICAL CODE (NEC) AND THE NATIONAL FIRE PROTECTION ASSOCIATION (NFPA) 70B.

FOR
RACHEL RICE
NEW RESIDENCE
1000 N. 10TH AVE
LAKE CHARLES, LA 70601
PHONE: 504.233.1234
EMAIL: rachel@rachelrice.com
PROJECT NO.:
DATE: 01/15/2024
DRAWN BY: RACHEL RICE
CHECKED BY: RACHEL RICE
JOB NUMBER:
SHEET NUMBER:
A-6
OF 6 SHEETS

FOUNDATION NOTES

- [illegible]

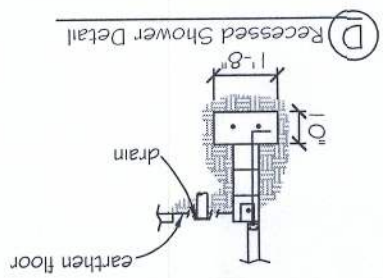
[illegible]

Digitally signed by Carol Chadwick
DN: c=US, o=Florida,
D9244CE0005954C, cn=Carol
Chadwick
Date: 2022.10.27 11:19:08 -0400

RICE RESIDENCE
FOUNDATION PLAN

PREPARED FOR:
RACHEL RICE

DATE	REVISION DESCRIPTION

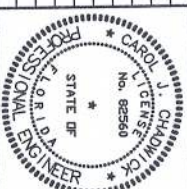

CAROL CHADWICK, PE