



FRONT ELEVATION
SCALE: 1/4" = 1'-0"



REAR ELEVATION
SCALE: 1/4" = 1'-0"






RIDGEPOINT
DESIGN, INC.

496 SW RING CT, LAKE CITY, FLORIDA 32025
P: 386-288-1188
E: RIDGEPOINTDESIGN@GMAIL.COM


REVISIONS SCHEDULE	
Oct. 8th, 2021	PROPOSAL

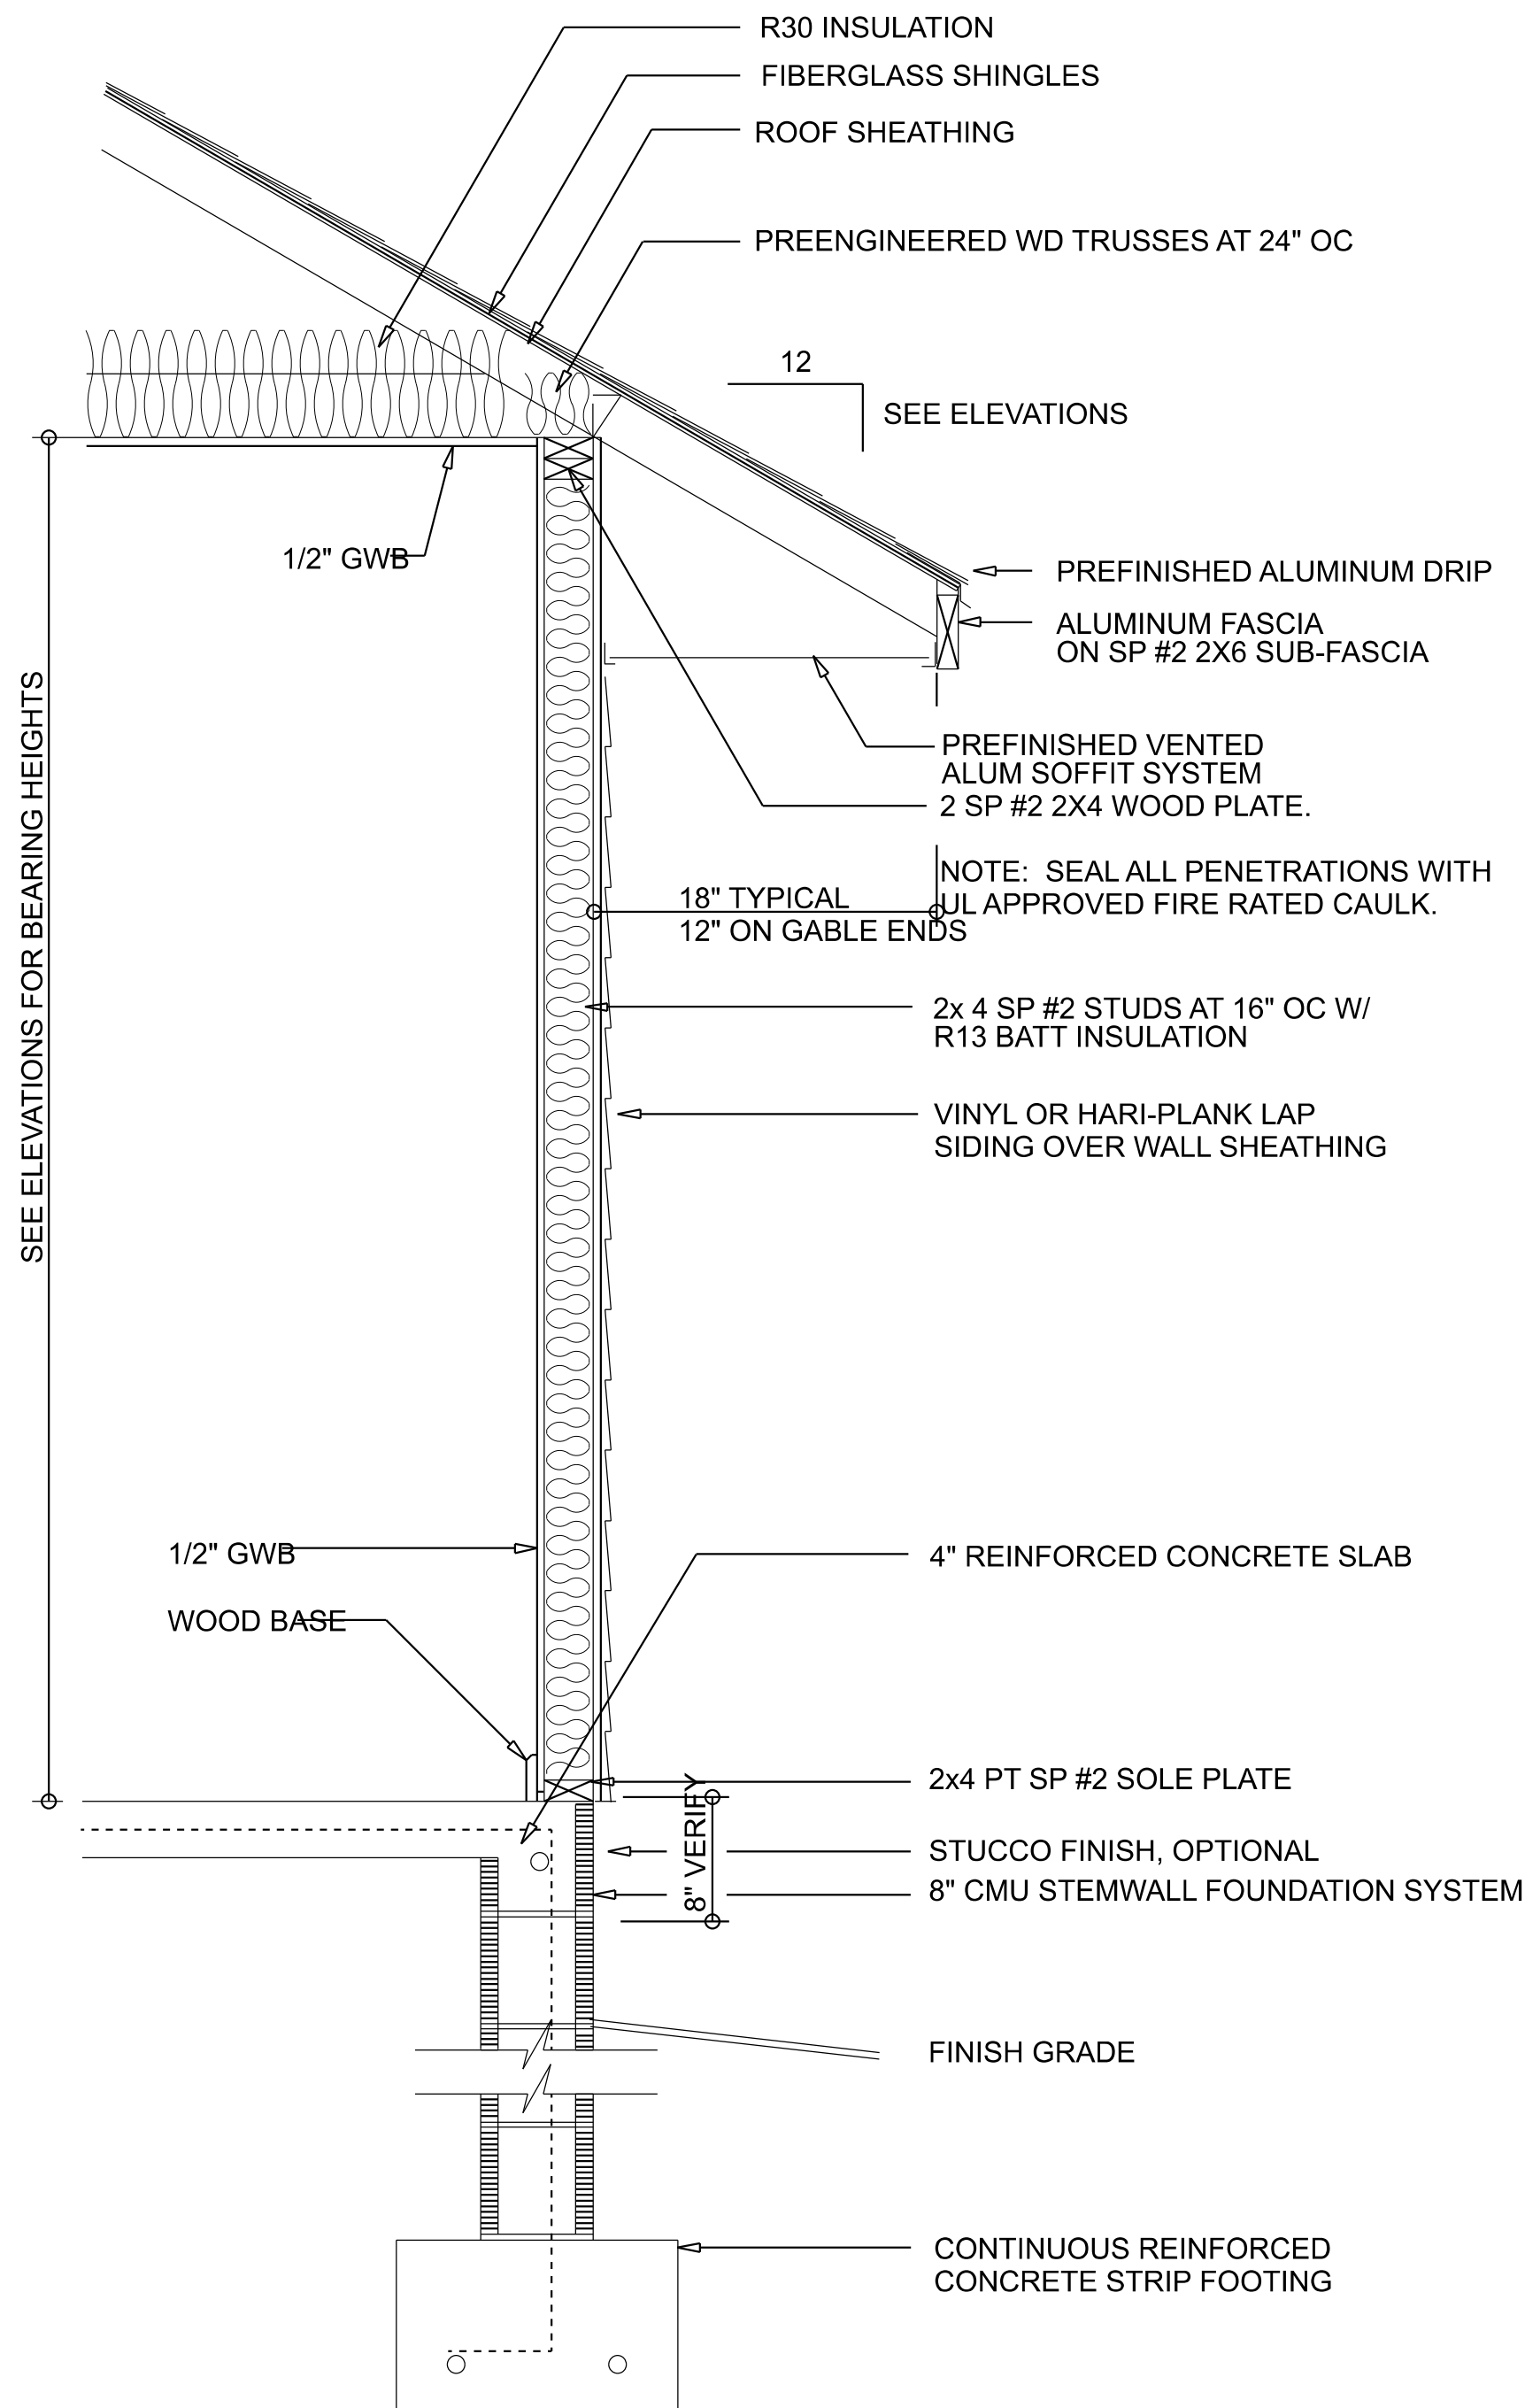

TYPICAL WALL SECTION
SCALE: 1" = 1'-0"




LEFT ELEVATION
SCALE: 1/4" = 1'-0"

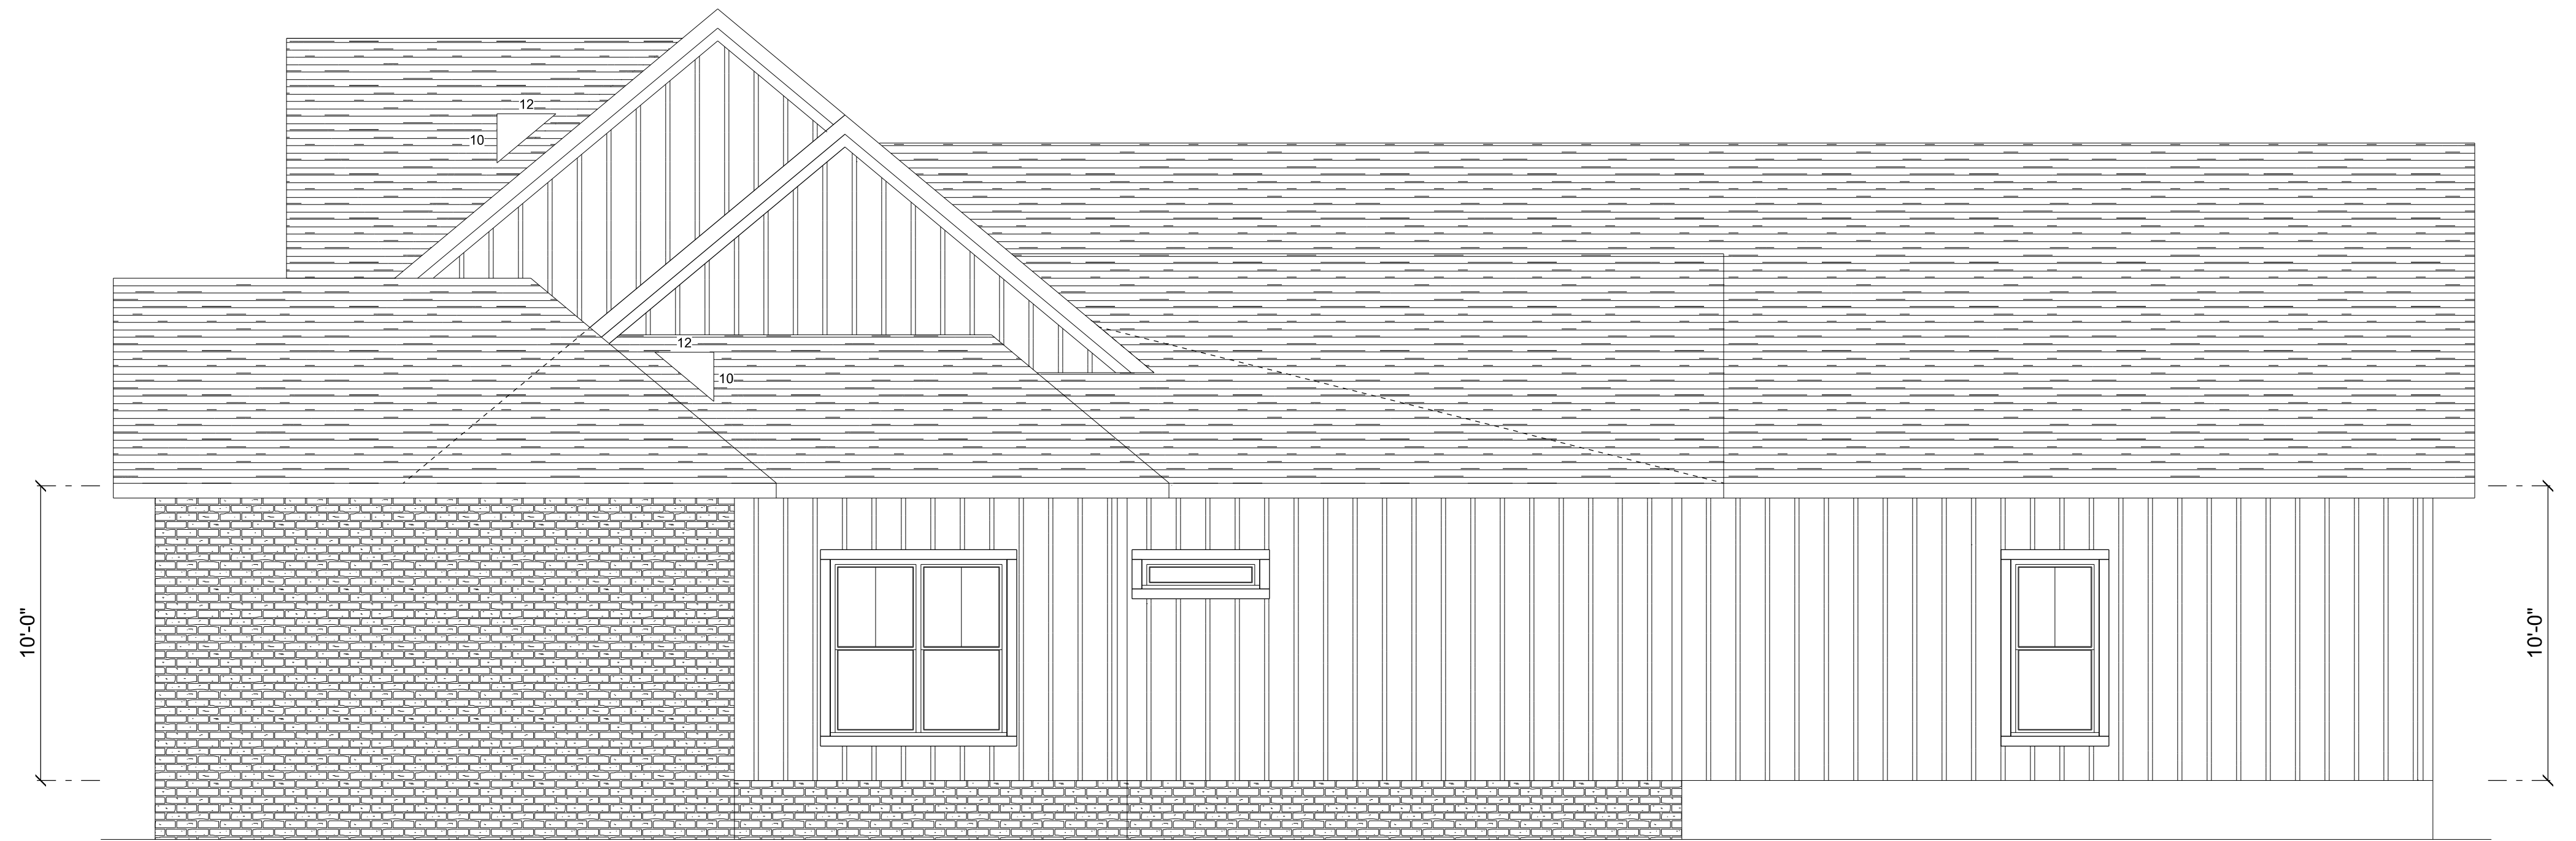

RIGHT ELEVATION
SCALE: 1/4" = 1'-0"

REVISIONS SCHEDULE	
Oct. 8th, 2021	PROPOSAL

GONZALEZ RESIDENCE
COLUMBIA COUNTY, FLORIDA

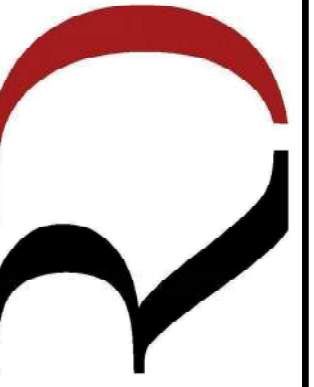


**RIDGEPOINT
DESIGN, INC.**
496 SW RING CT, LAKE CITY, FLORIDA 32025
P: 386-288-1188
E: RIDGEPOINTDESIGN@GMAIL.COM


SHEET NUMBER

A.2

OF 4 SHEETS

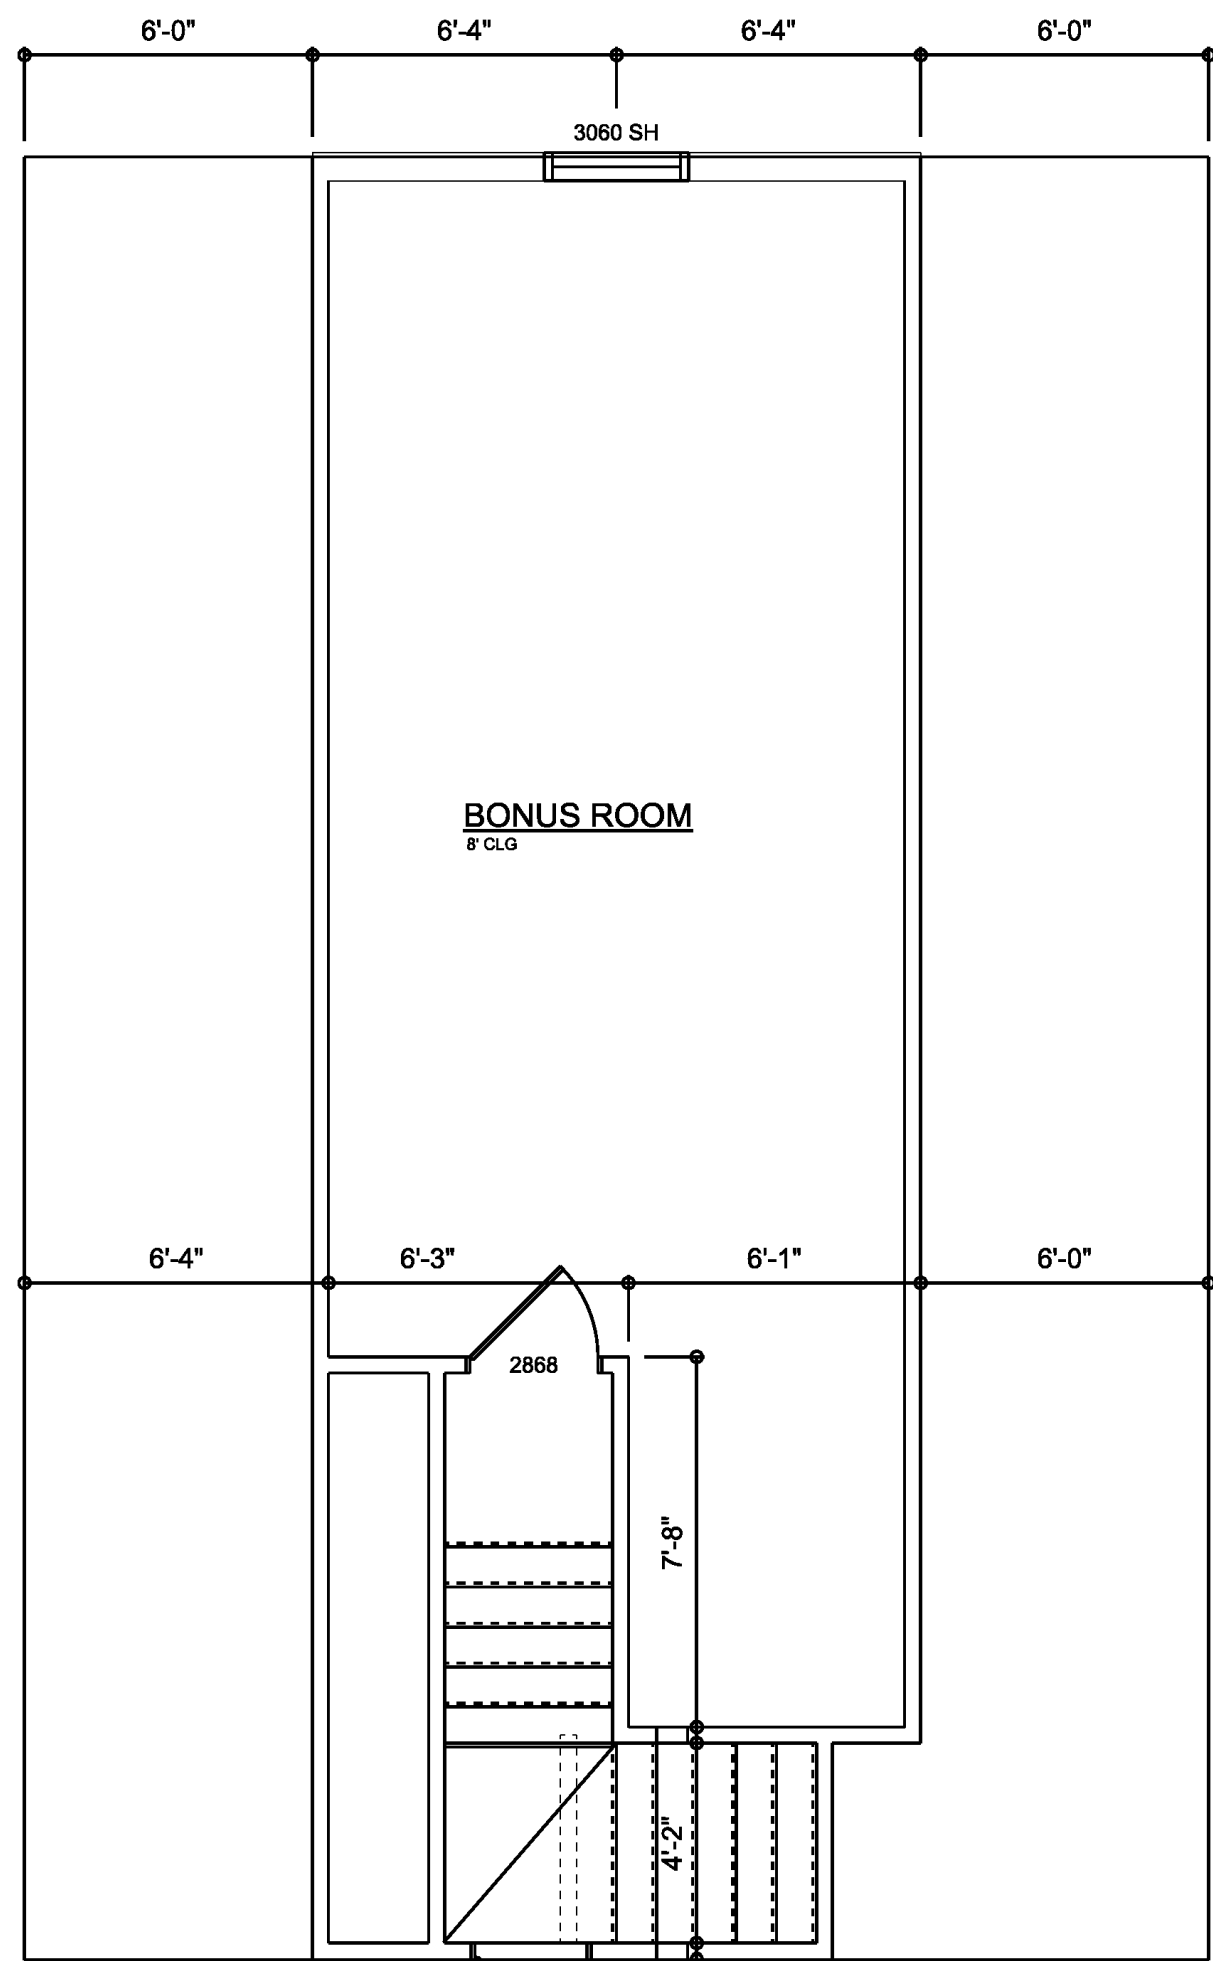

DIMENSIONED BONUS ROOM
SCALE: 1/4" = 1'-0"

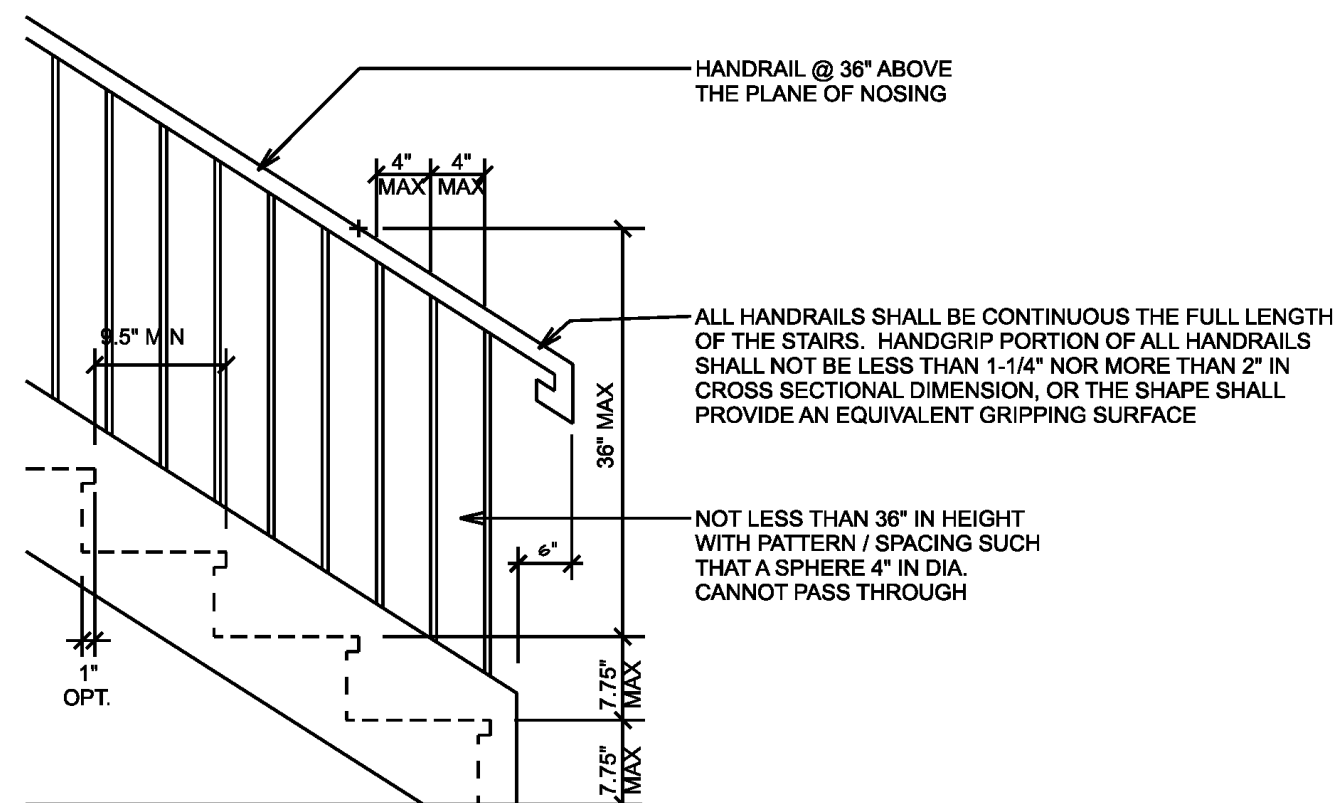

TYPICAL STAIR DETAIL
SCALE: NOT TO SCALE

AREA SUMMARY


LIVING	2,754	S.F.
BONUS ROOM	445	S.F.
TOTAL LIVING	3,199	S.F.
ENTRY PORCH	277	S.F.
REAR PORCH	462	S.F.
GARAGE	835	S.F.

TOTAL UNDER ROOF 4,773 S.F.


TOTAL CUBIC FOOTAGE OF CONDITIONED SPACE (SI) 29,395

DIMENSIONED FLOOR PLAN

SCALE: 1/4" = 1'-0"

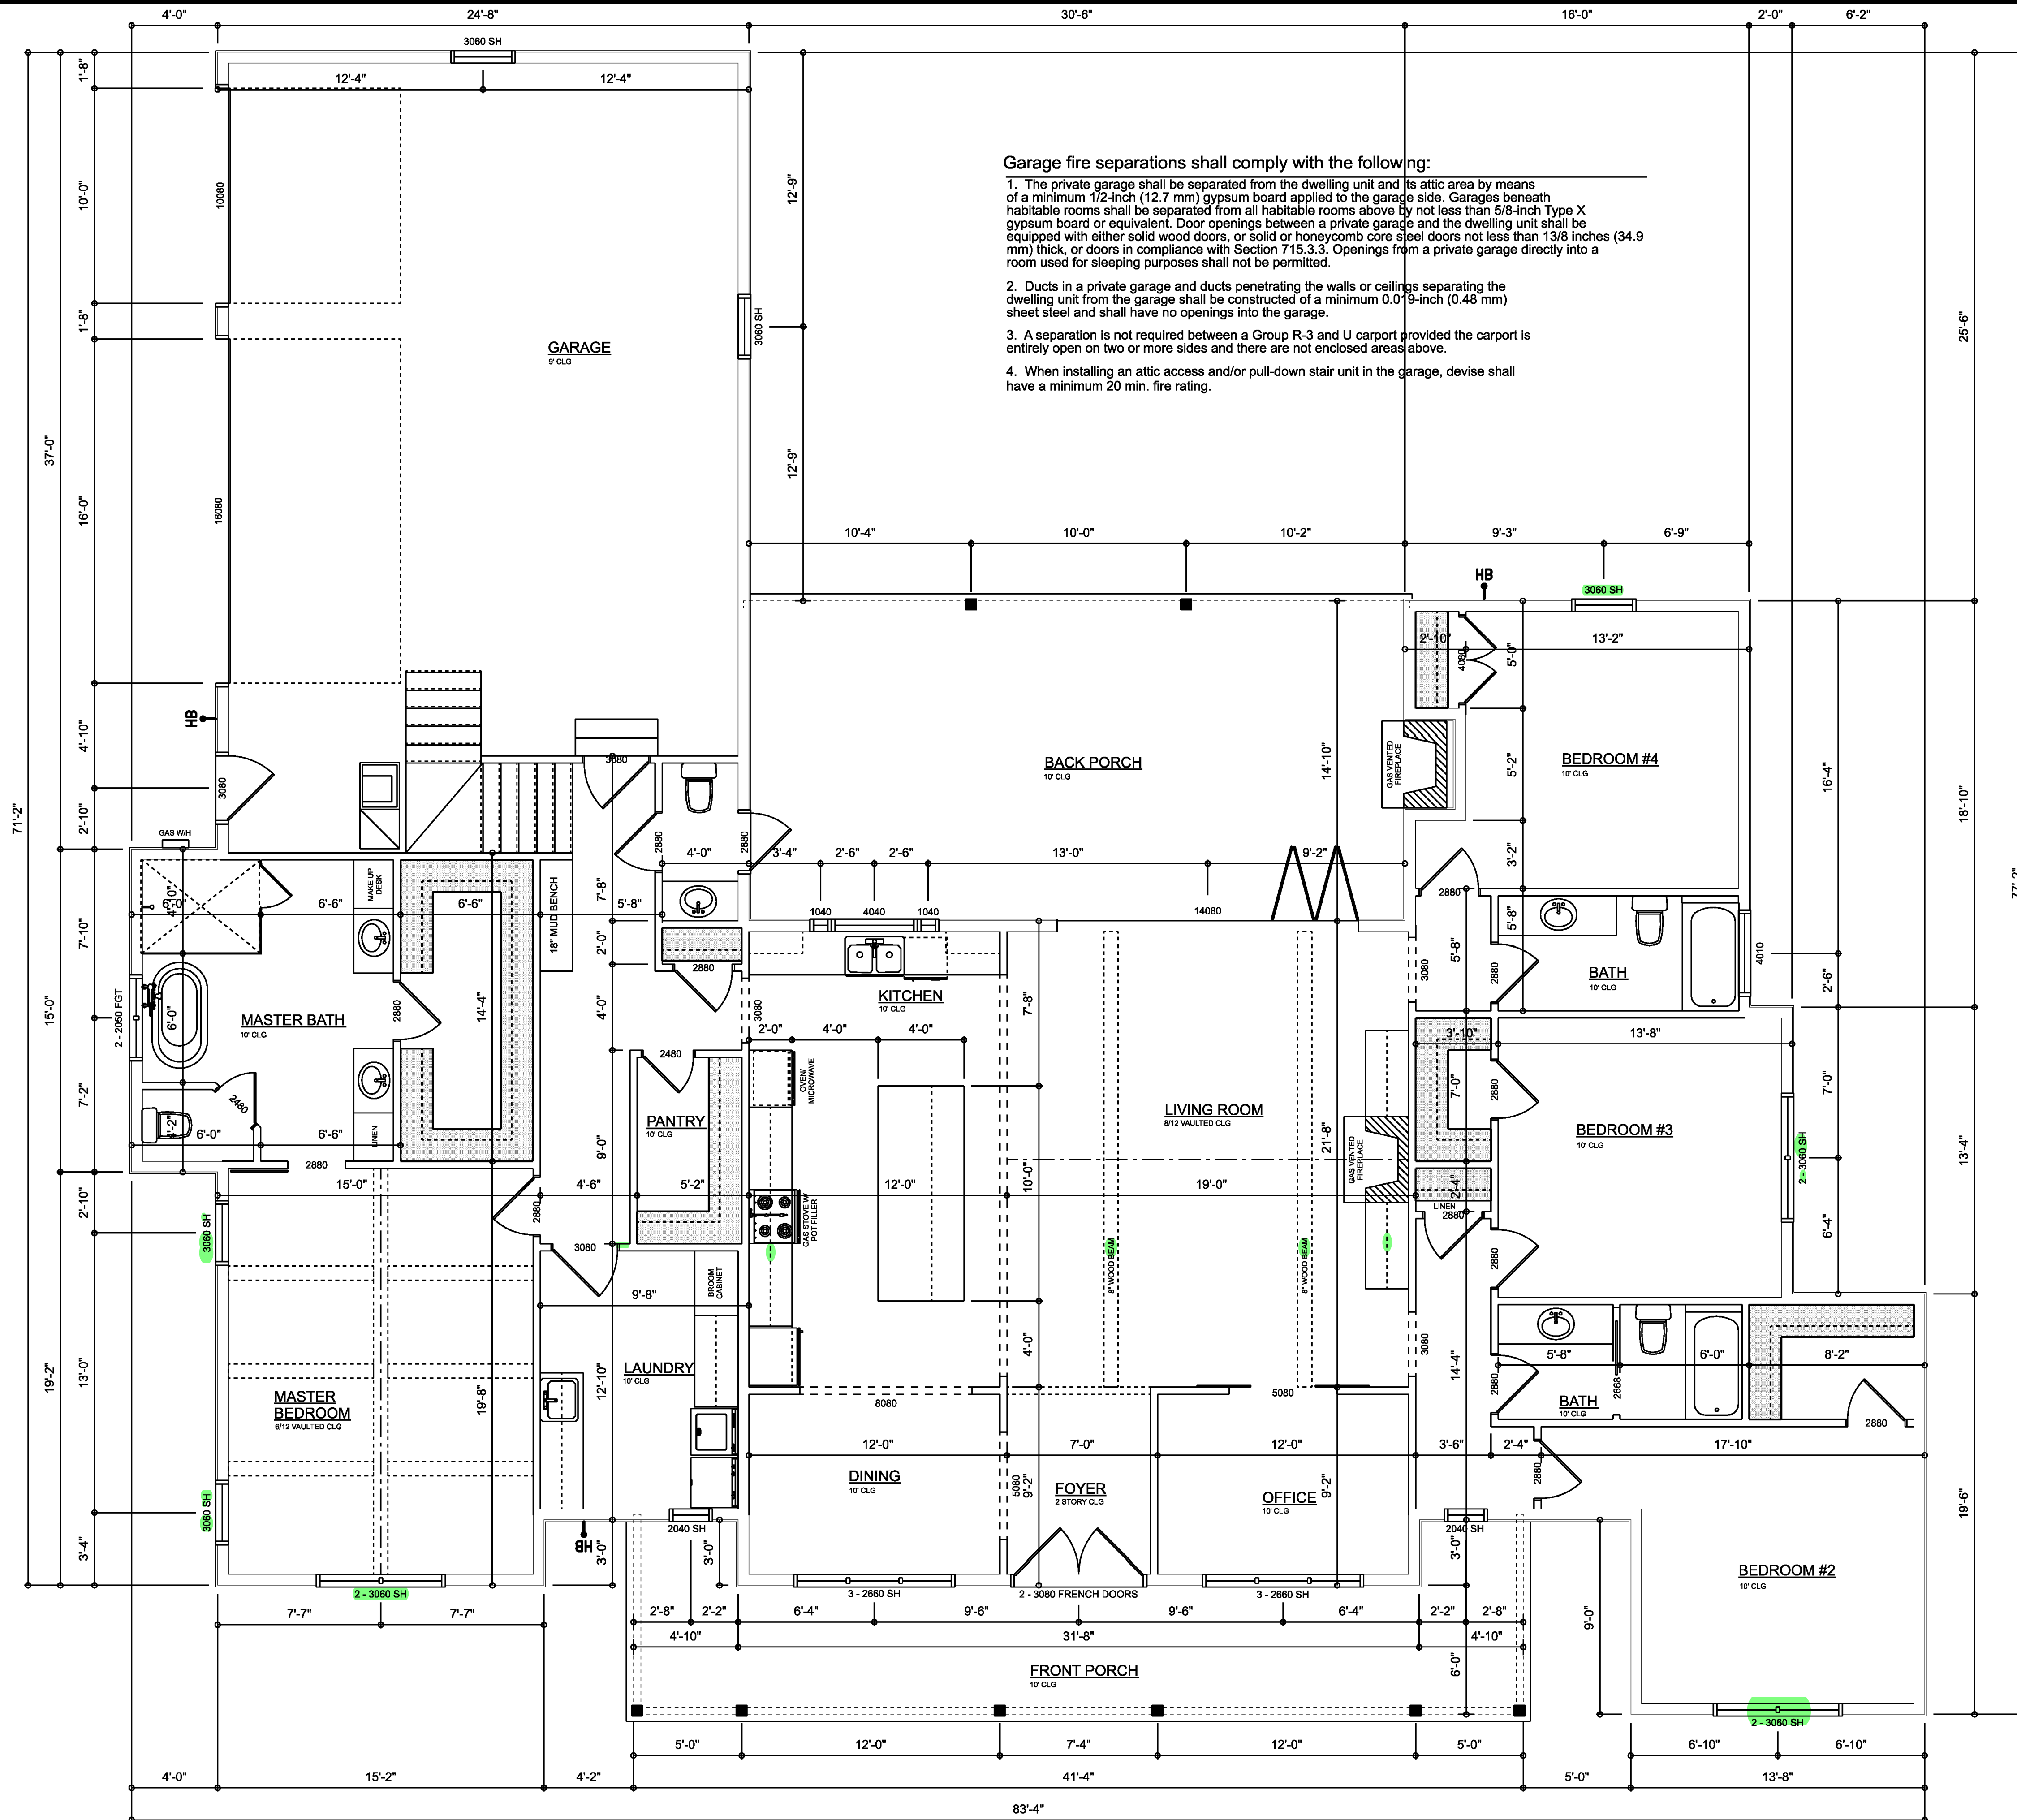

REVISIONS SCHEDULE	
Oct. 8th, 2021	PROPOSAL

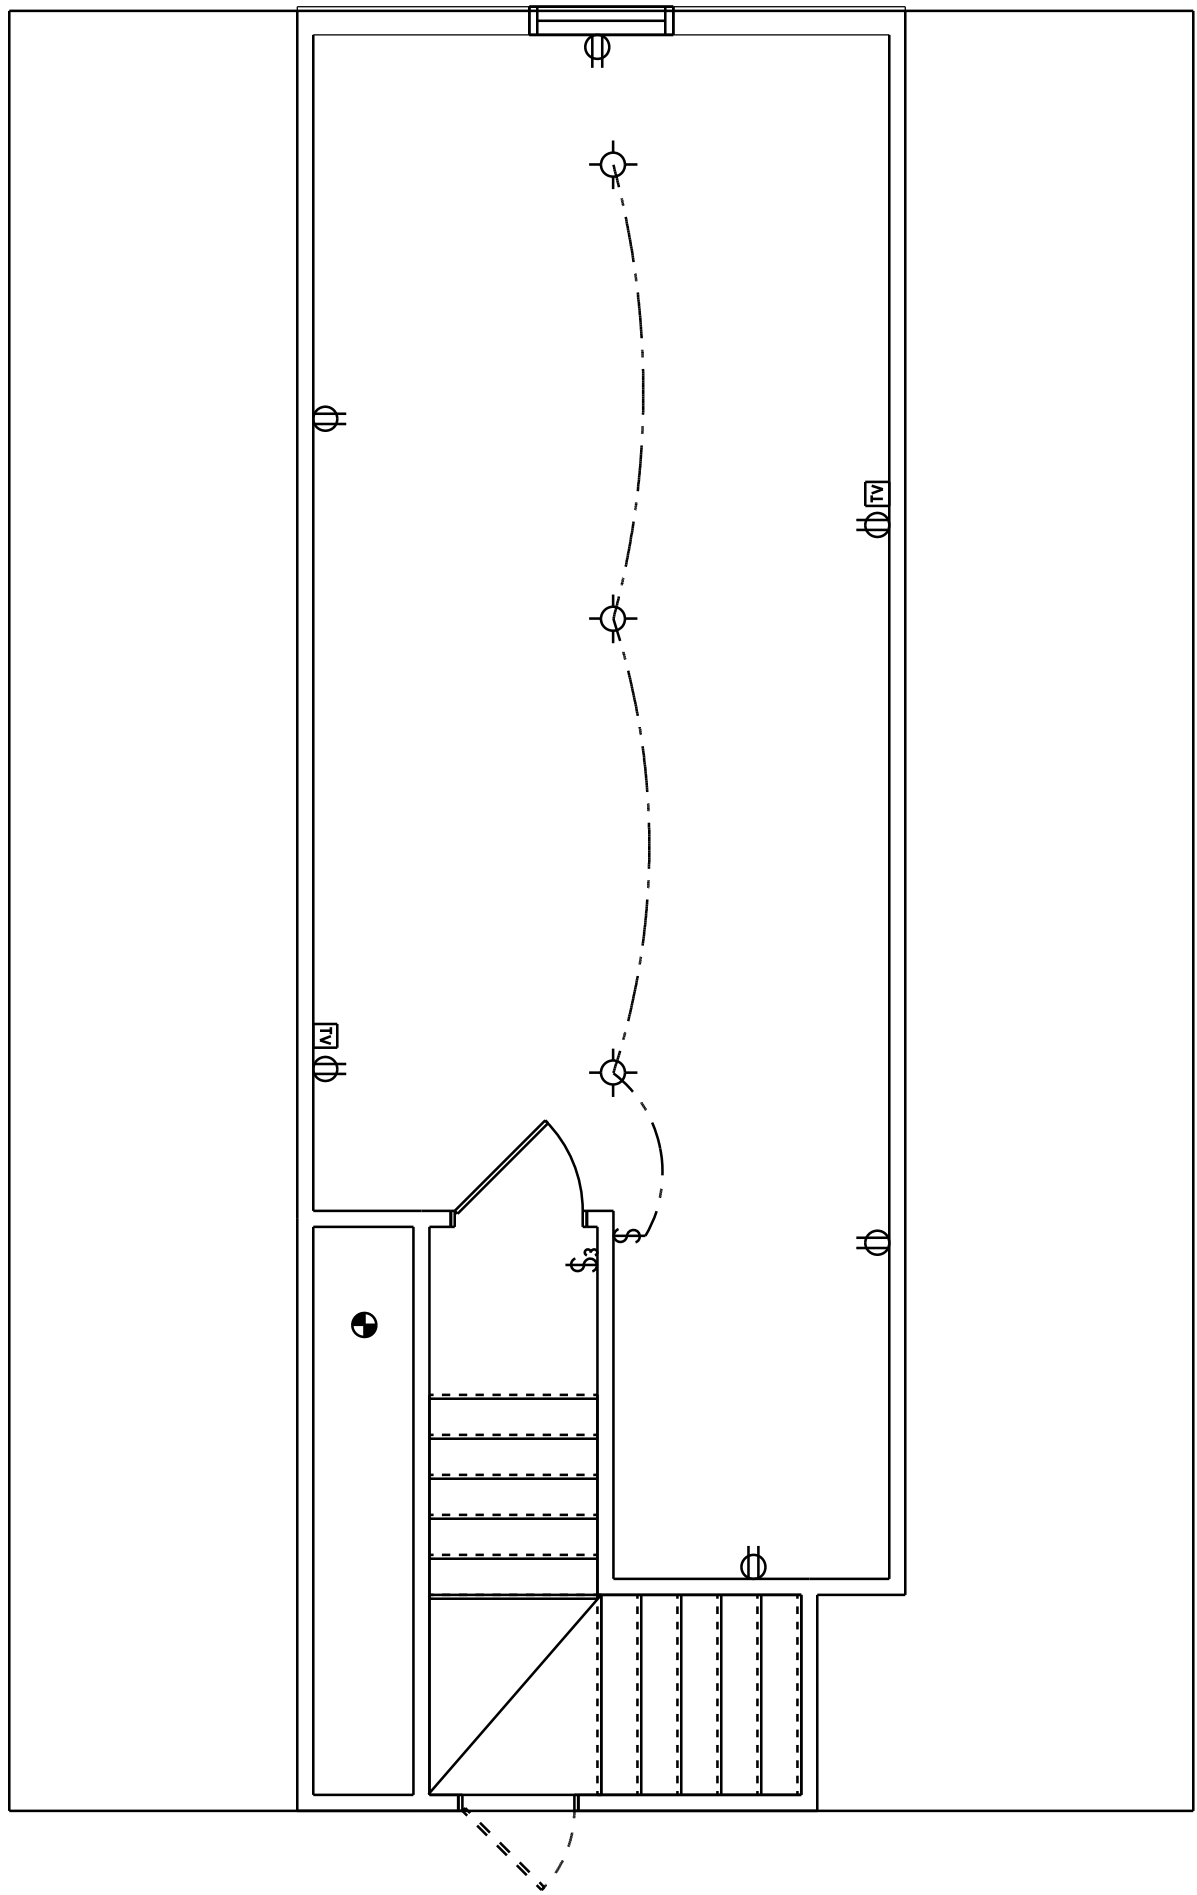

ELECTRICAL LEGEND		
ELECTRICAL	COUNT	SYMBOL
CEILING FAN	7	
CAN LIGHT 6inch	47	
CHANDELIER	2	
LED CEILING LIGHT 1x4	3	
PENDANT LIGHT	3	
EXTERIOR SCONCE	11	
MOTION SECURITY LIGHT	6	
AC DISCONNECT	1	
CARBON DETECTOR	3	
COAX OUTLET	8	
EXHAUST FAN	4	
OUTLET	66	
OUTLET 220v	3	
OUTLET GFI	19	
OUTLET WP	2	
SMOKE DETECTOR	9	
STANDARD LIGHT	5	
SWITCH	43	
SWITCH 3 WAY	26	
VANITY BAR LIGHT - SMALL	5	

ELECTRICAL PLAN NOTES:

INSTALLATION SHALL BE PER LATEST NAT'L ELECTRIC CODE.

WIRE ALL APPLIANCES, HVAC UNITS AND OTHER EQUIPMENT PER MANUF. SPECIFICATIONS

CONSULT WITH THE OWNER FOR THE NUMBER OF SEPERATE TELEPHONE LINES TO BE INSTALLED

ALL SMOKE DETECTORS SHALL BE 120v W/ BATTERY BACKUP OF THE PHOTOELECTRIC TYPE, AND SHALL BE INTERLOCKED TOGETHER. INSTALL INSIDE AND NEAR ALL BEDROOMS


TELEPHONE, TELEVISION AND OTHER LOW VOLTAGE DEVICES OR OUTLETS SHALL BE AS PER THE OWNER'S DIRECTIONS, & IN ACCORDANCE W/ APPLICABLE SECTIONS OF NEC-LATEST EDITION.

ALL RECEPTICALS, NOT OTHERWISE NOTED, SHALL BE ARC FAULT INTERRUPTER TYPE, EXCEPT DEDICATED OUTLETS

ALL RECEPTICALS IN WET AREAS SHALL BE GROUND FAULT INTERRUPTER TYPE (GFI)

ALL EXTERIOR RECEPTICALS SHALL BE WEATHERPROOF GROUD FAULT INTERRUPTER TYPE (WP/GFI)

NOTE:
ELECTRICAL CONTR SHALL PREPARE "AS-BUILT" SHOP DWGS INDICATING ALL ELECTRICAL WORK, INCLUDING ANY CHANGES TO THE ELEC. PLAN, ADDNS TO THE ELEC. PLAN, RISER DIAGRAM, AS-BUILT PANEL SCHEDULE W/ ALL CKTS IDENTIFIED W/ CKT Nr, DESCRIPTION & BRKR, SERVICE ENT. & ALL UNDERGROUND WIRE LOCATIONS/ROUTING / DEPTH. RISER DIA. SHALL INCLUDE WIRE SIZES/TYPE & EQUIPMENT TYPE W/ RATINGS & LOADS.
CONTRACTOR SHALL PROVIDE 1 COPY OF AS-BUILT DWGS TO OWNER & 1 COPY TO THE PERMIT ISSUING AUTHORITY

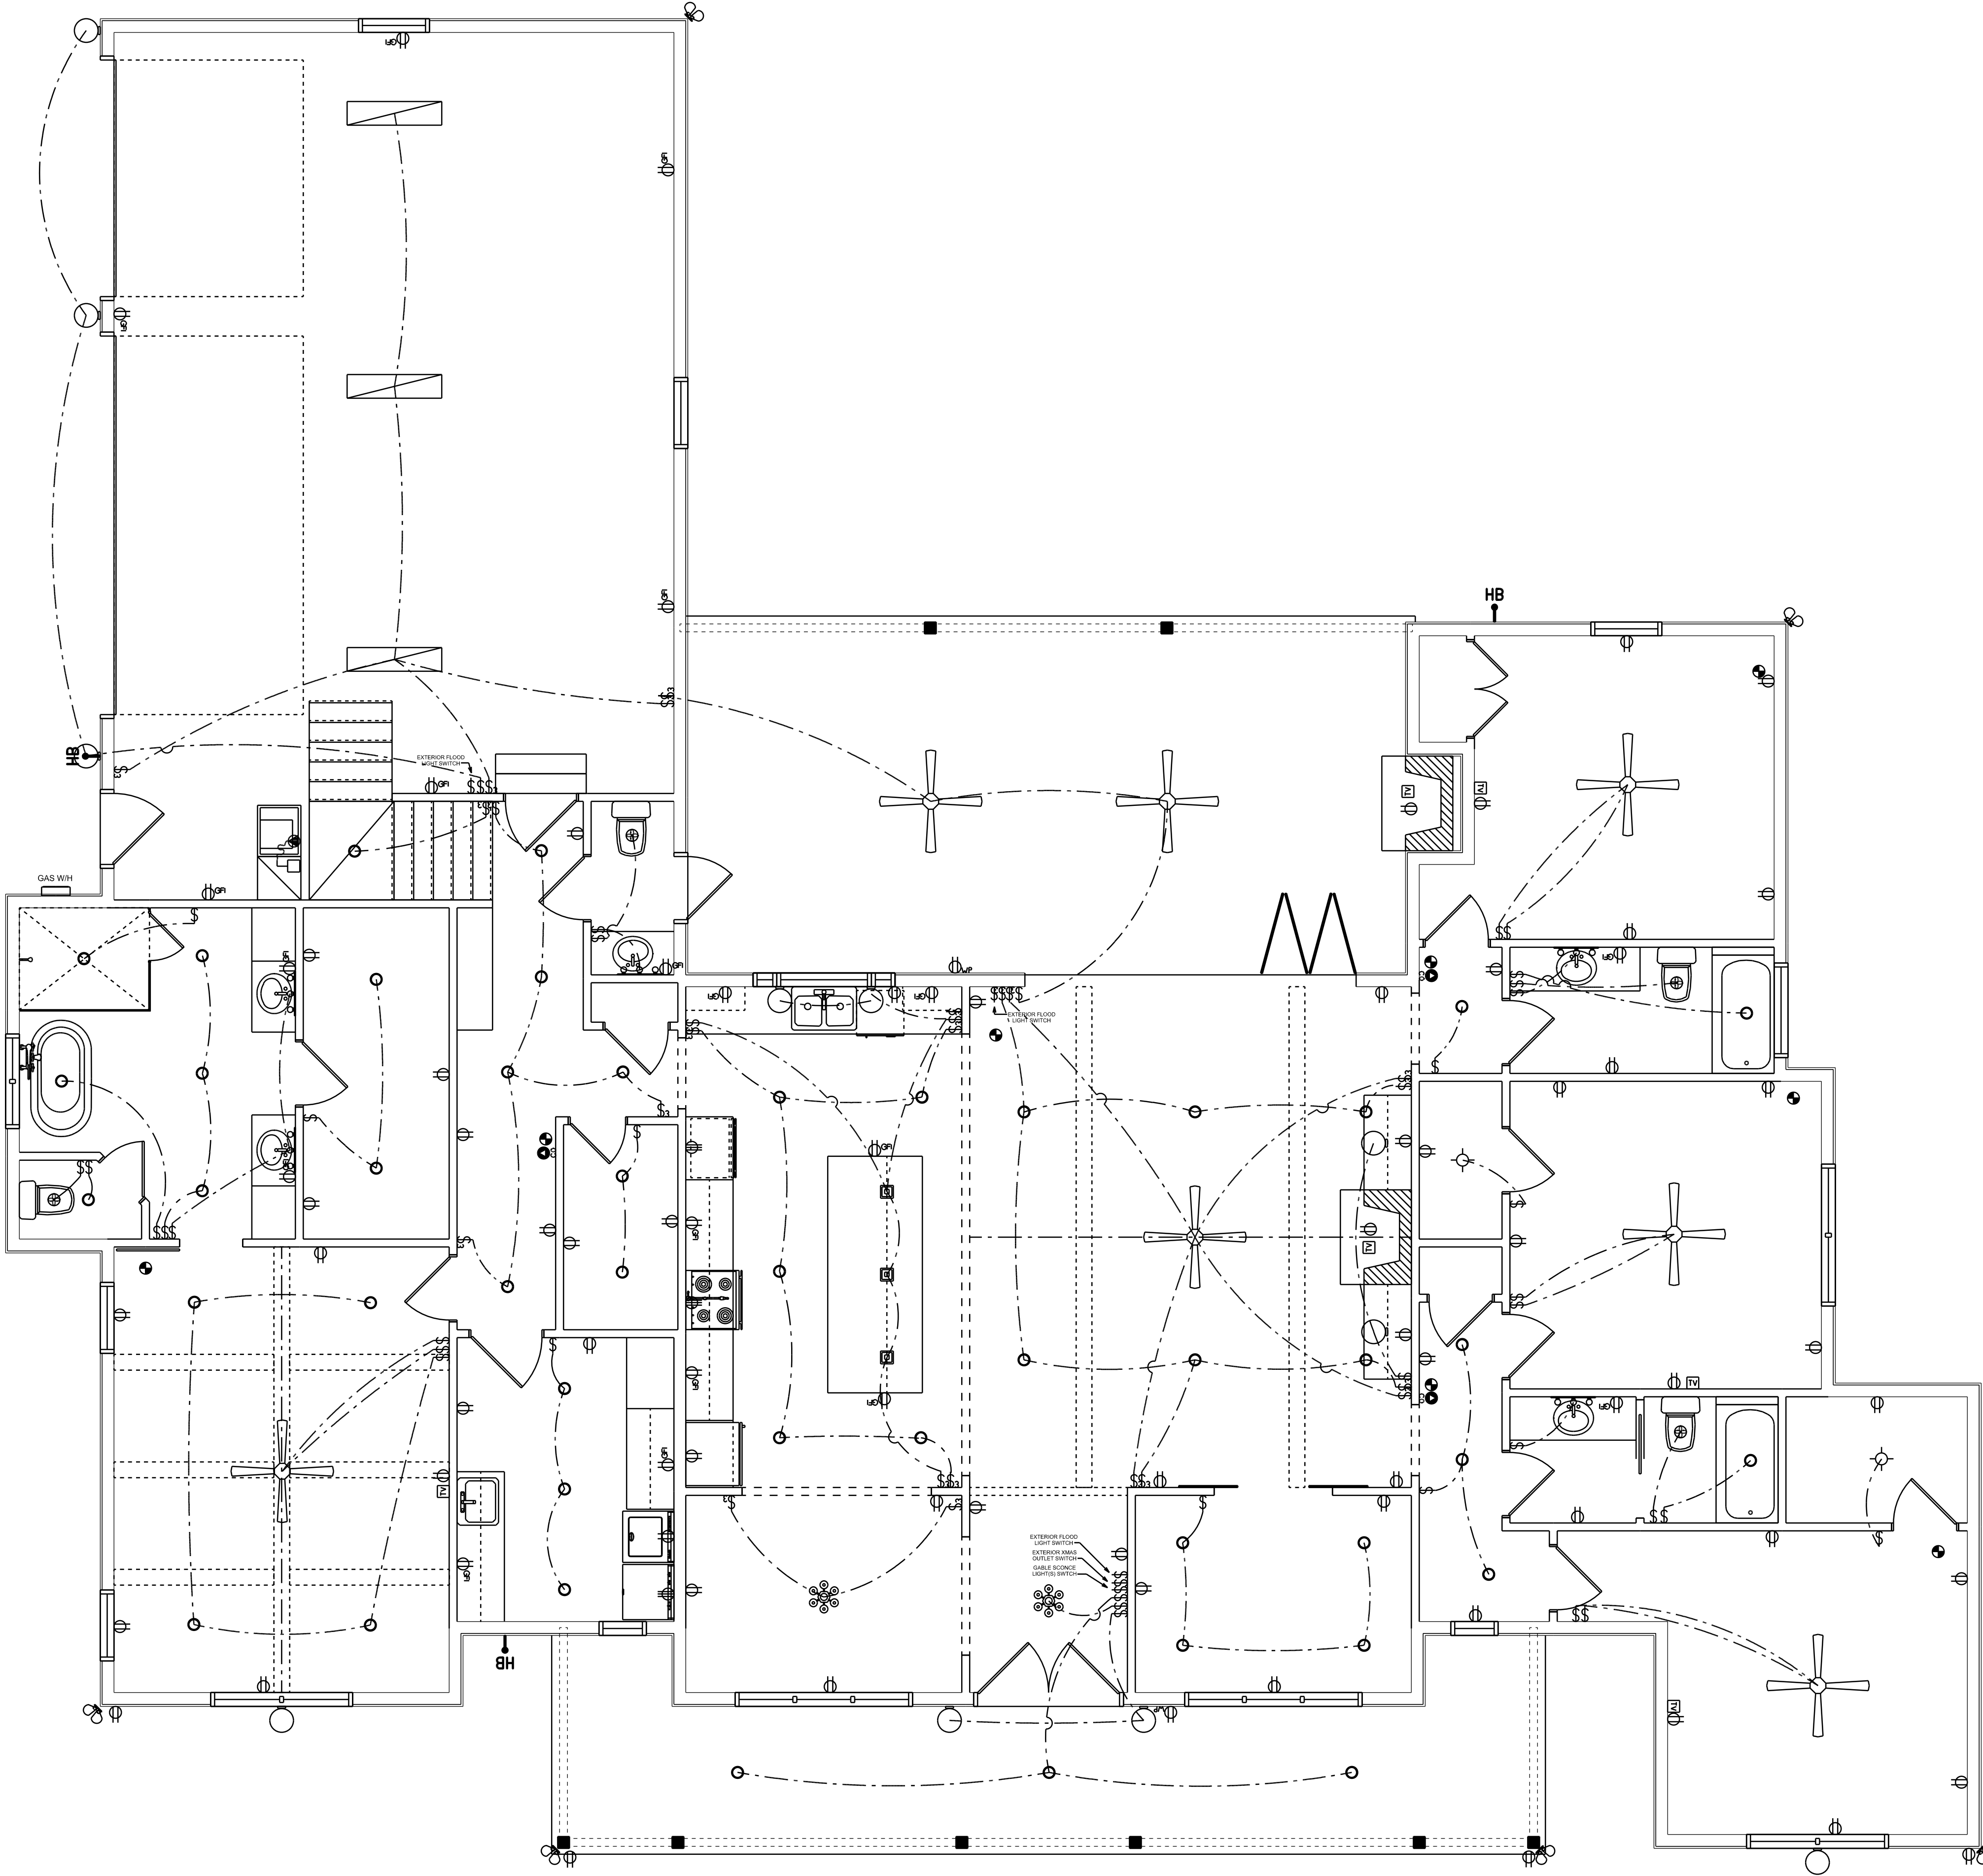

ELECTRICAL FLOOR PLAN
SCALE: 1/4" = 1'-0"

REVISIONS SCHEDULE	
Oct. 8th, 2021	PROPOSAL

RIDGEPOINT
DESIGN, INC
496 SW RING CT, LAKE CITY, FLORIDA 32025
P: 386-288-1188
E: RIDGEPOINTDESIGN@GMAIL.COM

GONZALEZ RESIDENCE
COLUMBIA COUNTY, FLORIDA

RIDGEPOINT
DESIGN, INC
496 SW RING CT, LAKE CITY, FLORIDA 32025
P: 386-288-1188
E: RIDGEPOINTDESIGN@GMAIL.COM

GONZALEZ RESIDENCE
COLUMBIA COUNTY, FLORIDA