


P:\1-10 Rest Area Improvements (19-049) GA14 - DrawingsA - Active Drawings\1 - B+P\Local Files\DD LOCAL\1-10 Rest_LOCAL_DD.rvt

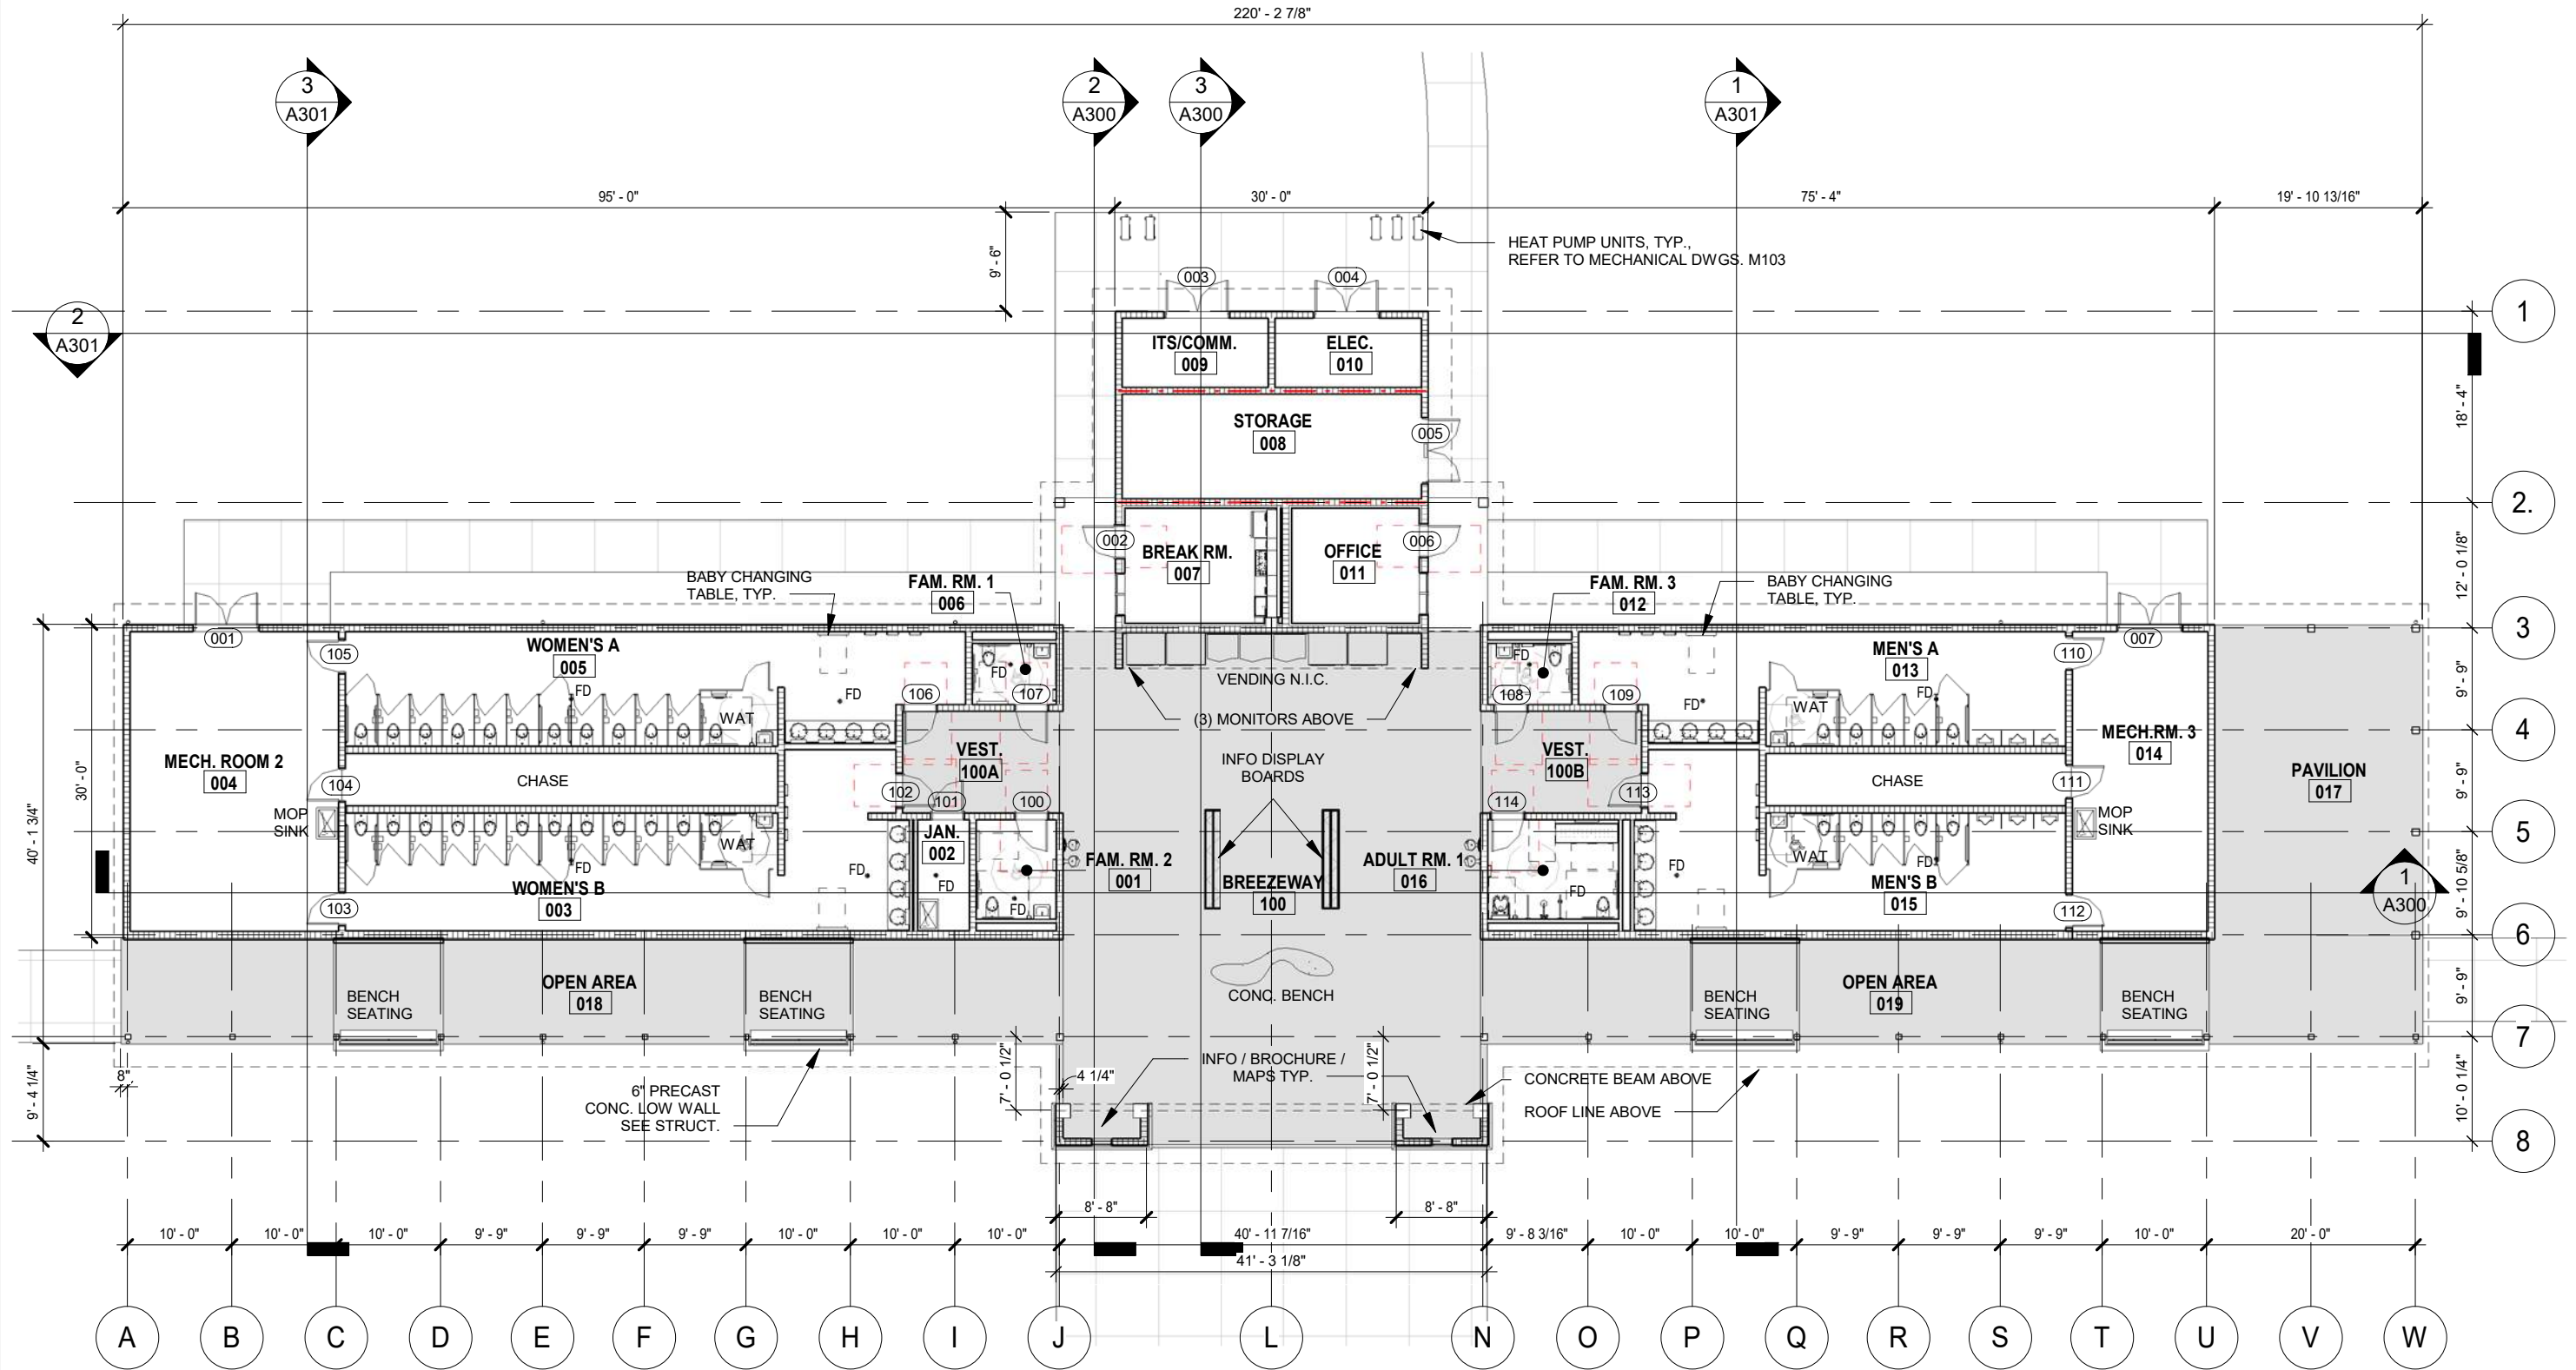

1 FLOOR PLAN
A100 1/16" = 1'-0"

1 PROJECT NORTH PHASE 2 - 90% SUBMITTAL

REVISIONS					
DATE	BY	DESCRIPTION	DATE	BY	DESCRIPTION




BORRELLI + PARTNERS
ARCHITECTURE PLANNING LANDSCAPE INTERIORS
720 Vassar Street, Orlando, FL 32804 407.418.1338 :: fax 407.418.1342
CONFIDENTIAL: THIS DRAWING IS THE PROPERTY OF BORRELLI + PARTNERS. UNLESS OTHERWISE PROVIDED, BY THE CONTRACT, THE CONTENTS OF THIS DRAWING ARE NOT TO BE TRANSMITTED TO ANY OTHER PARTY EXCEPT AS AGREED TO BY THE ARCHITECT. COPYRIGHT BORRELLI + PARTNERS, A/C 000711 / A/C 001842

STATE OF FLORIDA DEPARTMENT OF TRANSPORTATION		
ROAD NO.	COUNTY	FINANCIAL PROJECT ID
SR 8	COLUMBIA	438609-1-52-01

SR 8 (I-10) WESTBOUND - (COLUMBIA COUNTY) REST AREA
FLOOR PLAN

DRAWING NO.
A100
SHEET NO.

P:\1-10 Rest Area Improvements (19-049) GA\14 - Drawings\A - Active Drawings\1 - B+P\Local Files\DD LOCAL\1-10 Rest_LOCAL_DD.rvt

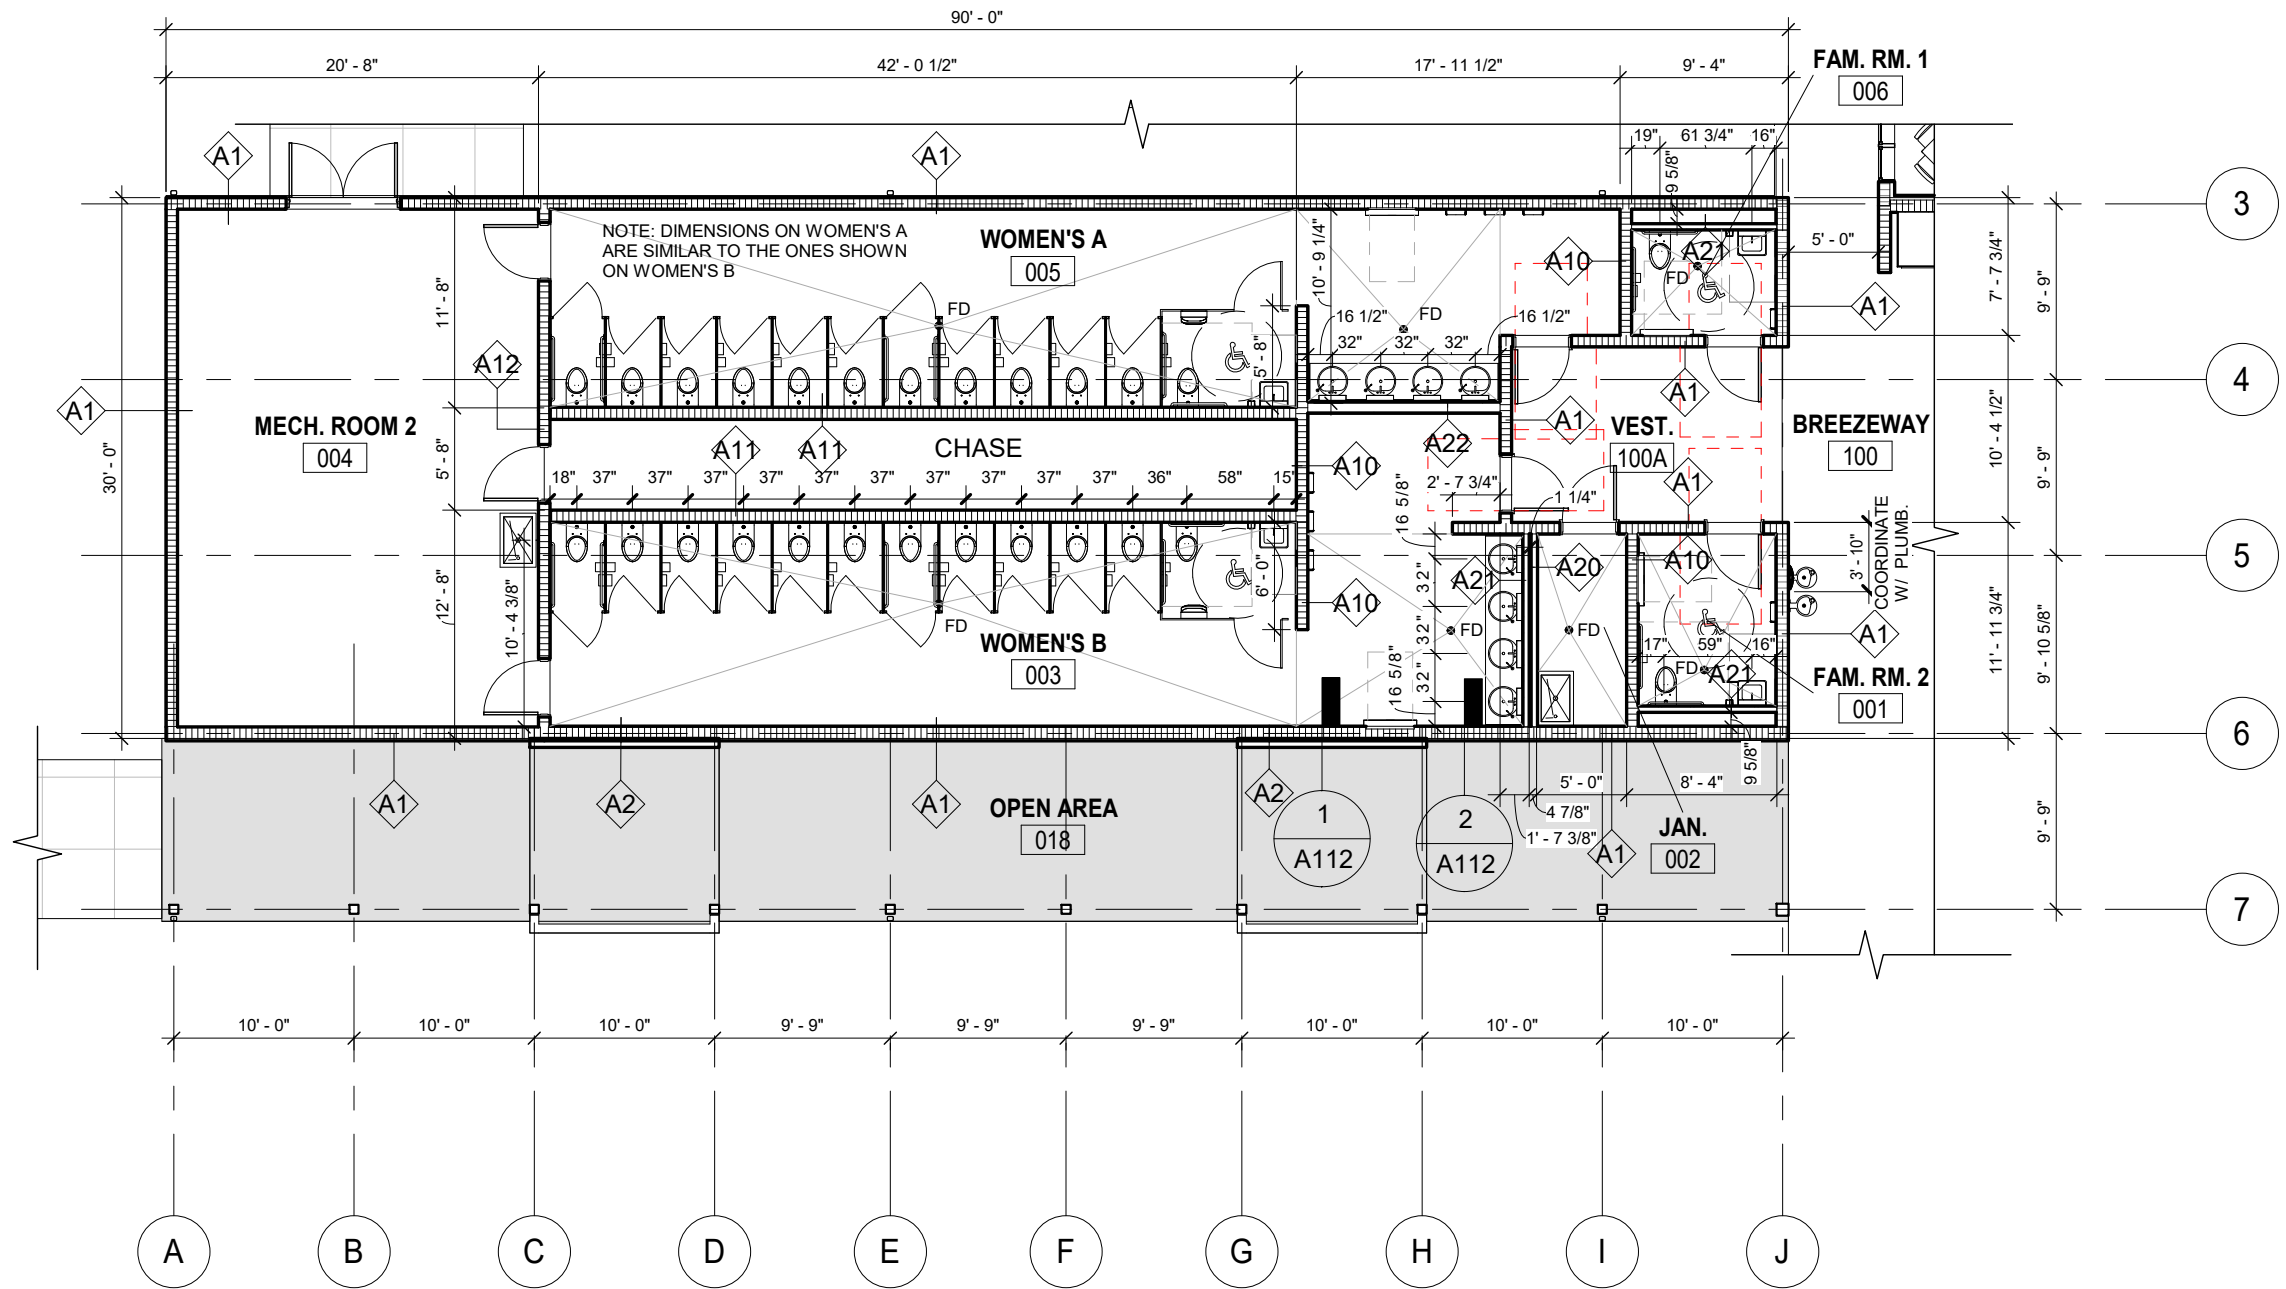

1 ENLARGED WOMENS
RESTROOM PLAN
3/32" = 1'-0"

PROJECT NORTH PHASE 2 - 90% SUBMITTAL

REVISIONS					
DATE	BY	DESCRIPTION	DATE	BY	DESCRIPTION




BORRELLI + PARTNERS
ARCHITECTURE PLANNING LANDSCAPE INTERIORS
720 Vassar Street, Orlando FL 32804 407.418.1338 :: fax 407.418.1342
CONFIDENTIAL: THIS DRAWING IS THE PROPERTY OF BORRELLI + PARTNERS UNLESS OTHERWISE PROVIDED. BY THE CONTRACT, THE CONTENTS OF THIS DRAWING ARE SHOWN AND SHALL NOT BE TRANSMITTED TO ANY OTHER PARTY EXCEPT AS AGREED TO BY THE ARCHITECT. COPYRIGHT BORRELLI + PARTNERS, A/C 000711 / A/C 001842

STATE OF FLORIDA DEPARTMENT OF TRANSPORTATION		
ROAD NO.	COUNTY	FINANCIAL PROJECT ID
SR 8	COLUMBIA	438609-1-52-01

SR 8 (I-10) WESTBOUND - (COLUMBIA COUNTY) REST AREA
ENLARGED WOMENS RESTROOM

DRAWING NO. A101
SHEET NO.

P:\1-10 Rest Area Improvements (19-049) GA14 - DrawingsA - Active Drawings1 - B+P\Local Files\DD LOCAL\1-10 Rest_LOCAL_DD.rvt

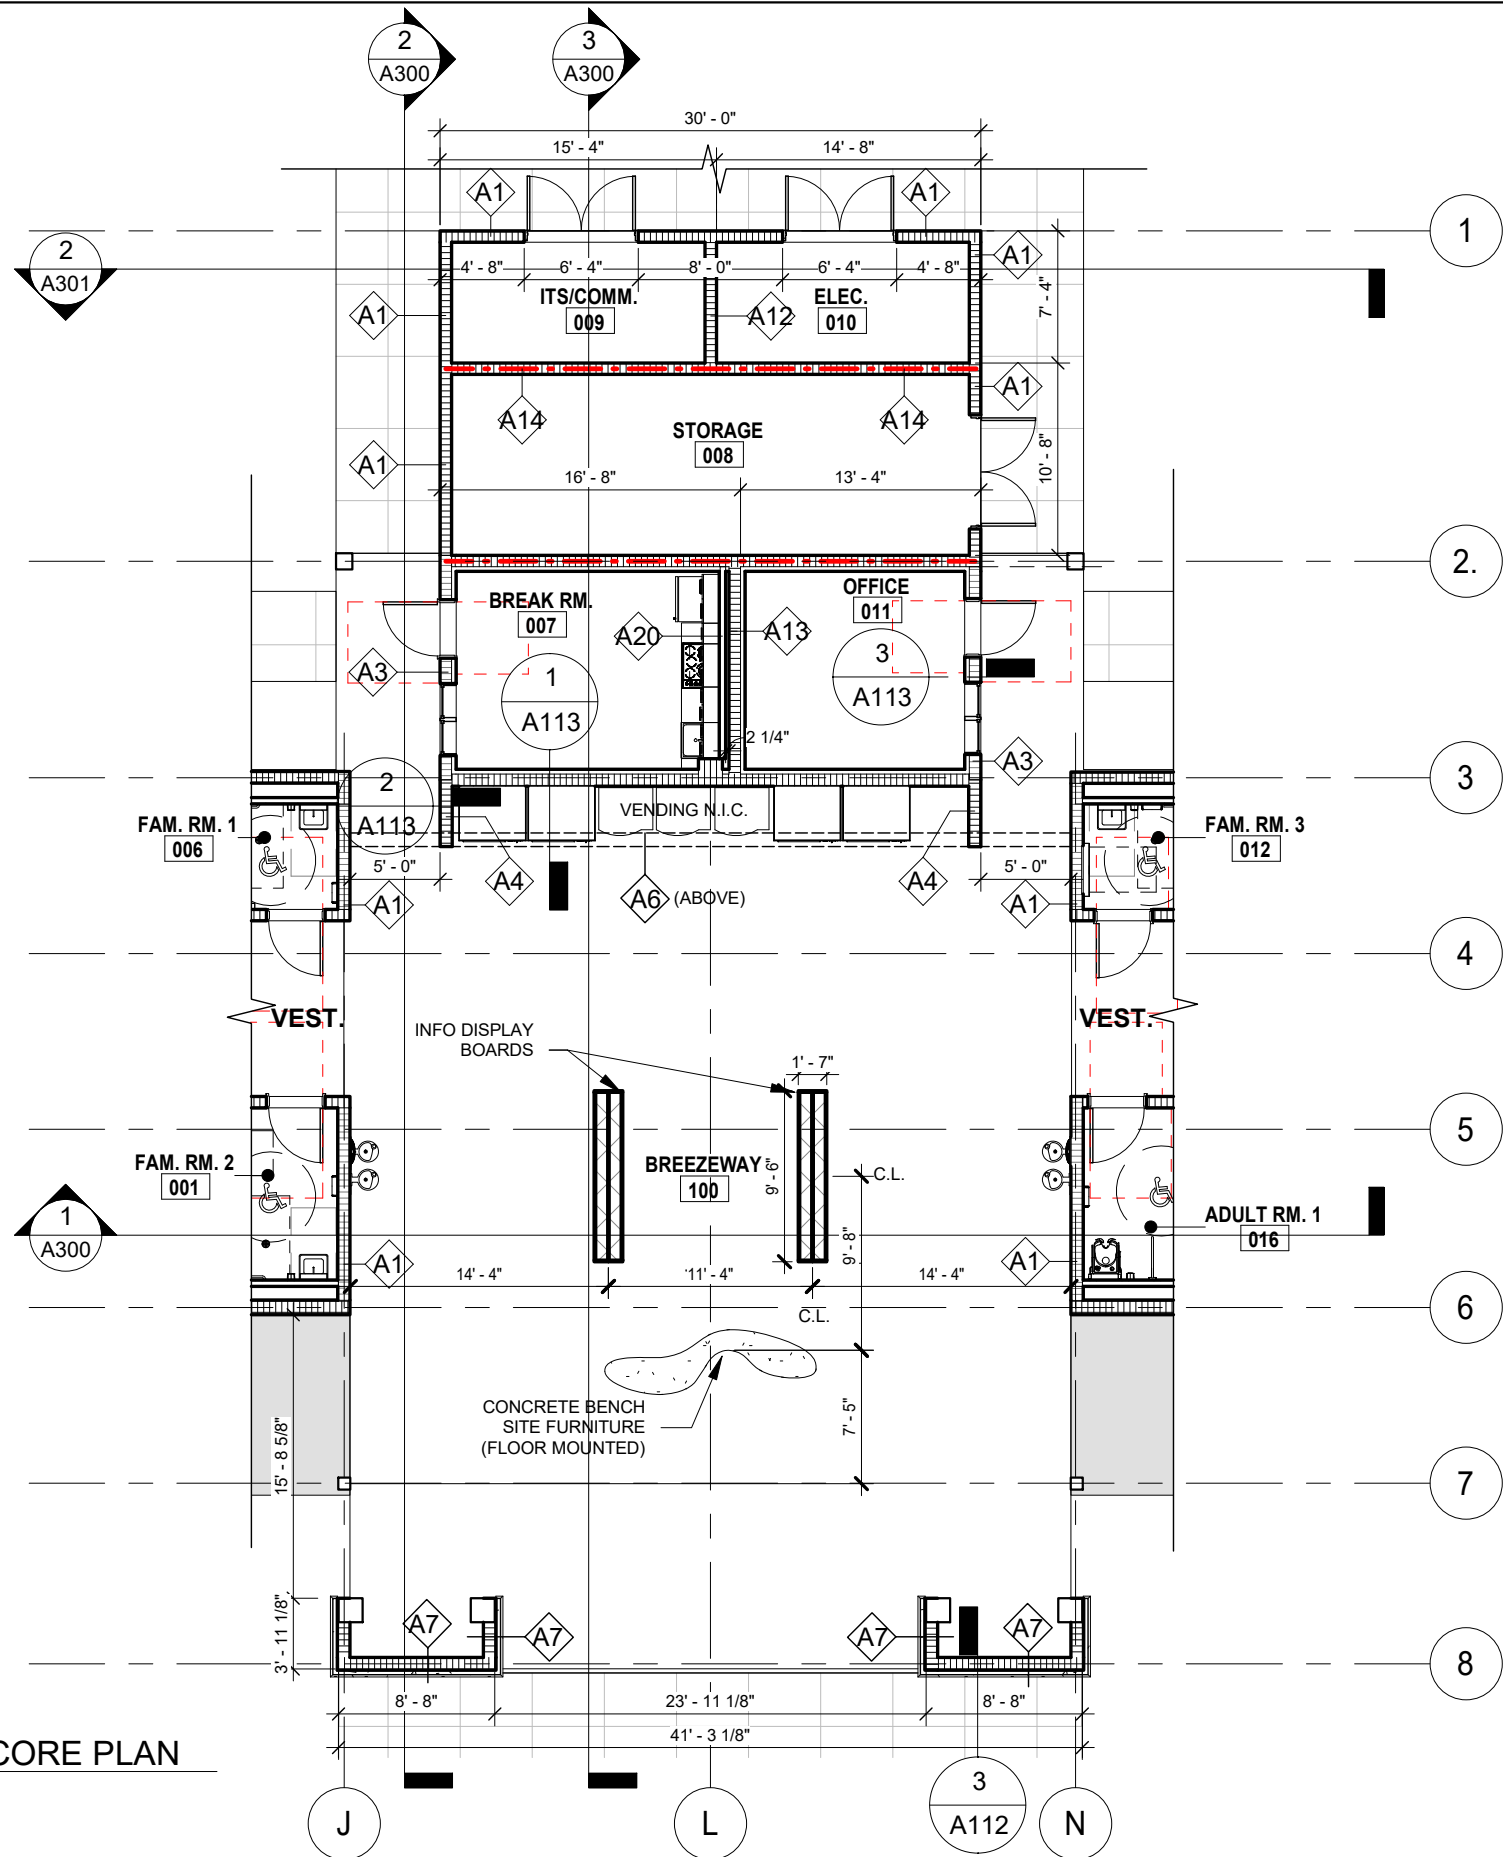

1 ENLARGED CORE PLAN
A102 3/32" = 1'-0"

PROJECT NORTH PHASE 2 - 90% SUBMITTAL

REVISIONS					
DATE	BY	DESCRIPTION	DATE	BY	DESCRIPTION




BORRELLI + PARTNERS
ARCHITECTURE PLANNING LANDSCAPE INTERIORS
720 Vassar Street, Orlando, FL 32804 407.418.1338 :: fax 407.418.1342
CONFIDENTIAL: THIS DRAWING IS THE PROPERTY OF BORRELLI + PARTNERS. UNLESS OTHERWISE PROVIDED, BY THE CONTRACT, THE CONTENTS OF THIS DRAWING ARE NOT TO BE TRANSMITTED TO ANY OTHER PARTY EXCEPT AS AGREED TO BY THE ARCHITECT. COPYRIGHT BORRELLI + PARTNERS, A/C 000711 / A/C 001842

STATE OF FLORIDA DEPARTMENT OF TRANSPORTATION		
ROAD NO.	COUNTY	FINANCIAL PROJECT ID
SR 8	COLUMBIA	438609-1-52-01

SR 8 (I-10) WESTBOUND - (COLUMBIA COUNTY) REST AREA		DRAWING NO.
ENLARGED CORE PLAN		A102
		SHEET NO.

P:\1-10 Rest Area Improvements (19-049) GAI\4 - Drawings\A - Active Drawings\1 - B+P\Local Files\DD LOCAL\1-10 Rest_LOCAL_DD.rvt

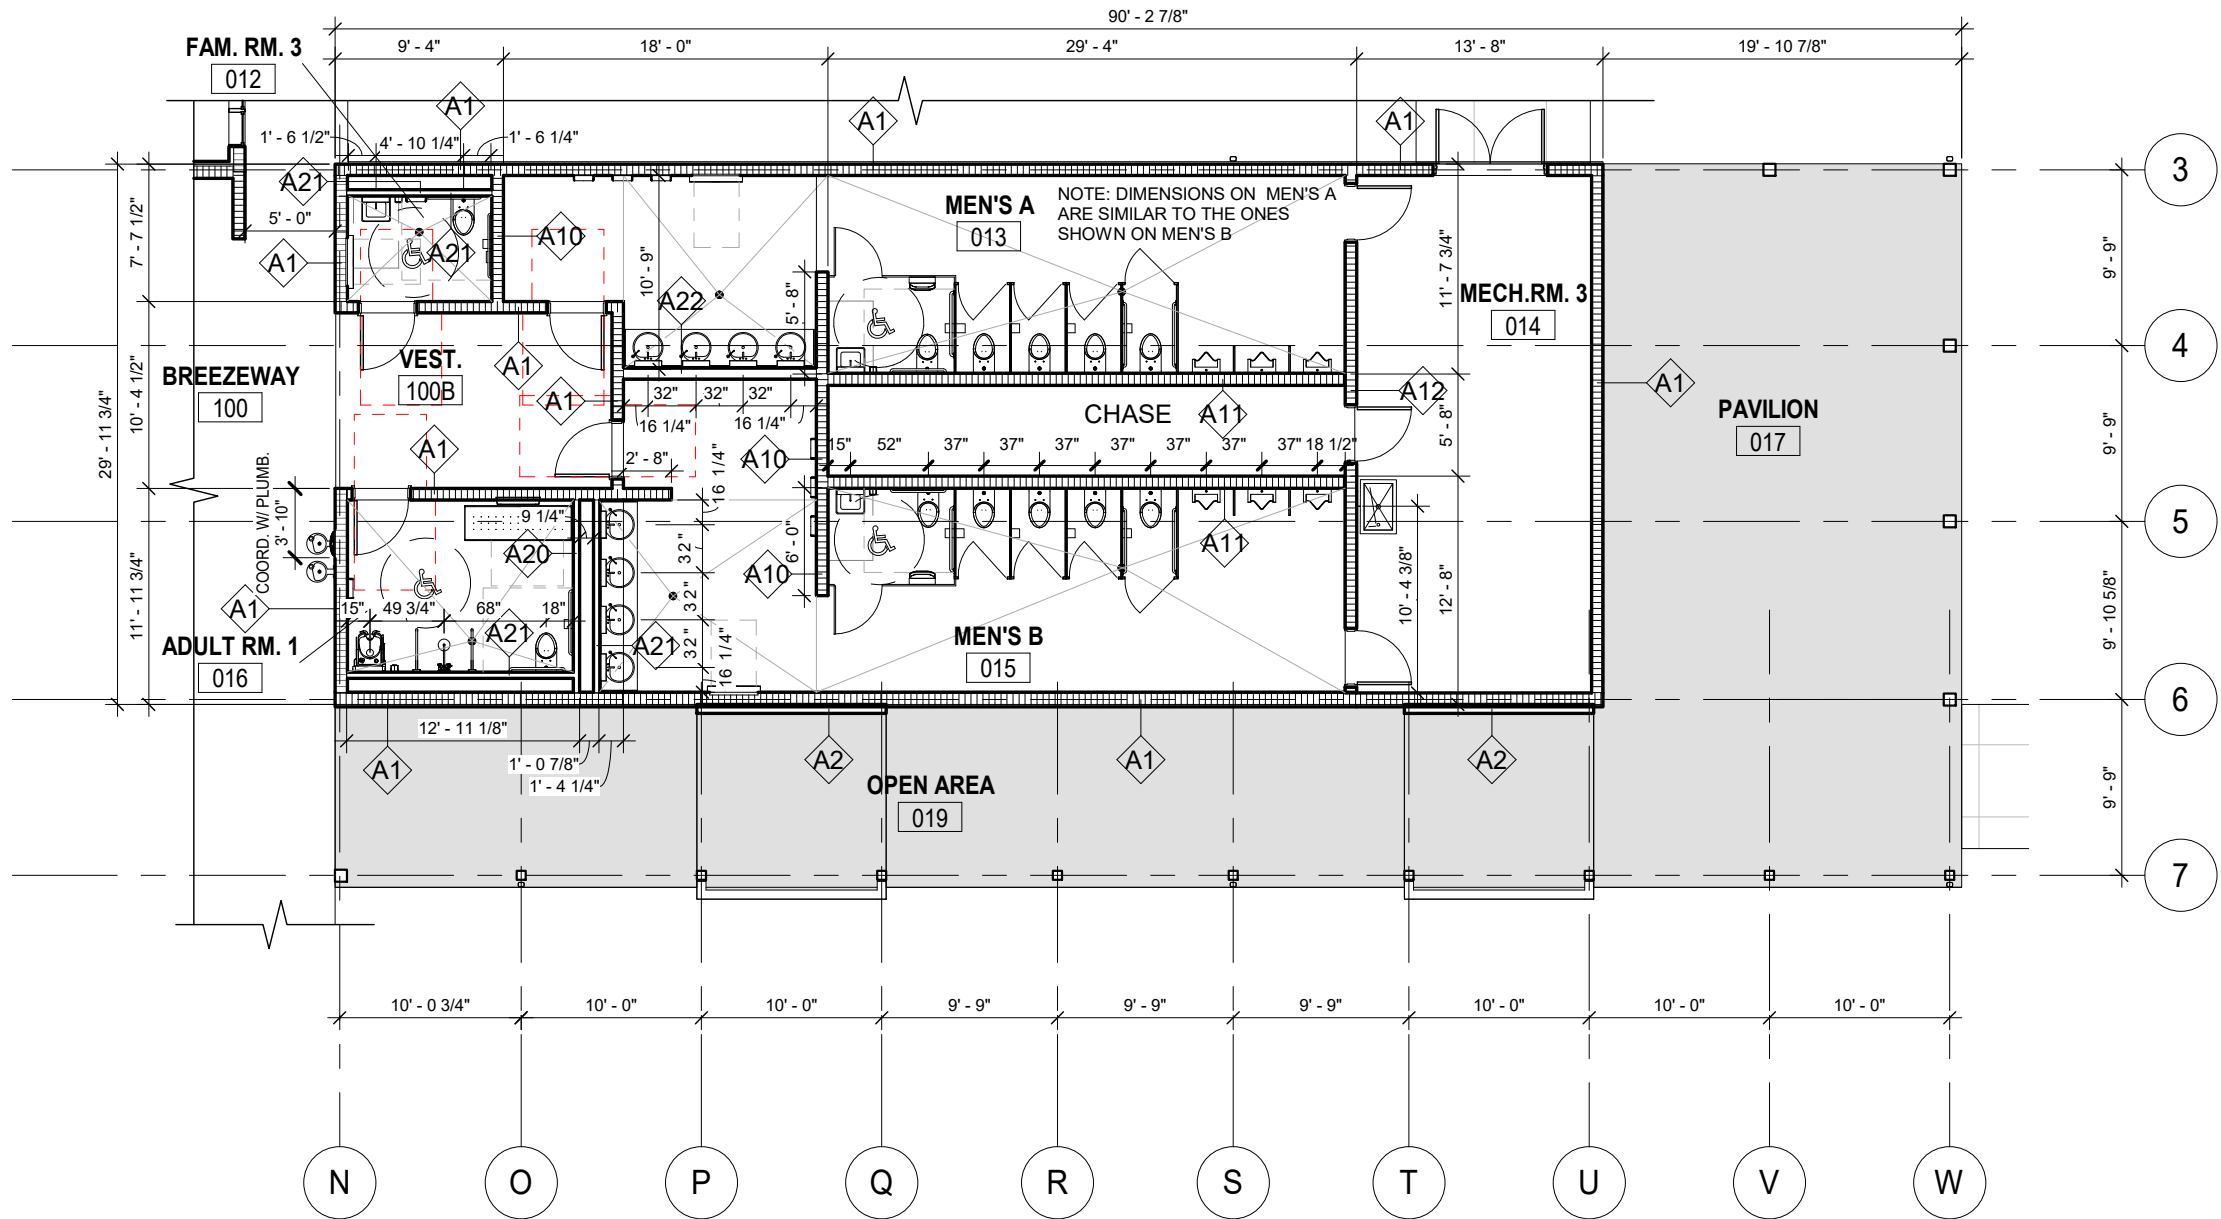

1
A103

ENLARGED MENS RESTROOM
PLAN
 $\frac{3}{32}'' = 1'-0''$

PROJECT NORTH

PHASE 2 - 90% SUBMITTAL

REVISIONS					
DATE	BY	DESCRIPTION	DATE	BY	DESCRIPTION








BORRELLI + PARTNERS
ARCHITECTURE PLANNING LANDSCAPE INTERIORS
720 Vassar Street, Orlando, FL 32804 407.418.1338 :: fax 407.418.1342
CONFIDENTIAL: THIS DRAWING IS THE PROPERTY OF BORRELLI + PARTNERS. UNLESS OTHERWISE PROVIDED, BY THE CONTRACT, THE CONTENTS OF THIS DRAWING ARE NOT TO BE TRANSMITTED TO ANY OTHER PARTY EXCEPT AS AGREED TO BY THE ARCHITECT. COPYRIGHT BORRELLI + PARTNERS, AEC 000711 / ACC 001842

STATE OF FLORIDA DEPARTMENT OF TRANSPORTATION		
ROAD NO.	COUNTY	FINANCIAL PROJECT ID
SR 8	COLUMBIA	438609-1-52-01

SR 8 (I-10) WESTBOUND - (COLUMBIA COUNTY) REST AREA
ENLARGED MENS RESTROOM PLAN

DRAWING NO. A103
SHEET NO.

   Interior Wall Type Schedule - CMU

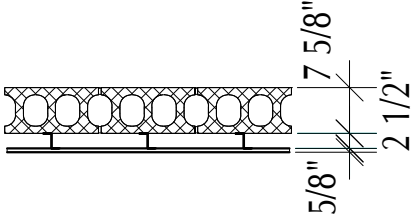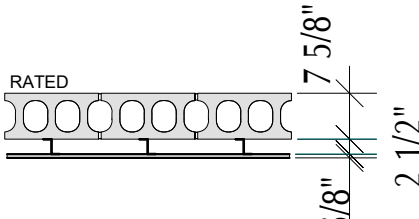TYPE	HEIGHT	INDICATION	DESCRIPTION	RATING	REMARKS
A10	12'-0" HT.		8" CMU TO INDICATED HEIGHT	NON-RATED	SEE STRUCT FOR REINFORCING STEEL REQUIREMENTS
A11	12'-0" HT.		8" CMU TO INDICATED HEIGHT WALL TILE (THIN SET)	NON-RATED	SEE STRUCT FOR REINFORCING STEEL REQUIREMENTS
A12	FULL SIZE (TO STRUCTURE)		8" CMU FULL SIZE TO STRUCTURE	NON-RATED	SEE STRUCT FOR REINFORCING STEEL REQUIREMENTS
A13	FULL SIZE (TO STRUCTURE)		8" CMU FULL SIZE TO STRUCTURE 2-1/2" "Z" FURRING CHANNELS 16 GA. @16" 5/8" GYPSUM WALL BOARD	NON-RATED	SEE STRUCT FOR REINFORCING STEEL REQUIREMENTS
A14	FULL SIZE (TO STRUCTURE)		8" <u>RATED</u> CMU FULL SIZE TO STRUCTURE	1 HR RATED	SEE STRUCT FOR REINFORCING STEEL REQUIREMENTS
A15	FULL SIZE (TO STRUCTURE)		8" <u>RATED</u> CMU FULL SIZE TO STRUCTURE 2-1/2" "Z" FURRING CHANNELS 16 GA. @16" 5/8" GYPSUM WALL BOARD	1 HR RATED	SEE STRUCT FOR REINFORCING STEEL REQUIREMENTS

NOTE: WALL TYPES FOR EXTERIOR WALLS ARE SHOWN ON THE WALL SECTIONS SHEETS A112 AND A113

 PROJECT NORTH

PHASE 2 - 90% SUBMITTAL

REVISIONS

DATE	BY	DESCRIPTION	DATE	BY	DESCRIPTION



BORRELLI + PARTNERS
ARCHITECTURE PLANNING LANDSCAPE INTERIORS
720 Vassar Street, Orlando FL 32804 407.418.1338 :: fax 407.418.1342
CONFIDENTIAL: THIS DRAWING IS THE PROPERTY OF BORRELLI + PARTNERS. UNLESS OTHERWISE PROVIDED, BY THE CONTRACT, THE CONTENTS OF THIS DRAWING ARE NOT TO BE TRANSMITTED TO ANY OTHER PARTY EXCEPT AS AGREED TO BY THE ARCHITECT. COPYRIGHT BORRELLI + PARTNERS, A/C 000711 / ACC 001842

STATE OF FLORIDA
DEPARTMENT OF TRANSPORTATION

ROAD NO.	COUNTY	FINANCIAL PROJECT ID
SR 8	COLUMBIA	438609-1-52-01

SR 8 (I-10) WESTBOUND - (COLUMBIA COUNTY) REST AREA

 

INTERIOR WALL TYPES

DRAWING NO.
A110

SHEET NO.

P:\1-10 Rest Area Improvements (19-049) GA14 - DrawingsA - Active Drawings1 - B+P\Local Files\DD LOCAL\1-10 Rest_LOCAL_DD.rvt

Interior Wall Type Schedule - Mtl. Framing

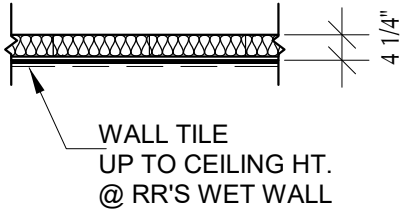TYPE	HEIGHT	INDICATION	DESCRIPTION	RATING	REMARKS
A20	12'-0" HT.		3-5/8" METAL STUDS 16 GA. @16" 5/8" GREEN BOARD (WATER RESISTANT)	NON-RATED	
A21	12'-0" HT.		3-5/8" MTL STUDS 16 GA. @16" WITH ACOUSTICAL INSULATION 5/8" WATER RESISTANT WALL BOARD 1/2" CEMENT BOARD WALL TILE THIN SET	NON-RATED	
A22	12'-0" HT.		5/8" WATER RESISTANT GYPSUM BOARD 6" METAL STUDS 16 GA. @16" WITH ACOUSTICAL INSULATION 5/8" WATER RESISTANT WALL BOARD 1/2" CEMENT BOARD WALL TILE THIN SET (ONE SIDE)	NON-RATED	

NOTE: WALL TYPES FOR EXTERIOR WALLS ARE SHOWN ON THE WALL SECTIONS SHEETS A112 AND A113

P:\1-10 Rest Area Improvements (19-049) GA14 - DrawingsA - Active Drawings1 - B+P\Local Files\DD LOCAL\1-10 Rest_LOCAL_DD.rvt

REVISIONS

DATE	BY	DESCRIPTION	DATE	BY	DESCRIPTION



BORRELLI + PARTNERS
ARCHITECTURE PLANNING LANDSCAPE INTERIORS
720 Vassar Street, Orlando FL 32804 407.418.1338 :: fax 407.418.1342
CONFIDENTIAL: THIS DRAWING IS THE PROPERTY OF BORRELLI + PARTNERS. UNLESS OTHERWISE PROVIDED, BY THE CONTRACT, THE CONTENTS OF THIS DRAWING ARE NOT TO BE TRANSMITTED TO ANY OTHER PARTY EXCEPT AS AGREED TO BY THE ARCHITECT. COPYRIGHT BORRELLI + PARTNERS, A/C 000711 / A/C 001842

STATE OF FLORIDA
DEPARTMENT OF TRANSPORTATION

ROAD NO.	COUNTY	FINANCIAL PROJECT ID
SR 8	COLUMBIA	438609-1-52-01

PROJECT NORTH

PHASE 2 - 90% SUBMITTAL

SR 8 (I-10) WESTBOUND - (COLUMBIA COUNTY) REST AREA

INTERIOR WALL TYPES

DRAWING NO.
A111

SHEET NO.

P:\1-10 Rest Area Improvements (19-049) GA14 - DrawingsA - Active Drawings\1 - B+P\Local Files\DD LOCAL\1-10 Rest_LOCAL_DD.rvt

STANDING SEAM METAL ROOF
AND SELF ADHERING
UNDERLAYMENT OVER RIGID
INSULATION AND METAL DECK.

SLOPED
CONCRETE
ENDWALL WITH
DECORATIVE
LOUVER

FOAM-PLASTIC
MOLDING

17' - 4"

13' - 11"

STUCCO FINISH ON 8" CMU

A7

STONE TRIM

3' - 4"

SPLIT FACED 12"CMU

METAL ROOF FRAMING

T&G WOOD CEILING

SIDING BEYOND

METAL FRAMING AROUND
CONCRETE TIE BEAM,
FOR MOUNTING OF
BUILDING SIGN

PAINT OVER CONC. COLUMN

PAINT OVER 8" CMU

PAINT OVER 12"
SPLIT FACED CMU

BREEZEWAY
100

3 Wall Type 7
A112 3/16" = 1'-0"

6

7

STANDING SEAM METAL ROOF
AND SELF ADHERING
UNDERLAYMENT OVER RIGID
INSULATION AND METAL DECK.

STANDING SEAM METAL ROOF AND SELF
ADHERING UNDERLAYMENT OVER RIGID
INSULATION AND T&G WOOD DECK

2-COURSE
BOND BEAM

11' - 0"

GWB CLNG

8" CMU

LINTEL

WINDOW AS SCHEDULED

SIDING
ON 2-1/2" "Z" FURRING AND
WATER RESISTIVE BARRIER
OVER 8" CMU

CAST STONE

SPLIT FACED 8" CMU

WOMEN'S B
003

2 Wall Type 1
A112 3/16" = 1'-0"

6

7

STANDING SEAM METAL ROOF AND SELF
ADHERING UNDERLAYMENT OVER RIGID
INSULATION AND METAL DECK.

ALUM DECORATIVE LOUVER ON 8" CMU
(SEE MECH FOR LOCATION OF INTAKE AND
EXHAUST OPENINGS BEHIND SOME LOUVERS)

8X12 RAKED TIE BEAM

8" CMU

2-COURSE
BOND BEAM

11' - 0"

GWB CLNG

12" CMU

A2

SIDING (ACCENT COLOR)
ON 2-1/2" "Z" FURRING AND
WATER RESISTIVE BARRIER
OVER 12" CMU

WOMEN'S B
003

1 Wall Type 2
A112 3/16" = 1'-0"

PROJECT NORTH

PHASE 2 - 90% SUBMITTAL


REVISIONS					
DATE	BY	DESCRIPTION	DATE	BY	DESCRIPTION

BORRELLI + PARTNERS
ARCHITECTURE PLANNING LANDSCAPE INTERIORS
720 Vassar Street, Orlando, FL 32804 407.418.1338 :: fax 407.418.1342
CONFIDENTIAL: THIS DRAWING IS THE PROPERTY OF BORRELLI + PARTNERS. UNLESS OTHERWISE PROVIDED, BY THE CONTRACT, THE CONTENTS OF THIS DRAWING ARE TO REMAIN THE PROPERTY OF BORRELLI + PARTNERS. EXCEPT AS AGREED TO BY THE ARCHITECT, COPYRIGHT BORRELLI + PARTNERS, A/C 000711 / ACC 001842


STATE OF FLORIDA DEPARTMENT OF TRANSPORTATION		
ROAD NO.	COUNTY	FINANCIAL PROJECT ID
SR 8	COLUMBIA	438609-1-52-01

SR 8 (I-10) WESTBOUND - (COLUMBIA COUNTY) REST AREA		DRAWING NO.
EXTERIOR WALL TYPES		A112
		SHEET NO.


P:\1-10 Rest Area Improvements (19-049) GA14 - DrawingsA - Active Drawings\1 - B+P\Local Files\DD LOCAL\1-10 Rest_LOCAL_DD.rvt

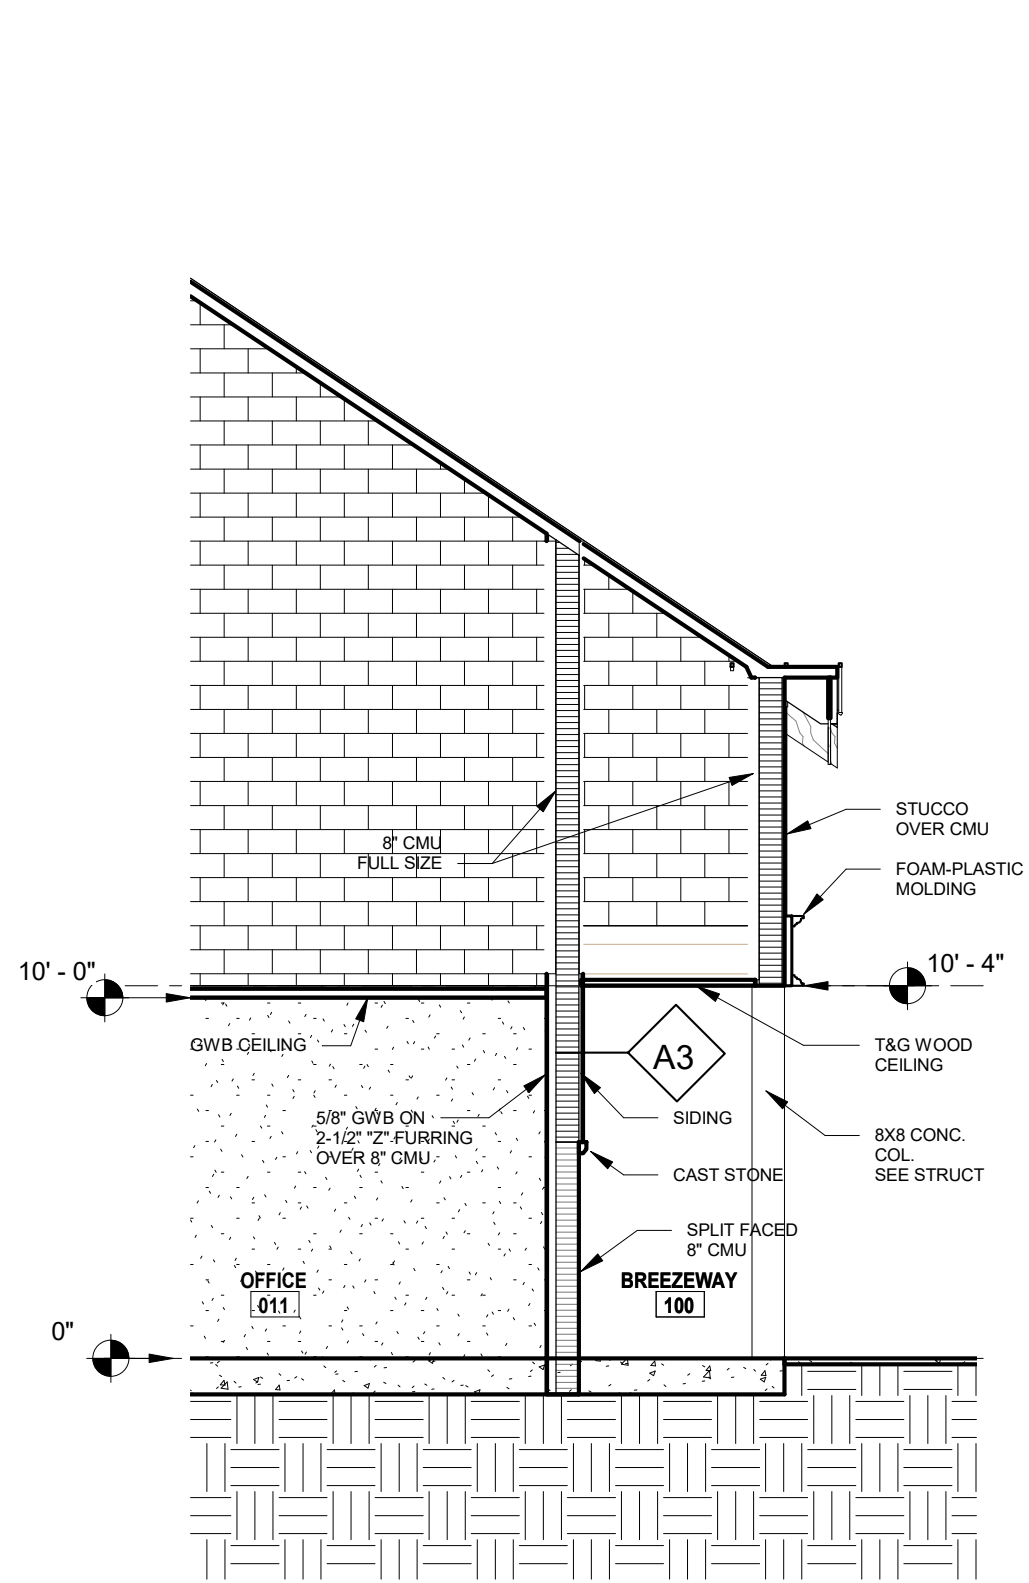

3 Wall Type A3
A113 3/16" = 1'-0"

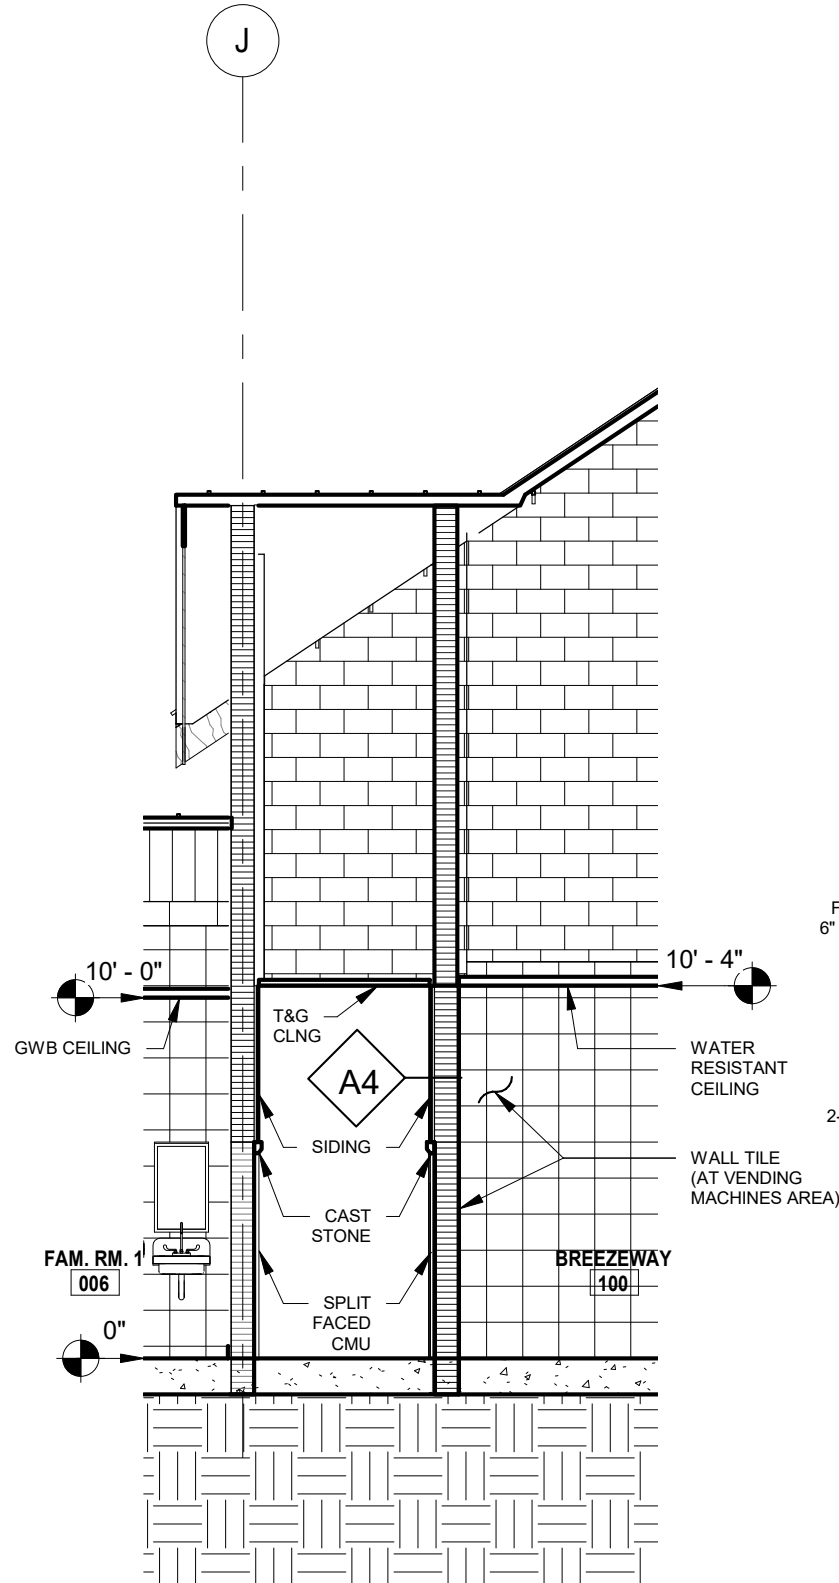

2 Wall Type A4
A113 3/16" = 1'-0"

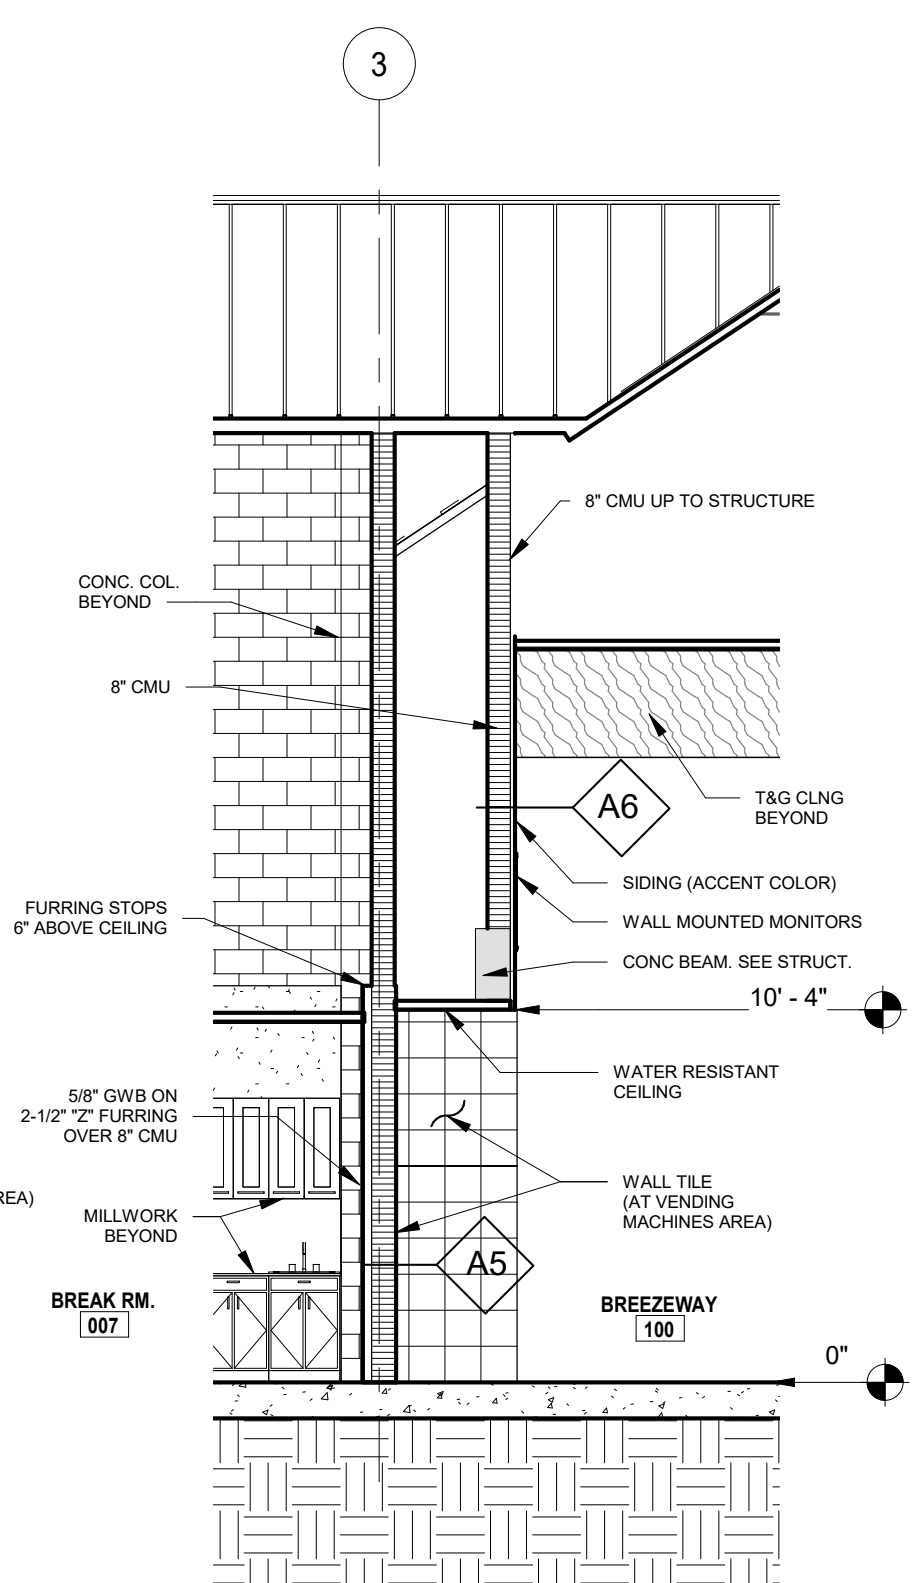


1 Wall Types A5 & A6
A113 3/16" = 1'-0"

1 PROJECT NORTH PHASE 2 - 90% SUBMITTAL

REVISIONS						 BORRELLI + PARTNERS ARCHITECTURE PLANNING LANDSCAPE INTERIORS 720 Vassar Street, Orlando FL 32804 407.418.1338 :: fax 407.418.1342 CONFIDENTIAL: THIS DRAWING IS THE PROPERTY OF BORRELLI + PARTNERS. UNLESS OTHERWISE PROVIDED, BY THE CONTRACT, THE CONTENTS OF THIS DRAWING ARE NOT TO BE TRANSMITTED TO ANY OTHER PARTY EXCEPT AS AGREED TO BY THE ARCHITECT. COPYRIGHT BORRELLI + PARTNERS, A/C 000711 / ACC 001842	STATE OF FLORIDA DEPARTMENT OF TRANSPORTATION			SR 8 (I-10) WESTBOUND - (COLUMBIA COUNTY) REST AREA		DRAWING NO. A113
DATE	BY	DESCRIPTION	DATE	BY	DESCRIPTION		ROAD NO.	COUNTY	FINANCIAL PROJECT ID	EXTERIOR WALL TYPES		SHEET NO.
							SR 8	COLUMBIA	438609-1-52-01			

P:\1-10 Rest Area Improvements (19-049) GA14 - DrawingsA - Active Drawings\1 - B+P\Local Files\DD LOCAL\1-10 Rest_LOCAL_DD.rvt

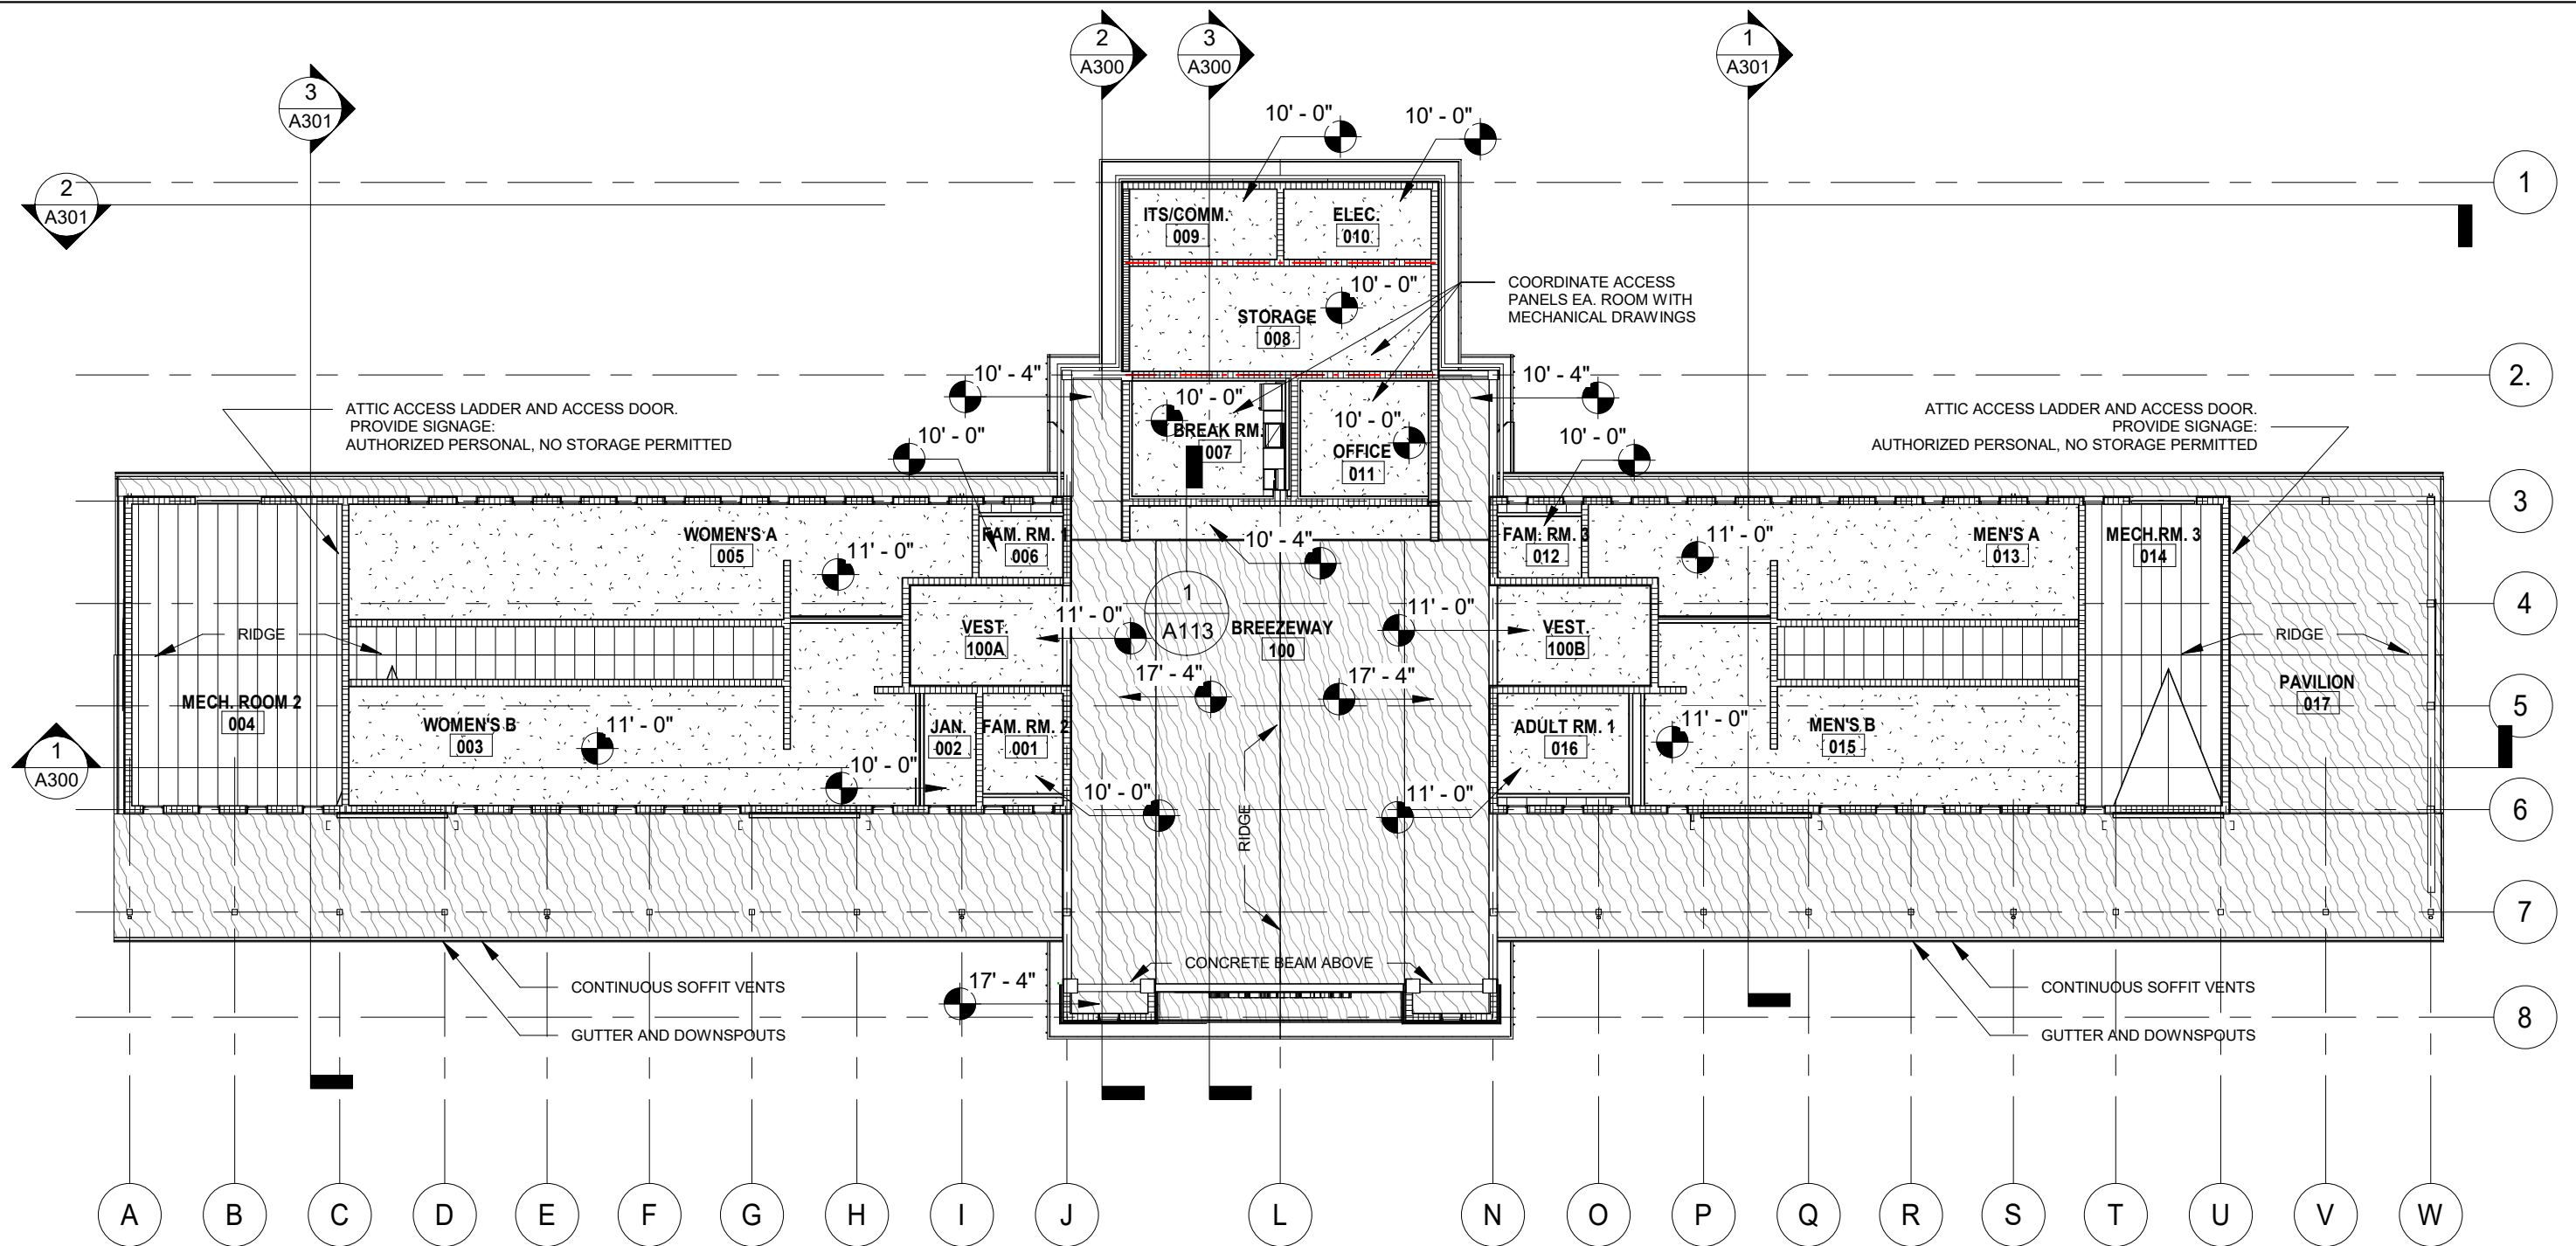

CEILING LEGEND AND SYMBOLS

SYMBOL	LEGEND
	T&G WOOD CEILING
	PLASTER OVER CEMENT BOARD
	OPEN TO STRUCTURE ABOVE

1 REFLECTED CEILING PLAN
A120 1/16" = 1'-0"

1 PROJECT NORTH PHASE 2 - 90% SUBMITTAL

REVISIONS					
DATE	BY	DESCRIPTION	DATE	BY	DESCRIPTION


BORRELLI + PARTNERS
ARCHITECTURE PLANNING LANDSCAPE INTERIORS
720 Vassar Street, Orlando, FL 32804 407.418.1338 :: fax 407.418.1342
CONFIDENTIAL: THIS DRAWING IS THE PROPERTY OF BORRELLI + PARTNERS. UNLESS OTHERWISE PROVIDED, BY THE CONTRACT, THE CONTENTS OF THIS DRAWING ARE NOT TO BE TRANSMITTED TO ANY OTHER PARTY EXCEPT AS AGREED TO BY THE ARCHITECT. COPYRIGHT BORRELLI + PARTNERS, A/C 000711 / ACC 001842

STATE OF FLORIDA DEPARTMENT OF TRANSPORTATION		
ROAD NO.	COUNTY	FINANCIAL PROJECT ID
SR 8	COLUMBIA	438609-1-52-01

SR 8 (I-10) WESTBOUND - (COLUMBIA COUNTY) REST AREA
REFLECTED CEILING PLAN

DRAWING NO.
A120
SHEET NO.

P:\1-10 Rest Area Improvements (19-049) GA14 - DrawingsA - Active Drawings\1 - B+P\Local Files\DD LOCAL\1-10 Rest_LOCAL_DD.rvt

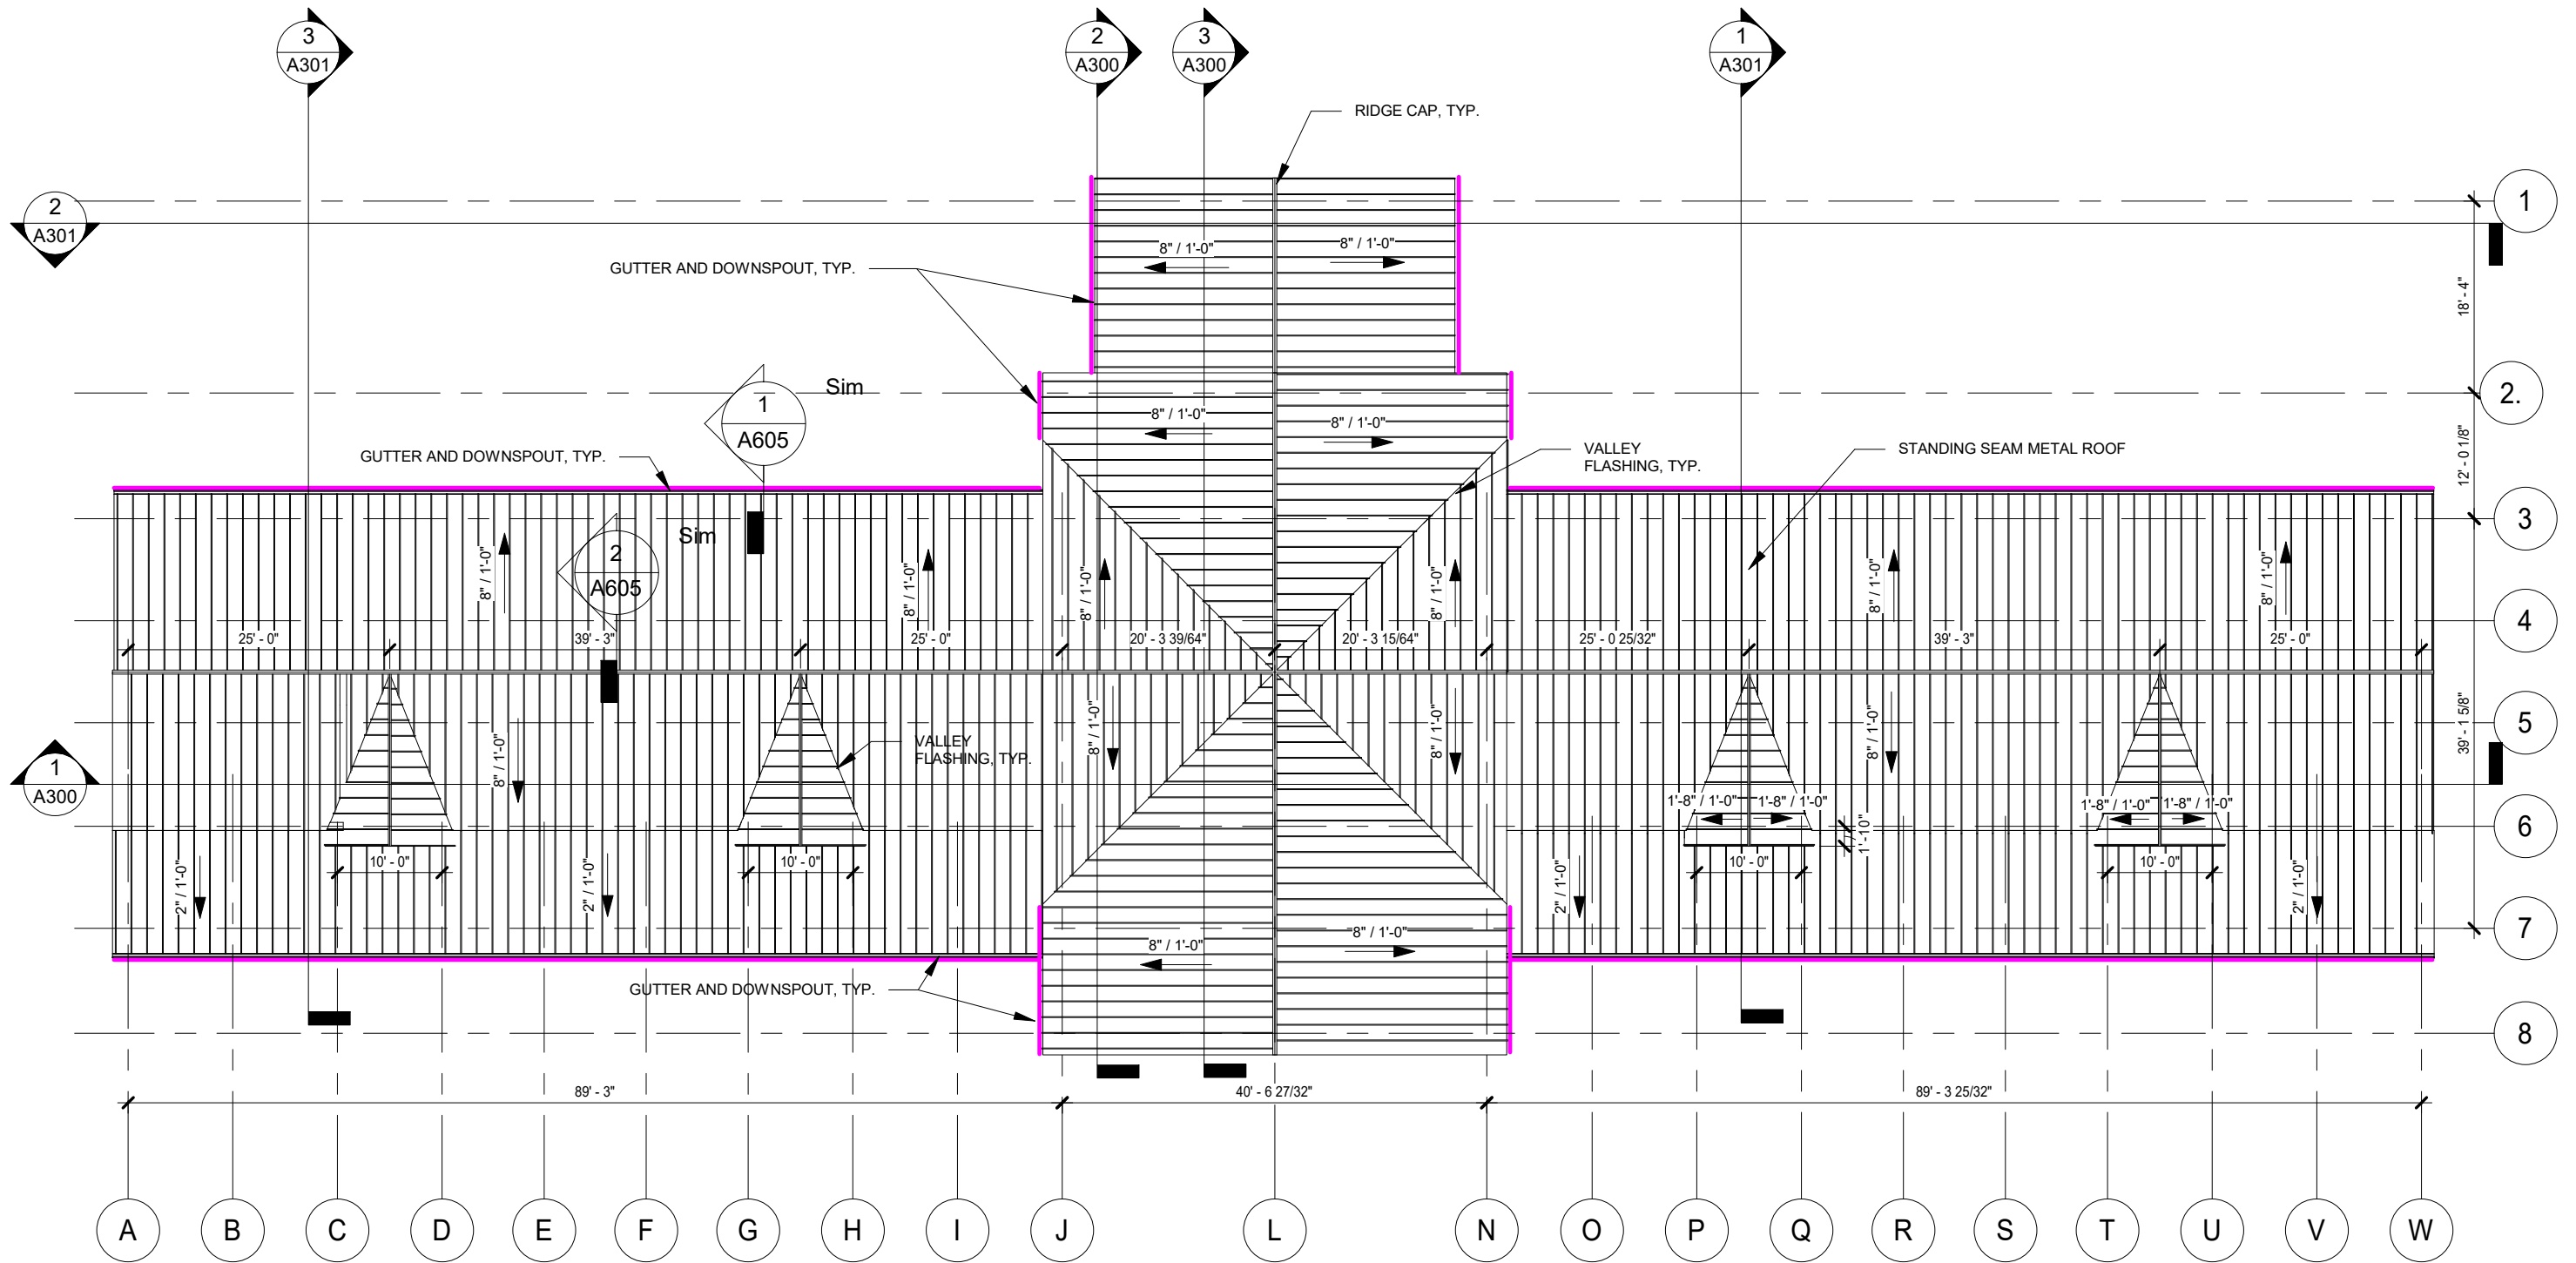

1 ROOF PLAN
A130 1/16" = 1'-0"

1 PROJECT NORTH

PHASE 2 - 90% SUBMITTAL


REVISIONS					
DATE	BY	DESCRIPTION	DATE	BY	DESCRIPTION




STATE OF FLORIDA DEPARTMENT OF TRANSPORTATION		
ROAD NO.	COUNTY	FINANCIAL PROJECT ID
SR 8	COLUMBIA	438609-1-52-01

SR 8 (I-10) WESTBOUND - (COLUMBIA COUNTY) REST AREA		DRAWING NO.
ROOF PLAN		A130
		SHEET NO.

P:\1-10 Rest Area Improvements (19-049) GAI\4 - Drawings\A - Active Drawings\1 - B+P\Local Files\DD LOCAL\1-10 Rest_LOCAL_DD.rvt

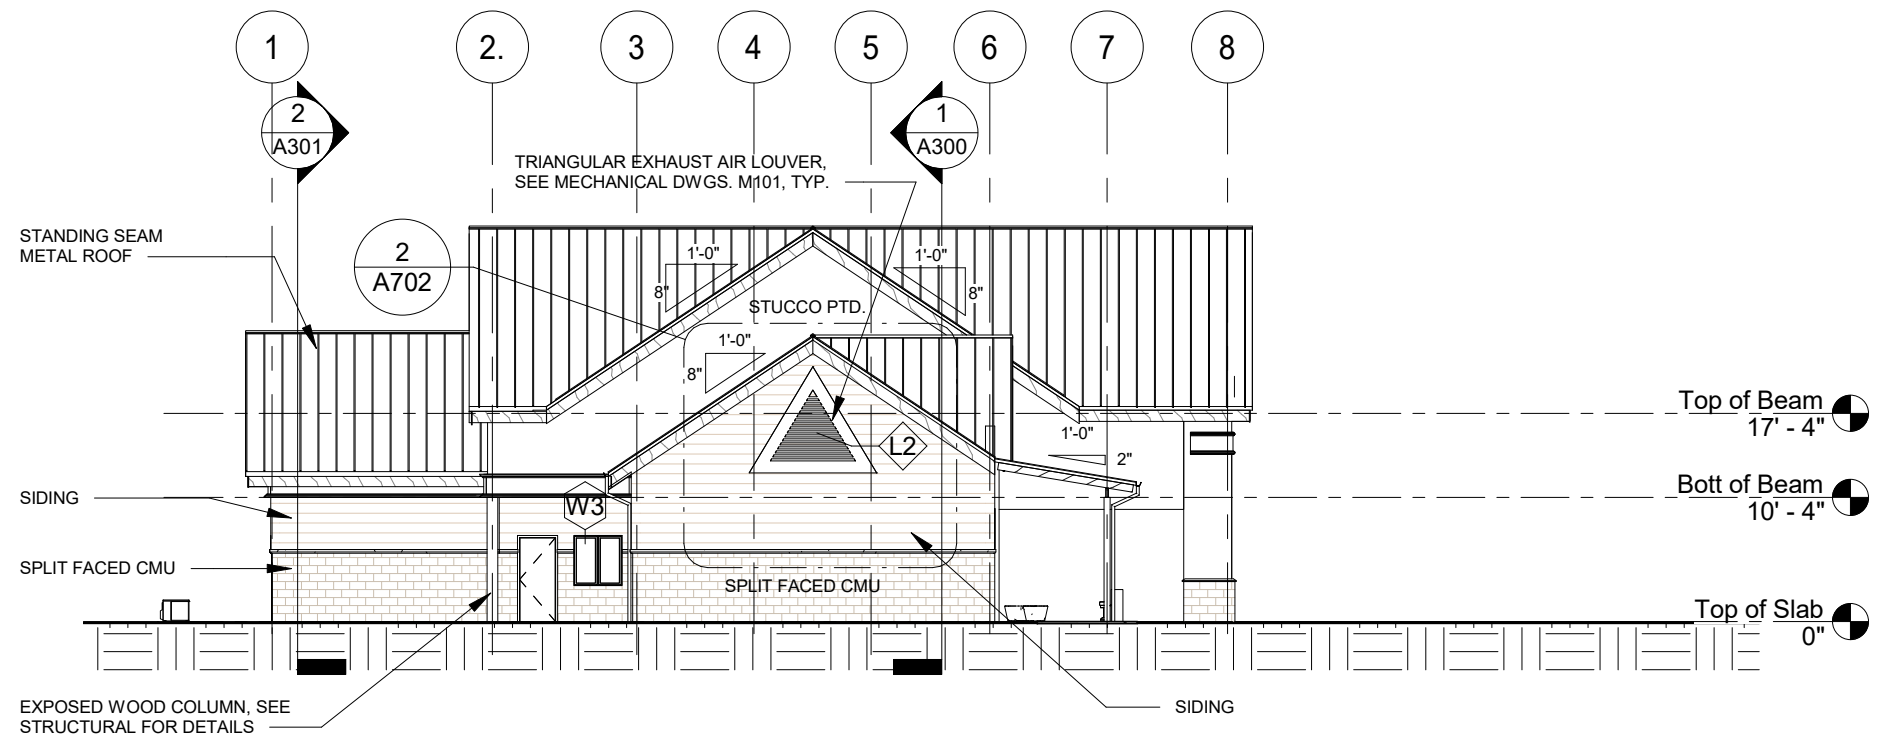

2 LEFT SIDE ELEVATION
A200 1/16" = 1'-0"

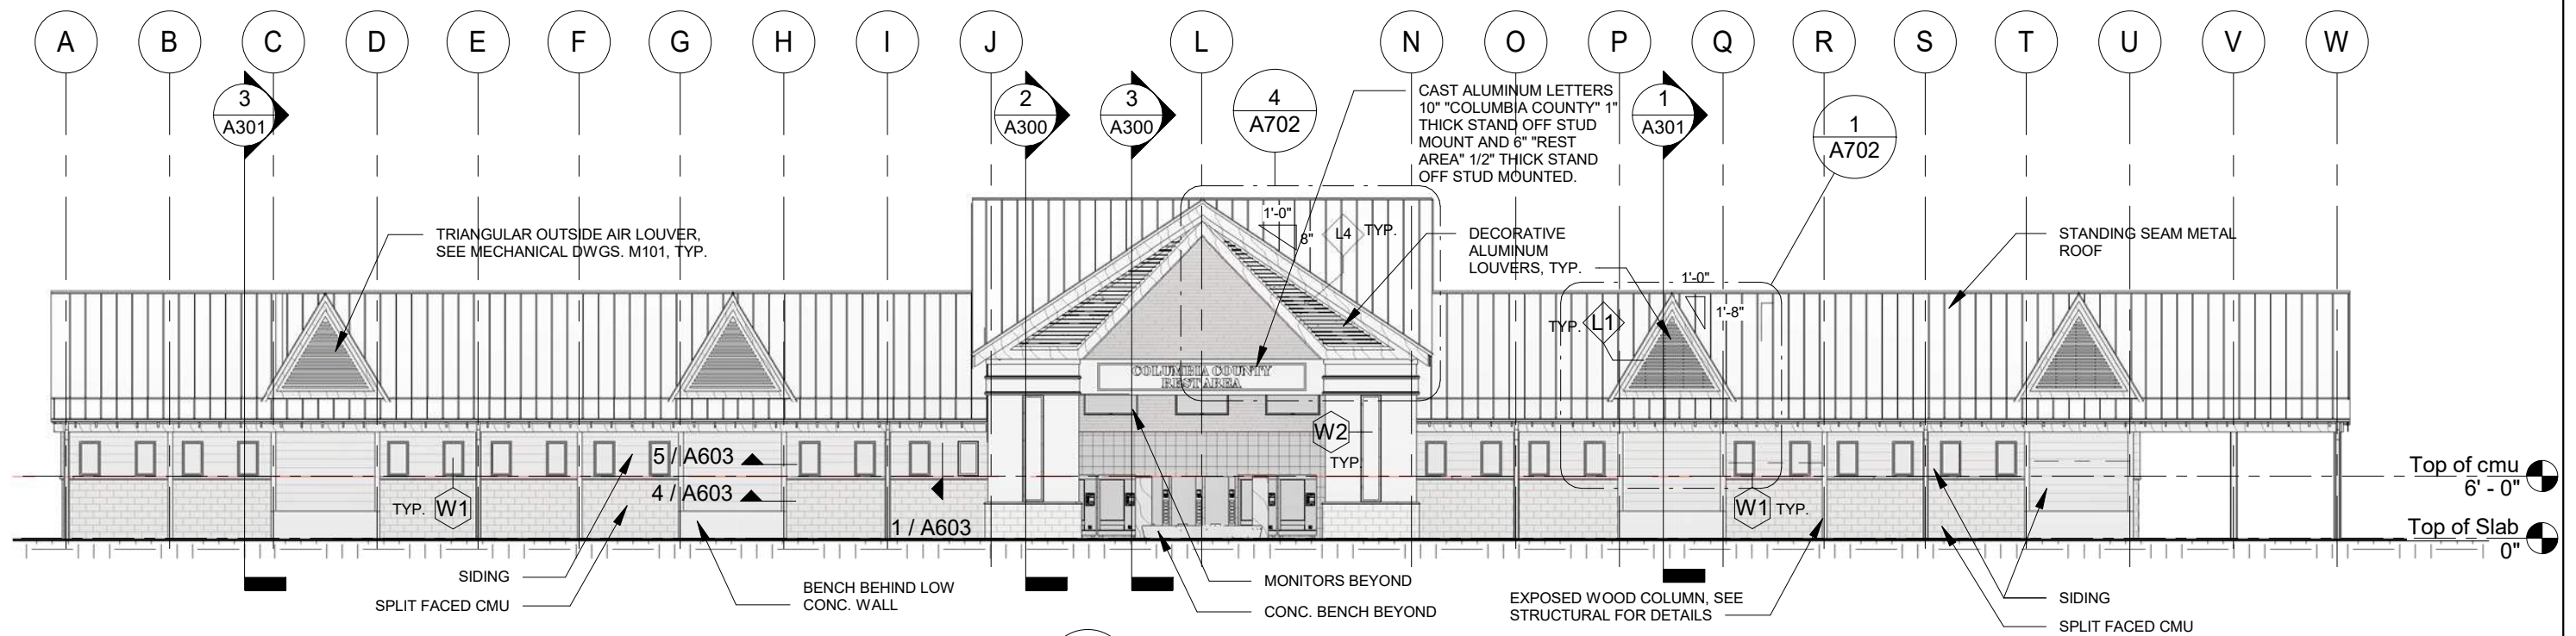

1 FRONT ELEVATION
A200 1/16" = 1'-0"

1 PROJECT NORTH

PHASE 2 - 90% SUBMITTAL



REVISIONS					
DATE	BY	DESCRIPTION	DATE	BY	DESCRIPTION



STATE OF FLORIDA DEPARTMENT OF TRANSPORTATION		
ROAD NO.	COUNTY	FINANCIAL PROJECT ID
SR 8	COLUMBIA	438609-1-52-01


SR 8 (I-10) WESTBOUND - (COLUMBIA COUNTY) REST AREA		DRAWING NO.
EXTERIOR ELEVATIONS		A200
		SHEET NO.

P:\1-10 Rest Area Improvements (19-049) GA14 - DrawingsA - Active Drawings\1 - B+P\Local Files\DD LOCAL\1-10 Rest_LOCAL_DD.rvt

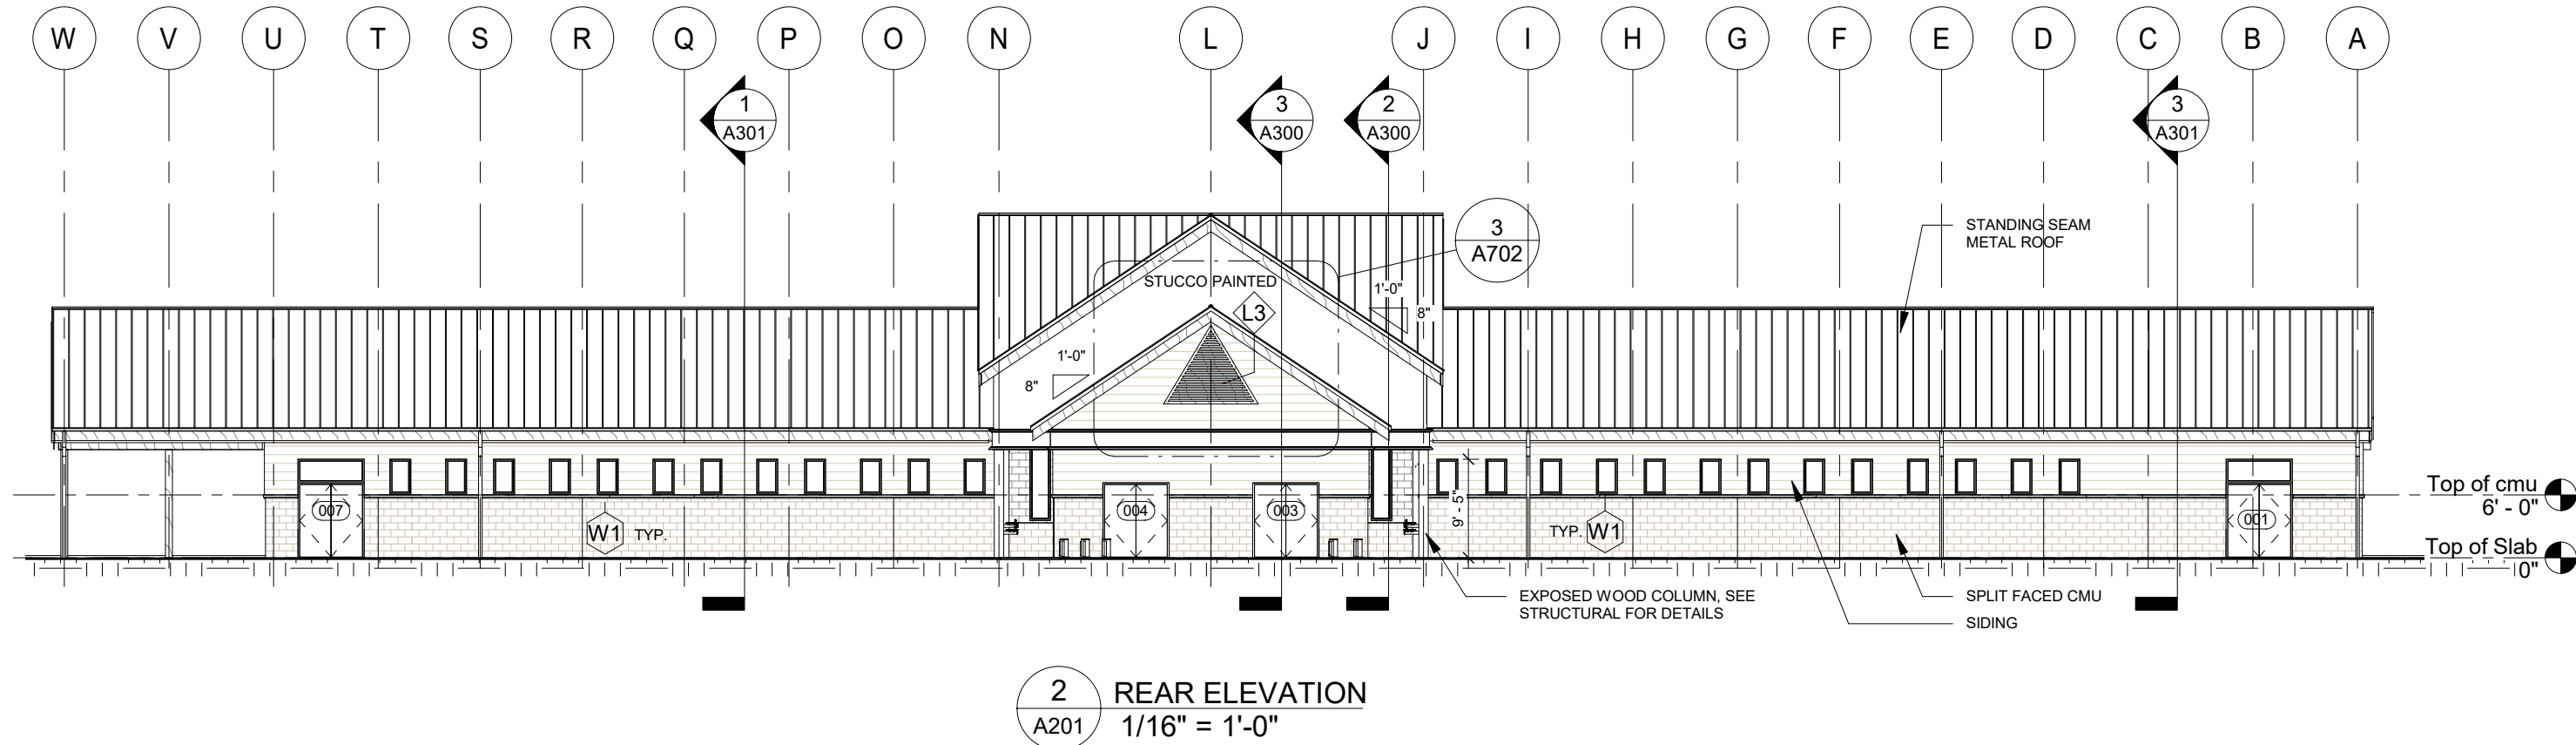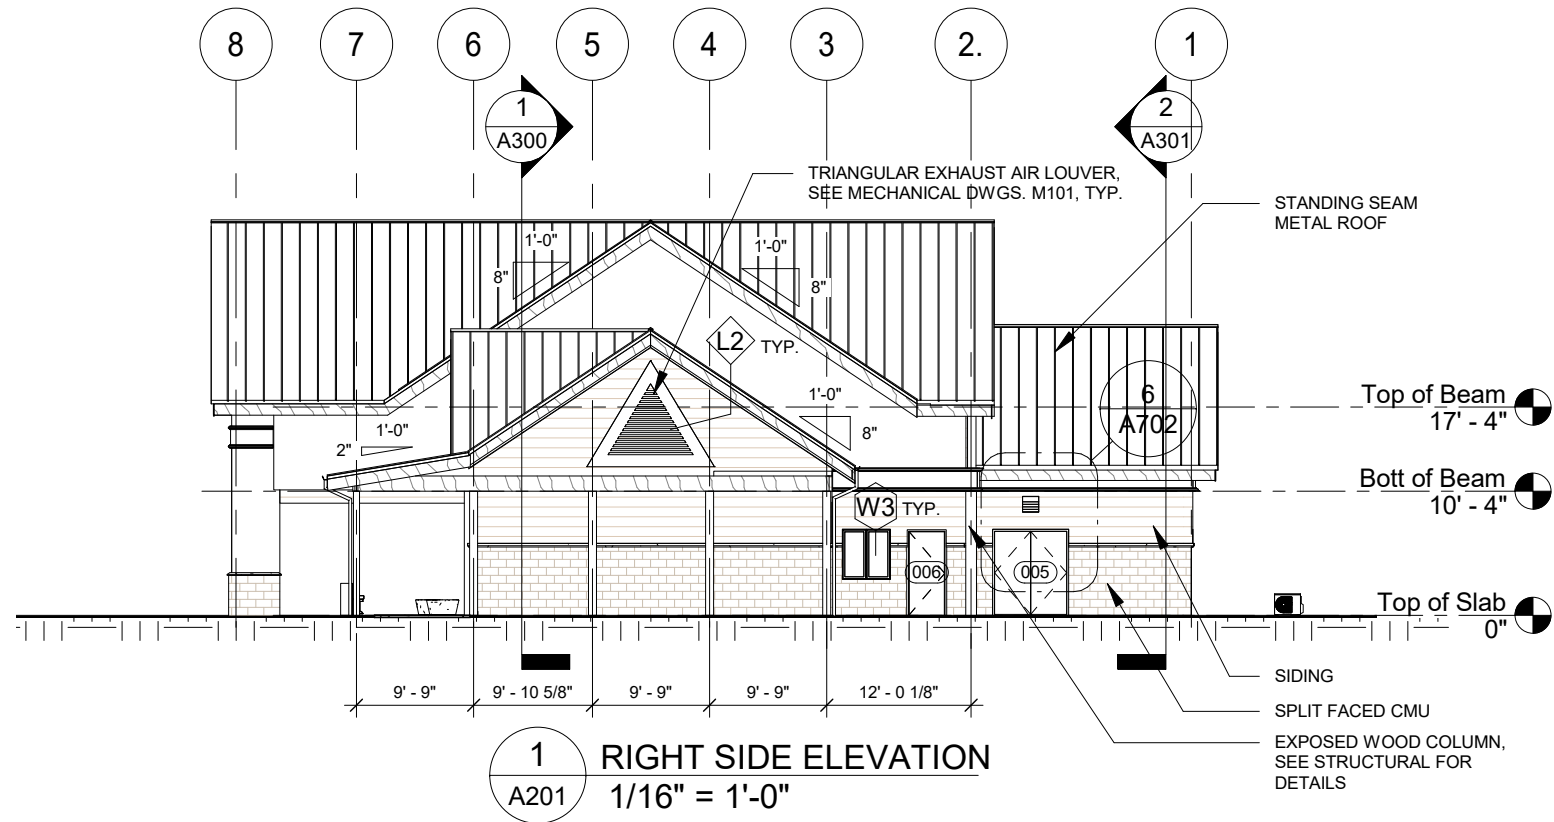


1 PROJECT NORTH PHASE 2 - 90% SUBMITTAL


REVISIONS						 BORRELLI + PARTNERS ARCHITECTURE PLANNING LANDSCAPE INTERIORS 720 Vassar Street, Orlando FL 32804 407.418.1338 :: fax 407.418.1342 CONFIDENTIAL: THIS DRAWING IS THE PROPERTY OF BORRELLI + PARTNERS UNLESS OTHERWISE PROVIDED. BY THE CONTRACT, THE CONTENTS OF THIS DRAWING ARE SHOWN TO ANY OTHER PARTY EXCEPT AS AGREED TO BY THE ARCHITECT. COPYRIGHT BORRELLI + PARTNERS, A/C 000711 / ACC 001842	STATE OF FLORIDA DEPARTMENT OF TRANSPORTATION			SR 8 (I-10) WESTBOUND - (COLUMBIA COUNTY) REST AREA		DRAWING NO.	
DATE	BY	DESCRIPTION	DATE	BY	DESCRIPTION		ROAD NO.	COUNTY	FINANCIAL PROJECT ID	SR 8	COLUMBIA	438609-1-52-01	A201
										EXTERIOR ELEVATIONS			

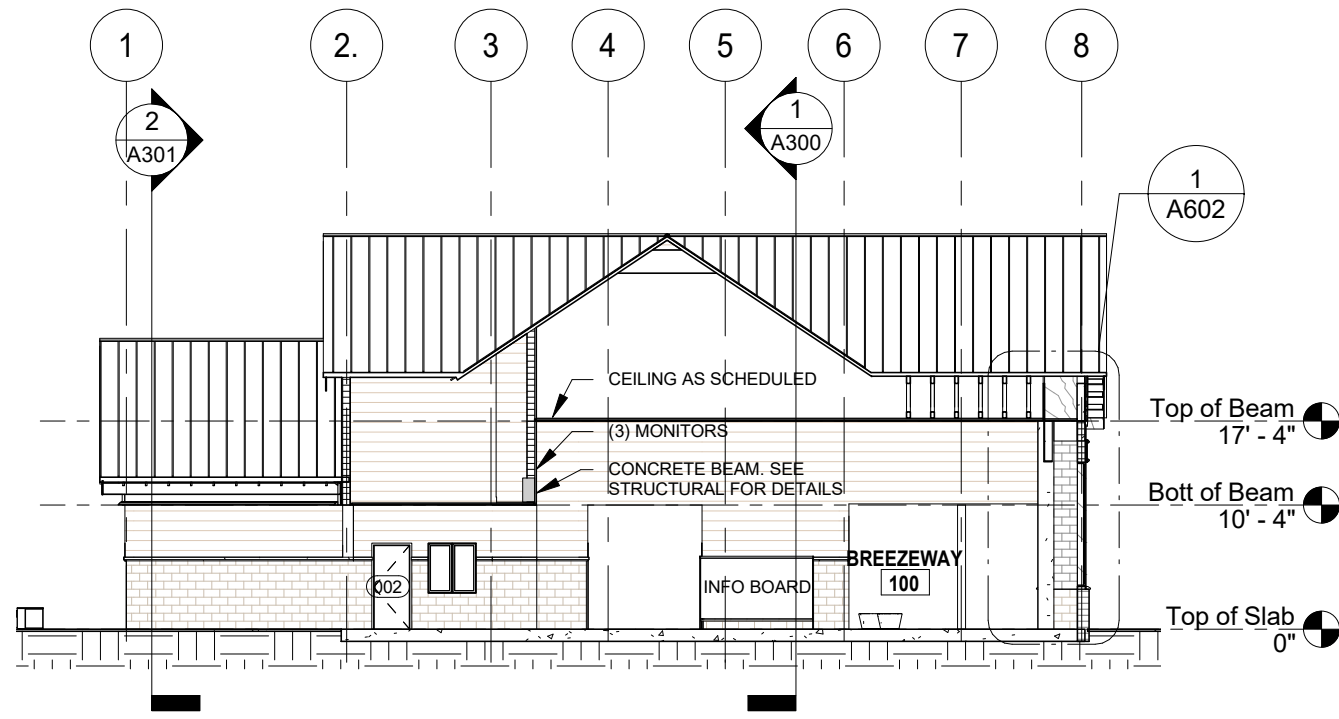

2 CROSS SECTION
1/16" = 1'-0"

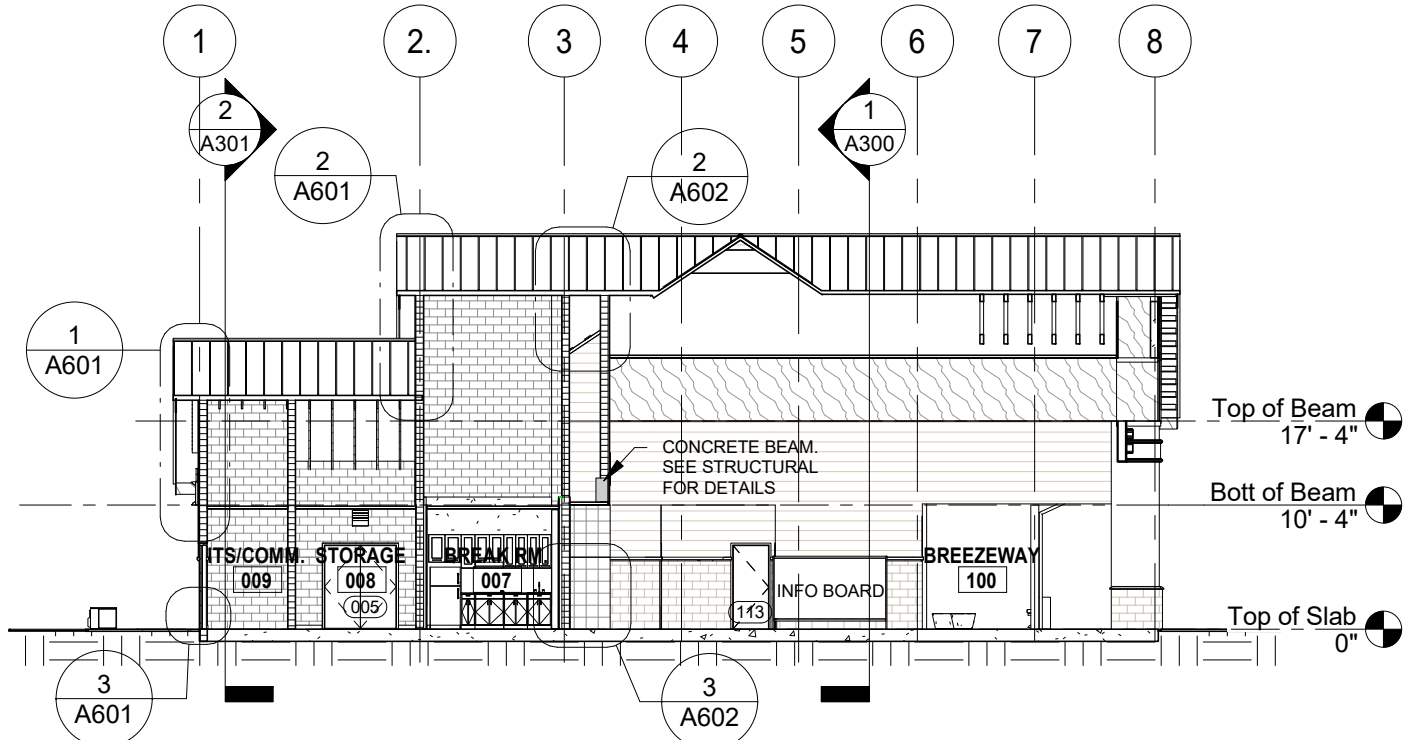

3 CORE CROSS SECTION
1/16" = 1'-0"

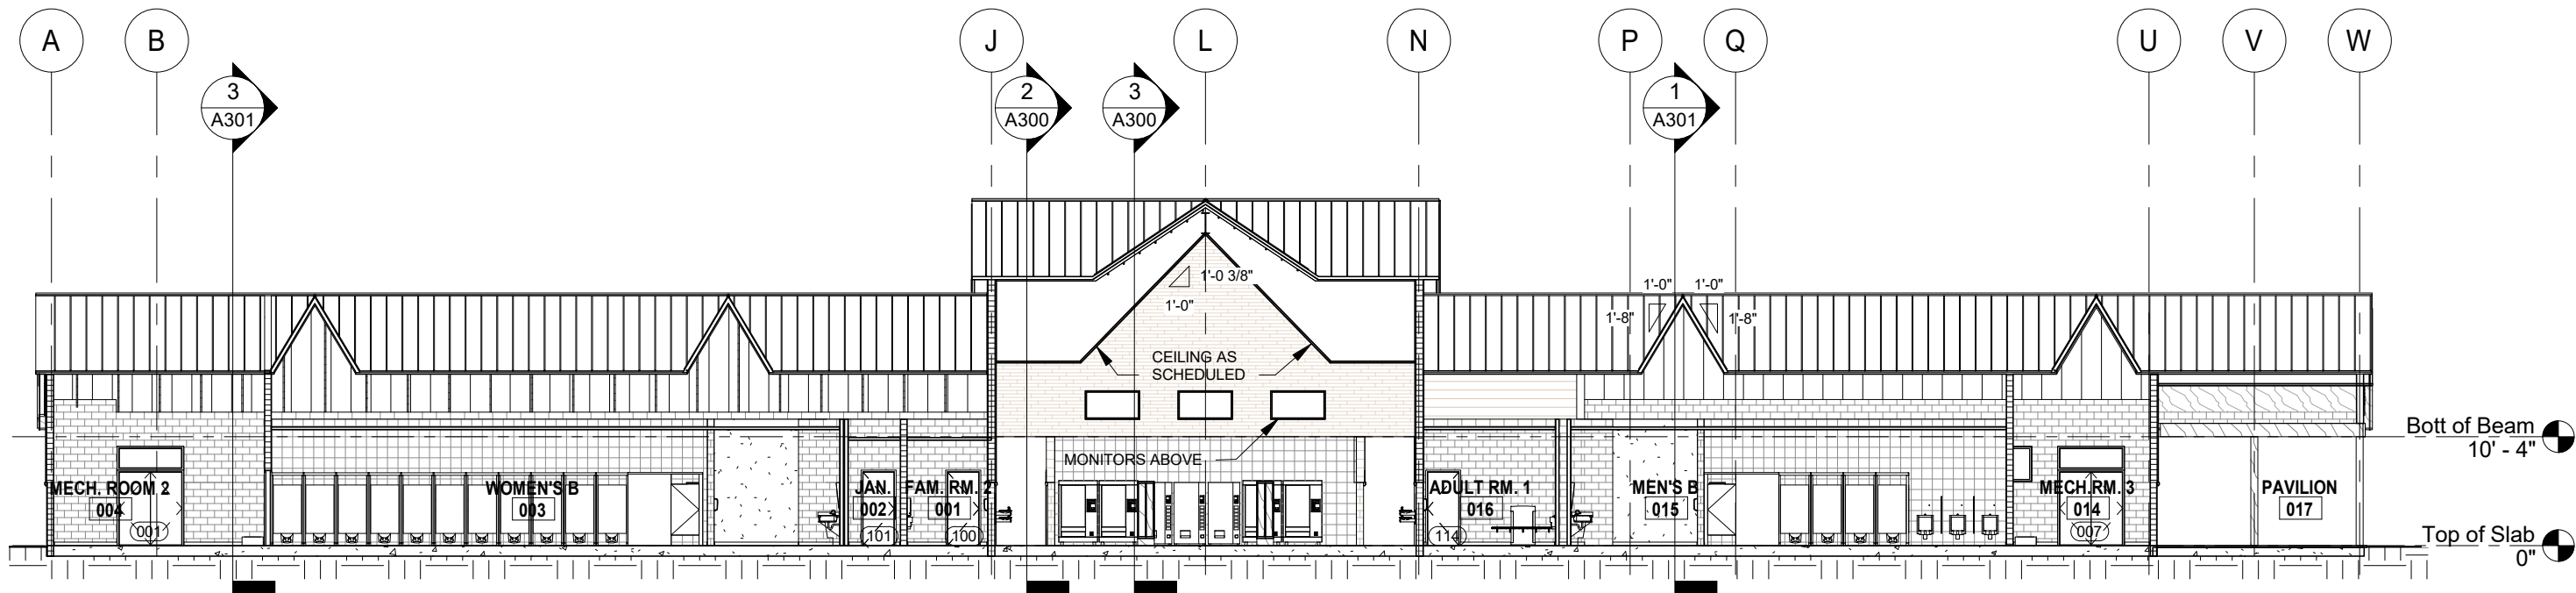


1 LONGITUDINAL SECTION
1/16" = 1'-0"


PROJECT NORTH PHASE 2 - 90% SUBMITTAL

P:\1-10 Rest Area Improvements (19-049) GA14 - DrawingsA - Active Drawings\1 - B+P\Local Files\DD LOCAL\1-10 Rest_LOCAL_DD.rvt


REVISIONS						 BORRELLI + PARTNERS ARCHITECTURE PLANNING LANDSCAPE INTERIORS AND MORE 720 Vassar Street, Orlando FL 32804 407.418.1338 :: fax 407.418.1342 CONFIDENTIAL: THIS DRAWING IS THE PROPERTY OF BORRELLI + PARTNERS UNLESS OTHERWISE PROVIDED. BY THE CONTRACT, THE CONTENTS OF THIS DRAWING ARE SHOWN NOT BE TRANSMITTED TO ANY OTHER PARTY EXCEPT AS AGREED TO BY THE ARCHITECT. COPYRIGHT BORRELLI + PARTNERS, A/C 000711 / A/C 001842	STATE OF FLORIDA DEPARTMENT OF TRANSPORTATION			SR 8 (I-10) WESTBOUND - (COLUMBIA COUNTY) REST AREA	DRAWING NO.
DATE	BY	DESCRIPTION	DATE	BY	DESCRIPTION		ROAD NO.	COUNTY	FINANCIAL PROJECT ID		A300
							SR 8	COLUMBIA	438609-1-52-01		
							BUILDING SECTIONS			SHEET NO.	

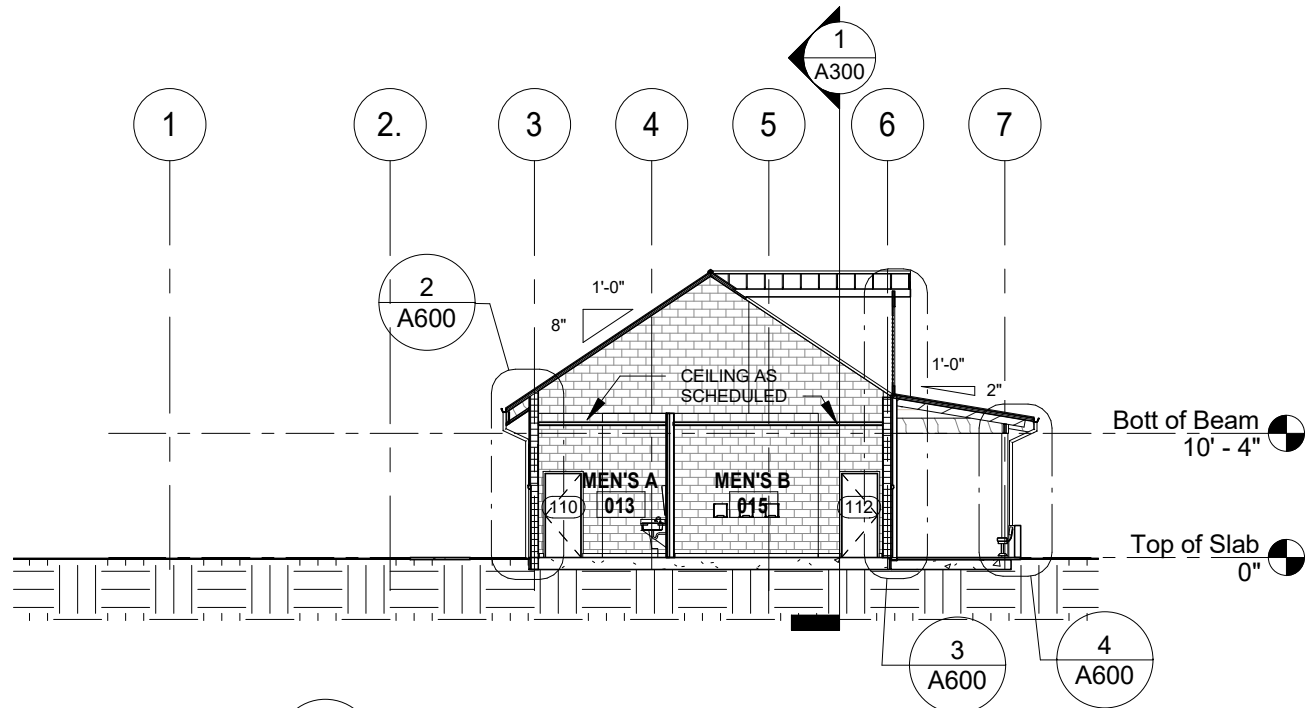

1 RESTROOM CROSS SECTION
1/16" = 1'-0"

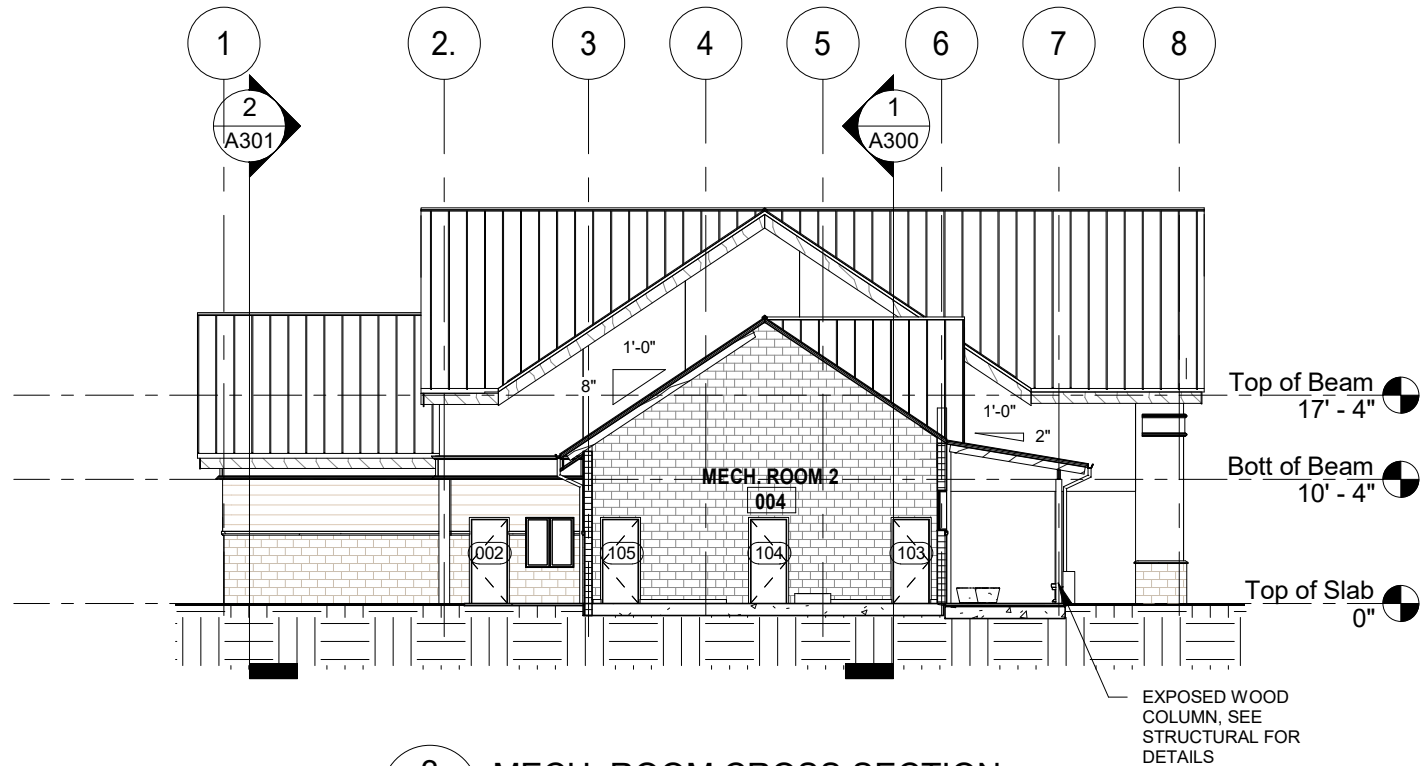

3 MECH. ROOM CROSS SECTION
1/16" = 1'-0"

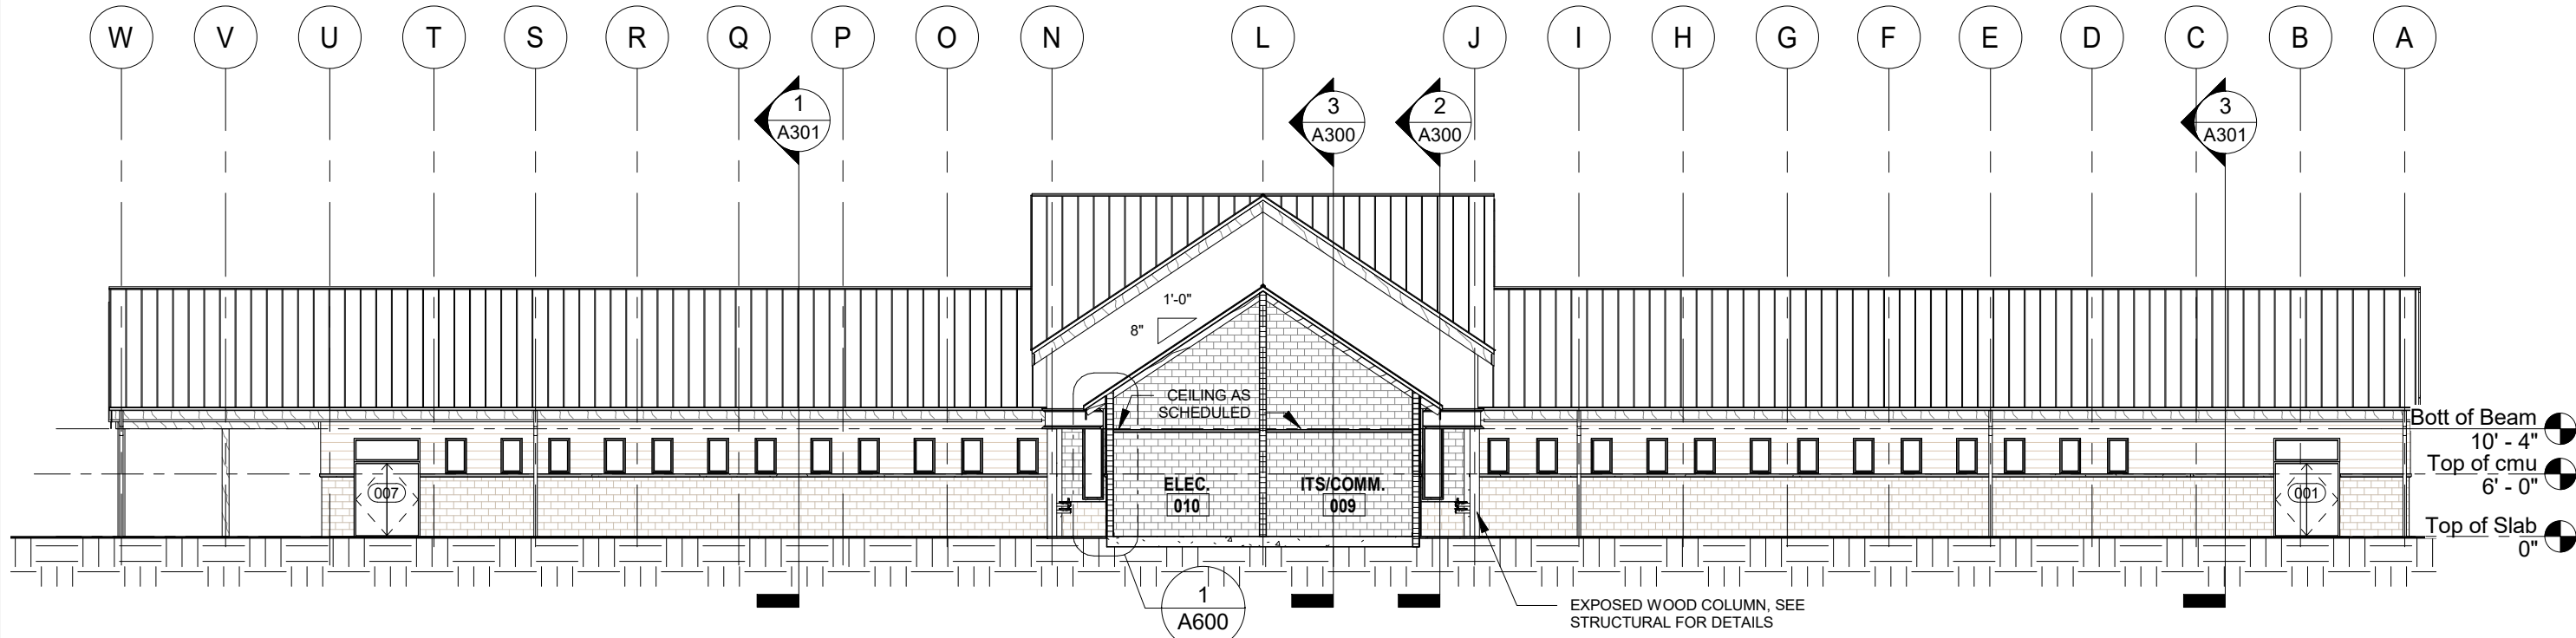

2 BUILDING CROSS SECTION
1/16" = 1'-0"

1 PROJECT NORTH PHASE 2 - 90% SUBMITTAL

REVISIONS					
DATE	BY	DESCRIPTION	DATE	BY	DESCRIPTION



BORRELLI + PARTNERS
ARCHITECTURE PLANNING LANDSCAPE INTERIORS
720 Vassar Street, Orlando, FL 32804 407.418.1338 :: fax 407.418.1342
CONFIDENTIAL: THIS DRAWING IS THE PROPERTY OF BORRELLI + PARTNERS. UNLESS OTHERWISE PROVIDED, BY THE CONTRACT, THE CONTENTS OF THIS DRAWING ARE NOT TO BE TRANSMITTED TO ANY OTHER PARTY EXCEPT AS AGREED TO BY THE ARCHITECT. COPYRIGHT BORRELLI + PARTNERS, A/C 000711 / A/C 001842


STATE OF FLORIDA DEPARTMENT OF TRANSPORTATION		
ROAD NO.	COUNTY	FINANCIAL PROJECT ID
SR 8	COLUMBIA	438609-1-52-01

SR 8 (I-10) WESTBOUND - (COLUMBIA COUNTY) REST AREA
BUILDING SECTIONS


DRAWING NO.
A301
SHEET NO.

P:\1-10 Rest Area Improvements (19-049) GA\14 - Drawings\A - Active Drawings\1 - B+P\Local Files\DD LOCAL\1-10 Rest_LOCAL_DD.rvt


P:\1-10 Rest Area Improvements (19-049) GAI\4 - Drawings\A - Active Drawings\1 - B+P\Local Files\DD LOCAL\1-10 Rest_LOCAL_DD.rvt

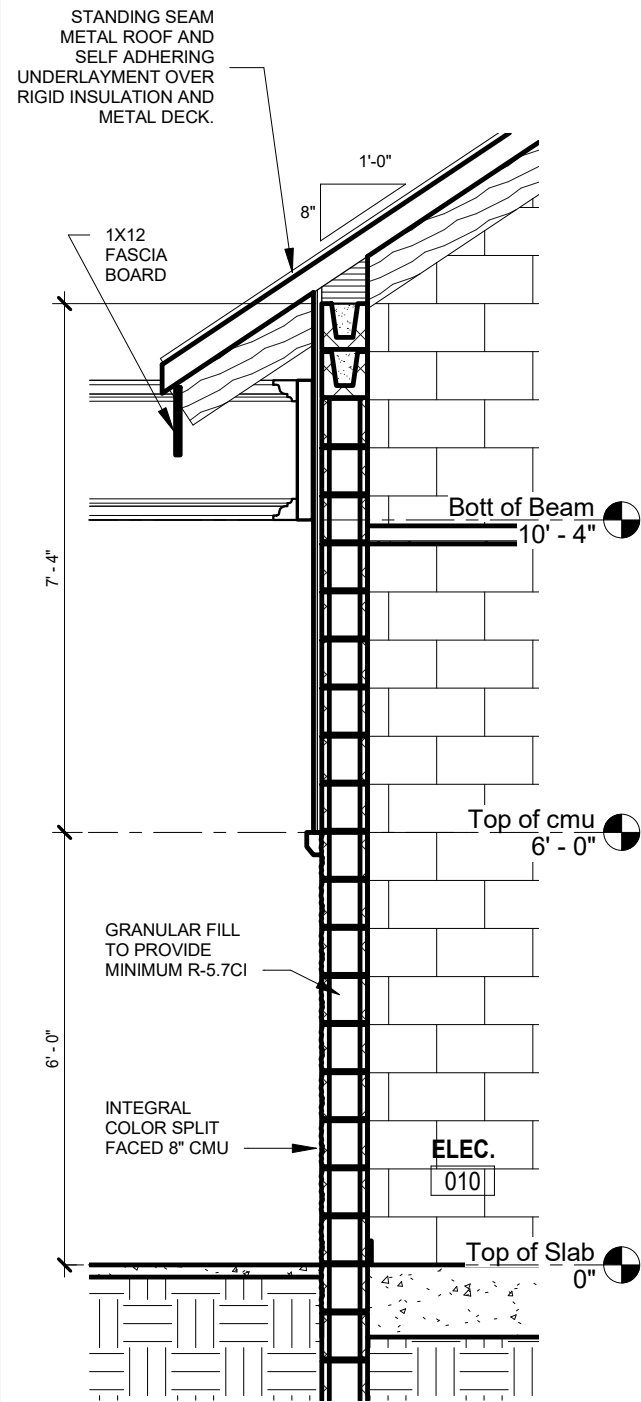


1 WALL SECTION - 1
A600 3/8" = 1'-0"

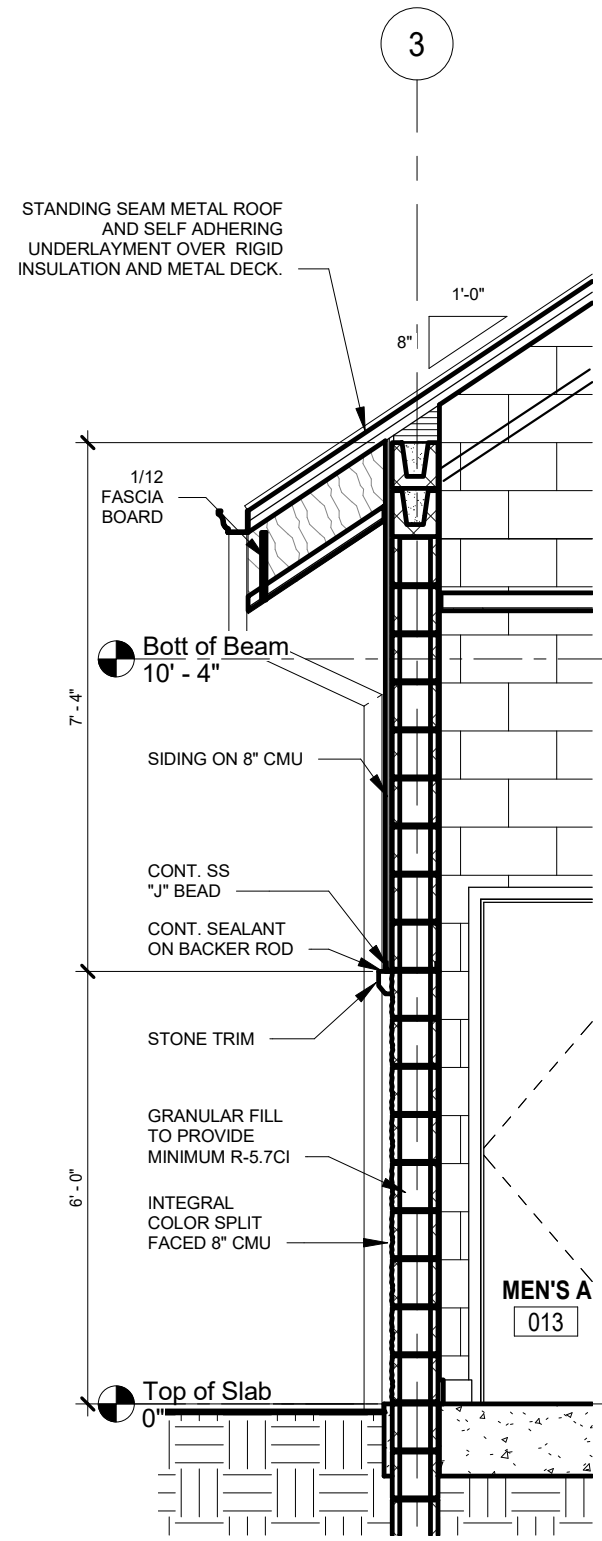

2 WALL SECTION - 2
A600 3/8" = 1'-0"

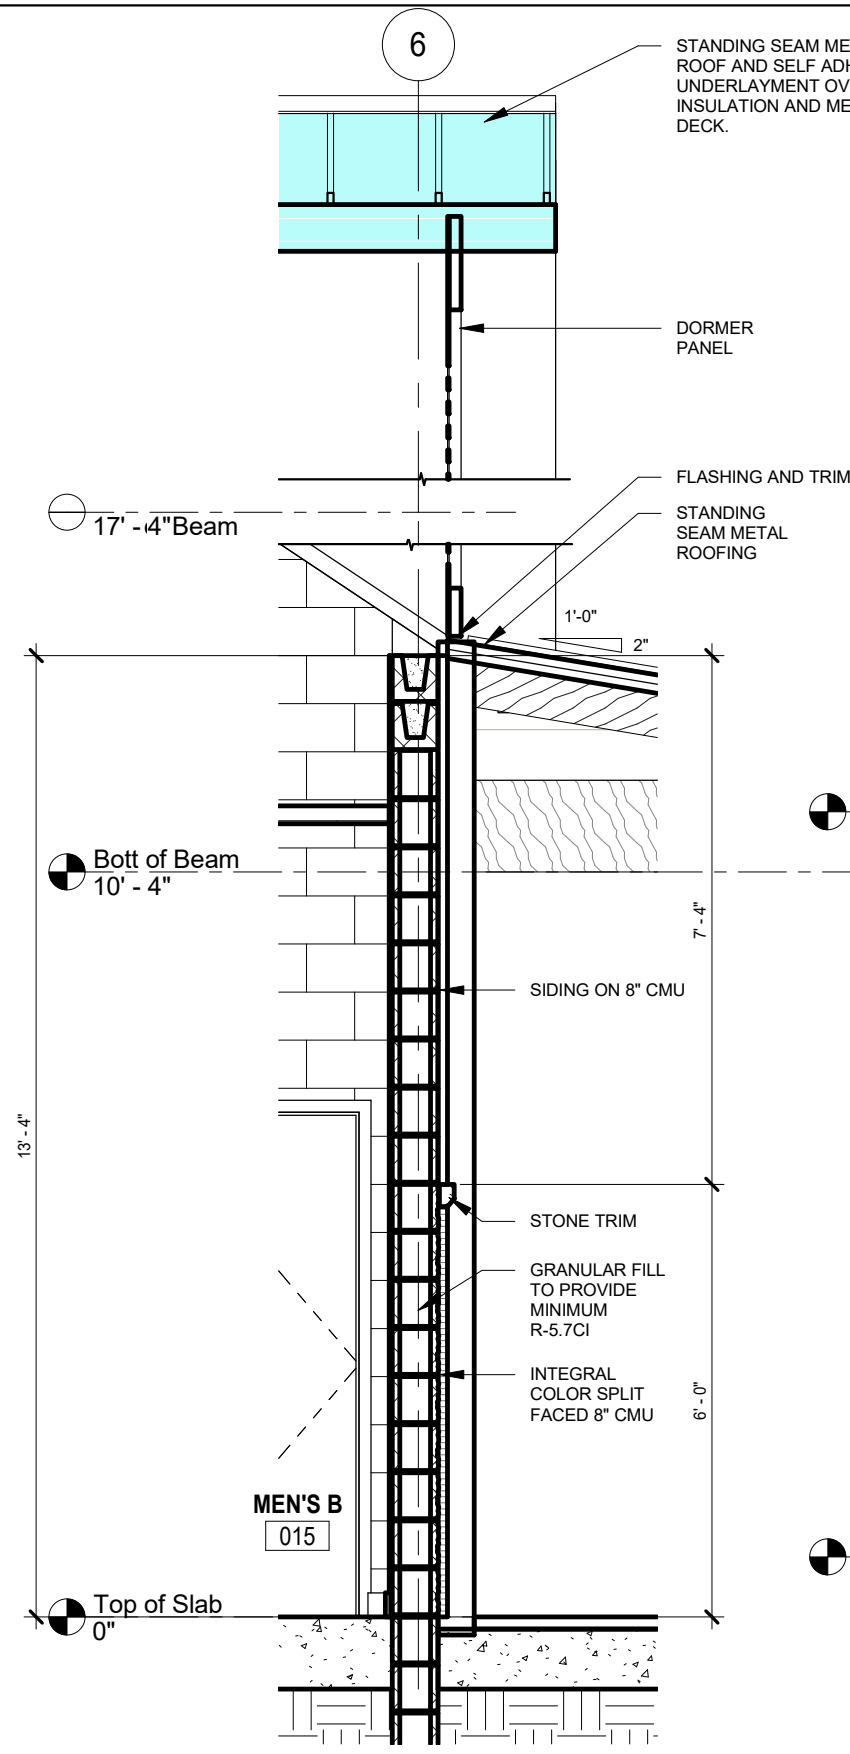

3 WALL SECTION - 3
A600 3/8" = 1'-0"

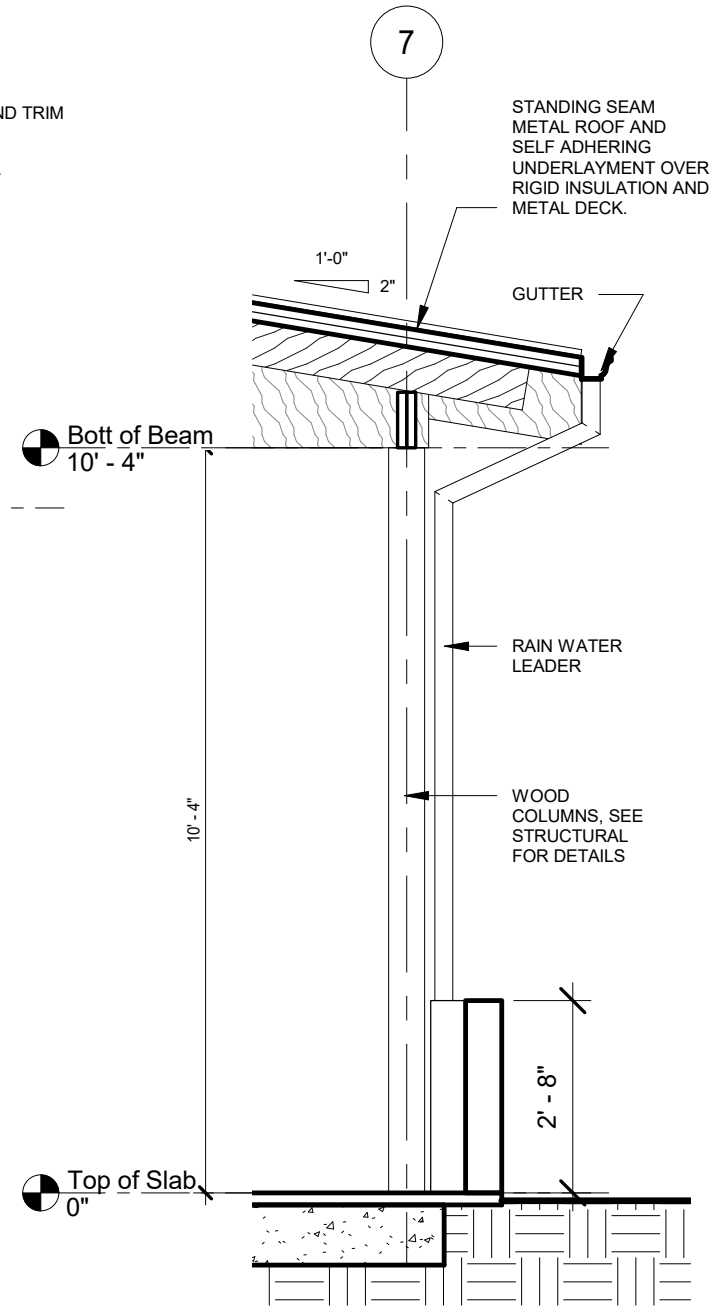

4 WALL SECTION - 4
A600 3/8" = 1'-0"

1 PROJECT NORTH

PHASE 2 - 90% SUBMITTAL


REVISIONS					
DATE	BY	DESCRIPTION	DATE	BY	DESCRIPTION




STATE OF FLORIDA DEPARTMENT OF TRANSPORTATION		
ROAD NO.	COUNTY	FINANCIAL PROJECT ID
SR 8	COLUMBIA	438609-1-52-01

SR 8 (I-10) WESTBOUND - (COLUMBIA COUNTY) REST AREA		DRAWING NO.
WALL SECTIONS		A600
		SHEET NO.


P:\1-10 Rest Area Improvements (19-049) GAI\4 - Drawings\A - Active Drawings\1 - B+P\Local Files\DD LOCAL\1-10 Rest_LOCAL_DD.rvt

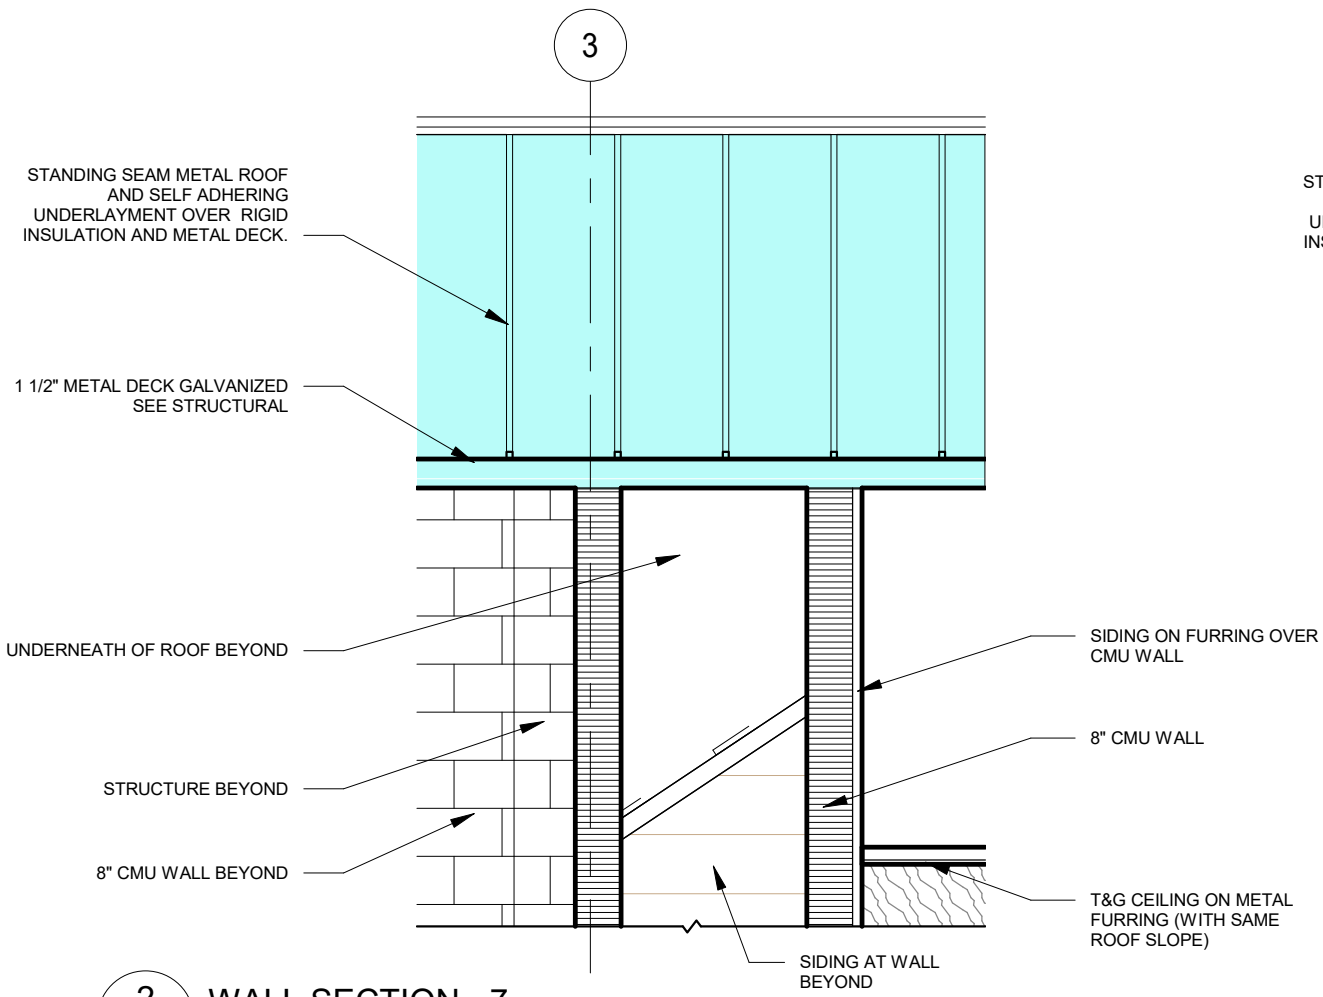

2 WALL SECTION - 7
A602 3/8" = 1'-0"

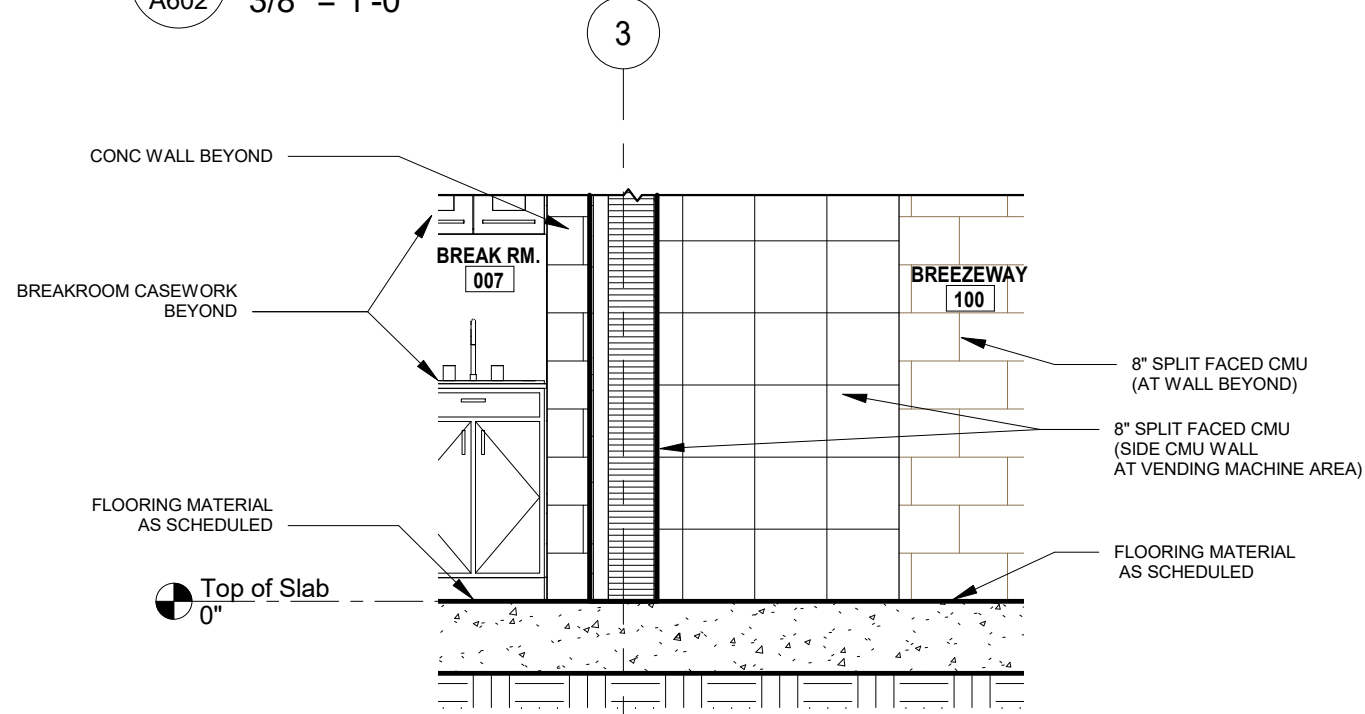

3 WALL SILL DETAIL - 9
A602 3/8" = 1'-0"

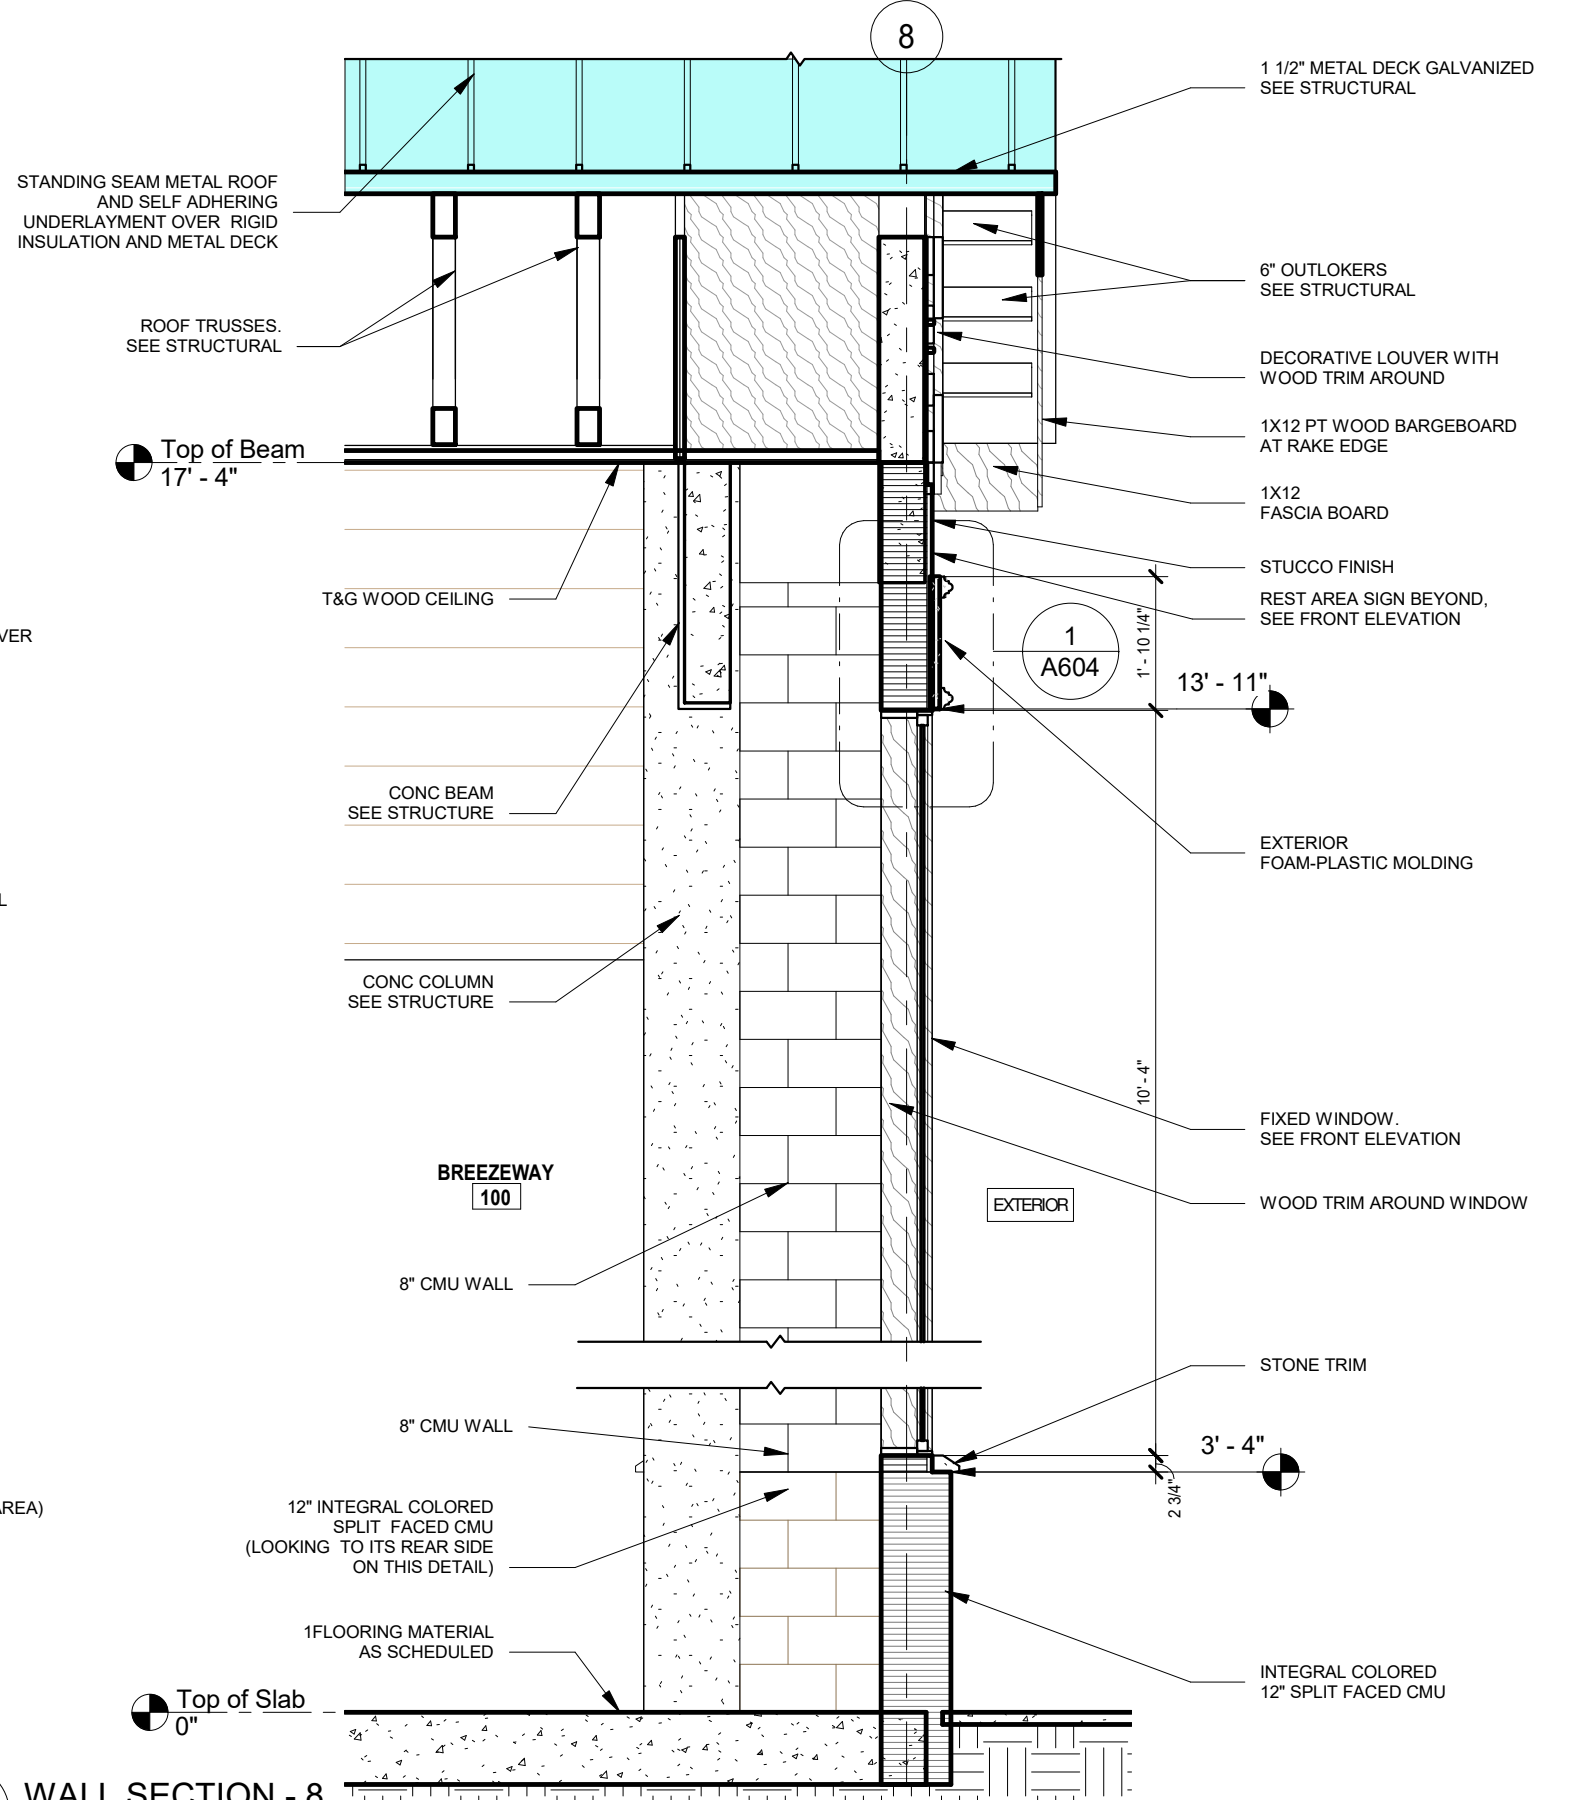

1 WALL SECTION - 8
A602 3/8" = 1'-0"

1 PROJECT NORTH PHASE 2 - 90% SUBMITTAL


REVISIONS					
DATE	BY	DESCRIPTION	DATE	BY	DESCRIPTION

BORRELLI + PARTNERS
ARCHITECTURE PLANNING LANDSCAPE INTERIORS
720 Vassar Street, Orlando, FL 32804 407.418.1338 :: fax 407.418.1342
CONFIDENTIAL: THIS DRAWING IS THE PROPERTY OF BORRELLI + PARTNERS. UNLESS OTHERWISE PROVIDED, BY THE CONTRACT, THE CONTENTS OF THIS DRAWING ARE NOT TO BE TRANSMITTED TO ANY OTHER PARTY EXCEPT AS AGREED TO BY THE ARCHITECT. COPYRIGHT BORRELLI + PARTNERS, A/C 000711 / A/C 001842


STATE OF FLORIDA DEPARTMENT OF TRANSPORTATION		
ROAD NO.	COUNTY	FINANCIAL PROJECT ID
SR 8	COLUMBIA	438609-1-52-01

SR 8 (I-10) WESTBOUND - (COLUMBIA COUNTY) REST AREA	
WALL DETAILS	


DRAWING NO.
A602
SHEET NO.

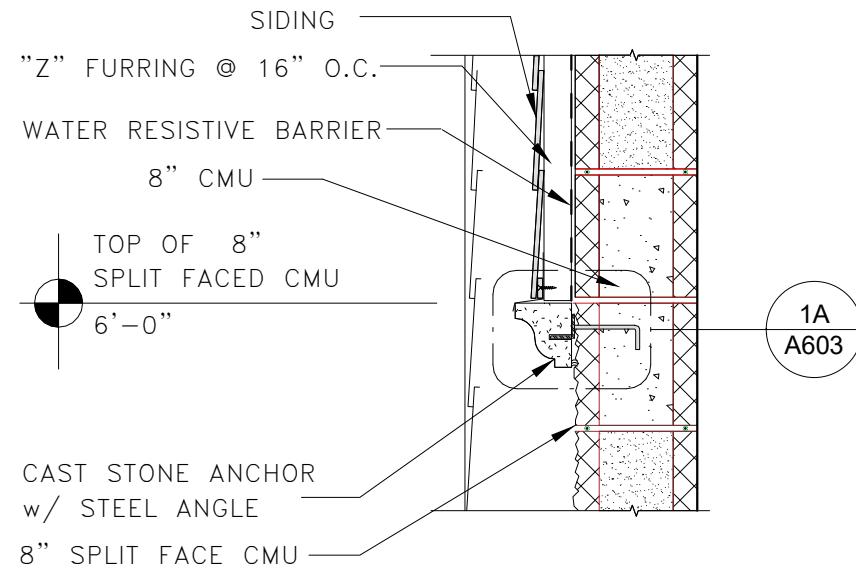


1 CAST STONE SECTION DETAIL 1
A603 1" = 1'-0"

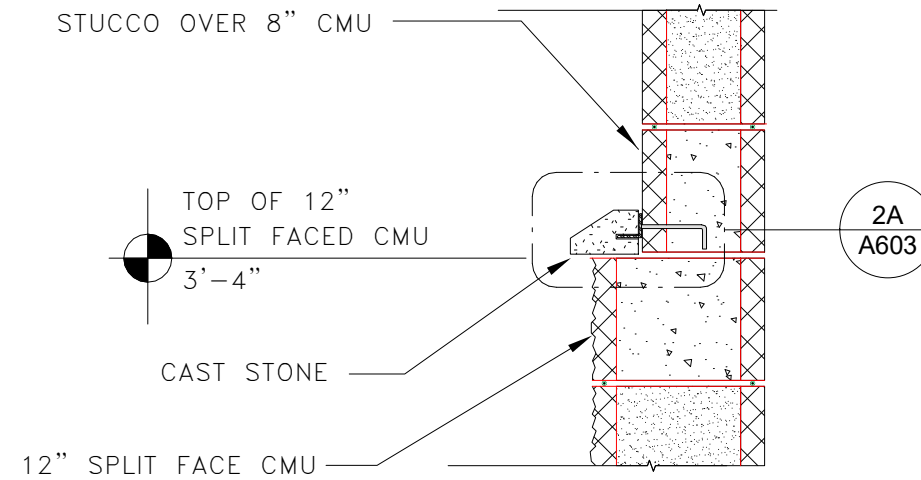


2 CAST STONE SECTION DETAIL 2
A603 1" = 1'-0"

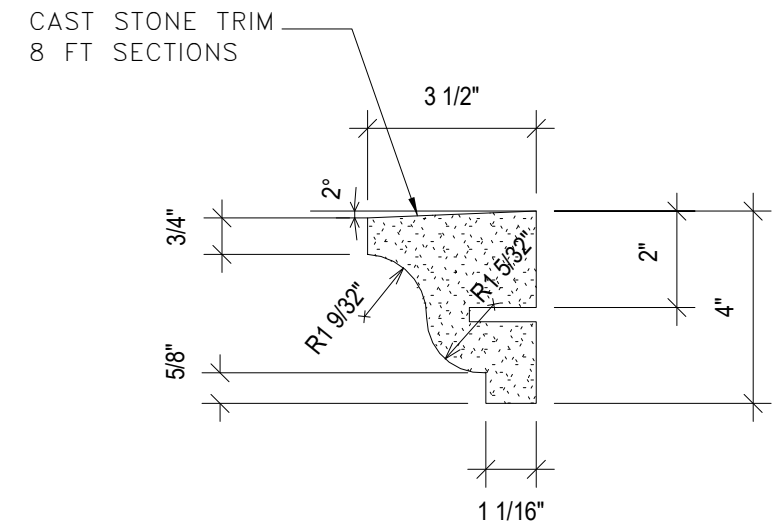



1A CAST STONE TYPE 1
A603 3" = 1'-0"

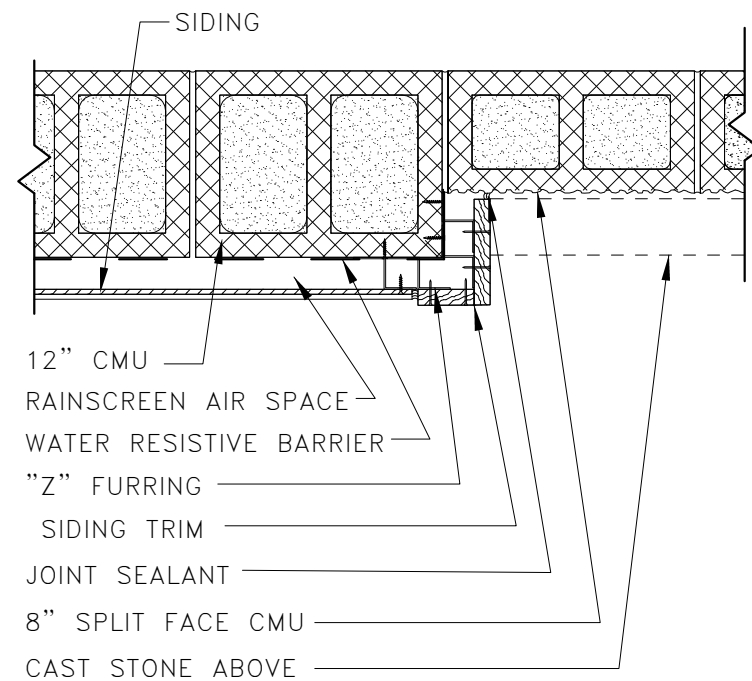

4 SEATING AREA WALL DETAIL - 1
A603 1" = 1'-0"

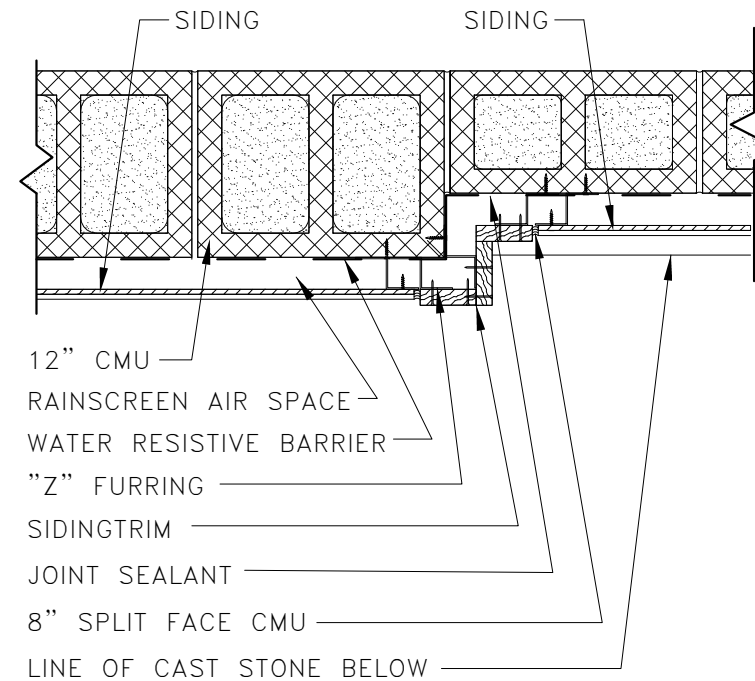

5 SEATING AREA WALL DETAIL - 2
A603 1" = 1'-0"

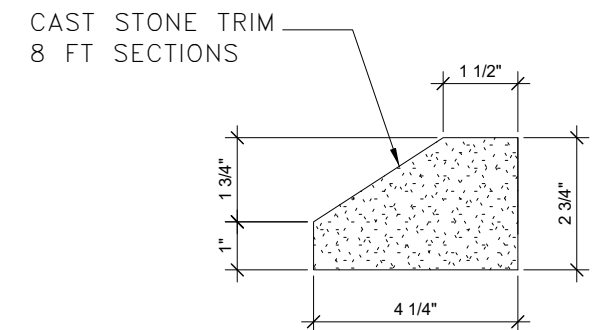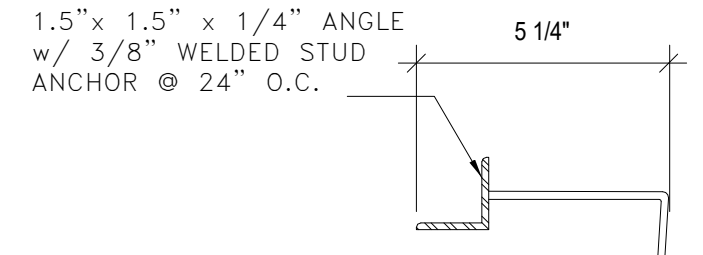


2A CAST STONE TYPE 2
A603 3" = 1'-0"

P:\10 Rest Area Improvements (19-049) GA\14 - Drawings\A - Active Drawings\1 - B+P\Local Files\DD LOCAL\1-10 Rest_LOCAL_DD.rvt


										🕒 PROJECT NORTH		PHASE 2 - 90% SUBMITTAL	
REVISIONS						 BORRELLI + PARTNERS ARCHITECTURE PLANNING LANDSCAPE INTERIORS ARE 000711 720 Vassar Street, Orlando FL 32804 407.418.1338 :: fax 407.418.1342 CONFIDENTIAL: THIS DRAWING IS THE PROPERTY OF BORRELLI + PARTNERS UNLESS OTHERWISE PROVIDED. BY THE CONTRACT, THE CONTENTS OF THIS DRAWING ARE TO REMAIN THE PROPERTY OF BORRELLI + PARTNERS. EXCEPT AS AGREED TO BY THE ARCHITECT, COPYRIGHT BORRELLI + PARTNERS, A/C 000711 / ACC 001842	STATE OF FLORIDA DEPARTMENT OF TRANSPORTATION			SR 8 (I-10) WESTBOUND - (COLUMBIA COUNTY) REST AREA			DRAWING NO.
DATE	BY	DESCRIPTION	DATE	BY	DESCRIPTION					A603			
							ROAD NO.	COUNTY	FINANCIAL PROJECT ID	DETAILS		SHEET NO.	
							SR 8	COLUMBIA	438609-1-52-01				

1 PROJECT NORTH


P:\1-10 Rest Area Improvements (19-049) GA\14 - DrawingsA - Active Drawings\1 - B+P\Local Files\DD LOCAL\1-10 Rest_LOCAL_DD.rvt

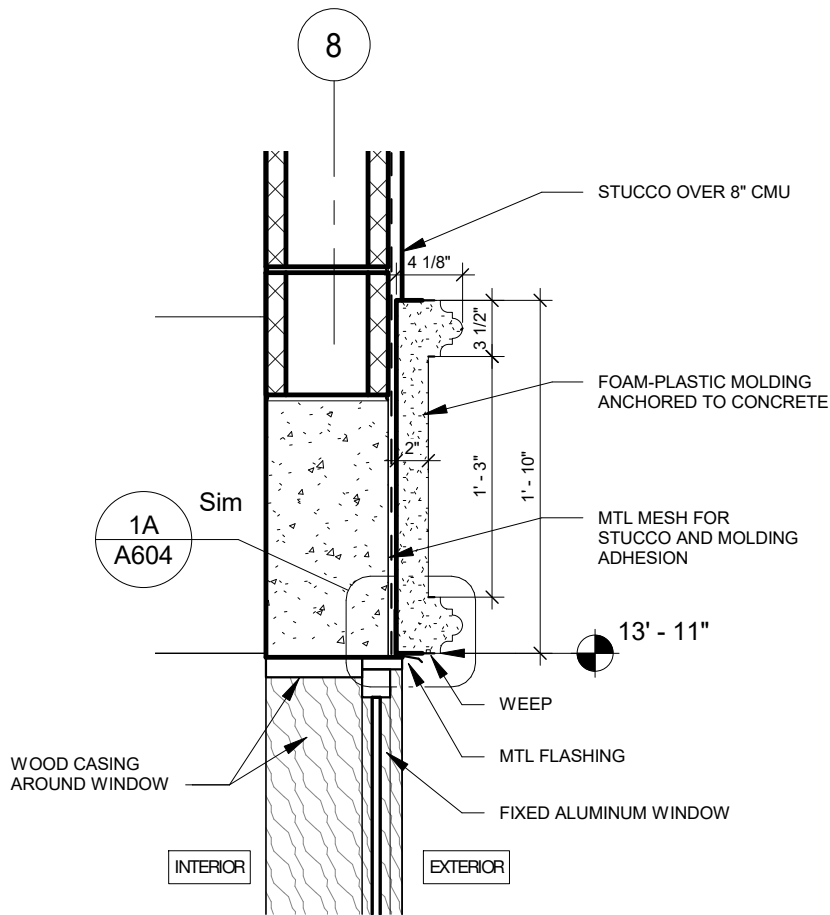


1 Foam Plastic Molding (Front Elev)
1" = 1'-0"

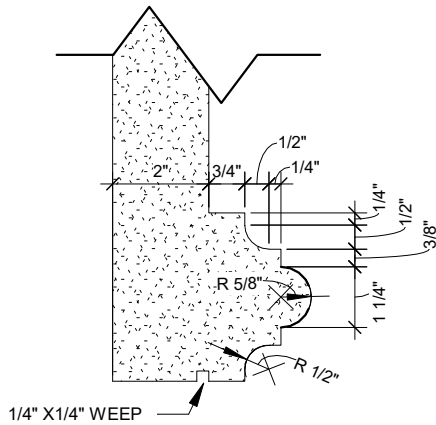

1A Molding Detail 1
3" = 1'-0"

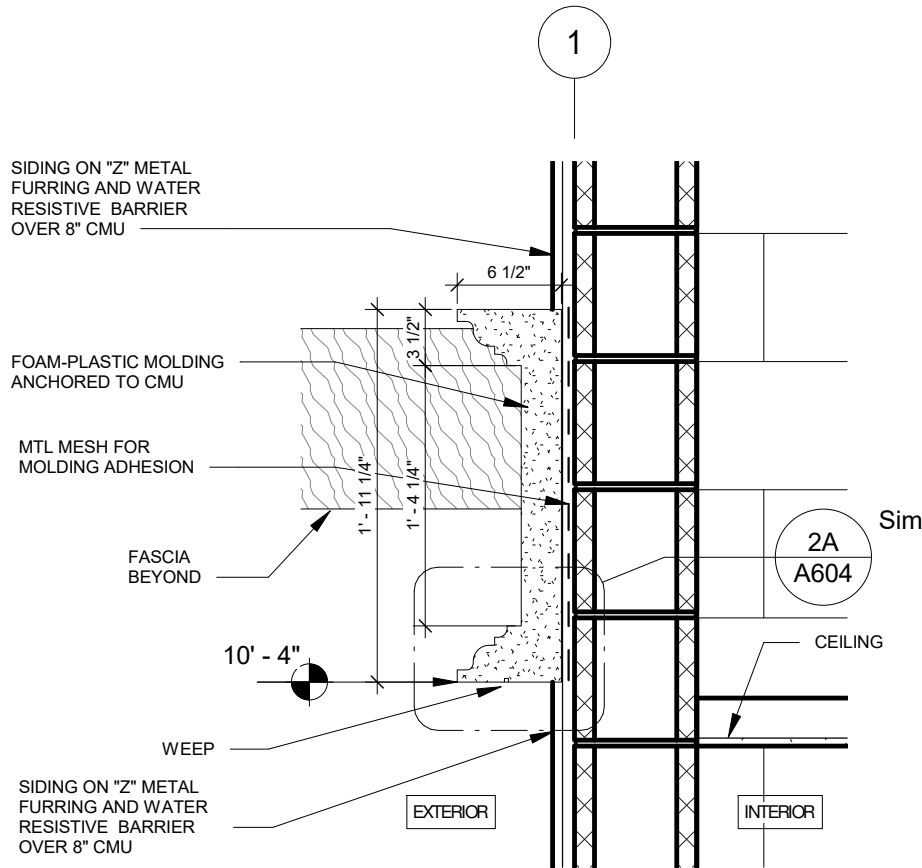

2 Foam Plastic Molding (Rear Elev)
1" = 1'-0"

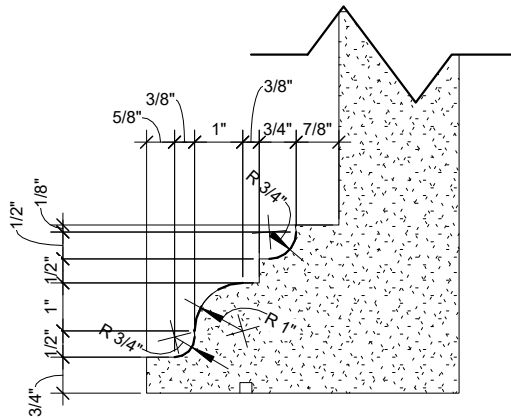

2A Molding Detail 2
3" = 1'-0"

PROJECT NORTH PHASE 2 - 90% SUBMITTAL


REVISIONS					
DATE	BY	DESCRIPTION	DATE	BY	DESCRIPTION



STATE OF FLORIDA DEPARTMENT OF TRANSPORTATION		
ROAD NO.	COUNTY	FINANCIAL PROJECT ID
SR 8	COLUMBIA	438609-1-52-01

SR 8 (I-10) WESTBOUND - (COLUMBIA COUNTY) REST AREA		DRAWING NO.
DETAILS		A604
		SHEET NO.

P:\1-10 Rest Area Improvements (19-049) GA14 - DrawingsA - Active Drawings\1 - B+P\Local Files\DD LOCAL\1-10 Rest_LOCAL_DD.rvt

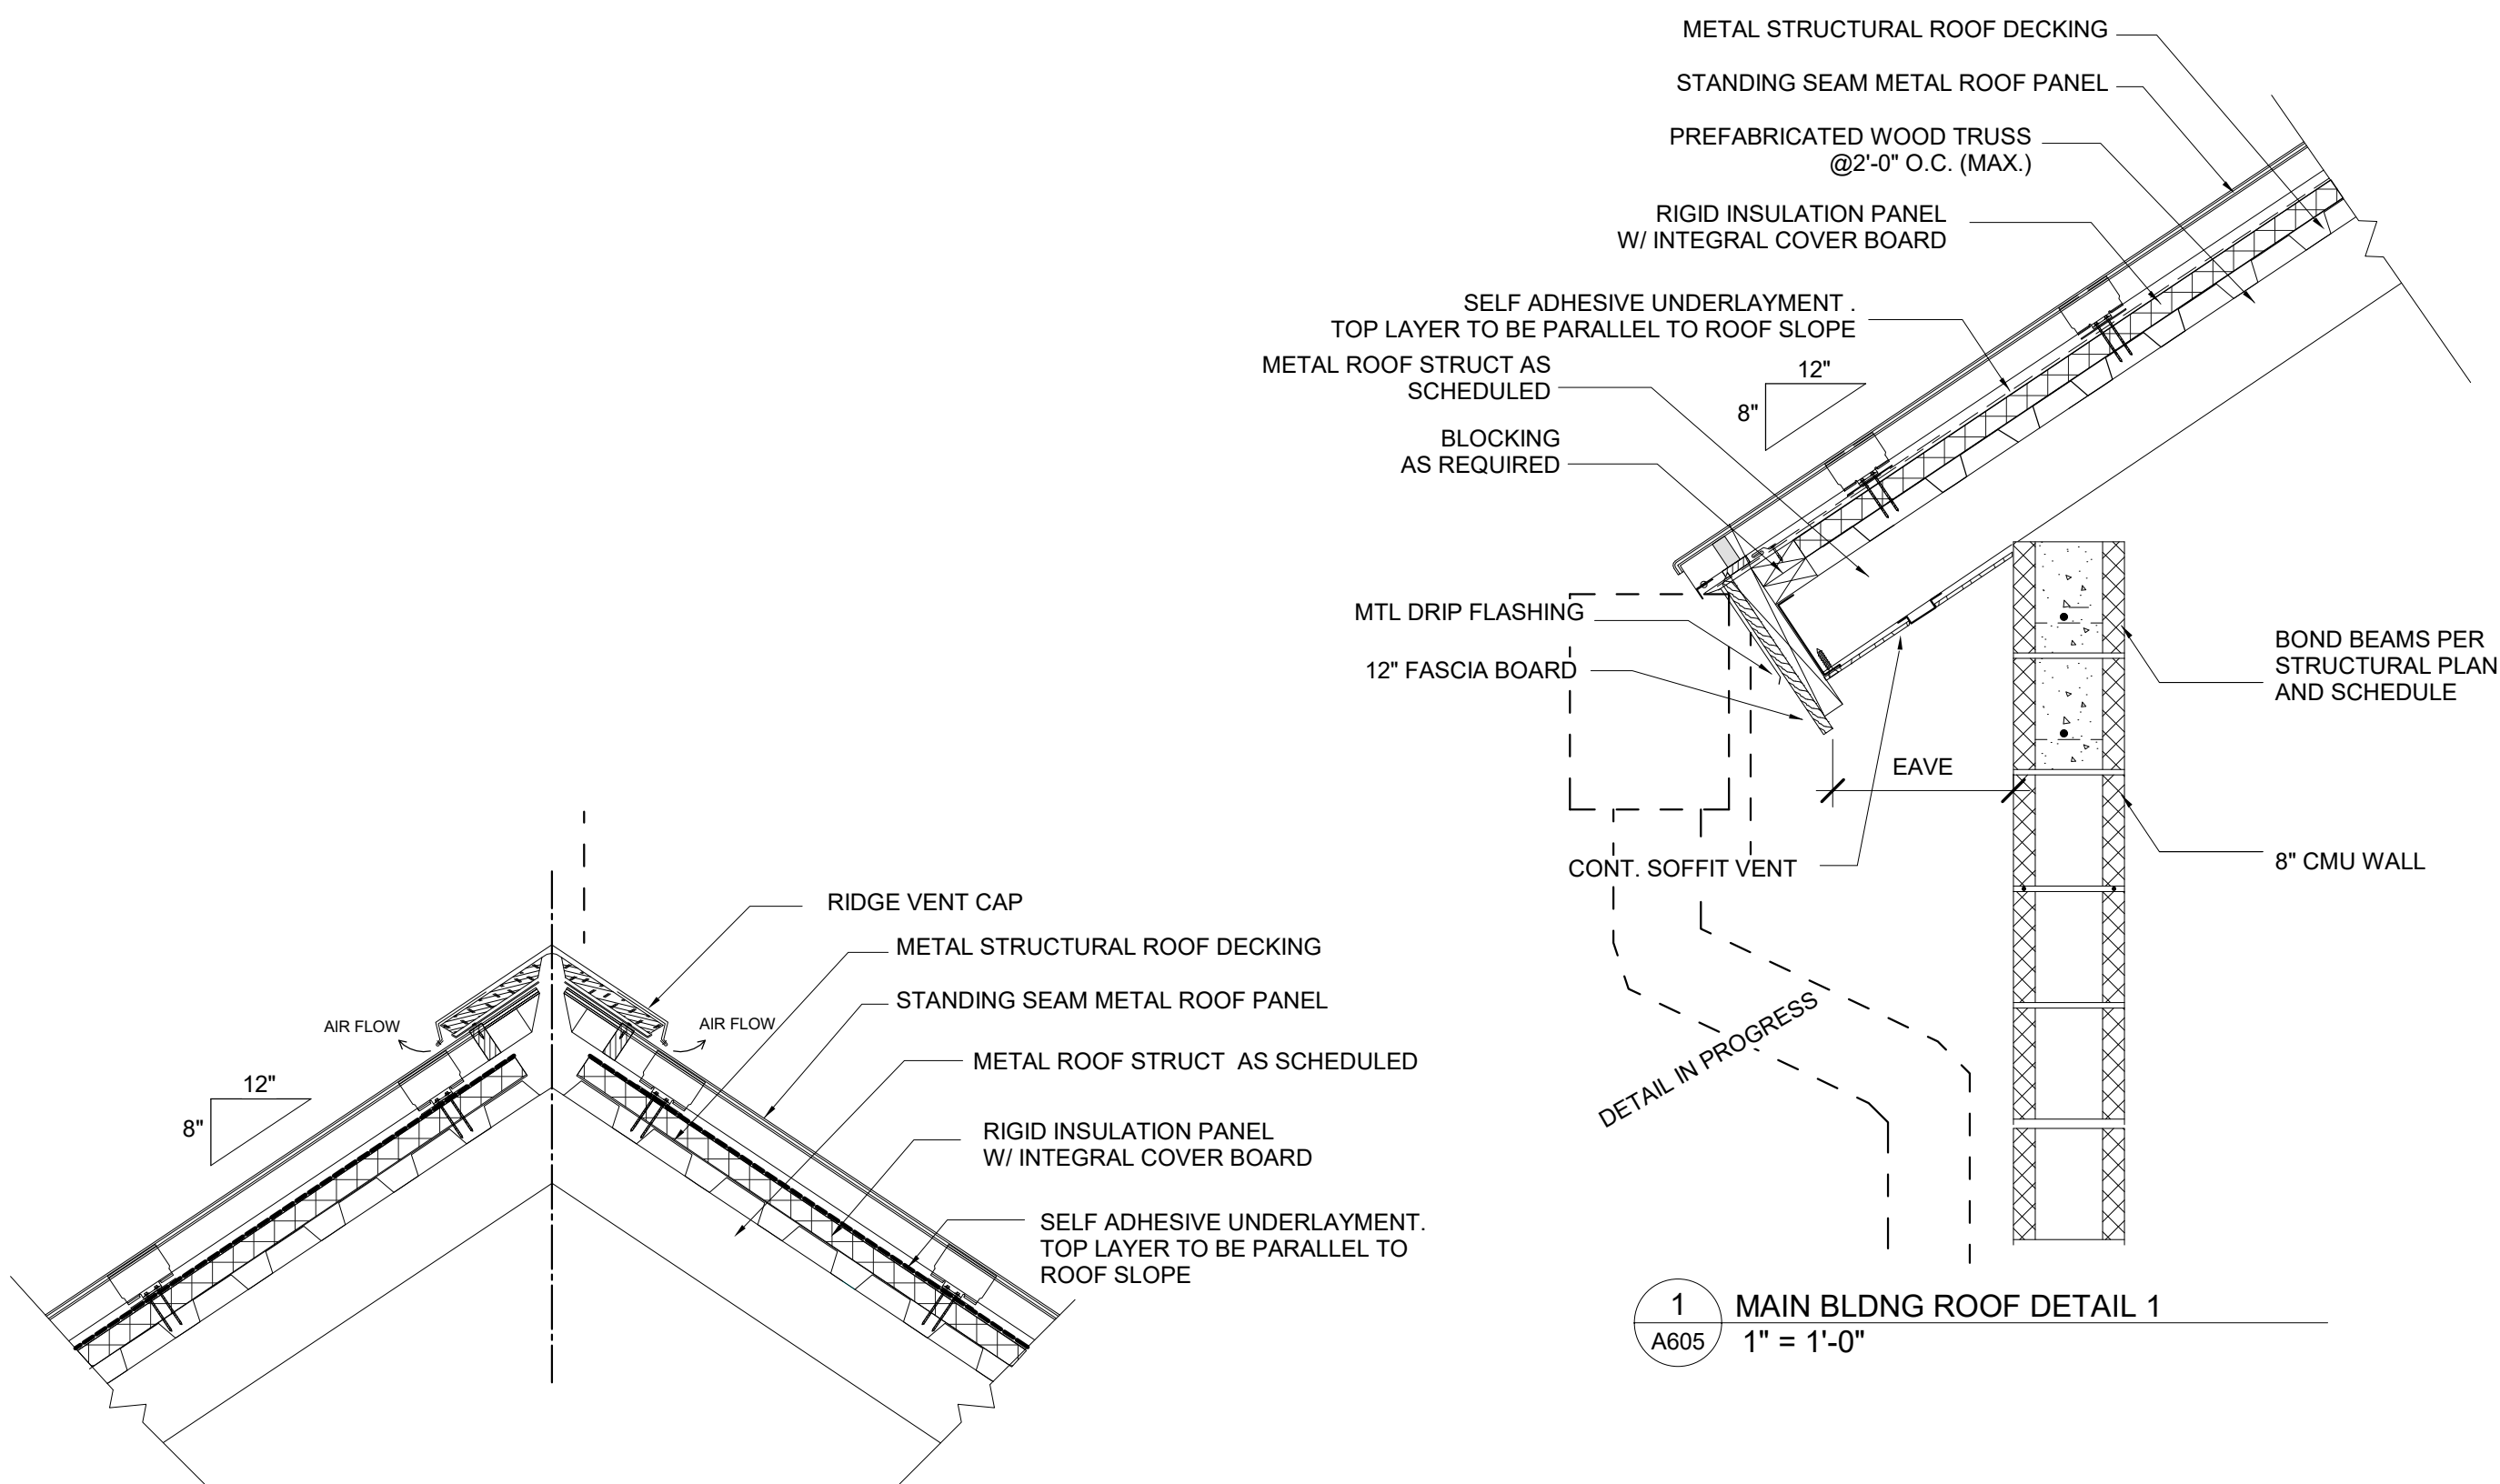

2 MAIN BLDNG ROOF DETAIL 2
A605 1" = 1'-0"

1 MAIN BLDNG ROOF DETAIL 1
A605 1" = 1'-0"

PROJECT NORTH

PHASE 2 - 90% SUBMITTAL

REVISIONS					
DATE	BY	DESCRIPTION	DATE	BY	DESCRIPTION



BORRELLI + PARTNERS
ARCHITECTURE PLANNING LANDSCAPE INTERIORS
720 Vassar Street, Orlando FL 32804 407.418.1338 :: fax 407.418.1342
CONFIDENTIAL THIS DRAWING IS THE PROPERTY OF BORRELLI + PARTNERS UNLESS OTHERWISE PROVIDED BY THE CONTRACT. THE CONTENTS OF THIS DRAWING ARE "NOT" TO BE TRANSMITTED TO ANY OTHER PARTY EXCEPT AS AGREED TO BY THE ARCHITECT. COPYRIGHT BORRELLI + PARTNERS, AAC 000711 / ACC 001842


STATE OF FLORIDA DEPARTMENT OF TRANSPORTATION		
ROAD NO.	COUNTY	FINANCIAL PROJECT ID
SR 8	COLUMBIA	438609-1-52-01

SR 8 (I-10) WESTBOUND - (COLUMBIA COUNTY) REST AREA	DRAWING NO. A605
MAIN BLDNG - ROOF DETAILS	SHEET NO.

Door Schedule

Mark	Location	Rm. No.	Door					Frame			HW Set	Comments
			Type	Width	Height	Thickness	Mat.	Type	Mat.	Fin.		
001	R/RM BLDG.	004	B	6' - 0"	7' - 0"	1 3/4"	H.M.	2FT	H.M.	Metal - Paint Fin 1	1.0	Door with Transom
002	R/RM BLDG.	007	A	3' - 0"	7' - 0"	1 3/4"	H.M.	F	H.M.	Metal - Paint Fin 2	5.0	
003	R/RM BLDG.	009	B	6' - 0"	7' - 0"	1 3/4"	H.M.	2F	H.M.	Metal - Paint Fin 1	1.0	
004	R/RM BLDG.	010	B	6' - 0"	7' - 0"	1 3/4"	H.M.	2F	H.M.	Metal - Paint Fin 1	1.0	
005	R/RM BLDG.	008	B	6' - 0"	7' - 0"	1 3/4"	H.M.	2F	H.M.	Metal - Paint Fin 1	1.0	
006	R/RM BLDG.	011	A	3' - 0"	7' - 0"	1 3/4"	H.M.	F	H.M.	Metal - Paint Fin 2	5.0	
007	R/RM BLDG.	014	B	6' - 0"	7' - 0"	1 3/4"	H.M.	2FT	H.M.	Metal - Paint Fin 1	1.0	Door with Transom
100	R/RM BLDG.	001	A	3' - 0"	7' - 0"	1 3/4"	H.M.	F	H.M.	Metal - Paint Fin 1	3.0	
101	R/RM BLDG.	002	A	3' - 0"	7' - 0"	1 3/4"	H.M.	F	H.M.	Metal - Paint Fin 1	2.0	
102	R/RM BLDG.	003	A	3' - 0"	7' - 0"	1 3/4"	H.M.	F	H.M.	Metal - Paint Fin 1	6.0	
103	R/RM BLDG.	003	A	3' - 0"	7' - 0"	1 3/4"	H.M.	F	H.M.	Metal - Paint Fin 2	7.0	Post Sign: "Authorized Personnel Only. Not an Exit."
104	R/RM BLDG.	CHASE	A	3' - 0"	7' - 0"	1 3/4"	H.M.	F	H.M.	Metal - Paint Fin 2	7.0	
105	R/RM BLDG.	005	A	3' - 0"	7' - 0"	1 3/4"	H.M.	F	H.M.	Metal - Paint Fin 2	7.0	Post Sign: "Authorized Personnel Only. Not an Exit."
106	R/RM BLDG.	005	A	3' - 0"	7' - 0"	1 3/4"	H.M.	F	H.M.	Metal - Paint Fin 1	6.0	
107	R/RM BLDG.	005	A	3' - 0"	7' - 0"	1 3/4"	H.M.	F	H.M.	Metal - Paint Fin 1	4.0	
108	R/RM BLDG.	012	A	3' - 0"	7' - 0"	1 3/4"	H.M.	F	H.M.	Metal - Paint Fin 1	4.0	
109	R/RM BLDG.	013	A	3' - 0"	7' - 0"	1 3/4"	H.M.	F	H.M.	Metal - Paint Fin 1	6.0	
110	R/RM BLDG.	013	A	3' - 0"	7' - 0"	1 3/4"	H.M.	F	H.M.	Metal - Paint Fin 2	7.0	Post Sign: "Authorized Personnel Only. Not an Exit."
111	R/RM BLDG.	CHASE	A	3' - 0"	7' - 0"	1 3/4"	H.M.	F	H.M.	Metal - Paint Fin 2	7.0	
112	R/RM BLDG.	015	A	3' - 0"	7' - 0"	1 3/4"	H.M.	F	H.M.	Metal - Paint Fin 2	7.0	Post Sign: "Authorized Personnel Only. Not an Exit."
113	R/RM BLDG.	015	A	3' - 0"	7' - 0"	1 3/4"	H.M.	F	H.M.	Metal - Paint Fin 1	6.0	
114	R/RM BLDG.	016	A	3' - 0"	7' - 0"	1 3/4"	H.M.	F	H.M.	Metal - Paint Fin 1	3.0	
115	STO. BLDG.	S01	R	8' - 0"	8' - 0"	0"	STEEL	R	STEEL	Finishes - OHD - White	8.0	
116	STO. BLDG.	S01	C	3' - 0"	7' - 0"	1 3/4"	H.M.	F	H.M.	Metal - Paint Fin 1	2.0	

NOTE: SEE SPECS
SECTION 08 71 00
FOR HDWR SETS SCHEDULE.

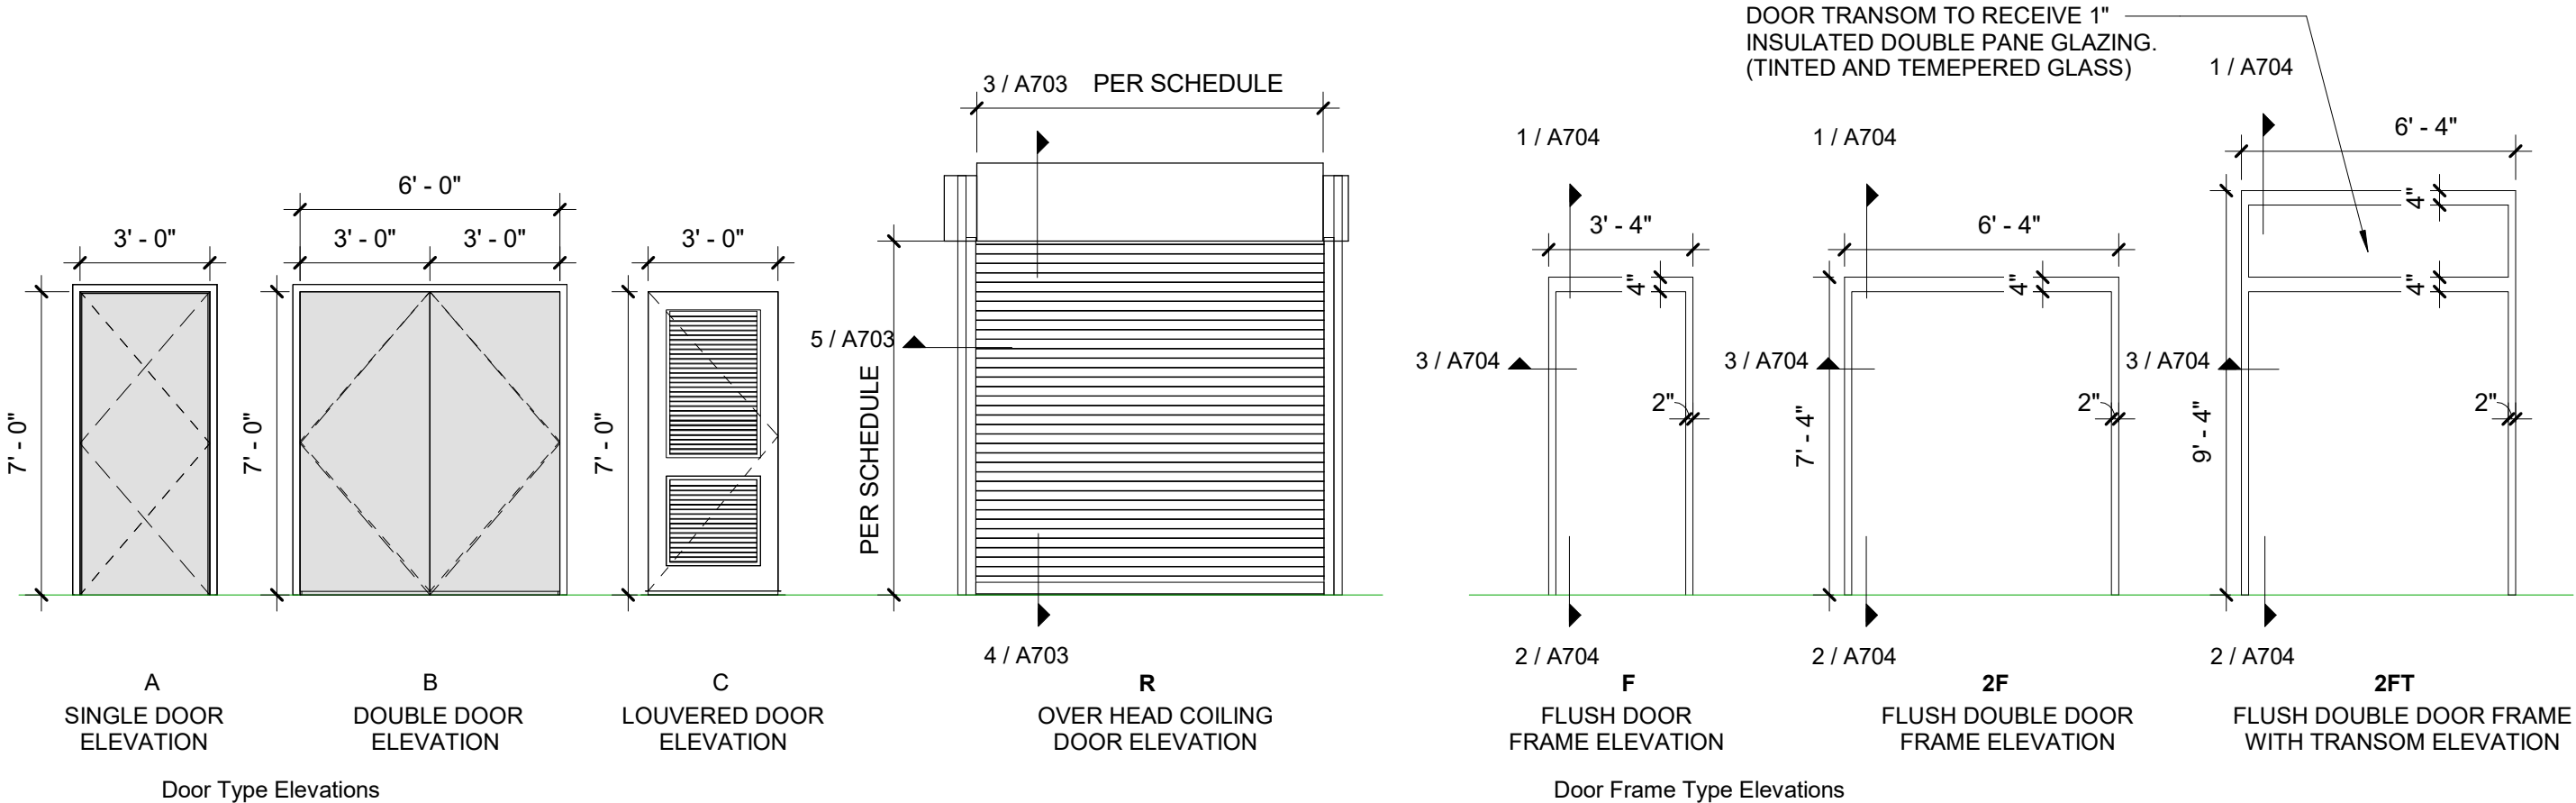

P:\1-10 Rest Area Improvements (19-049) GAI\4 - Drawings\A - Active Drawings\1 - B+P\Local Files\DD LOCAL\1-10 Rest_LOCAL_DD.rvt

PROJECT NORTH			PHASE 2 - 90% SUBMITTAL	
SR 8 (I-10) WESTBOUND - (COLUMBIA COUNTY) REST AREA			DRAWING NO.	
			A700	
			SHEET NO.	

REVISIONS					
DATE	BY	DESCRIPTION	DATE	BY	DESCRIPTION




BORRELLI + PARTNERS
ARCHITECTURE PLANNING LANDSCAPE INTERIORS
720 Vassar Street, Orlando FL 32804 407.418.1338 :: fax 407.418.1342
CONFIDENTIAL: THIS DRAWING IS THE PROPERTY OF BORRELLI + PARTNERS UNLESS OTHERWISE PROVIDED. BY THE CONTRACT, THE CONTENTS OF THIS DRAWING ARE SHALL NOT BE TRANSMITTED TO ANY OTHER PARTY EXCEPT AS AGREED TO BY THE ARCHITECT. COPYRIGHT BORRELLI + PARTNERS, AAC 000711 / ACC 001842

STATE OF FLORIDA DEPARTMENT OF TRANSPORTATION		
ROAD NO.	COUNTY	FINANCIAL PROJECT ID
SR 8	COLUMBIA	438609-1-52-01

P:\1-10 Rest Area Improvements (19-049) GA\14 - Drawings\A - Active Drawings\1 - B+P\Local Files\DD LOCAL\1-10 Rest_LOCAL_DD.rvt

NOTE:
ALL EXTERIOR GLAZING SHALL BE INSULATED DOUBLE-PANE
(CENTERED GLAZED SYSTEM)
THE 1" THICK GLAZING SYSTEM COMPONENTS ARE:
- OUTER PANE: 1/4" TINTED, TEMEPERED GLASS
- 1/2" AIR SPACE
- INNER PANE 1/4" CLEAR, TEMPERED GLASS

Window Schedule						
Mark	Count	Type	Height	Width	Sill Height	Comments
W1	59	24" x 40"	3' - 4"	2' - 0"	6' - 1"	
W2	2	24" x 124"	10' - 4"	2' - 0"	3' - 6 3/4"	
W3	2	48" x 50"	4' - 2"	2' - 0"	3' - 0"	

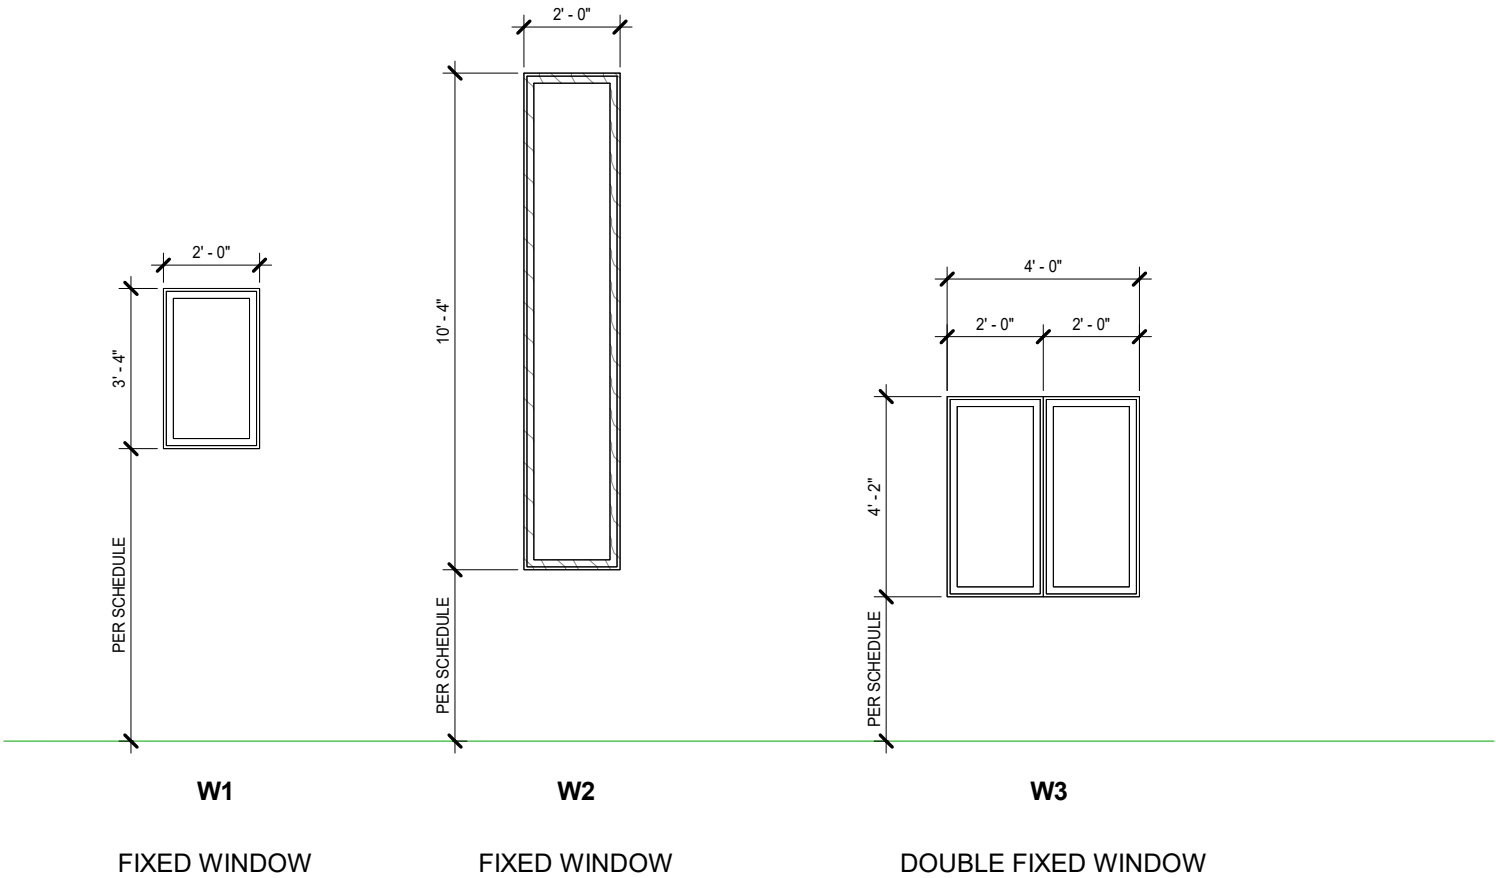

① PROJECT NORTH		PHASE 2 - 90% SUBMITTAL	
SR 8 (I-10) WESTBOUND - (COLUMBIA COUNTY) REST AREA			DRAWING NO.
			A701
			SHEET NO.


REVISIONS					
DATE	BY	DESCRIPTION	DATE	BY	DESCRIPTION



BORRELLI + PARTNERS
ARCHITECTURE PLANNING LANDSCAPE INTERIORS
720 Vassar Street, Orlando FL 32804 407.418.1338 :: fax 407.418.1342
CONFIDENTIAL: THIS DRAWING IS THE PROPERTY OF BORRELLI + PARTNERS UNLESS OTHERWISE PROVIDED. BY THE CONTRACT, THE CONTENTS OF THIS DRAWING ARE SHOWN NOT BE TRANSMITTED TO ANY OTHER PARTY EXCEPT AS AGREED TO BY THE ARCHITECT. COPYRIGHT BORRELLI + PARTNERS. AAC 000711 / ACC 001842


STATE OF FLORIDA DEPARTMENT OF TRANSPORTATION		
ROAD NO.	COUNTY	FINANCIAL PROJECT ID
SR 8	COLUMBIA	438609-1-52-01

WINDOW SCHEDULE	
-----------------	--

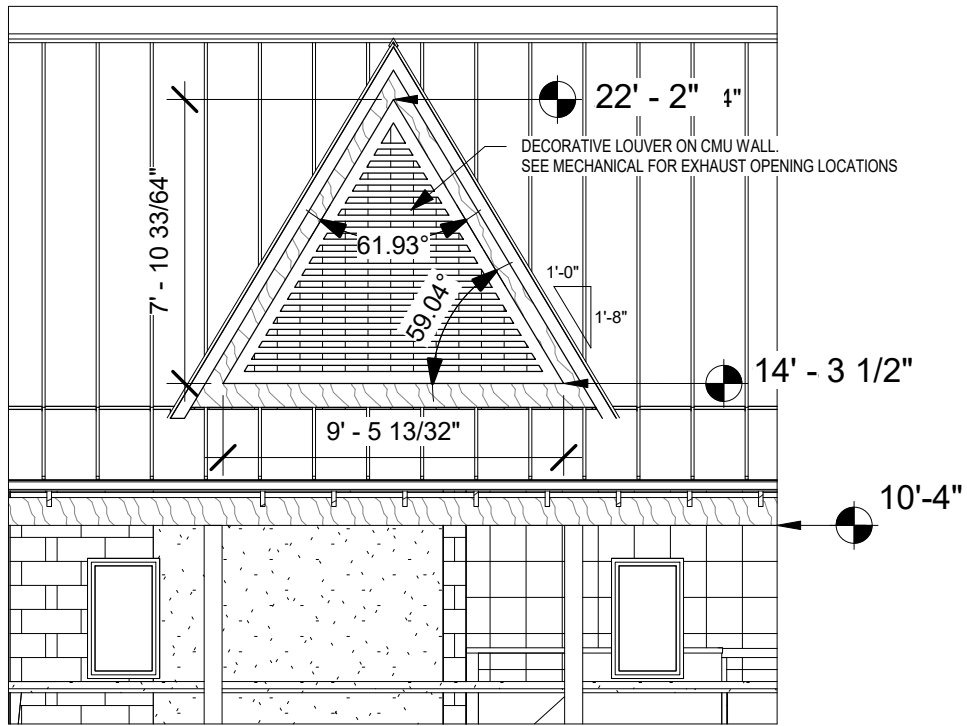


1 Louver L1 Detail
3/16" = 1'-0"

NOTE: TOTAL OF 4 TYPE L1 LOUVERS

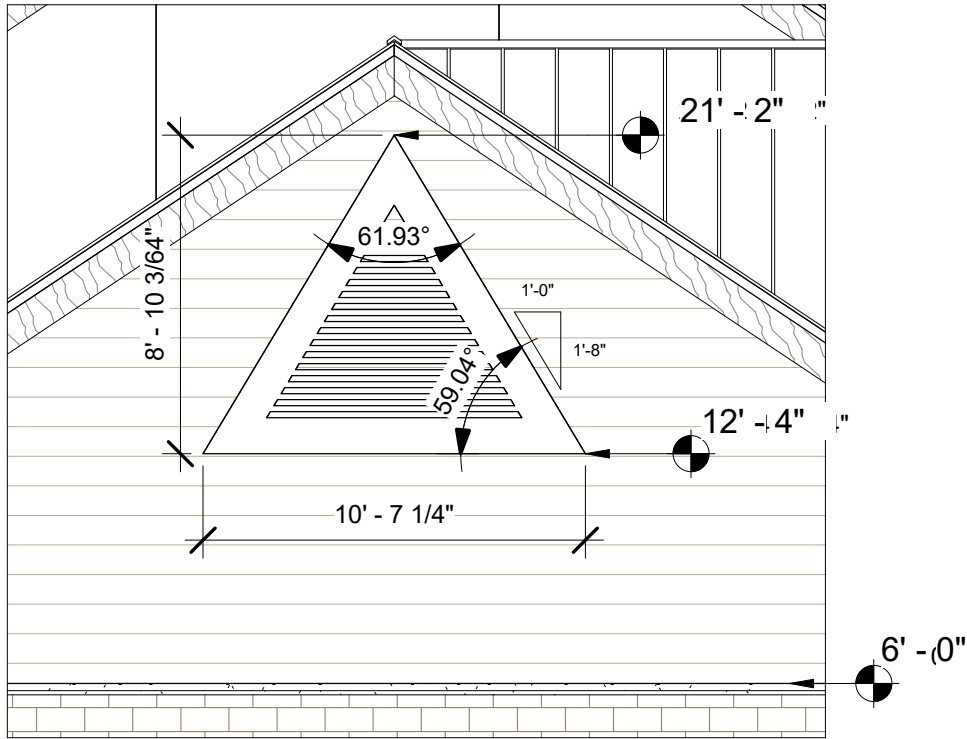


2 Louver L2 Detail
3/16" = 1'-0"

NOTE: TOTAL OF 2 TYPE L2 LOUVERS

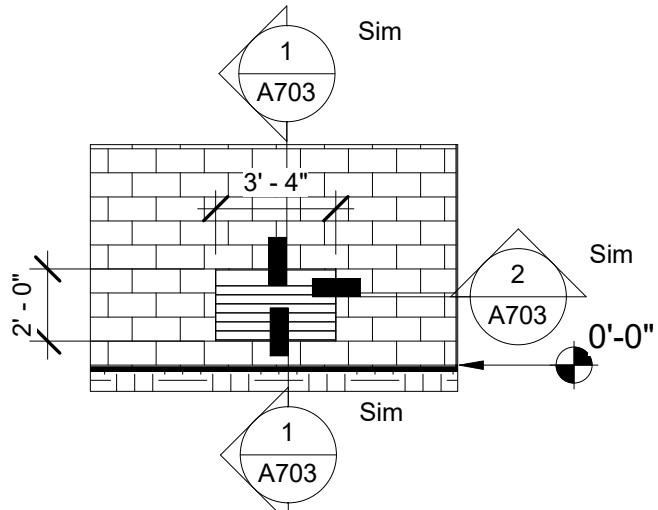


5 Louver L5 Detail
3/16" = 1'-0"

NOTE: TOTAL OF 2 TYPE L5 LOUVERS

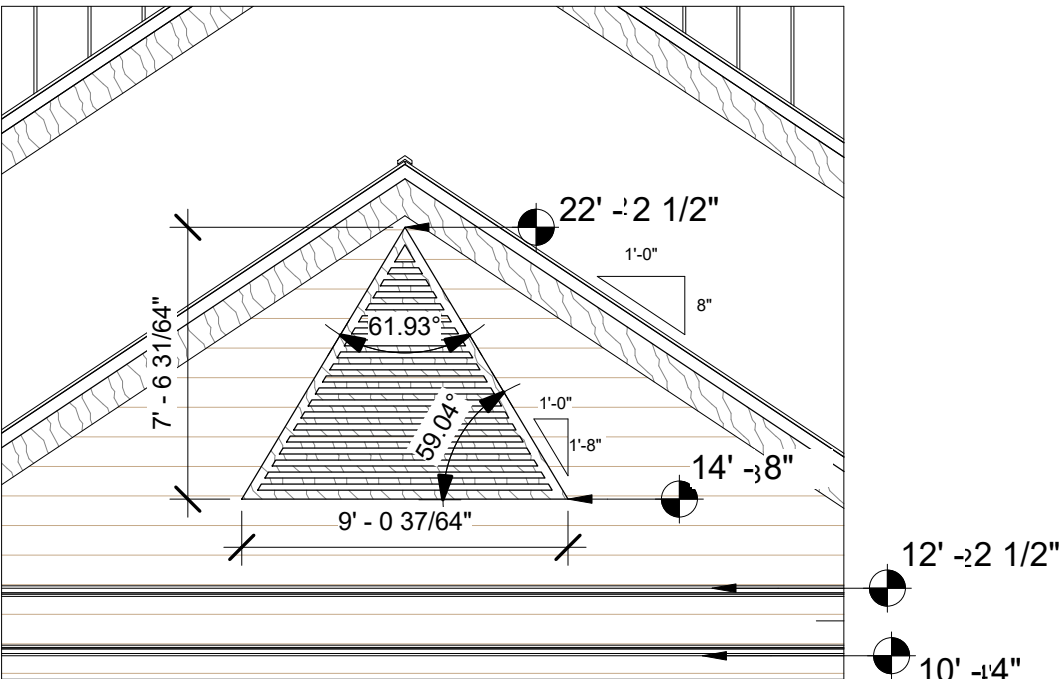


3 Louver L3 Detail
3/16" = 1'-0"

NOTE: TOTAL OF 1 TYPE L3 LOUVER

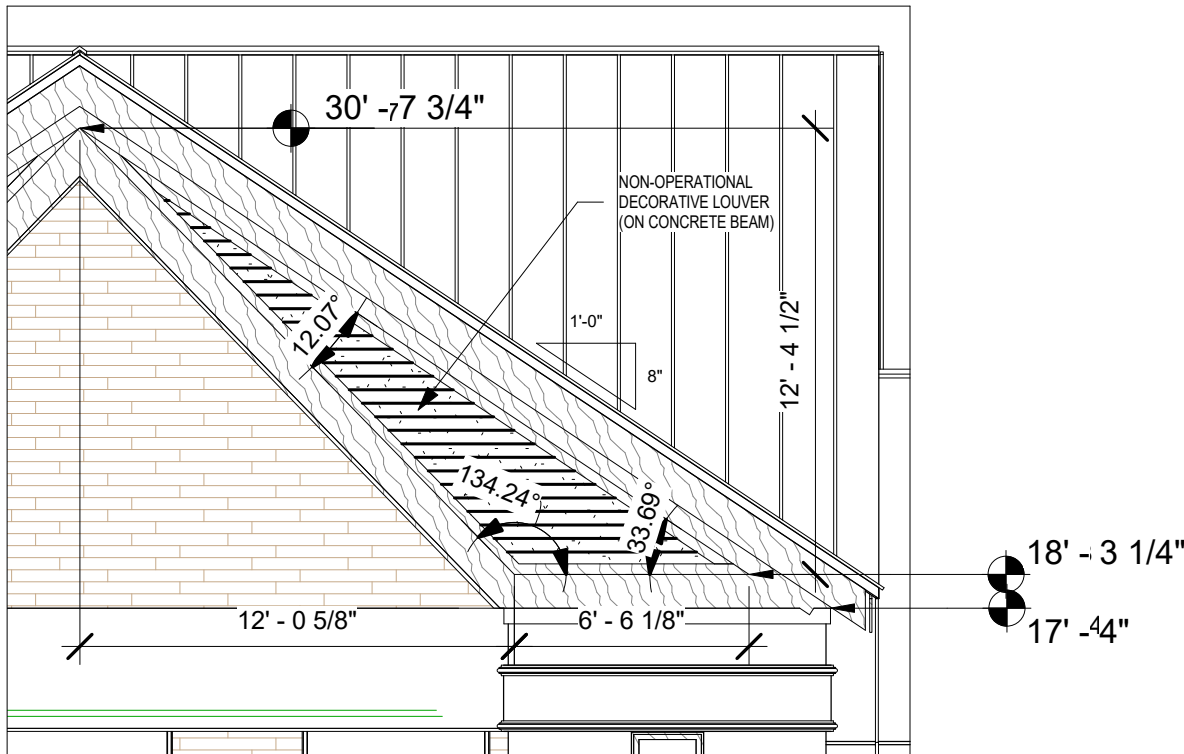

4 Decorative Louver L4 Detail
3/16" = 1'-0"

NOTE: TOTAL OF 2 (MIRRORW) TYPE L4 LOUVERS

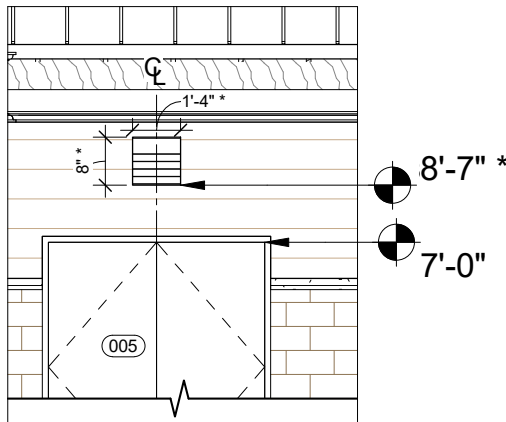

6 Louver L6 Detail
3/16" = 1'-0"

NOTE:
* COORDINATE DIMENSIONS
AND HT. WITH MECHANICAL

1 PROJECT NORTH PHASE 2 - 90% SUBMITTAL


REVISIONS					
DATE	BY	DESCRIPTION	DATE	BY	DESCRIPTION




STATE OF FLORIDA DEPARTMENT OF TRANSPORTATION		
ROAD NO.	COUNTY	FINANCIAL PROJECT ID
SR 8	COLUMBIA	438609-1-52-01

SR 8 (I-10) WESTBOUND - (COLUMBIA COUNTY) REST AREA		DRAWING NO.
LOUVER SCHEDULE		A702
		SHEET NO.


P:\1-10 Rest Area Improvements (19-049) GA14 - DrawingsA - Active Drawings\1 - B+P\Local Files\DD LOCAL\1-10 Rest_LOCAL_DD.rvt

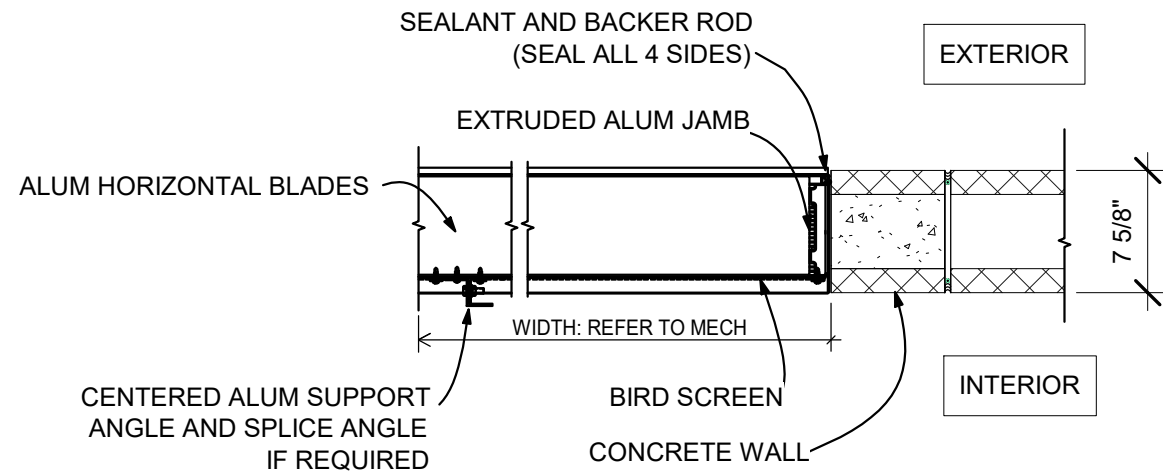


2 Louver Detail (Jamb)
A703 1" = 1'-0"

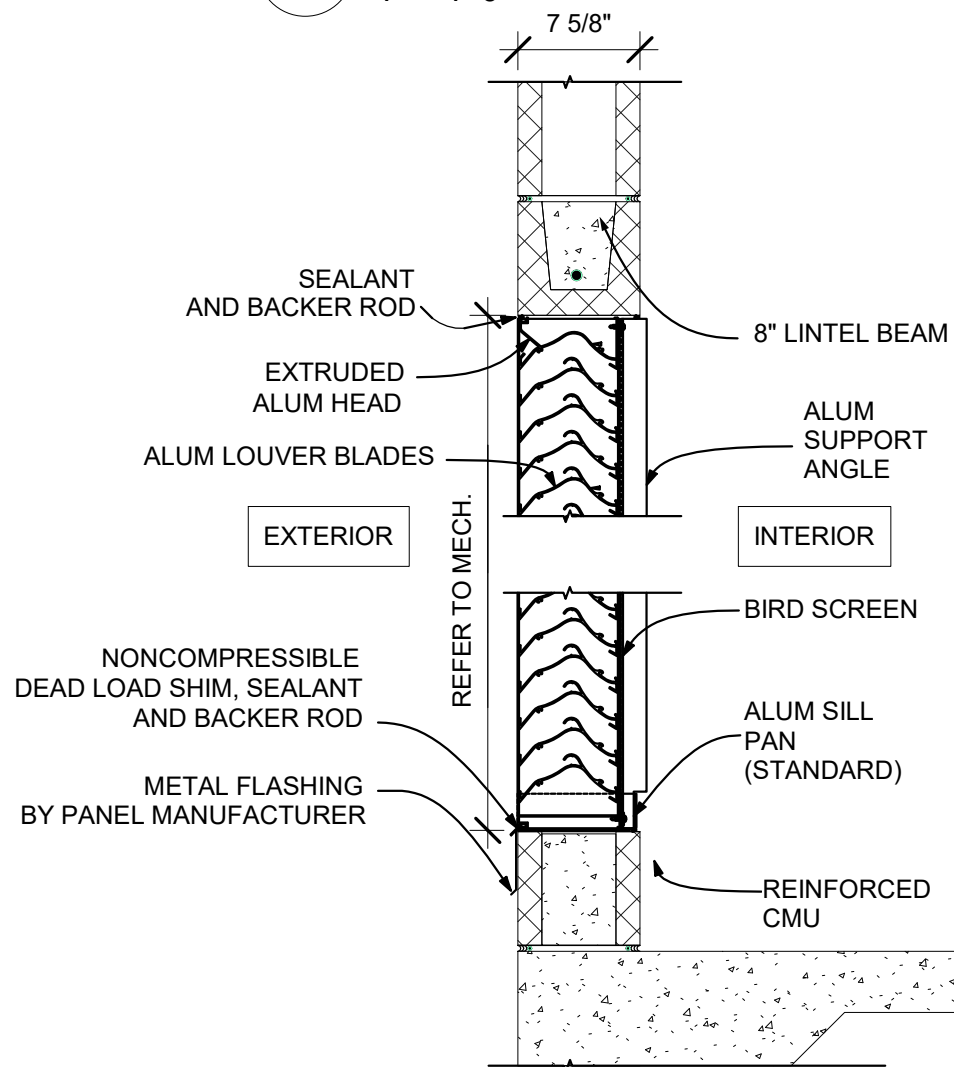


1 Louver Detail (Head and Sill)
A703 1" = 1'-0"

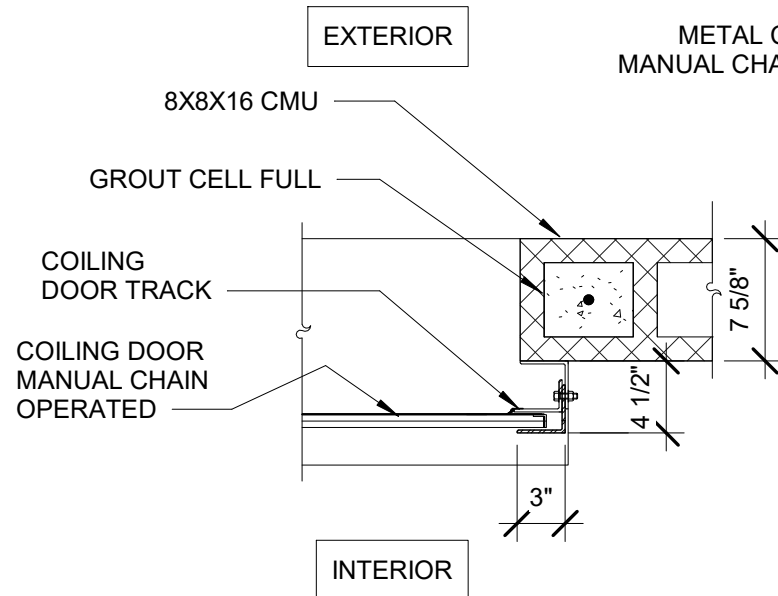

5 Coiling Door Det. (Jamb)
A703 1" = 1'-0"

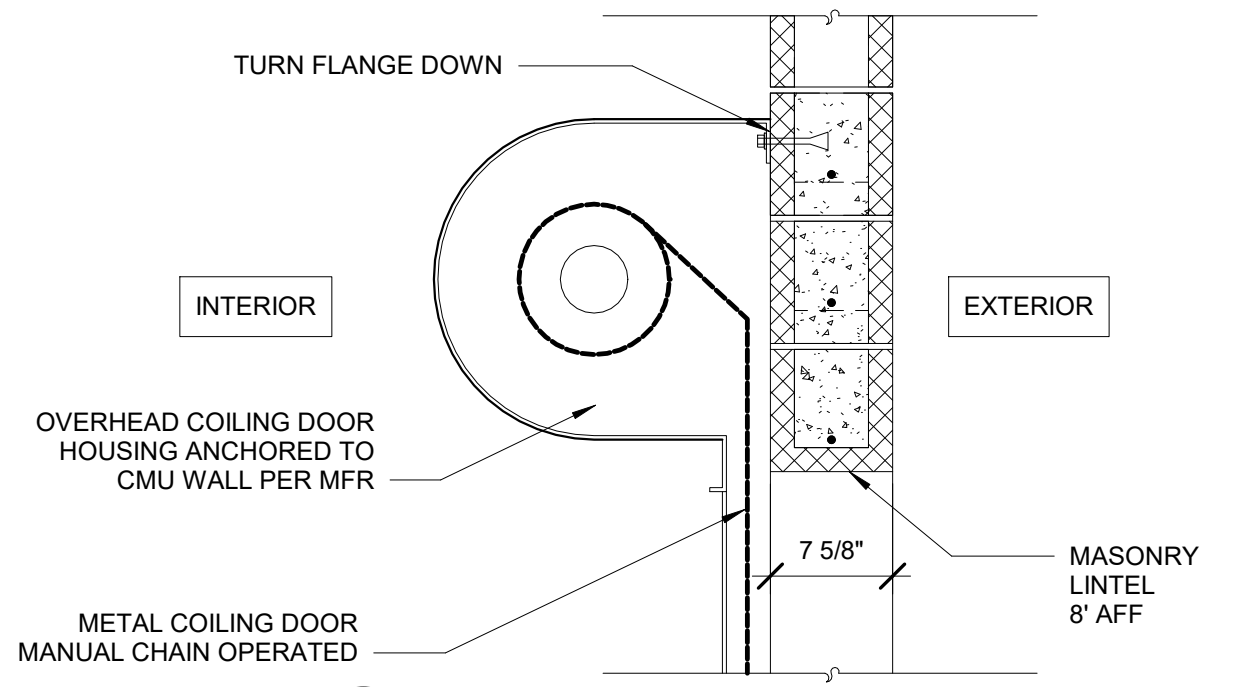

3 Coiling Door Det. (Head)
A703 1" = 1'-0"

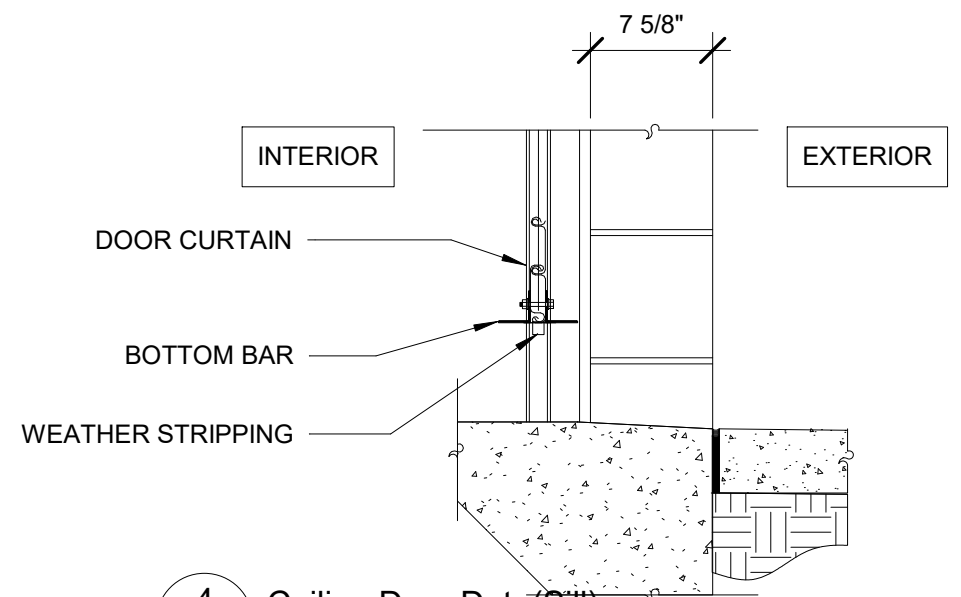

4 Coiling Door Det. (Sill)
A703 1" = 1'-0"

PROJECT NORTH			PHASE 2 - 90% SUBMITTAL	
SR 8 (I-10) WESTBOUND - (COLUMBIA COUNTY) REST AREA			DRAWING NO.	
			A703	
			SHEET NO.	


REVISIONS					
DATE	BY	DESCRIPTION	DATE	BY	DESCRIPTION

BORRELLI + PARTNERS
ARCHITECTURE PLANNING LANDSCAPE INTERIORS
720 Vassar Street, Orlando, FL 32804 407.418.1338 :: fax 407.418.1342
CONFIDENTIAL: THIS DRAWING IS THE PROPERTY OF BORRELLI + PARTNERS. UNLESS OTHERWISE PROVIDED, BY THE CONTRACT, THE CONTENTS OF THIS DRAWING ARE NOT TO BE TRANSMITTED TO ANY OTHER PARTY EXCEPT AS AGREED TO BY THE ARCHITECT. COPYRIGHT BORRELLI + PARTNERS, A/C 000711 / A/C 001842


STATE OF FLORIDA DEPARTMENT OF TRANSPORTATION		
ROAD NO.	COUNTY	FINANCIAL PROJECT ID
SR 8	COLUMBIA	438609-1-52-01

DOOR AND LOUVER DETAILS


P:\1-10 Rest Area Improvements (19-049) GA14 - DrawingsA - Active Drawings1 - B+P\Local Files\DD LOCAL\1-10 Rest_LOCAL_DD.rvt

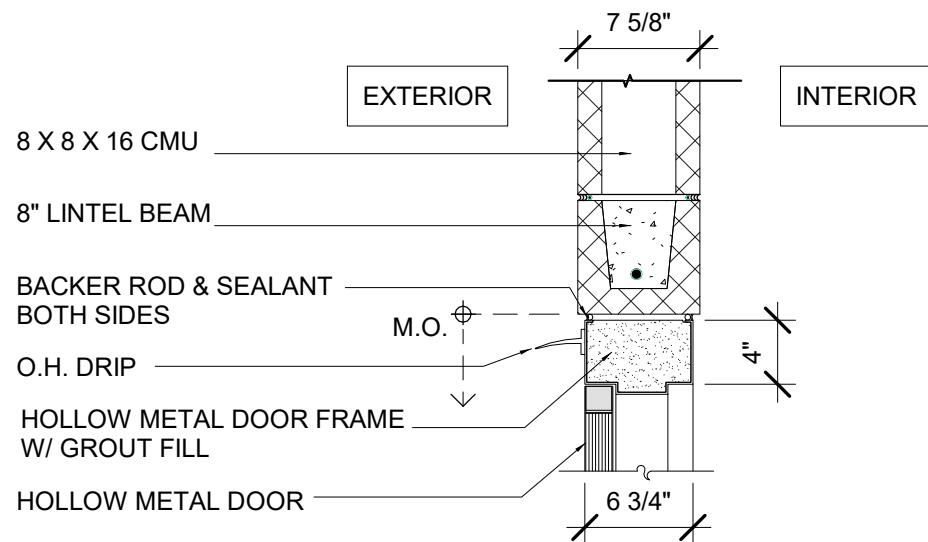


1 Door Detail (Head)
A704 1" = 1'-0"

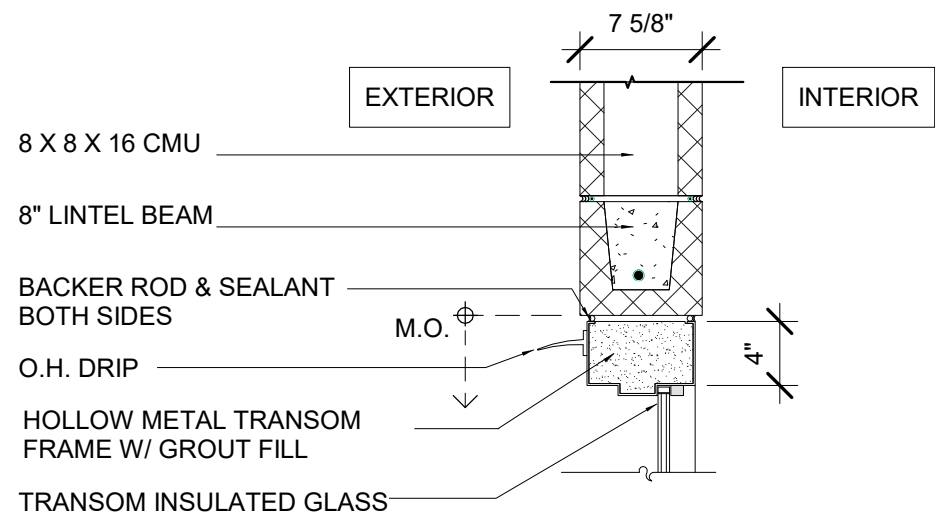

1A Door Detail (Head) at Door
Transom
A704 1" = 1'-0"

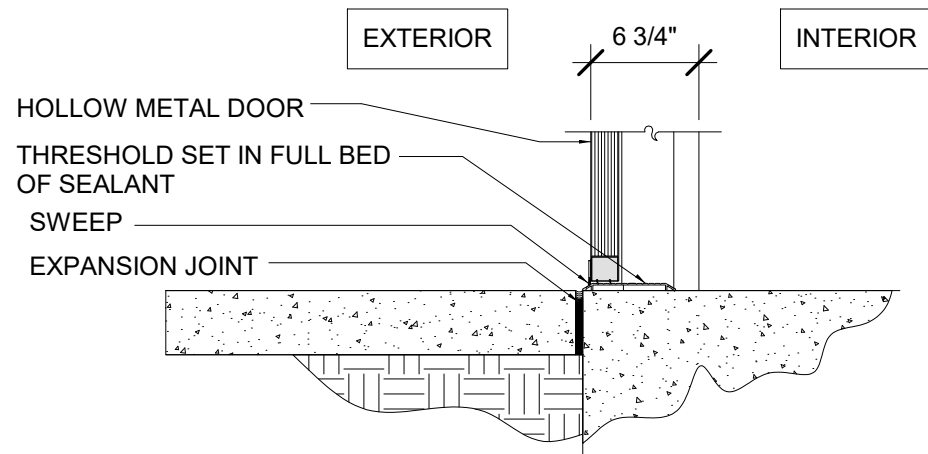

2 Door Detail (Sill)
A704 1" = 1'-0"

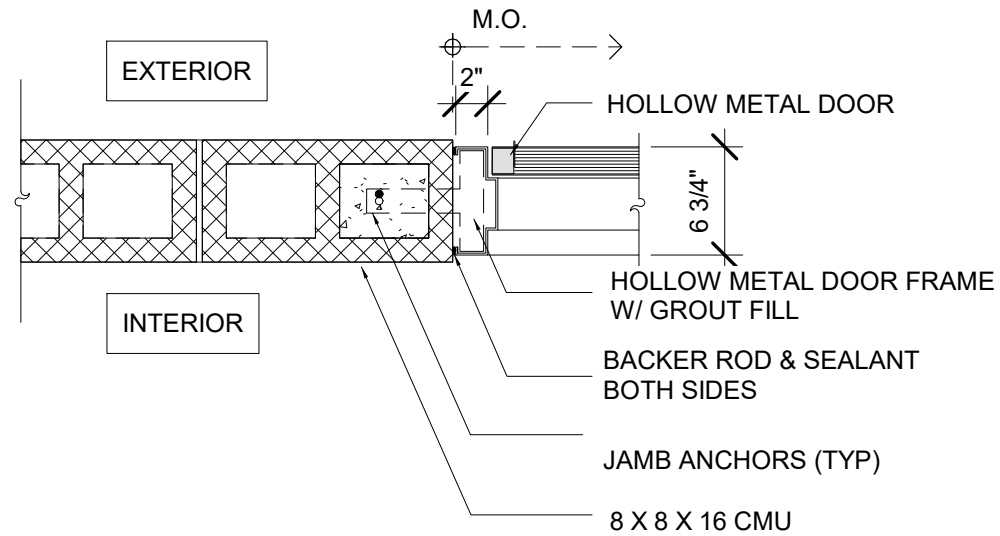

3 Door Detail (Jamb)
A704 1" = 1'-0"

1 PROJECT NORTH

PHASE 2 - 90% SUBMITTAL

REVISIONS					
DATE	BY	DESCRIPTION	DATE	BY	DESCRIPTION




STATE OF FLORIDA DEPARTMENT OF TRANSPORTATION		
ROAD NO.	COUNTY	FINANCIAL PROJECT ID
SR 8	COLUMBIA	438609-1-52-01


SR 8 (I-10) WESTBOUND - (COLUMBIA COUNTY) REST AREA		DRAWING NO.
DOOR DETAILS		A704
		SHEET NO.

P:\1-10 Rest Area Improvements (19-049) GAI\4 - Drawings\A - Active Drawings\1 - B+P\Local Files\IDD LOCAL\1-10 Rest_LOCAL_DD.rvt

Fixtures & Accessories Mounting Heights

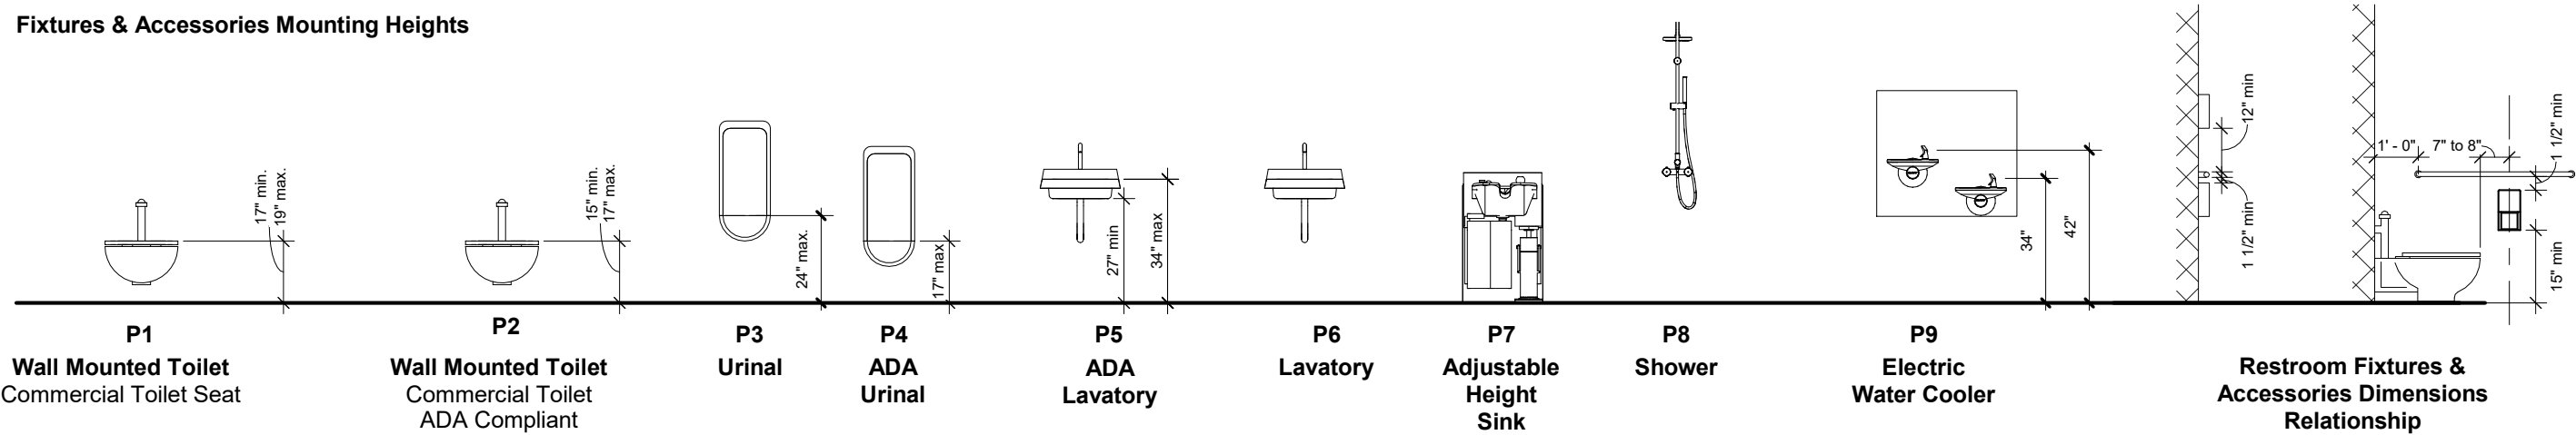

Plumbing Fixtures

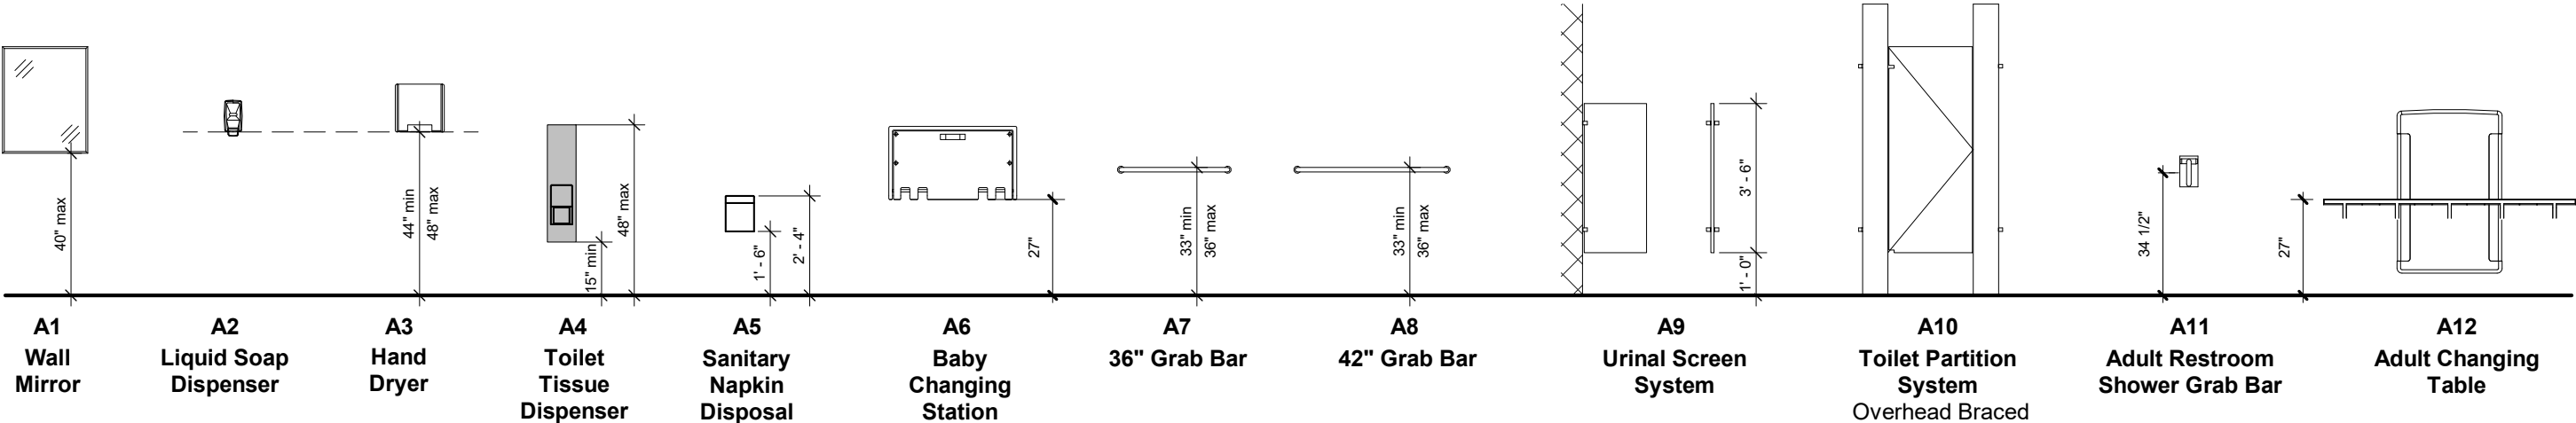

Specialty Equipment

NOTE:

FIXTURES & ACCESSORIES MOUNTING HEIGHTS MAY CHANGE DEPENDING ON THE SPECIFIC FIXTURES SELECTED. ALL PROPOSED FIXTURES MUST BE REVIEWED AND APPROVED PRIOR TO INSTALLATION.

ALL ITEMS TO BE MOUNTED IN ACCORDANCE WITH FLORIDA BUILDING CODE.

① PROJECT NORTH			PHASE 2 - 90% SUBMITTAL	
SR 8 (I-10) WESTBOUND - (COLUMBIA COUNTY) REST AREA			DRAWING NO.	
FIXTURES AND ACCESSORIES MOUNTING HEIGHT			A800	
			SHEET NO.	

REVISIONS					
DATE	BY	DESCRIPTION	DATE	BY	DESCRIPTION



BORRELLI + PARTNERS
ARCHITECTURE PLANNING LANDSCAPE INTERIORS
720 Vassar Street, Orlando FL 32804 407.418.1338 :: fax 407.418.1342
CONFIDENTIAL: THIS DRAWING IS THE PROPERTY OF BORRELLI + PARTNERS. UNLESS OTHERWISE PROVIDED, BY THE CONTRACT, THE CONTENTS OF THIS DRAWING ARE NOT TO BE TRANSMITTED TO ANY OTHER PARTY EXCEPT AS AGREED TO BY THE ARCHITECT. COPYRIGHT BORRELLI + PARTNERS, A/C 000711 / ACC 001842


STATE OF FLORIDA DEPARTMENT OF TRANSPORTATION		
ROAD NO.	COUNTY	FINANCIAL PROJECT ID
SR 8	COLUMBIA	438609-1-52-01

NOTES:

- 1- ALL ITEM TO BE MOUNTED IN ACCORDANCE WITH FLORIDA BUILDING CODE 2017 - 6TH EDITION.
- 2- FIXTURES AND ACCESSORIES MOUNTING HEIGHTS MAY CHANGE DEPENDING ON THE SPECIFIC FIXTURES SELECTED. ALL PROPOSED FIXTURES MUST BE REVIEWED AND APPROVED.
- 3- PROVIDE WOOD BLOCKING AROUND WATER CLOSETS AND SHOWER AND AT ALL GRAB BARS & OTHER TOILET ACCESSORYS AS NECESSARY.

REVISIONS						 BORRELLI + PARTNERS ARCHITECTURE PLANNING LANDSCAPE INTERIORS (INCORPORATED) 720 Vassar Street, Orlando FL 32804 407.418.1338 :: fax 407.418.1342 CONFIDENTIAL: THIS DRAWING IS THE PROPERTY OF BORRELLI + PARTNERS UNLESS OTHERWISE PROVIDED; BY THE CONTRACT, THE CONTENTS OF THIS DRAWING ARE TO BE TRANSMITTED TO ANY OTHER PARTY EXCEPT AS ORDERED BY THE ARCHITECT. COPYRIGHT BORRELLI + PARTNERS, A/C 000711 / ACC 001842	STATE OF FLORIDA DEPARTMENT OF TRANSPORTATION			SR 8 (I-10) WESTBOUND - (COLUMBIA COUNTY) REST AREA		DRAWING NO.
DATE	BY	DESCRIPTION	DATE	BY	DESCRIPTION		ROAD NO.	COUNTY	FINANCIAL PROJECT ID		SHEET NO.	
							SR 8	COLUMBIA	438609-1-52-01	WOMEN RR'S TOILET ACCESSORIES		

P:\1-10 Rest Area Improvements (19-049) GA14 - DrawingsA - Active Drawings\1 - B+P\Local Files\DD LOCAL\1-10 Rest_LOCAL_DD.rvt

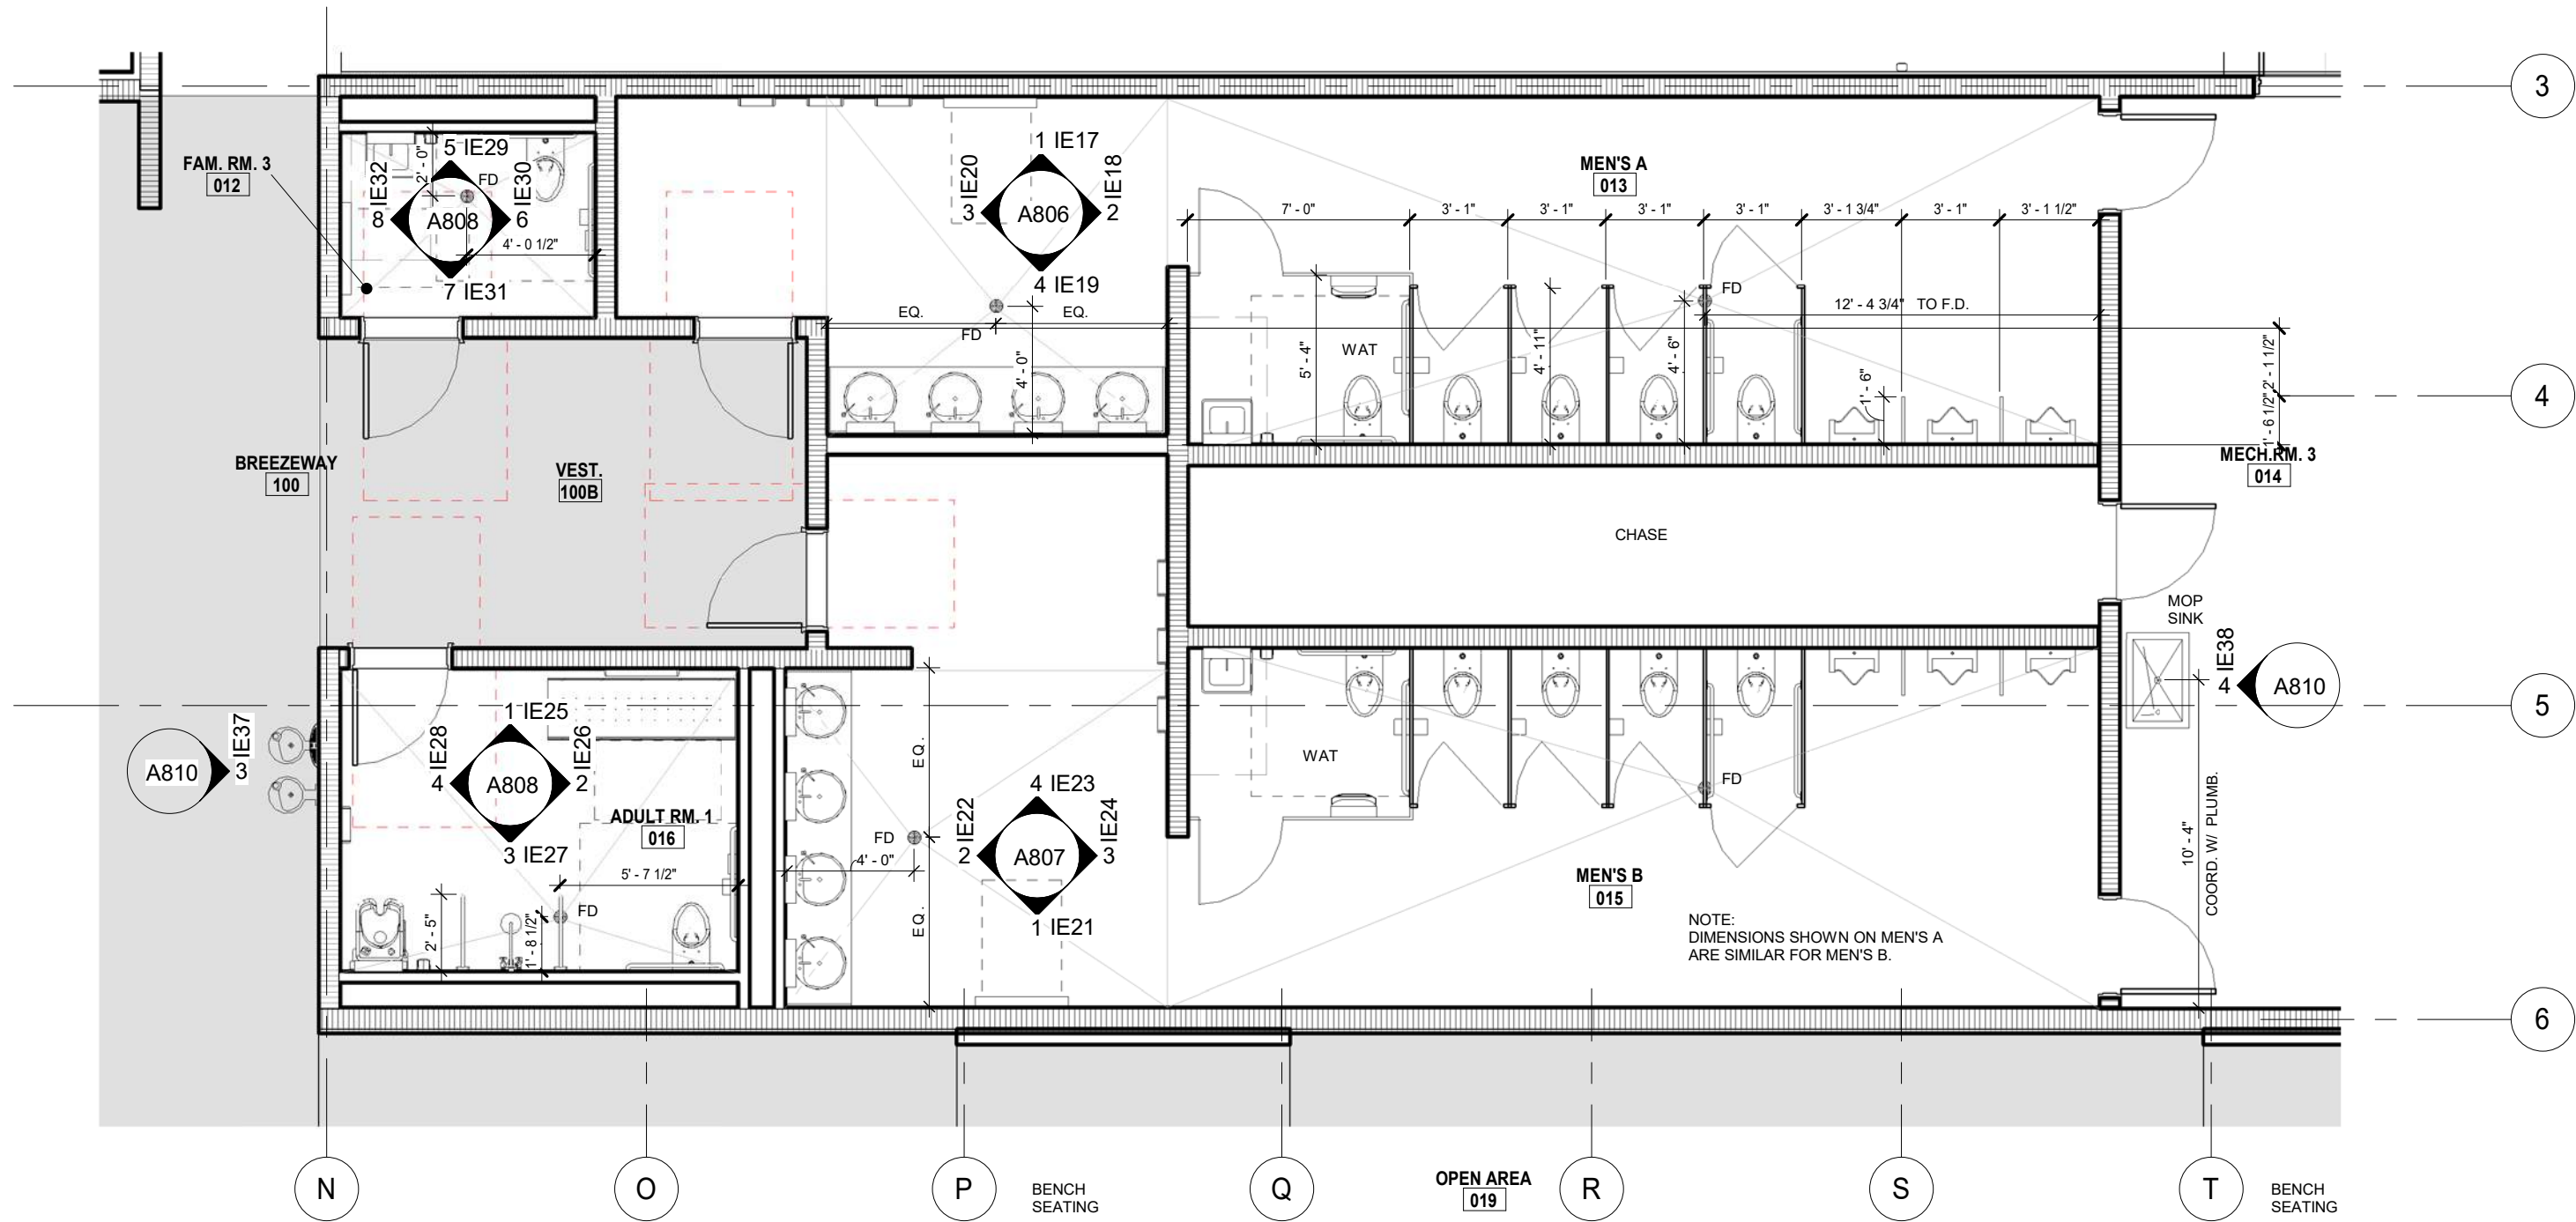

1 MEN RR'S TA
A802 3/16" = 1'-0"

- NOTES:
- 1- ALL ITEM TO BE MOUNTED IN ACCORDANCE WITH FLORIDA BUILDING CODE 2017 - 6TH EDITION.
 - 2- FIXTURES AND ACCESSORIES MOUNTING HEIGHTS MAY CHANGE DEPENDING ON THE SPECIFIC FIXTURES SELECTED. ALL PROPOSED FIXTURES MUST BE REVIEWED AND APPROVED.
 - 3- PROVIDE WOOD BLOCKING AROUND WATER CLOSETS AND SHOWER AND AT ALL GRAB BARS & OTHER TOILET ACCESSORYS AS NECESSARY.


PROJECT NORTH			PHASE 2 - 90% SUBMITTAL	
SR 8 (I-10) WESTBOUND - (COLUMBIA COUNTY) REST AREA			DRAWING NO.	
			A802	
			SHEET NO.	

REVISIONS					
DATE	BY	DESCRIPTION	DATE	BY	DESCRIPTION




STATE OF FLORIDA DEPARTMENT OF TRANSPORTATION		
ROAD NO.	COUNTY	FINANCIAL PROJECT ID
SR 8	COLUMBIA	438609-1-52-01


P:\1-10 Rest Area Improvements (19-049) GA\14 - DrawingsA - Active Drawings\1 - B+P\Local Files\DD LOCAL\1-10 Rest_LOCAL_DD.rvt

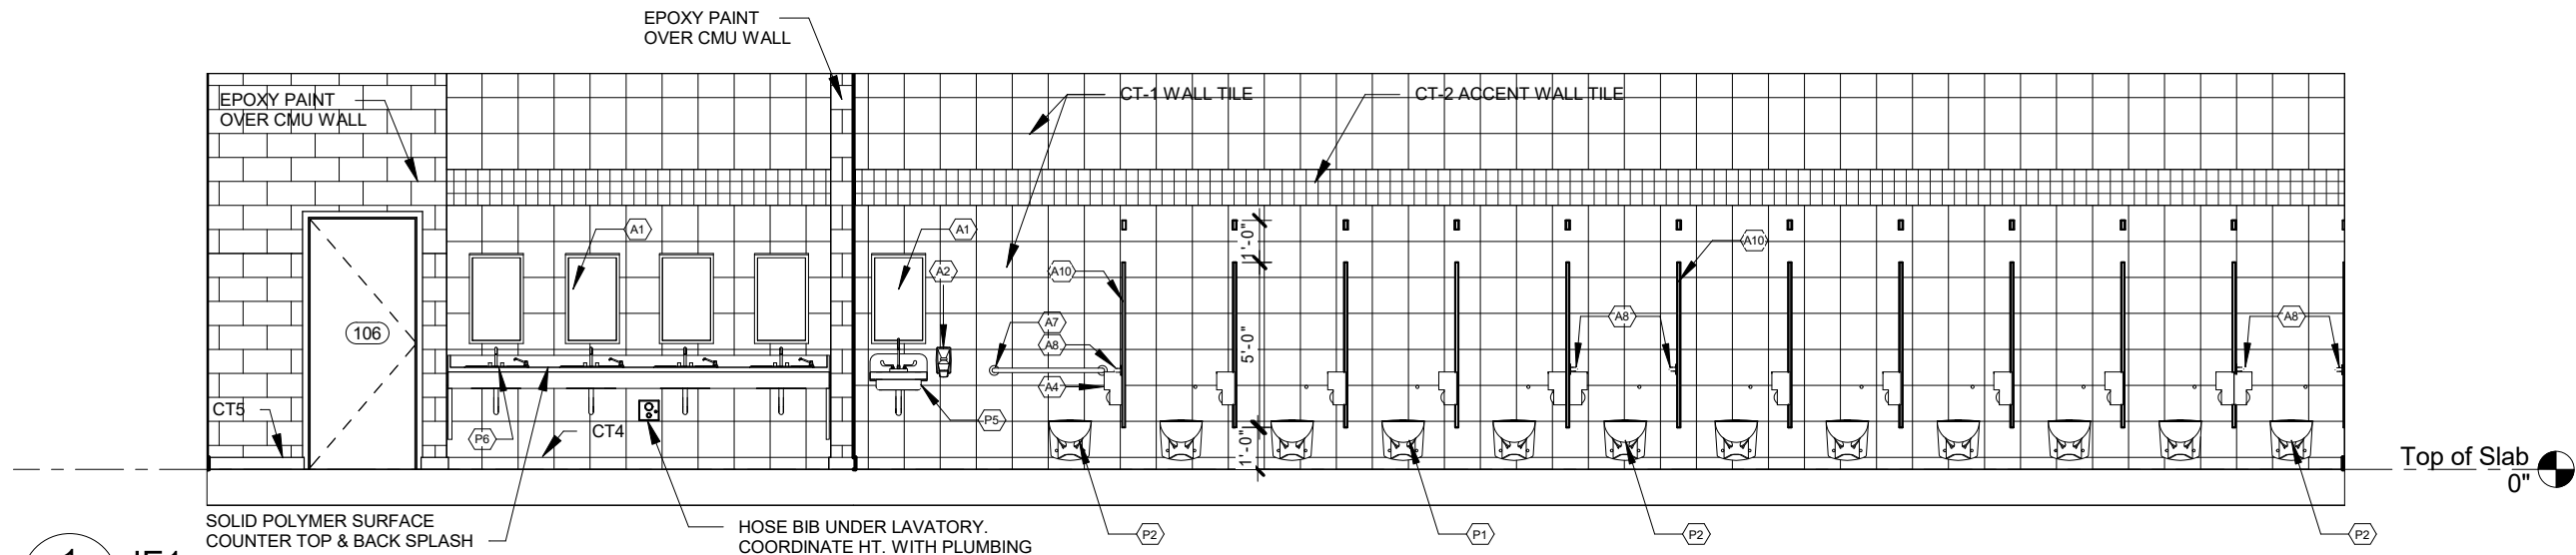


1 IE1
A803 3/16" = 1'-0"

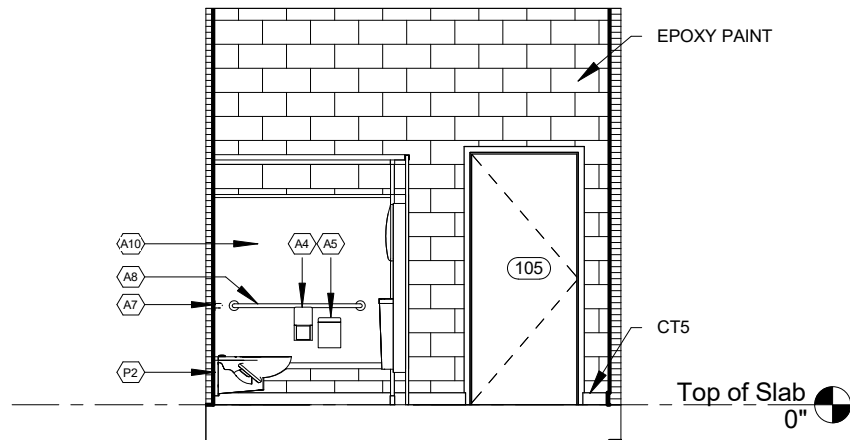

2 IE2
A803 3/16" = 1'-0"

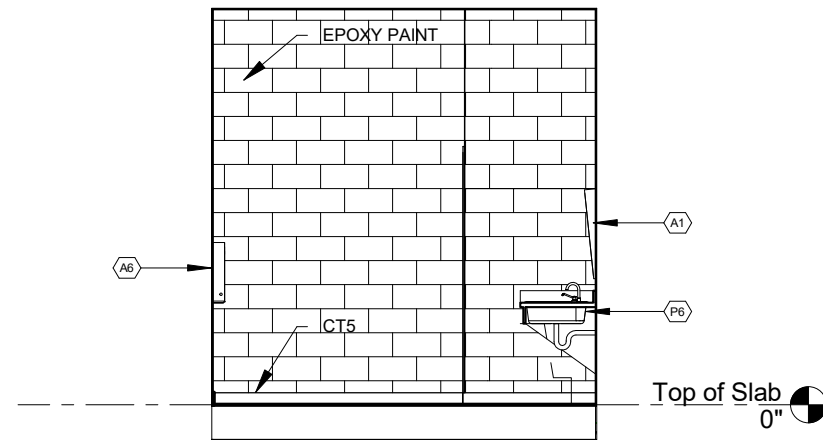

3 IE4
A803 3/16" = 1'-0"

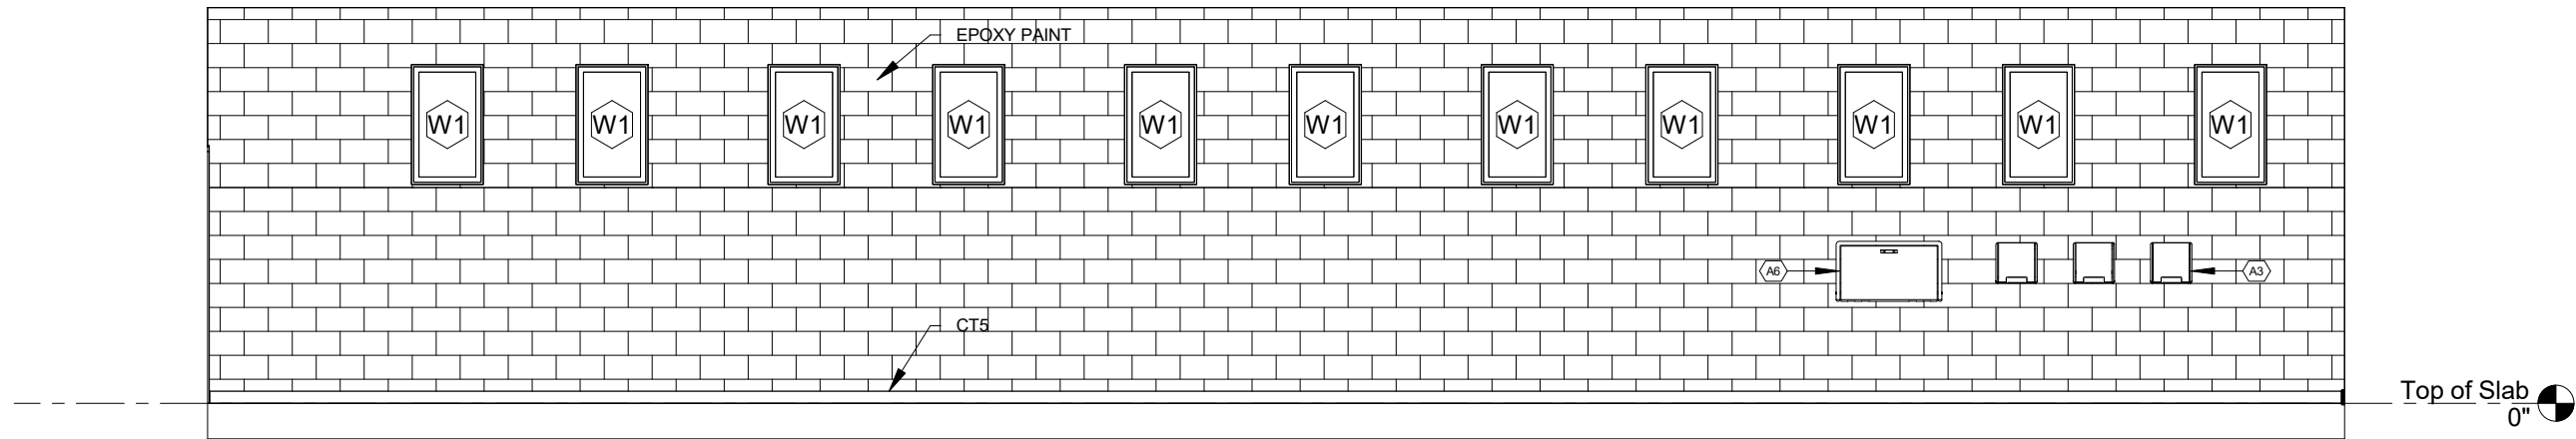

4 IE3
A803 3/16" = 1'-0"

1 PROJECT NORTH PHASE 2 - 90% SUBMITTAL

REVISIONS					
DATE	BY	DESCRIPTION	DATE	BY	DESCRIPTION


BORRELLI + PARTNERS
ARCHITECTURE PLANNING LANDSCAPE INTERIORS
720 Vassar Street, Orlando, FL 32804 407.418.1338 :: fax 407.418.1342
CONFIDENTIAL: THIS DRAWING IS THE PROPERTY OF BORRELLI + PARTNERS. UNLESS OTHERWISE PROVIDED, BY THE CONTRACT, THE CONTENTS OF THIS DRAWING ARE NOT TO BE TRANSMITTED TO ANY OTHER PARTY EXCEPT AS AGREED TO BY THE ARCHITECT. COPYRIGHT BORRELLI + PARTNERS, A/C 000711 / A/C 001842

STATE OF FLORIDA DEPARTMENT OF TRANSPORTATION		
ROAD NO.	COUNTY	FINANCIAL PROJECT ID
SR 8	COLUMBIA	438609-1-52-01


SR 8 (I-10) WESTBOUND - (COLUMBIA COUNTY) REST AREA
INTERIOR ELEVATIONS

DRAWING NO.
A803
SHEET NO.


P:\1-10 Rest Area Improvements (19-049) GA\14 - DrawingsA - Active Drawings\1 - B+P\Local Files\DD LOCAL\1-10 Rest_LOCAL_DD.rvt

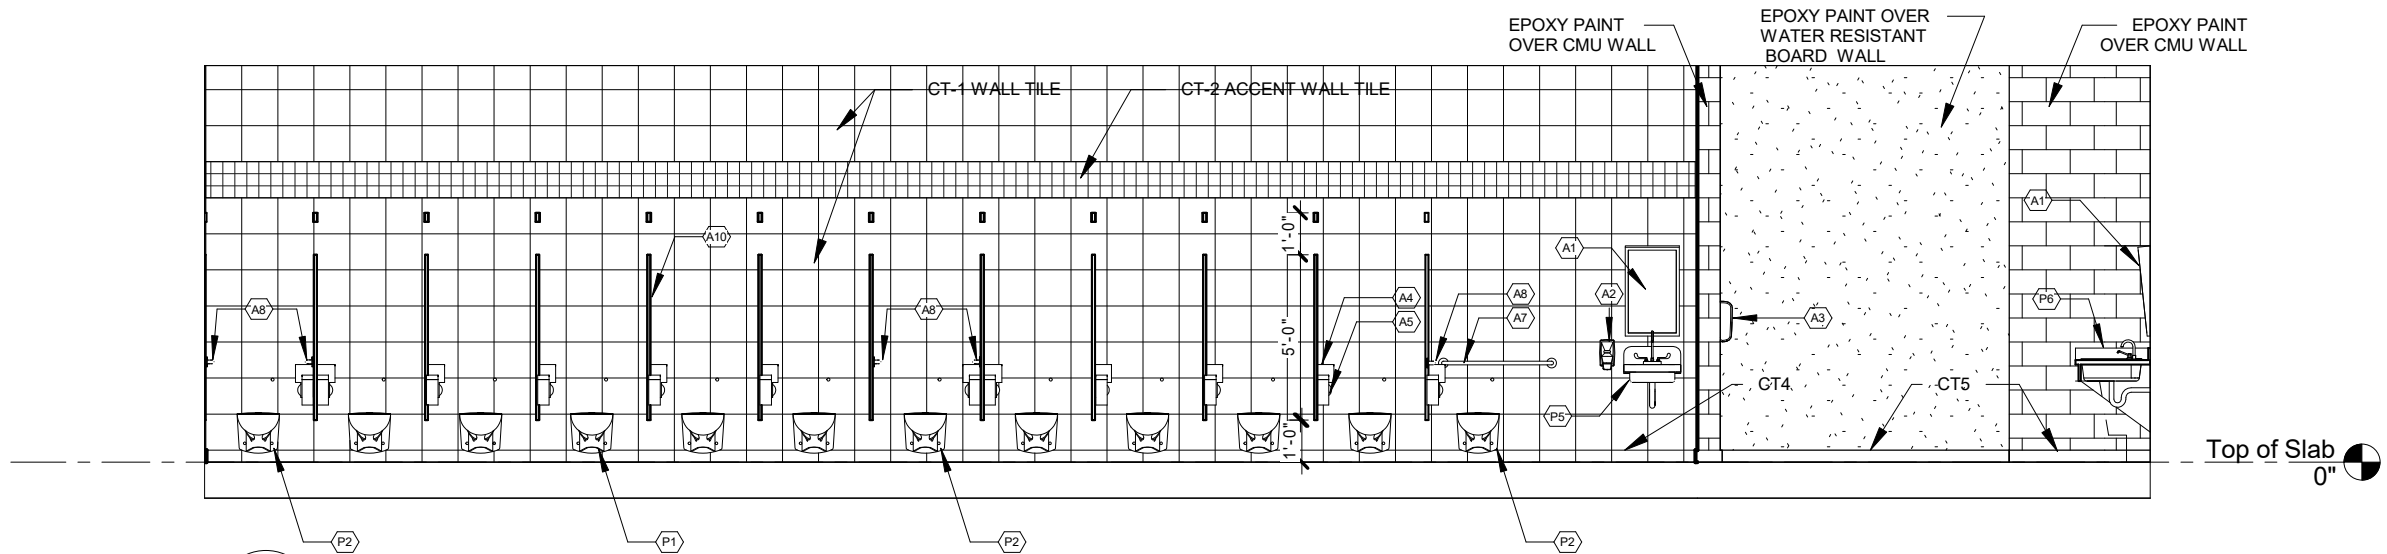


1 IE5
A804 3/16" = 1'-0"

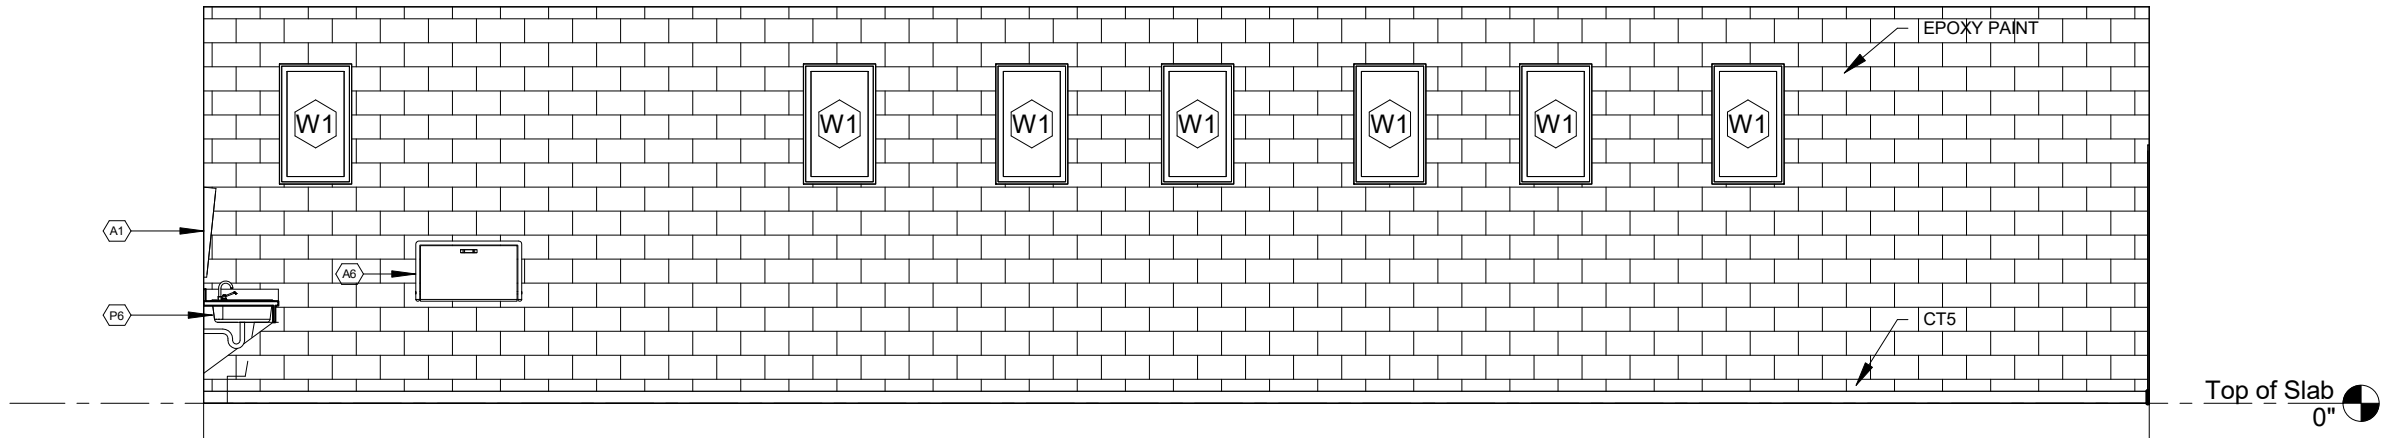

2 IE7
A804 3/16" = 1'-0"

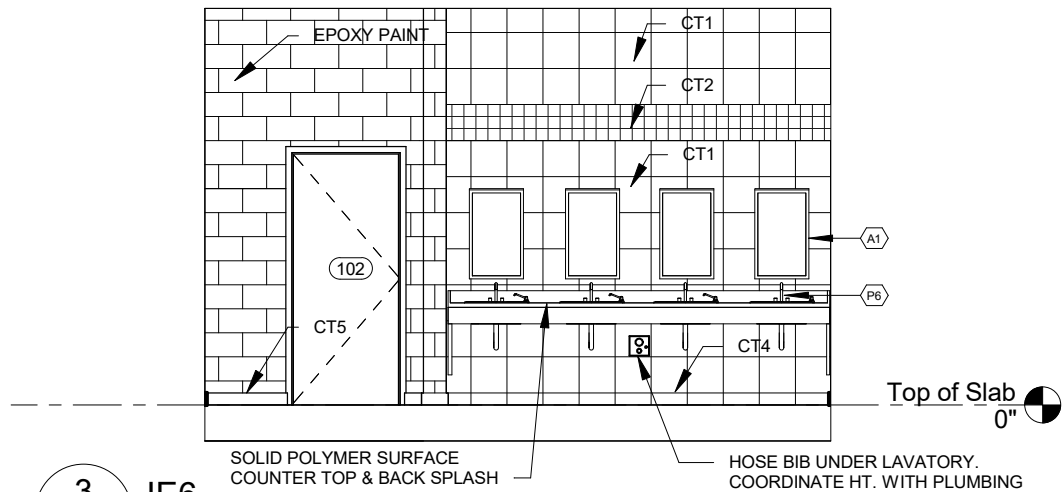

3 IE6
A804 3/16" = 1'-0"

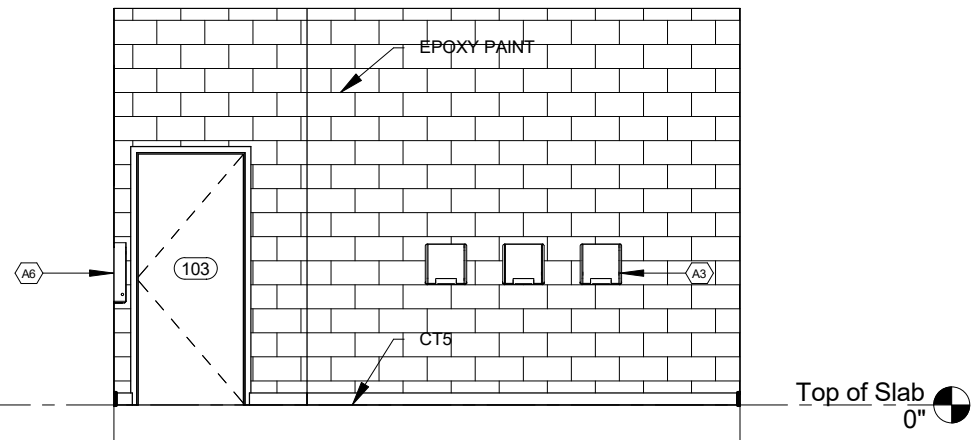

4 IE8
A804 3/16" = 1'-0"


PROJECT NORTH			PHASE 2 - 90% SUBMITTAL	
SR 8 (I-10) WESTBOUND - (COLUMBIA COUNTY) REST AREA			DRAWING NO.	
INTERIOR ELEVATIONS			A804	
			SHEET NO.	

REVISIONS					
DATE	BY	DESCRIPTION	DATE	BY	DESCRIPTION




STATE OF FLORIDA DEPARTMENT OF TRANSPORTATION		
ROAD NO.	COUNTY	FINANCIAL PROJECT ID
SR 8	COLUMBIA	438609-1-52-01


P:\1-10 Rest Area Improvements (19-049) GA\14 - Drawings\A - Active Drawings\1 - B+P\Local Files\DD LOCAL\1-10 Rest_LOCAL_DD.rvt

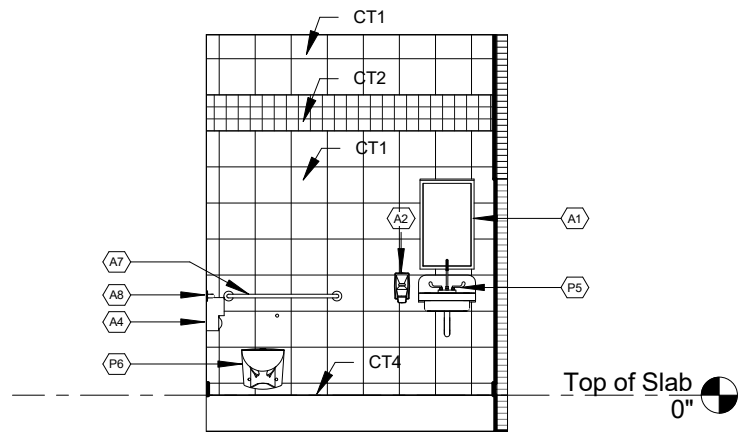


1 IE9
A805 3/16" = 1'-0"

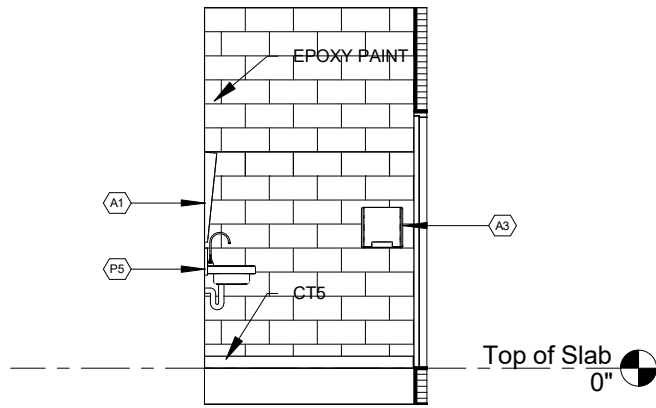


2 IE10
A805 3/16" = 1'-0"

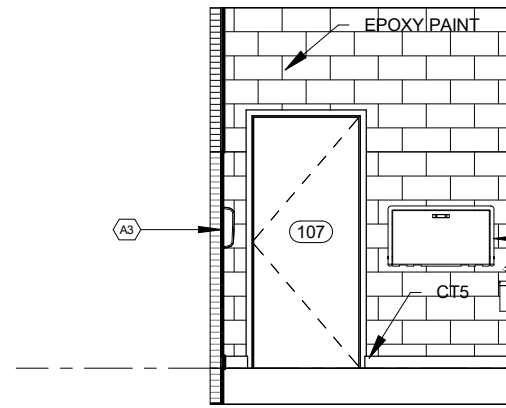


3 IE11
A805 3/16" = 1'-0"

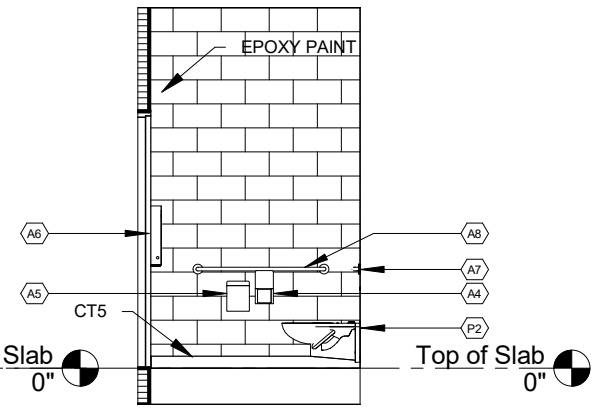


4 IE12
A805 3/16" = 1'-0"

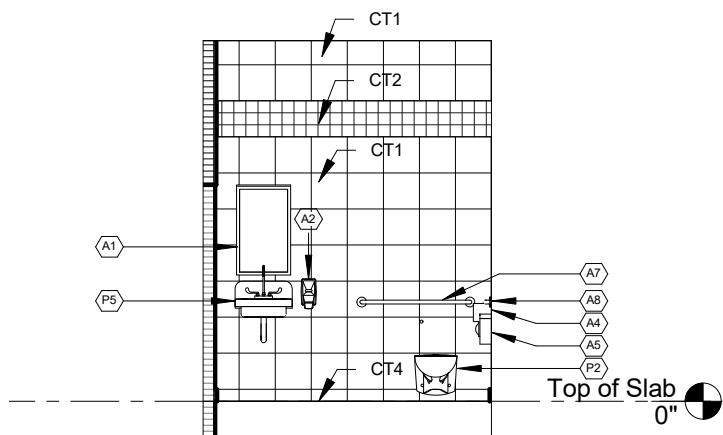


5 IE13
A805 3/16" = 1'-0"

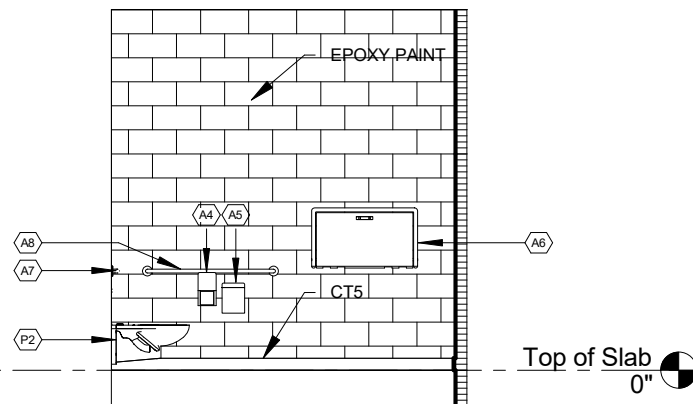

6 IE14
A805 3/16" = 1'-0"

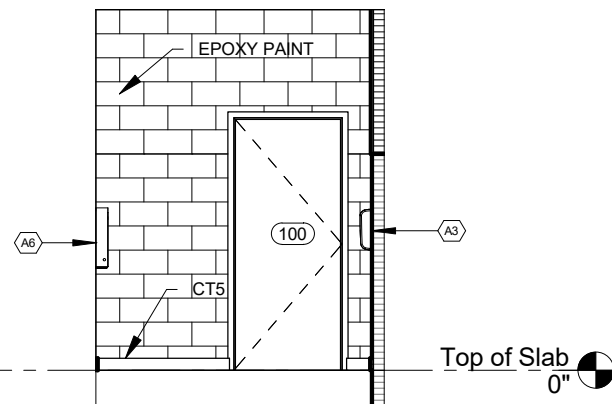

7 IE15
A805 3/16" = 1'-0"

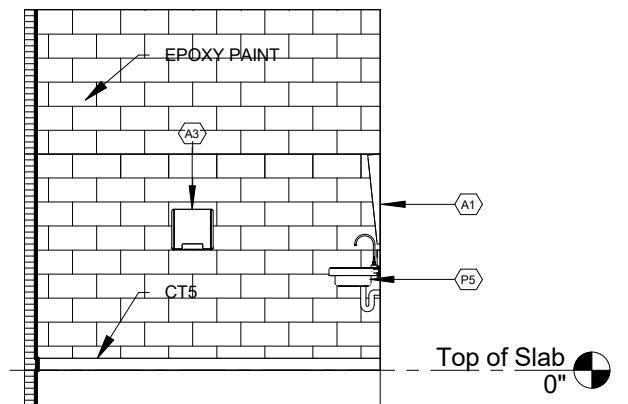

8 IE16
A805 3/16" = 1'-0"

PROJECT NORTH			PHASE 2 - 90% SUBMITTAL	
SR 8 (I-10) WESTBOUND - (COLUMBIA COUNTY) REST AREA			DRAWING NO.	
INTERIOR ELEVATIONS			A805	
			SHEET NO.	


REVISIONS					
DATE	BY	DESCRIPTION	DATE	BY	DESCRIPTION




BORRELLI + PARTNERS
ARCHITECTURE PLANNING LANDSCAPE INTERIORS
720 Vassar Street, Orlando, FL 32804 407.418.1338 :: fax 407.418.1342
CONFIDENTIAL: THIS DRAWING IS THE PROPERTY OF BORRELLI + PARTNERS. UNLESS OTHERWISE PROVIDED, BY THE CONTRACT, THE CONTENTS OF THIS DRAWING ARE NOT TO BE TRANSMITTED TO ANY OTHER PARTY EXCEPT AS AGREED TO BY THE ARCHITECT. COPYRIGHT BORRELLI + PARTNERS, A/C 000711 / ACC 001842

STATE OF FLORIDA DEPARTMENT OF TRANSPORTATION		
ROAD NO.	COUNTY	FINANCIAL PROJECT ID
SR 8	COLUMBIA	438609-1-52-01


P:\1-10 Rest Area Improvements (19-049) GAI\4 - Drawings\A - Active Drawings\1 - B+P\Local Files\DD LOCAL\1-10 Rest_LOCAL_DD.rvt

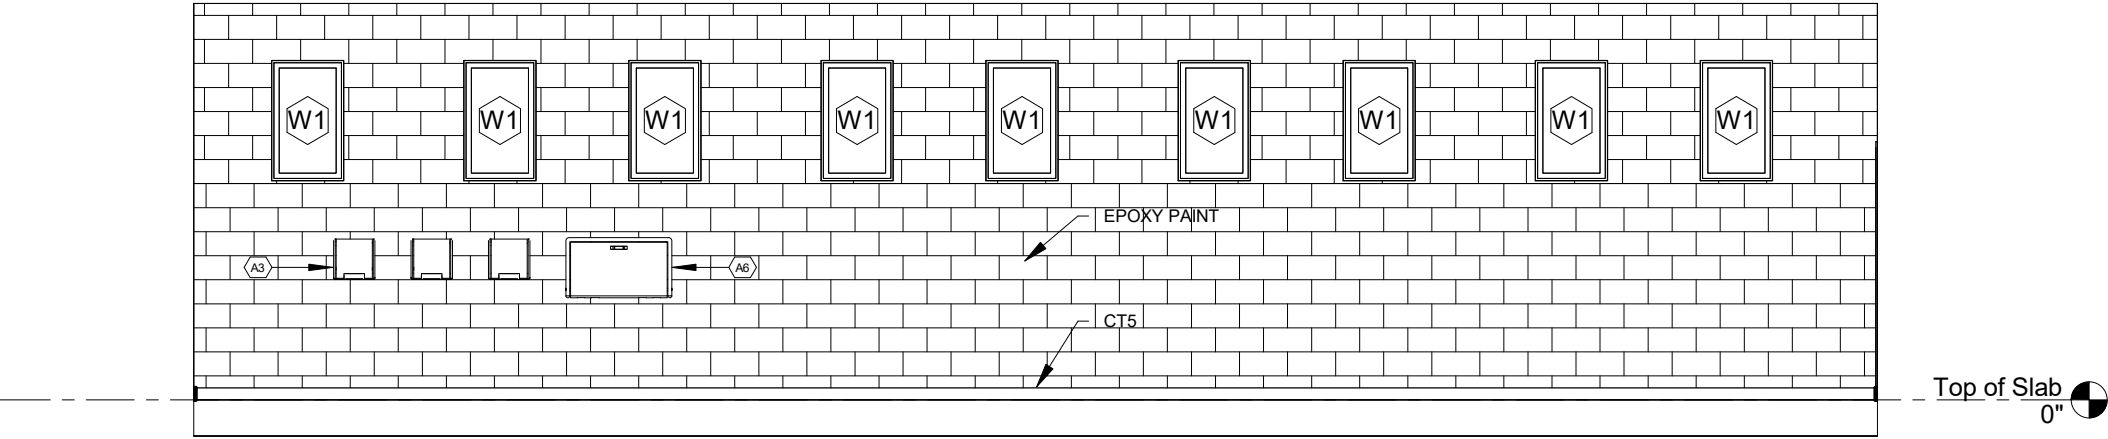


1 IE17
A806 3/16" = 1'-0"

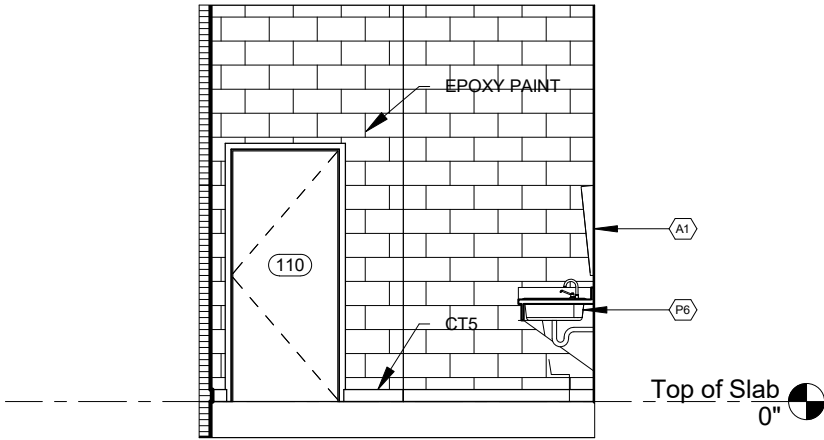

2 IE18
A806 3/16" = 1'-0"

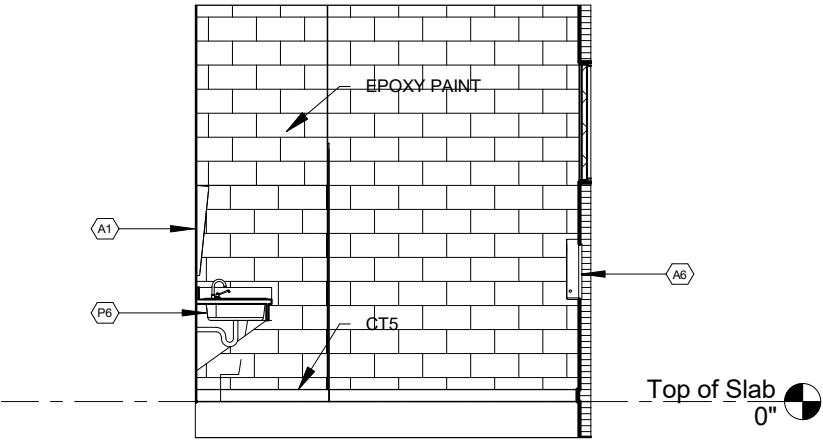

3 IE20
A806 3/16" = 1'-0"

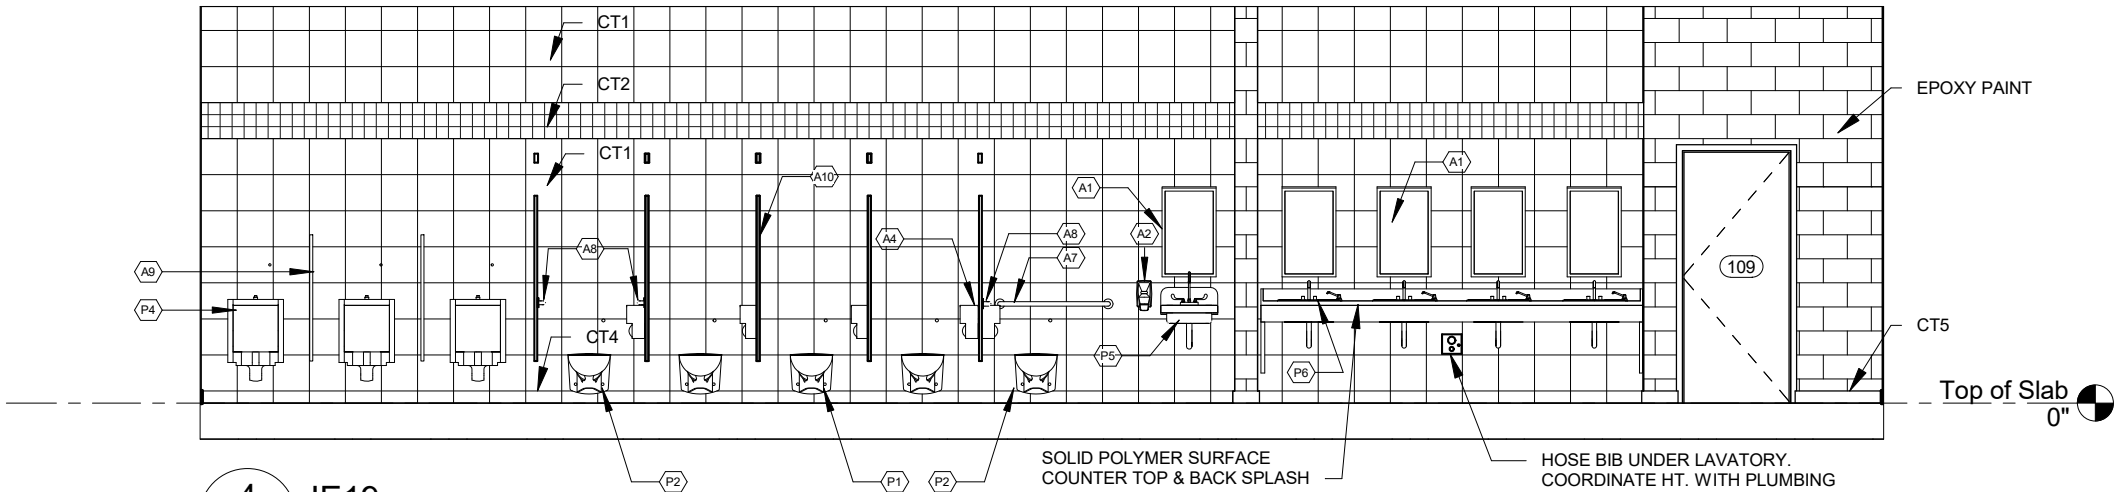

4 IE19
A806 3/16" = 1'-0"

1 PROJECT NORTH

PHASE 2 - 90% SUBMITTAL

REVISIONS					
DATE	BY	DESCRIPTION	DATE	BY	DESCRIPTION




STATE OF FLORIDA DEPARTMENT OF TRANSPORTATION		
ROAD NO.	COUNTY	FINANCIAL PROJECT ID
SR 8	COLUMBIA	438609-1-52-01


SR 8 (I-10) WESTBOUND - (COLUMBIA COUNTY) REST AREA	
INTERIOR ELEVATIONS	

DRAWING NO.
A806
SHEET NO.


P:\1-10 Rest Area Improvements (19-049) GAI\4 - Drawings\A - Active Drawings\1 - B+P\Local Files\DD LOCAL\1-10 Rest_LOCAL_DD.rvt

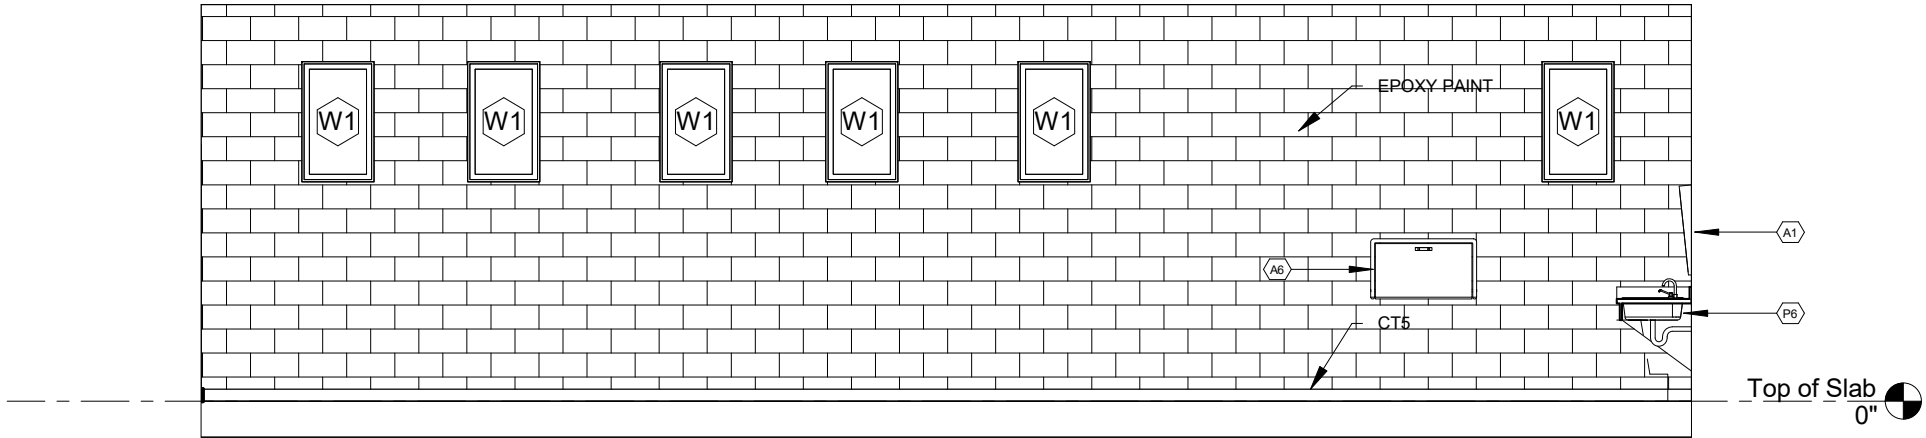


1 IE21
A807 3/16" = 1'-0"

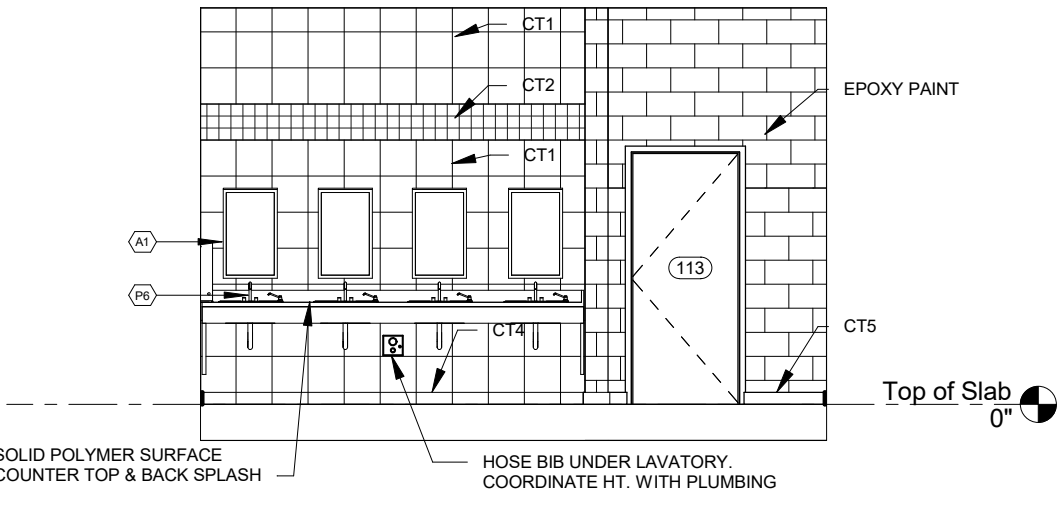

2 IE22
A807 3/16" = 1'-0"

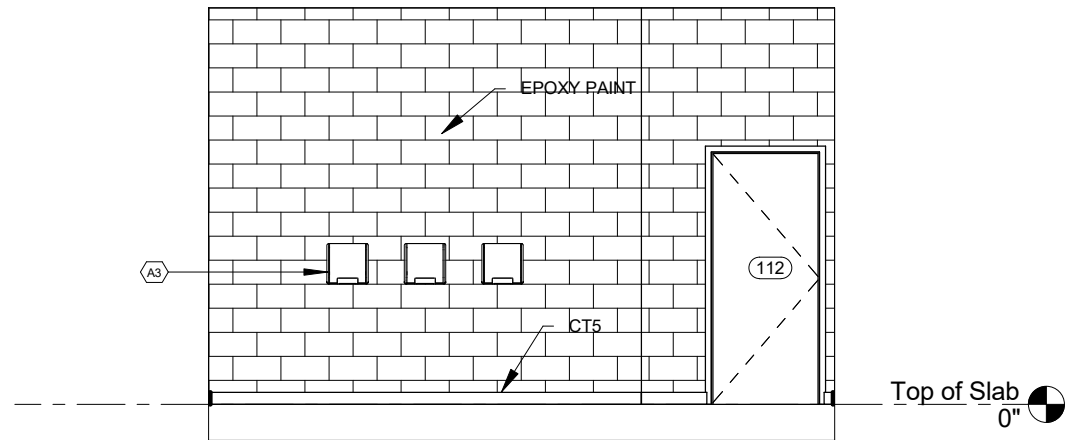

3 IE24
A807 3/16" = 1'-0"

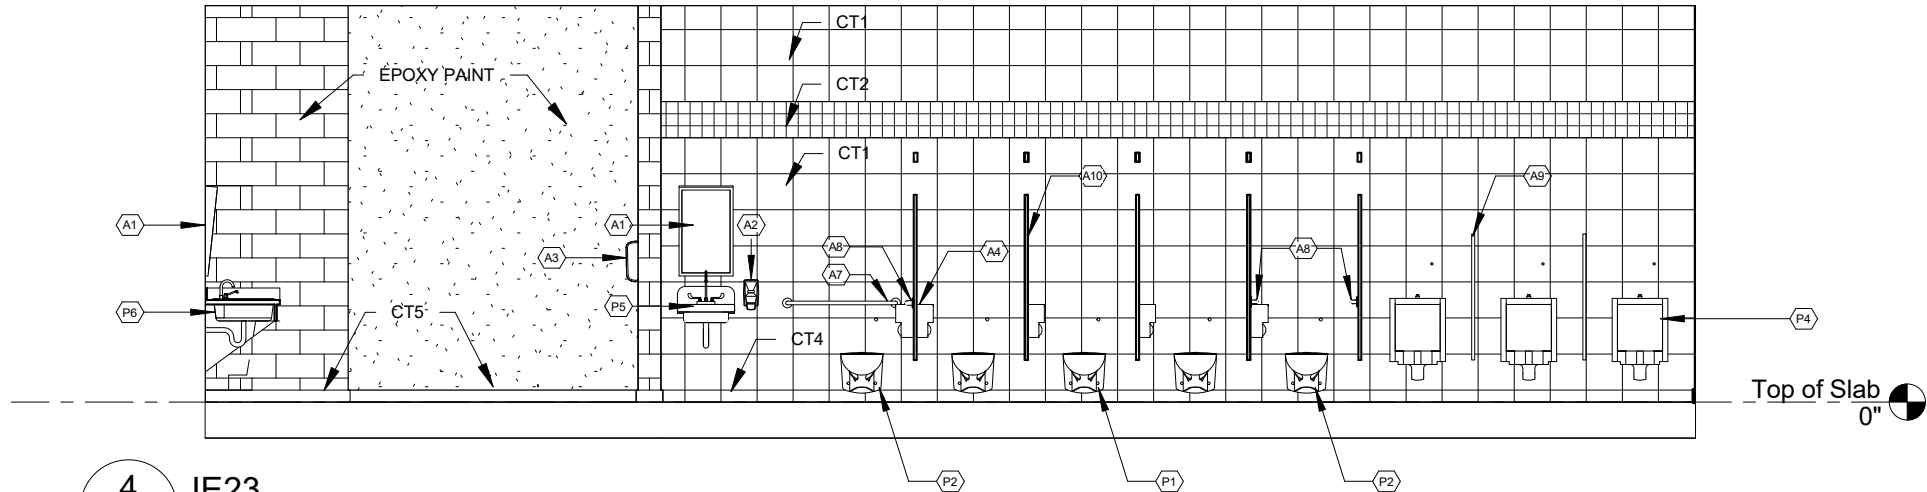

4 IE23
A807 3/16" = 1'-0"


1 PROJECT NORTH PHASE 2 - 90% SUBMITTAL

REVISIONS					
DATE	BY	DESCRIPTION	DATE	BY	DESCRIPTION



STATE OF FLORIDA DEPARTMENT OF TRANSPORTATION		
ROAD NO.	COUNTY	FINANCIAL PROJECT ID
SR 8	COLUMBIA	438609-1-52-01

SR 8 (I-10) WESTBOUND - (COLUMBIA COUNTY) REST AREA	DRAWING NO.
INTERIOR ELEVATIONS	A807
	SHEET NO.

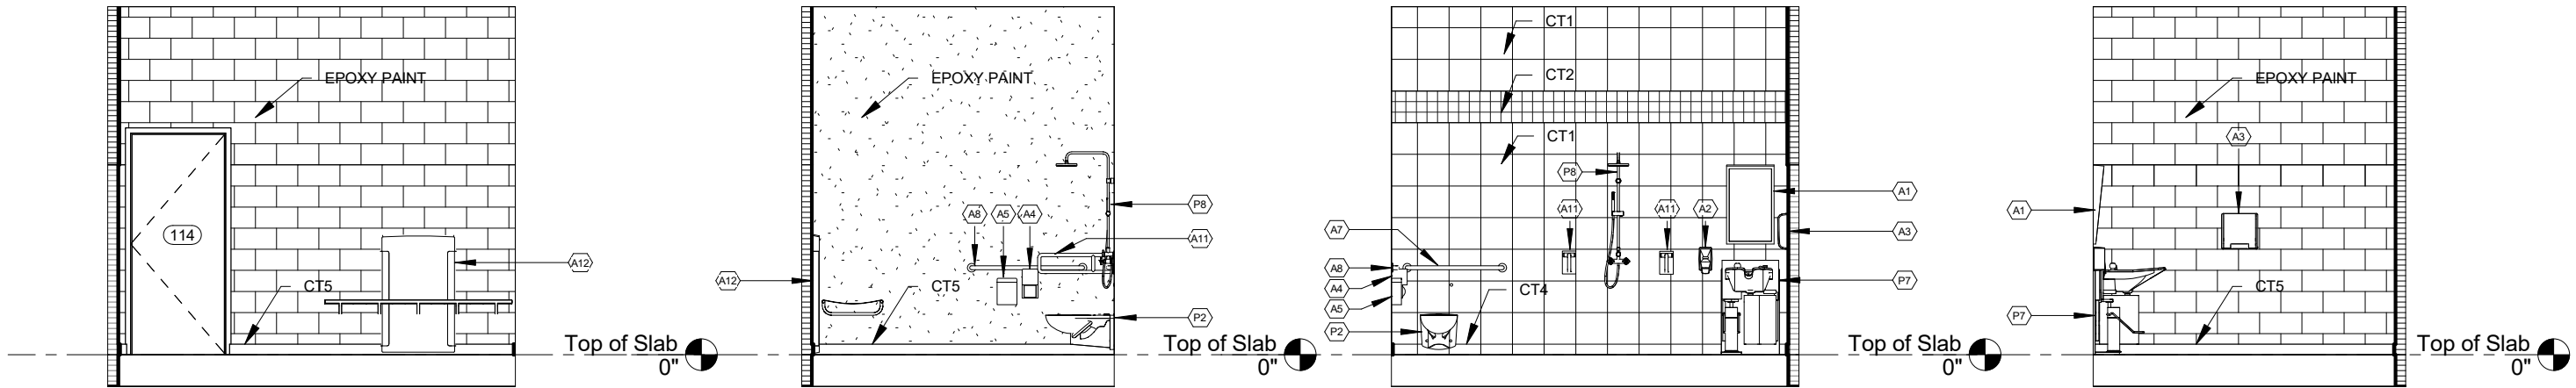


$$\frac{1}{A808} \text{ IE25 } \frac{3}{16}'' = 1'-0''$$

$$\frac{2}{A808} \text{ IE26 } \frac{3}{16}'' = 1'-0''$$

$$\frac{3}{A808} \quad \text{IE27} \quad \frac{3}{16}'' = 1'-0''$$

$$\frac{4}{A808} \text{ IE28} \\ 3/16" = 1'-0"$$

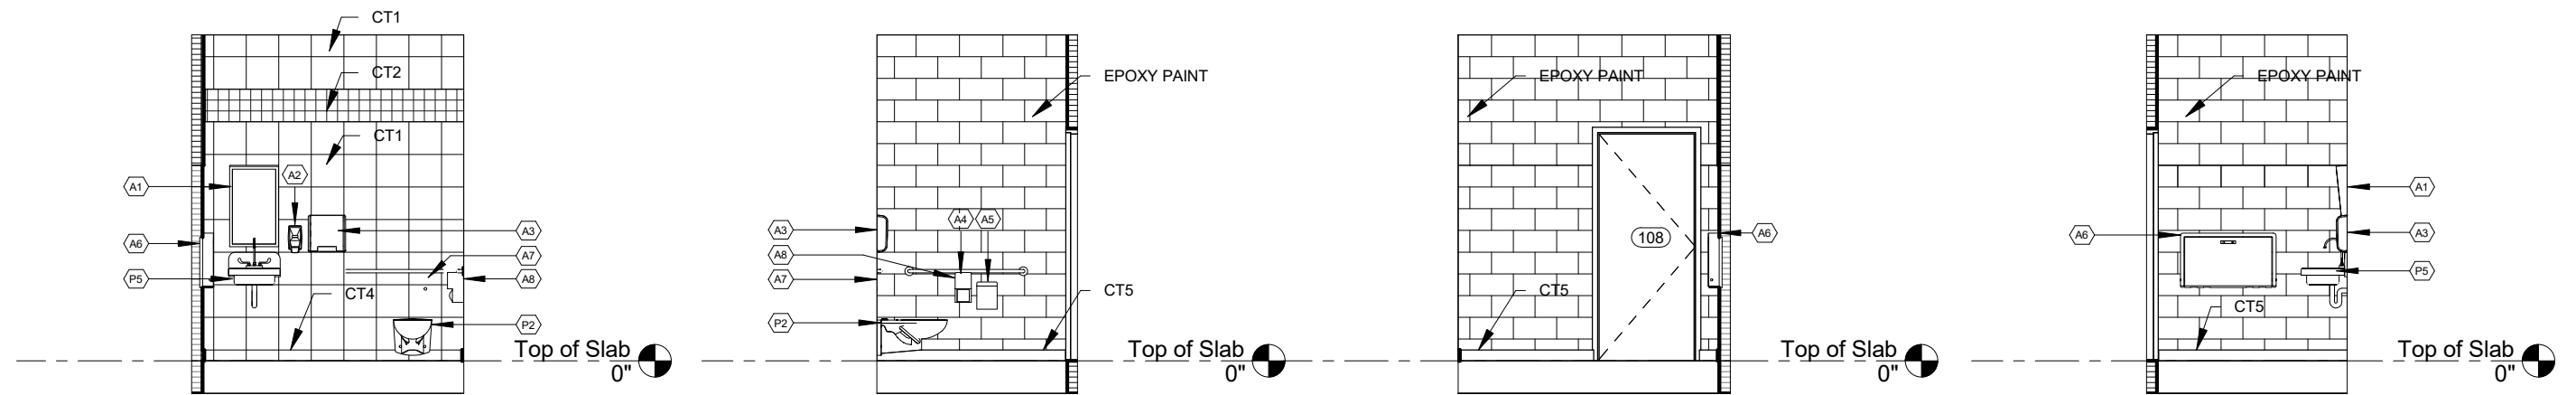

$$\frac{5}{A808} \quad \begin{array}{l} \text{IE29} \\ 3/16" = 1'-0" \end{array}$$


6 IE30
A808 $3/16" = 1'-0"$

7 IE31
A808 $3/16" = 1'-0"$


$$\frac{8}{A808} \quad \begin{array}{l} \text{IE32} \\ 3/16" = 1'-0" \end{array}$$

						🕒 PROJECT NORTH			PHASE 2 - 90% SUBMITTAL												
REVISIONS						BORRELLI + PARTNERS ARCHITECTURE PLANNING LANDSCAPE INTERIORS AAC 000711 720 Vassar Street, Orlando FL 32804 407.418.1338 :: fax 407.418.1342 CONFIDENTIAL THIS DRAWING IS THE PROPERTY OF BORRELLI + PARTNERS UNLESS OTHERWISE PROVIDED BY THE CONTRACT. THE CONTENTS OF THIS DRAWING ARE NOT TO BE TRANSMITTED TO ANY OTHER PARTY EXCEPT AS AGREED TO BY THE ARCHITECT. COPYRIGHT BORRELLI + PARTNERS. AAC 000711 / ACC 001842			STATE OF FLORIDA DEPARTMENT OF TRANSPORTATION			SR 8 (I-10) WESTBOUND - (COLUMBIA COUNTY) REST AREA			DRAWING NO. A808						
DATE	BY	DESCRIPTION			DATE				BY	DESCRIPTION			ROAD NO.			COUNTY	FINANCIAL PROJECT ID	INTERIOR ELEVATIONS			SHEET NO.
													SR 8			COLUMBIA	438609-1-52-01				


P:\1-10 Rest Area Improvements (19-049) GAI\4 - Drawings\A - Active Drawings\1 - B+P\Local Files\DD LOCAL\1-10 Rest_LOCAL_DD.rvt

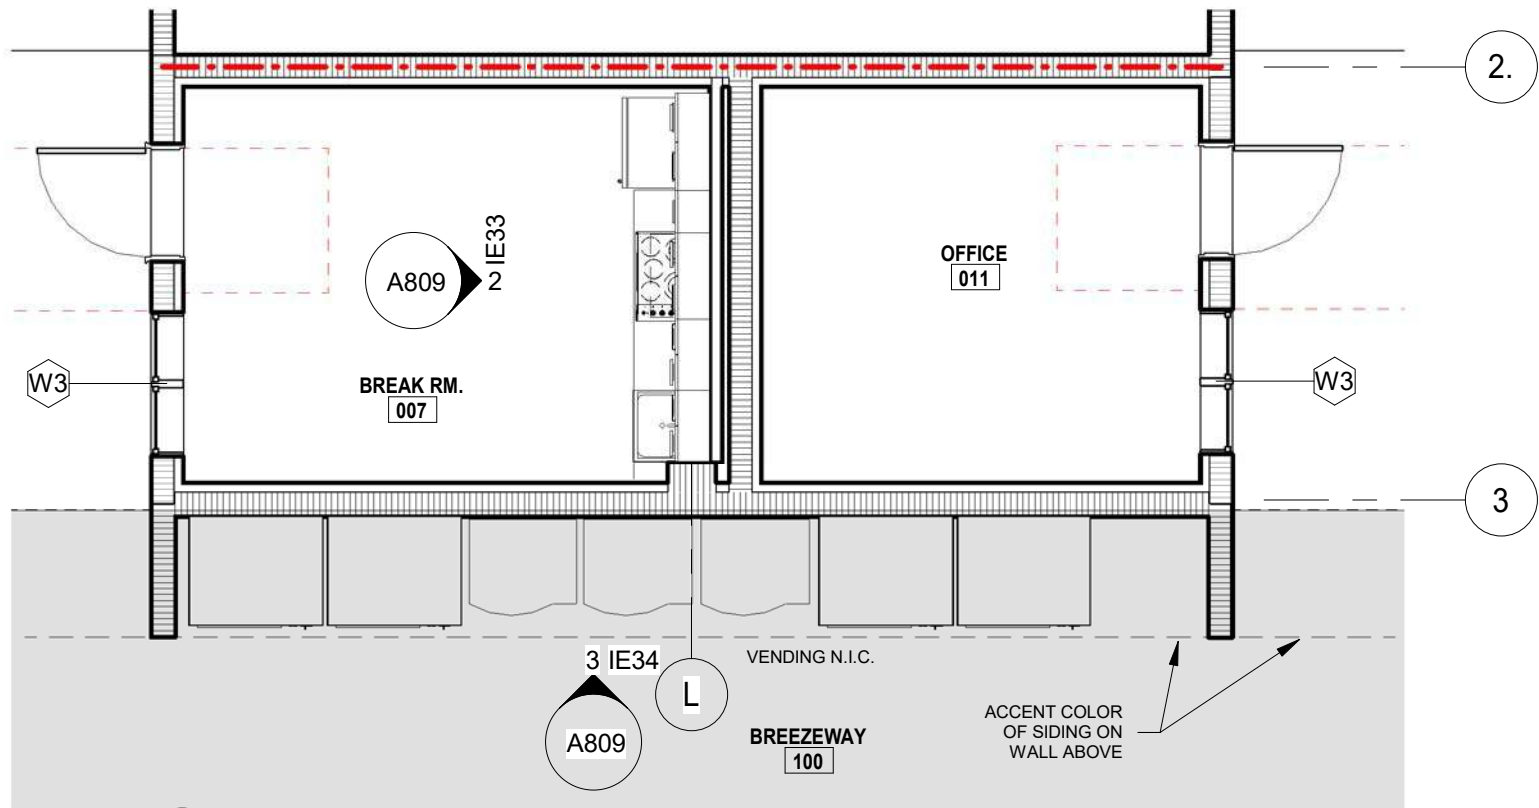

1
A809
BREAK ROOM ENLARGEMENT
3/16" = 1'-0"

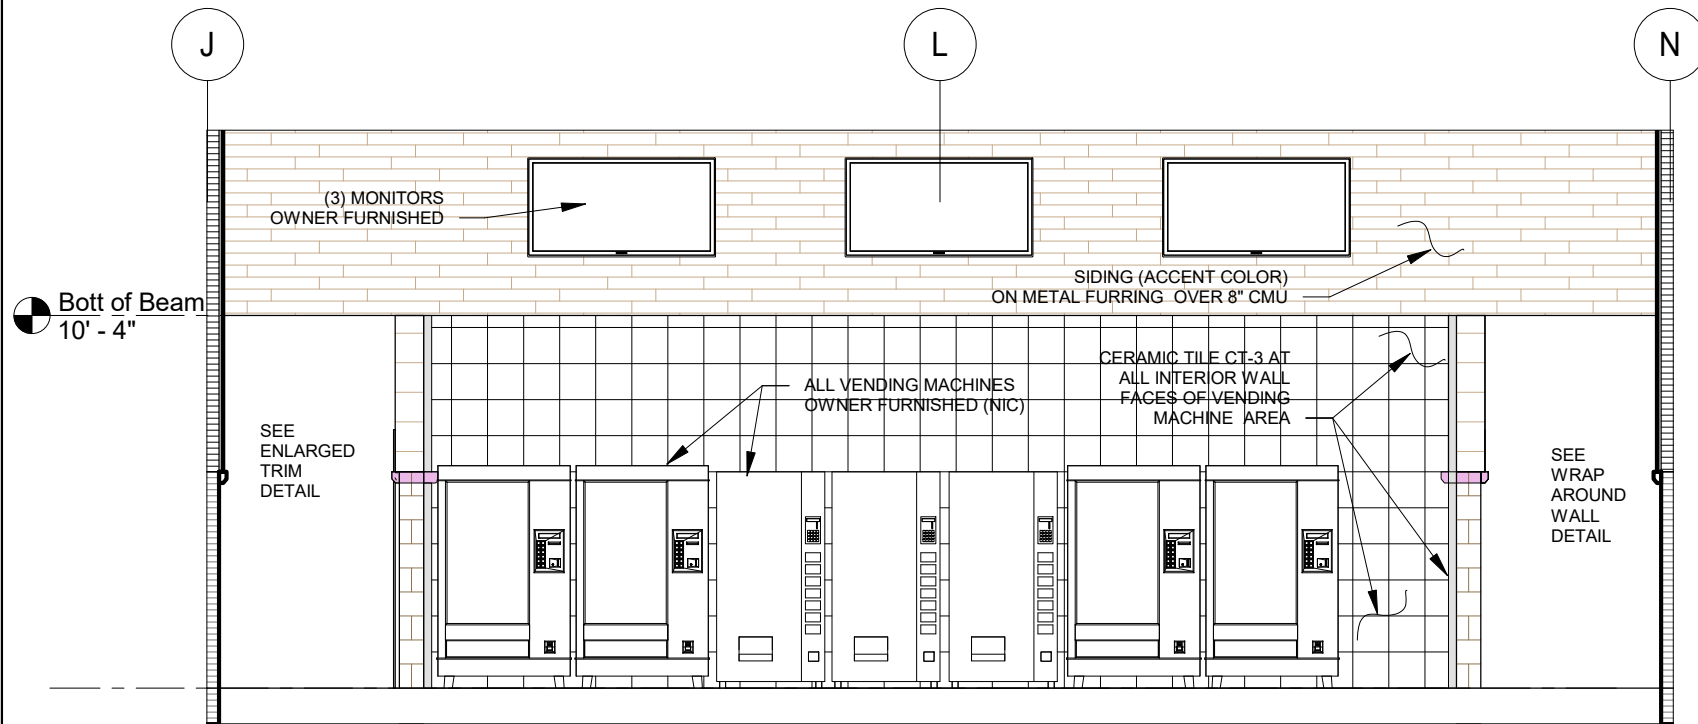

3
A809
IE34
3/16" = 1'-0"

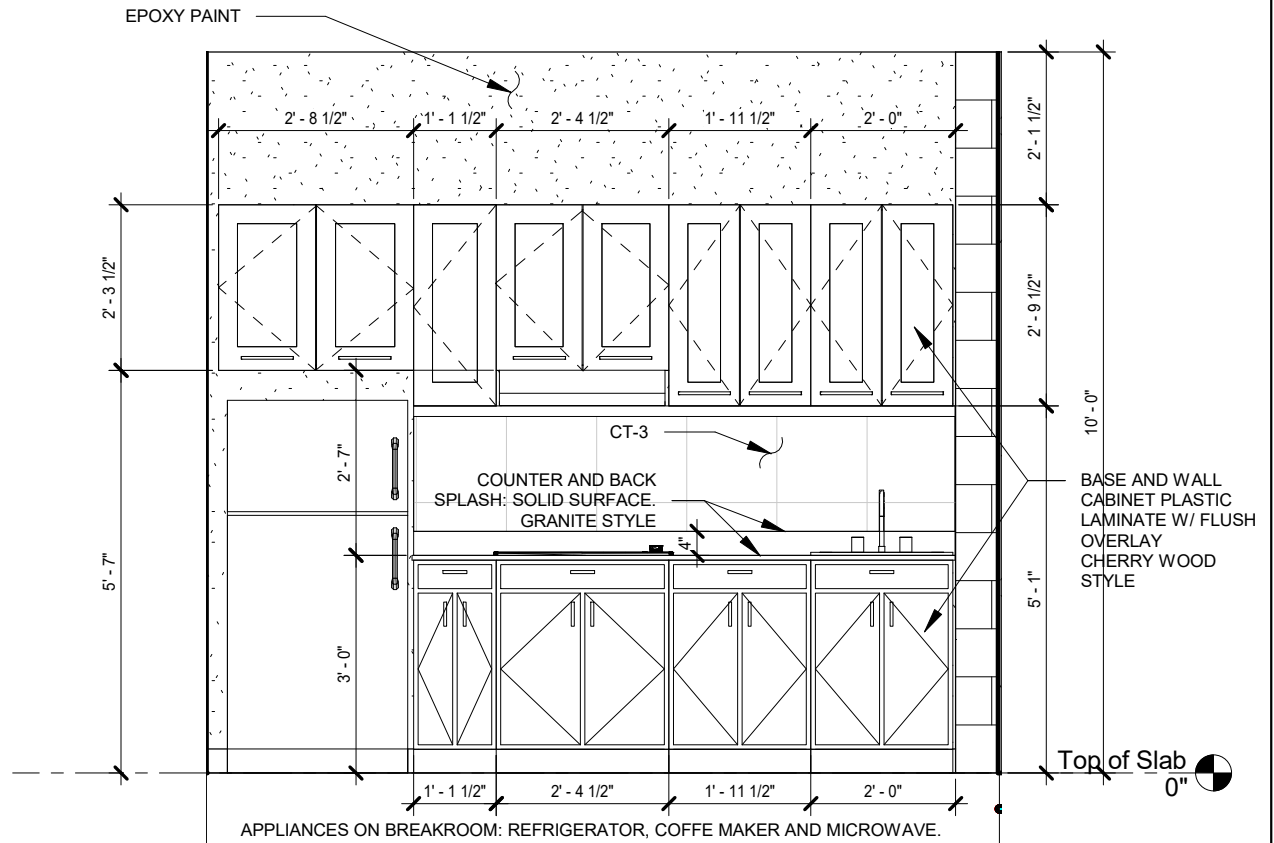

2
A809
IE33
3/8" = 1'-0"

1 PROJECT NORTH PHASE 2 - 90% SUBMITTAL


REVISIONS					
DATE	BY	DESCRIPTION	DATE	BY	DESCRIPTION




STATE OF FLORIDA DEPARTMENT OF TRANSPORTATION		
ROAD NO.	COUNTY	FINANCIAL PROJECT ID
SR 8	COLUMBIA	438609-1-52-01

SR 8 (I-10) WESTBOUND - (COLUMBIA COUNTY) REST AREA		DRAWING NO.
INTERIOR ELEVATIONS		A809
		SHEET NO.


P:\1-10 Rest Area Improvements (19-049) GA\14 - Drawings\A - Active Drawings\1 - B+P\Local Files\DD LOCAL\1-10 Rest_LOCAL_DD.rvt

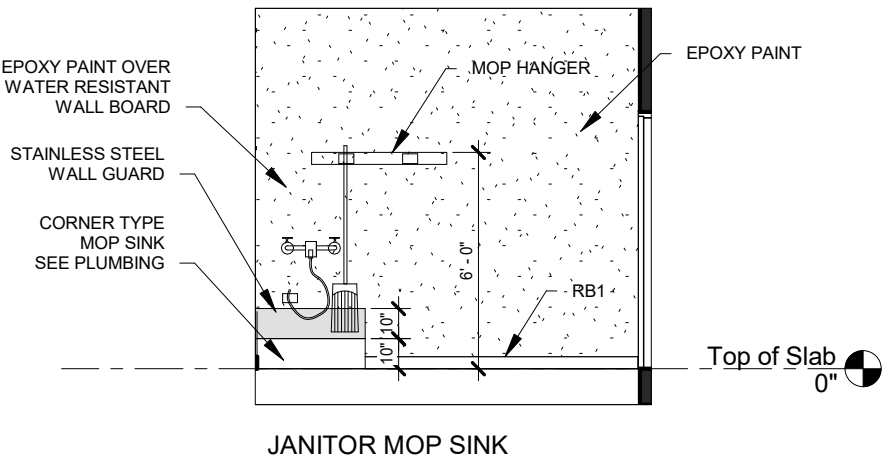


1 IE35
A810 3/16" = 1'-0"

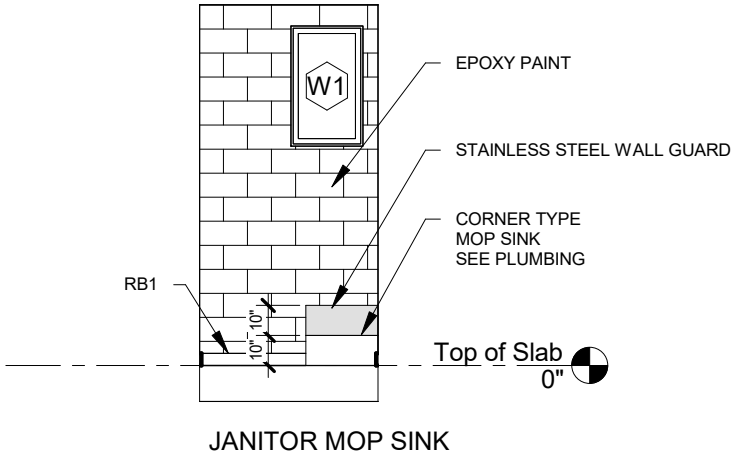

2 IE36
A810 3/16" = 1'-0"

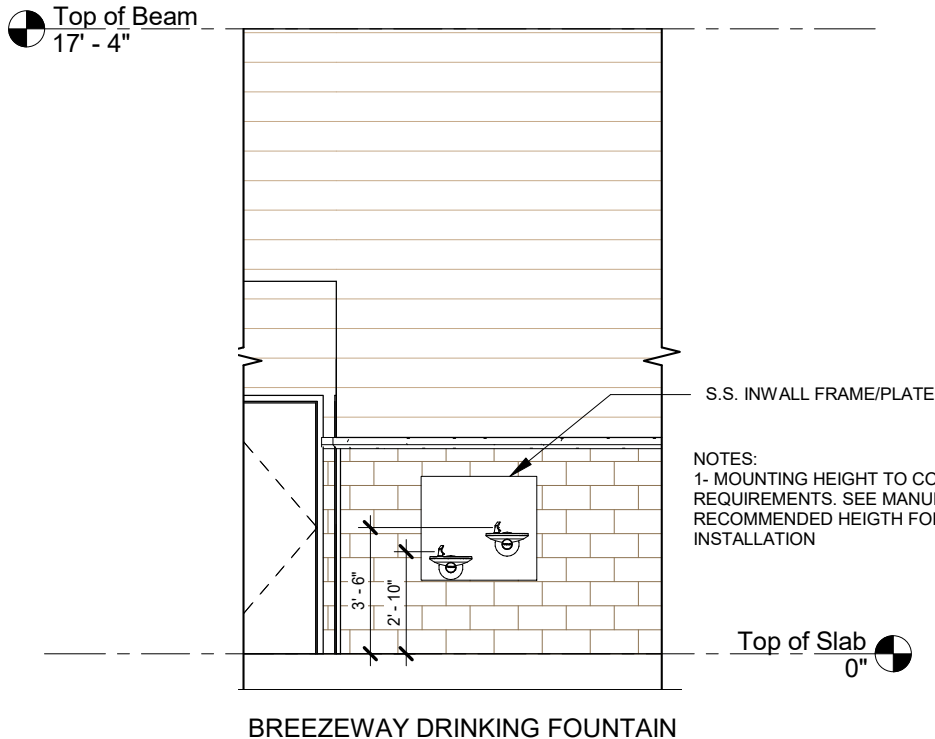

3 IE37
A810 3/16" = 1'-0"

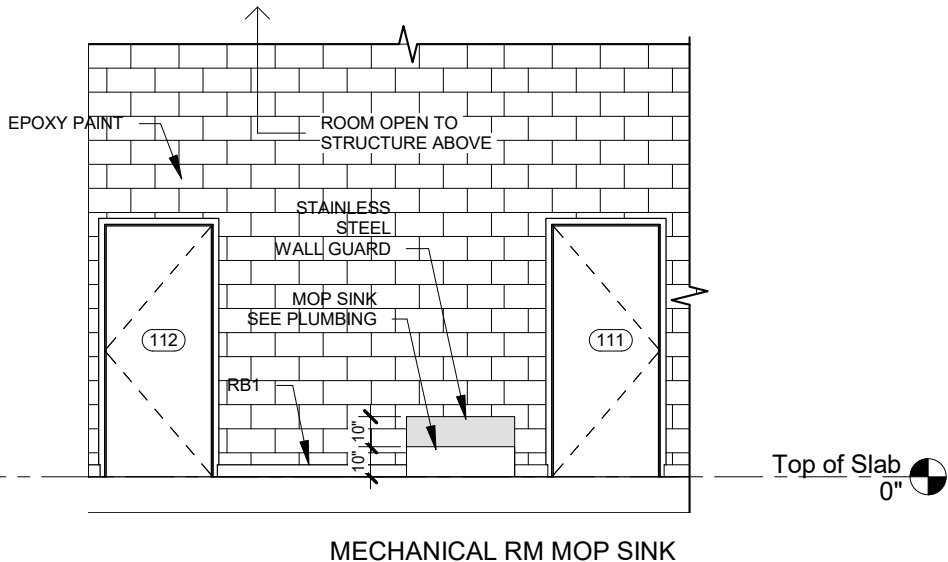

4 IE38
A810 3/16" = 1'-0"


1 PROJECT NORTH PHASE 2 - 90% SUBMITTAL

REVISIONS						 BORRELLI + PARTNERS ARCHITECTURE PLANNING LANDSCAPE INTERIORS 720 Vassar Street, Orlando FL 32804 407.418.1338 :: fax 407.418.1342 CONFIDENTIAL: THIS DRAWING IS THE PROPERTY OF BORRELLI + PARTNERS. UNLESS OTHERWISE PROVIDED, BY THE CONTRACT, THE CONTENTS OF THIS DRAWING ARE NOT TO BE TRANSMITTED TO ANY OTHER PARTY EXCEPT AS AGREED TO BY THE ARCHITECT. COPYRIGHT BORRELLI + PARTNERS, A/C 000711 / A/C 001842	STATE OF FLORIDA DEPARTMENT OF TRANSPORTATION			SR 8 (I-10) WESTBOUND - (COLUMBIA COUNTY) REST AREA	DRAWING NO.
DATE	BY	DESCRIPTION	DATE	BY	DESCRIPTION		ROAD NO.	COUNTY	FINANCIAL PROJECT ID		A810
							SR 8	COLUMBIA	438609-1-52-01		
INTERIOR ELEVATIONS										SHEET NO.	

FINISH LEGEND

- CONCRETE
- EPOXY COATING (FF2)
- EPOXY COATING (FF4)
- EPOXY TEXTURED (FF3)
- SEAL. CONC (FF1)
- VCT-1

..... SIDING ACCENT COLOR ABOVE

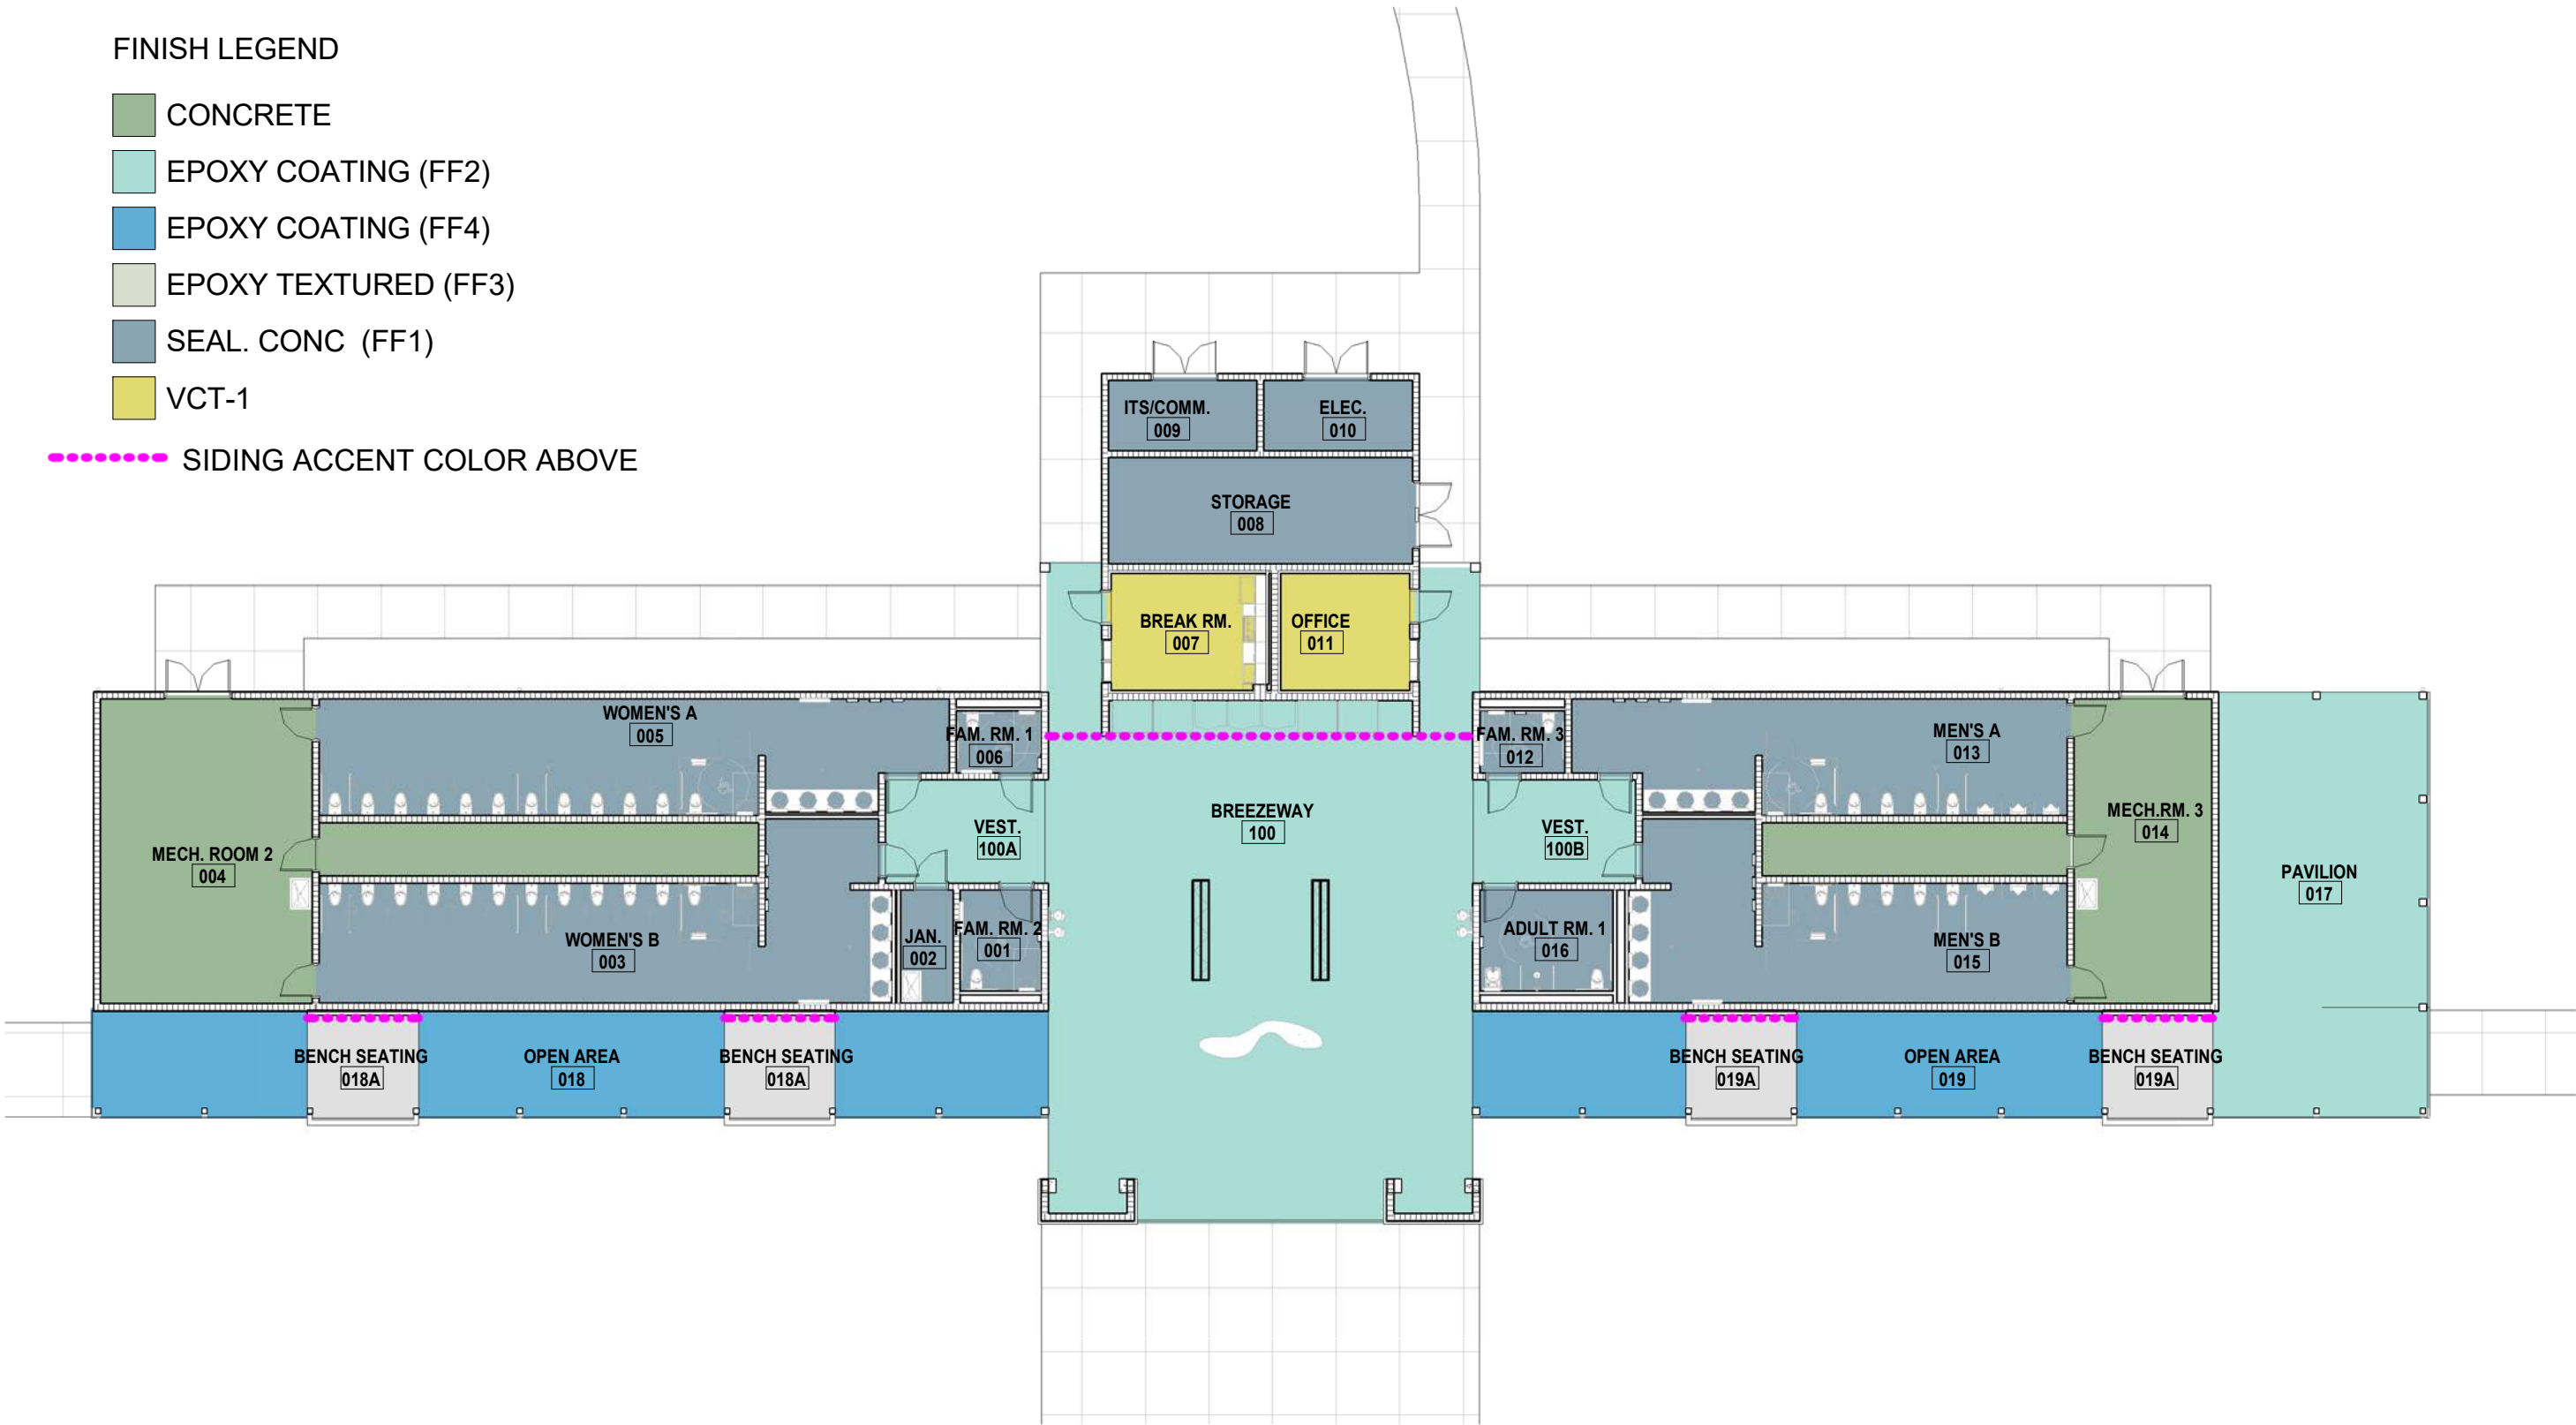

1 FINISH FLOOR PLAN
A811 1/16" = 1'-0"

PROJECT NORTH PHASE 2 - 90% SUBMITTAL

REVISIONS						STATE OF FLORIDA DEPARTMENT OF TRANSPORTATION			SR 8 (I-10) WESTBOUND - (COLUMBIA COUNTY) REST AREA	FINISH PLAN	DRAWING NO.	
DATE	BY	DESCRIPTION	DATE	BY	DESCRIPTION	ROAD NO.	COUNTY	FINANCIAL PROJECT ID			A811	
						SR 8	COLUMBIA	438609-1-52-01			SHEET NO.	



BORRELLI + PARTNERS
ARCHITECTURE PLANNING LANDSCAPE INTERIORS
720 Vassar Street, Orlando, FL 32804 407.418.1338 :: fax 407.418.1342
CONFIDENTIAL: THIS DRAWING IS THE PROPERTY OF BORRELLI + PARTNERS. UNLESS OTHERWISE PROVIDED, BY THE CONTRACT, THE CONTENTS OF THIS DRAWING ARE NOT TO BE TRANSMITTED TO ANY OTHER PARTY EXCEPT AS AGREED TO BY THE ARCHITECT. COPYRIGHT BORRELLI + PARTNERS, A/C 000711 / ACC 001842

P:\1-10 Rest Area Improvements (19-049) GA\14 - DrawingsA - Active Drawings\1 - B+P\Local Files\DD LOCAL\1-10 Rest_LOCAL_DD.rvt

ROOM FINISH SCHEDULE									
Rm. No.	Name	Floor Finish	Base Finish	WALLS				CEILING	Comments
				South	West	North	East	Finish	
001	FAM. RM. 2	SEAL. CONC (FF1)	CT4,CT5	CT1, CT2	EPOXY PAINT	EPOXY PAINT	EPOXY PAINT	SEMI-GLOSS LATEX PAINT	
002	JAN.	SEAL. CONC (FF1)	RB1	EPOXY PAINT	EPOXY PAINT	EPOXY PAINT	EPOXY PAINT	SEMI-GLOSS LATEX PAINT	
003	WOMEN'S B	SEAL. CONC (FF1)	CT4,CT5	EPOXY PAINT	EPOXY PAINT	CT1, CT2	CT1, CT2	SEMI-GLOSS LATEX PAINT	
004	MECH. ROOM 2	CONCRETE	RB1	PAINT	PAINT	PAINT	PAINT	EXPOSED	
005	WOMEN'S A	SEAL. CONC (FF1)	CT4,CT5	CT1, CT2	EPOXY PAINT	EPOXY PAINT	EPOXY PAINT	SEMI-GLOSS LATEX PAINT	
006	FAM. RM. 1	SEAL. CONC (FF1)	CT4,CT5	EPOXY PAINT	EPOXY PAINT	CT1, CT2	EPOXY PAINT	SEMI-GLOSS LATEX PAINT	
007	BREAK RM.	VCT-1	RB1	EPOXY PAINT	EPOXY PAINT	EPOXY PAINT	EPOXY PAINT	SEMI-GLOSS LATEX PAINT	
008	STORAGE	SEAL. CONC (FF1)	RB1	PAINT	PAINT	PAINT	PAINT	PAINT	
009	ITS/COMM.	SEAL. CONC (FF1)	RB1	PLYWOOD	PLYWOOD	PLYWOOD	PLYWOOD	PAINT	WALLS COVERED W/ 3/4" FIRE RETARDANT PLYWOOD
010	ELEC.	SEAL. CONC (FF1)	RB1	PAINT	PAINT	PAINT	PAINT	PAINT	
011	OFFICE	VCT-1	RB1	PAINT	PAINT	PAINT	PAINT	PAINT	
012	FAM. RM. 3	SEAL. CONC (FF1)	CT4,CT5	EPOXY PAINT	EPOXY PAINT	CT1, CT2	EPOXY PAINT	SEMI-GLOSS LATEX PAINT	
013	MEN'S A	SEAL. CONC (FF1)	CT4,CT5	CT1, CT2	EPOXY PAINT	EPOXY PAINT	EPOXY PAINT	SEMI-GLOSS LATEX PAINT	
014	MECH.RM. 3	CONCRETE	RB1	PAINT	PAINT	PAINT	PAINT	EXPOSED	
015	MEN'S B	SEAL. CONC (FF1)	CT4,CT5	EPOXY PAINT	CT1, CT2	CT1, CT2	EPOXY PAINT	SEMI-GLOSS LATEX PAINT	
016	ADULT RM. 1	SEAL. CONC (FF1)	CT4,CT5	CT1, CT2	EPOXY PAINT	EPOXY PAINT	EPOXY PAINT	SEMI-GLOSS LATEX PAINT	
017	PAVILION	EPOXY COATING (FF2)	-	-	-	-	-	T&G WOOD STAIN	WOOD STAIN COLS & BEAMS. WHITE BIRCH. EXTERIOR SEMITRANSSPARENT STAIN
018	OPEN AREA	EPOXY COATING (FF4)	-	-	-	-	-	T&G WOOD STAIN	WOOD STAIN COLS & BEAMS. WHITE BIRCH. EXTERIOR SEMITRANSSPARENT STAIN
018A	BENCH SEATING	EPOXY TEXTURED (FF3)	-	-	-	-	-	T&G WOOD STAIN	WOOD STAIN COLS & BEAMS. WHITE BIRCH. EXTERIOR SEMITRANSSPARENT STAIN
019	OPEN AREA	EPOXY COATING (FF4)	-	-	-	-	-	T&G WOOD STAIN	WOOD STAIN COLS & BEAMS. WHITE BIRCH. EXTERIOR SEMITRANSSPARENT STAIN
019A	BENCH SEATING	EPOXY TEXTURED (FF3)	-	-	-	-	-	T&G WOOD STAIN	WOOD STAIN COLS & BEAMS. WHITE BIRCH. EXTERIOR SEMITRANSSPARENT STAIN
020	CHASE	CONCRETE	-	-	-	-	-	EXPOSED	
021	CHASE	CONCRETE	-	-	-	-	-	EXPOSED	
100	BREEZEWAY	EPOXY COATING (FF2)	-	PTD CONC COLS.	-	-	-	T&G WOOD STAIN	EXTERIOR PAINT ON CONC. COLUMNS & BEAM AT BUILDING ENTRANCE
100A	VEST.	EPOXY COATING (FF2)	-	-	-	-	-	PAINT	
100B	VEST.	EPOXY COATING (FF2)	-	-	-	-	-	PAINT	
E003	PICNIC SHELTER	CONCRETE	-	-	-	-	-	PAINT	PAINT PREFAB SHELTER STRUCTURE
E004	DUMPSTER AREA	CONCRETE	-	PTD STUCCO	PTD STUCCO	PTD STUCCO	PTD STUCCO	-	EXTERIOR PAINT BOTH SIDES OF WALLS
E005	STORAGE ROOM	CONCRETE	RB1	PTD CMU	PTD CMU	PTD CMU	PTD CMU	EXPOSED	PAINT INTERIOR AND EXTERIOR OF BUILDING (CMU)

FINISH LEGEND:

FLOORING FINISH:

FF1: CLEAR SEALED CONCRETE
(AT BATHROOM, FAMILY ROOMS, ADULT ROOM AND JANITOR FLOORING)

FF2: EPOXY COATING, MIXED APPLICATION OF FEDERAL COLOR: 33617 AND 33690 SAND
(AT BREEZEWAY, OPEN AREAS AND PAVILION FLOORING)

FF3: EPOXY TEXTURED, FEDERAL COLOR: 36555 TAN
(AT BENCH SEATING SECTIONS OF THE OPEN AREAS, AS AN ACCENT FLOORING FINISH)

FF4: EPOXY COATING, FEDERAL COLOR: 33690 SAND
(AT ALL WALKWAYS)

FLOORING GROUT COLOR: COLOR TO BE SUBMITTED FOR REVIEW AND APPROVAL.
(NO WHITE OR LIGHT COLOR)

WALL BASE:

RB1: 4" RUBBER BASE, FEDERAL COLOR: 36373 LIGHT GRAY
(AT INTERIOR ROOMS AS INDICATED)

CERAMIC TILE:

CT1: 15-3/4" X 31-1/2" ATLAS CONCORDE, CHERRY TONED REFLECTIVE, PORCELAIN TILE (OR EQUAL)
(AT RESTROOMS WET WALLS)

CT2: 12" X 12" ATLAS CONCORDE, CURRY MINIBRICK,, FEDERAL COLOR 30257 TAN (OR EQUAL)
TOP BAND TRIM (AT RESTROOMS WET WALLS)

CT3: 12" X 12" CERAMIC TILE, NEUTRAL COLOR, MFR AND MODEL T.B.D.
(AT BREAKROOM AND VENDING MACHINES AREA)

CT4: 4" CERAMIC TILE BASE (FLAT TOP, COVED BASE) MFR AND COLOR SIMILAR TO CT1
(AT RESTROOMS WET WALLS)

CT5: 4" CERAMIC TILE BASE (BULL NOSE, COVED BASE) MFR T.B.D. AND COLOR LIGHT GRAY

SEAL. CONC. - SCORED SEALED CONCRETE FINISH
TILE - FULL HEIGHT TILE WITH 12" TRIM
PTD CMU - PAINTED CMU WITH LATEX ENAMEL FINISH
PTD - PAINTED GYPSUM BOARD
VCT - 12"x12" VINYL COMPOSITE TILE (VCT) WITH VINYL BASES


PROJECT NORTH		PHASE 2 - 90% SUBMITTAL	
R 8 (I-10) WESTBOUND - (COLUMBIA COUNTY) REST AREA		DRAWING NO.	
		A812	
FINISH SCHEDULE		SHEET NO.	

REVISIONS					
DATE	BY	DESCRIPTION	DATE	BY	DESCRIPTION




BORRELLI + PARTNERS
ARCHITECTURE PLANNING LANDSCAPE INTERIORS
720 Vassar Street, Orlando FL 32804 407.418.1338 :: fax 407.418.1342
CONFIDENTIAL THIS DRAWING IS THE PROPERTY OF BORRELLI + PARTNERS UNLESS OTHERWISE PROVIDED. BY THE CONTRACT, THE CONTENTS OF THIS DRAWING ARE GRANTED TO ANY OTHER PARTY EXCEPT AS AGREED TO BY THE ARCHITECT. COPYRIGHT BORRELLI + PARTNERS. AAC 000711 / ACC 001842


STATE OF FLORIDA DEPARTMENT OF TRANSPORTATION		
ROAD NO.	COUNTY	FINANCIAL PROJECT ID
SR 8	COLUMBIA	438609-1-52-01

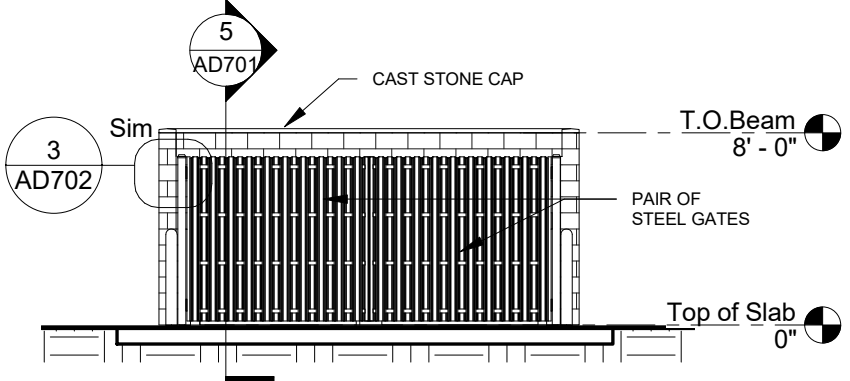


1 DUMPSTER FRONT ELEV.
1/8" = 1'-0"

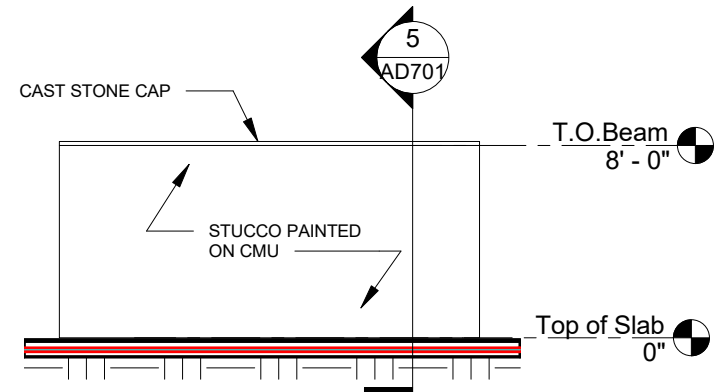


2 DUMPSTER REAR ELEV.
1/8" = 1'-0"

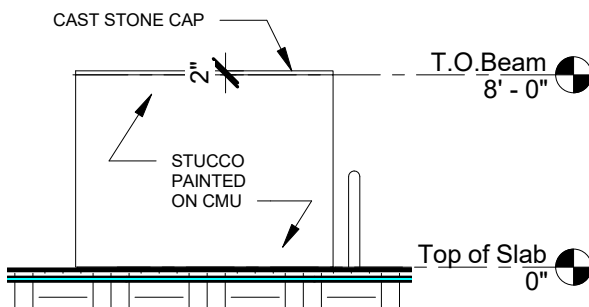

3 DUMPSTER SIDE ELEV.
1/8" = 1'-0"

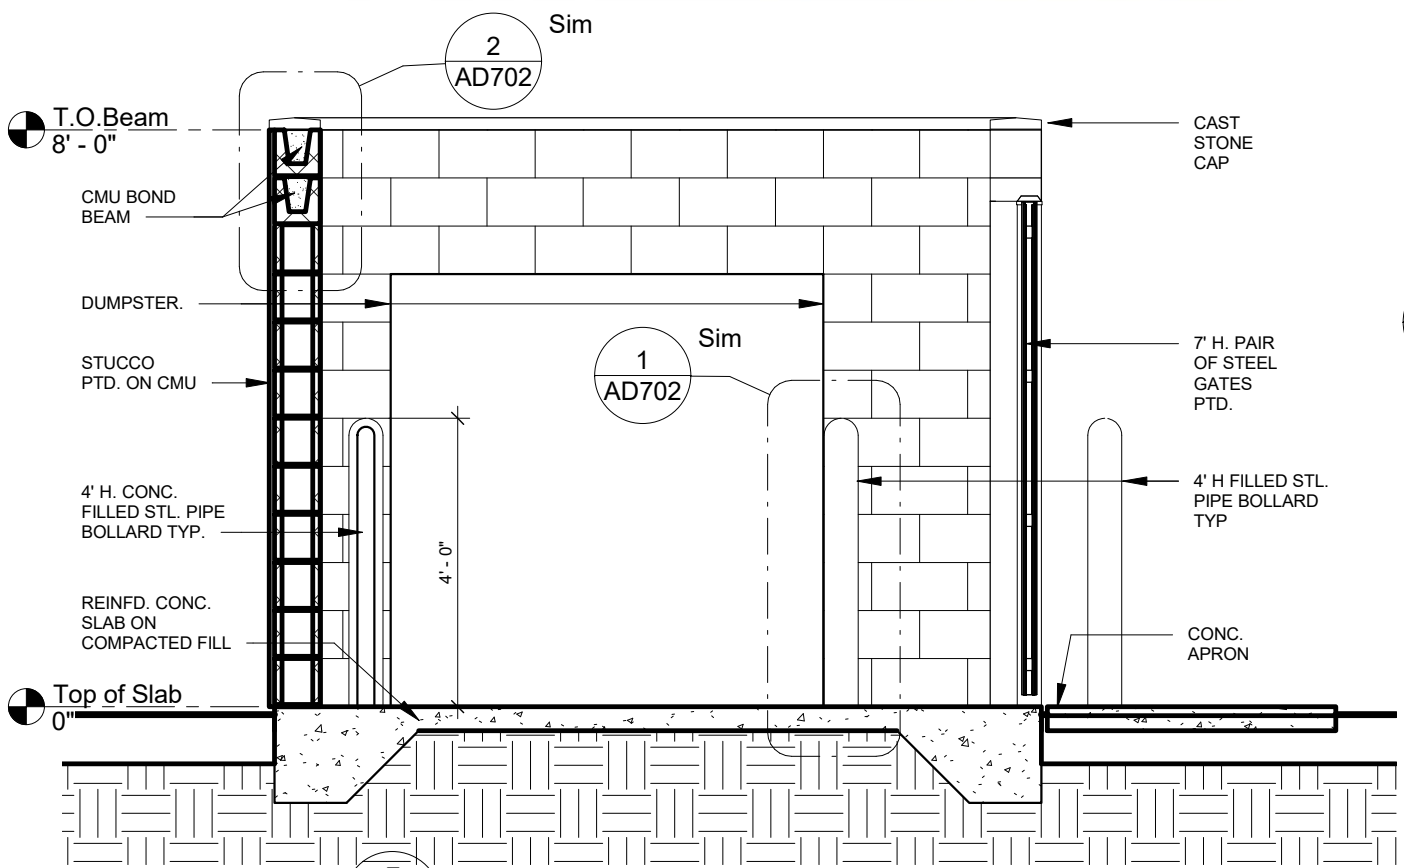

5 DUMPSTER SECTION
3/8" = 1'-0"

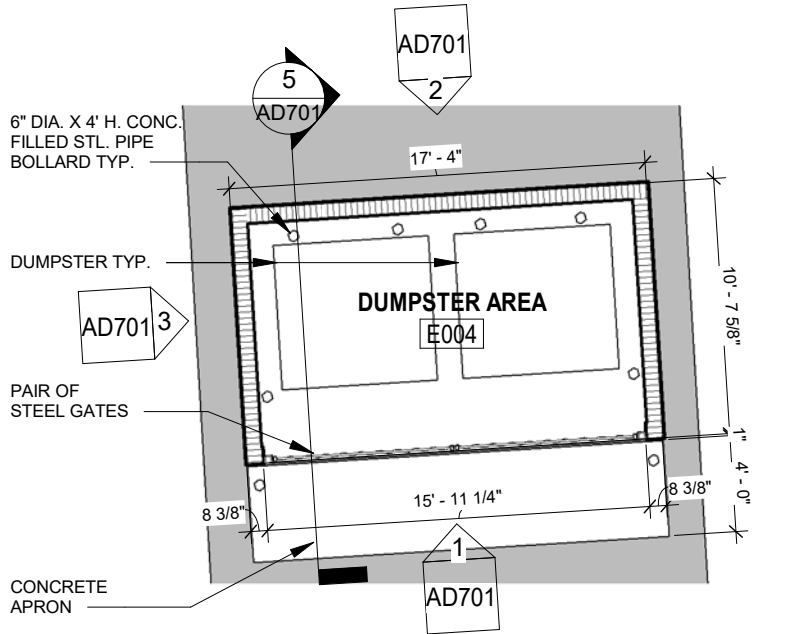


4 DUMPSTER FLOOR PLAN
1/8" = 1'-0"

1 PROJECT NORTH PHASE 2 - 90% SUBMITTAL


P:\1-10 Rest Area Improvements (19-049) GA14 - DrawingsA - Active Drawings\1 - B+P\Local Files\DD LOCAL\1-10 Rest_LOCAL_DD.rvt

REVISIONS						 BORRELLI + PARTNERS ARCHITECTURE PLANNING LANDSCAPE INTERIORS AND MORE 720 Vassar Street, Orlando FL 32804 407.418.1338 :: fax 407.418.1342 CONFIDENTIAL: THIS DRAWING IS THE PROPERTY OF BORRELLI + PARTNERS UNLESS OTHERWISE PROVIDED. BY THE CONTRACT, THE CONTENTS OF THIS DRAWING ARE SHOWN NOT BE TRANSMITTED TO ANY OTHER PARTY EXCEPT AS AGREED TO BY THE ARCHITECT. COPYRIGHT BORRELLI + PARTNERS, A/C 000711 / ACC 001842	STATE OF FLORIDA DEPARTMENT OF TRANSPORTATION			SR 8 (I-10) WESTBOUND - (COLUMBIA COUNTY) REST AREA	DRAWING NO.
DATE	BY	DESCRIPTION	DATE	BY	DESCRIPTION		ROAD NO.	COUNTY	FINANCIAL PROJECT ID		AD701
07/31/19		GENERAL REVISIONS					SR 8	COLUMBIA	438609-1-52-01		
											SHEET NO.
						DUMPSTER					


P:\1-10 Rest Area Improvements (19-049) GA14 - DrawingsA - Active Drawings\1 - B+P\Local Files\DD LOCAL\1-10 Rest_LOCAL_DD.rvt

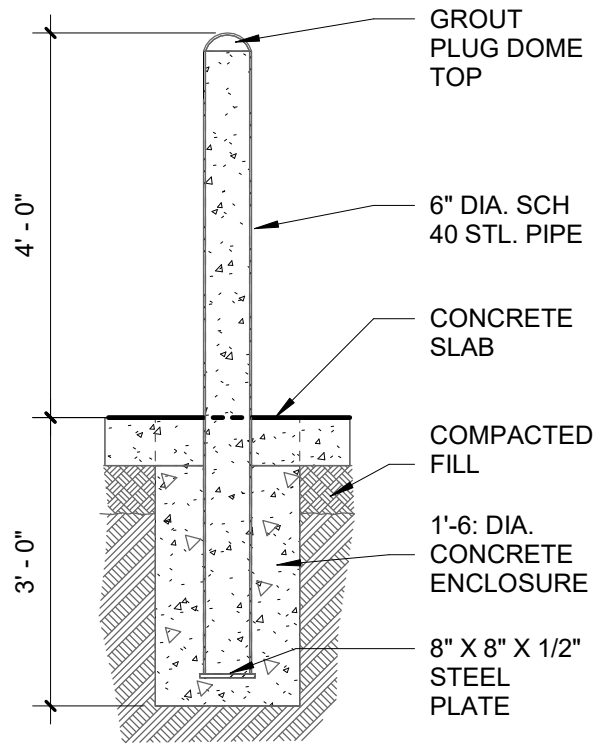


1 Mtl. Utility Bollard Detail
AD702 1/2" = 1'-0"

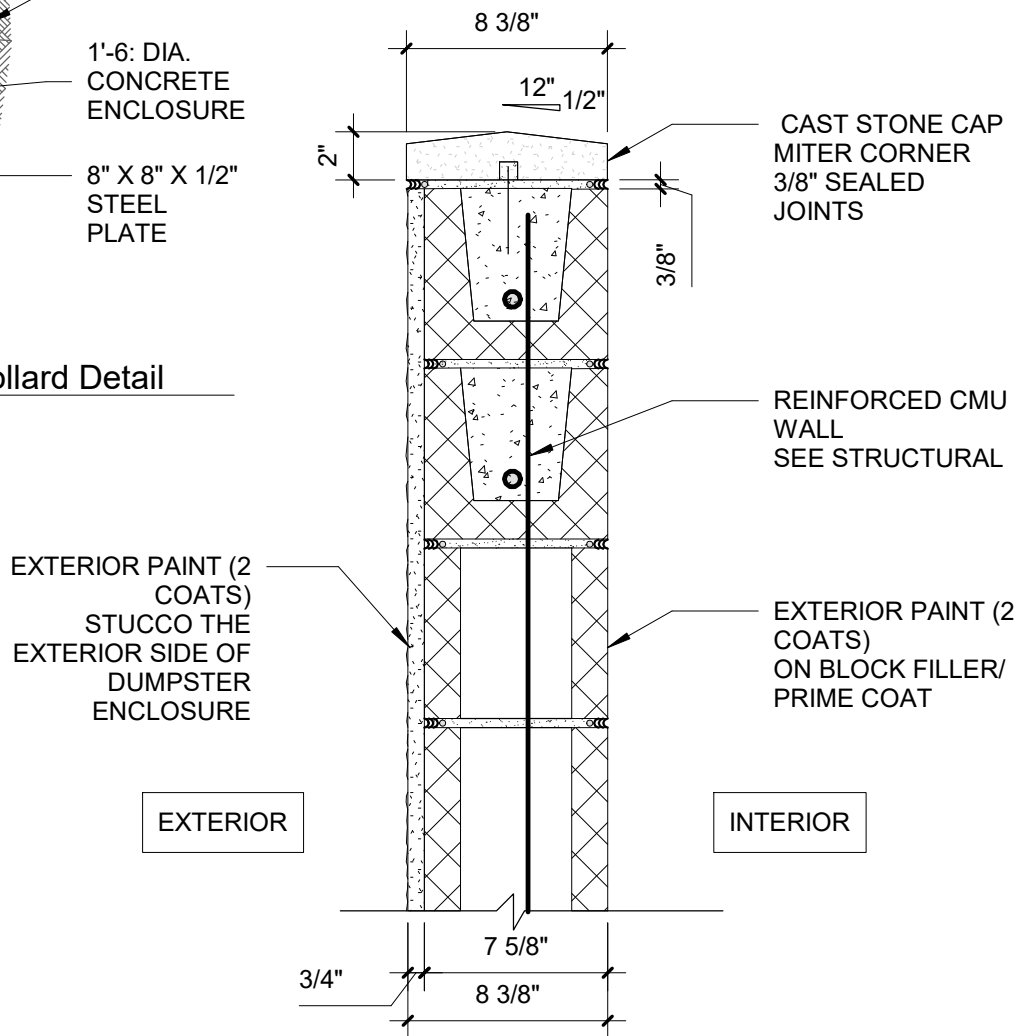


2 Top of Enclosure Wall Detail
AD702 1 1/2" = 1'-0"

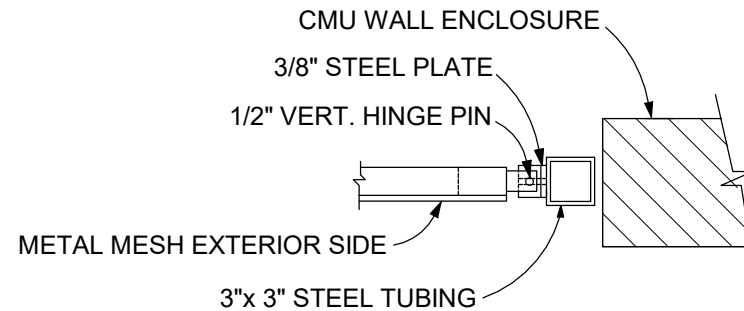

PLAN VIEW

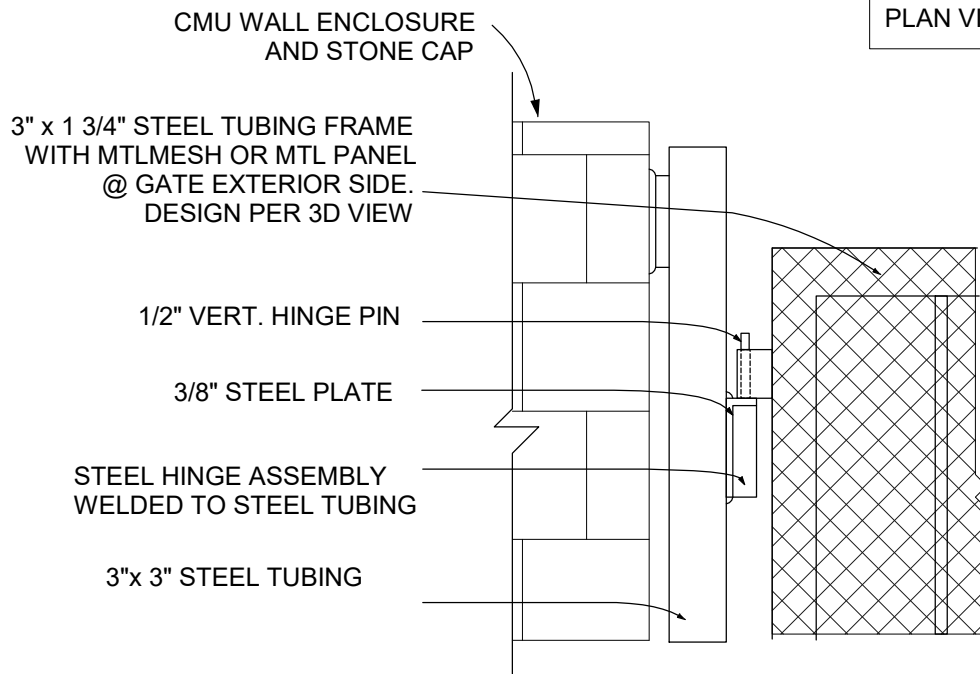

FRONT VIEW

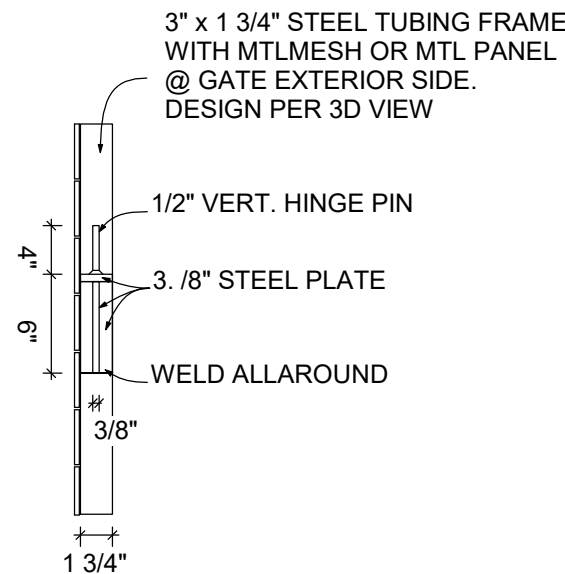

SIDE VIEW

3 Gate Hinge Details
AD702 1" = 1'-0"

1 PROJECT NORTH

PHASE 2 - 90% SUBMITTAL


REVISIONS					
DATE	BY	DESCRIPTION	DATE	BY	DESCRIPTION




STATE OF FLORIDA DEPARTMENT OF TRANSPORTATION		
ROAD NO.	COUNTY	FINANCIAL PROJECT ID
SR 8	COLUMBIA	438609-1-52-01

SR 8 (I-10) WESTBOUND - (COLUMBIA COUNTY) REST AREA	
DUMPSTER DETAILS	


DRAWING NO.
AD702
SHEET NO.

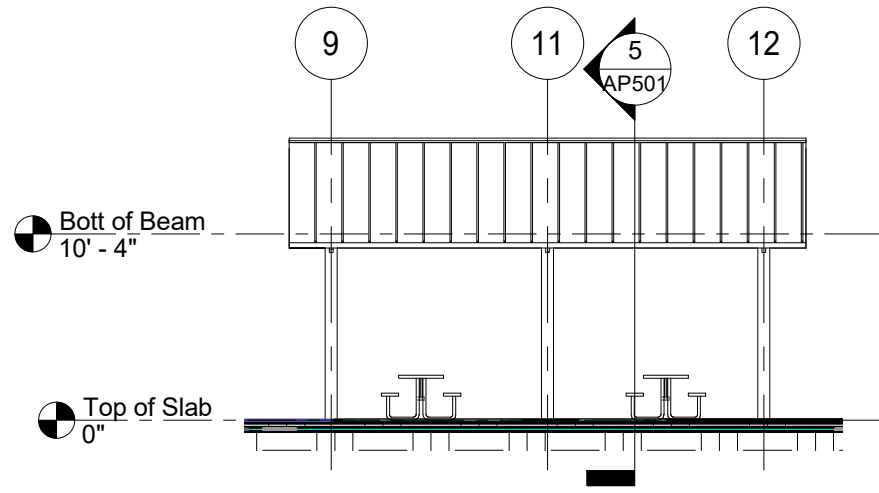


4 PAVILION ELEV. 1
AP501 3/32" = 1'-0"

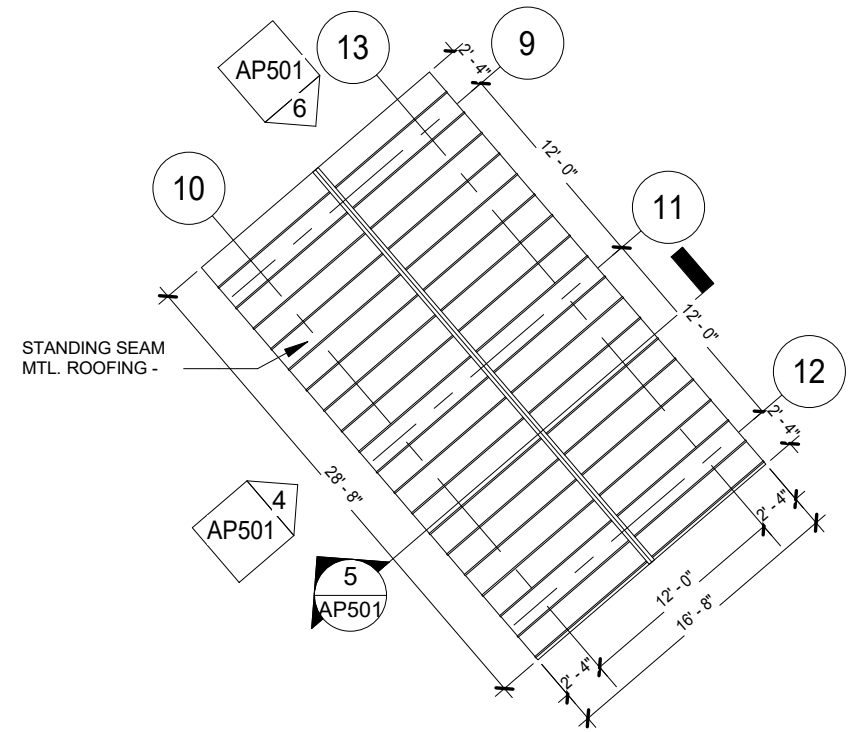


3 PAVILION ROOF PLAN
AP501 3/32" = 1'-0"

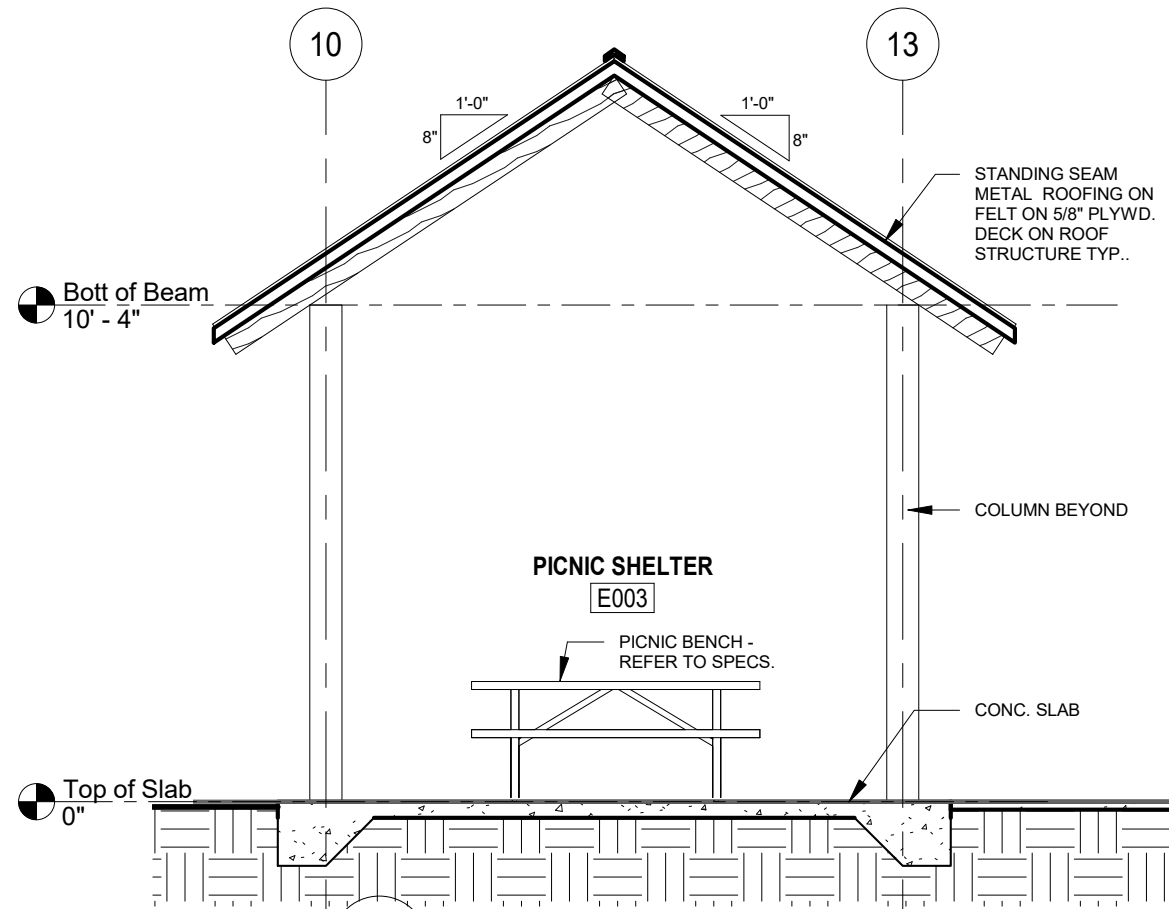

5 PICNIC PAVILION SECTION
AP501 1/4" = 1'-0"

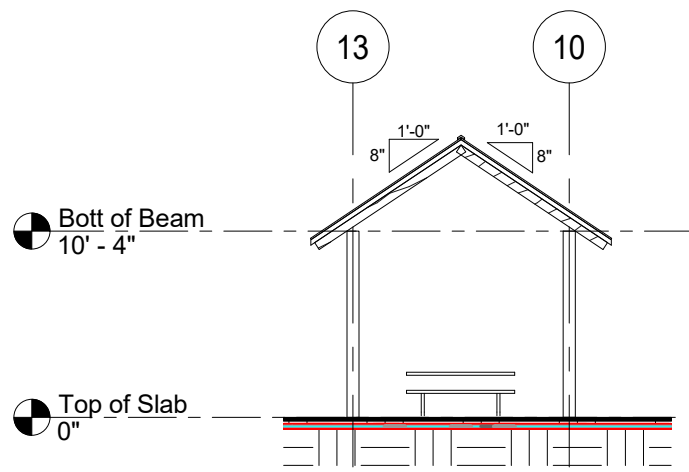

6 PAVILION ELEV. 2
AP501 3/32" = 1'-0"

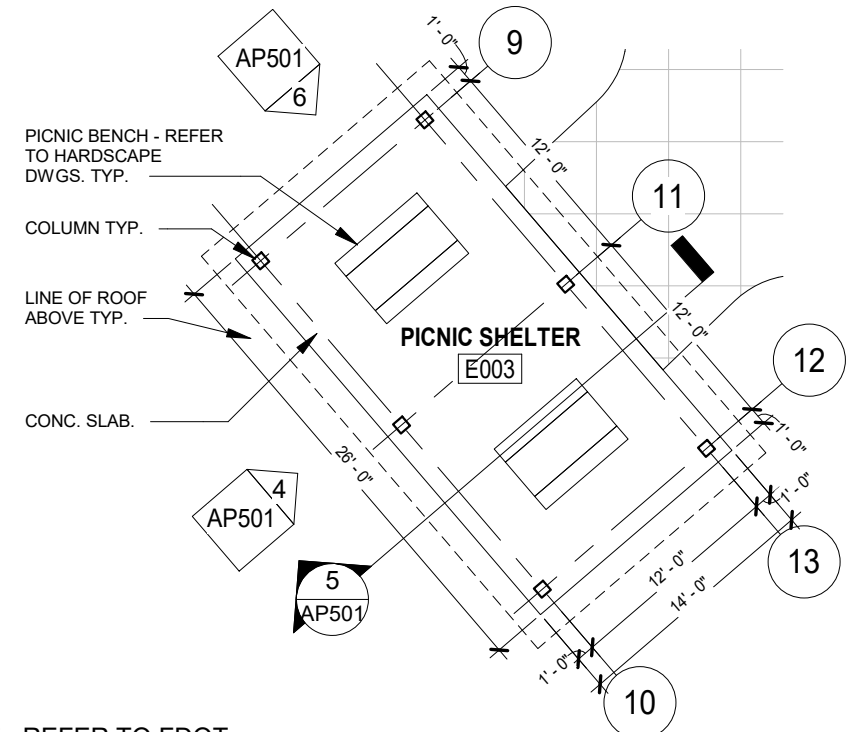

1 PAVILION FLOOR PLAN
AP501 3/32" = 1'-0"


NOTE : REFER TO FDOT
INDEX 530 FOR SMALL
SIZE SHELTERS PLANS
FOR BUILDING
LOCATIONS

1 PROJECT NORTH PHASE 2 - 90% SUBMITTAL


P:\1-10 Rest Area Improvements (19-049) GAI\4 - Drawings\A - Active Drawings\1 - B4P\Local Files\DD LOCAL\1-10 Rest_LOCAL_DD.rvt

REVISIONS						 BORRELLI + PARTNERS ARCHITECTURE PLANNING LANDSCAPE INTERIORS 400 SOTI 720 Vassar Street, Orlando FL 32804 407.418.1338 :: fax 407.418.1342 CONFIDENTIAL: THIS DRAWING IS THE PROPERTY OF BORRELLI + PARTNERS UNLESS OTHERWISE PROVIDED. BY THE CONTRACT, THE CONTENTS OF THIS DRAWING ARE NOT TO BE TRANSMITTED TO ANY OTHER PARTY EXCEPT AS AGREED TO BY THE ARCHITECT. COPYRIGHT BORRELLI + PARTNERS, A/C 000711 / ACC 001842	STATE OF FLORIDA DEPARTMENT OF TRANSPORTATION			SR 8 (I-10) WESTBOUND - (COLUMBIA COUNTY) REST AREA	DRAWING NO.
DATE	BY	DESCRIPTION	DATE	BY	DESCRIPTION				AP501		
							ROAD NO.	COUNTY	FINANCIAL PROJECT ID	PICNIC PAVILION	
							SR 8	COLUMBIA	438609-1-52-01		
										SHEET NO.	

P:\1-10 Rest Area Improvements (19-049) GA14 - DrawingsA - Active Drawings\1 - B+P\Local Files\DD LOCAL\1-10 Rest_LOCAL_DD.rvt

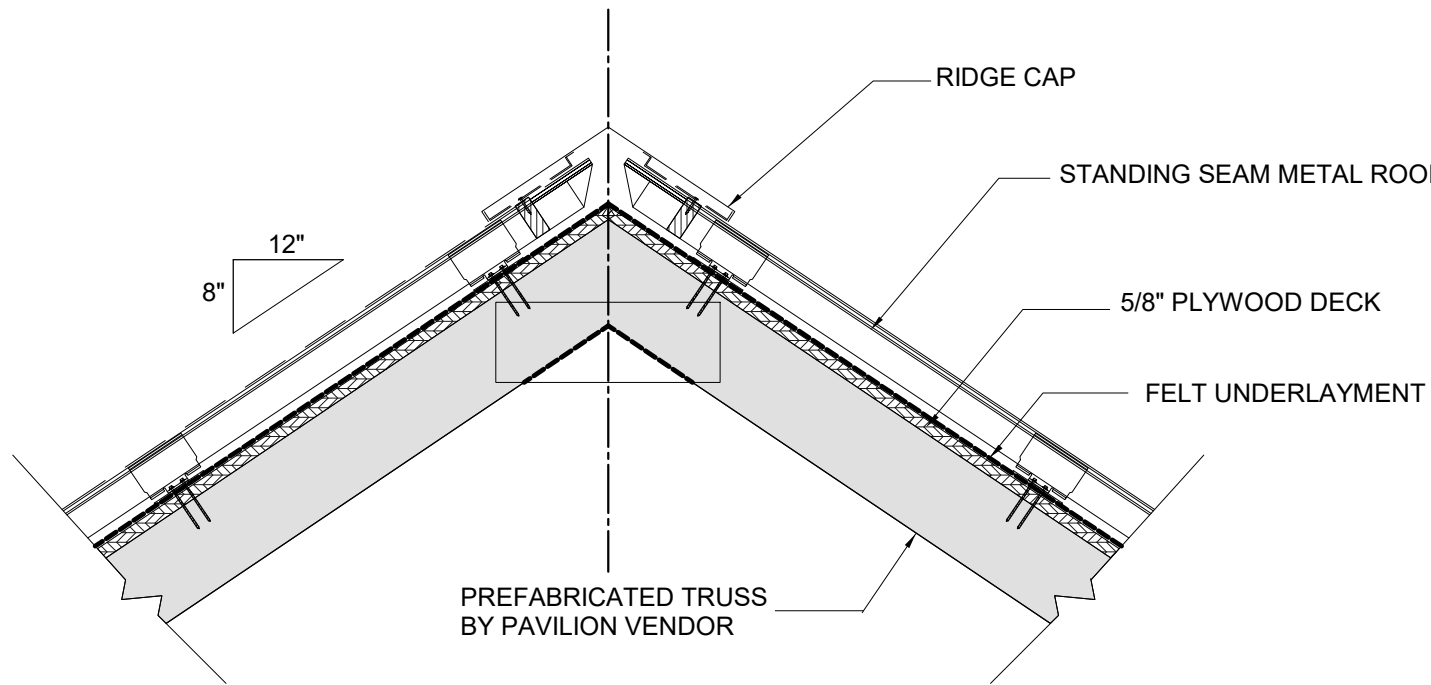

1 Pavilion Roof Detail (Ridge)
AP502 1" = 1'-0"

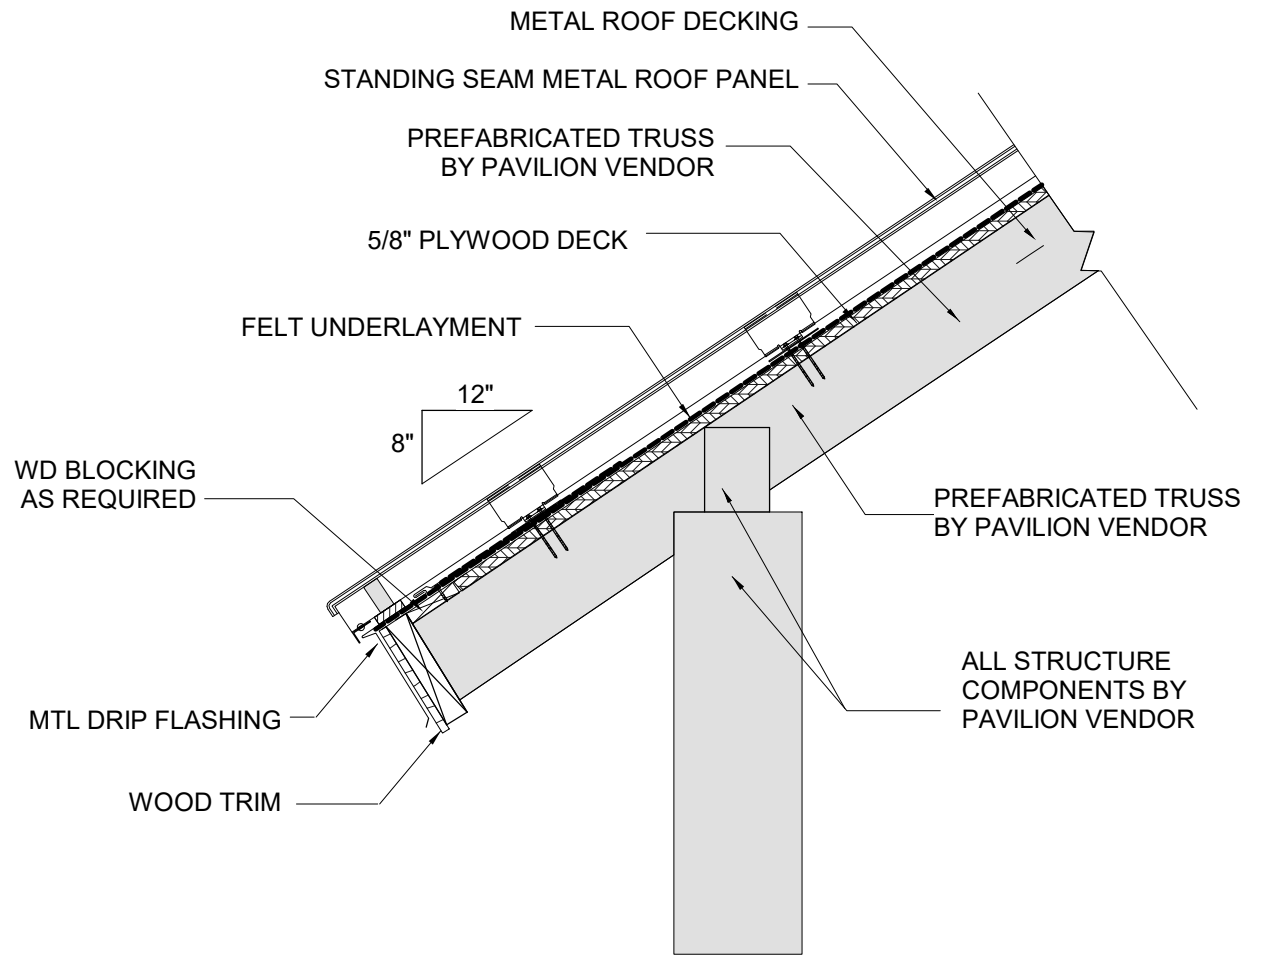

2 Pavilion Roof Detail (Eave)
AP502 1" = 1'-0"

PROJECT NORTH

PHASE 2 - 90% SUBMITTAL

REVISIONS					
DATE	BY	DESCRIPTION	DATE	BY	DESCRIPTION



STATE OF FLORIDA DEPARTMENT OF TRANSPORTATION		
ROAD NO.	COUNTY	FINANCIAL PROJECT ID
SR 8	COLUMBIA	438609-1-52-01


SR 8 (I-10) WESTBOUND - (COLUMBIA COUNTY) REST AREA

PICNIC PAVILION DETAILS


DRAWING NO.

AP502


SHEET NO.

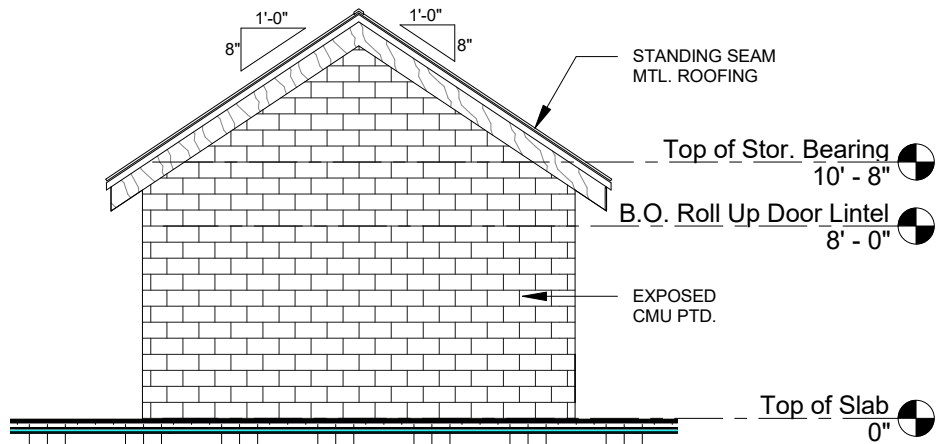


1 STO. RM. REAR ELEV.
1/8" = 1'-0"

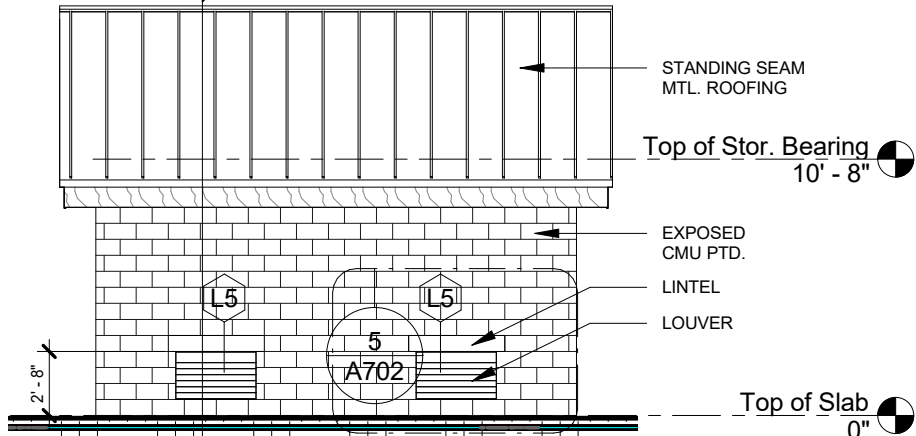


2 STO. RM. TYP. SIDE ELEV.
1/8" = 1'-0"

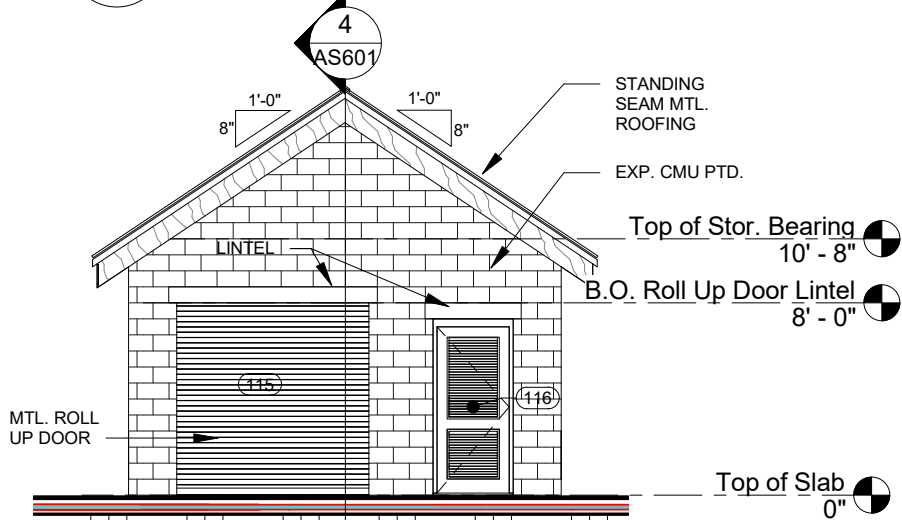


3 STO. RM. FRONT ELEV.
1/8" = 1'-0"

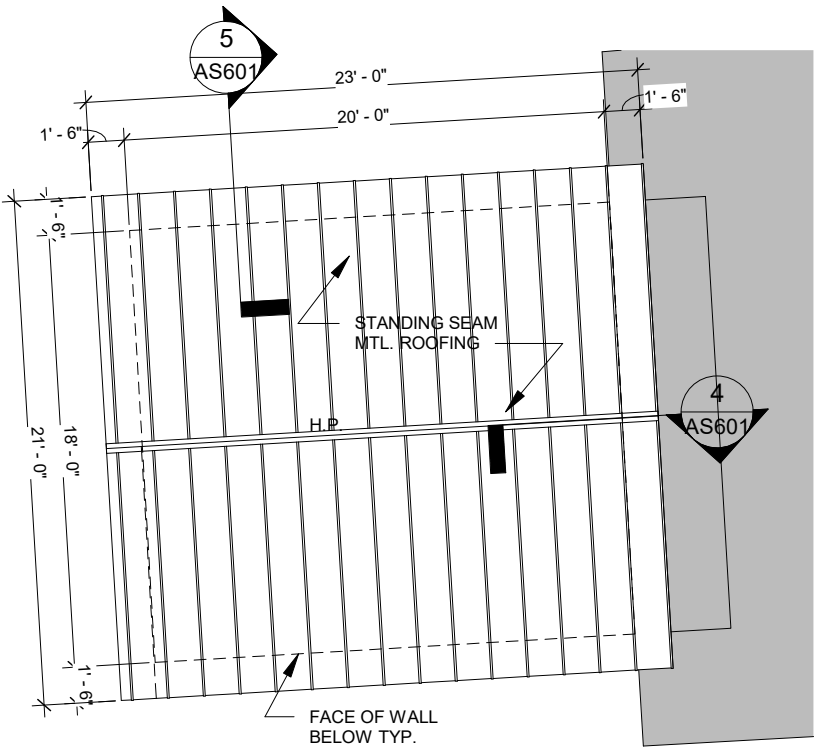

6 STORAGE ROOM ROOF PLAN
1/8" = 1'-0"

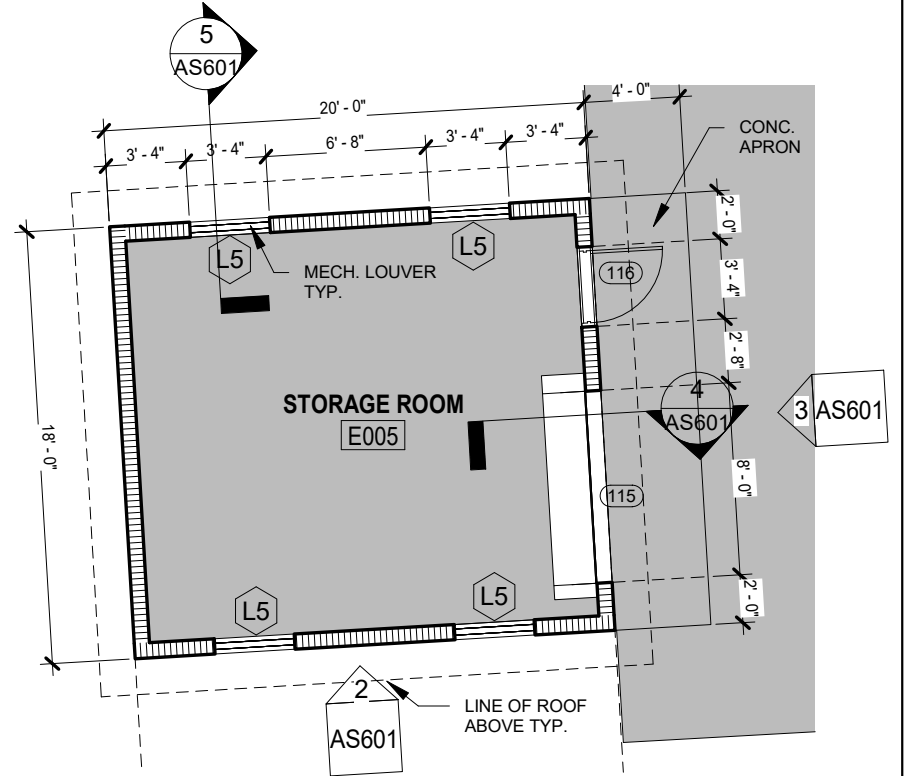


7 STORAGE ROOM FLOOR PLAN
1/8" = 1'-0"

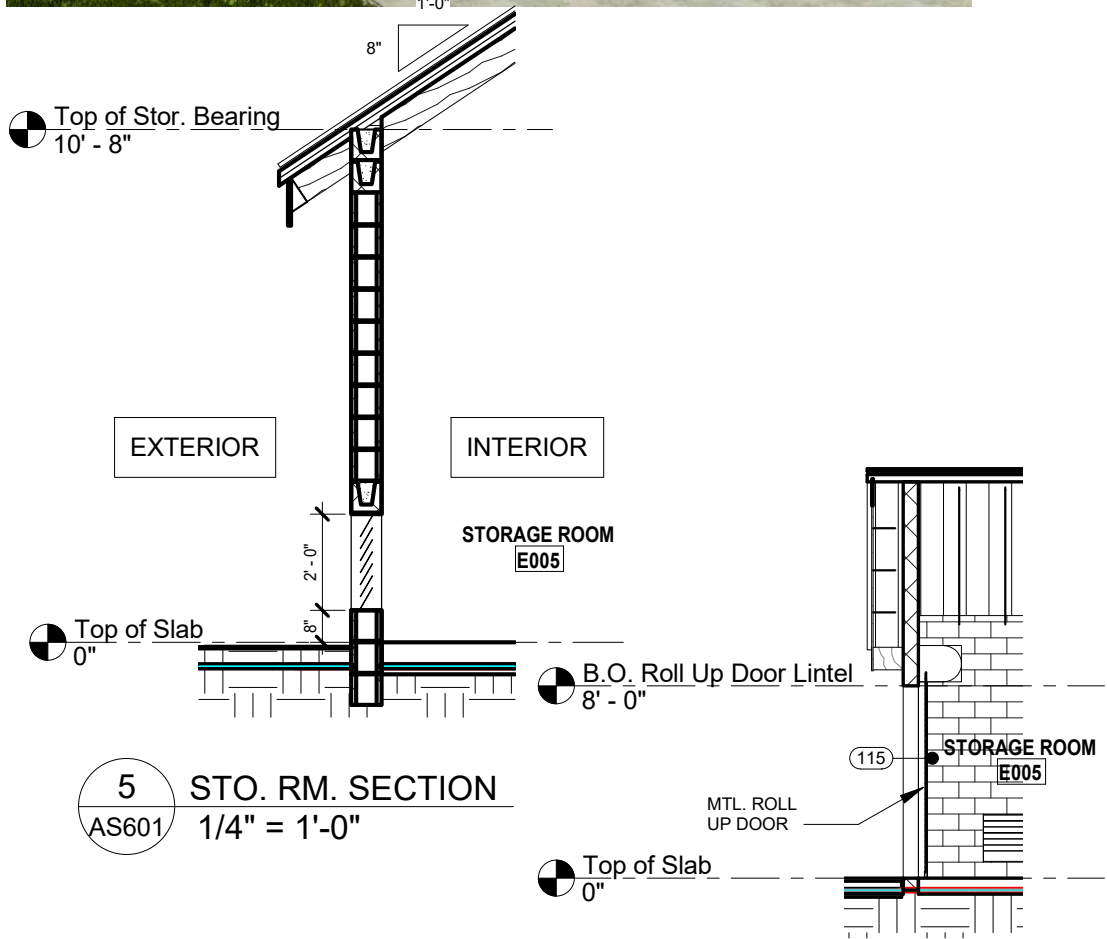

4 STOR. RM. SECTION
1/8" = 1'-0"

5 STO. RM. SECTION
1/4" = 1'-0"

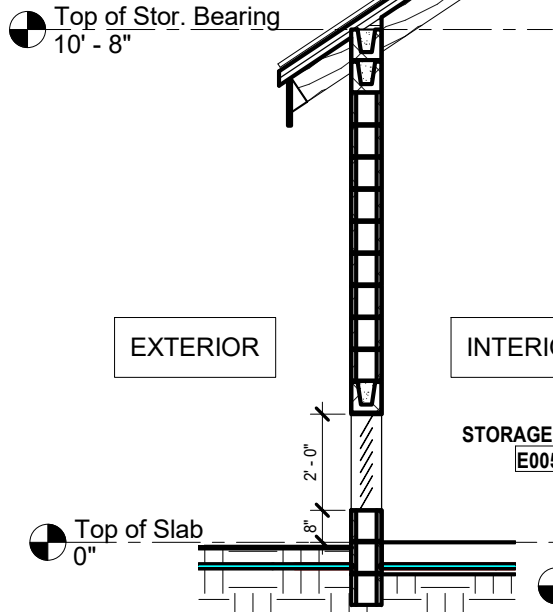

PROJECT NORTH PHASE 2 - 90% SUBMITTAL

SR 8 (I-10) WESTBOUND - (COLUMBIA COUNTY) REST AREA

STORAGE BUILDING

DRAWING NO.

AS601

SHEET NO.

BORRELLI + PARTNERS
ARCHITECTURE PLANNING LANDSCAPE INTERIORS

720 Vassar Street, Orlando, FL 32804 407.418.1338 :: fax 407.418.1342
CONFIDENTIAL: THIS DRAWING IS THE PROPERTY OF BORRELLI + PARTNERS. UNLESS OTHERWISE PROVIDED, BY THE CONTRACT, THE CONTENTS OF THIS DRAWING ARE NOT TO BE TRANSMITTED TO ANY OTHER PARTY EXCEPT AS AGREED TO BY THE ARCHITECT. COPYRIGHT BORRELLI + PARTNERS, A/C 000711 / A/C 001842

STATE OF FLORIDA
DEPARTMENT OF TRANSPORTATION

ROAD NO.	COUNTY	FINANCIAL PROJECT ID
SR 8	COLUMBIA	438609-1-52-01

Diagram illustrating the construction details of a roof-to-wall connection, showing the assembly from the roof slope down to the wall structure.

Roof Assembly Components (from top to bottom):

- PLYWOOD SHEATHING
- STANDING SEAM METAL ROOF PANEL
- PREFABRICATED WOOD TRUSS @2'-0" O.C. (MAX.)
- RIGID INSULATION PANEL W/ INTEGRAL COVER BOARD
- SELF ADHESIVE UNDERLAYMENT . TOP LAYER TO BE PARALLEL TO ROOF SLOPE

Roof Slope: 12" vertical rise, 8" horizontal run.

Roof Edge Details:

- WOOD TRUSS
- 2X WD BLOCKING AS REQUIRED
- MTL DRIP FLASHING
- 12" FASCIA BOARD
- WOOD TRIM
- CONTINUOUS SOFFIT VENT

Wall Assembly Components (from top to bottom):

- TRUSS ANCHOR EA. TRUSS
- 8" CONC BOND BEAM
- 8" CMU WALL

Dimensions:

- 18" (Total wall thickness)
- 12" (Roof slope vertical rise)
- 8" (Roof slope horizontal run)

 PROJECT NORTH	PHASE 2 - 90% SUBMITTAL
--	--------------------------------


BORRELLI + PARTNERS
ARCHITECTURE PLANNING LANDSCAPE INTERIORS
720 Vassar Street, Orlando FL 32804 407.418.1338 :: fax 407.418.1342

CONFIDENTIAL: THIS DRAWING IS THE PROPERTY OF BORRELLI + PARTNERS UNLESS OTHERWISE PROVIDED. IF THE CONTRACT, THE CONTENTS OF THIS DRAWING ARE SHALL NOT BE TRANSMITTED TO ANY OTHER PARTY EXCEPT AS AGREED TO BY THE ARCHITECT. COPYRIGHT BORRELLI + PARTNERS. AEC 000711 / AEC-00184