
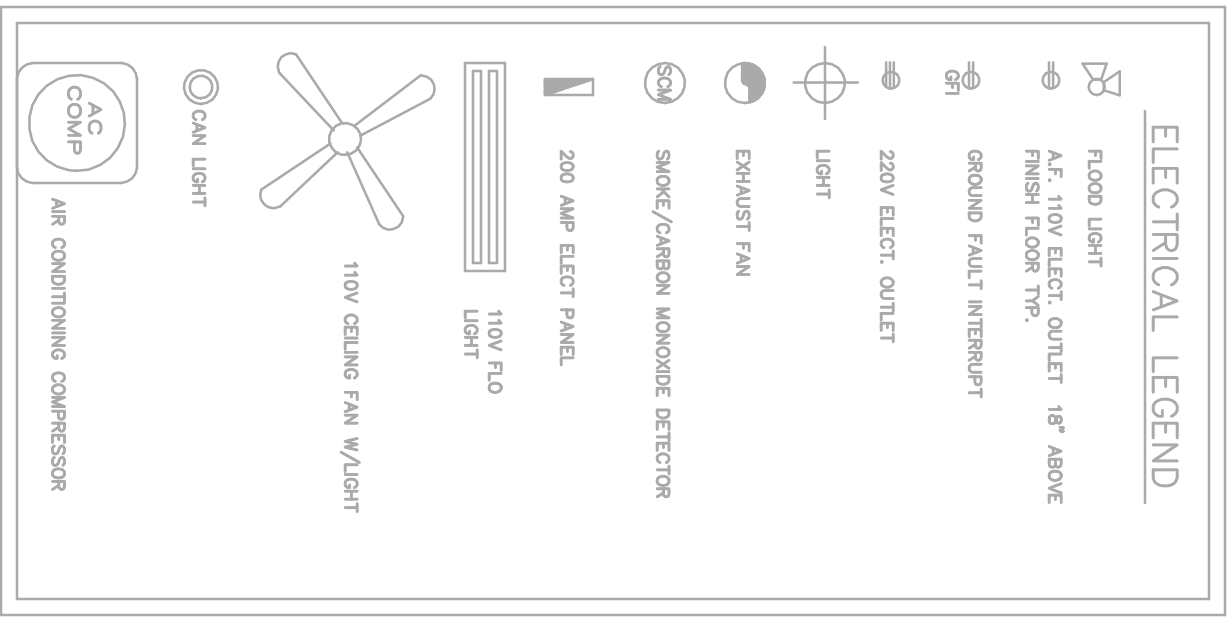


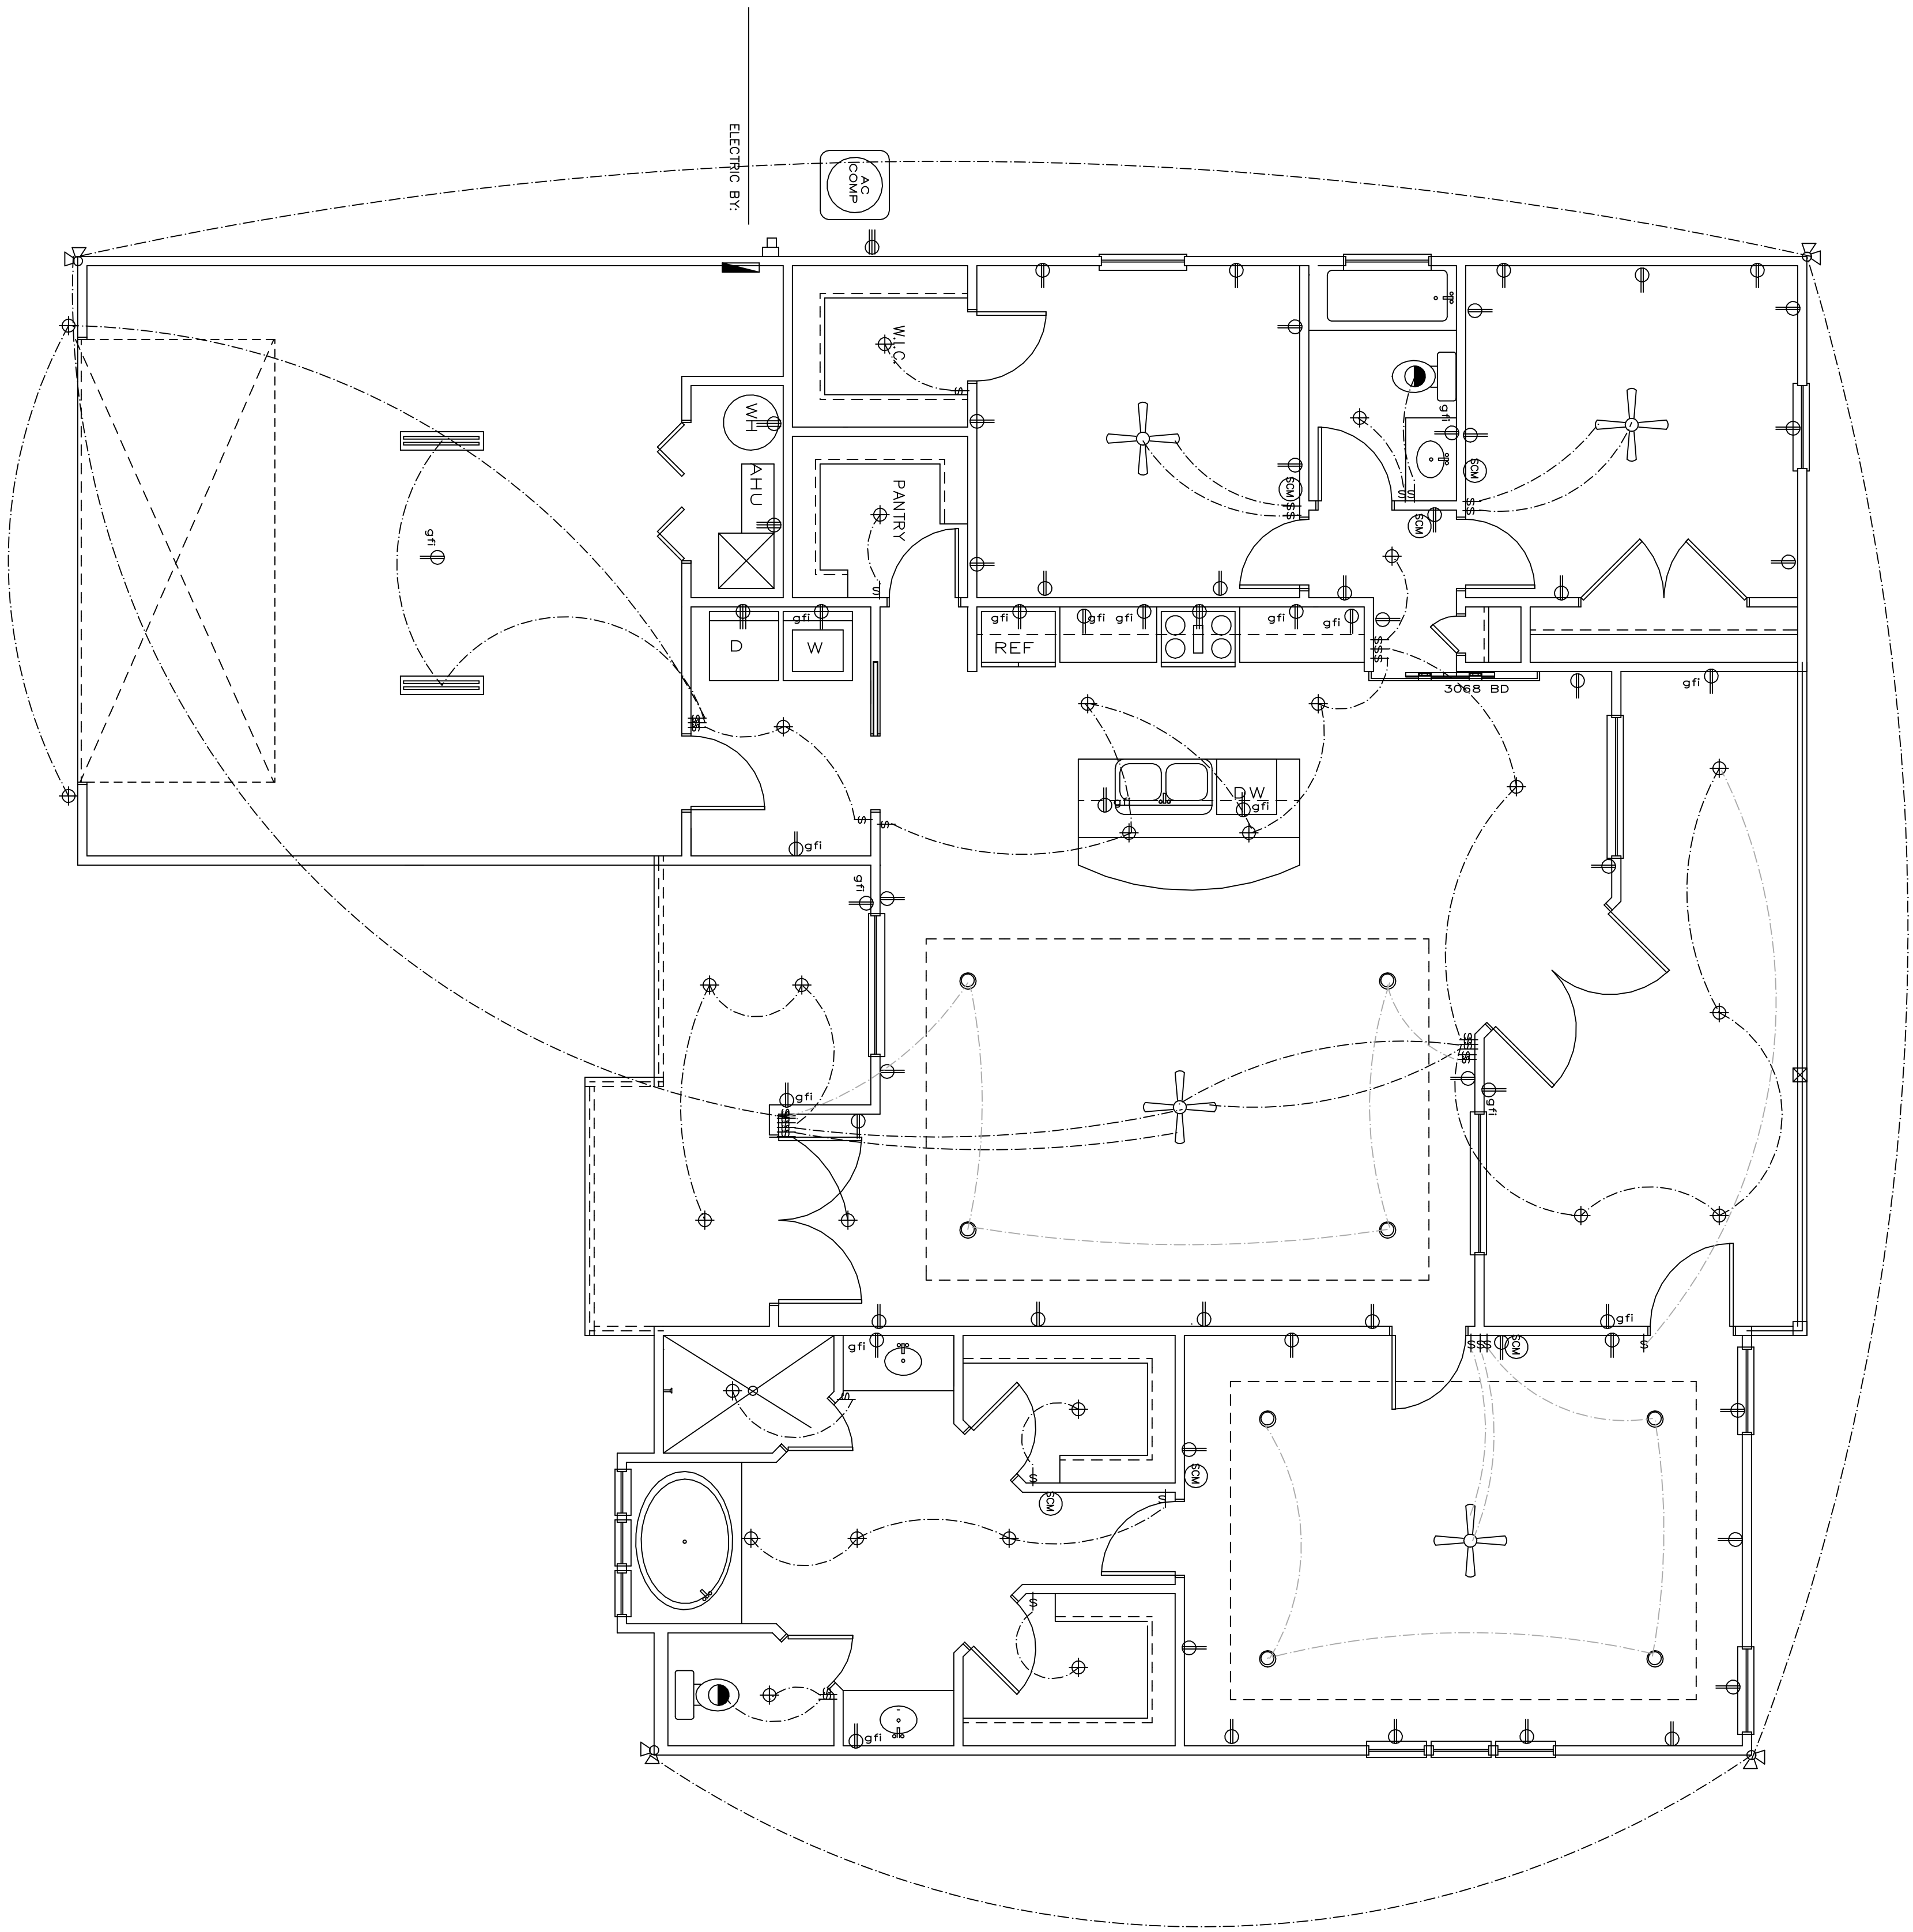

SMOKE DETECTORS TO BE WIRED BACK UP AS REQUIRED BY CODE. W/ BATTERY FAULT PROTECTED BY CIRCUIT. ALTER TO BE CHF. NEAR ALL EXTERIOR OUTLETS.

NOTES:

ALL WORK SHALL COMPLY WITH THE 2020 NEC AND ALL OTHER APPLICABLE LOCAL CODES AND ORDINANCES. ALL SMOKE DETECTORS TO BE WIRED TOGETHER TO ACTIVATE AS ONE UNIT. PROVIDE GFI OUTLETS AT BATHROOMS, KITCHEN, EXTERIOR AND ANY WET AREA OUTLETS. OUTLETS SUPPLYING POWER TO THE STOVE, RANGE, A/C, WATER HEATER, DRYER AND DISH WASHER ARE TO BE WIRED ON SEPARATE DEDICATED CIRCUITS.

Note:

THIS ELECTRICAL PLAN IS A SCHEMATIC WITH SUGGESTED SWITCH, REPLACEMENT AND LIGHT FIXTURE LOCATIONS, DUE TO VARYING LOCAL AND STATE CODES, REGULATIONS, AND STATUTES. IT IS THE RESPONSIBILITY OF THE OWNER AND/OR CONTRACTOR TO COMPLY WITH ALL LOCAL AND STATE CODES, REGULATIONS AND STATUTES.

ELECTRICAL NOTES:


INSTALLATION SHALL BE PER 2020 NAT'L. ELECTRIC CODE. WIRE ALL APPLIANCES, HVAC UNITS AND OTHER EQUIPMENT PER MANUFACTURER'S SPECIFICATIONS.

SMOKE ALARMS SHALL BE LISTED IN ACCORDANCE WITH UL 217. COMBINATION SMOKE AND CARBON MONOXIDE ALARM SHALL BE LISTED IN ACCORDANCE WITH UL 217 AND 2034. R314.1.1

ANY BUILDINGS HAVING A FOSSIL-FUEL-BURNING HEATER OR APPLIANCE, A FIREPLACE OR AN ATTACHED GARAGE SHALL HAVE CARBON MONOXIDE DETECTORS WITHIN 10' OF EACH ROOM USED FOR SLEEPING PURPOSES. R315.1

TELEPHONE, TELEVISION, AND OTHER LOW VOLTAGE DEVICES OR OUTLETS SHALL BE AS PER THE OWNER'S DIRECTIONS, AND IN ACCORDANCE WITH APPLICABLE SECTIONS OF NEC-LATEST EDITION 2020 NEC. ALL BEDROOM RECEPTACLES SHALL BE AFCI. 2017 (ARC FAULT CIRCUIT INTERRUPT)

NOTE: ALL 15 AND 20 AMP BRANCH CIRCUITS THAT SUPPLY 120 VOLT OUTLETS IN HABITABLE ROOMS SHALL BE ARC FAULT PROTECTED (AFP)

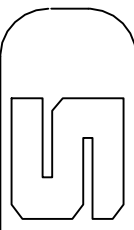

ELECTRICAL PLAN

SCALE: 1/4"=1'-0"

DWC CONSTRUCTION
THORNWOOD \ LOT 22
ALACHUA COUNTY, FLORIDA

JACOB ESKRIDGE
jacobeskridge@yahoo.com
DRAFTING & DESIGNS
14705 MAIN STREET
ALACHUA, FLORIDA
386-462-1340