



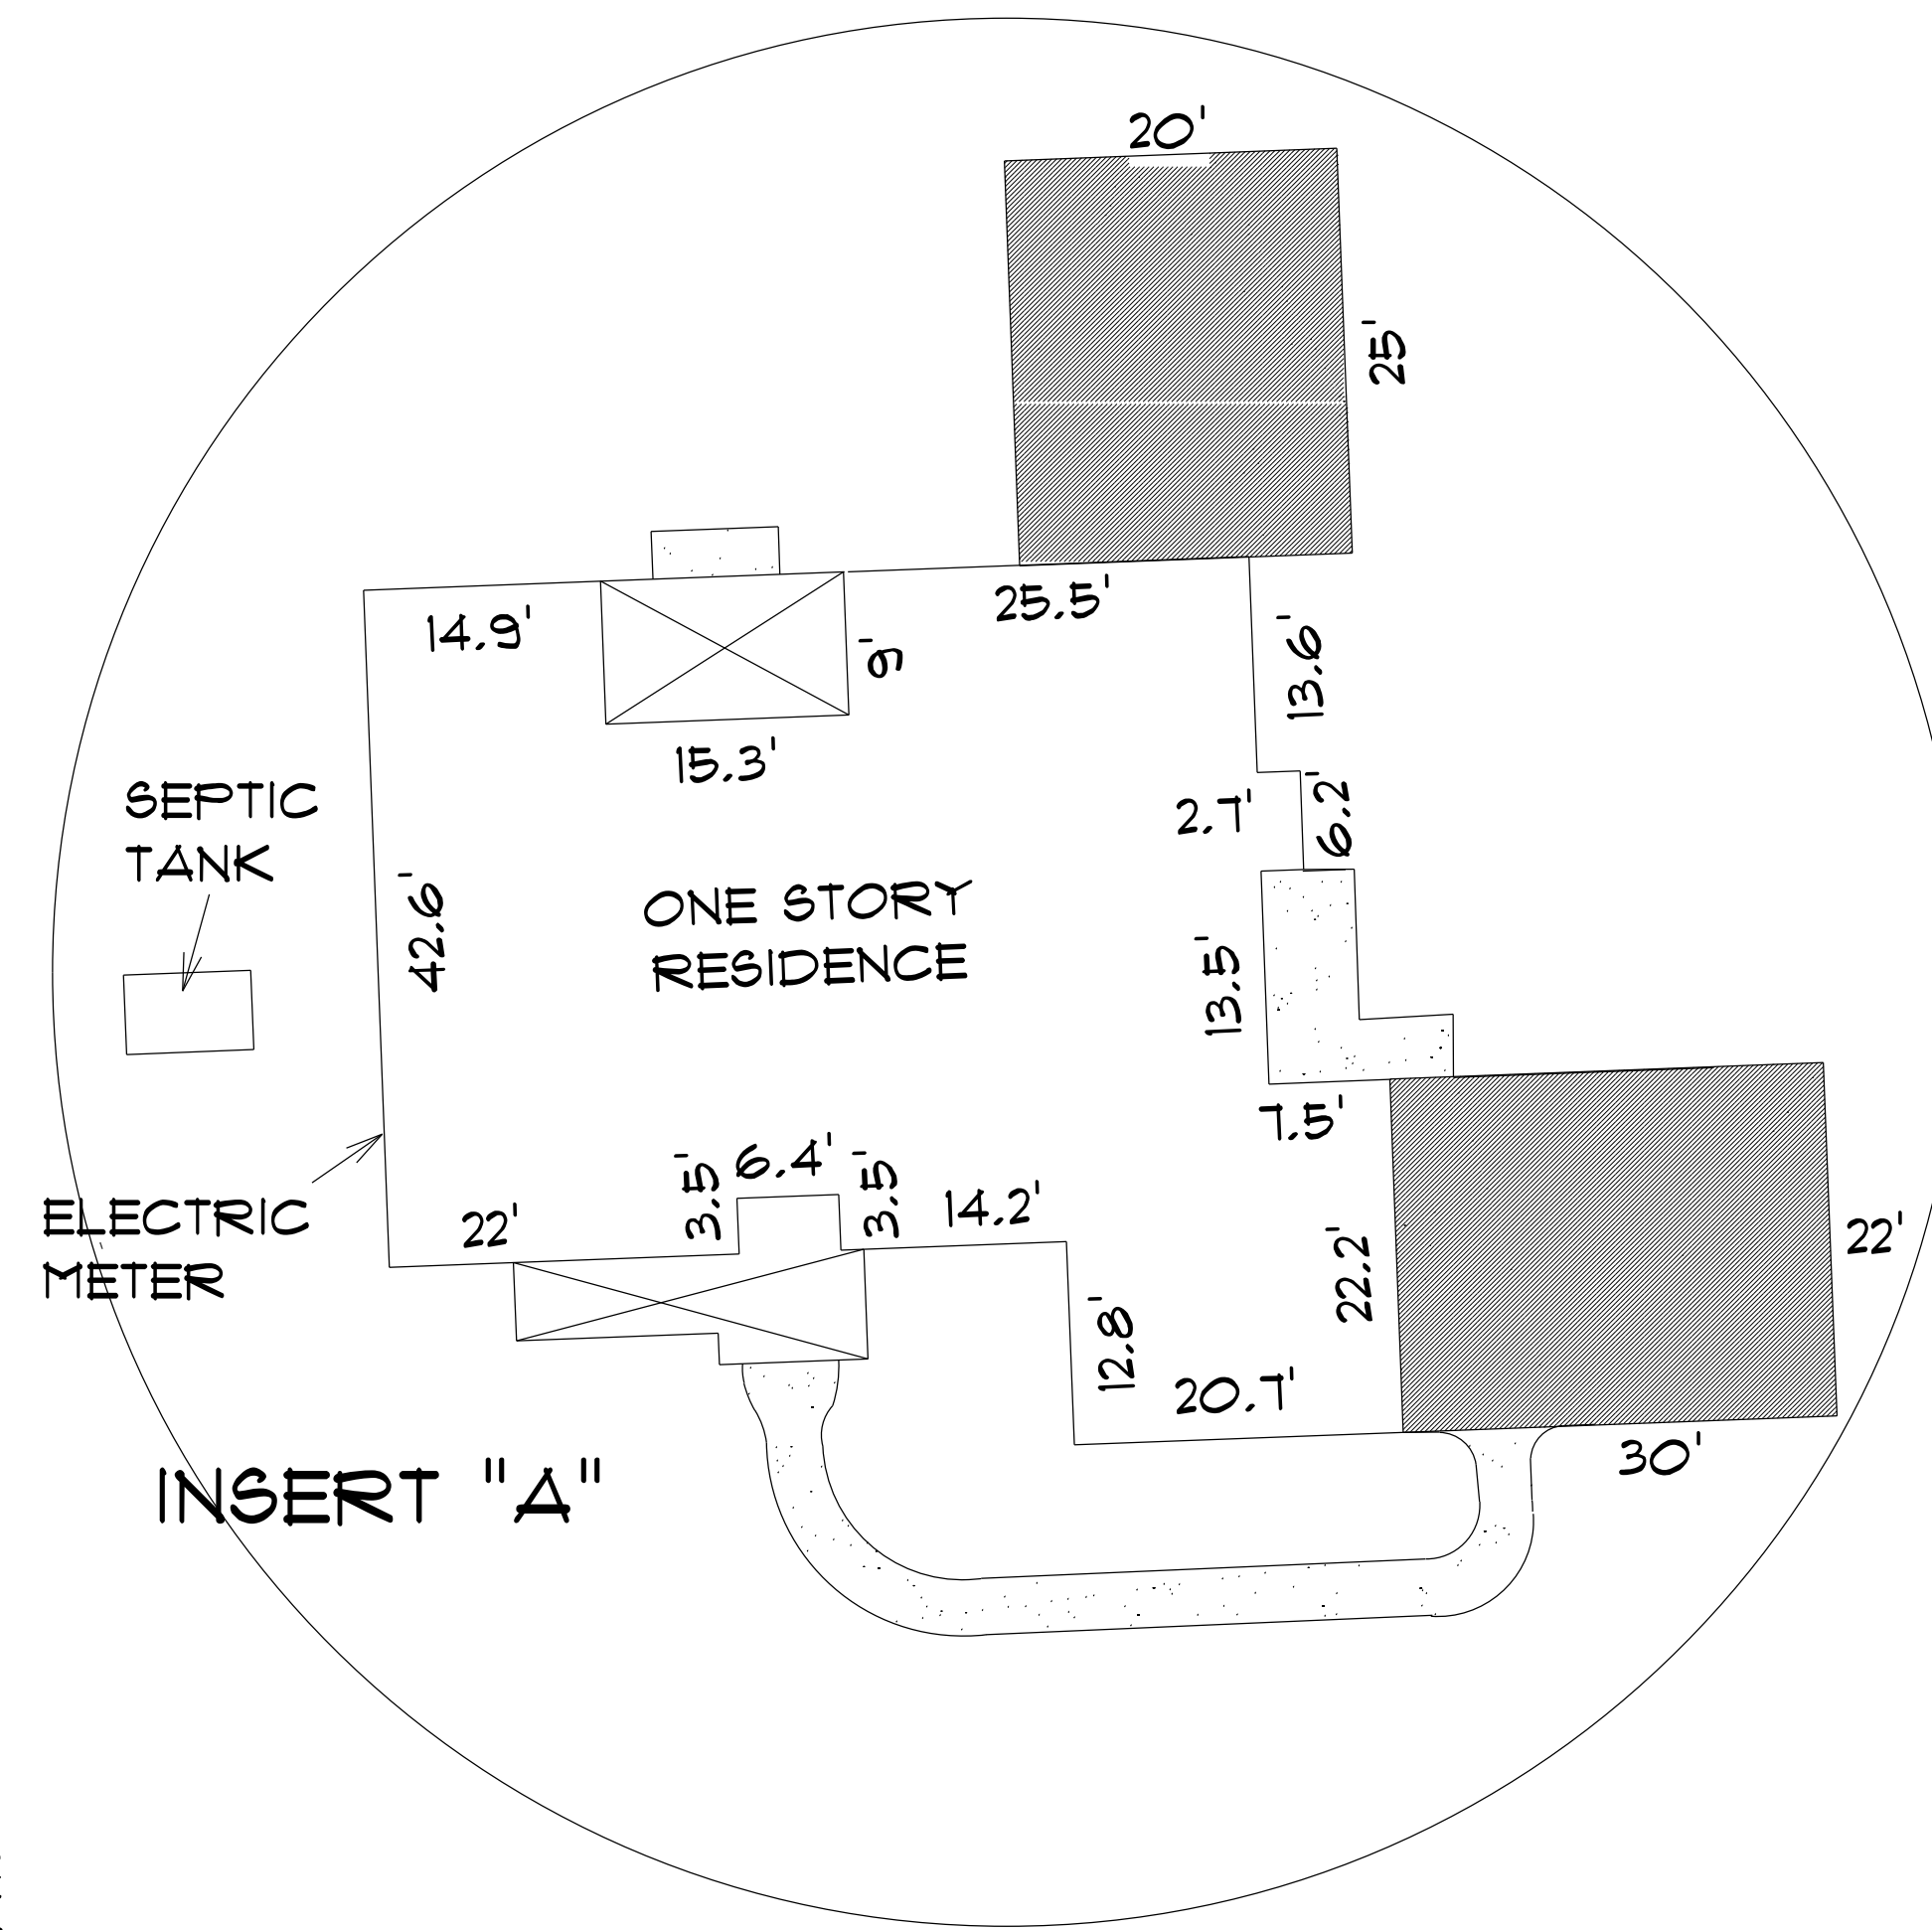

SCALE: 1" = 40'

ADDITION for MARK & SARAH LANE	
830 SW MANDIWA DR LAKE CITY, FLORIDA 32025	
Teana M. Ruffo 2525 SW 98 47 Lake City Florida, 32025 Cell: (386) 867-1181 Email: teanaruffo@gmail.com	
PRINTED DATE: Friday, January 26, 2024	
DRAWN BY: Teana M. Ruffo	CHECKED BY:
BUILDING CONTRACTOR: ZECHER CONSTRUCTION	
FINAL DATE:	
JOB NUMBER:	
DRAWING NUMBER A-1	
OF 1 SHEETS	

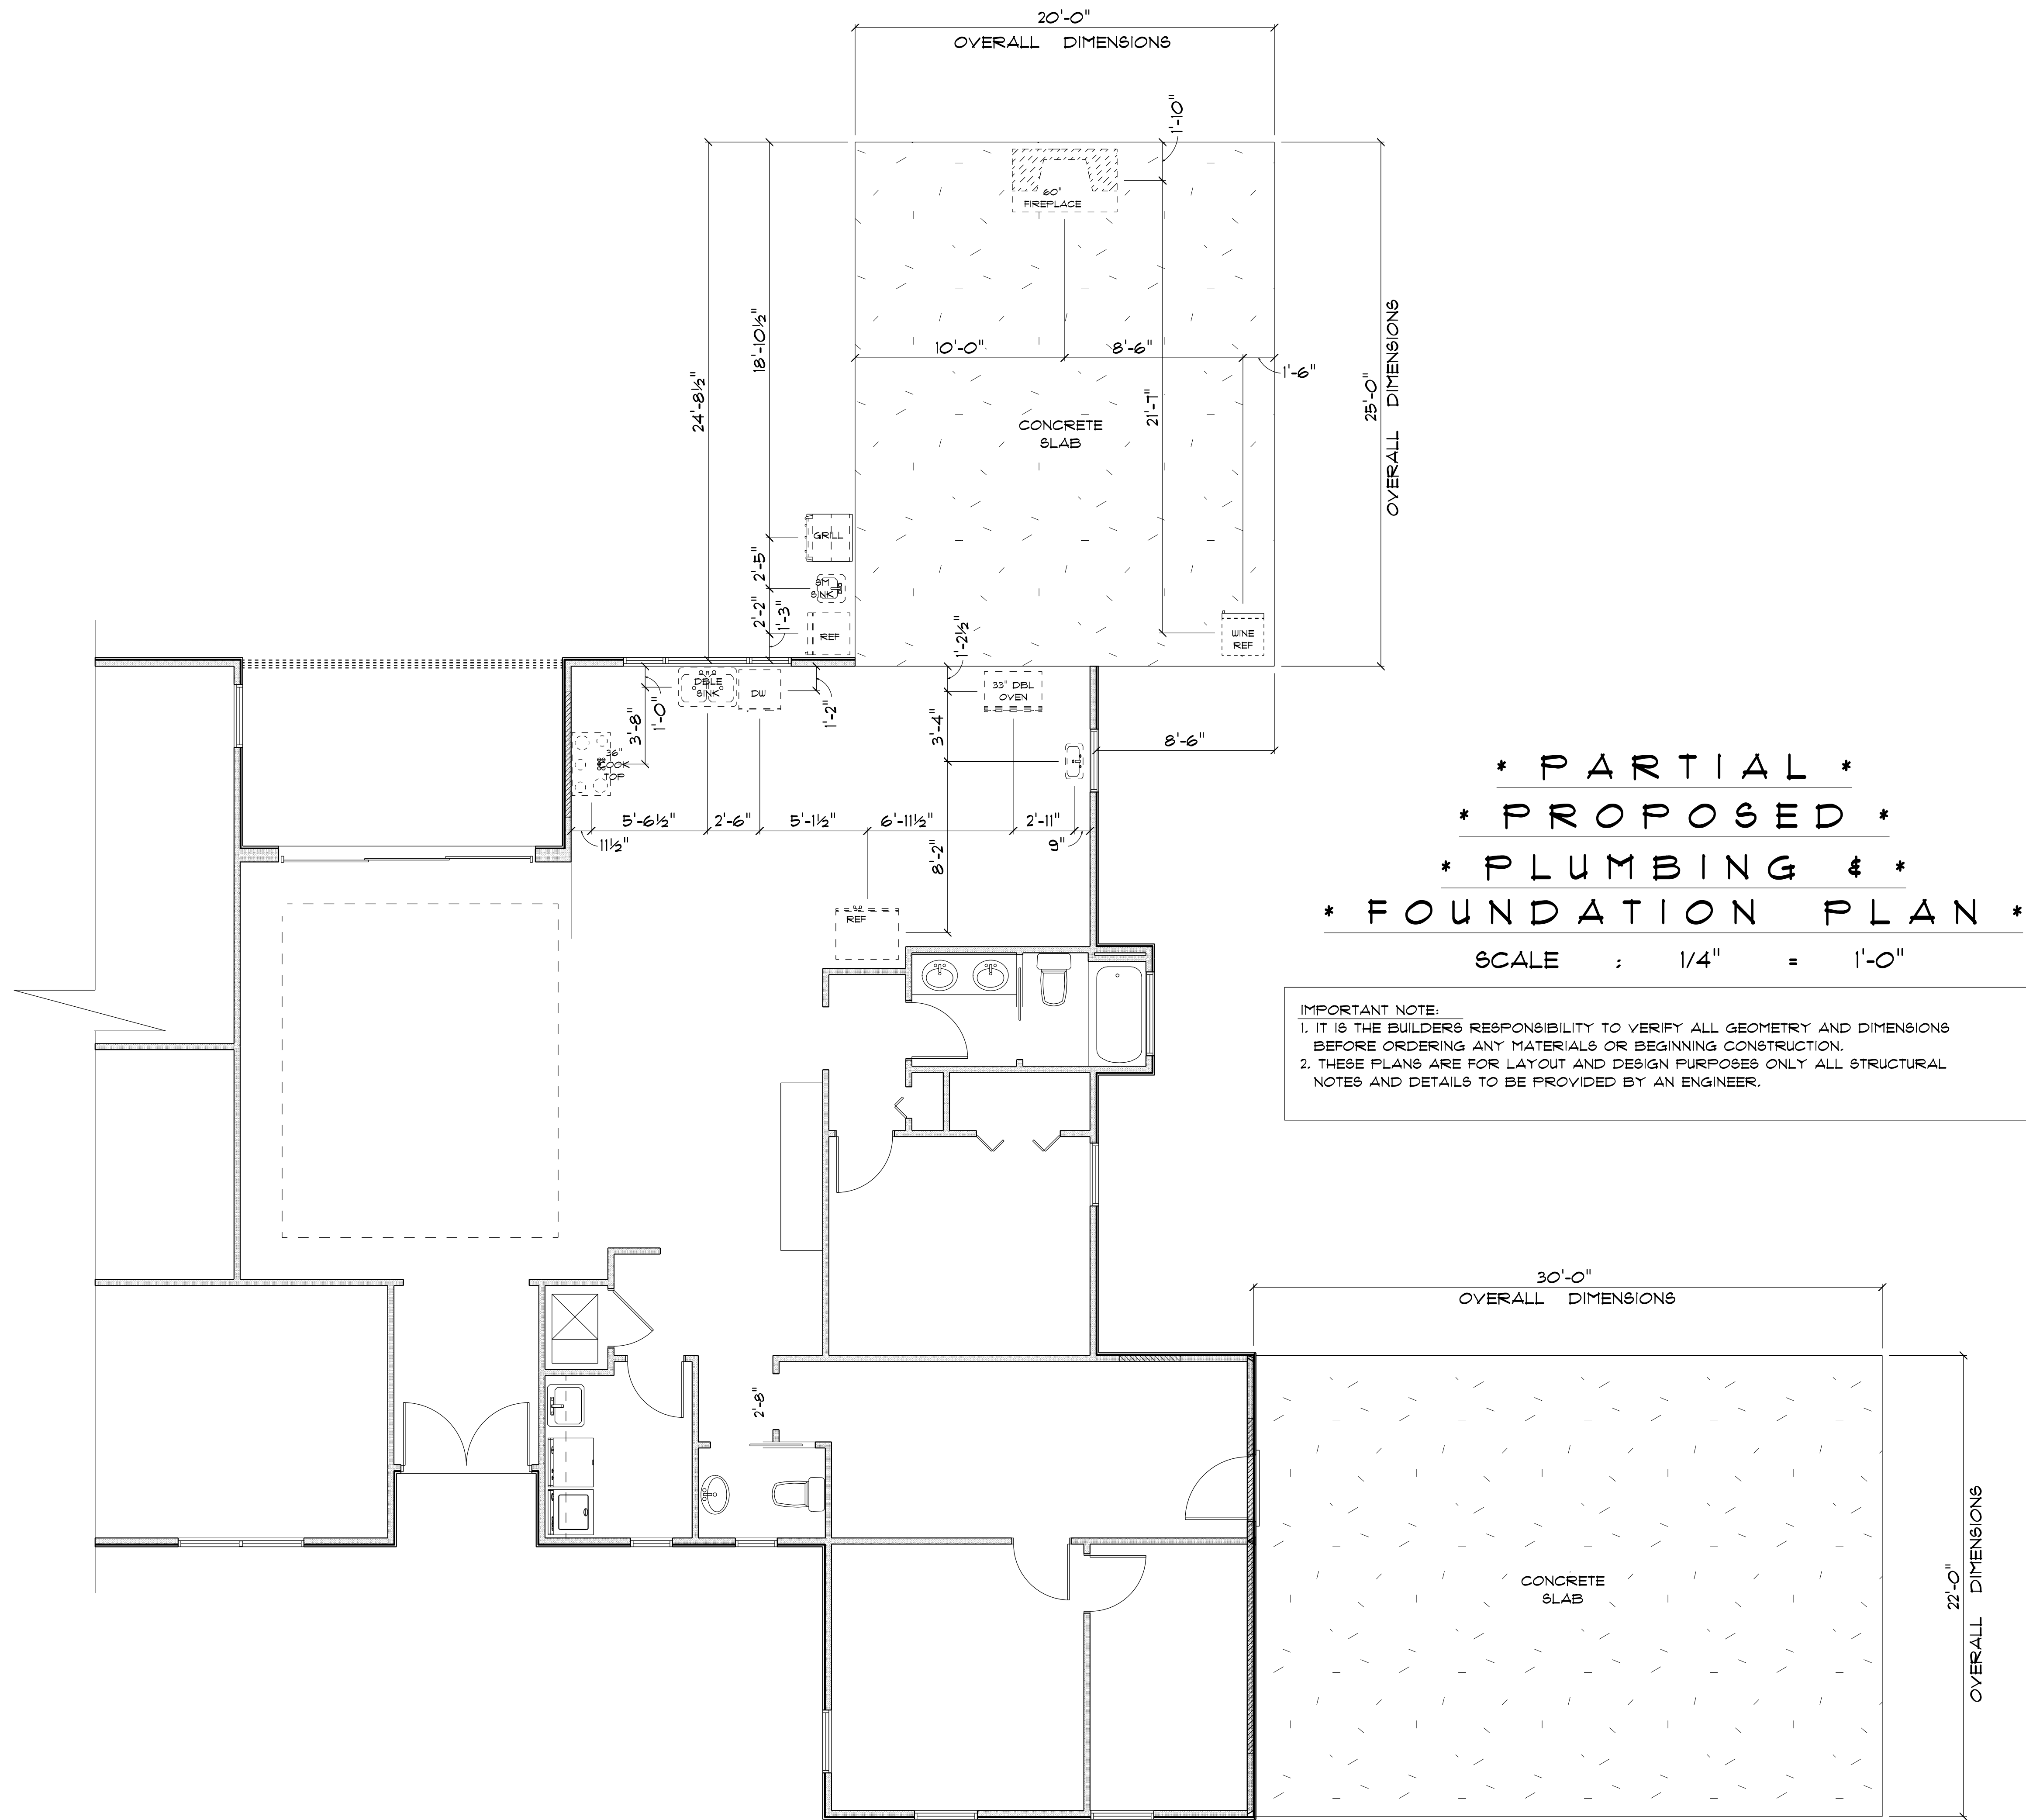

ADDITION
for
MARK & SARAH
LANE

830 SW MANDIBA DR
LAKE CITY, FLORIDA
32025

Teena M. Ruffo
2925 SW SR 47
Lake City Florida, 32025
Cell: (386) 861-1191
Email: teenaruffo@gmail.com

PRINTED DATE:
Friday, January 26, 2024

DRAWN BY: Teena M. Ruffo CHECKED BY:

BUILDING CONTRACTOR:
ZECHER CONSTRUCTION


FINAL DATE:

JOB NUMBER:

DRAWING NUMBER

A-2

OF 1 SHEETS

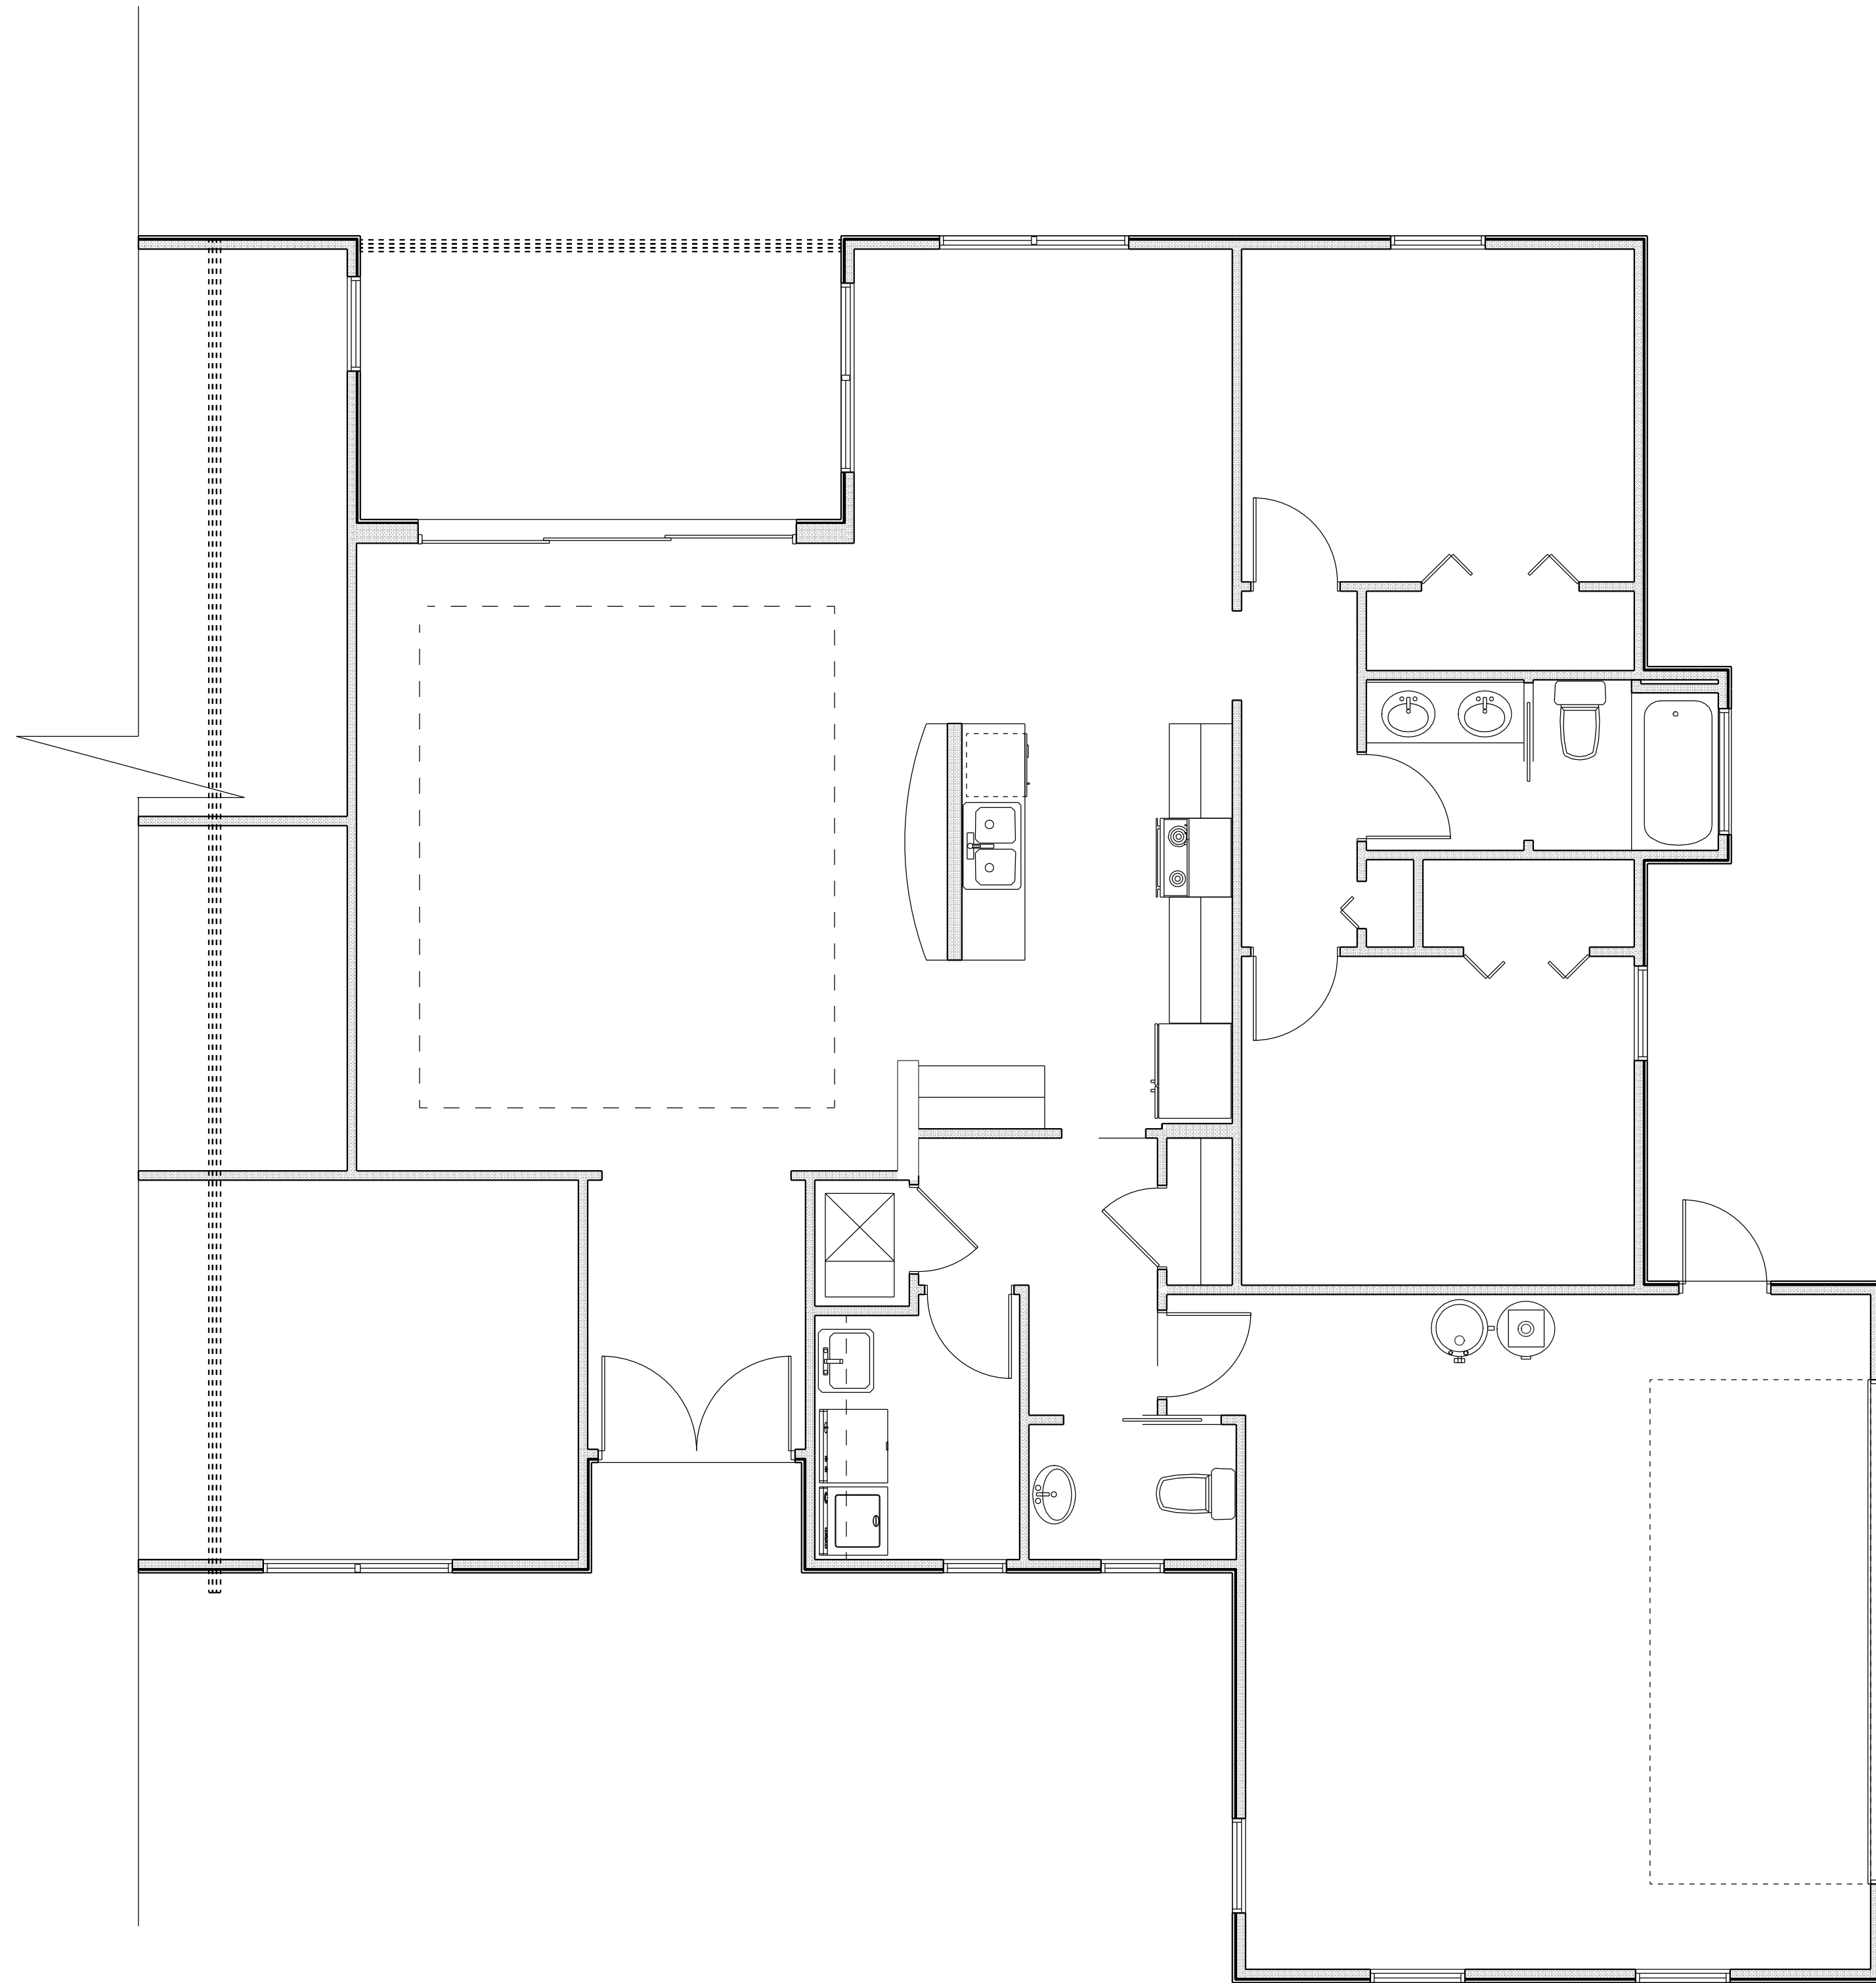

* PARTIAL *
* EXISTING *
* FLOOR PLAN *
SCALE : 1/4" = 1'-0"

ADDITION
for
MARK & SARAH
LANE

830 SW MANDIBA DR
LAKE CITY, FLORIDA
32025

Teena M. Ruffo
2925 SW SR 47
Lake City Florida, 32025
Cell: (386) 867-1191
Email: teenaruffo@gmail.com

PRINTED DATE:
Friday, January 26, 2024

DRAWN BY: Teena M. Ruffo
CHECKED BY:

BUILDING CONTRACTOR:
ZECHER CONSTRUCTION


FINAL DATE:

JOB NUMBER:

DRAWING NUMBER

A-3

OF 1 SHEETS

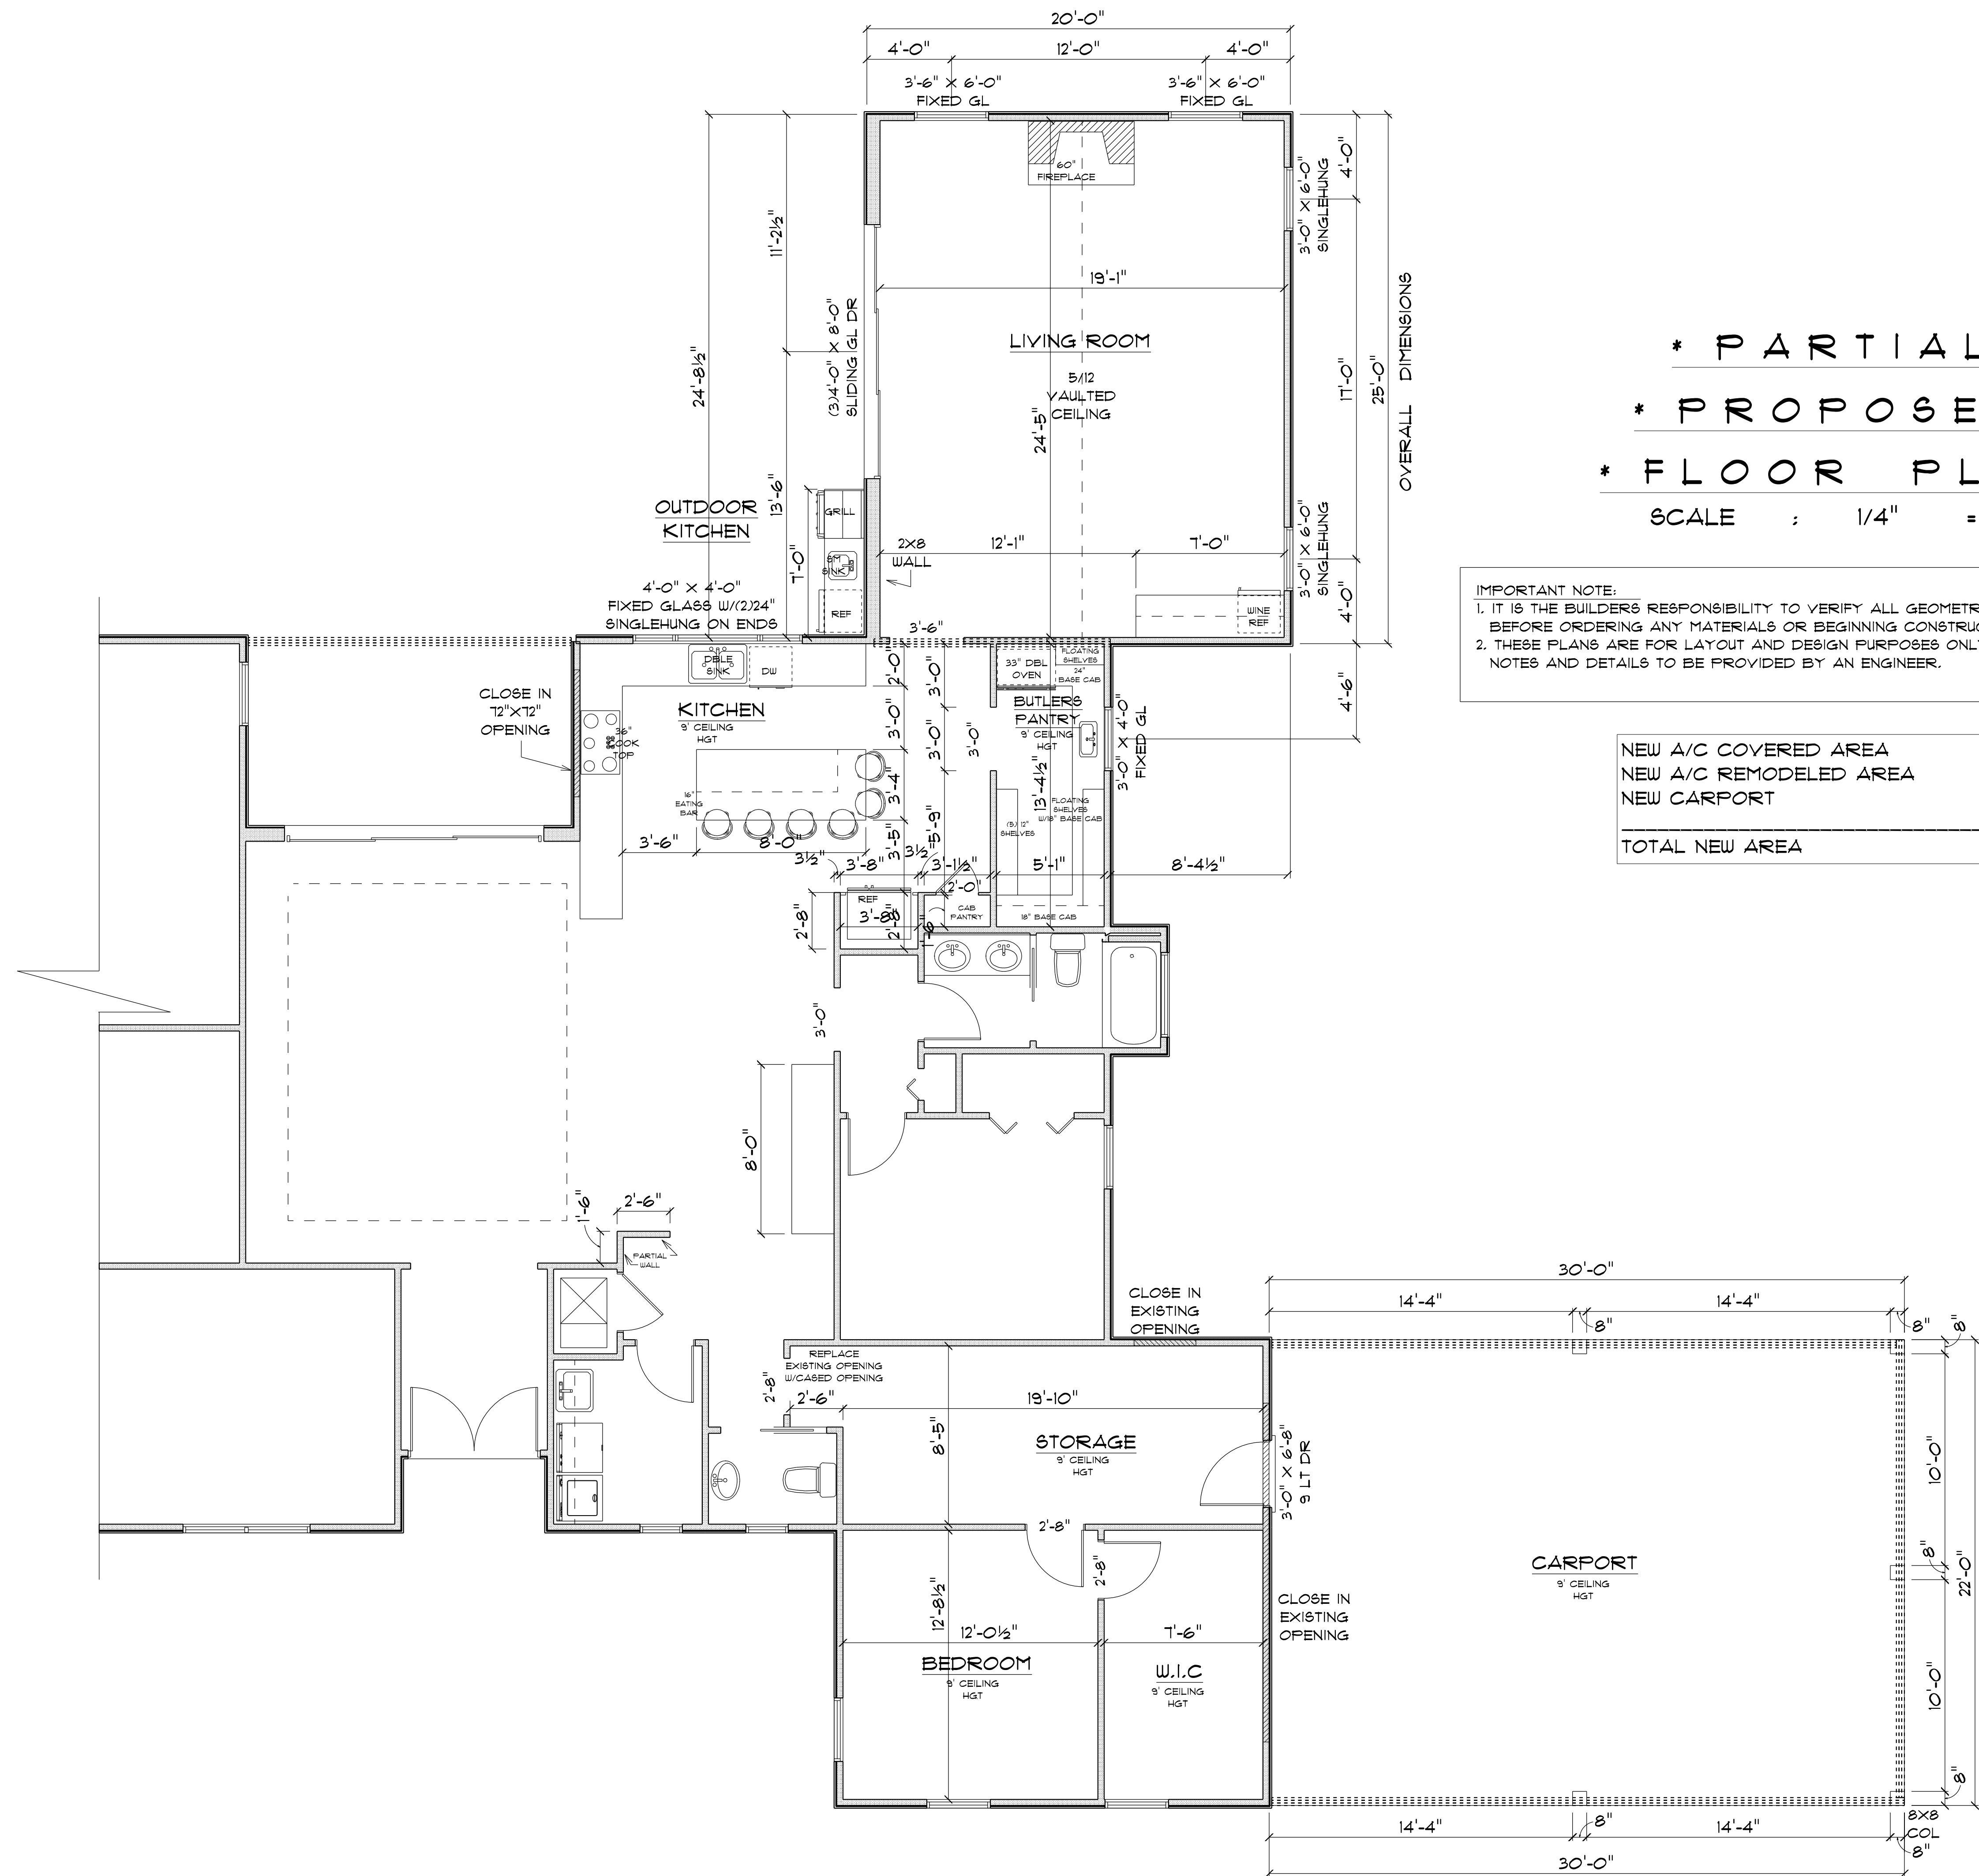

* PARTIAL *
* PROPOSED *
* FLOOR PLAN *
SCALE : 1/4" = 1'-0"

IMPORTANT NOTE:
1. IT IS THE BUILDERS RESPONSIBILITY TO VERIFY ALL GEOMETRY AND DIMENSIONS BEFORE ORDERING ANY MATERIALS OR BEGINNING CONSTRUCTION.
2. THESE PLANS ARE FOR LAYOUT AND DESIGN PURPOSES ONLY ALL STRUCTURAL NOTES AND DETAILS TO BE PROVIDED BY AN ENGINEER.

NEW A/C COVERED AREA	=	500	S.F.
NEW A/C REMODELED AREA	=	821	S.F.
NEW CARPORT	=	660	S.F.
TOTAL NEW AREA		=	1,981 S.F.

ADDITION
for
MARK & SARAH
LANE

830 SW MANDIBA DR
LAKE CITY, FLORIDA
32025

Teena M. Ruffo
2925 SW SR 41
Lake City Florida, 32025
Cell: (386) 861 - 1191
Email: teenaruffo@gmail.com

PRINTED DATE:
Friday, January 26, 2024

DRAWN BY: Teena M. Ruffo CHECKED BY:


BUILDING CONTRACTOR:
ZECHER CONSTRUCTION

FINAL DATE:


JOB NUMBER:

DRAWING NUMBER
A-4

OF 1 SHEETS

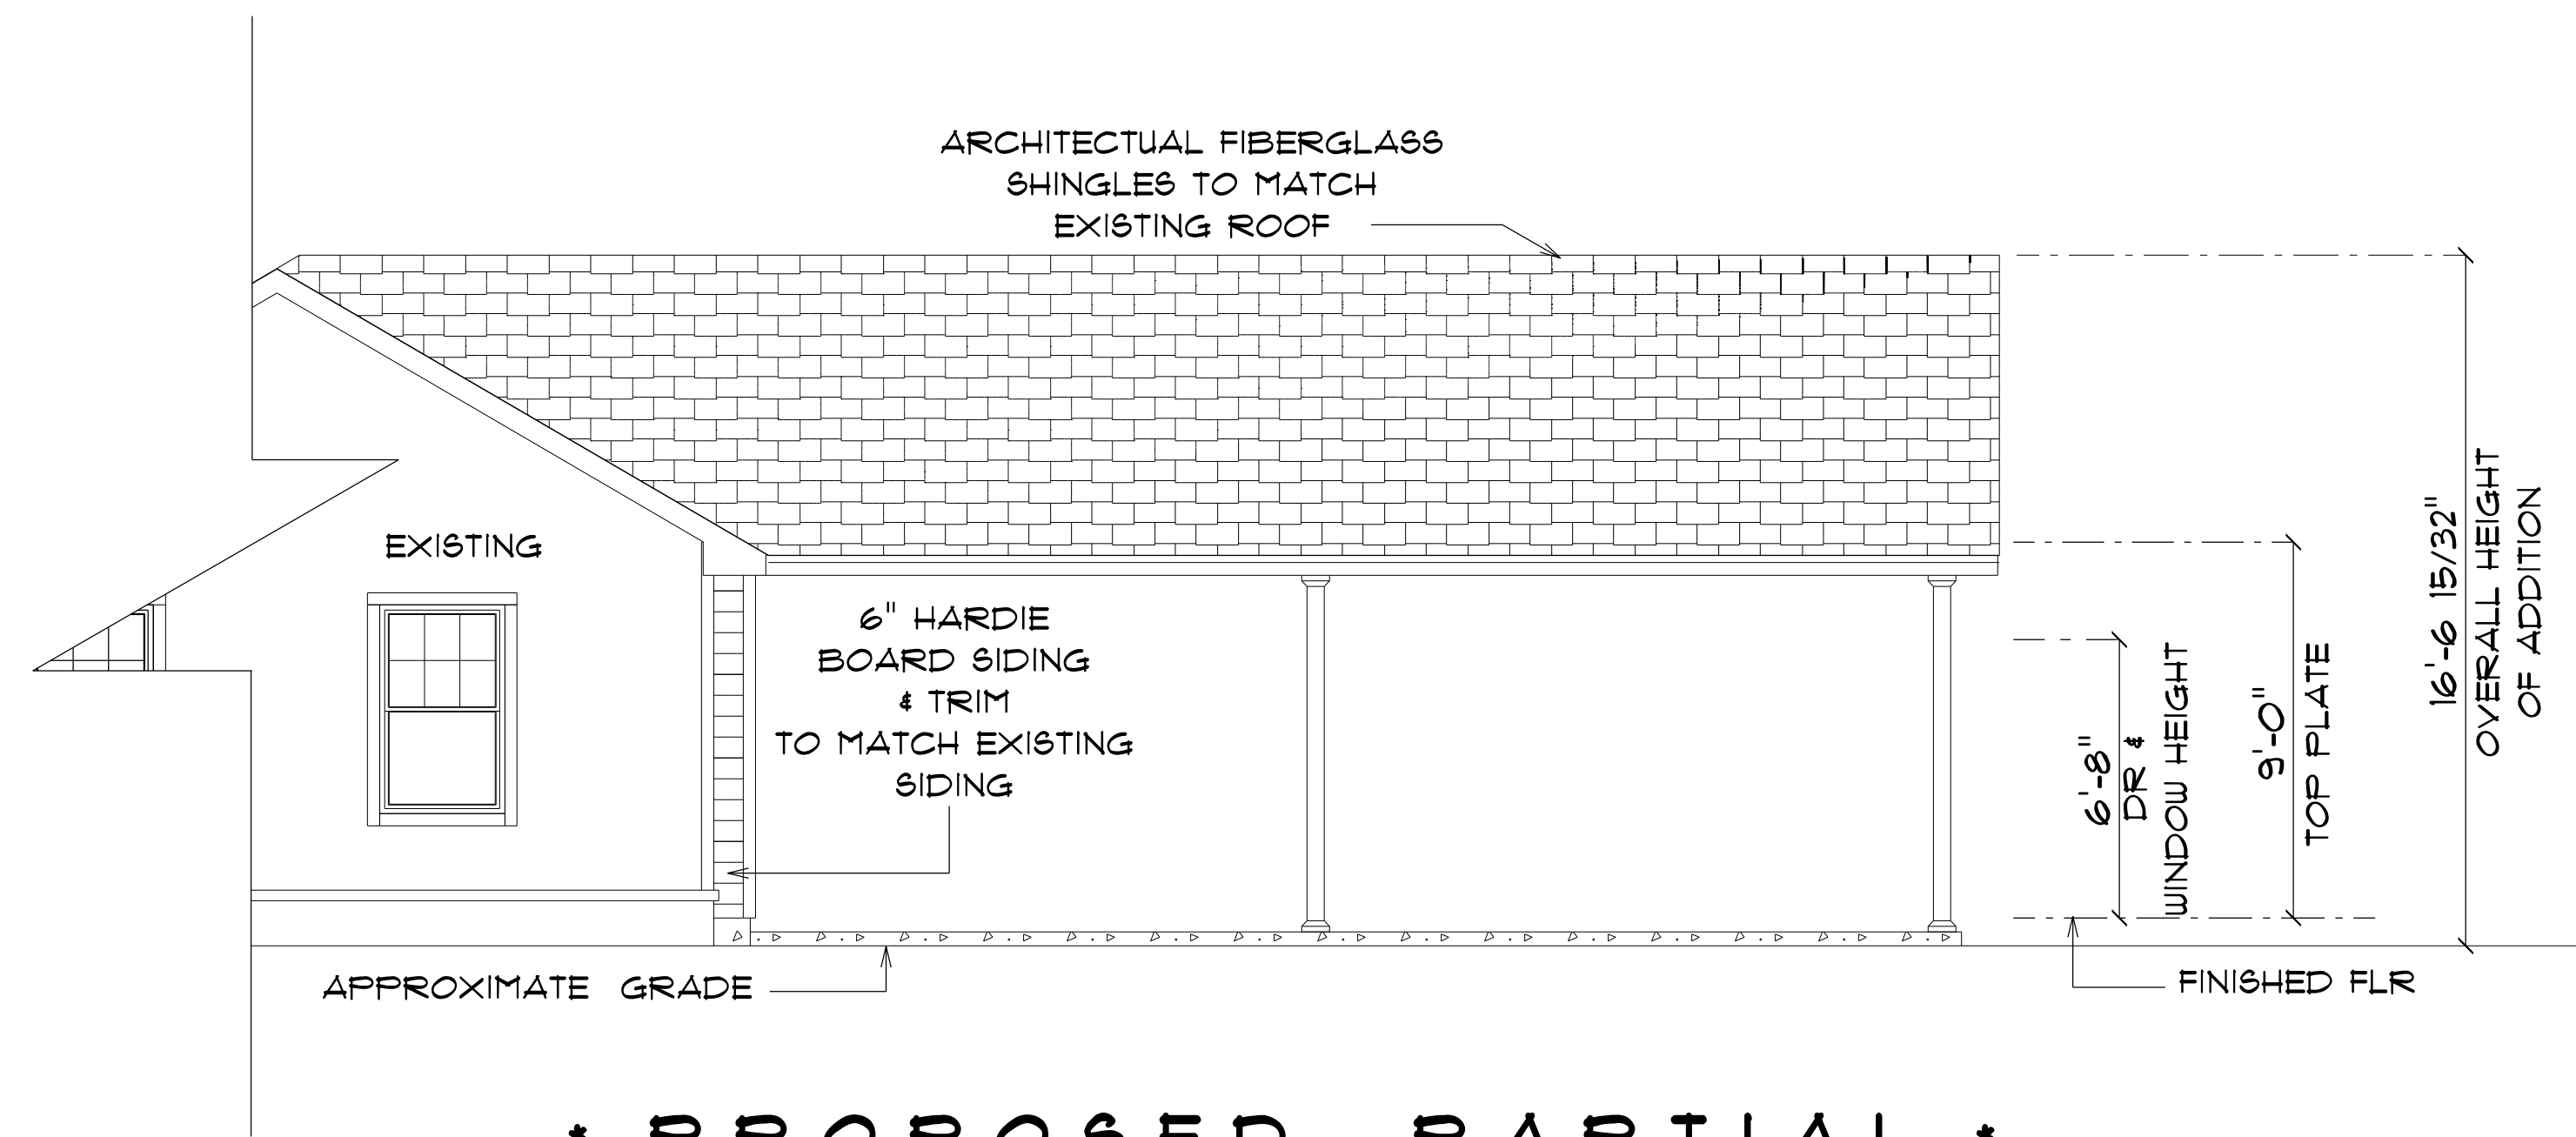

* PROPOSED PARTIAL *
* FRONT ELEVATION *
SCALE : 1/4" = 1'-0"

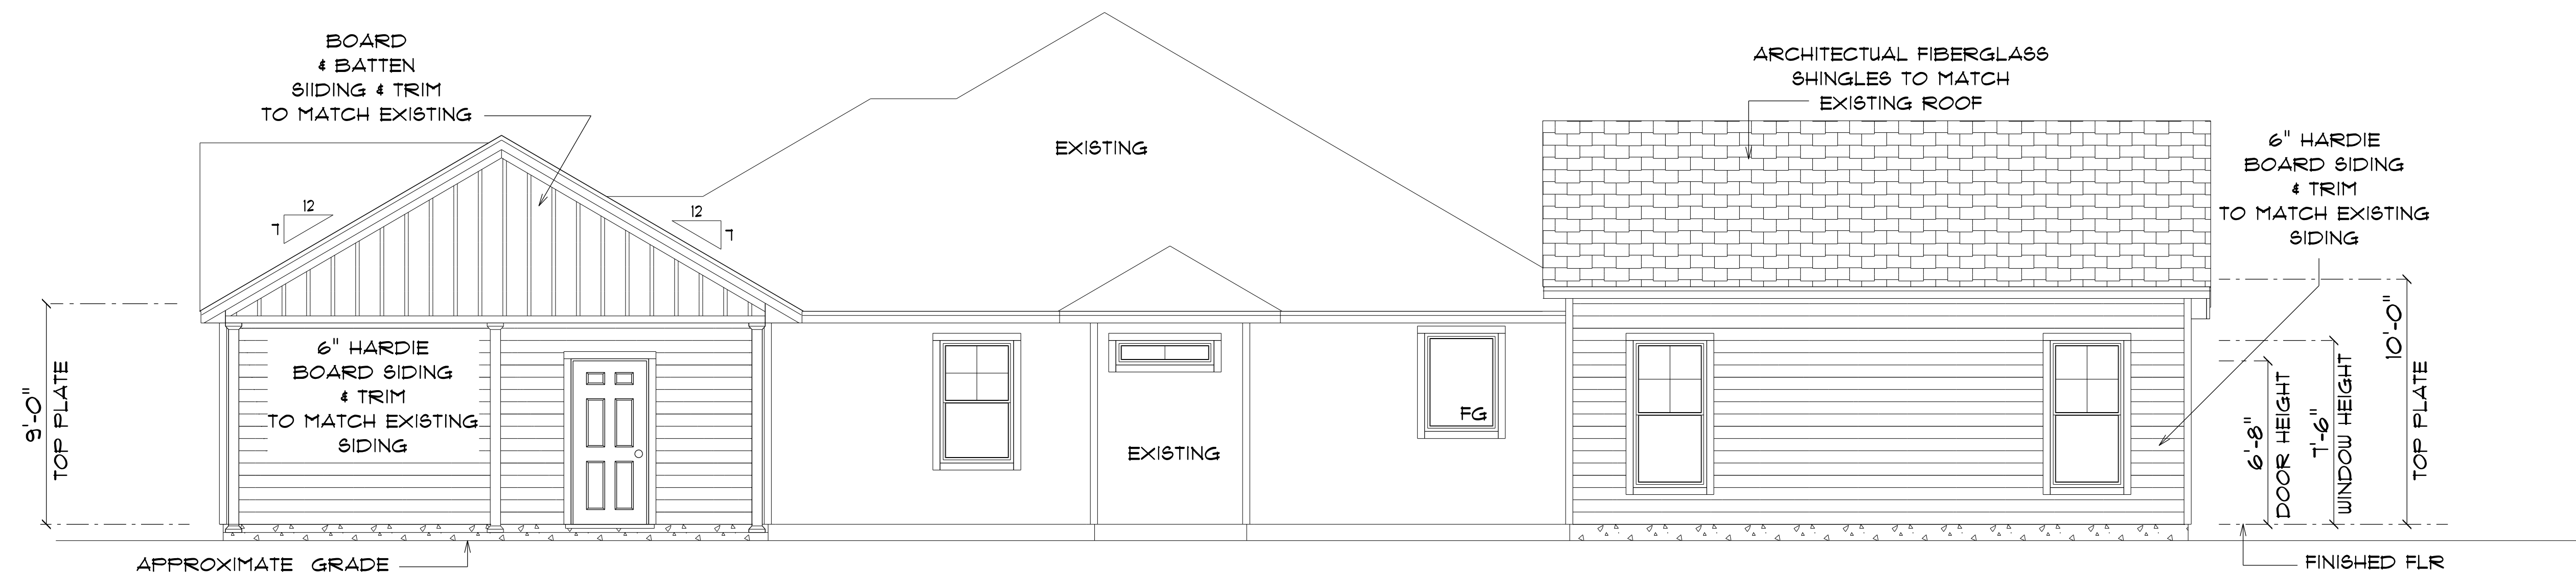

* PROPOSED PARTIAL *
* RIGHT ELEVATION *
SCALE : 1/4" = 1'-0"

ADDITION
for
MARK & SARAH
LANE

830 SW MANDIBA DR
LAKE CITY, FLORIDA
32025

Teena M. Ruffo
2925 SW SR 41
Lake City Florida, 32025
Cell: (386) 861-1191
Email: teenaruffo@gmail.com

PRINTED DATE:
Friday, January 26, 2024

DRAWN BY: Teena M. Ruffo CHECKED BY:

BUILDING CONTRACTOR:
ZECHER CONSTRUCTION


FINAL DATE:

JOB NUMBER:


DRAWING NUMBER

A-5

OF 1 SHEETS

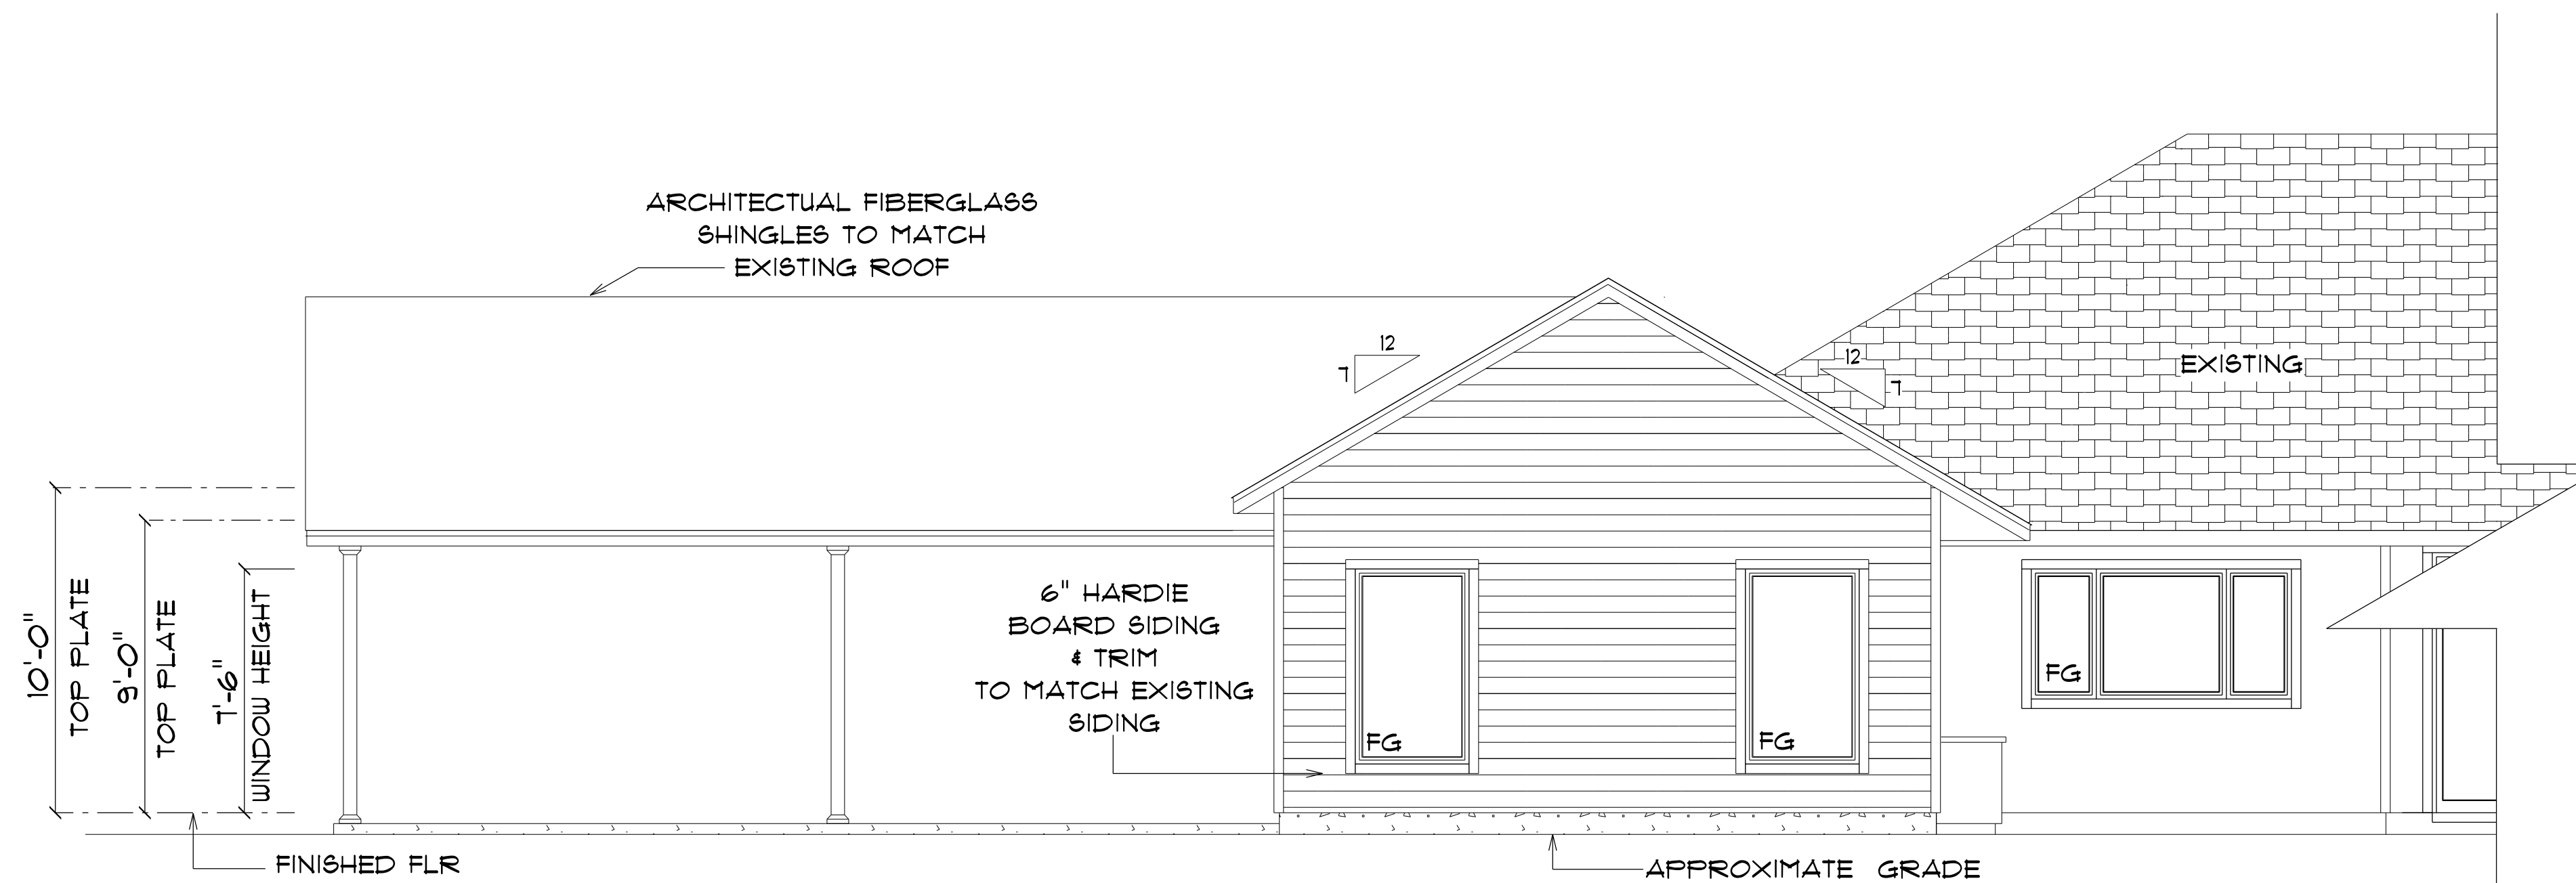

*** PROPOSED PARTIAL ***
*** REAR ELEVATION ***
 SCALE : 1/4" = 1'-0"

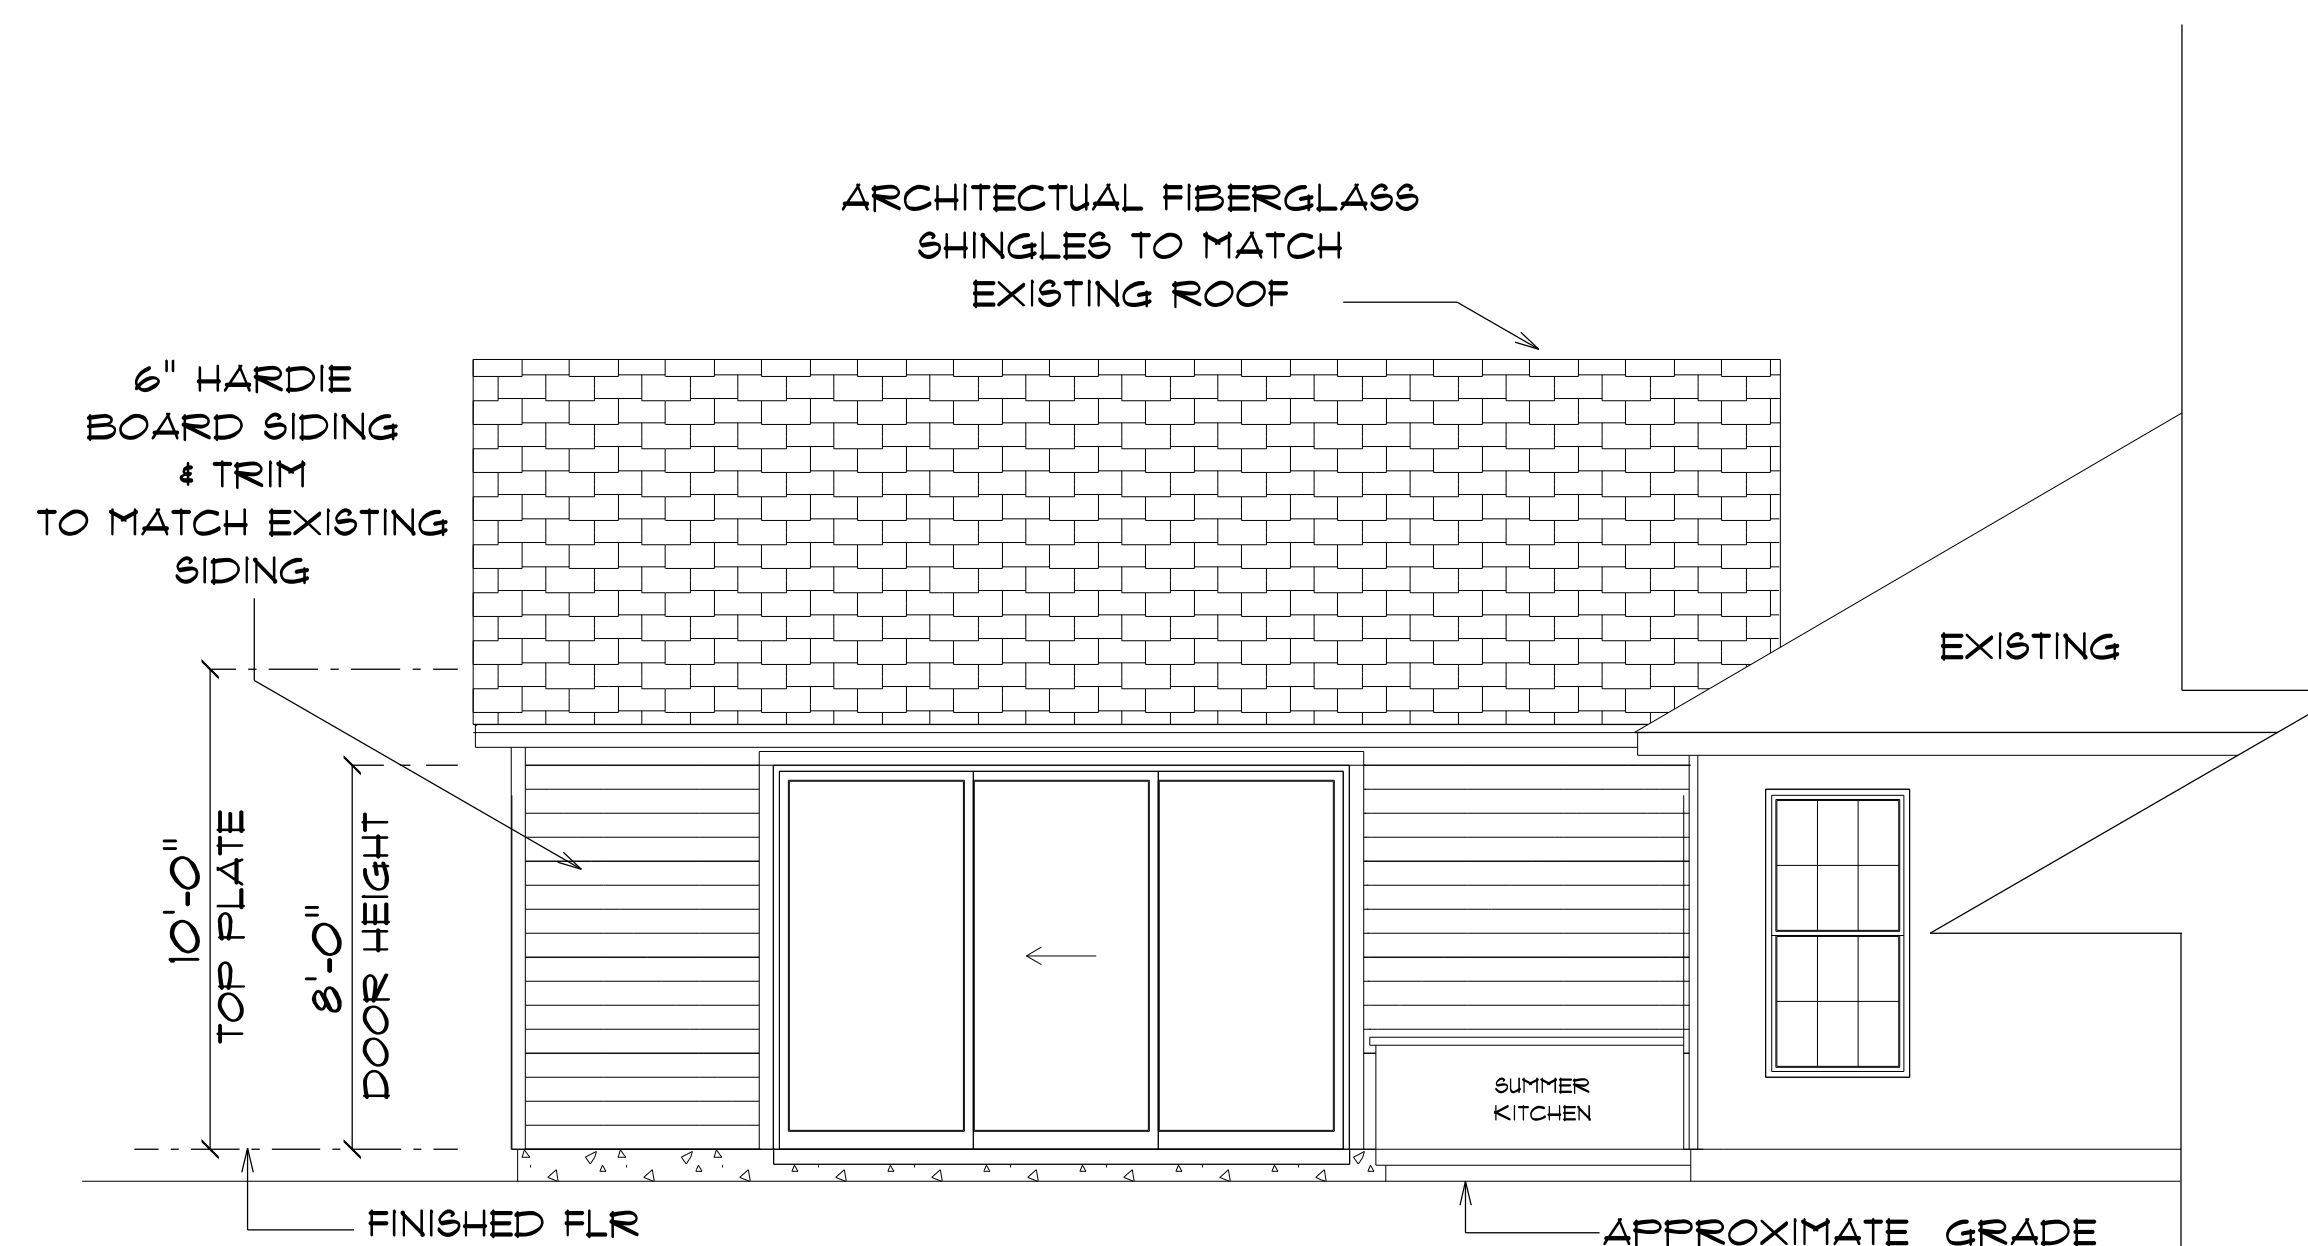

*** PROPOSED PARTIAL ***
*** LEFT ELEVATION ***
 SCALE : 1/4" = 1'-0"

ADDITION
for
MARK & SARAH
LANE

830 SW MANDIBA DR
 LAKE CITY, FLORIDA
 32025

Teena M. Ruffo
 2925 SW SR 41
 Lake City Florida, 32025
 Cell: (386) 861 - 1191
 Email: teenaruffo@gmail.com

PRINTED DATE:
 Friday, January 26, 2024

DRAWN BY: Teena M. Ruffo CHECKED BY:

BUILDING CONTRACTOR:
 ZECHER CONSTRUCTION


FINAL& DATE:

JOB NUMBER:

DRAWING NUMBER

A-6

OF 1 SHEETS

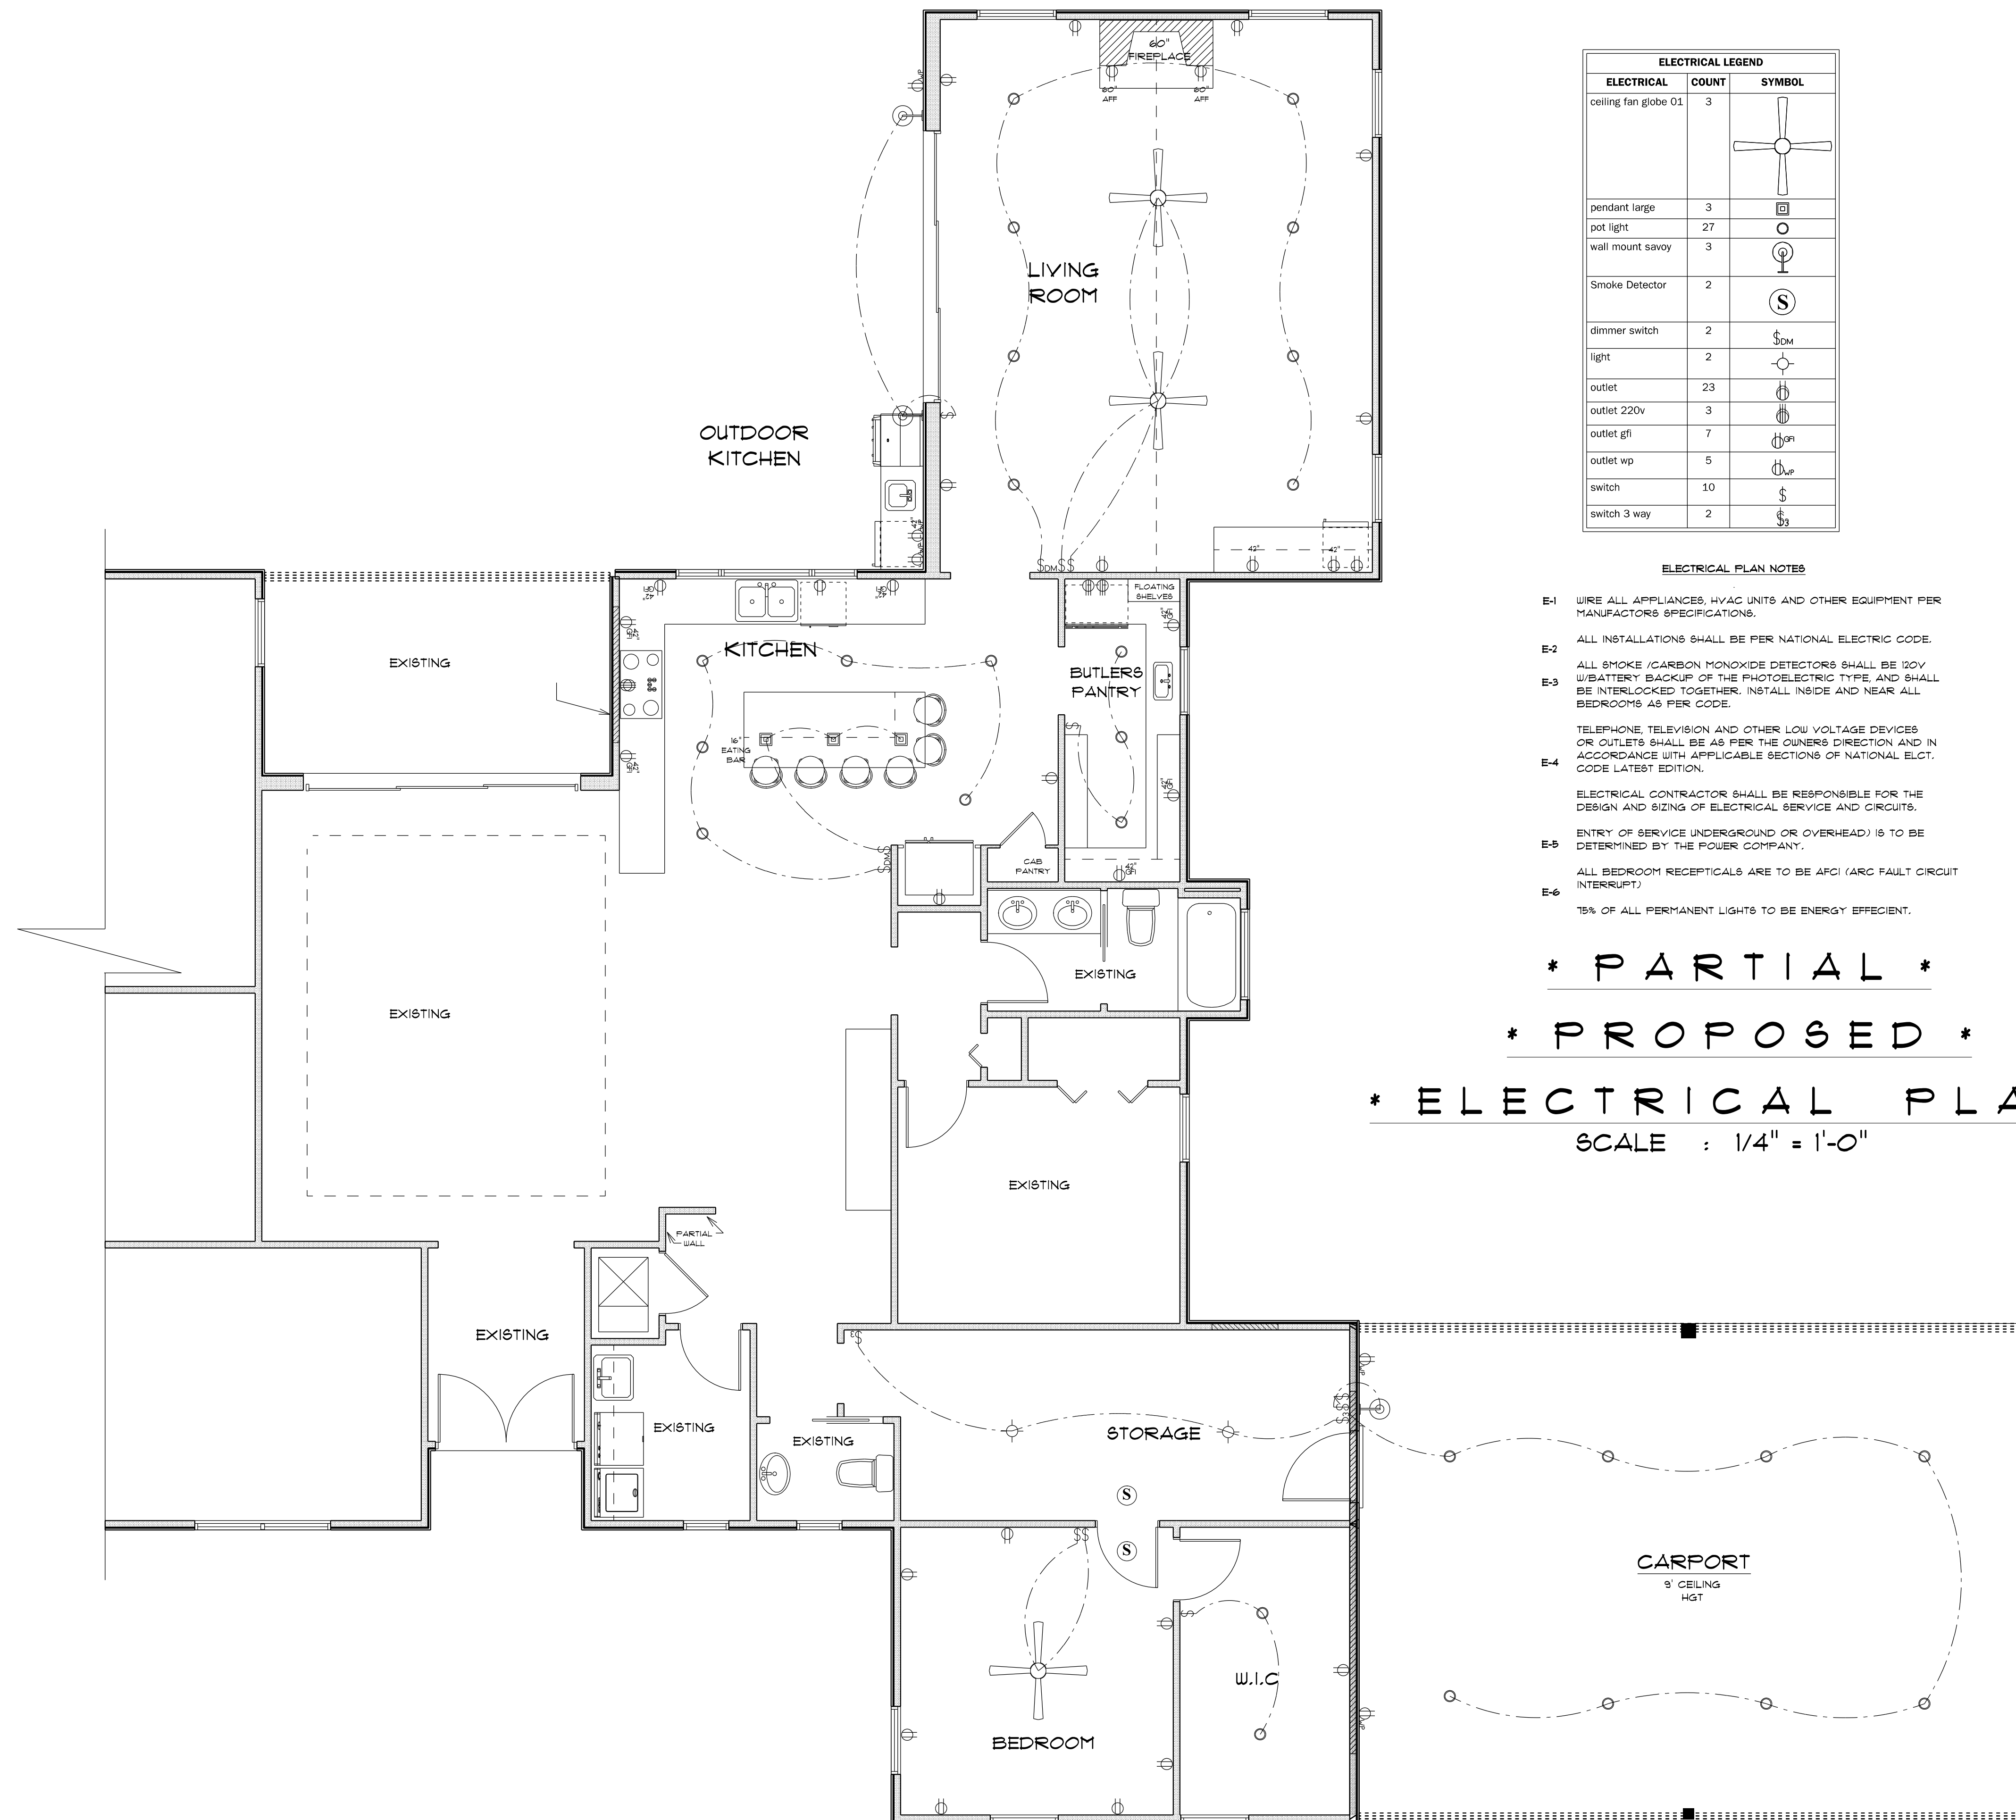

ELECTRICAL LEGEND		
ELECTRICAL	COUNT	SYMBOL
ceiling fan globe 01	3	
pendant large	3	
pot light	27	
wall mount savoy	3	
Smoke Detector	2	
dimmer switch	2	
light	2	
outlet	23	
outlet 220v	3	
outlet gfi	7	
outlet wp	5	
switch	10	
switch 3 way	2	

- E-1 WIRE ALL APPLIANCES, HVAC UNITS AND OTHER EQUIPMENT PER MANUFACTURERS SPECIFICATIONS.
- E-2 ALL INSTALLATIONS SHALL BE PER NATIONAL ELECTRIC CODE.
- E-3 ALL SMOKE /CARBON MONOXIDE DETECTORS SHALL BE 120V, W/BATTERY BACKUP OF THE PHOTOELECTRIC TYPE, AND SHALL BE INTERLOCKED TOGETHER. INSTALL INSIDE AND NEAR ALL BEDROOMS AS PER CODE.
- E-4 TELEPHONE, TELEVISION AND OTHER LOW VOLTAGE DEVICES OR OUTLETS SHALL BE AS PER THE OWNERS DIRECTION AND IN ACCORDANCE WITH APPLICABLE SECTIONS OF NATIONAL ELCT. CODE LATEST EDITION.
- E-5 ELECTRICAL CONTRACTOR SHALL BE RESPONSIBLE FOR THE DESIGN AND SIZING OF ELECTRICAL SERVICE AND CIRCUITS.
- E-6 ENTRY OF SERVICE UNDERGROUND OR OVERHEAD) IS TO BE DETERMINED BY THE POWER COMPANY.
- E-7 ALL BEDROOM RECEPTALS ARE TO BE AFCI (ARC FAULT CIRCUIT INTERRUPT)
- E-8 15% OF ALL PERMANENT LIGHTS TO BE ENERGY EFFICIENT.

* PARTIAL *

* PROPOSED *

* ELECTRICAL PLAN *

SCALE : 1/4" = 1'-0"

ADDITION
for
MARK & SARAH
LANE

830 SW MANDIBA DR
LAKE CITY, FLORIDA
32025

Teena M. Ruffo
2925 SW SR 47
Lake City Florida, 32025
Cell: (386) 861 - 1191
Email: teenaruffo@gmail.com

PRINTED DATE:
Friday, January 26, 2024

DRAWN BY: Teena M. Ruffo CHECKED BY:

BUILDING CONTRACTOR:
ZECHER CONSTRUCTION

FINAL& DATE:

JOB NUMBER:

DRAWING NUMBER

A-1

OF 1 SHEETS