



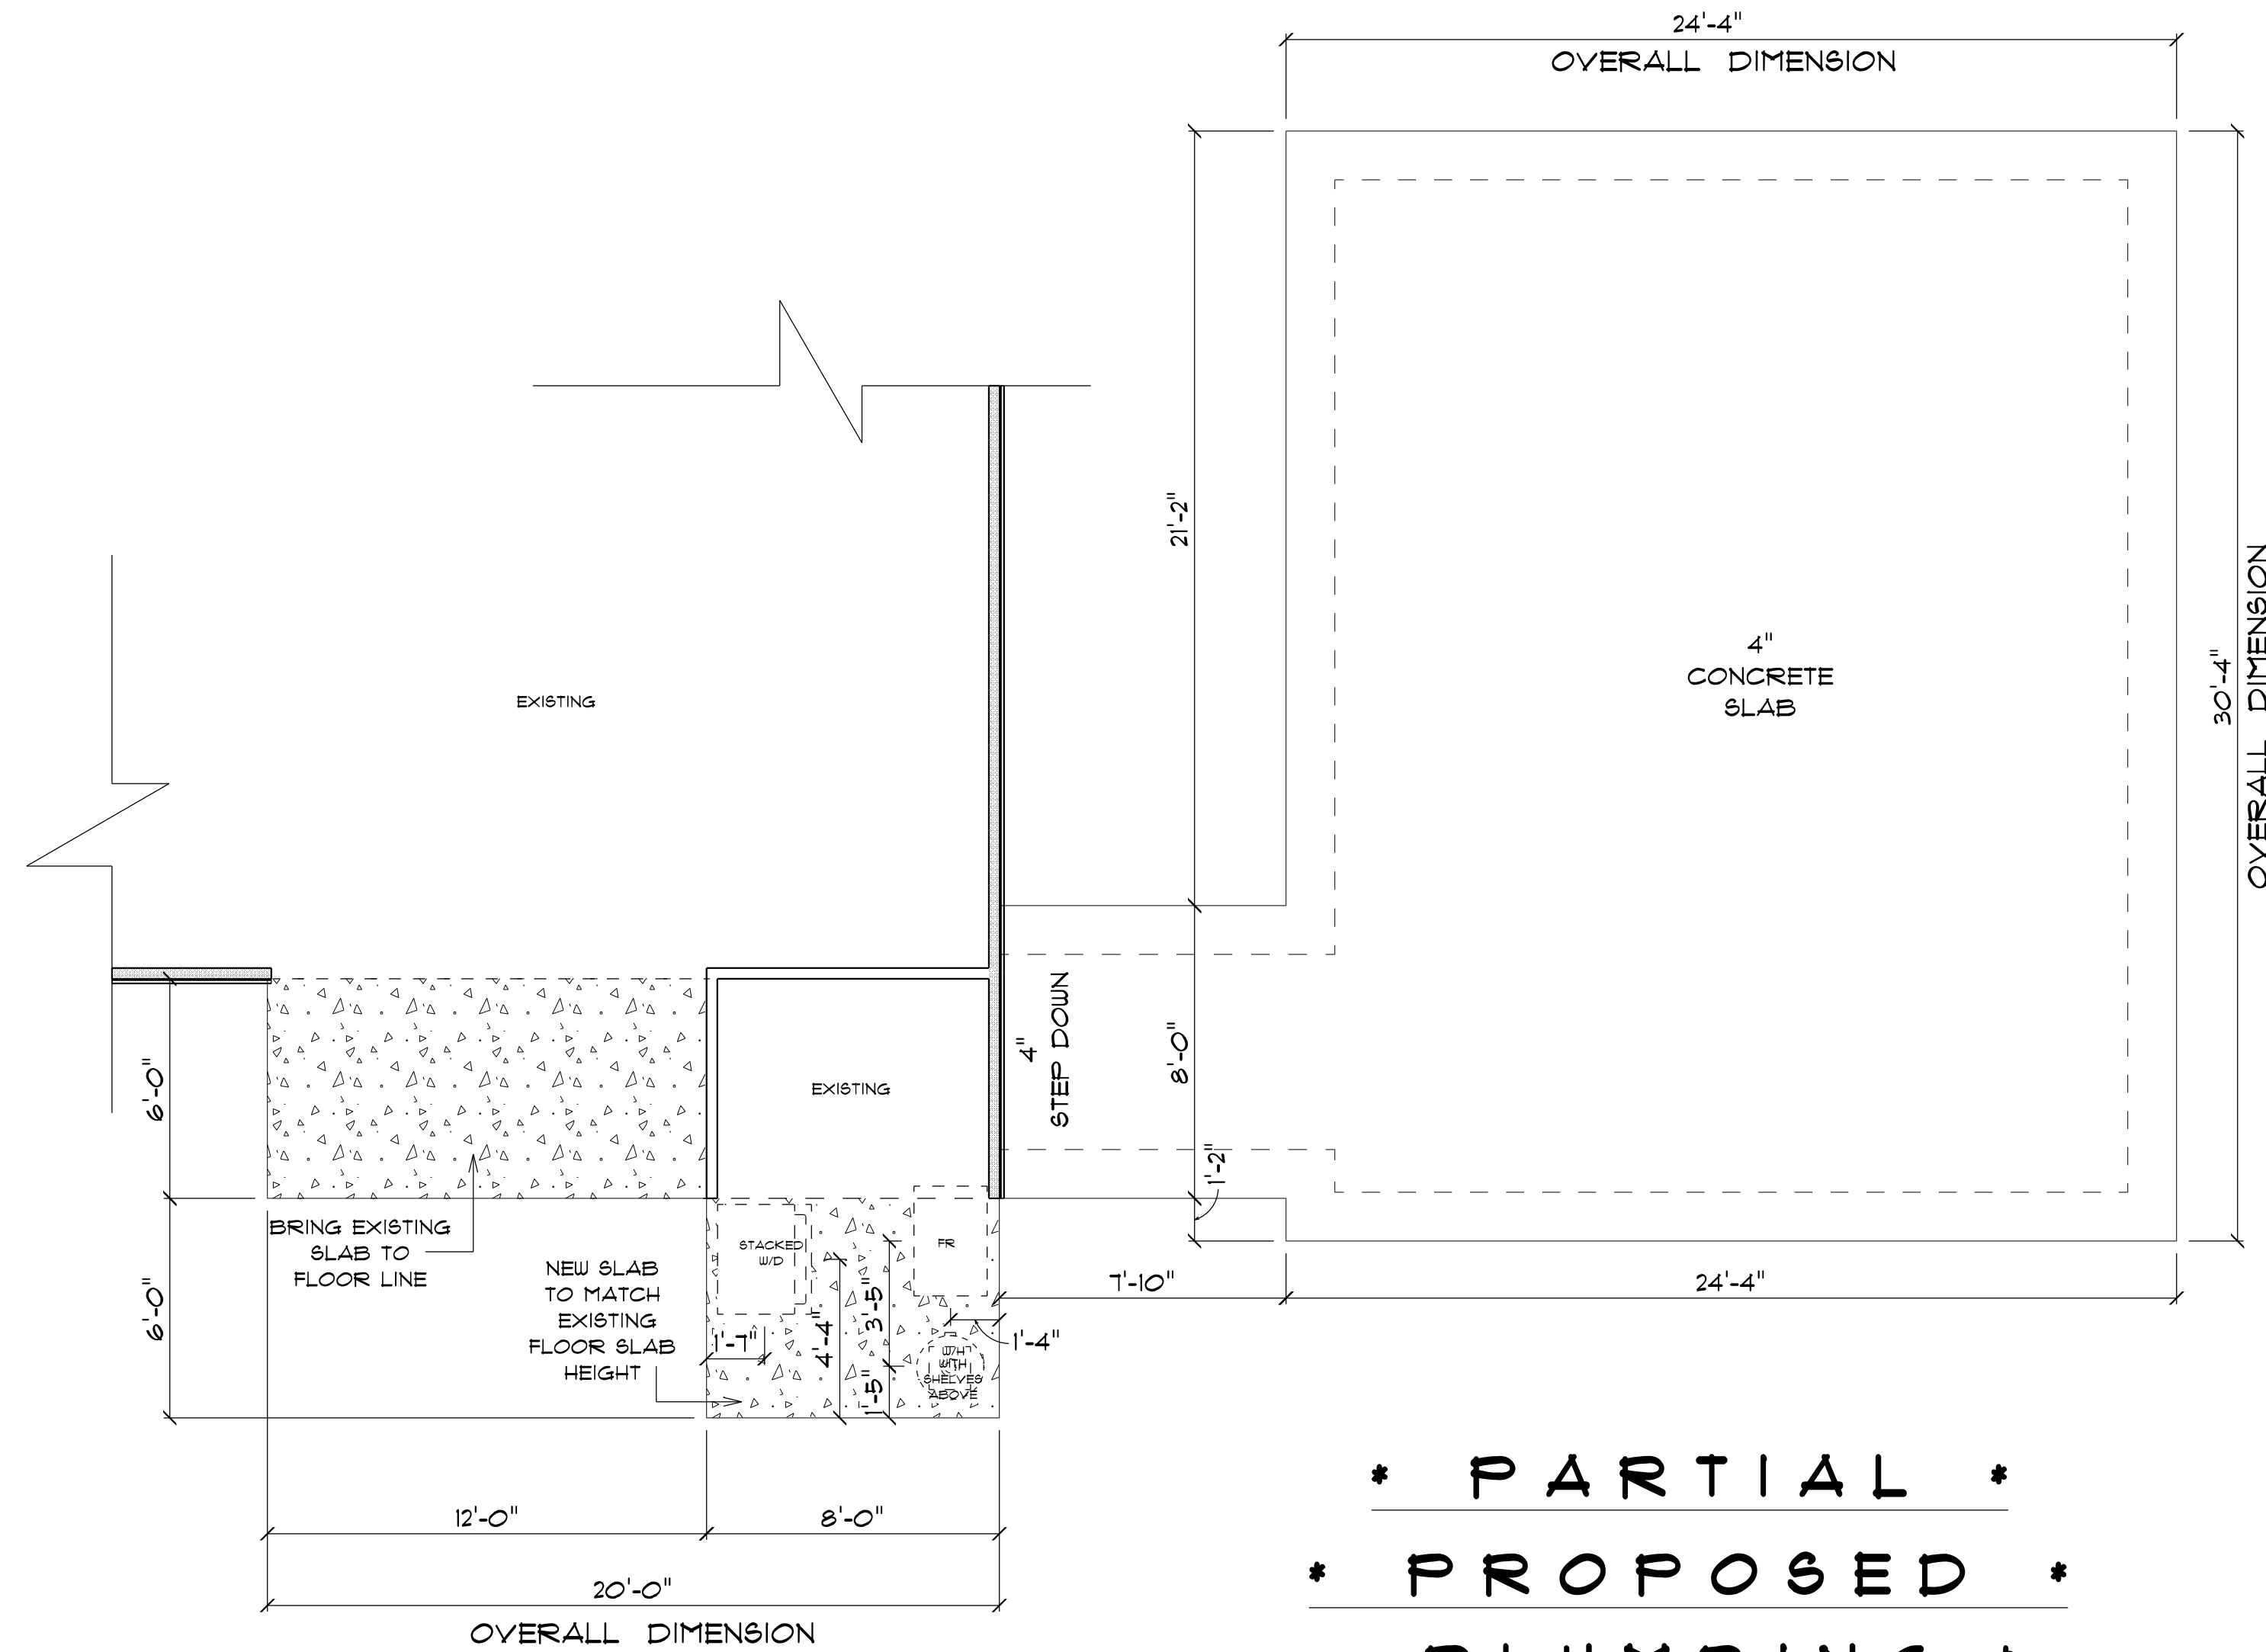

* PARTIAL *
* PROPOSED *
* PLUMBING & *
* FOUNDATION PLAN & *
SCALE : 1/4" = 1'-0"

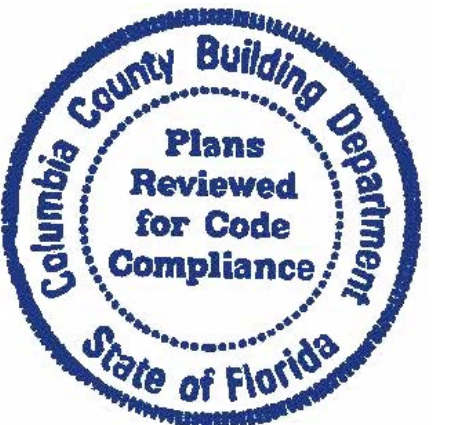

ADDITION
for
SUE & RANDY
FRAZE

LAKE CITY, FL

Teena M. Ruffo
2925 SW SR 47
Lake City Florida, 32025
Cell: (386) 867-1191
Email: teenaruffo@gmail.com

PRINTED DATE:
Friday, January 6, 2023

DRAWN BY: Teena M. Ruffo CHECKED BY:

BUILDING CONTRACTOR
Roger Whiddon


FINAL& DATE:

JOB NUMBER:

DRAWING NUMBER

A-1



OF 4 SHEET(S)

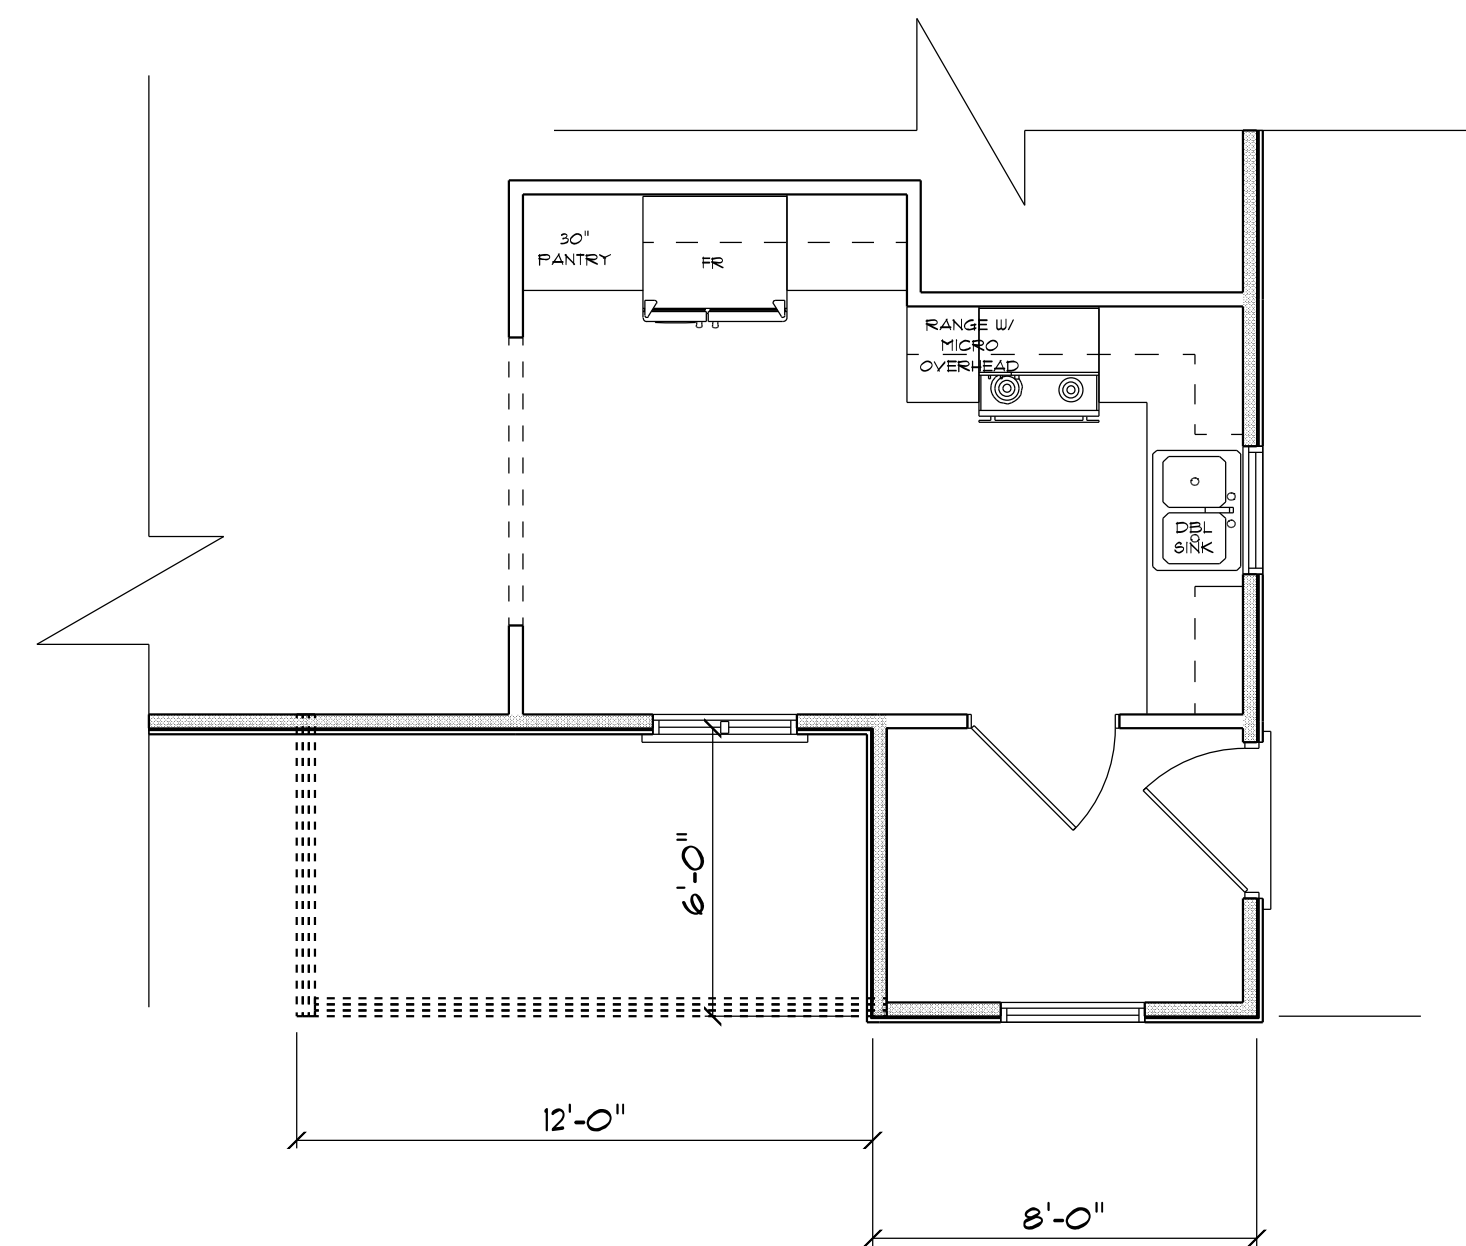

* PARTIAL *
* EXISTING *
* FLOOR PLAN *

SCALE : 1/4" = 1'-0"

LEGEND	
EXISTING EXTERIOR WALL	=
EXISTING INTERIOR WALL	=

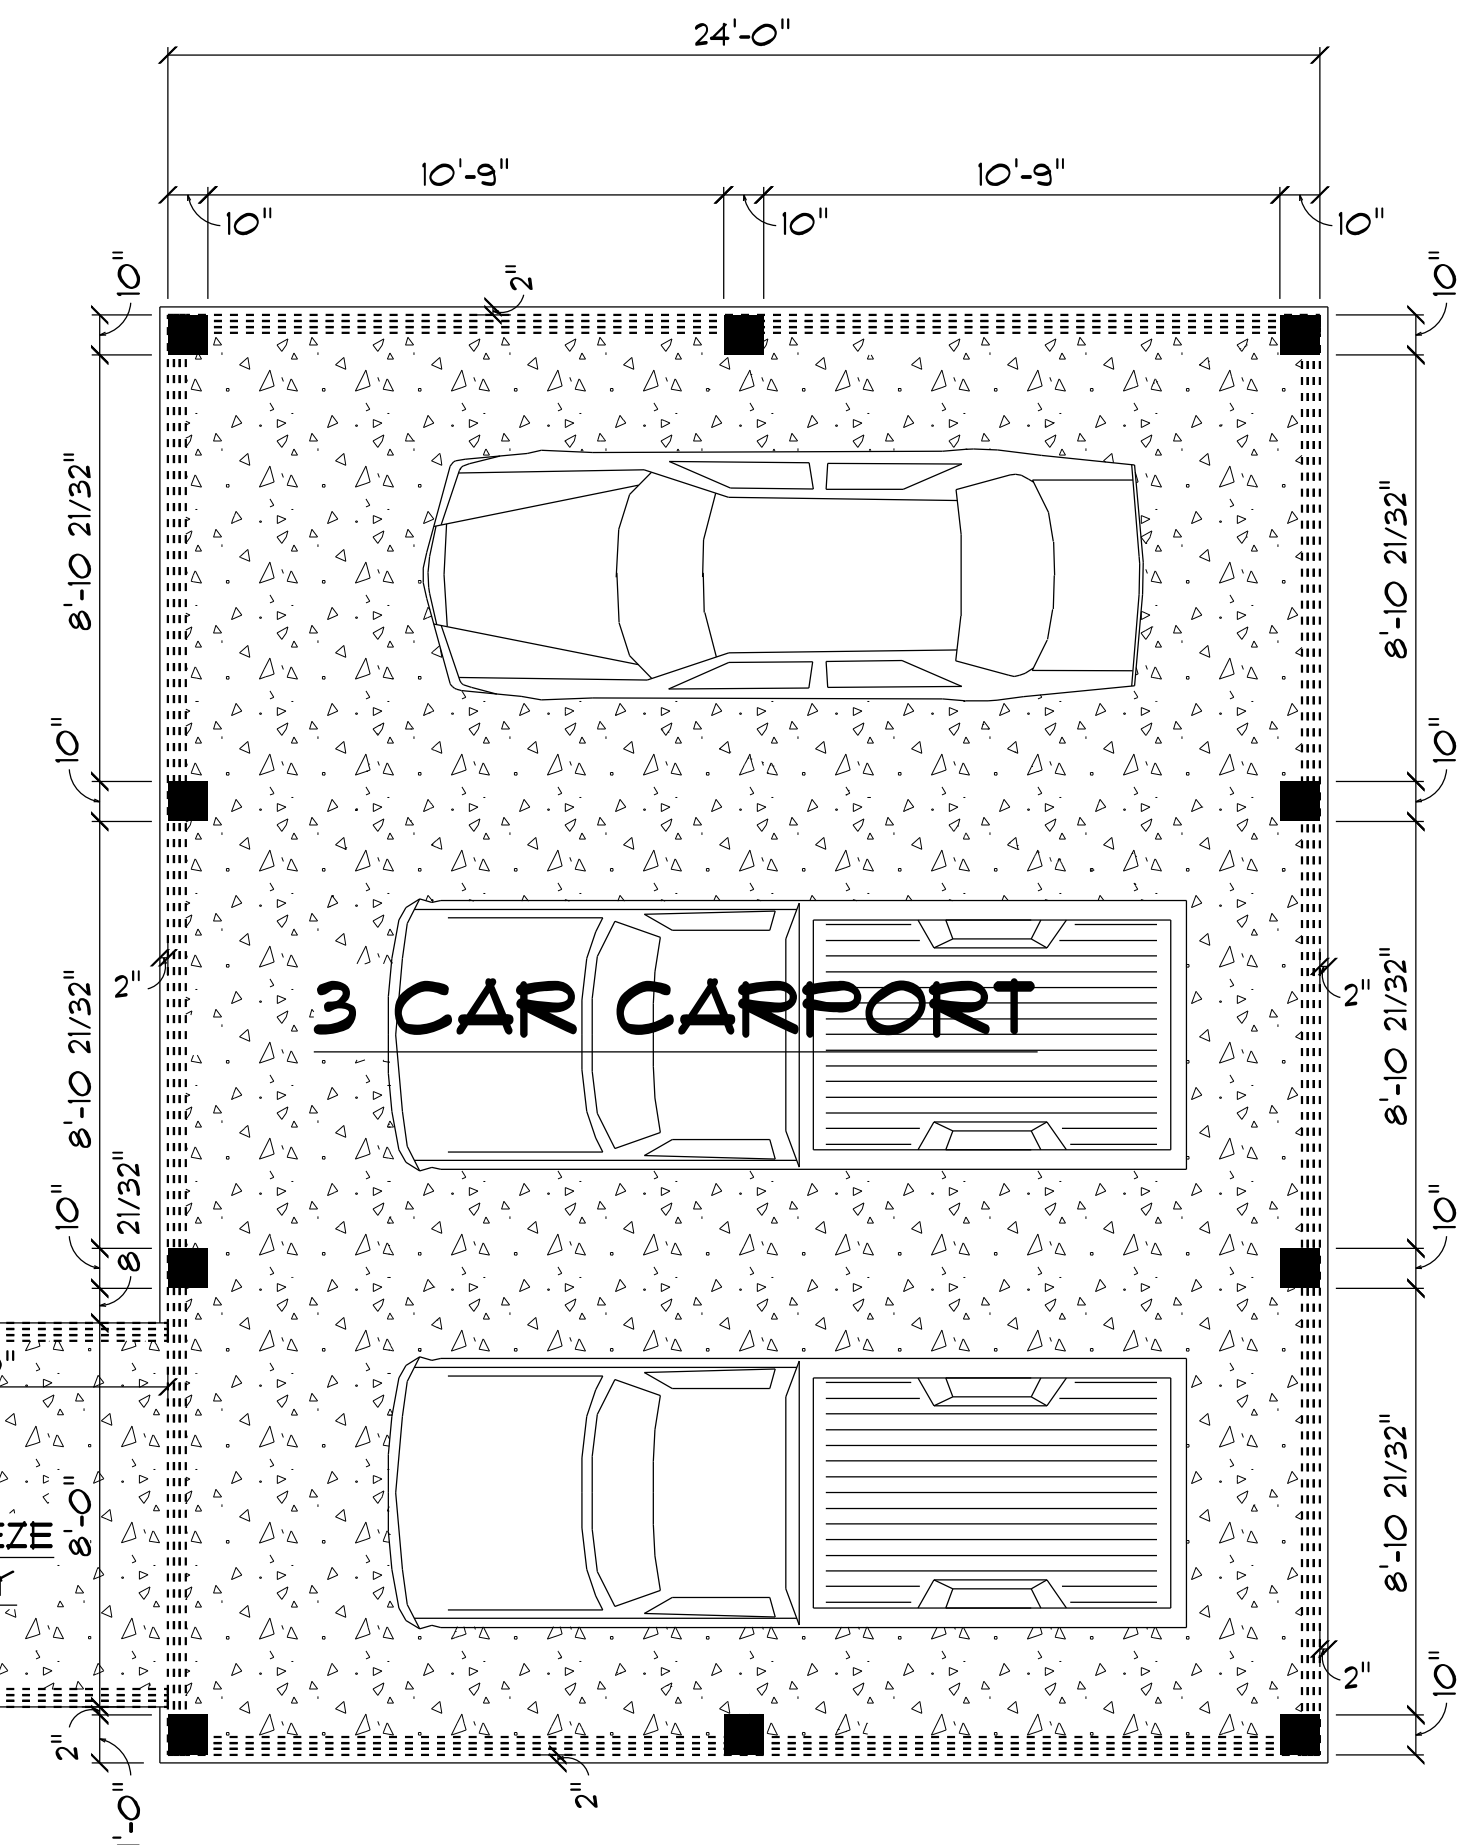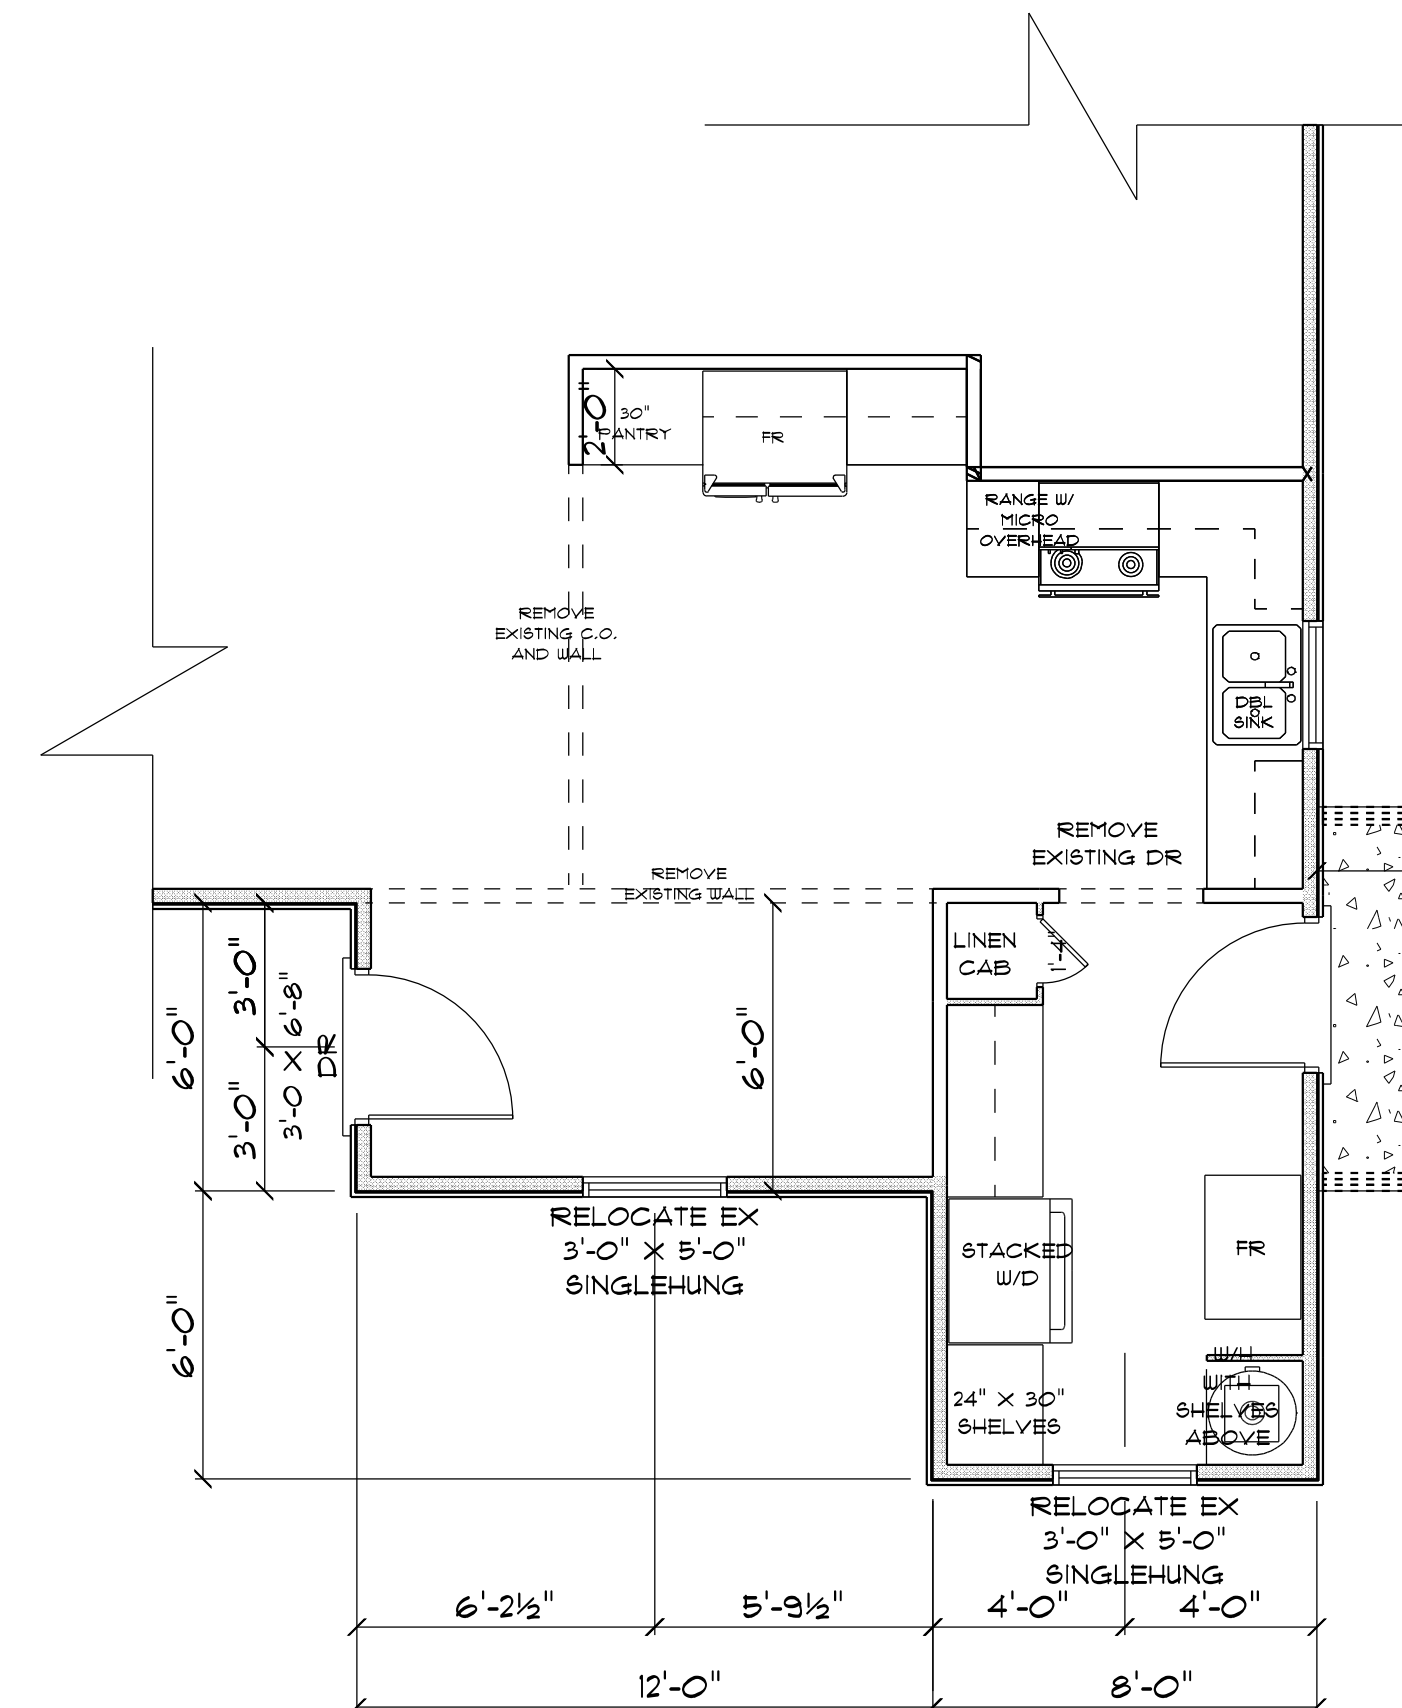

* PARTIAL *
* PROPOSED *
* FLOOR PLAN *

SCALE : 1/4" = 1'-0"

LEGEND	
EXISTING EXTERIOR WALL	=
EXISTING INTERIOR WALL	=

ADDITION
for
SUE & RANDY
FRAZE

LAKE CITY, FL

Teena M. Ruffo
2925 SW SR 47
Lake City Florida, 32025
Cell: (386) 867-1191
Email: teenaruffo@gmail.com

PRINTED DATE:
Friday, January 6, 2023

DRAWN BY: Teena M. Ruffo CHECKED BY:

BUILDING CONTRACTOR
Roger Whiddon


FINAL DATE:

JOB NUMBER:

DRAWING NUMBER

A-2


OF 4 SHEET(S)

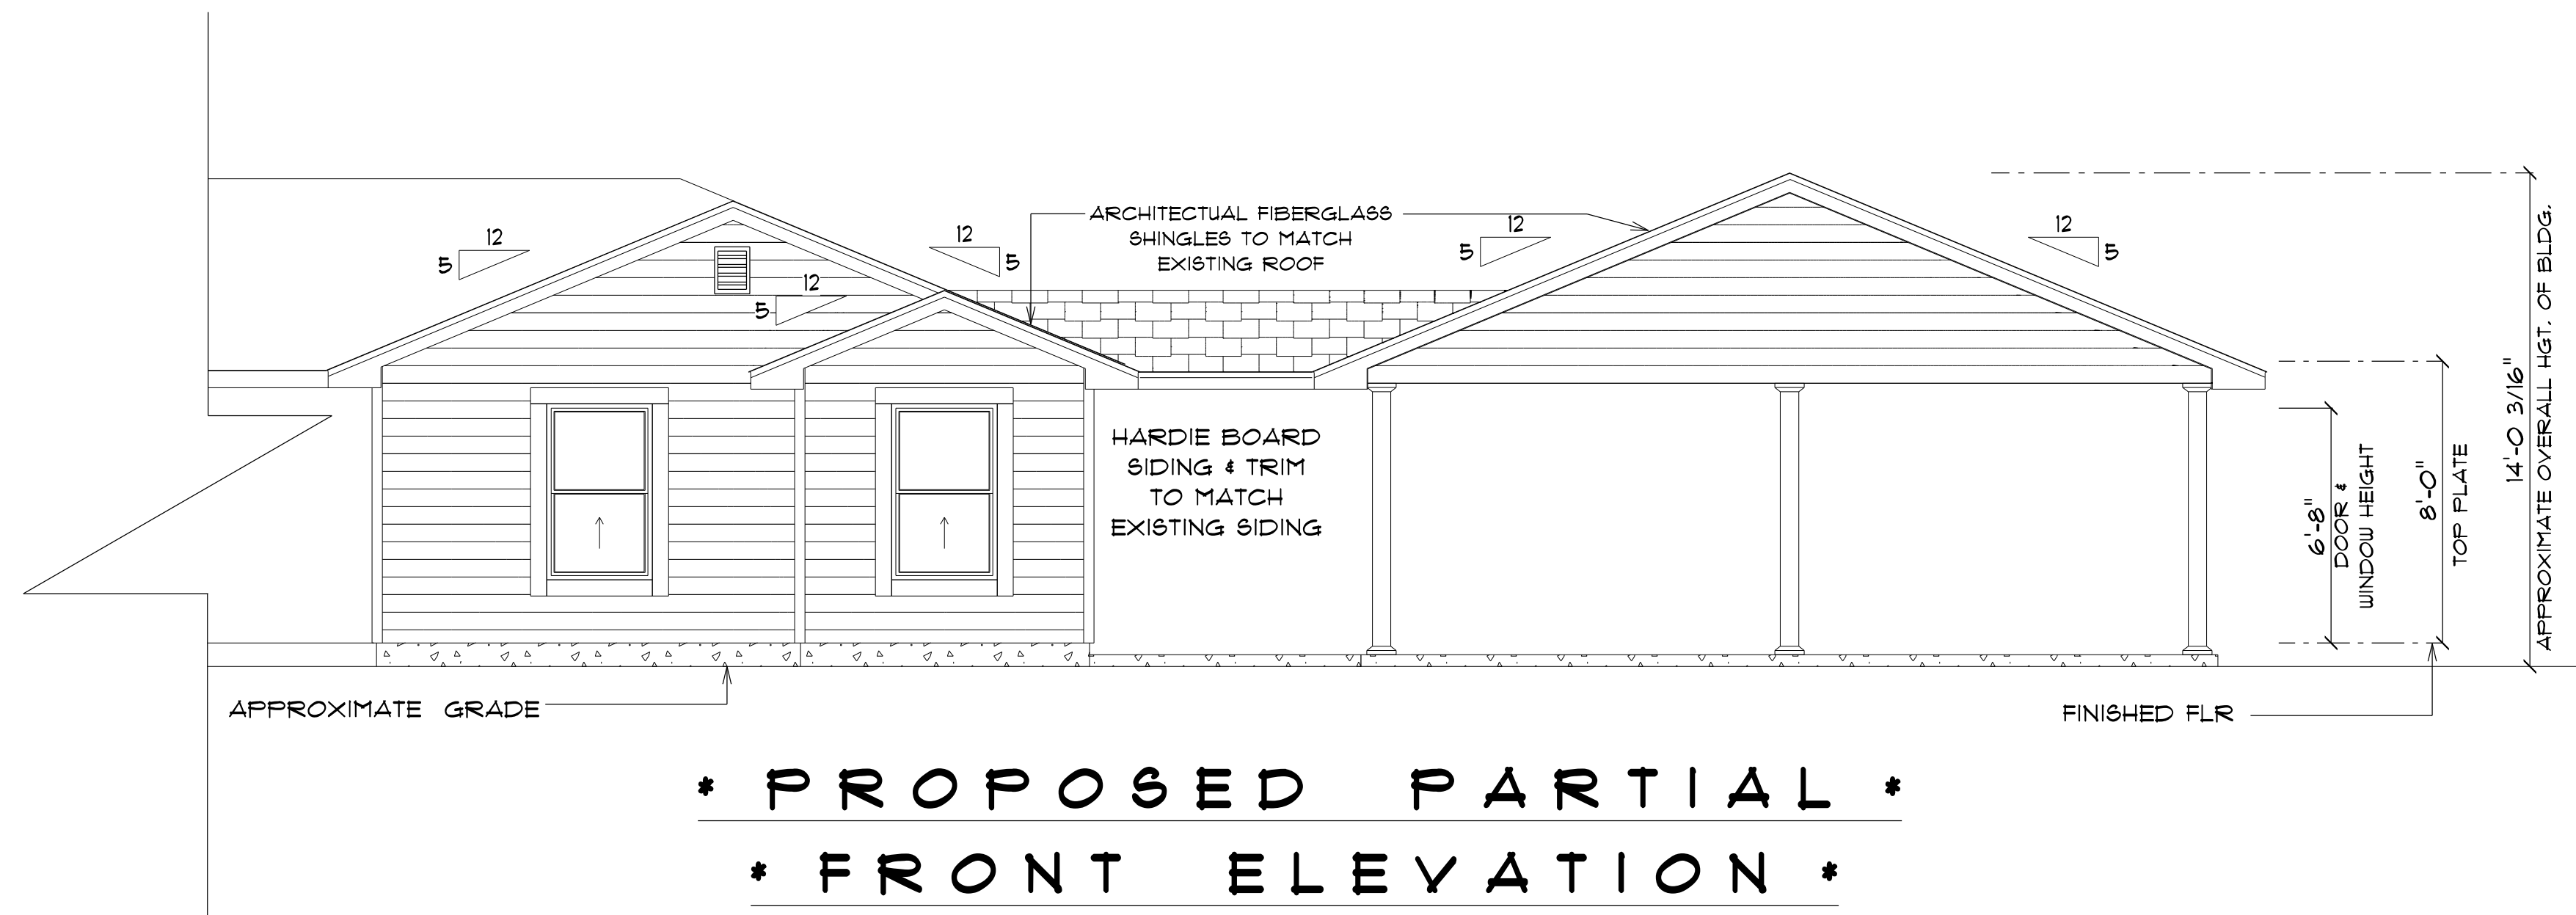

* PROPOSED PARTIAL *

* FRONT ELEVATION *


SCALE : 1/4" = 1'-0"

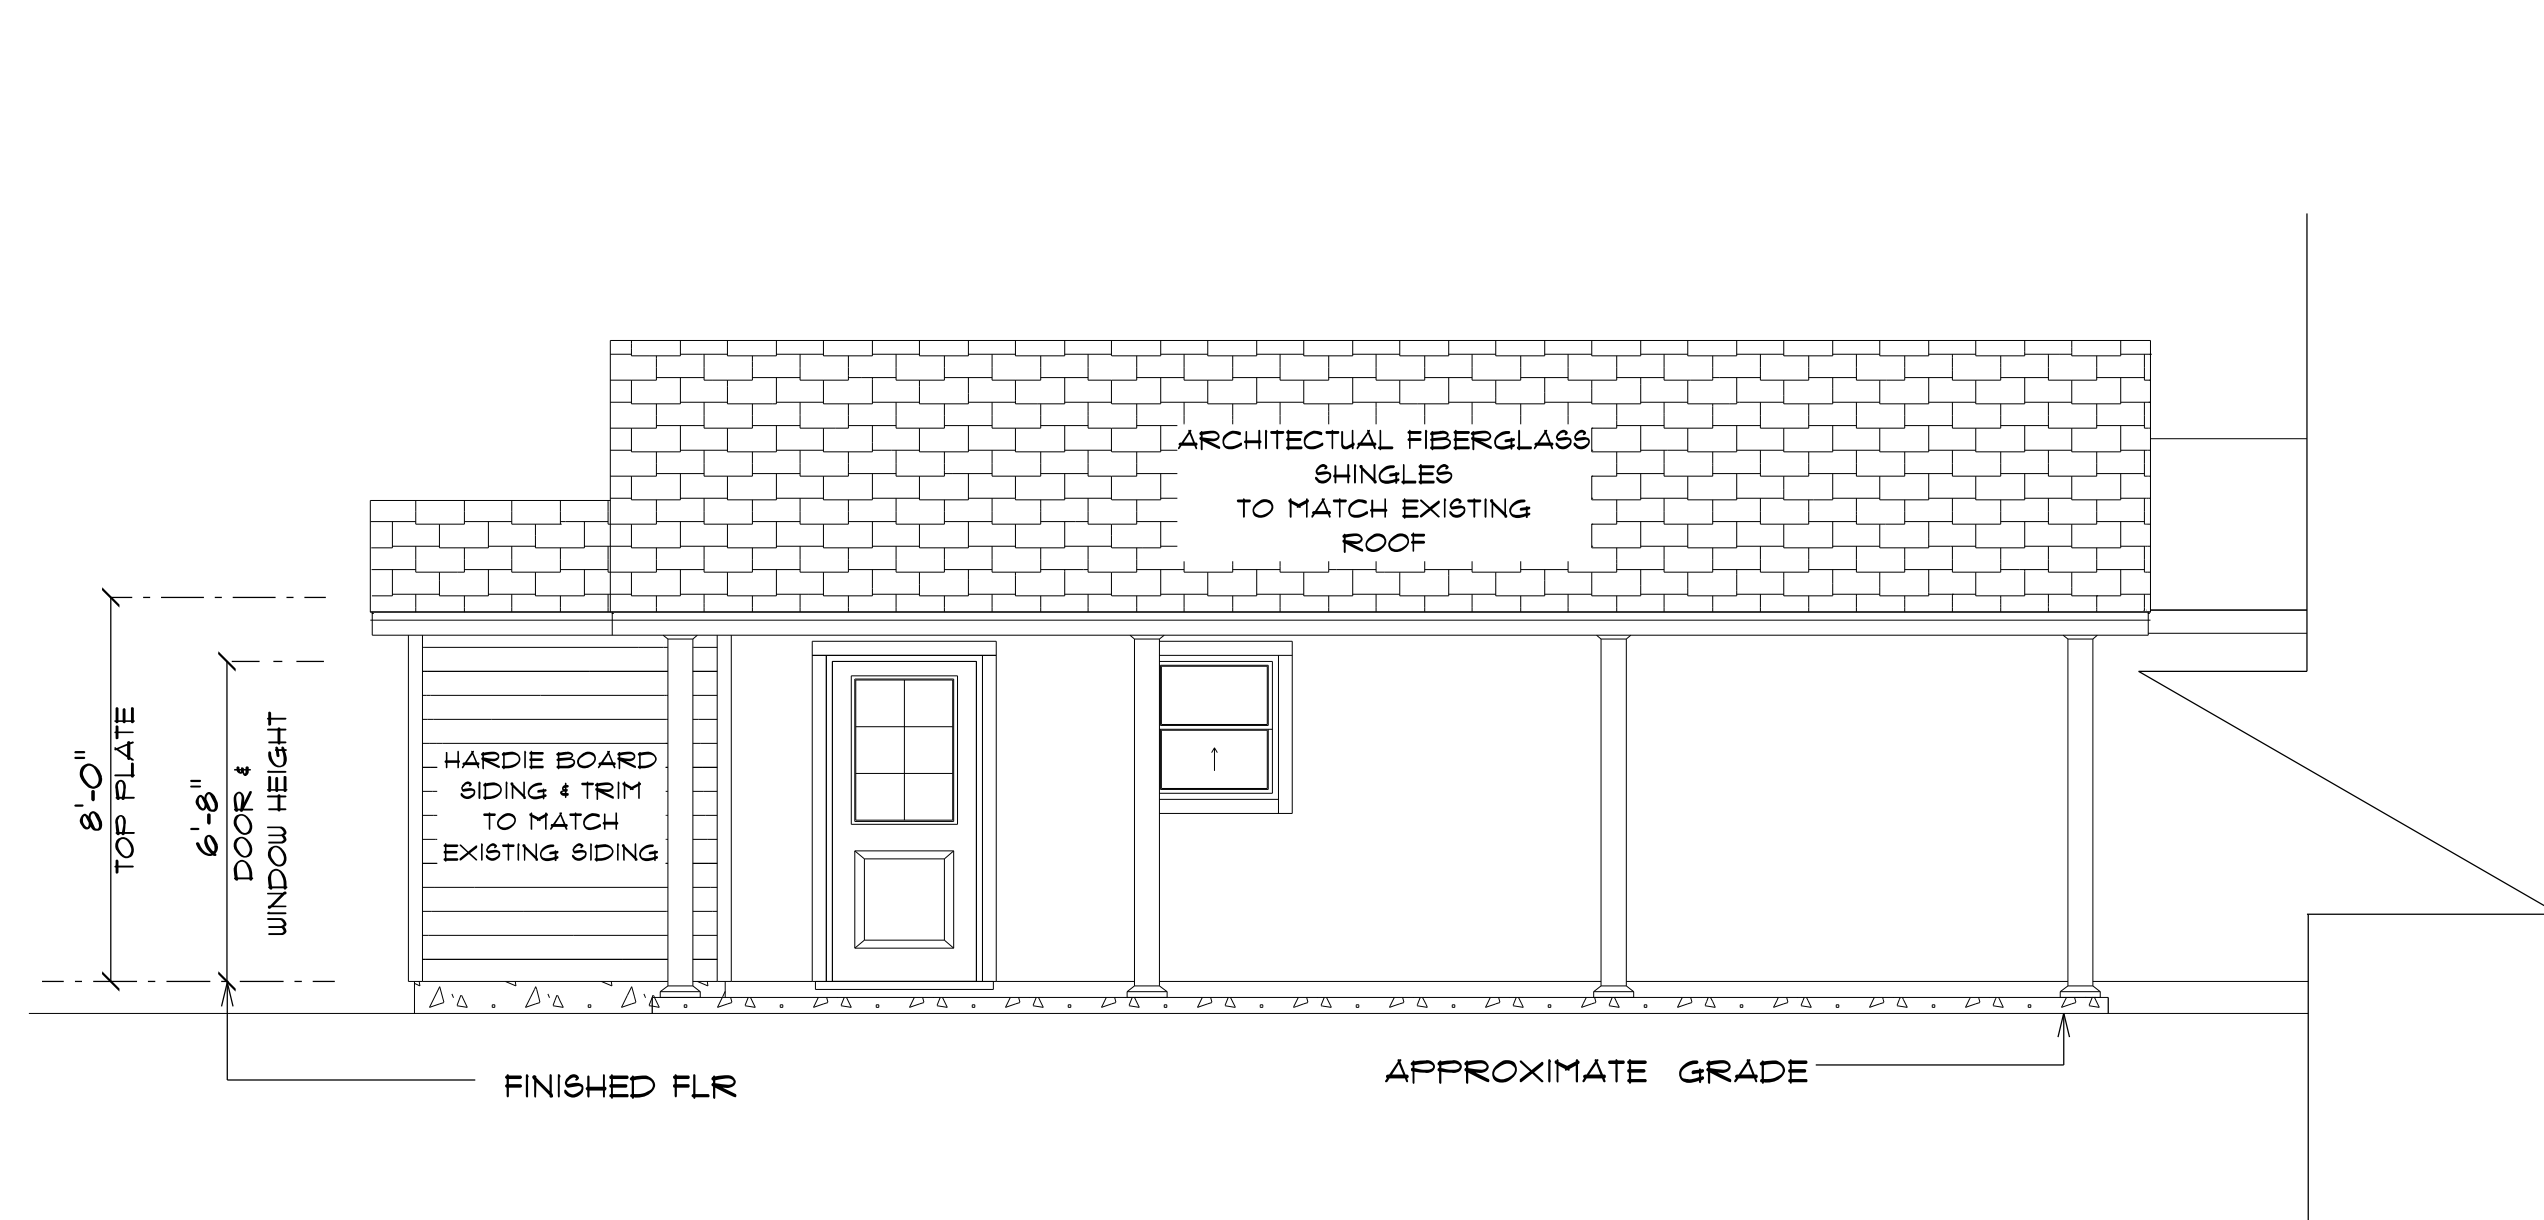

* PROPOSED PARTIAL *

* RIGHT ELEVATION *

SCALE : 1/4" = 1'-0"

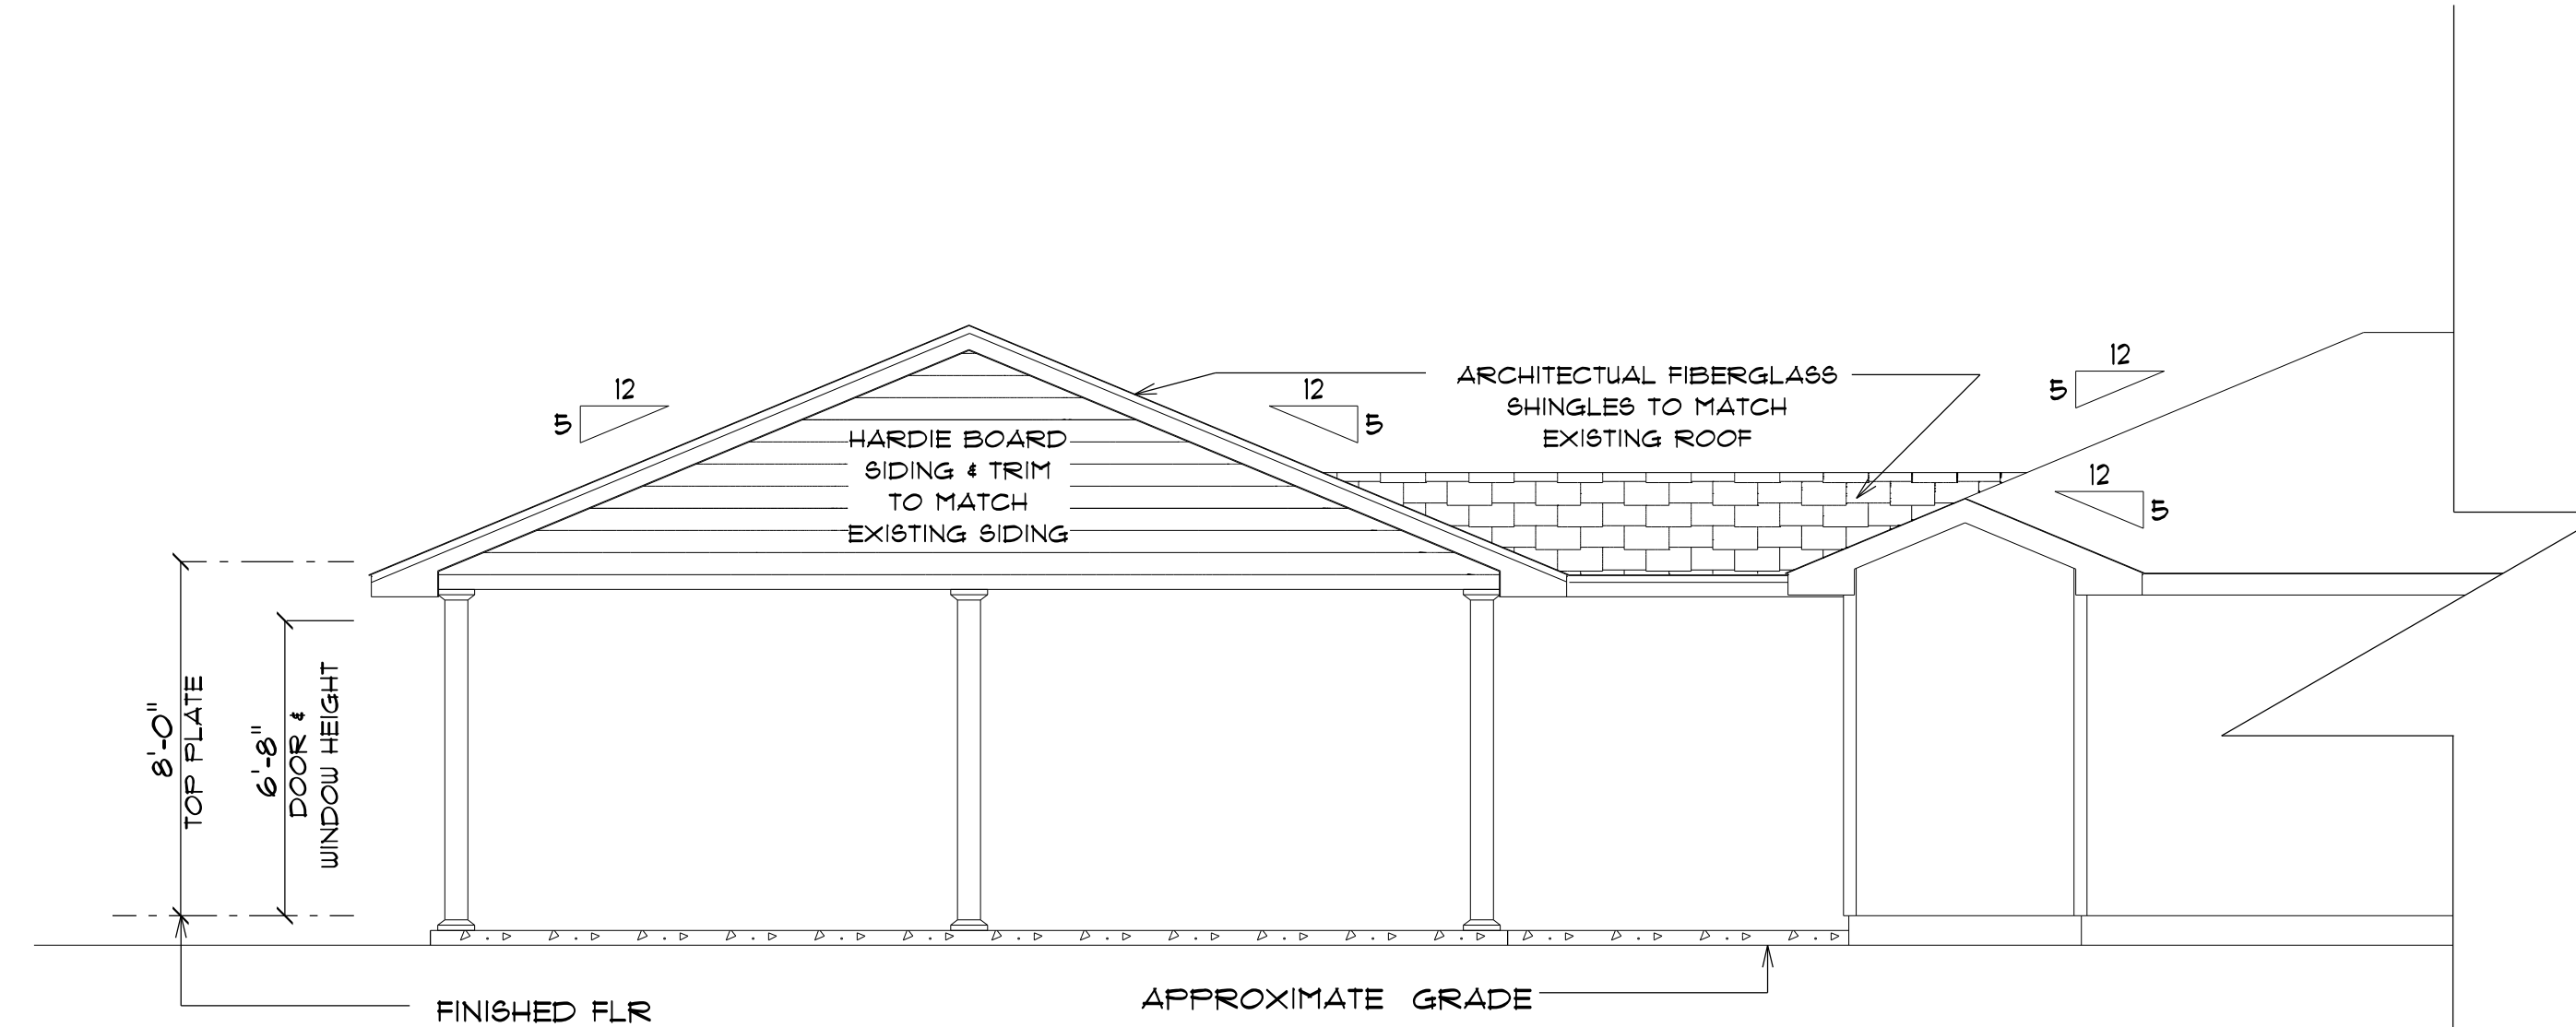

* PROPOSED PARTIAL *

* REAR ELEVATION *

SCALE : 1/4" = 1'-0"

ADDITION
for
SUE & RANDY
FRAZE

LAKE CITY, FL

Teena M. Ruffo
2925 SW SR 47
Lake City Florida, 32025
Cell: (386) 867-1191
Email: teenaruffo@gmail.com

PRINTED DATE:
Friday, January 6, 2023

DRAWN BY: Teena M. Ruffo CHECKED BY:

BUILDING CONTRACTOR
Roger Whiddon


FINAL DATE:

JOB NUMBER:

DRAWING NUMBER

A-3

OF 4 SHEET(S)

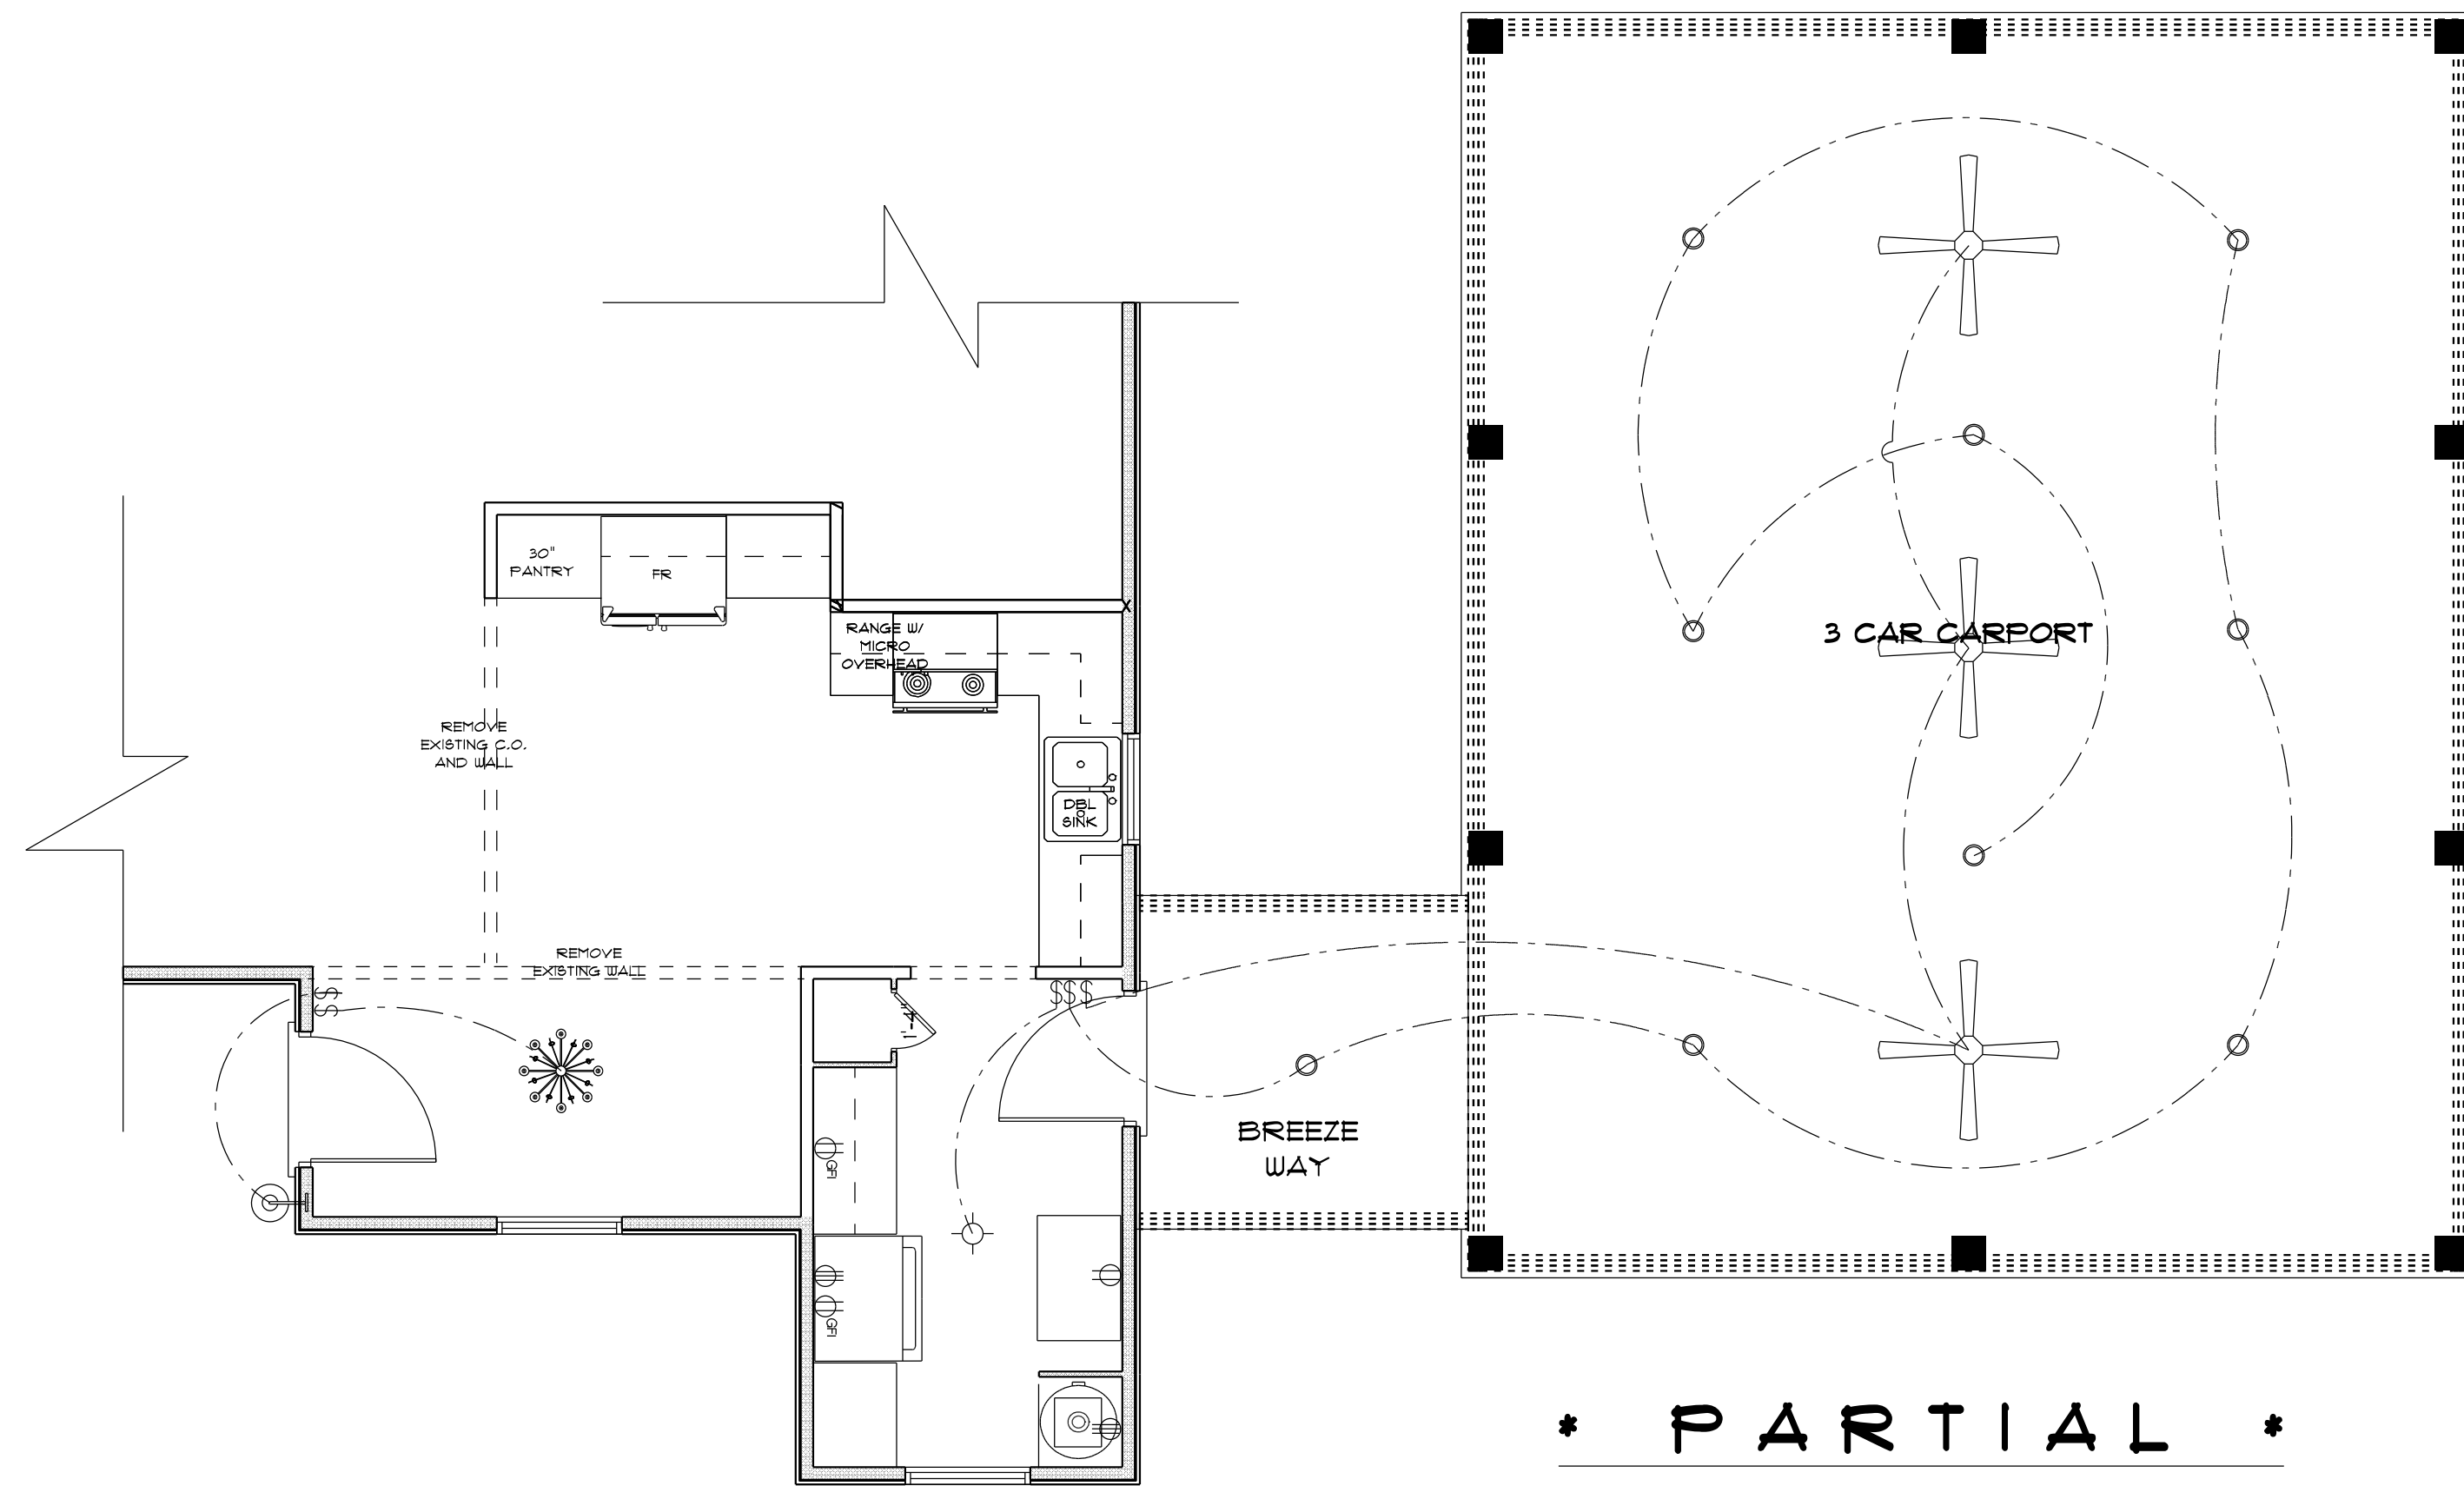

* PARTIAL *
* PROPOSED *
* ELECTRIC PLAN *

ELECTRICAL LEGEND		
ELECTRICAL	COUNT	SYMBOL
ceiling fan 4 bladed 01	3	
ceiling classic	1	
pot light	9	
wall mount savvy	1	
light	1	
outlet	1	
outlet 220v	2	
outlet gfi	2	
switch	5	

ELECTRICAL PLAN NOTES

- E-1 WIRE ALL APPLIANCES, HVAC UNITS AND OTHER EQUIPMENT PER MANUFACTURER'S SPECIFICATIONS.
- E-2 ALL INSTALLATIONS SHALL BE PER NATIONAL ELECTRIC CODE.
- E-3 ALL SMOKE /CARBON MONOXIDE DETECTORS SHALL BE 120V W/BATTERY BACKUP OF THE PHOTOELECTRIC TYPE, AND SHALL BE INTERLOCKED TOGETHER. INSTALL INSIDE AND NEAR ALL BEDROOMS AS PER CODE.
- E-4 TELEPHONE, TELEVISION AND OTHER LOW VOLTAGE DEVICES OR OUTLETS SHALL BE AS PER THE OWNER'S DIRECTION AND IN ACCORDANCE WITH APPLICABLE SECTIONS OF NATIONAL ELCT. CODE LATEST EDITION.
- E-5 ELECTRICAL CONTRACTOR SHALL BE RESPONSIBLE FOR THE DESIGN AND SIZING OF ELECTRICAL SERVICE AND CIRCUITS.
- E-6 ENTRY OF SERVICE UNDERGROUND OR OVERHEAD) IS TO BE DETERMINED BY THE POWER COMPANY.
- ALL BEDROOM RECEPTALS ARE TO BE AFCI (ARC FAULT CIRCUIT INTERRUPT)
- 75% OF ALL PERMANENT LIGHTS TO BE ENERGY EFFICIENT.

ADDITION
for
SUE & RANDY
FRAZE

LAKE CITY, FL

Teena M. Ruffo
2925 SW 8R 41
Lake City Florida, 32025
Cell: (386) 861 - 1191
Email: teenaruffo@gmail.com

PRINTED DATE:
Friday, January 6, 2023

DRAWN BY: Teena M. Ruffo CHECKED BY:

BUILDING CONTRACTOR

Roger Whiddon

FINAL DATE:

JOB NUMBER:

DRAWING NUMBER

A-4

OF 4 SHEET(S)