

BUILT-OUT RENOVATIONS For:

VERA SALON

Lake City, FL 32055

PROJECT DIRECTORY

ARCHITECT
NICHOLAS PAUL GELER
NICHOLAS PAUL GELER, ARCHITECT
FL REG: ARO00106
1758 NW BROWN RD
LAKE CITY, FLORID 32055
CELL: (386) 365-435
EMAIL: npgelsler@gmail.com

DESIGNER
JON MORRIS
RIDGEPOINT DESIGN
566 SW ARLINGTONBLVD, STE 101
LAKE CITY, FLORID 32025
PHONE: (386) 288-118
EMAIL: jon@RidgepntDesign.com

CODE , PROJECT DATA

BUILDING CODE DTA:
BUILDING CODE: 2020 FLORIDA BUILDING CODE - BUILDING
PLUMBING CODE: 2020 FLORIDA BUILDING CODE - PLUMBING
MECHANICAL COD: 2020 FLORIDA BUILDING CODE - MECHANICAL
ELECTRICAL CODE NATIONAL ELECTRICAL CODE - LATEST
FIRE CODE: 2021 NFPA FIRE CODE & 2021 NFPA 101 LIFE SAFETY CODE
- 7TH EDITION FLORIDA FIRE PREVENTION CODE
ACCESSIBILITY: FLORIDA ACCESSIBILITY CODE - LATEST
CONSTRUCTION CLASSIFICATION:
FBC: TYPE V, NONSPRINKLERED
NFPA: TYPE II (OO) (NON-SPRINKLERED)

SHEET INDEX

DESCRIPTION	
A.1	COVER SHEET
A.2	LIFE SAFETY PLAN
A.3	RENOVATED FLOOR PLAN
A.4	EXISTING FLOOR PLAN
A.5	ELECTRICAL PLAN

REVISION:

RESIDENTIAL + COMMERCIAL

BUILDING DEPARTMENT

REGISTRATION NO. 1807-0000

CBC 1204659

330 SW BLAYLOCK COURT

LAKE CITY, FL 32024

(386) 965 - 8340

BUILT-OUT RENOVATIONS FOR:

VERA SALON

LAKE CITY, FLORIDA

RIDGEPOINT DESIGN

566 SW ARLINGTON BLVD, STE 101, LAKE CITY, FL 32025

P: 386-288-1188

E: RIDGEPOINTDESIGN@GMAIL.COM

Celebrating 49 Years of Service

1972 - 2021

NFPA 101

AR0001006

NPG

NICHOLAS PAUL GELER

ARCHITECT

FLORIDA

1758 NW BROWN RD

LAKE CITY, FLORIDA 32055

386-365-435

DATE:

28th JUNE 2021

COMM:

SHEET:

A.1

1 OF 6



MP

15 July 2021

AR0001006

	EXIT LIGHT - ARROW REPRESENTS DIRECTION OF EXIT
	WALL HUNG "ABC" FIRE EXTINGUISHER
	DOOR / CLOSET FOR EXIT OR RATING REASONS
	PRIMARY EGRESS w/ EXIT CAPACITY
	SECONDARY EGRESS
	EMERGENCY LIGHT w/ BATTERY BACKUP

NOTE:
EMERGENCY LIGHTING AND EXIT SIGNS, SHALL BE PROVIDED
AS DIRECTED BY THE FIRE MARSHAL, AND SHALL BE WIRED
PER NEC 700-12F

NOTE:
SMOKE DETECTORS SHALL BE MOUNTED AT LEAST
THAN 90" ABOVE FINISHED FLOOR AND SHALL BE THE
IONIZATION TYPE, INTERLOCKED TOGETHER, POWERED
FROM EACH STORE PANEL w/ BATTERY BACKUP

EXIT ACCESS TRAVEL DISTANCE PER FB0015, TABLE 1015.1

OCCUPANCY - BUSINESS
150 FT. (WITHOUT SPRINKLER SYSTEM)
250 FT. (WITH SPRINKLER SYSTEM)

NOTE:
TRAVEL DISTANCES SHOWN ARE MAXIMUM FOR EMERGENCY EGRESS,
SECONDARY EM. EGRESS AND NON-EMERGENCY EGRESS - ALL OTHER
TRAVEL DISTANCES ARE LESS THAN THOSE SHOWN




8" SQ. MALTESE, CROSS w/ "F/R" IDENTIFIR
SIGNAGE, MOUNTED @ 60" ABY. WALKWAY
LOCATE AS DIRECTED BY THE FIRE MARSHAL

2020 FBC-BUILDING, TABLE 1004.1.2


MAXIMUM FLOOR AREA ALLOWABLE PER OCCUPANT

OCCUPANCY CLASSIFICATION	FLOOR AREA	OCCUPANCY ASIS	NUMBER OF OCCUPANTS
BUSINESS	1254	1/100 SF	13
WAITING / LOBBY	315	1/15 SF	21
RESTROOMS	117	1 PER BATH	2
EMPLOYEE / BREAK	240	1/30 SF	8
WALLS	74	A	N/A
SPACE TOTALS	2,000		44

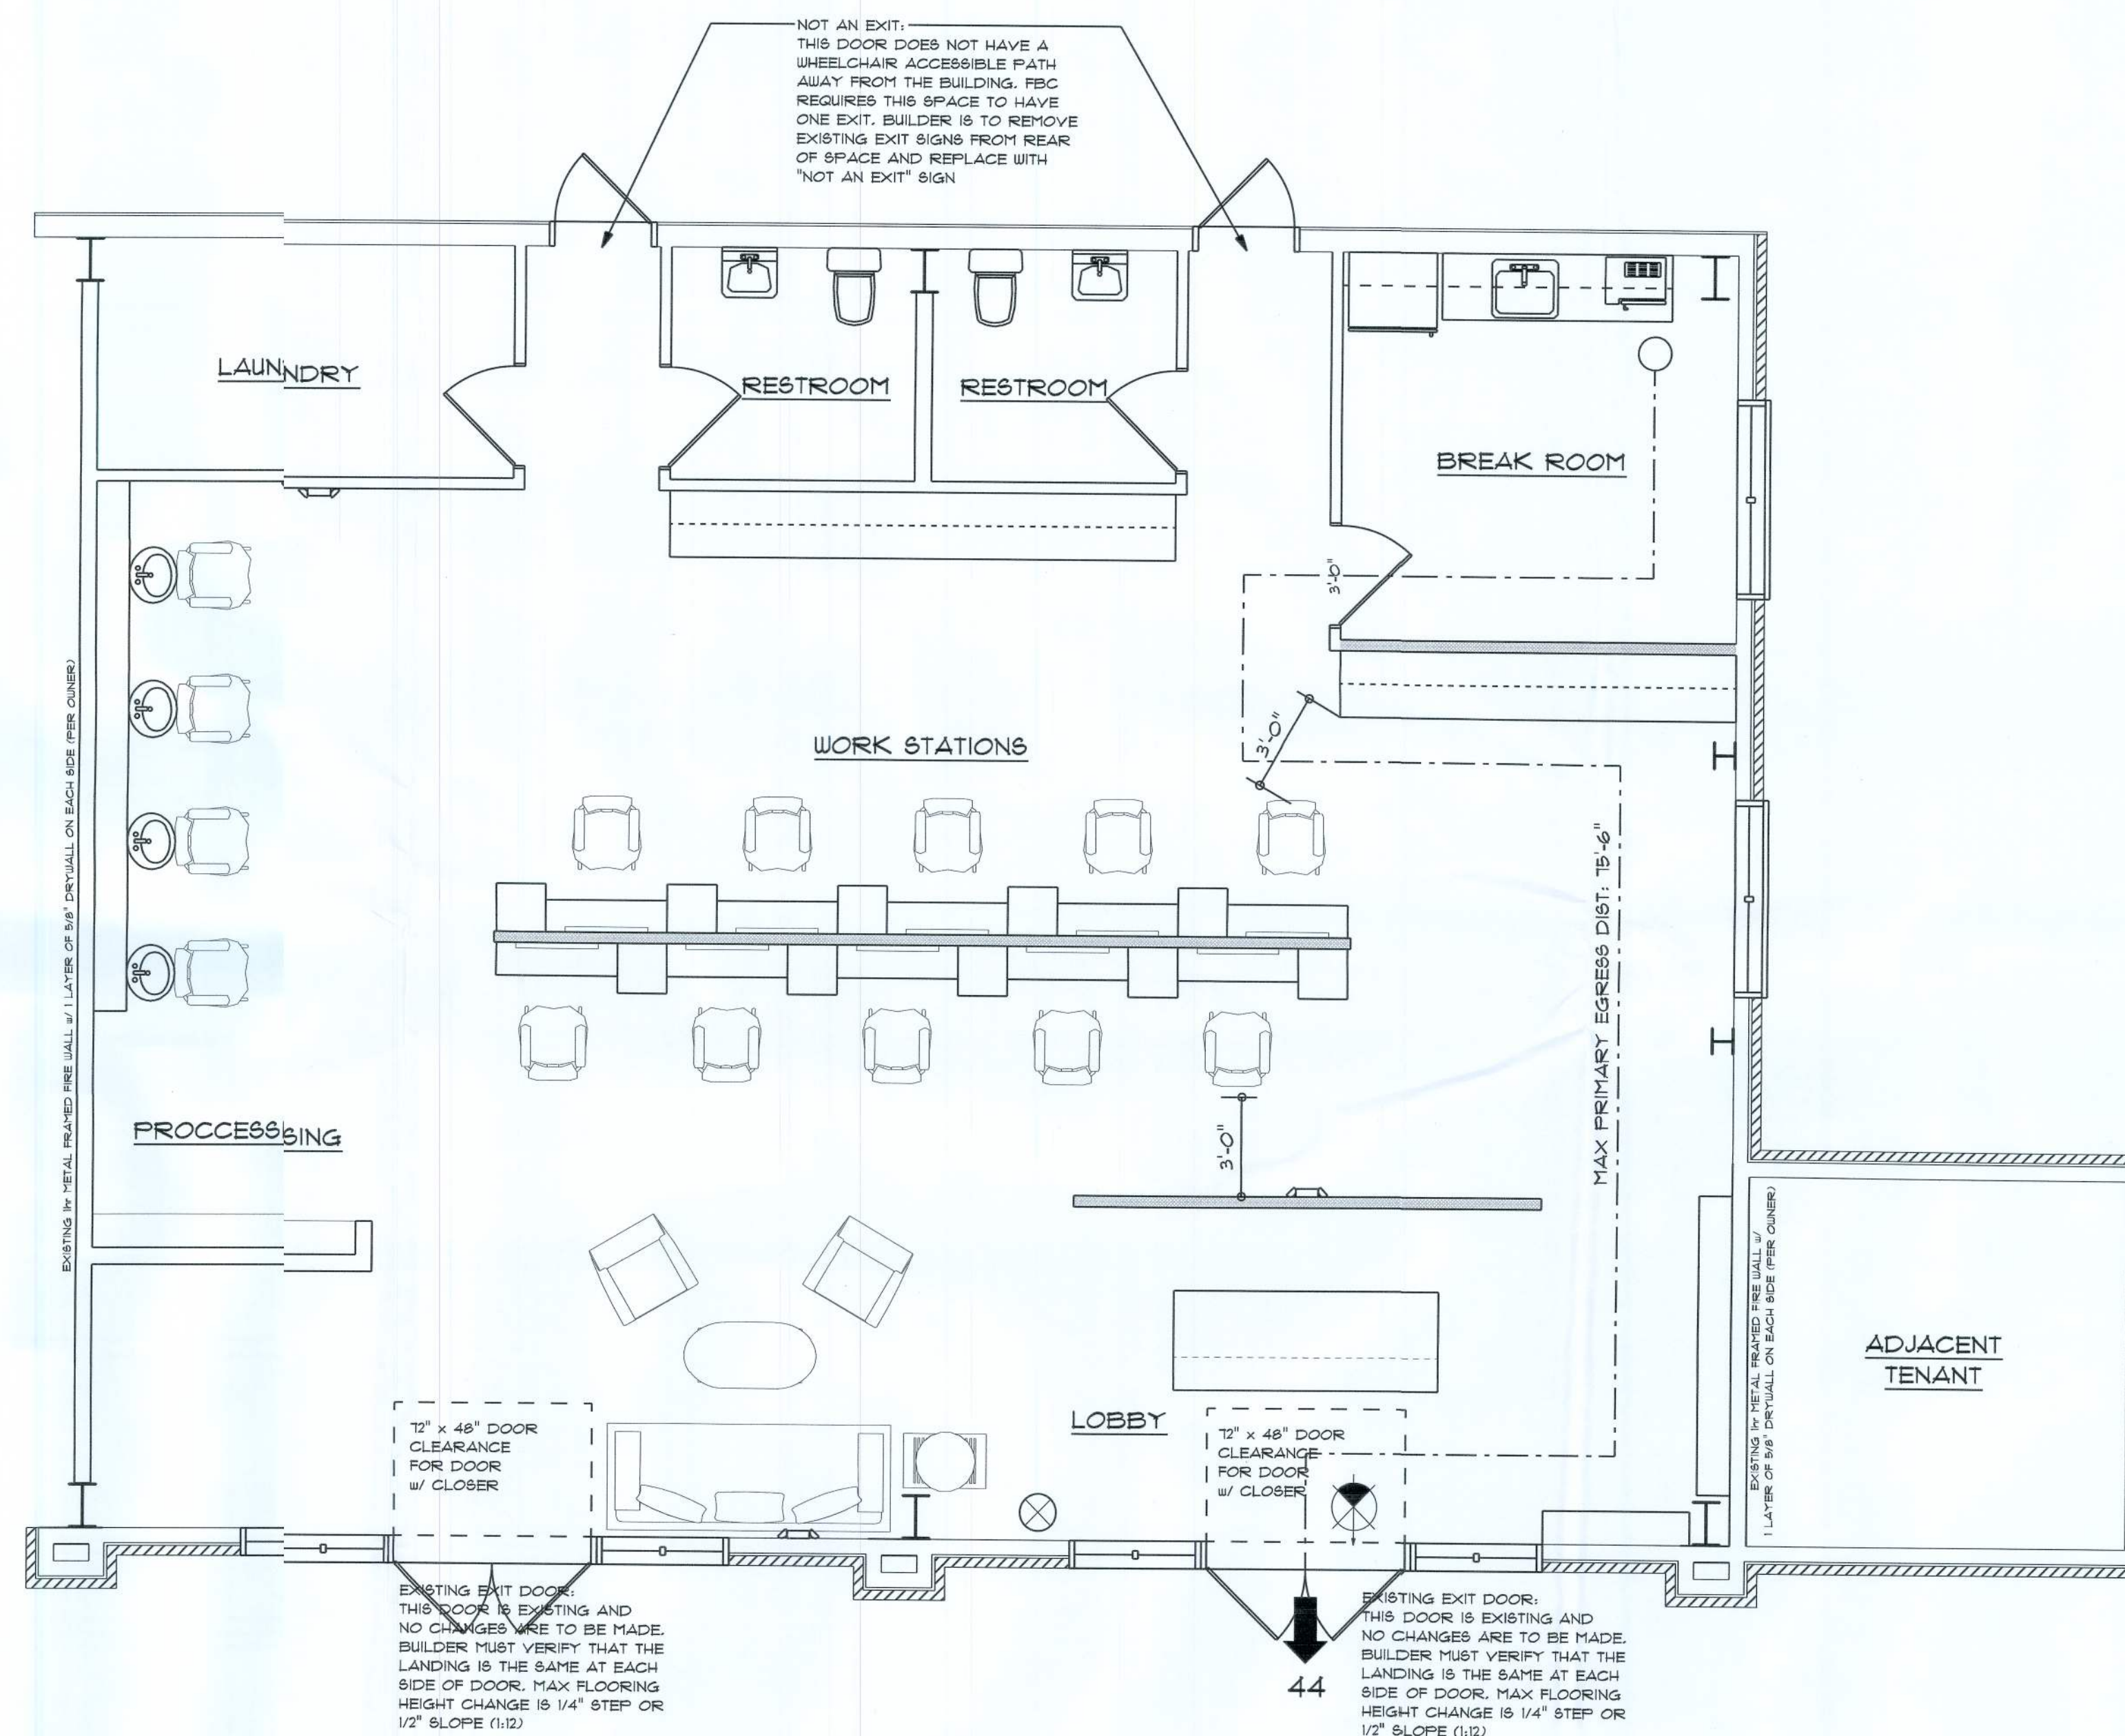

SCALE: 1/4" = 1'-0"

These drawings, as instruments of service, are the sole property of the architect, and may not be used, copied or reproduced in whole or in part for use on or for any other project without specific and individual authorization by the architect.

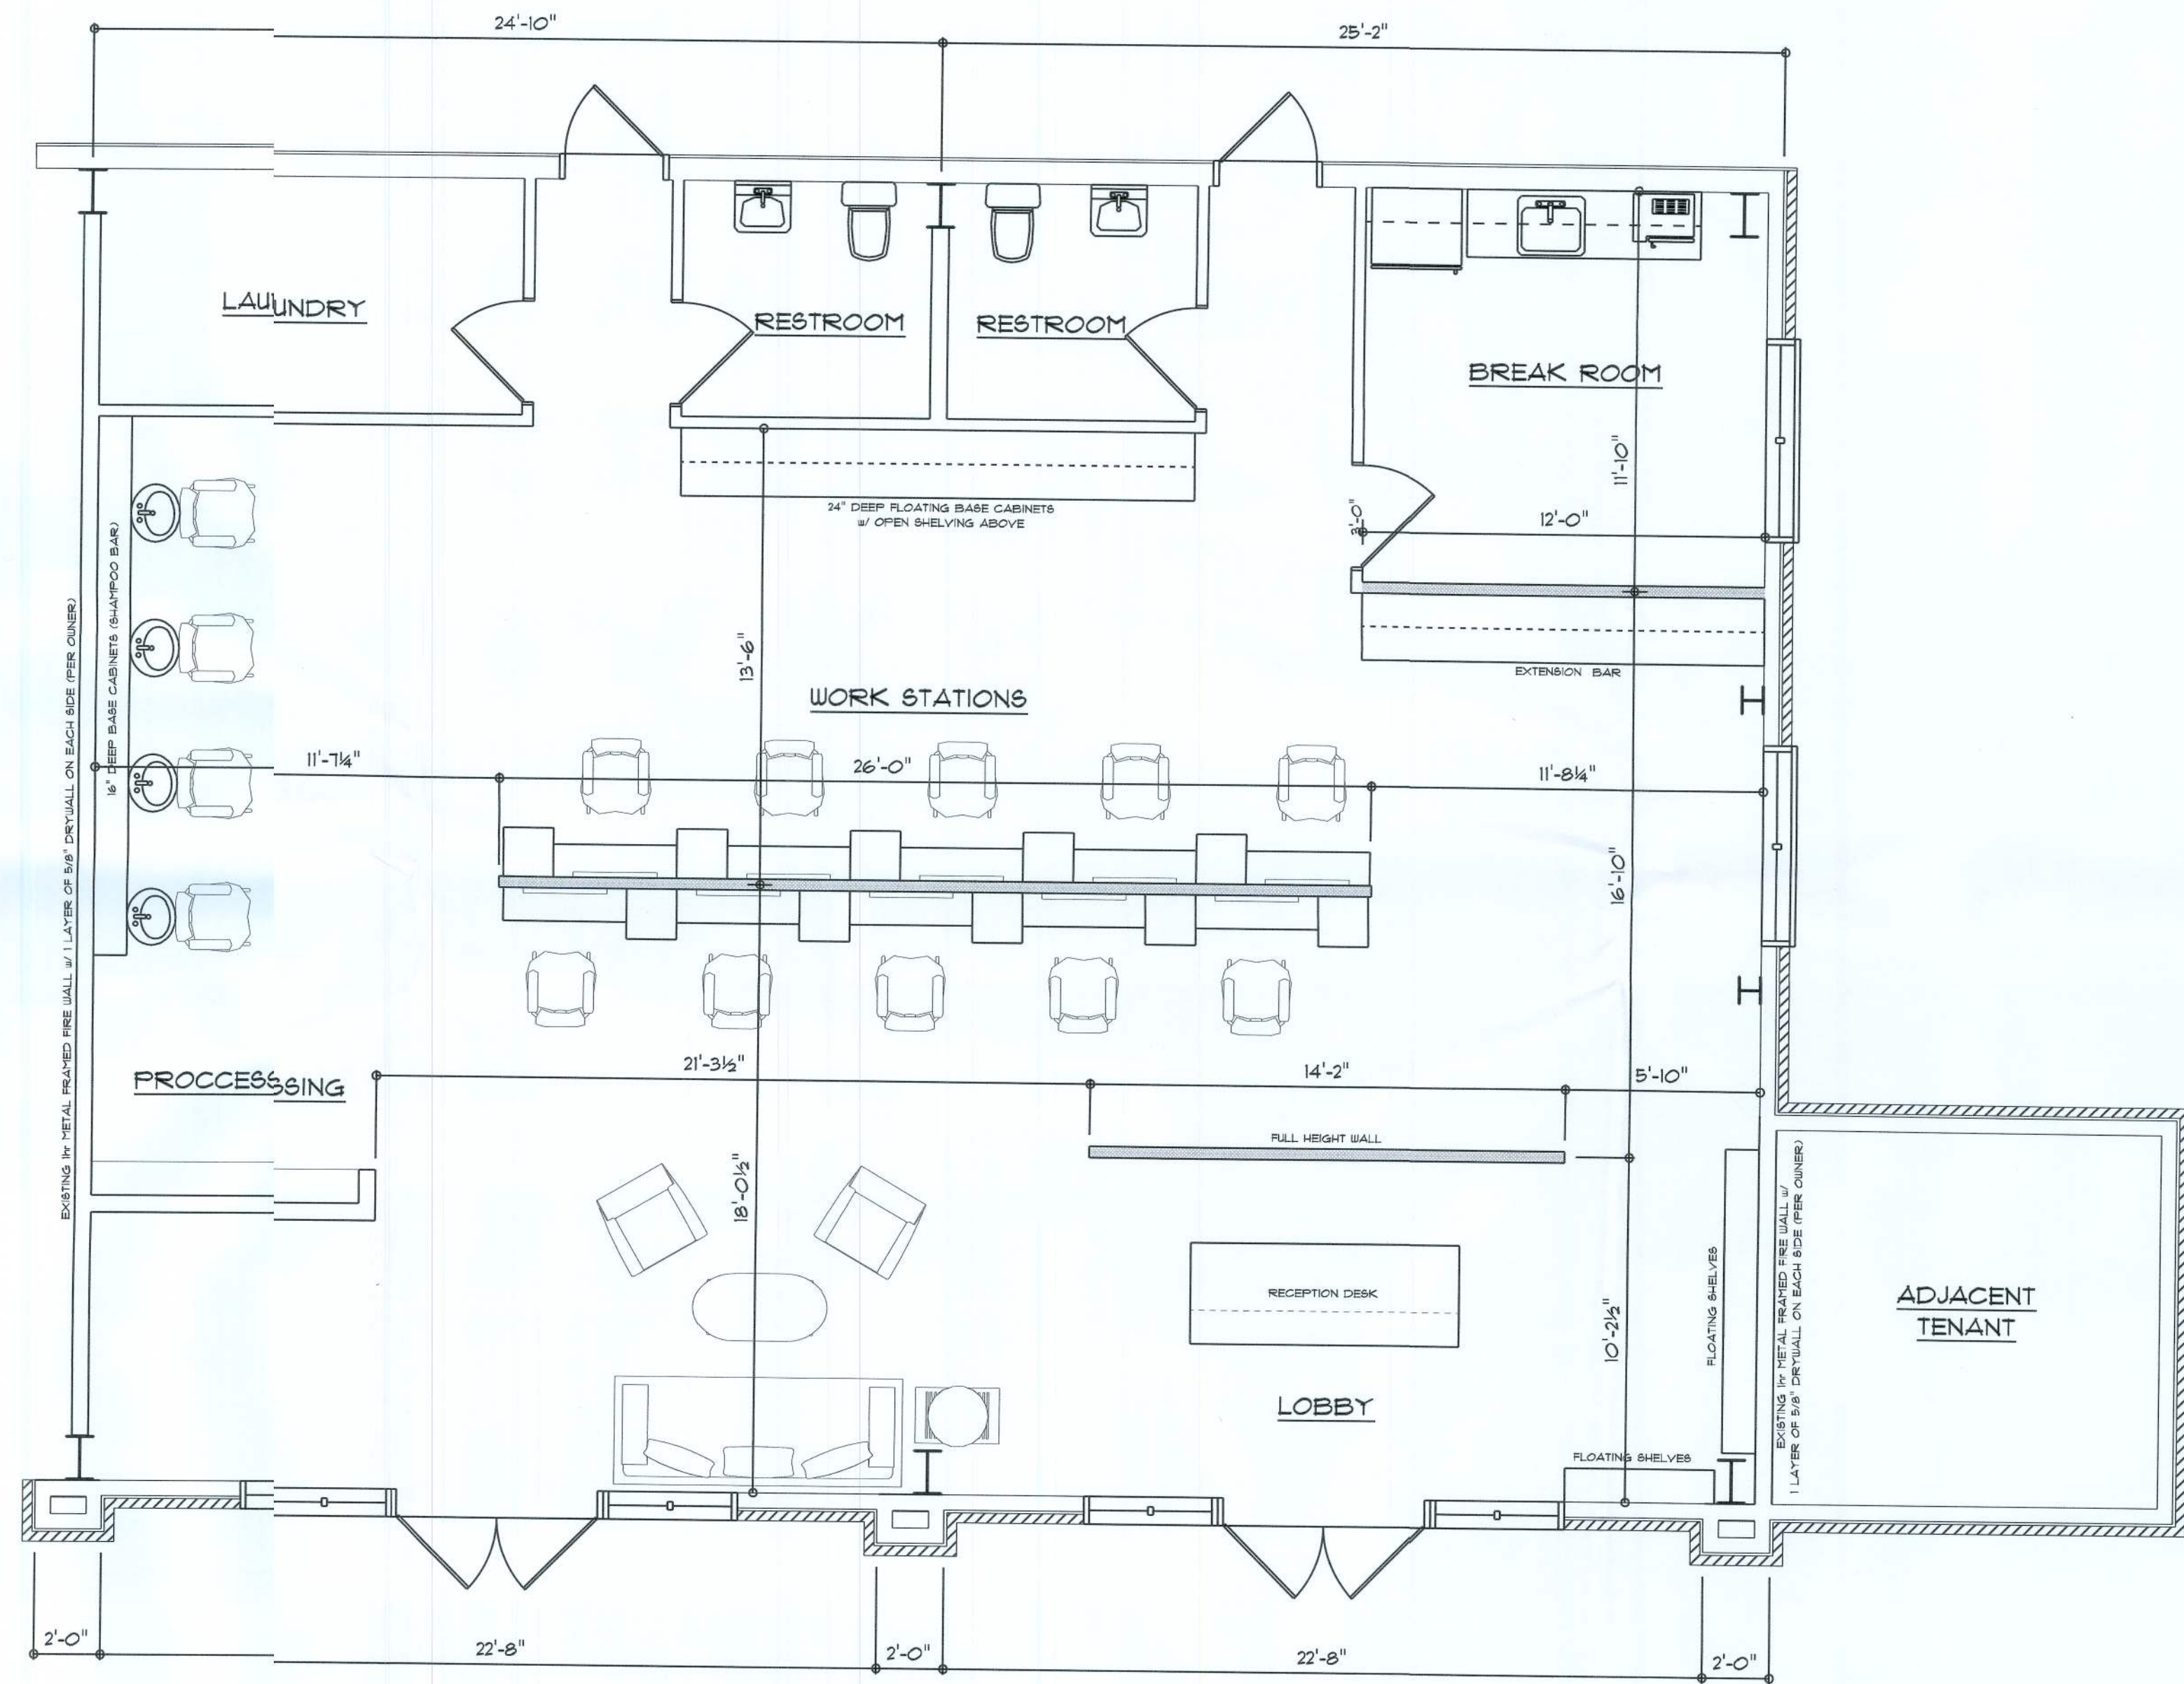

RENOVATED FLOOR PLAN
SCALE: 1/4" = 1'-0"

EXISTING HVAC & DUCT WORK TO BE REPLACED AS REQUIRED.
HVAC CONTRACTOR WILL PROVIDE NECESSARY DRUGS & FORMS
FOR PROPOSED WORK.

REVISION:

BUILDING DESIGN CO.
RESIDENTIAL + COMMERCIAL
DESIGN
CBC 1264659
330 SW PLAYLOCK COURT
LAKE CITY, FL 32024
(386) 965 - 8340

BUILD-OUT RENOVATIONS FOR:
VERA SALON
LAKE CITY, FLORIDA

RIDGEPOINT DESIGN
266 SW ARLINGTON BLVD, STE 101, LAKE CITY, FL 32025
P: 386-288-1188
E: RIDGEPOINTDESIGN@GMAIL.COM

Celebrating 48 years of service
1972 - 2021
NICHOLAS PAUL GEBLER ARCHITECT
NICHOLAS GEBLER ARCHITECTS

NG
NICHOLAS PAUL GEBLER ARCHITECT
NICHOLAS GEBLER ARCHITECTS
788 N. Bruce Rd.
Lake City, FL 32026
386-965-8340


DATE:
28th JUNE 2021

COMM:

SHEET:
A.3
3 OF 6

[Signature]
AR000700B

These drawings, as instruments of service, are the sole property of the architect, and may not be used, copied or reproduced in whole or in part for use on or incorporated within any other job without specific and individual authorization by the architect.

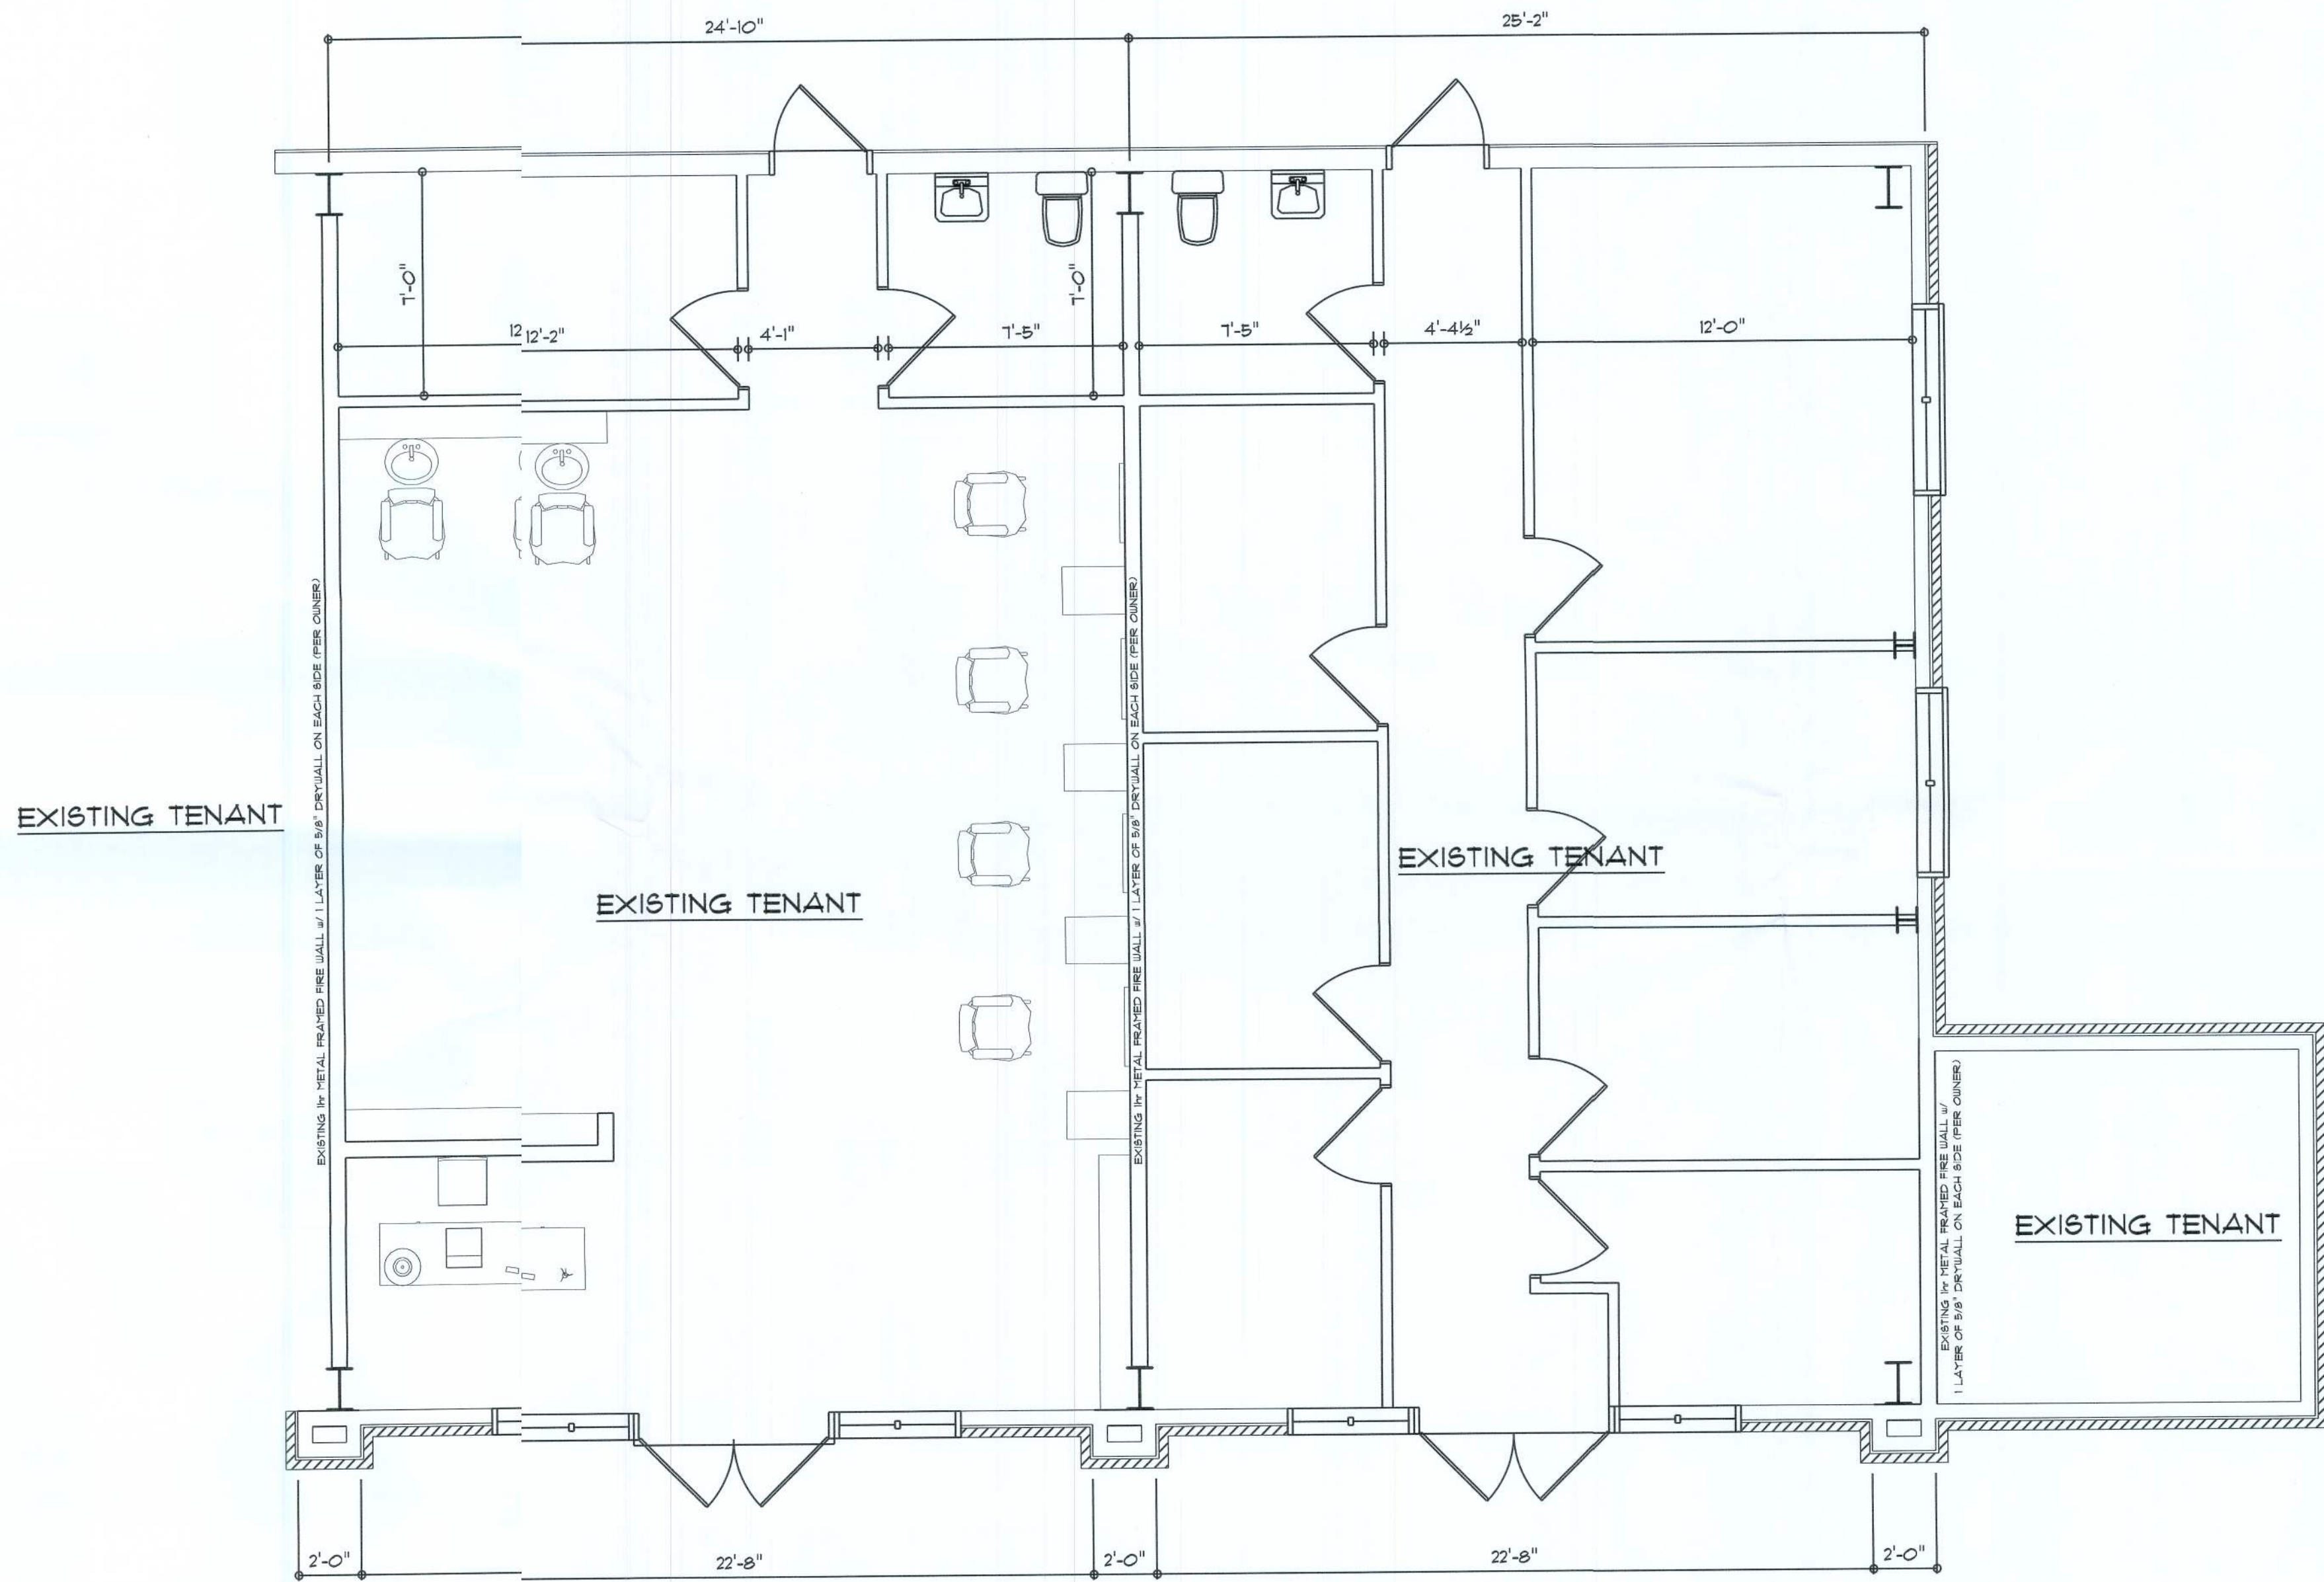

EXISTING 3 FLOOR PLAN
SCALE: 1/4" = 1'-0"

REVISION:

BUILDING B P DESIGN CO.
RESIDENTIAL • COMMERCIAL
PROFESSIONAL NEW BARS
CBC 1264659
330 SW BLAYLOCK COURT
LAKE CITY, FL 32024
(386) 955 - 8340

BUILD-OUT RENOVATIONS FOR:
VERA SALON
LAKE CITY, FLORIDA


RIDGEPOINT DESIGN
5601 W. ALMINGTON BLVD. STE. 101, LAKE CITY, FL 32025
P: 386-288-1188
E: RIDGEPOINTDESIGN@GMAIL.COM

NE
NICHOLAS PAUL
GEISLER
ARCHITECT
N.C.A.A. CERTIFIED
1970 - 2021
Celebrating 50 Years of
Professional Service
N.P. ARCHITECTS
ARCHITECTS
1970 - 2021

DATE:
28th JUNE 2021
COMPI:
SHEET:
A.4
4 OF 6

Handwritten signature and date: 15 July 2021
AR0001005

These drawings, in instrument of service, are the sole property of the architect, and may not be used, copied or reproduced in whole or in part for use on or incorporated within any other job without specific and individual authorization by the architect.

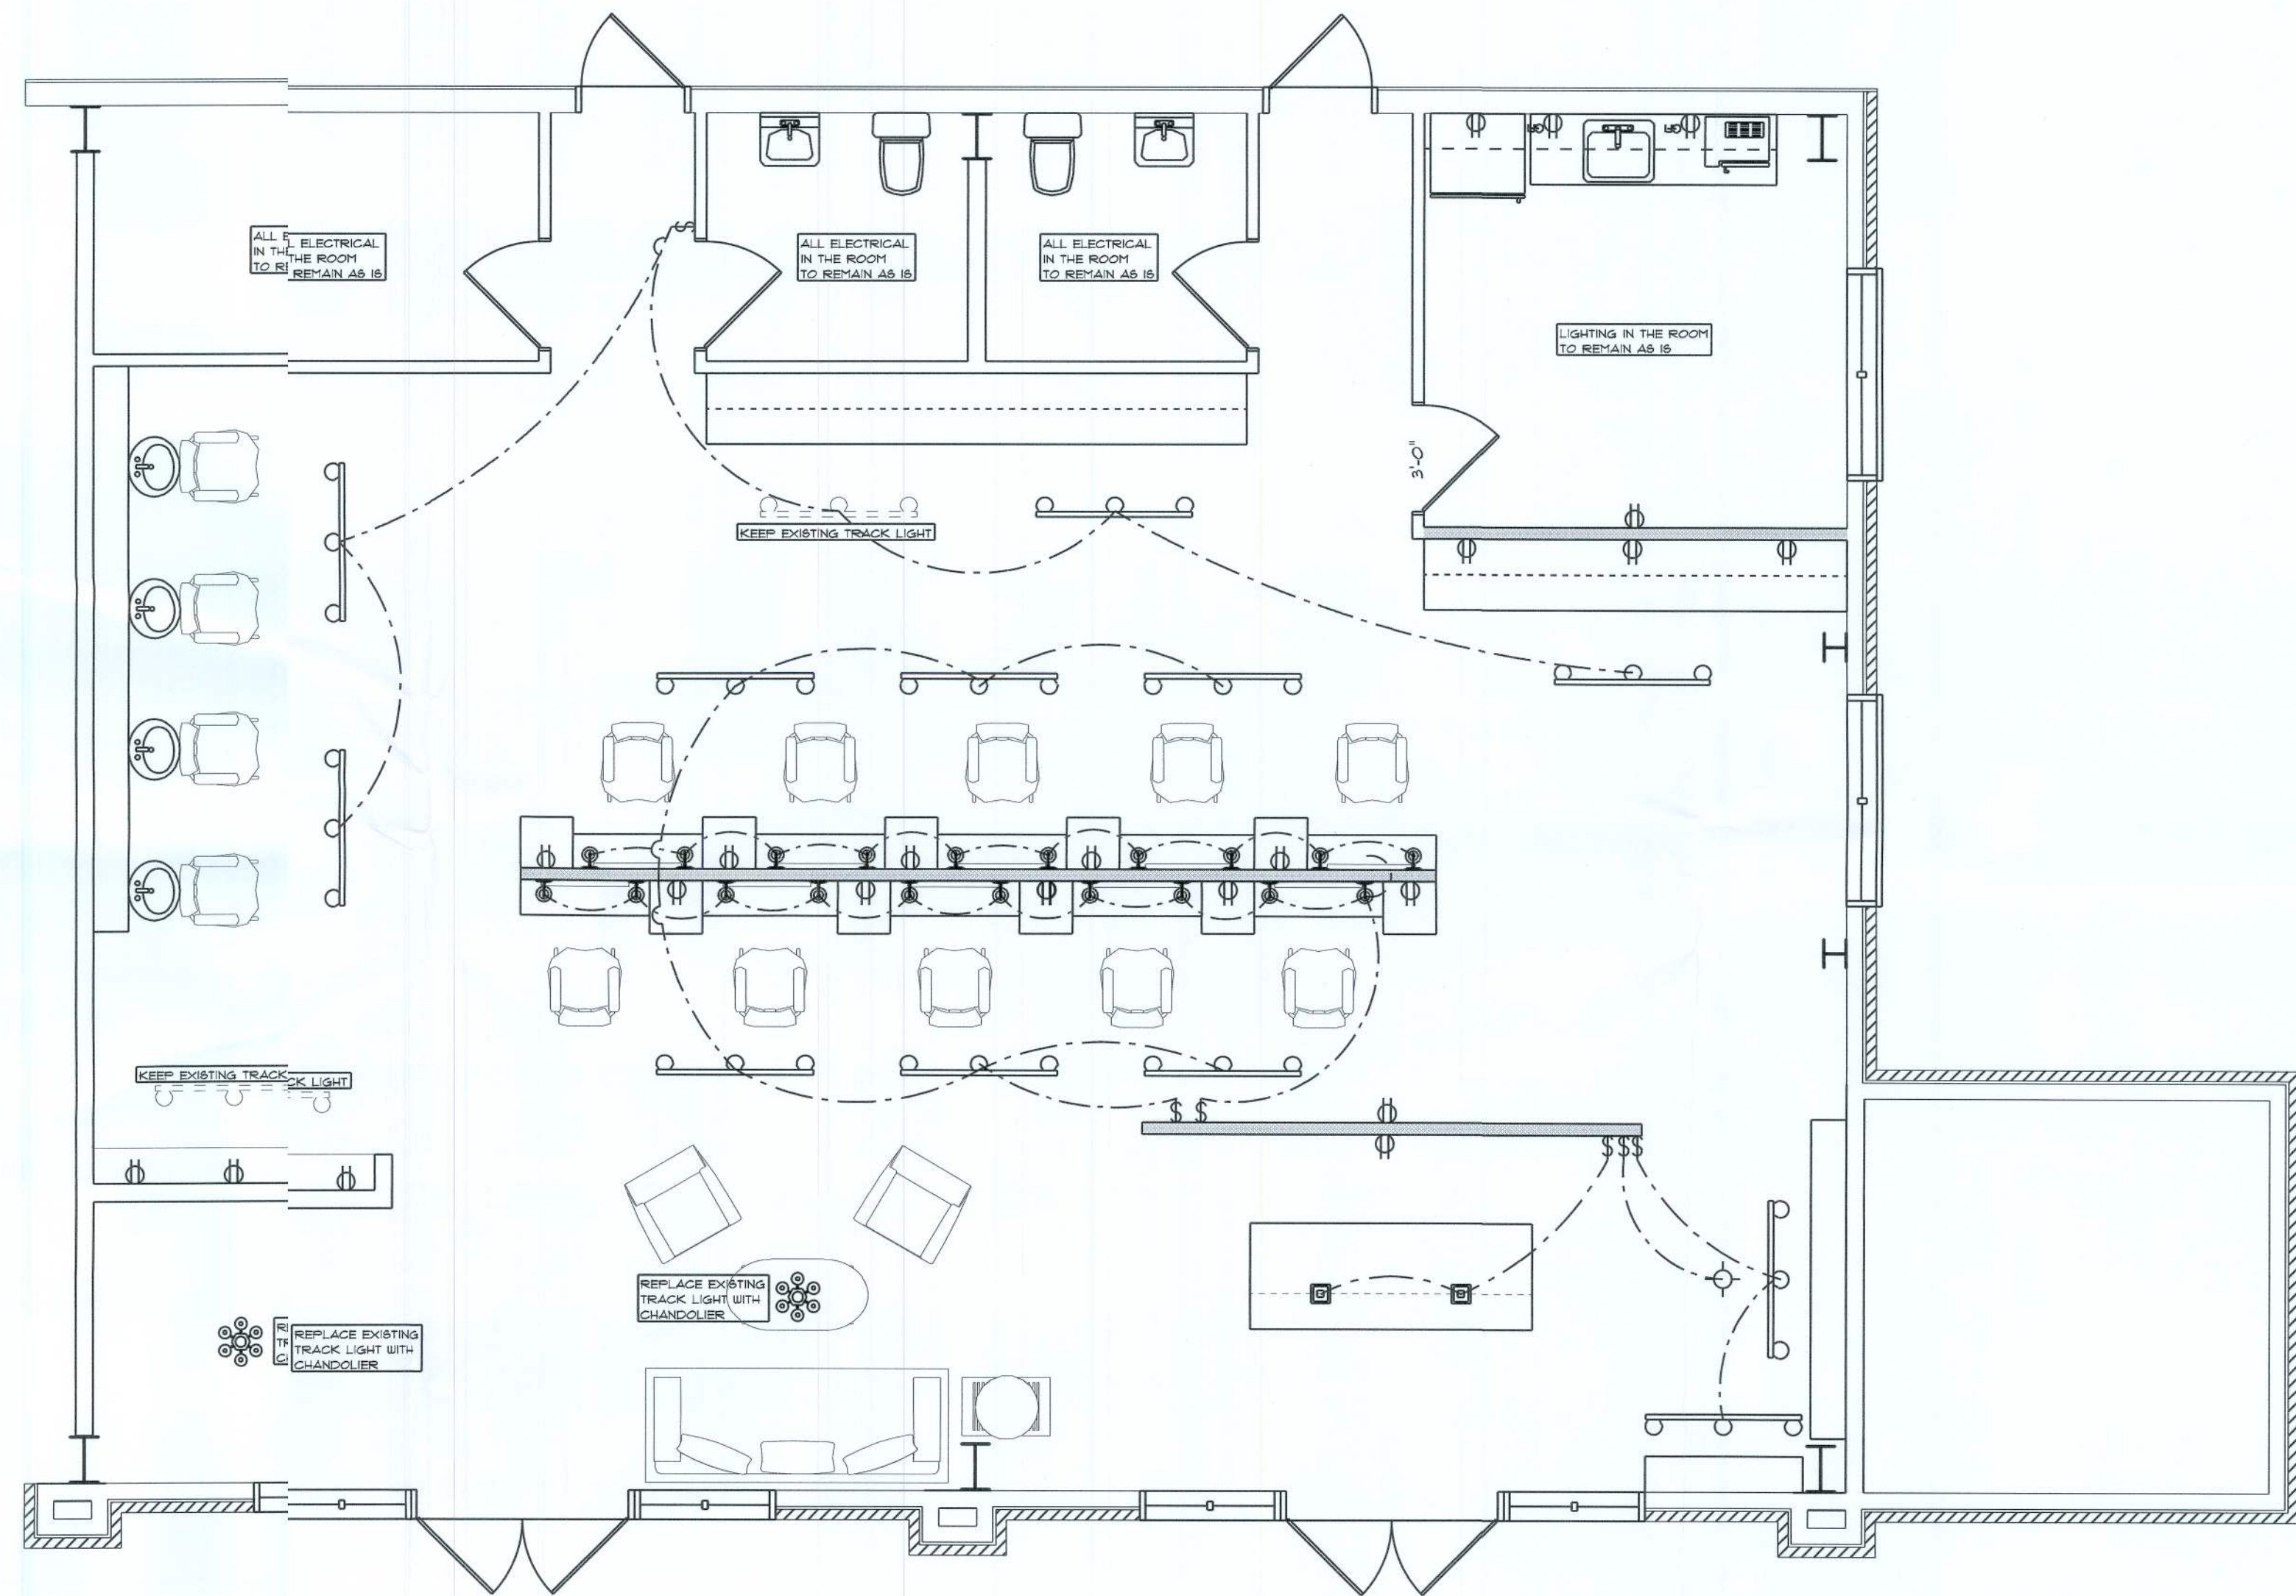

RENOWNED ELECTRICAL

SCALE: 1/4" = 1'-0"

ALL NEW ELECTRICAL WILL TIE INTO EXISTING ELECTRICAL PANELS. ELECTRICAL CONTRACTOR WILL BE RESPONSIBLE FOR SUBMITTING DRUGS & FORMS NECESSARY FOR PERMITTING.

REVISION:

RESIDENTIAL + COMMERCIAL
BUILDING DESIGN CO.
REVOLUTIONS NEW 8008
CBC 1264659
330 SW BLAYLOCK COURT
LAKE CITY, FL 32024
(386) 965 - 8340

BUILD-OUT RENOVATIONS FOR:
VERA SALON
LAKE CITY, FLORIDA

RIDGEPOINT
DESIGN
360 NW 10TH AVE, SUITE 101, LAKE CITY, FL 32025
P: 386-288-1188
E: RIDGEPOINTDESIGN@GMAIL.COM

Celebrating
45 Years of Service
1972 - 2021
N.E. CONTRACTORS
MEMBERSHIP

NICOLAS
PAUL
GEBLER
ARCHITECT
780 NW 8TH AVE
LAKE CITY, FL 32026
386-999-9999

DATE:
28th JUNE 2021
COMM:

SHEET:
A.5
5 OF 6

15 July 2021
AR0007005