
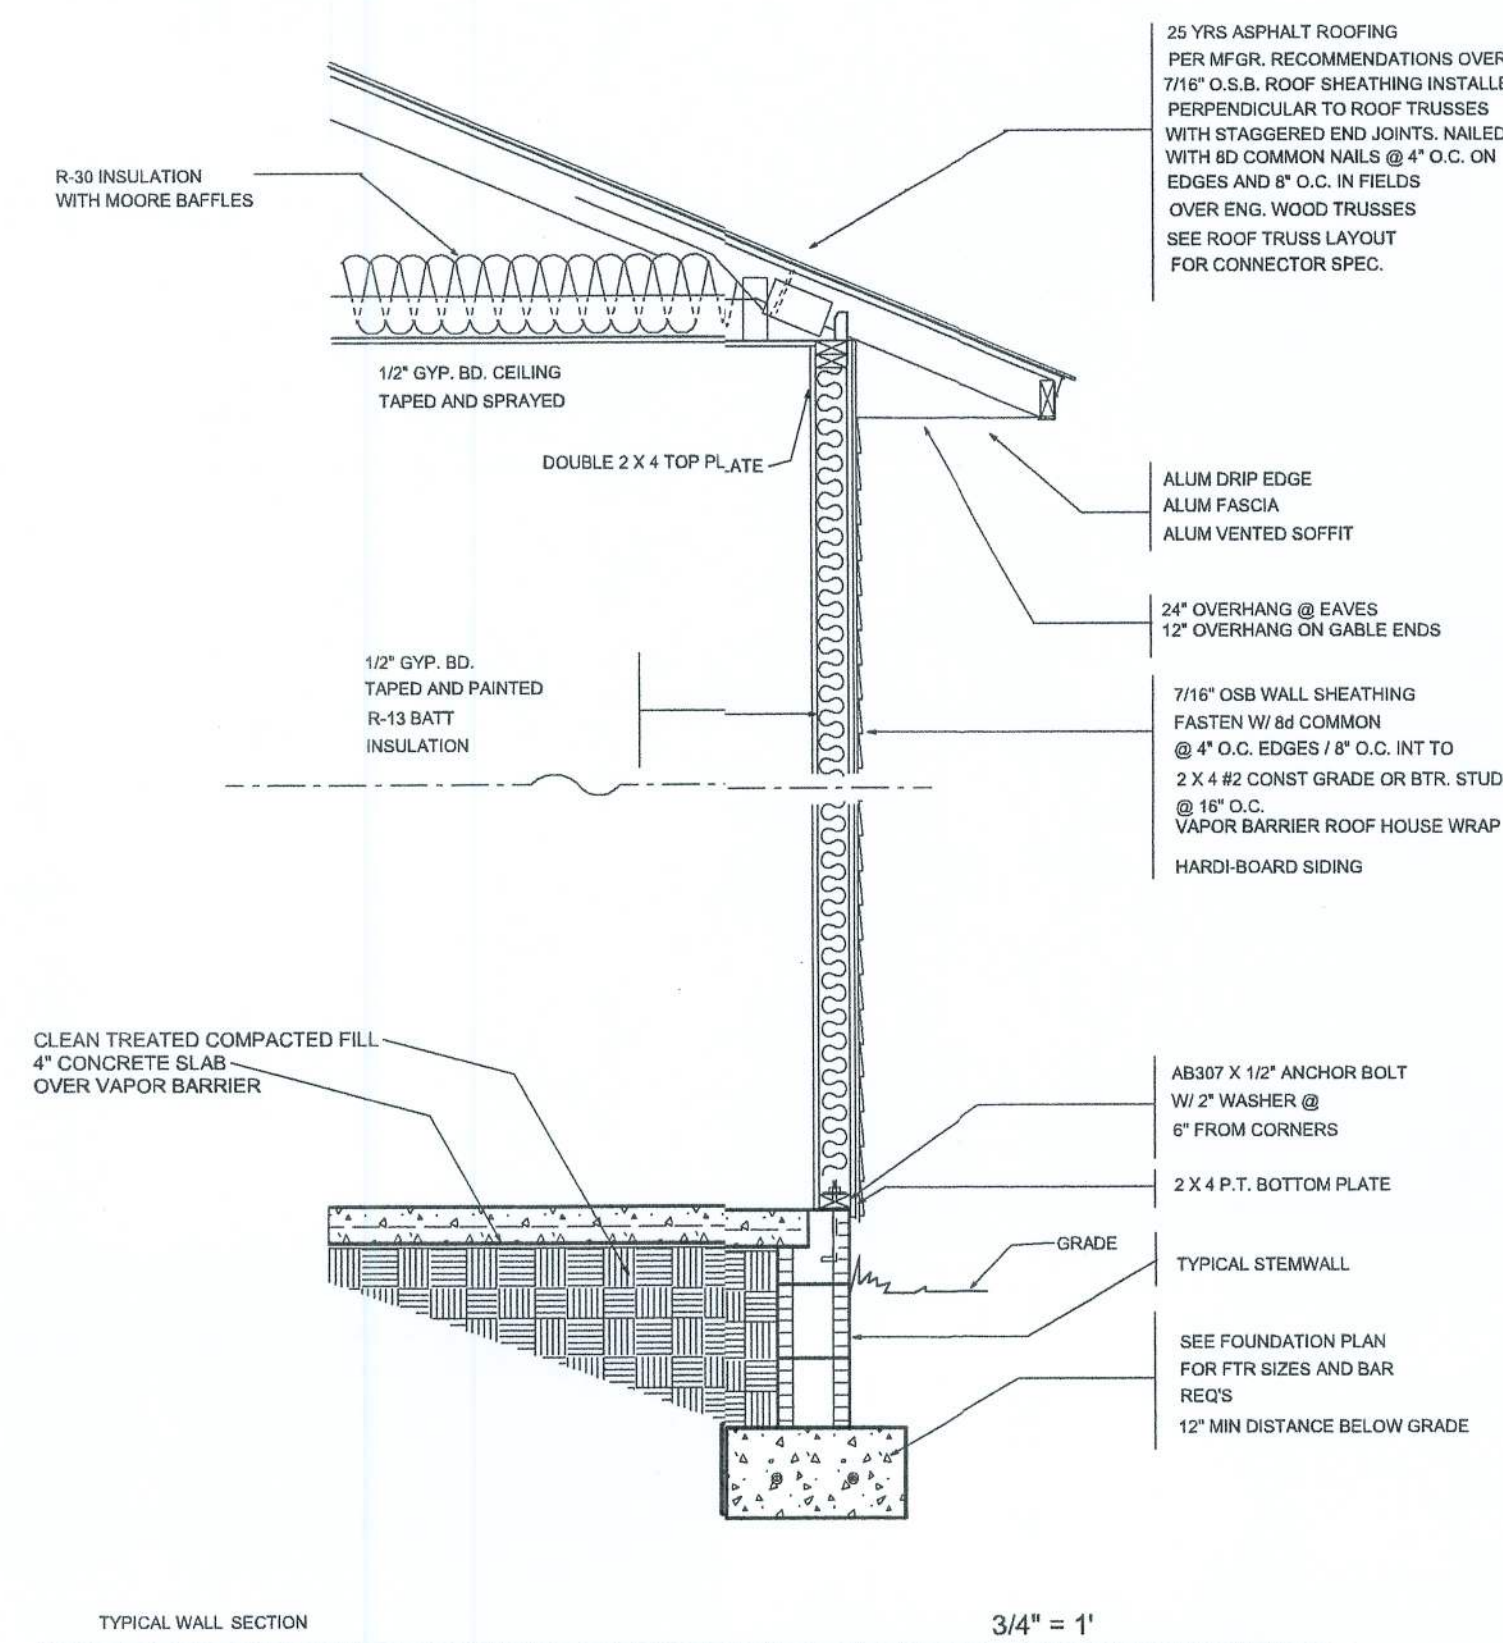
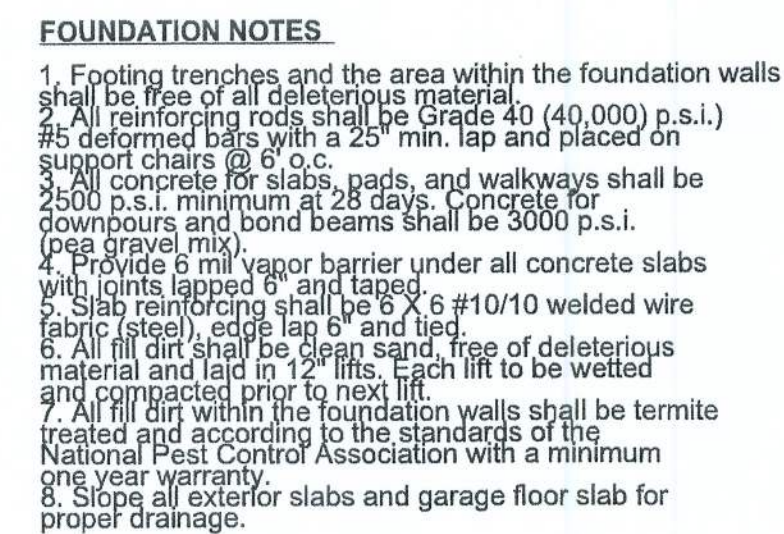


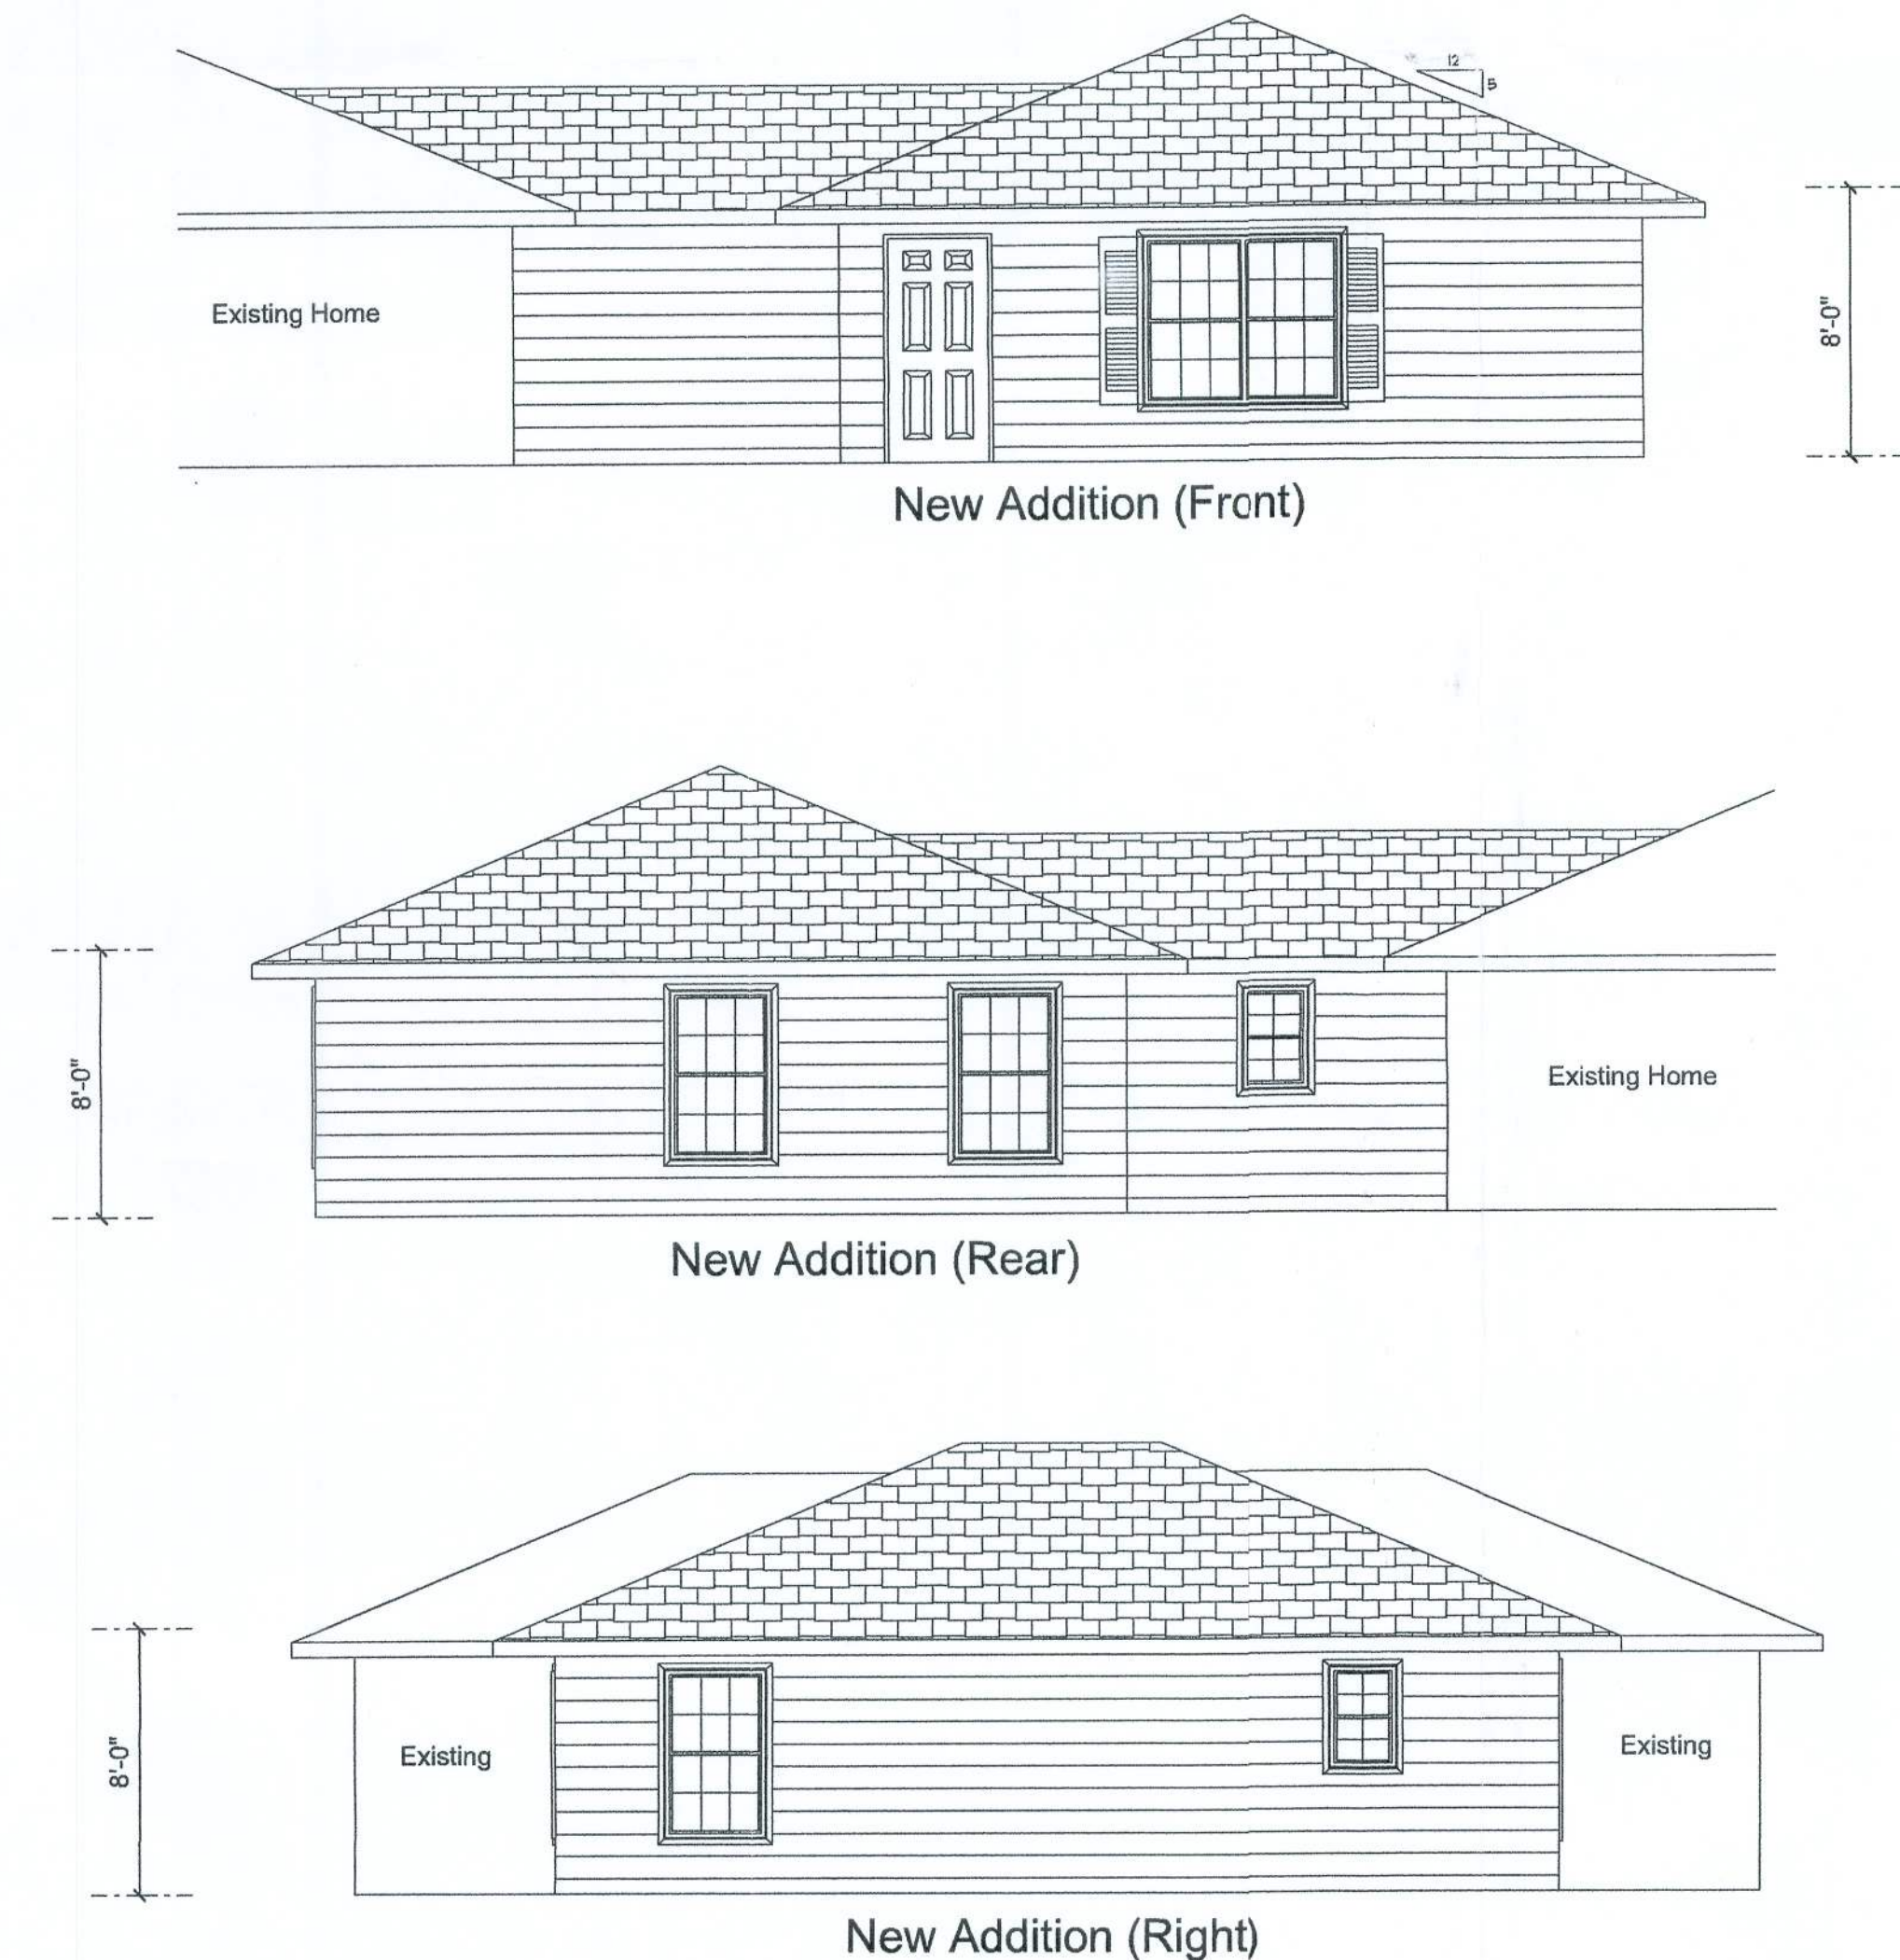

WIRE ALL APPLIANCES, HVAC UNIT AND OTHER EQUIPMENT PER MANUFACTURER SPECS

INSTALLATION SHALL BE PER NATIONAL ELECTRIC CODE


TELEPHONE, T.V. AND OTHER LOW VOLTAGE
DEVICES OR OUTLETS SHALL BE AS PER THE OWNERS
DIRECTIONS AND IN ACCORDANCE WITH APPLICABLE
SECTIONS OF NEC-LATEST EDITIONS

ALL SMOKE DETECTORS SHALL BE 120V WITH BATTERY
BACKUP OF THE PHOTOELECTRIC TYPE, AND SHALL BE
INTERLOCKED TOGETHER

ALL MATERIAL SHALL HAVE A UL LABEL OR LISTING

ALL BEDROOM OUTLETS TO BE ARC-FAULT BREAKERS
OR GFI OUTLETS

HVAC UPGRADE TO BE DETERMINED BY HVAC CONTRACTOR

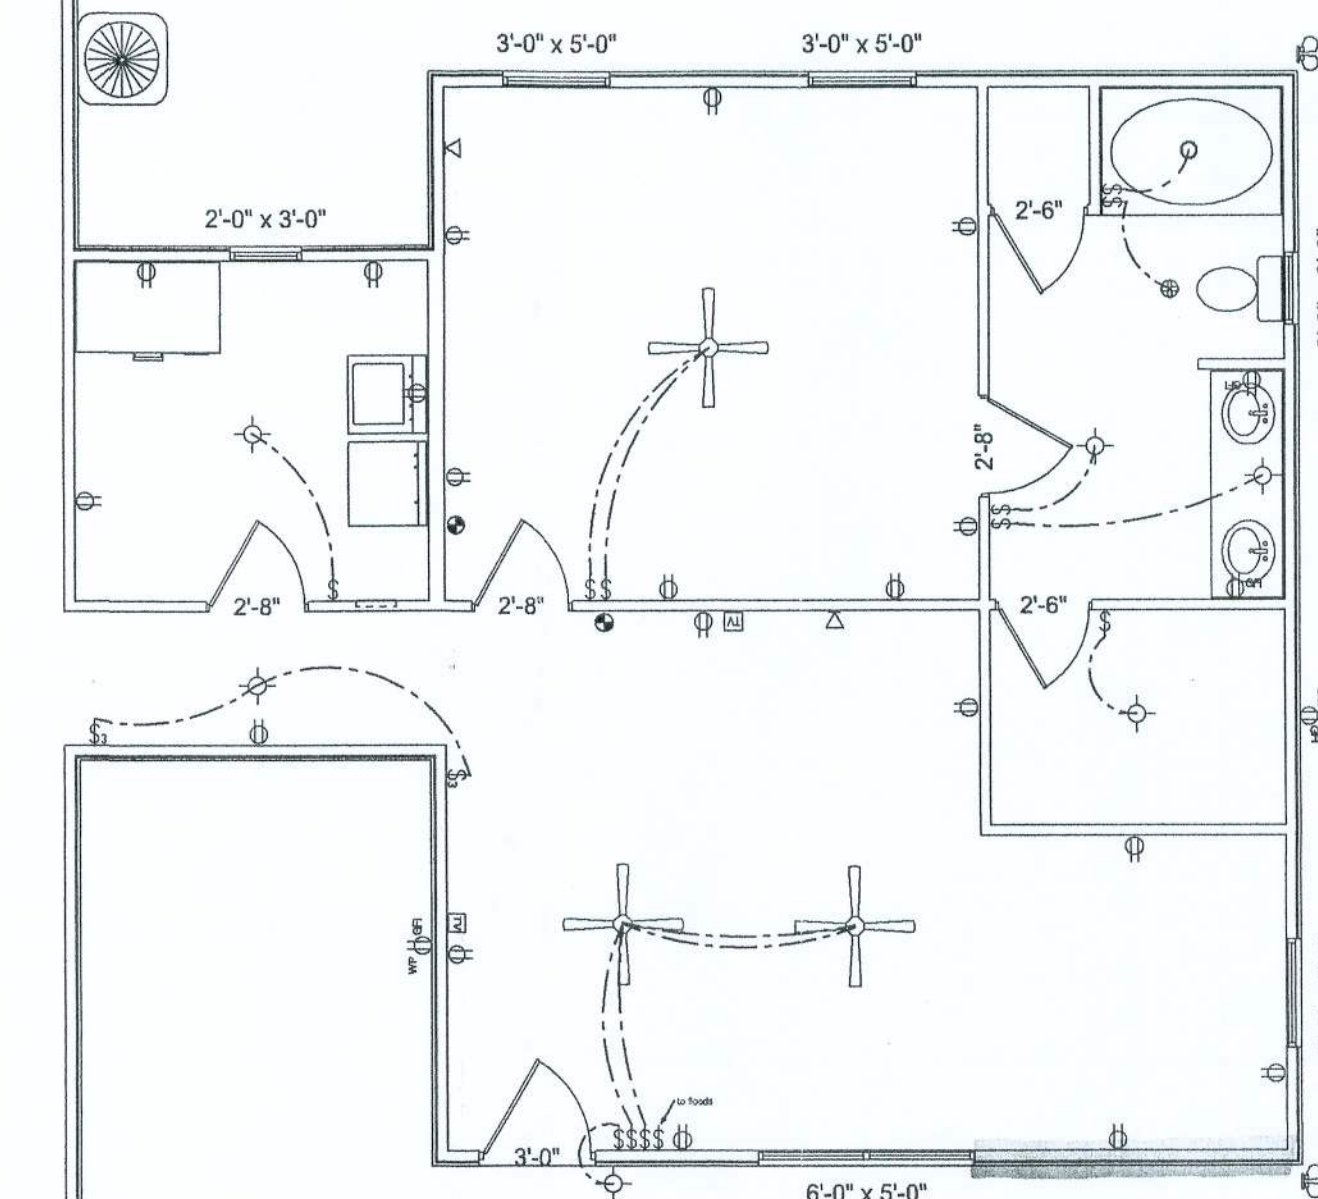

ELECTRICAL PLAN

NAME	AREA
Addition	720 sq ft.
Laundry	140 sq ft.
Total	860 sq ft.

It is important that the Client and Contractor examine the drawings and documentation in detail. It shall be the final responsibility of the Contractor to review and check the plans for accuracy and compliance with regulatory agencies. It is customary and ordinary not to include details well within the knowledge of licensed Contractor. If necessary, further clarification of these plans should be obtained before signing the construction contract and obtaining a building permit, otherwise the Contractor assumes responsibility for the construction in question. Methods of construction shall be determined by the Contractor.

DRAWN BY:
JASON ELIXSON CONSTRUCTION, LLC
4853 WEST SR. 238
LAKE BUTLER, FL. 32054
(386) 623-1741

Glen and Tscharna Keen Addition

Columbia Co.

DATE: 09-19-07

SCALE: 3/16" = 1 Foot

PAGE

1