


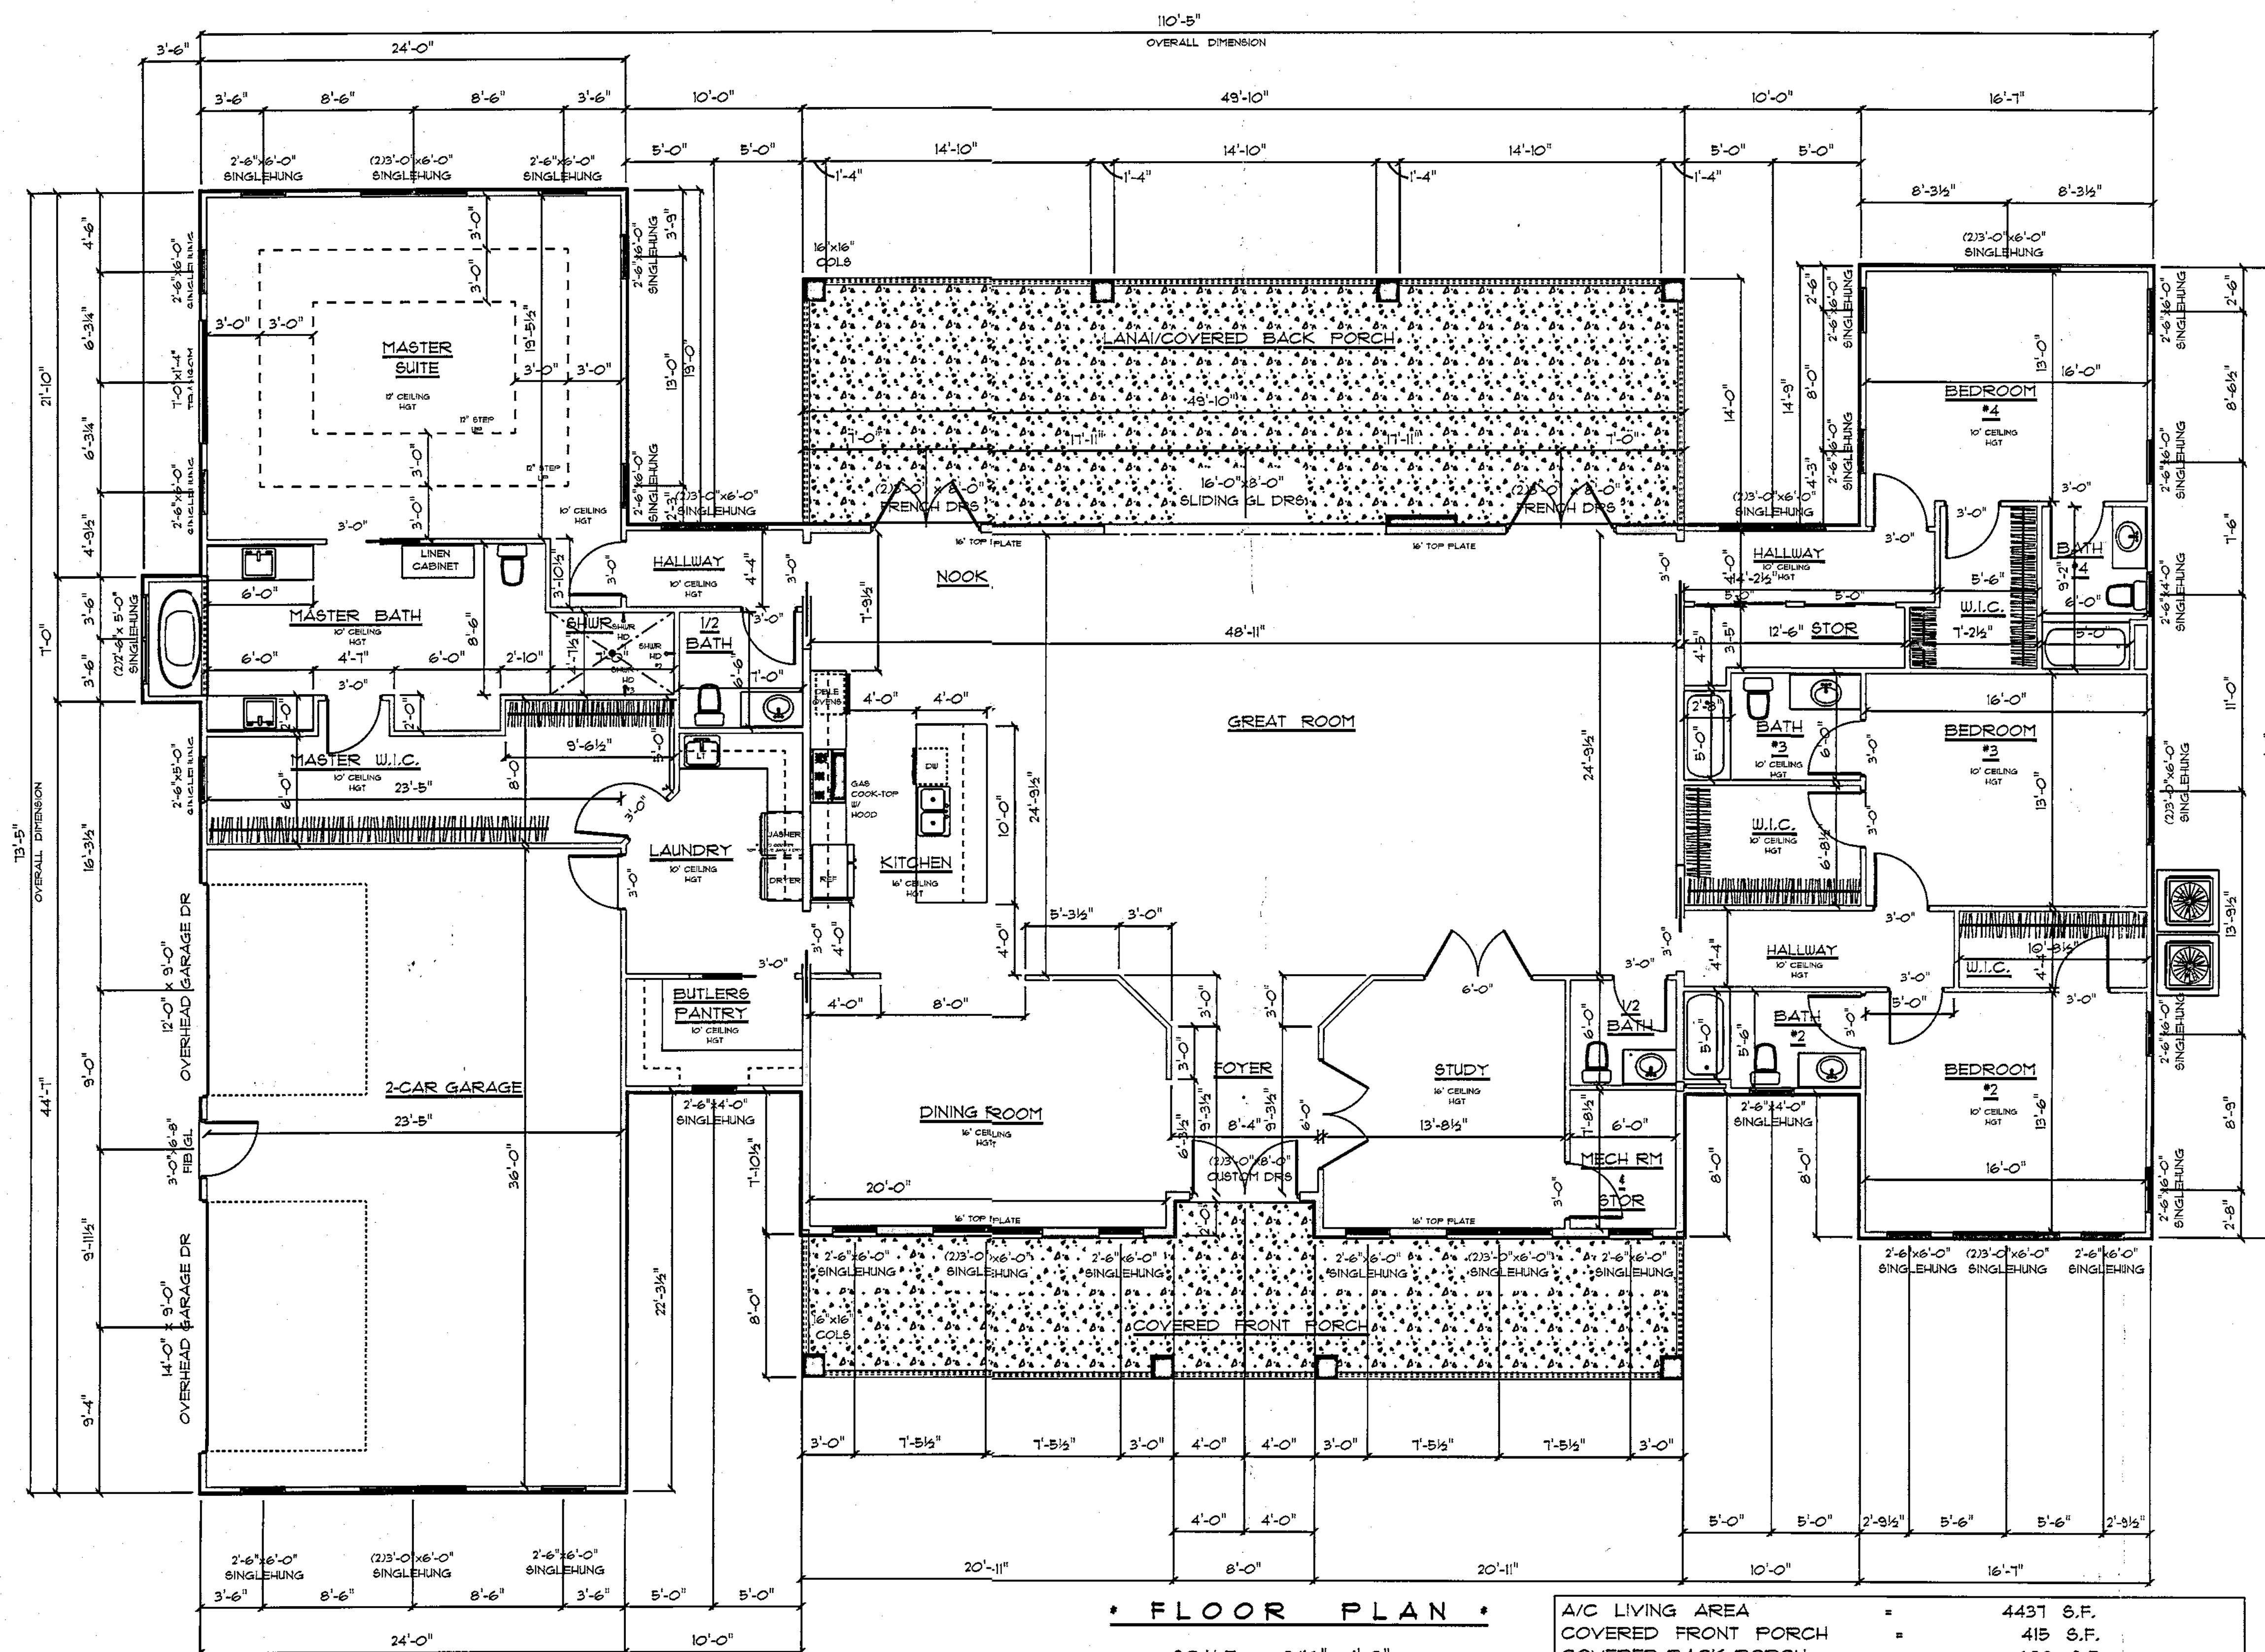

* FLOOR PLAN *

SCALE : 3/16" = 1'-0"

IMPORTANT NOTE:
 1. IT IS THE BUILDER'S RESPONSIBILITY TO VERIFY ALL GEOMETRY AND DIMENSIONS, BEFORE ORDERING ANY MATERIALS OR BEGINNING CONSTRUCTION.
 2. THESE PLANS ARE FOR LAYOUT AND DESIGN PURPOSES ONLY ALL STRUCTURAL NOTES AND DETAILS TO BE PROVIDED BY AN ENGINEER.
 3. ALL EXTERIOR WALLS TO BE 2X6 FRAMING ALL INTERIOR WALLS 2X4.
 4. ALL DOORS & CASED OPENINGS ON 1ST FLOOR TO BE 8'-0" TALL SECOND FLOOR DOORS TO BE 6'-8".

A/C LIVING AREA	=	4431 S.F.
COVERED FRONT PORCH	=	415 S.F.
COVERED BACK PORCH	=	638 S.F.
2 CAR GARAGE	=	878 S.F.
TOTAL AREA UNDER ROOF	=	6428 S.F.

RESIDENCE
 for
 MARK & LAUREN
 GANSKOP

FLORIDA

Teresa M. Ruffo
 2825 SW 8th St. 41
 Lake City, Florida, 33025
 Cell: (386) 867-1191
 Email: terauruffo@gmail.com

PRINTED DATE:
 Saturday, September 21, 2010

DRAWN BY: Teresa M. Ruffo

CHECKED BY:

BUILDING CONTRACTOR

FINAL DATE:

JOB NUMBER:

DRAWING NUMBER


A-1

OF 5 SHEETS



*** FRONT ELEVATION ***

SCALE : 1/4" = 1'-0"

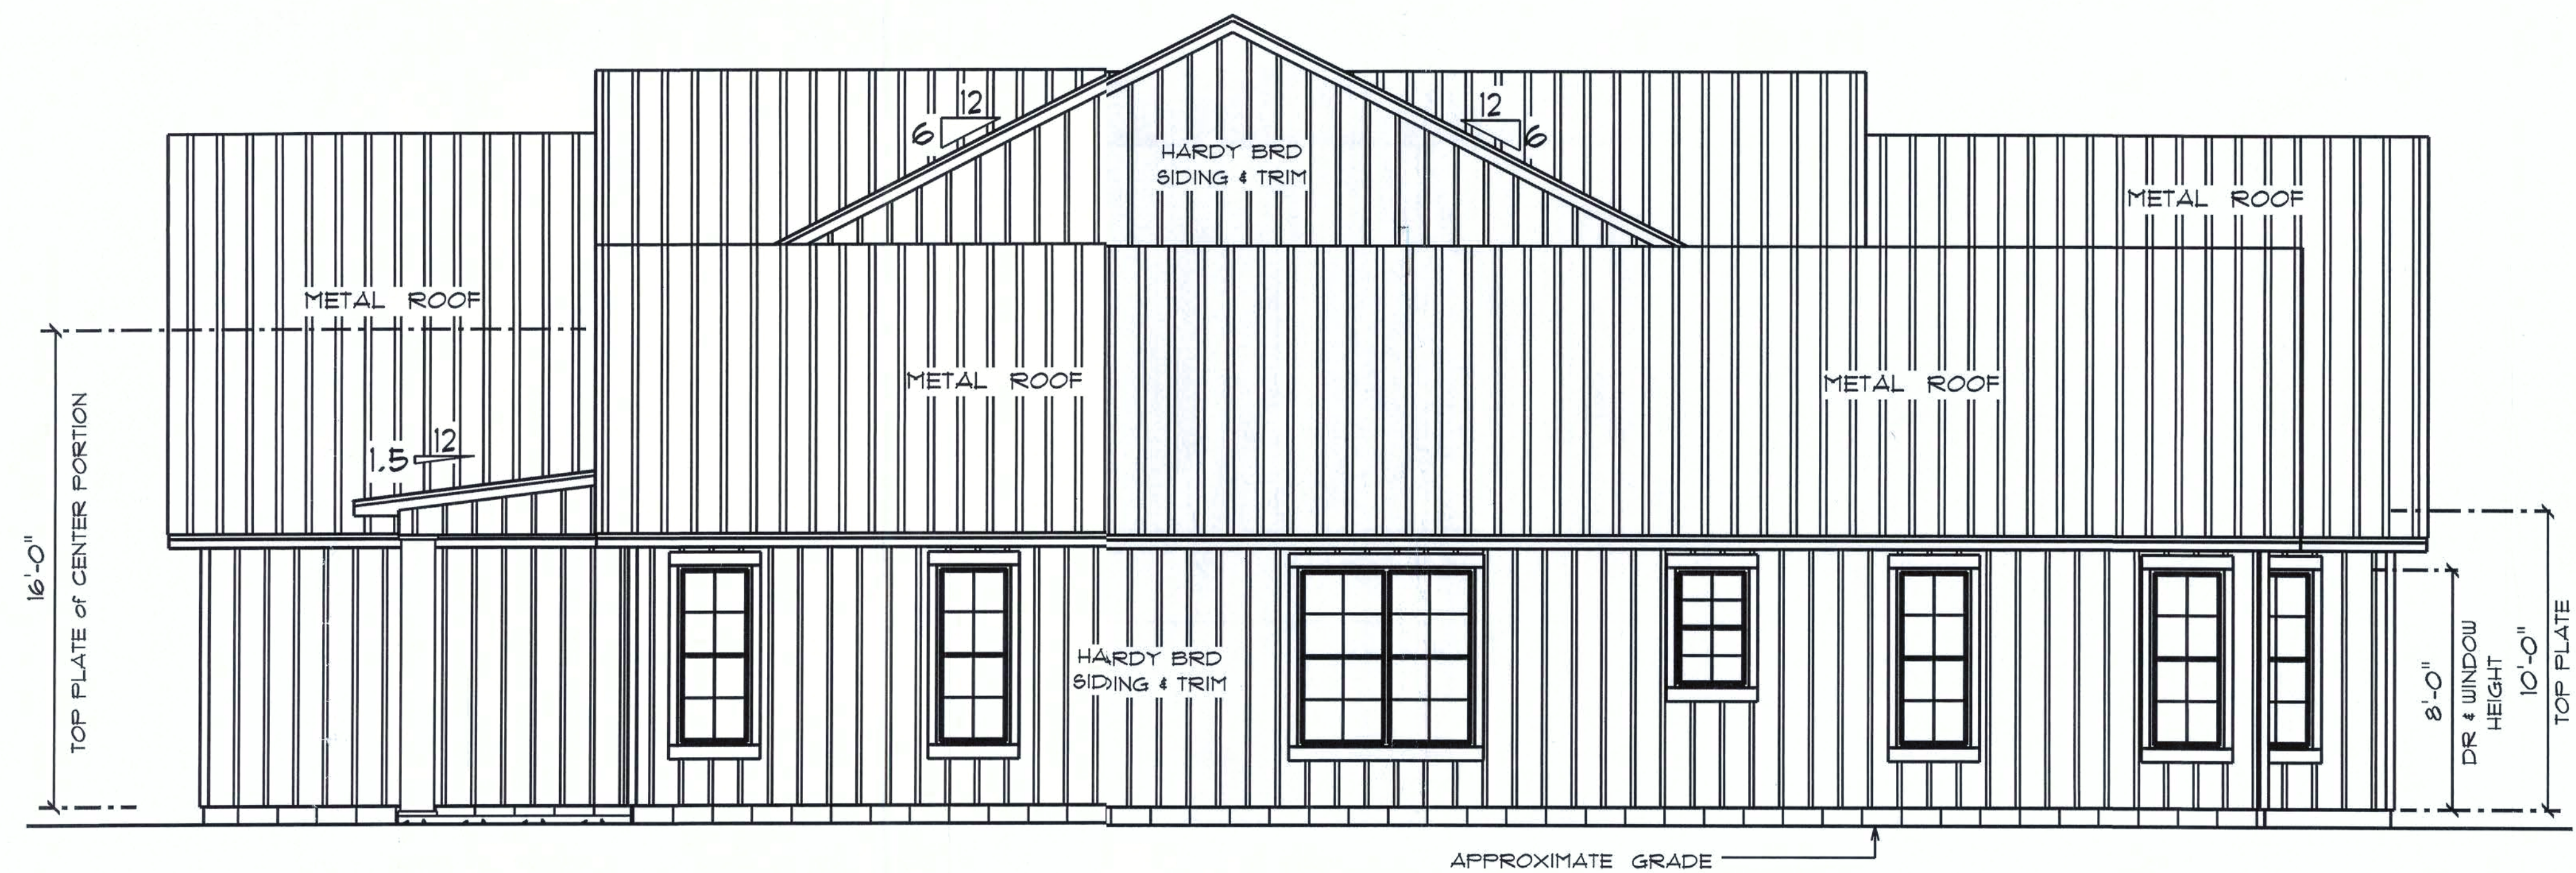

*** RIGHT SIDE ELEVATION ***

SCALE : 3/16" = 1'-0"

RESIDENCE
FOR
MARK & LAUREN
GANSKOP

FLORIDA

Teena M. Ruffo
2925 SW SR 41
Lake City, Florida, 32026
Cell: (386) 861-1191
Email: teenauffo@gmail.com

PRINTED DATE:
Saturday, September 21, 20

DRAWN BY: Teena M. Ruffo CHECKED BY:

BUILDING CONTRACTOR

FINALS DATE:

JOB NUMBER:

DRAWING NUMBER


A-2

OF 5 SHEETS



*** REAR ELEVATION ***

SCALE : 1/4" = 1'-0"

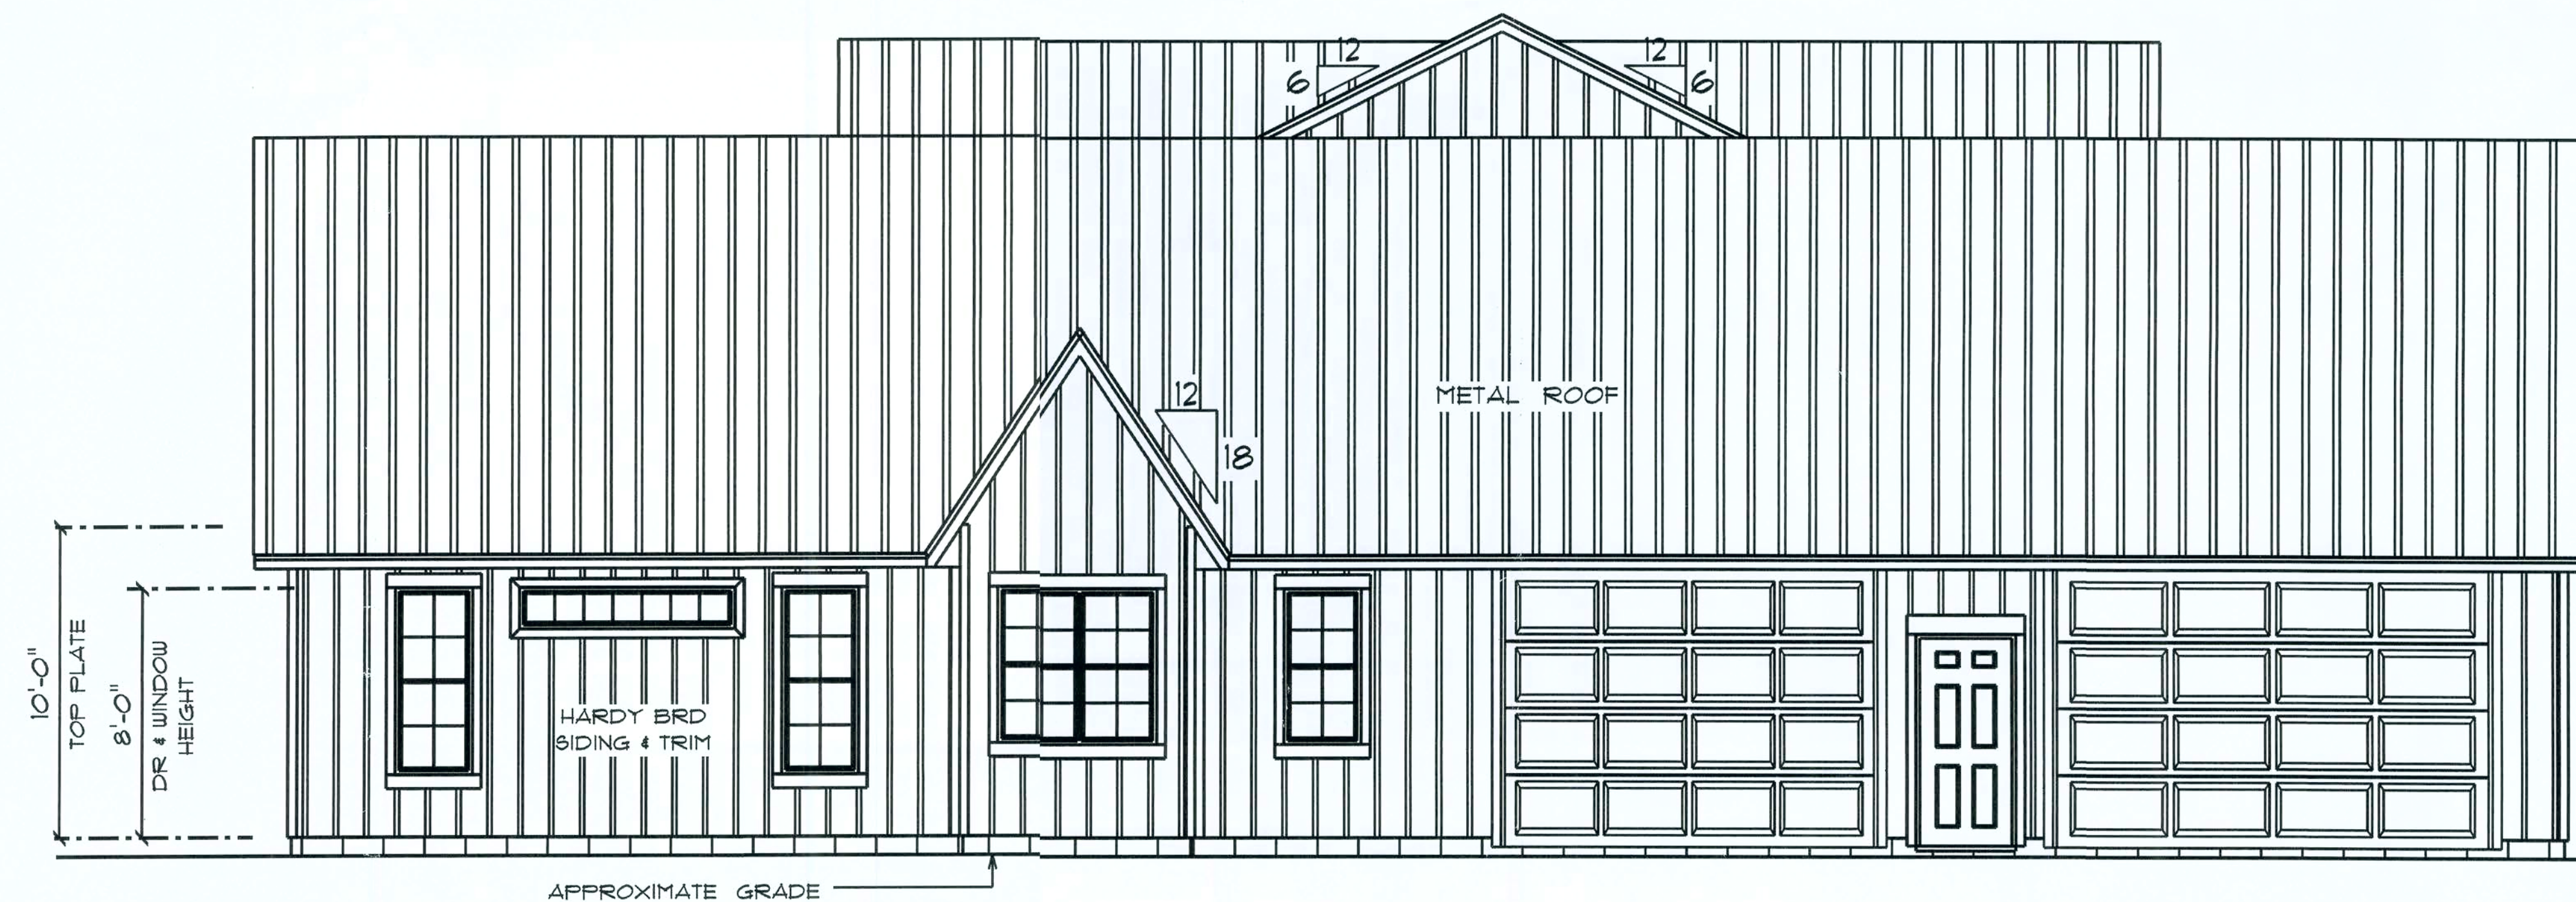

*** LEFT SIDE ELEVATION ***

SCALE : 3/16" = 1'-0"

RESIDENCE
for
MARK & LAUREN
GANSKOP

FLORIDA

Teens M. Ruffo
2825 SW 8R 41
Lake City Florida, 32025
Cell: (386) 867-1191
Email: teendruffo@gmail.com

PRINTED DATE:
Saturday, September 21, 20

DRAWN BY: CHECKED BY:

Teens M. Ruffo


BUILDING CONTRACTOR

FINALS DATE:

JOB NUMBER:


DRAWING NUMBER

OF 5 SHEETS

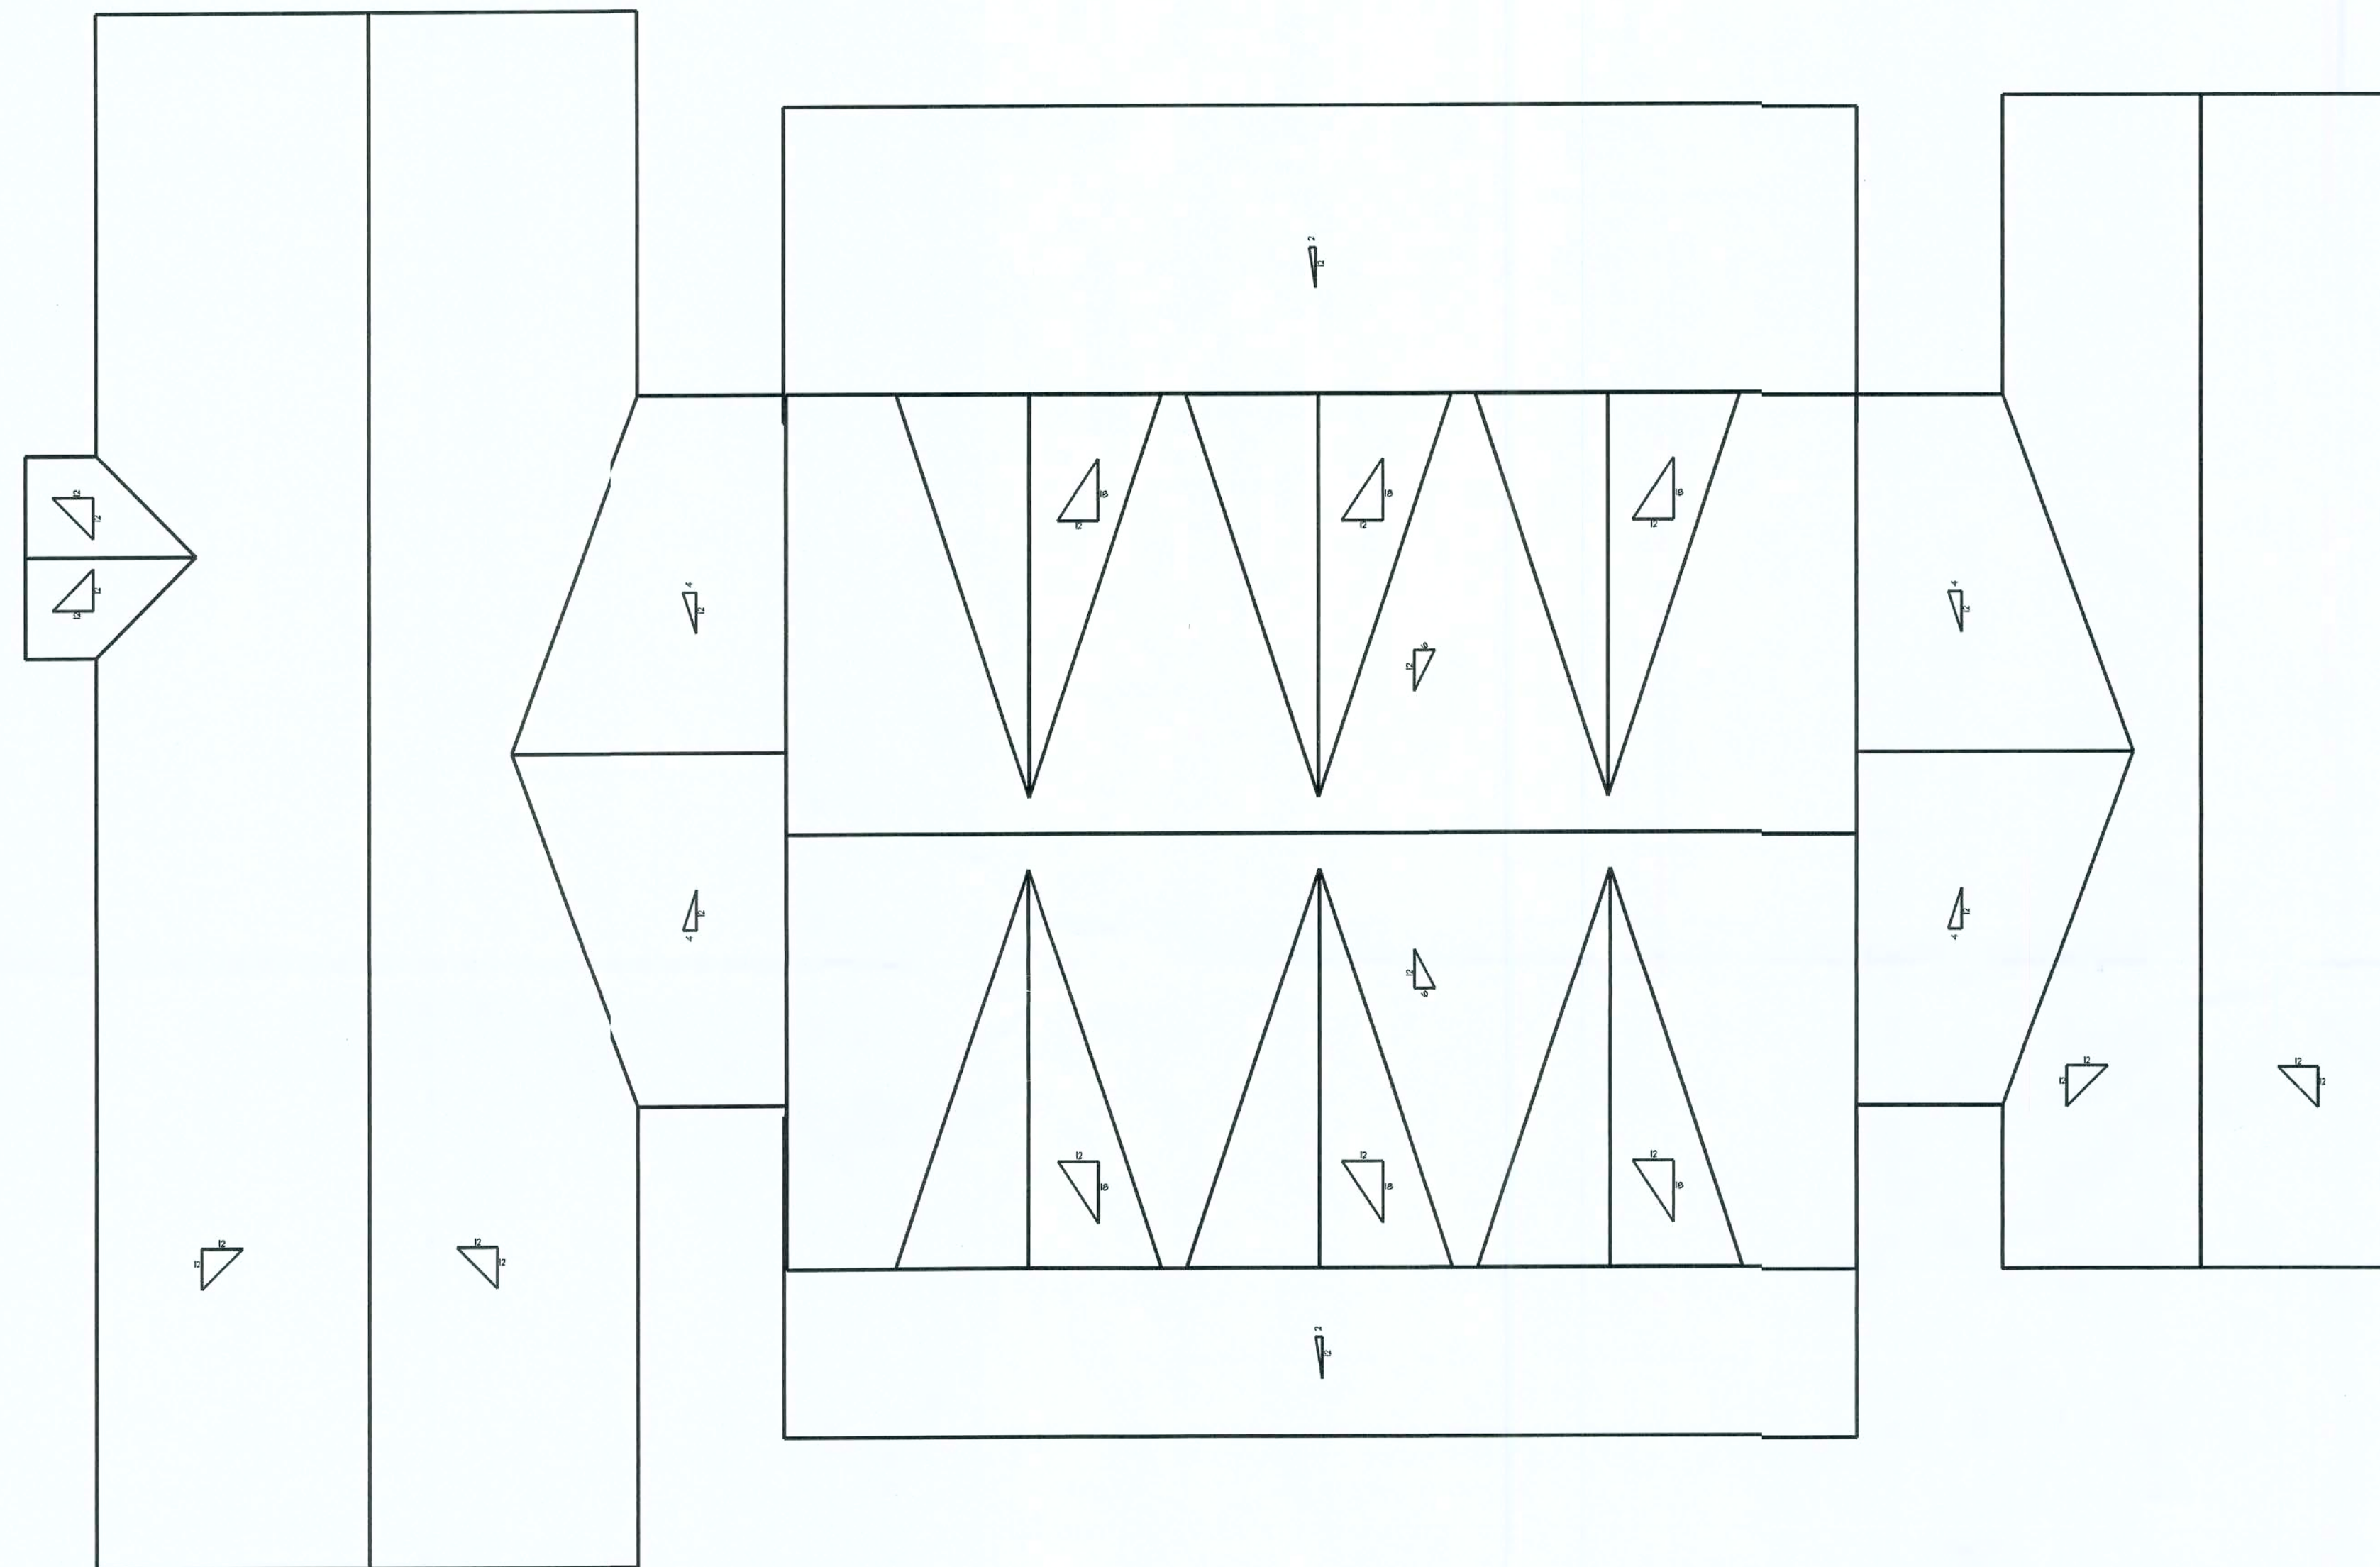

* ROOF PLAN *

N.T.S.

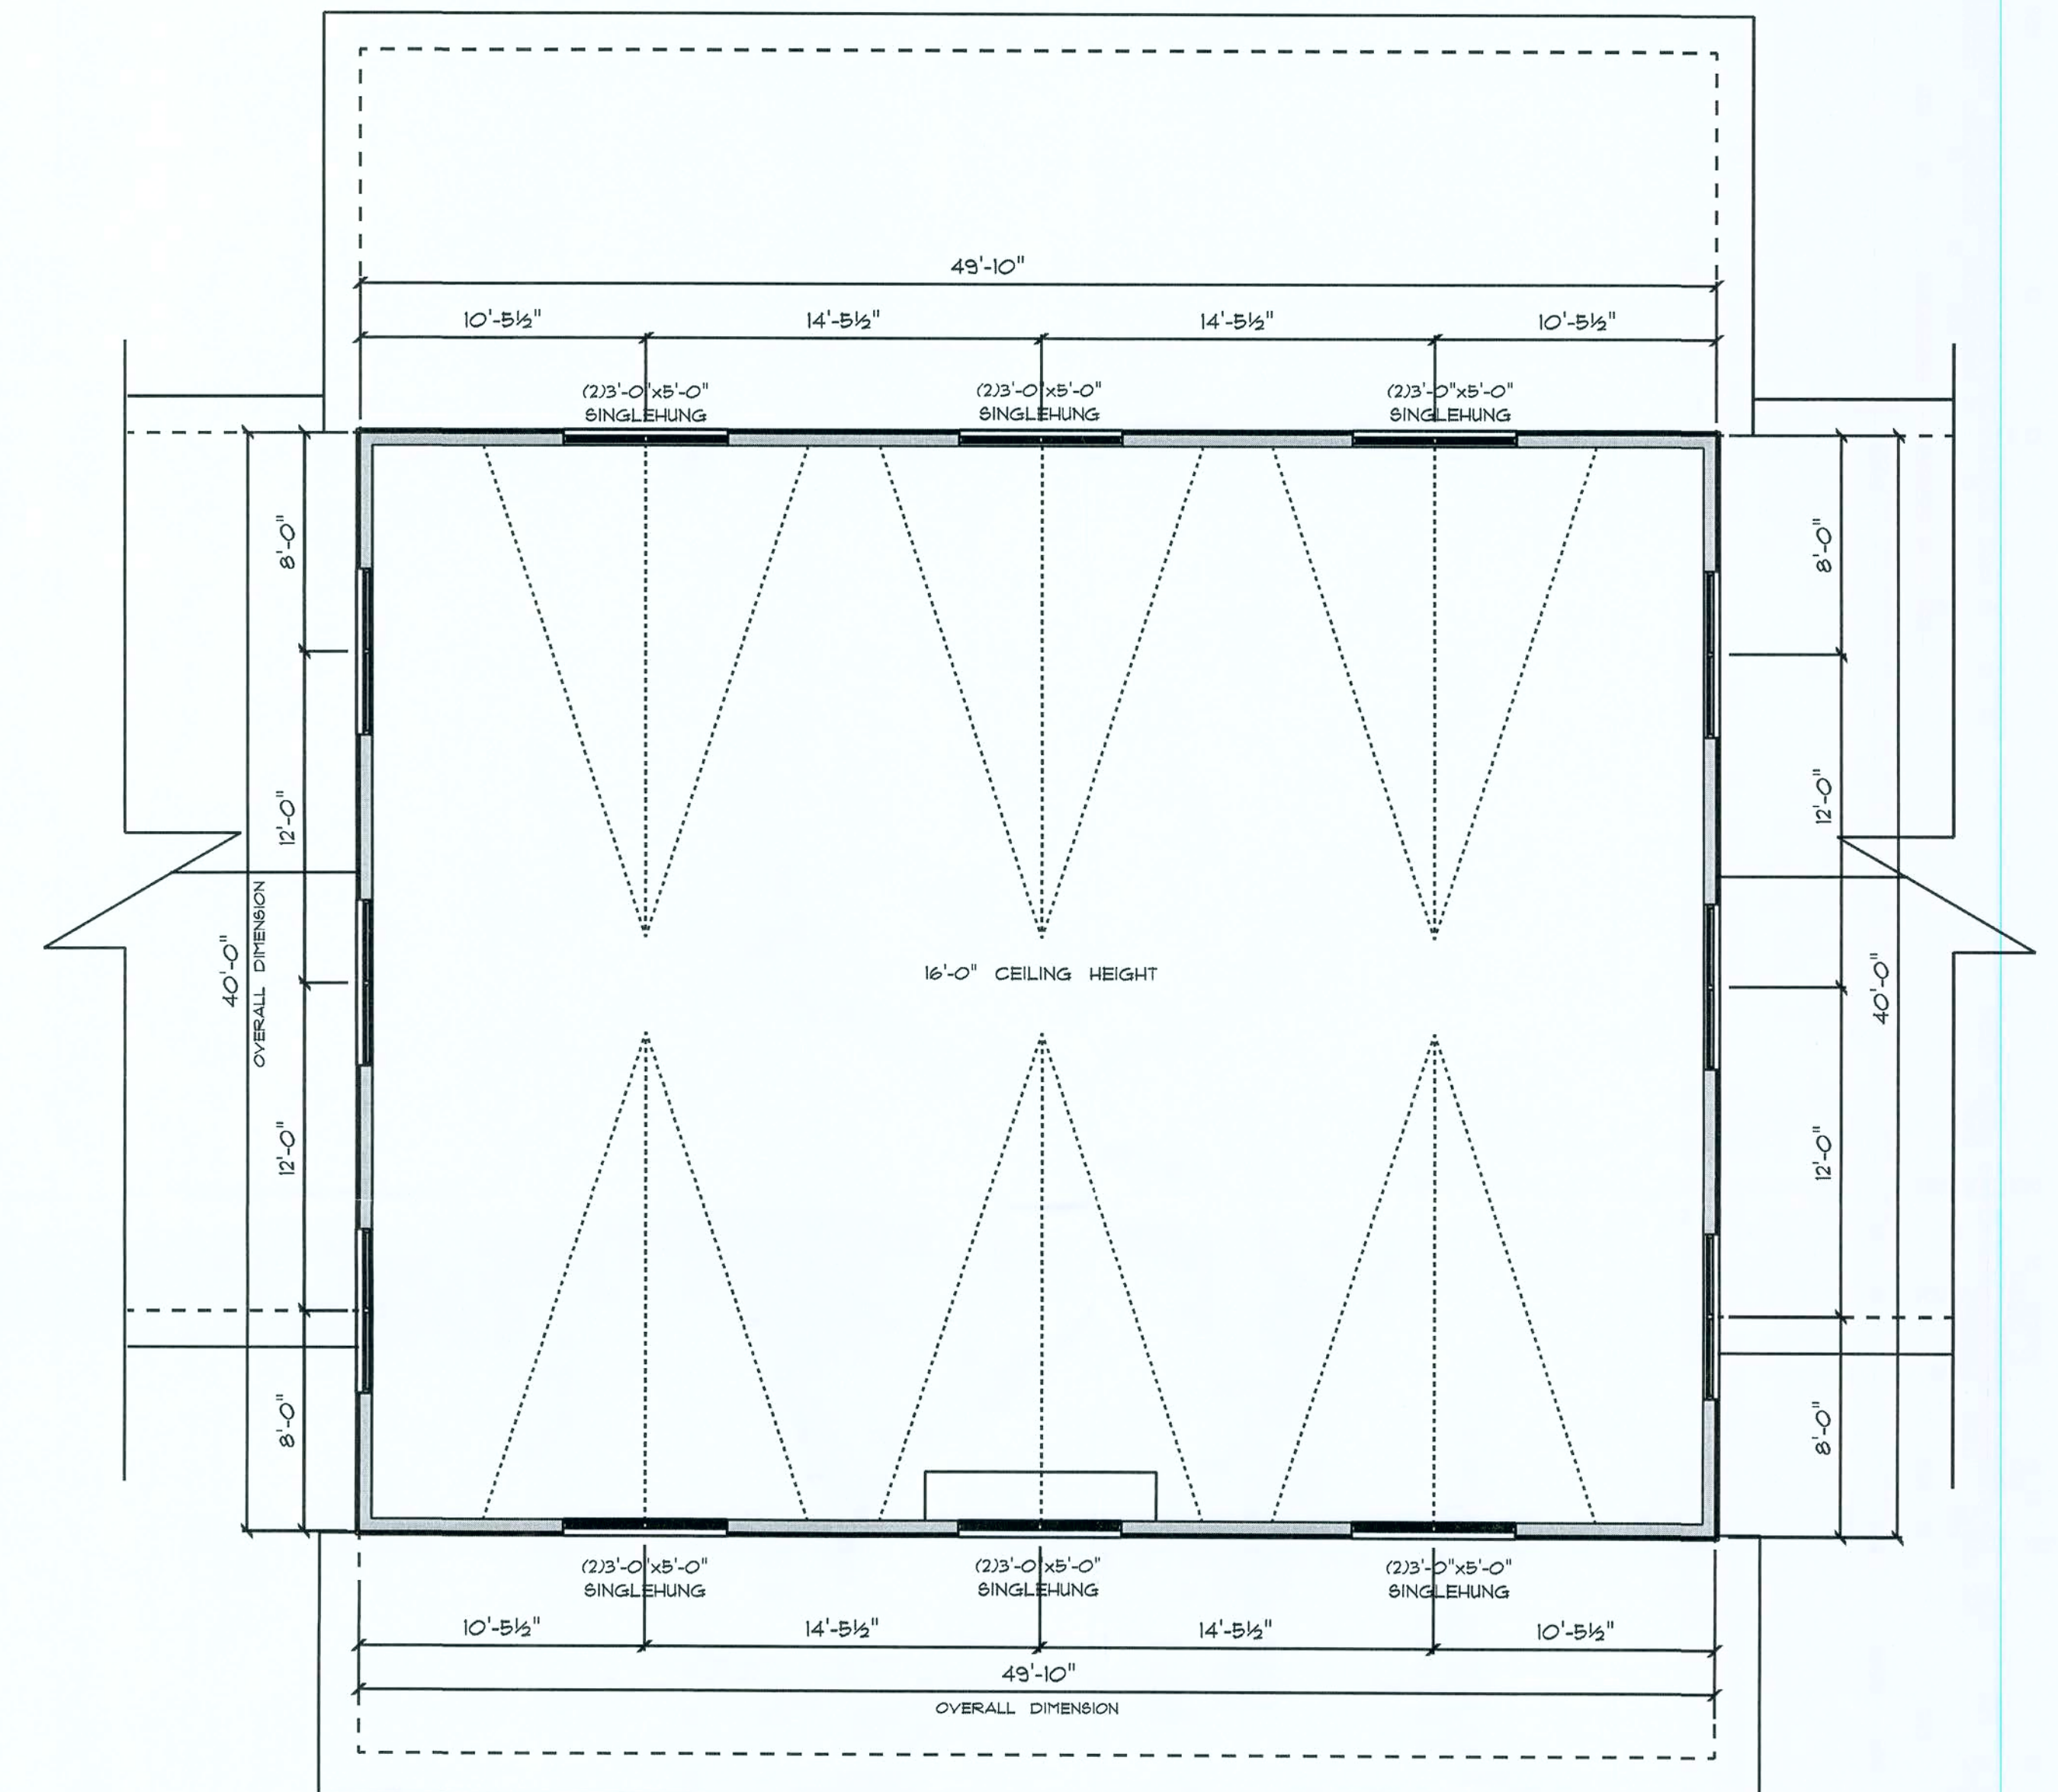

* MAIN FLOOR UPPER WINDOWS PLAN *

SCALE : 3/16" = 1'-0"

RESIDENCE
FOR
MARK & LAUREN
GANSKOP

FLORIDA

Teresa M. Ruffo
2325 SW 8R 41
Lake City Florida, 32025
Cell: (352) 861-1181
Email: teresaruffo@gmail.com

PRINTED DATE:
Saturday, September 21, 20

DRAWN BY: Teresa M. Ruffo CHECKED BY:


BUILDING CONTRACTOR

FINAL DATE:

JOB NUMBER:

DRAWING NUMBER

A-4
OF 5 SHEETS

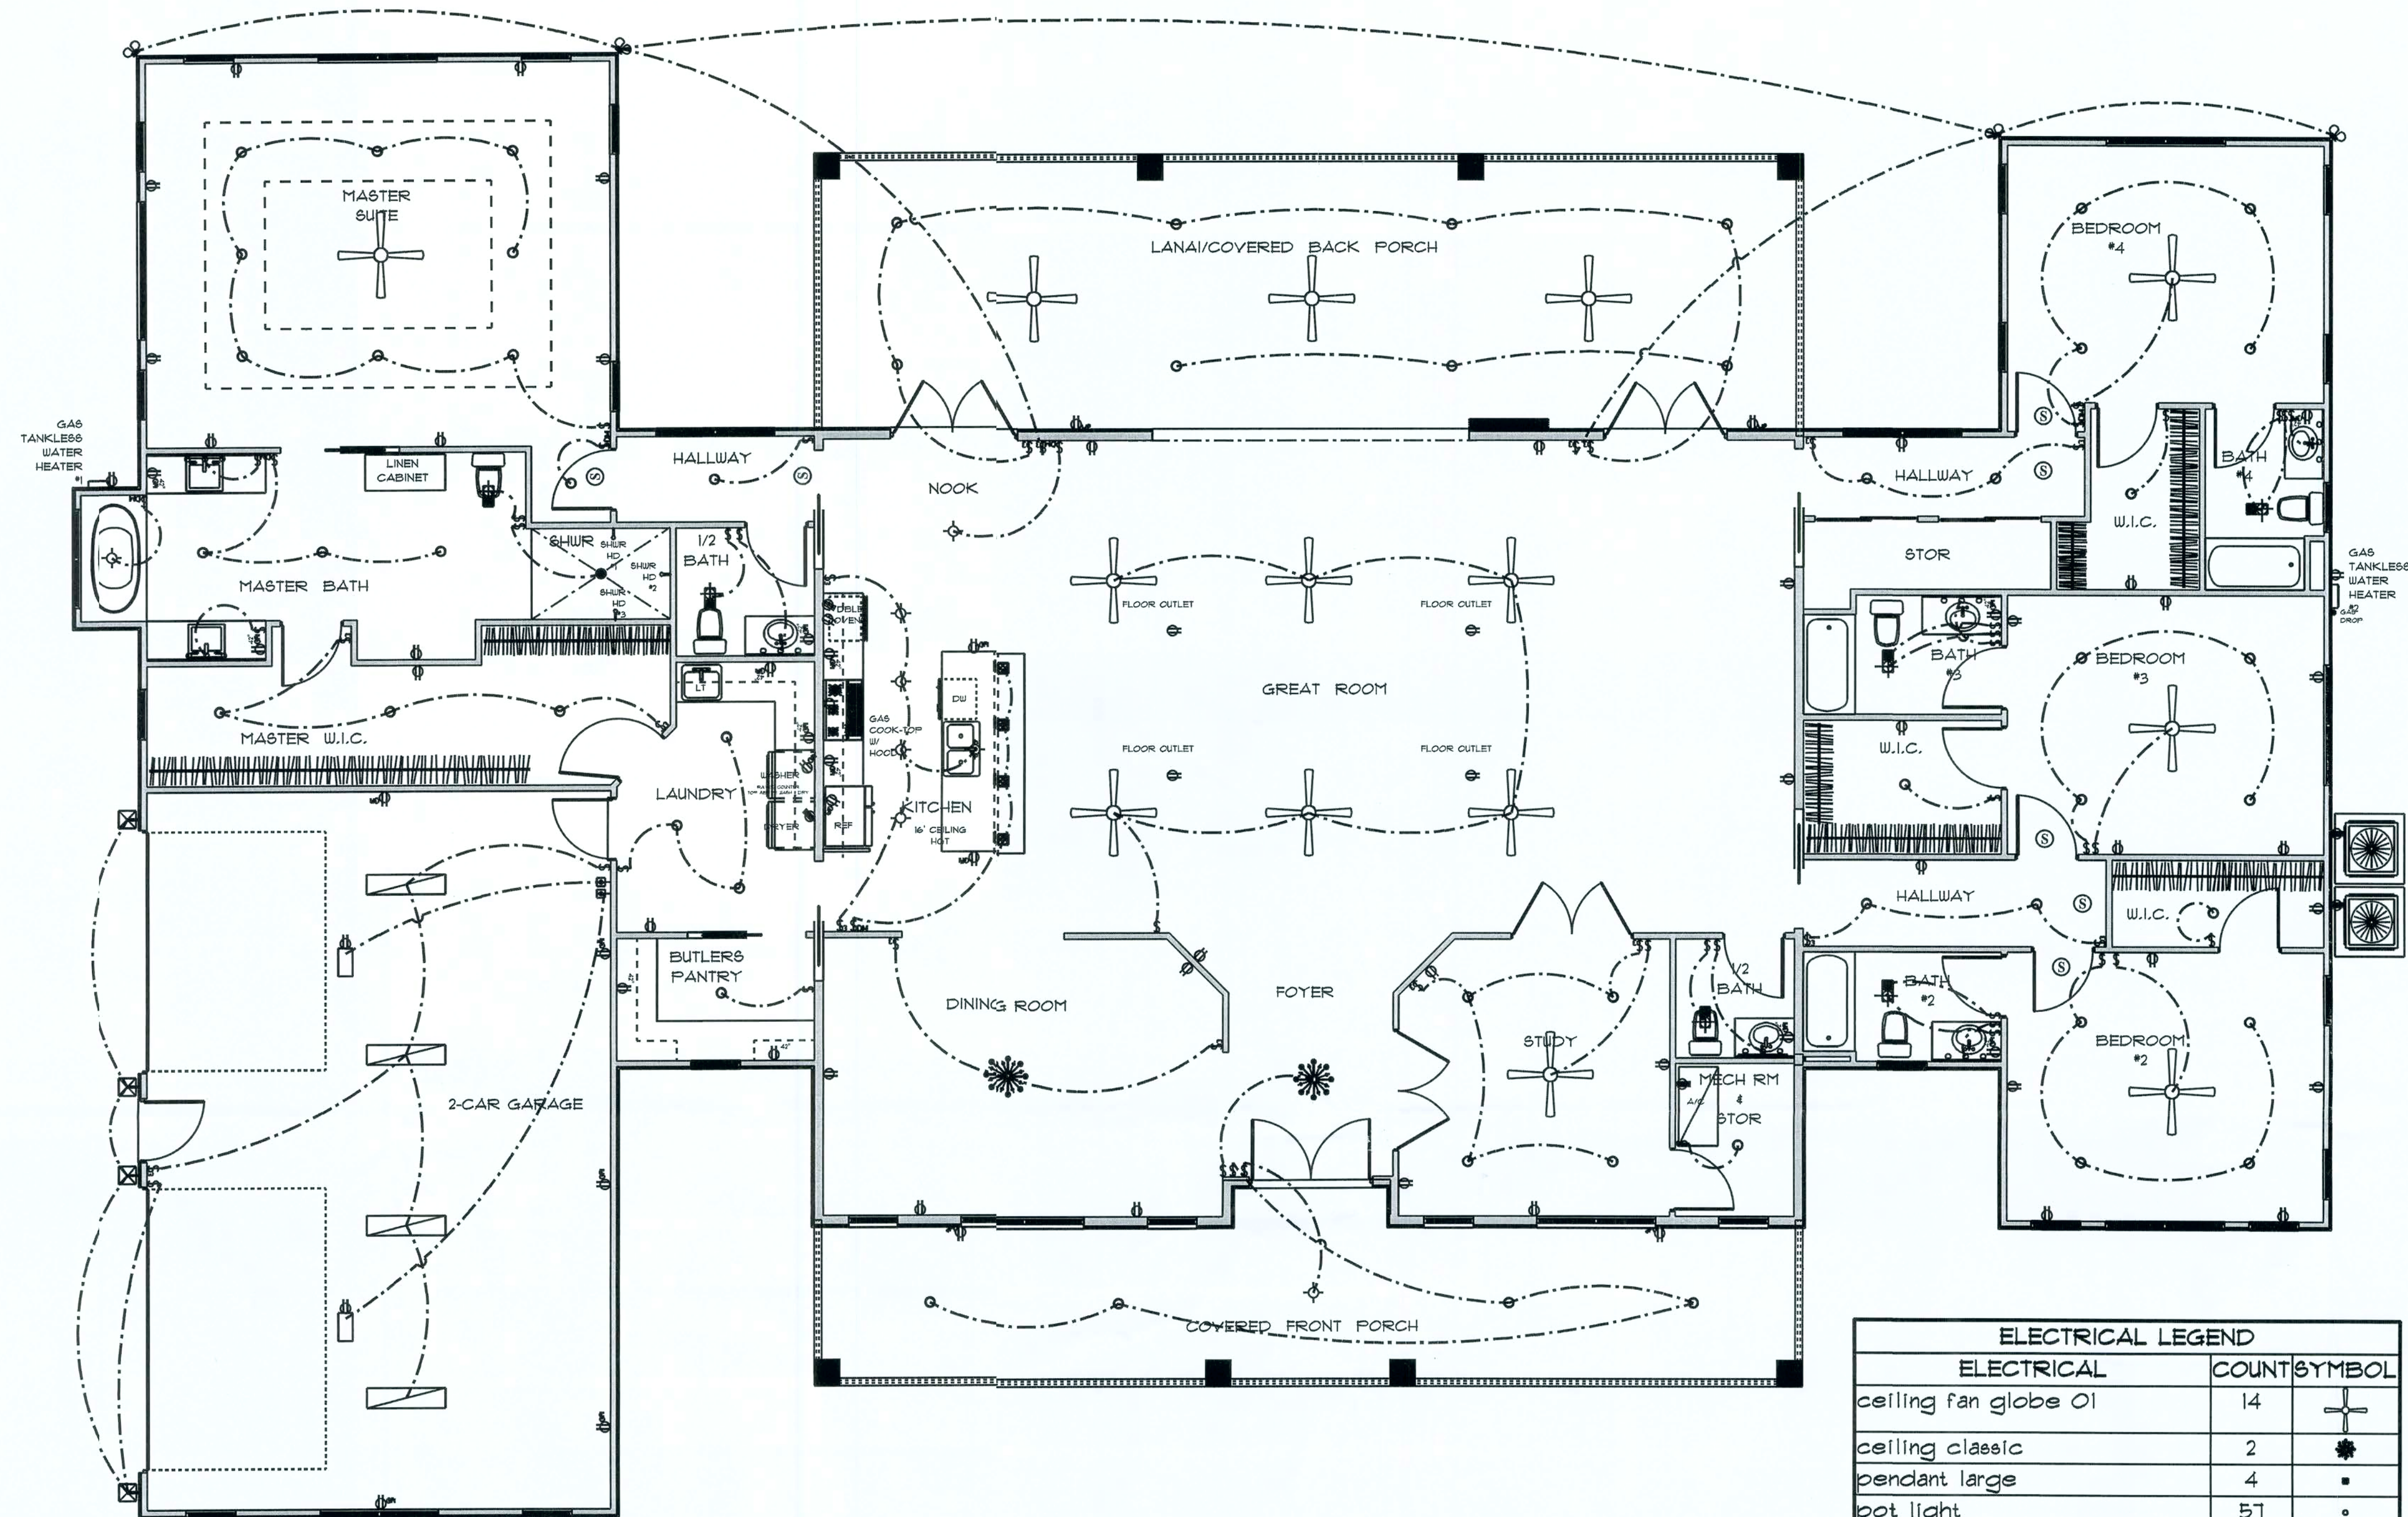

* ELECTRICAL PLAN *

SCALE : 1/8" = 1'-0"

- ELECTRICAL PLAN NOTES**
- E-1 WIRE ALL APPLIANCES, HVAC UNITS AND OTHER EQUIPMENT PER MANUFACTURER'S SPECIFICATIONS.
 - E-2 ALL INSTALLATIONS SHALL BE PER NATIONAL ELECTRIC CODE.
 - E-3 ALL SMOKE / CARBON MONOXIDE DETECTORS SHALL BE 120V W/BATTERY BACKUP OF THE PHOTOELECTRIC TYPE, AND SHALL BE INTERLOCKED TOGETHER, INSTALL INSIDE AND NEAR ALL BEDROOMS AS PER CODE.
 - E-4 TELEPHONE, TELEVISION AND OTHER LOW VOLTAGE DEVICES OR OUTLETS SHALL BE AS PER THE OWNER'S DIRECTION AND IN ACCORDANCE WITH APPLICABLE SECTIONS OF NATIONAL ELCT. CODE LATEST EDITION.
 - E-5 ELECTRICAL CONTRACTOR SHALL BE RESPONSIBLE FOR THE DESIGN AND SIZING OF ELECTRICAL SERVICE AND CIRCUITS.
 - E-6 ENTRY OF SERVICE UNDERGROUND OR OVERHEAD) IS TO BE DETERMINED BY THE POWER COMPANY.
 - E-7 ALL BEDROOM RECEPTALS ARE TO BE AFCI (ARC FAULT CIRCUIT INTERRUPT)
 - E-8 15% OF ALL PERMANENT LIGHTS TO BE ENERGY EFFICIENT.

ELECTRICAL LEGEND		
ELECTRICAL	COUNT	SYMBOL
ceiling fan globe 01	14	
ceiling classic	2	
pendant large	4	
pot light	51	
exterior craftsman light fixture	4	
spotlight double	4	
Smoke Detector	7	
Light	5	
automatic garage dr opener	2	
dimmer switch	6	
floor outlet	4	
garage dr opener	2	
light	3	
outlet	45	
outlet 220v	5	
outlet gfi	20	
outlet wp	4	
switch	37	
switch 3 way	17	
vent light combo	6	
fluorescent light 1 x 4	4	
vanity bar light 02	7	

RESIDENCE
FOR
MARK & LAUREN
GANSKOP

FLORIDA

Teena M. Ruffo
2925 SW 6R 41
Lake City Florida, 32025
Cell: (386) 861-1181
Email: teenaruffo@gmail.com

PRINTED DATE:
Saturday, September 21, 20

DRAWN BY: Teena M. Ruffo CHECKED BY:

BUILDING CONTRACTOR

FINAL DATE:

JOB NUMBER:

DRAWING NUMBER

A-5
OF 5 SHEETS