


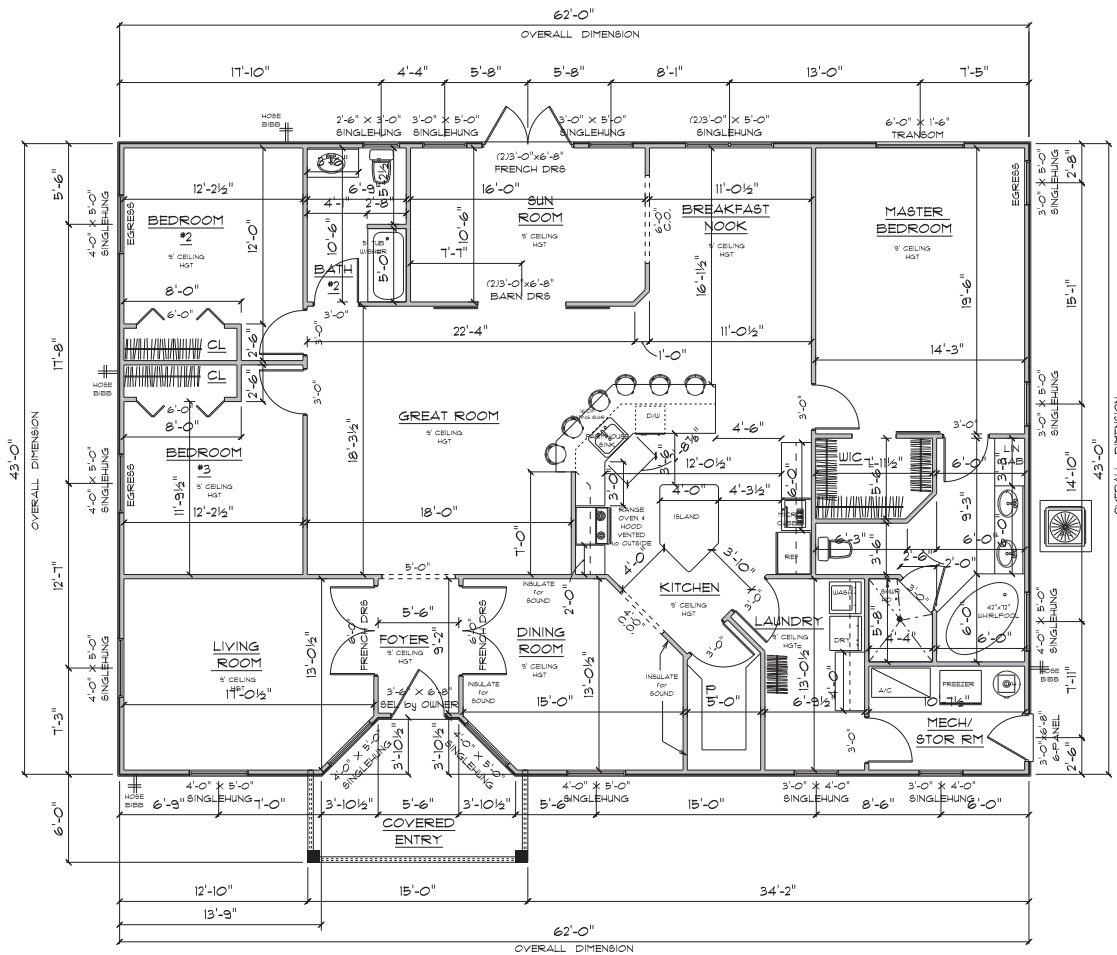

A/C LIVING AREA	2628 S.F.
COVERED ENTRY	158 S.F.
TOTAL AREA UNDER ROOF	2786 S.F.

* FLOOR PLAN *

SCALE : 1/4" = 1'-0"


IMPORTANT NOTES:
 1. IT IS THE BUILDERS RESPONSIBILITY TO VERIFY ALL GEOMETRY AND DIMENSIONS BEFORE ORDERING ANY MATERIALS OR BEGINNING CONSTRUCTION.
 2. THESE PLANS ARE FOR LAYOUT AND DESIGN PURPOSES ONLY ALL STRUCTURAL NOTES AND DETAILS TO BE PROVIDED BY AN ENGINEER.

MERVIN &
KATHLEEN
DALE

FLORIDA

Teena M. Ruffo
2235 SW 47
Lake City Florida 32025
Cell: (386) 861-1191
Email: teena@ruffo.com


PRINTED DATE:
Tuesday, June 15, 2021
 DRAWN BY: Teena M. Ruffo
 CHECKED BY:
 BUILDING CONTRACTOR:
ROGER WHIDDON
 FINALS DATE:
 JOB NUMBER:
 DRAWING NUMBER:
A-3
 OF 6 SHEETS

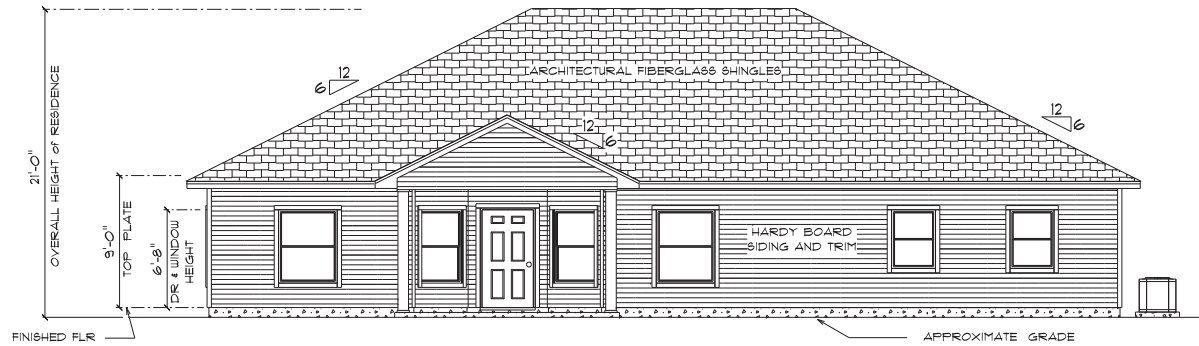

• FRONT ELEVATION •

NOTE:
12" OVERHANG ON GABLE ENDS
18" ON ALL OTHER EAVES

SCALE : 1/4" = 1'-0"

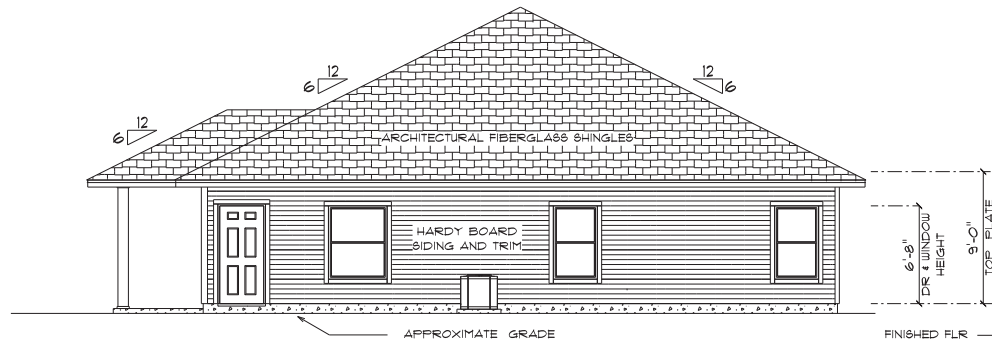

• RIGHT ELEVATION •

NOTE:
12" OVERHANG ON GABLE ENDS
18" ON ALL OTHER EAVES

SCALE : 1/4" = 1'-0"


MERVIN &
KATHLEEN
DALE

FLORIDA

Teena M. Ruffo
2325 SW 4th St.
Lake City, Florida 32025
Cell: (386) 881-1181
Email: teena@ruffo.com

PRINTED DATE:
Tuesday, June 15, 2021
DRAWN BY: Teena M. Ruffo
CHECKED BY:
BUILDING CONTRACTOR:
ROGER WHIDDON
FINALS DATE:
JOB NUMBER:


DRAWING NUMBER
A-4
OF 6 SHEETS

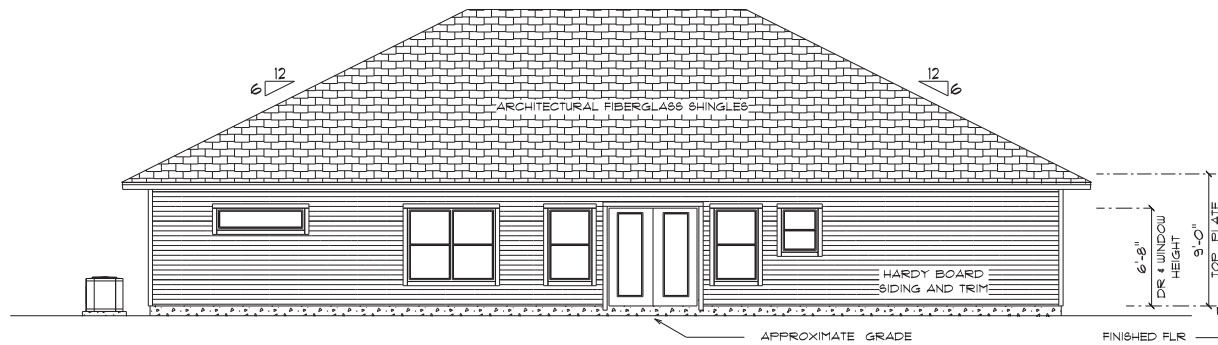

• REAR ELEVATION •

SCALE : 1/4" = 1'-0"

NOTE:
12" OVERHANG ON GABLE ENDS
18" ON ALL OTHER EAVES

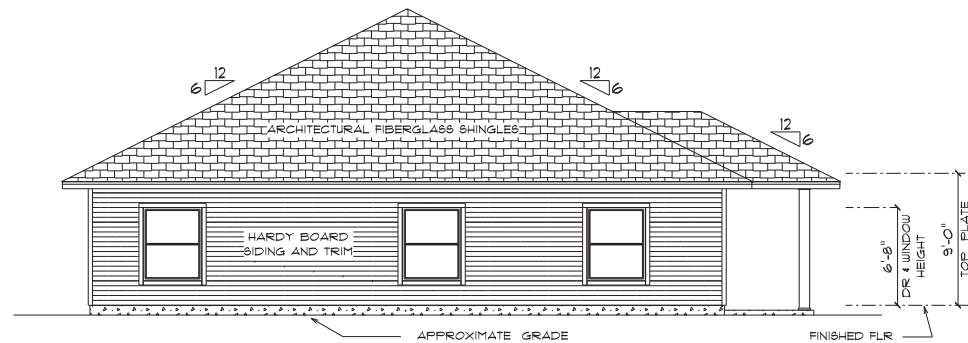

• LEFT ELEVATION •

SCALE : 1/4" = 1'-0"

NOTE:
12" OVERHANG ON GABLE ENDS
18" ON ALL OTHER EAVES

MERVIN &
KATHLEEN
DALE

FLORIDA

Teena M. Ruffo
2325 SW 4th St.
Lake City, Florida 32025
Cell: (386) 861-1171
Email: teena@tfr.com

PRINTED DATE:
Tuesday, June 15, 2021

DRAWN BY: Teena M. Ruffo

CHECKED BY: ROGER WHIDDON

FINAL DATE:

JOB NUMBER:

DRAWING NUMBER


A-5

OF 6 SHEETS

ELECTRICAL LEGEND		
ELECTRICAL	COUNT	SYMBOL
ceiling fan globe 01	6	+
ceiling classic	2	✱
pendant large	5	•
pot light	18	•
spotlight double	4	•
wall mount savoy	5	•
Smoke Detector	3	⊙
electrical panel	1	■
floor outlet single	2	•
door bell	1	•
light	10	•
outlet	62	•
outlet 220v	3	•
outlet gfi	20	•
outlet wp	9	•
switch	34	•
switch 3 way	18	•
vent light combo	2	•
vanity bar light 01	2	•

ELECTRICAL PLAN NOTES

- E-1 WIRE ALL APPLIANCES, HVAC UNITS AND OTHER EQUIPMENT PER MANUFACTURER'S SPECIFICATIONS.
- E-2 ALL INSTALLATIONS SHALL BE PER NATIONAL ELECTRIC CODE.
- E-3 ALL SMOKE / CARBON MONOXIDE DETECTORS SHALL BE 120V @ BATTERY BACKUP OR THE PHOTOELECTRIC TYPE AND SHALL BE INTERLOCKED TOGETHER. INSTALL INSIDE AND NEAR ALL BEDROOMS AS PER CODE.
- E-4 TELEPHONE, TELEVISION AND OTHER LOW VOLTAGE DEVICES OR OUTLETS SHALL BE AS PER THE OWNER'S DIRECTION AND IN ACCORDANCE WITH APPLICABLE SECTIONS OF NATIONAL ELEC. CODE LATEST EDITION.
- E-5 ELECTRICAL CONTRACTOR SHALL BE RESPONSIBLE FOR THE DESIGN AND SIZING OF ELECTRICAL SERVICE AND CIRCUITS.
- E-6 ENTRY OF SERVICE UNDERGROUND OR OVERHEAD IS TO BE DETERMINED BY THE POWER COMPANY.
- E-7 ALL BEDROOM RECEPTALS ARE TO BE AFCI (ARC FAULT CIRCUIT INTERRUPT)
- E-8 75% OF ALL PERMANENT LIGHTS TO BE ENERGY EFFICIENT.

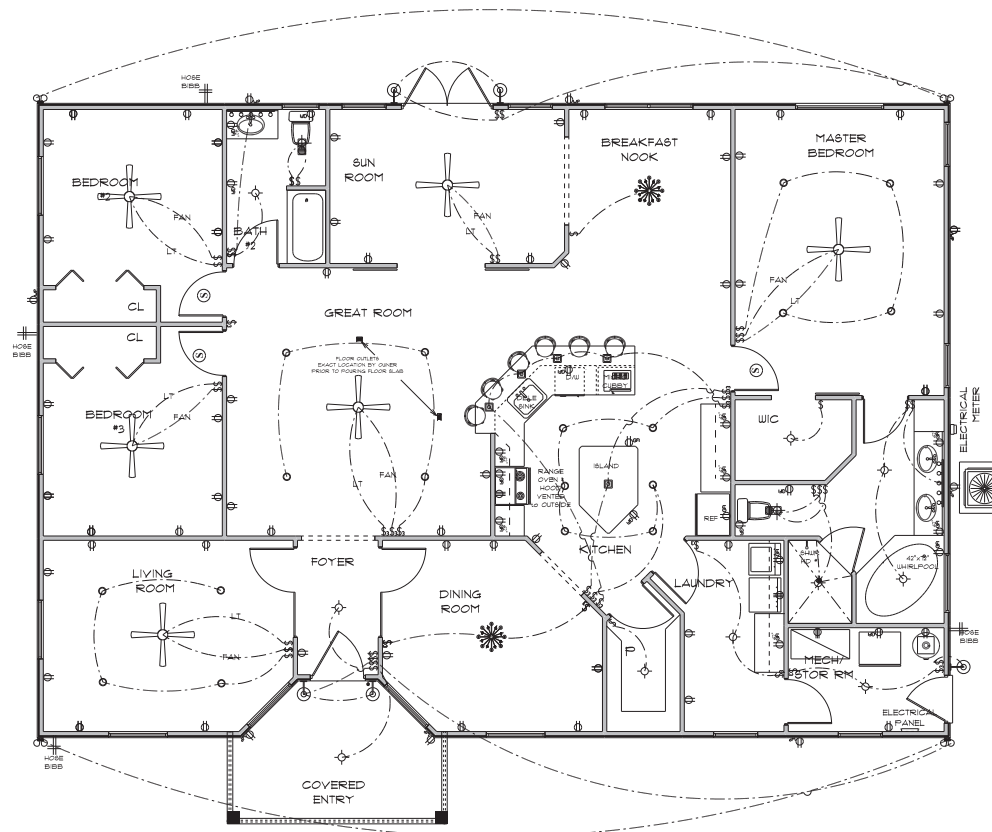

* ELECTRICAL PLAN *

SCALE : 1/4" = 1'-0"

MERVIN &
KATHLEEN
DALE

FLORIDA

Teresa M. Ruffo
2325 SW 48th
Lake City, Florida 32025
Cell: (386) 861-1191
Email: tsera@tfora.com

PRINTED DATE:
Tuesday, June 15, 2021

DRAWN BY: Teresa M. Ruffo

CHECKED BY: ROGER WHIDDON

FINAL DATE:

JOB NUMBER:

DRAWING NUMBER:
A-6

OF 6 SHEETS