



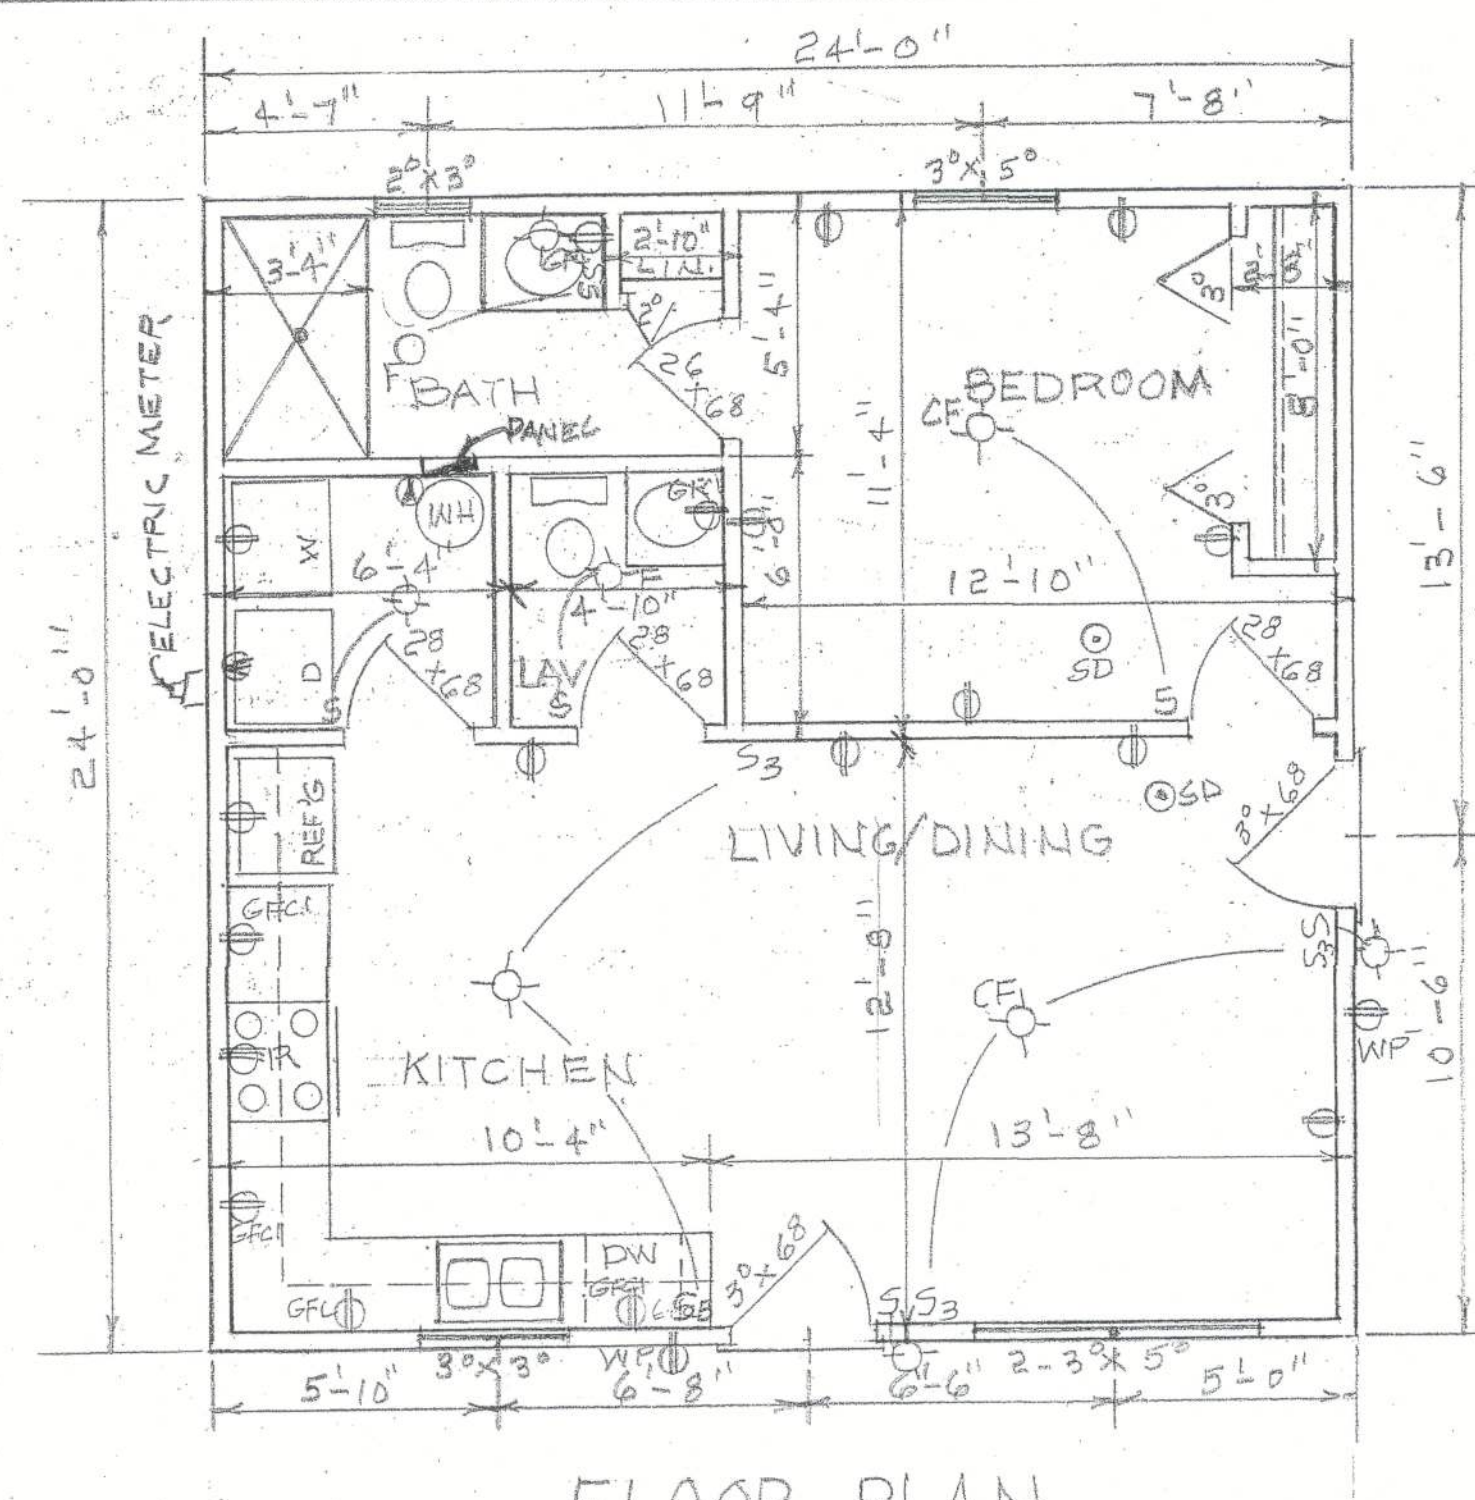


FLOOR PLAN
SCALE: 1/4" = 1'-0"
576 SQ. FT.

ELECTRICAL LEGEND


- S-SINGLE POLE SWITCH S₃-THREE WAY SWITCH Ⓢ-DUPLEX CONV. OUTLET
- Ⓢ-SPECIAL PURPOSE OUTLET Ⓢ-WEATHERPROOF OUTLET Ⓢ-EXHAUST FAN
- Ⓢ-GROUND FAULT CIRCUIT Ⓢ-CEILING LIGHT Ⓢ-CEILING FAN W/LIGHT
- Ⓢ-WALL MOUNTED LIGHT Ⓢ-SMOKE DETECTOR Ⓢ-ELECTRICAL PANEL
- Ⓢ-ELECTRIC METER Ⓢ-R-RANGE OUTLET

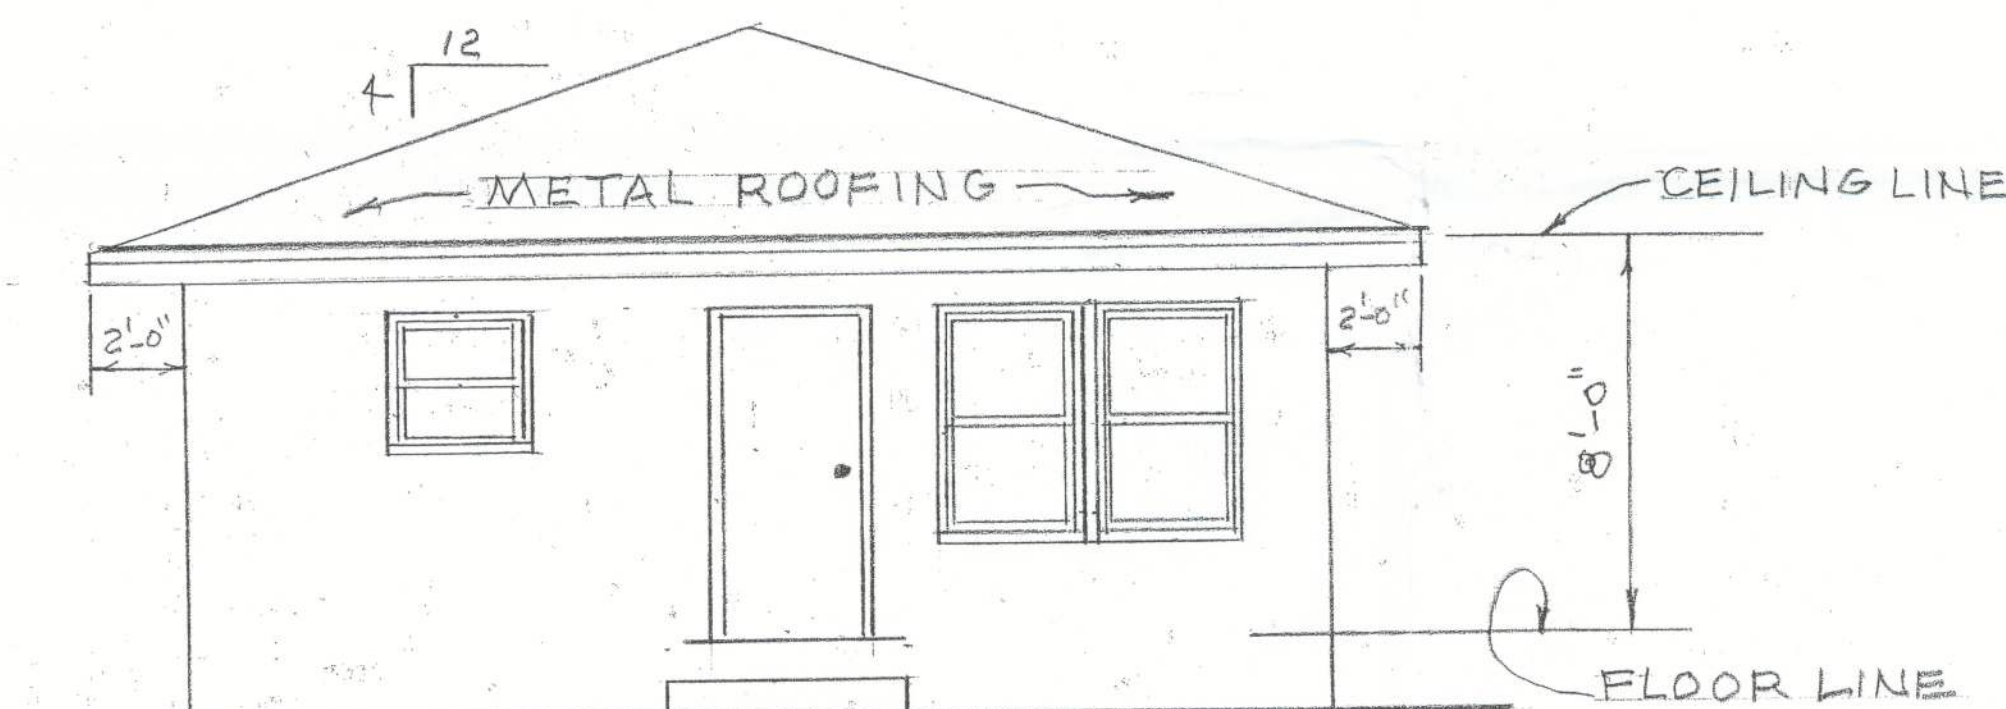


FRONT ELEVATION
SCALE: 1/4" = 1'-0"

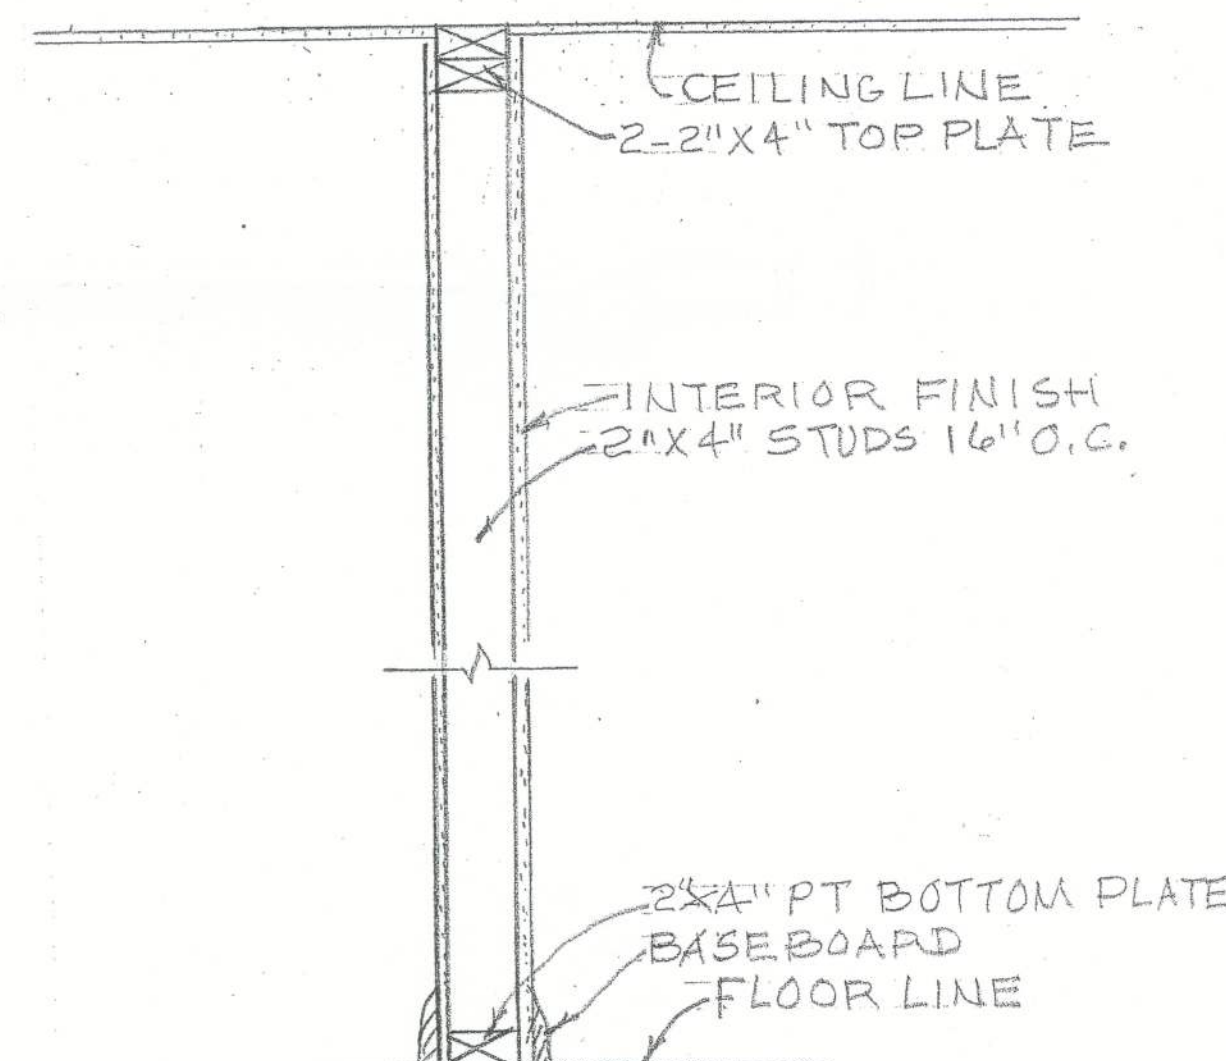


INTERIOR WALL SECTION
SCALE: 1" = 1'-0"

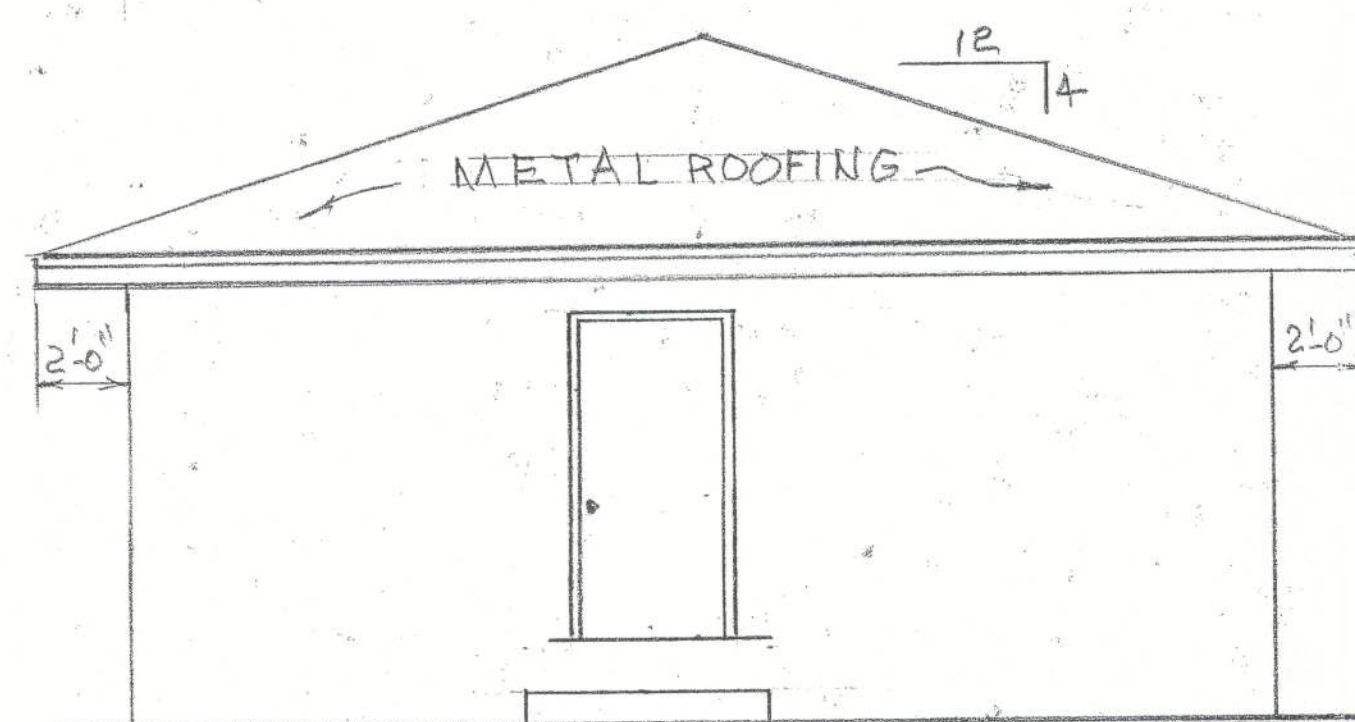


RIGHT SIDE ELEVATION
SCALE: 1/4" = 1'-0"

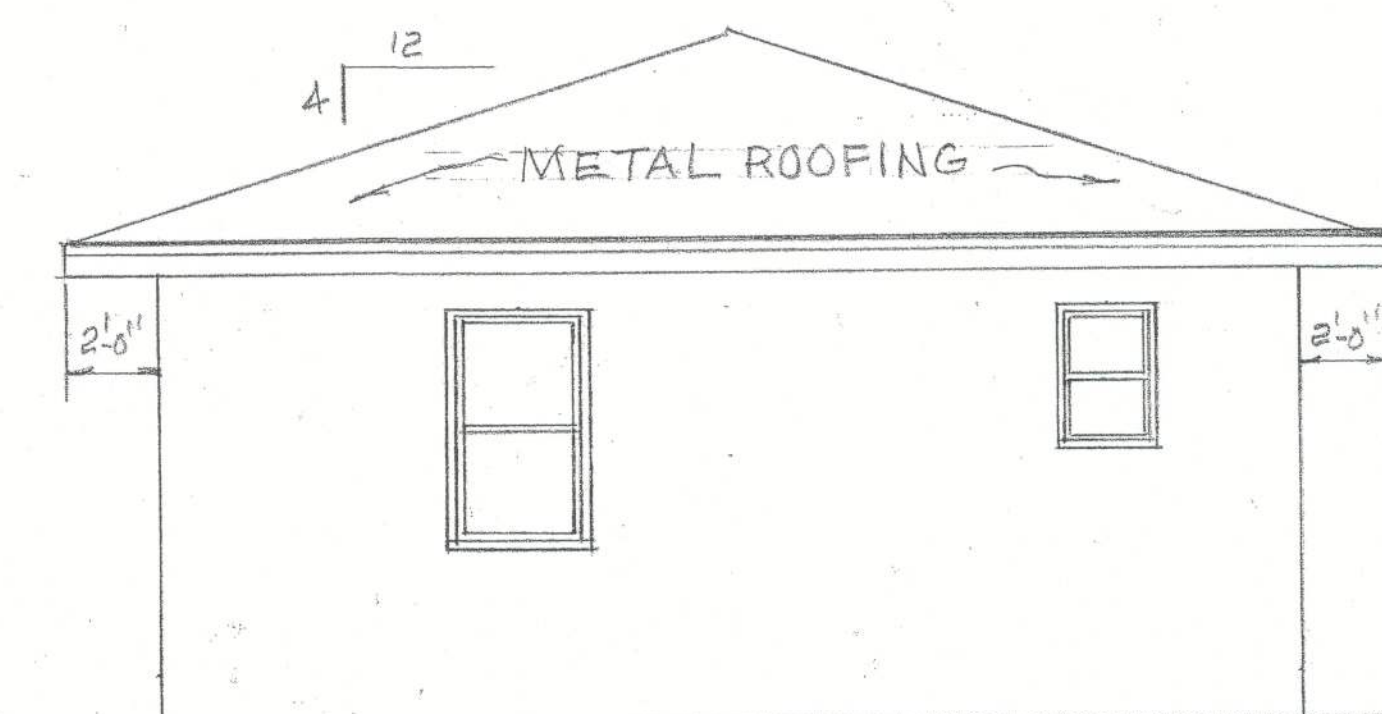


REAR ELEVATION
SCALE: 1/4" = 1'-0"

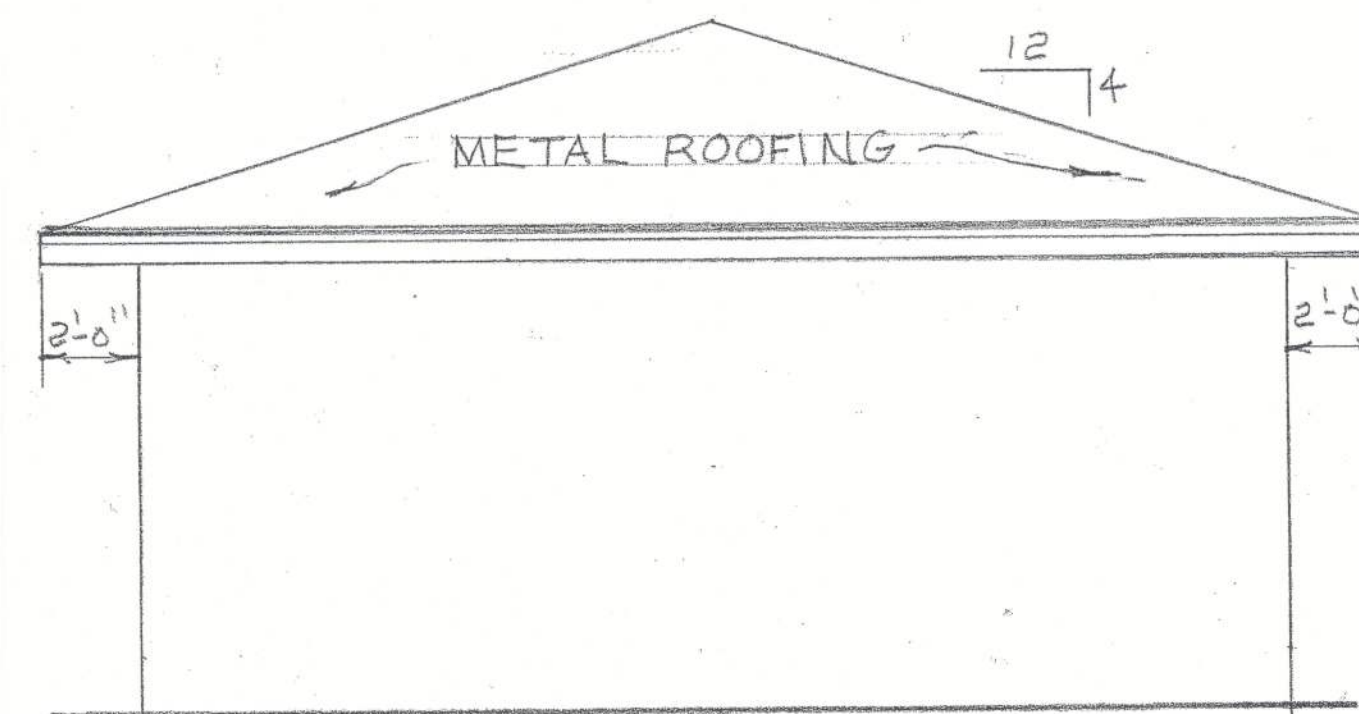


LEFT SIDE ELEVATION
SCALE: 1/4" = 1'-0"

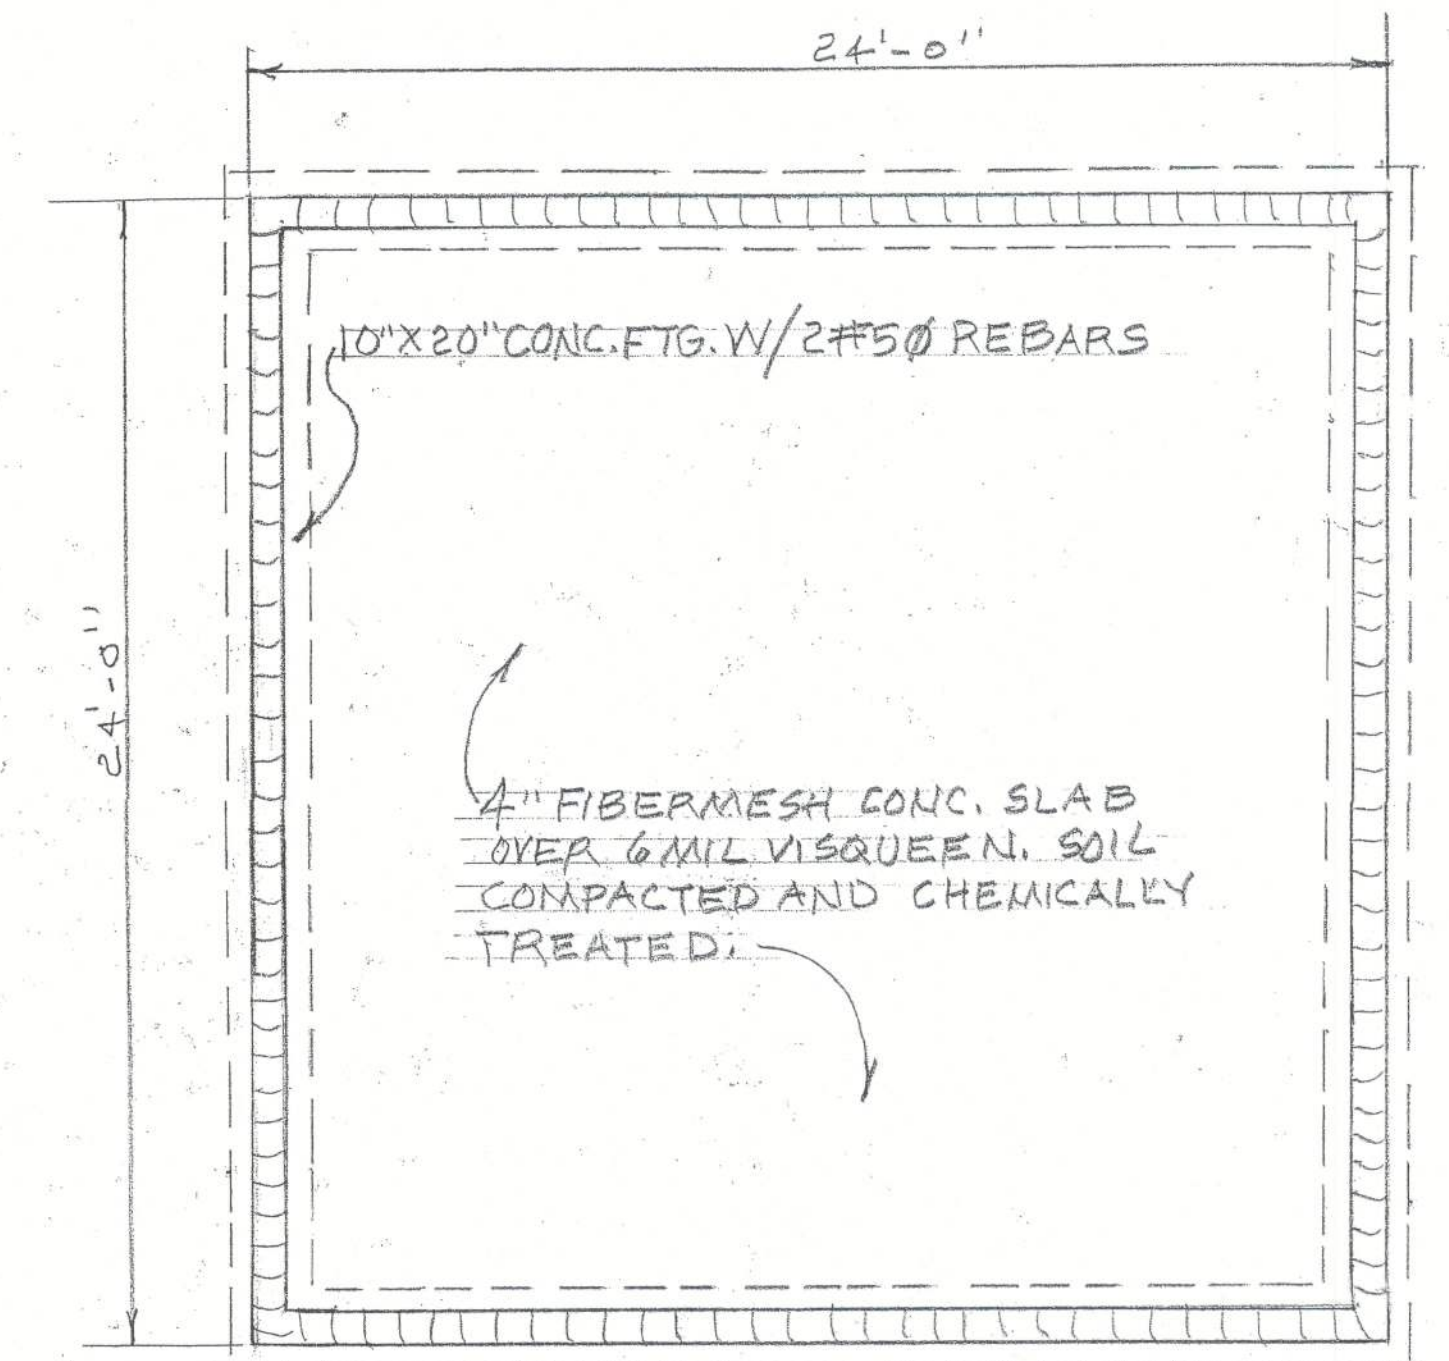

FOUNDATION PLAN
SCALE: 1/4" = 1'-0"

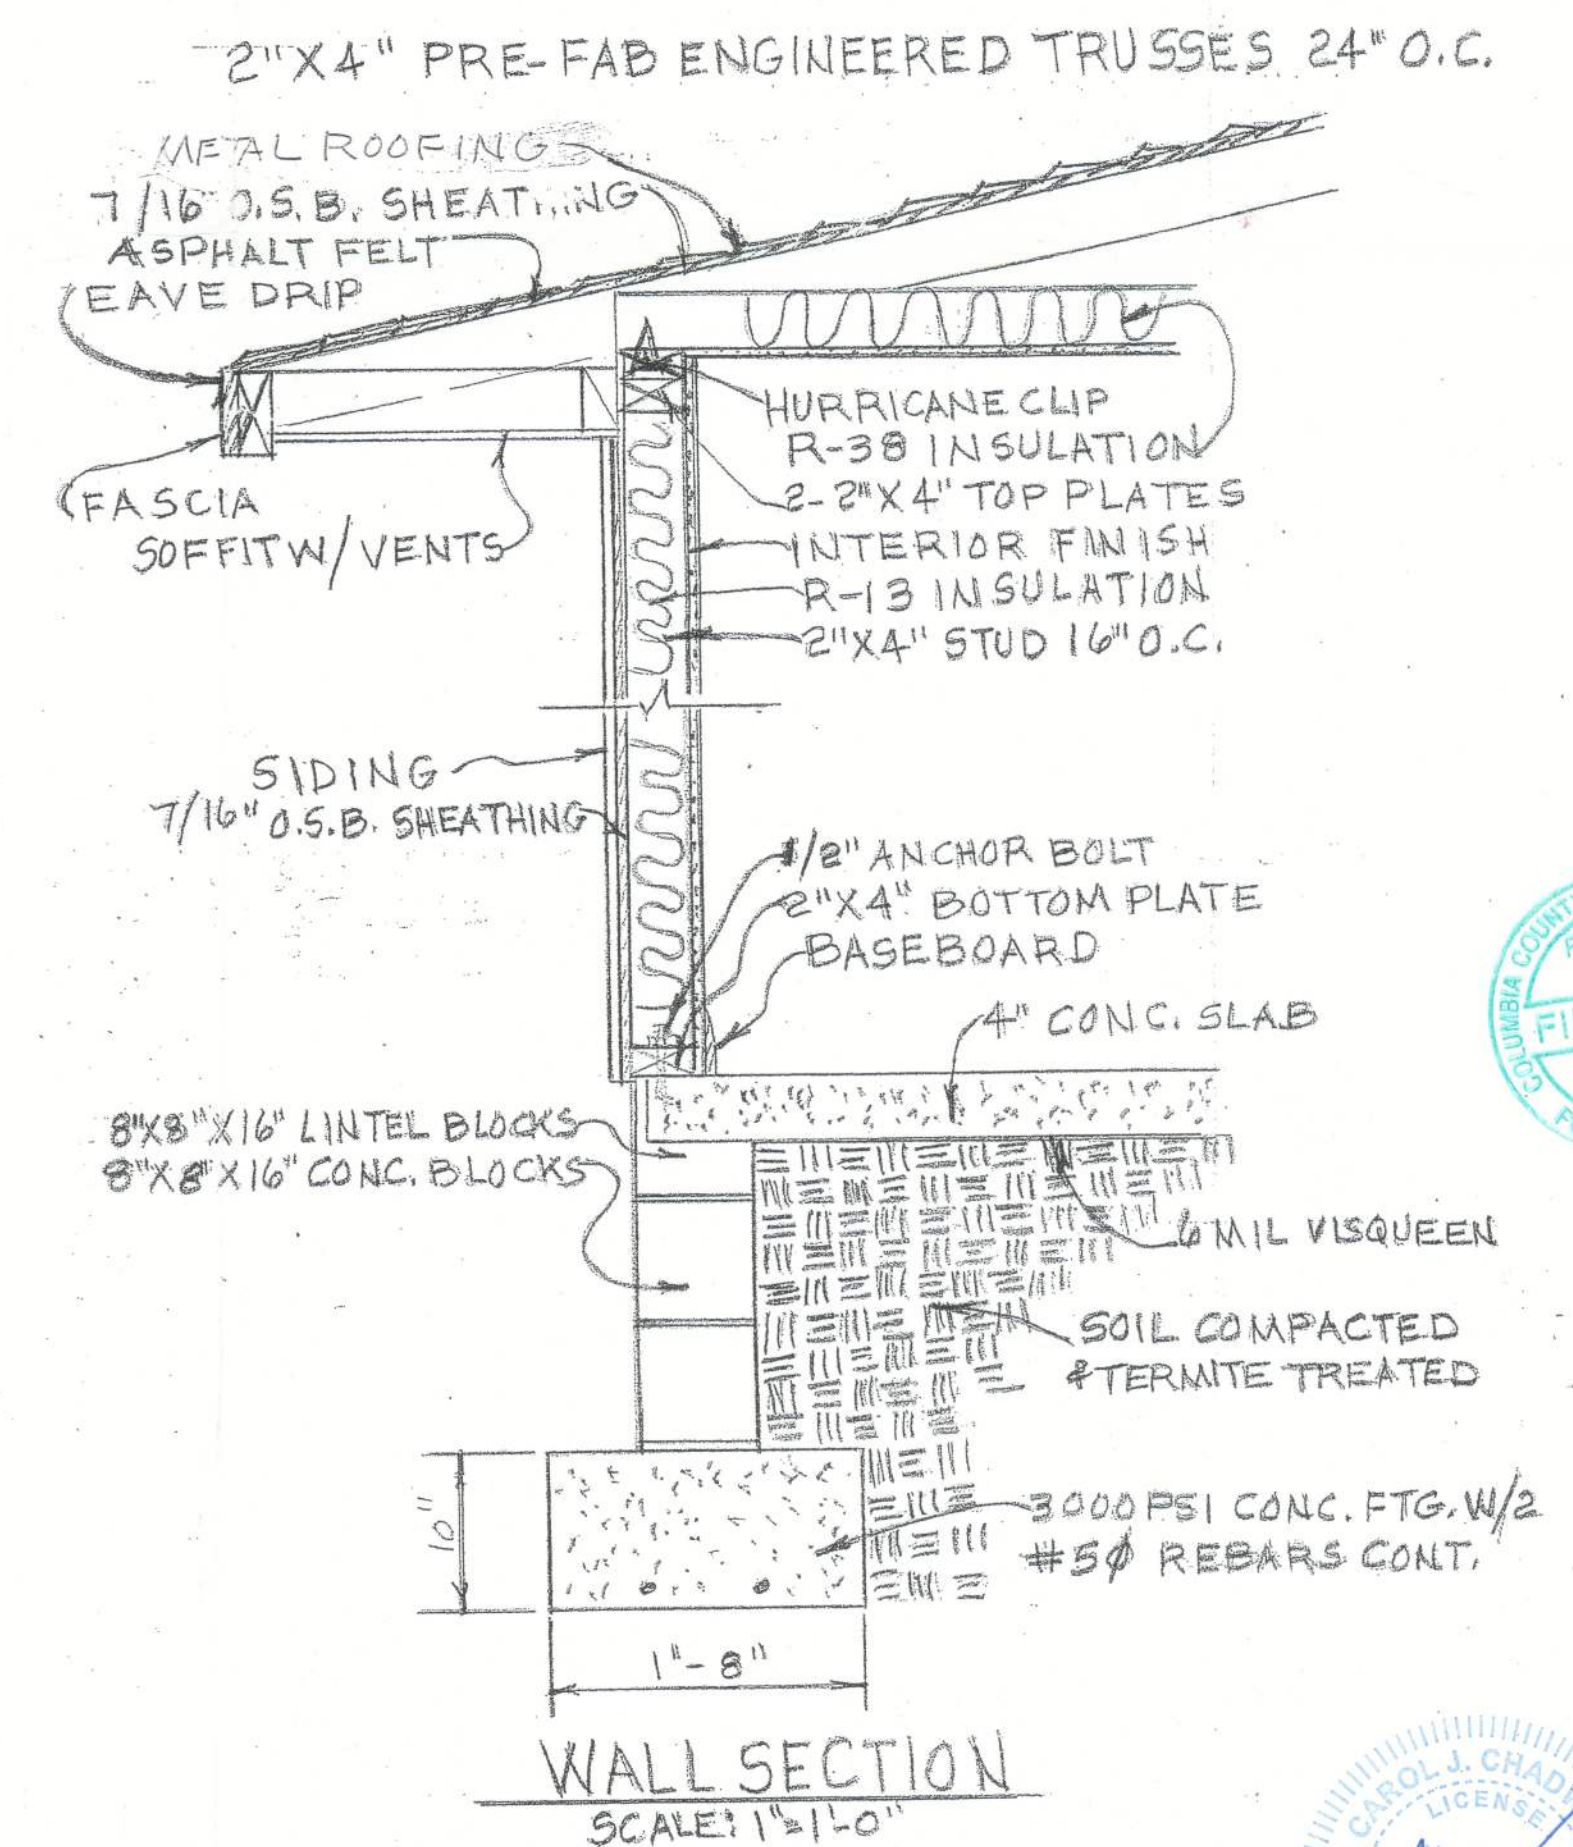

WALL SECTION
SCALE: 1" = 1'-0"

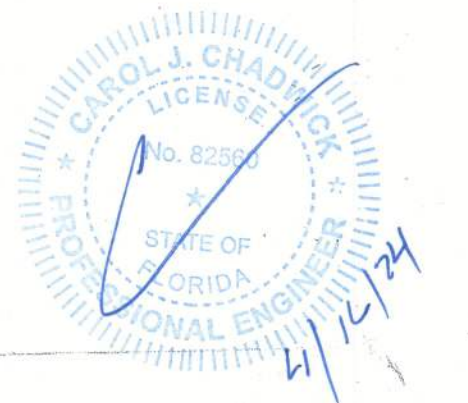

HOUSE PLANS FOR MR. JAMES SIMMONS 185 NE VEGAS TERRACE - LAKE CITY, FLORIDA DRAWN BY: S. L. BYRD

65037