
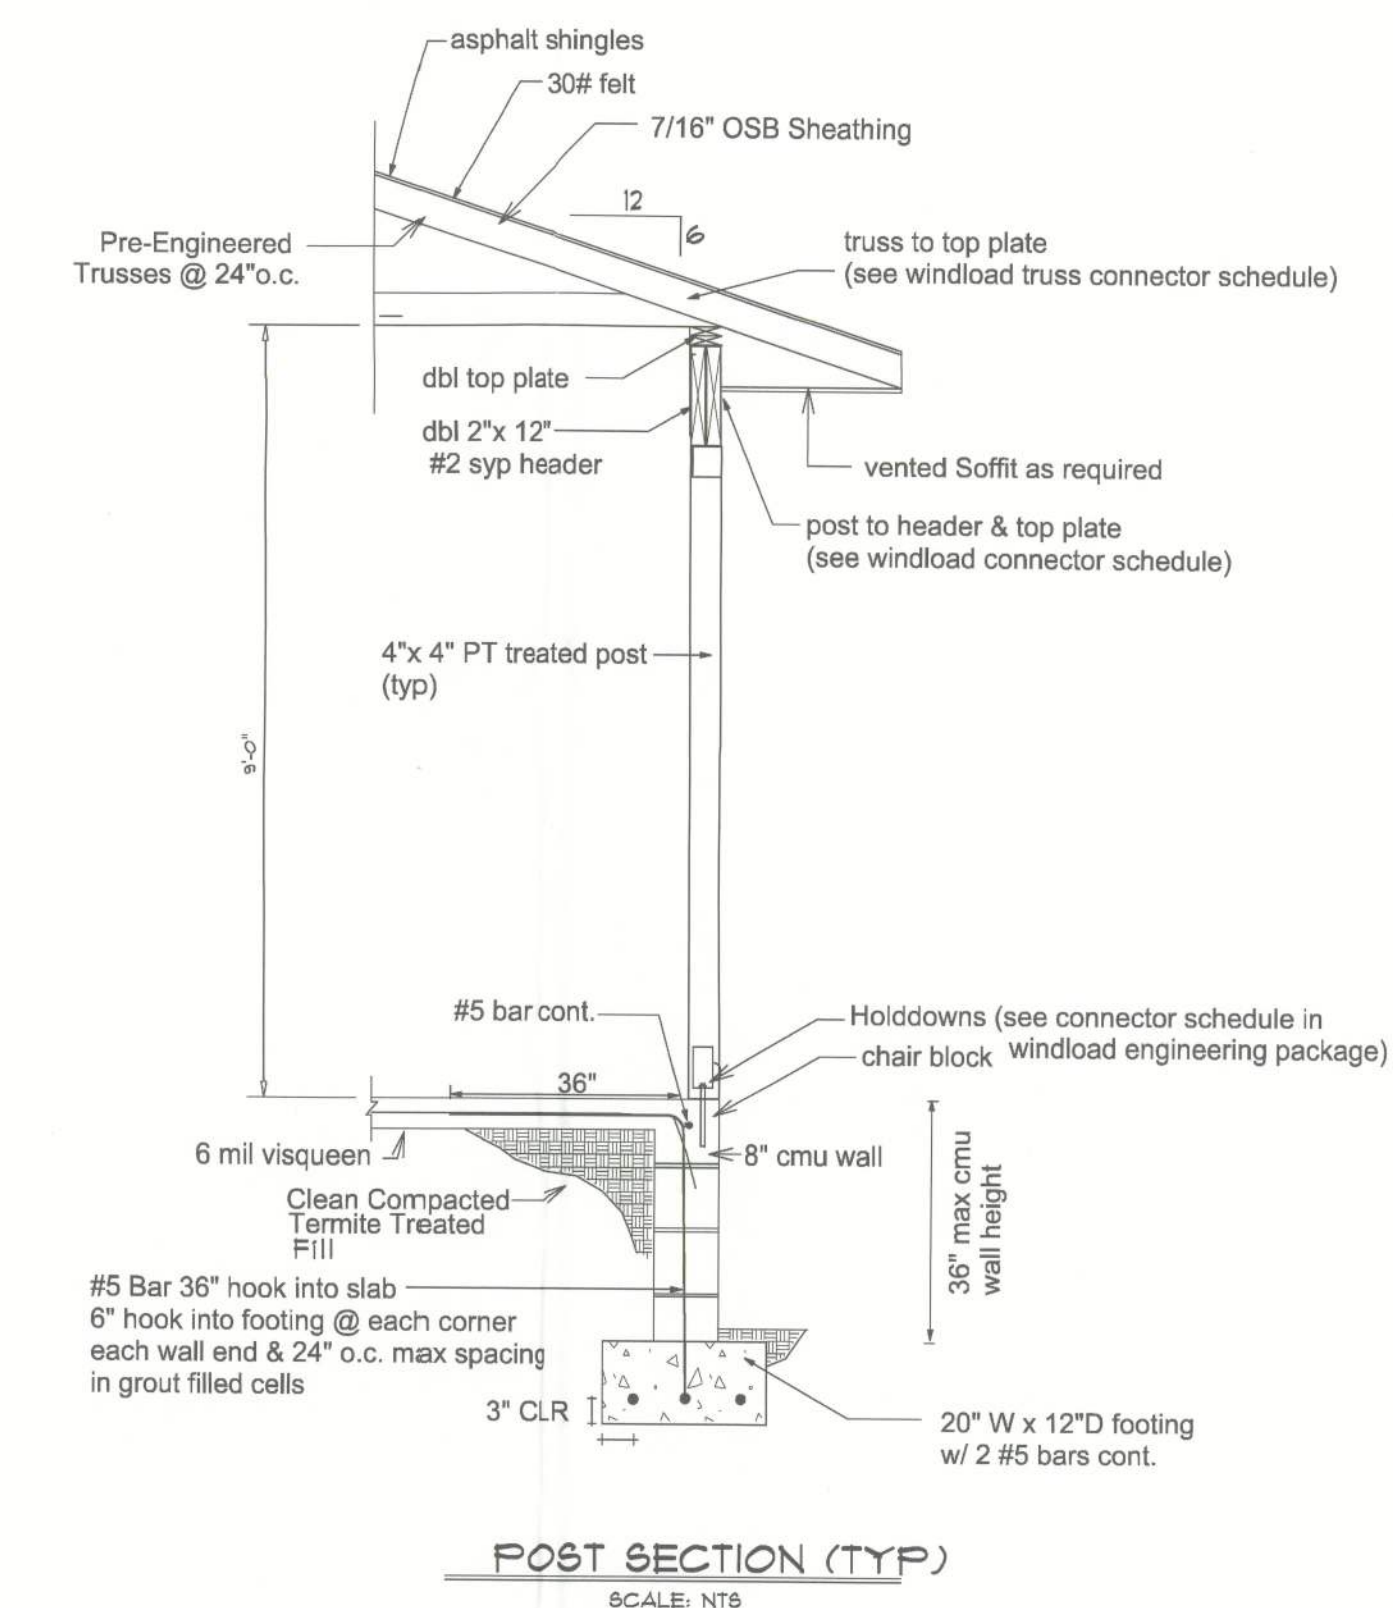
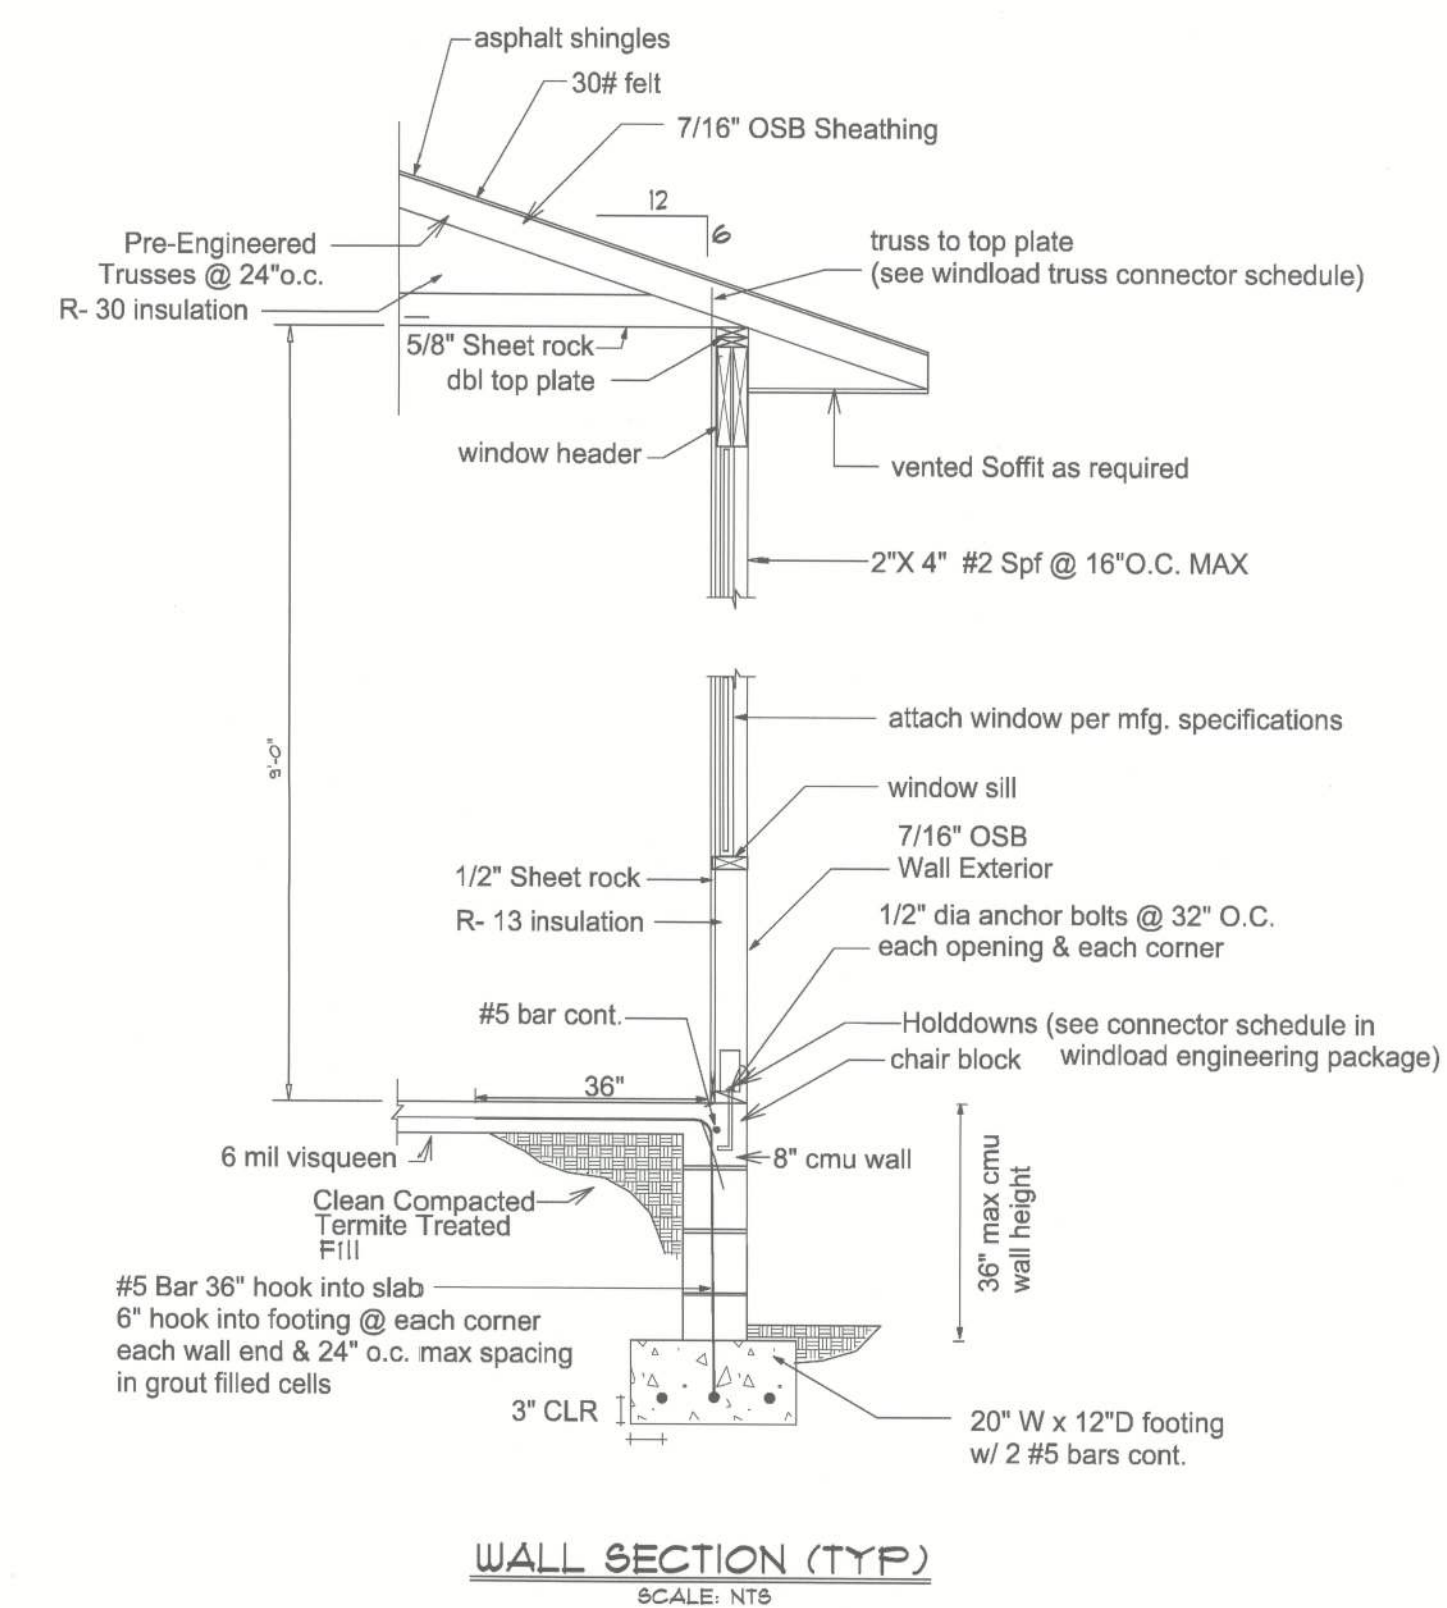


NEW FOUNDATION PLAN
1/4" = 1'-0" SCALE

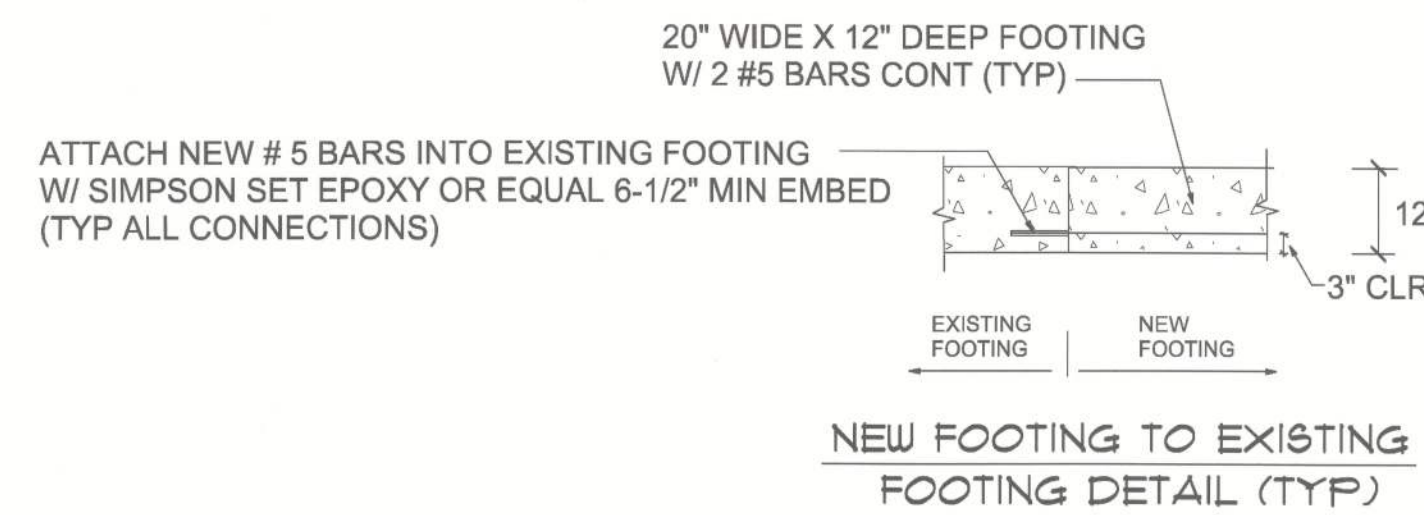

DRISCOLL ENGINEERING, INC.
CONSULTING ENGINEERS
PO BOX 357577
GAINESVILLE, FL 32606
PH (352) 331-1513
CA 8690

OSTEEN ADDITION
479 SEDGEFIELD ROAD
FT WHITE, FL DS09-247

WILLIAM JOHNSON
CUSTOM DRAFTING
16909 N.E. 21st. STREET
GAINESVILLE, FL 32609
PH (352) 485-1942 (352) 494-2041

SHEET:

3

DATE: 11-10-09
MICHAEL E. DRISCOLL P.E.
FL REG # 43922