

ABBREVIATIONS

A/C	AIR COOLING UNIT
ADJ	ADJACENT
AFF	ABOVE FINISHED FLOOR
AHU	AIR HANDLING UNIT
ALUM	ALUMINUM
BLK	BLOCK
BOT	BOTTOM
BRG	BEARING
CJ	CONTROL JOINT
CLG	CEILING
COL	COLUMN
CONC	CONCRETE
CONT	CONTINUOUS
CPT	CARPET
DIA	DIAMETER
DN	DOWN
DWG	DRAWING
EA	EACH
ELEC	ELECTRIC
EQ	EQUAL
FF	FINISH FLOOR
FTG	FOOTING
HB	HOSE BIB
HDR	HEADER
HGT	HEIGHT
MAX	MAXIMUM
MIN	MINIMUM
NTS	NOT TO SCALE
OPNG	OPENING
SIM	SIMILAR
TYP	TYPICAL
VLT	VAULT
UNO	UNLESS NOTED OTHERWISE

area tabulation 'a'

GARAGE	401 SF
FRONT PORCH	21 SF
REAR PATIO	72 SF
FLOOR 1 LIVING	1,607 SF
TOTAL LIVING	1,607 SF

area tabulation 'b'

GARAGE	401 SF
FRONT PORCH	108 SF
REAR PATIO	72 SF
FLOOR 1 LIVING	1,607 SF
TOTAL LIVING	1,607 SF

Covington

38' - 1607 - RH

Florida Region (Frame)

BUILDING CODE COMPLIANCE

ALL CONSTRUCTION TO COMPLY WITH LOCAL CODES AND ORDINANCE CURRENTLY IN USE WITH THE LOCAL JURISDICTION.

PRODUCT: NEW SINGLE FAMILY DETACHED

OCCUPANCY CLASSIFICATION:

RESIDENTIAL R-3

CONSTRUCTION CLASS:

UNPROTECTED

CONSTRUCTION TYPE:

TYPE VB

EMERGENCY ESCAPE:

EGRESS OR RESCUE WINDOWS FROM SLEEPING ROOMS SHALL HAVE MINIMUM OF 5.7 SQUARE FEET

APPLICABLE CODES:
FOLLOW ALL APPLICABLE STATE AND LOCAL CODES.
FLORIDA STATE SUPPLEMENTS AND AMENDMENTS.

2020 Florida Building Code, Residential, 7th Edition

2017 National Electrical Code, NFPA 70



Reserve at Jewel Lake
Lot 030
436 SW Jewel Lake Drive
Lake City, FL 32024

Century Communities expressly reserves its common law copyright in these plans. Plans are not to be copied, reproduced, or changed, in any manner whatsoever, nor are they to be assigned to a third party without written permission and consent of Century Communities.

PLAN NUMBER:

33811607

RELEASE DATE:

08.30.2021

MODEL:

COVINGTON

DRAWING TITLE:

COVER SHEET

SHEET NO:

CS

INDEX

ARCHITECTURAL

CS	GENERAL NOTES & LEGENDS
A1	EXTERIOR ELEVATIONS
A2	SLAB PENETRATION PLAN
A3	FLOOR PLANS
A4	SECTIONS & DETAILS
A5	INTERIOR DETAILS
A6	ROOF PLAN
E1	ELECTRICAL PLANS
CD	CONSTRUCTION DETAILS

REVISIONS

NUMBER	DATE	DESCRIPTION
01	03.04.2021	Added Elevations A1 & B1
02	06.14.21	Added outlet to O.Suite & noted outlets to meet 6' max from wall break & 12' max between outlet spacing at habitable rooms (E1.1)
03	07.08.21	Added floor break transition strips to plan
04	07.20.21	Added elevations A4 & B4
05	08.02.21	labeled egress windows, labeled accessible bath, smoke/carbon alarms near appliances noted
06	08.30.21	Added stemwall options, called out GFI at outlets within 6'-0" of Kitchen sink
07	09.08.21	Carbon / smoke alarm moved 3' min away from bathroom door/opening with tub/shower

Keynotes | Legend

1.

CORROSION RESISTANT ROOF TO WALL FLASHING AT ALL ROOF / WALL INTERSECTIONS.
2.


CORROSION RESISTANT SCREEN LOUVERED VENTS, SIZE AS NOTED.
3.

BRICK WAINSCOT WITH SLOPED BRICK ROWLOCK CAP.
4.

STONE WAINSCOT WITH SLOPED STONE CAP.
5.

3 1/2" VINYL TRIM SURROUND
6.


36" H. GUARDRAIL AS REQUIRED

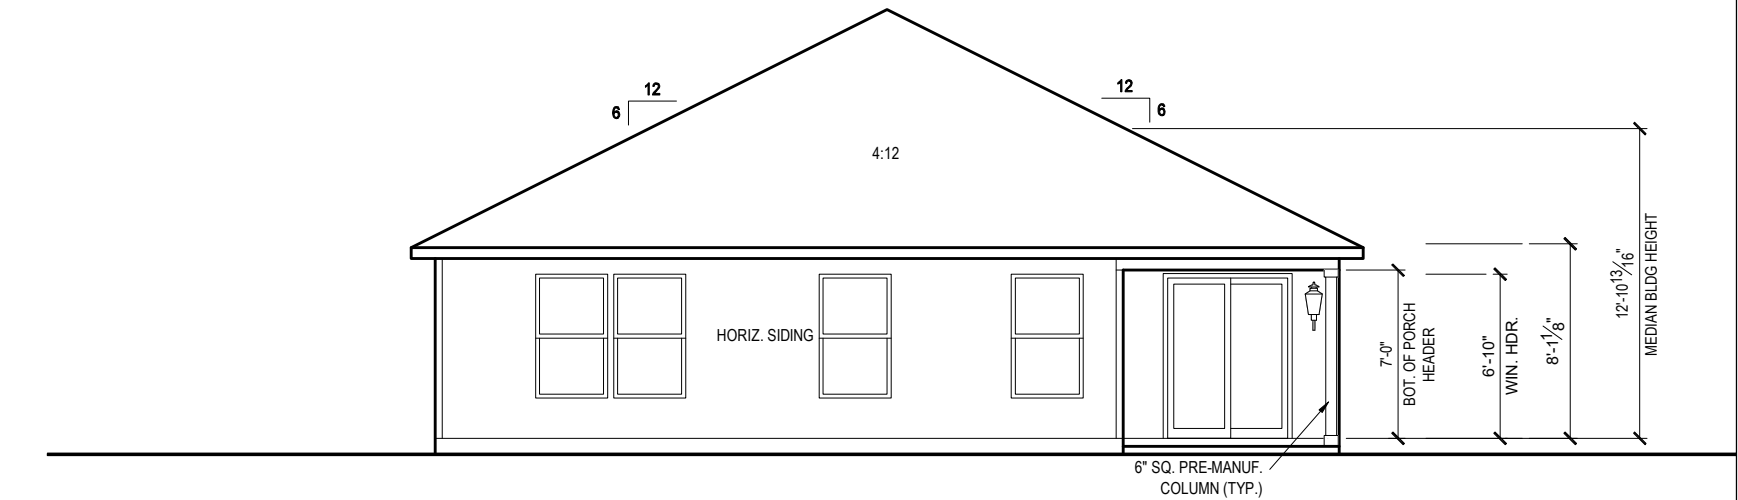

REAR ELEVATION 'B1'

1/8" = 1'-0" @ 11x17

1/4" = 1'-0" @ 22x34

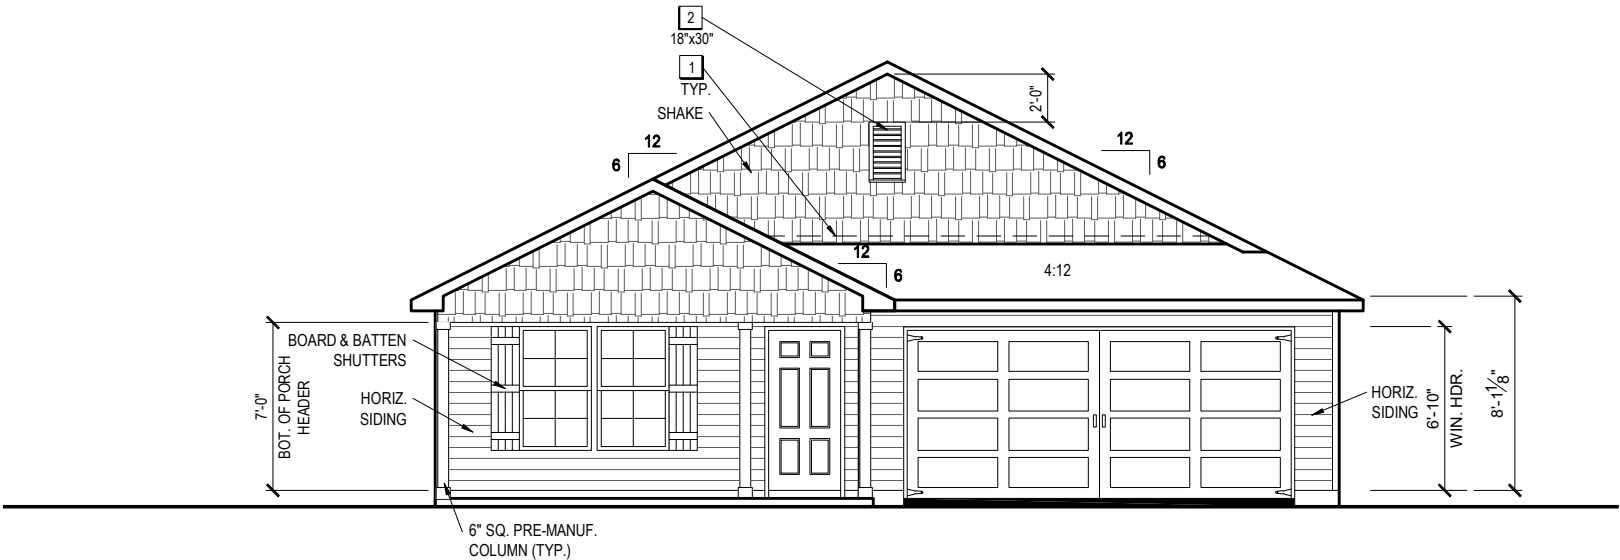

FRONT ELEVATION 'B1'

1/8" = 1'-0" @ 11x17

1/4" = 1'-0" @ 22x34



THE SET OF PLANS SHOWN HEREIN, INCLUDING ALL NOTATIONS, DIMENSIONS, AND SPECIFICATIONS, IS THE PROPERTY OF CENTURY COMMUNITIES, INC. AND IS TO BE USED ONLY FOR THE PROJECT AND SITE SPECIFICALLY IDENTIFIED HEREON. ANY REPRODUCTION OR TRANSMISSION OF THESE PLANS WITHOUT THE WRITTEN PERMISSION OF CENTURY COMMUNITIES, INC. IS STRICTLY PROHIBITED. ANY VIOLATION OF THESE TERMS SHALL BE CONSIDERED A VIOLATION OF APPLICABLE LAWS AND REGULATIONS. 1-14-2022



Reserve at Jewel Lake
Lot 030
436 SW Jewel Lake Drive
Lake City, FL 32024

Century Communities expressly reserves its common law copyright in these plans. Plans are not to be copied, reproduced, or changed, in any manner whatsoever, nor are they to be assigned to a third party without written permission and consent of Century Communities.

PLAN NUMBER:
33811607


RELEASE DATE:
08.30.2021

MODEL:
COVINGTON

DRAWING TITLE:
EXTERIOR ELEVATIONS

SHEET NO:


1.1-B1

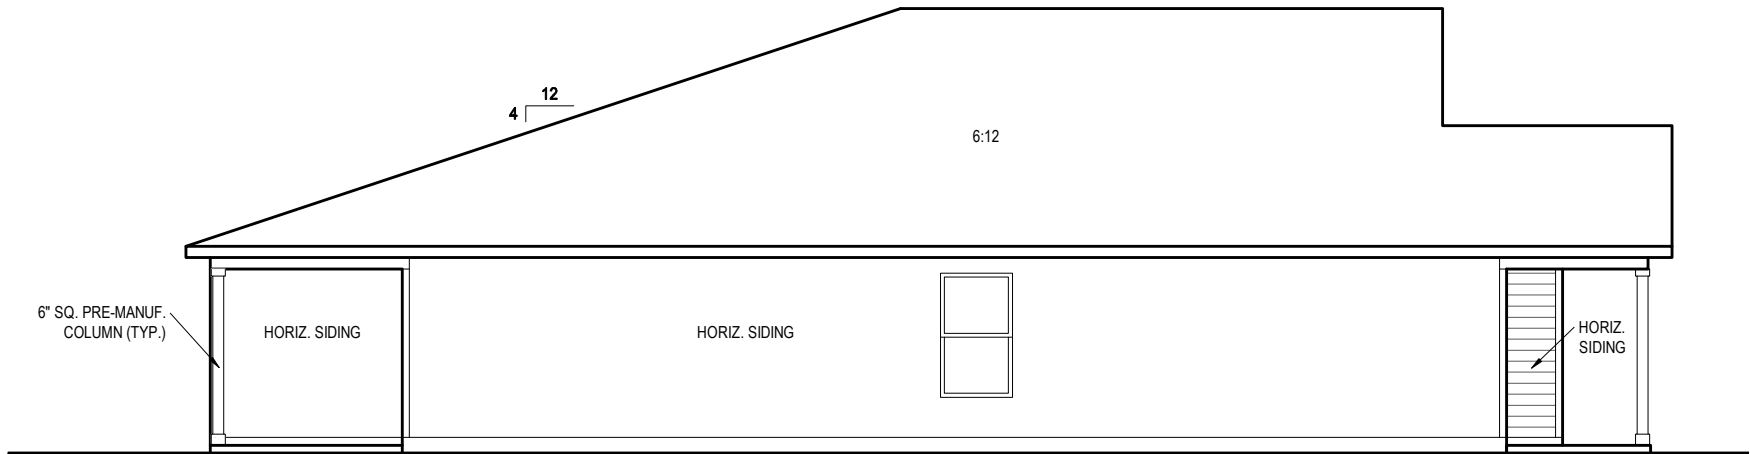

LEFT SIDE ELEVATION 'B1'

1/8" = 1'-0" @ 11x17

1/4" = 1'-0" @ 22x34

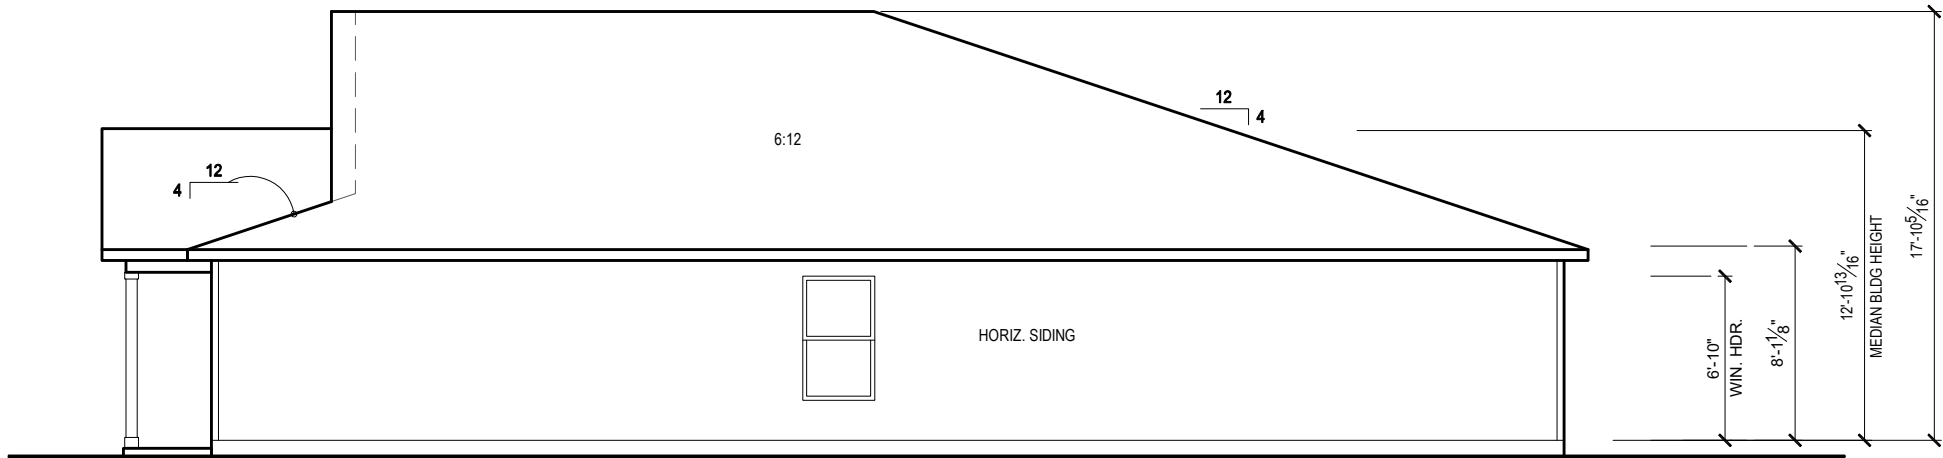

RIGHT SIDE ELEVATION 'B1'

1/8" = 1'-0" @ 11x17

1/4" = 1'-0" @ 22x34



THE SET OF 16 CONCEPT DRAWINGS, INCLUDING, BUT NOT LIMITED TO, ARCHITECTURAL, MECHANICAL, ELECTRICAL, AND PLUMBING DRAWINGS, ARE HEREBY SUBMITTED TO THE FLORIDA DEPARTMENT OF BUSINESS AND PROFESSIONAL REGULATION FOR REVIEW AND APPROVAL. THE DRAWINGS ARE NOT TO BE USED FOR CONSTRUCTION WITHOUT THE WRITTEN PERMISSION OF CENTURY COMMUNITIES, INC. AND WITHOUT THE WRITTEN PERMISSION OF THE FLORIDA DEPARTMENT OF BUSINESS AND PROFESSIONAL REGULATION. IF SEAL AND SIGNATURE ARE NOT MADE ON ONE SET OF THE DRAWINGS, CONTACT THE CLERK FOR INFORMATION.

1-14-2022



256 Southrail Lane, Suite 200
Ocala, FL 34761
O: 352.972-2491 F: 352.972-2492
Certificate Of Authorization No. 9161
☐ CARLA BROWN, PE - FL #58128
☐ LUIS PABLO TORRES, PE - FL #17194

Reserve at Jewel Lake
Lot 030
436 SW Jewel Lake Drive
Lake City, FL 32024

Century Communities expressly reserves its common law copyright in these plans. Plans are not to be copied, reproduced, or changed, in any manner whatsoever, nor are they to be assigned to a third party without written permission and consent of Century Communities.

PLAN NUMBER:
33811607

RELEASE DATE:
08.30.2021

MODEL:
COVINGTON


DRAWING TITLE:
EXTERIOR ELEVATIONS

SHEET NO:

1.2-B1

GENERAL SLAB FOUNDATION NOTES

- PLUMBING CONTRACTOR SHALL FIELD VERIFY ALL PLUMBING LOCATIONS.
- REFER TO EXTERIOR ELEVATIONS FOR BRICK/STONE LOCATIONS.
- GARAGE SLAB SHALL SLOPE TOWARD GARAGE DOOR OPENING.

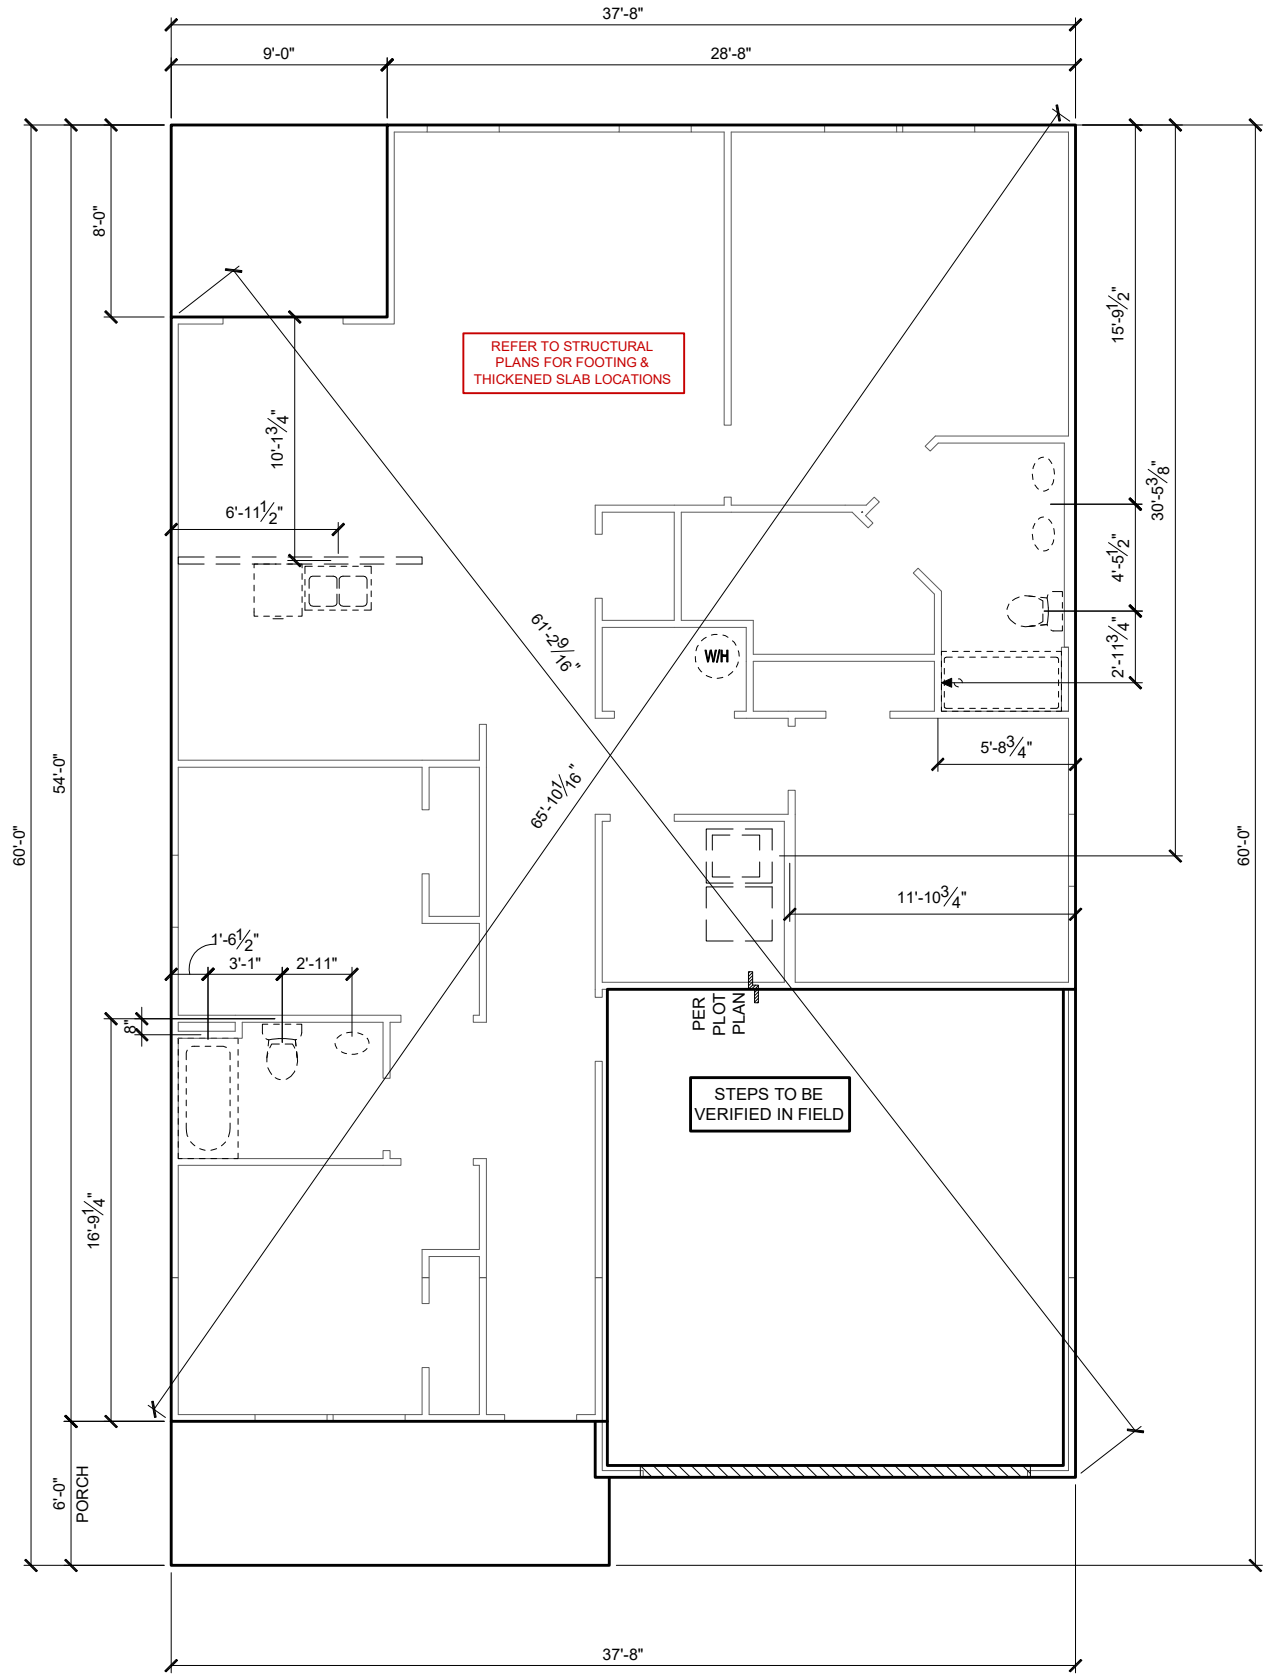

SLAB PENETRATION PLAN 'B1'

1/8" = 1'-0" @ 11x17

1/4" = 1'-0" @ 22x34

1-14-2022

256 Southrail Lane, Suite 200
O: 322.972.2451 F: 407.880.2304
Certificate Of Authorization No. 9161
CARLA BROWN, PE - FL # 55128
LUIS PABLO TORRES, PE - FL # 17194

Reserve at Jewel Lake
Lot 030
436 SW Jewel Lake Drive
Lake City, FL 32024

Century Communities expressly reserves its common law copyright in these plans. Plans are not to be copied, reproduced, or changed, in any manner whatsoever, nor are they to be assigned to a third party without written permission and consent of Century Communities.

PLAN NUMBER:
33811607

RELEASE DATE:
08.30.2021

MODEL:
COVINGTON

DRAWING TITLE:
SLAB PENETRATION PLAN

SHEET NO:
2.1-B

NOTES & LEGENDS

1. REFER TO ENGINEERING STRUCTURAL DRAWINGS (S-#) FOR BEARING WALL LOCATIONS AND FOR ALL BEAM & HEADER SIZES AND BEARING WALL LOCATIONS

2. ALL BEARING WALLS SHALL BE 16" O.C. WALL CONST. W/ DOUBLE TOP PLATE U.N.O.

3. ALL INTERIOR NON BEARING DOOR & WINDOW HEADERS SHALL BE (1) 2x4 OR (1) 2x6 W/VERTICAL CRIPPLERS @ 2'-0" O.C. TO MATCH WALL WIDTH UNLESS NOTED OTHERWISE.

4. (2) HOSE BIBS SHALL BE INSTALLED, LOCATION TO BE DETERMINED BY PLUMBING CONTRACTOR
- OPTIONAL WINDOW

2X4 FRAME WALL

2X6 FRAME WALL

BALLOON FRAME WALL
(PER STRUCTURALS)

KEYNOTES

- A1 GARAGE CEILING - 5/8" TYPE X DRYWALL
VERTICAL SURFACE WALLS - 1/2" DRYWALL

A2 22X30" ATTIC ACCESS CONSTRUCTED WITH GYP. BD. (5/8" TYPE X AT GARAGE) WITH DOOR TRIM FRAME ACCESS SUPPORT

A3 PROVIDE 6" MIN. FLAT CLG AT ANGLED CLG CONDITION

A4 PULL DOWN STAIRS 25.5" x 54"

A5 TEMPERED SAFETY GLASS PER IRC R308.4

A6 HOUSE TO GARAGE DOOR SEPARATION. PROVIDE APPROVED 20 MINUTE RATED DOOR PER IRC 302.5.1

A7 A/C CONDENSER PAD. REFER TO SITE PLAN FOR FINAL LOCATION. VERIFY CONNECTION TO CONC. PAD W/ MANUF. SPECS

A8 1/2" TYPE X DRYWALL AT ACCESSIBLE AREAS UNDER STAIRS

A9 LOUVERED DOOR w/ GAS FURNACE
- D1 DRYWALL SOFFIT - 12" DROP FROM CEILING LINE

D2 DRYWALL SOFFIT - 8" DROP FROM CEILING LINE
- K1 39" KNEE WALL WITH CAP PER SPECS

K2 38" KNEE WALL WITH 1x CAP

K3 46" KNEE WALL WITH CAP PER SPECS

K4 34 1/2" KNEE WALL

K5 42" KNEE WALL WITH 1x CAP

K6 KNEE WALL WITH 1x CAP 42" ABOVE STAIR NOSING OR LANDING
- P1 30" X 60" SHOWER ENCLOSURE PER SPECS


P2 30"x60" TUB PER SPECS
- S1 BOX STAIR WITH 38" KNEE WALL & 1X CAP

S2 1X CAPPED STRINGER, TOP AT 3" ABOVE TREAD

S3 HANDRAIL AT +36" ABV. STAIR NOSING OR LANDING

area tabulation 'b'

GARAGE	401 SF
FRONT PORCH	108 SF
REAR PATIO	72 SF
FLOOR 1 LIVING	1,607 SF
TOTAL LIVING	1,607 SF

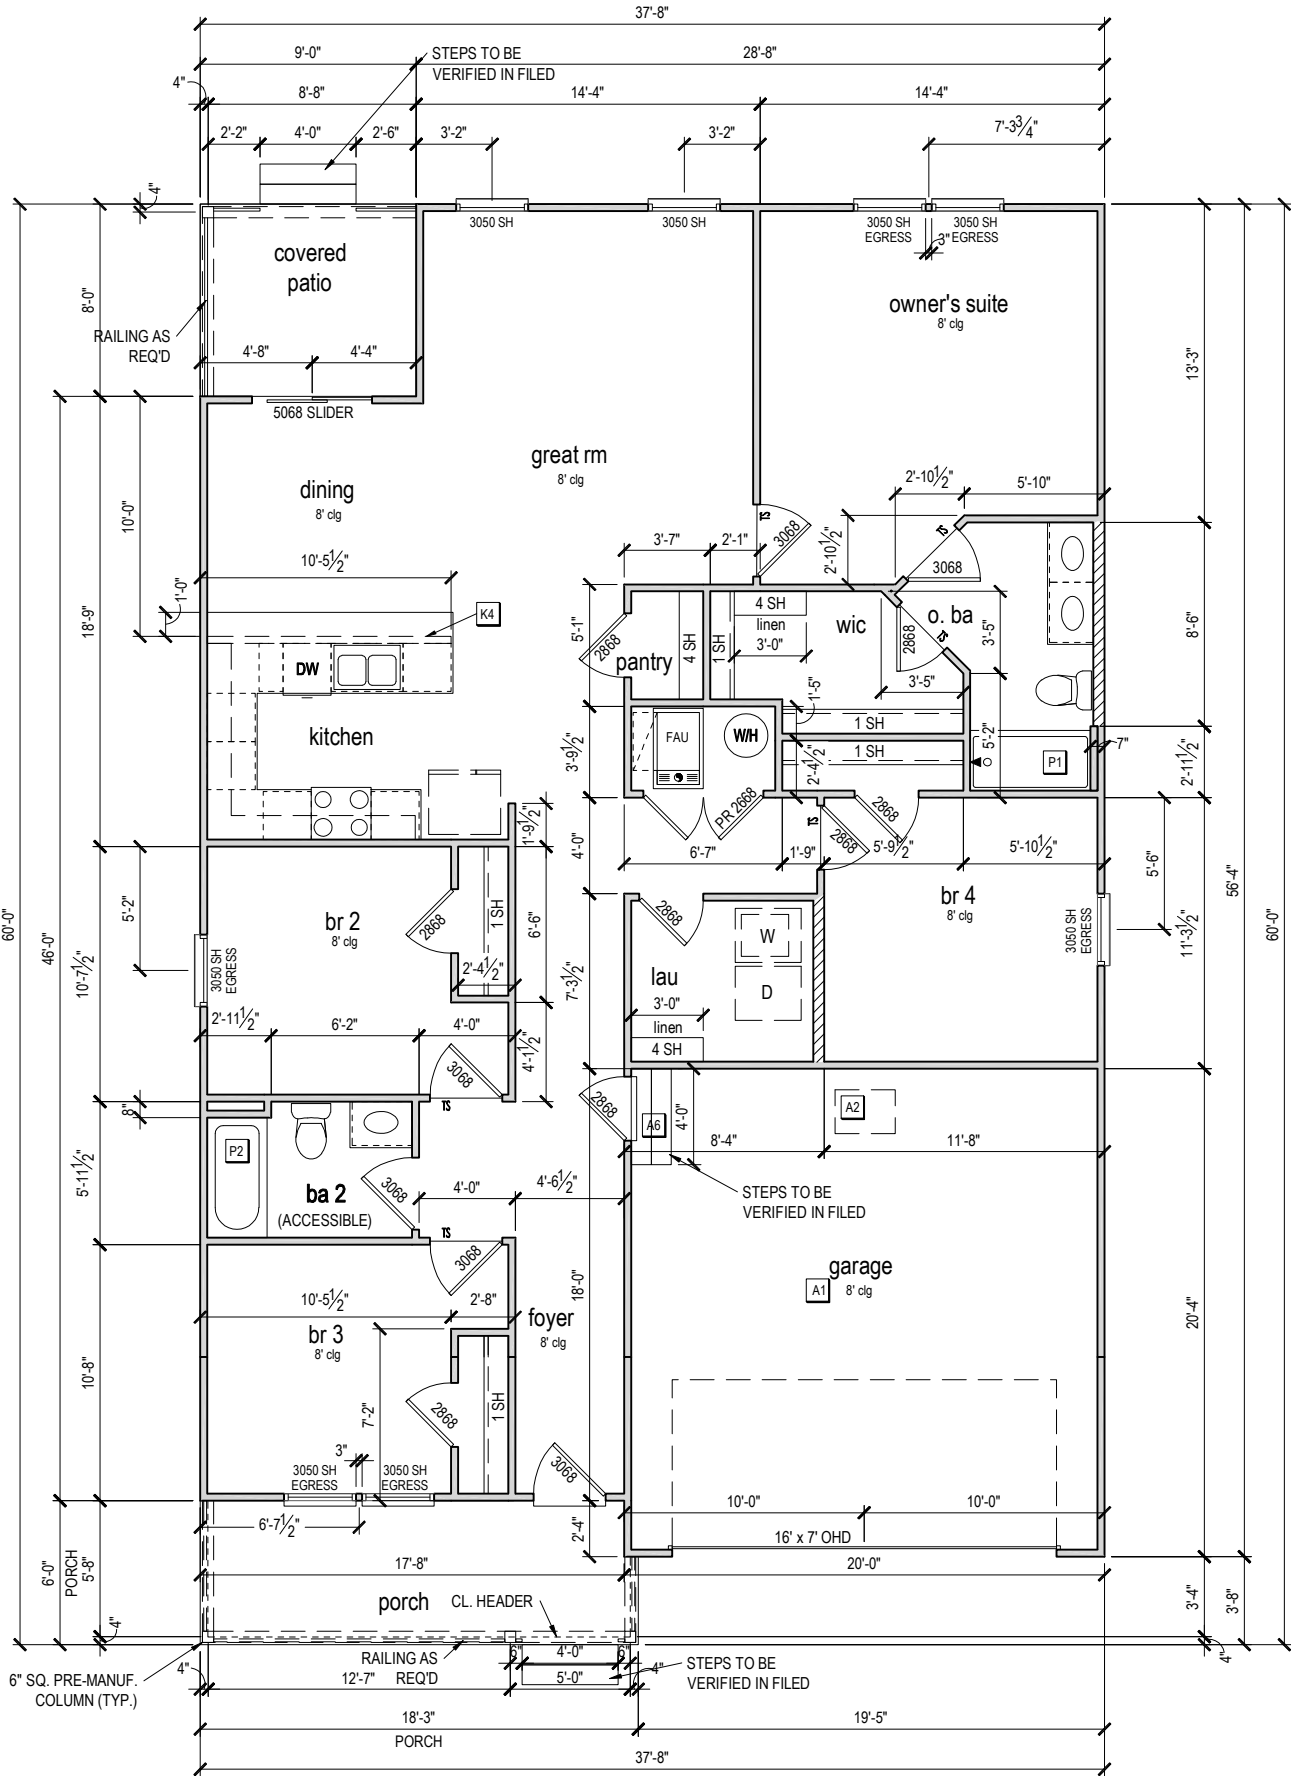

FIRST FLOOR PLAN 'B'

1/8" = 1'-0" @ 11x17
1/4" = 1'-0" @ 22x34

CENTURY
Complete

1-14-2022

FDS

ENGINEERING ASSOCIATES

256 Southrail Lane, Suite 200
O 321.972-2491 F 407.880-2304
Certificate Of Authorization No. 9161

CARLA BROWN, P.E. - FL # 58128

LUIS PABLO TORRES, P.E. - FL # 27184

Reserve at Jewel Lake
Lot 030
436 SW Jewel Lake Drive
Lake City, FL 32024

Century Communities expressly reserves its common law copyright in these plans. Plans are not to be copied, reproduced, or changed, in any manner whatsoever, nor are they to be assigned to a third party without written permission and consent of Century Communities.

MODEL: COVINGTON

DRAWING TITLE: FIRST FLOOR PLAN

PLAN NUMBER: 33811607
RELEASE DATE: 08.30.2021
SHEET NO: 3.1-Bs

ATTIC VENT CALCULATION


ATTIC VENTILATION TO COMPLY w/ F.B.C RESIDENTIAL CODE. THE REQUIRED NET FREE VENTILATING AREA OF NOT LESS THAN 1/150 OF THE SPACE VENTILATED. AREA MAY BE REDUCED TO 1/300 PROVIDED THAT 40 TO 50 PERCENT OF THE REQ'D VENTILATING AREA IS PROVIDED IN THE UPPER PORTION OF THE SPACE TO BE VENTILATED AT LEAST 3 FEET ABOVE EAVE OR CORNICE WITH THE BALANCE OF THE REQ'D VENTILATION PROVIDED BY THE EAVE OR CORNICE VENTS.

MANUFACTURE SELECTED TO VERIFY THE NET FREE VENTILATION OF THE VENT PRODUCT SELECTED AND TO MAINTAIN THE REQUIRED VENTILATION.

DO NOT LOCATE VENTS ON ROOF PLANE(S) FACING STREET.

ROOF VENTILATION CALCULATIONS			
ROOF AREA	2,388 SF		
TOTAL NET FREE AREA REQ'D (1 TO 300)	1146.2 SQ. IN.		
MAIN HOUSE INLET (SOFFIT) VENTILATION	100.0 LF x	6.4 SQ. IN / LINEAR FT =	640.0 SQ. IN.
POD VENT(S) REQUIRED WITH BASE HOUSE	8	VENTS AT 70.0 SQ. IN EA. =	560.0 SQ. IN.
LOWER VENTING PROVIDED (573.1 SQ. IN. REQ'D)	640.0 SQ. IN	53.3%	
UPPER VENTING PROVIDED (573.1 SQ. IN. REQ'D)	560.0 SQ. IN	46.7%	

NOTE: TYPICAL VENTILATION INCLUDES:
1. SOFFIT VENTS
(AREA: 6.4 SQ. IN PER FOOT - VERIFY WITH MANUFACTURE)
2. LOMANCO 770" ATTIC VENT LOCATED 12" MIN. FROM RIDGE
(AREA: 70 SQ. IN. - VERIFY W MANUFACTURE)
*(1) LOMANCO 770D VENT AT 140 S.I. EA.CAN BE USED IN PLACE OF (2) 770 VENTS.

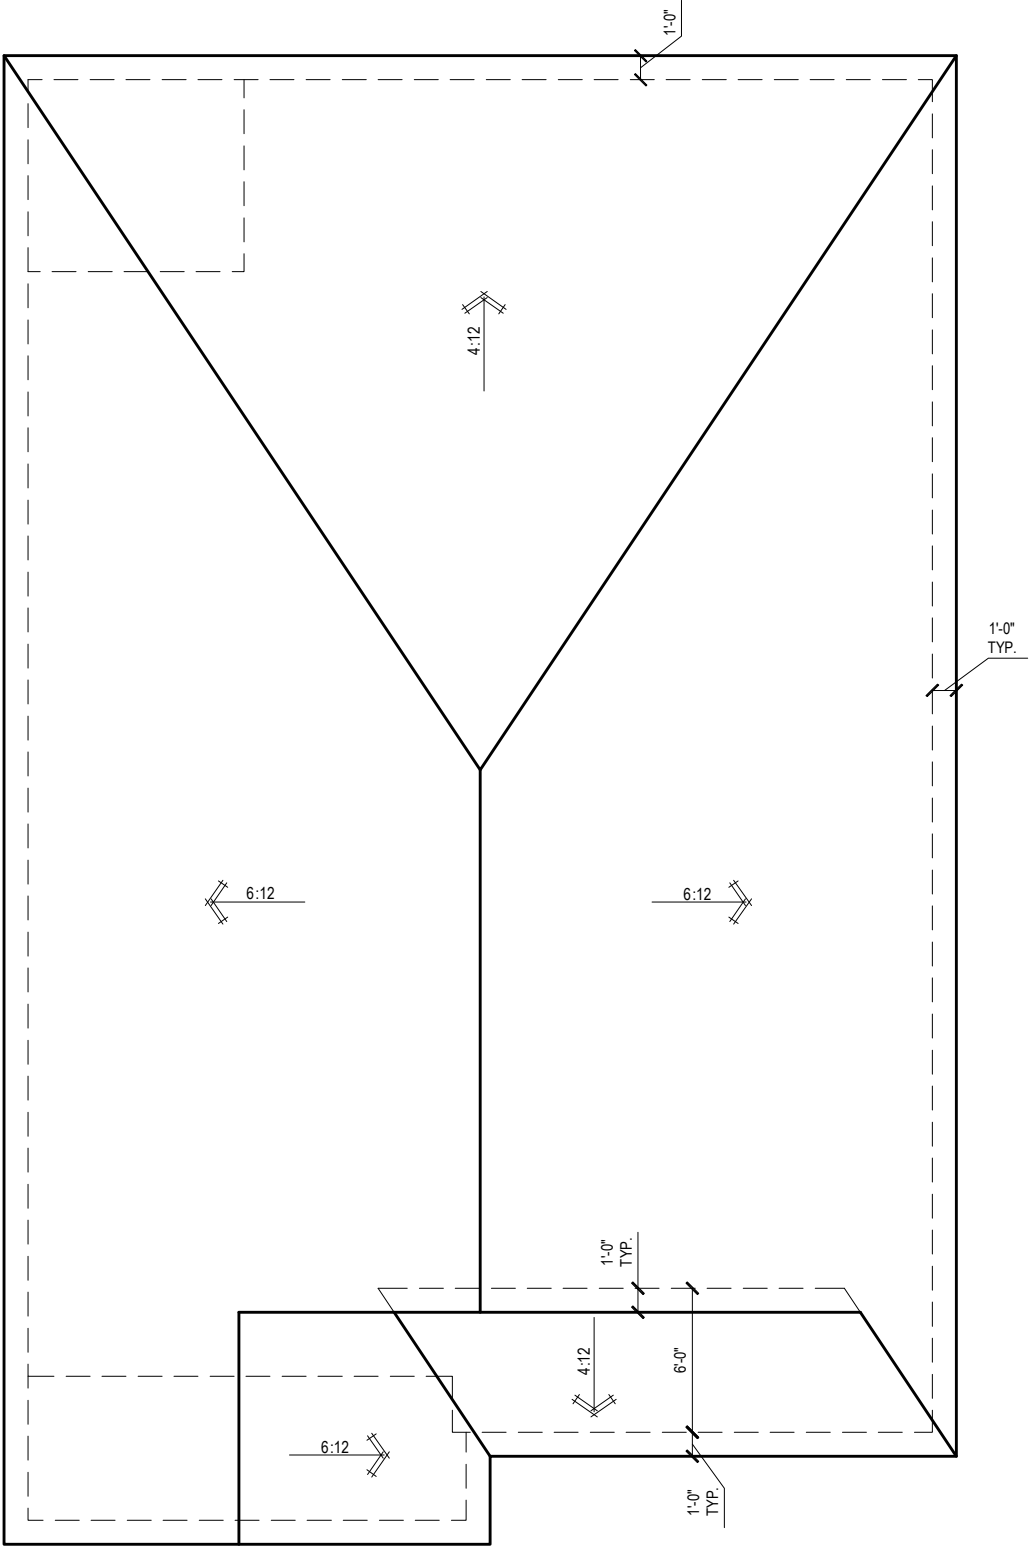

ROOF PLAN 'B'
1/8" = 1'-0" @ 11x17
1/4" = 1'-0" @ 22x34



THIS SET OF PLANS COMPLIES WITH THE F.B.C. RESIDENTIAL CODE. THE REQUIRED NET FREE VENTILATING AREA OF NOT LESS THAN 1/150 OF THE SPACE VENTILATED. AREA MAY BE REDUCED TO 1/300 PROVIDED THAT 40 TO 50 PERCENT OF THE REQ'D VENTILATING AREA IS PROVIDED IN THE UPPER PORTION OF THE SPACE TO BE VENTILATED AT LEAST 3 FEET ABOVE EAVE OR CORNICE WITH THE BALANCE OF THE REQ'D VENTILATION PROVIDED BY THE EAVE OR CORNICE VENTS.

1-14-2022

IF SEAL AND SIGNATURE ARE NOT MADE OR ONE NOT BE, BRANDED CONTACT THE CLERK FOR AUTHORIZATION.



FDS
ENGINEERING ASSOCIATES
256 Southrail Lane, Suite 200
O 321.972-2491 F 407.880-2304
Certificate Of Authorization No. 9161
☐ CARLA A. BROWN, PE - FL # 58128
☐ LUIS PABLO TORRES, PE - FL # 127184

Reserve at Jewel Lake
Lot 030
436 SW Jewel Lake Drive
Lake City, FL 32024

Century Communities expressly reserves its common law copyright in these plans. Plans are not to be copied, reproduced, or changed, in any manner whatsoever, nor are they to be assigned to a third party without written permission and consent of Century Communities.

PLAN NUMBER:	33811607	RELEASE DATE:	08.30.2021
--------------	----------	---------------	------------

MODEL:	COVINGTON	DRAWING TITLE:	ROOF PLAN
--------	-----------	----------------	-----------

SHEET NO:

6.1-B

ELECTRICAL LEGEND

\$

SWITCH

\$3

3 WAY SWITCH

\$4

4 WAY SWITCH

WALL MOUNTED LIGHT

LED DOWNLIGHT

DISCONNECT

CEILING FIXTURE OUTLET

S

SMOKE DETECTOR

C

SMOKE/CARBON MONOXIDE ALARM

SW

110v RECEPTACLE

110v SWITCHED RECEPTACLE

110v ABOVE COUNTER RECEPTACLE. GFI PROTECTED AT KITCHEN, BATH & LAUNDRY

110v DEDICATED RECEPTACLE FOR SECURITY/STRUCTURED WIRING PANEL

GFI

GFI OUTLET

220v

220v RECEPTACLE

110v FLOOR RECEPTACLE

DISPOSAL

CHIME

BATH EXHAUST FAN

CEILING FAN PREWIRE WITH BRACING FOR FUTURE FAN

PW

B = BRACE FOR FUTURE FAN

H = HANGING

P = OPT. PENDANT

VP=VAPOR PROTECTED

• PROVIDE ADDITIONAL EXTERIOR WEATHERPROOF RECEPTACLE WITHIN 15 FEET OF CONDENSING UNITS

• INSTALL GFCI AND ARC FAULT CIRCUIT INTERRUPTER PROTECTION PER NEC SECTIONS 210.52G


• ALL GARAGE OUTLETS SHALL BE ON A DEDICATED CIRCUIT

• IONIZATION SMOKE ALARMS WITH AN ALARM-SILENCING SWITCH SHALL NOT BE INSTALLED LESS THAN 10 FEET (3048 MM) HORIZONTALLY FROM A PERMANENTLY INSTALLED COOKING APPLIANCE.

• DWGS. ARE DIAGRAMMATICAL & INDICATE THE GENERAL ARRANGEMENT OF THE ELECTRICAL WORK. ANY DISCREPANCIES ON THE DOCUMENTS SHALL BE CALLED TO THE ARCHITECT'S ATTENTION PRIOR TO THE COMMENCEMENT OF WORK. DO NOT SCALE ELECTRICAL DRAWINGS.

KEYNOTES

- E1 ELECTRICAL PANEL PER SPECS
- E2 INSTALL GFI OUTLET UNDER SINK FOR FUTURE DISPOSAL
- E3 DOOR CHIME TRANSFORMER LOCATION
- E4 MECHANICAL ROOMS TO INCLUDE KEYLESS LIGHT, PLUG AND DISCONNECT FOR AIR HANDLER
- E5 COACH LIGHT ONLY IF REQUIRED BY LOCAL MUNICIPALITY. INSTALL AT 68" AFF
- E6 INSTALL COACH LIGHT AT 68" AFF

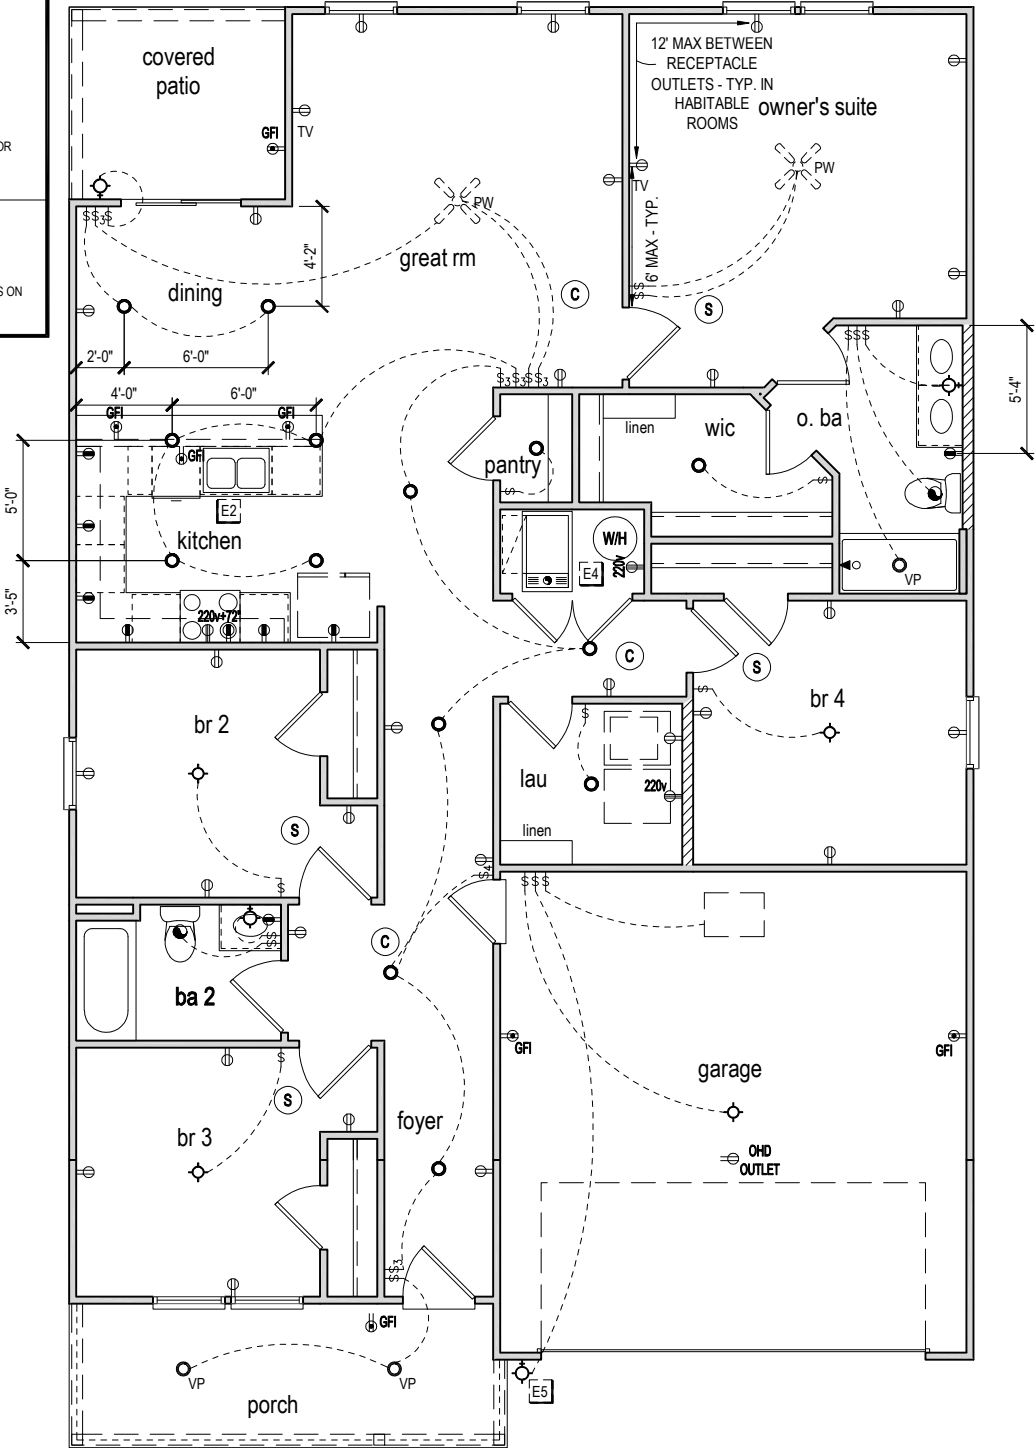

FIRST FLOOR ELECTRICAL PLAN 'B'

1/8" = 1'-0" @ 11x17
1/4" = 1'-0" @ 22x34



1-14-2022

Reserve at Jewel Lake
Lot 030
436 SW Jewel Lake Drive
Lake City, FL 32024

Century Communities expressly reserves its common law copyright in these plans. Plans are not to be copied, reproduced, or changed, in any manner whatsoever, nor are they to be assigned to a third party without written permission and consent of Century Communities.

PLAN NUMBER:
33811607

RELEASE DATE:
08.30.2021

MODEL:
COVINGTON

DRAWING TITLE:
FIRST FLOOR ELECTRICAL

SHEET NO:

E1.1

[illegible]

ABBREVIATIONS

A.B.	Anchor Bolt	F.S.M.	Flare System	P.S.F.	Pounds per square foot
Abv.	Above	P.T.	Face of Masonry	P.T.	Pressure Treated
Adj.	Adjustable	Fl.	Foot / Feet	Rd.	Radius
A.F.F.	Above Finished Floor	Ftg.	Footing	Req'd.	Required
ALT.	Alternate	Galv.	Galvanized	Rm.	Room
Bm.	Beam	G.C.	General Contractor	Rnd.	Round
B/Btm	Bottom of Beam	G.F.I.	Ground Fault Interrupter	S.F.	Square Feet
Brg.	Bearing	G.T.	Grid Truss	S.L.	Shed
Cant.	Cantilever	Hdr.	Header	S.H.T.	Square Light
Cir.	Circle	Hgt.	Height	S.P.F.	Spruce Pine Fir
Clq.	Ceiling	Int.	Interior	Sq.	Square
CJ	Control Joint	K/Wall	Kneewall	S.Y.P.	Southern Yellow Pine
Col.	Column	L.F.	Linear Ft.	Thickn.	Thicken
Cont.	Continuous	Mas.	Masonry	T.O.B.	Top of Block
Dbt.	Double	Max	Maximum	T.M.	Top of Member
Dia.	Diameter	Min	Minimum	T.O.P.	Top of Plate
Ea.	Each	M.L.	Microalun	Trans.	Transom Window
E.W.	Each Way	Mir.	Mirror	Typ.	Typical
Elec.	Electrical	Mon.	Monolithic	U.N.O.	Unless Noted Otherwise
Elev.	Elevation	N.T.S.	Not to Scale	Vert.	Vertical
E.O.R	Engineering or Other	O.C.	On center	V.L.	Versalun
Ext.	Exterior	Oprg.	Opening	VTR	Vent through Roof
Exp.	Expansion	O.P.	Opening	W	Washer
F.B.C.	Florida Bldg. Code	Pt.	Piece	W/	With
Fin. Flr.	Finished Floor	P.L.	Paralun	W.A.	Wedge Anchor
		PLF	Pounds per linear foot	Wd	Wood
Fdn.	Foundation	Plt. Ht.	Plate Height	WP	Water Proof

TERMITE SPECIFICATIONS

SECTION R318 PROTECTION AGAINST TERMITES

TERMITE PROTECTION SHALL BE PROVIDED BY REGISTERED TERMITICIDES, INCLUDING SOLID APPLIED PESTICIDES, BAITING SYSTEMS, AND PESTICIDES APPLIED TO WOOD, OR OTHER APPROVED METHODS OF TERMITE PROTECTION LABELED FOR USE AS PREVENTIVE TREATMENT TO NEW CONSTRUCTION (SEE SECTION 202, REGISTERED TERMITICIDES). UPON COMPLETION OF THE APPLICATION OF THE TERMITE PREVENTIVE TREATMENT, THE BUILDING DEPARTMENT SHALL BE ISSUED TO THE BUILDING DEPARTMENT BY THE LICENSED PEST CONTROL COMPANY THAT CONTAINS THE FOLLOWING STATEMENT: "THE BUILDING HAS RECEIVED A COMPLETE TREATMENT FOR THE PREVENTION OF SUBTERRANEAN TERMITES. TREATMENT IS IN ACCORDANCE WITH RULES AND LAWS ESTABLISHED BY THE FLORIDA DEPARTMENT OF AGRICULTURE AND CONSUMER SERVICES."

NOTES:

1. METHOD OF TREATMENT SHALL BE APPROVED BY THE GOVERNING JURISDICTION "LIQUID BORATE OR BOR-A-COR" PRODUCT METHODS MUST BE DETERMINED AT PERMIT STAGE AND PRODUCT APPROVAL DATA MUST BE ON FILE WITH THE BUILDING DEPARTMENT.
2. PRESSURE TREATED LUMBER THAT HAS BEEN CUT OR DRILLED THAT EXPOSES UNTREATED PORTIONS OF WOOD ARE REQUIRED TO BE FIELD TREATED TO PREVENT INSECT INFESTATION
3. OPTIONAL BORATE APPLIED TO ALL FRAME MEMBERS WITHIN 24" A.F.F.

- -NOTICE TO BUILDER AND ALL SUBCONTRACTORS- -

IT IS THE INTENT OF THE ENGINEER LISTED IN THE TITLEBLOCK OF THESE DOCUMENTS THAT THESE DOCUMENTS BE ACCURATE, PROVIDING LICENSED PROFESSIONALS CLEAR INFORMATION. EVERY ATTEMPT HAS BEEN MADE TO PREVENT ERROR. THE BUILDER AND ALL SUBCONTRACTORS ARE REQUIRED TO:

1. REVIEW ALL THE INFORMATION CONTAINED IN THESE DOCUMENTS, PRIOR TO THE COMMENCEMENT OF ANY WORK. THE ENGINEER ARE NOT RESPONSIBLE FOR ANY PLAN ERRORS, OMISSIONS, OR MISINTERPRETATIONS UNDETECTED AND NOT REPORTED TO THE ENGINEER PRIOR TO CONSTRUCTION.
2. SHALL STRICTLY OBSERVE ALL APPLICATION CODES DURING THE COURSE OF CONSTRUCTION INCLUDING ALL STATE, CITY, AND COUNTY BUILDING, ZONING, ELECTRICAL, MECHANICAL, PLUMBING AND FIRE CODES. CONTRACTOR SHALL VERIFY ALL CODE REQUIREMENTS PRIOR TO COMMENCEMENT OF WORK.
3. THE ARCHITECT OR ENGINEER SHALL NOT BE RESPONSIBLE FOR SAFETY PROCEDURES, THE MEANS AND METHODS OF CONSTRUCTION, TECHNOLOGIES, OR THE CONTRACTOR TO CARRY OUT THE WORK IN ACCORDANCE WITH THE DRAWINGS AND SPECIFICATIONS OR RELATED CODES.
4. THE FRAMING PLAN SHOWN INDICATES THE "TRUSS SYSTEM" AND IS THE RESPONSIBILITY OF THE TRUSS SYSTEM ENGINEER (DESIGN PROFESSIONAL OF RECORD). THE TRUSS DESIGN ENGINEER IS SEPARATE AND INDEPENDENT FROM THE PROJECT ARCHITECT OR ENGINEER. THE TRUSS PROFILE, AND IS TO SUBMIT A FINAL SET OF TRUSS ENGINEERING SIGNED AND SEALED TRUSS DRAWINGS TO DESIGN PROFESSIONAL OF RECORD FOR REVIEW PRIOR TO FABRICATION.
5. ANY DISCREPANCY OR ERROR IN DIMENSIONS OR NOTES WITH IN THIS PLAN SHALL BE BROUGHT TO THE ATTENTION OF THE DESIGN PROFESSIONAL FOR CLARIFICATION PRIOR TO CONSTRUCTION.
6. ALL CONSTRUCTION MUST BE IN ACCORDANCE TO THE INFORMATION FOUND IN THESE DOCUMENTS. ANY QUESTIONS REGARDING THE INFORMATION FOUND IN THESE PLANS SHOULD BE DIRECTED TO OUR QUALITY ASSURANCE MANAGER AT 321-972-0491 IMMEDIATELY. NO BACK CHARGES WILL BE CONSIDERED. NO AMBUSHMENT BY THE ENGINEER WITHOUT ADVANCED NOTIFICATION AND APPROVAL BY THE ENGINEER. PAYMENTS WILL BE MADE IN ACCORDANCE TO THE TERMS OF THE AGREEMENT.

HOME MAINTENANCE & INSPECTIONS

YEARLY MAINTENANCE AND INSPECTIONS BY THE BUILDER/HOMEOWNER ARE NECESSARY FOR THE FUTURE LIFE OF THIS HOME. CARE MUST BE TAKEN TO CHECK WINDOWS AND DOORS FOR CAULKING, REMOVE LEAVES AND DEBRIS OFF ROOFS, MAKE SURE THAT WATER FLOW IS AWAY FROM THE HOUSE AND HAVE YOUR HOME REPAINTED EVERY 3 - 5 YEARS TO PROTECT THE COATINGS. THE DESIGNER AND ENGINEER ARE RESPONSIBLE FOR THE RESPONSIBILITY FOR THE UPKEEP OF THE HOME AND WILL NOT BE HELD LIABLE FOR INSTANCES THAT MAY OCCUR OVER THE NORMAL LIFE OF THE HOME WITHOUT PROPER MAINTENANCE.

STRUCTURAL DESIGN CRITERIA

CODE CRITERIA

- FLORIDA BUILDING CODE 7TH EDITION (2020) RESIDENTIAL
- FLORIDA FIRE PREVENTION CODE 7TH EDITION (2020)
- FLORIDA BUILDING CODE ACCESSIBILITY 7TH EDITION (2020)
- NFPA 70-17. NATIONAL ELECTRICAL CODES. (NEC 2017)
- BUILDING CODE REQUIREMENTS FOR STRUCTURAL CONCRETE - (ACI 318-14).
- SPECIFICATIONS FOR STRUCTURAL CONCRETE - (ACI 301-16).
- BUILDING CODE REQUIREMENTS FOR MASONRY STRUCTURES - (ACI 530-13).
- NATIONAL DESIGN SPECIFICATION FOR WOOD CONSTRUCTION - 2018 EDITION
- WOOD FRAMED CONSTRUCTION MANUAL 2018 EDITION.
- APA PLYWOOD DESIGN SPECIFICATION E30-16
- AMERICAN SOCIETY OF CIVIL ENGINEERS: ASCE/SEI 7-16
- ALUMINUM DESIGN MANUAL - AAF-20

GENERAL ROOF LOADING

	SHINGLE ROOF (PSF)	METAL ROOF (PSF)	TILE ROOF (PSF)	HEAVY ROOF (PSF)
TOP CHORD LL	20	20	20	20
TOP CHORD LD	10	10	15	25
BOTTOM CHORD LL*	0	0	0	0
BOTTOM CHORD LD	10	10	10	10
TOTAL	40	40	45	55
BOTTOM CHORD LL (OPT)				
ATTICS W/ LIMITED STORAGE	20			
ATTICS W/ HEAVY STORAGE	50			
* ATTICS W/ NO STORAGE (NON-CONCURRENT)	10			

NOTE: LL REDUCTIONS ARE ALLOWED PER CODE BUT ONLY WITH WRITTEN APPROVAL FROM EOR OR INDICATED ON PLAN

GENERAL FLOOR LOADING

TOP CHORD LL	40 (PSF)	COMMENTS:
TOP CHORD DL	10 (PSF)	
BOTTOM CHORD LL	0 (PSF)	
BOTTOM CHORD DL	5 (PSF)	

SPECIAL FLOOR LOADING

GAME ROOM / READING ROOMS	60 (PSF)	COMMENTS: a. SINGLE CONCENTRATED LOAD APPLIED IN ANY DIRECTION AT ANY POINT ALONG THE TOP b. BALUSTERS AND PANELS FILLERS SHALL BE DESIGNED TO WITHSTAND A HORIZONTALLY APPLIED NORMAL LOAD OF 50 POUNDS ON AN AREA EQUAL TO 1 SQ. FT.
BALCONIES / DECKS	40 (PSF)	
STAIRS OF OVER 100 SQ.FT	120 (PSF)	
LIGHT STORAGE	100 (PSF)	
GUARDRAILS AND HANDRAILS	200 (LBS)(d)	
GUARDRAIL IN-FILL COMPONENTS	50 (LBS)(f)	
STAIRS / NON SLEEPING ROOMS	40 (PSF)	
BATHS / BATH ROOMS	50 (PSF)	
LIBRARIES - STACK ROOMS	150 (PSF)	
HABITABLE ATTICS SERVED w/ FIXED STAIRS	30 (PSF)	
PASSENGER VEHICLE GARAGES	50 (PSF)	

DEFLECTION CRITERIA

ROOF TRUSSES*	LL/360	TL/240
ROOF RAFTERS	LL/180	TL/120
ROOF RAFTERS (W/O CLG)	LL/360	TL/240
FLOOR TRUSSES/ BEAMS **	LL/360	TL/240
FLOOR I-JOIST***	LL/480	TL/240

*TL MAX 2" UP TO 40FT SPAN
**TL MAX 3/4"
*** TL MAX 1/2"

GENERAL STRUCTURAL NOTES

STRUCTURAL STEEL

1. MATERIAL SPECIFICATIONS: SIDE FLANGE ALL SECTIONS: ASTM A992, 60ksi, Fy=50 ksi TUBE STEEL (HSS); ASTM A500, GRADE B; Fy = 46 ksi PIPE STEEL; ASTM S3120, TYPE E OR W, Fy = 35 ksi ALL OTHER STRUCTURAL & MISC. STEEL. A36 Fy=36 ksi STRUCTURAL CONNECTIONS; ALL STRUCTURAL BOLTS SHALL BE SMALLER THAN 5/8" DIA. TO BE A307 THREADED ROD SHALL CONFORM TO A306 OR A307 ANCHOR BOLTS SHALL CONFORM TO ASTM F1554 ALL BOLTS CAST IN CONCRETE. ASTM A36 OR A307 3-SHOT SHOP AND FIELD WELDS: ETXX ELECTRODES STEEL REINFORCEMENT SHOP DRAWINGS TO BE PROVIDED TO ENGINEER OF RECORD BEFORE FABRICATION FOR REVIEW AND APPROVAL.
2. STRUCTURAL BOLTS SHALL BE SMALLER THAN 5/8" DIA. TO BE A307 THREADED ROD SHALL CONFORM TO A306 OR A307 ANCHOR BOLTS SHALL CONFORM TO ASTM F1554 ALL BOLTS CAST IN CONCRETE. ASTM A36 OR A307 3-SHOT SHOP AND FIELD WELDS: ETXX ELECTRODES STEEL REINFORCEMENT SHOP DRAWINGS TO BE PROVIDED TO ENGINEER OF RECORD BEFORE FABRICATION FOR REVIEW AND APPROVAL.
3. STRUCTURAL BOLTS SHALL BE SMALLER THAN 5/8" DIA. TO BE A307 THREADED ROD SHALL CONFORM TO A306 OR A307 ANCHOR BOLTS SHALL CONFORM TO ASTM F1554 ALL BOLTS CAST IN CONCRETE. ASTM A36 OR A307 3-SHOT SHOP AND FIELD WELDS: ETXX ELECTRODES STEEL REINFORCEMENT SHOP DRAWINGS TO BE PROVIDED TO ENGINEER OF RECORD BEFORE FABRICATION FOR REVIEW AND APPROVAL. WELDED CONNECTIONS: ELECTRODES - ETXX UNO (LOW HYDROGEN), FILLET WELDS SHALL BE 3/4" UNO.
4. SHOP DRAWINGS OF ALL STRUCTURAL STEEL SHALL BE SUBMITTED TO THE ENGINEER OF RECORD FOR REVIEW PRIOR TO FABRICATION. SHOP DRAWINGS SHALL INCLUDE COMPLETE DETAILS AND SCHEDULES FOR FABRICATION AND ASSEMBLY OF STRUCTURAL STEEL MEMBERS, PROCEDURES, AND DIAGRAMS INCLUDING DETAILS OF CUTS, CAMBERS, HOLES, PROFILES, SIZES, SPACING, AND LOCATIONS OF STRUCTURAL MEMBERS, CONNECTION ATTACHMENTS, FASTENERS, LOAD, TOLERANCES, AND OTHER PERTINENT DATA. INDICATE WELDS BY STANDARD AWS SYMBOLS AND SHOW LOCATION OF WELDS WITH REFERENCE TO DIMENSIONS, TEMPLATES, AND DIRECTIONS FOR INSTALLATION OF ANCHOR BOLTS AND OTHER ANCHORAGE TO BE INSTALLED FOR WORK OF OTHER TRADES.
5. STRUCTURAL STEEL SHALL RECEIVE SHOP COAT OF PRIMER (COLOR AS DIRECTED BY ARCHITECT) EXCEPT FOR AREAS WHICH WILL RECEIVE SPRAY-ON FIRE PROTECTION.
6. INSPECTION AND TESTING: THE CONTRACTOR SHALL BE ENGAGED TO PERFORM INDUSTRY STANDARD INSPECTIONS TO ENSURE CONFORMANCE WITH PLANS AND SPECIFICATIONS (IF PROVIDED). SUBMIT REPORTS TO ARCHITECT AND ENGINEER.

PRE ENGINEERED WOOD TRUSSES

1. ALL PREFABRICATED WOOD TRUSSES SHALL BE SECURELY FASTENED TO THEIR SUPPORTING WALLS OR BEAMS WITH HURRICANE CLIPS OR ANCHORS PER STRUCTURAL PLAN.
2. THE TRUSS MANUFACTURER SHALL BE DESIGNED IN ACCORDANCE WITH THE LATEST EDITION OF THE "NATIONAL DESIGN SPECIFICATION FOR STRESS-GRADE LUMBER AND ITS FASTENERS" AS RECOMMENDED BY THE NATIONAL FOREST PRODUCTS ASSOCIATION.
3. TRUSS MEMBERS AND CONNECTIONS SHALL BE PROPORTIONED (WITH A MAXIMUM ALLOWABLE STRESS INCREASE FOR LOAD DURATION OF 25%) TO WITHSTAND THE LIVE LOAD GIVEN IN THE NOTES AND TOTAL DEAD LOADS AS SPECIFIED BY THE TRUSS MANUFACTURER UNLESS NOTED ON THE PLANS.
4. BRACING FOR ALL ENGINEERED TRUSSES IS REQUIRED BY THE TRUSS MANUFACTURER UNLESS NOTED ON THE PLANS.
5. TRUSS ELEVATIONS AND SECTIONS ARE FOR GENERAL CONFIGURATION OF TRUSSES ONLY. WEB MEMBERS ARE NOT SHOWN, BUT SHALL BE DESIGNED BY THE TRUSS MANUFACTURER IN ACCORDANCE WITH THE FRAMING DESIGN LOADS:
6. THE TRUSS MANUFACTURER SHALL SUBMIT TRUSS PLANS TO THE TRUSS PLAN INSTITUTE (TPI) LATEST EDITION.
7. PRE-ENGINEERED WOOD TRUSSES SHALL BE DESIGNED BY THE MANUFACTURER IN ACCORDANCE WITH SPECIFIED LOADS AND GOVERNING CODES. SUBMITTALS SHALL INCLUDE TRUSS FRAMING PLANS AND DETAILS SHOWING MEMBER SIZES, BRACING, ANCHORAGE, CONNECTIONS, TRUSS BRACING AND END JOINT DETAILING. THE TRUSS MANUFACTURER SHALL SUBMIT THREE COPIES OF THE TRUSS MANUFACTURER'S SUBMITTALS TO BE SIGNED AND SEALED BY A FLORIDA REGISTERED STRUCTURAL ENGINEER. SUBMIT 3 COPIES FOR REVIEW AND APPROVAL PRIOR TO FABRICATION.
8. THE TRUSS MANUFACTURER SHALL DETERMINE ALL SPANS WORKING POINTS, BEARING POINTS, AND SIMILAR CONDITIONS. TRUSS SHOP DRAWINGS SHALL SHOW ALL TRUSSES, ALL BRACING MEMBERS, AND ALL TRUSS TO TRUSS HANGERS.

UPLIFT CONNECTORS

1. UPLIFT CONNECTORS SUCH AS HURRICANE CLIPS, TRUSS ANCHORS AND ANCHOR BOLTS ARE ONLY REQUIRED ON MEMBERS IN WALLS THAT ARE EXPOSED TO UPLIFT OR LATERAL FORCES. INTERIOR LOAD BEARING WALLS ARE NOT ALWAYS EXPOSED TO UPLIFT FORCES. THE MEMBERS OF THESE WALLS WOULD NOT NEED TO HAVE CONNECTORS APPLIED. PLEASE COORDINATE THE TRUSS ENGINEER FOR THE LOCATION OF THESE WALLS AND STRUCTURAL PLANS FOR MORE INFO.

FIELD REPAIR NOTES

1. MISS J "B" BOLTS FOR WOOD BEARING WALLS MAY BE SUBSTITUTED WITH 1/2" DIA. EPOXY ANCHORS WITH 7" EMBEDMENT. SIMPSON "SET" EPOXY ADHESIVE DURING FOLLOWING ALL MANUFACTURER'S RECOMMENDATIONS OR SIMPSON 1/2" TITEN HUB BOLTS WITH MINIMUM 7" EMBEDMENT. SEE PLAN FOR EMBEDMENT DEPTH AT FLOOR STEPS.
2. IF EOR HERT 1/2" DIA. EPOXY ANCHOR HOLE 6" DEEP AT THE LOCATION OF THE OMITTED REBAR AND INSTALL A 32" LONG #8 BAR INTO THE EPOXY FILLED HOLE. USE A TWO PART EMBEDMENT EPOXY (SIMPSON HIGH STRENGTH EPOXY-TIE ANCHORING ADHESIVE) MIXED PER THE MANUFACTURER'S INSTRUCTIONS. ASSURE THAT ALL DUST AND DEBRIS FROM DRILLING ARE REMOVED FROM THE HOLE BY BRUSHING AND USING COMPRESSED AIR PRIOR TO APPLYING THE EPOXY. ALLOW THE EPOXY TO CURE TO THE MANUFACTURER'S SPECIFICATIONS, THEN FILL THE CELL IN THE MORTAR JOINTS DURING BOND BEHIND THE REBAR.
3. FOR MORTAR JOINTS LESS THAN 1/4", PROVIDE (1) #8 VERT. IN CONC. FILLED CELL EACH SIDE OF THE JOINT (BAR DOES NOT HAVE TO BE CONT. TO FOOTING).
4. MISS LINTEL STRIPS FOR MASONRY CONSTRUCTION MAY BE SUBSTITUTED WITH (1) SIMPSON MSTM16 TWIST STRAP W/ (4) 3/4" X 2 1/4" TITENS TO MASONRY AND (7)-10d NAILS TO TRUSS FOR UPLIFTS LESS THAN 800 LBS (USE (2) MSTM16 FOR UPLIFTS LESS THAN 1800lb). IF CORNER STRAP IS MISSED, CONTACT THE EOR FOR SUBSTITUTION.
5. NO MORE THAN 10 STRAPS MAY BE SUBSTITUTED OR NO MORE THAN 3 IN A ROW WITHOUT APPROVAL FROM EOR. IF GIRDER TRUSS CONNECTIONS ARE MISSED, CONTACT THE EOR FOR SUBSTITUTION.
6. IF MISSED, MSTAM3B OR MSTAM4D STRAP IS MISSED FOR 2ND FLOOR JAMB STUD CONNECTION, CONTRACTOR MAY INSTALL SIMPSON HTTS W/ (2) 3/4" X 2 1/4" TITEN STRAPS TO ANCHOR BOLTS TO STUDS.
7. IF STRAPS ARE MISSED UNDER GIRDER JAMB STUD LOCATIONS.

WIND LOADING CRITERIA		
WIND SPEED (ULTIMATE)		130.0 MPH
WIND SPEED (ALLOWABLE)		101.0 MPH
EXPOSURE CATEGORY		C
BUILDING CATEGORY		V
BUILDING TYPE		ENCLOSED
ENCLOSURE CLASSIFICATION		+/- 0.18
INTERNAL PRESSURE COEFFICIENT		

NOTE: MEAN ROOF HEIGHT FOR TYPICAL SINGLE STORY HOME IS 15FT. AND FOR 2 STORY HOME IS 30FT

**ASCE 7-16 WALL DESIGN ALLOWABLE COMPONENTS
AND CLADDING WIND PRESSURES AND SUCTIONS
FOR MEAN ROOF HEIGHT ≤ 60 ft**

EFFECTIVE WIND AREA (SQ FEET)	WIND PRESSURE AND SUCTION (PSF) (+) VALUE DENOTES PRESSURE (-) VALUE DENOTES SUCTION	WIND PRESSURE AND SUCTION DIAGRAM
AREA	(A) (B) (C) (D) (E) (F) (G) (H)	DIAGRAM
10 - 19.99	(+) 25.5 (-) 26.6	
20 - 49.99	(+) 24.4 (-) 26.6	
50 - 99.99	(+) 22.8 (-) 23.8	
> 100	(+) 21.7 (-) 23.8	
GARAGE DOORS*	SOFFIT	
9'-0" x 7'-0"	16'-0" x 7'-0"	
(+) 22.5 (-) 25.5	(+) 21.7 (-) 24.1	(+) 25.5 (-) 33.6

GENERAL PRESSURE NOTES

- NOTE:
1. MULTIPLY THE ABOVE PRESSURES BY 1.67 TO GET ULTIMATE WIND PRESSURES.
- "g" = END ZONE IS ONLY WITHIN 4'-0" OF ALL EXTERIOR BUILDING CORNERS. * DESIGNATED PRESSURES CAN BE INTERPOLATED FOR OTHER DOOR SIZES, OTHERWISE USE LOAD ASSOCIATED WITH THE LOWER EFFECTIVE AREAS.
- DESIGNATED AREAS WHERE THE ULTIMATE WIND SPEED IS 140 MPH OR GREATER ARE TO BE CONSIDERED TO BE IN THE WIND-BORNE DEBRIS AREA. CONTRACTOR TO PROVIDED ADDITIONAL INFO AS REQUIRED FOR PERMITTING.

SHEET INDEX

S0	NOTES & SCHEDULES		
S1	FOUNDATION PLAN		
S2	ROOF FRAMING PLAN		
SN	NOTES & SCHEDULES		
D1	FOUNDATION DETAILS		
D2	FRAMING DETAILS		
D3	FRAMING DETAILS		
D4	FRAMING DETAILS		
D5	FRAMING DETAILS		



LOT 30
RESERVE @ JEWEL LAKE
436 SW JEWEL LAKE DR.
LAKE CITY, FL 32024


AN
NUMBER:
811607

MODEL: COVINGTON

DRAWING TITLE: NOTES & SCHEDULES

SHEET
NO:

S0

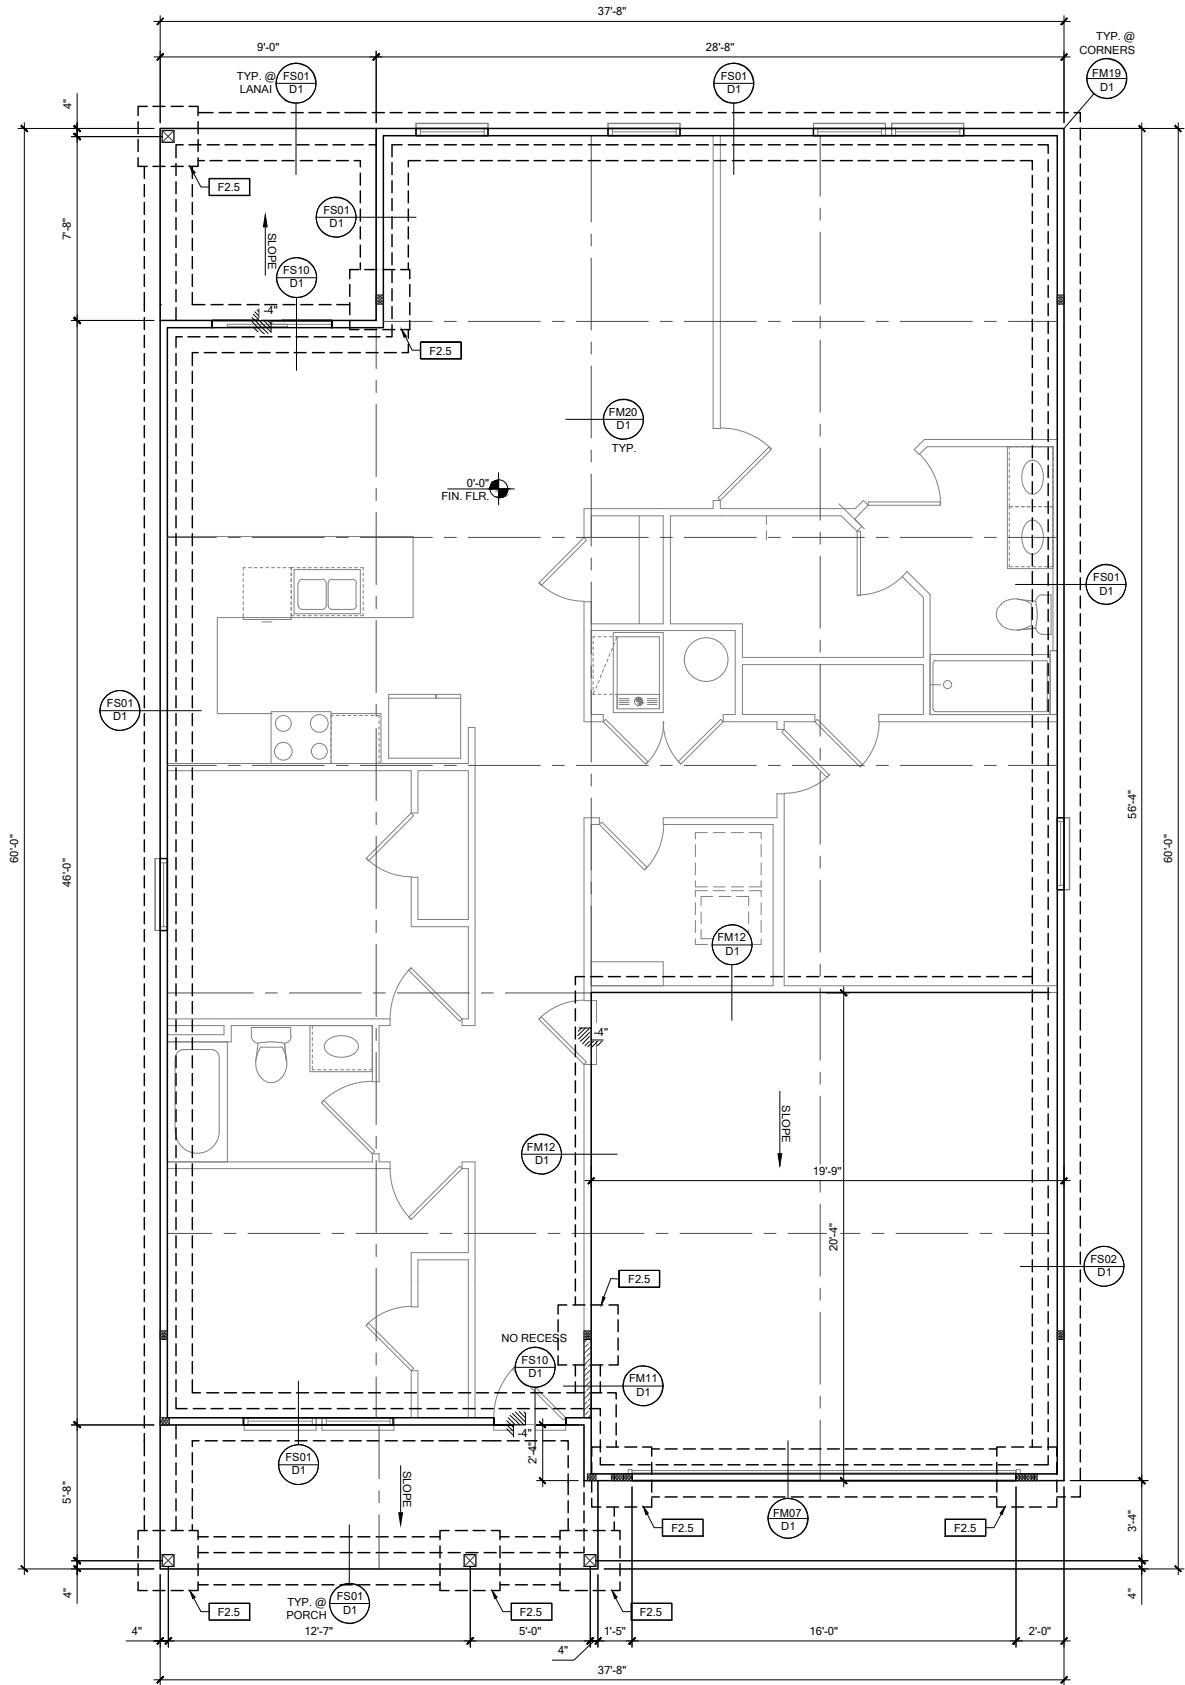

FOUNDATION PLAN B

SCALE: 1/4" = 1'-0" @ 22x34
SCALE: 1/8" = 1'-0" @ 11x17

FOUNDATION LEGEND	
SYMBOL	DESIGN DESCRIPTION
	INDICATES CONCRETE FOOTING w/ MINIMUM SOIL BEARING CAPACITY OF 2000 PSF. REINFORCE PER GENERAL FOUNDATIONS SCHEDULE ON SHEET SN FOR DESIGN SPECIFICATIONS.
	INDICATES CONSTRUCTION JOINT (IF SHOWN) SHALL BE 1/2" x 1" SAW CUTS FILLED WITH APPROVED SLAB JOINT MATERIAL COVERING A 12'x12' SQUARE MAXIMUM
	INDICATES STEP IN FOUNDATION, VERIFY PER ARCHITECTURAL PLANS CONSTRUCT PER PLAN SECTION CUT AND DETAIL SHEET D1
	4" 2500 PSI CONC. SLAB W/ REINF. PER S0 w/6 MIL VISQUEEN VAPOR BARRIER & TREATED FOR TERMITES. SEE FOUNDATION SCHEDULE ON SN
	INDICATES BUILT UP COLUMN, SEE FRAMING PLAN FOR SIZE, DETAIL WF37/SN FOR PLY ATTACHMENT, AND UPLIFT CONNECTION SCHEDULE ON SN FOR CONNECTION TO SLAB

- GENERAL NOTES:
1. TYPICAL CORNER FRAMING PER DETAIL FM19/D1
 2. SEE ARCHITECTURAL PLANS FOR ALL SLAB STEP DEPTHS IF SHOW SHOWN WITHIN THESE DOCUMENTS.

PLAN KEY NOTES

BUILDER NOTE:
ANY DISCREPANCY OR ERROR IN DIMENSIONS OR NOTES SHALL BE BROUGHT TO THE ATTENTION OF THE DESIGN PROFESSIONAL FOR CLARIFICATION PRIOR TO COMMENCEMENT OF CONSTRUCTION

WALL TYPE	
SYMBOL	DESIGN DESCRIPTION
	2x. INTERIOR BEARING SHEARWALL - SEE BEARING WALL SCHEDULE ON SHEET SN FOR REQUIREMENTS.
	INDICATES BEARING WALL SEE BEARING WOOD BEARING SCHEDULE ON SN
	2x WOOD FRAME EXTERIOR WALL

DATE: January 20, 2022
ISSUED CONTRACT & LOG OF REVISIONS

FDS Engineering & Associates
238 South Highway 100, Suite 200
Maitland, FL 32751
O: 321.972.0481 F: 407.880.2304
Certificate of Authorization No. 9161
C CARL A. BROWN, PE - FL #56126
C LUIS PABLO TORRES, PE - FL #87864
C SCOTT LEWOWSKI, PE - FL #78750

LOT 30
RESERVE @ JEWEL LAKE
436 SW JEWEL LAKE DR.
LAKE CITY, FL 32024


MODEL: COVINGTON

DRAWING TITLE: FOUNDATION PLAN A & B

PLAN NUMBER: 33811607

RELEASE DATE: 08.03.2020

SHEET NO: S1

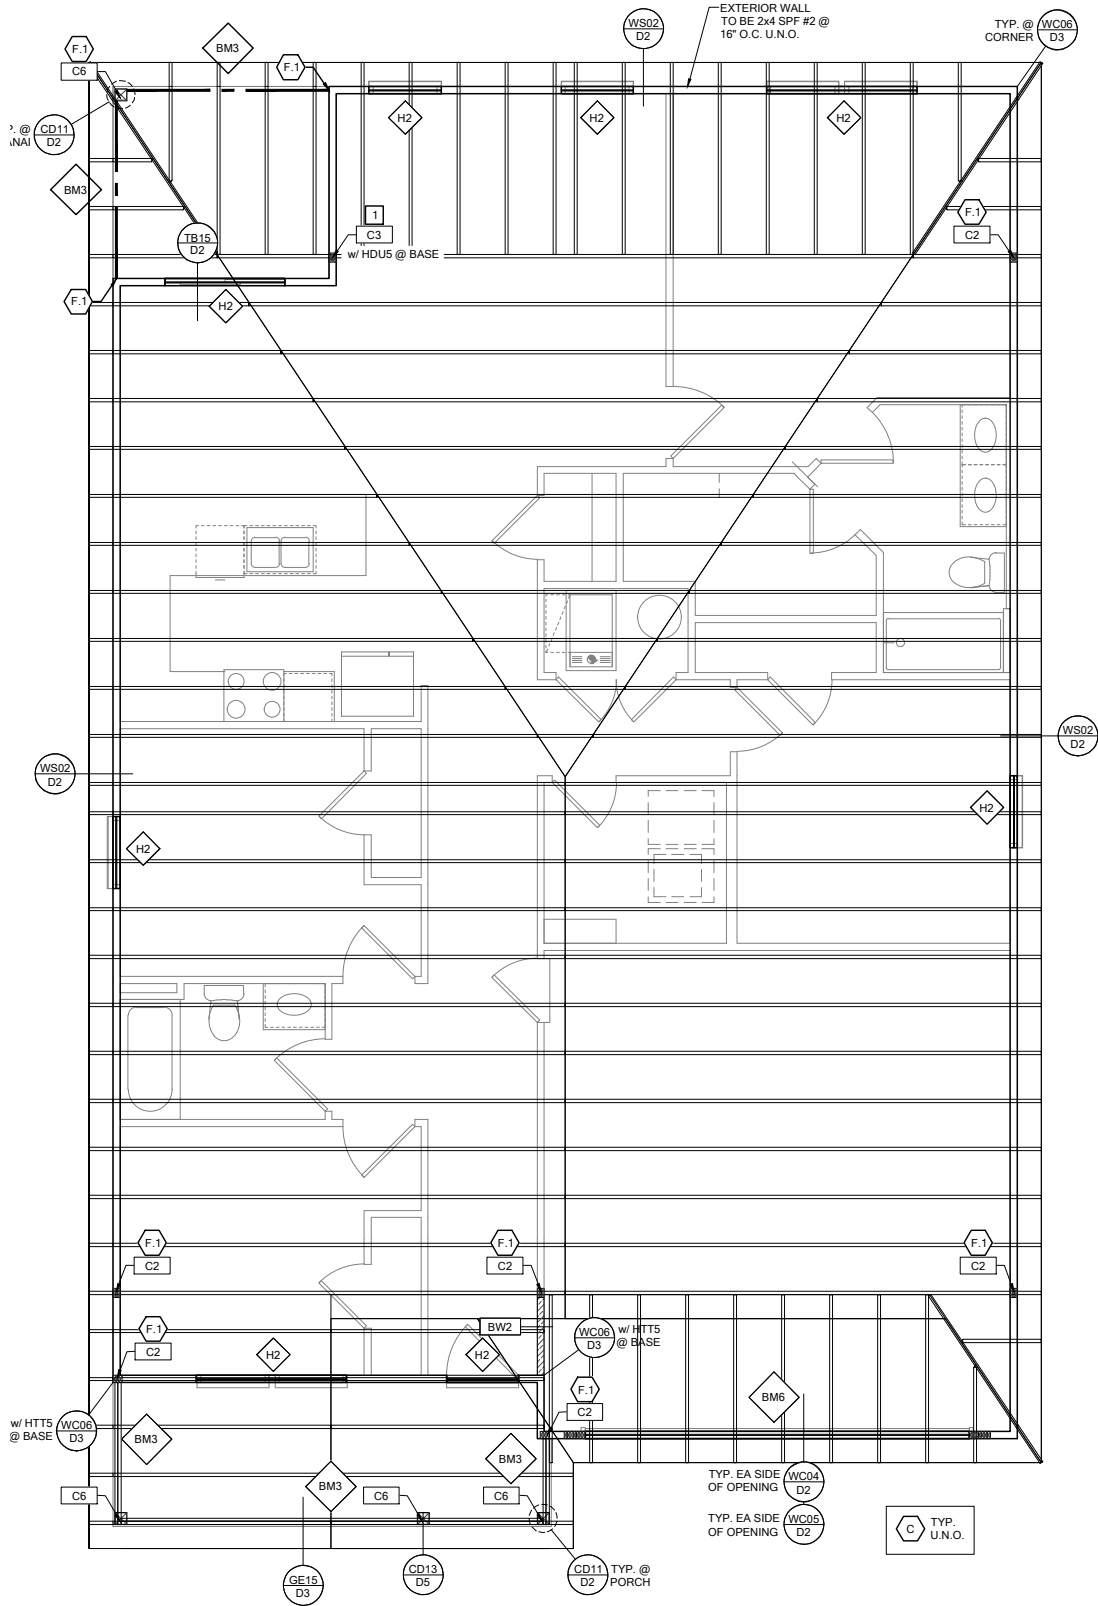

ROOF FRAMING PLAN B

SCALE: 1/4" = 1'-0" @ 22x34
SCALE: 1/8" = 1'-0" @ 11x17

RSH

ENGINEERED ROOF PER ASCE 7-16 ROOF DESIGN ALLOWABLE COMPONENTS AND CLADDING WIND PRESSURES AND SUCTIONS FOR MEAN ROOF HEIGHT ≤ 25 ft

WIND SPEED (ULTIMATE)

130 MPH

WIND SPEED (ALLOWABLE)

100.7 MPH

EXPOSURE CATEGORY

C

EFFECTIVE WIND AREA (SQ FEET)

10

WIND PRESSURE AND SUCTION (PSF)

(+) VALUE DENOTES PRESSURE
(-) VALUE DENOTES SUCTION

AREA	ROOF	1	2e	2n	2r	3	3e	3r
10	HIP	-33.0	-45.50		-45.50	-45.50		
	GABLE	-35.0	-35.0	-55.90	-55.90		-55.90	-65.20

ROOF NAILING SCHEDULE/ NAILING ZONES (SHINGLE AND TILE):

ZONE 1: ASTM F1667 RSRs-01 (8d) NAILS @ 6" O.C. ON EDGE AND 6" O.C IN FIELD
ZONE 2e, 2n, 2r: ASTM F1667 RSRs-01 (8d) NAILS @ 4" O.C. ON EDGE AND 4" O.C IN FIELD
ZONE 3, 3e, 3r: ASTM F1667 RSRs-01 (8d) NAILS @ 4" O.C. ON EDGE AND 4" O.C IN FIELD

ROOF SHEATHING:
SHINGLE: 3/8" EXP. 1 (2 3/4)" EXP. 1 (2 3/4)"
TILE: 1 1/2" EXP. 1 (2 3/4)"

NOTE:
1. PER CODE ASTM F1667 RSRs-01 REFERENCE TO 8d (2 3/4" x 0.113") NAILS
2. WHERE THE SHEATHING THICKNESS IS GREATER THAN 1 1/2", SHEATHING SHALL BE FASTENED WITH ASTM F1667 RSRs-03 10d (2 1/2" x 0.131") NAILS OR ASTM F1667 RSRs-04 (3" x .120") NAILS
3. GABLES- DROP GABLE END & (1) ADDITIONAL DROPPED TRUSS 2x4 #2 SYP OUTLOOKER RAFTER W/ BLOCKING @ 16" O.C. IF NO DROPPED GABLE END, ATTACH 2x4 #2 SYP BLOCKING @ 16" O.C FIRST 4 BAYS WITH (2) 12d NAILS EA. END. ATTACH ROOF SHEATHING TO RAFTERS W/ BLOCKING PER NAILING SCHEDULE.

HIP ROOF >20 TO 27 DEG. [4:12]-[6:12]

GABLE ROOF > 20 TO 27 DEG. [4:12]-[6:12]

SYMBOL	DESIGN DESCRIPTION
 2x	INDICATES BEARING WALL SEE BEARING WOOD BEARING SCHEDULE ON SN. SEE ARCHITECTURAL PLANS FOR WALL WIDTH, 2x4 MINIMUM U.O.N.
	INDICATES UPLIFT CONNECTION CONSTRUCTED PER DETAIL UPLIFT CONNECTOR SCHEDULE ON SHEET SN

FRAMING NOTES:

- SEE WIND SPEED CHART ON S0 FOR WINDOW PRESSURES
- AT SECOND FLOOR FOR TYPICAL CORNER FRAMING SEE DETAIL FB06/D4

GENERAL NOTES:

- THE FRAMING PLAN SHOWN INDICATES THE "TRUSS SYSTEM" AND IS THE RESPONSIBILITY OF THE TRUSS SYSTEM ENGINEER (DESIGN PROFESSIONAL OF RECORD). THE TRUSS DESIGN ENGINEER (DELEGATED ENGINEER) HAS FINAL, RESONSIBILITY FOR EACH INDIVIDUAL TRUSS AND TRUSS PROFILE, AND IS TO SUBMIT A FINAL SET OF TRUSS ENGINEERING SIGNED AND SEALED TRUSS DRAWINGS TO DESIGN PROFESSIONAL OF RECORD FOR REVIEW PRIOR TO FABRICATION
- ANY DISCREPANCY OR ERROR IN DIMENSIONS OR NOTES WITH IN THIS PLAN SHALL BE BROUGHT TO THE ATTENTION OF THE DESIGN PROFESSIONAL FOR CLARIFICATION PRIOR TO CONSTRUCTION.
- SEE SHEET SN FOR DESIGN SCHEDULES AND NOTES: FOUNDATION SCHEDULE / COLUMN SCHEDULE / BEARING WALL SCHEDULE / BEAM SCHEDULE / HEADER SCHEDULE / CONNECTION SCHEDULE / FLOOR AND ROOF NOTES.

PLAN KEY NOTES

- SIMPSON MGT w/ (22) 0.148 x 1 1/2" & (1) 3/8" ATR & SIMPSON HDU4-SDS 2.5 w/ (10) 1/4" x 2 1/2" SDS SCREWS

BUILDER NOTE:
IF THE TRUSS LAYOUT SHOWN DOES NOT MATCH THE TRUSS MANUFACTURERS LAYOUT

-----STOP-----

AND CALL THE ENGINEER OF RECORD PRIOR TO PLACEMENT OF ANY TRUSSES.

WALL TYPE

SYMBOL	DESIGN DESCRIPTION
	2x INTERIOR BEARING SHEARWALL - SEE BEARING WALL SCHEDULE ON SHEET SN FOR REQUIREMENTS.
	INDICATES BEARING WALL SEE BEARING WOOD BEARING SCHEDULE ON SN
	2x WOOD FRAME EXTERIOR WALL

DATE: January 20, 2022
DRAWING CONTRACTED FOR INFORMATION

LOT 30
RESERVE @ JEWEL LAKE
436 SW JEWEL LAKE DR.
LAKE CITY, FL 32024

MODEL: COVINGTON
DRAWING TITLE: ROOF FRAMING PLAN A & B

PLAN NUMBER: 33811607
RELEASE DATE: 08.03.2020

SHEET NO: S2

FOUNDATION SCHEDULE				
MARK	SIZE	DEPTH	REINFORCING	
F1.5	1'-6" x 1'-6"	1'-0"	(2) #5 E.W. BOT.	
F2.0	2'-0" x 2'-0"	1'-0"	(2) #5 E.W. BOT.	
F2.5	2'-6" x 2'-6"	1'-0"	(2) #5 E.W. BOT.	
F3.0	3'-0" x 3'-0"	1'-0"	(4) #5 E.W. BOT.	
F3.5	3'-6" x 3'-6"	1'-0"	(4) #5 E.W. BOT.	
F4.0	4'-0" x 4'-0"	1'-0"	(5) #5 E.W. BOT.	
F4.5	4'-6" x 4'-6"	1'-4"	(5) #5 E.W. BOT.	
F5.0	5'-0" x 5'-0"	1'-4"	(6) #5 E.W. BOT.	
F6.0	6'-0" x 6'-0"	1'-5"	(8) #5 E.W. BOT.	

FOUNDATION DEPTH NOTE:

- INTERIOR PAD DEPTHS AS LISTED IN THE SCHEDULE ARE THE TOTAL DEPTH AND MEASURED FROM THE TOP OF THE SLAB.
- EXTERIOR PAD DEPTHS AS LISTED IN THE SCHEDULE ARE TOTAL DEPTH WITH THE BOTTOM OF THE FOOTING TO MATCH THE BOTTOM OF THE CONTINUOUS MONOLITHIC POUR WHICH RUNS THROUGH IT.


GENERAL FOUNDATION NOTES:

- PROVIDE MIN. 6 MIL APPROVED VAPOR BARRIER. ALL JOINTS TO BE LAPPED MIN. 6" AND SEALED.
- 4" 2500 PSI CONC. SLAB WITH W1.4W1.4 OVER 6 MIL VISOQUEEN VAPOR BARRIER & TREATED FOR TERMITES.
- GO BUILDER: SEE ARCH PLANS FOR ROUGH OPENING LOCATIONS AND ADDITIONAL INFORMATION REQ'D FOR DOOR/WINDOW INSTALLATION ALONG W/ DIMENSIONS NOT SHOWN ON FOUNDATION CONSULT W/ MANUFACTURER SPECIFICATIONS PRIOR TO POURING OR RECESSING DOOR SILLS OR SLIDING GLASS DOOR SILLS.
- NO WOOD STAKES PERMITTED IN FOUNDATION.
- PENDING SITE CONDITIONS, FOUNDATION MAY HAVE TO BE STEPPED DOWN. SEE FPM101 FOR ADDITIONAL INFORMATION. G.C. TO DETERMINE STEP LOCATIONS, IF REQUIRED.
- STEEL BENDS AND LAP SPLICE SEE FPM101 AND FPM101.
- ALL EQUIPMENT AND APPLIANCES HAVING AN IGNITION SOURCE SHALL BE ELEVATED A MIN OF 18" CONTRACTOR TO PROVIDE SUCH PLATFORM W/ EITHER MASONRY OR WOOD CONSTRUCTION.
- ASSUMED ALLOWABLE SOIL BEARING PRESSURE AFTER COMPACTION: 2000 PSF (SEE SOILS REPORT AND SPECIFICATIONS FOR COMPACTION REQUIREMENTS). IF SOIL CONDITIONS ON THE PROJECT DO NOT MEET OR EXCEED THE CAPACITY, THE GENERAL CONTRACTOR SHALL CONTACT THE ENGINEER PRIOR TO FOUNDATION POUR FOR VERIFICATION OF FOUNDATION DESIGN. SOIL TO BE FREE OF ORGANIC MATERIAL AND COHESIVE SOILS, COMPACTION IN 12" LIFTS TO AT LEAST 96% OF MAX. DRY DENSITY AS DETERMINED BY ASTM D 1557 (MODIFIED PROCTOR).
- R403.1.4 MINIMUM DEPTH: EXTERIOR FOOTINGS SHALL BE PLACED NOT LESS THAN 12 INCHES (305mm) BELOW THE FINISHED GRADE OF GROUND SURFACE.


COLUMN SCHEDULE				
MARK	COLUMN SIZE	FIRST FLOOR BASE CONNECTIONS, SEE PLAN FOR SECOND FLOOR CONNECTIONS	UPLIFT (lb)	
C1	(3) 2x #2 SPF	(4) 12d TOENAILS	NO UPLIFT	
C2	(3) 2x #2 SPF	DTT22 w/ 1/2" ATR & (8) 1/2" x 1 1/2" SDS SCREWS	1835	
C3	(3) 2x #1 SYP	(4) 12d TOENAILS	NO UPLIFT	
C4	(3) 2x #1 SYP	DTT22 w/ 1/2" ATR & (8) 1/2" x 1 1/2" SDS SCREWS	1835	
C5	4x4 P.T.#2 SYP POST	ABU44 w/ 1/2" ATR & (12) 16d NAILS FIRST/SECOND FLOOR CONN.	G = 6665 U = 1782	
C6	6x6 P.T.#2 SYP POST	ABU66 w/ 1/2" ATR & (12) 16d NAILS FIRST/SECOND FLOOR CONN.	G = 12000 U = 2070	
C7	8x8 P.T.#2 SYP POST	ABU88 w/ (2) 1/2" ATR & (18) 16d FIRST/SECOND FLOOR CONN.	G = 24335 U = 2088	
C8	3 1/2" x 3 1/2" P.L. 1.8E Fb=2400 PSI (WOLMANIZED IF EXT.)	HDU5-SDS2.5 w/ 1/2" ATR AND (14) 1/2"x2 1/2" SDS WOOD SCREWS	5080	
C9	3 1/2" x 5.25" P.L. 1.8E Fb=2400 PSI (WOLMANIZED IF EXT.)	HDU5-SDS2.5 w/ 1/2" ATR AND (14) 1/2"x2 1/2" SDS WOOD SCREWS	5080	
C10	3 1/2" x 7" P.L. 1.8E Fb=2400 PSI (WOLMANIZED IF EXT.)	HDU8-SDS2.5 w/ 1/2" ATR AND (20) 1/2"x2 1/2" SDS WOOD SCREWS	6372	
C11	5.25" x 5.25" P.L. 1.8E Fb=2400 PSI (WOLMANIZED IF EXT.)	HDU8-SDS2.5 w/ 1/2" ATR AND (20) 1/2"x2 1/2" SDS WOOD SCREWS	7082	
C12	5.25" x 5.25" P.L. 1.8E Fb=2400 PSI (WOLMANIZED IF EXT.)	HDU8-SDS2.5 w/ 1/2" ATR AND (20) 1/2"x2 1/2" SDS WOOD SCREWS	7082	
C13	5.25" x 7" P.L. 1.8E Fb=2400 PSI (WOLMANIZED IF EXT.)	HDU8-SDS2.5 w/ 1/2" ATR AND (20) 1/2"x2 1/2" SDS WOOD SCREWS	7082	

GENERAL COLUMN NOTES:

- ALL STRUCTURAL LUMBER TO BE SYP#2 OR SPF#2 UNO ON PLAN.
- MINIMUM BOLT EMBEDMENT: 5" EMBEDMENT FOR 1/2" ATR. 6" EMBEDMENT FOR 5/8" ATR. 8" EMBEDMENT FOR 7/8" ATR.
- P.L. COL. TO BRG DIRECTLY ON FOUNDATION. CUT BASE PLATE AS REQ'D. G.C. TO PROVIDE MOISTURE BARRIER.
- IF COL. IS CALLED OUT ON 2ND FLOOR, THE BASE CONNECTION IS NOT REQ'D. SEE PLANS FOR BASE CONNECTION.
- VALUES HAVE BEEN REDUCED FOR NARROW FACE APPLICATION. CONNECTIONS SHALL BE INSTALLED ON NARROW OR WIDE FACE PER SIMPSON TC-SCLCLM

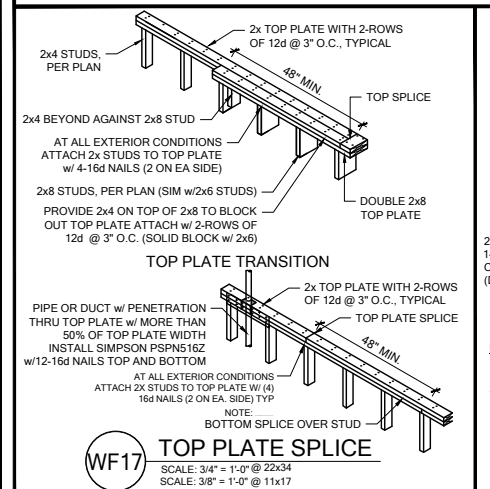


WOOD BEARING WALL SCHEDULE				
MARK	STUD SPACING	CONNECTION & FASTENERS	LUMBER SPECIES	UPLIFT CAP. (lb)
BW1	16"	(2) 16d TOENAILS OR (2) 12d END OR BOX NAILS	#2 SPF	NO UPLIFT
BW2	16"	SP2 w/ (6) 10d NAILS	#2 SPF	402
BW3	16"	(2) SP2 w/ (6) 10d NAILS	#2 SPF	804
BW4	16"	(2) 16d TOENAILS OR (2) 12d END OR BOX NAILS	#2 SYP	NO UPLIFT
BW5	16"	SP2 w/ (6) 10d NAILS	#2 SYP	439
BW6	16"	(2) SP2 w/ (6) 10d NAILS	#2 SYP	878
BW7	12"	(2) 16d TOENAILS OR (2) 12d END OR BOX NAILS	#2 SPF	NO UPLIFT
BW8	12"	SP2 w/ (6) 10d NAILS	#2 SPF	535
BW9	12"	(2) SP2 w/ (6) 10d NAILS	#2 SPF	1070
BW10	12"	(2) 16d TOENAILS OR (2) 12d END OR BOX NAILS	#2 SYP	NO UPLIFT
BW11	12"	SP2 w/ (6) 10d NAILS	#2 SYP	585
BW12	12"	(2) SP2 w/ (6) 10d NAILS	#2 SYP	1170

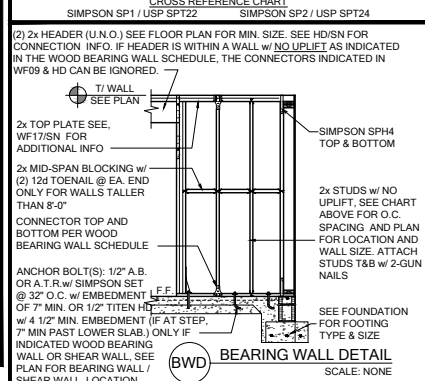


GENERAL BEARING WALL NOTES:

- ALL STRUCTURAL LUMBER DESIGNATED AS SYP SHALL BE SYP #2 AND ALL STRUCTURAL LUMBER DESIGNATED AS SPF SHALL BE SPF #2 UNO.
- SEE FLOOR PLAN FOR WALL SIZE. ASSUME 2x4 STUDS USED UNO.
- CONNECTIONS TO BE INSTALLED TO EACH STUD AS INDICATED.
- CONTACT E.O.R. IF SP4's, SP6's OR SP8's CONNECTORS ARE SUBSTITUTED, TO VERIFY THEY MEET THE STRUCTURAL REQUIREMENTS.
- IF "BW" IS INDICATED ON SECOND FLOOR BASE CONNECTION TO BE IGNORED. SEE WF06 AND FB06 OR INDICATED DETAIL FOR PROPER CONNECTIONS FOR 2ND FLOOR TO FIRST FLOOR CONNECTIONS. (NOTE: THIS IS FOR 2 STORY PROJECTS ONLY).
- IF "SW" IS INDICATED ON PLAN THE WALL IS CONSIDERED A SHEAR WALL AND REQUIRES MIN. 7/16" OSB / PLYWOOD w/ 8d NAILS @ 4" O.C. IN FIELD AND EDGE TO ONE SIDE OF WALL. UNO ON PLANS.
- ALL 2x EXTERIOR WALLS W/ SHEATHING ATTACHED PER NAILING SCHEDULE TB13/SN ACTS AS SHEAR WALLS. SEE PLAN AND WALL SECTIONS FOR STUD SPACING AND GRADE.
- ALL TOP PLATES AND SILL PLATES SHALL BE THE SAME SPECIES AS THE WOOD STUDS.
- IF THE BEARING WALL IS INDICATED WITH THE BW1, BW4, BW7, BW10, THESE WALLS ARE ONLY SUPPORTING THE FLOOR LOAD AND DO NOT HAVE UPLIFT. THE STUDS ARE TOE NAIL TO THE 2x PLATE CAN BE ATTACHED WITH HARD CASED NAILS (GUN NAILS) AND WILL NOT REQUIRE THE ANCHOR BOLT ATTACHMENT INDICATED IN THE BEARING WALL SCHEDULE.

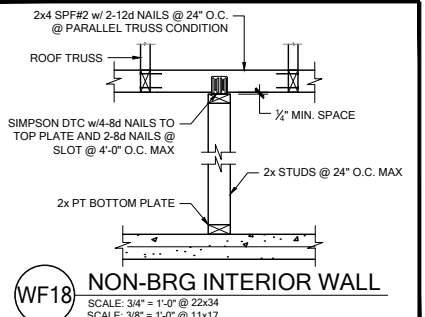

HEADER SCHEDULE				
MARK	HEADER SIZE	HEADER NOTES		
H1	(2) 2x6 #2 SYP w/ 7/16" FLUTCH PLATE	1. VERIFY W/ PLAN CORRECT LENGTH OF HEADER REQUIRED. IF HEADER IS ON THE 1ST FLOOR SEE PLAN FOR BEARING WALL TYPE AND FOLLOW INSTRUCTIONS WITHIN BEARING WALL SCHEDULE FOR REQUIRED CORRECTIONS U.N.O. ON PLAN.		
H2	(2) 2x10 #2 SYP w/ 7/16" FLUTCH PLATE	3. IF HEADER IS ON THE 2ND FLOOR SEE PLAN FOR INDICATED HEADER CONNECTION FOR REQUIRED CONNECTIONS.		
H3	(2) 2x12 #2 SYP w/ 7/16" FLUTCH PLATE	4. ALL HEADER JACK AND KING STUDS SHALL BE FASTENED TO EACH PER DETAIL WF37/SN.		
H4	(2) 1 3/4" x 1 1/4" LVL 2.0E Fb=2600	5. FASTEN ALL MULTI-PLY HEADERS TOGETHER W/ (2) ROWS 12d COMMON NAILS AT 12" O.C. OR (3) ROWS IF 2x10 OR LARGER TYP. EACH SIDE OR (2) ROWS 1 1/4" x 3 1/2" SDS WOOD SCREWS @ 16" O.C. TYP. EACH SIDE.		
H5	(2) 1 3/4" x 1 1/4" LVL 2.0E Fb=2600	6. FASTEN ALL HEADERS TO KING STUDS W/ (3) 10d TOENAILS PER SIDE.		
H6	(2) 1 3/4" x 1 1/4" LVL 2.0E Fb=2600	7. IF HEADER IS NOT SPECIFIED CONTACT E.O.R.		


HEADER SUPPORT - NUMBER OF JACKS & STUDS REQUIRED AT OPENINGS				
OPENING SIZE	2x4 WALL	2x6 OR 2x8 WALL		
1'-0" - 3'-11"	(1)	(1)		
4'-0" - 8'-11"	(2)	(3)		
10'-0" - 16'-0"	(3)	(4)		

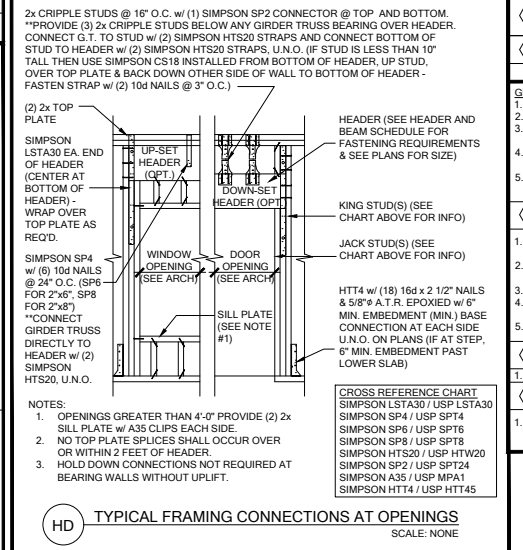

BEAM SCHEDULE				
MARK	BEAM SIZE	FASTENING SCHEDULE		
BM1	(2) 2x8 SYP #2 w/ 7/16" OSB FLUTCH PLATE	(2) ROWS OF 12d @ 12" O.C. TYP. EACH SIDE	U.N.O. ON FRAMING PLAN	
BM2	(2) 2x10 SYP #2 w/ 7/16" OSB FLUTCH PLATE	(2) ROWS OF 12d @ 12" O.C. TYP. EACH SIDE	U.N.O. ON FRAMING PLAN	
BM3	(2) 2x12 SYP #2 w/ 7/16" OSB FLUTCH PLATE	(2) ROWS OF 12d @ 12" O.C. TYP. EACH SIDE	U.N.O. ON FRAMING PLAN	
BM4	(2) 1 3/4"x11 1/4" LVL 2.0E Fb=2600	(2) ROWS 1/4" x 3 1/2" SDS WOOD SCREWS @ 16" O.C. TYP. EACH SIDE	U.N.O. ON FRAMING PLAN	
BM5	(2) 1 3/4"x11 7/8" LVL 2.0E Fb=2600	(2) ROWS 1/4" x 3 1/2" SDS WOOD SCREWS @ 16" O.C. TYP. EACH SIDE	U.N.O. ON FRAMING PLAN	
BM6	(2) 1 3/4"x16" LVL 2.0E Fb=2600	(2) ROWS OF 12d NAILS @ 12" O.C. TYP. EACH SIDE	U.N.O. ON FRAMING PLAN	
BM7	(3) 2x10 SYP #2 w/ (2) 7/16" OSB FLUTCH PLATES	(2) ROWS OF 12d NAILS @ 12" O.C. TYP. EACH SIDE	U.N.O. ON FRAMING PLAN	
BM8	(2) 1 3/4"x9 1/4" LVL 2.0E Fb=2600	(2) ROWS OF 12d NAILS @ 12" O.C. TYP. EACH SIDE	U.N.O. ON FRAMING PLAN	
BM10			U.N.O. ON FRAMING PLAN	

GENERAL BEAM NOTES:

- VERIFY WITH PLAN CORRECT LENGTH OF BEAMS REQUIRED (MIN 4" BEARING EACH END).
- SEE PLAN FOR TOP OR BOTTOM OF BEAM INDICATIONS.
- BEAMS ARE NOT TO BE DRILLED OR NOTCHED IN ANY WAY WITHOUT WRITTEN APPROVAL FROM THE E.O.R.

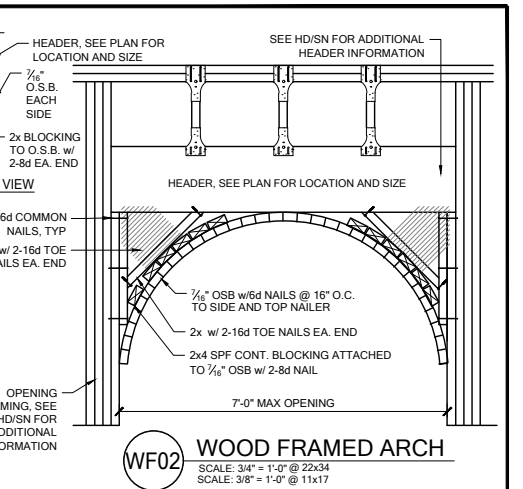

SIMPSON - CONNECTOR SCHEDULE				
MARK	TYPE	CONNECTOR & FASTENERS	SPF	SYP
B	FRAME TO FRAME	H2.5a w/ (10) 8d NAILS	535	565
C	FRAME TO FRAME	H10a w/ (18) 10d x 1 1/2" AT 2 PLY TRUSSES	1015	1040
D	FRAME TO FRAME	MTS12 w/ (14) 10d x 1 1/2" AT EXTERIOR LOCATION INCLUDE (3) 12d TOENAILS	850	990
E	FRAME TO FRAME	HTS20 w/ (24) 10d x 1 1/2" AT EXTERIOR LOCATION INCLUDE (3) 12d TOENAILS	1125	1310
F	FRAME TO FRAME	HTS20 w/ (24) 10d x 1 1/2" AT EXTERIOR LOCATION INCLUDE (3) 12d TOENAILS	2250	2620
G	FRAME TO MASONRY / FRAME	(2) LGT2 w/ (32) 16d SINKERS & (14) 1/4" x 2 1/4" TITEN (2 PLY TRUSSES) OR (28) 16d SINKERS FOR FRAME (EA)	3500-M 3240-F	4060-M 3770-F
H	FRAME TO MASONRY / FRAME	(2) LGT3 w/ (24) 1/4" x 3" SDS SCREWS & (8) 3/8" x 5" TITEN (2 PLY TRUSSES) OR (52) 16d SINKERS FOR FRAME (EA)	4730-M 5010-F	6570-M 6960-F
I	BEAM TO BEAM	HU410 OPT HUC410 w/ (18) 16d & (10) 10d NAILS	GP2680	U11895
J	BEAM TO MASONRY / FRAME	HU46 OPT HUC46 w/ (6) 10d NAILS & (12) 1/4" x 2 3/4" TITEN (TO MAS.) OR (12) 16d & (6) 10d (FOR FRAME)	GH1785	GK3000
K	FRAME TO FRAME	H105 w/ (24) 10d x 1 1/2" NAILS	U1135 SYP-F	U1135 SYP-M
L	FRAME TO FRAME	VGT w/ (16) 1/4"x3" SDS WOOD SCREWS & (10) 1/4"x2 1/2" SDS WOOD SCREWS & (1) 5/8" A.T.R.	3285	4565
M	FRAME TO FRAME	(2) HTTS w/ (52) 16d x 1/2" NAILS & (2) 5/8" A.T.R. (SEE NOTE #4)	8750	10180

GENERAL CONNECTOR NOTES:

- CONNECT ALL FLOOR TRUSSES TO INTERIOR BEARING WOOD WALLS / BEAMS w/ (2) 12d TOENAILS.
- ALL TRUSS TO TRUSS CONNECTIONS ARE PROVIDED BY TRUSS MANUFACTURER. U.N.O. ON PLAN.
- G.C. MAY USE EITHER SIMPSON OR USP CONNECTIONS. SEE FRAMING PLAN FOR CONNECTOR CALL OUT.
- FOR SINGLE PLY TRUSSES, SCAB ON FULL HEIGHT SYP #1 2"x4" TO TRUSS VERTICAL WEB w/ (2) ROWS OF 10d NAILS @ 3" O.C. STAGGERED.
- MINIMUM A.T.R. EMBEDMENT: 5" EMBEDMENT FOR 1/2" A.T.R. 6" EMBEDMENT FOR 5/8" A.T.R. 8" EMBEDMENT FOR 7/8" A.T.R. (IF AT STEP, DEPTH IS FROM LOWER SLAB).

(A) MINIMAL CONNECTOR UNO ON FRAMING PLAN

(B) MINIMAL CONNECTOR UNO ON FRAMING PLAN

(C) MINIMAL CONNECTOR UNO ON FRAMING PLAN

(D) MINIMAL CONNECTOR UNO ON FRAMING PLAN

(E) MINIMAL CONNECTOR UNO ON FRAMING PLAN

(F) MINIMAL CONNECTOR UNO ON FRAMING PLAN

(G) MINIMAL CONNECTOR UNO ON FRAMING PLAN

(H) MINIMAL CONNECTOR UNO ON FRAMING PLAN

(I) MINIMAL CONNECTOR UNO ON FRAMING PLAN

(J) MINIMAL CONNECTOR UNO ON FRAMING PLAN

(K) MINIMAL CONNECTOR UNO ON FRAMING PLAN

(L) MINIMAL CONNECTOR UNO ON FRAMING PLAN

(M) MINIMAL CONNECTOR UNO ON FRAMING PLAN

(N) MINIMAL CONNECTOR UNO ON FRAMING PLAN

(O) MINIMAL CONNECTOR UNO ON FRAMING PLAN

(P) MINIMAL CONNECTOR UNO ON FRAMING PLAN

(Q) MINIMAL CONNECTOR UNO ON FRAMING PLAN

(R) MINIMAL CONNECTOR UNO ON FRAMING PLAN

(S) MINIMAL CONNECTOR UNO ON FRAMING PLAN

(T) MINIMAL CONNECTOR UNO ON FRAMING PLAN


(U) MINIMAL CONNECTOR UNO ON FRAMING PLAN

(V) MINIMAL CONNECTOR UNO ON FRAMING PLAN


(W) MINIMAL CONNECTOR UNO ON FRAMING PLAN

(X) MINIMAL CONNECTOR UNO ON FRAMING PLAN

(Y) MINIMAL CONNECTOR UNO ON FRAMING PLAN

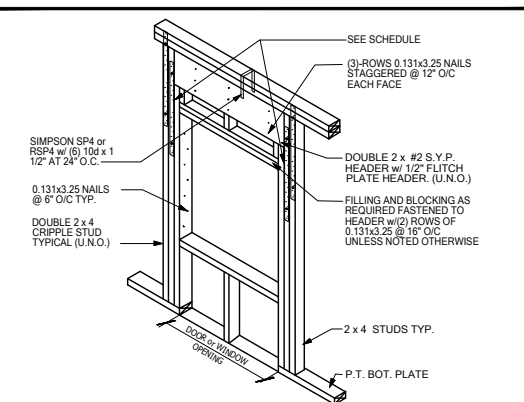

WALL HEADER DETAIL
SCALE: N.T.S.

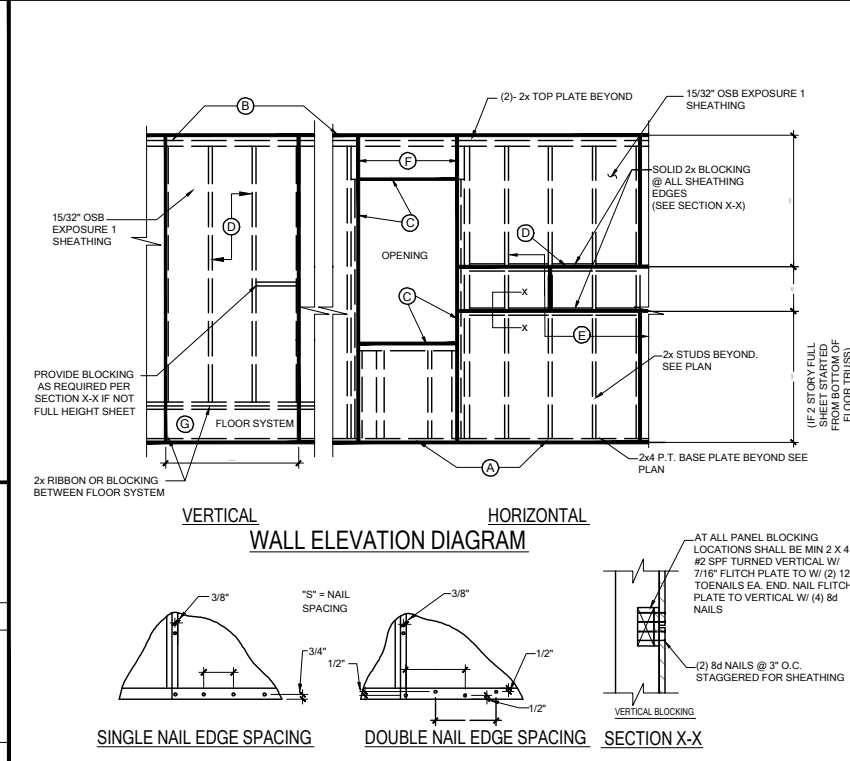

VERTICAL WALL ELEVATION DIAGRAM

(A) NAIL AT BASE 2 ROWS @ 4" O.C. w/ 8d COMMON NAIL.

(B) NAIL AT TOP PLATE TWO ROWS @ 4" O.C. w/ 8d COMMON NAIL.

(C) NAIL OPENING PERIMETER w/ (2) ROWS @ 4" O.C. w/ 8d COMMON NAIL.


(D) NAIL INTERIOR AT 6" O.C. w/ 8d COMMON NAIL.

(E) STAGGER ALL VERTICAL JOINTS & NAIL @ 4" O.C. w/ 8d COMMON NAIL.


(F) PLYWOOD SPLICES @ HEADER - NAIL SHEATHING TO HEADER w/ 8d COMMON NAILS @ 4" O.C. (2) ROWS @ TOP & BOT.

(G) (2) 8d NAILS @ 3" O.C. TO EACH TRUSS END OR VERTICAL MEMBER IF GABLE END.

NOTE: 8d NAILS FOR WALL SHEATHING MUST BE MIN. 1 1/2" x 2 1/2". DO NOT OVERDRIVE NAILS: FASTENERS SHALL NOT PENETRATE SURFACE MORE THAN 1/8".

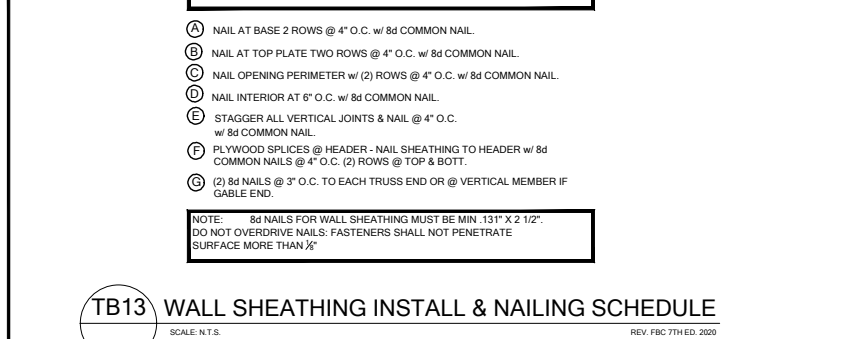

TB13 WALL SHEATHING INSTALL & NAILING SCHEDULE
SCALE: N.T.S.

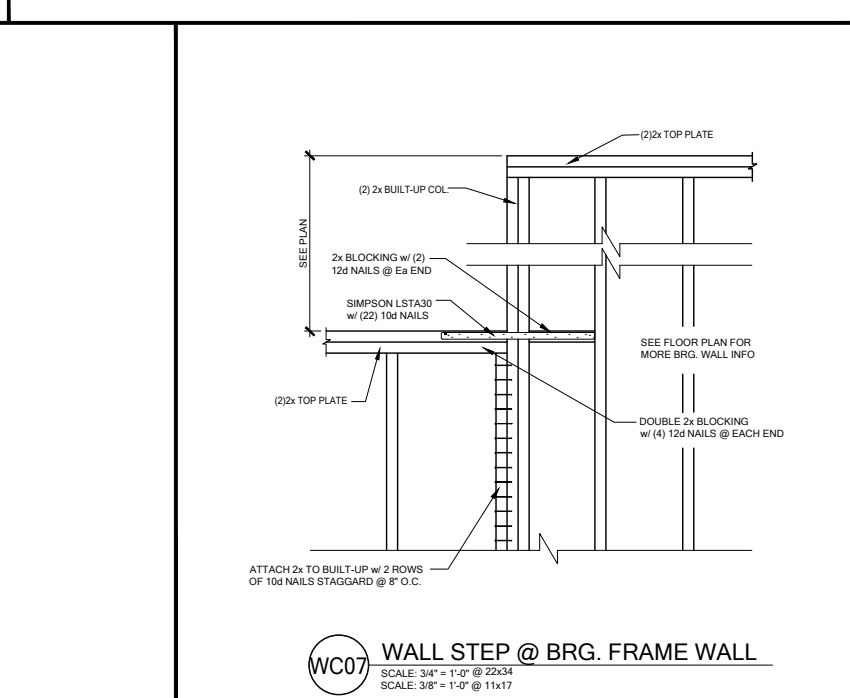

WALL STEP @ BRG. FRAME WALL
SCALE: 3/4" = 1'-0" @ 22x34
SCALE: 3/8" = 1'-0" @ 11x17

DATE: January 20, 2022
REVISION: 01/20/2022


238 South Main Street
Maitland, FL 32751
O: 321-972-0491 F: 321-972-0491
Certificate of Authorization No. 9161
□ CARLA A. BROWN, PE - FL #58126
□ LUIS PABLO TORRES, PE - FL #67684
□ SCOTT LEWIS, PE - FL #79794

LOT 30
RESERVE @ JEWEL LAKE
436 SW JEWEL LAKE DR.
LAKE CITY, FL 32024


PLAN NUMBER: 33811607
RELEASE DATE: 08.03.2020

MODEL: COVINGTON
DRAWING TITLE: NOTES & SCHEDULES


SHEET NO: SN

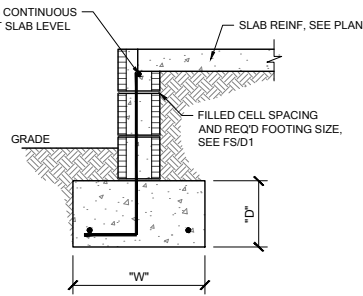


FS01 SINGLE OR 2-STORY FOOTING
SCALE: 3/4" = 1'-0" @ 22x34
SCALE: 3/8" = 1'-0" @ 11x17

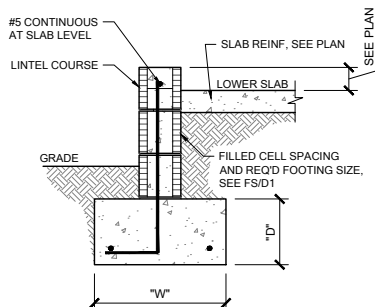


FS02 EXTERIOR BEARING @ GARAGE
SCALE: 3/4" = 1'-0" @ 22x34
SCALE: 3/8" = 1'-0" @ 11x17

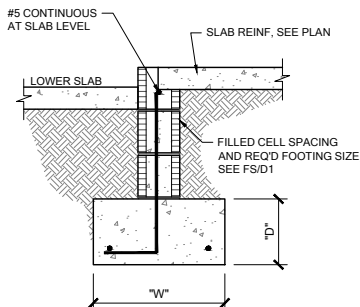


FS03 EXTERIOR BEARING
SCALE: 3/4" = 1'-0" @ 22x34
SCALE: 3/8" = 1'-0" @ 11x17

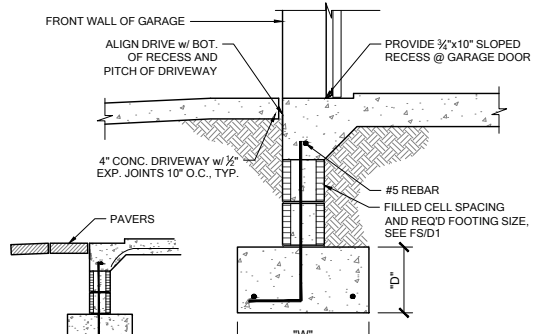


FS07 FOOTING @ GARAGE DOOR
SCALE: 3/4" = 1'-0" @ 22x34
SCALE: 3/8" = 1'-0" @ 11x17

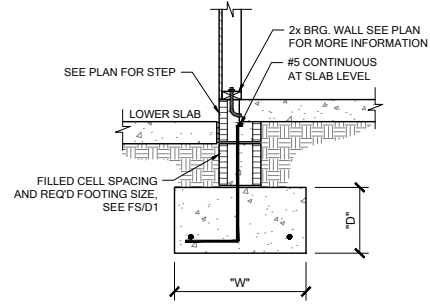


FS08 INT. BRG. @ STEP DOWN
SCALE: 3/4" = 1'-0" @ 22x34
SCALE: 3/8" = 1'-0" @ 11x17

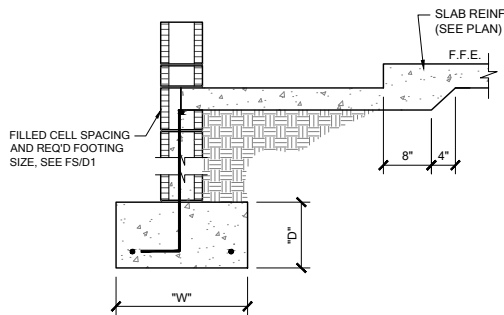


FS09 SECTION @ SHOWER
SCALE: 3/4" = 1'-0" @ 22x34
SCALE: 3/8" = 1'-0" @ 11x17

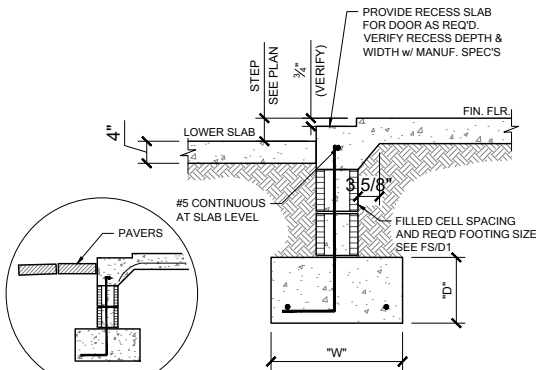


FS10 EXTERIOR BEARING @ RECESS
SCALE: 3/4" = 1'-0" @ 22x34
SCALE: 3/8" = 1'-0" @ 11x17

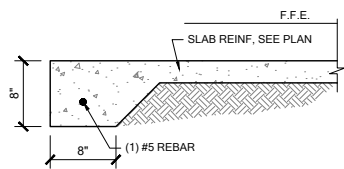


FM03 THICKENED EDGE
SCALE: 3/4" = 1'-0" @ 22x34
SCALE: 3/8" = 1'-0" @ 11x17

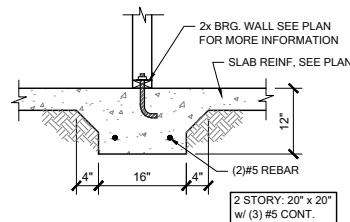


FM10 INT. BRG WALL
SCALE: 3/4" = 1'-0" @ 22x34
SCALE: 3/8" = 1'-0" @ 11x17

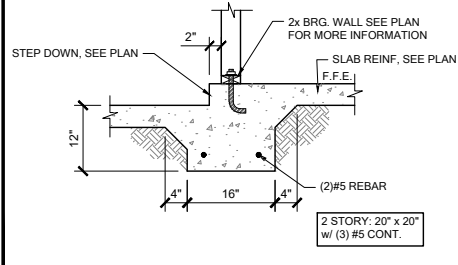


FM11 STEP DOWN BEARING
SCALE: 3/4" = 1'-0" @ 22x34
SCALE: 3/8" = 1'-0" @ 11x17

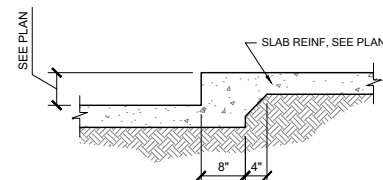


FM12 STEP DOWN @ NON BRG.
SCALE: 3/4" = 1'-0" @ 22x34
SCALE: 3/8" = 1'-0" @ 11x17

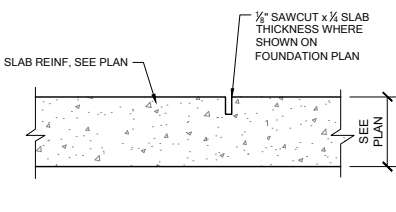


FM20 CONTROL JOINT
SCALE: 3/4" = 1'-0" @ 22x34
SCALE: 3/8" = 1'-0" @ 11x17

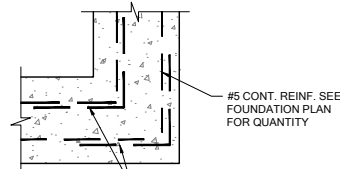


FM19 TYP. CORNER BAR DETAIL
SCALE: 3/4" = 1'-0" @ 22x34
SCALE: 3/8" = 1'-0" @ 11x17

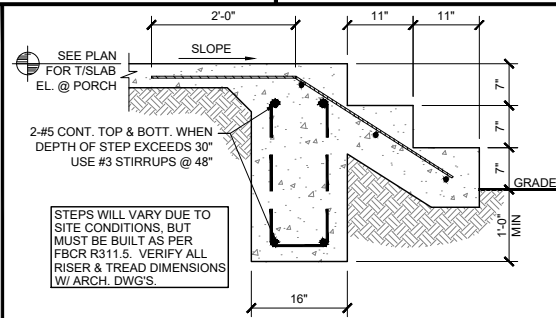


FM22 PORCH STEP
SCALE: 3/4" = 1'-0" @ 22x34
SCALE: 3/8" = 1'-0" @ 11x17

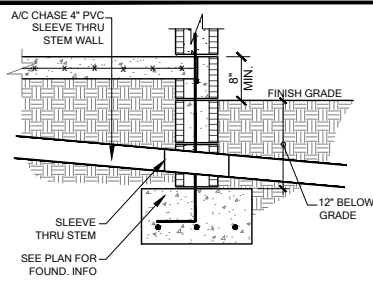


FS23 FOUNDATION PENETRATIONS, TYPICAL
SCALE: 3/4" = 1'-0" @ 22x34
SCALE: 3/8" = 1'-0" @ 11x17

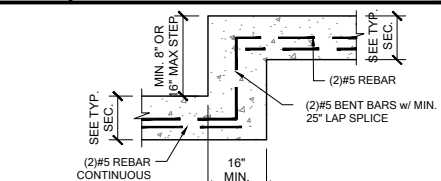

FM18 TYP. STEP FOOTING DETAIL
SCALE: 3/4" = 1'-0" @ 22x34
SCALE: 3/8" = 1'-0" @ 11x17

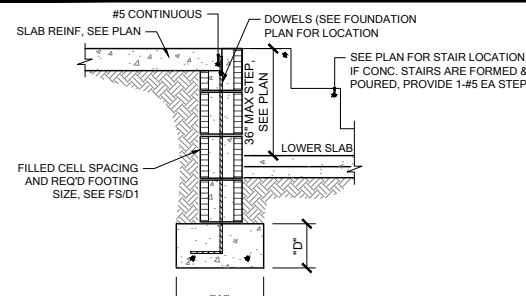

FS16 LARGE STEP DOWN
SCALE: 3/4" = 1'-0" @ 22x34
SCALE: 3/8" = 1'-0" @ 11x17

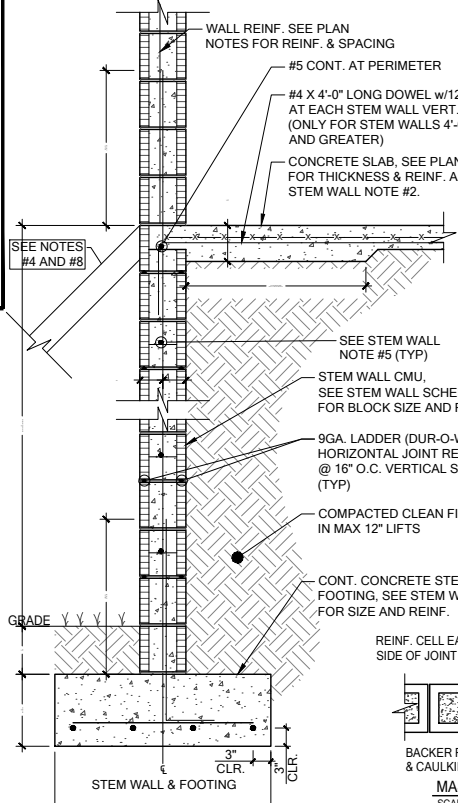



FS STEM WALL FOOTING SCHEDULE
SCALE: N.T.S.

- STEM WALL NOTES:**
1. VERTICAL REINFORCING IN SOLID GROUTED CELLS (3,000 PSI CONCRETE) AT ALL CORNERS, JAMBS, WALL INTERSECTIONS, BELOW GIRDER TRUSS LOCATIONS, AND AT THE MAXIMUM SPACING STATED IN SCHEDULE.
 2. A. 6x6 - W1.4 x W1.4 W.W.M. IS REQUIRED TO MAKE ADEQUATE CONNECTION BETWEEN SLAB AND WALL WHEN STEM WALL EXCEEDS 4'-0" TALL.
B. FIBERMESH CONCRETE CAN NOT BE USED.
C. #4 TURN BARS ARE REQUIRED AT EACH FILLED CELL LOCATION.
D. EACH BAR TO TIE INTO VERTICAL STEM WALL REINFORCING BAR AND EXTEND OUT A MINIMUM OF 4'-0" INTO SLAB.
 3. IF STEM WALL IS REQUIRED TO BE HIGHER THAN 12 FEET (18 COURSES), CONTACT ENGINEER OF RECORD PRIOR TO CONSTRUCTION FOR MORE INFORMATION.
 4. GENERAL CONTRACTOR TO PROVIDE ADEQUATE BRACING OF STEM WALL WHEN UNEVEN BACK FILLING IS TAKING PLACE.
 5. A. WHEN STEM WALL IS LESS THAN 4'-0" TALL, PROVIDE (1) - #5 HORIZONTAL CORNER BARS WITH 4'-0" X 4'-0" LEGS IN KNOCKOUT BLOCK SPACED @ 16" O.C. VERTICALLY. (TYPICAL AT ALL CORNERS).
B. WHEN STEM WALL IS 4'-0" TALL AND GREATER, PROVIDE CORNER BAR MENTIONED ABOVE AND (1) - #5 CONTINUOUS HORIZONTAL BAR IN KNOCKOUT BLOCK SPACED @ 16" O.C. VERTICALLY. GROUT ENTIRE WALL SOLID.
C. ALL STEM WALLS GREATER THAN (4) COURSES, SHALL BE GROUTED SOLID WITH 3,000 PSI CONCRETE.
D. IF STEM WALL IS WITHIN 5'-0" OF POOL OR WATER FEATURE, FOUNDATIONS TO BE A MINIMUM 12" BELOW BOTTOM OF POOL OR WATER FEATURE.
 7. R.403.1.4 MINIMUM DEPTH: ALL EXTERIOR FOOTINGS (BOTTOM) SHALL BE PLACED NOT LESS THAN 12" BELOW THE FINISHED GRADE OF GROUND SURFACE. WHERE APPLICABLE, THE DEPTH OF FOOTINGS SHALL ALSO CONFORM TO SECTION R403.1.4.1.
 8. EXTERIOR SHORING BY CONTRACTOR AS REQUIRED WHEN STEM IS OVER 4'-0" TALL.
 9. CONTROL JOINTS TO BE LOCATED AT 20' O.C. MAX AND @ ALL CHANGES IN WALL WIDTHS.


STEM WALL HEIGHT (h)	COURSES OF BLOCKS	BLOCK SIZE	FOOTING DIMENSION (d) & (w)				NUMBER/SIZE OF BOTTOM BARS IN CONT. FOOTING	MAXIMUM VERTICAL FILLED CELL SPACING IN STEM WALL CENTERED (U.N.O.)
			(d) 1 STRY.	(d) 2 STRY.	(w) 1 STRY.	(w) 2 STRY.		
0'-0" - 2'-0"	1 - 3	8"	8"	10"	16"	20"	(2) - #5 BARS	#5 @ 80" O.C.
2'-0" - 3'-4"	4 - 5	8"	10"	10"	20"	24"	(3) - #5 BARS	#5 @ 64" O.C.
4'-0"	6	8"	12"	12"	32"	32"	(4) - #5 BARS	#5 @ 48" O.C.
4'-8" - 5'-4"	7 - 8	8"	16"	16"	40"	40"	(4) - #5 BARS CONT. & #5 AT 24" O.C. TRANSV.	#5 @ 32" O.C.
6'-0" - 6'-8"	9 - 10	8"	16"	16"	48"	48"	(4) - #5 BARS CONT. & #5 AT 12" O.C. TRANSV.	#5 @ 32" O.C.
7'-4" - 8'-0"	11 - 12	8"	16"	16"	48"	48"	(5) - #5 BARS CONT. & #5 AT 12" O.C. TRANSV.	#5 @ 16" O.C.
8'-8" - 10'-0"	13 - 15	12"	16"	16"	54"	54"	(5) - #5 BARS CONT. & #5 AT 12" O.C. TRANSV.	#5 @ 8" O.C.
10'-8" - 12'-0"	16 - 18	12"	16"	16"	54"	54"	(6) - #5 BARS CONT. & #5 AT 12" O.C. TRANSV.	(2) - #5 @ 16" O.C. SPACED 4" APART IN CELL

NOTE: SEE FOUNDATION PLAN FOR FILLED CELL SPACING ABOVE SLAB LEVEL.

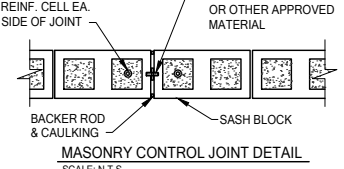


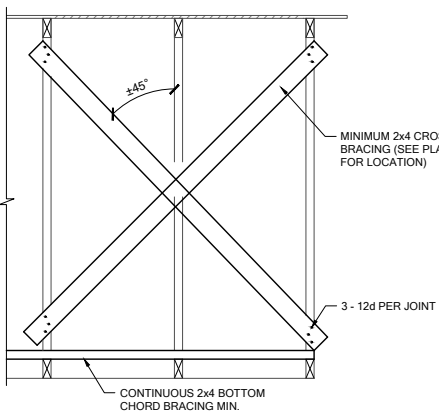


TB01 CROSS BRACING, TYP.
SCALE: 3/4" = 1'-0" @ 22x34
SCALE: 3/8" = 1'-0" @ 11x17

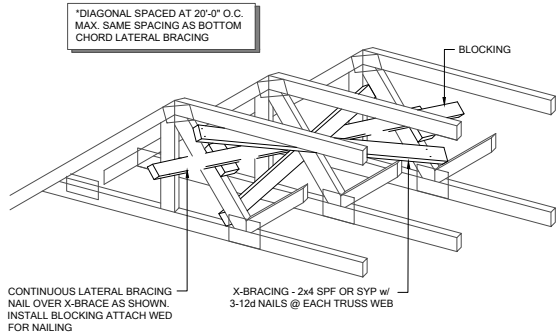


TB02 CROSS BRACING TYPICAL
SCALE: N.T.S.

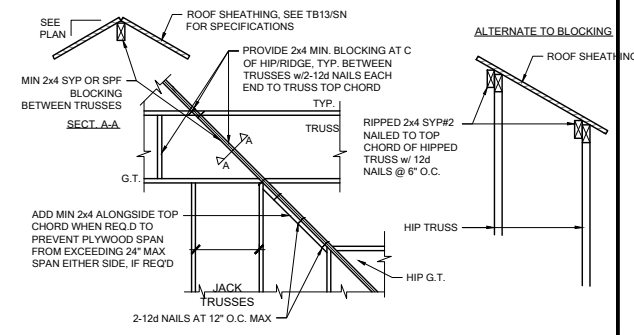


TB03 HIP/RIDGE BLOCKING
SCALE: 3/4" = 1'-0" @ 22x34
SCALE: 3/8" = 1'-0" @ 11x17

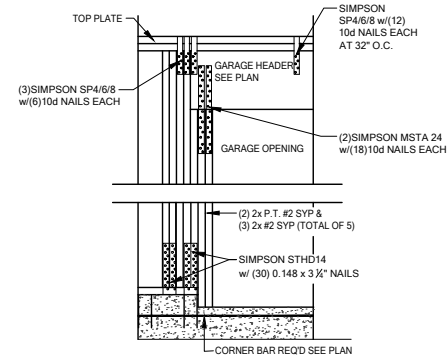


WC04 GARAGE HEADER ANCHOR
SCALE: 3/4" = 1'-0" @ 22x34
SCALE: 3/8" = 1'-0" @ 11x17

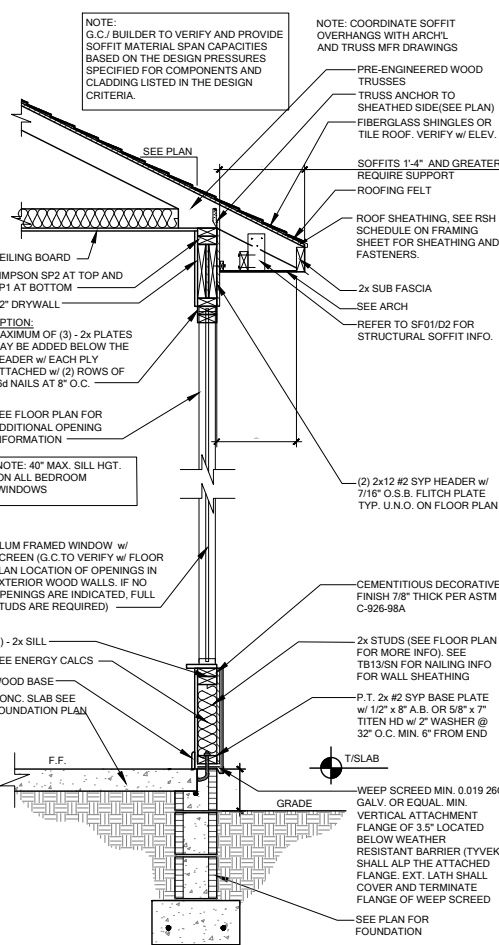


WS02 TYP. WALL SECTION
SCALE: 3/4" = 1'-0" @ 22x34
SCALE: 3/8" = 1'-0" @ 11x17

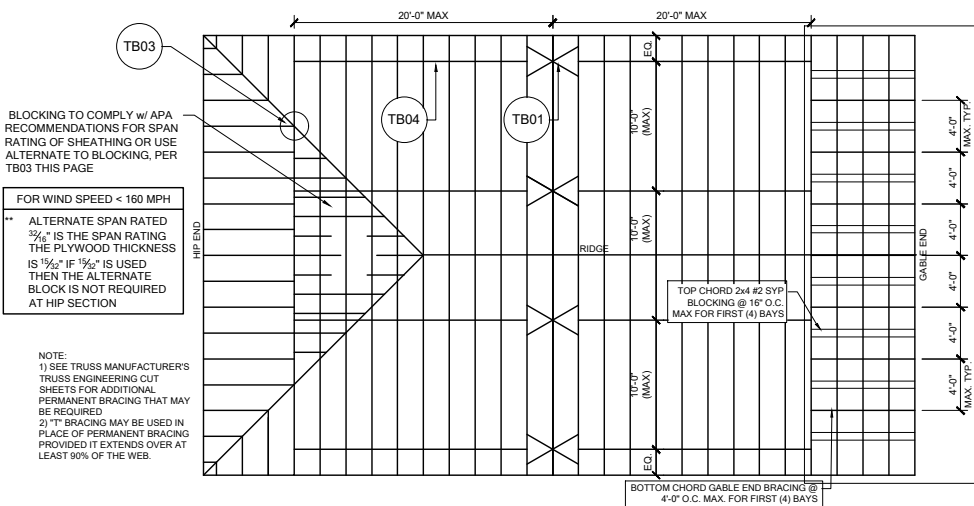


TB05 REQUIRED MIN. PERMANENT TRUSS BRACING PLAN
SCALE: N.T.S.

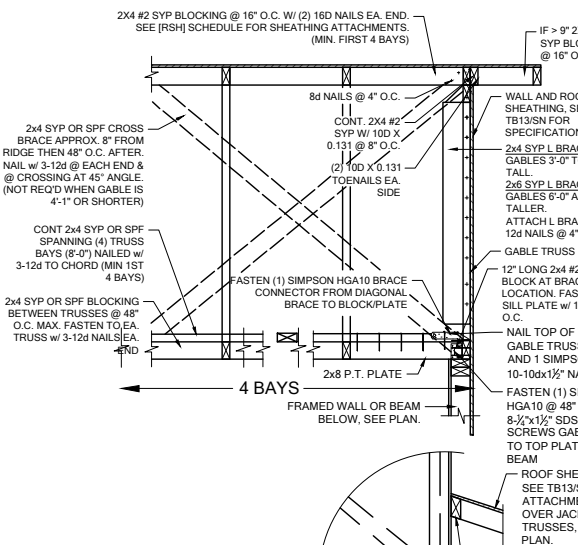


GE05 GABLE END BRACE
SCALE: 3/4" = 1'-0" @ 22x34
SCALE: 3/8" = 1'-0" @ 11x17

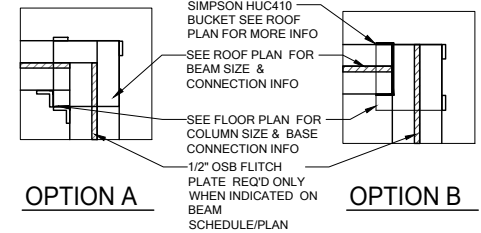


A COMMON BM. TO POST ATTACHMENT
SCALE: 3/4" = 1'-0" @ 22x34
SCALE: 3/8" = 1'-0" @ 11x17

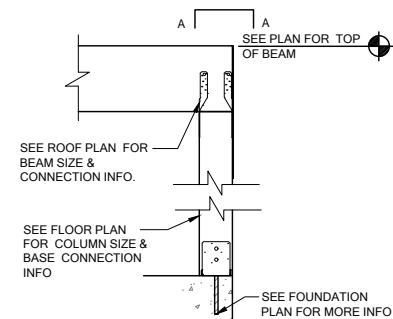


CD11 COMMON BM. ATTACHMENT
SCALE: 3/4" = 1'-0" @ 22x34
SCALE: 3/8" = 1'-0" @ 11x17

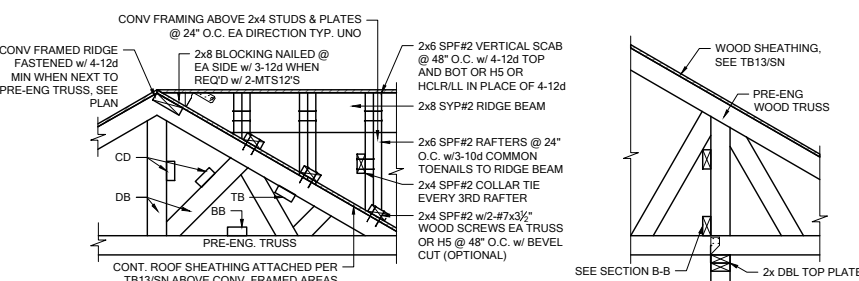


TB06 BLOCKING/CONV. FRAME DETAILS
SCALE: 1/2" = 1'-0" @ 22x34
SCALE: 3/8" = 1'-0" @ 11x17

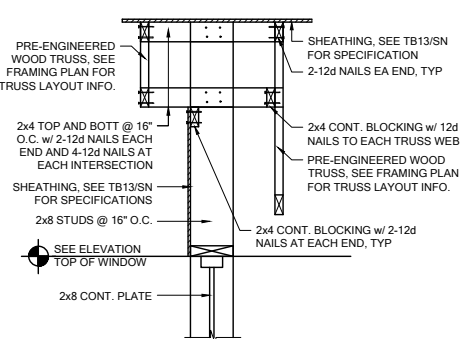


WF27 KNEEWALL @ ENTRY
SCALE: 3/4" = 1'-0" @ 22x34
SCALE: 3/8" = 1'-0" @ 11x17

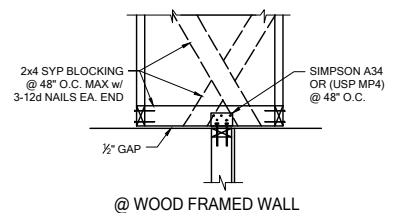


TB15 NON-BEARING EXTERIOR WALL
SCALE: 3/4" = 1'-0" @ 22x34
SCALE: 3/8" = 1'-0" @ 11x17

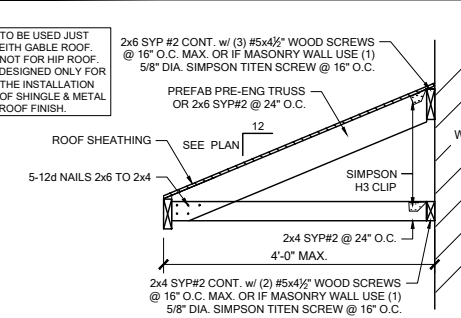


SR01 SHED ROOF CONNECTION
SCALE: 3/4" = 1'-0" @ 22x34
SCALE: 3/8" = 1'-0" @ 11x17

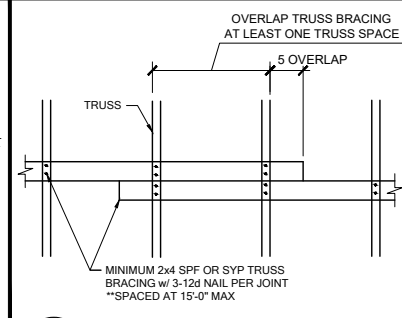


TB04 TRUSS BRACING OVER LAP
SCALE: 3/4" = 1'-0" @ 22x34
SCALE: 3/8" = 1'-0" @ 11x17

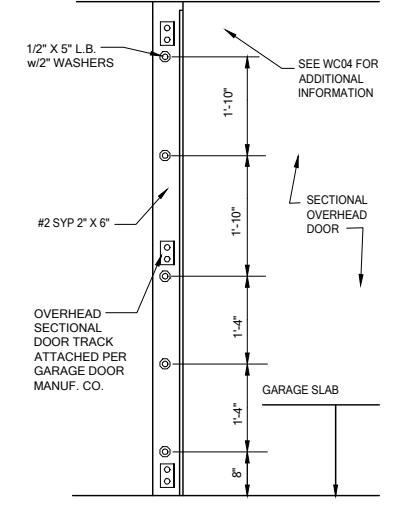


WC05 SECT. OVERHEAD GAR. DOOR INSTALL
SCALE: 3/4" = 1'-0" @ 22x34
SCALE: 3/8" = 1'-0" @ 11x17

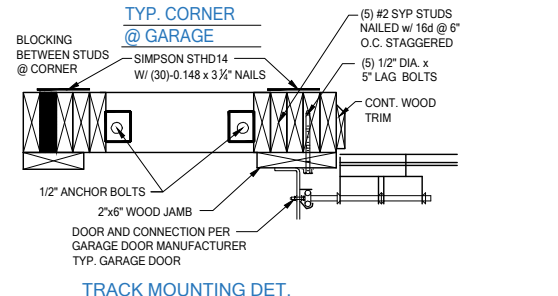


SF01 STRUCTURAL SOFFIT
SCALE: 3/4" = 1'-0" @ 22x34
SCALE: 3/8" = 1'-0" @ 11x17
NOT REQUIRED. VINYL SOFFITS >1'-0" SHALL HAVE MID BLOCKING PER R704.2.1
REFER TO THE PRODUCT APPROVAL FOR INSTALLATION DETAILS.

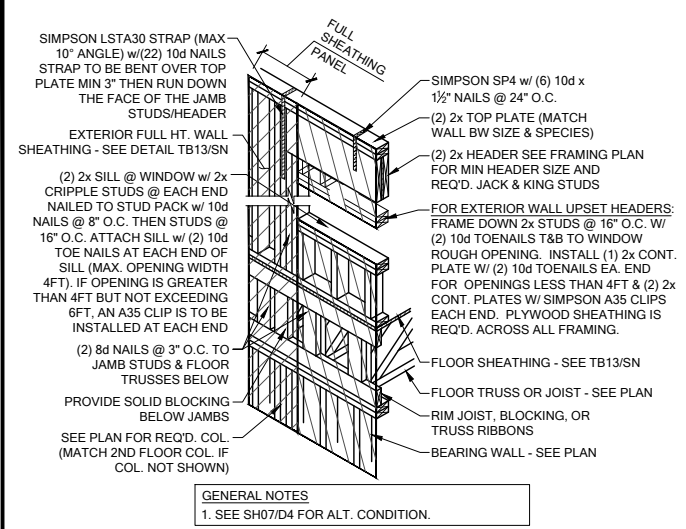


SH00 HEADER CONN. @ 2ND FLOOR (NO BASE STRAP)
SCALE: 3/4" = 1'-0" @ 22x34
SCALE: 3/8" = 1'-0" @ 11x17

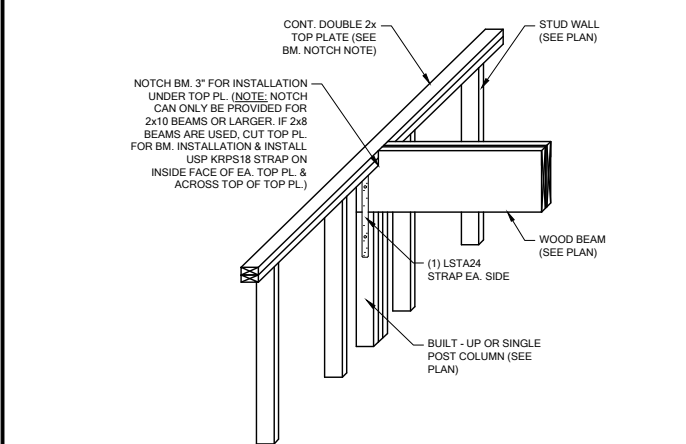


WF103 TYP. WOOD BEAM TO WOOD WALL CONN.
SCALE: 3/4" = 1'-0" @ 22x34
SCALE: 3/8" = 1'-0" @ 11x17

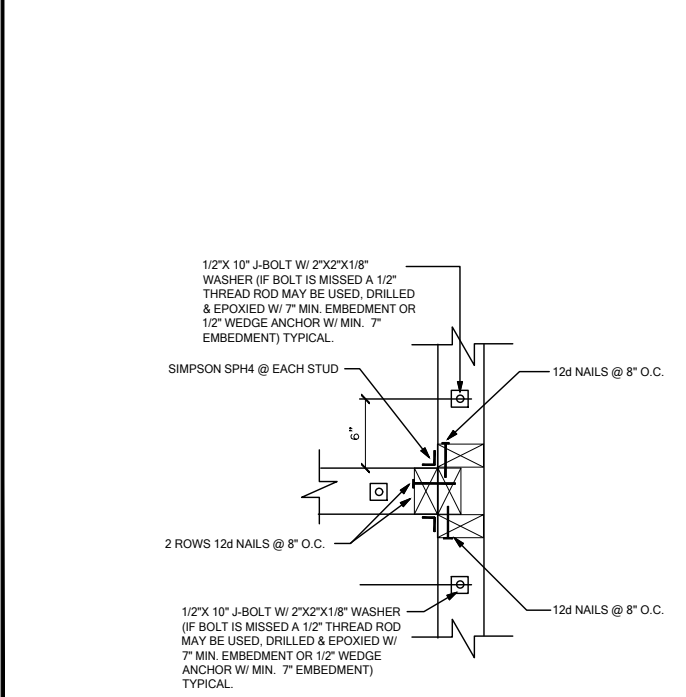


WC03 WALL TO WALL @ END OF SHEAR WALL
SCALE: 3/4" = 1'-0" @ 22x34
SCALE: 3/8" = 1'-0" @ 11x17

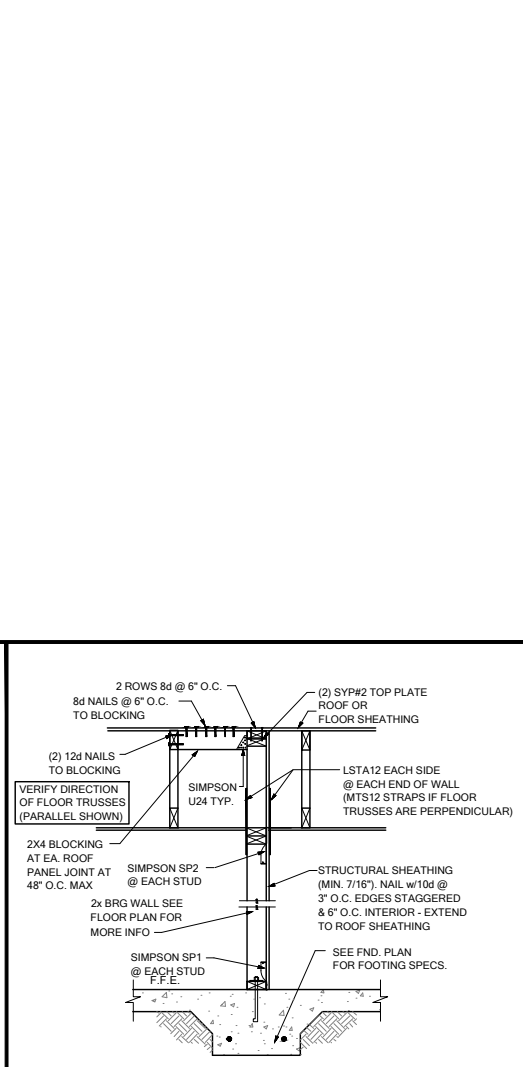


SW04 INTERIOR SHEAR WALL @ TRUSSES
SCALE: 3/4" = 1'-0" @ 22x34
SCALE: 3/8" = 1'-0" @ 11x17

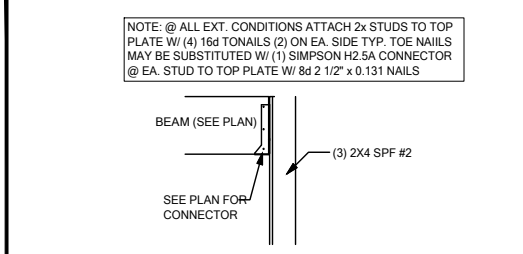


CD25 BEAM TO WALL CONNECTION
SCALE: 3/4" = 1'-0"

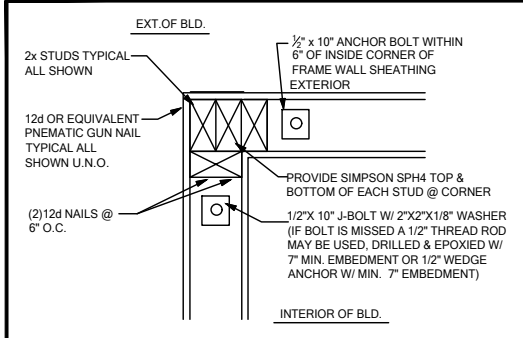


WC06 EXTERIOR FRAME CORNER
SCALE: 3/4" = 1'-0" @ 22x34
SCALE: 3/8" = 1'-0" @ 11x17

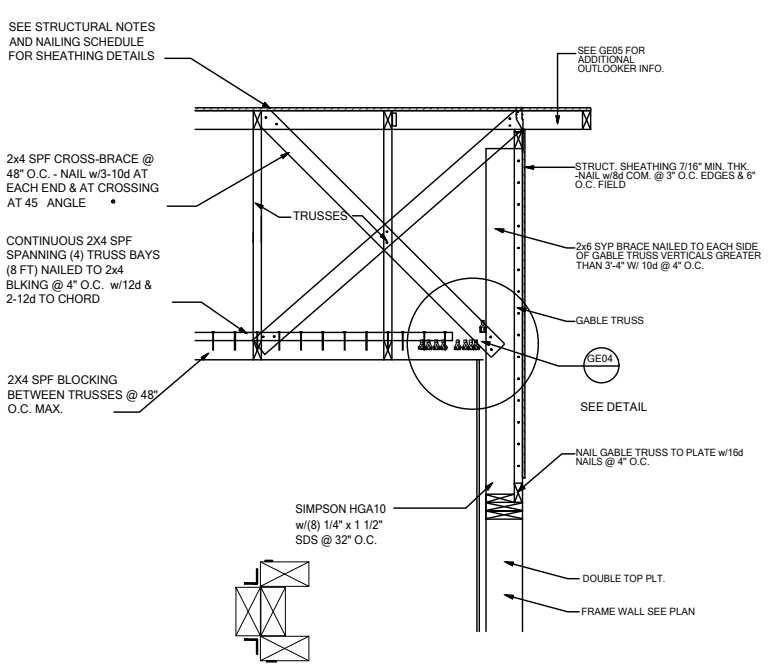


GE03 GABLE END BRACIN w/ VOLUME CEILING
SCALE: 3/4" = 1'-0" @ 22x34
SCALE: 3/8" = 1'-0" @ 11x17

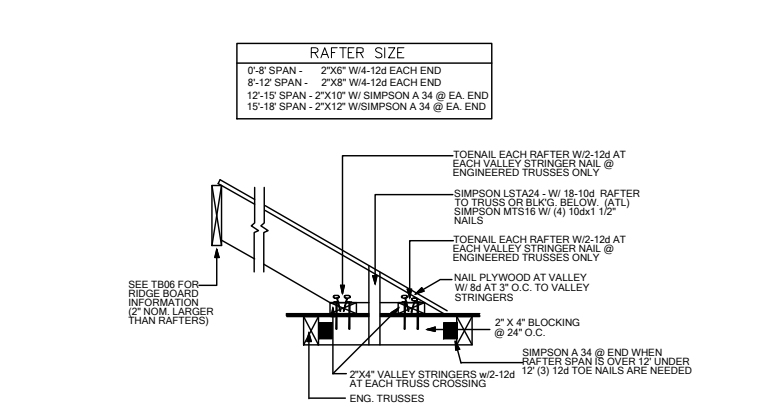


TB17 CONV. FRAMING & VALLEY FRAMING
SCALE: 3/4" = 1'-0" @ 22x34
SCALE: 3/8" = 1'-0" @ 11x17

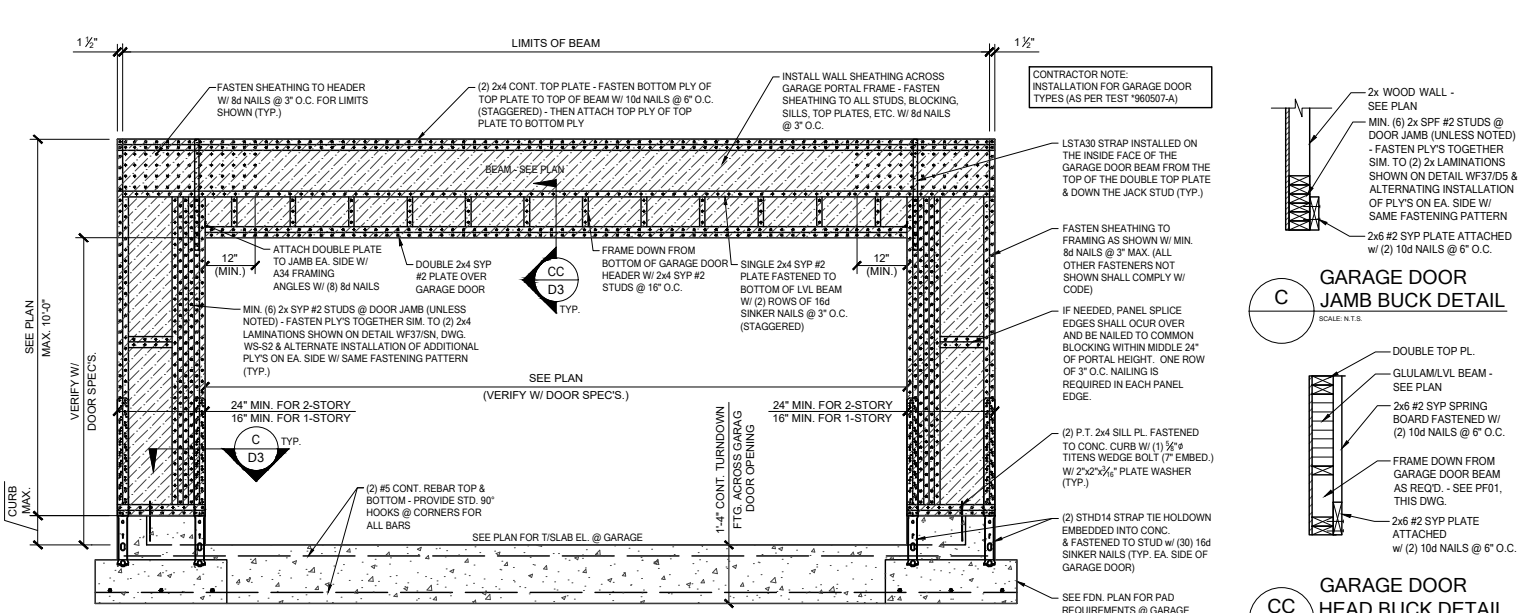


PF01 GARAGE DOOR PORTAL FRAME
SCALE: 3/4" = 1'-0" @ 22x34
SCALE: 3/8" = 1'-0" @ 11x17

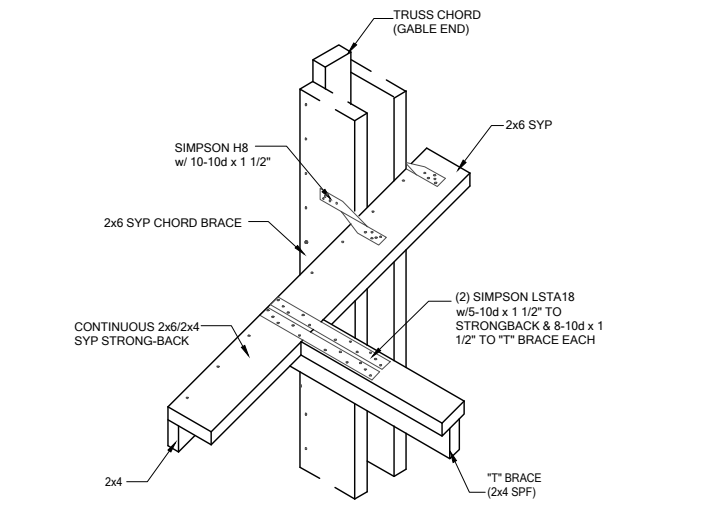


GE04 \"T\" BRACE CONNECTION @ VOLUME CEILING
SCALE: 3/4" = 1'-0" @ 22x34
SCALE: 3/8" = 1'-0" @ 11x17

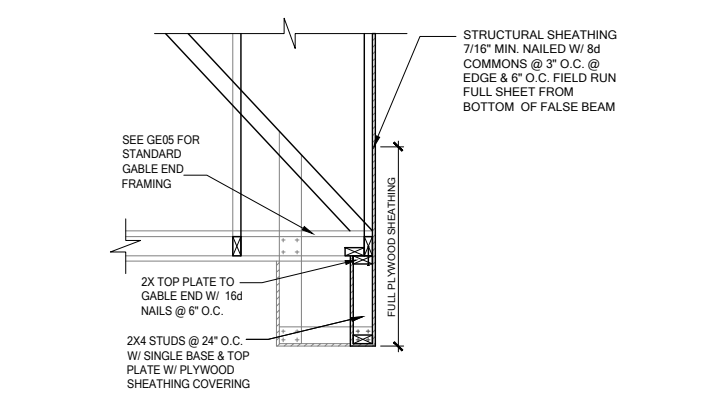












GE15 FALSE BEAM @ GABLE END
SCALE: 3/4" = 1'-0" @ 22x34
SCALE: 3/8" = 1'-0" @ 11x17

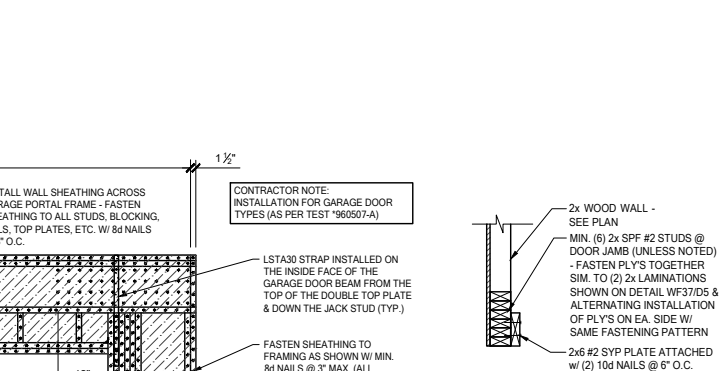

C GARAGE DOOR JAMB BUCK DETAIL
SCALE: N.T.S.

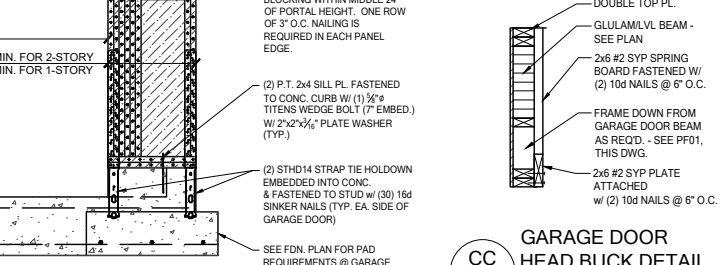

         CC GARAGE DOOR HEAD BUCK DETAIL
SCALE: N.T.S.

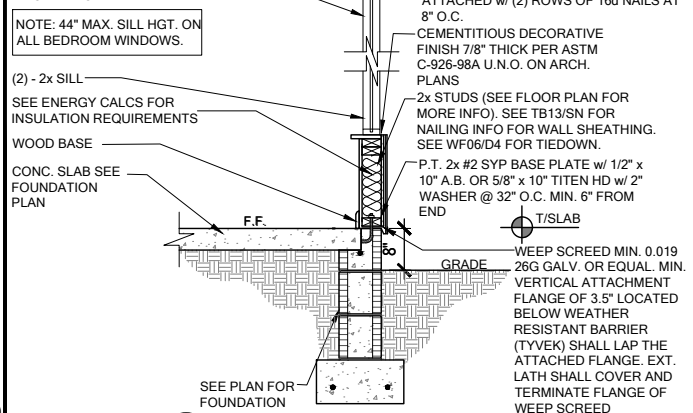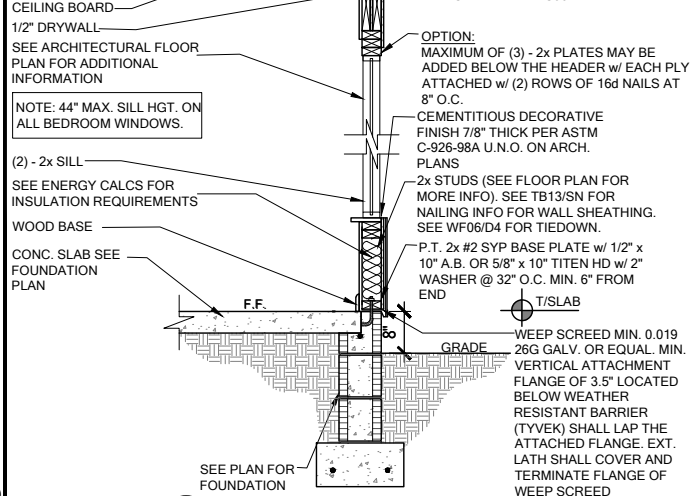[illegible]

FDS
238 Southall Lane, Suite 200
Maitland, FL 32751
O: 321-972-0491 F: 407-880-2304
Certificate Of Authorization No. 9161

☐ CARLA A. BROWN, PE - FL #56126
☐ LUIS PABLO TORRES, PE - FL #7864
☐ SCOTT LEWKOWSKI, PE - FL #78750

WWW.EDFDS.COM

LOT 30
RESERVE @ JEWEL LAKE
436 SW JEWEL LAKE DR.
LAKE CITY, FL 32024

LAN
UMBER:
3811607


RELEASE
ATE:
8.03.2020

[illegible]


MODEL: COVINGTON

DRAWING TITLE: FLOOR FRAMING DB


SHEET
NO: **D4**

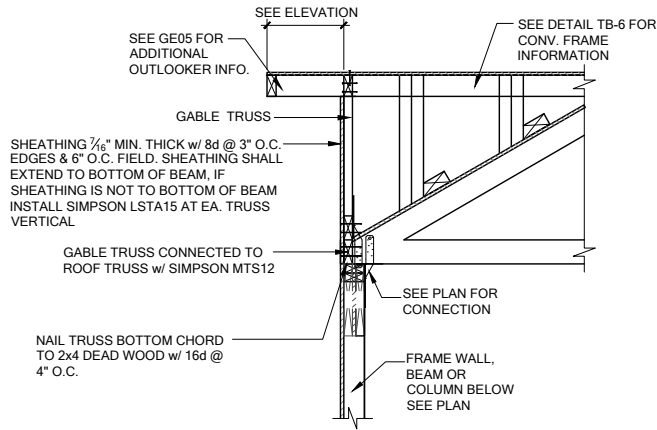

GE13A SECTION AT HIP GABLE
SCALE: 3/4" = 1'-0"
SCALE: 3/8" = 1'-0" @ 11x17


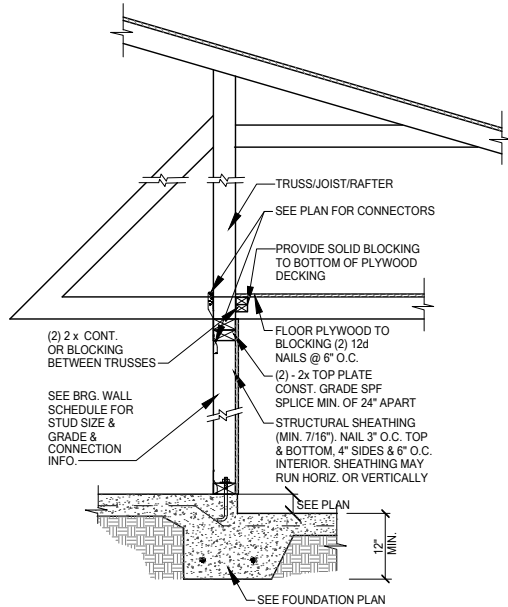


SW01 INTERIOR BEARING STEP-DOWN SHEARWALL w/UPLIFT
SCALE: 3/4" = 1'-0" @ 22x34
SCALE: 3/8" = 1'-0" @ 11x17

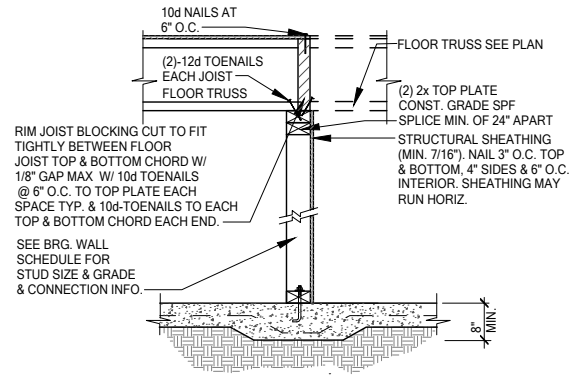

UPLIFT VALUES - (DOUBLE SIDE PLYWOOD DOUBLES VALUE BELOW)
SHEATHING I-SIDE - 860 LBS. PER TRUSS/JOIST/RAFTER

SW02 INTERIOR SHEAR WALL
SCALE: 3/4" = 1'-0" @ 22x34
SCALE: 3/8" = 1'-0" @ 11x17

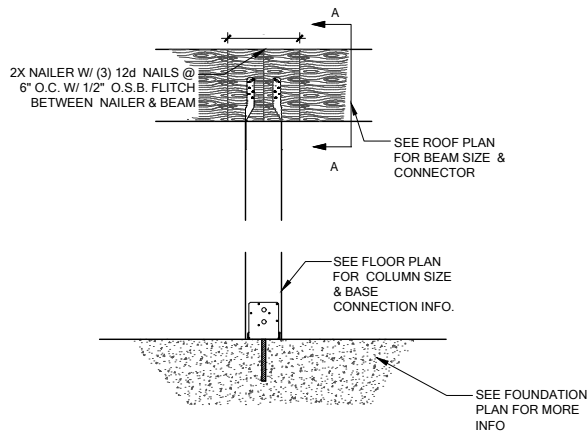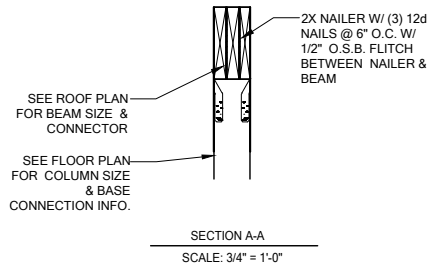

CD13 COLUMN BM. ATTACHMENT
SCALE: 3/4" = 1'-0"
SCALE: 3/8" = 1'-0" @ 11x17