




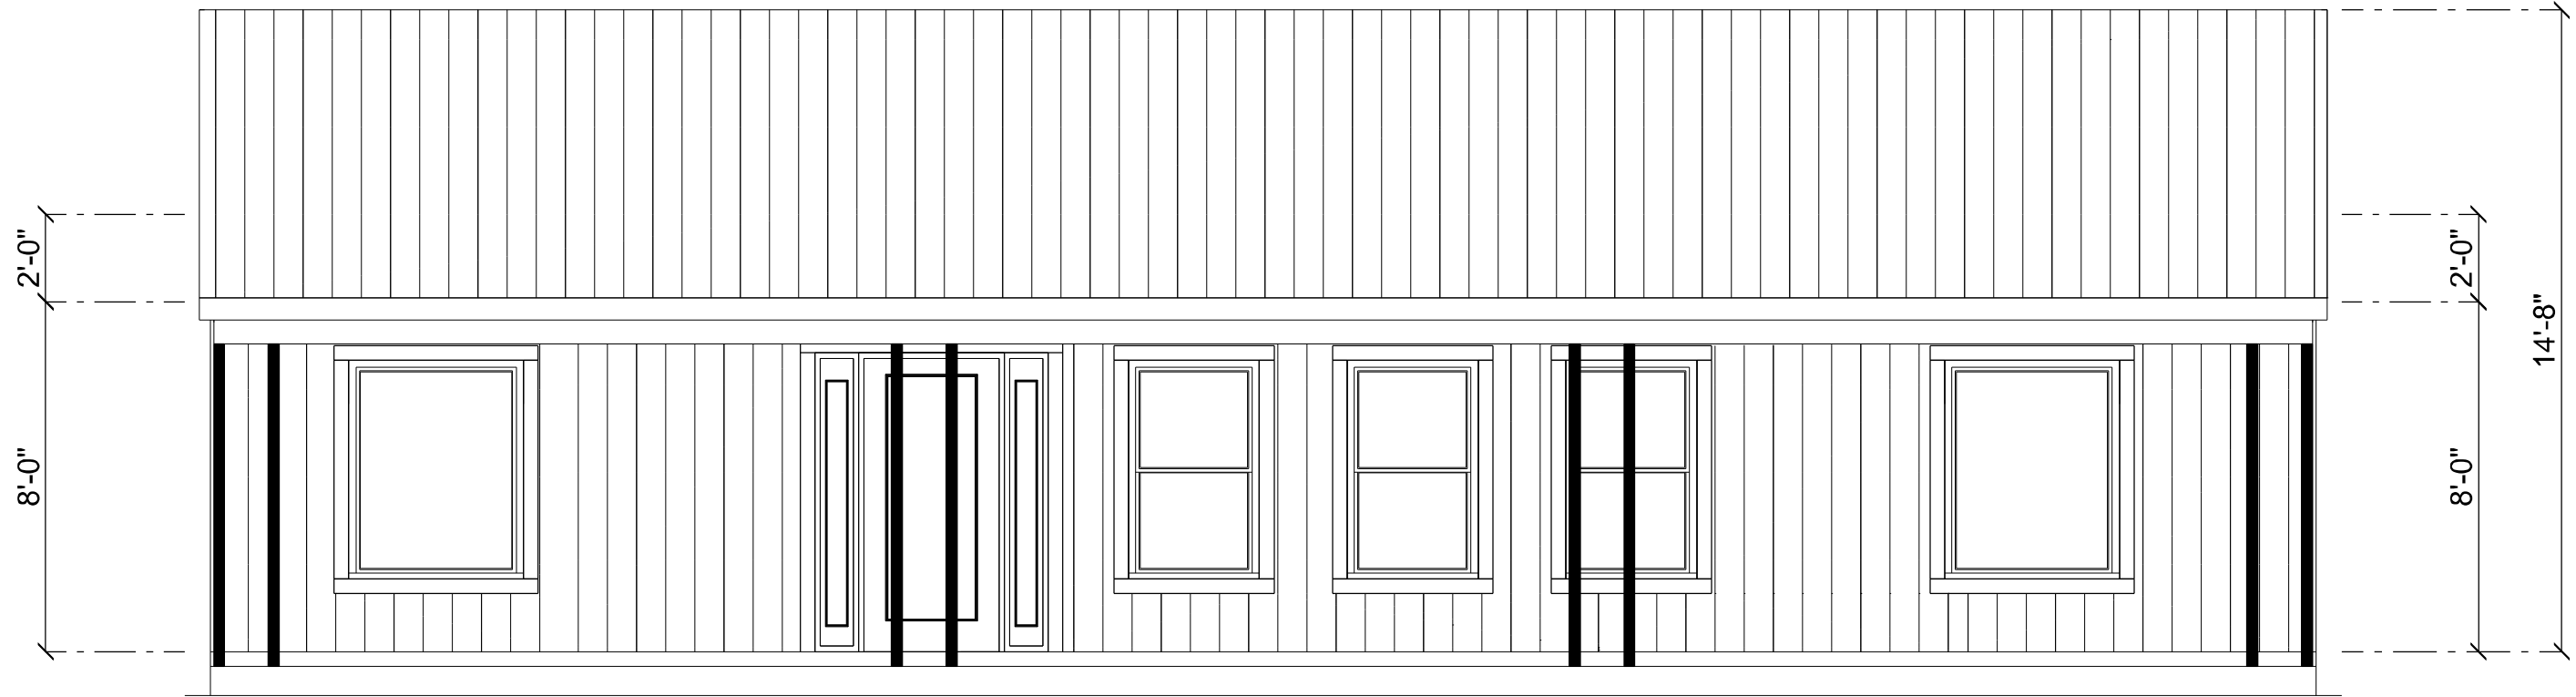


FRONT ELEVATION
SCALE: 1/4" = 1'-0"

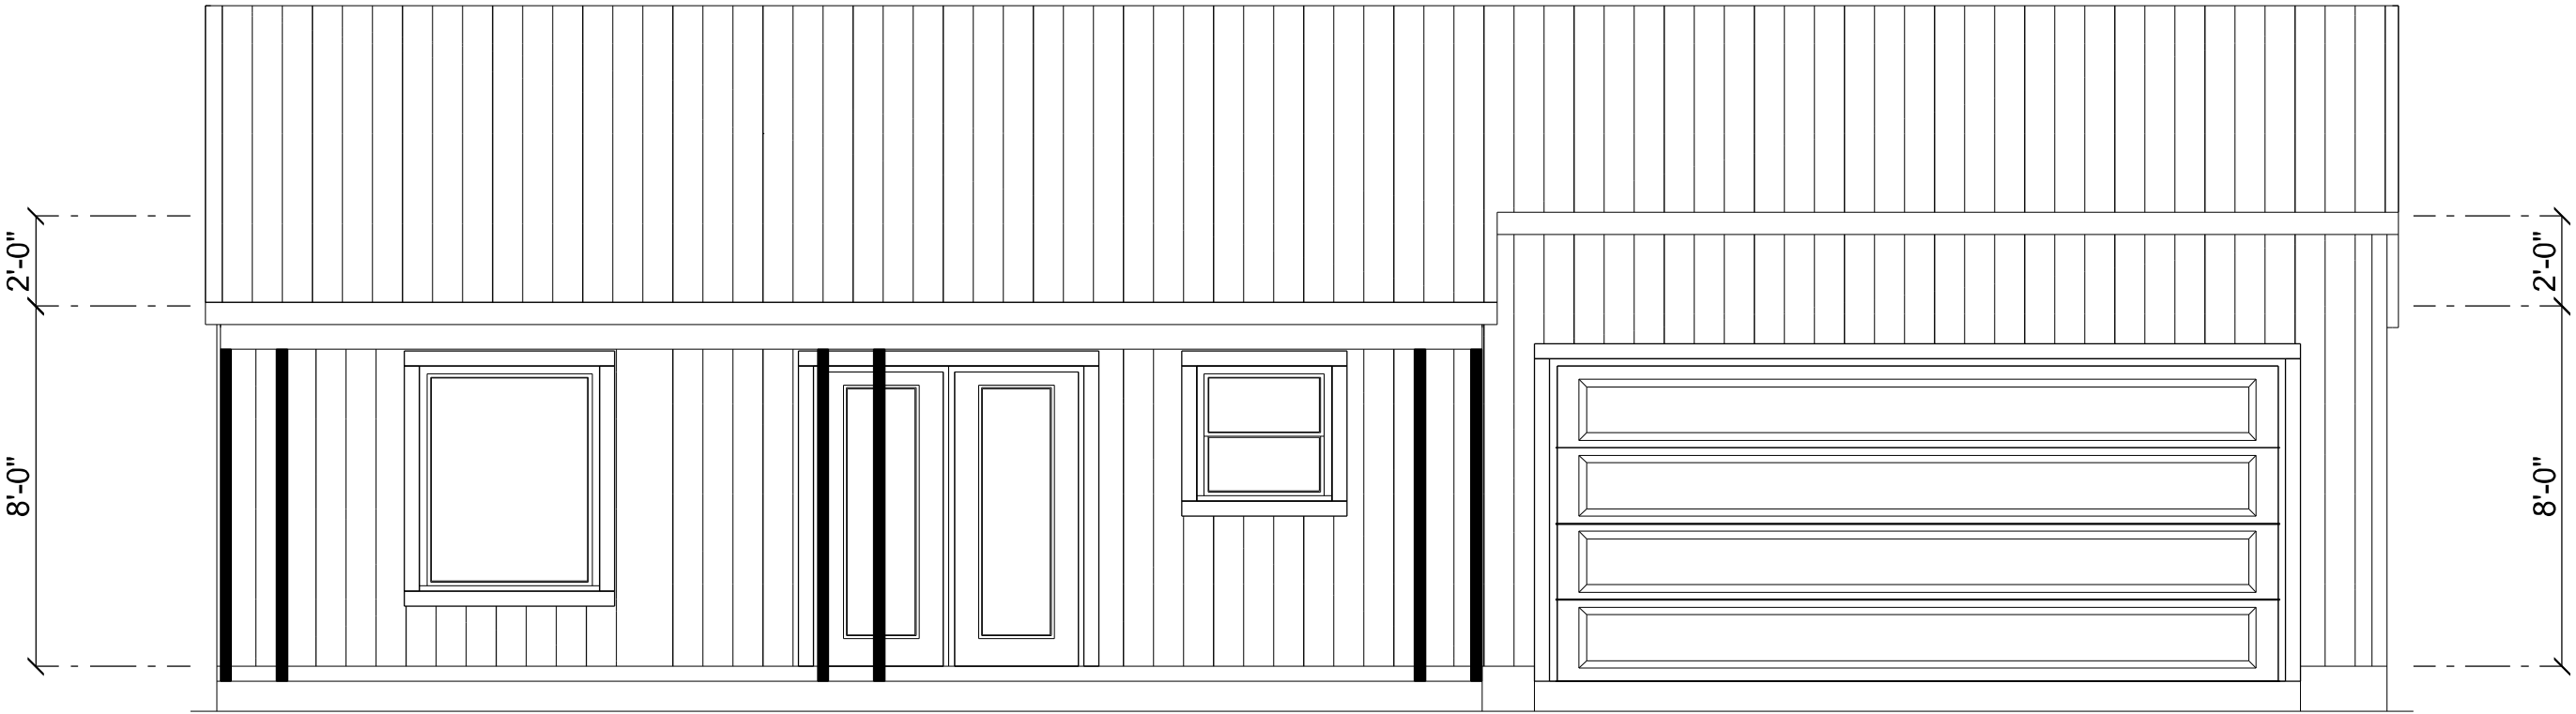

REAR ELEVATION
SCALE: 1/4" = 1'-0"

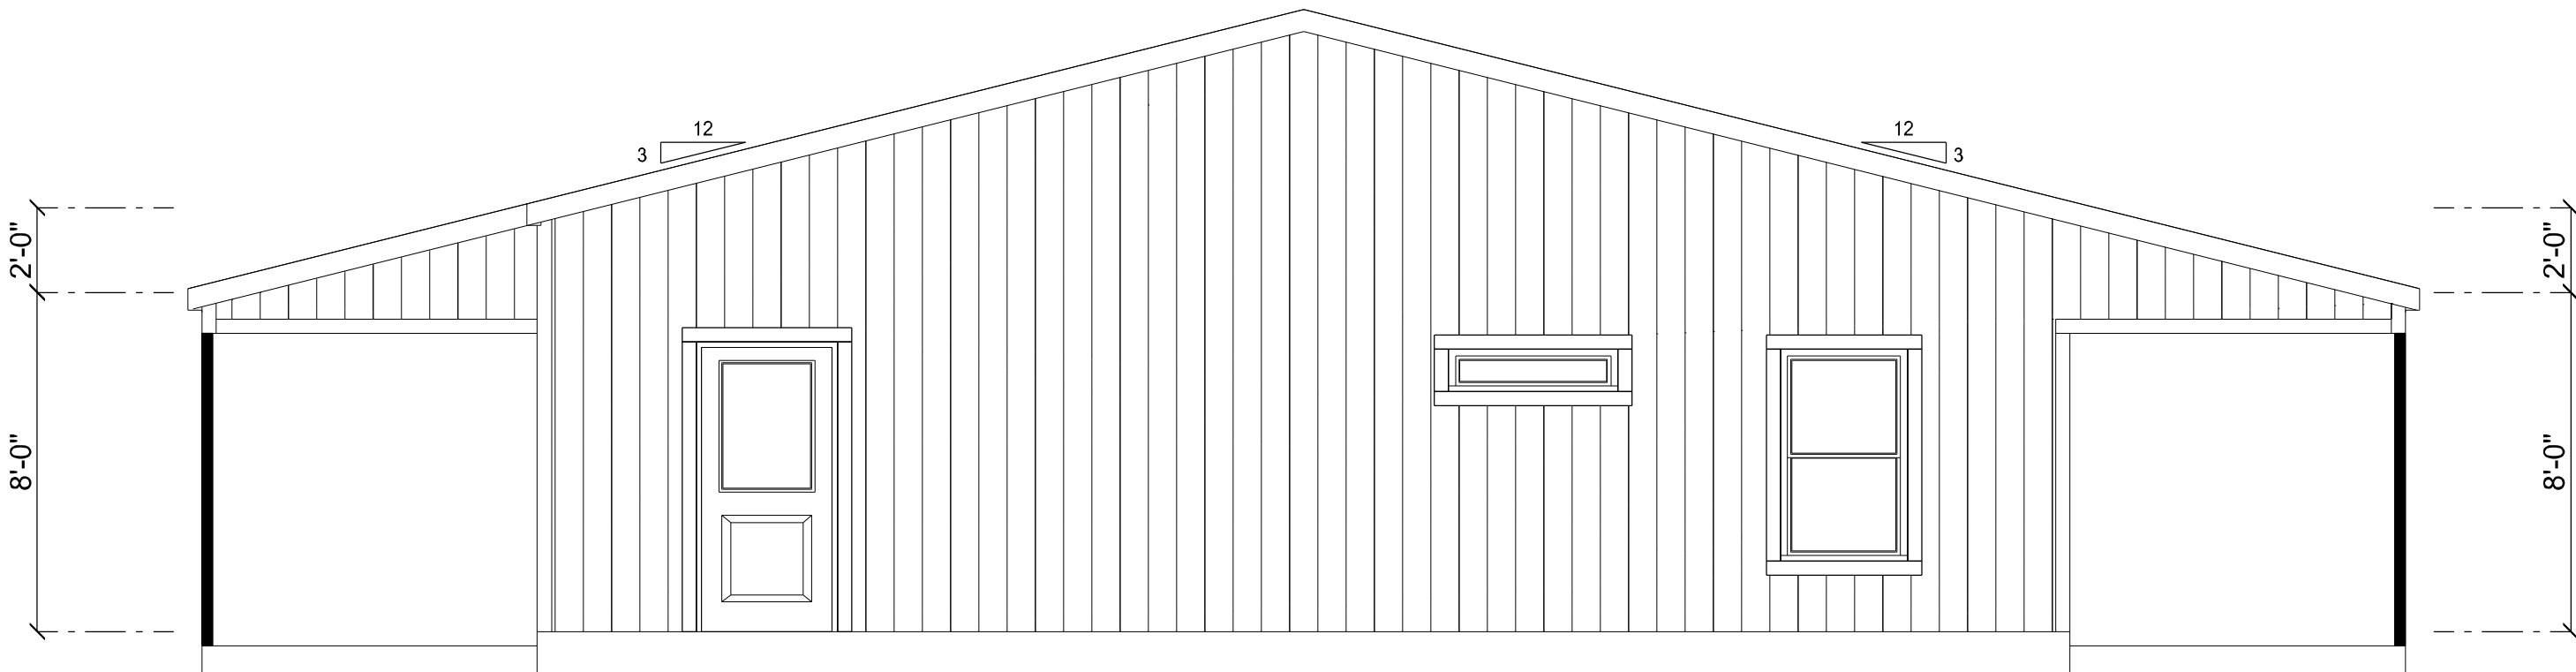


LEFT ELEVATION
SCALE: 1/4" = 1'-0"

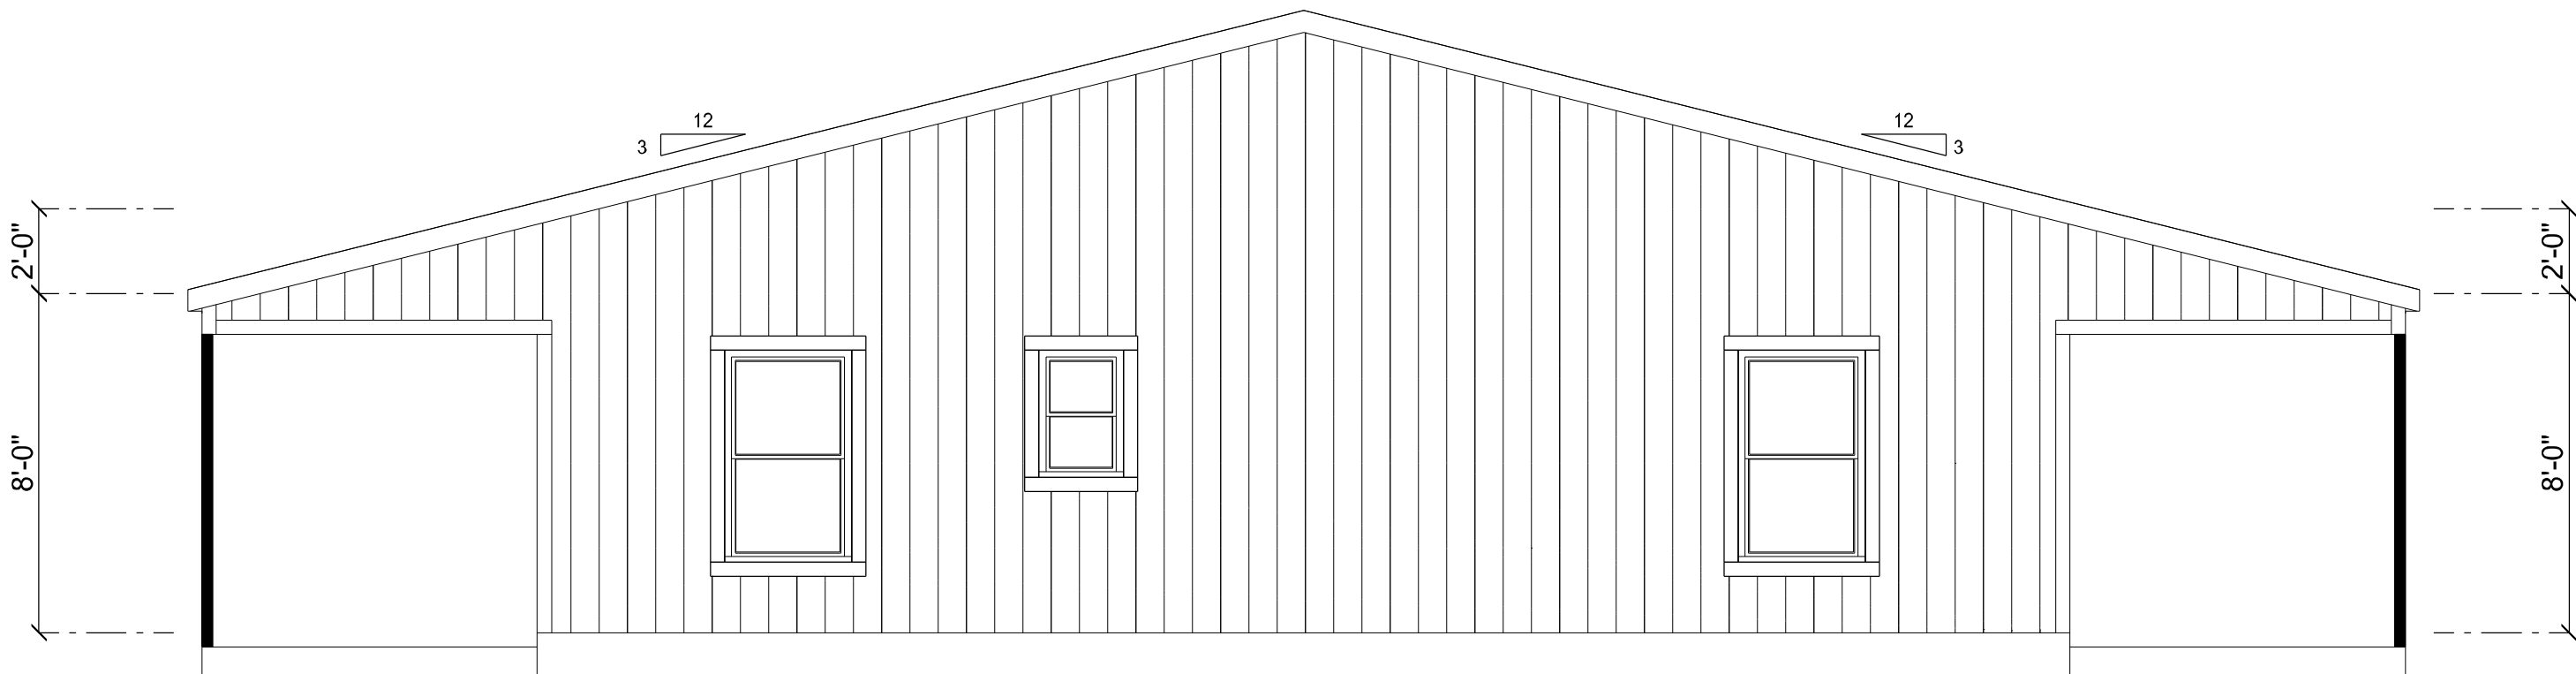

RIGHT ELEVATION
SCALE: 1/4" = 1'-0"


REVISIONS SCHEDULE		
PROPOSAL	Apr. 22nd, 2024	
REVISIONS	May 30th, 2024	

A BARNDOMINIUM FOR:
STILWELL RESIDENCE
COLUMBIA COUNTY, FLORIDA

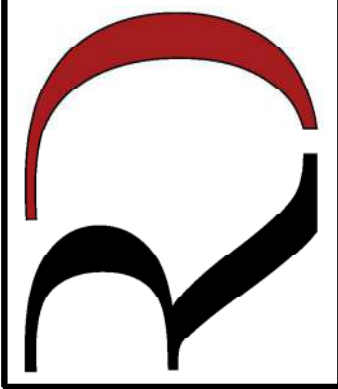**RIDGEPOINT
DESIGN**

566 SW ARLINGTON BLVD. STE 101, LAKE CITY, FL 32025
P: 386-288-1188
E: RIDGEPOINTDESIGN@GMAIL.COM

SHEET NUMBER
A.1
OF 6 SHEETS

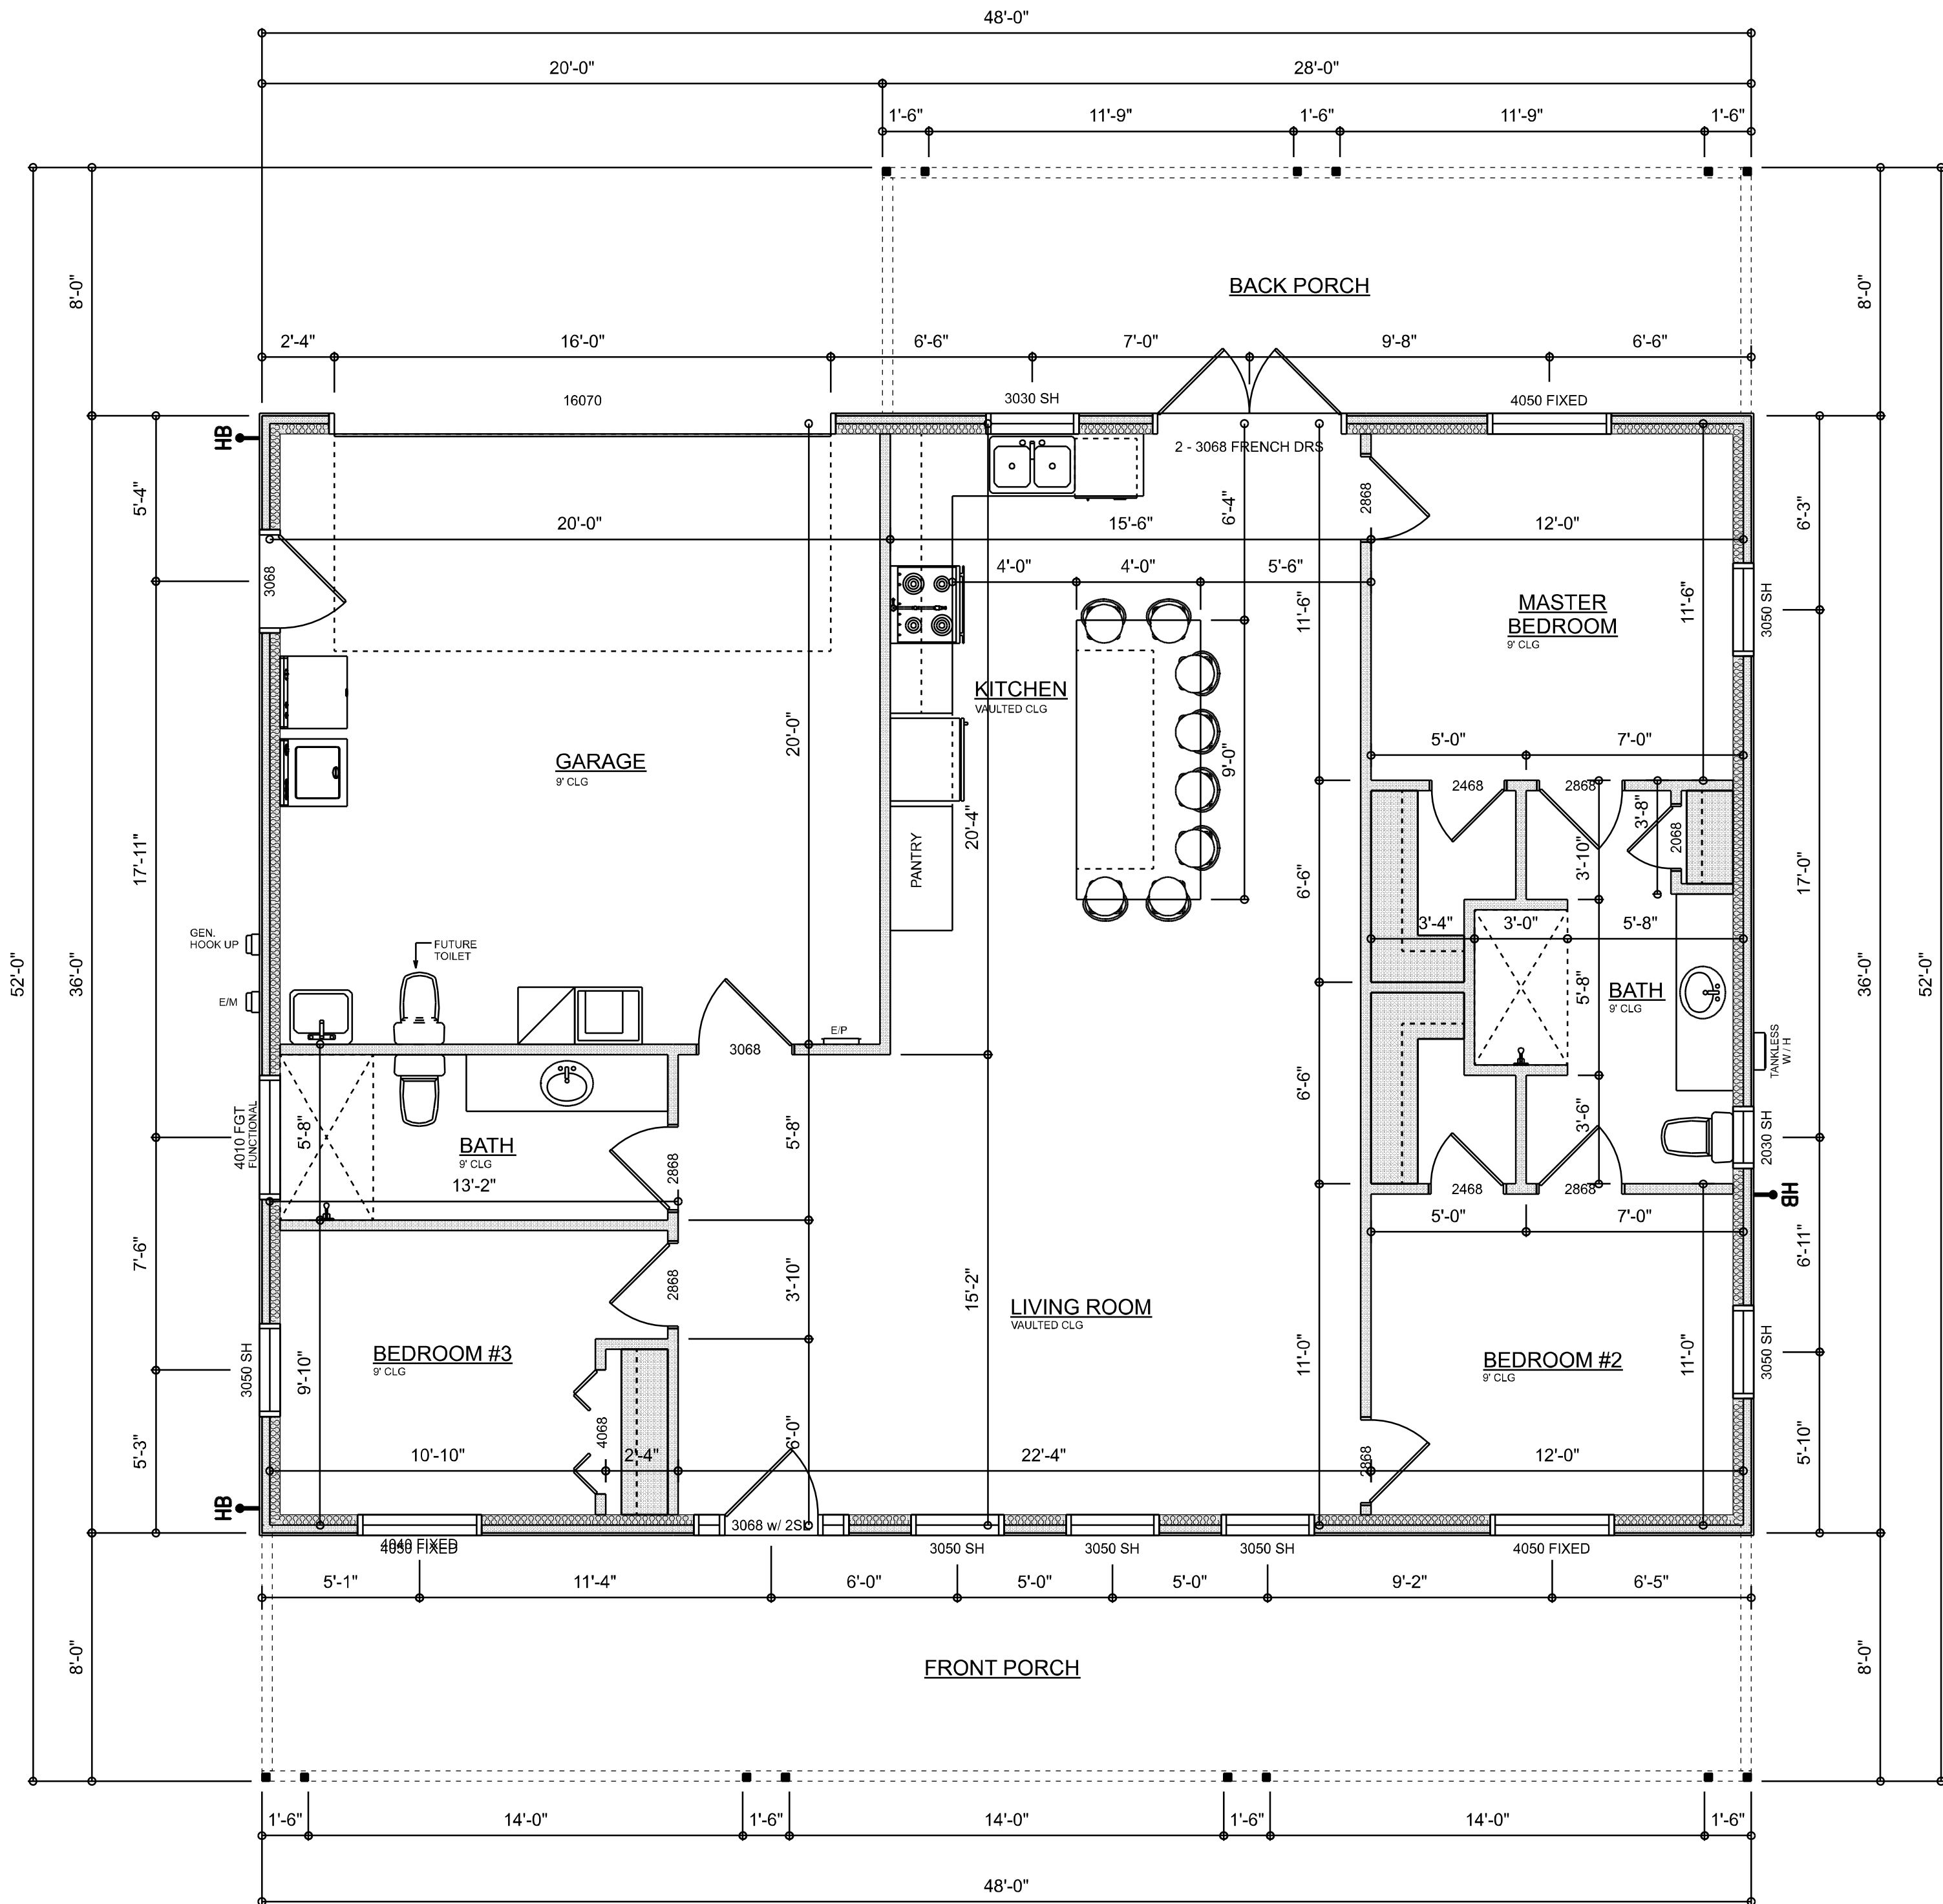

DEMENSIONED FLOOR PLAN
 SCALE: 1/4" = 1'-0"

AREA SUMMARY

LIVING AREA	1,318	S.F.
GARAGE	410	S.F.
FRONT PORCH	384	S.F.
BACK PORCH	224	S.F.
TOTAL AREA	2,336	S.F.

REVISIONS SCHEDULE	
PROPOSAL	Apr. 22nd, 2024
REVISIONS	May 30th, 2024


A BARNDOMINIUM FOR:

STILWELL RESIDENCE
 COLUMBIA COUNTY, FLORIDA

RIDGEPOINT
 DESIGN

566 SW ARLINGTON BLVD. STE 101, LAKE CITY, FL 32025
 P: 386-288-1188
 E: RIDGEPOINTDESIGN@GMAIL.COM

SHEET NUMBER
 A.2
 OF 6 SHEETS

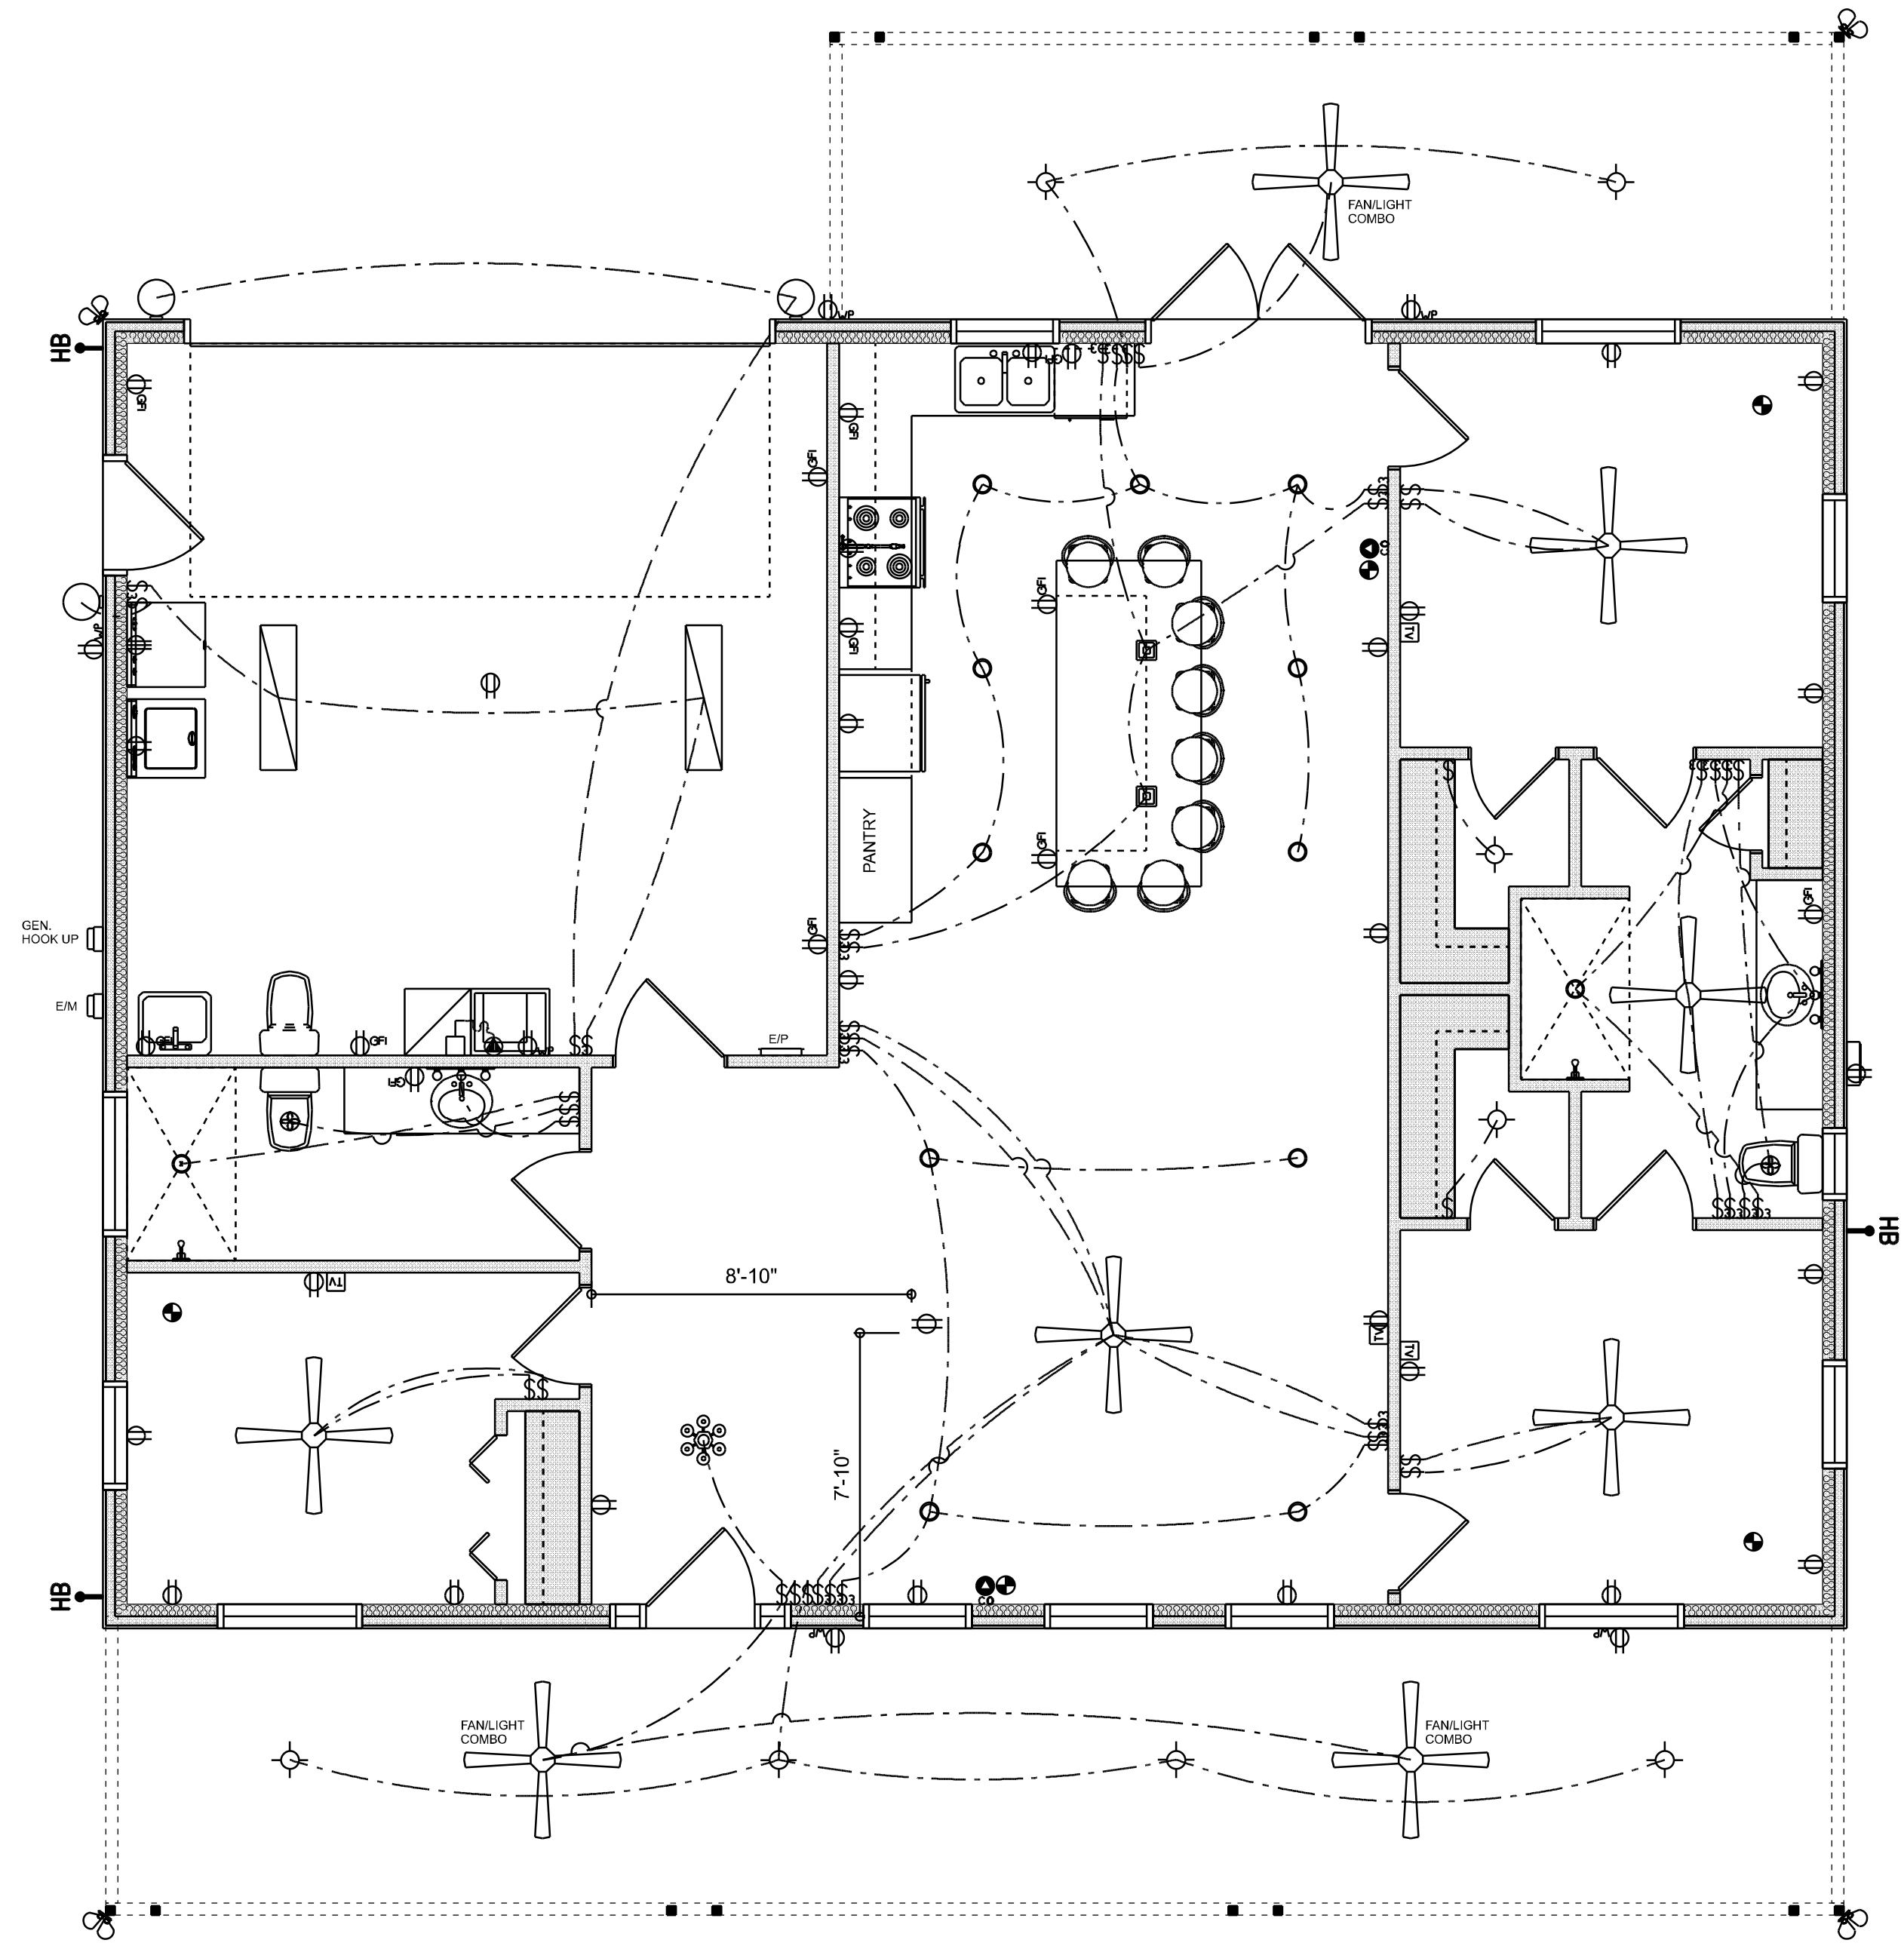

ELECTRICAL PLAN
SCALE: 1/4" = 1'-0"

ELECTRICAL LEGEND		
ELECTRICAL	COUNT	SYMBOL
CEILING FAN	8	
CAN LIGHT 6inch	13	
CHANDELIER	1	
LED CEILING LIGHT 1x4	2	
PENDANT LIGHT	2	
EXTERIOR SCONCE	3	
MOTION SECURITY LIGHT	4	
ELECTRIC PANEL	1	
AC DISCONNECT	1	
CABLE TV OUTLET	4	
CARBON DETECTOR	2	
EXHAUST FAN	2	
FLOOR OULET DUPLEX	1	
OUTLET	24	
OUTLET 220v	2	
OUTLET GFI	12	
OUTLET WP	6	
SMOKE DETECTOR	5	
STANDARD LIGHT	8	
SWITCH	18	
SWITCH 3 WAY	25	
VANITY BAR LIGHT - SMALL	2	

ELECTRICAL PLAN NOTES:

- INSTALLATION SHALL BE PER LATEST NAT'L ELECTRIC CODE.
- WIRE ALL APPLIANCES, HVAC UNITS AND OTHER EQUIPMENT PER MANUF. SPECIFICATIONS
- CONSULT WITH THE OWNER FOR THE NUMBER OF SEPERATE TELEPHONE LINES TO BE INSTALLED
- ALL SMOKE DETECTORS SHALL BE 120v W/ BATTERY BACKUP OF THE PHOTOELECTRIC TYPE, AND SHALL BE INTERLOCKED TOGETHER. INSTALL INSIDE AND NEAR ALL BEDROOMS
- TELEPHONE, TELEVISION AND OTHER LOW VOLTAGE DEVICES OR OUTLETS SHALL BE AS PER THE OWNER'S DIRECTIONS, & IN ACCORDANCE W/ APPLICABLE SECTIONS OF NEC-LATEST EDITION.
- ELECTRICAL CONTR SHALL PREPARE "AS-BUILT" SHOP DWGS INDICATING ALL ELECTRICAL WORK, INCLUDING ANY CHANGES TO THE ELEC. PLAN, ADDNS TO THE ELEC. PLAN, RISER DIAGRAM, AS-BUILT PANEL SCHEDULE W/ ALL CKTS IDENTIFIED W/ CKT N°, DESCRIPTION & BRKR, SERVICE ENT. & ALL UNDERGROUND WIRE
- LOCATIONS/ROUTING / DEPTH, RISER DIA. SHALL INCLUDE WIRE SIZES/TYPE & EQUIPMENT TYPE W/ RATINGS & LOADS.
- CONTRACTOR SHALL PROVIDE 1 COPY OF AS-BUILT DWGS TO OWNER & 1 COPY TO THE PERMIT ISSUING AUTHORITY. ALL RECEPTICALS, NOT OTHERWISE NOTED, SHALL BE ARC FAULT INTERRUPTER TYPE, EXCEPT DEDICATED OUTLETS
- ALL RECEPTICALS IN WET AREAS SHALL BE GROUND FAULT INTERRUPTER TYPE (GFI)
- ALL EXTERIOR RECEPTICALS SHALL BE WEATHERPROOF GROUD FAULT INTERRUPTER TYPE (WP/GFI)



REVISIONS SCHEDULE	
PROPOSAL	Apr. 22nd, 2024
REVISIONS	May 30th, 2024

A BARNDOMINIUM FOR:
STILWELL RESIDENCE
COLUMBIA COUNTY, FLORIDA

**RIDGEPOINT
DESIGN**
366 SW ARLINGTON BLVD. STE 101, LAKE CITY, FL 32025
P: 386-288-1188
E: RIDGEPOINTDESIGN@GMAIL.COM