

PHOTOVOLTAIC ROOF MOUNT SYSTEM

24 MODULES-ROOF MOUNTED - 9.960 kW DC, 7.600 kW AC

251 IRENE LN, LAKE CITY, FL 32055



LUNEX POWER INC.
4721 N GRADY AVE
TAMPA FL 33614
LIC #: CVC57085
PHONE: 813-540-8807

PROJECT DATA

PROJECT ADDRESS: 251 IRENE LN, LAKE CITY, FL 32055

OWNER: CHARLES DOWNING

CONTRACTOR: LUNEX POWER, 4721 N GRADY AVE TAMPA FL 33614 PHONE: 813-540-8807

DESIGNER: ESR

SCOPE: 9.960 KW DC ROOF MOUNT SOLAR PV SYSTEM WITH 24 TRINA SOLAR: TSM-NE09RC.05 415W PV MODULES WITH 24 SOLAREEDGE: S440 POWER OPTIMIZERS 01 SOLAREEDGE: SE7600H-USMNUBL15 (DOMESTIC) INVERTER

AUTHORITIES HAVING JURISDICTION:
BUILDING: COLUMBIA COUNTY
ZONING: COLUMBIA COUNTY
UTILITY: FPL

SHEET INDEX

PV-1	COVER SHEET
PV-2	SITE PLAN
PV-3	ROOF PLAN & MODULES
PV-4	ELECTRICAL PLAN
PV-5	STRUCTURAL DETAIL
PV-6	ELECTRICAL LINE DIAGRAM
PV-7	WIRING CALCULATIONS
PV-8	LABELS
PV-9	PLACARD
PV-10	OPTIMIZER CHART
PV-11+	EQUIPMENT SPECIFICATIONS

GENERAL NOTES

- ALL COMPONENTS ARE UL LISTED AND CEC CERTIFIED, WHERE WARRANTED.
- THE SOLAR PV SYSTEM WILL BE INSTALLED IN ACCORDANCE WITH ARTICLE 690 OF THE NEC 2020.
- THE UTILITY INTERCONNECTION APPLICATION MUST BE APPROVED AND PV SYSTEM INSPECTED PRIOR TO PARALLEL OPERATION.
- ALL CONDUCTORS OF A CIRCUIT, INCLUDING THE EGC, MUST BE INSTALLED IN THE SAME RACEWAY, OR CABLE, OR OTHERWISE RUN WITH THE PV ARRAY CIRCUIT CONDUCTORS WHEN THEY LEAVE THE VICINITY OF THE PV ARRAY.
- WHERE METALLIC CONDUIT CONTAINING DC CONDUCTORS IS USED INSIDE THE BUILDING, IT SHALL BE IDENTIFIED AS "CAUTION: SOLAR CIRCUIT" EVERY 10FT.
- HEIGHT OF THE AC DISCONNECT SHALL NOT EXCEED 6'-7" PER NEC CODE 240.24.
- A GROUNDING ELECTRODE SYSTEM IN ACCORDANCE WITH NEC 2020 690.47 AND 250.50 THROUGH 60 AND 250-166 SHALL BE PROVIDED. PER NEC GROUNDING ELECTRODE SYSTEM OF EXISTING BUILDING MAY BE USED AND BONDED TO THE SERVICE ENTRANCE. IF EXISTING SYSTEM IS INACCESSIBLE OR INADEQUATE A SUPPLEMENTAL GROUNDING ELECTRODE WILL BE USED AT THE INVERTER LOCATION CONSISTING OF A UL LISTED 8 FT. GROUND ROD WITH ACORN CLAMP. GROUNDING ELECTRODE CONDUCTORS SHALL BE NO LESS THAN #8 AWG AND NO LARGER THAN #6 AWG COPPER AND BONDED TO THE EXISTING GROUNDING ELECTRODE TO PROVIDE FOR A COMPLETE SYSTEM.
- PHOTOVOLTAIC MODULES ARE TO BE CONSIDERED NON-COMBUSTIBLE.
- PHOTOVOLTAIC INSTALLATION WILL NOT OBSTRUCT ANY PLUMBING. MECHANICAL, OR BUILDING ROOF VENTS.
- ALL WIRING MUST BE PROPERLY SUPPORTED BY DEVICES OR MECHANICAL MEANS DESIGNED AND LISTED FOR SUCH USE. WIRING MUST BE PERMANENTLY AND COMPLETELY HELD OFF THE ROOF SURFACE.
- ALL SIGNAGE TO BE PLACED IN ACCORDANCE WITH THE LOCAL BUILDING CODE. IF EXPOSED TO SUNLIGHT, IT SHALL BE UV RESISTANT. ALL PLAQUES AND SINAGE WILL BE INSTALLED AS REQUIRED BY THE NEC AND AHJ.
- INVERTER(S) USED IN UNGROUNDED SYSTEM SHALL BE UL 1741 LISTED.
- THE INSTALLATION OF EQUIPMENT AND ALL ASSOCIATED WIRING AND INTERCONNECTION SHALL BE PERFORMED ONLY BY QUALIFIED PERSONS [NEC 690.4(C)]
- ALL OUTDOOR EQUIPMENT SHALL BE NEMA 3R RATED (OR BETTER), INCLUDING ALL ROOF MOUNTED TRANSITION BOXES AND SWITCHES.
- ALL EQUIPMENT SHALL BE PROPERLY GROUNDED AND BONDED IN ACCORDANCE WITH NEC ARTICLE 250.
- SYSTEM GROUNDING SHALL BE IN ACCORDANCE WITH NEC 690.41.
- PV SYSTEM CIRCUITS INSTALLED ON OR IN BUILDINGS SHALL INCLUDE A RAPID SHUTDOWN FUNCTION IN ACCORDANCE WITH NEC 690.12
- DISCONNECTING MEANS SHALL BE LOCATED IN A VISIBLE, READILY ACCESSIBLE LOCATION WITHIN THE PV SYSTEM EQUIPMENT OR A MAXIMUM OF 10 FEET AWAY FROM THE SYSTEM [NEC 690.13(A)]
- ALL WIRING METHODS SHALL BE IN ACCORDANCE WITH NEC 690.31
- WORK CLEARANCES AROUND ELECTRICAL EQUIPMENT WILL BE MAINTAINED PER NEC 110.26(A)(1), 110.26(A)(2) AND 110.26(A)(3).
- ROOFTOP MOUNTED PHOTOVOLTAIC PANELS AND MODULES SHALL BE TESTED, LISTED & IDENTIFIED IN ACCORDANCE WITH UL1703
- ELECTRICAL CONTRACTOR TO PROVIDE CONDUIT EXPANSION JOINTS AND ANCHOR CONDUIT RUNS AS REQUIRED PER NEC.

VICINITY MAP



HOUSE PHOTO



CODE REFERENCES


PROJECT TO COMPLY WITH THE FOLLOWING:

FLORIDA RESIDENTIAL CODE, 8TH EDITION 2023 (FRC)
FLORIDA PLUMBING CODE, 8TH EDITION 2023 (FPC)
FLORIDA BUILDING CODE, 8TH EDITION 2023 EDITION (FBC)
FLORIDA MECHANICAL CODE, 8TH EDITION 2023 (FMC)
2020 NATIONAL ELECTRICAL CODE
FLORIDA FIRE PREVENTION CODE, 8TH EDITION 2023 (FFPC)

Andrew D. Leone
Digitally signed by Andrew D. Leone
Date: 2025.03.05 15:46:38 -05'00'

REVISIONS

DESCRIPTION	DATE	REV

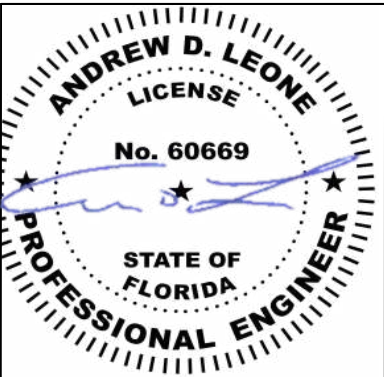

DATE: 03/05/2025

PROJECT NAME & ADDRESS

CHARLES DOWNING
RESIDENCE
251 IRENE LN,
LAKE CITY, FL 32055

DRAWN BY

ESR

SHEET NAME

COVER SHEET

SHEET SIZE

ANSI B
11" X 17"

SHEET NUMBER

PV-1

PROFESSIONAL ENGINEER SEAL

This item has been digitally signed and sealed by Andrew D. Leone on the date adjacent to the seal.

Printed copies of this document are not considered signed and sealed and the signature must be verified on any electronic copies.

PROJECT DESCRIPTION:

24 X TRINA SOLAR: TSM-NE09RC.05 415W PV MODULES
ROOF MOUNTED SOLAR PHOTOVOLTAIC MODULES
DC SYSTEM SIZE: 24 x 415 = 9.960KW DC
AC SYSTEM SIZE: 01 x 7.600 = 7.600KW AC

EQUIPMENT SUMMARY
24 TRINA SOLAR: TSM-NE09RC.05 415W MONO MODULES
24 SOLAREEDGE: S440 POWER OPTIMIZERS
01 SOLAREEDGE: SE7600H-USMNUBL15 (DOMESTIC) INVERTER

ROOF ARRAY AREA #1:- 344.00 SQ FT.
ROOF ARRAY AREA #2:- 172.00 SQ FT.



NOTE: VISIBLE, LOCKABLE, LABELED AC DISCONNECT
LOCATED WITHIN 10' OF UTILITY METER

(E) DETACHED
STRUCTURE (TYP.)

This item has been digitally
signed and sealed by
Andrew D. Leone on the date
adjacent to the seal.


Printed copies of this
document are not considered
signed and sealed and the
signature must be verified on
any electronic copies.

ROOF #2
(8) TRINA SOLAR:TSM-NE09RC.05
415W MONO MODULES WITH SOLAREEDGE:
S440 POWER OPTIMIZERS
ROOF #1
(16) TRINA SOLAR:TSM-NE09RC.05
415W MONO MODULES WITH SOLAREEDGE:
S440 POWER OPTIMIZERS

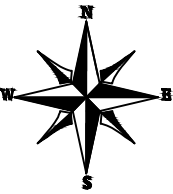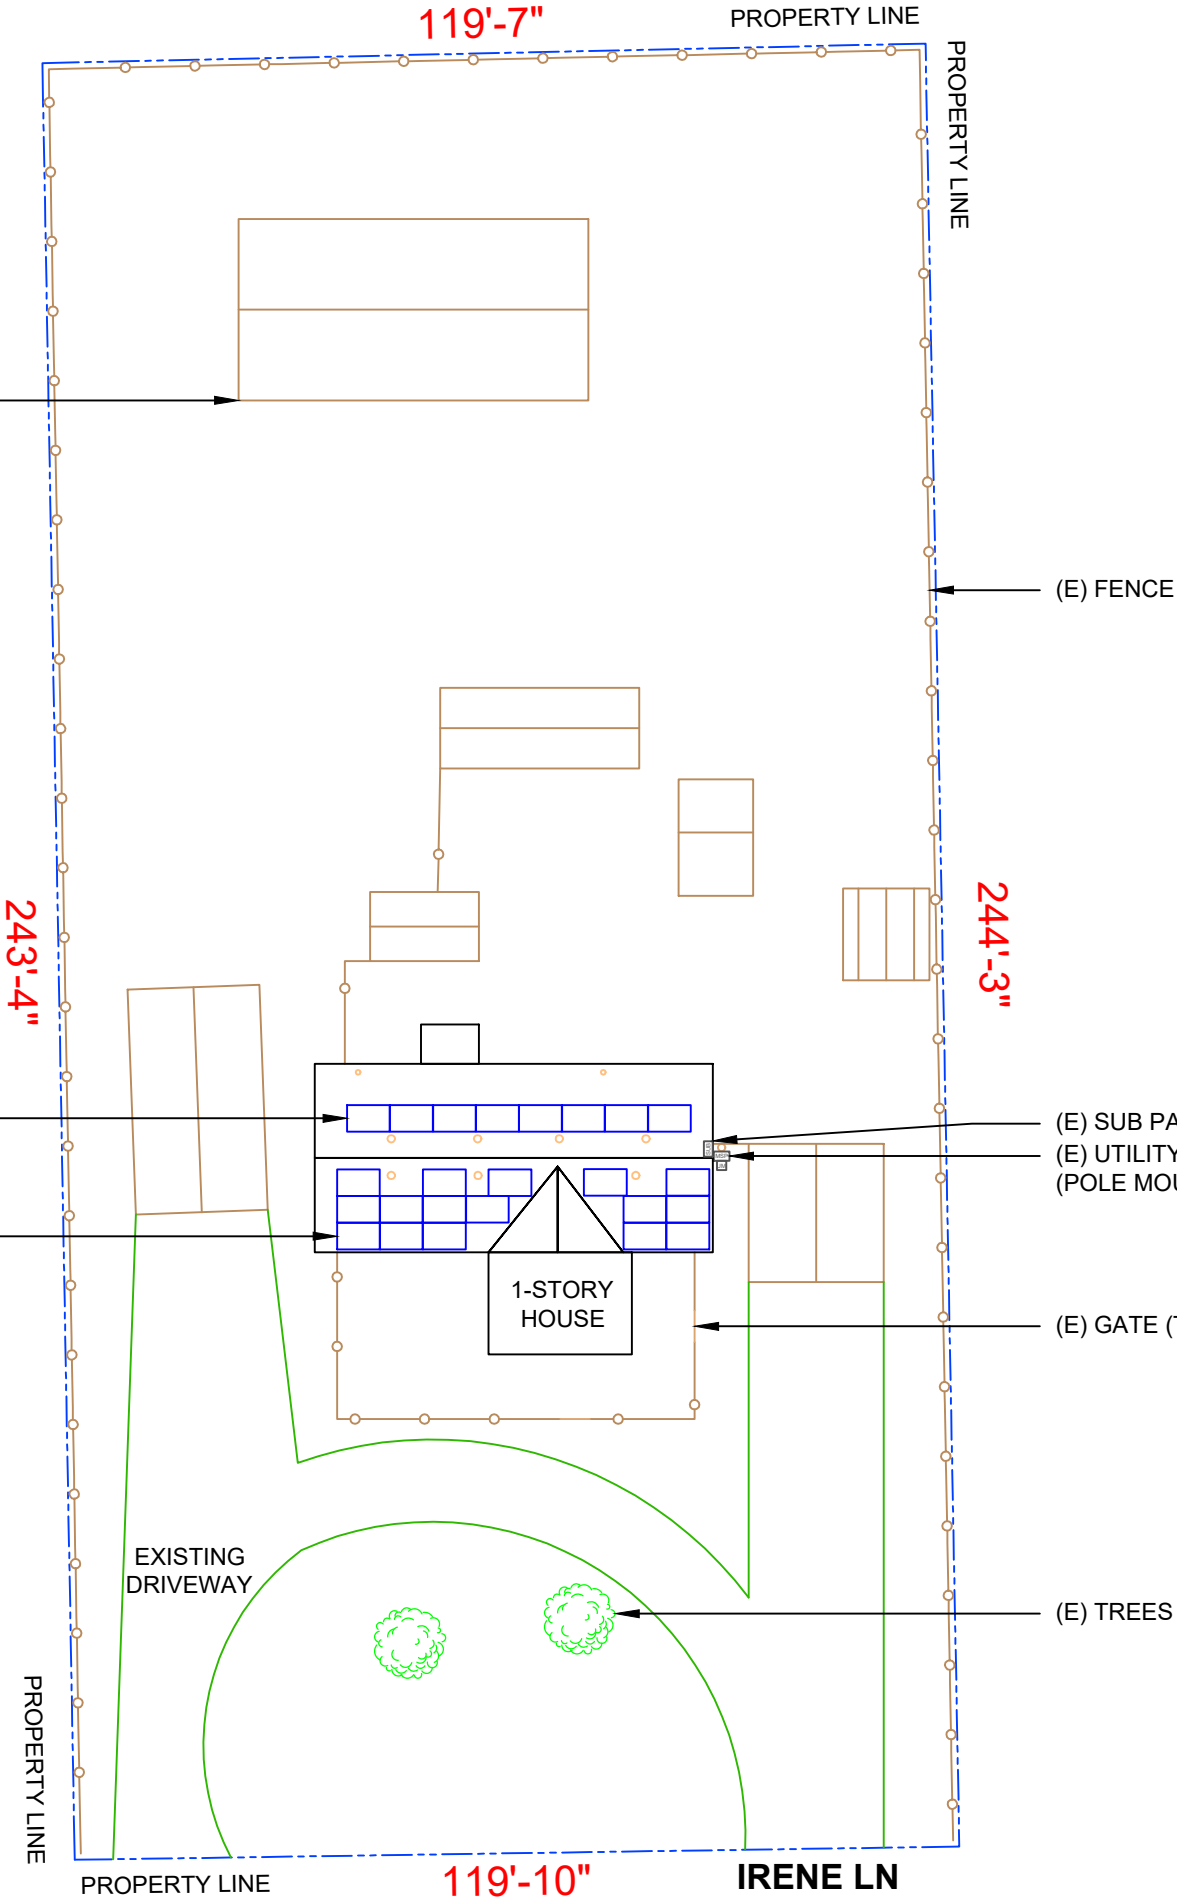

LUNEX POWER INC.
4721 N GRADY AVE
TAMPA FL 33614
LIC #: CVC57085
PHONE: 813-540-8807

REVISIONS		
DESCRIPTION	DATE	REV

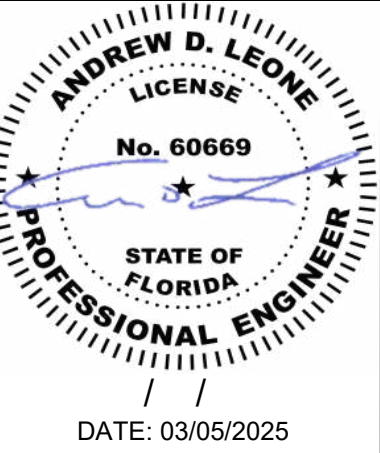

PROJECT NAME & ADDRESS

CHARLES DOWNING
RESIDENCE
251 IRENE LN,
LAKE CITY, FL 32055

DRAWN BY
ESR


SHEET NAME
SITE PLAN

SHEET SIZE
ANSI B
11" X 17"

SHEET NUMBER
PV-2

MODULE TYPE, DIMENSIONS & WEIGHT

NUMBER OF MODULES = 24 MODULES
MODULE TYPE = TRINA SOLAR: TSM-NE09RC.05 415W MONO MODULES
MODULE WEIGHT = 47.0 LBS / 21.3KG.
MODULE DIMENSIONS = 69.37" x 44.65" = 21.50 SF

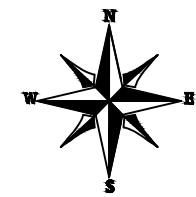


ARRAY AREA & ROOF AREA CALC'S				
ROOF	# OF MODULES	ARRAY AREA (Sq. Ft.)	ROOF AREA (Sq. Ft.)	ROOF AREA COVERED BY ARRAY (%)
#1	16	344.00	581.89	59
#2	8	172.00	687.54	25
TOTAL	24	516.00	1684.48	31

ROOF DESCRIPTION				
ROOF TYPE		ASPHALT SHINGLE		
ROOF	ROOF PITCH	AZIMUTH	TRUSS SIZE	TRUSS SPACING
#1	15°	180°	2"X2"	24"
#2	15°	0°	2"X2"	24"



LUNEX POWER INC.
4721 N GRADY AVE
TAMPA FL 33614
LIC #: CVC57085
PHONE: 813-540-8807

REVISIONS		
DESCRIPTION	DATE	REV

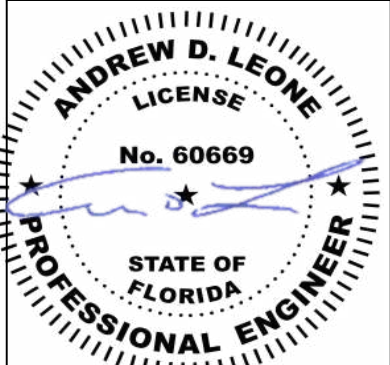

DATE: 03/05/2025

PROJECT NAME & ADDRESS

CHARLES DOWNING
RESIDENCE

251 IRENE LN,
LAKE CITY, FL 32055

DRAWN BY

ESR

SHEET NAME


ROOF PLAN & MODULES

SHEET SIZE

ANSI B
11" X 17"

SHEET NUMBER

PV-3

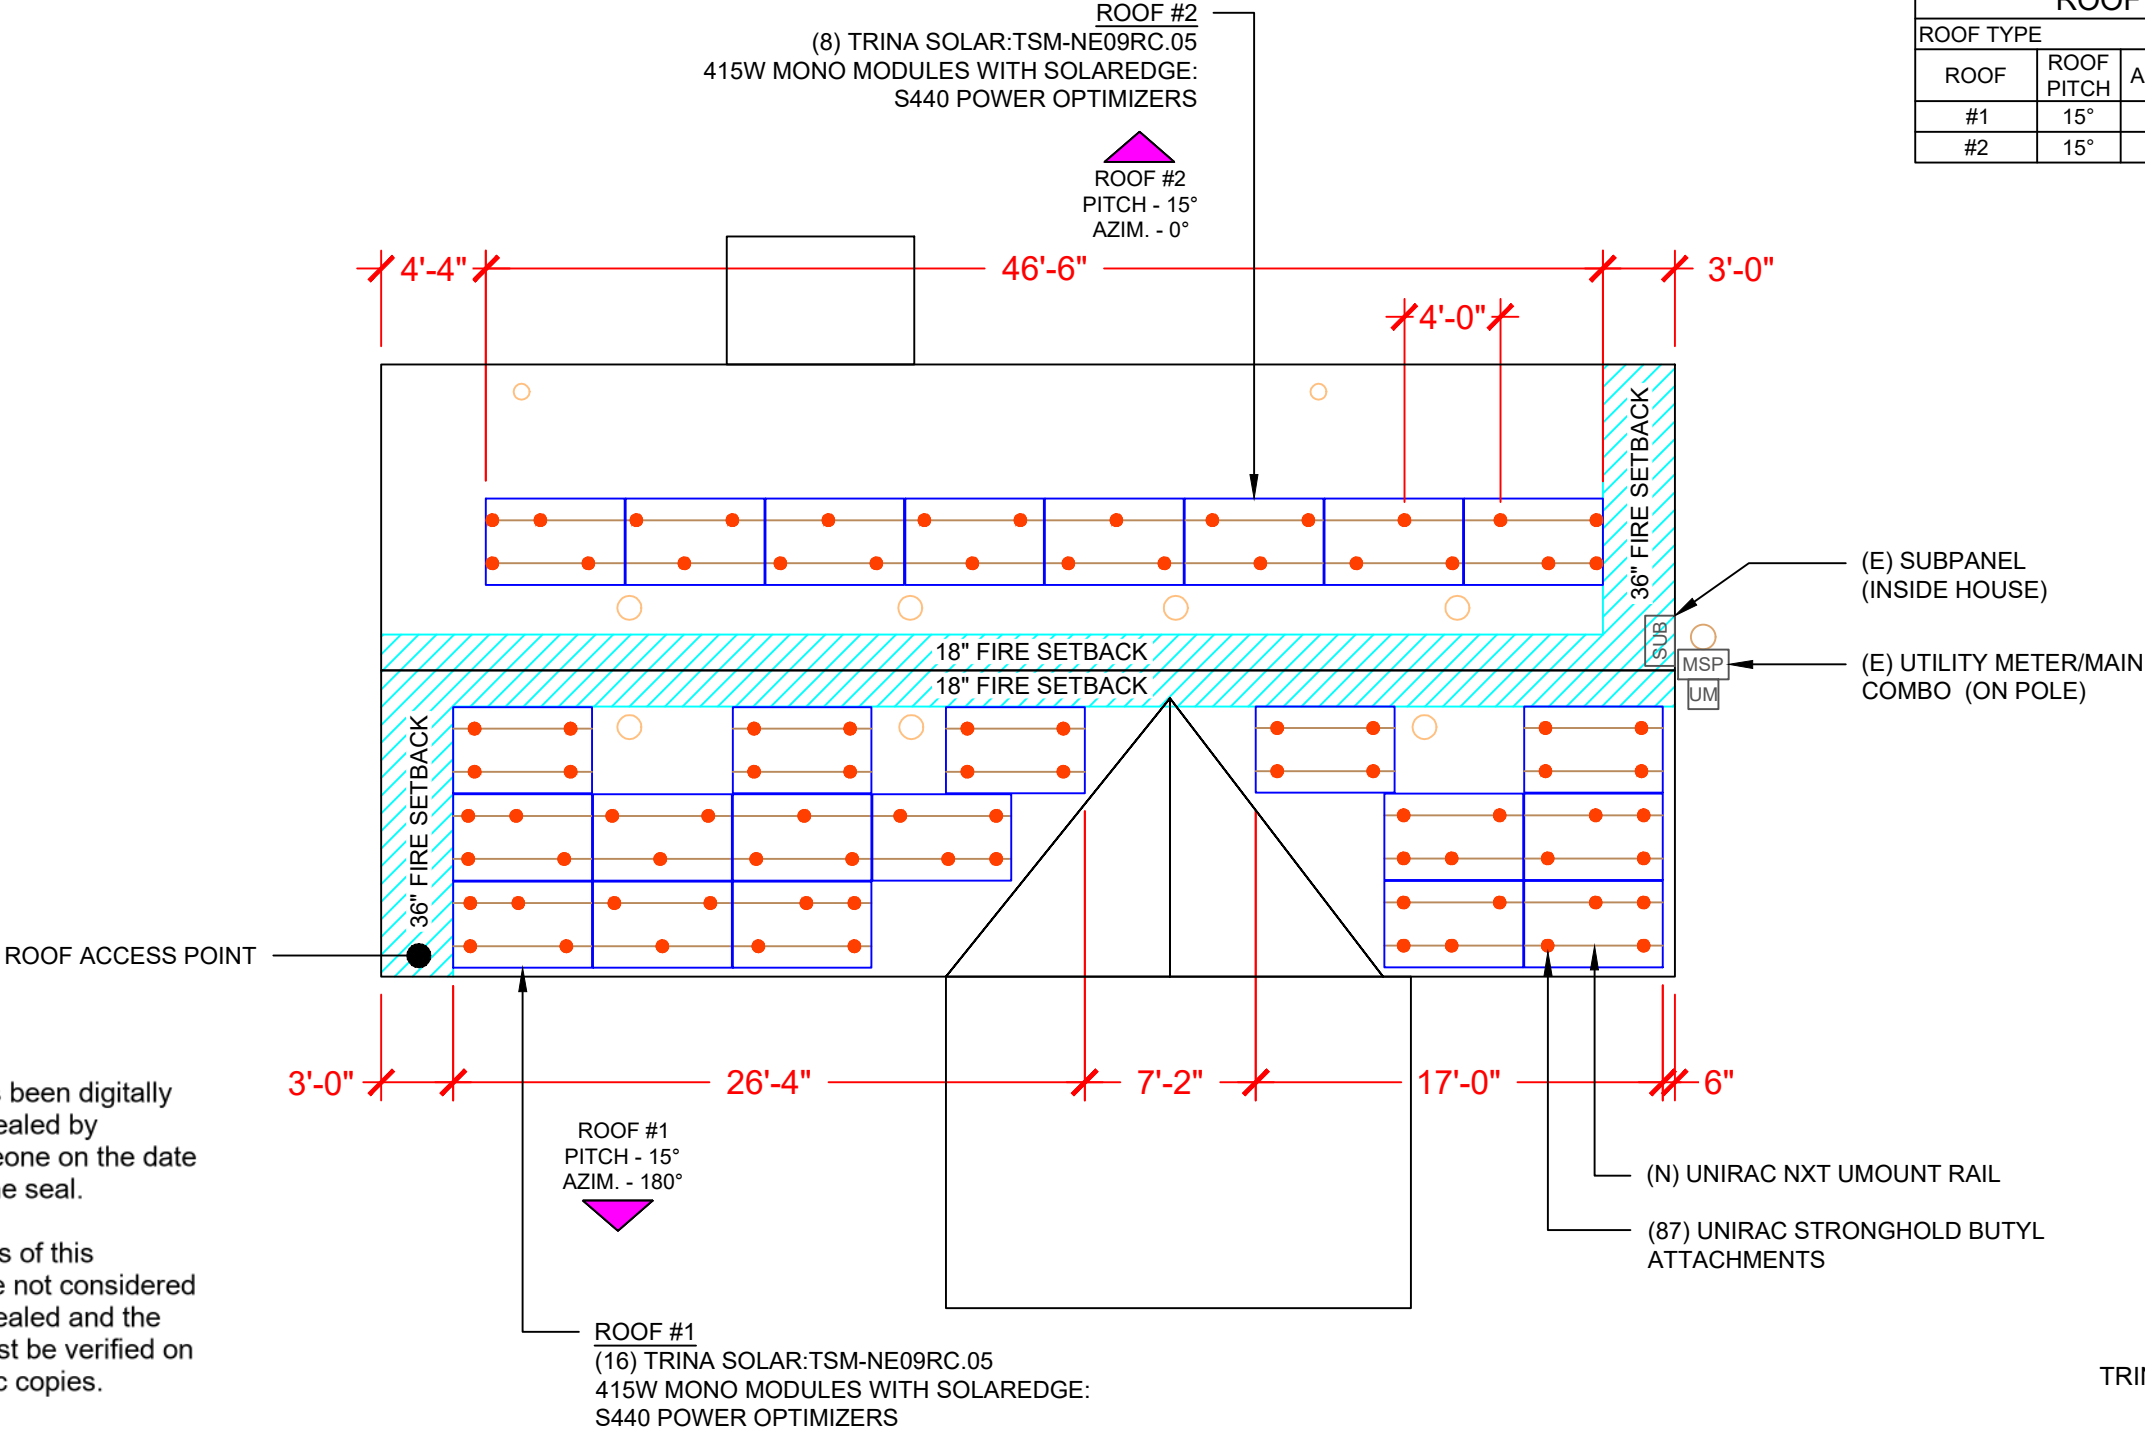

LEGEND

- VENT, ATTIC FAN
(ROOF OBSTRUCTION)

- ROOF ATTACHMENT


- MAIN SERVICE PANEL

- UTILITY METER

CIRCUIT LEGENDS

STRING #1

STRING #2

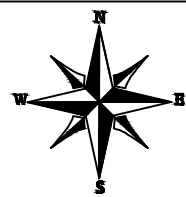

This item has been digitally signed and sealed by Andrew D. Leone on the date adjacent to the seal.

Printed copies of this document are not considered signed and sealed and the signature must be verified on any electronic copies.

LEGEND

JB

- JUNCTION BOX

INV

- INVERTER

ACD

- AC DISCONNECT

UM

- UTILITY METER

MSP

- MAIN SERVICE PANEL

- CONDUIT

LUNEX POWER

THE PURE SOURCE

LUNEX POWER INC.
4721 N GRADY AVE
TAMPA FL 33614
LIC #: CVC57085
PHONE: 813-540-8807

REVISIONS		
DESCRIPTION	DATE	REV

ANDREW D. LEONE

LICENSE

No. 60669

STATE OF FLORIDA

PROFESSIONAL ENGINEER

/ /

DATE: 03/05/2025

PROJECT NAME & ADDRESS

CHARLES DOWNING
RESIDENCE

251 IRENE LN,
LAKE CITY, FL 32055

DRAWN BY

ESR

SHEET NAME


ELECTRICAL PLAN

SHEET SIZE

ANSI B
11" X 17"

SHEET NUMBER

PV-4

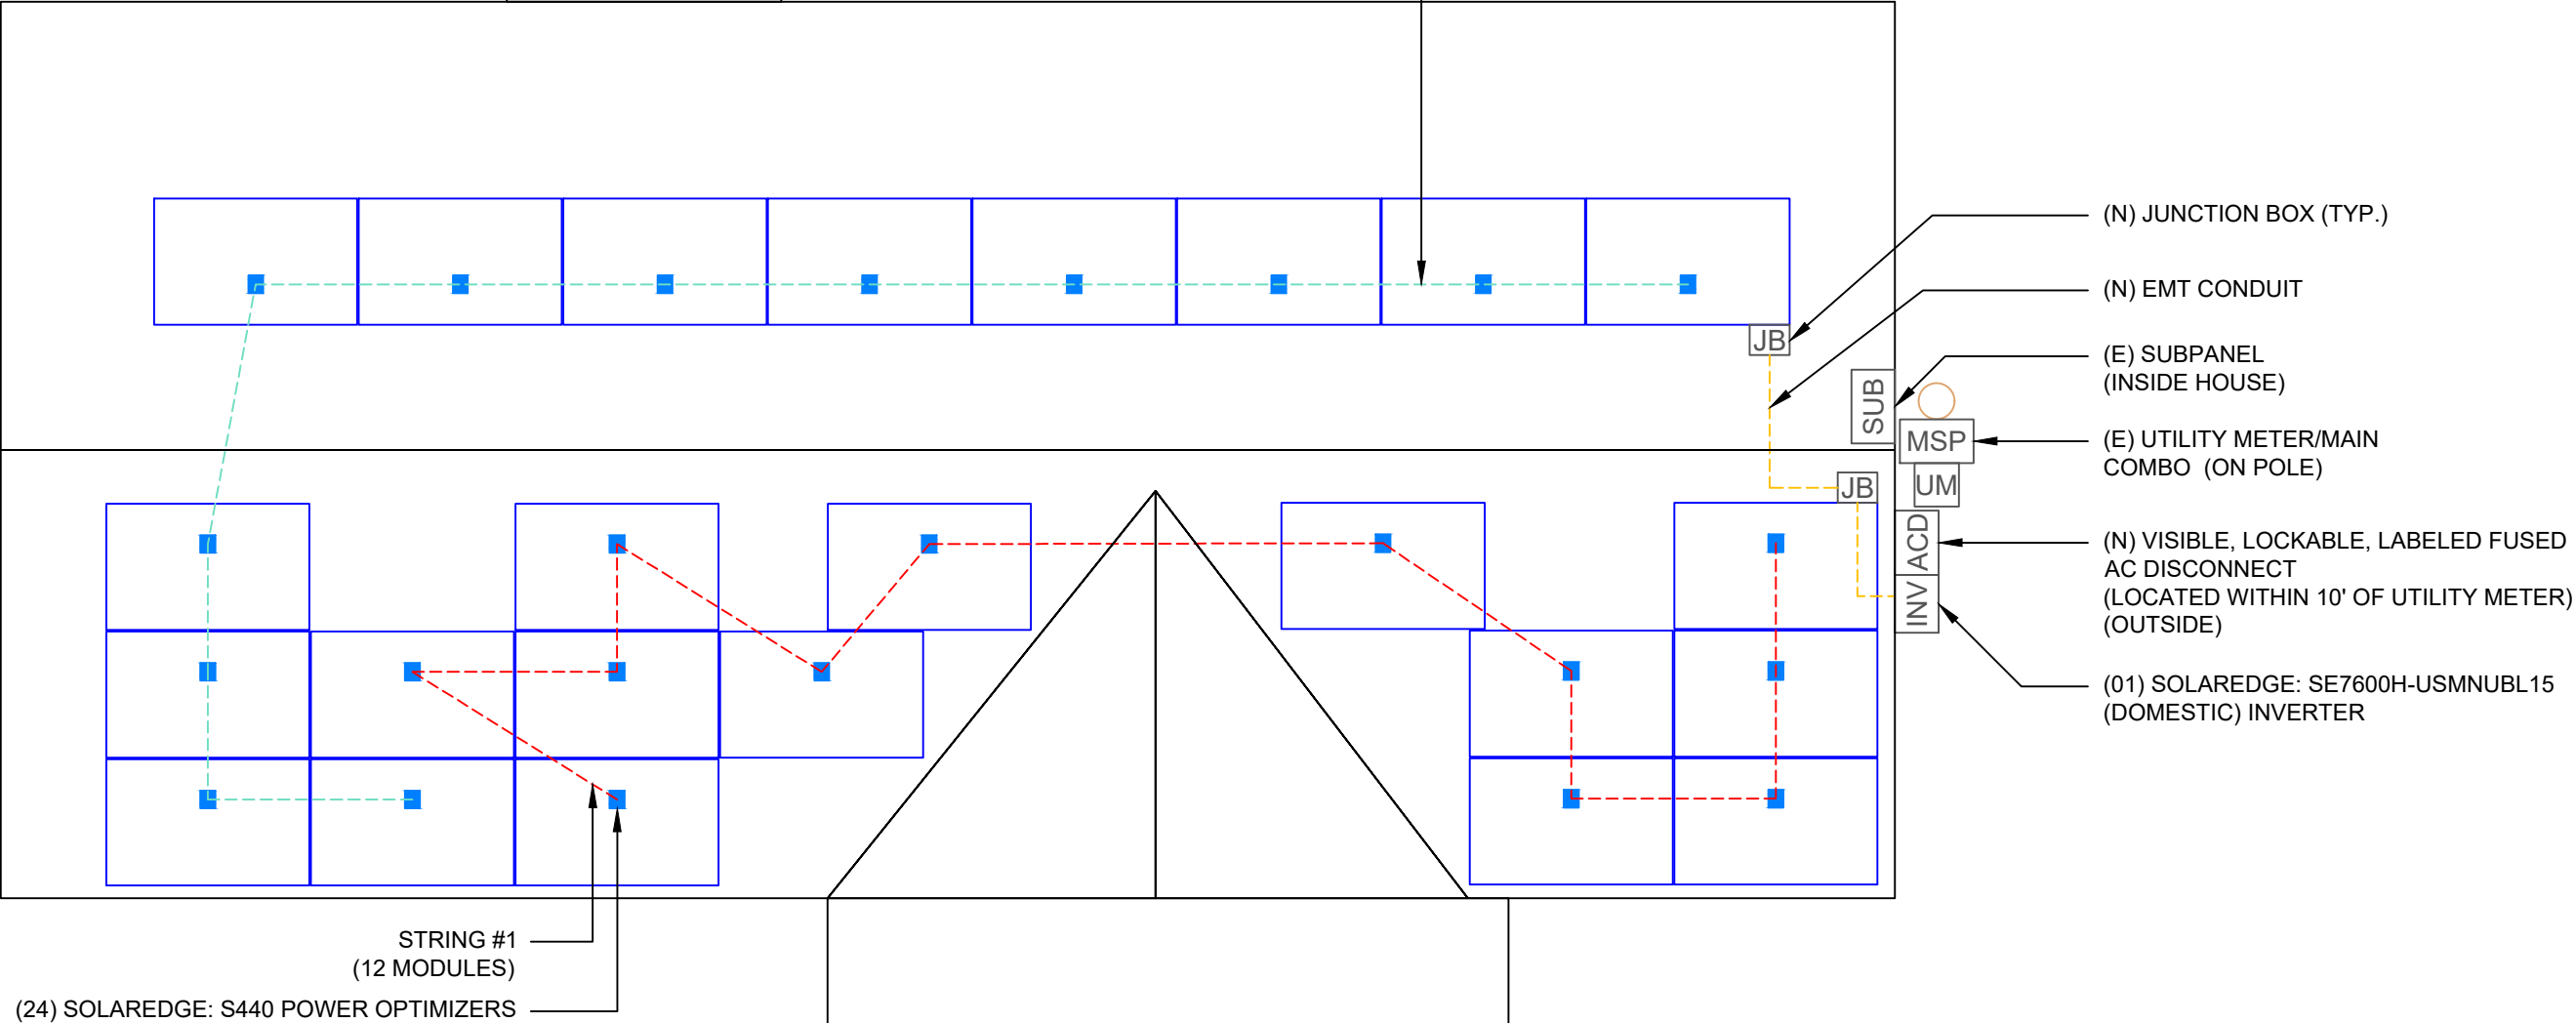

BILL OF MATERIALS		
EQUIPMENT	QTY	DESCRIPTION
SOLAR PV MODULES	24	TRINA SOLAR: TSM-NE09RC.05 415W MODULE
POWER OPTIMIZERS	24	SOLAREEDGE: S440 POWER OPTIMIZERS
INVERTER	1	SOLAREEDGE: SE7600H-USMNUBL15 (DOMESTIC) INVERTER
JUNCTION BOX	2	JUNCTION BOXES
RAILS	20	UNIRAC NXT U MOUNT RAIL
SPLICES	10	SPLICE KIT
MID MODULE CLAMPS	28	MID MODULE CLAMPS
END CLAMPS	40	END CLAMPS / STOPPER SLEEVE
ATTACHMENTS	87	UNIRAC STRONGHOLD BUTYL ATTACHMENTS


1

ELECTRICAL PLAN

PV-4

SCALE: 3/16" = 1'-0"


DESCRIPTION: CANTILEVER
CANTILEVER CONSIDER 1/3RD OF ROOF ATTACHMENT SPACING.
ATTACHMENT SPACING= 48" O/C
CANTILEVER = 16"

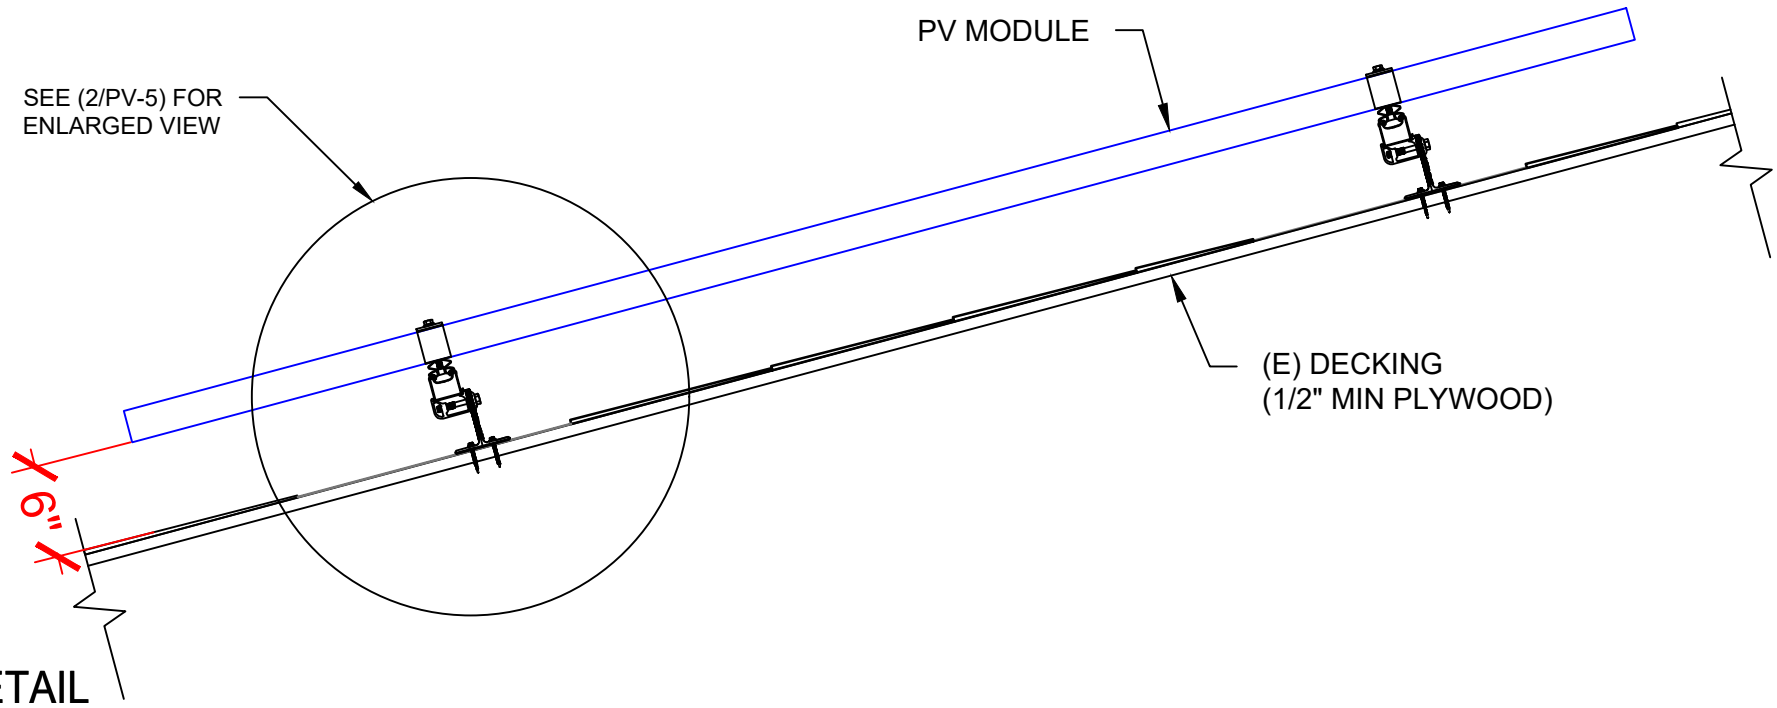

1 ATTACHMENT DETAIL
PV-5 SCALE: NTS

This item has been digitally signed and sealed by Andrew D. Leone on the date adjacent to the seal.

Printed copies of this document are not considered signed and sealed and the signature must be verified on any electronic copies.

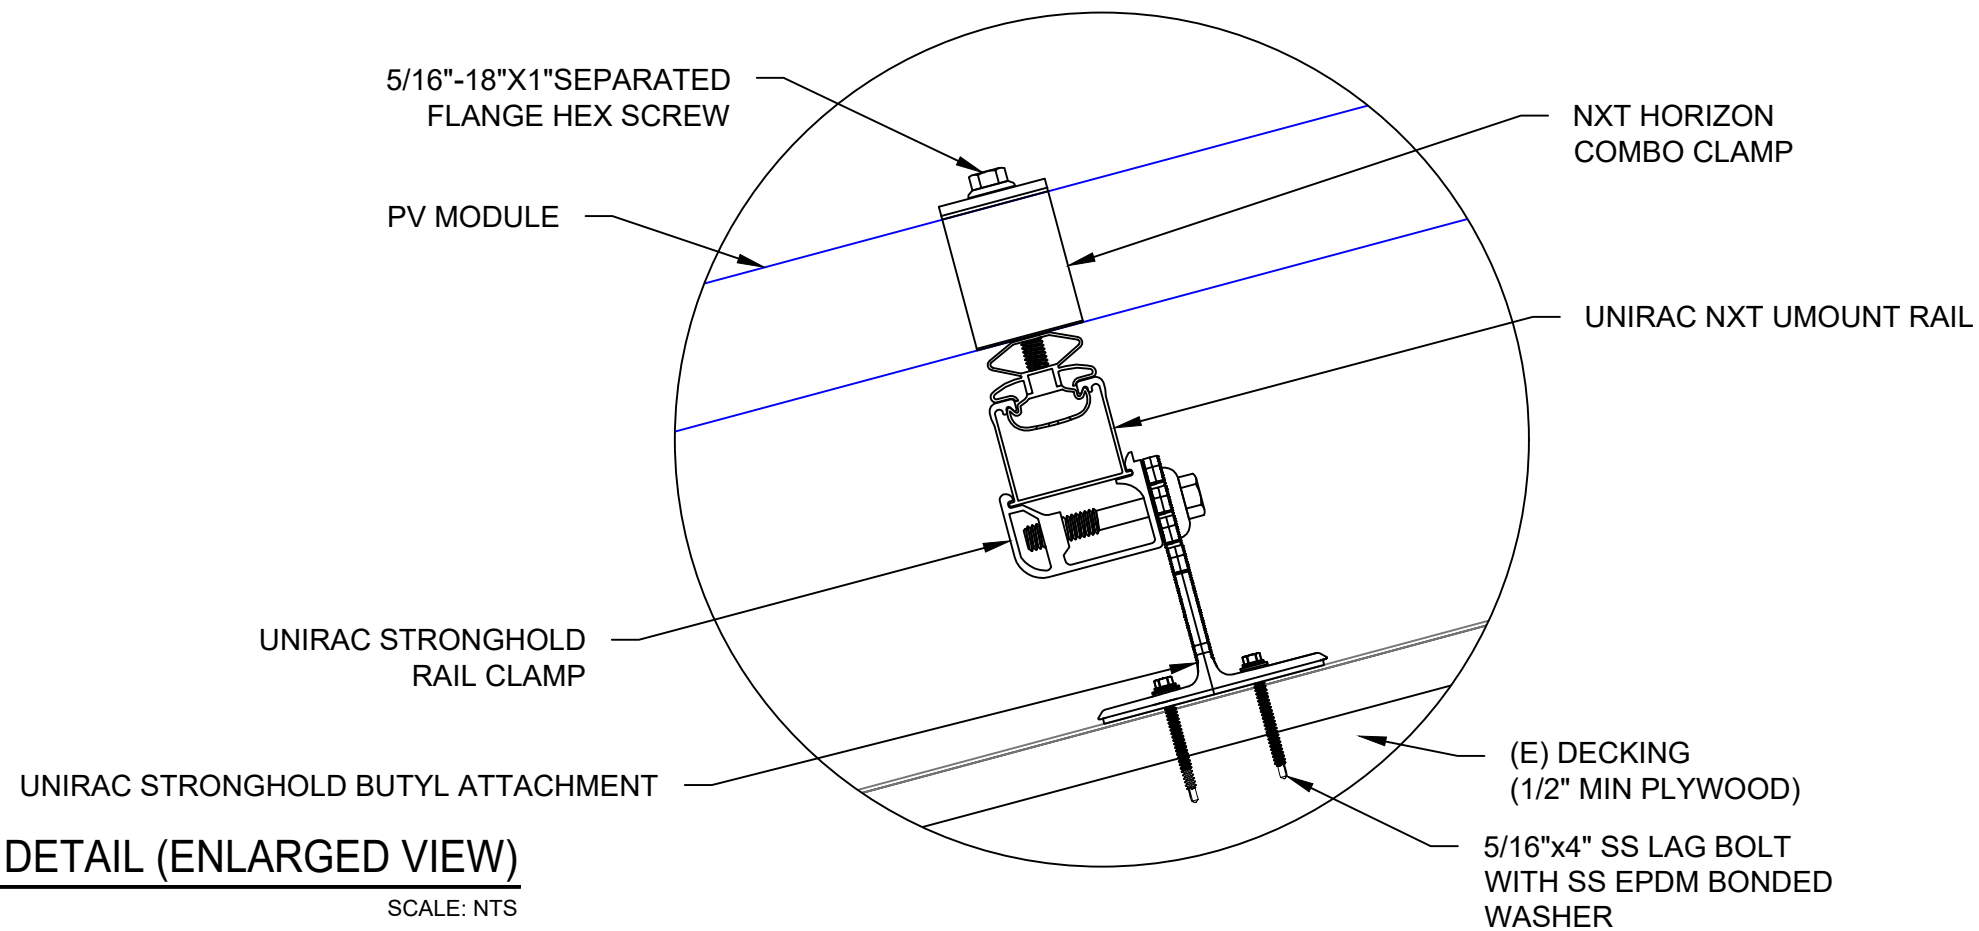


2 ATTACHMENT DETAIL (ENLARGED VIEW)
PV-5 SCALE: NTS



LUNEX POWER INC.
4721 N GRADY AVE
TAMPA FL 33614
LIC #: CVC57085
PHONE: 813-540-8807

REVISIONS		
DESCRIPTION	DATE	REV

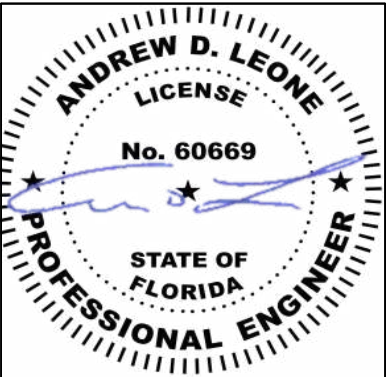

DATE: 03/05/2025

PROJECT NAME & ADDRESS

CHARLES DOWNING
RESIDENCE
251 IRENE LN,
LAKE CITY, FL 32055

DRAWN BY
ESR

SHEET NAME
STRUCTURAL DETAIL

SHEET SIZE
ANSI B
11" X 17"

SHEET NUMBER
PV-5

DC SYSTEM SIZE: 24 x 415 = 9.960KW DC
AC SYSTEM SIZE: 01 x 7.600 = 7.600KW AC

(24) TRINA SOLAR: TSM-NE09RC.05 415W MONO MODULES WITH
(24) SOLAREEDGE: S440 POWER OPTIMIZERS
01 SOLAREEDGE: SE7600H-USMNUBL15 (DOMESTIC) INVERTER

(2) BRANCH CIRCUITS OF 12 MODULES ARE CONNECTED IN PARALLEL

INTERCONNECTION NOTES:

1. INTERCONNECTION SIZING, LIMITATIONS AND COMPLIANCE DETERMINED IN ACCORDANCE WITH [NEC 705.12], AND [NEC 690.59].
2. GROUND FAULT PROTECTION IN ACCORDANCE WITH [NEC 215.9], [NEC 230.95].
3. ALL EQUIPMENT TO BE RATED FOR BACKFEEDING.
4. PV BREAKER TO BE POSITIONED AT THE OPPOSITE END OF THE BUSBAR RELATIVE TO THE MAIN BREAKER.

DISCONNECT NOTES:

1. DISCONNECTING SWITCHES SHALL BE WIRED SUCH THAT WHEN THE SWITCH IS OPENED THE CONDUCTORS REMAINING LIVE ARE CONNECTED TO THE TERMINALS MARKED "LINE SIDE" (TYPICALLY THE UPPER TERMINALS)
2. AC DISCONNECT MUST BE ACCESSIBLE TO QUALIFIED UTILITY PERSONNEL, BE LOCKABLE, AND BE A VISIBLE-BREAK SWITCH
3. DISCONNECT MEANS AND THEIR LOCATION SHALL BE IN ACCORDANCE WITH [NEC 225.31] AND [NEC 225.32].

RACKING NOTES:


1. BOND EVERY OTHER RAIL WITH #6 BARE COPPER

GROUNDING & GENERAL NOTES:

1. **GROUNDING ELECTRODES AND GROUNDING ELECTRODE CONDUCTORS.** ADDITIONAL GROUNDING ELECTRODES SHALL BE PERMITTED TO BE INSTALLED IN ACCORDANCE WITH 250.52 AND 250.54. GROUNDING ELECTRODES SHALL BE PERMITTED TO BE CONNECTED DIRECTLY TO THE PV MODULE FRAME(S) OR SUPPORT STRUCTURE PER [NEC 690.47(B)]
2. PV INVERTER IS UNGROUNDED, TRANSFORMER-LESS TYPE.
3. DC GEC AND AC EGC TO REMAIN UNSPLICED, OR SPLICED TO EXISTING ELECTRODE
4. ANY EXISTING WIRING INVOLVED WITH PV SYSTEM CONNECTION THAT IS FOUND TO BE INADEQUATE PER CODE SHALL BE CORRECTED PRIOR TO FINAL INSPECTION.
5. JUNCTION BOX QUANTITIES, AND PLACEMENT SUBJECT TO CHANGE IN THE FIELD - JUNCTION BOX DEPICTED ON ELECTRICAL DIAGRAM REPRESENT WIRE TYPE TRANSITIONS.
6. AC DISCONNECT NOTED IN EQUIPMENT SCHEDULE OPTIONAL IF OTHER AC DISCONNECTING MEANS IS LOCATED WITHIN 10' OF SERVICE DISCONNECT.
7. RACEWAYS AND CABLES EXPOSED TO SUNLIGHT ON ROOFTOPS SHOULD BE INSTALLED MORE THAN 7/8" ABOVE THE ROOF USING CONDUIT SUPPORTS.

INSTALLER / ELECTRICIAN NOTE:

EC IS TO MEASURE VOLTAGE BEFORE STARTING WORK.
IF RESULT IS ANY OTHER VOLTAGE MEASURED THAN 120/240V IS OBSERVED, DO NOT PROCEED. CONTACT ENGINEER.

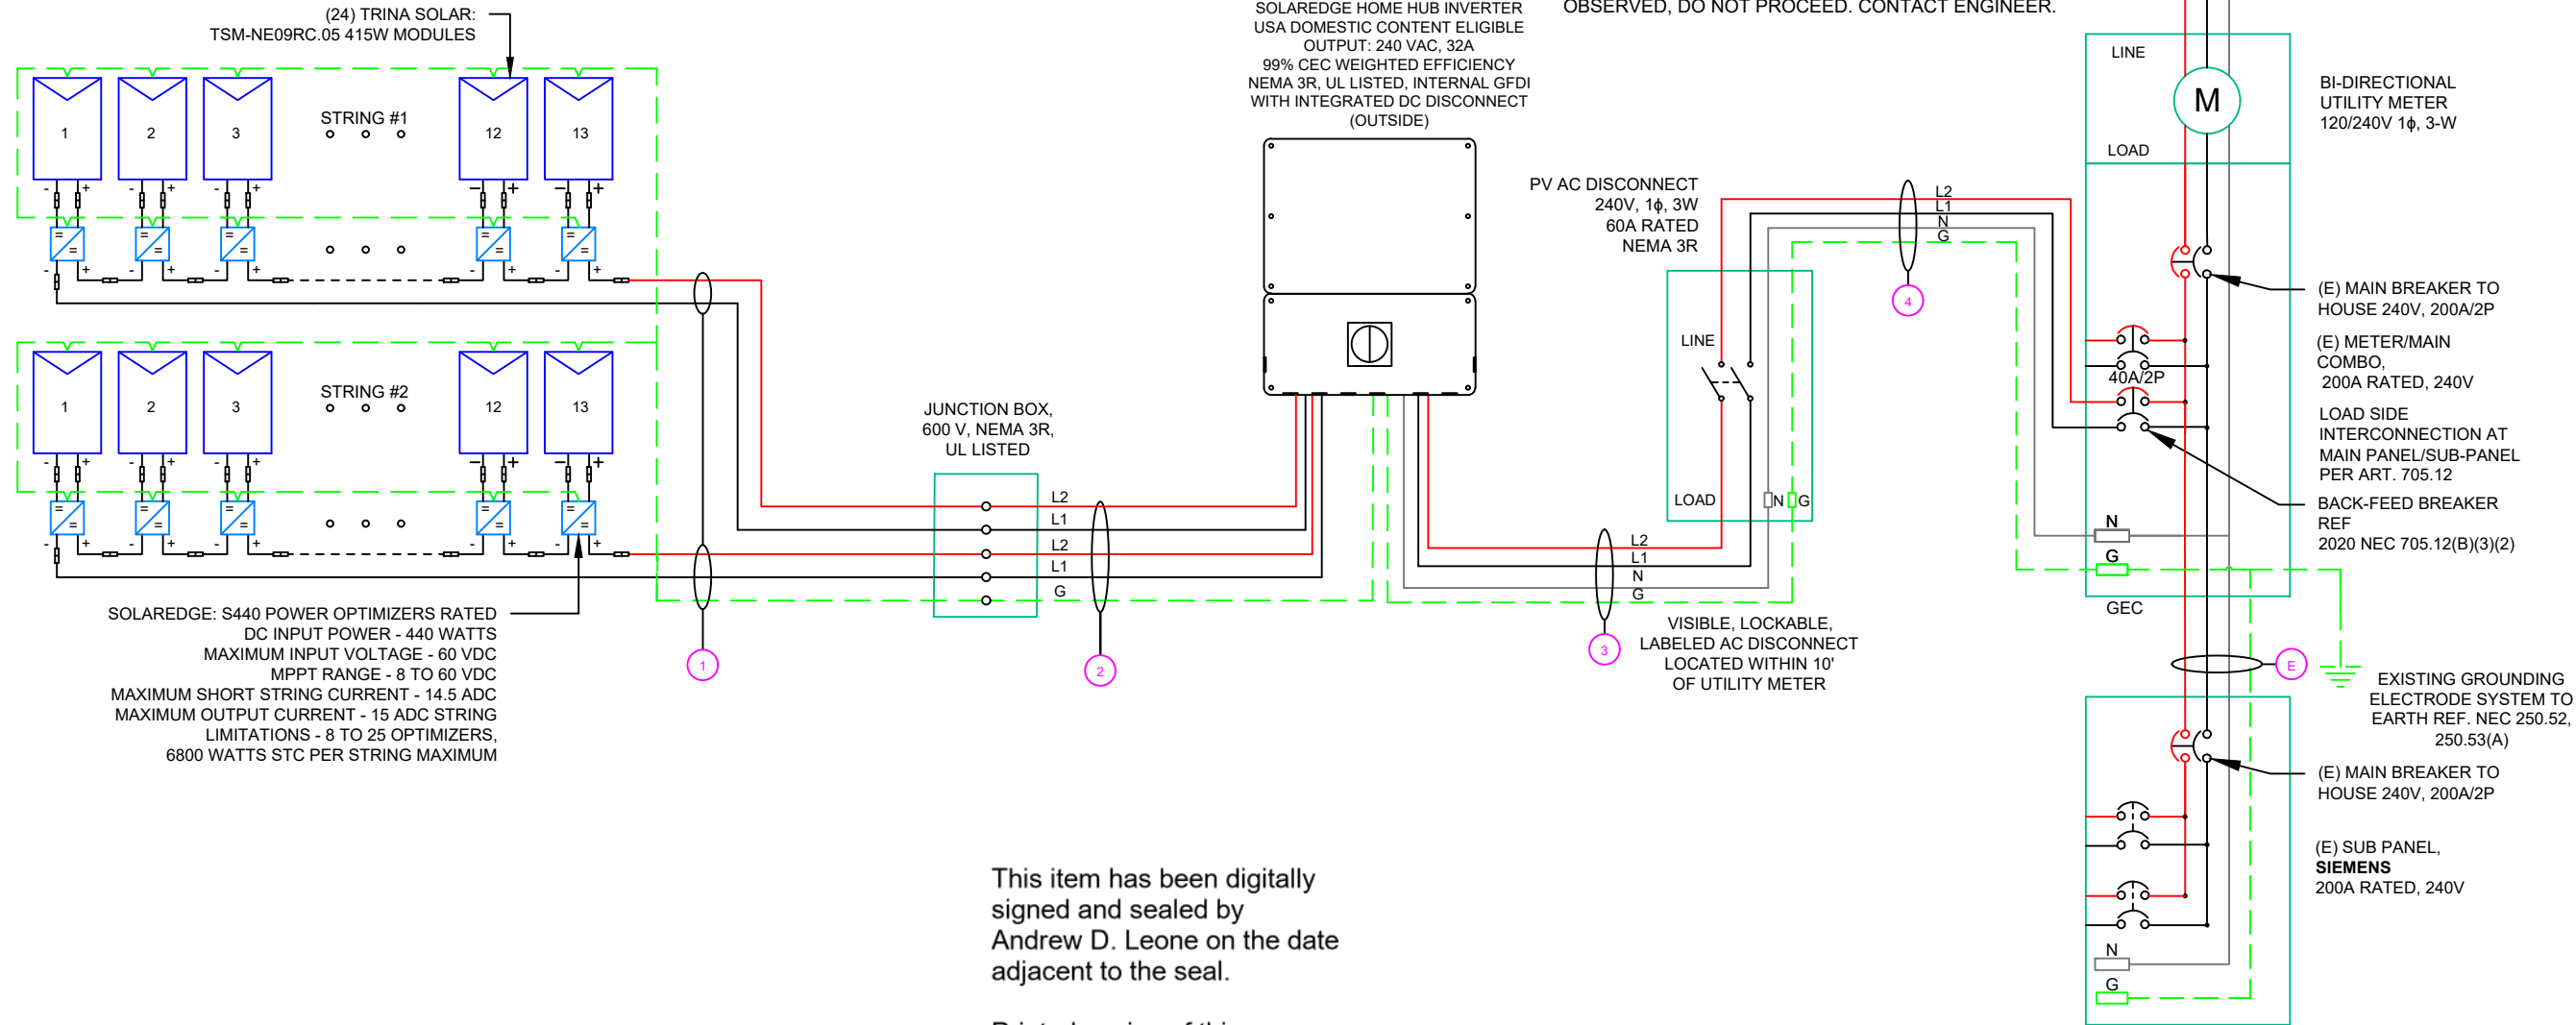


This item has been digitally
signed and sealed by
Andrew D. Leone on the date
adjacent to the seal.

Printed copies of this
document are not considered
signed and sealed and the
signature must be verified on
any electronic copies.

QTY	CONDUCTOR INFORMATION		CONDUIT TYPE	CONDUIT SIZE
① (4)	CU#10AWG -	PV WIRE/USE-2	N/A	N/A
(1)	CU#6AWG -	BARE COPPER IN FREE AIR		
② (4)	CU#10AWG -	THWN-2 (L1,L2)	EMT OR LFMC IN ATTIC	3/4"
(1)	CU#10AWG -	THWN-2 GND		
(2)	CU#8AWG -	THWN-2 (L1,L2)	EMT OR LFMC IN ATTIC	3/4"
(1)	CU#8AWG -	THWN-2 N		
(1)	CU#10AWG -	THWN-2 GND	EMT, LFMC OR LFNC	3/4"
(3)	CU#8AWG -	THWN-2 (L1,L2,N)		
(1)	CU#10AWG -	THWN-2 GND		

REVISIONS		
DESCRIPTION	DATE	REV

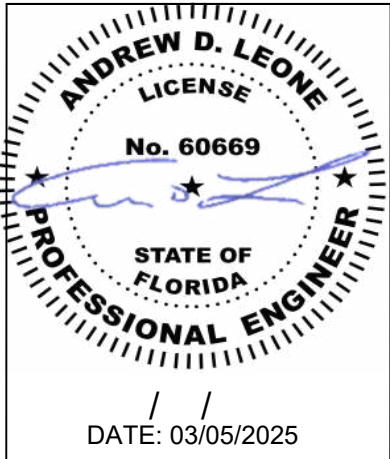

PROJECT NAME & ADDRESS

CHARLES DOWNING
RESIDENCE
251 IRENE LN,
LAKE CITY, FL 32055

DRAWN BY

ESR

SHEET NAME

ELECTRICAL LINE DIAGRAM

SHEET SIZE

ANSI B
11" X 17"

SHEET NUMBER

PV-6

INVERTER SPECIFICATIONS	
MANUFACTURER / MODEL #	SOLAREEDGE: SE7600H-USMNUBL15(DOMESTIC) INVERTER
NOMINAL AC POWER	7.600 KW
NOMINAL OUTPUT VOLTAGE	240 VAC
NOMINAL OUTPUT CURRENT	32A

SOLAR MODULE SPECIFICATIONS	
MANUFACTURER / MODEL #	TRINA SOLAR: TSM-NE09RC.05 415W MODULE
VMP	42.5V
IMP	9.77A
VOC	50.5V
ISC	10.40A
TEMP. COEFF. VOC	-0.24%/°C
MODULE DIMENSION	69.37"L x 44.65"W x 1.18"D (In Inch)

AMBIENT TEMPERATURE SPECS	
RECORD LOW TEMP	-5°
AMBIENT TEMP (HIGH TEMP 2%)	37°
MODULE TEMPERATURE COEFFICIENT OF Voc	-0.24%/°C

PERCENT OF VALUES	NUMBER OF CURRENT CARRYING CONDUCTORS IN EMT
.80	4-6
.70	7-9
.50	10-20

DC FEEDER CALCULATIONS																					
CIRCUIT ORIGIN	CIRCUIT DESTINATION	VOLTAGE (V)	FULL LOAD AMPS "FLA" (A)	FLA*1.25 (A)	OCPD SIZE (A)	GROUND SIZE	CONDUCTOR SIZE	75°C AMPACITY (A)	AMPACITY CHECK #1	AMBIENT TEMP. (°C)	TOTAL CC CONDUCTORS IN RACEWAY	90°C AMPACITY (A)	DERATION FACTOR FOR AMBIENT TEMPERATURE NEC 310.15(B)(1)	DERATION FACTOR FOR CONDUCTORS PER RACEWAY NEC 310.15(C)(1)	90°C AMPACITY DERATED (A)	AMPACITY CHECK #2	FEEDER LENGTH (FEET)	CONDUCTOR RESISTANCE (OHM/KFT)	VOLTAGE DROP AT FLA (%)	CONDUIT SIZE	CONDUIT FILL (%)
STRING 1	JUNCTION BOX	400	15.00	18.75	20	BARE COPPER #6 AWG	CU #10 AWG	35	PASS	37	2	40	0.91	1	36.4	PASS	65	1.24	0.605	N/A	#N/A
STRING 2	JUNCTION BOX	400	15.00	18.75	20	BARE COPPER #6 AWG	CU #10 AWG	35	PASS	37	2	40	0.91	1	36.4	PASS	62	1.24	0.577	N/A	#N/A
JUNCTION BOX	INVERTER	400	15.00	18.75	20	CU #10 AWG	CU #10 AWG	35	PASS	37	4	40	0.91	0.8	29.12	PASS	16	1.24	0.149	3/4" EMT	19.79362
																			String 1 Voltage Drop	0.753	
																			String 2 Voltage Drop	0.725	

AC FEEDER CALCULATIONS																						
CIRCUIT ORIGIN	CIRCUIT DESTINATION	VOLTAGE (V)	FULL LOAD AMPS "FLA" (A)	FLA*1.25 (A)	OCPD SIZE (A)	NEUTRAL SIZE	GROUND SIZE	CONDUCTOR SIZE	75°C AMPACITY (A)	AMPACITY CHECK #1	AMBIENT TEMP. (°C)	TOTAL CC CONDUCTORS IN RACEWAY	90°C AMPACITY (A)	DERATION FACTOR FOR AMBIENT TEMPERATURE NEC 310.15(B)(1)	DERATION FACTOR FOR CONDUCTORS PER RACEWAY NEC 310.15(C)(1)	90°C AMPACITY DERATED (A)	AMPACITY CHECK #2	FEEDER LENGTH (FEET)	CONDUCTOR RESISTANCE (OHM/KFT)	VOLTAGE DROP AT FLA (%)	CONDUIT SIZE	CONDUIT FILL (%)
INVERTER	AC DISCONNECT	240	32	40	40	CU #8 AWG	CU #10 AWG	CU #8 AWG	50	PASS	37	2	55	0.91	1	50.05	PASS	5	0.778	0.104	3/4" EMT	24.5591
AC DISCONNECT	POI	240	32	40	40	CU #8 AWG	CU #10 AWG	CU #8 AWG	50	PASS	37	2	55	0.91	1	50.05	PASS	5	0.778	0.104	3/4" EMT	24.5591
																			CUMULATIVE VOLTAGE		0.207	

This item has been digitally signed and sealed by Andrew D. Leone on the date adjacent to the seal.

Printed copies of this document are not considered signed and sealed and the signature must be verified on any electronic copies.


ELECTRICAL NOTES

1. ALL EQUIPMENT TO BE LISTED BY UL OR OTHER NRTL, AND LABELED FOR ITS APPLICATION.
2. ALL CONDUCTORS SHALL BE RATED UPTO 600V FOR RESIDENTIAL AND 1000V FOR COMMERCIAL AND 90 DEGREE C WET ENVIRONMENT.
3. WIRING, CONDUIT, AND RACEWAYS MOUNTED ON ROOFTOPS SHALL BE ROUTED DIRECTLY TO, AND LOCATED AS CLOSE AS POSSIBLE TO THE NEAREST RIDGE, HIP, OR VALLEY.
4. WORKING CLEARANCES AROUND ALL NEW AND EXISTING ELECTRICAL EQUIPMENT SHALL COMPLY WITH NEC 110.26.
5. DRAWINGS INDICATE THE GENERAL ARRANGEMENT OF SYSTEMS. CONTRACTOR SHALL FURNISH ALL NECESSARY OUTLETS, SUPPORTS, FITTINGS AND ACCESSORIES TO FULFILL APPLICABLE CODES AND STANDARDS.
6. WHERE SIZES OF JUNCTION BOX, RACEWAYS, AND CONDUITS ARE NOT SPECIFIED, THE CONTRACTOR SHALL SIZE THEM ACCORDINGLY.
7. ALL WIRE TERMINATIONS SHALL BE APPROPRIATELY LABELED AND READILY VISIBLE.
8. MODULE GROUNDING CLIPS TO BE INSTALLED BETWEEN MODULE FRAME AND MODULE SUPPORT RAIL, PER THE GROUNDING CLIP MANUFACTURER'S INSTRUCTION.
9. MODULE SUPPORT RAIL TO BE BONDED TO CONTINUOUS COPPER G.E.C. VIA WEEB LUG OR ILSCO GBL-4DBT LAY-IN LUG.
10. TEMPERATURE RATINGS OF ALL CONDUCTORS, TERMINATIONS, BREAKERS, OR OTHER DEVICES ASSOCIATED WITH THE SOLAR PV SYSTEM SHALL BE RATED FOR AT LEAST 75 DEGREE C.



LUNEX POWER INC.
4721 N GRADY AVE
TAMPA FL 33614
LIC #: CVC57085
PHONE: 813-540-8807

REVISIONS		
DESCRIPTION	DATE	REV

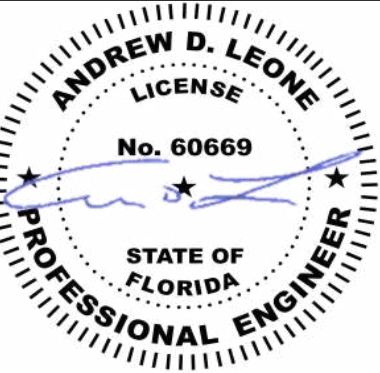

/ /
DATE: 03/05/2025

PROJECT NAME & ADDRESS

CHARLES DOWNING
RESIDENCE

251 IRENE LN,
LAKE CITY, FL 32055

DRAWN BY

ESR

SHEET NAME

WIRING CALCULATIONS

SHEET SIZE

ANSI B
11" X 17"

SHEET NUMBER

PV-7

CAUTION:
AUTHORIZED SOLAR
PERSONNEL ONLY!

LABEL-1:
LABEL LOCATION:
AC DISCONNECT

 **WARNING**

ELECTRICAL SHOCK HAZARD

TERMINALS ON THE LINE AND LOAD SIDES MAY
BE ENERGIZED IN THE OPEN POSITION

LABEL- 2:
LABEL LOCATION:
AC DISCONNECT
COMBINER
MAIN SERVICE PANEL
SUBPANEL
MAIN SERVICE DISCONNECT
CODE REF: NEC 690.13(B)

 **WARNING DUAL POWER SOURCE**

SECOND SOURCE IS PHOTOVOLTAIC SYSTEM

LABEL- 3:
LABEL LOCATION:
PRODUCTION METER
UTILITY METER
MAIN SERVICE PANEL
SUBPANEL
CODE REF: NEC 705.12(C) & NEC 690.59

 **WARNING**

**TURN OFF PHOTOVOLTAIC AC
DISCONNECT PRIOR TO
WORKING INSIDE PANEL**

LABEL- 4:
LABEL LOCATION:
MAIN SERVICE PANEL
SUBPANEL
MAIN SERVICE DISCONNECT
COMBINER
CODE REF: NEC 110.27(C) & OSHA 1910.145 (f) (7)


 **WARNING**

**POWER SOURCE OUTPUT
CONNECTION. DO NOT
RELOCATE THIS
OVERCURRENT DEVICE**

LABEL- 5:
LABEL LOCATION:
MAIN SERVICE PANEL (ONLY IF SOLAR IS BACK-FED)
SUBPANEL (ONLY IF SOLAR IS BACK-FED)
CODE REF: NEC 705.12(B)(3)(2)

SOLAR PV SYSTEM EQUIPPED
WITH RAPID SHUTDOWN

TURN RAPID SHUTDOWN
SWITCH TO THE
"OFF" POSITION TO
SHUT DOWN PV SYSTEM
AND REDUCE
SHOCK HAZARD
IN THE ARRAY

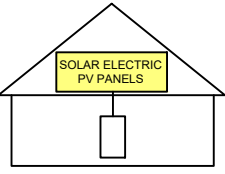

LABEL- 6:
LABEL LOCATION:
AC DISCONNECT
CODE REF: IFC 605.11.3.1(1) & NEC 690.56(C)

RAPID SHUTDOWN SWITCH
FOR SOLAR PV SYSTEM

LABEL- 7:
LABEL LOCATION:
AC DISCONNECT
CODE REF: NEC 690.56(C)(2)

PHOTOVOLTAIC

AC DISCONNECT

LABEL- 8:
LABEL LOCATION:
AC DISCONNECT
CODE REF: NEC 690.13(B)

PHOTOVOLTAIC
AC DISCONNECT

NOMINAL OPERATING AC VOLATGE240 V

RATED AC OUTPUT CURRENT32 A

LABEL- 9:
LABEL LOCATION:
MAIN SERVICE PANEL
SUBPANEL
AC DISCONNECT
CODE REF: NEC 690.54

MAIN PHOTOVOLTAIC
SYSTEM DISCONNECT

LABEL- 10:
LABEL LOCATION:
MAIN SERVICE DISCONNECT (ONLY IF MAIN SERVICE DISCONNECT IS PRESENT)
CODE REF: NEC 690.13(B)

PRODUCTION
METER

LABEL- 11:
LABEL LOCATION:
PRODUCTION METER (ONLY IF PRODUCTION METER IS USED)

This item has been digitally
signed and sealed by
Andrew D. Leone on the date
adjacent to the seal.

Printed copies of this
document are not considered
signed and sealed and the
signature must be verified on
any electronic copies.

CAUTION: PHOTOVOLTAIC SYSTEM
FOR SERVICE : LUNEX POWER
813-540-8807

LABEL-12:

WARNING: PHOTOVOLTAIC
POWER SOURCE

LABEL-13:
LABEL LOCATION:
EMT/CONDUIT RACEWAY
SOLADECK/JUNCTION BOX
CODE REF : NEC 690.31 (D) (14)

EMERGENCY RESPONDER
THIS SOLAR PV SYSTEM EQUIPPED
WITH RAPID SHUTDOWN

TURN RAPID SHUTDOWN
SWITCH TO THE 'OFF'
POSITION TO SHUTDOWN
ENTIRE PV SYSTEM.

THE LABEL SHALL BE REFLECTIVE, WITH ALL LETTERS CAPITALIZED AND HAVING
A MINIMUM HEIGHT OF 3/8 IN. (9.5 MM), IN WHITE ON A RED BACKGROUND.

LABEL- 14:
LABEL LOCATION:
AC DISCONNECT
CODE REF:NFPA 1 (11.12.2.1.1.1.1)
1. THE RAPID SHUTDOWN LABEL SHALL BE LOCATED ON OR NO MORE
THAN 3 FT (1 M) FROM THE SERVICE DISCONNECTING MEANS
2. (HEIGHT OF LABEL IS 3/8 IN. (9.5 MM), IN WHITE ON A RED BACKGROUND)

MAXIMUM VOLTAGE:480 V

MAXIMUM CIRCUIT CURRENT:40 A


MAXIMUM RATED OUTPUT
CURRENT OF THE CHARGE
CONTROLLER OR DC-TO-DC
CONVERTER (IF INSTALLED):

LABEL- 15:
LABEL LOCATION:
INVERTER
CODE REF: NEC 690.53



LUNEX POWER INC.
4721 N GRADY AVE
TAMPA FL 33614
LIC #: CVC57085
PHONE: 813-540-8807

REVISIONS		
DESCRIPTION	DATE	REV

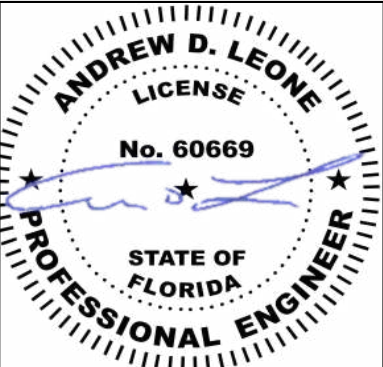

/ /
DATE: 03/05/2025

PROJECT NAME & ADDRESS

CHARLES DOWNING
RESIDENCE
251 IRENE LN,
LAKE CITY, FL 32055

DRAWN BY

ESR

SHEET NAME


LABELS

SHEET SIZE

ANSI B
11" X 17"

SHEET NUMBER

PV-8

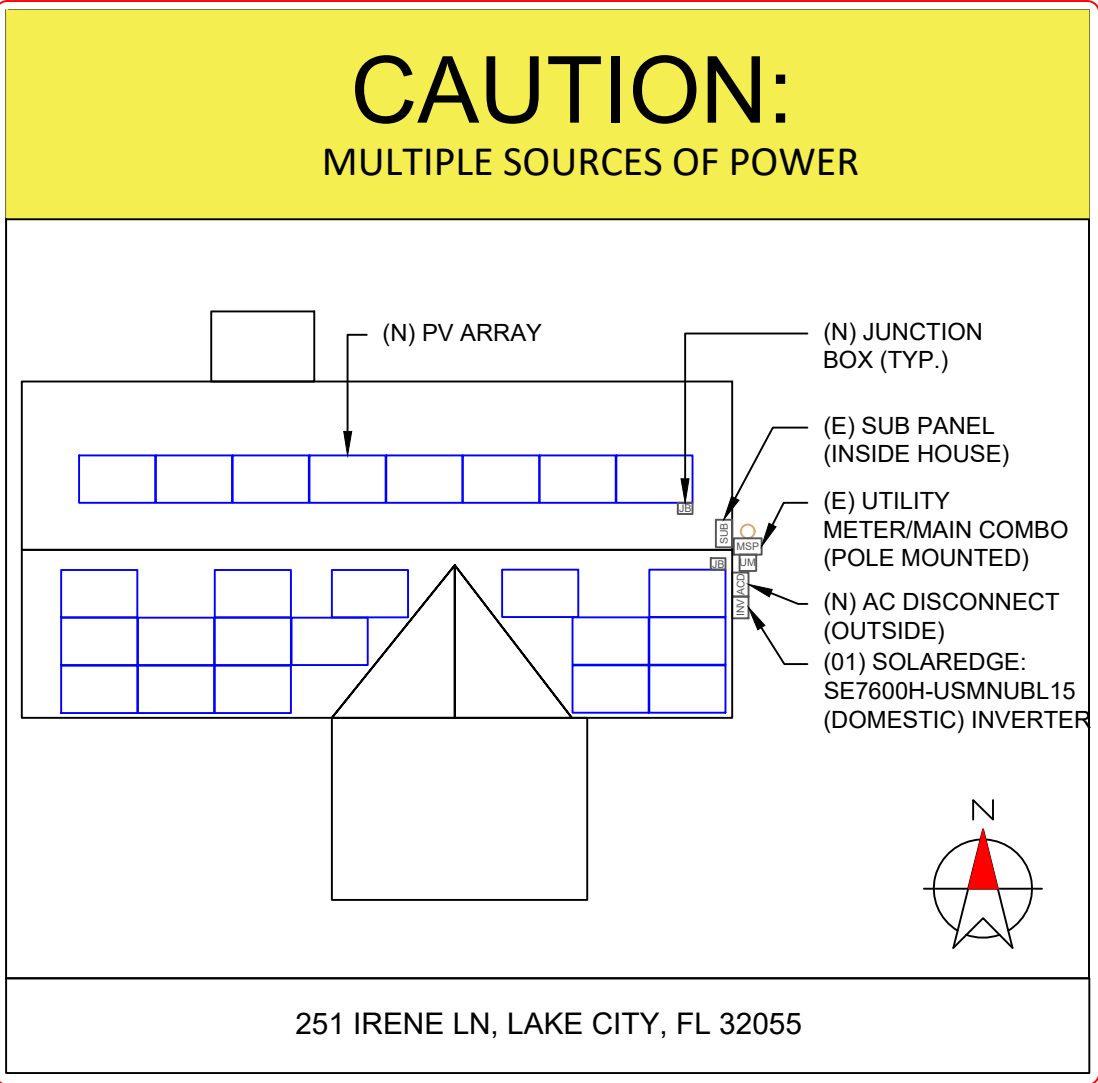

This item has been digitally signed and sealed by Andrew D. Leone on the date adjacent to the seal.

Printed copies of this document are not considered signed and sealed and the signature must be verified on any electronic copies.

- LABELING NOTES:
1. LABELS CALLED OUT ACCORDING TO ALL COMMON CONFIGURATIONS. ELECTRICIAN TO DETERMINE EXACT REQUIREMENTS IN THE FIELD PER CURRENT NEC AND LOCAL CODES AND MAKE APPROPRIATE ADJUSTMENTS.
 2. LABELING REQUIREMENTS BASED ON THE 2020 NATIONAL ELECTRIC CODE, OSHA STANDARD 19010.145, ANSI Z535.
 3. MATERIAL BASED ON THE REQUIREMENTS OF THE AUTHORITY HAVING JURISDICTION.
 4. LABELS TO BE OF SUFFICIENT DURABILITY TO WITHSTAND THE ENVIRONMENT INVOLVED [NEC 110.21]
 5. LABELS TO BE A MINIMUM LETTER HEIGHT OF 3/8", WHITE ON RED BACKGROUND; REFLECTIVE, AND PERMANENTLY AFFIXED [IFC 605.11.1.1]


DIRECTORY
PERMANENT PLAQUE OR DIRECTORY PROVIDING THE LOCATION OF THE SERVICE DISCONNECTING MEANS AND THE PHOTOVOLTAIC SYSTEM.

(ALL PLAQUES AND SIGNAGE WILL BE INSTALLED AS OUTLINED WITHIN:
NEC 690.56(B)&(C), [NEC 705.10])



LUNEX POWER INC.
4721 N GRADY AVE
TAMPA FL 33614
LIC #: CVC57085
PHONE: 813-540-8807

REVISIONS		
DESCRIPTION	DATE	REV

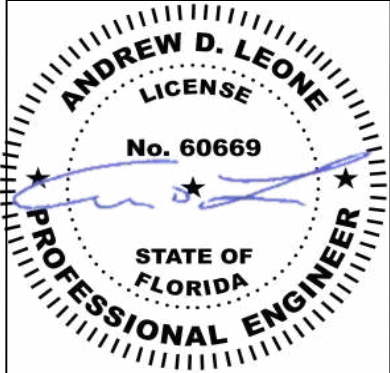

DATE: 03/05/2025

PROJECT NAME & ADDRESS

CHARLES DOWNING
RESIDENCE
251 IRENE LN,
LAKE CITY, FL 32055

DRAWN BY

ESR

SHEET NAME

PLACARD

SHEET SIZE


ANSI B
11" X 17"

SHEET NUMBER


PV-9

1-1011-2021-3031-4041-5051-6061-70

1
2
3
4
5
6
7
8
9
10

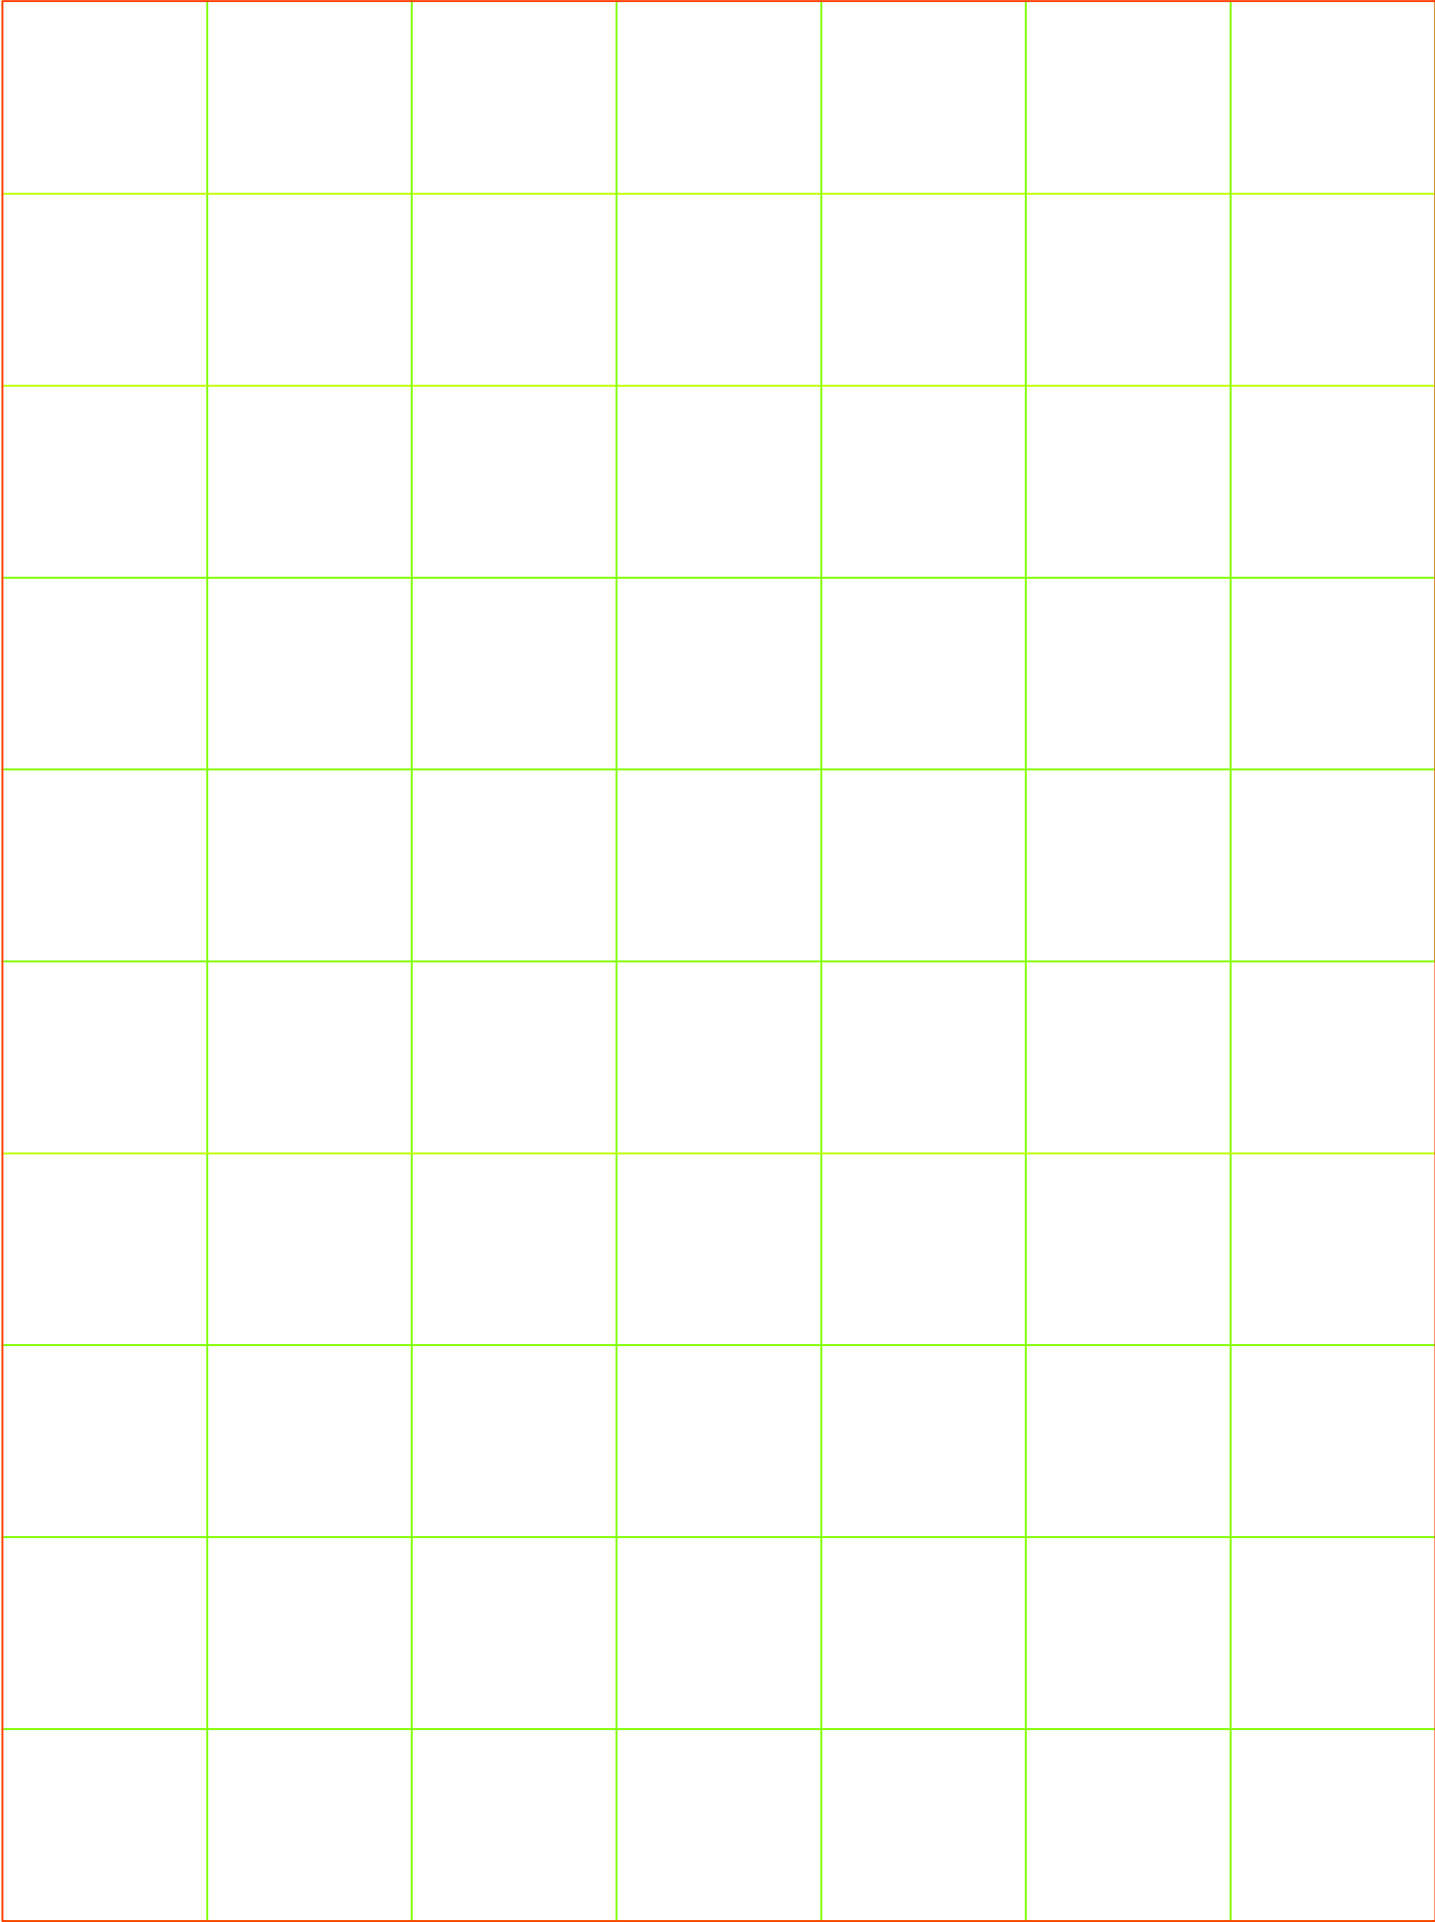

OPTIMIZER CHART

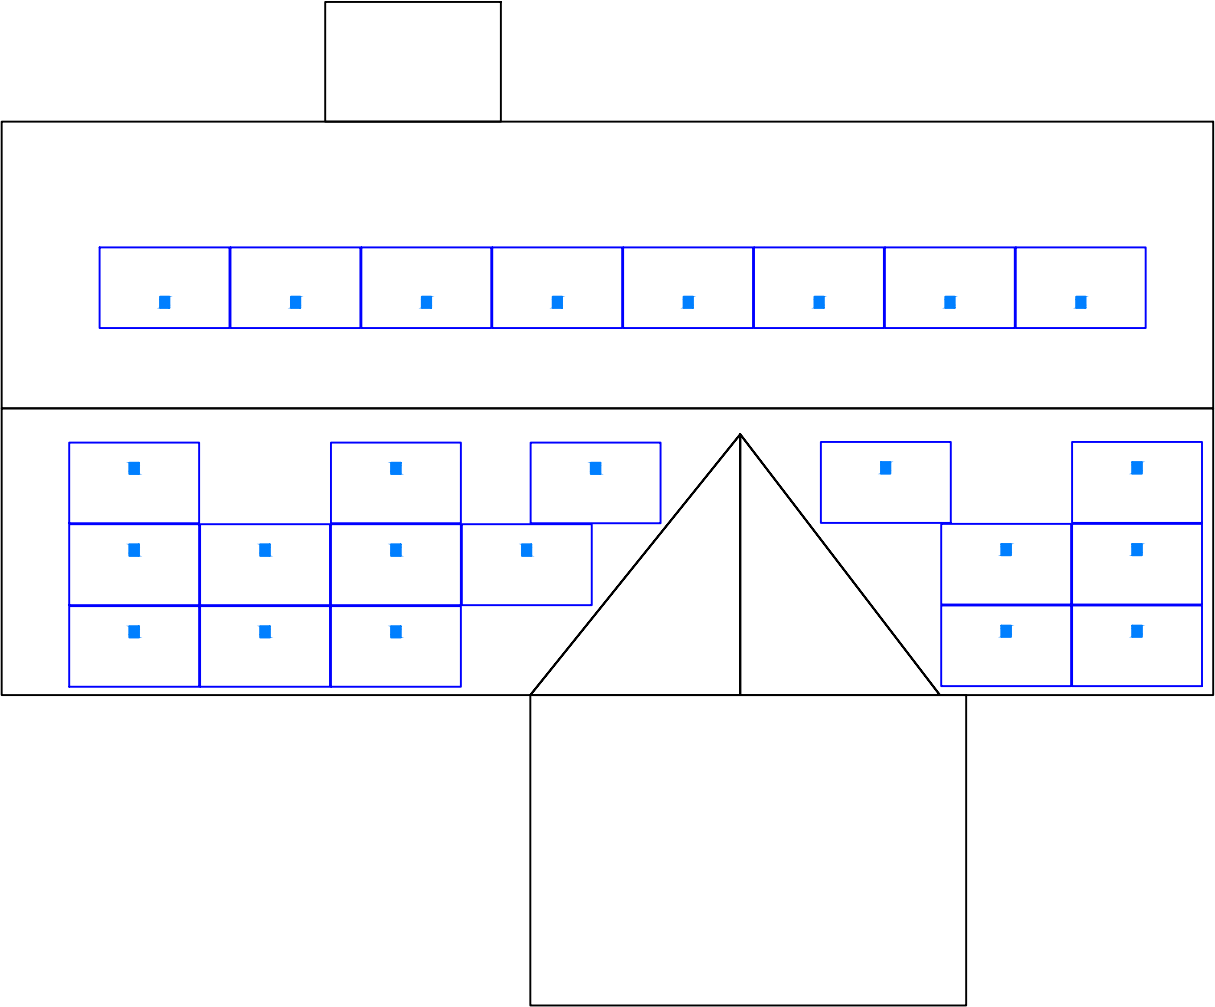



LUNEX POWER INC.
4721 N GRADY AVE
TAMPA FL 33614
LIC #: CVC57085
PHONE: 813-540-8807

REVISIONS		
DESCRIPTION	DATE	REV

DATE: 03/05/2025

PROJECT NAME & ADDRESS

CHARLES DOWNING
RESIDENCE

251 IRENE LN,
LAKE CITY, FL 32055

DRAWN BY

ESR

SHEET NAME

OPTIMIZER CHART

SHEET SIZE

ANSI B
11" X 17"

SHEET NUMBER

PV-10



BACKSHEET MONOCRYSTALLINE MODULE

PRODUCT: TSM-NE09RC.05
PRODUCT RANGE: 400-430W

430W

MAXIMUM POWER OUTPUT

0~+5W

POSITIVE POWER TOLERANCE

21.5%

MAXIMUM EFFICIENCY



Small in size, bigger on power

- Up to 430W, 21.5% module efficiency with high density interconnect technology
- Reduce installation cost with higher power bin and efficiency
- Boost performance in warm weather with low temperature coefficient and operating temperature



High Reliability

- Innovative non-destructive cutting for improved mechanical resistance and strength
- Excellent fire rating, weather resistance, salt spray, sand dust, ammonia performance which is fully applicable in coastal, high temperature, humidity area and harsh environment



Ultra-low Degradation, longer warranty, higher output


- First-year degradation 1% and annual degradation at 0.4%
- Up to 25 years product warranty and 25 years power warranty



Universal solution for residential and C&I rooftops




- Easy for integration, designed for compatibility with existing mainstream inverters and diverse mounting systems
- Perfect size and low weight for handling and installation
- Most valuable solution on low load capacity rooftops (weight similar to backsheet version)
- Mechanical performance up to 6000 Pa positive load and 4000 Pa negative load

Trina Solar's Vertex Bifacial Backsheet Performance Warranty

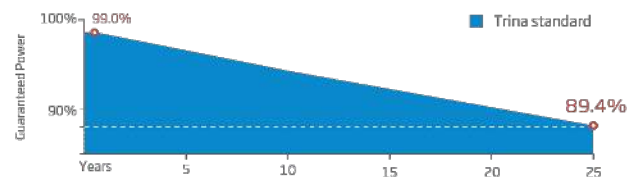

BACKSHEET MONOCRYSTALLINE MODULE

DIMENSIONS OF PV MODULE(mm)

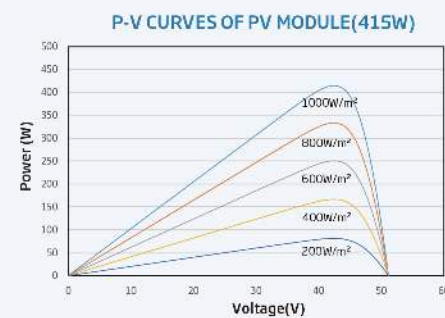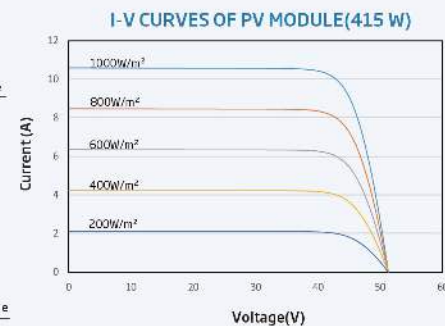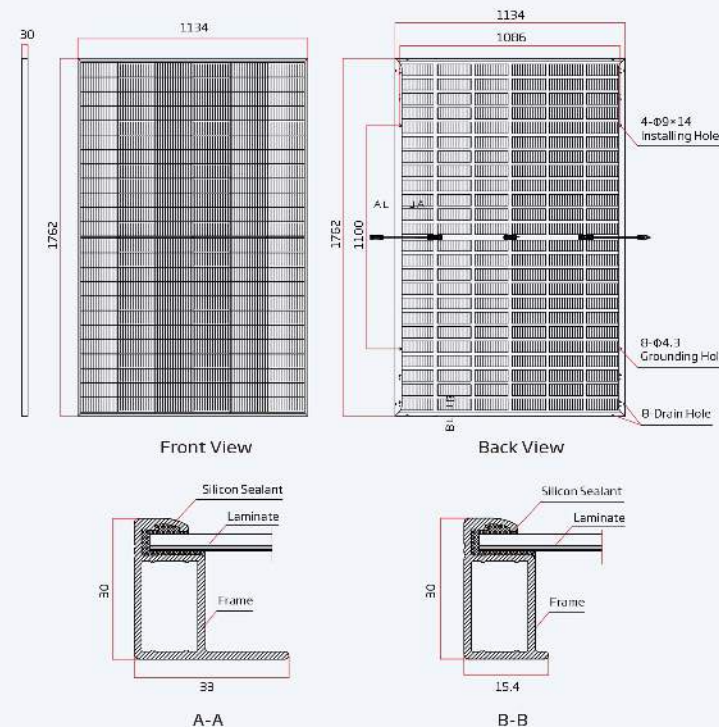

ELECTRICAL DATA (STC)

Peak Power Watts-P _{max} (Wp)*	400	405	410	415	420	425	430
Power Tolerance-PMAX (W)				0~+5			
Maximum Power Voltage-V _{mp} (V)	41.3	41.7	42.1	42.5	42.8	43.2	43.6
Maximum Power Current-I _{mp} (A)	9.68	9.71	9.73	9.77	9.80	9.84	9.87
Open Circuit Voltage-V _{oc} (V)	49.2	49.6	50.1	50.5	50.9	51.4	51.8
Short Circuit Current-I _{sc} (A)	10.30	10.33	10.37	10.40	10.43	10.47	10.50
Module Efficiency, η _m (%)	20.0	20.3	20.5	20.8	21.0	21.3	21.5

STC: Irradiance 1000W/m², Cell Temperature 25°C, Air Mass AM1.5. *Measuring tolerance: ±3%

Electrical characteristics with different power bin (reference to 10% Irradiance ratio)

Total Equivalent power-P _{max} (Wp)	425	431	437	442	447	453	458
Maximum Power Voltage-V _{mp} (V)	41.3	41.7	42.1	42.5	42.8	43.2	43.6
Maximum Power Current-I _{mp} (A)	10.31	10.34	10.36	10.41	10.44	10.48	10.51
Open Circuit Voltage-V _{oc} (V)	49.2	49.6	50.1	50.5	50.9	51.4	51.8
Short Circuit Current-I _{sc} (A)	10.97	11.00	11.04	11.08	11.11	11.15	11.18
Irradiance ratio (rear/front)				10%			

Power Tolerance: ±5%±10%

ELECTRICAL DATA (NOCT)

Maximum Power-P _{max} (Wp)	312	308	312	316	319	324	328
Maximum Power Voltage-V _{mp} (V)	38.6	39.0	39.3	39.7	40.0	40.4	40.7
Maximum Power Current-I _{mp} (A)	7.08	7.91	7.93	7.96	7.98	8.01	8.04
Open Circuit Voltage-V _{oc} (V)	46.6	47.0	47.5	47.8	48.2	48.7	49.1
Short Circuit Current-I _{sc} (A)	8.30	8.32	8.36	8.38	8.41	8.44	8.46

NOCT: Irradiance at 800W/m², Ambient Temperature 20°C, Wind Speed 1m/s

MECHANICAL DATA

Solar Cells	Topcon Bifacial
No. of cells	144cells
Module Dimensions	1762×1134×30mm (69.37×44.65×1.18 inches)
Weight	21.3kg (47.0 lb)
Front Glass	3.2mm (0.12 inches), High Transmission, Tempered Glass
Encapsulant material	POE/EVA
Backsheet	Black Grid Transparent Backsheet
Frame	30mm (1.18 inches) Anodized Aluminium Alloy, Black
J-Box	IP68 rated
Cables	Photovoltaic Technology Cable 4.0mm² (0.006 inches²) Landscape: V1100mm/P1100mm (43.31/43.31 inches)
Connector	MC4 EVO2
Fire Type	Type 1 or Type 2

TEMPERATURE RATINGS

NOCT (Nominal Operating Cell Temperature)	43°C (±2°C)
Temperature Coefficient of P _{max}	-0.30%/°C
Temperature Coefficient of V _{oc}	-0.24%/°C
Temperature Coefficient of I _{sc}	0.04%/°C

MAXIMUM RATINGS

Operational Temperature	-40~+85°C
Maximum System Voltage	1500V DC (IEC)
Max Series Fuse Rating	25 A

WARRANTY

 
25 year Product Workmanship Warranty
25 year Power Warranty
1% first year degradation
0.4% Annual Power Attenuation

(Please refer to product warranty for details)

PACKAGING CONFIGURATION

Modules per box: 35 pieces
Modules per 40' container: 792 pieces
Pallet dimensions (L x W x H): 1800 x 1135 x 1259 mm
Pallet weight: 829 kg (1827 lb)

Comprehensive Products and System Certificates



CAUTION: READ SAFETY AND INSTALLATION INSTRUCTIONS BEFORE USING THE PRODUCT.

© 2023 Trina Solar Co., Ltd. All rights reserved. Specifications included in this datasheet are subject to change without notice.

Version number: TSM_NA_EN_2023_A

www.trinasolar.com

LUNEX POWER INC.
4721 N GRADY AVE
TAMPA FL 33614
LIC #: CVC57085
PHONE: 813-540-8807

REVISIONS

DESCRIPTION	DATE	REV

DATE: 03/05/2025

PROJECT NAME & ADDRESS

CHARLES DOWNING
RESIDENCE
251 IRENE LN,
LAKE CITY, FL 32055

DRAWN BY

ESR

SHEET NAME
EQUIPMENT
SPECIFICATION

SHEET SIZE

ANSI B
11" X 17"

SHEET NUMBER

PV-11

SE3800H-US / SE5700H-US / SE7600H-US / SE10000H-US /
SE11400H-US



12-25
YEAR
WARRANTY

HOME BACKUP



Eligible for domestic content: SolarEdge USA-manufactured inverters*, when paired with certain SolarEdge power optimizers, are intended to be eligible for the enhanced federal income tax credit for domestic content.	Fast and easy installation – small and lightweight, with reduced commissioning time
The ultimate home energy manager in charge of PV production, battery storage, backup operation during a power outage**, EV Charging, and smart energy devices	A scalable solution that supports future homeowner needs through easy connection to a growing ecosystem of products
Record breaking 99% weighted efficiency with up to 200% DC oversizing	Advanced safety features with integrated arc fault protection and rapid shutdown for 690.11 and 690.12
Ability to start high LRA HVAC systems during backup operation	Advanced reliability with automotive-grade components
Integrates seamlessly with the complete SolarEdge Home Smart Energy Ecosystem, through SolarEdge Home Network	Embedded revenue grade production data, ANSI C12.20, Class 0.5
Module-level monitoring and visibility of battery status, PV production, and self-consumption data	NEMA 4X-rated, for indoor and outdoor installations
	Embedded Power Control System (PCS) – install larger systems while avoiding main panel upgrade

[illegible]

solaredge.com

USA Domestic Content Eligible
Single Phase, for North America

SE3800H-US / SE5700H-US / SE7600H-US / SE10000H-US / SE11400H-US

Applicable to inverters with part number	SExxxxxX-USMNXbLx5 / USExxxxxX-USMNBbL75				
Model Number ¹⁾	SE3800H-US	SE5700H-US	SE7600H-US	SE10000H-US	SE11400H-US
OUTPUT – AC ON GRID					
Maximum AC Power Output	3800 @ 240V 3100 @ 208V	5760 @ 240V 5200 @ 208V	7680 @ 240V	10,000 @ 240V 9000 @ 208V	11,400 @ 240V 10,000 @ 208V
AC Output Voltage (Nominal)	208 / 240				
AC Output Voltage Range	181 – 274				
AC Frequency Range (Hz) – nominal	50.3 – 60.5 ²⁾				
Maximum Continuous Output Current	16 @ 240V 16 @ 208V	24 @ 240V 21 @ 208V	32 @ 240V	42 @ 240V	47.5 @ 240V 46 @ 208V
GFN Threshold	1				
Total Harmonic Distortion (THD)	< 5				
Power Factor	1, adjustable > 0.95 (to 0.85)				
Utility Mains Voltage, Maximum Protection	Yes				
Current Limitable Trips (inrush)	Yes				
Charge Battery from AC (if allowed)	Yes				
Typical Nighttime Power Consumption	< 2.5				
OUTPUT – AC STANDALONE (BACKUP) ³⁾					
Rated AC Power in Standalone Operation ⁴⁾	7,400				
Maximum Continuous Output Current in Standalone Operation ⁵⁾	48				
Maximum AC Voltage @ 80%	Up to 100				
AC L-L Output Voltage Range in Standalone Operation	211 – 261				
AC L-N Output Voltage Range in Standalone Operation	105 – 132				
AC Frequency Range in Standalone Operation (Hz) – nominal	55 – 60 – 65				
GFN	1				
THD	< 5				
INPUT – DC (PV AND BATTERY)					
Transformer-less, Ungrounded	Yes				
Maximum Input Voltage	630				
Nominal DC Input Voltage	550				
Reverse Polarity Protection	Yes				
Cross-Line Isolation Detection	60VDC Sensitivity				
Maximum Input Short-Circuit Current	N/A				
Maximum Inverter Efficiency	99.4				
CEC Weighted DC Energy	98.5				
2-Pole Disconnection	Yes				
DC CONNECTION – PV					
Maximum Input Power	3900 @ 240V 6000 @ 208V	11,500 @ 240V 15,000 @ 208V	15,000 @ 240V	20,000 @ 240V	32,000 @ 240V 20,000 @ 208V
Maximum Input Current	20 @ 240V 17.5 @ 208V	30 @ 240V 26 @ 208V	40 @ 240V	58 @ 240V	65 @ 240V 53.5 @ 208V
Number of Ports	2				
Maximum Current per Port	40				

[illegible]

© 2012 Wiley Periodicals, Inc. All rights reserved. DOI: 10.1002/anie.201200444. The Wiley Online Library on Wiley InterScience (www.interscience.wiley.com) is a service that allows registered users to access Wiley InterScience journals and Wiley InterScience databases. For more information on Wiley InterScience, please visit the Wiley InterScience website at <http://www.interscience.wiley.com>. Date: September 17, 2012 11:41:14 AM. Subject: Organic Chemistry.



USA Domestic Content Eligible
Single Phase, for North America

SE3800H-US / SE5700H-US / SE7600H-US / SE10000H-US / SE11400H-US

Applicable to inverters with part number	SExxxx0H-USMNXBLx5 / USExxx0H-USMNBTLx5			
Model Number ⁽¹⁾	SE3800H-US	SE5700H-US	SE7600H-US	SE10000H-US
DC CONNECTION – BATTERY				
Supported Battery Types	SolarEdge home Battery 400V			
Number of Batteries per Inverter	Up to 3			
Maximum Continuous Power (Charge and Discharge) ⁽²⁾	13,600			
Number of Ports	2			
Maximum Current per Port	40			
2-wire Disconnection	Up to the inverter rated transience power			
SMART ENERGY CAPABILITIES				
Consumption Matching	Built-in ⁽³⁾			
Standalone & Battery Storage	With Back-up Interface (part sold separately) for service up to 20kVA, up to 3 inverters			
EV Charging	Direct connection to the SolarEdge home EV Charger ⁽⁴⁾			
ADDITIONAL FEATURES				
Supported Communication Interfaces	RS-485, Ethernet, Cellular ⁽⁵⁾ , Wi-Fi ⁽⁶⁾ (optional), SolarEdge home Network ⁽⁷⁾ (optional)			
Reverse Grade-Marking, A-IO, CIG-IO ⁽⁸⁾	Built-in ⁽³⁾			
Integrated AC, DC, and Communication Connection Unit	Yes			
Power Monitoring	With the SEApp mobile application using built-in Wi-Fi Access Point for local connection			
AC Voltage, Power, Shunt, CT and Energy	Yes, NEMA 3R ⁽⁹⁾			
STANDARD COMPLIANCE				
Safety	UL 1741, UL 1741A, UL 1718, UL 1699, CSA 22.2 117, IEC 62109-1, IEC 62109-2, IEC 62470, IEC 62473, IEC 62540, IEC 62541, IEC 62542, IEC 63828, IEC 6			

[illegible]

LUNEX POWER
THE PURE SOURCE

LUNEX POWER INC.
4721 N GRADY AVE
TAMPA FL 33614
LIC #: CVC57085
PHONE: 813-540-8807

REVISIONS		
DESCRIPTION	DATE	REV

DATE: 03/05/2025

PROJECT NAME & ADDRESS

CHARLES DOWNING
RESIDENCE

DRAWN BY
ESR

SHEET NAME
EQUIPMENT
SPECIFICATION

SHEET SIZE
ANSI B
11" X 17"

SHEET NUMBER

PV-12

Residential Power Optimizer
For North America

S440 / S500B / S650B



POWER OPTIMIZER

PV power optimization at the module level

- Specifically designed to work with SolarEdge residential inverters
- Detected abnormal PV connector behavior, preventing potential safety issues
- Module-level voltage shutdown for installer and firefighter safety
- Superior efficiency (99.5%)
- Mitigates all types of module mismatch loss, from manufacturing tolerance to partial shading
- Faster installations with simplified cable management and easy assembly using a single bolt
- Flexible system design for maximum space utilization
- Compatible with bifacial PV modules
- Meets NEC requirements for arc fault protection (AFCI) and Photovoltaic Rapid Shutdown System (PVRSS)

Residential Power Optimizer

For North America

S440 / S500B / S650B

	S440	S500B	S650B	
INPUT				
Rated Input DC Power ⁽¹⁾	440	500	650	W
Absolute Maximum Input Voltage (Voc)	60	125	85	Vdc
MPPT Operating Range	8 – 60	12.5 – 105	12.5 – 85	Vdc
Maximum Input Current (Maximum Isc of Connected PV Module)	14.5	15		Adc
Maximum Input Short Circuit Current ⁽²⁾		18.75		Adc
Maximum Efficiency		99.5		%
Weighted Efficiency		98.6		%
Overvoltage Category		II		
OUTPUT DURING OPERATION (POWER OPTIMIZER CONNECTED TO OPERATING SOLAREGE INVERTER)				
Maximum Output Current		15		Adc
Maximum Output Voltage	60	80		Vdc
OUTPUT DURING STANDBY (POWER OPTIMIZER DISCONNECTED FROM SOLAREGE INVERTER OR INVERTER OFF)				
Safety Output Voltage per Power Optimizer		1 ± 0.1		Vdc
STANDARD COMPLIANCE				
Photovoltaic Rapid Shutdown System		NEC 2014 – 2023		
EMC		FCC Part 15 Class B, IEC 61000-6-2, IEC 61000-6-3		
Safety		IEC 62109-1 (class II safety), UL 1741		
Material		UL 94 V-0, UV Resistant		
RoHS		Yes		
Fire Safety		VDE-AR-E 2100-712:2013-05		
INSTALLATION SPECIFICATIONS				
Maximum Allowed System Voltage		1000		Vdc
Dimensions (W x L x H)	129 x 155 x 30 / 5.07 x 6.10 x 1.18	129 x 165 x 45 / 5.07 x 6.49 x 1.77		mm / in
Weight	720 / 1.6	790 / 1.74		gr / lb
Input Connector		MC4		
Input Wire Length		0.1 / 0.32		m / ft
Output Connector		MC4		
Output Wire Length		(+) 2.3, (-) 0.10 / (+) 7.54, (-) 0.32		m / ft
Operating Temperature Range ⁽³⁾		-40 to +85		°C
Protection Rating		IP68 / NEMA6P		
Relative Humidity		0 – 100		%

(1) Rated power of the module at STC will not exceed the power optimizer Rated Input DC Power. Modules with up to +5% power tolerance are allowed.
(2) The Maximum Input Short Circuit Current is adjusted for worst case conditions of ambient temperature, irradiance, bifacial gain, and so on, in accordance with NEC and CSA.
(3) Power derating is applied for ambient temperatures above +85°C / +185°F for S440, and for ambient temperatures above +75°C / 167°F for S500B. Refer to the Power Optimizers Temperature Derating technical note for more details.

PV System Design Using a SolarEdge Inverter ⁽⁴⁾		SolarEdge Home Wave/Hub Single Phase	Three Phase for 208V Grid	Three Phase for 277/480V Grid	
Minimum String Length (Power Optimizers)	S440	8	10	18	
	S500B, S650B	6	8	14	
Maximum String Length (Power Optimizers)		25		50 ⁽⁵⁾	
Maximum Usable Power Delivered per String		5700	6000	12,750	W
Maximum Allowed Connected Power per String ⁽⁷⁾⁽⁸⁾	Inverters with Rated AC Power ≤ 5700W	Per the inverter's maximum input DC power ⁽⁶⁾	One string: 7200 Two strings or more: 7800	15,000	W
	Inverters with Rated AC Power of 6000W	5700			
	Inverters with Rated AC Power ≥ 7600W	6800, only when connected to at least two strings			
Parallel Strings of Different Lengths or Orientations		Yes			



(4) It is not allowed to mix S-series and P-series Power Optimizers in new installations in the same string.
(5) A string with more than 30 optimizers does not meet NEC rapid shutdown requirements; safety voltage will be above the 30 V requirement.
(6) Refer to the Single String Design Guidelines application note for more details.
(7) For the 208 V grid, the maximum is permitted only when the difference in connected power between strings is 1,000 W or less.
(8) For the 240 V or 277/480 V grids, the maximum is permitted only when the difference in connected power between strings 2,000 W or less.

REVISIONS		
DESCRIPTION	DATE	REV

DATE: 03/05/2025	
PROJECT NAME & ADDRESS	
CHARLES DOWNING RESIDENCE 251 IRENE LN, LAKE CITY, FL 32055	

DRAWN BY ESR	
SHEET NAME EQUIPMENT SPECIFICATION	
SHEET SIZE ANSI B 11" X 17"	
SHEET NUMBER PV-13	

PART # TABLE		
P/N	DESCRIPTION	LENGTH
084RLM1	NXT HORIZON RAIL 84" MILL	84"
084RLD1	NXT HORIZON RAIL 84" DARK	84"
168RLM1	NXT HORIZON RAIL 168" MILL	168"
168RLD1	NXT HORIZON RAIL 168" DARK	168"
208RLM1	NXT HORIZON RAIL 208" MILL	208"
208RLD1	NXT HORIZON RAIL 208" DARK	208"
246RLM1	NXT HORIZON RAIL 246" MILL	246"
246RLD1	NXT HORIZON RAIL 246" DARK	246"

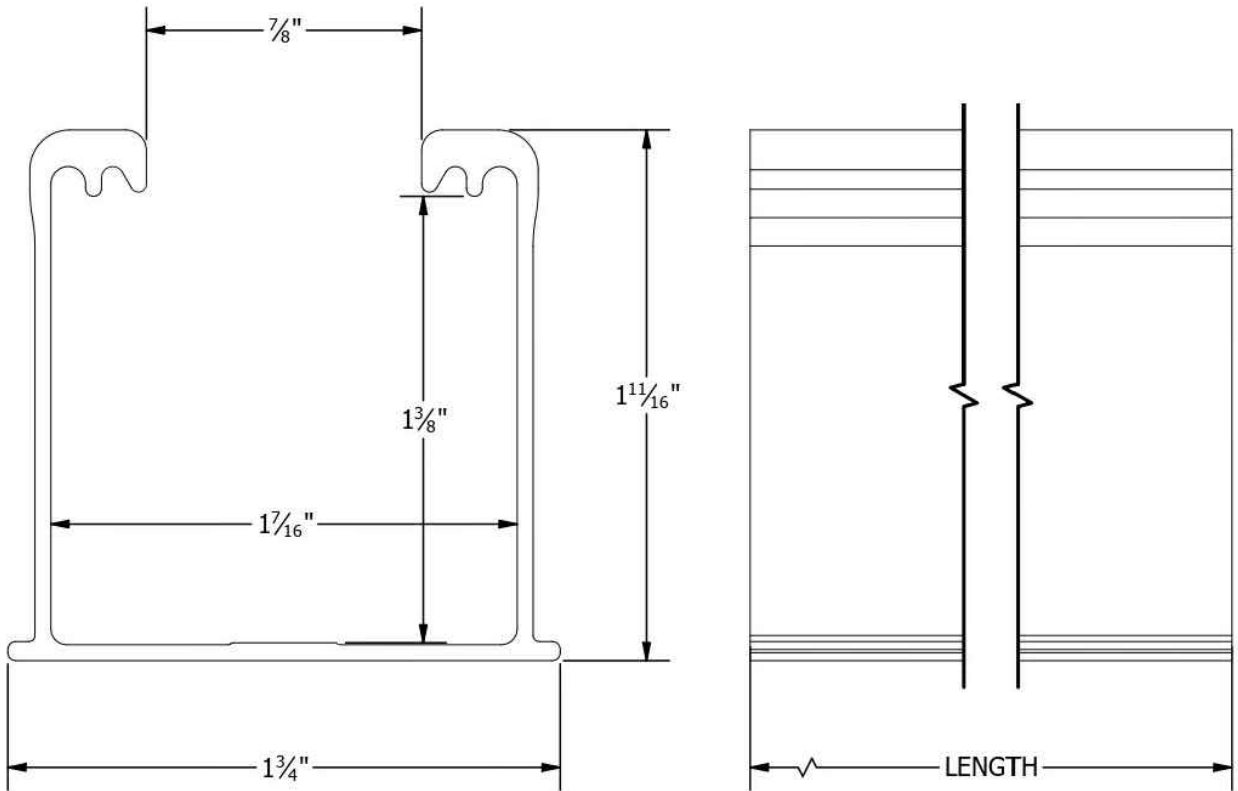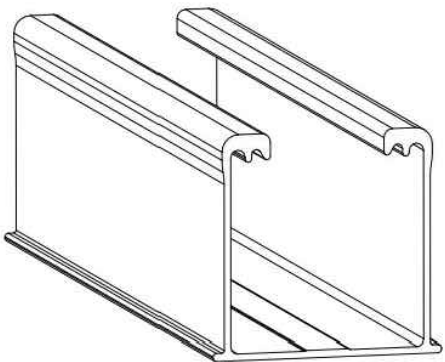

1411 BROADWAY BLVD. NE
ALBUQUERQUE, NM 87102 USA
PHONE: 505.242.6411
WWW.UNIRAC.COM

PRODUCT LINE:	NXT HORIZON
DRAWING TYPE:	PART DETAIL
DESCRIPTION:	RAIL
REVISION DATE:	9/13/2021

DRAWING NOT TO SCALE
ALL DIMENSIONS ARE
NOMINAL

PRODUCT PROTECTED BY
ONE OR MORE US PATENTS
LEGAL NOTICE

NH-P01

SHEET



LUNEX POWER INC.
4721 N GRADY AVE
TAMPA FL 33614
LIC #: CVC57085
PHONE: 813-540-8807

REVISIONS		
DESCRIPTION	DATE	REV

DATE: 03/05/2025

PROJECT NAME & ADDRESS


CHARLES DOWNING
RESIDENCE
251 IRENE LN,
LAKE CITY, FL 32055

DRAWN BY
ESR

SHEET NAME
EQUIPMENT
SPECIFICATION

SHEET SIZE
ANSI B
11" X 17"

SHEET NUMBER
PV-14

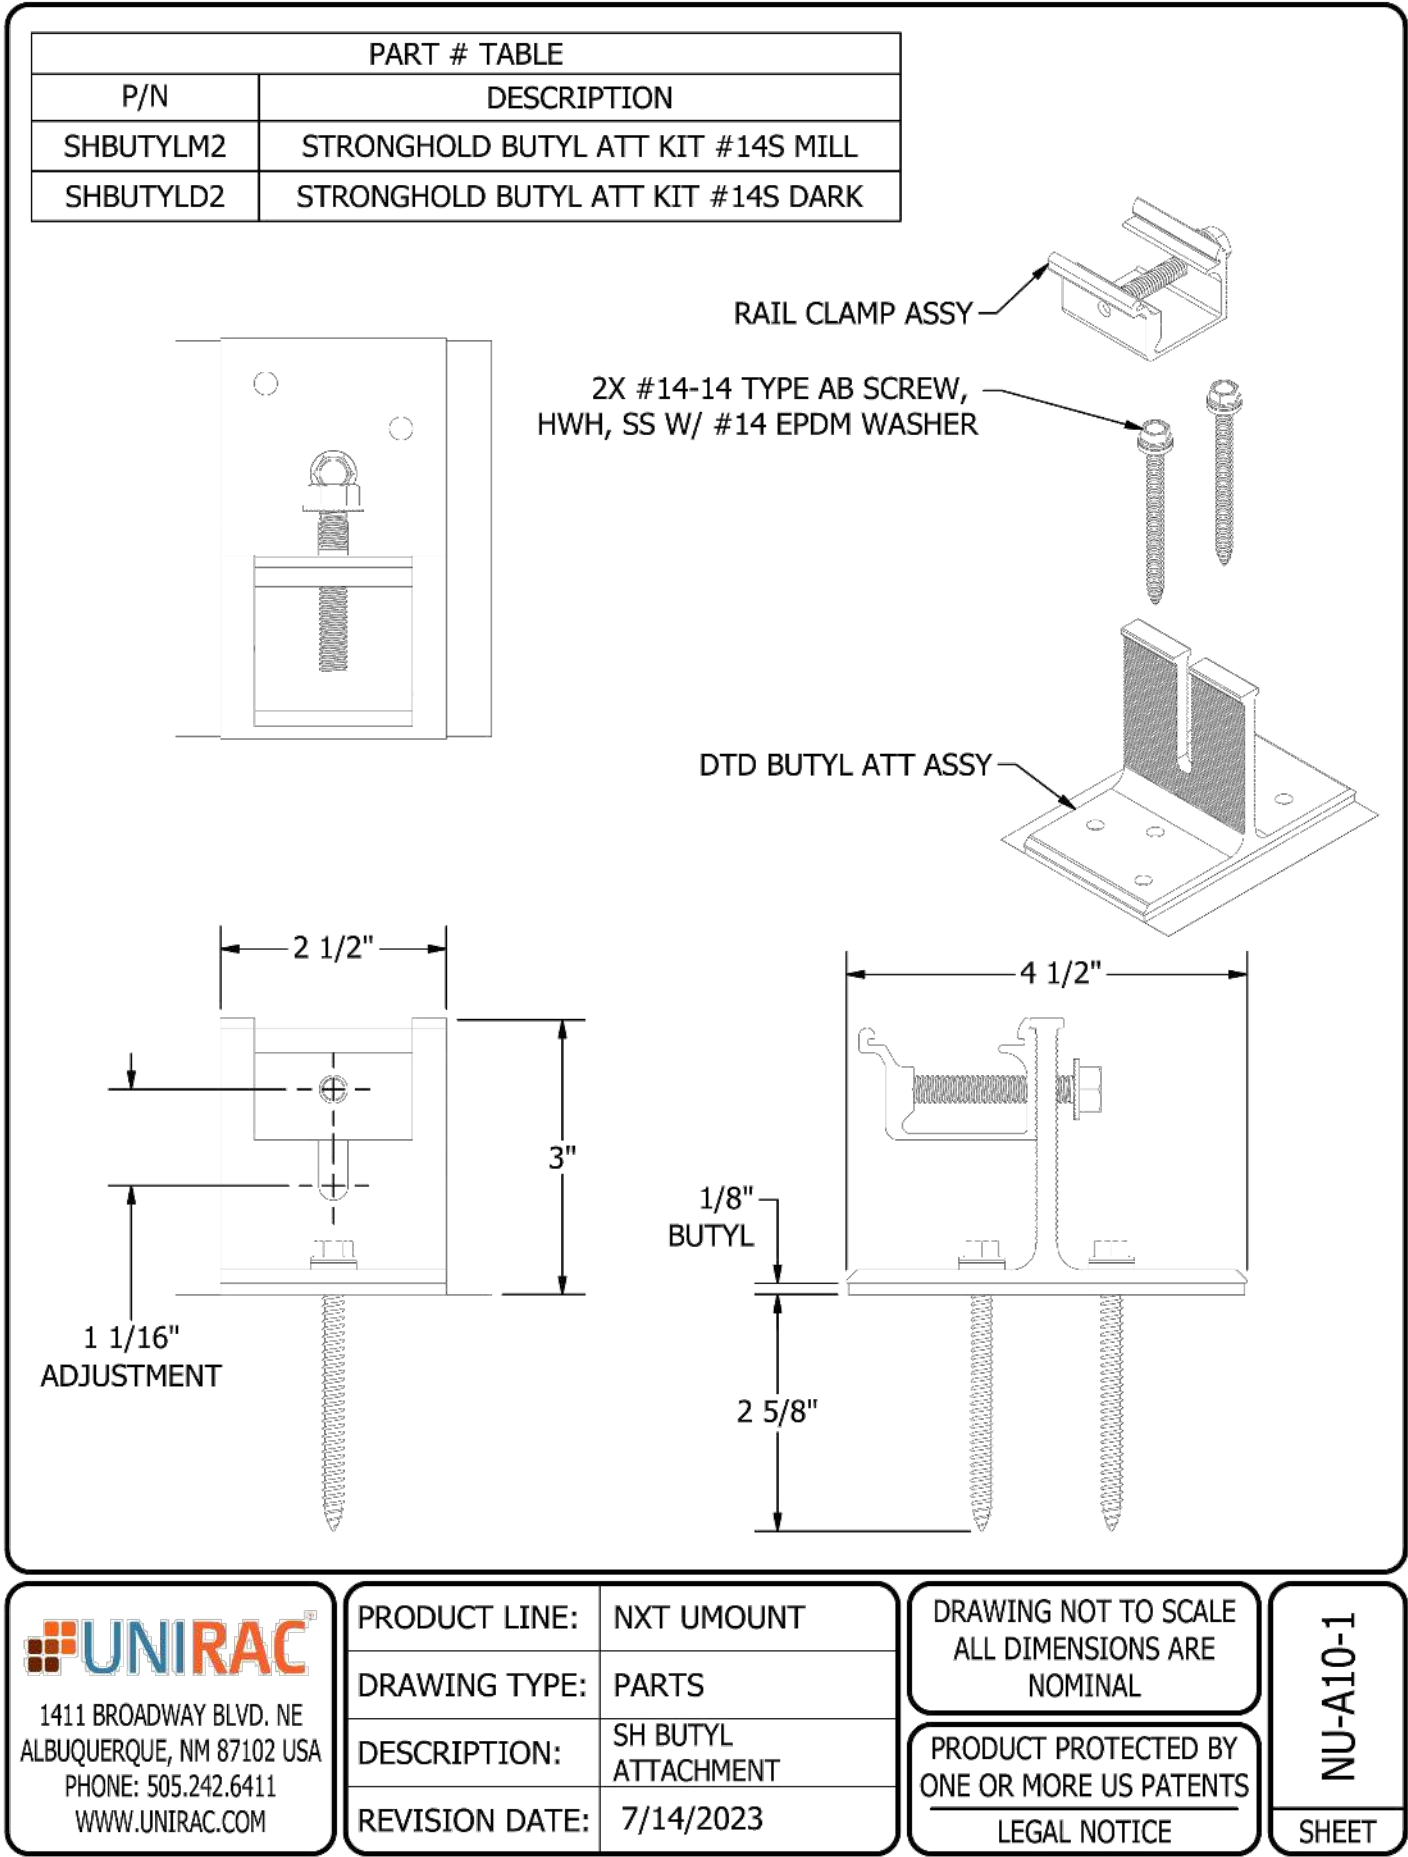

LUNEX POWER INC.
4721 N GRADY AVE
TAMPA FL 33614
LIC #: CVC57085
PHONE: 813-540-8807

REVISIONS		
DESCRIPTION	DATE	REV

DATE: 03/05/2025		
------------------	--	--



PROJECT NAME & ADDRESS		
CHARLES DOWNING RESIDENCE		
251 IRENE LN, LAKE CITY, FL 32055		

DRAWN BY
ESR

SHEET NAME
EQUIPMENT SPECIFICATION

SHEET SIZE
ANSI B 11" X 17"


SHEET NUMBER
PV-15

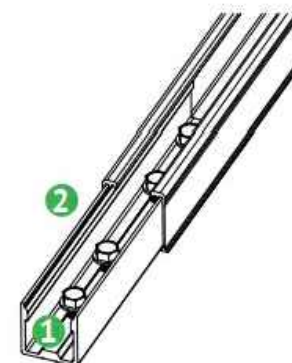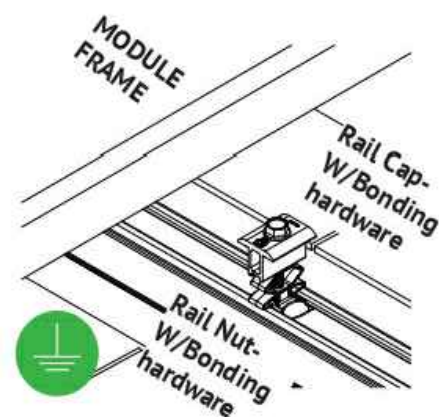

BONDING COMBO MID-END CLAMP ASSEMBLY

- 1 Aluminum combo mid-end clamp cap with stainless steel bonding pins that pierce module frame anodization to bond module to module through clamp
- 2 Stainless steel bolt bonds aluminum clamp to stainless steel Hex bolt
- 3 Aluminum combo mid-end clamp rail nut with stainless steel bonding pins that pierce rail anodization to bond module to module through clamp

NOTE: See Page 19 for installation details.

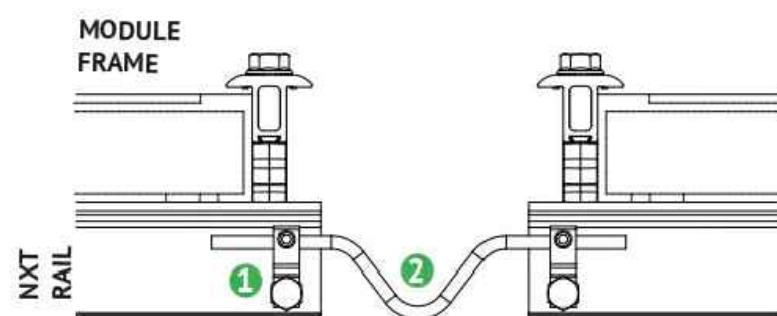

BONDING BETWEEN THERMAL BREAKS

- 1 Lug is connected at the end of each thermal break to the rail.
- 2 Solid copper wire is connected across the gap to bond the two ends.


NOTE: See Page 5 for installation details.

BONDING RAIL SPLICE

- 1 Bonding Hardware creates bond between Splice bar and each rail section.
- 2 Aluminum splice bar spans across rail gap to create rail to rail bond. Rail on at least one side of splice will be grounded.

NOTE:

- See Page 15 for installation details
- Splice certified for single-use only

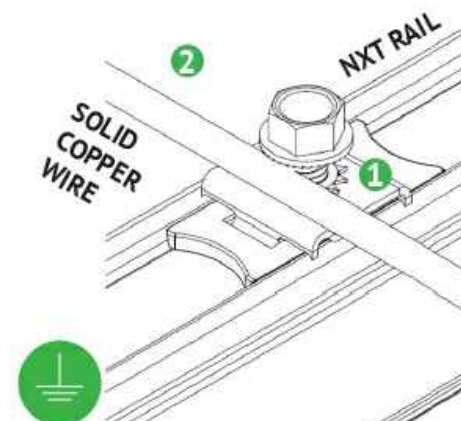

RACK SYSTEM GROUNDING

- 1 Tabs on the stainless-steel washer pierce anodization on the rail to bond rail to ground wire.
- 2 Solid copper wire connected to lug is routed to provide final system ground connection.

NOTE: See Page 16 for installation details and alternate racking system grounding methods.

REVISIONS

DESCRIPTION	DATE	REV

DATE: 03/05/2025

PROJECT NAME & ADDRESS

CHARLES DOWNING
RESIDENCE
251 IRENE LN,
LAKE CITY, FL 32055

DRAWN BY

ESR

SHEET NAME

EQUIPMENT
SPECIFICATION

SHEET SIZE

ANSI B
11" X 17"

SHEET NUMBER

PV-16


NXTUMOUNTTM

BONDING CONNECTIONS & GROUNDING PATHS

INSTALLATION GUIDE

22


PAGE

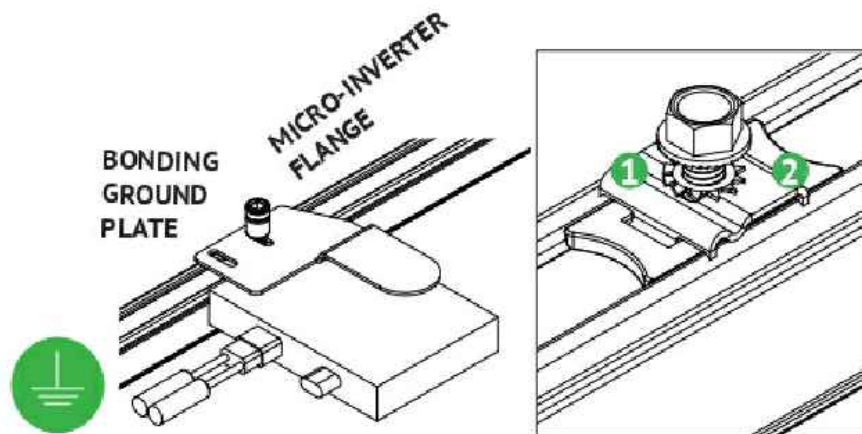

BONDING MICROINVERTER MOUNT

- 1 Stainless steel Tooth lock washer beneath the MLPE flange remove anodization on the MLPE and bonds.
- 2 Tabs on the stainless steel washer remove anodization on the rail and bonds.

NOTE: See Page 17 for installation details

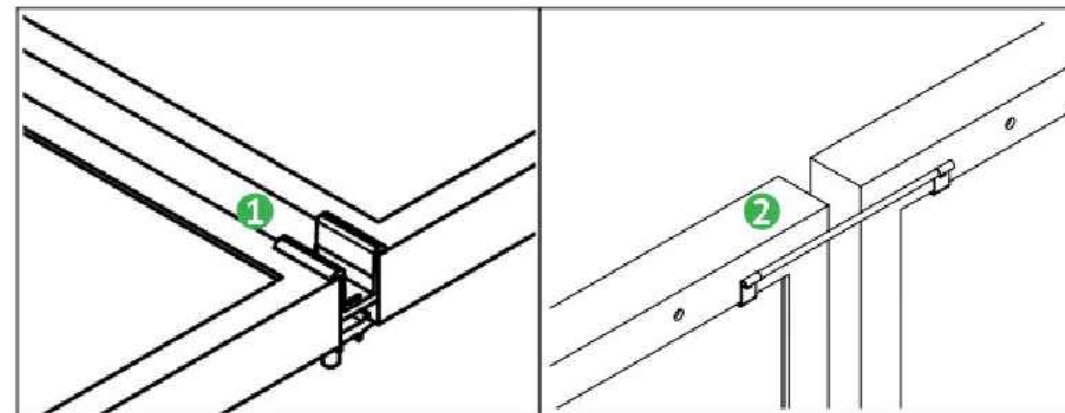

ALTERNATE ROW-TO-ROW BONDING PATHS

- 1 Row-to-row module bonding is accomplished with bonding clamp with 2 integral bonding pins.
- 2 Alternate method by connecting clips on either module to complete the bonding path.

NOTE:

- See Page 16 for installation details
- Row-to-row module bonding certified for single-use only

REVISIONS		
DESCRIPTION	DATE	REV

DATE: 03/05/2025

PROJECT NAME & ADDRESS

CHARLES DOWNING
RESIDENCE
251 IRENE LN,
LAKE CITY, FL 32055

DRAWN BY
ESR

SHEET NAME
EQUIPMENT
SPECIFICATION

SHEET SIZE
ANSI B
11" X 17"

SHEET NUMBER
PV-17



JB-1.2, JB-1.XL

Specification Sheet

PV Junction Box for Composition/Asphalt Shingle Roofs

A. System Specifications and Ratings

- Maximum Voltage: 1,000 Volts
- Maximum Current: **JB-1.2:** 80 Amps; **JB-1.XL:** 120 Amps
- Allowable Wire: 14 AWG – 6 AWG
- Spacing: Please maintain a spacing of at least ½” between uninsulated live parts and fittings for conduit, armored cable, and uninsulated live parts of opposite polarity.
- Enclosure Rating: Type 3R
- Roof Slope Range: 2.5 – 12:12
- Max Side Wall Fitting Size: 1”
- Max Floor Pass-Through Fitting Size: 1”
- Ambient Operating Conditions: (-35°C) - (+75°C)
- Compliance:
 - **JB-1.2:** UL1741, CSA C22.2 No. 290; **JB-1.XL:** UL1741, CSA C22.2 No. 290
 - Approved wire connectors: must conform to UL1741, CSA C22.2 No. 290
- System Marking: **Intertek Symbol and File #5019942**
- Periodic Re-inspections: If re-inspections yield loose components, loose fasteners, or any corrosion between components, components that are found to be affected are to be replaced immediately.



Table 1: Typical Wire Size, Torque Loads and Ratings

	1 Conductor	2 Conductor	Torque				
			Type	NM	Inch Lbs	Voltage	Current
ABB ZS6 terminal block	10-24 awg	16-24 awg	Sol/Str	0.5-0.7	6.2-8.85	600V	30 amp
ABB ZS10 terminal block	6-24 awg	12-20 awg	Sol/Str	1.0-1.6	8.85-14.16	600V	40 amp
ABB ZS16 terminal block	4-24 awg	10-20 awg	Sol/Str	1.6-2.4	14.6-21.24	600V	60 amp
ABB M6/8 terminal block	8-22 awg		Sol/Str	.08-1	8.85	600V	50 amp
Ideal 452 Red WING-OUT Wire Connector	8-18 awg		Sol/Str	Self-Torque	Self-Torque	600V	
Ideal 451 Yellow WING-OUT Wire Connector	10-18 awg		Sol/Str	Self-Torque	Self-Torque	600V	
Ideal, In-Sure Push-In Connector Port #93	10-14 awg		Sol/Str	Self-Torque	Self-Torque	600V	
WAGO, 2204-1201	10-20 awg	16-24 awg	Sol/Str	Self-Torque	Self-Torque	600V	30 amp
WAGO, 221-612	10-20 awg	10-24 awg	Sol/Str	Self-Torque	Self-Torque	600V	30 amp
Dottie DRC75	6-12 awg		Sol/Str	Snap-In	Snap-In		
ESP NG-53	4-6 awg		Sol/Str		45	2000V	
	10-14 awg		Sol/Str		35		
ESP NG-717	4-6 awg		Sol/Str		45	2000V	
	10-14 awg		Sol/Str		35		
Brumall 4-5,3	4-6 awg		Sol/Str		45	2000V	
	10-14 awg		Sol/Str		35		

Table 2: Minimum wire-bending space for conductors through a wall opposite terminals in mm (inches)

Wire size, AWG or kcmil (mm2)	Wires per terminal (pole)			
	1 mm (inch)	2 mm (inch)	3 mm (inch)	4 or More mm (inch)
14-10 (2.1-5.3)	Not Specified	-	-	-
8 (8.4)	38.1 (1-1/2)	-	-	-
6 (13.3)	50.8 (2)	-	-	-



LUNEX POWER INC.
4721 N GRADY AVE
TAMPA FL 33614
LIC #: CVC57085
PHONE: 813-540-8807

REVISIONS

DESCRIPTION	DATE	REV

DATE: 03/05/2025

PROJECT NAME & ADDRESS

CHARLES DOWNING
RESIDENCE

DRAWN BY

ESR

SHEET NAME
EQUIPMENT
SPECIFICATION

SHEET SIZE

ANSI B
11" X 17"

SHEET NUMBER

PV-18



PHONE: 801-613-2759 | WWW.EZSOLARPRODUCTS.COM