


LOT 14 - STONEHENGE PHASE 2

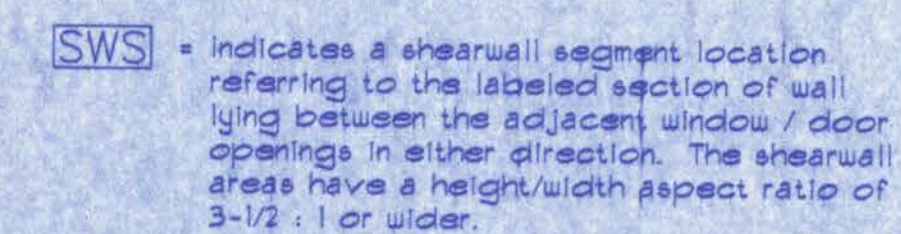


CONDITIONED	- - - - -	1934 SF
GARAGE	- - - - -	546 SF
ENTRY	- - - - -	86 SF
TOTAL ROOF	- - - - -	2877 SF
PATIO	- - - - -	311 SF

SHEET A-1	- - - - -	-	SITE PLAN + FLOOR PLAN
SHEET A-2	- - - - -	-	ELEVATIONS + GEN. NOTES
SHEET A-3	- - - - -	-	ELEVATIONS
SHEET A-4	- - - - -	-	FOUNDATION + SECTIONS
SHEET A-5	- - - - -	-	ELECTRICAL
SHEET S-1	- - - - -	-	WIND ENGINEERING


A-1

FILE: 05-020	RESIDENCE LOT 14 - STONEHENGE PH. 2	SHEET: 1 OF 5
DATE: 4-8-05		CAD FILE: 05020
DRAWN: T A D		REV: 12-9-04
CHECK: T A D		REV:

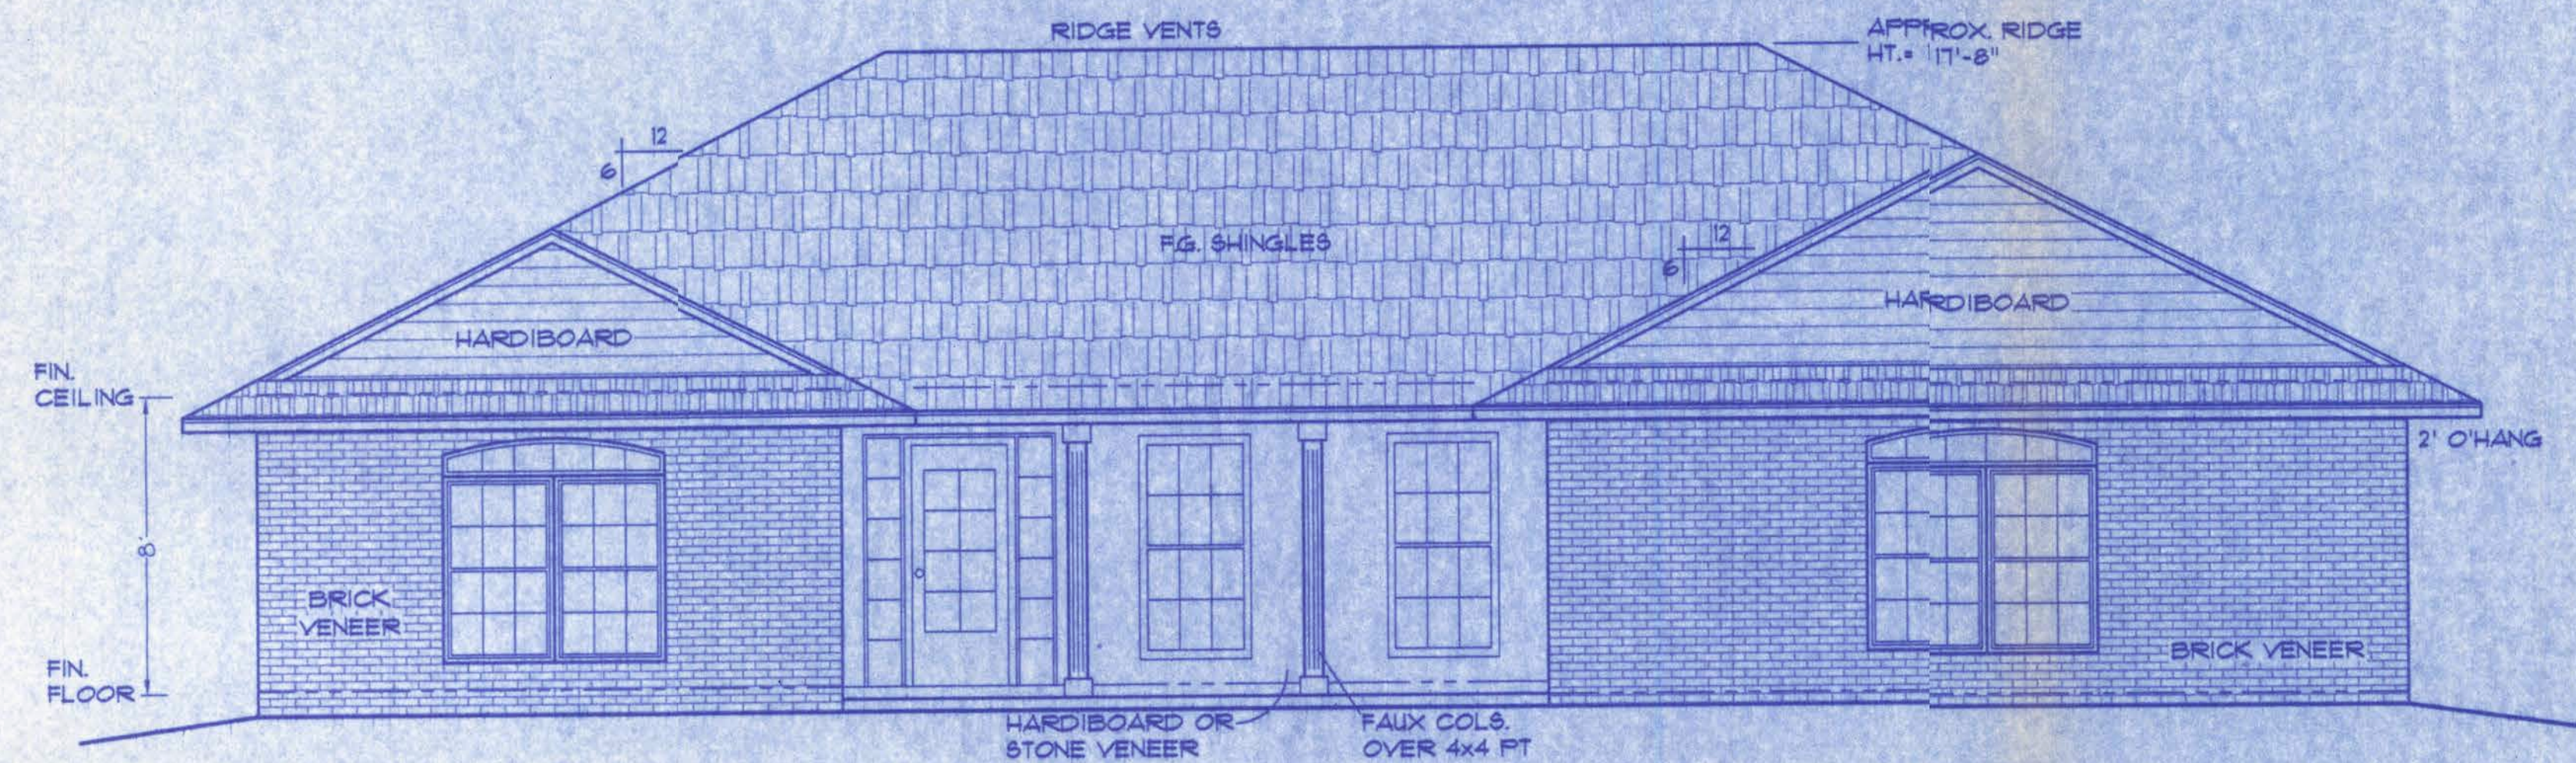

FRONT ELEVATION

SCALE: 1/4 IN. = 1 FT.

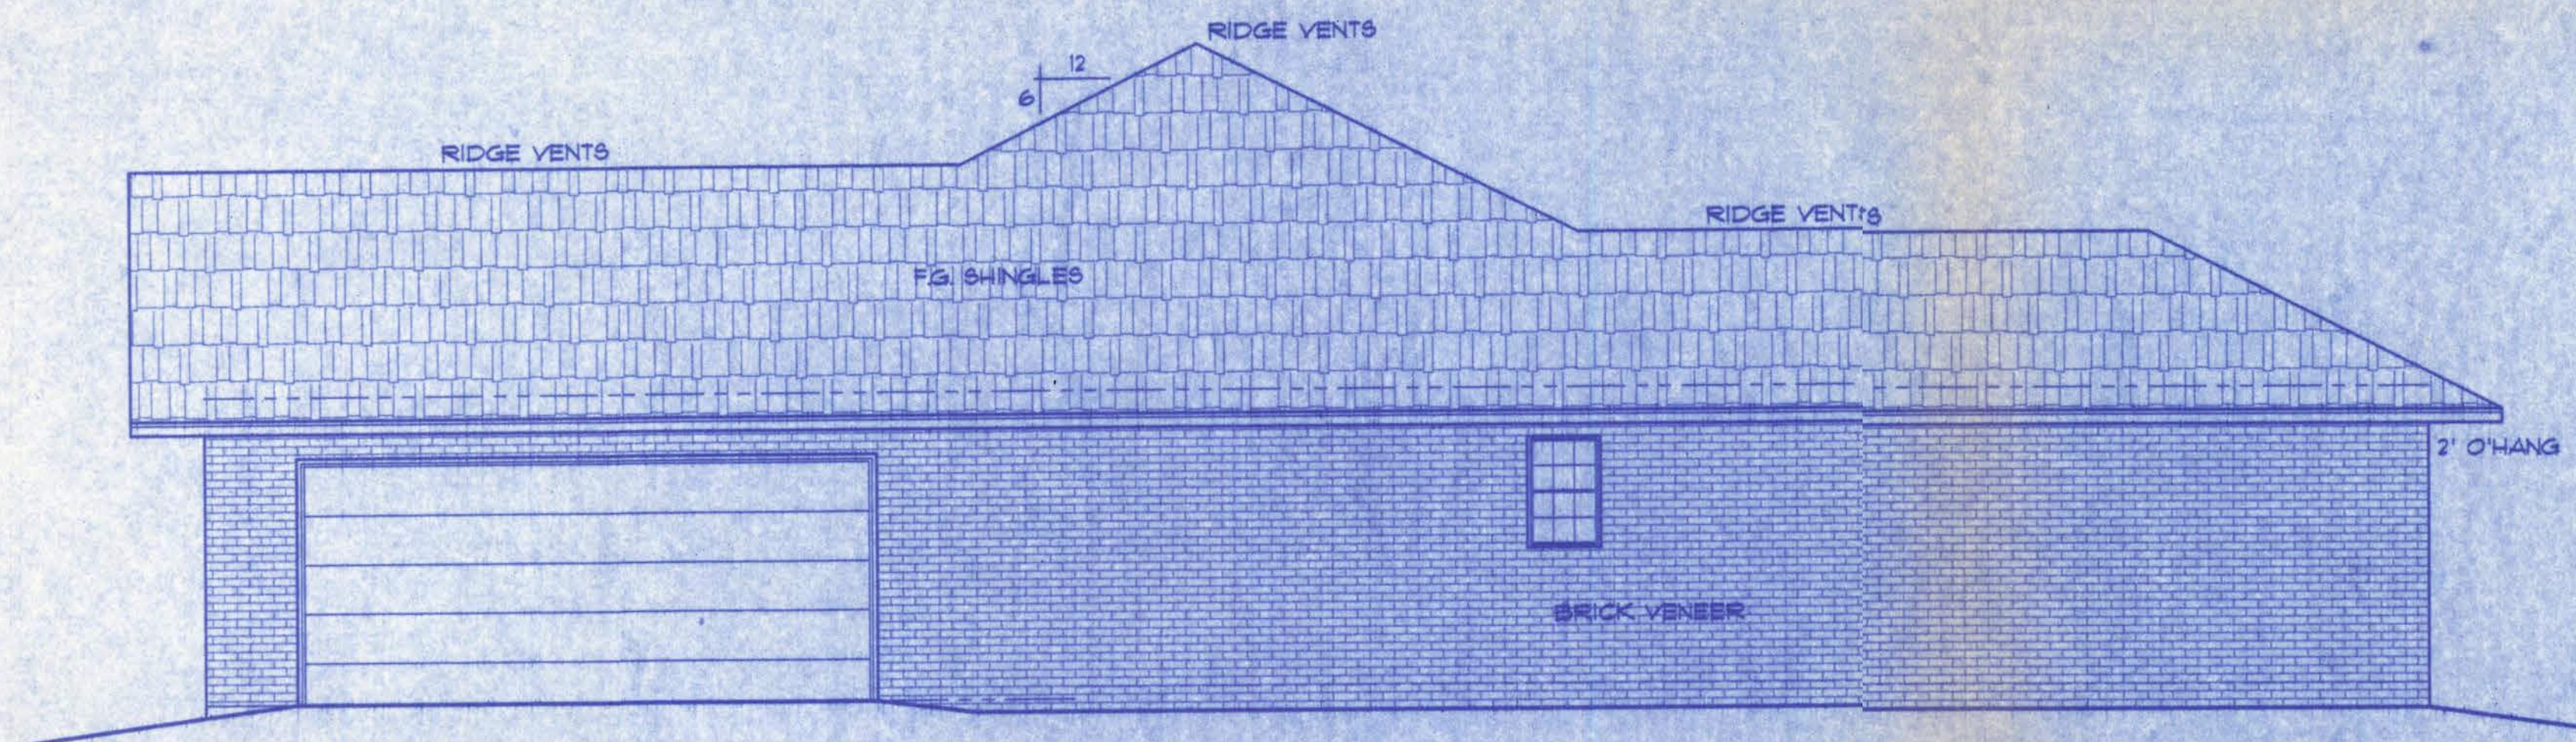

RIGHT ELEVATION

SCALE: 1/4 IN. = 1 FT.

GENERAL NOTES:

- 1.) See "Wind Load Detail Sheet S-1" and Wind Engineer's Notes for data pertaining to Wind Design and compliance w/ Florida Building Code.
- 2.) All concrete used to be 2500 PSI strength or greater.
- 3.) HVAC duct and unit size/design is by engineered shop drawings from the AC contractor.
- 4.) Windows to be alum. framed and double glazed. Sizes shown are nominal and may vary with manufacturer.
- 5.) Roof Truss design is the responsibility of the supplier.
- 6.) The Truss Manufacturer shall prepare Shop Drawings indicating Truss placement, Girder locations, Truss-to-Truss Connections and any point loads. The Contractor shall notify the Designer of any point loads in excess of 2.0k for Fnd. Modification.
- 7.) Site analysis or preparation information is not a part of this plan and is the responsibility of the owner.
- 8.) Cabinet and millwork detail is not a part of this plan. The plan is a general design and details shall be the responsibility of the owner and/or contractor.

WINDLOAD ENGINEER: Mark Diasway, PE No.53915, POB 868, Lake City, FL 32056, 386-754-5419


CERTIFICATION: These plans and "Windload Engineering", Sheet S-1, attached, comply with Florida Building Code 2001, Section 1606 wind loads, to the best of my knowledge.

LIMITATION: This design is valid for one building, at specified location, permitted within 90 days of signature date. In case of conflict, structural requirements, scope of work, and builder responsibilities on sheet S-1 control.

LOT No. 14, STONEHEDGE
Location: PHASE 2 - COLUMBIA CO. Job No. 509155


A-2

FILE: 05-020	RESIDENCE LOT 14 - STONEHEDGE PH. 2	SHEET: 2 OF 5
DATE: 4-7-05		CAD FILE: 05020
DRAWN: T A D	PREPARED BY: TIM DELBENE Residential Drafting + Design	REV:
CHECK: T A D	Rt. 4, Box 330, Lake City, FL 32055 Phone: C 904 3 755-5891	REV:

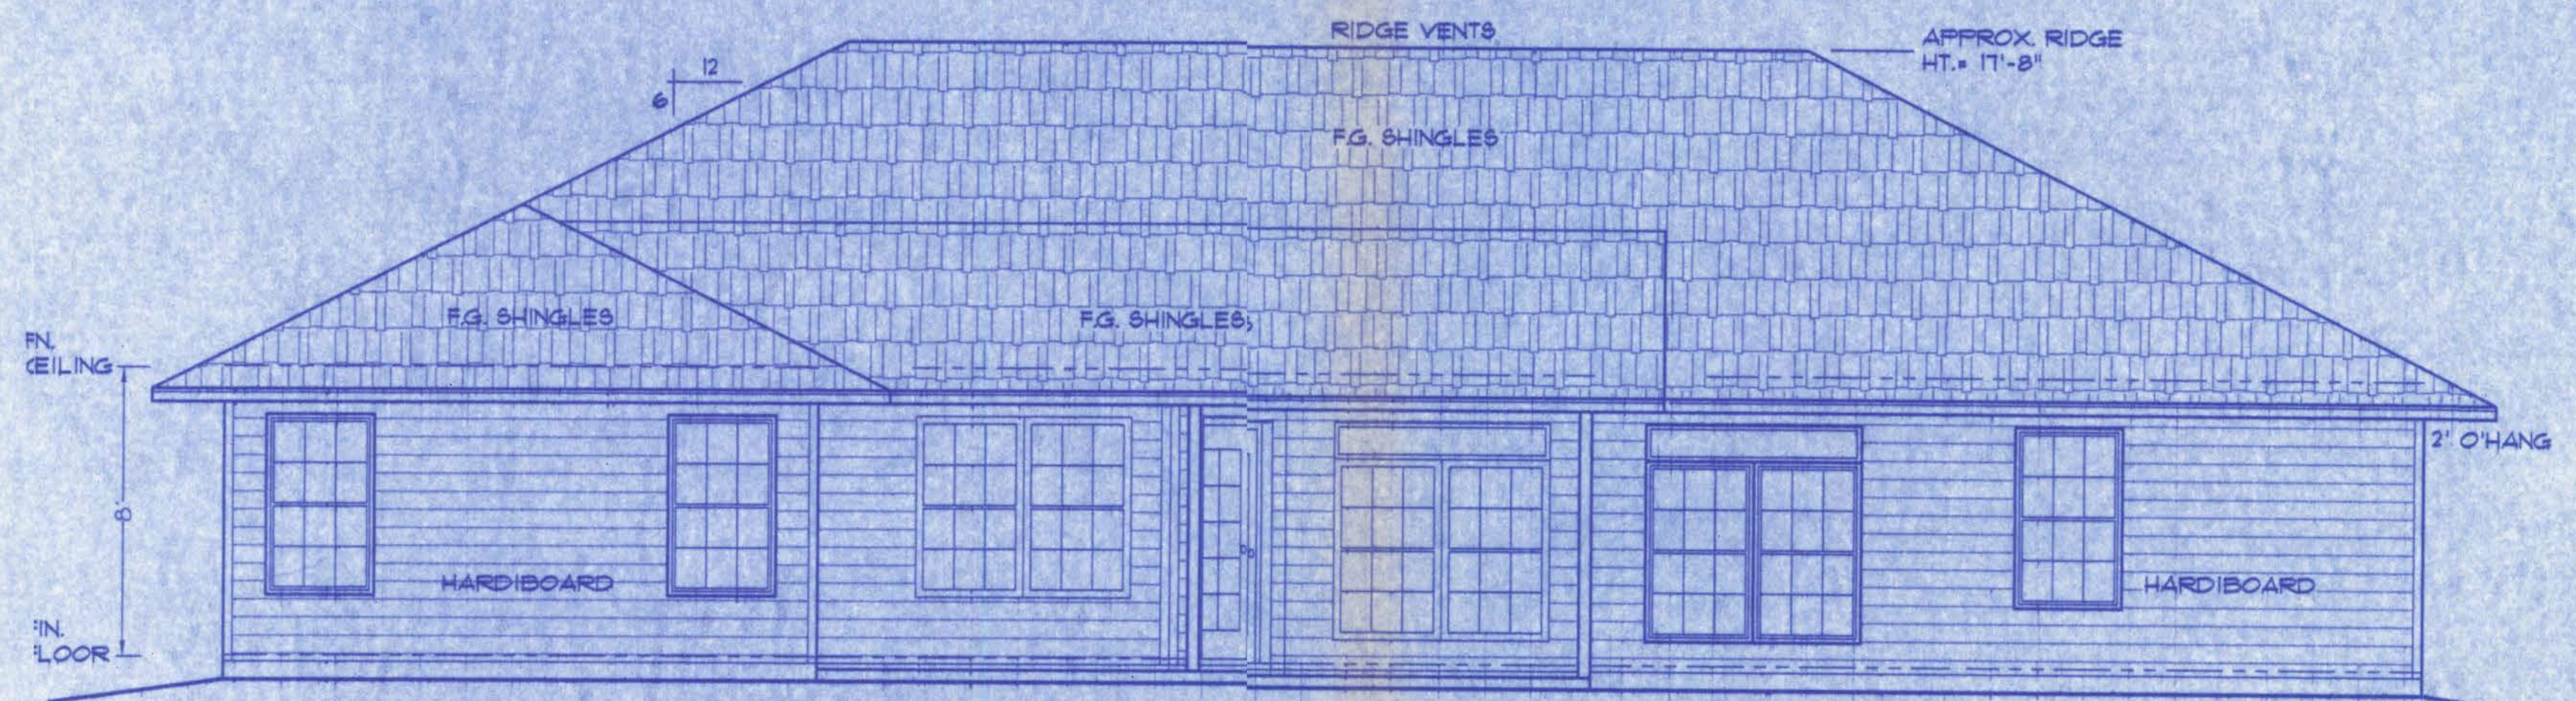

REAR ELEVATION

SCALE: 1/4" IN. = 1 FT.

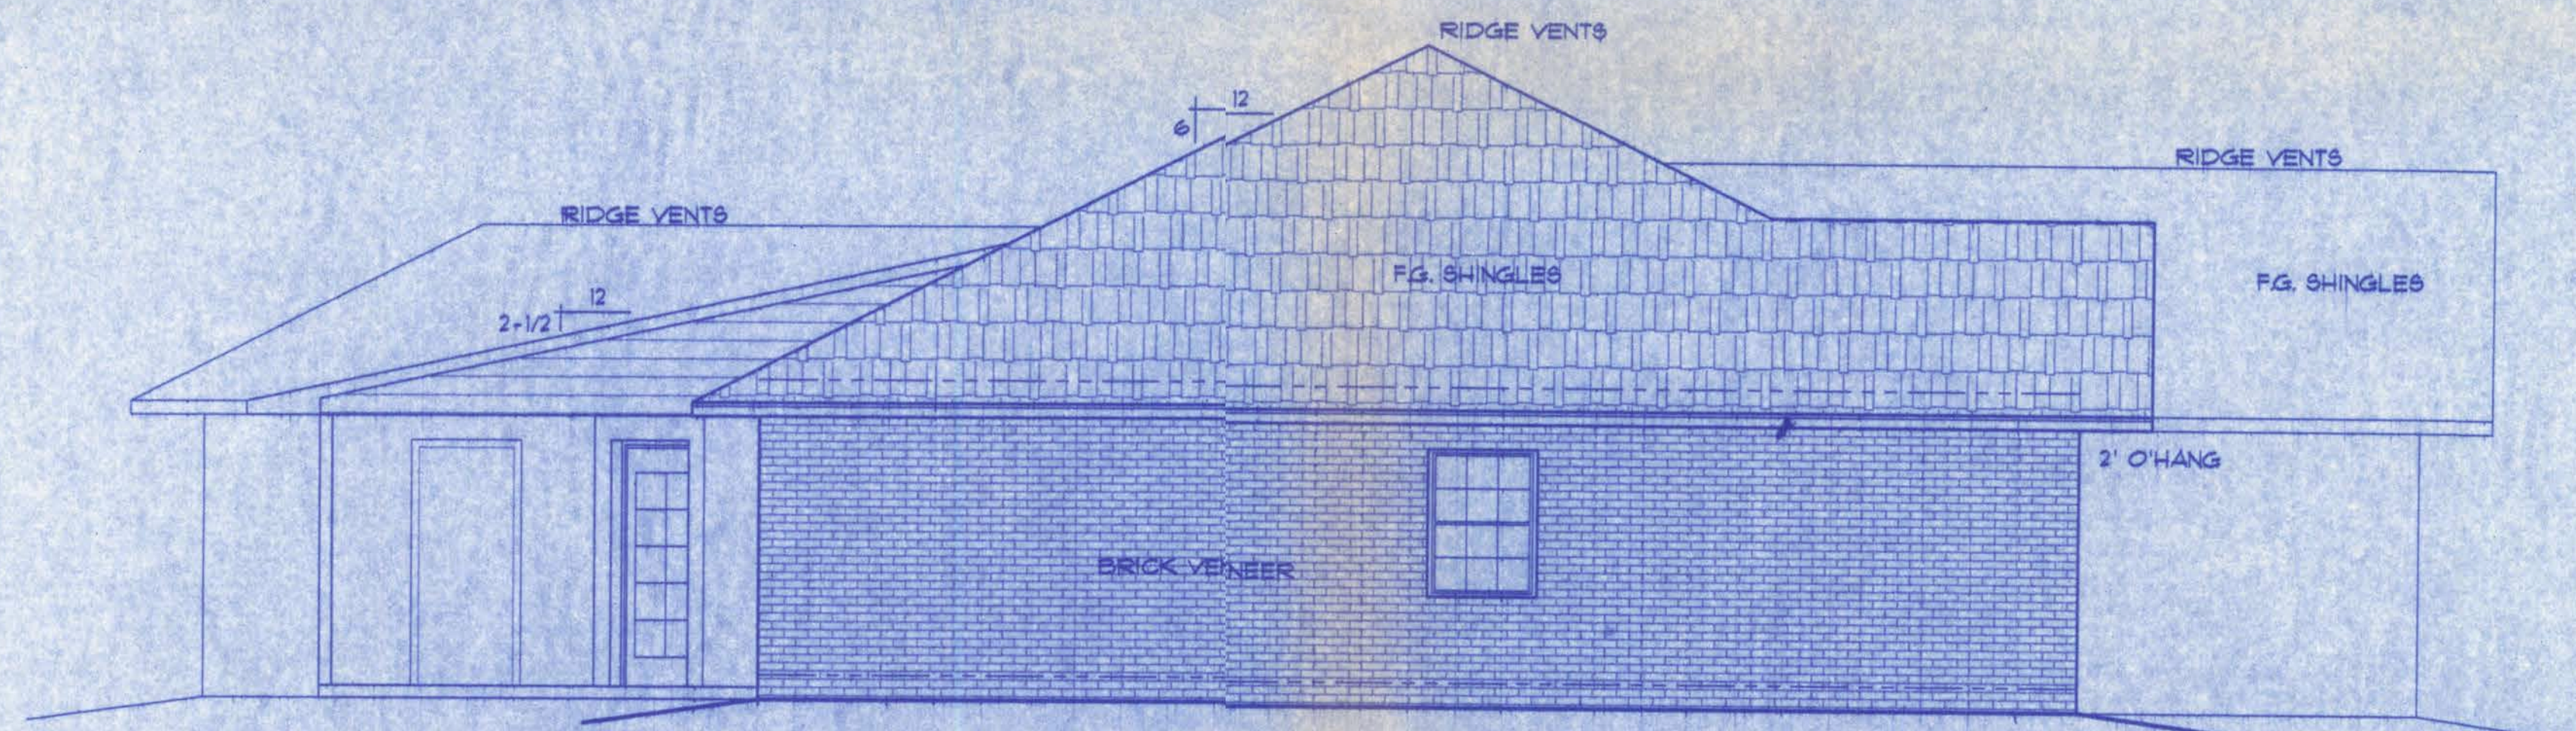

LEFT ELEVATION

SCALE: 1/4" IN. = 1 FT.

WINDLOAD ENGINEER: Mark Disoway, PE No.53915, POB 868, Lake City, FL 32056, 386-754-5419

CERTIFICATION: These plans and "Windload Engineering", Sheet S-1, attached, comply with Florida Building Code 2001, Section 1608, wind loads, to the best of my knowledge.






LIMITATION: This design is valid for one building, at specified location, permitted within 90 days of signature date. In case of conflict, structural requirements, scope of work, and builder responsibilities on sheet S-1 control.

LOT No. 14, STONEHENGE
Location: PHASE 2 - COLUMBIA CO. Job No. 509155

Mark Disoway
2758185

A-3

FILE: 05-020	RESIDENCE LOT 14 - STONEHENGE PH. 2	SHEET: 3 OF 5
DATE: 4-7-05		CAD FILE: 05020
DRAWN: T A D	PREPARED BY: TIM DELBENE Residential Drafting + Design	REV:
CHECK: T A D	Rt. 4, Box 330, Lake City, FL 32055 Phone: (904) 275-5831	REV:

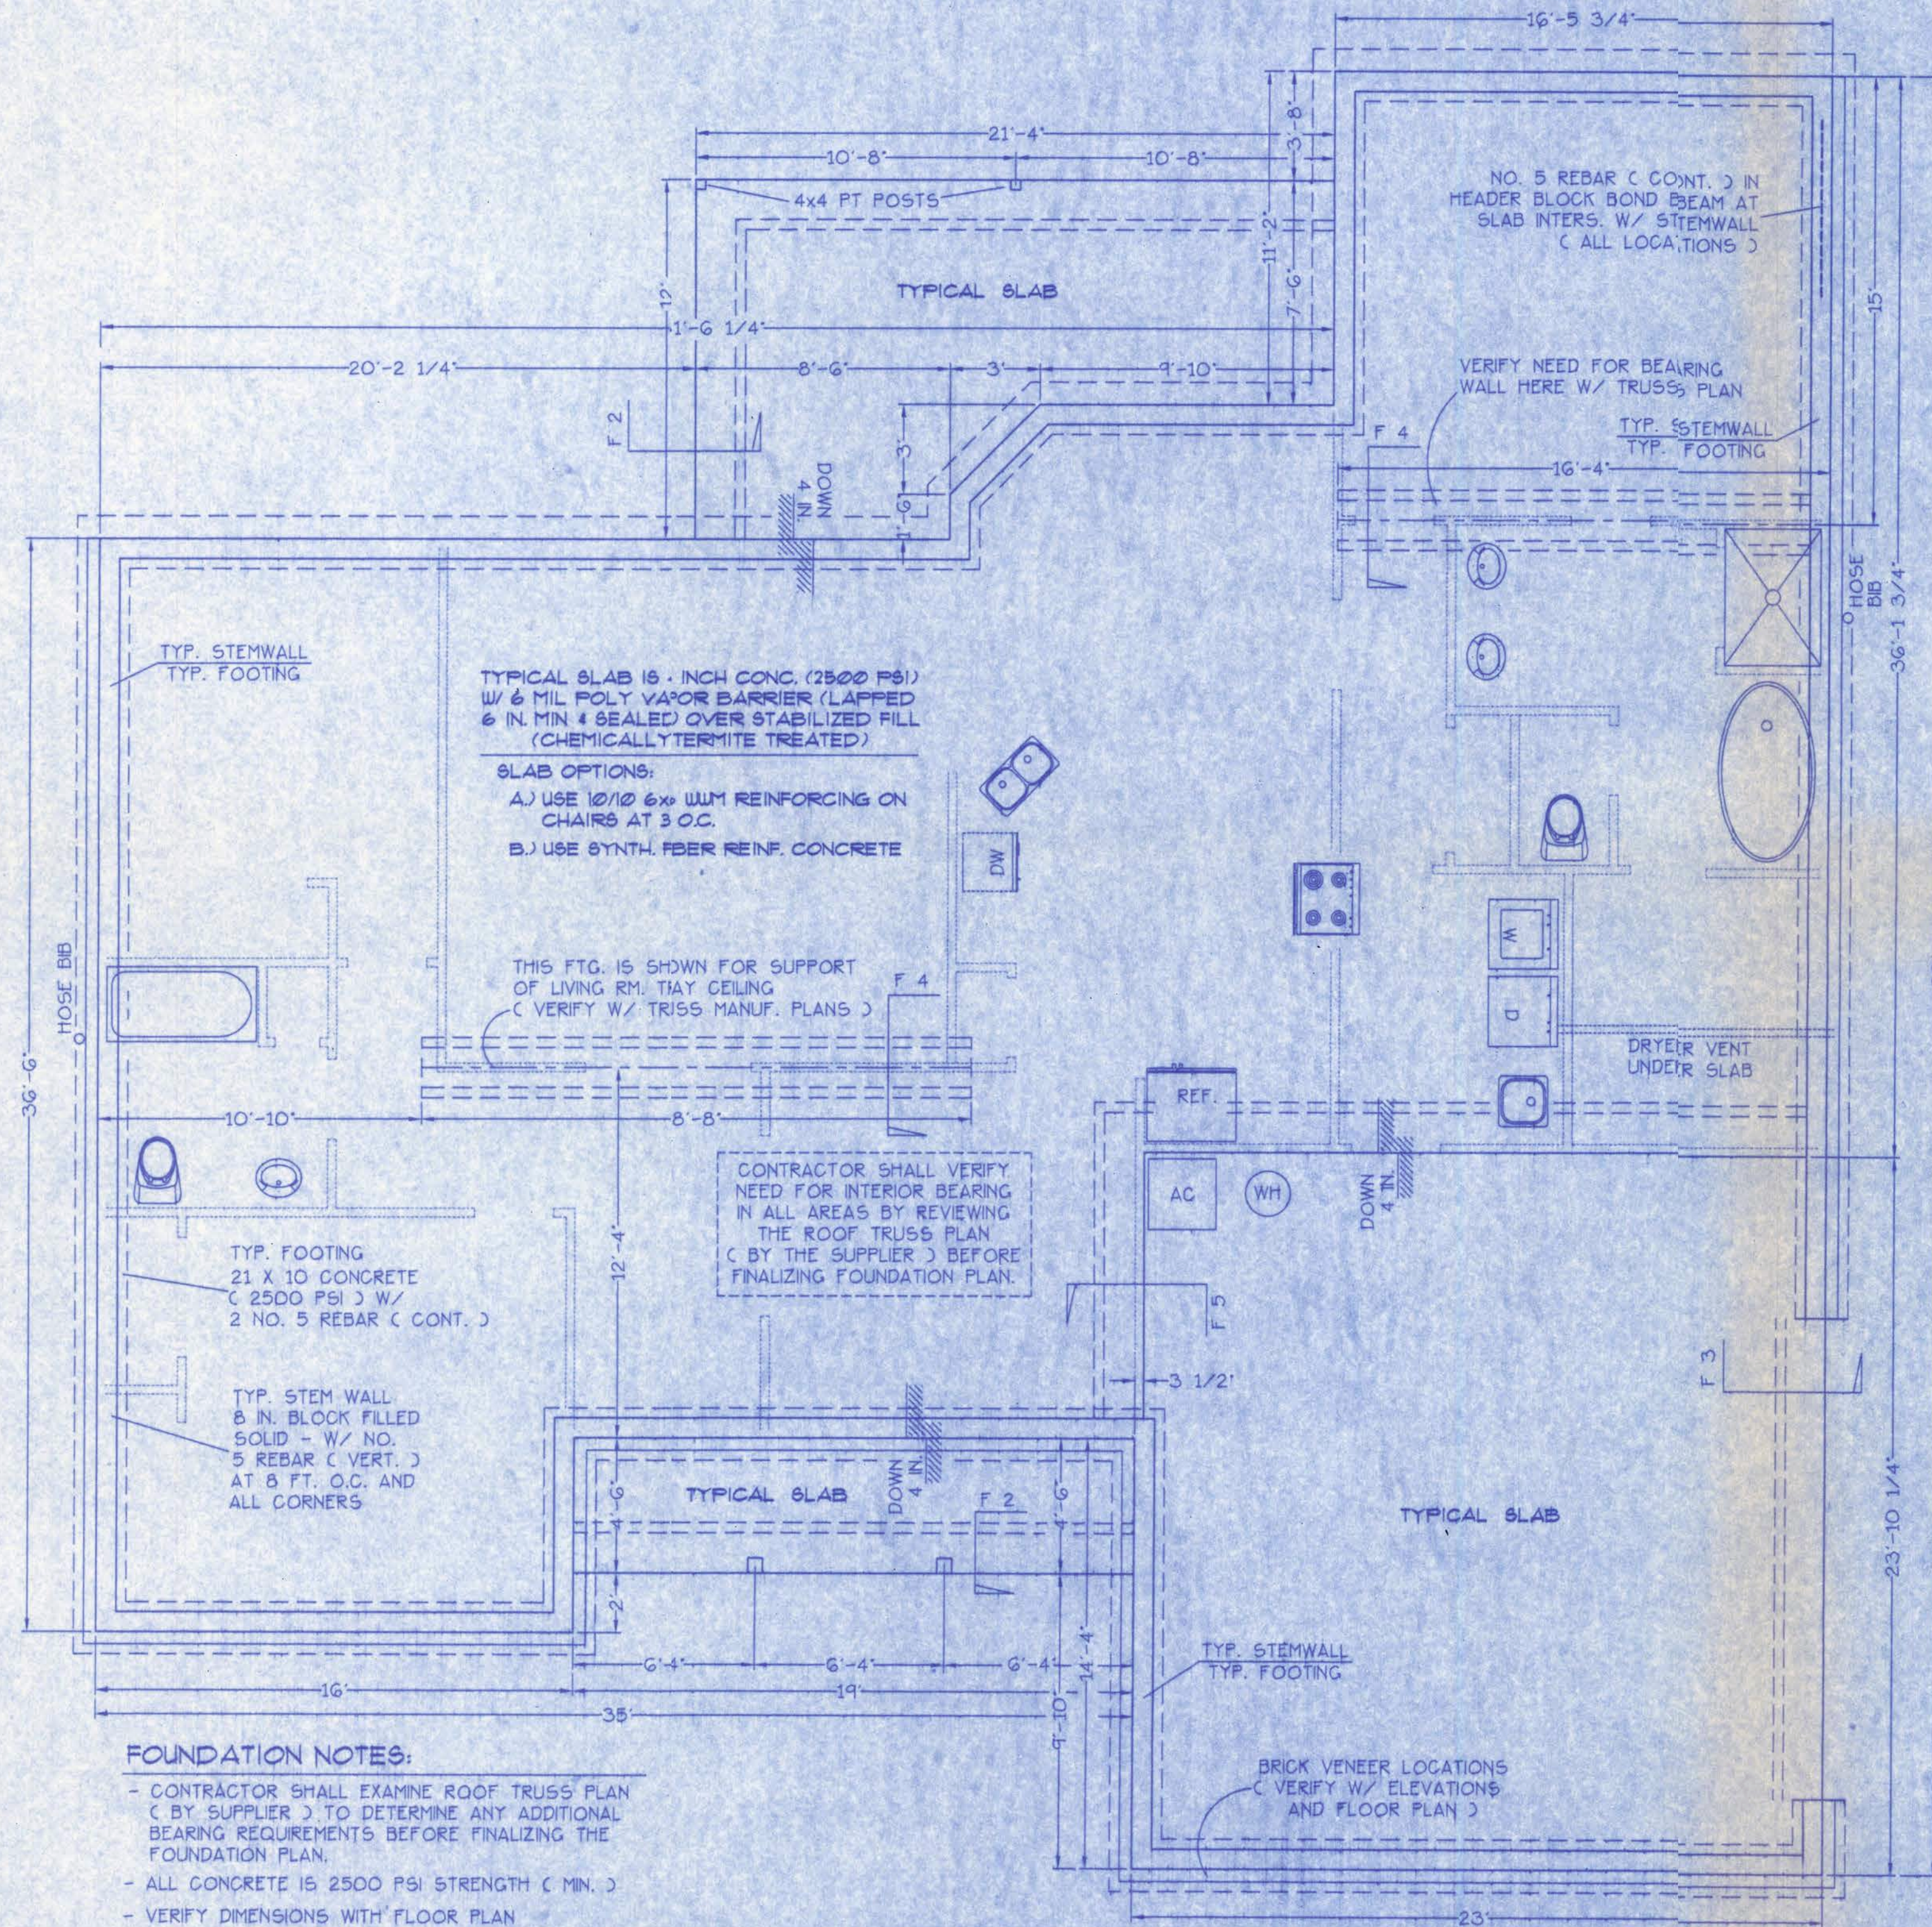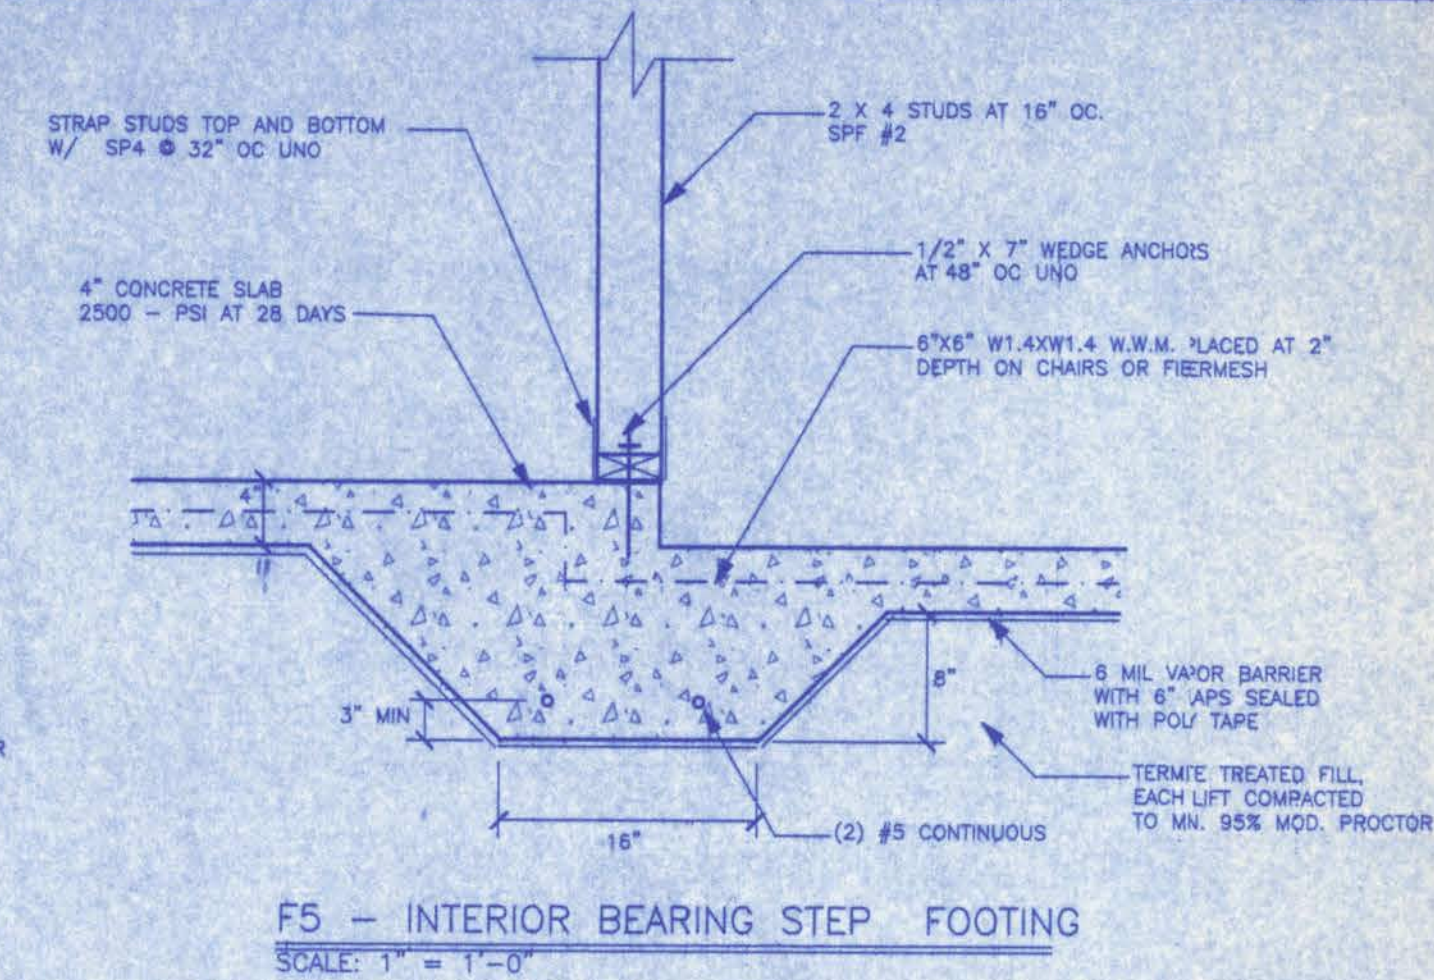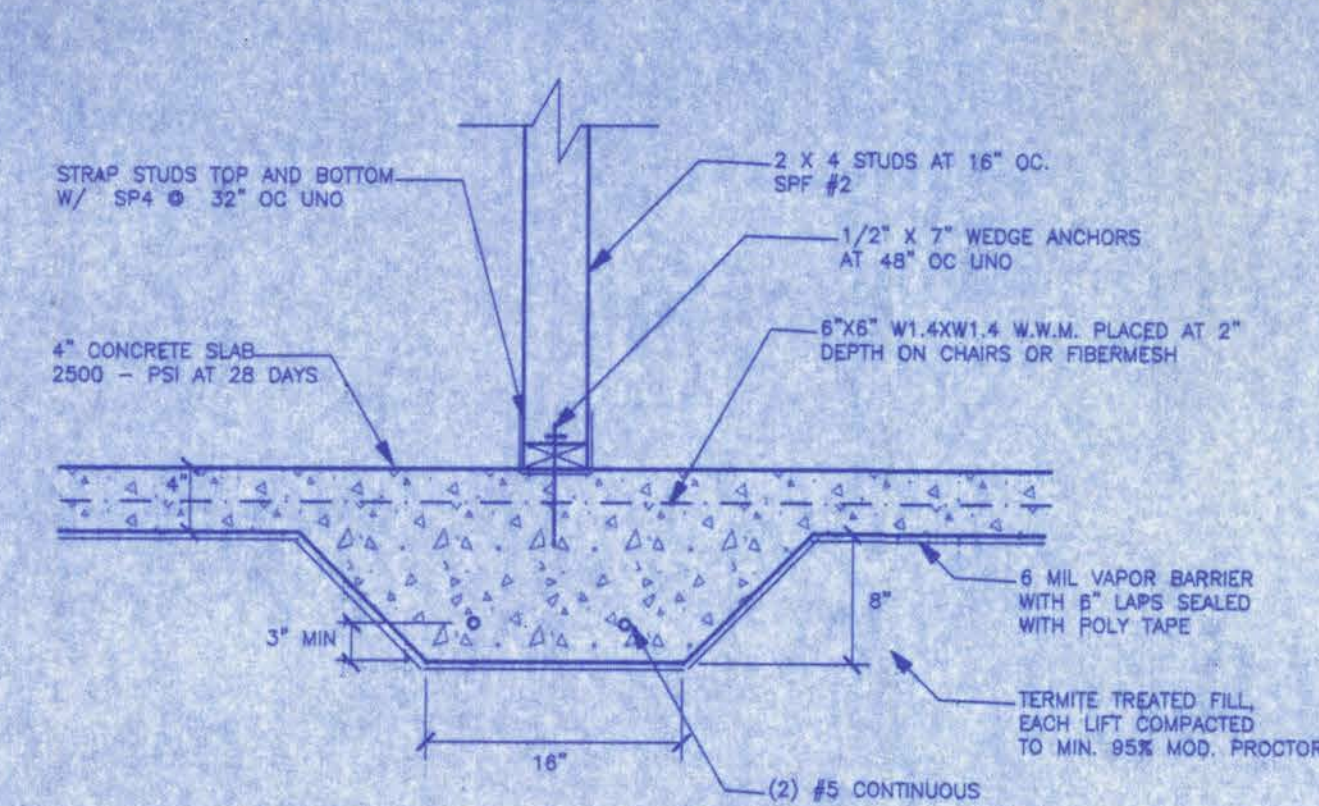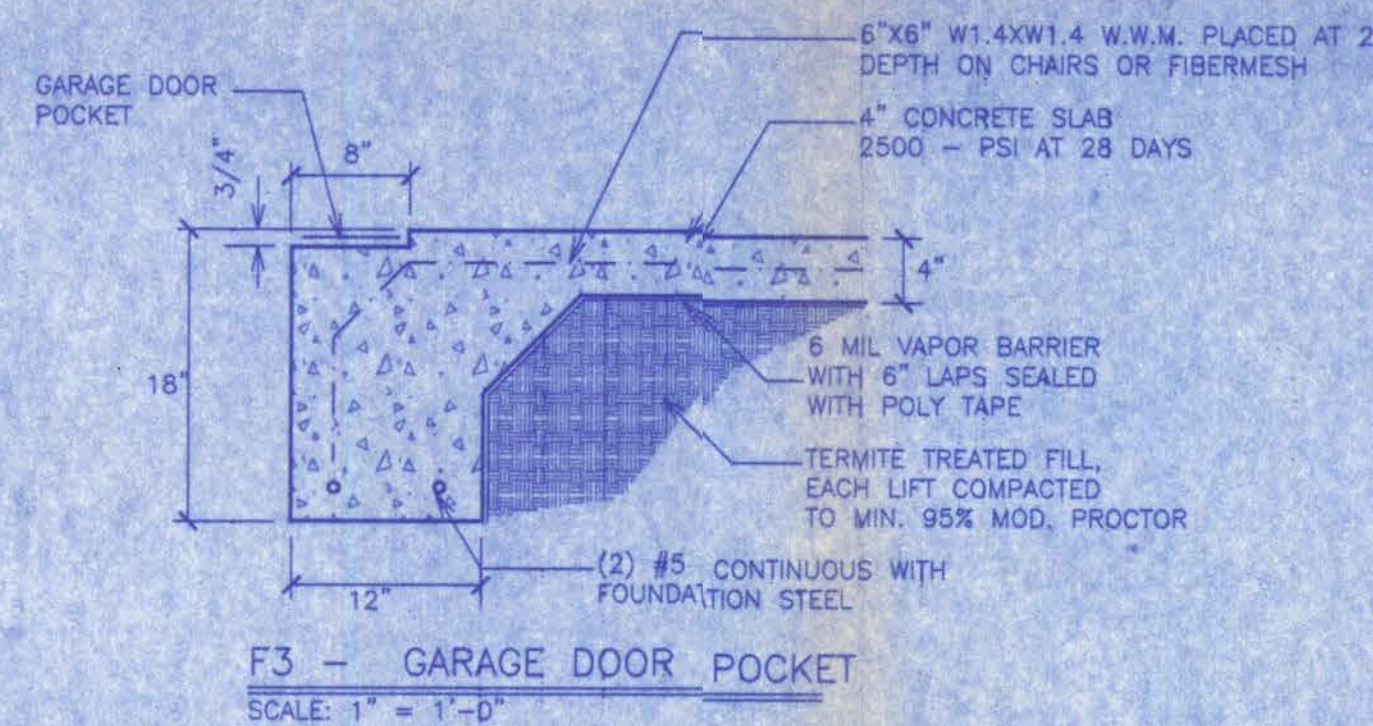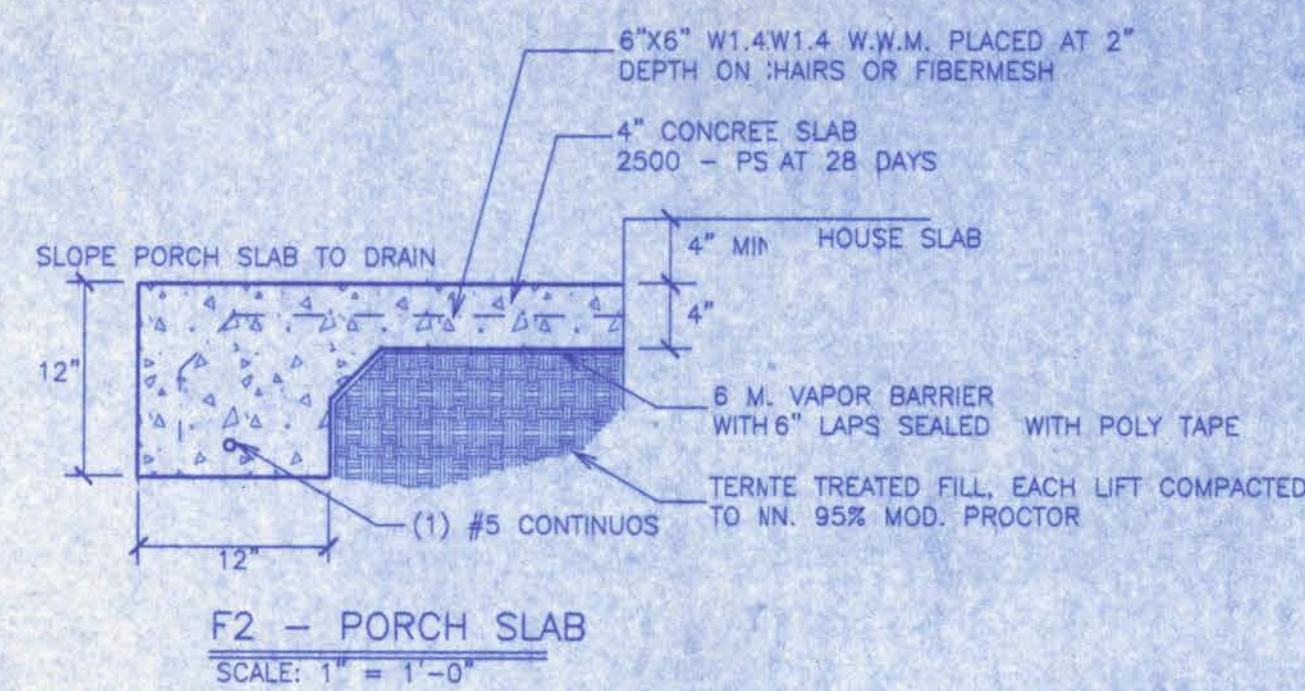


FOUNDATION NOTES:

- CONTRACTOR SHALL EXAMINE ROOF TRUSS PLAN (BY SUPPLIER) TO DETERMINE ANY ADDITIONAL BEARING REQUIREMENTS BEFORE FINALIZING THE FOUNDATION PLAN.
- ALL CONCRETE IS 2500 PSI STRENGTH (MIN.)
- VERIFY DIMENSIONS WITH FLOOR PLAN
- SITE ANALYSIS AND PREPARATION DATA IS NOT A PART OF THIS PLAN AND IS THE RESPONSIBILITY OF THE CONTRACTOR / OWNER.

FOUNDATION PLAN

SCALE: 1/4" = 1 FT.

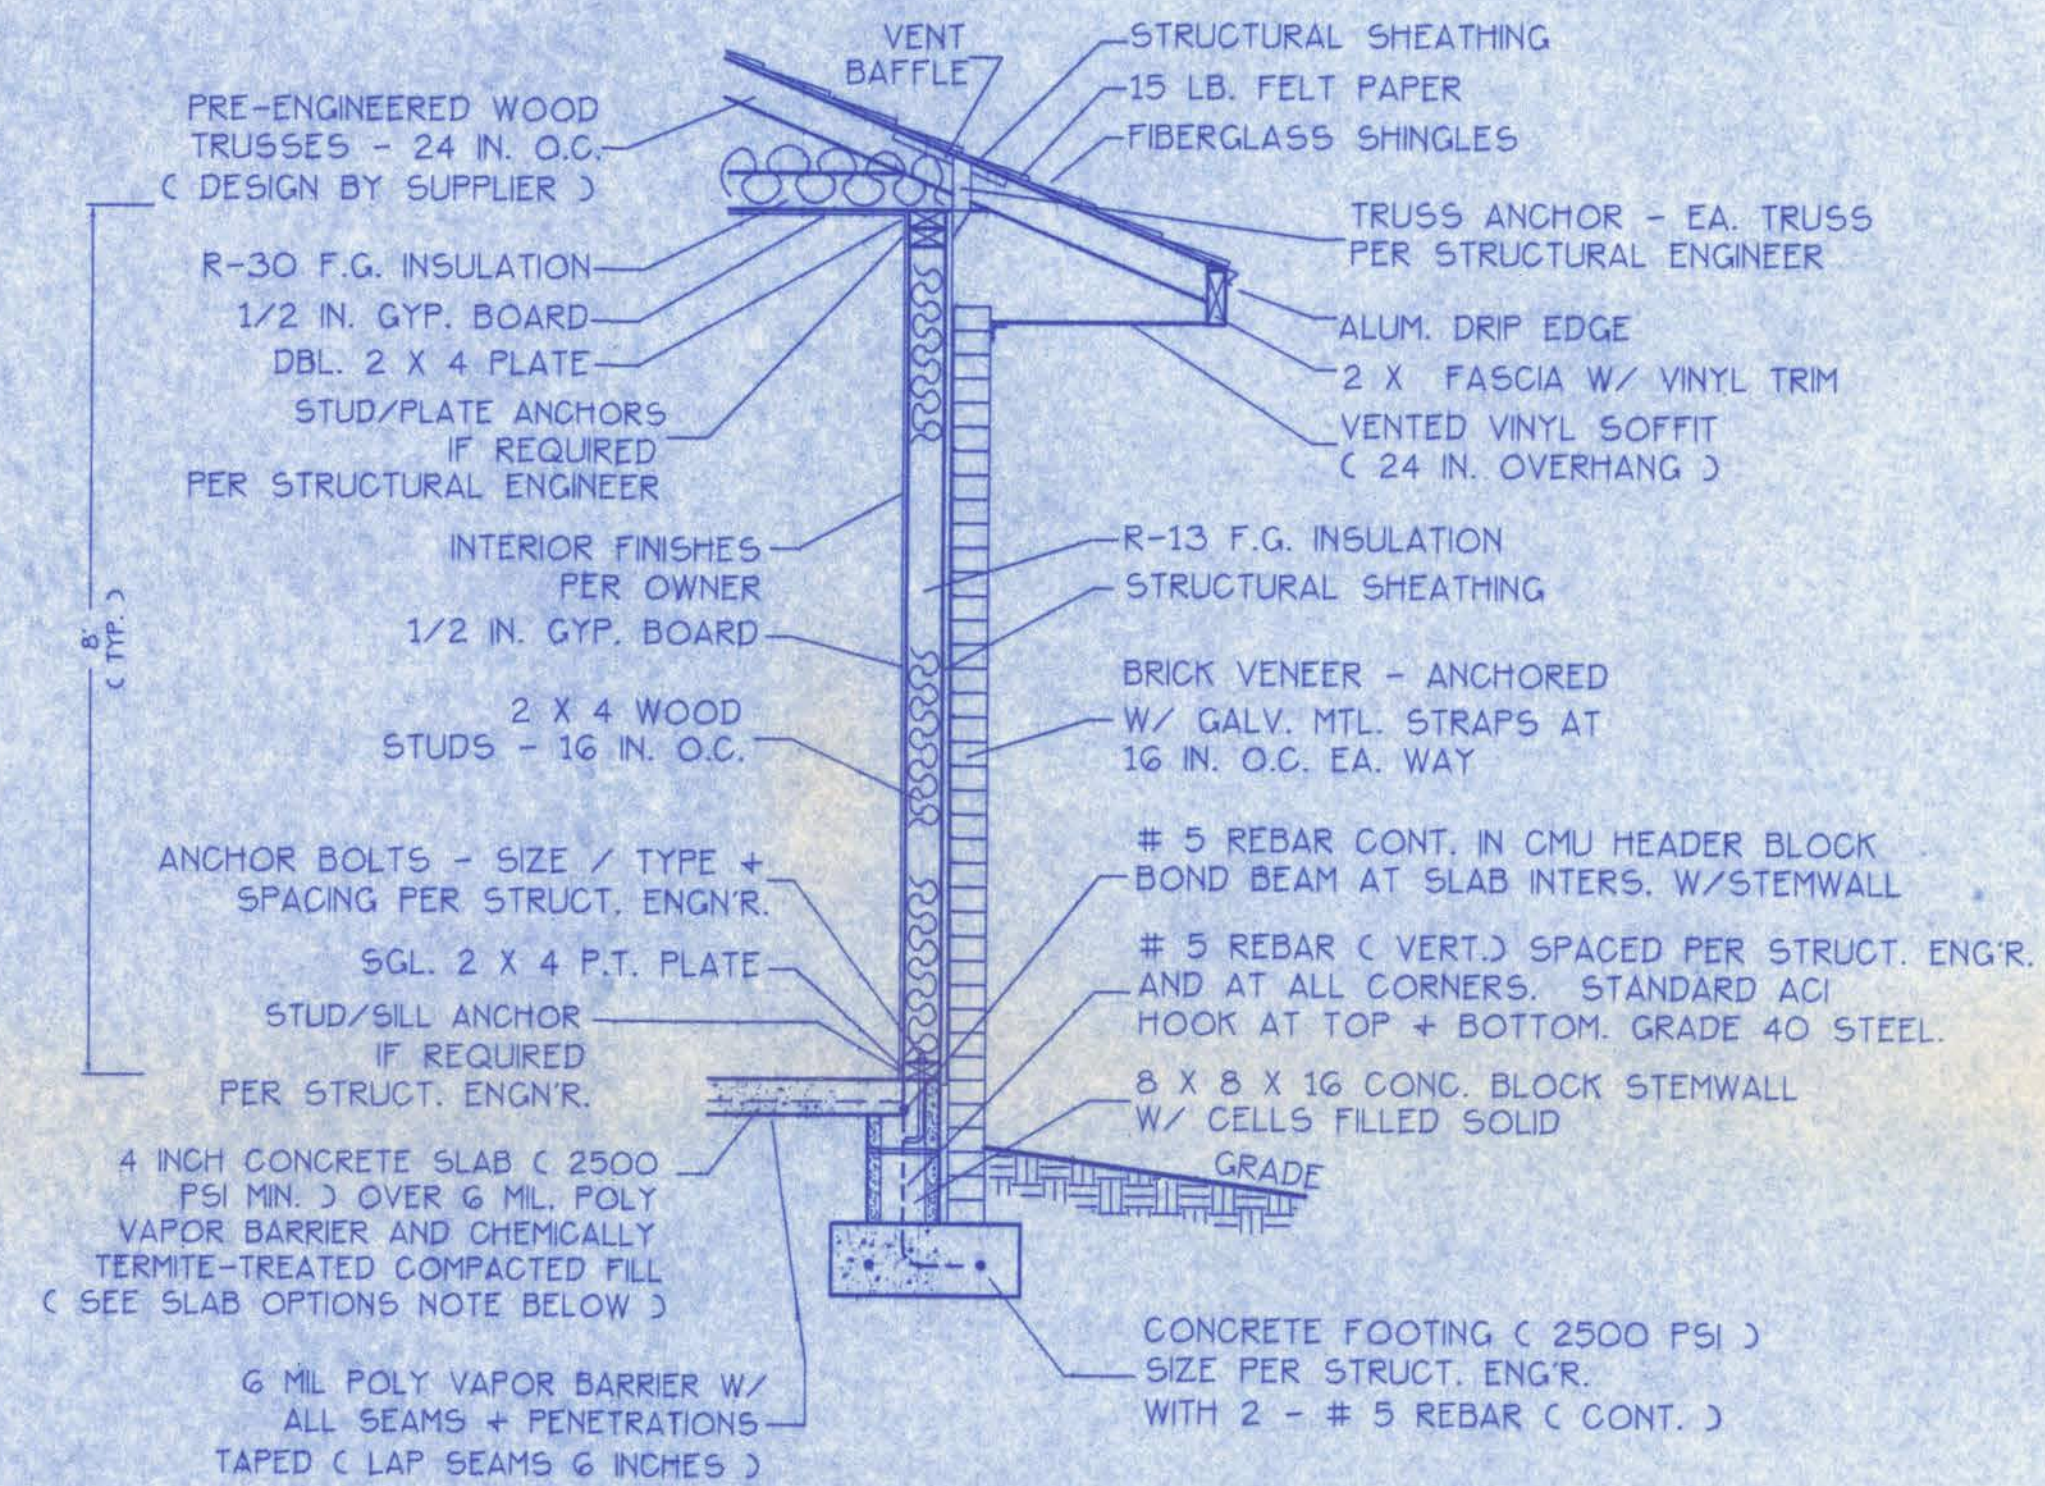

SLAB OPTIONS:

- OPTION 1 - Use 6x6 10/10 WWM reinforcing on chair supports at 3' O.C.
- OPTION 2 - Use Synthetic Fiber reinforced concrete.

WALL SECTION NOTES:

- This Typical Wall Section is for Estimating purposes only.
- All data shown in this Wall Section shall be subject to review and final input by the Structural Engineer.

DESIGN WALL SECTION

NON-STRUCTURAL DATA

SCALE: 3/4" = 1 FT.

WINDLOAD ENGINEER: Mark Disosway, PE No. 53915, POB 868, Lake City, FL 32056, 386-754-5419


CERTIFICATION: These plans and "Windload Engineering", Sheet S-1, attached, comply with Florida Building Code 2001, Section 1606 wind loads, to the best of my knowledge.

LIMITATION: This design is valid for one building, at specified location, permitted within 90 days of signature date. In case of conflict, structural requirements, scope of work, and builder responsibilities on sheet S-1 control.

LOT No. 14, STONEHEDGE
Location: PHASE 2 - COLUMBIA CO. Job No. 509155 11/20/2005 27 SEP 2005

A-4

FILE: 05-020	RESIDENCE LOT 14 - STONEHEDGE PH. 2	SHEET: 4 OF 5
DATE: 4-7-05	PREPARED BY: TIM DELBENE Residential Drafting + Design	CAD FILE: 05020
DRAWN: T A D	REV:	REV:
CHECK: T A D	Rev. 4, Box 330, Lake City, FL 32055 Phone: 386-754-5419	REV:

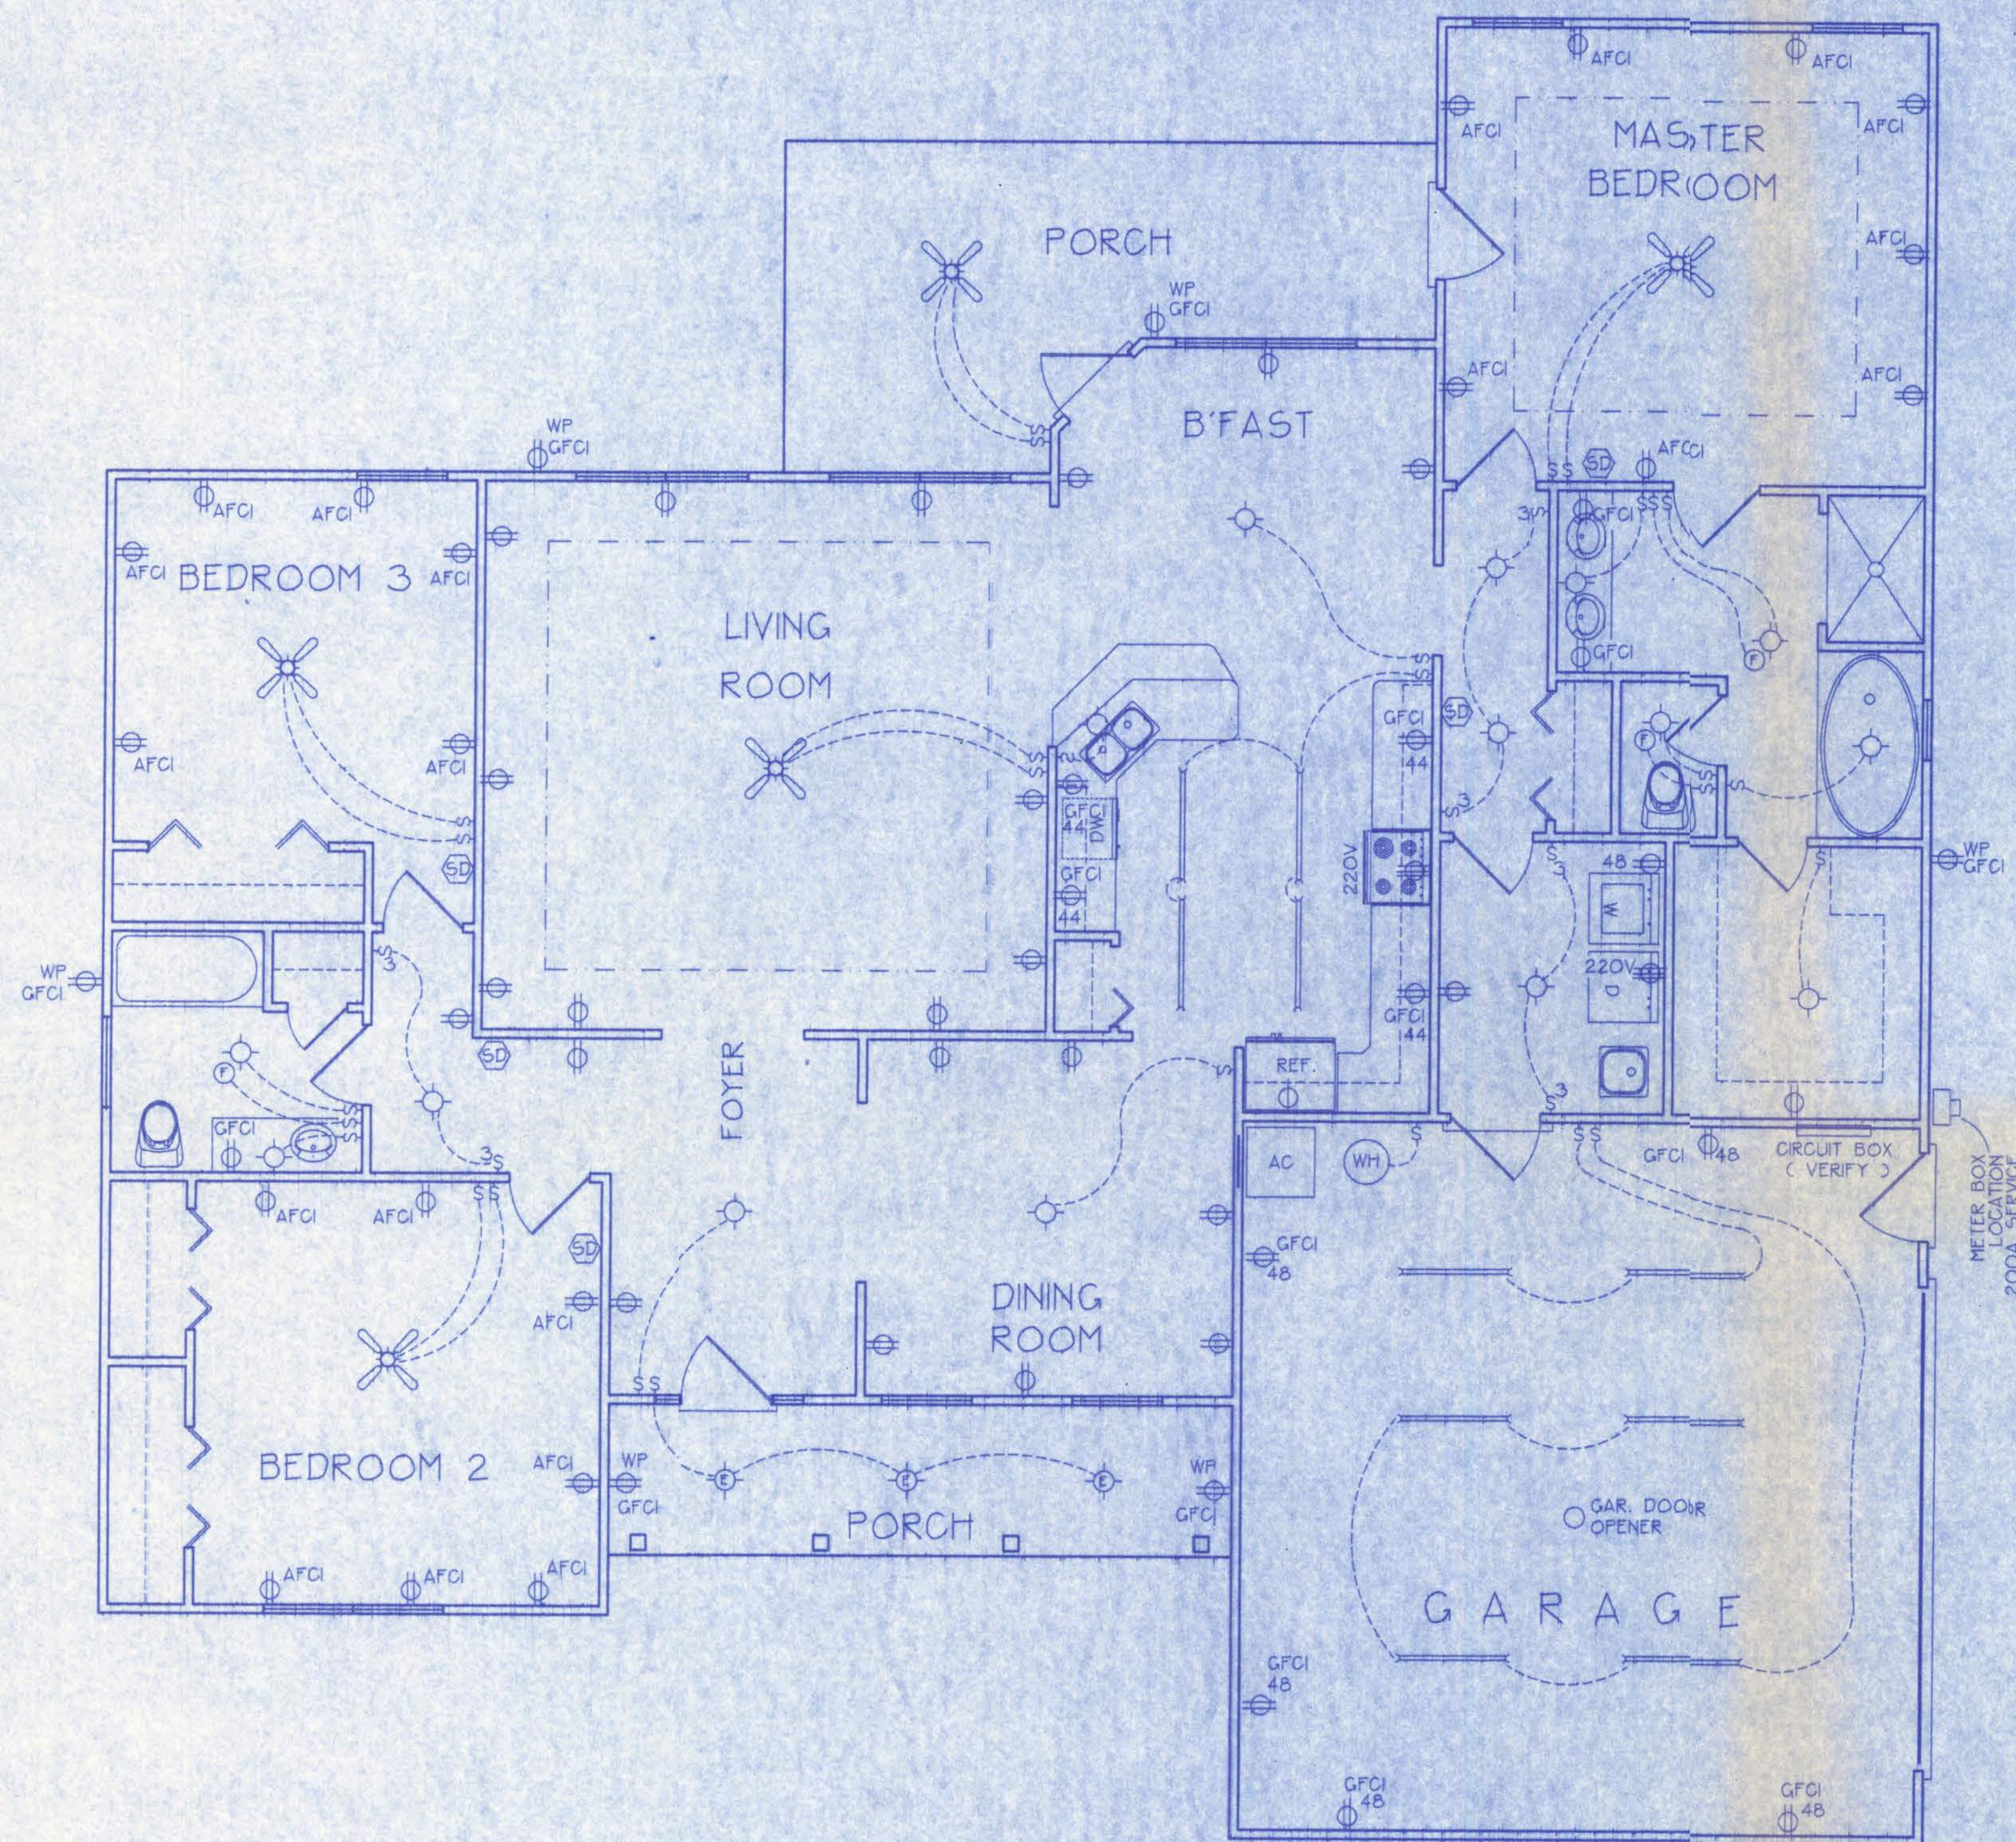

ELECTRICAL SYMBOL LEGEND	
	= FLOURESCENT LIGHTING FIXTURE.
	= CEILING LIGHT FIXTURE
	= EXTERIOR LIGHTING FIXTURE
	= LIGHT SWITCH.
	= THREE-WAY SWITCH.
	= 110 V. DUPLEX OUTLET.
	= SPECIAL HEIGHT 110 V. DUPLEX OUTLET
	= GROUND FAULT CIRC. OUTLET
	= ARC FAULT CIRC. OUTLET
	= 110 V. SINGLE RECEPTACLE OUTLET.
	= 220 VOLT OUTLET (4 WIRE)
	= FAN LOCATION (CEILING)
	= FAN LOCATION (EXHAUST)
	= SMOKE DETECTOR

ELECTRICAL PLAN NOTES

- WIRE ALL APPLIANCES, HVAC UNITS AND OTHER EQUIPMENT PER MANUF. SPECIFICATIONS.
- CONSULT THE OWNER FOR THE NUMBER OF SEPERATE TELEPHONE LINES TO BE INSTALLED.
- ALL INSTALLATIONS SHALL BE PER NAT'L. ELECTRIC CODE.
- ALL SMOKE DETECTORS SHALL BE 120V W/ BATTERY BACKUP OF THE PHOTOELECTRIC TYPE, AND SHALL BE INTERLOCKED TOGETHER. INSTALL INSIDE AND NEAR ALL BEDROOMS.
- TELEPHONE, TELEVISION AND OTHER LOW VOLTAGE DEVICES OR OUTLETS SHALL BE AS PER THE OWNER'S DIRECTIONS, + IN ACCORDANCE W/ APPLICABLE SECTIONS OF NEC-LATEST EDITION.
- ELECTRICAL CONTR SHALL BE RESPONSIBLE FOR THE DESIGN + SIZING OF ELECTRICAL SERVICE AND CIRCUITS.
- ENTRY OF SERVICE (UNDERGROUND OR OVERHEAD) TO BE DETERMINED BY POWER COMPANY.


Overcurrent protection device shall be installed on the exterior of structures to serve as a disconnecting means. Conductors used from the exterior disconnecting means to a panel or sub panel shall have four-wire conductors, of which one conductor shall be used as an equipment ground.

ELECTRICAL PLAN

NOT TO SCALE

A-5

FILE: 05-020	RESIDENCE LOT 14 - STONEHENGE PH. 2	SHEET: 5 OF 5
DATE: 4-7-05		CAD FILE: 05020
DRAWN: T A D	PREPARED BY: TIM DELBENE Residential Drafting + Design Rt. 4, Box 350, Lake City, FL 32055 Phone (904) 755-5831	REV:
CHECK: T A D		REV:

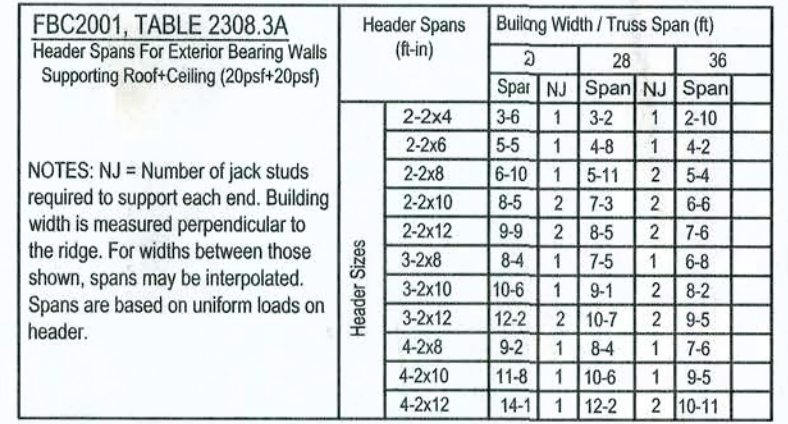

SCALE: N.T.S. REV-18-JUL-03