


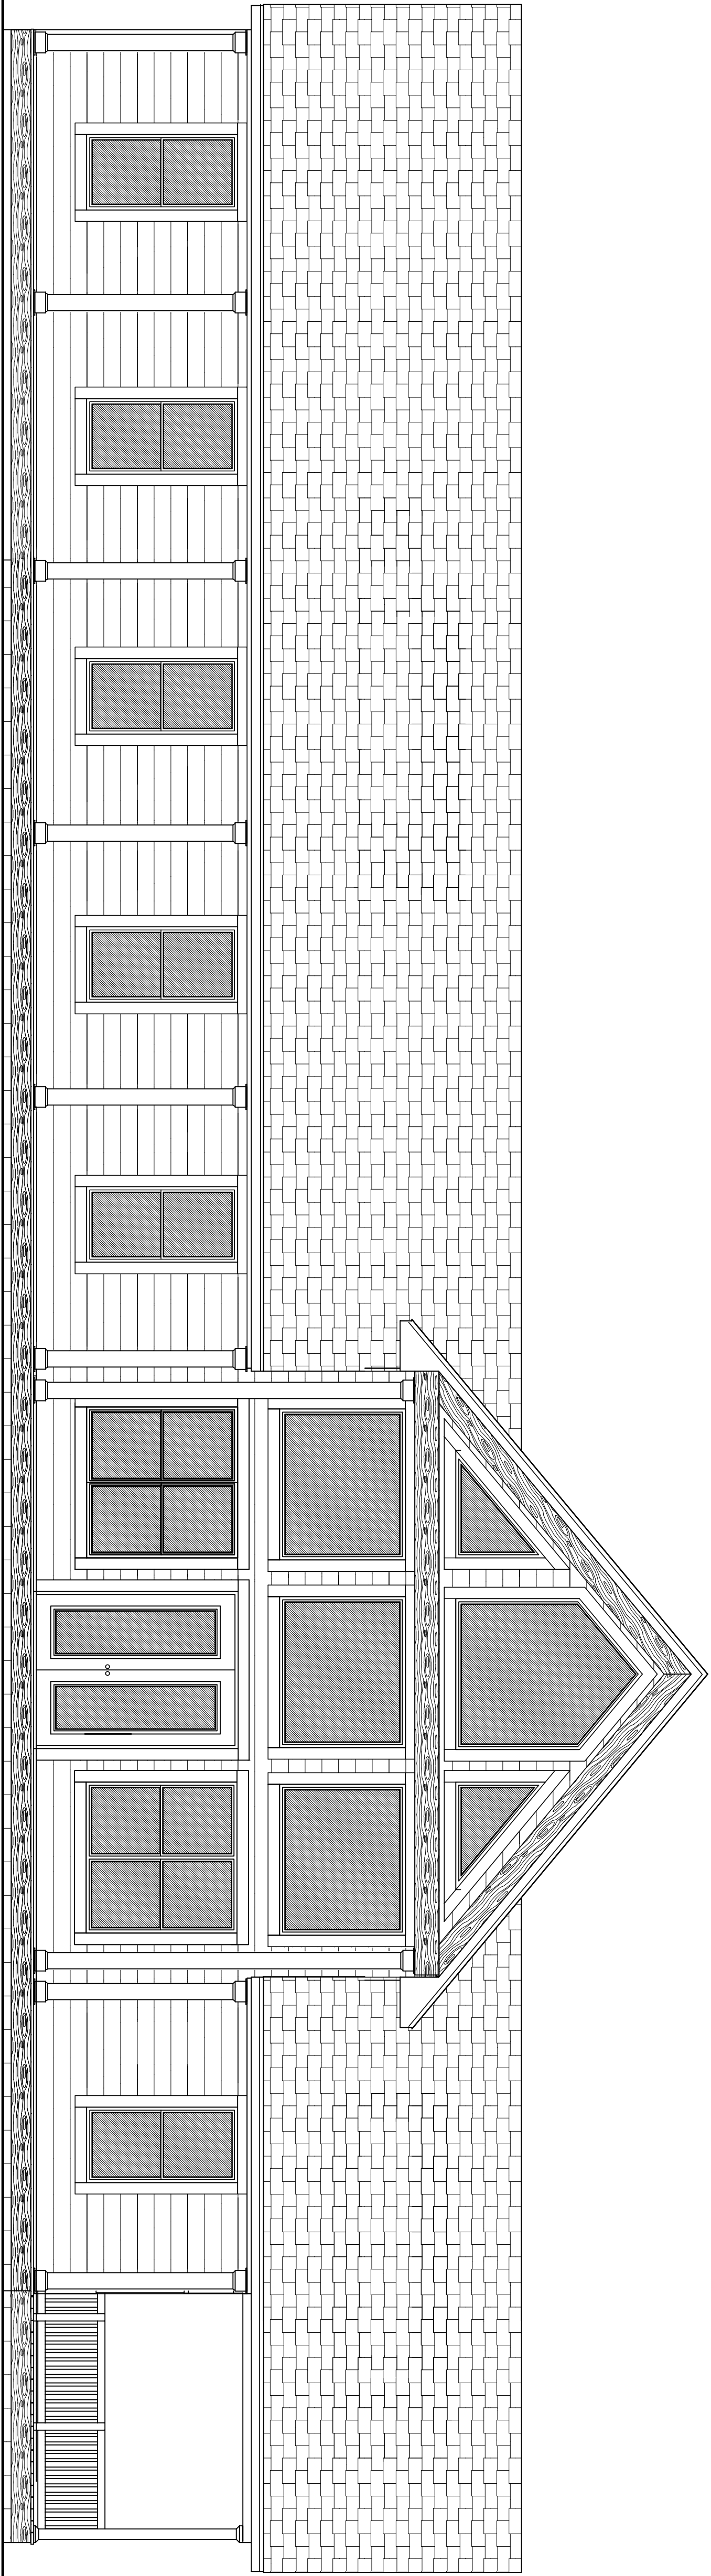

Custom Residential Design for:

JOHN and DEBBIE STALLINGS

Columbia County, Florida

D r a w i n g I n d e x

SHT N°.	DRAWING TITLE	ISSUED	LATEST REVN
C6.1	COVER SHEET	17 APR 2023	.
G.1	GENERAL INFORMATION	17 APR 2023	.
A.1	ELEVATIONS	17 APR 2023	.
A.2	ELEVATIONS	17 APR 2023	.
A.3	1st FLOOR PLAN	17 APR 2023	.
A.4	BASEMENT FLOOR PLAN	17 APR 2023	.

SHT N°.	DRAWING TITLE	ISSUED	LATEST REVN
A.5	1st FLOOR ELECTRICAL PLAN	17 APR 2023	.
A.6	BASEMENT ELECTRICAL PLAN	17 APR 2023	.
A.7	ARCHITECTURAL DETAILS	17 APR 2023	.
G.1	STRUCTURAL INFORMATION	17 APR 2023	.
G.2	FOUNDATION PLAN	17 APR 2023	.
G.3a	ICF WALL DETAILS	17 APR 2023	.
G.3b	STANDARD ICF WALL DETAILS	17 APR 2023	.

SHT N°.	DRAWING TITLE	ISSUED	LATEST REVN
G.3c	STANDARD ICF WALL DETAILS	17 APR 2023	.
G.3d	STANDARD ICF WALL DETAILS	17 APR 2023	.
G.4	FLOOR SLAB PLAN	17 APR 2023	.
G.5	ICF FLOOR DETAILS	17 APR 2023	.
G.6	ROOF PLAN	17 APR 2023	.
G.7	WALL SECTION WITH DETAILS	17 APR 2023	.
G.8	STRUCTURAL DETAILS	17 APR 2023	.
G.9	GENERAL STRUCTURAL SPECIFICATION	17 APR 2023	.

These drawings, as instruments of service, are the sole property of the architect, and may not be used, copied or reproduced in whole or in part for use on or incorporated within any other job without specific and individual authorization by the architect.

REVISION:


Stamp: 2023
N.P. Geisler, Architect
AR0000

DRAWN:


128

NEW CUSTOM RESIDENTIAL DESIGN for:
JOHN and DEBBIE STALLINGS
860 EVERGREEN DRIVE - LAKE CITY, FLORIDA
COVER SHEET

Celebrating
51 Years of Service
1972 - 2023
N.P. Geisler, Architect
AR00000

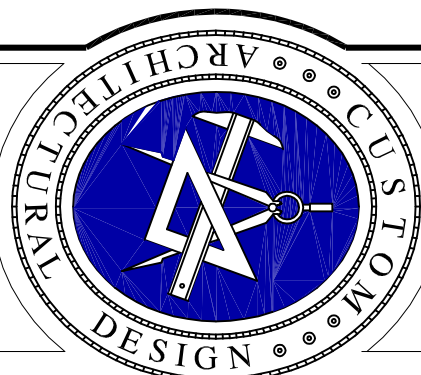

**NICHOLAS
GEISLER
ARCHITECT**

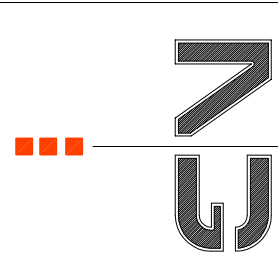

1758 NW BROWNS
LAKE CITY, FLORIDA
356-365-4355

DATE:

10 MAR 2023

CONTRACT:

2K2301

SHEET:

C6.1

1 OF 1

AR0007005

Digitally signed by: N. P. GEISLER
DN: CN = N. P. GEISLER C = US O
= AR0007005 OU = ARCHITECT
Date: 2023.09.20 11:51:31 -05'00'