



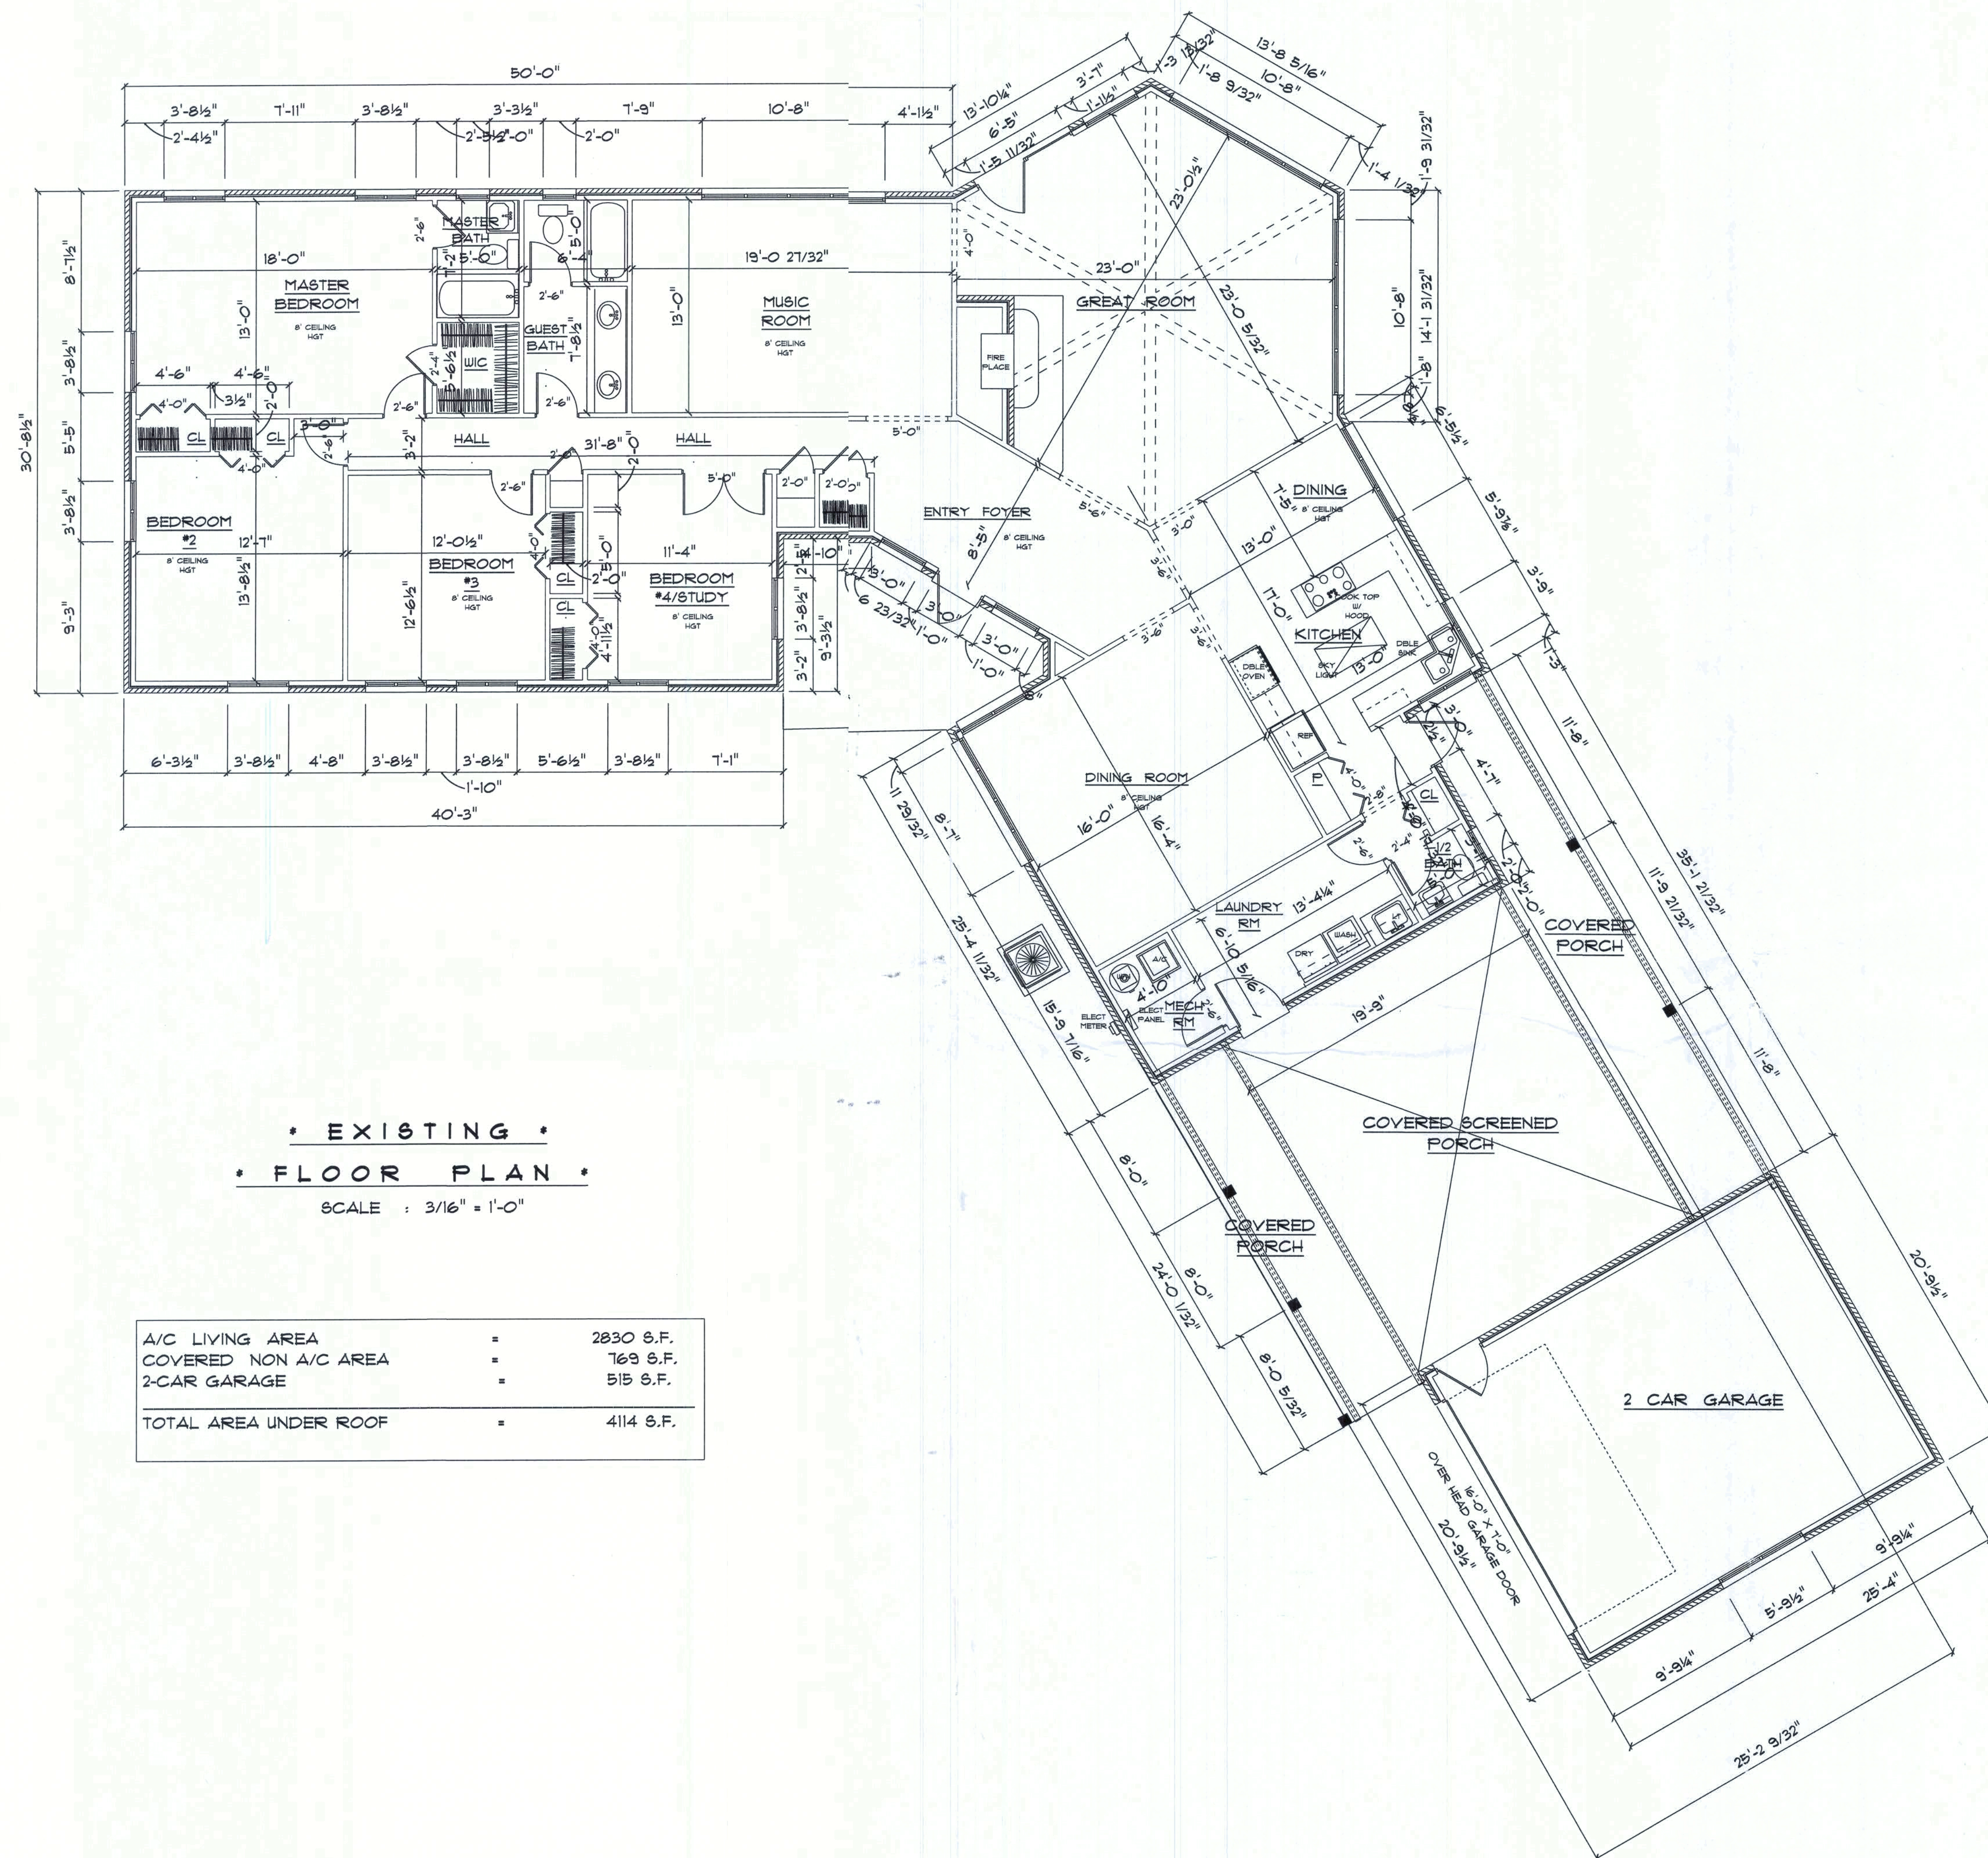


• EXISTING •
 • FLOOR PLAN •
 SCALE : 3/16" = 1'-0"

A/C LIVING AREA	=	2830 S.F.
COVERED NON A/C AREA	=	769 S.F.
2-CAR GARAGE	=	515 S.F.
TOTAL AREA UNDER ROOF	=	4114 S.F.

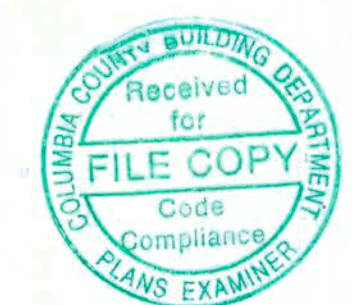

REMODEL for JERRY & DANA SOLENSKI	
1060 NW OLD MILL RD LAKE CITY, FLORIDA 32055	
Treana M. Ruffo 2025 SW 8th St Lake City, Florida, 32025 Cell: (386) 861-1191 Email: tnanaruffo@gmail.com	
PRINTED DATE: Wednesday, March 10, 2021	CHECKED BY: Treana M. Ruffo
BUILDING CONTRACTOR _____	
FINAL DATE: _____	
JOE NUMBER: _____	
DRAWING NUMBER A-1 OF 3 SHEETS	

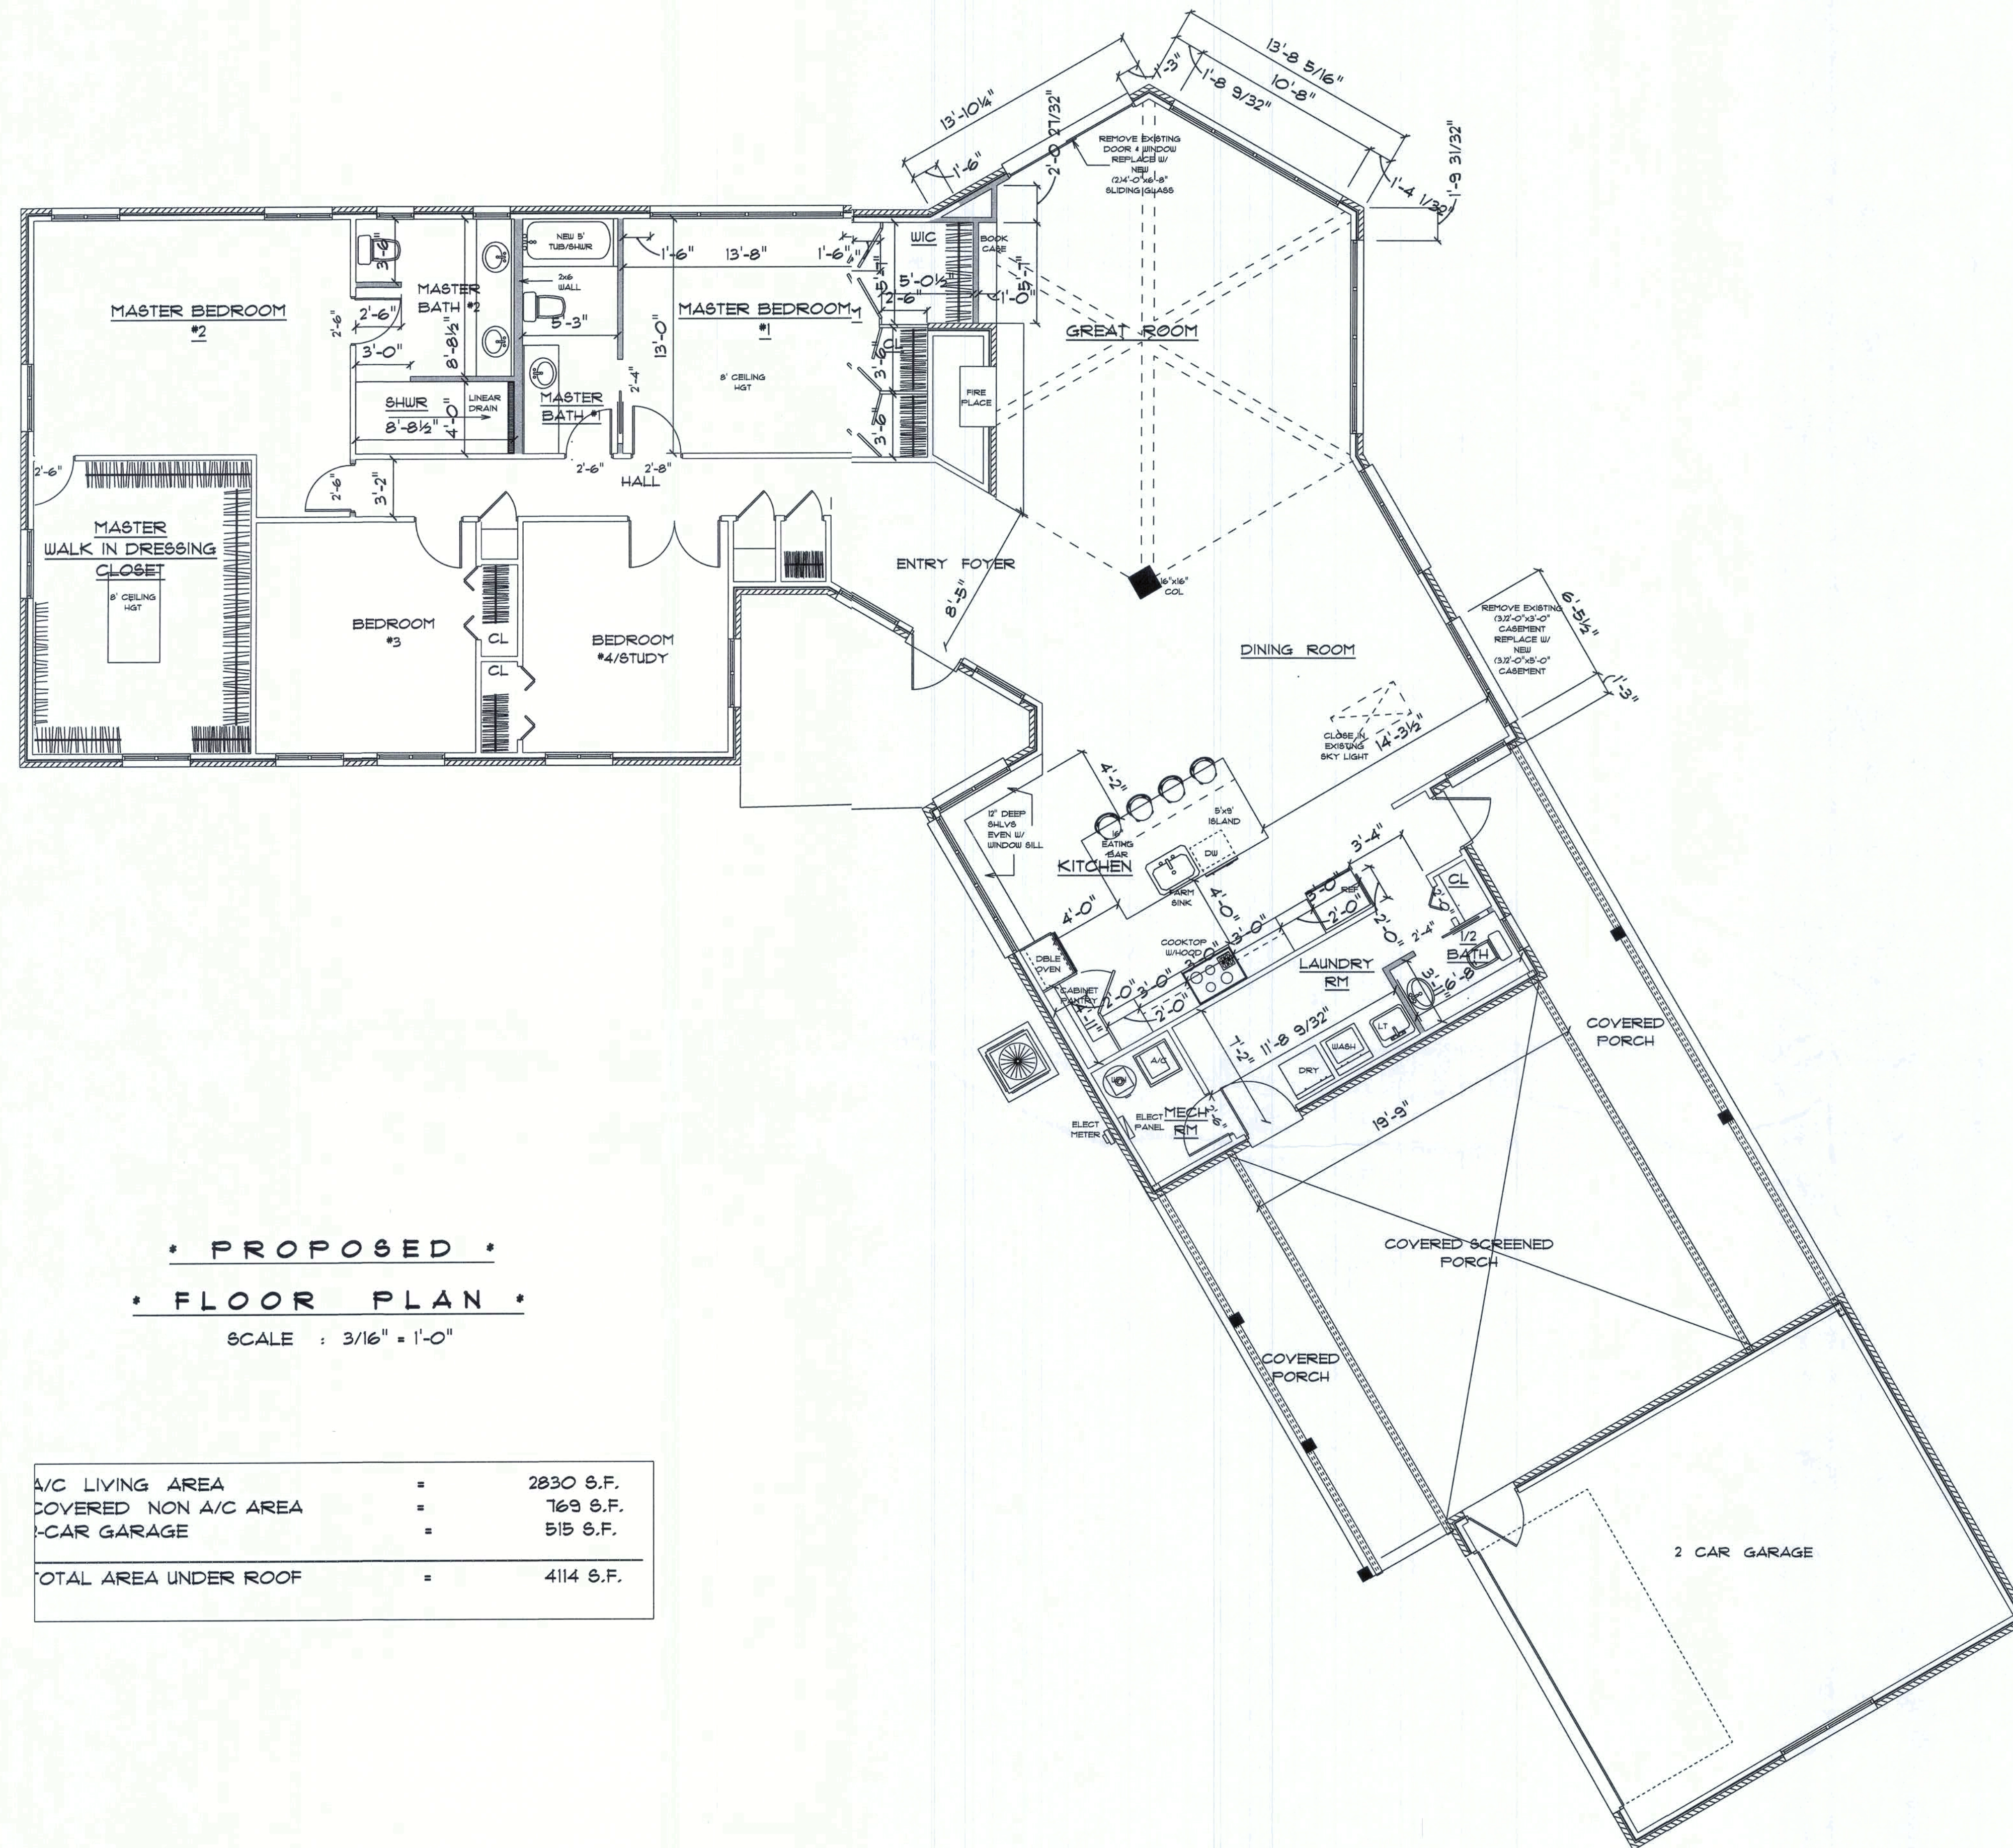

REMODEL
 for
 JERRY & DANA
 SCLENSKI

1060 N. OLD MILL RD
 LAKE CITY, FLORIDA
 32055

TERRI M. RUFFO
 2925 SW 68 47
 LAKE CITY, FLORIDA, 32025
 Cell: (361) 861-1191
 Email: terriruffo@gmail.com

PRINTED DATE:
 Wednesday, March 10, 2021

DRAWN BY: TERRI M. RUFFO CHECKED BY:

BUILDING CONTRACTOR


FINALS DATE:

JOB NUMBER:

DRAWING NUMBER

A-2

OF 3 SHEETS

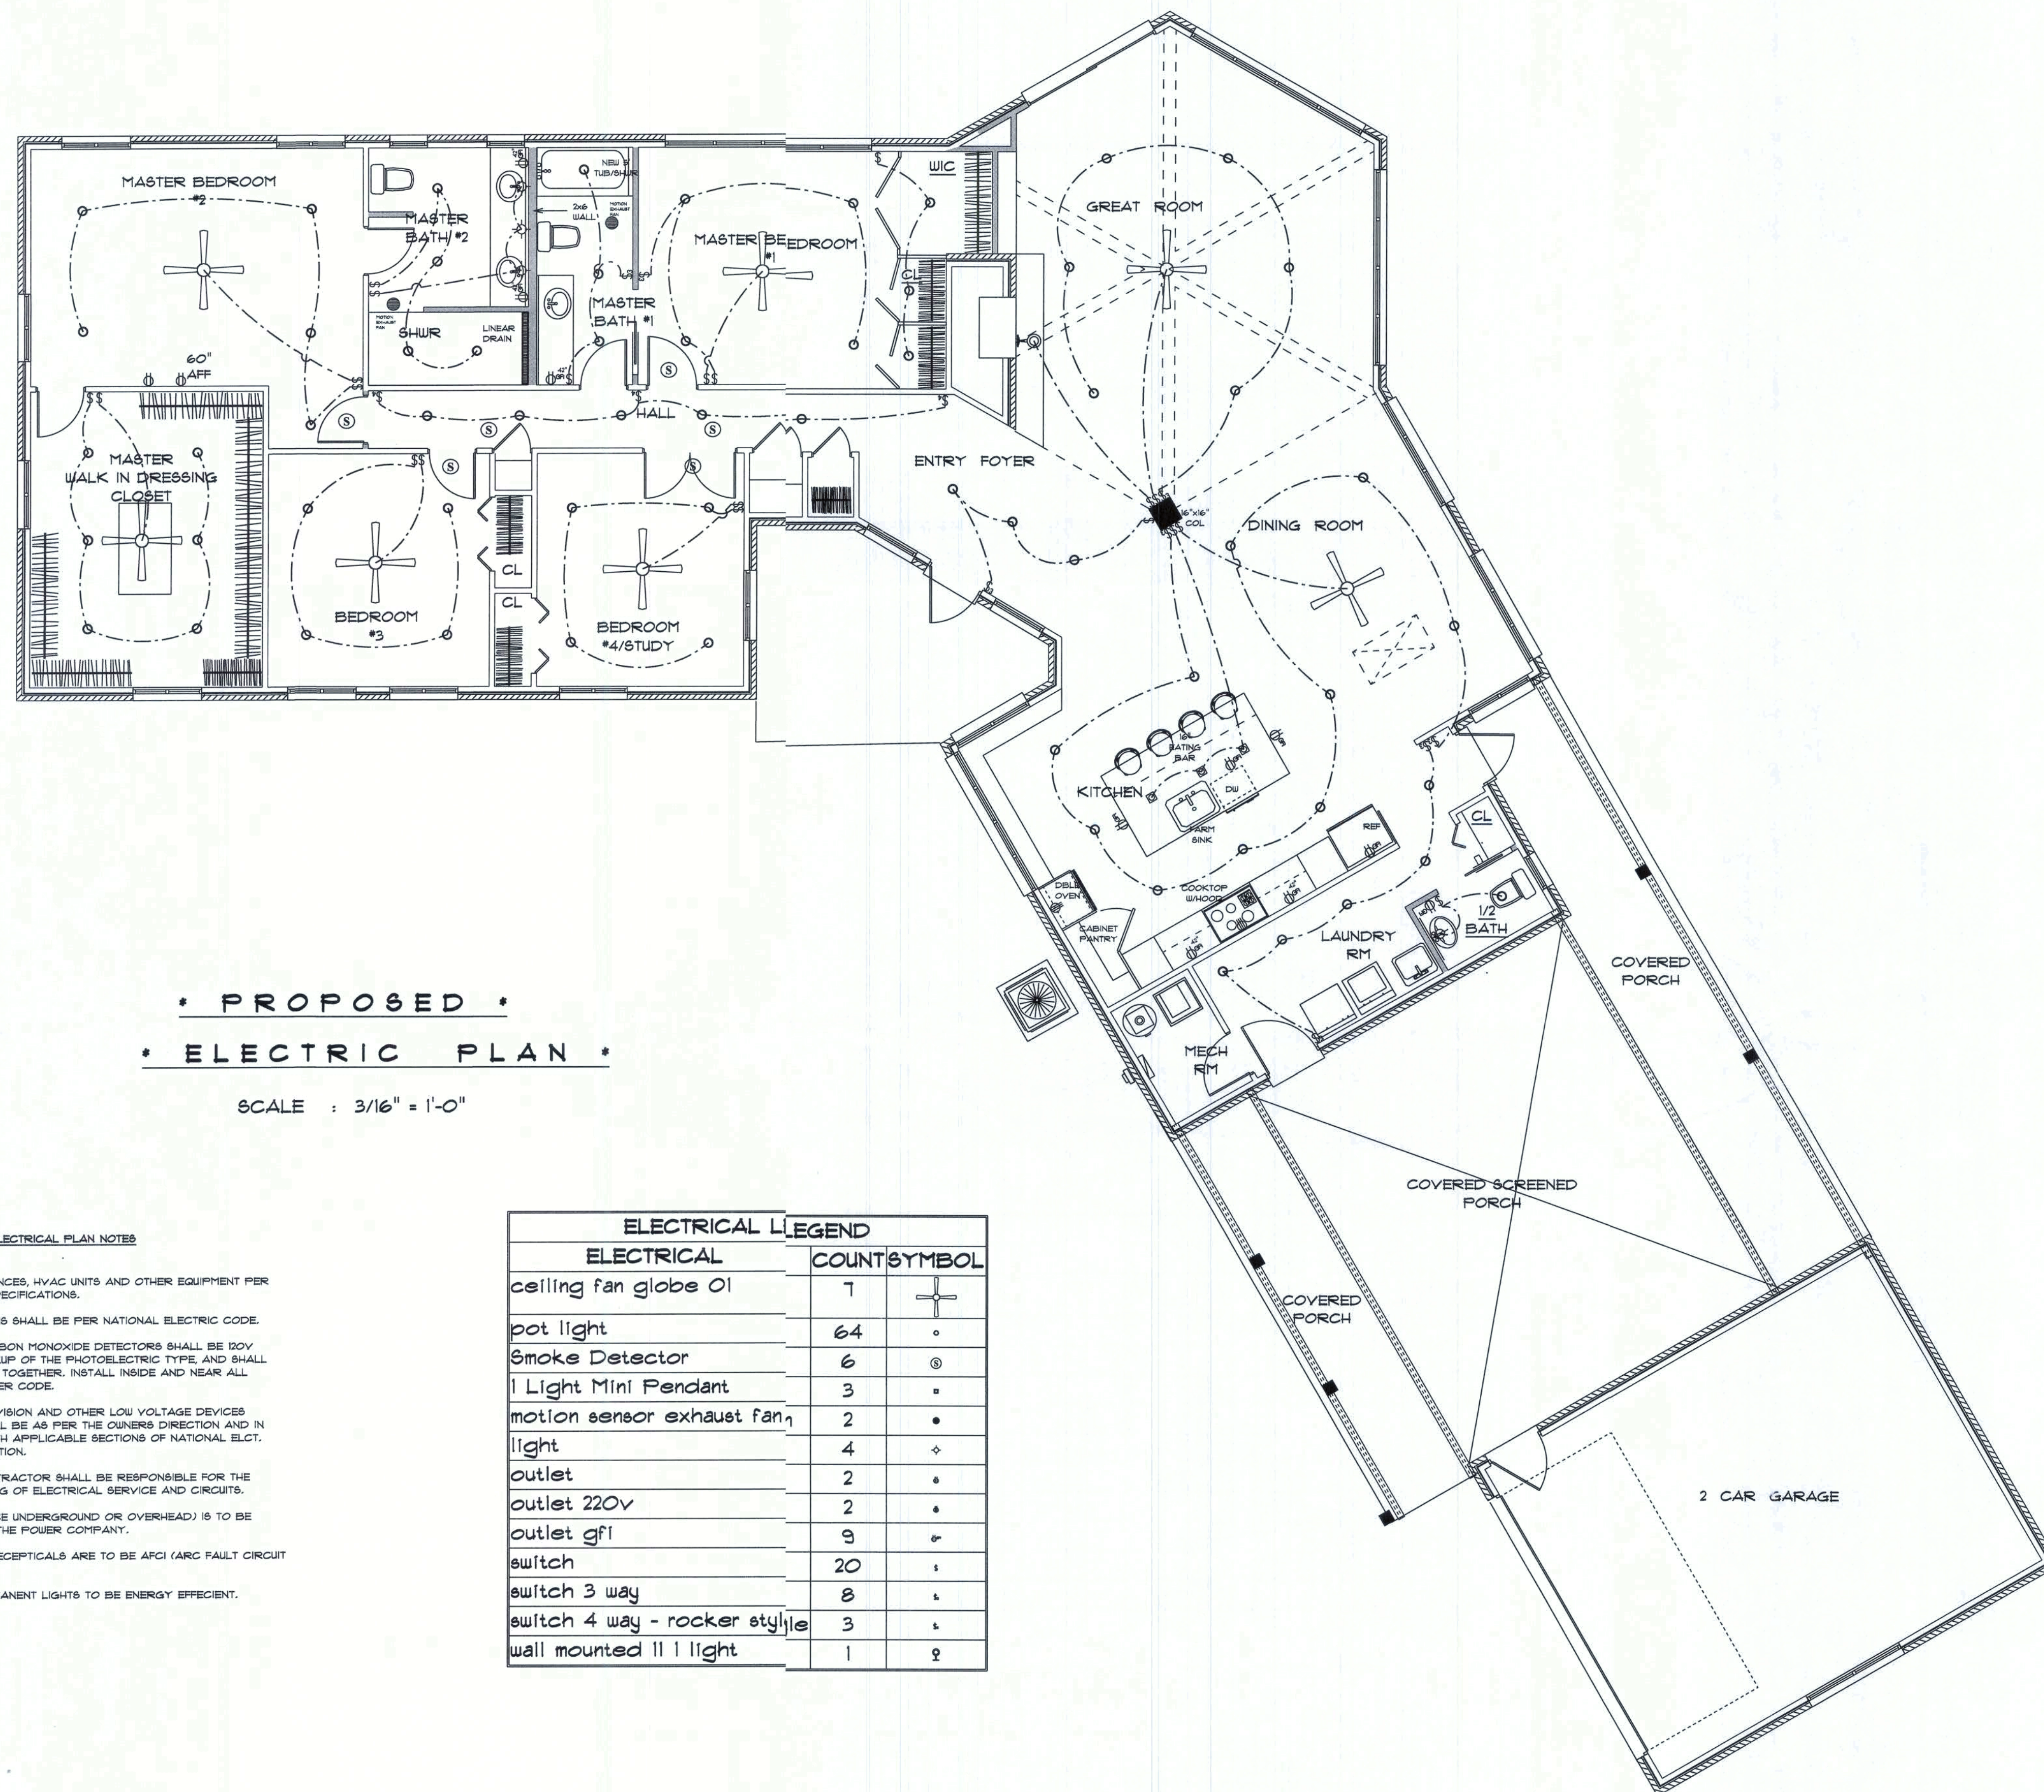

* PROPOSED *

* ELECTRIC PLAN *

SCALE : 3/16" = 1'-0"

ELECTRICAL PLAN NOTES

- E-1 WIRE ALL APPLIANCES, HVAC UNITS AND OTHER EQUIPMENT PER MANUFACTURER'S SPECIFICATIONS.
- E-2 ALL INSTALLATIONS SHALL BE PER NATIONAL ELECTRIC CODE.
- E-3 ALL SMOKE / CARBON MONOXIDE DETECTORS SHALL BE ROV W/BATTERY BACKUP OF THE PHOTOELECTRIC TYPE, AND SHALL BE INTERLOCKED TOGETHER. INSTALL INSIDE AND NEAR ALL BEDROOMS AS PER CODE.
- E-4 TELEPHONE, TELEVISION AND OTHER LOW VOLTAGE DEVICES OR OUTLETS SHALL BE AS PER THE OWNER'S DIRECTION AND IN ACCORDANCE WITH APPLICABLE SECTIONS OF NATIONAL ELCT. CODE LATEST EDITION.
- E-5 ELECTRIC CONTRACTOR SHALL BE RESPONSIBLE FOR THE DESIGN AND SIZING OF ELECTRICAL SERVICE AND CIRCUITS.
- E-6 ENTRY OVERHEAD UNDERGROUND OR OVERHEAD) IS TO BE DETERMINED BY THE POWER COMPANY.
- E-7 ALL BEDROOM RECEPTALS ARE TO BE AFCI (ARC FAULT CIRCUIT INTERRUPTER)
- E-8 15% OF A PERMANENT LIGHTS TO BE ENERGY EFFICIENT.

ELECTRICAL LEGEND		
ELECTRICAL	COUNT	SYMBOL
ceiling fan globe 01	1	
pot light	64	
Smoke Detector	6	
1 Light Mini Pendant	3	
motion sensor exhaust fan	2	
light	4	
outlet	2	
outlet 220v	2	
outlet gfi	9	
switch	20	
switch 3 way	8	
switch 4 way - rocker style	3	
wall mounted 111 light	1	

REMODEL
for
JERRY & DANA
SOLENSKI

1060 N. OLD MILL RD
LAKE CITY, FLORIDA
32055

Tessa M. Ruffo
2925 SW 8R 47
Lake City, Florida, 32025
Cell: (361) 861-1191
Email: tessaruffo@gmail.com

PRINTED DATE:
Wednesday, March 10, 2021

DRAWN BY: Tessa M. Ruffo CHECKED BY:

BUILDING CONTRACTOR

FINALS DATE:

JOB NUMBER:

DRAWING NUMBER

A-3

OF 3 SHEETS