




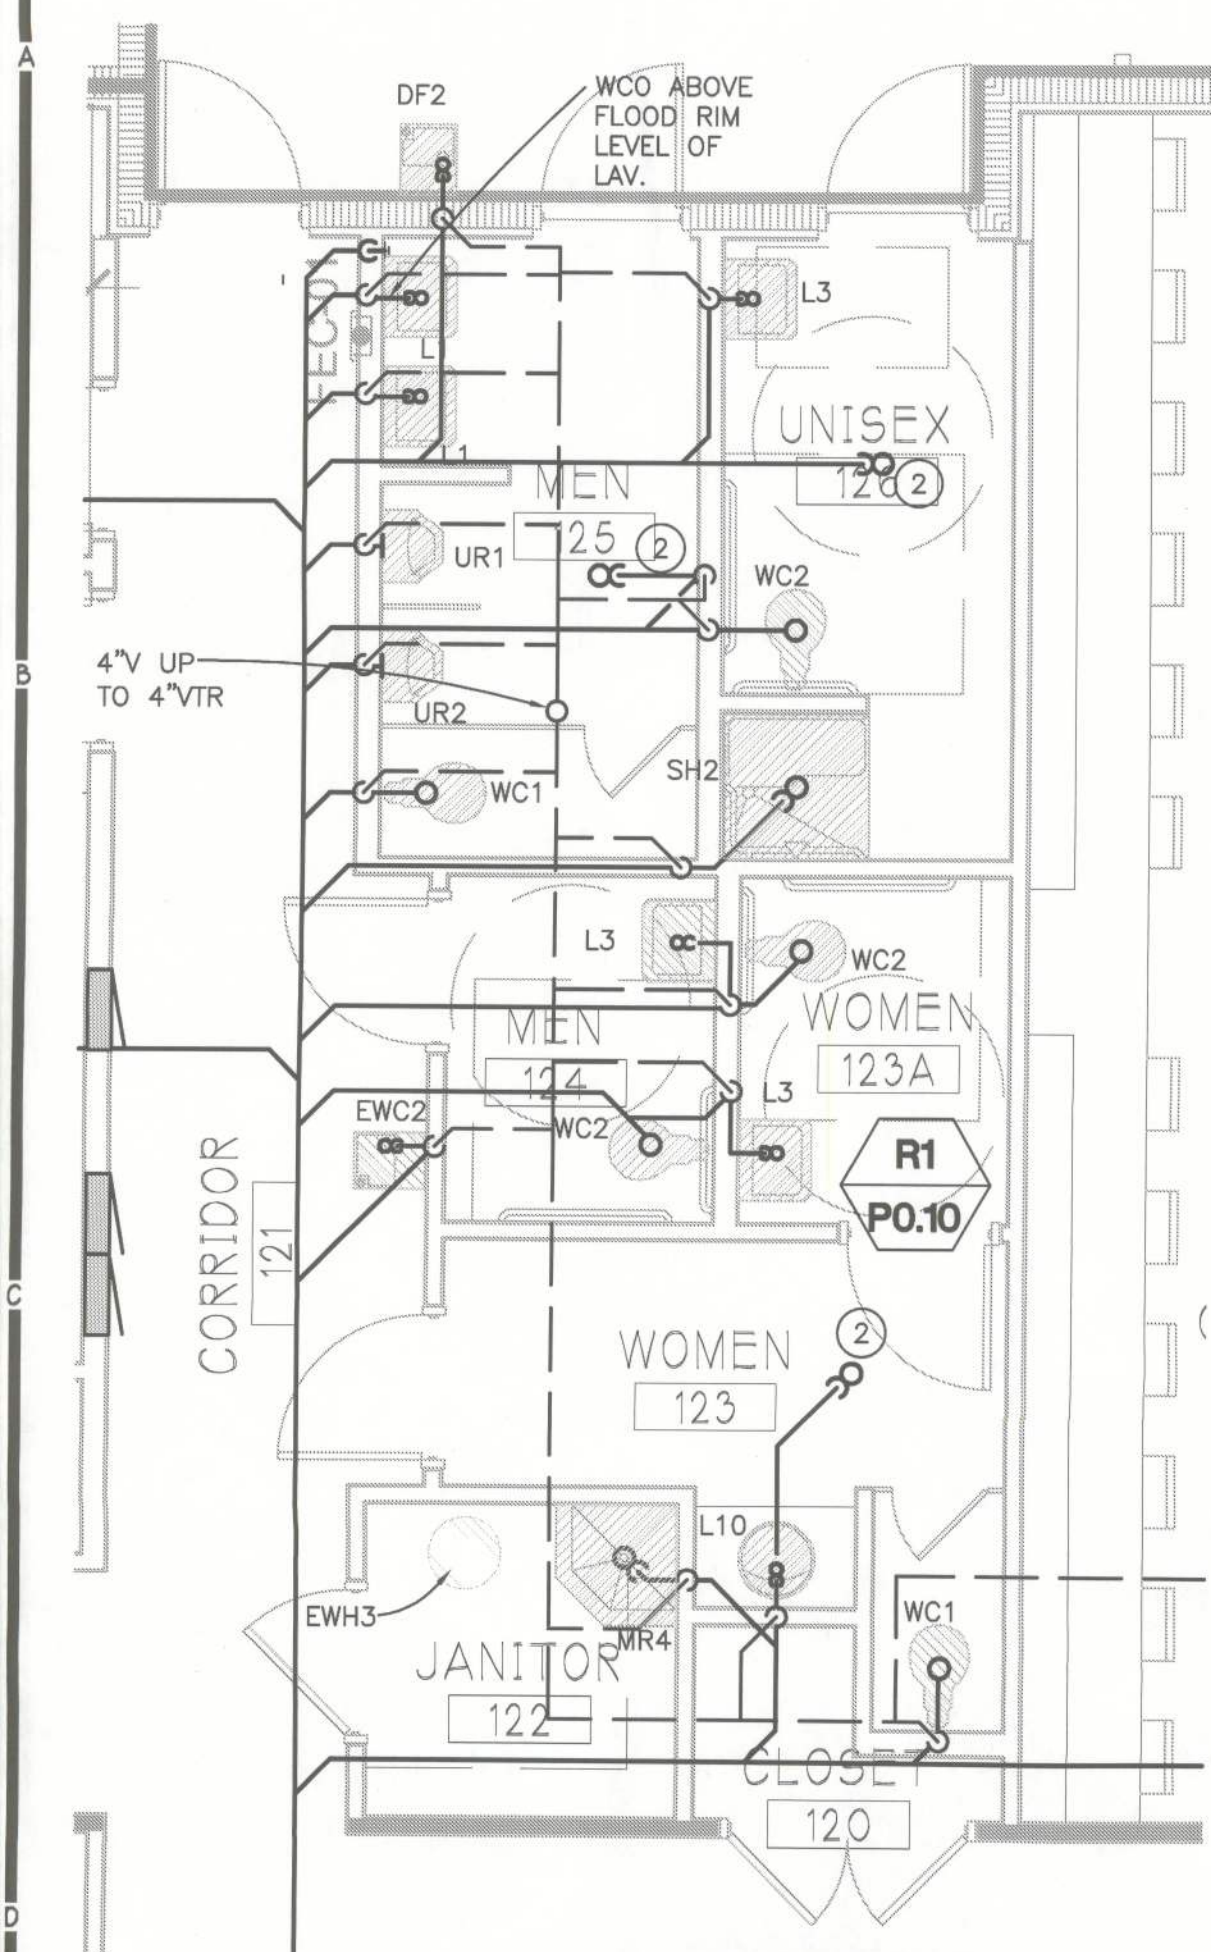


PARTIAL FLOOR PLAN - SANITARY WASTE AND VENT PIPING
SCALE: 1/4" = 1'-0"

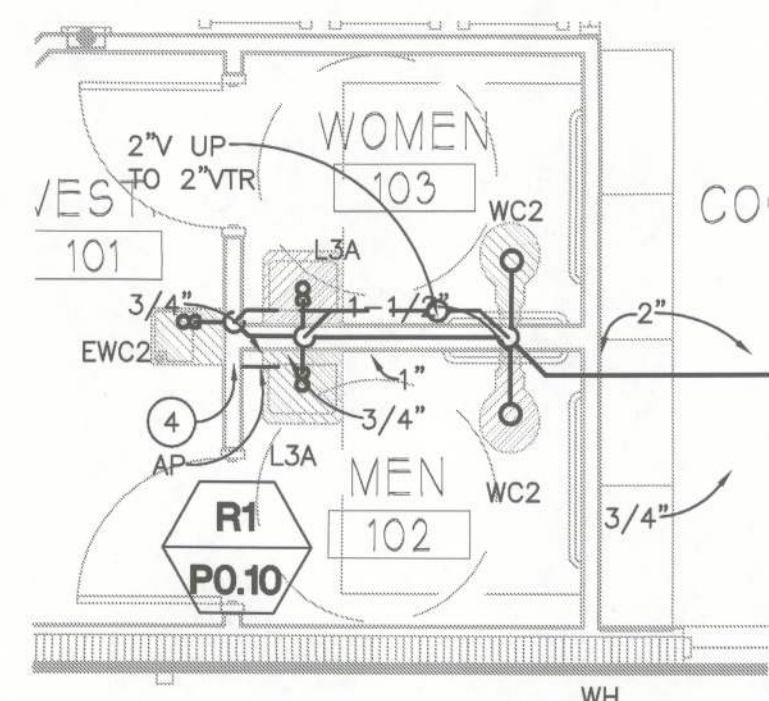


PARTIAL FLOOR PLAN - SANITARY WASTE AND VENT PIPING
SCALE: 1/4" = 1'-0"

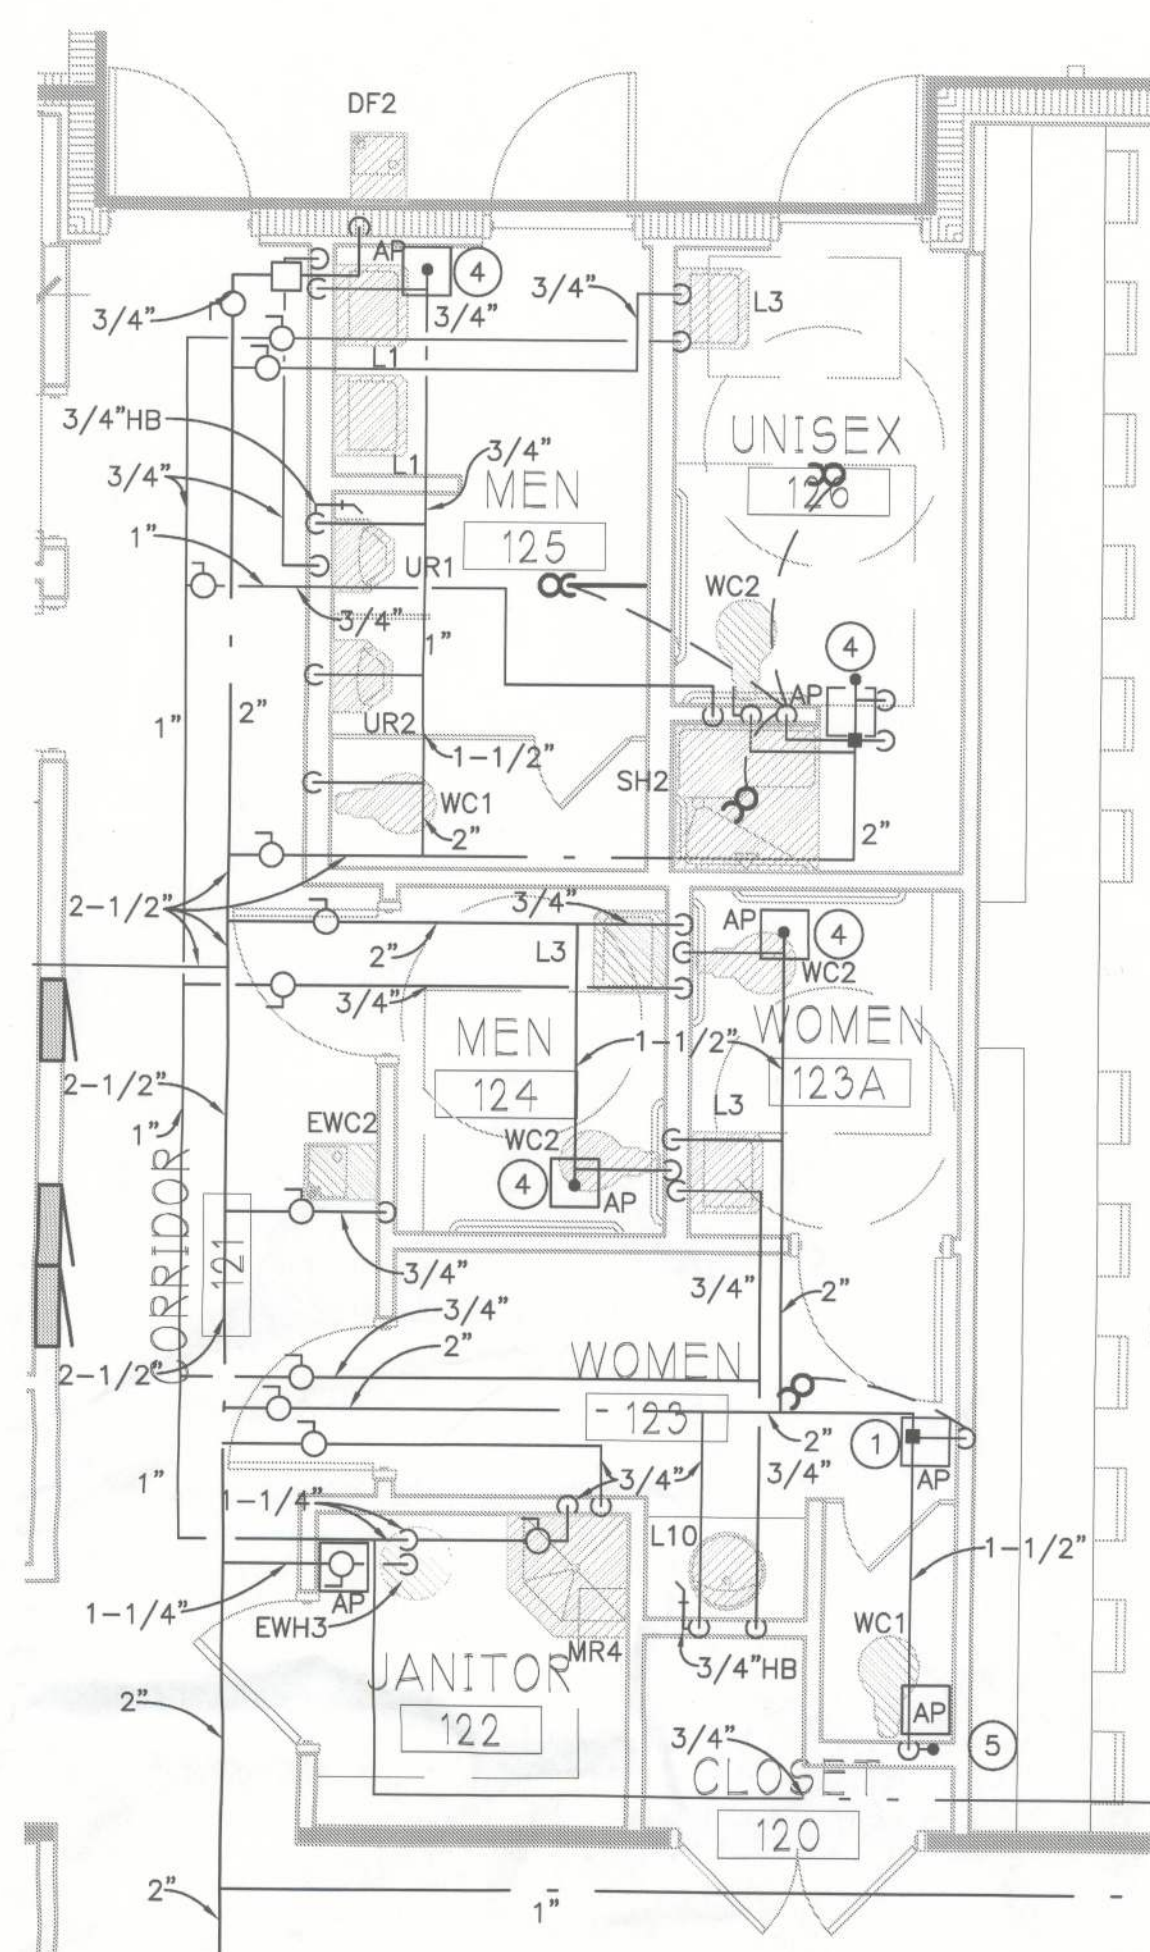

PARTIAL FLOOR PLAN - WATER PIPING
SCALE: 1/4" = 1'-0"

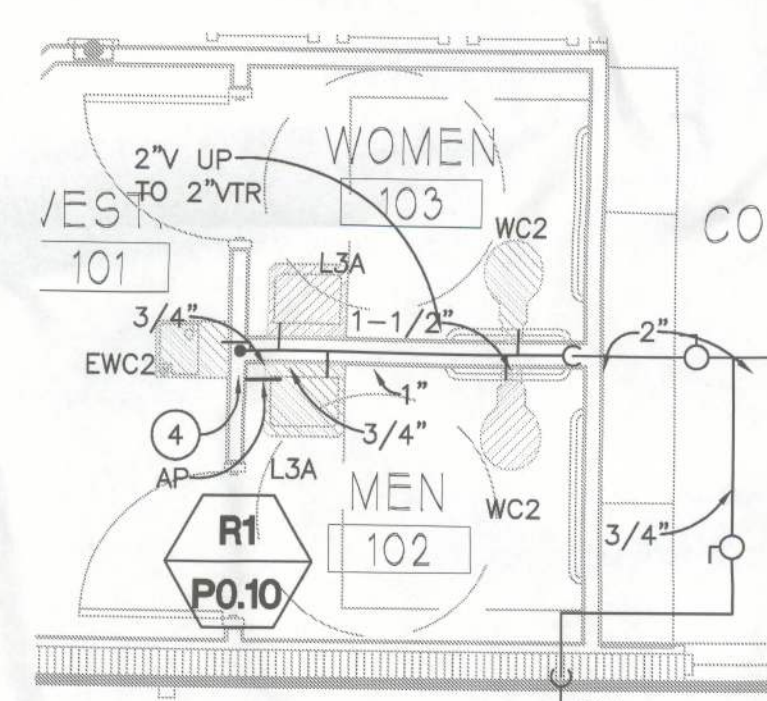

PARTIAL FLOOR PLAN - WATER PIPING
SCALE: 1/4" = 1'-0"

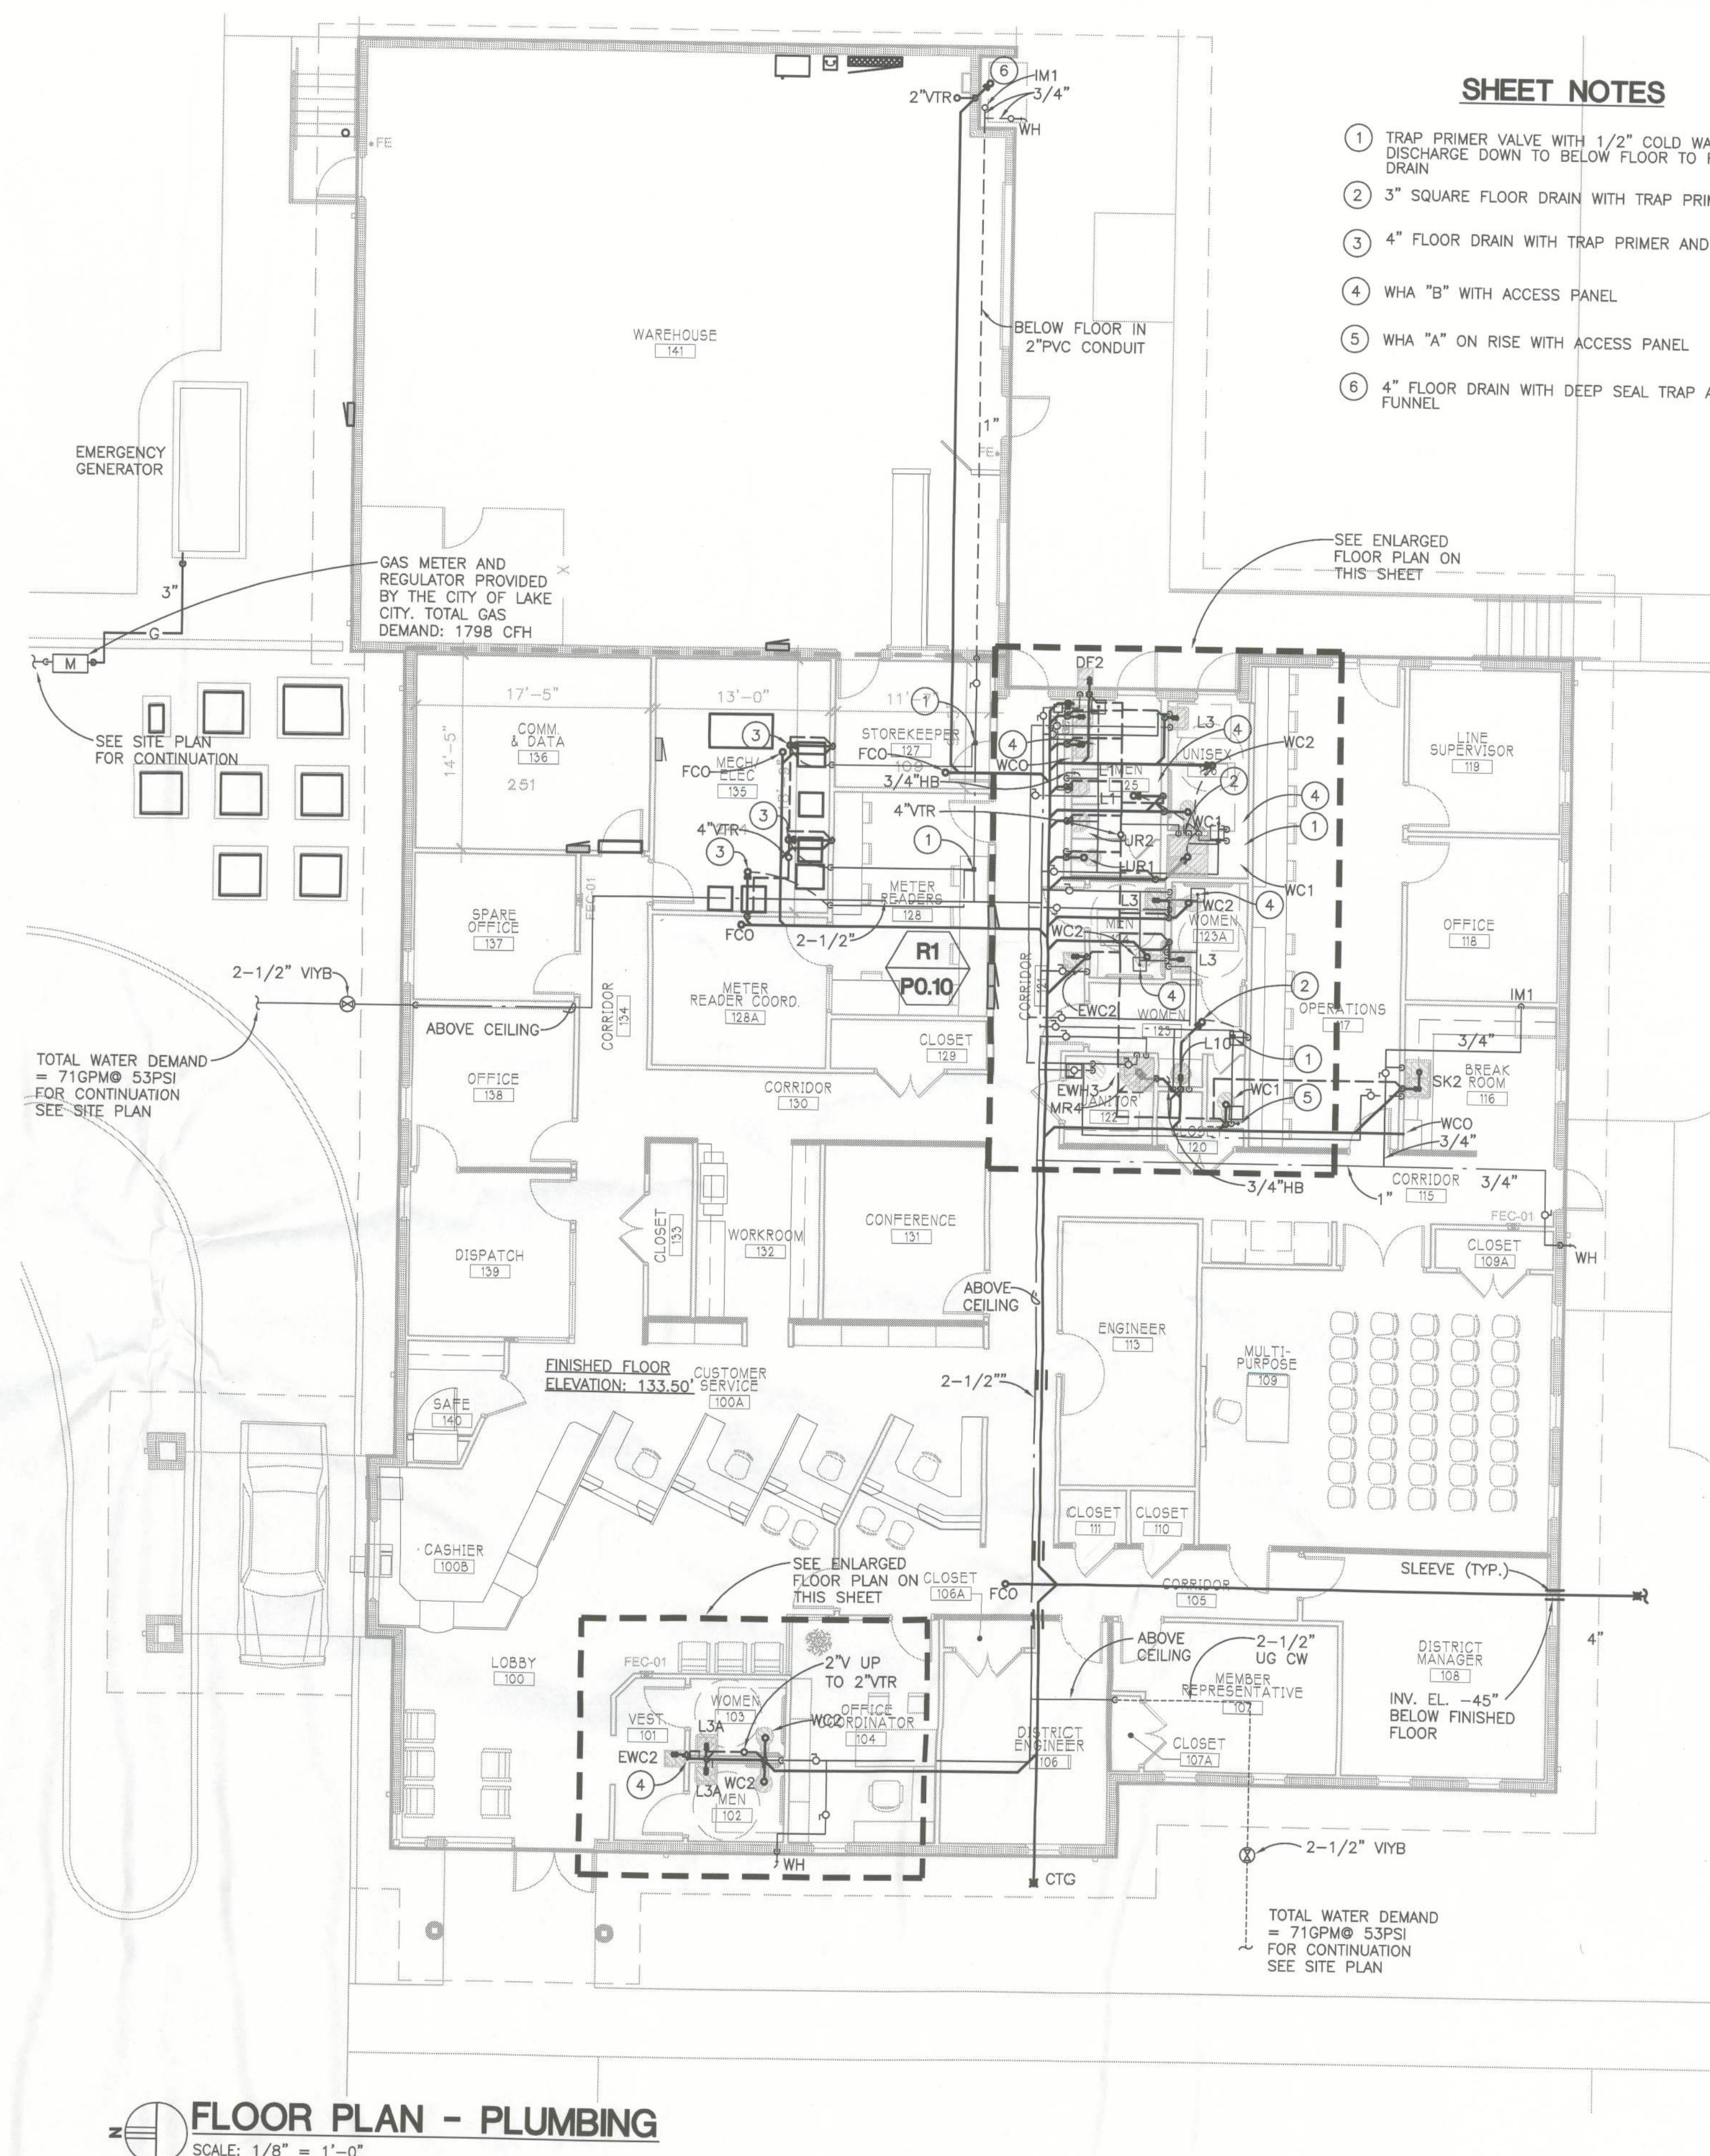

FLOOR PLAN - PLUMBING
SCALE: 1/8" = 1'-0"

SHEET NOTES

- 1 TRAP PRIMER VALVE WITH 1/2" COLD WATER DISCHARGE DOWN TO BELOW FLOOR TO FLOOR DRAIN
- 2 3" SQUARE FLOOR DRAIN WITH TRAP PRIMER
- 3 4" FLOOR DRAIN WITH TRAP PRIMER AND FUNNEL
- 4 WHA "B" WITH ACCESS PANEL
- 5 WHA "A" ON RISE WITH ACCESS PANEL
- 6 4" FLOOR DRAIN WITH DEEP SEAL TRAP AND FUNNEL

SEE ENLARGED FLOOR PLAN ON THIS SHEET