




MAIN FLOOR PLAN
SCALE: 1/4" = 1'-0"



REAR ELEVATION
SCALE: 1/4" = 1'-0"

IT IS THE OWNER AND CONTRACTORS RESPONSIBILITY
TO VERIFY ALL STRUCTURAL ASPECTS OF THESE DRAWINGS,
THIS INCLUDES, BUT IS NOT LIMITED TO: DIMENSIONS,
WALL HEIGHTS, AND MATERIAL, WINDOW SIZE AND LOCATION,
ALSO ALL STATE AND LOCAL CODES MUST BE MET.

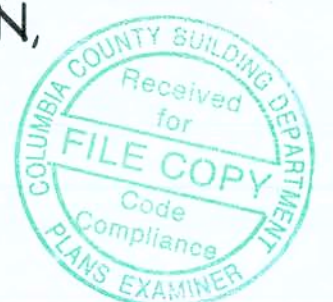


CK CONTRACTING, INC.
CUNNINGHAM RESIDENCE


DESIGNED BY: Kellie White
DATE: July 26, 2008
REVISION DATE: August 1, 2008

CK CONTRACTING, INC.
1400 NE SR 47
TRENTON, FL 32693
352-472-9888

SHEET NO.
1
OF
5

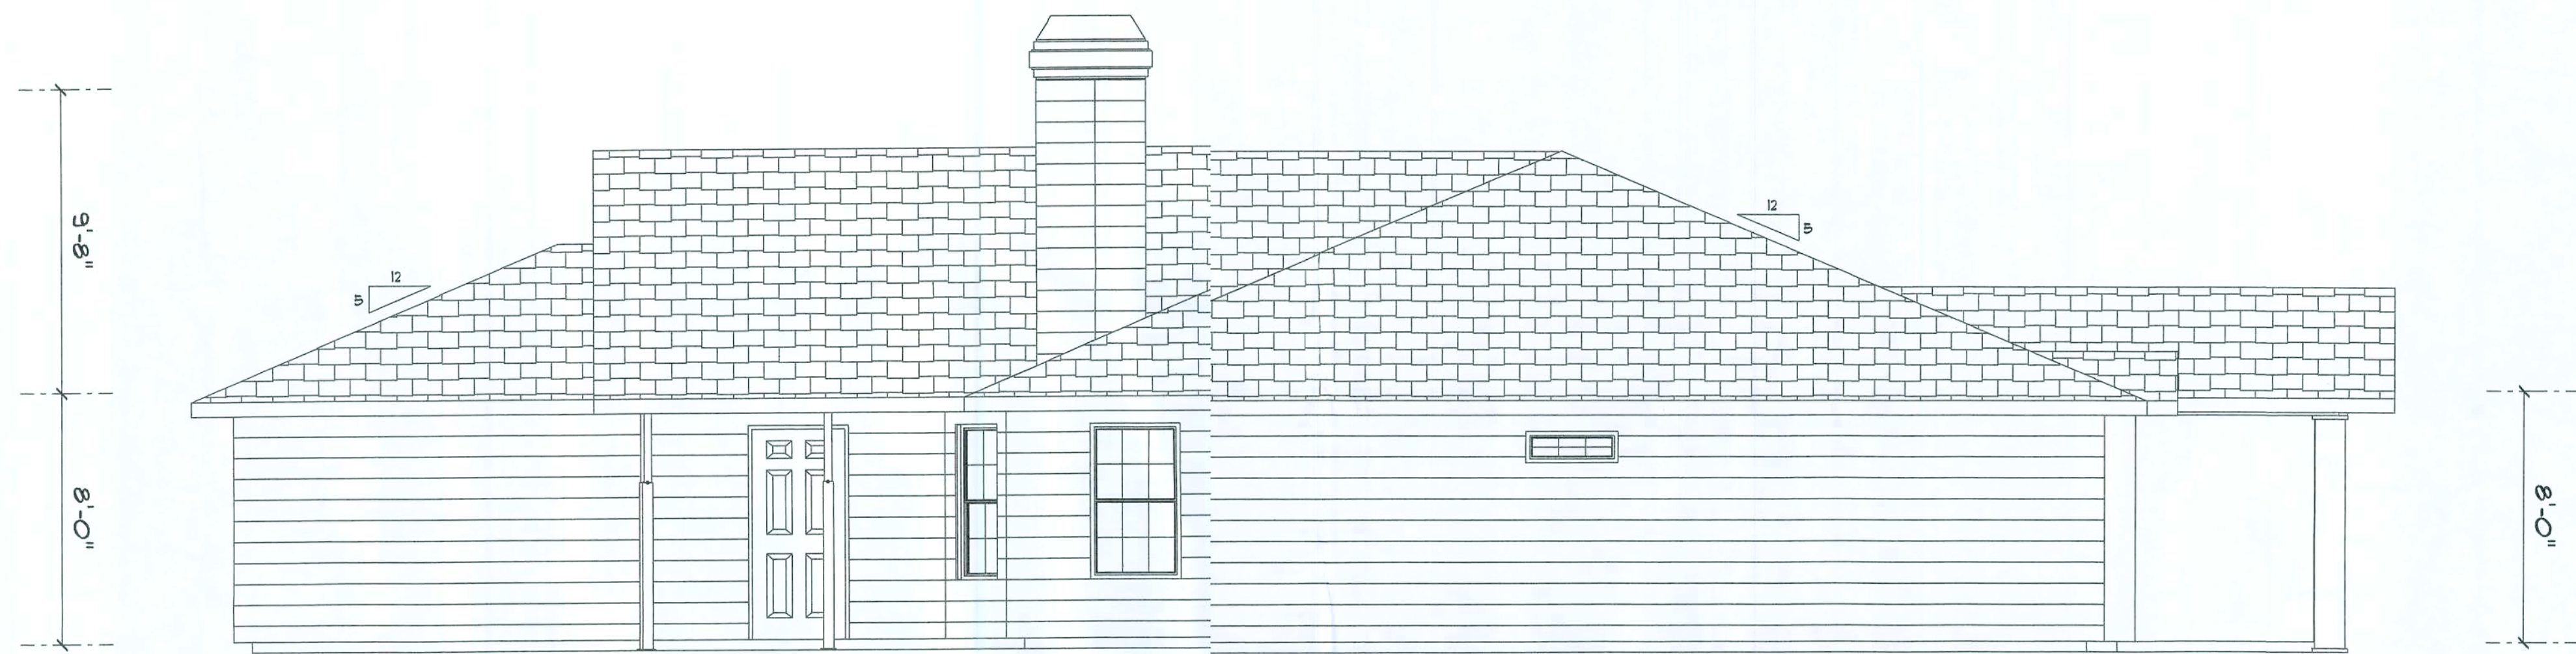

LEFT ELEVATION
SCALE: 1/4" = 1'-0"

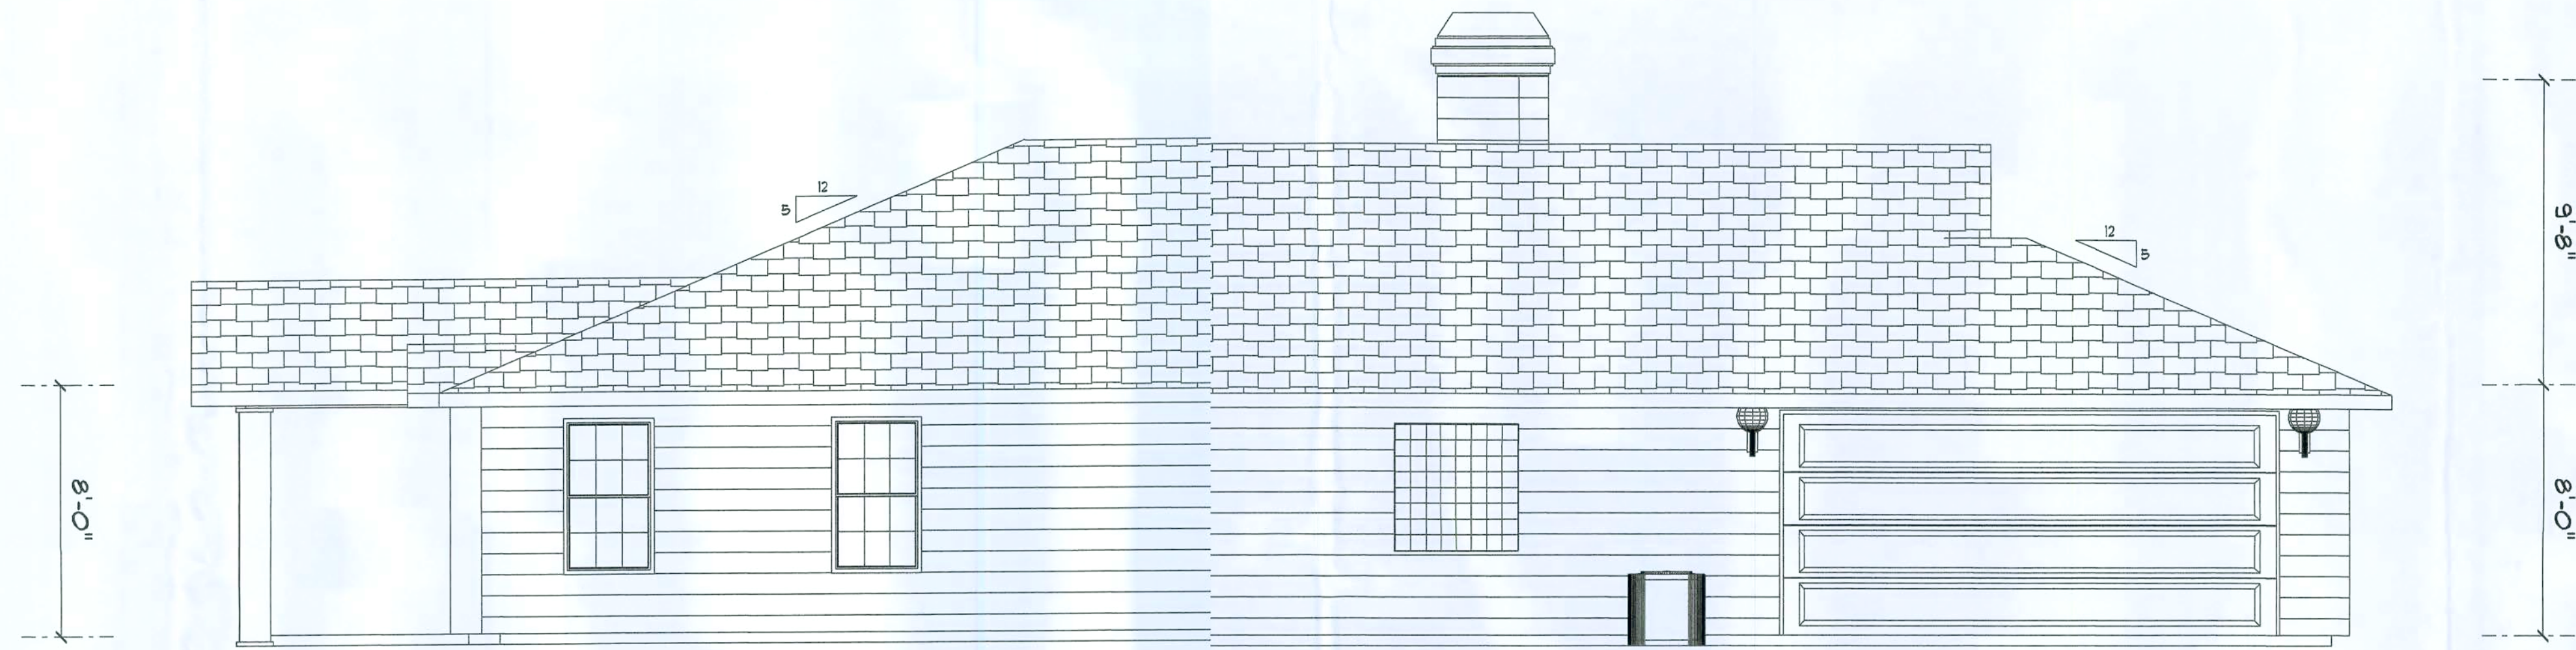

RIGHT ELEVATION
SCALE: 1/4" = 1'-0"




CK CONTRACTING, INC.
CUNNINGHAM RESIDENCE

DESIGN BY: Kelle White
DATE: July 28, 2008
REVISION DATE: August 1, 2008

CK CONTRACTING, INC.
1400 NE SR 47
TRENTON, FL 32693
352-472-9888


SHEET NO.
2
OF
3

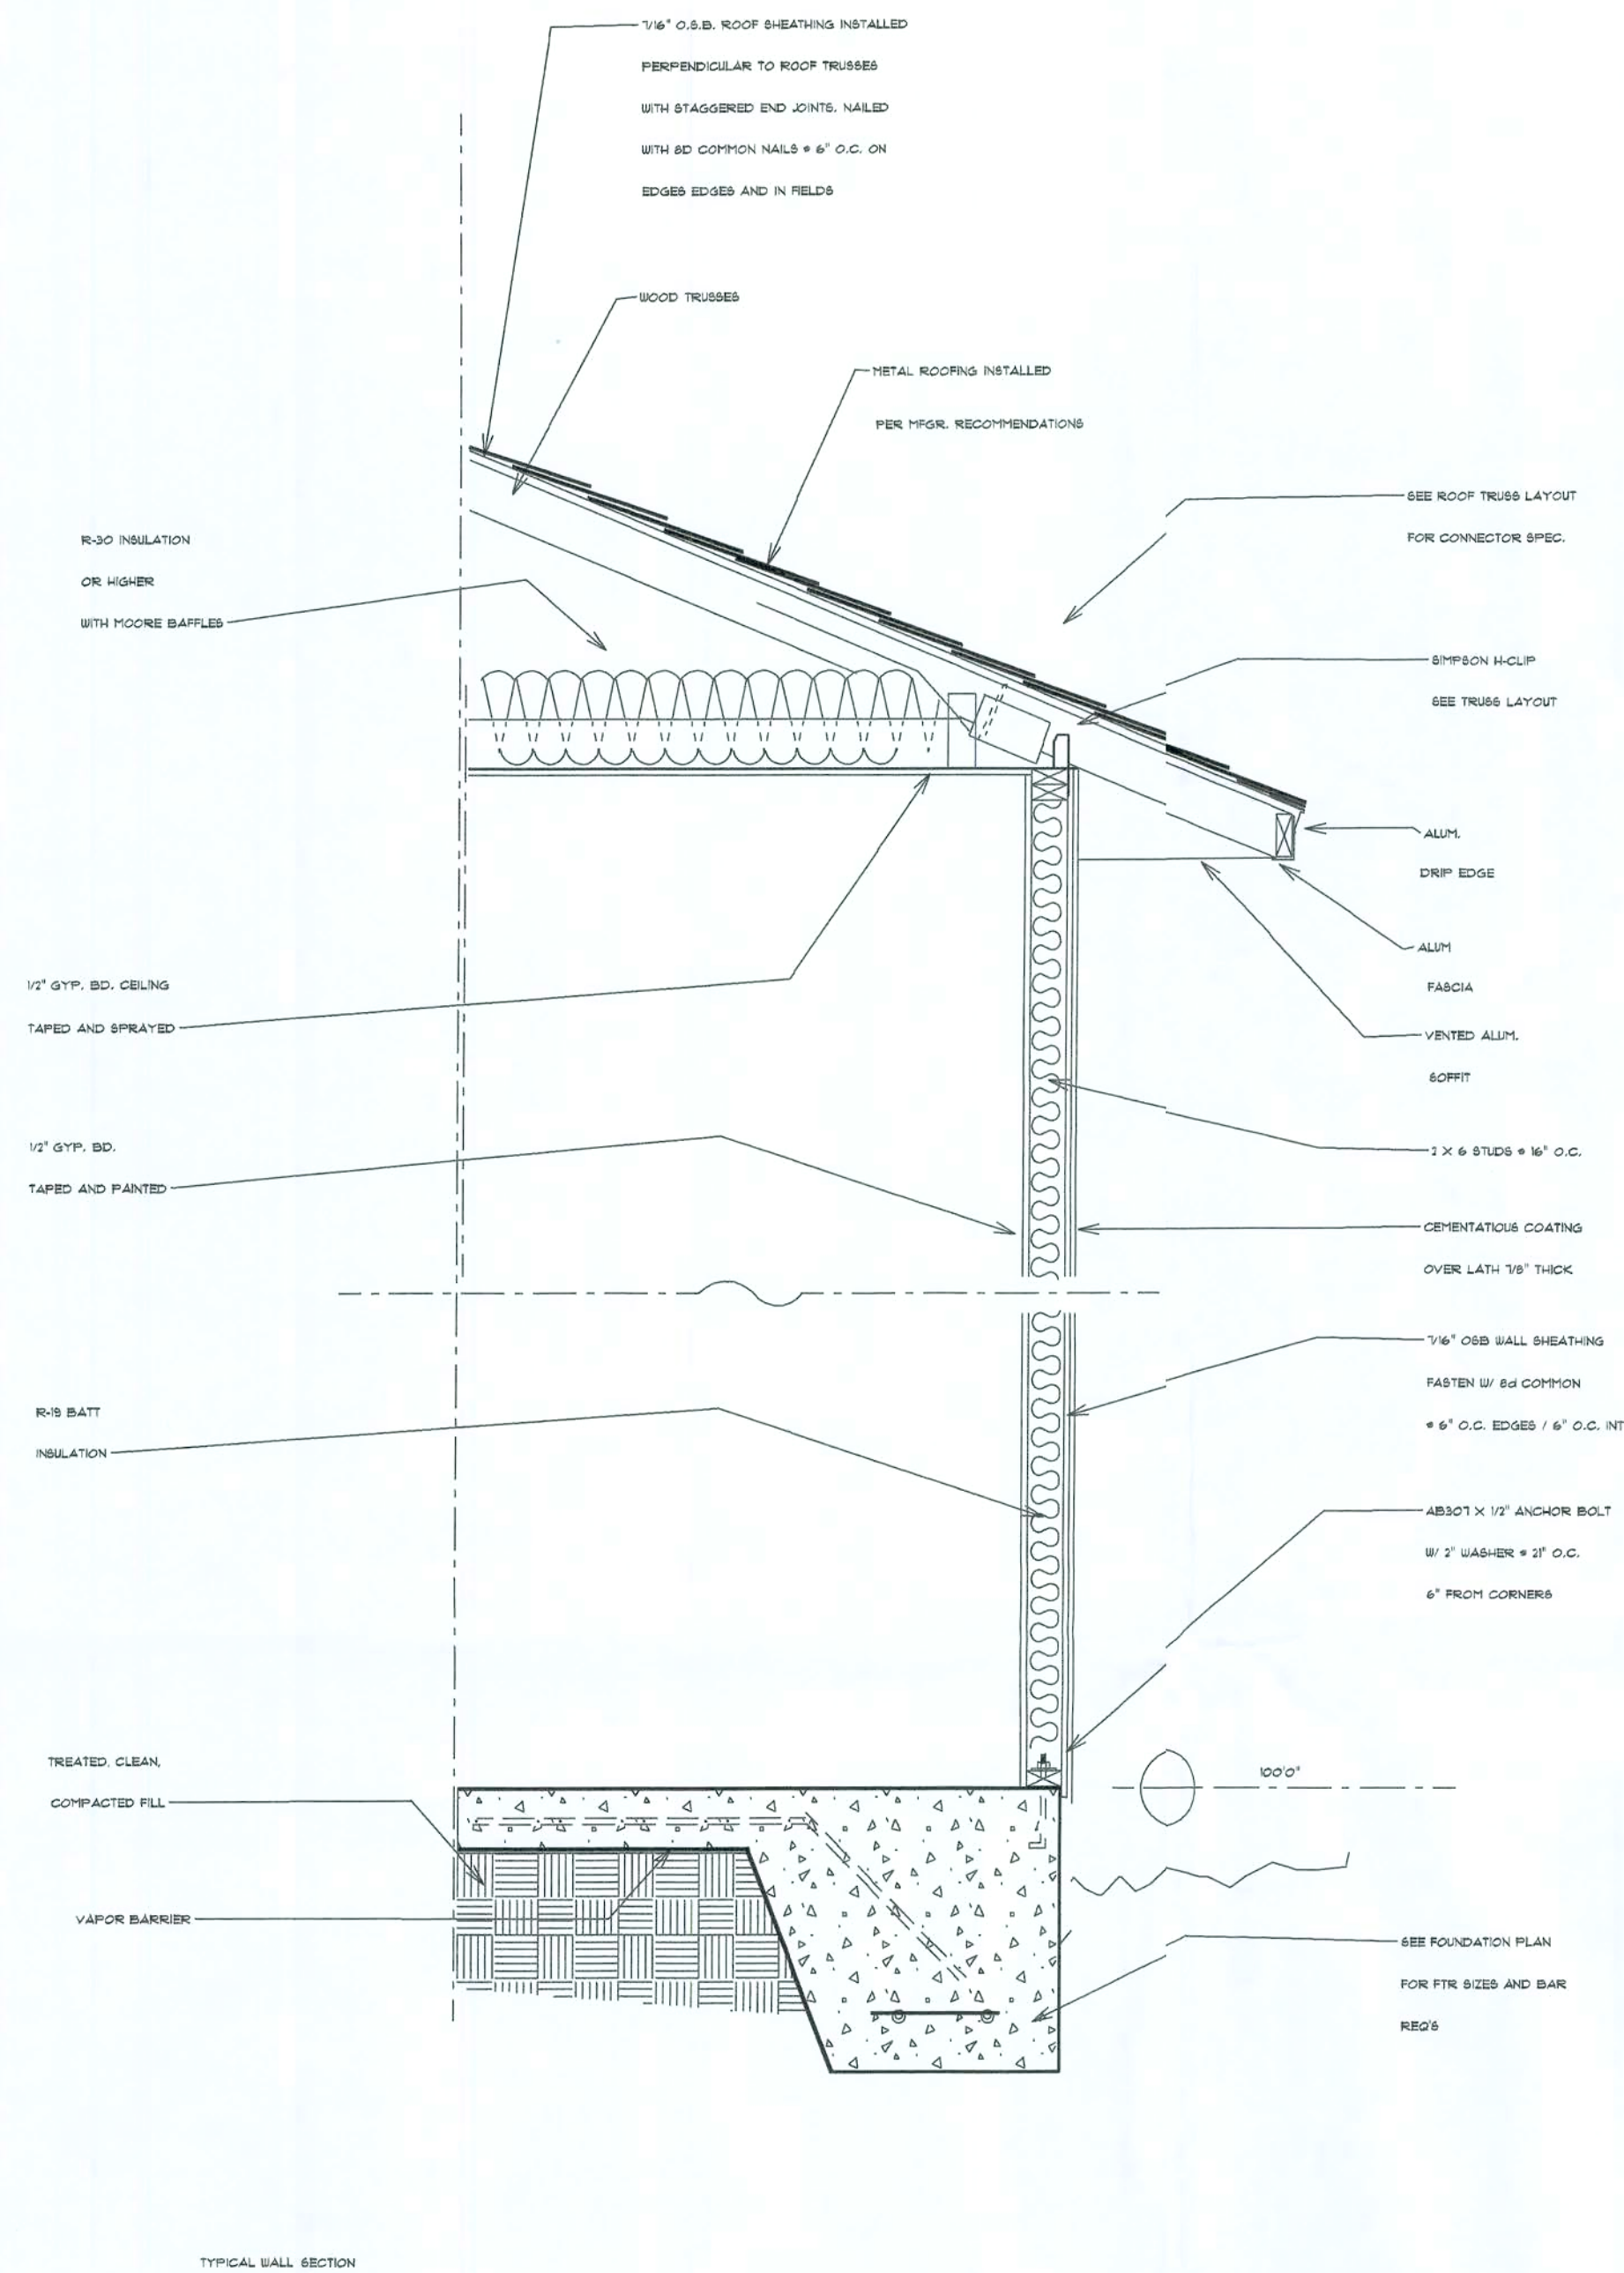

NAME	AREA
Heated Space	2128 sq ft.
Garage	420 sq ft.
Entry	200 sq ft.
Covered Porch	230 sq ft.
TOTAL	2978 sq ft.

NOTE:
All ceiling heights are 8'
unless otherwise noted.

MAIN FLOOR PLAN
SCALE: 1/4" = 1'-0"

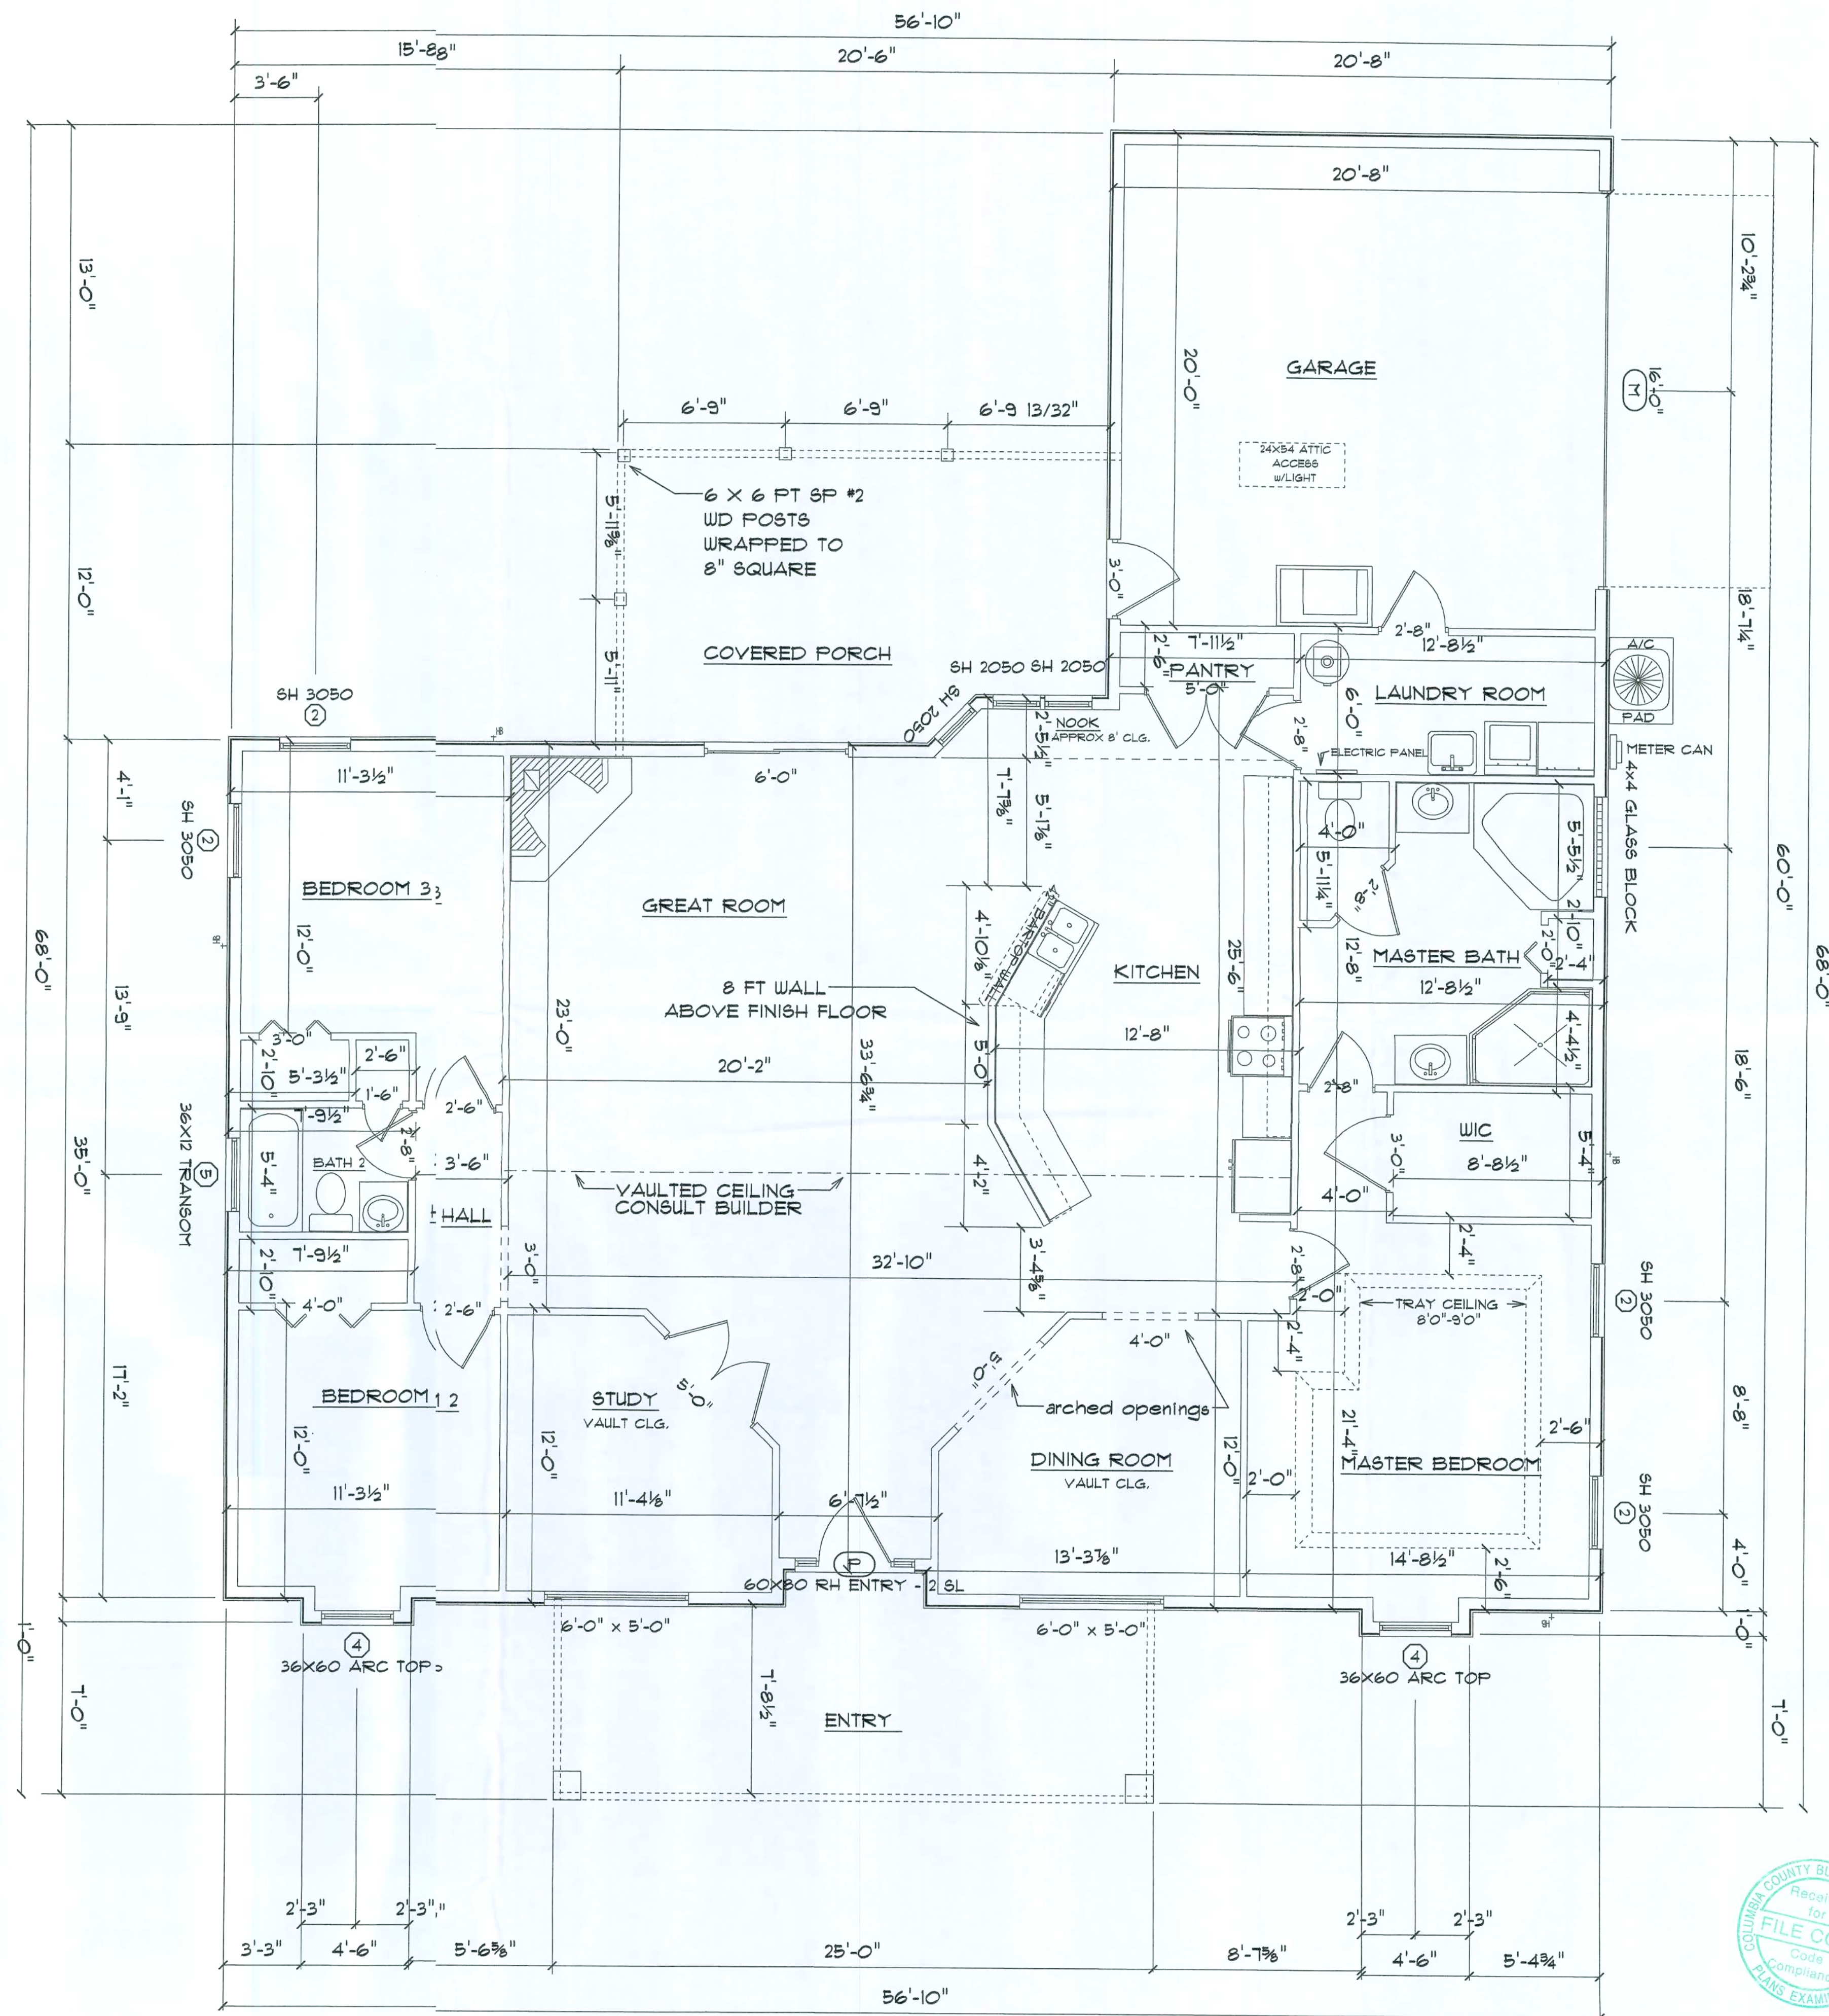

CK CONTRACTING, INC.

CUNNINGHAM RESIDENCE

CK CONTRACTING, INC.




1400 NE SR 47
TRENTON, FL 32693
352-472-9888

SHEET NO.

3

OF


5

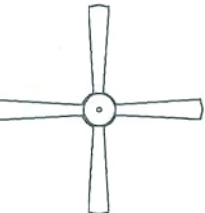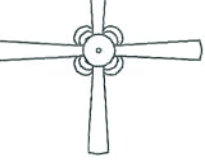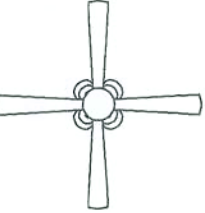ELECTRICAL	COUNT	SYMBOL
ceiling fan glibs 2	1	
ceiling fan sptlights 1	1	
ceiling fan sptlights 2	3	
ceiling dish rund	3	
ceiling lamp globe	3	
ceiling lamp lrge	1	
exterior light1	2	
ceiling globelight	5	
chandelier	1	
fluorescent flture	3	
pendant globe	2	
electrical panel	1	
outlet	58	
switch	33	

NOTE:
ALL BEDROOM RCEPTACLES SHALL BE AFCI
(ARC FAULT CIRCUIT INTERRUPT)

ALL SMOKE DETETORS SHALL HAVE BATTERY
BACKUP POWER AND ALL WIRED TOGETHER
SO IF ANY ONE UIT IS ACTUATED THEY ALL ACTIVATE.

ELECTRICAL PLAN
SCALE: 1/4" = 1'-0"

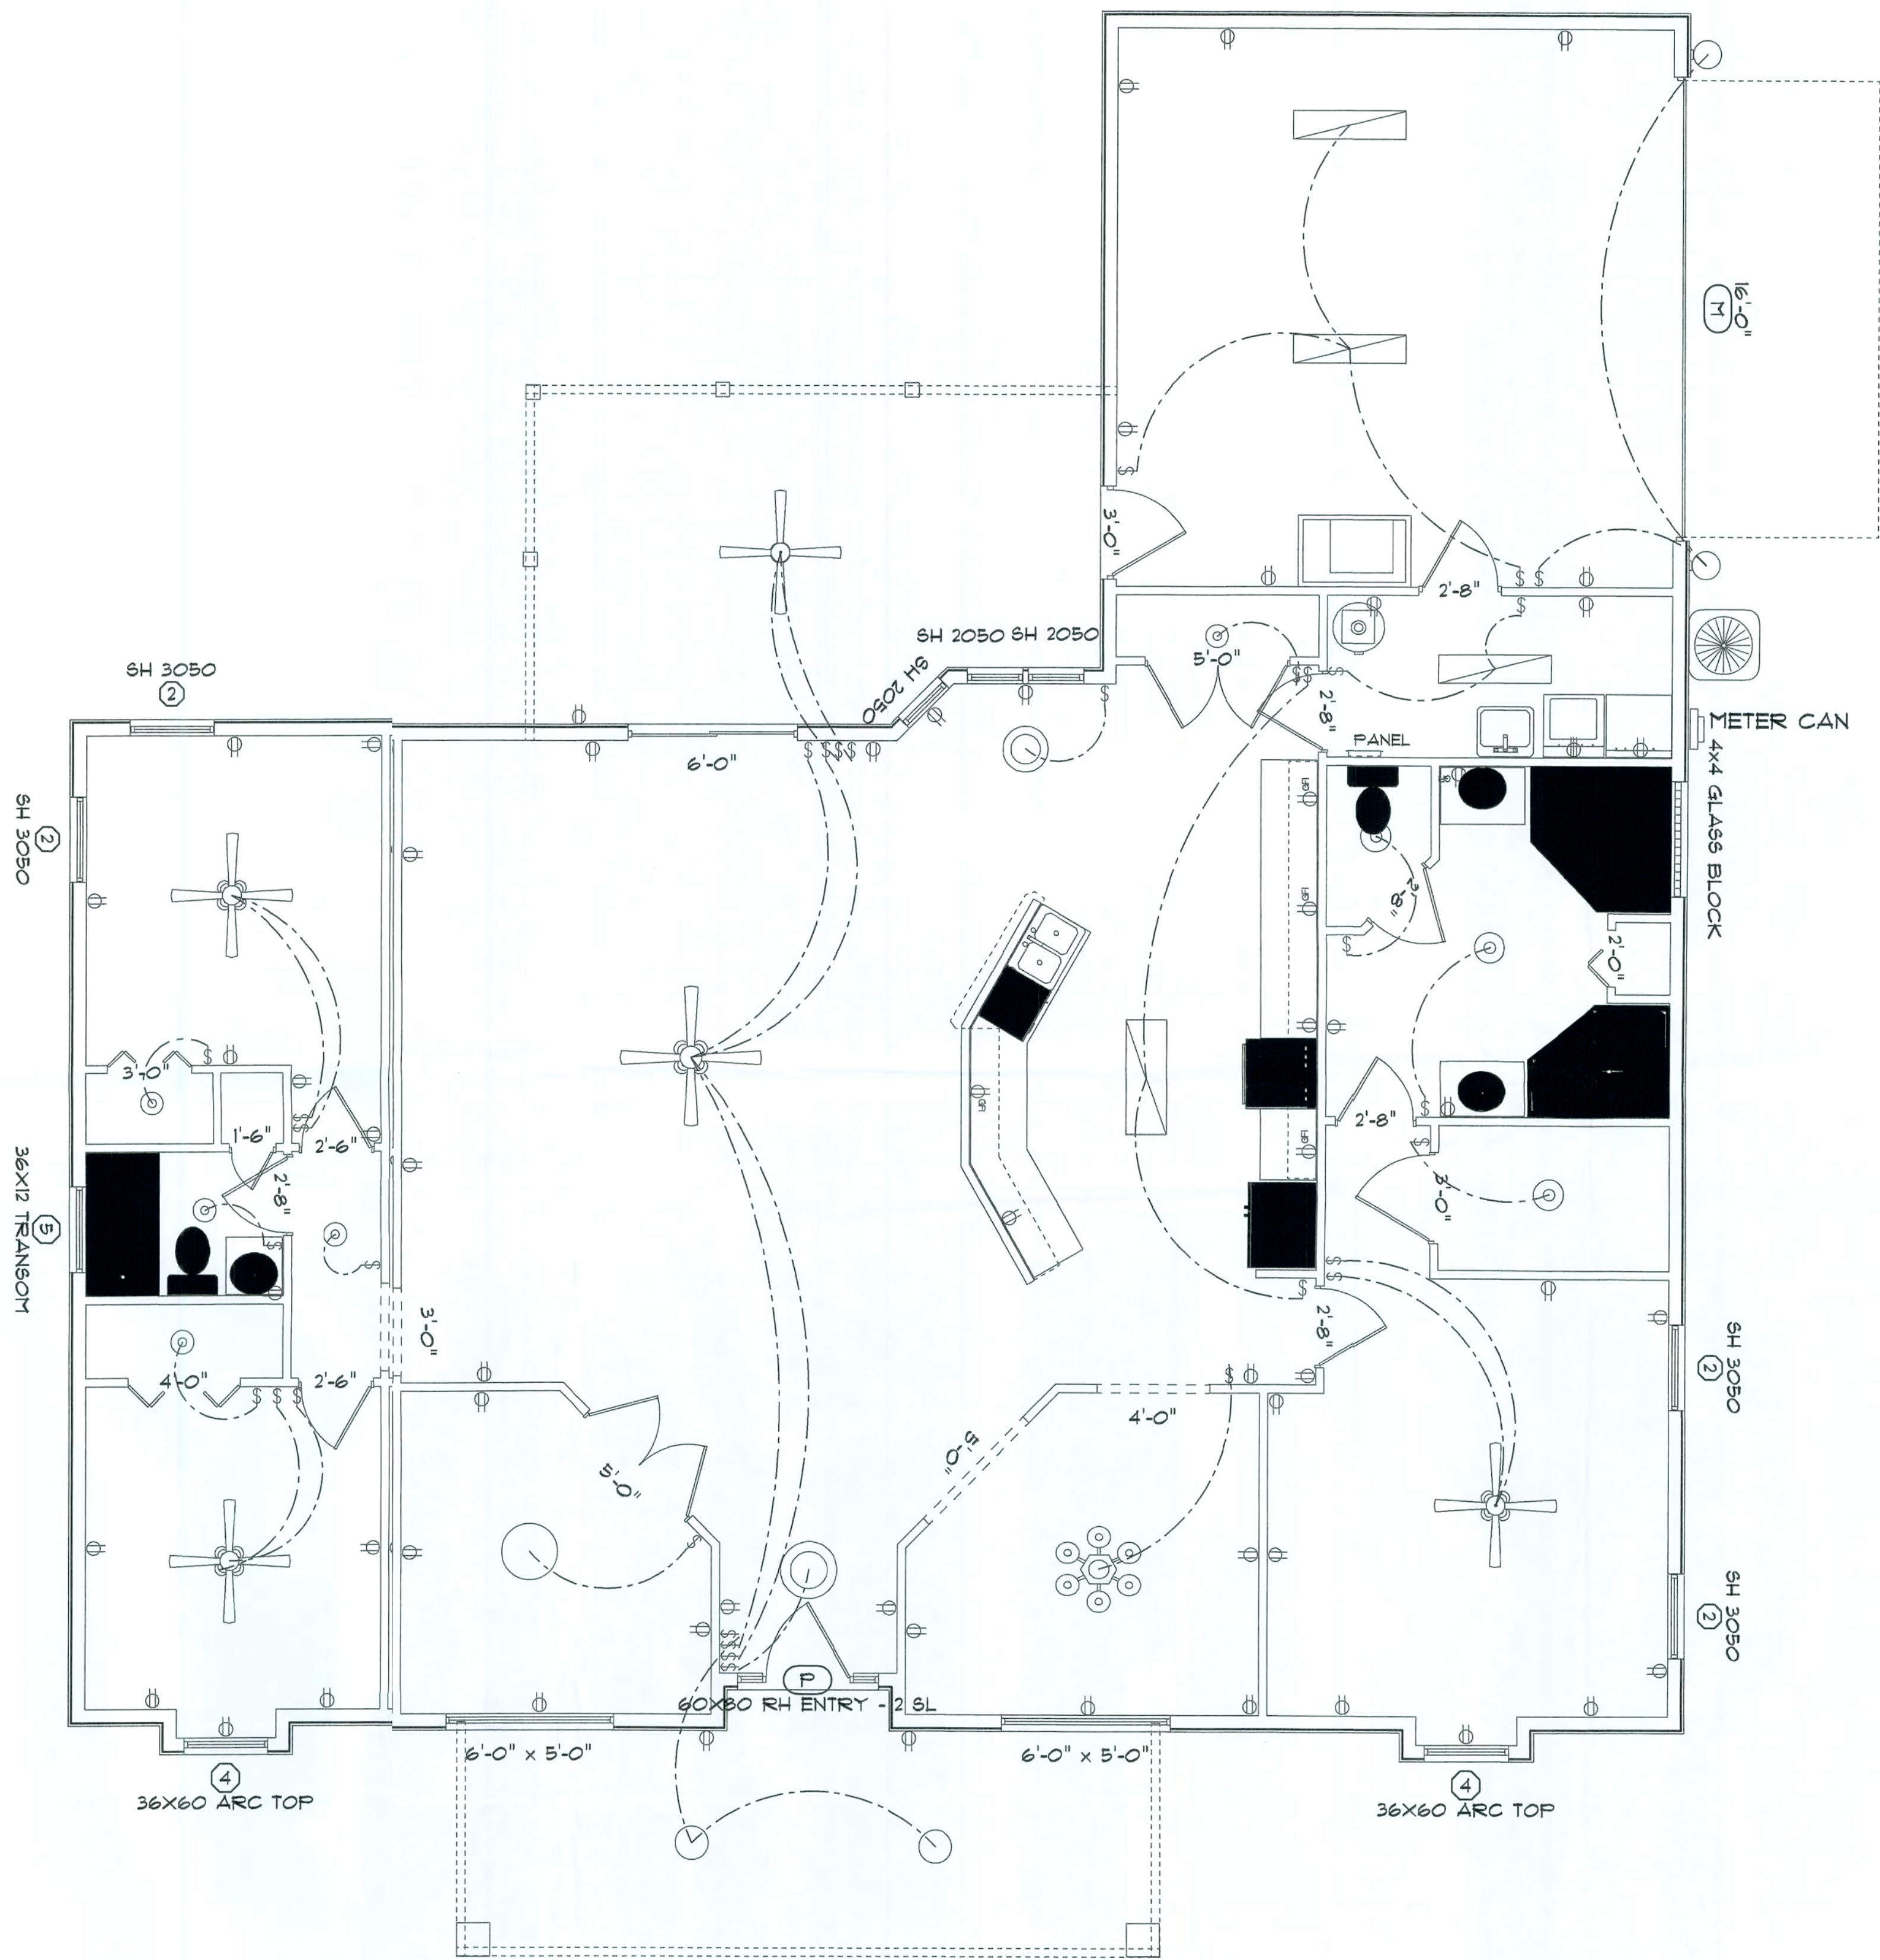


CK CONTRACTING, INC.
CUNNINGHAM RESIDENCE

DESIGNED BY: Kellis White
DATE: July 28, 2009

CK CONTRACTING, INC.
1400 NE SR 47
TRENTON, FL 32693
352-472-9888

SHEET NO.
4
OF
5

FOUNDATION PLAN
SCALE: 1/4" = 1'-0"

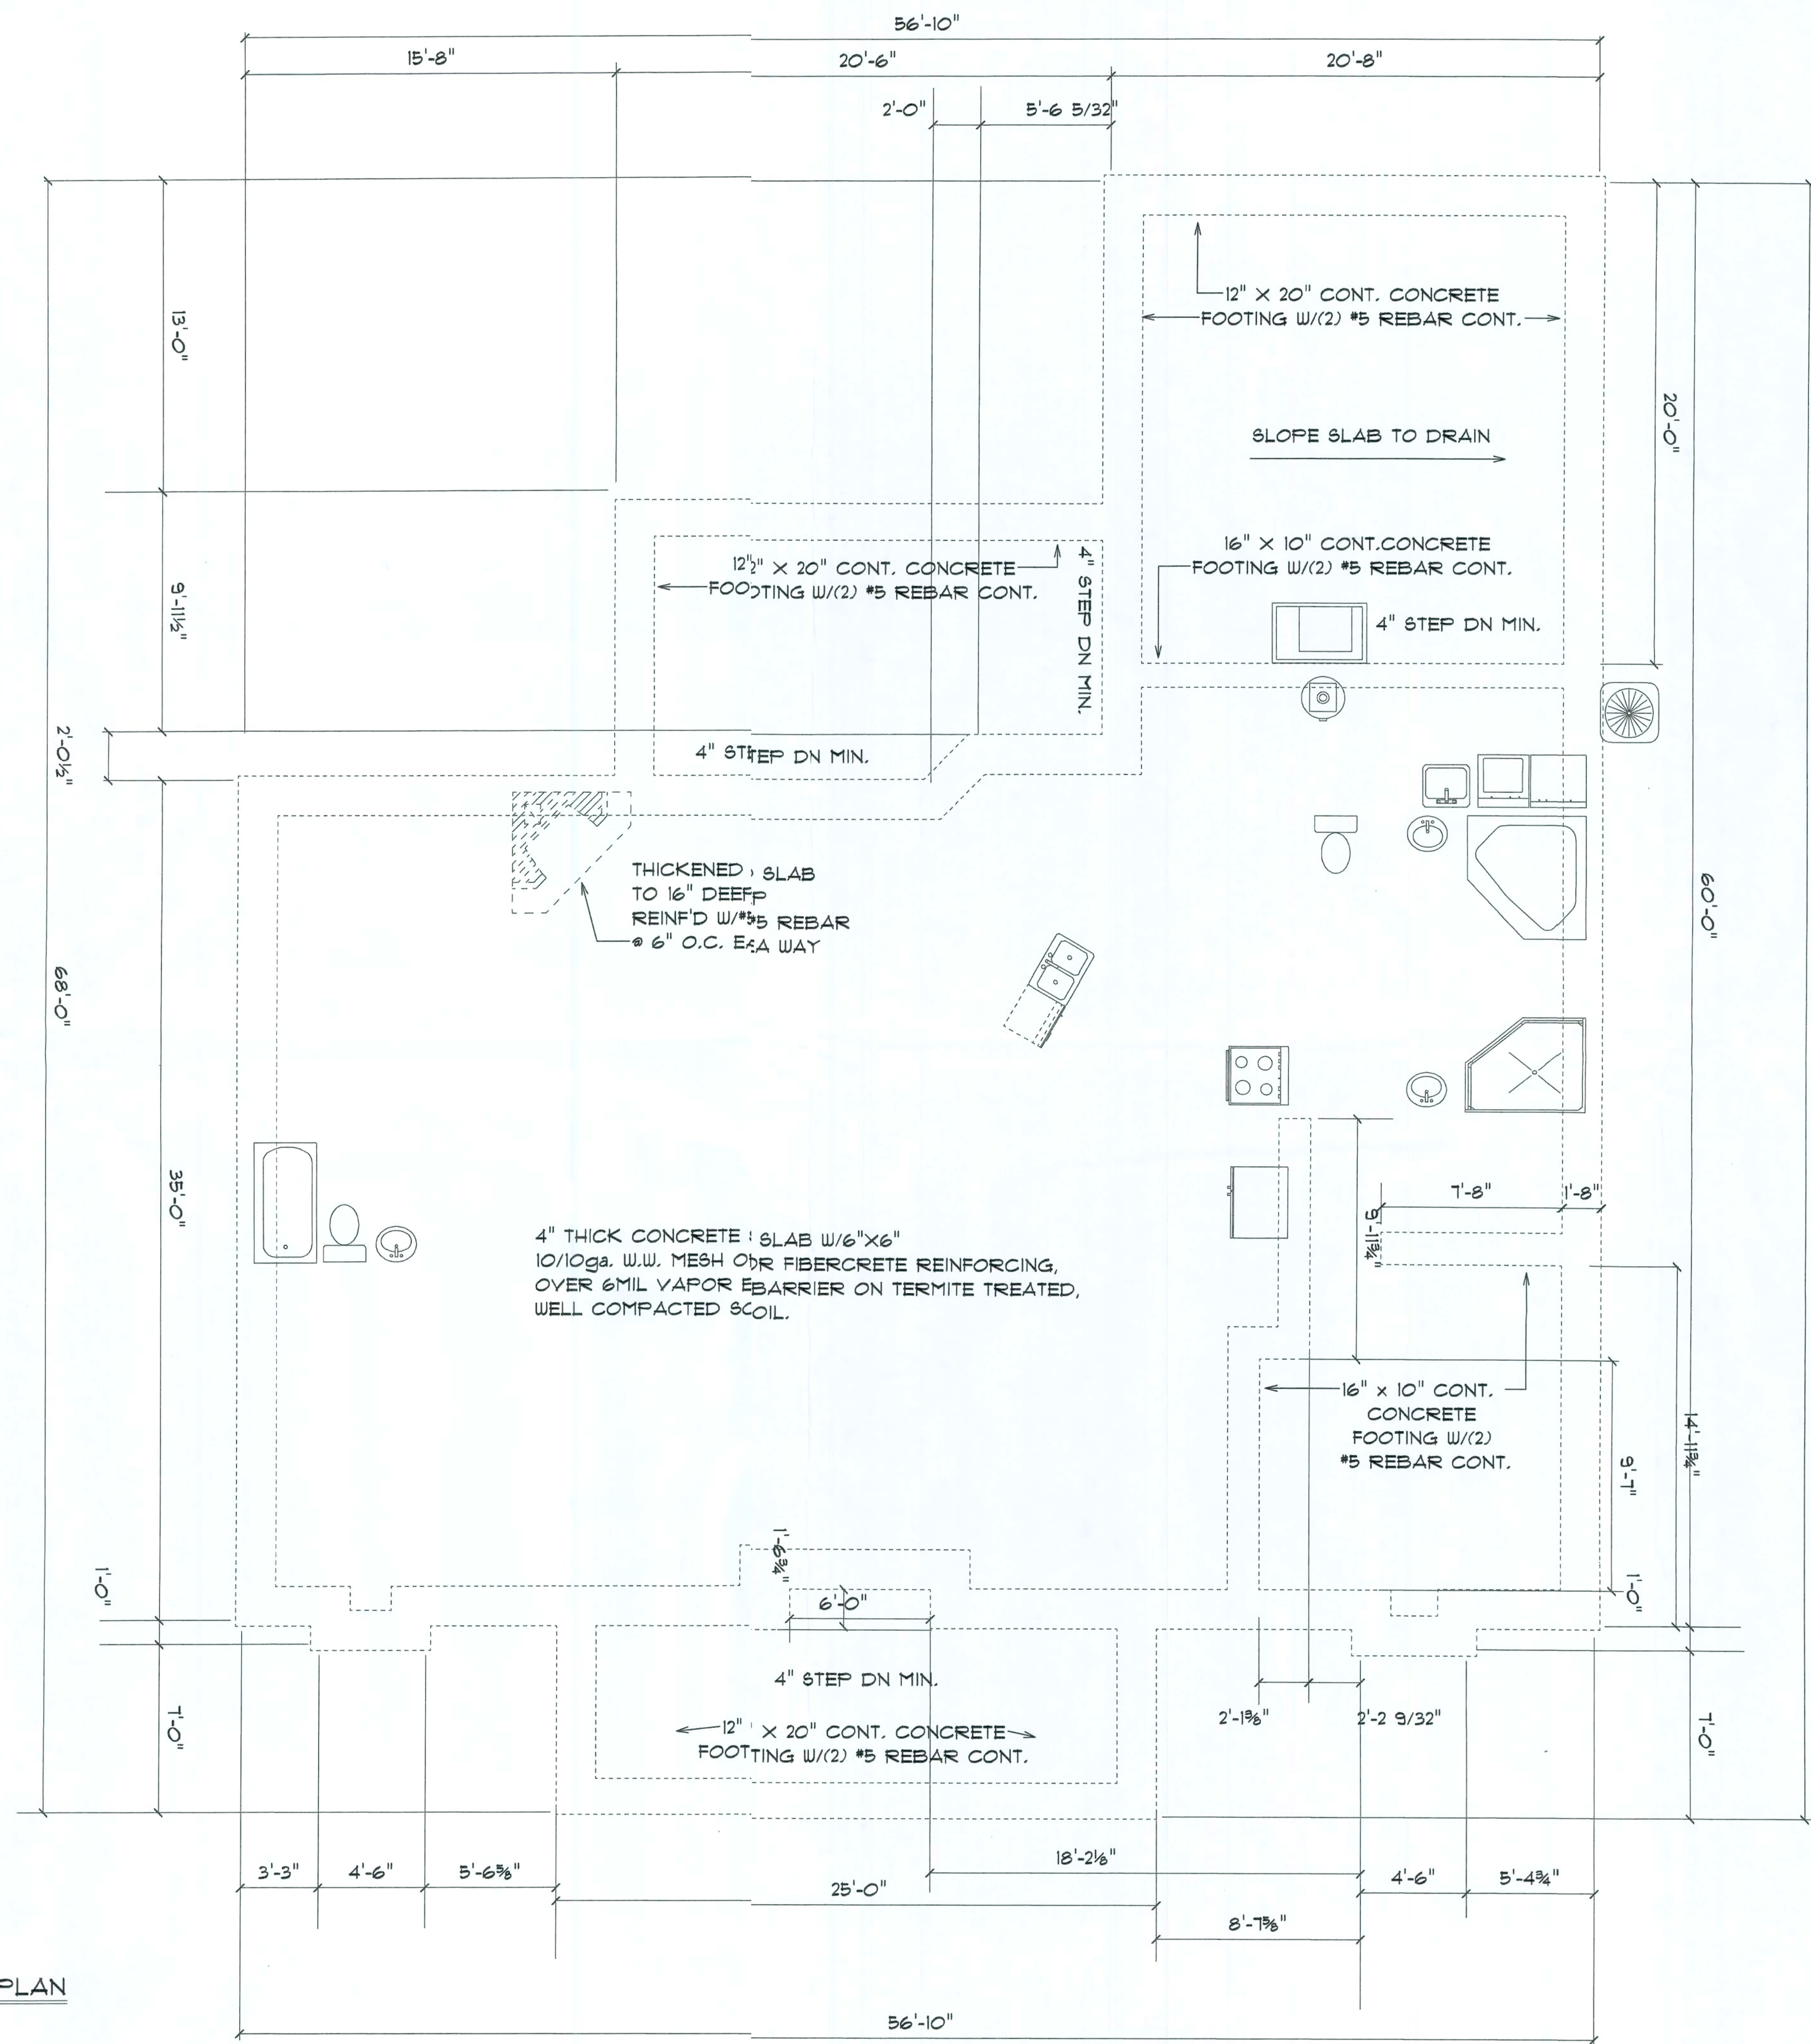

CK CONTRACTING, INC.

CUNNINGHAM RESIDENCE

DRAWN BY: Kellie White
DATE: July 28, 2008

CK CONTRACTING, INC.
1400 NE SR 47
TRENTON, FL 32693
352-472-9888

SHEET NO.
5
OF
5