



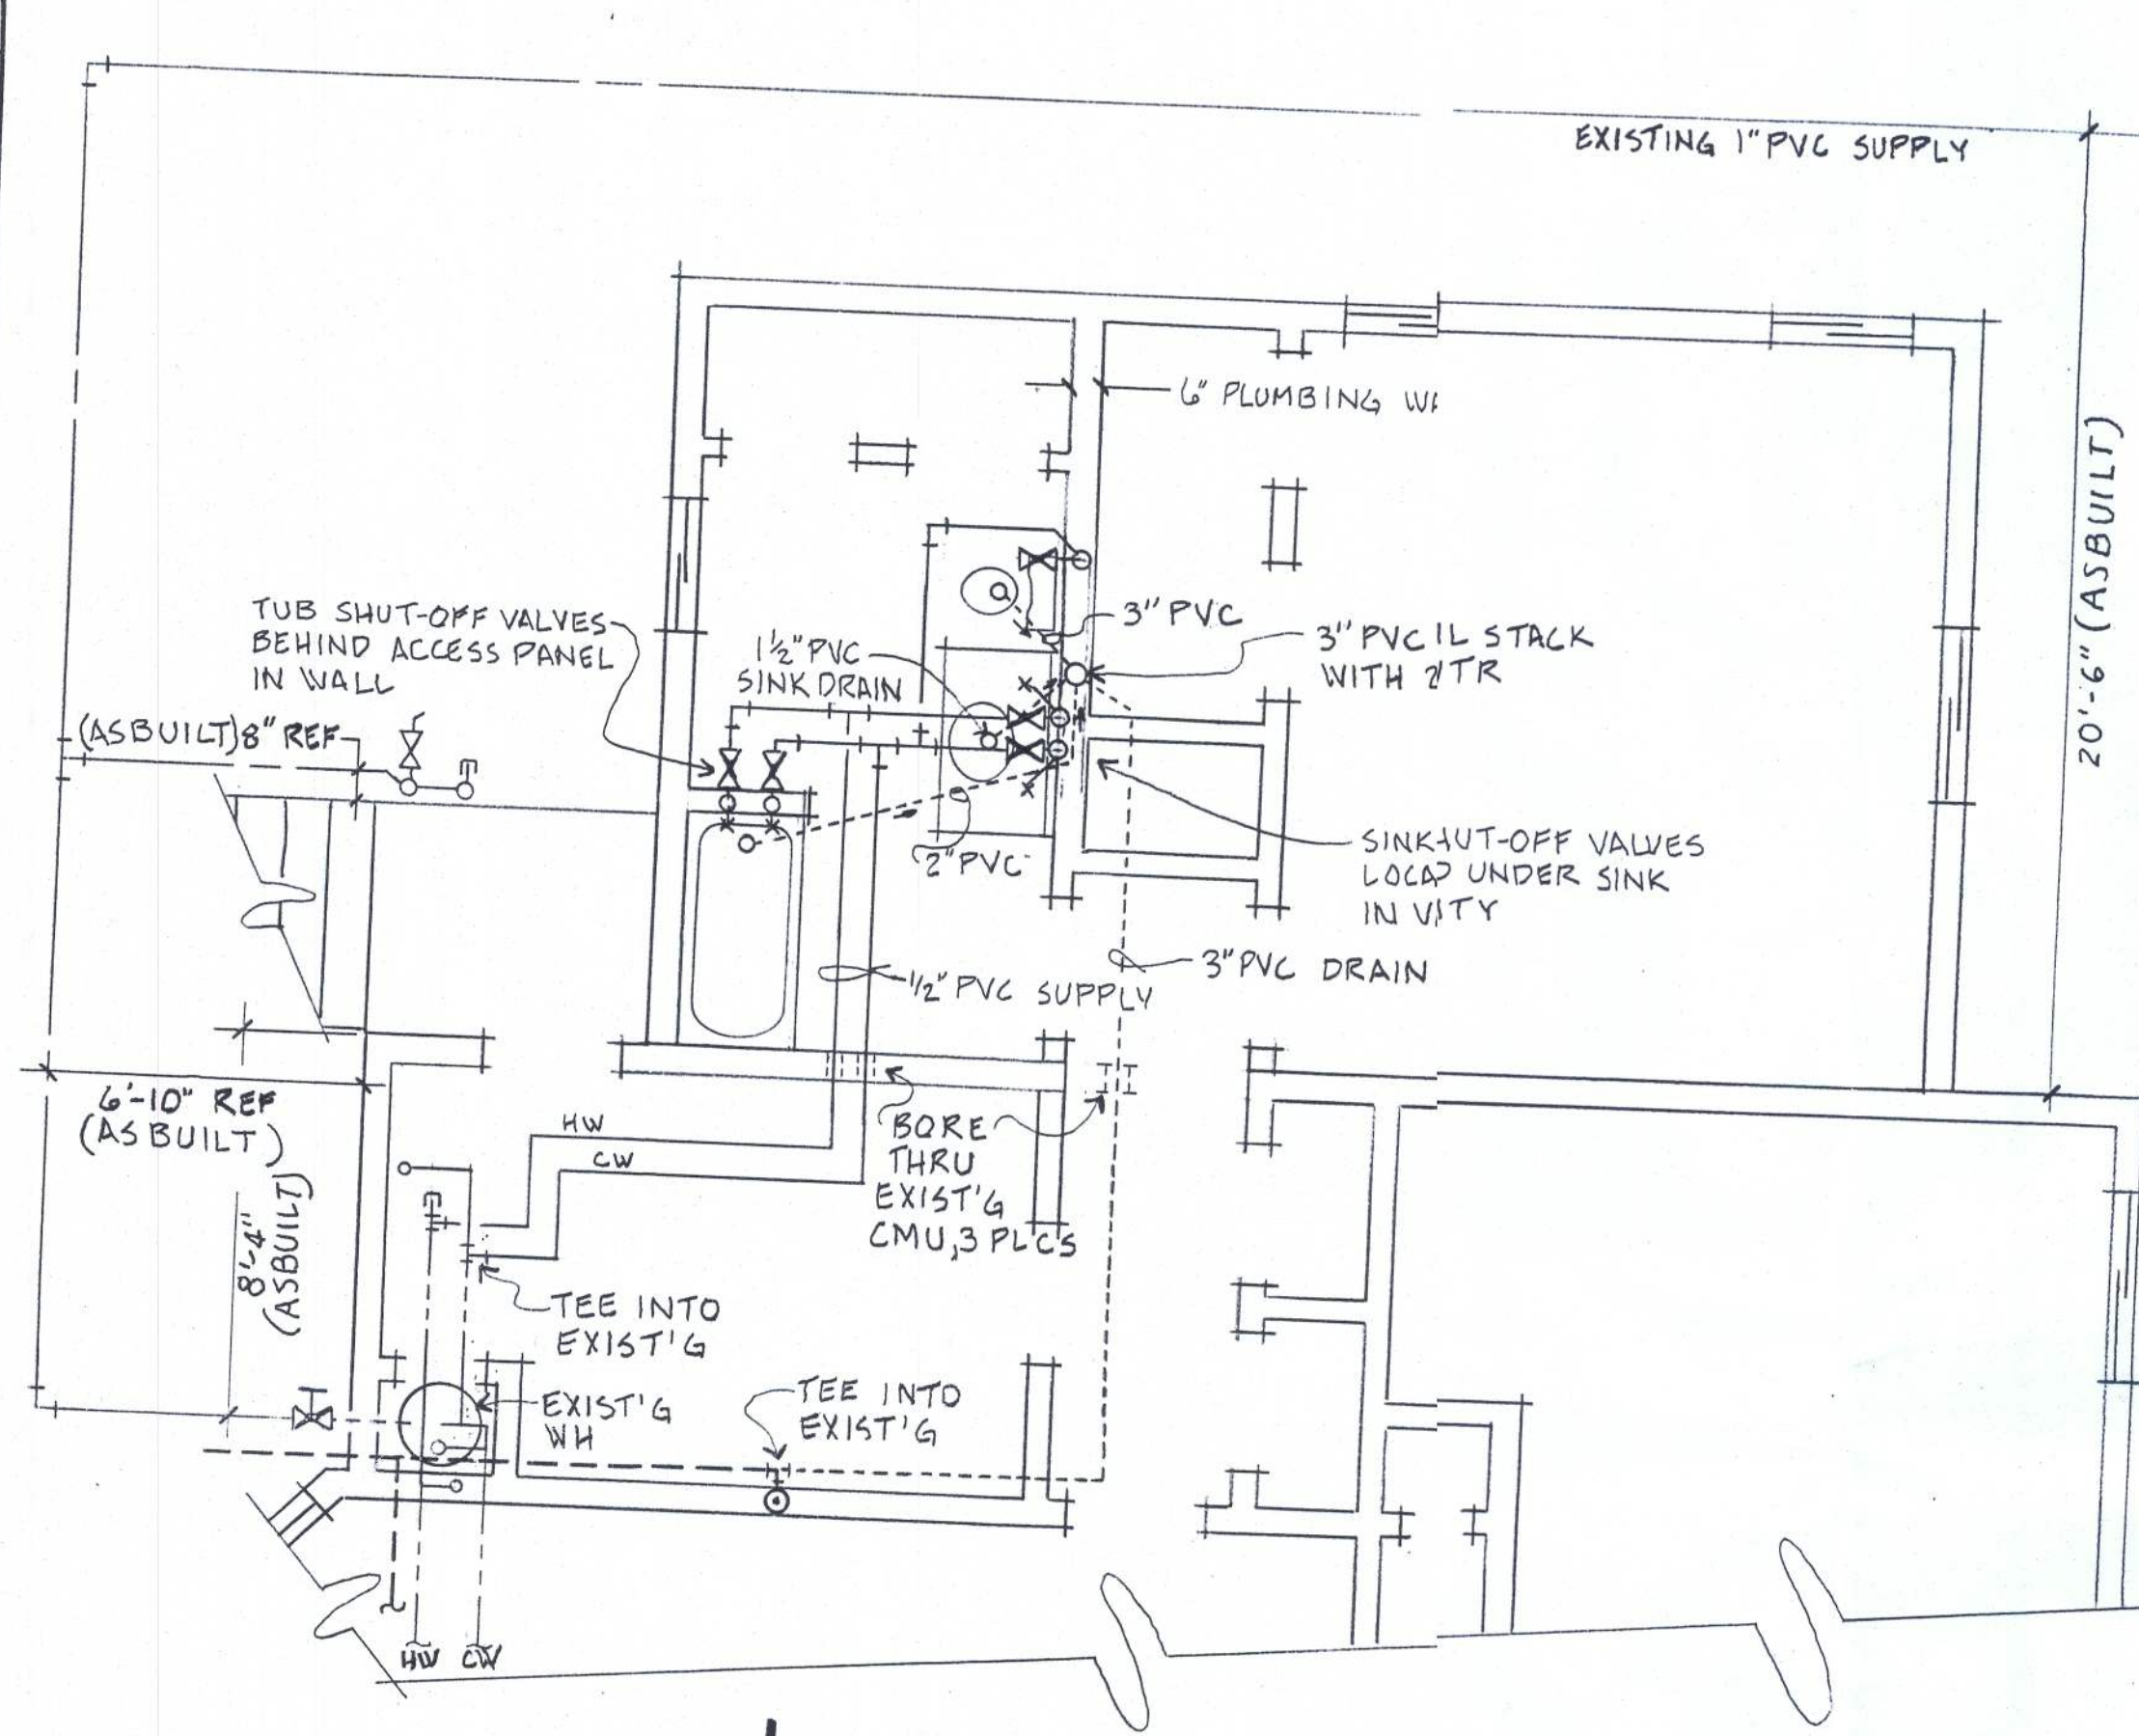

FLOOR PLAN
 SCALE = 1/4" = 1'-0"

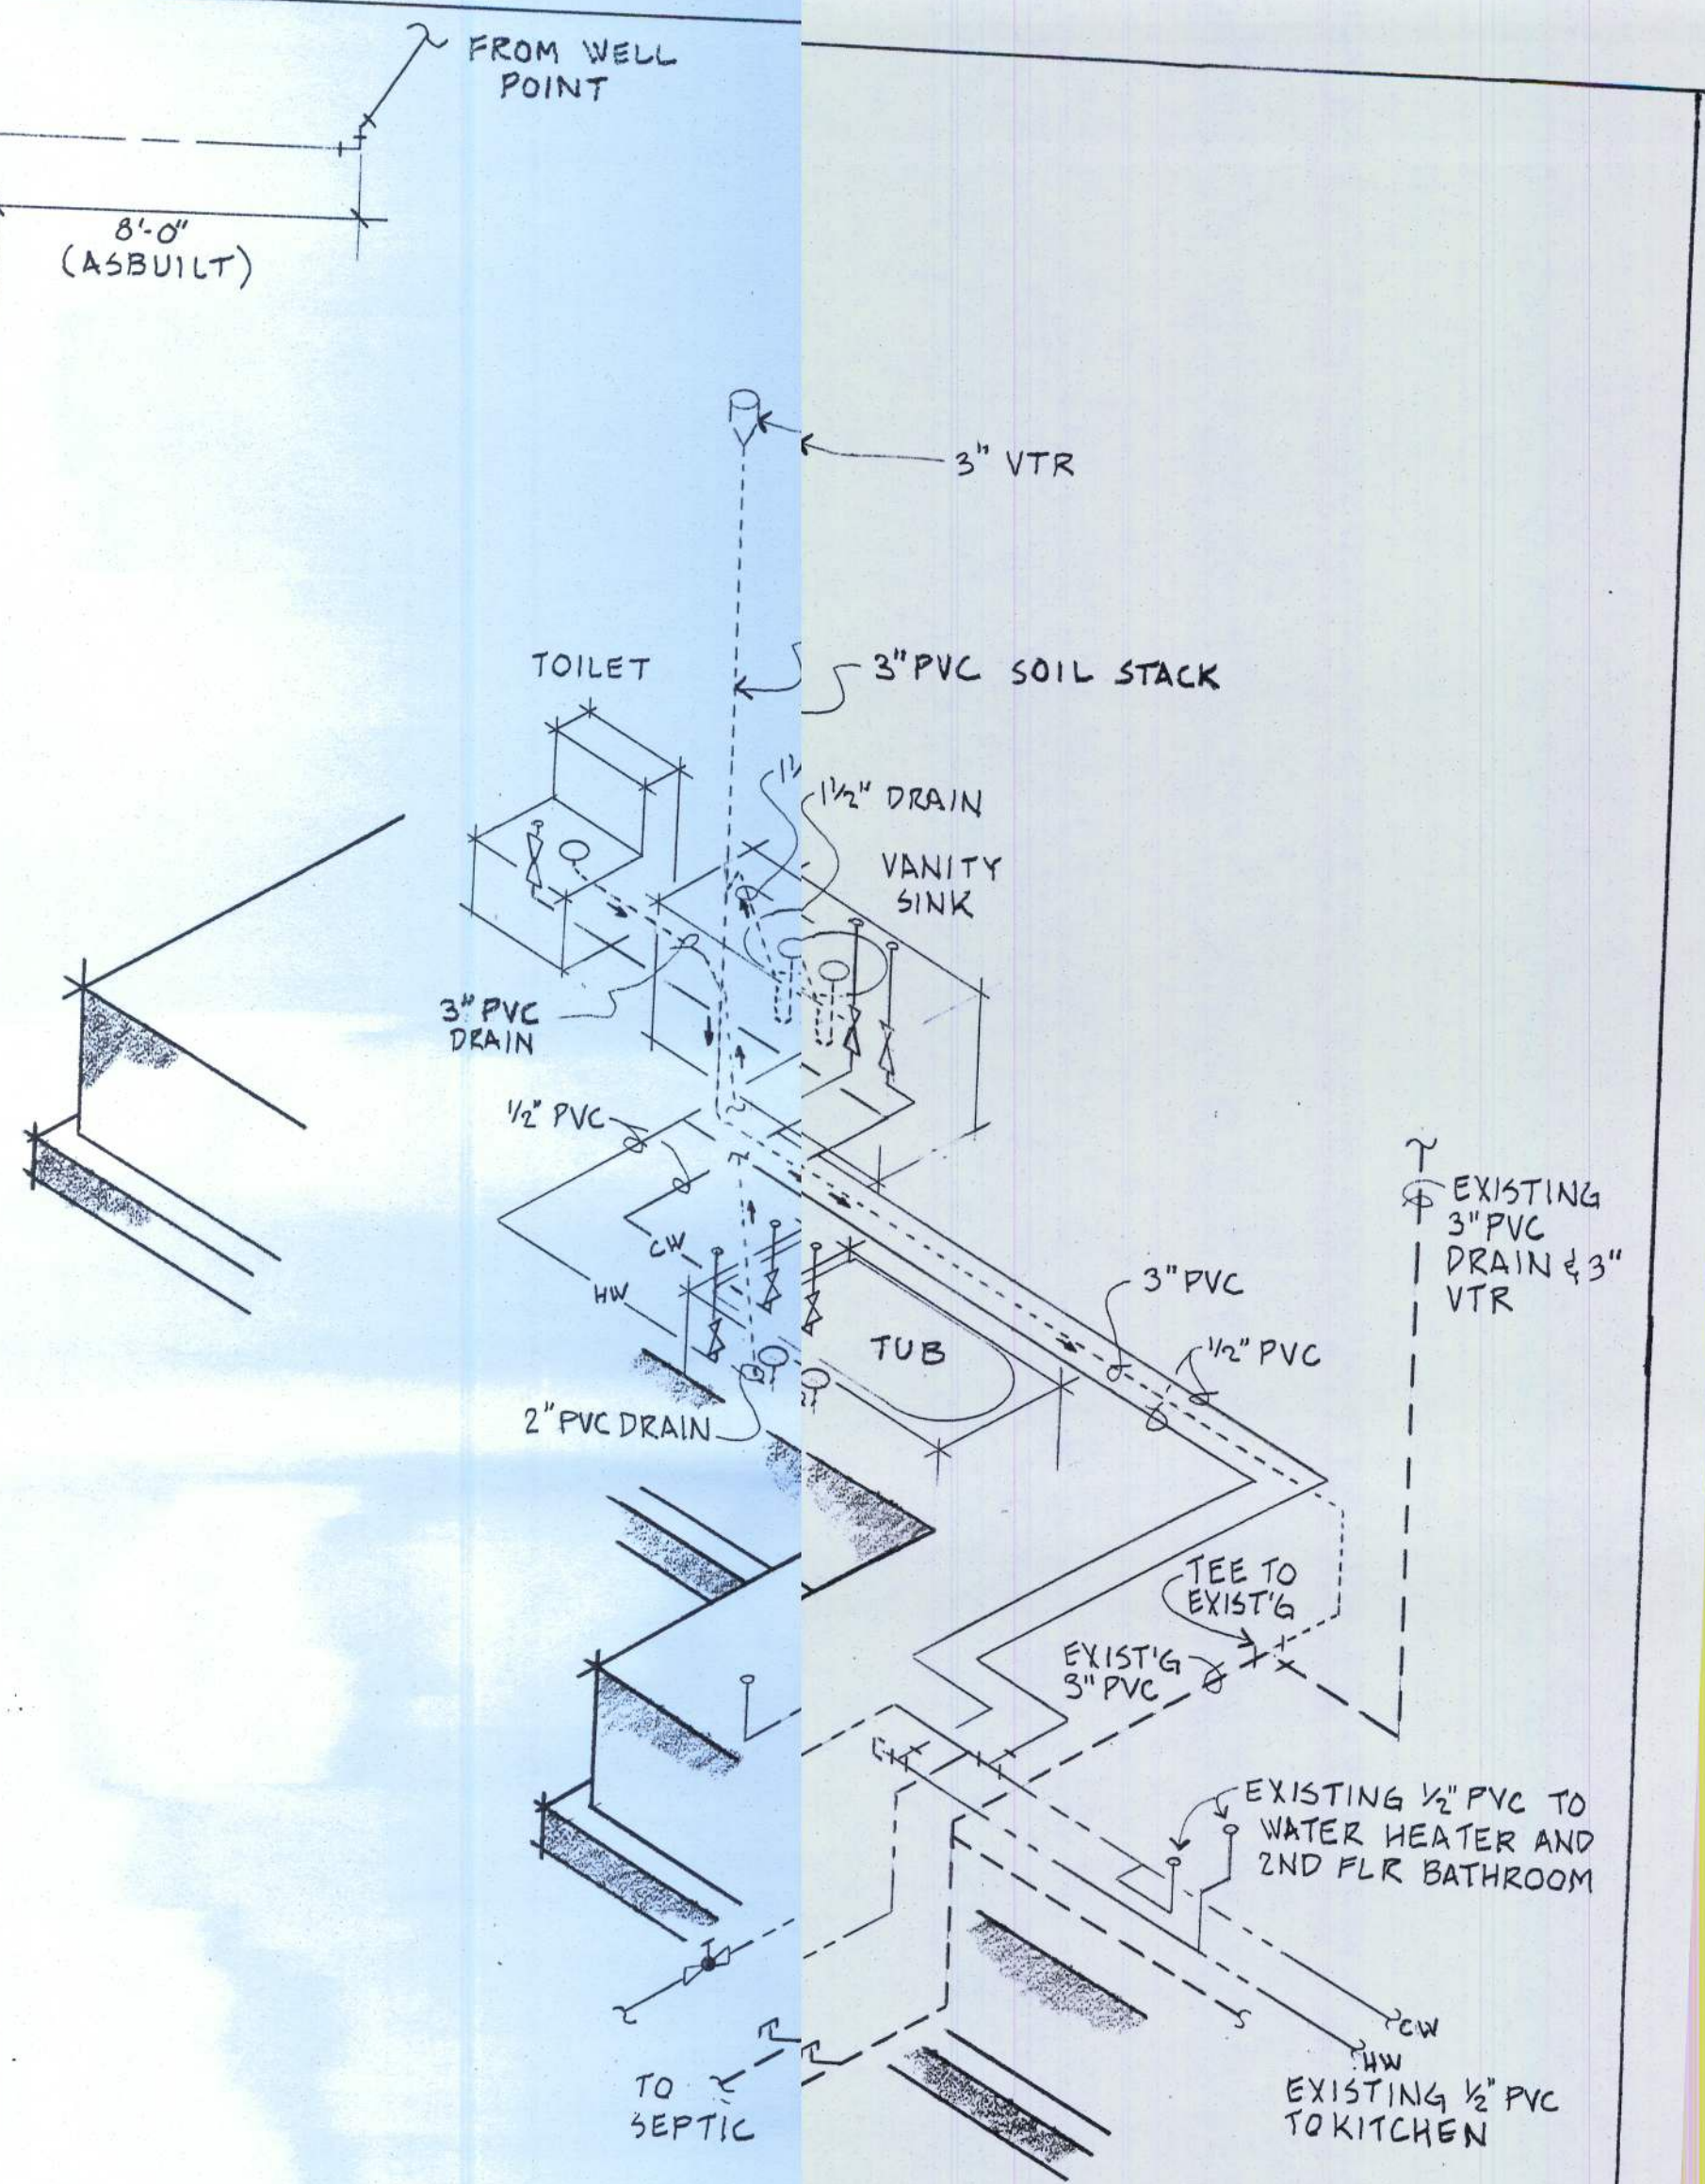

ISOMETRIC DETAIL
 NOT TO SCALE

PROJECT: SPENCE RESIDENCE		
B+B ADDITION, 190 SW LONGCALA LOOP		
SHEET TITLE: PLUMBING PLAN AND ISOMETRIC DET.		
DRAWN BY: GD SPENCE	DATE: 4 20 2014	SHEET NO. P-19