



OVERALL DIMENSION
48'-11 1/2"

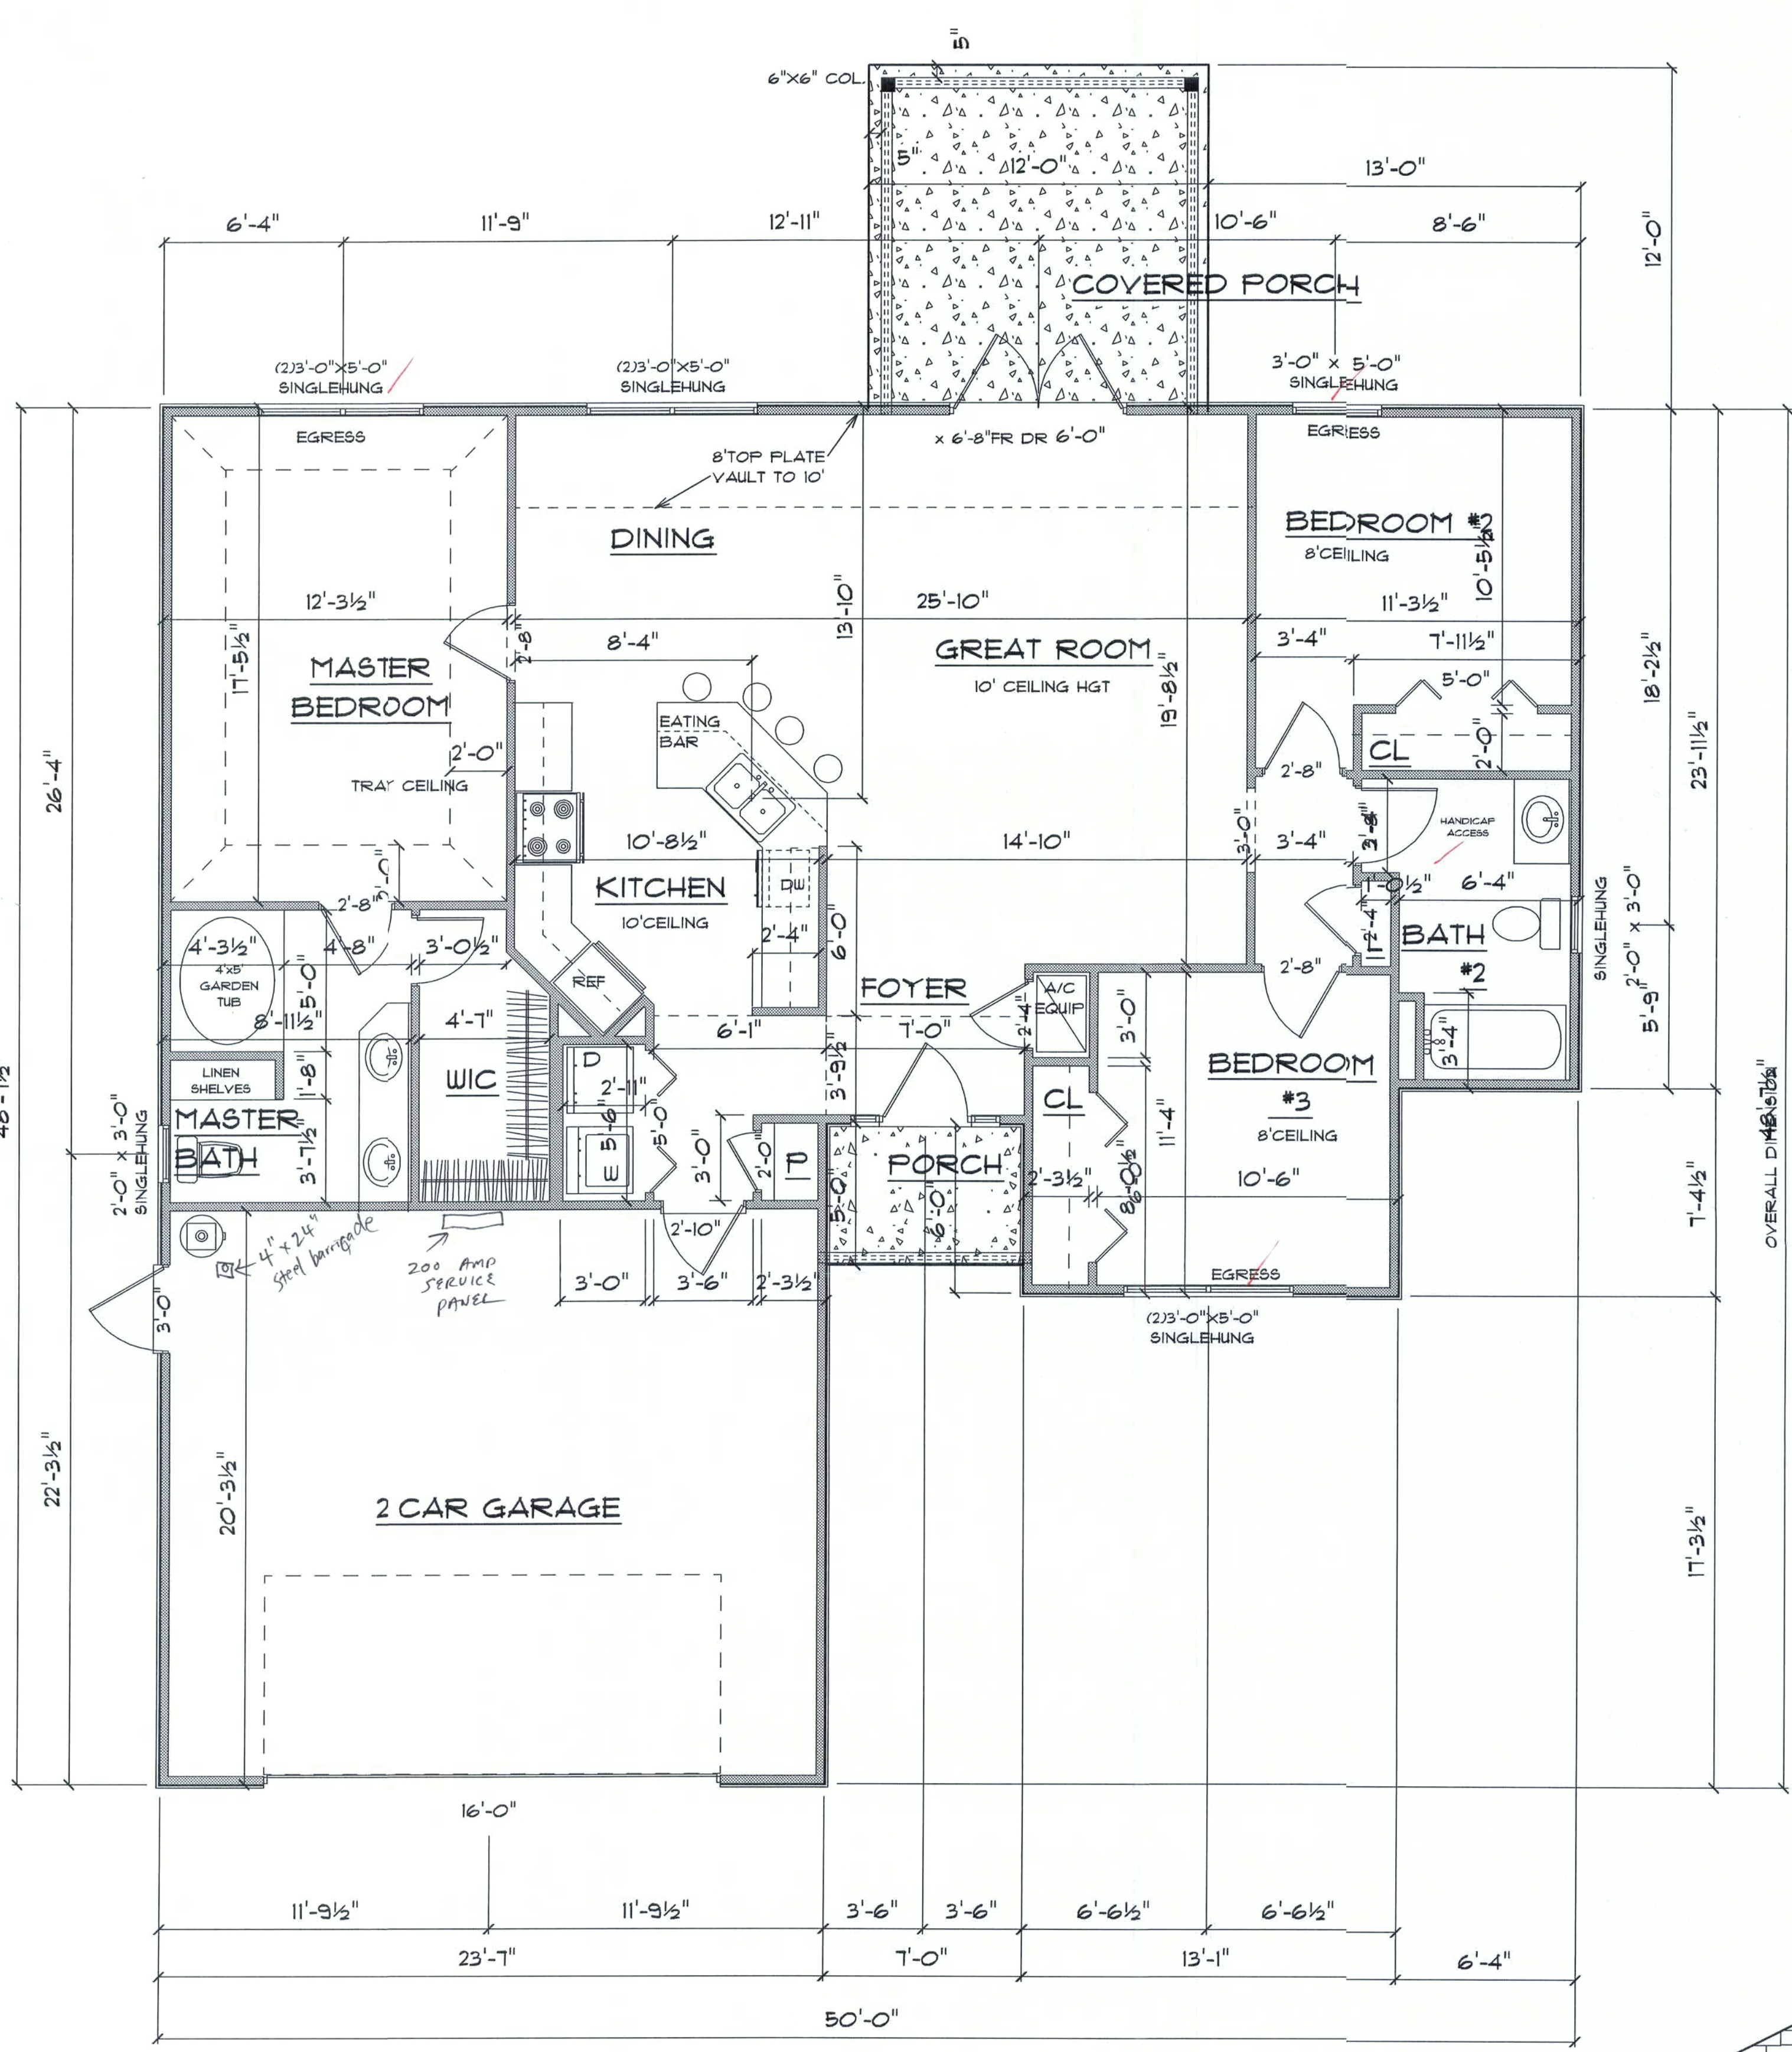

*** FLOOR PLAN ***

SCALE : 1/4" = 1'-0"


A/C LIVING AREA	= 1400 S.F.
FRONT PORCH	= 35 S.F.
2-CAR GARAGE	= 494 S.F.
TOTAL AREA UNDER ROOF = 1929 S.F.	

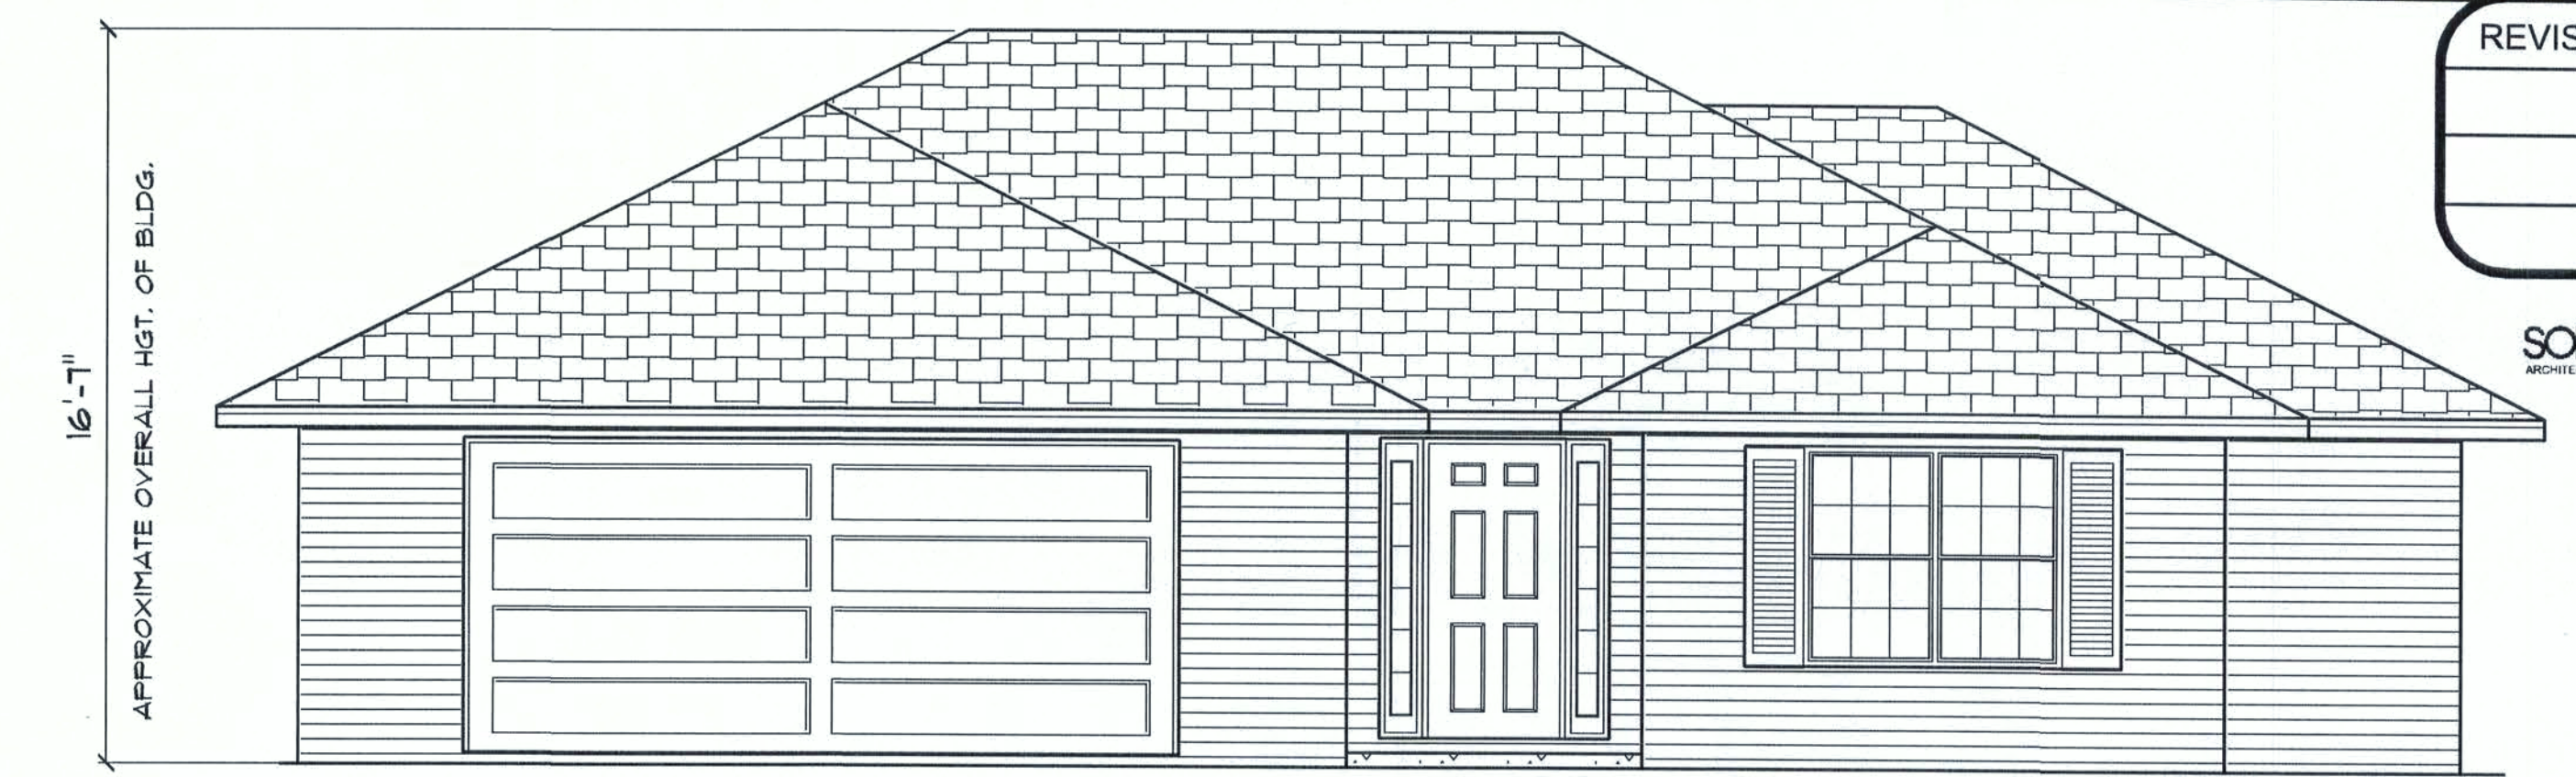

*** FRONT ELEVATION ***


SCALE : 1/4" = 1'-0"

NOTE: 24" OVERHANG ON EAVES
12" OVERHANG ON GABLE ENDS

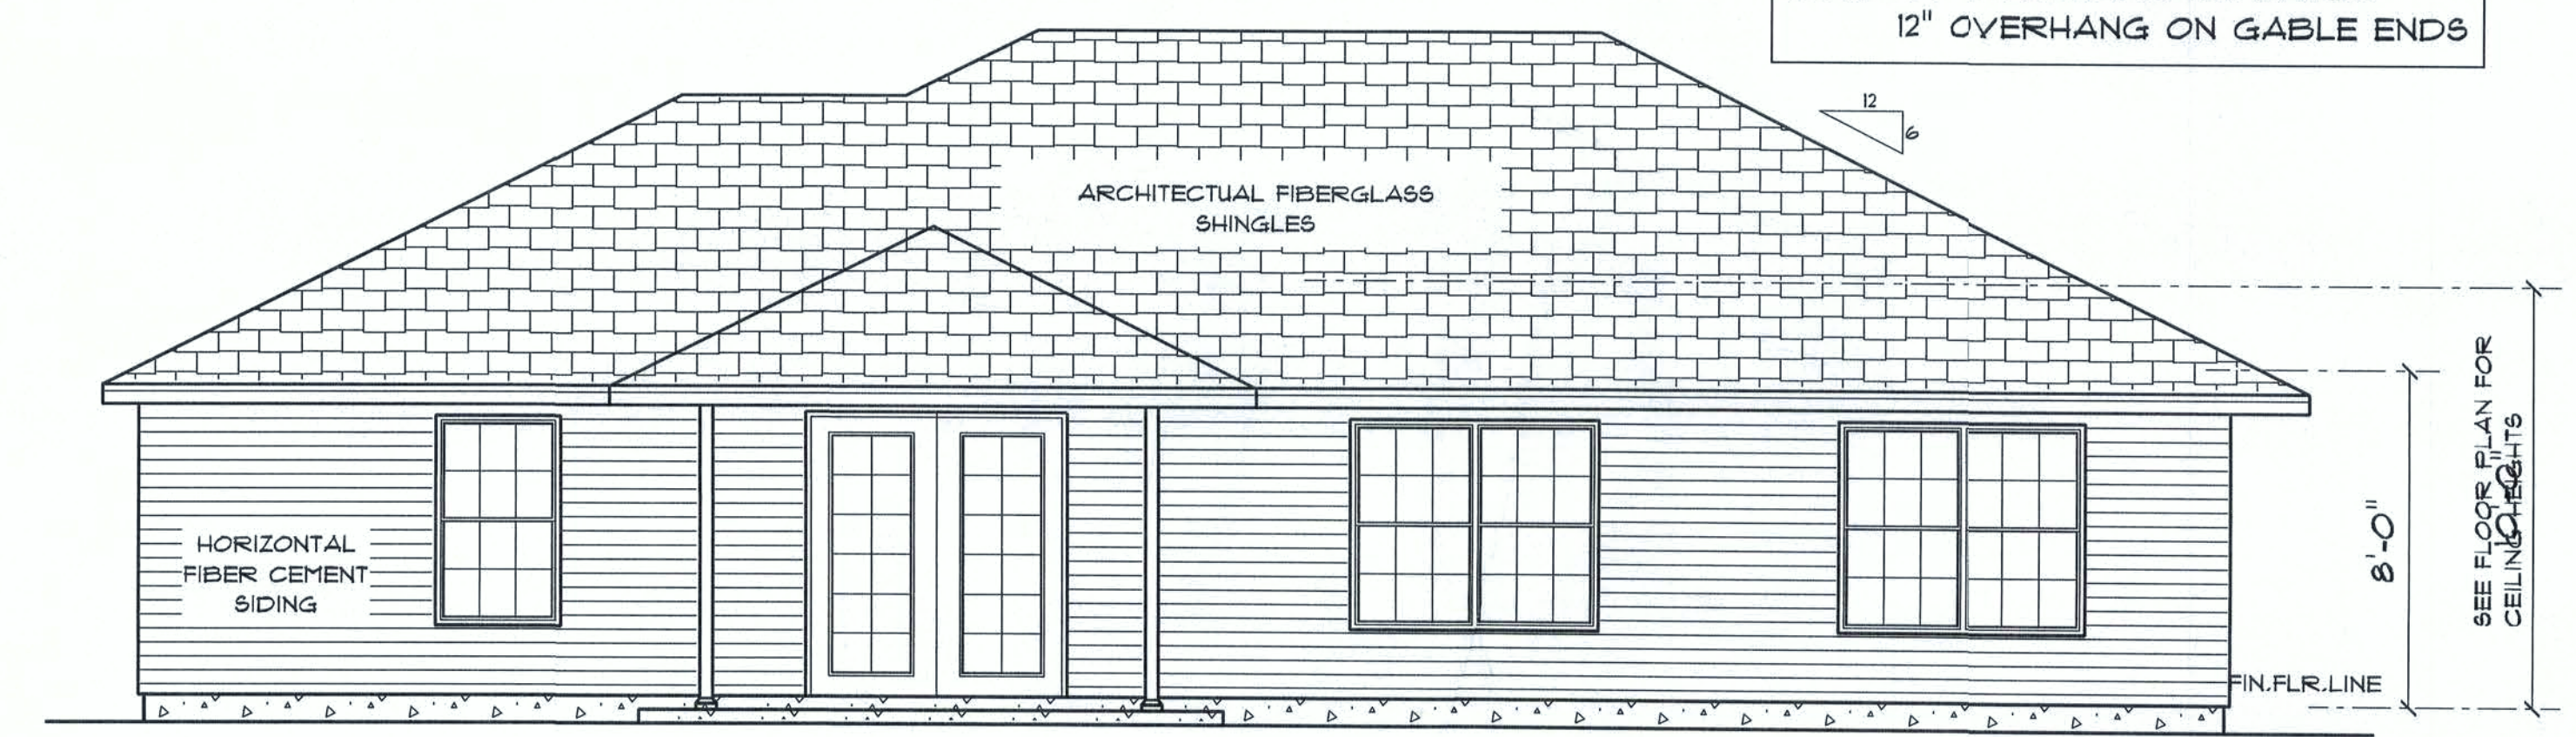


*** REAR ELEVATION ***

SCALE : 1/2" = 1'-0"

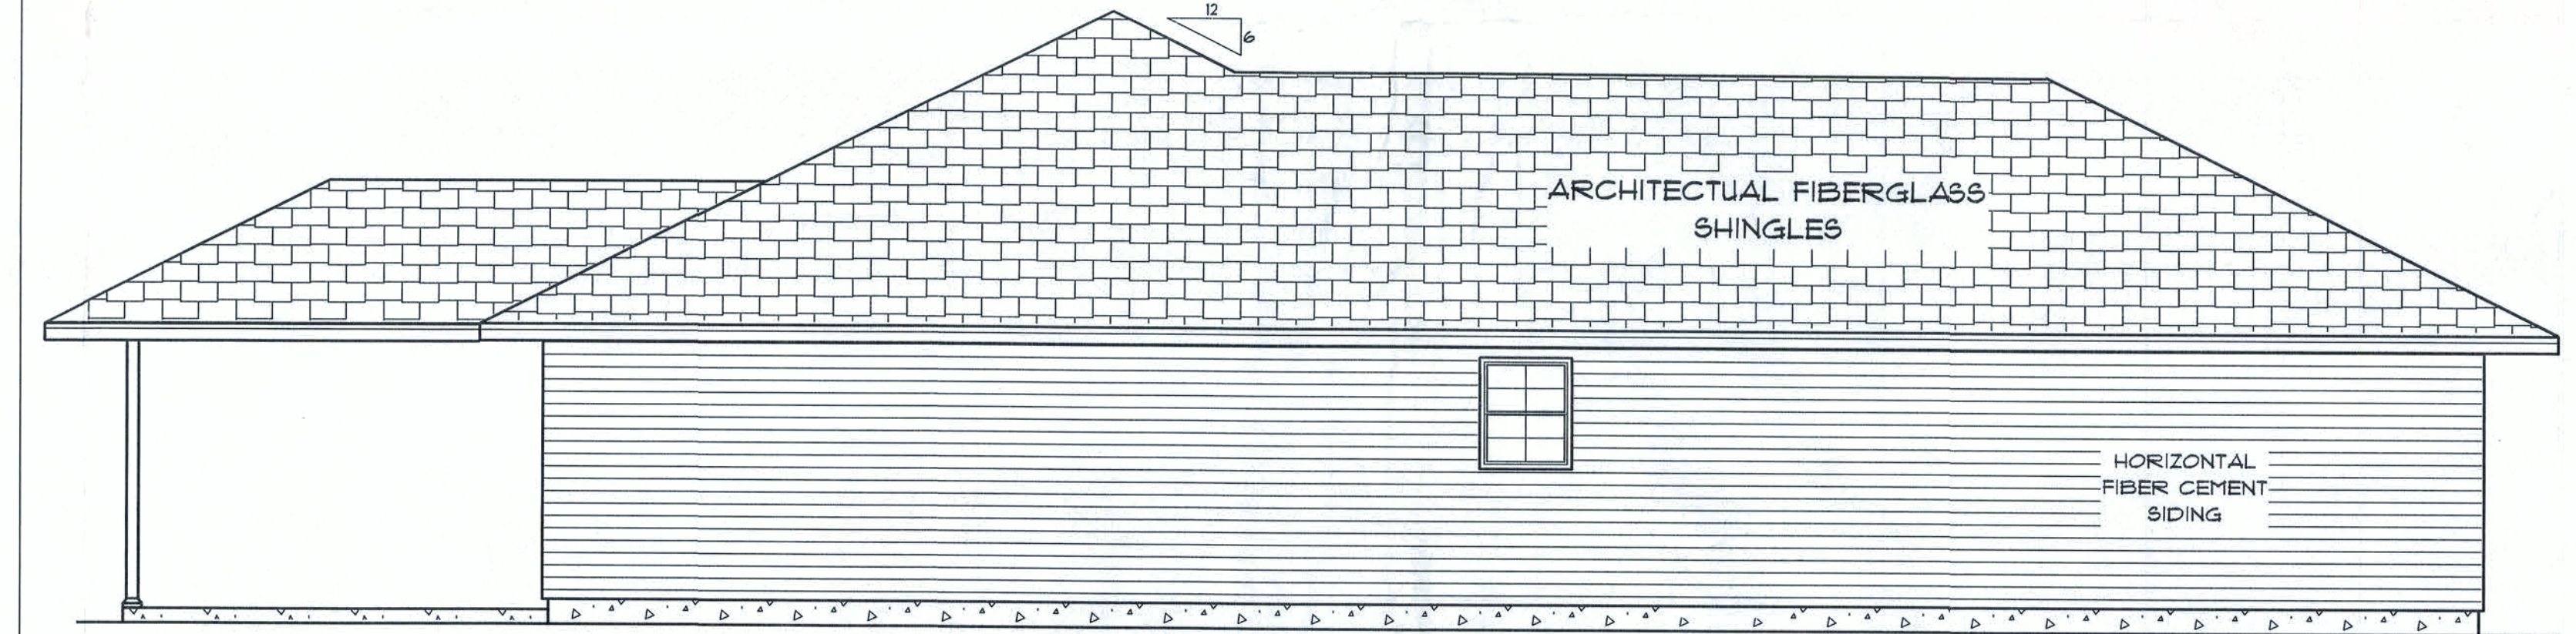

*** LEFT SIDE ELEVATION ***

SCALE : 1/2" = 1'-0"

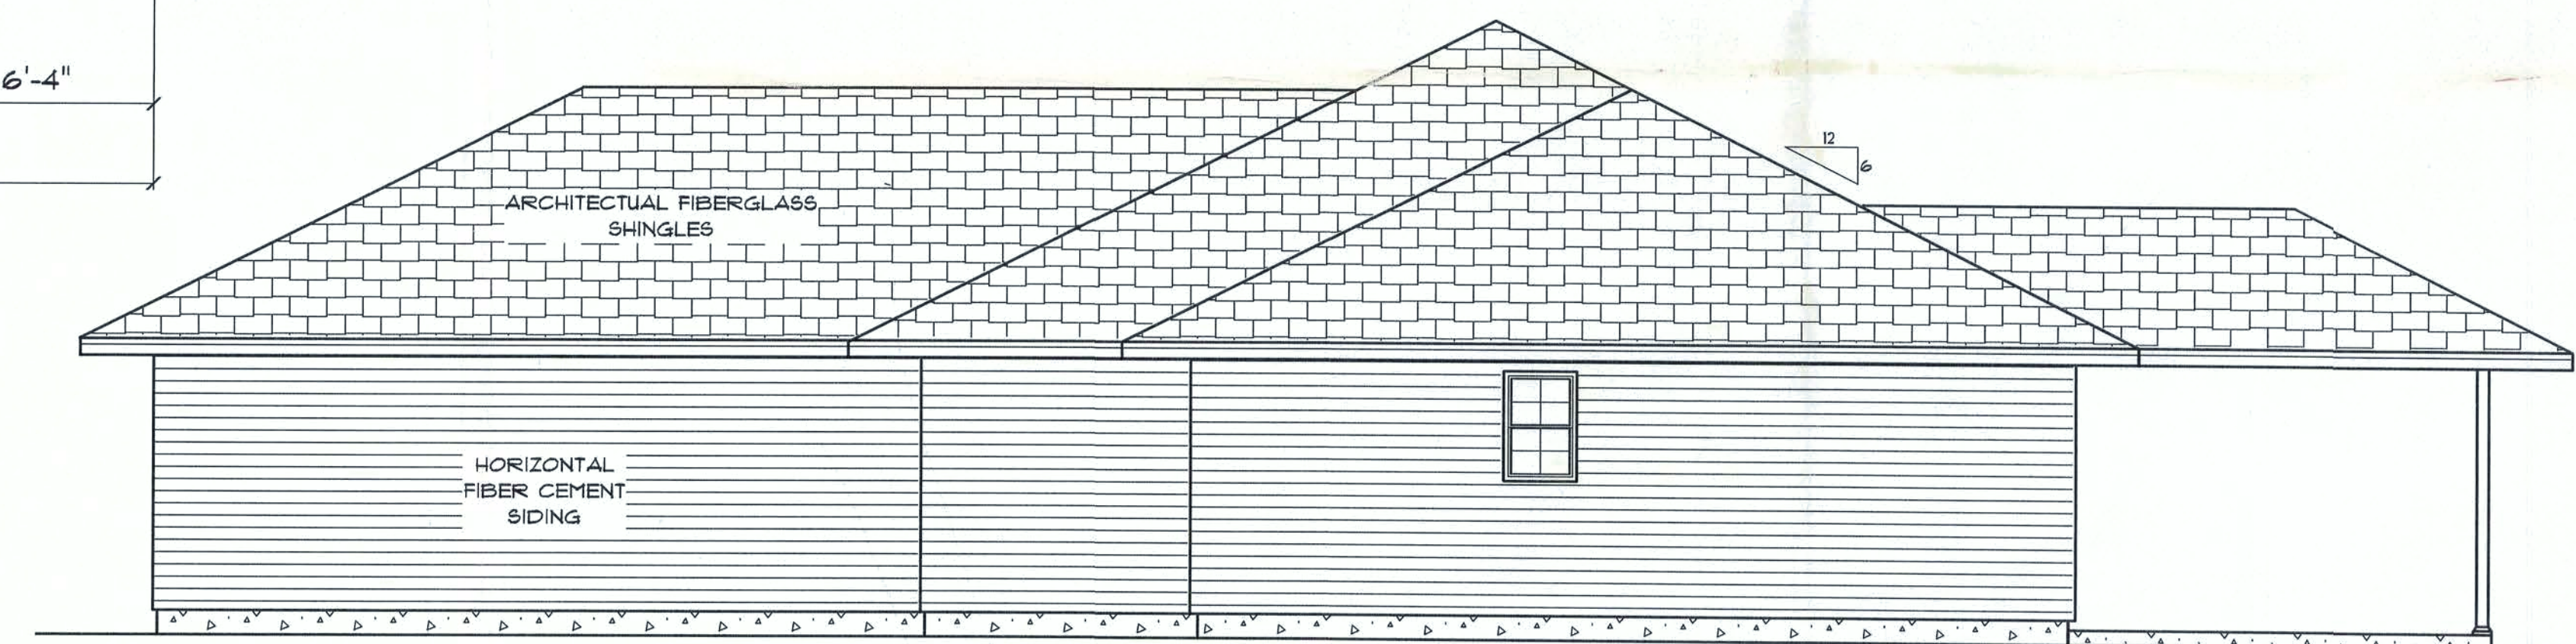

*** RIGHT SIDE ELEVATION ***

SCALE : 1/2" = 1'-0"

REVISIONS	

SOFTPLAN
ARCHITECTURAL DESIGN SOFTWARE

THE MATTHEW
LOT #14
CSE

LAKE CITY
FLORIDA

Teena M. Ruffo
251 NW Hall of Fame Dr.
Lake City, Florida 32055
Phone: (386) 755 - 9993
Cell: (386) 867 - 1191
Email: easystreet@tani.net

PRINTED DATE:
November 16, 2005

DRAWN BY: Teena M. Ruffo
CHECKED BY: Teena M. Ruffo

DESIGNED BY: Teena M. Ruffo

FINALS DATE:

JOB NUMBER:

DRAWING NUMBER
A-1

OF 2 SHEETS

OFFICE COPY

REVISIONS	


SOFTPLAN
ARCHITECTURAL DESIGN SOFTWARE

ELECTRICAL	COUNT	SYMBOL
ceiling fan	2	
Light	2	
automatic garage dr opener	1	
fluorescent lt fixture	1	
garage dr opener	1	
gfi waterproof outlet	2	
light	12	
outlet	25	
outlet 220v	3	
outlet gfi	12	
smoke detector	5	
switch	17	
switch 3 way	2	
vent light combo	2	


ELECTRICAL PLAN NOTES

- E-1 WIRE ALL APPLIANCES, HVAC UNITS AND OTHER EQUIPMENT PER MANUFACTURER'S SPECIFICATIONS.
- E-2 CONSULT THE OWNER FOR THE NUMBER OF SEPERATE TELEPHONE LINES TO BE INSTALLED.
- E-3 ALL INSTALLATIONS SHALL BE PER NATIONAL ELECTRIC CODE.
- E-4 ALL SMOKE DETECTORS SHALL BE 120V W/BATTERY BACKUP OF THE PHOTOELECTRIC TYPE, AND SHALL BE INTERLOCKED TOGETHER. INSTALL INSIDE AND NEAR ALL BEDROOMS.
- E-5 TELEPHONE, TELEVISION AND OTHER LOW VOLTAGE DEVICES OR OUTLETS SHALL BE AS PER THE OWNERS DIRECTION AND IN ACCORDANCE WITH APPLICABLE SECTIONS OF NATIONAL ELCT. CODE LATEST EDITION.
- E-6 ELECTRICAL CONTRACTOR SHALL BE RESPONSIBLE FOR THE DESIGN AND SIZING OF ELECTRICAL SERVICE AND CIRCUITS.
- E-8 ENTRY OF SERVICE UNDERGROUND OR OVERHEAD) IS TO BE DETERMINED BY THE POWER COMPANY.

ALL BEDROOM RECEPTALS ARE TO BE AFCI (ARC FAULT CIRCUIT INTERRUPT)

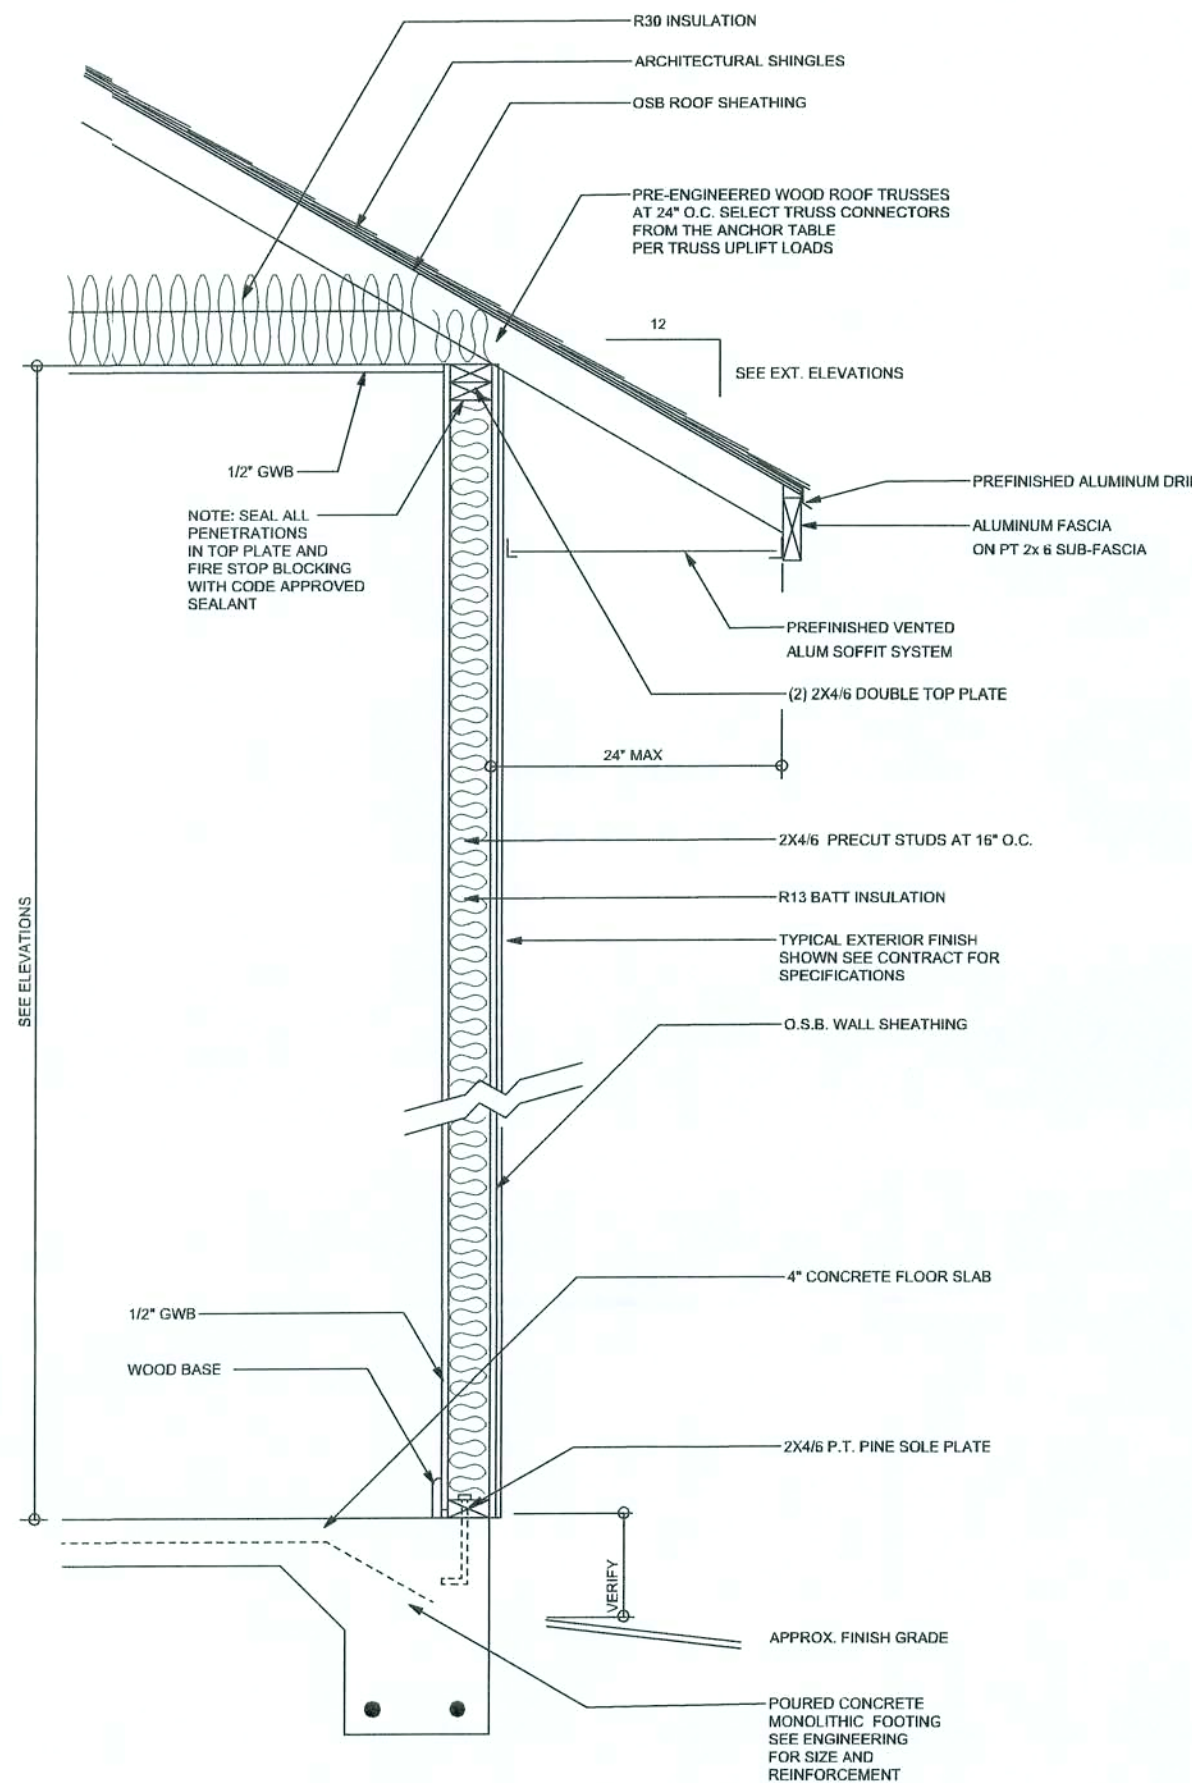

TYPICAL DESIGN WALL SECTION
NON - STRUCTURAL DATA
SCALE 1\"/>

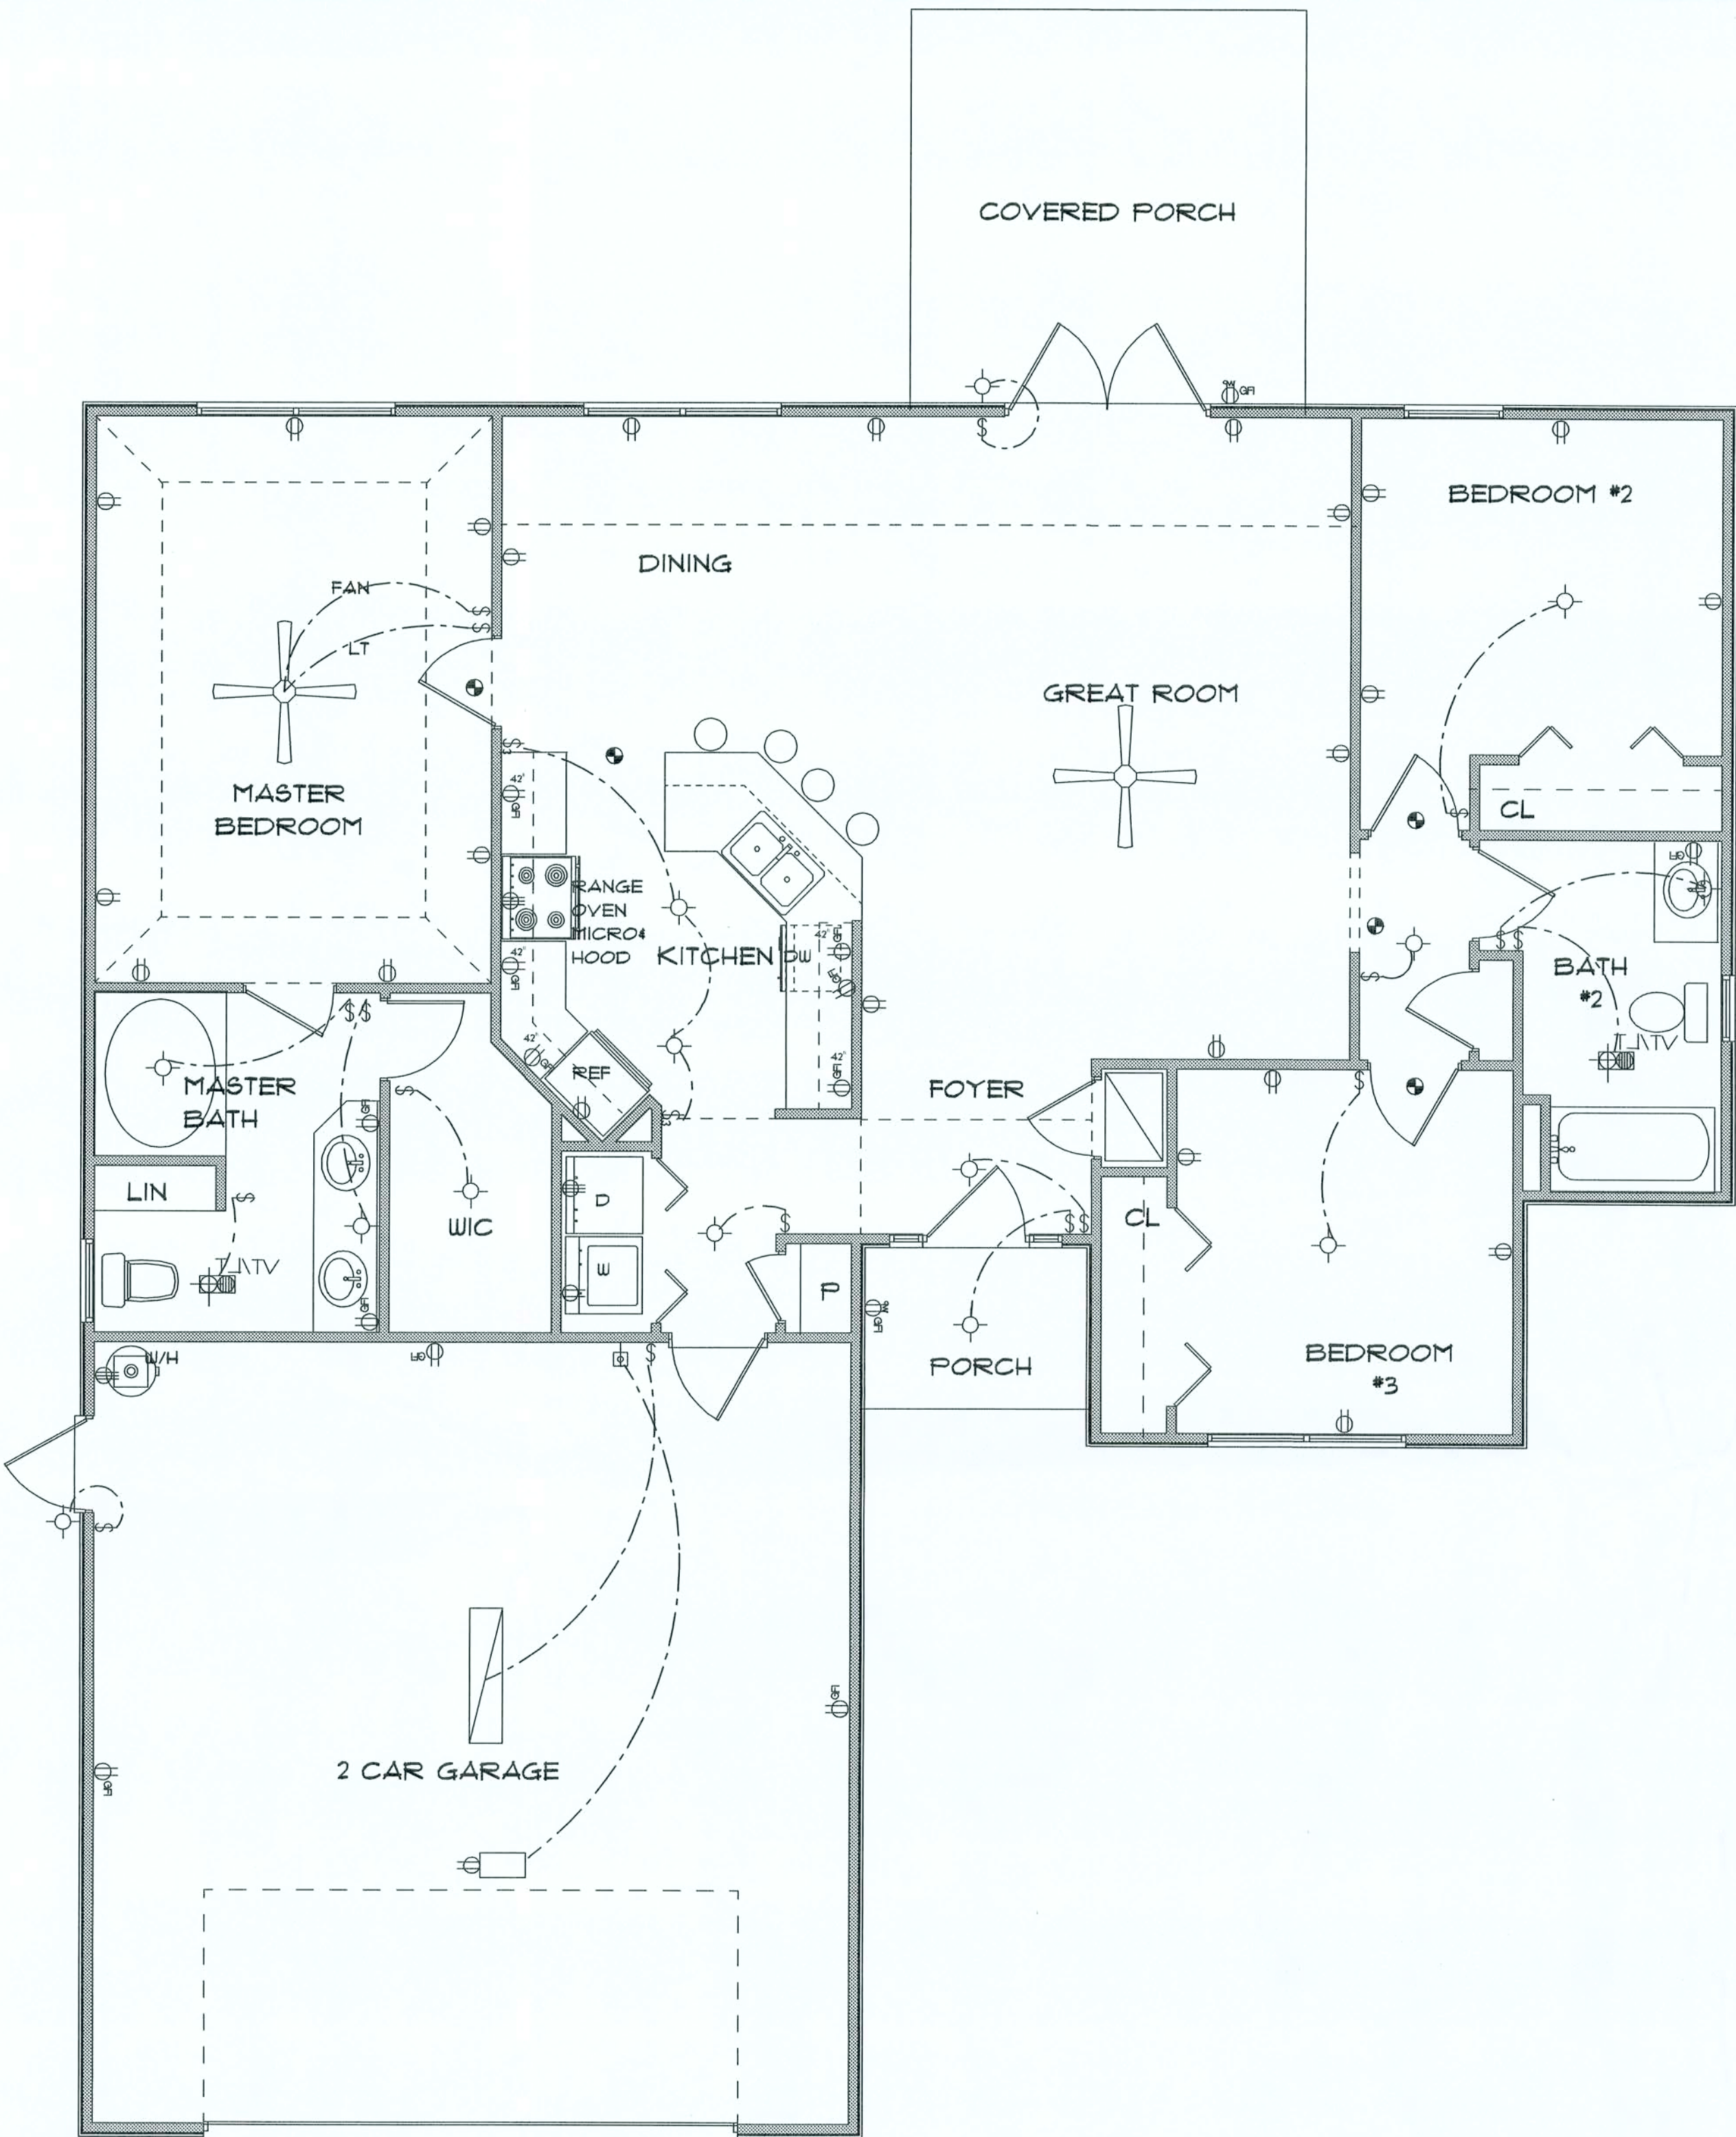

* ELECTRICAL PLAN *

SCALE : 1/4" = 1'-0"

THE MATTHEW
LOT #14
C&E

LAKE CITY
FLORIDA

Teena M. Ruffo
251 NW Hall of Fame Dr.
Lake City, Florida 32055
Phone: (386) 755 - 9993
Cell: (386) 867 - 1191
Email: teenasruffo@aol.net

PRINTED DATE:
November 16, 2005

DRAWN BY: Teena M. Ruffo

CHECKED BY:

DESIGNED BY:

Teena M. Ruffo

FINALS DATE:

JOB NUMBER:


DRAWING NUMBER

A-2

OF 2 SHEETS

REVISIONS	


SOFTPLAN
ARCHITECTURAL DESIGN SOFTWARE

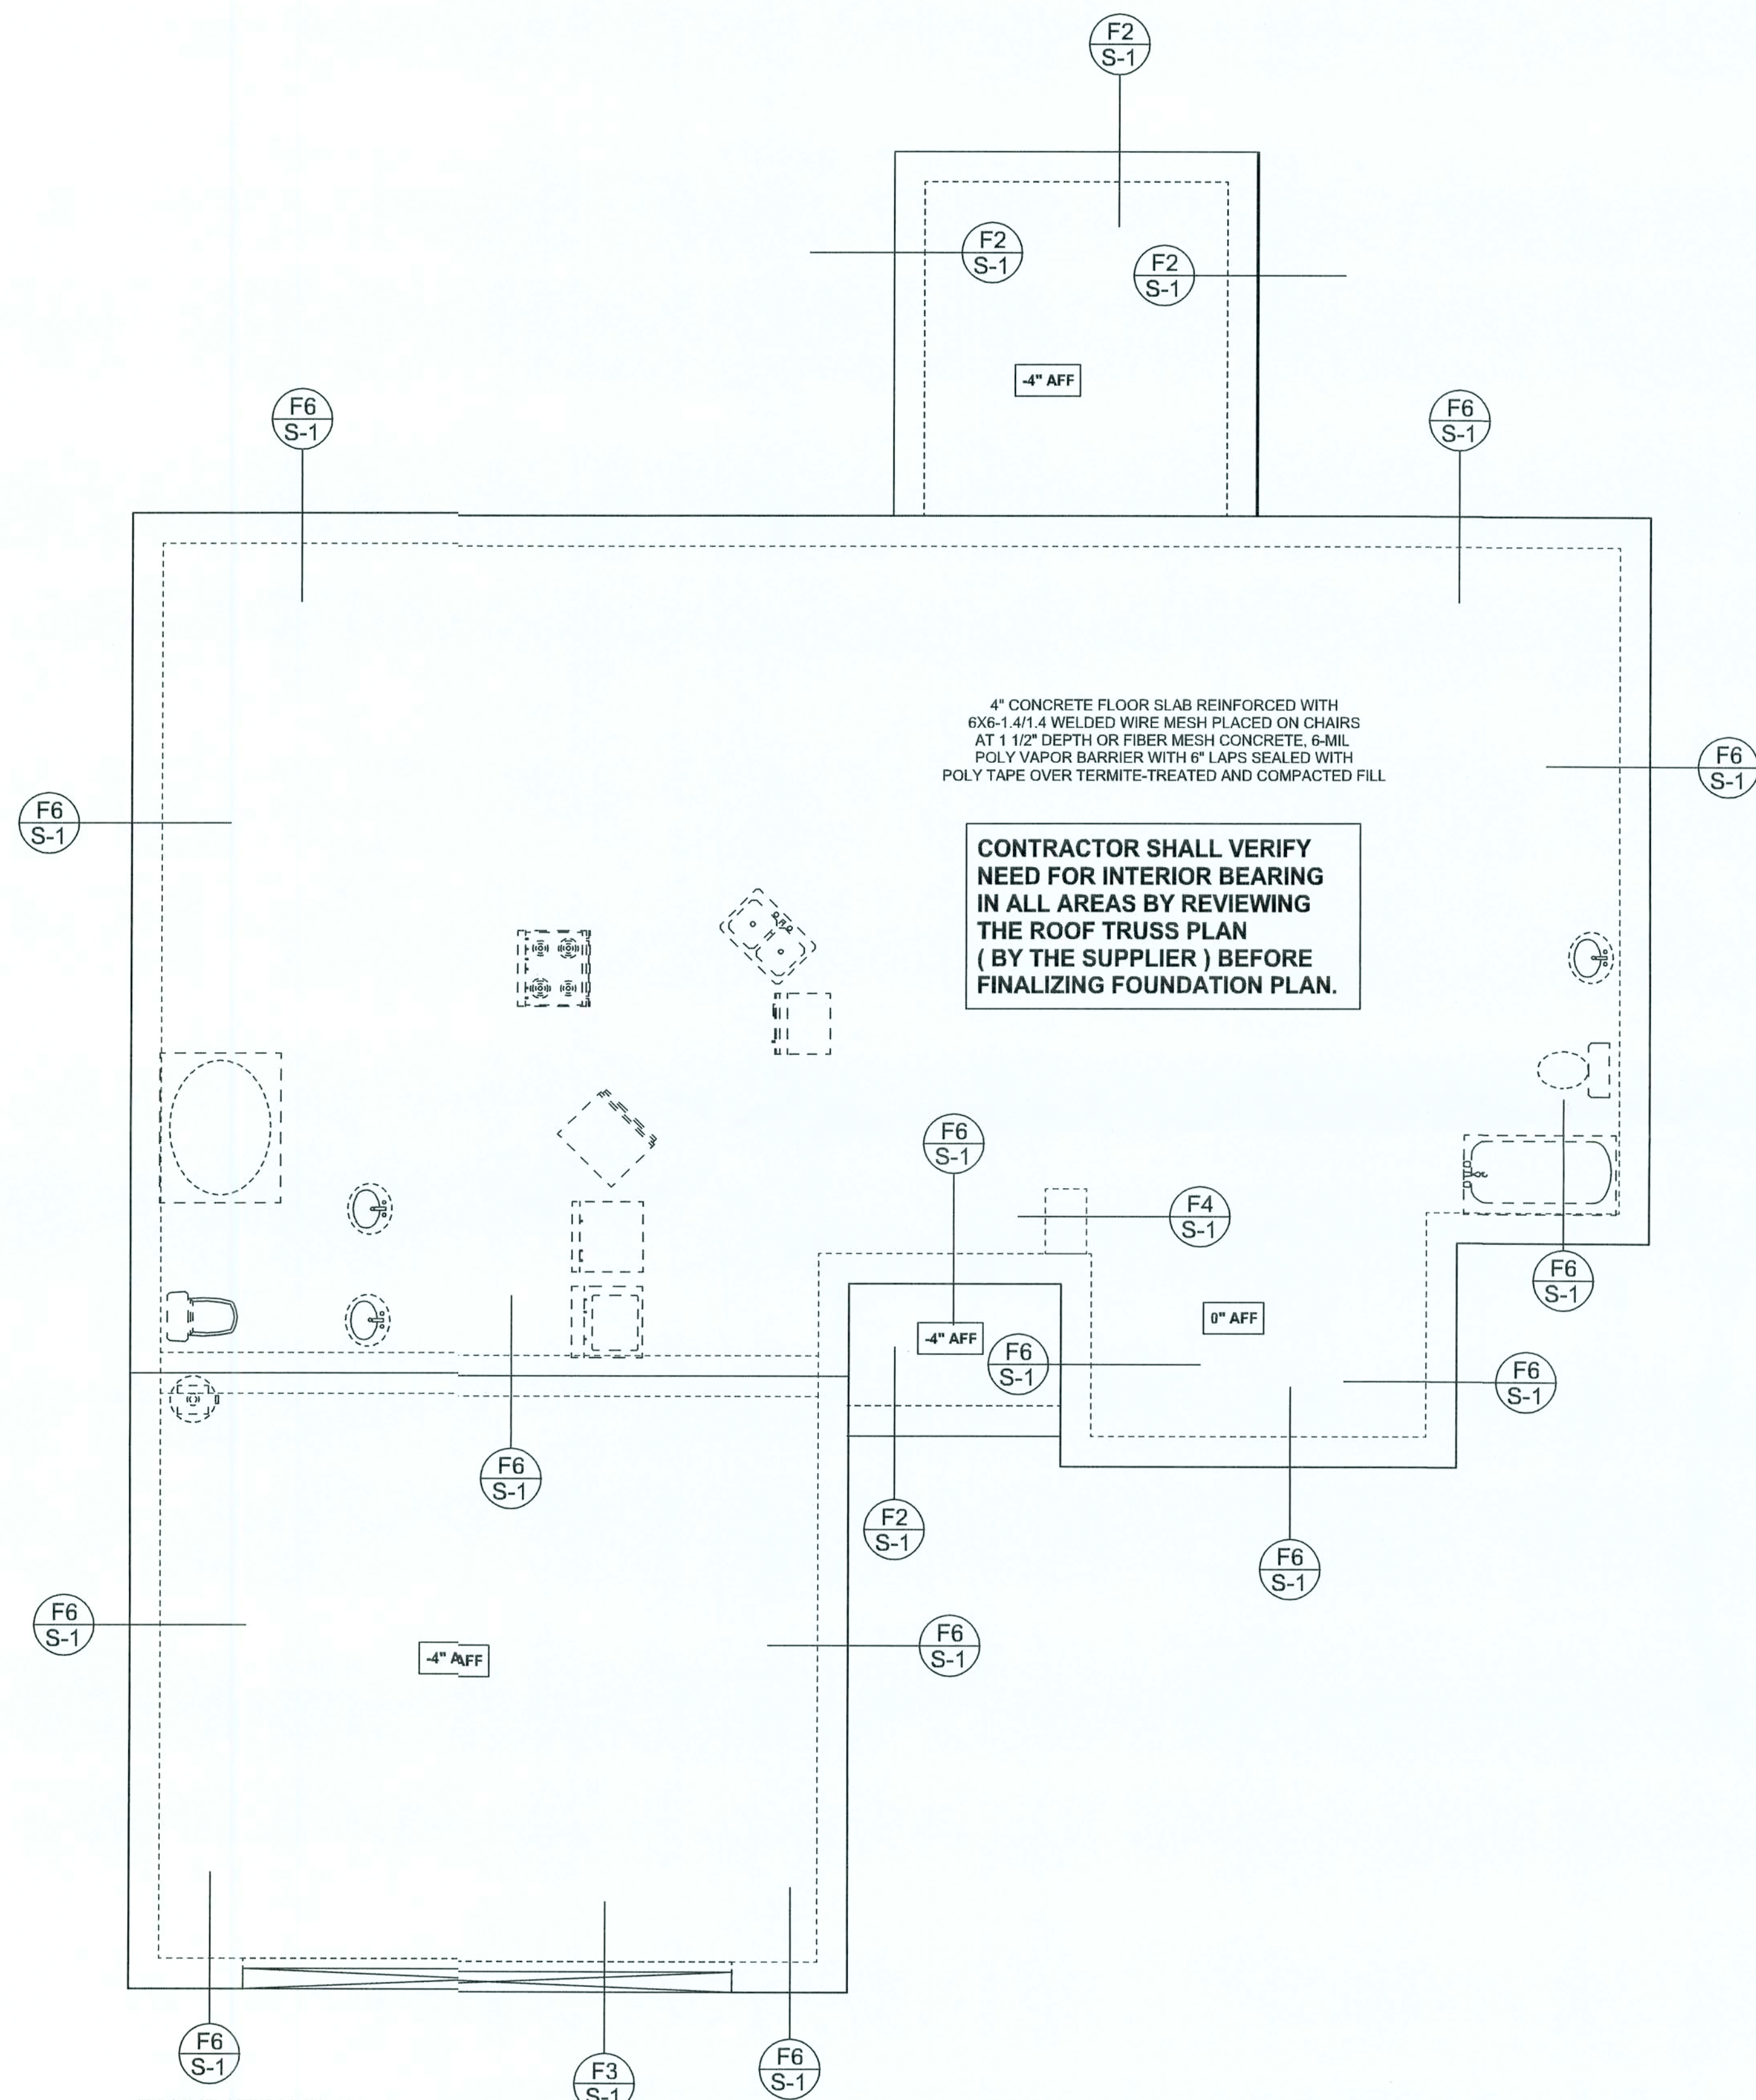

FOUNDATION PLAN

SCALE: 1/4" = 1'-0"

DIMENSIONS ON STRUCTURAL SHEETS
ARE NOT EXACT. REFER TO ARCHITECTURAL
FLOOR PLAN FOR ACTUAL DIMENSIONS

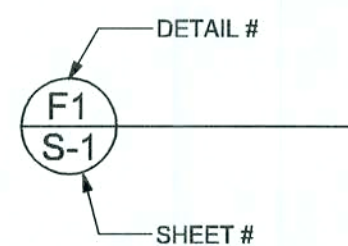

WINDLOAD ENGINEER: Mark Disosway,
P.E. No. 53915, PCB 868, Lake City, FL
32056, 386-754-5419

DIMENSIONS:
Stated dimensions supersede scaled
dimensions. Refer all questions to
Mark Disosway, P.E. for resolution.
Do not proceed without clarification.

COPYRIGHTS AND PROPERTY RIGHTS:
Mark Disosway, P.E. hereby expressly reserves
his common law copyrights and property right in
these instruments of service. This document is
not to be reproduced, altered or copied in any
form or manner without first the express written
permission and consent of Mark Disosway.

CERTIFICATION: These plans and
"Windload Engineering", Sheet S-1, attached,
comply with Florida Building Code 2004,
Section 1609 wind loads, to the best of my
knowledge.

LIMITATION: This design is valid for one
building at specified location. In case of conflict,
structural requirements, scope of work, and
builder responsibilities on sheet S-1 control.

MARK DISOSWAY
P.E. 53915

Mark Disosway
16 NOV 05

SEAL

Cornerstone Development

The Matthew Model

ADDRESS:
Lot #14, Country Side Estates S/D
Lake City, Florida

Mark Disosway P.E.
P.O. Box 868
Lake City, Florida 32056
Phone: (386) 754 - 5419
Fax: (386) 754 - 6749
Email: mdpe@bellsouth.net

PRINTED DATE:
November 16, 2005

DRAWN BY: Evan Beamsley

CHECKED BY:

JOB NUMBER:
511102

DRAWING NUMBER

S-2
OF 2 SHEETS