


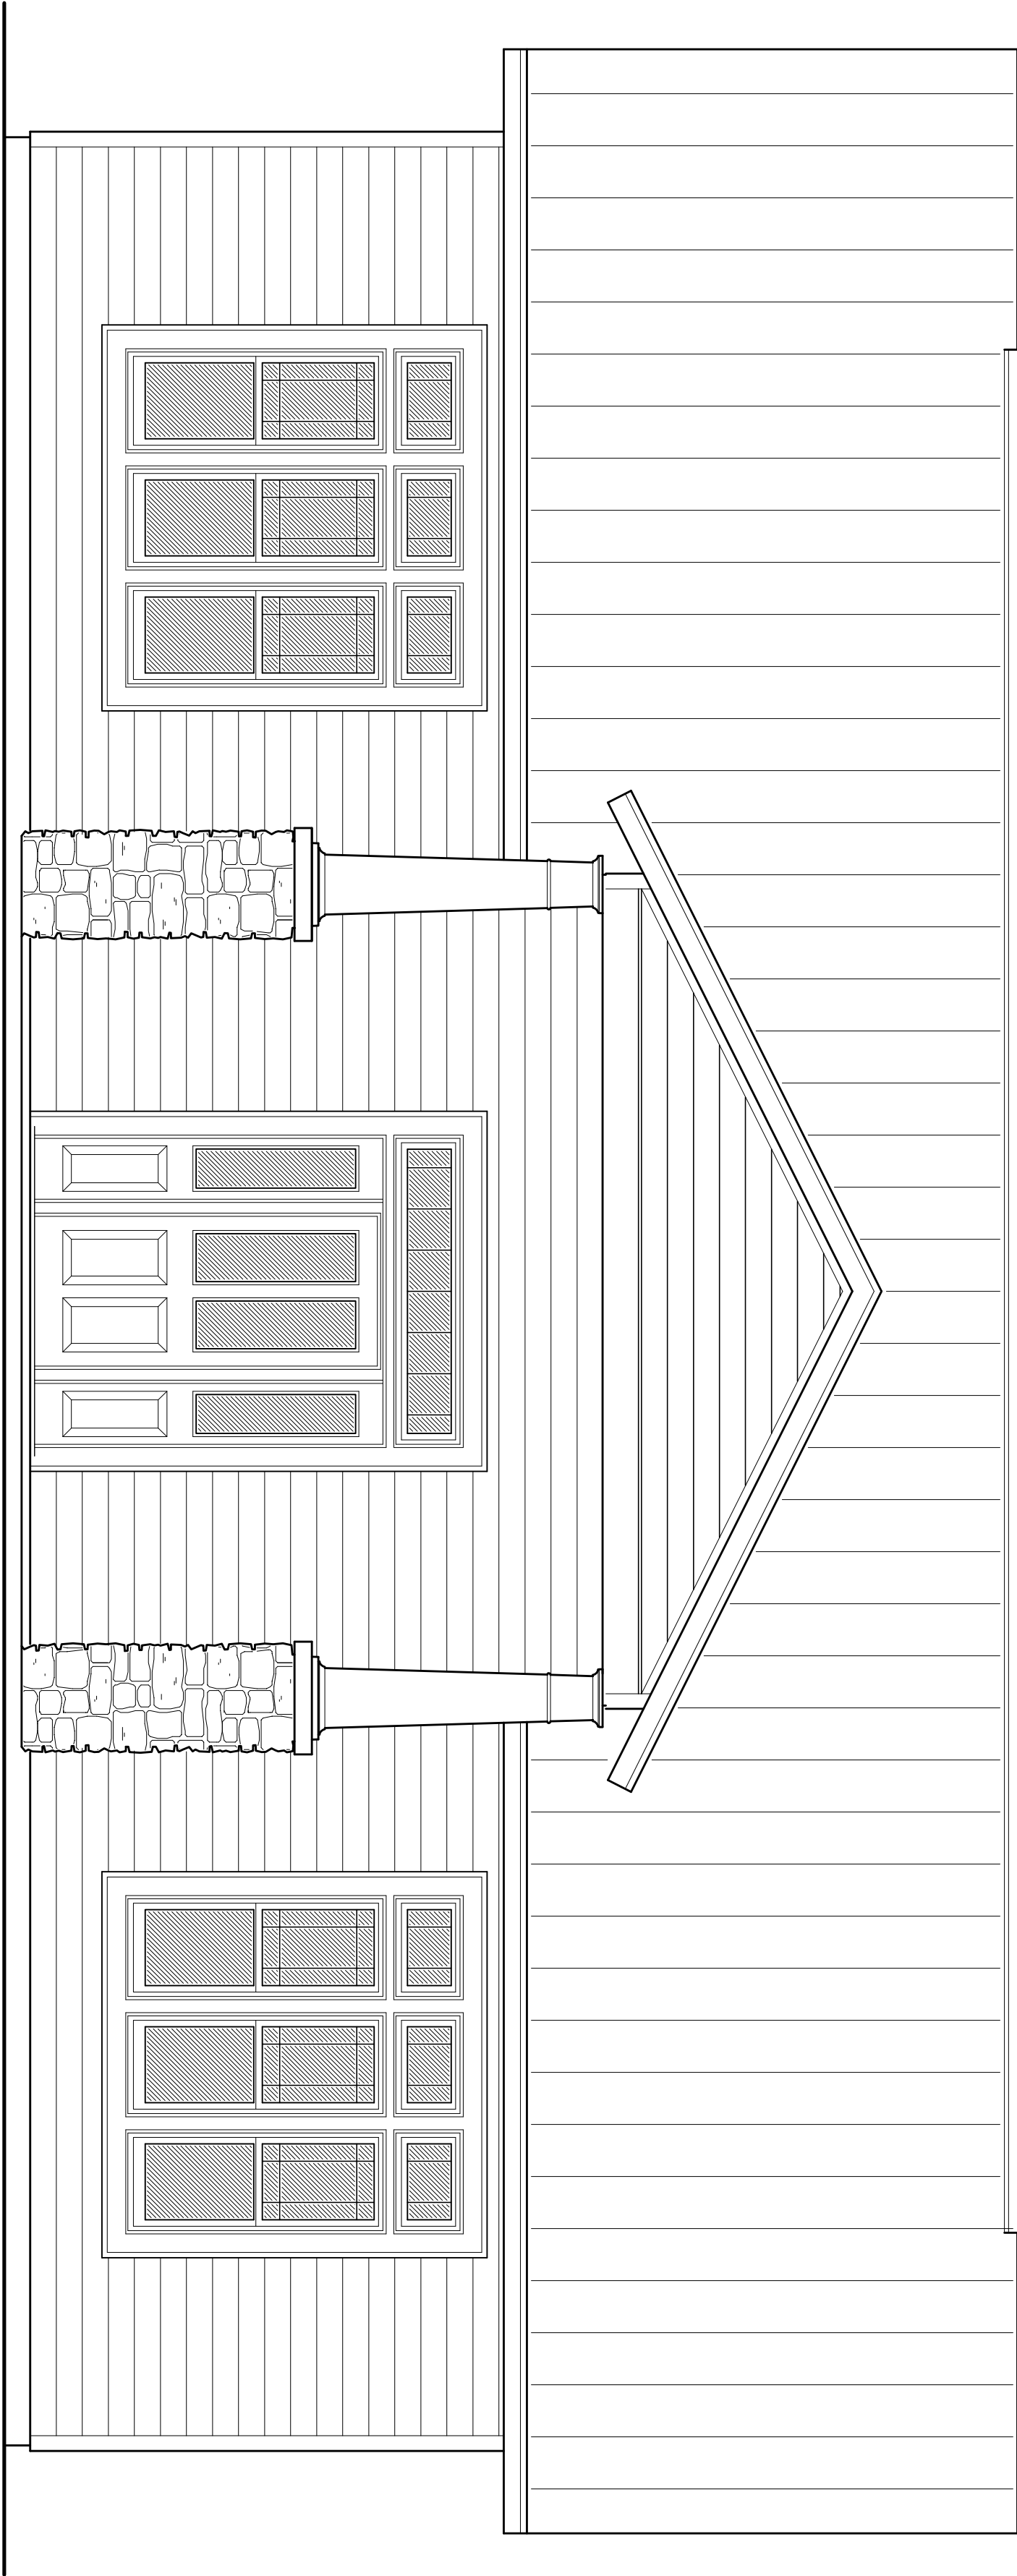

New Office Facilities for:

Kyle McLeod

Lake City, Florida

Drawing Index

COVER SHEET, DRAWING INDEX	
CS.I	LIFE SAFETY PLAN
G.I	GENERAL CONSTRUCTION NOTES
A.I	BUILDING ELEVATIONS
A.2	FLOOR PLANS, ELECTRICAL DATA
A.3	ARCHITECTURAL DETAILS / HVAC PLAN
A.4	GENERAL STRUCTURAL INFORMATION
A.5	FOUNDATION PLAN & DETAILS
A.6	ROOF PLAN & DETAILS
A.7	WALL SECTION & FRAMING DETAILS

REVISION:


Copyright 2023
N.P. Geisler, Architect

DRAWN:

128

NEW OFFICE for:
KYLE McLEOD
LAKE CITY, FLORIDA
COVER SHEET

Celebrating
51 Years of Service
1972 - 2023
N.P. Geisler, Architect
AR0007005

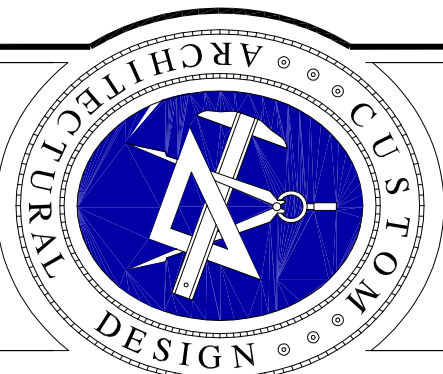

NICHOLAS
GAULER
ARCHITECT

1728 NW Broward
Ave., Suite 350
Fort Lauderdale, FL 33305

DATE:

16 NOV 2023

CODE:

2K2336

SHEET:

CS.I

1 of 1

N. P.
GEISLER

Digitally signed by: N. P. Geisler
DN: CN = N. P. Geisler
C = US, O = AR0007005
OU = ARCHITECT
Date: 2023.11.21 17:06:
45 -05'00'

AR0007005