



FRONT ELEVATION
SCALE: 1/4" = 1'-0"

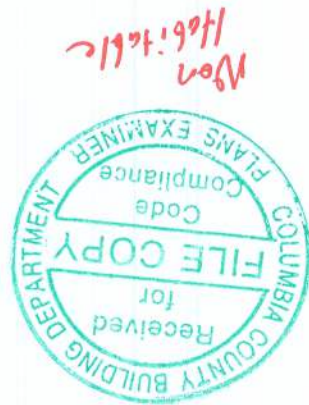

REAR ELEVATION
SCALE: 1/4" = 1'-0"

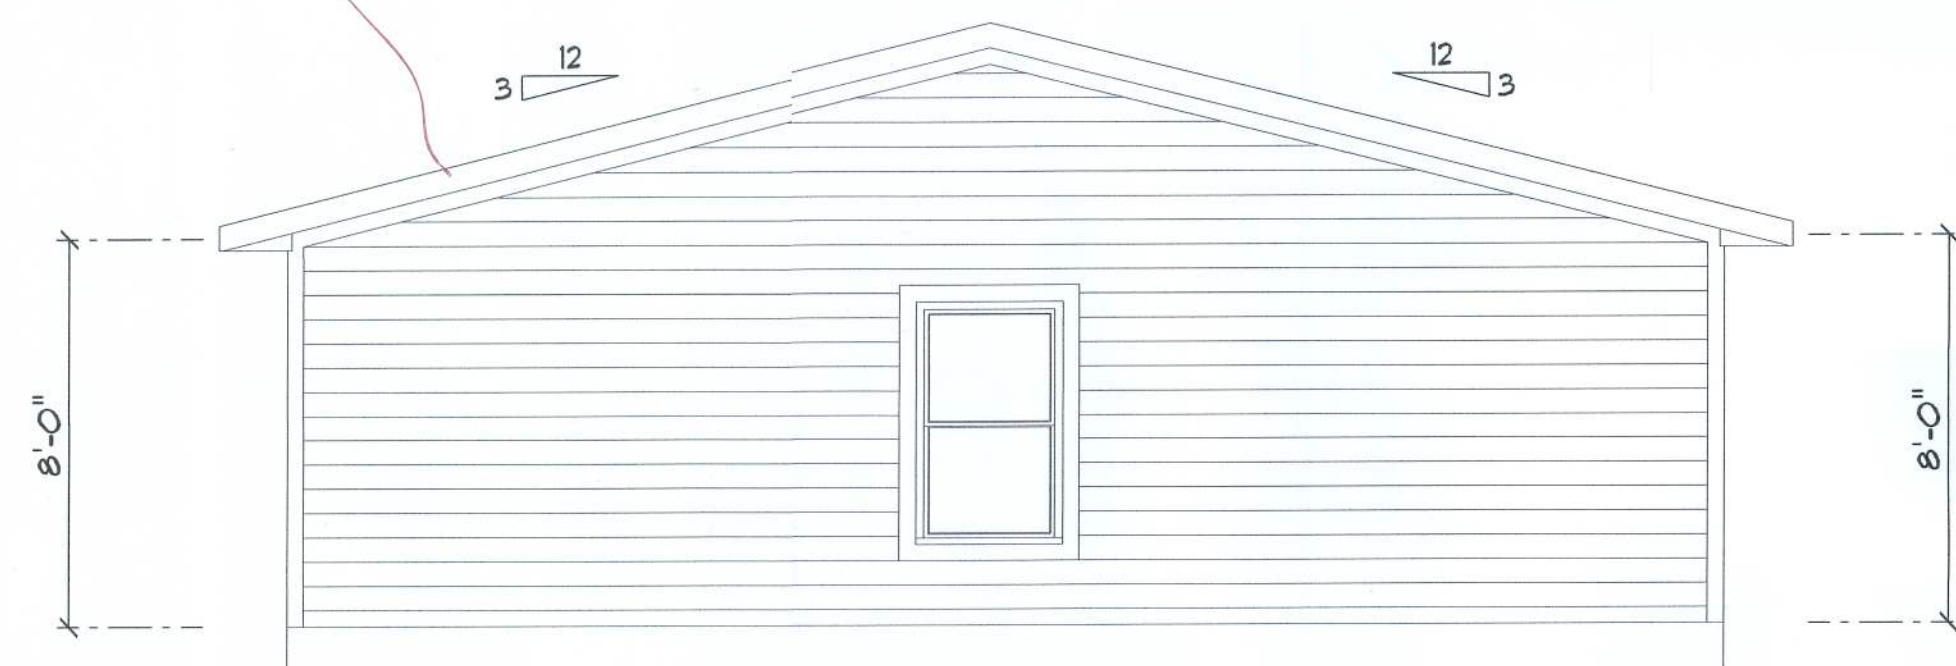

RIGHT ELEVATION
SCALE: 1/4" = 1'-0"




LEFT ELEVATION
SCALE: 1/4" = 1'-0"

REVISIONS SCHEDULE	
Aug. 17th, 2021	PROPOSAL


COLLAR BARN PROJECT

359 SE Seawolf Way, High Springs, FL 32643

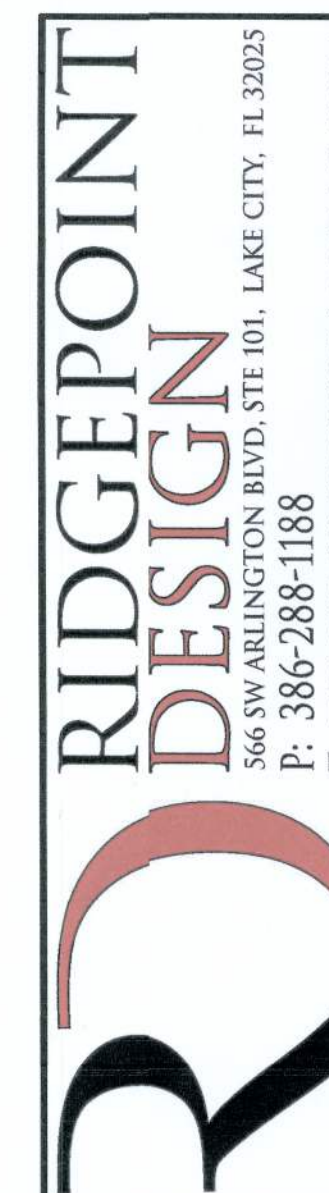

SHEET NUMBER
A.1
OF 3 SHEETS

50411

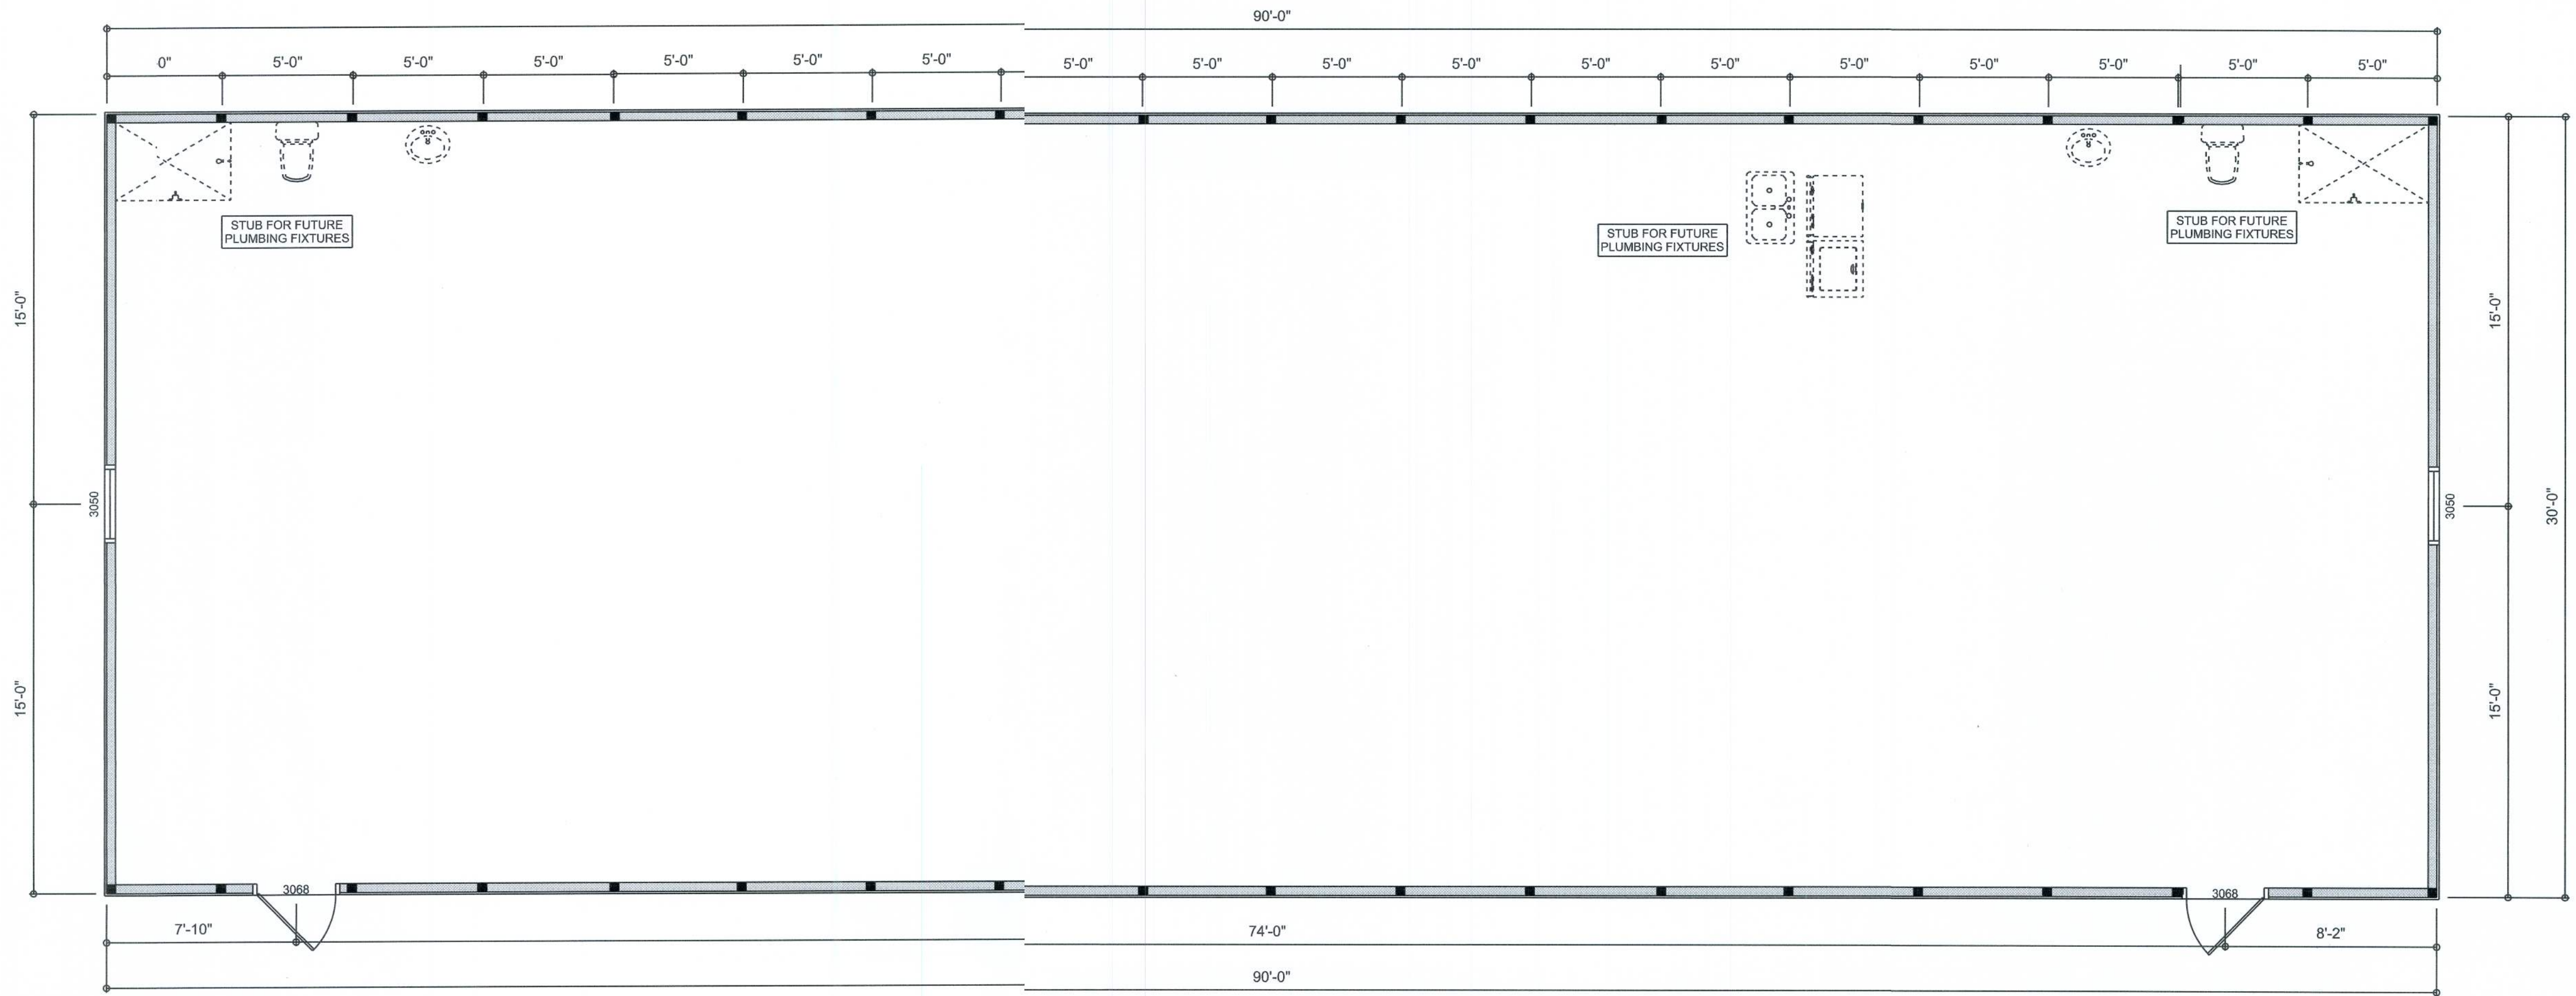

DIMENSIONED FLOOR PLAN
SCALE: 1/4" = 1'-0"

AREA SUMMARY	
UNDER ROOF AREA	2,700 S.F.
TOTAL UNDER ROOF	2,700 S.F.

ELECTRICAL LEGEND		
ELECTRICAL	COUNT	SYMBOL
fluorescent light 2 x 4	5	
MOTION SECURITY LIGHT	4	
OUTLET	13	
SWITCH 3 WAY	4	

ELECTRICAL PLAN NOTES:

INSTALLATION SHALL BE PER LATEST NAT'L. ELECTRIC CODE.

WIRE ALL APPLIANCES, HVAC UNITS AND OTHER EQUIPMENT PER MANUF. SPECIFICATIONS

CONSULT WITH THE OWNER FOR THE NUMBER OF SEPERATE TELEPHONE LINES TO BE INSTALLED

ALL SMOKE DETECTORS SHALL BE 120v W/ BATTERY BACKUP OF THE PHOTOELECTRIC TYPE, AND SHALL BE INTERLOCKED TOGETHER. INSTALL INSIDE AND NEAR ALL BEDROOMS


TELEPHONE, TELEVISION AND OTHER LOW VOLTAGE DEVICES OR OUTLETS SHALL BE AS PER THE OWNER'S DIRECTIONS, & IN ACCORDANCE W/ APPLICABLE SECTIONS OF NEC-LATEST EDITION.

ALL RECEPTICALS, NOT OTHERWISE NOTED, SHALL BE ARC FAULT INTERRUPTER TYPE, EXCEPT DEDICATED OUTLETS

ALL RECEPTICALS IN WET AREAS SHALL BE GROUND FAULT INTERRUPTER TYPE (GFI)

ALL EXTERIOR RECEPTICALS SHALL BE WEATHERPROOF GROUND FAULT INTERRUPTER TYPE (WPGFI)

NOTE:
ELECTRICAL CONTR SHALL PREPARE "AS-BUILT" SHOP DWGS INDICATING ALL ELECTRICAL WORK, INCLUDING ANY CHANGES TO THE ELEC. PLAN, ADDNS TO THE ELEC. PLAN, RISER DIAGRAM, AS-BUILT PANEL SCHEDULE W/ ALL CKTS IDENTIFIED W/ CKT N: DESCRIPTION & BRKR, SERVICE ENT, & ALL UNDERGROUND WIRE LOCATIONS/ROUTING / DEPTH. RISER DIA. SHALL INCLUDE WIRE SIZES/TYPE & EQUIPMENT TYPE W/ RATINGS & LOADS.
CONTRACTOR SHALL PROVIDE 1 COPY OF AS-BUILT DWGS TO OWNER & 1 COPY TO THE PERMIT ISSUING AUTHORITY

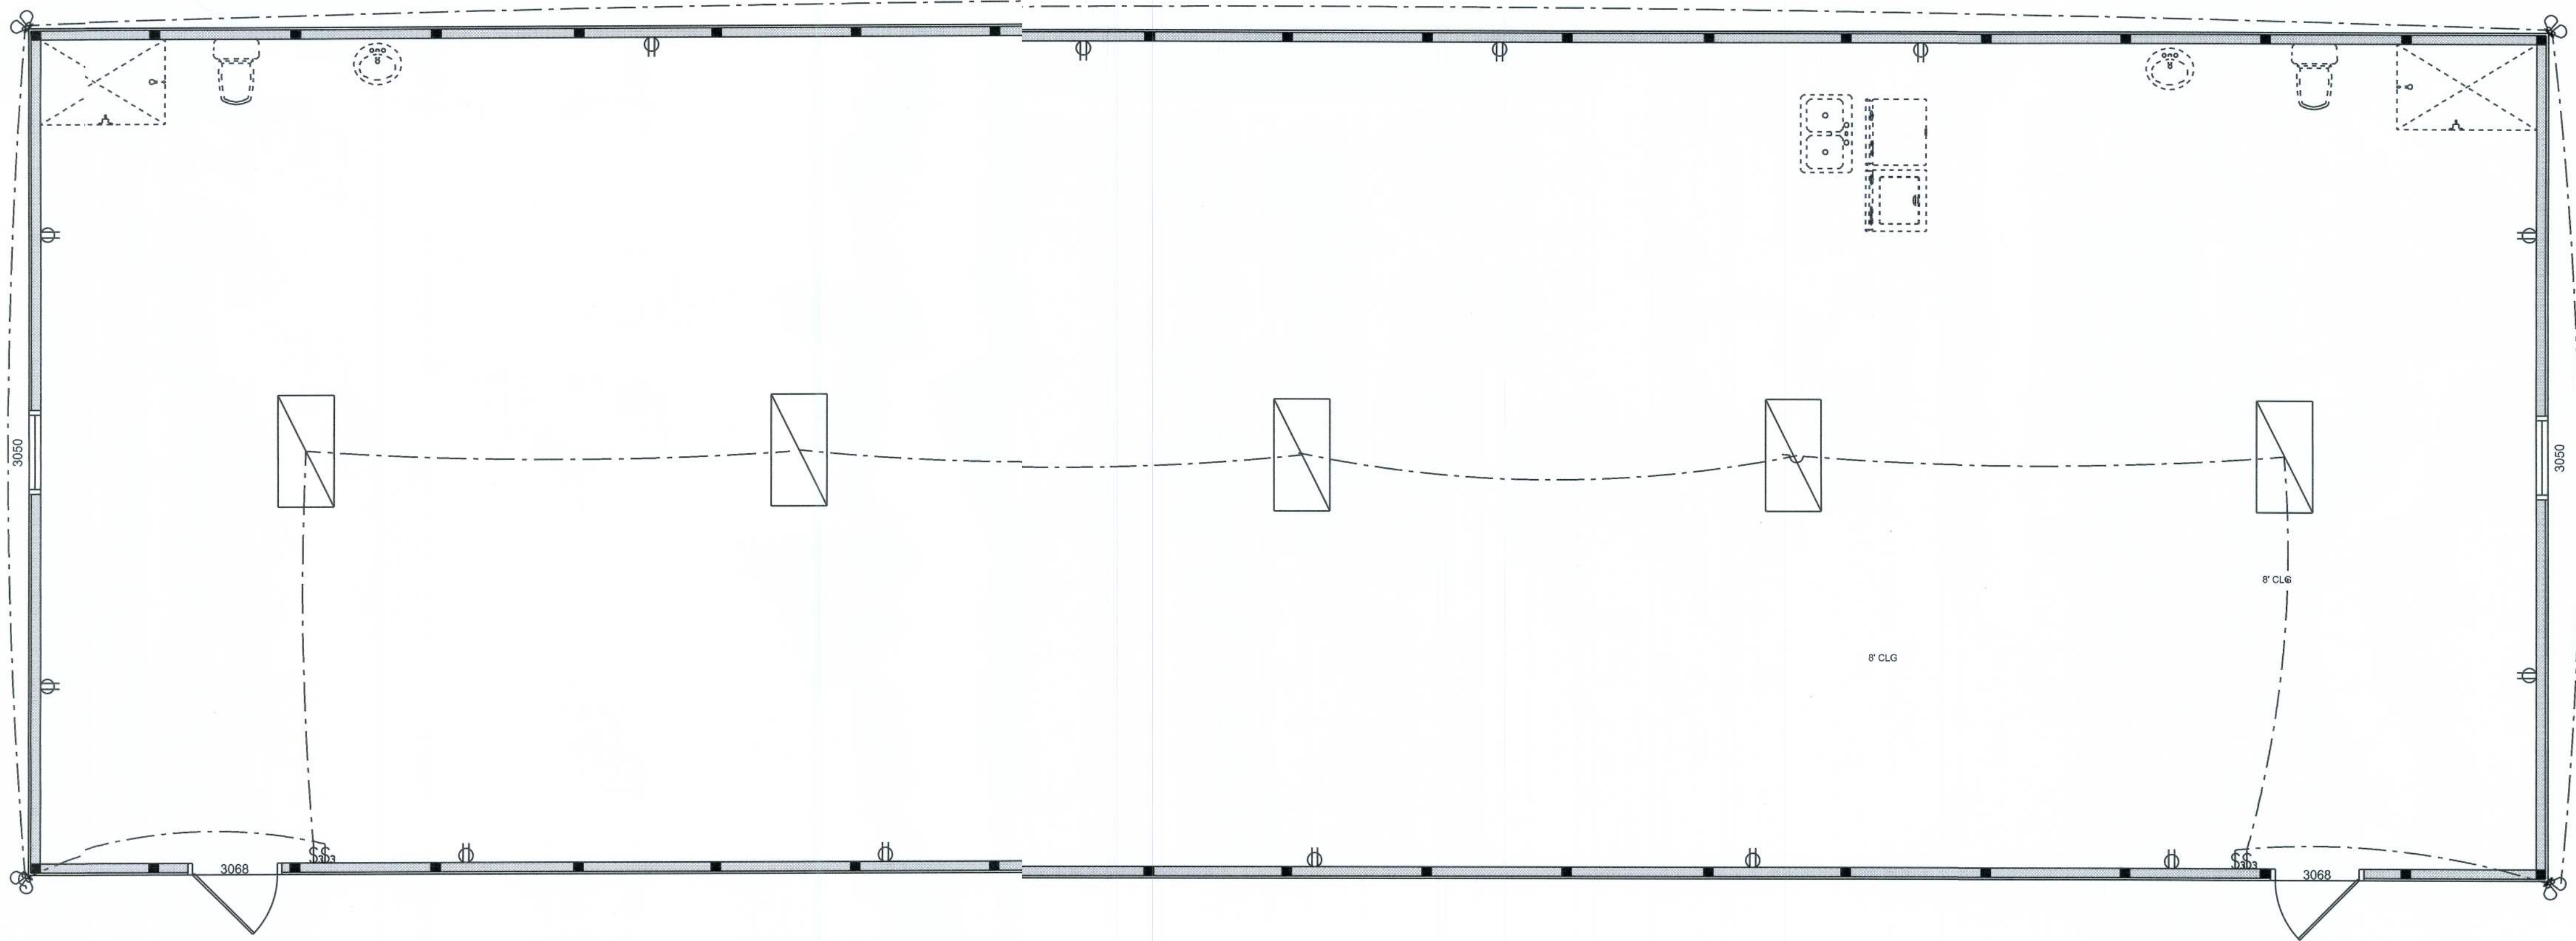

ELECTRICAL FLOOR PLAN
SCALE: 1/4" = 1'-0"


REVISIONS SCHEDULE	
Aug. 17th, 2021	PROGNOAL

COLLAR BARN PROJECT
355 SE Seacoff Way, High Springs, FL 32643

RIDGEPOINT DESIGN
366 SW ARLINGTON BLVD, STE 101, LAKE CITY, FL 32825
P: 386-288-1188
E: RIDGEPOINTDESIGN@GMAIL.COM


SHEET NUMBER
A.2
OF 3 SHEETS

ROAD
HAWKS RIDGE DRIVE

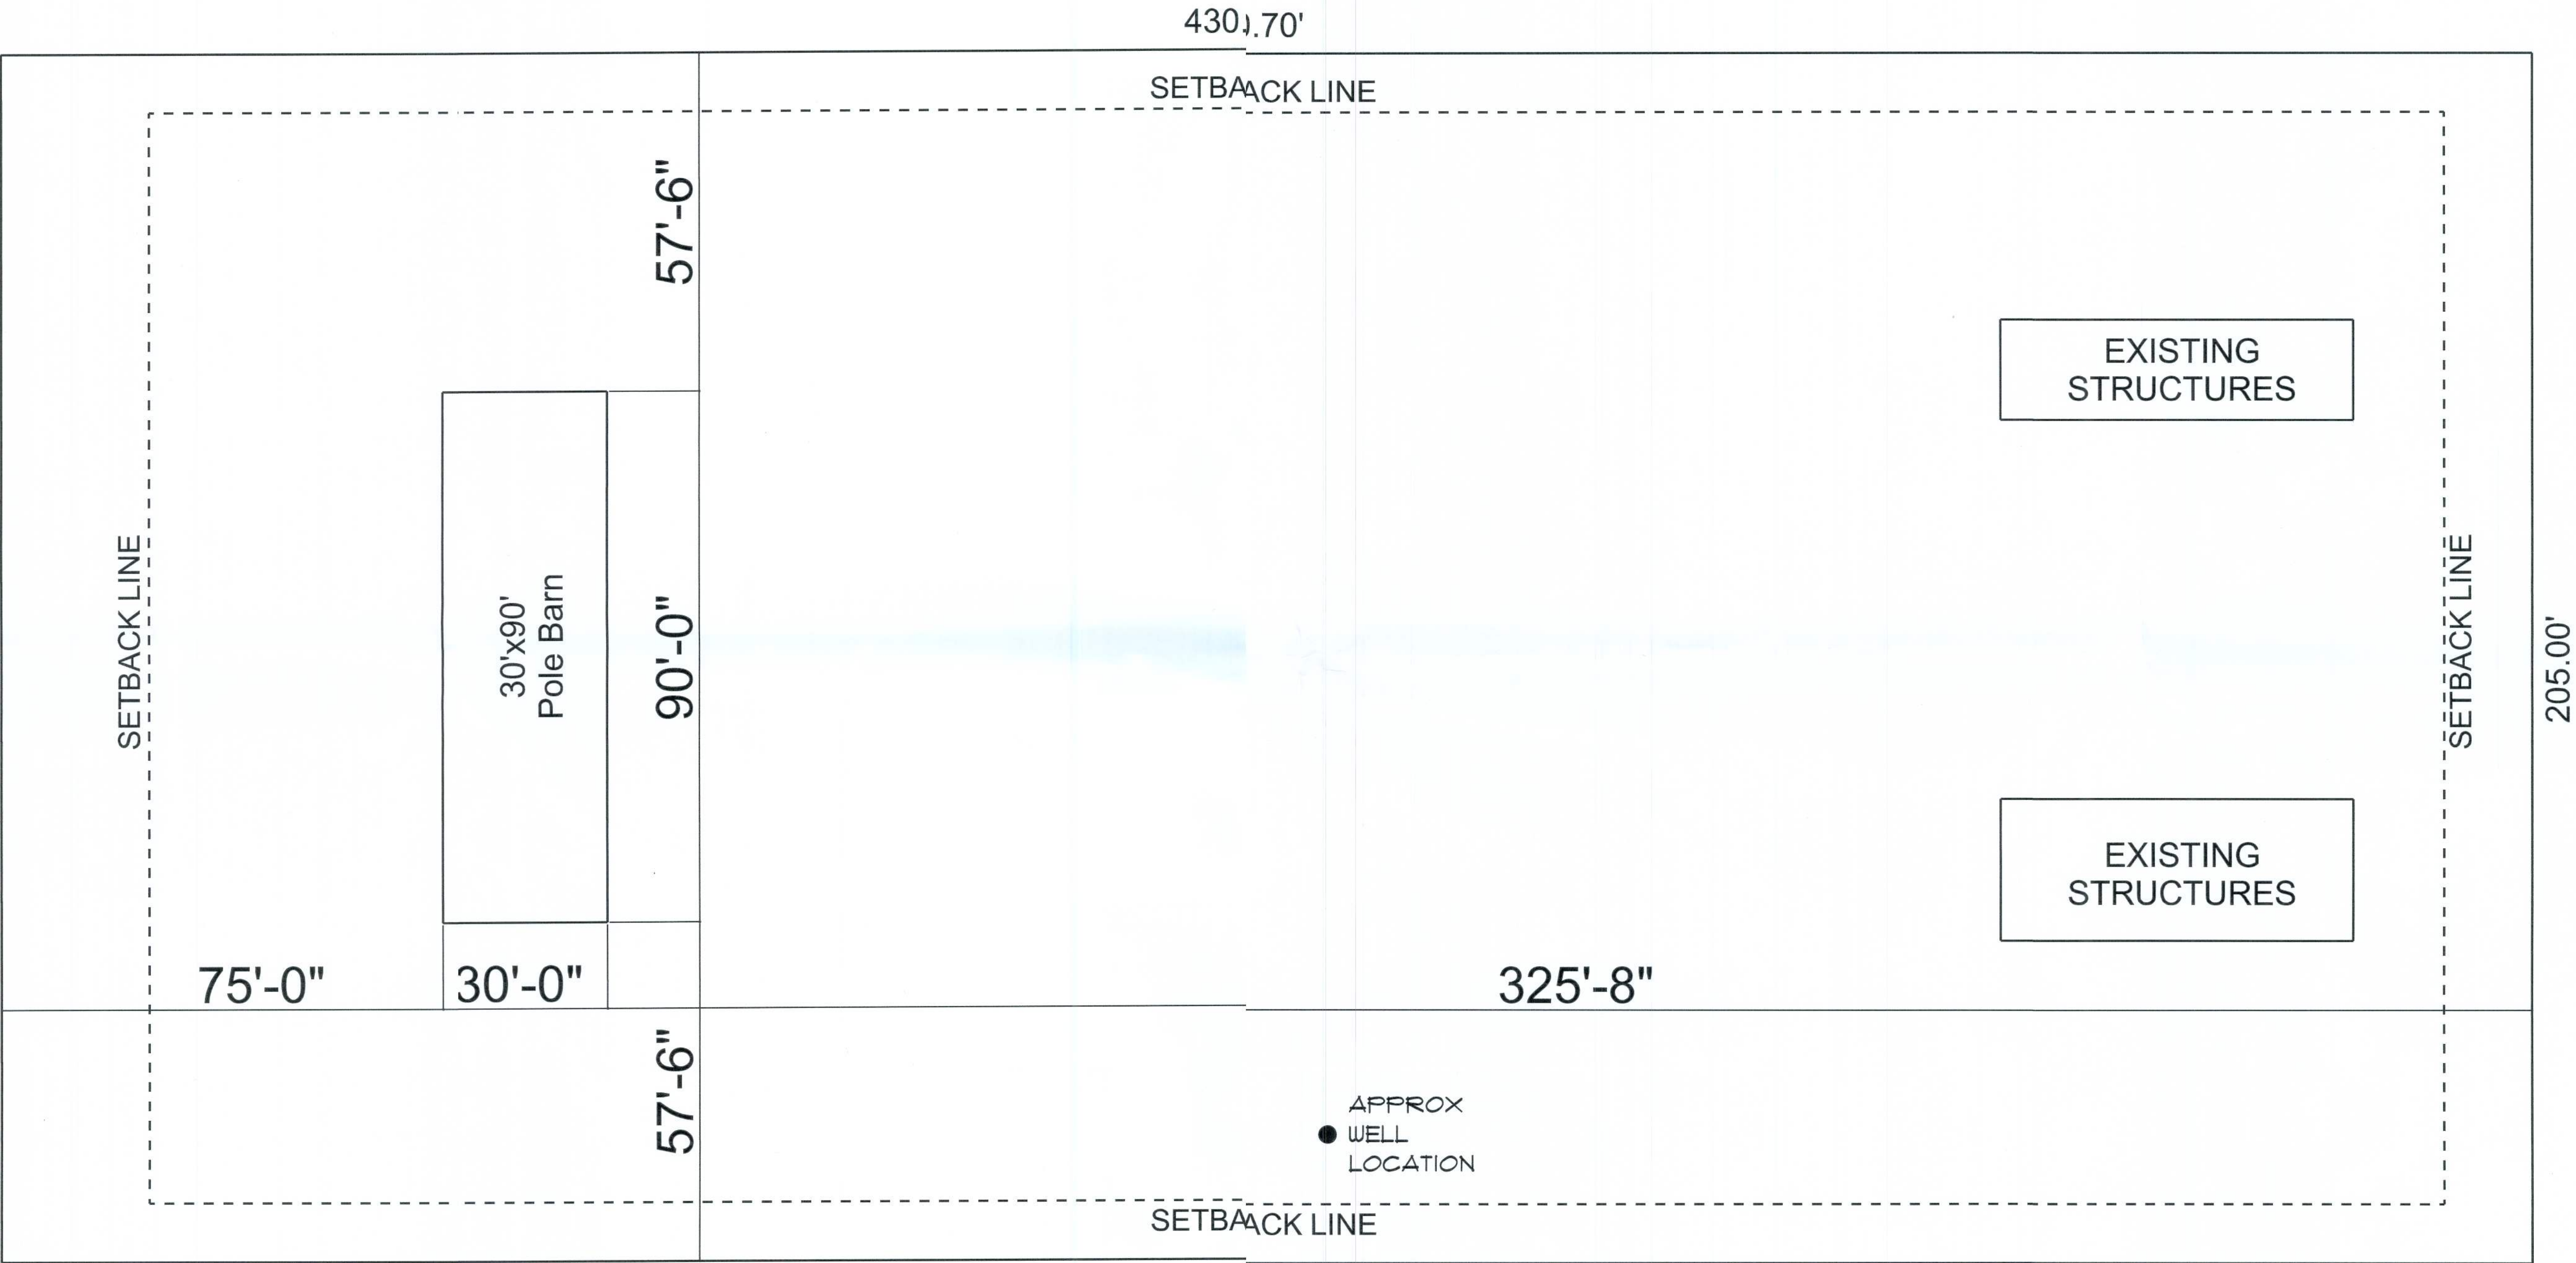

REVISIONS SCHEDULE	
Aug. 17th, 2021	PROPOSAL

COLLAR BARN PROJECT
359 SE Sawdust Way, High Springs, FL 32643

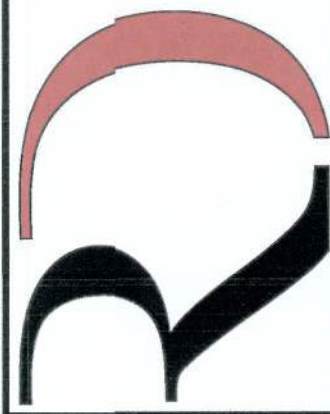

**RIDGEPOINT
DESIGN**
566 SW ARLINGTON BLVD, STE 101, LAKE CITY, FL 32025
P: 386-288-1188
E: RIDGEPOINTDESIGN@GMAIL.COM

SHEET NUMBER
A.3
OF 3 SHEETS