



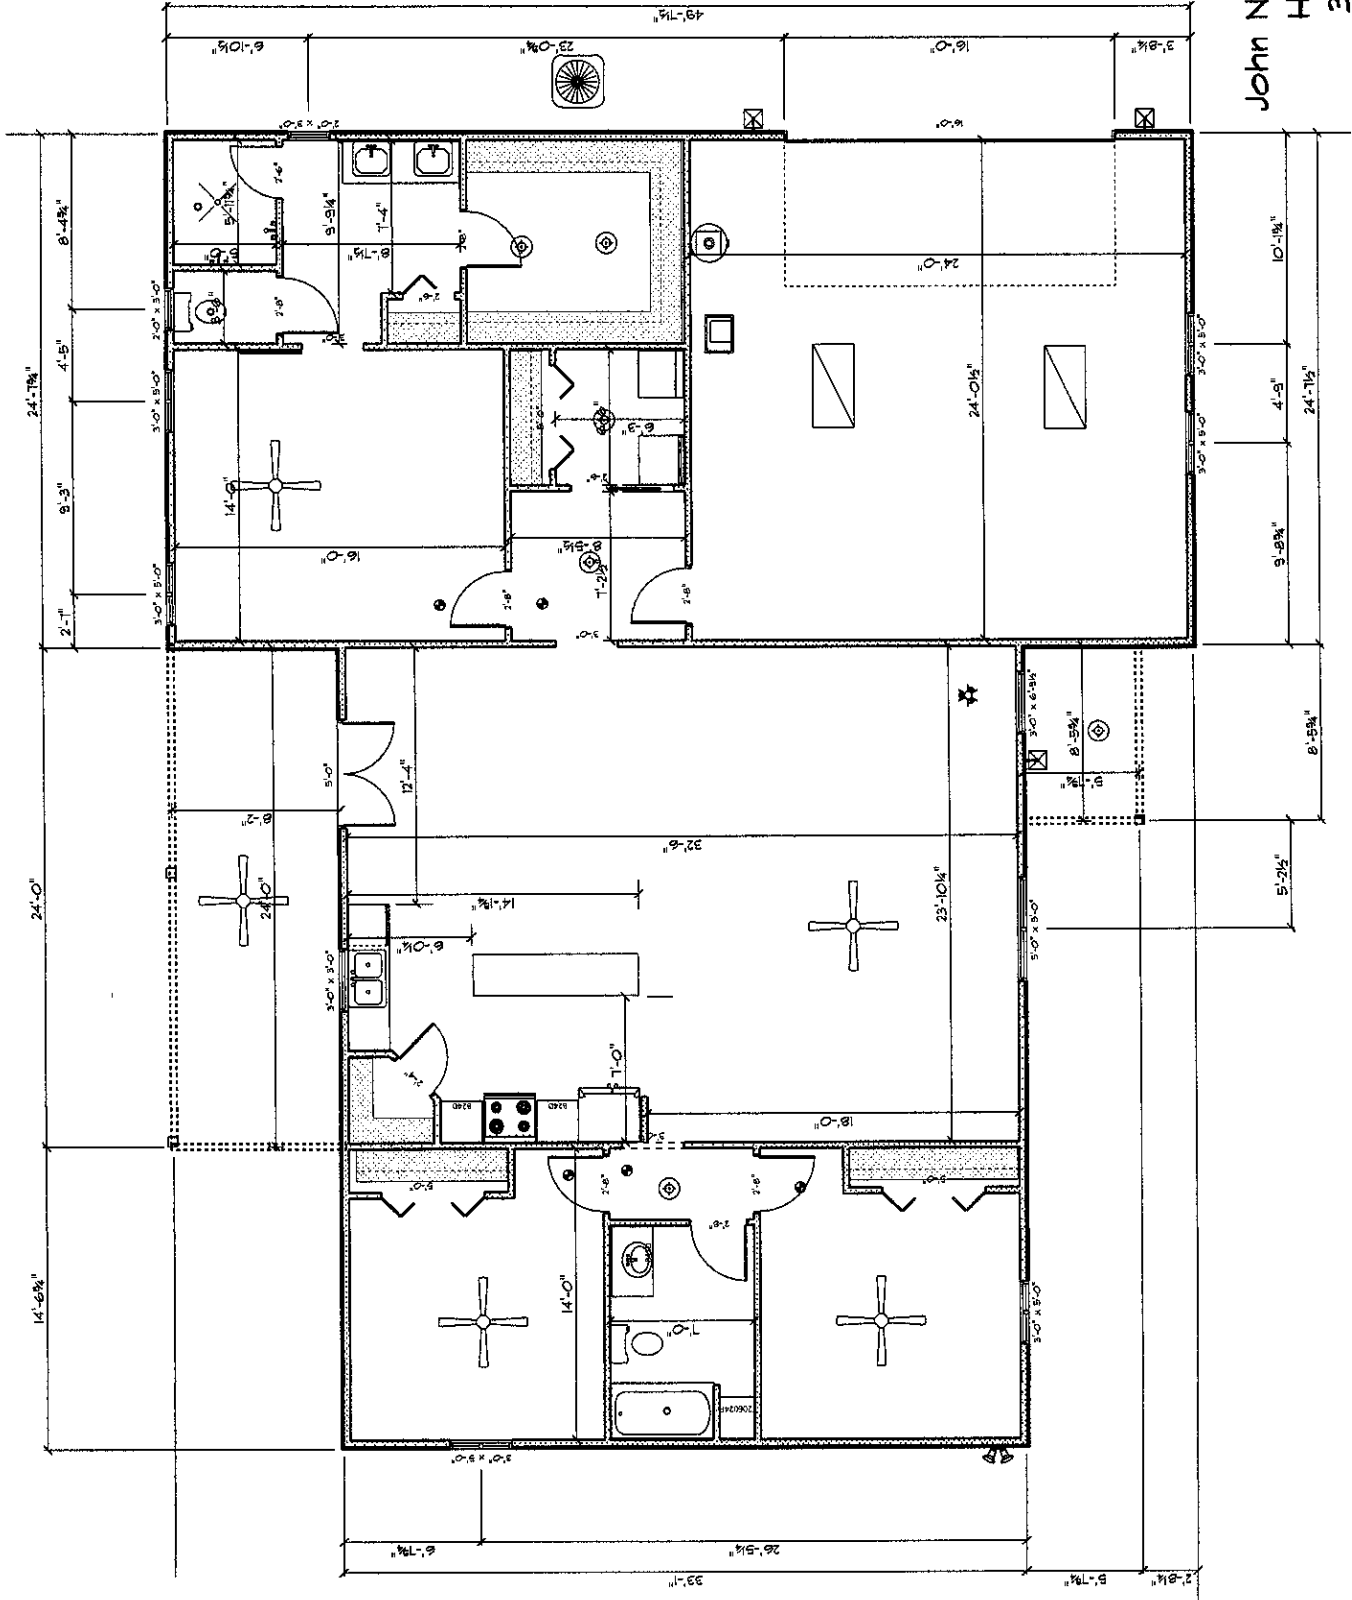

ELECTRICAL LEGEND		
ELECTRICAL	COUNT	SYMBOL
ceiling fan 4 speed DL	6	
can light directly with exhaust fan	3	
can light direct	3	
string room chandelier	1	
Pendant lighting	3	
basic flush mount lighting	9	
fluorescent light 2 x 4	2	
exterior craftsman light fixture	2	
spotlight double with motor detector	4	
electrical panel	1	
outlet	52	
outlet gfi	17	
smoke detector	5	
ceiling bar light DL	1	
ceiling bar light DL	2	


AREA SCHEDULE	
NAME	AREA
Total Sq. Ft.	2786.1 sq. ft.
Net Area	181.7 sq. ft.
Net Area	242.2 sq. ft.
Net Area	604.8 sq. ft.

John Norris Construction, L.L.C.
Heritage Subdivision
331 SW Legacy Glen
Lake City, FL 32025

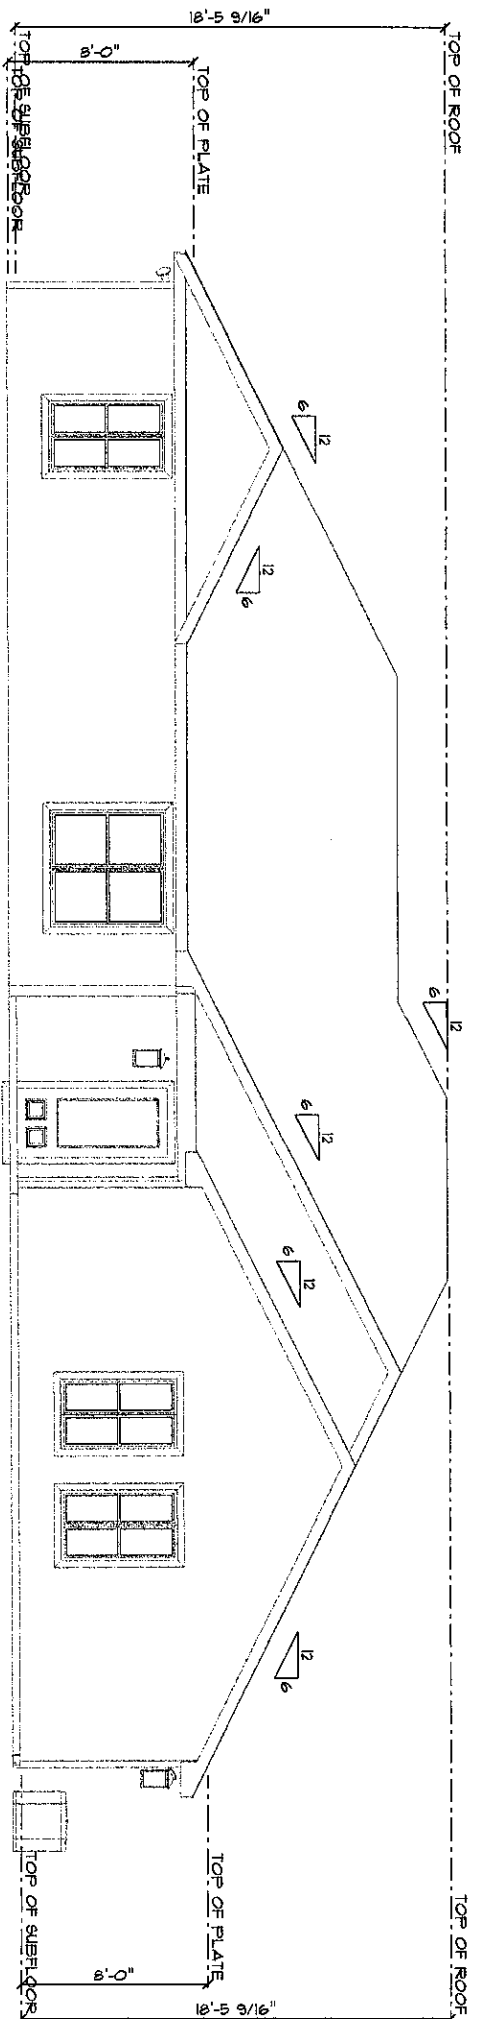


Front Elevation

SCALE: 1/8" = 1'-0"

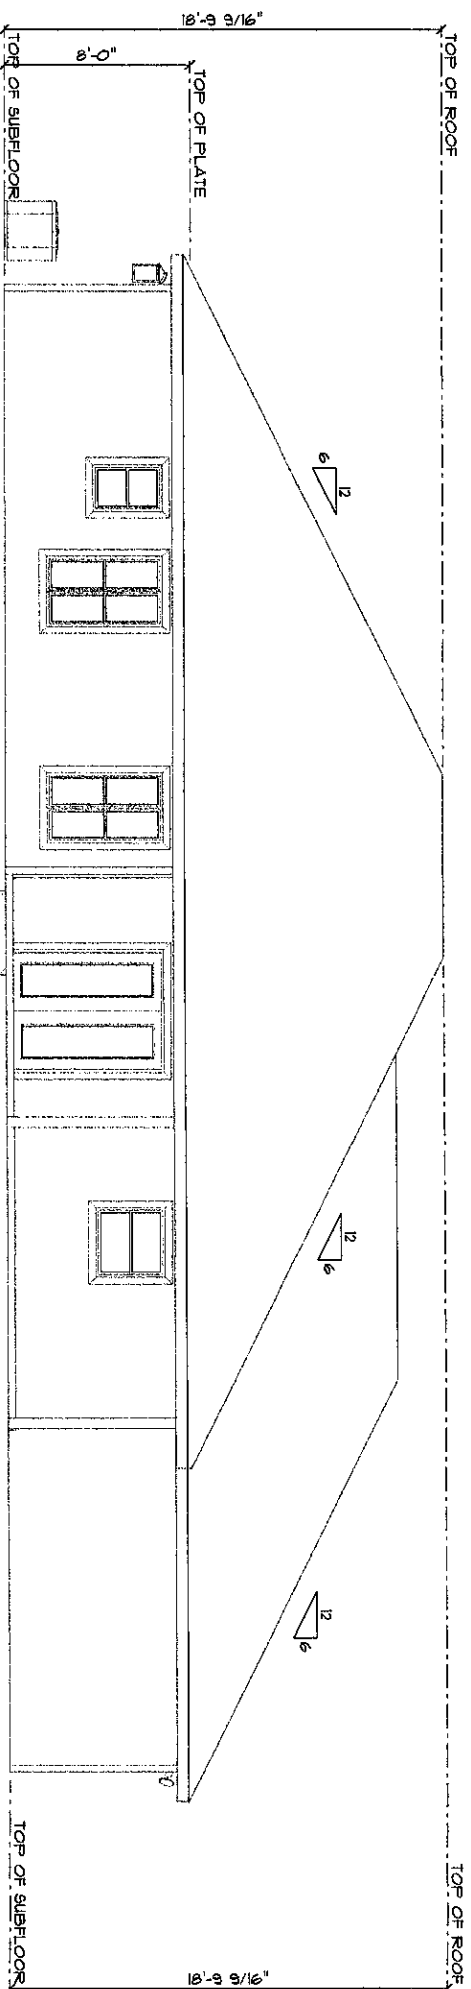


Rear Elevation

SCALE: 1/8" = 1'-0"

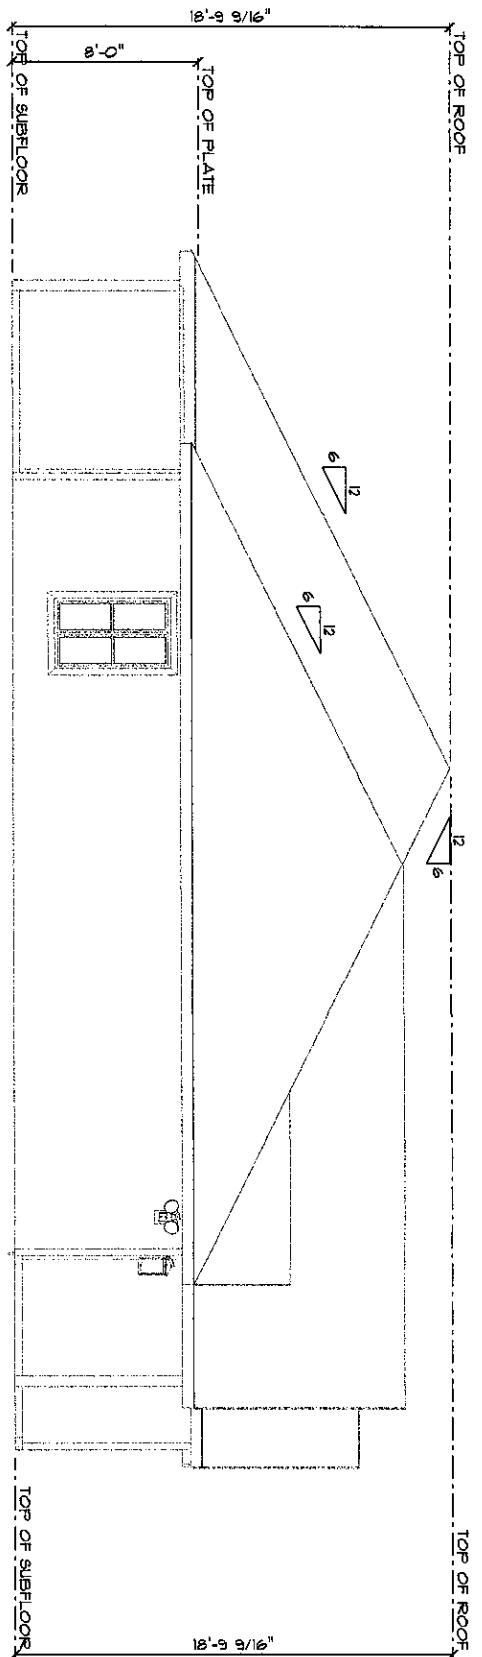

Left Elevation

SCALE: 1/8" = 1'-0"

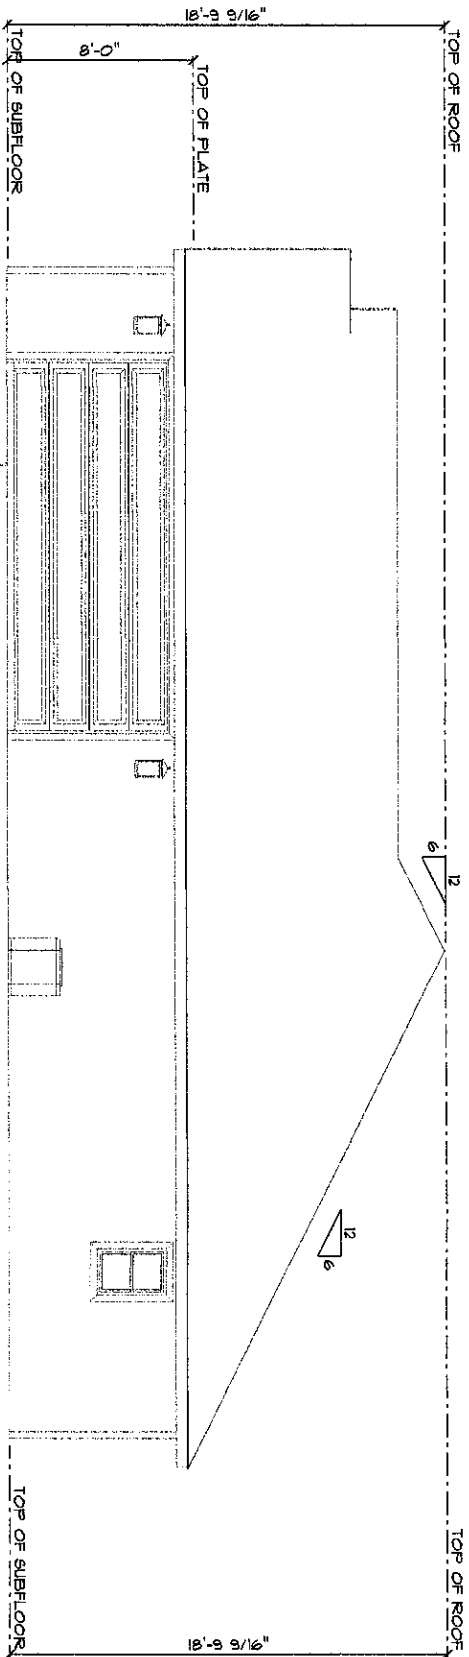

Right Elevation

SCALE: 1/8" = 1'-0"