


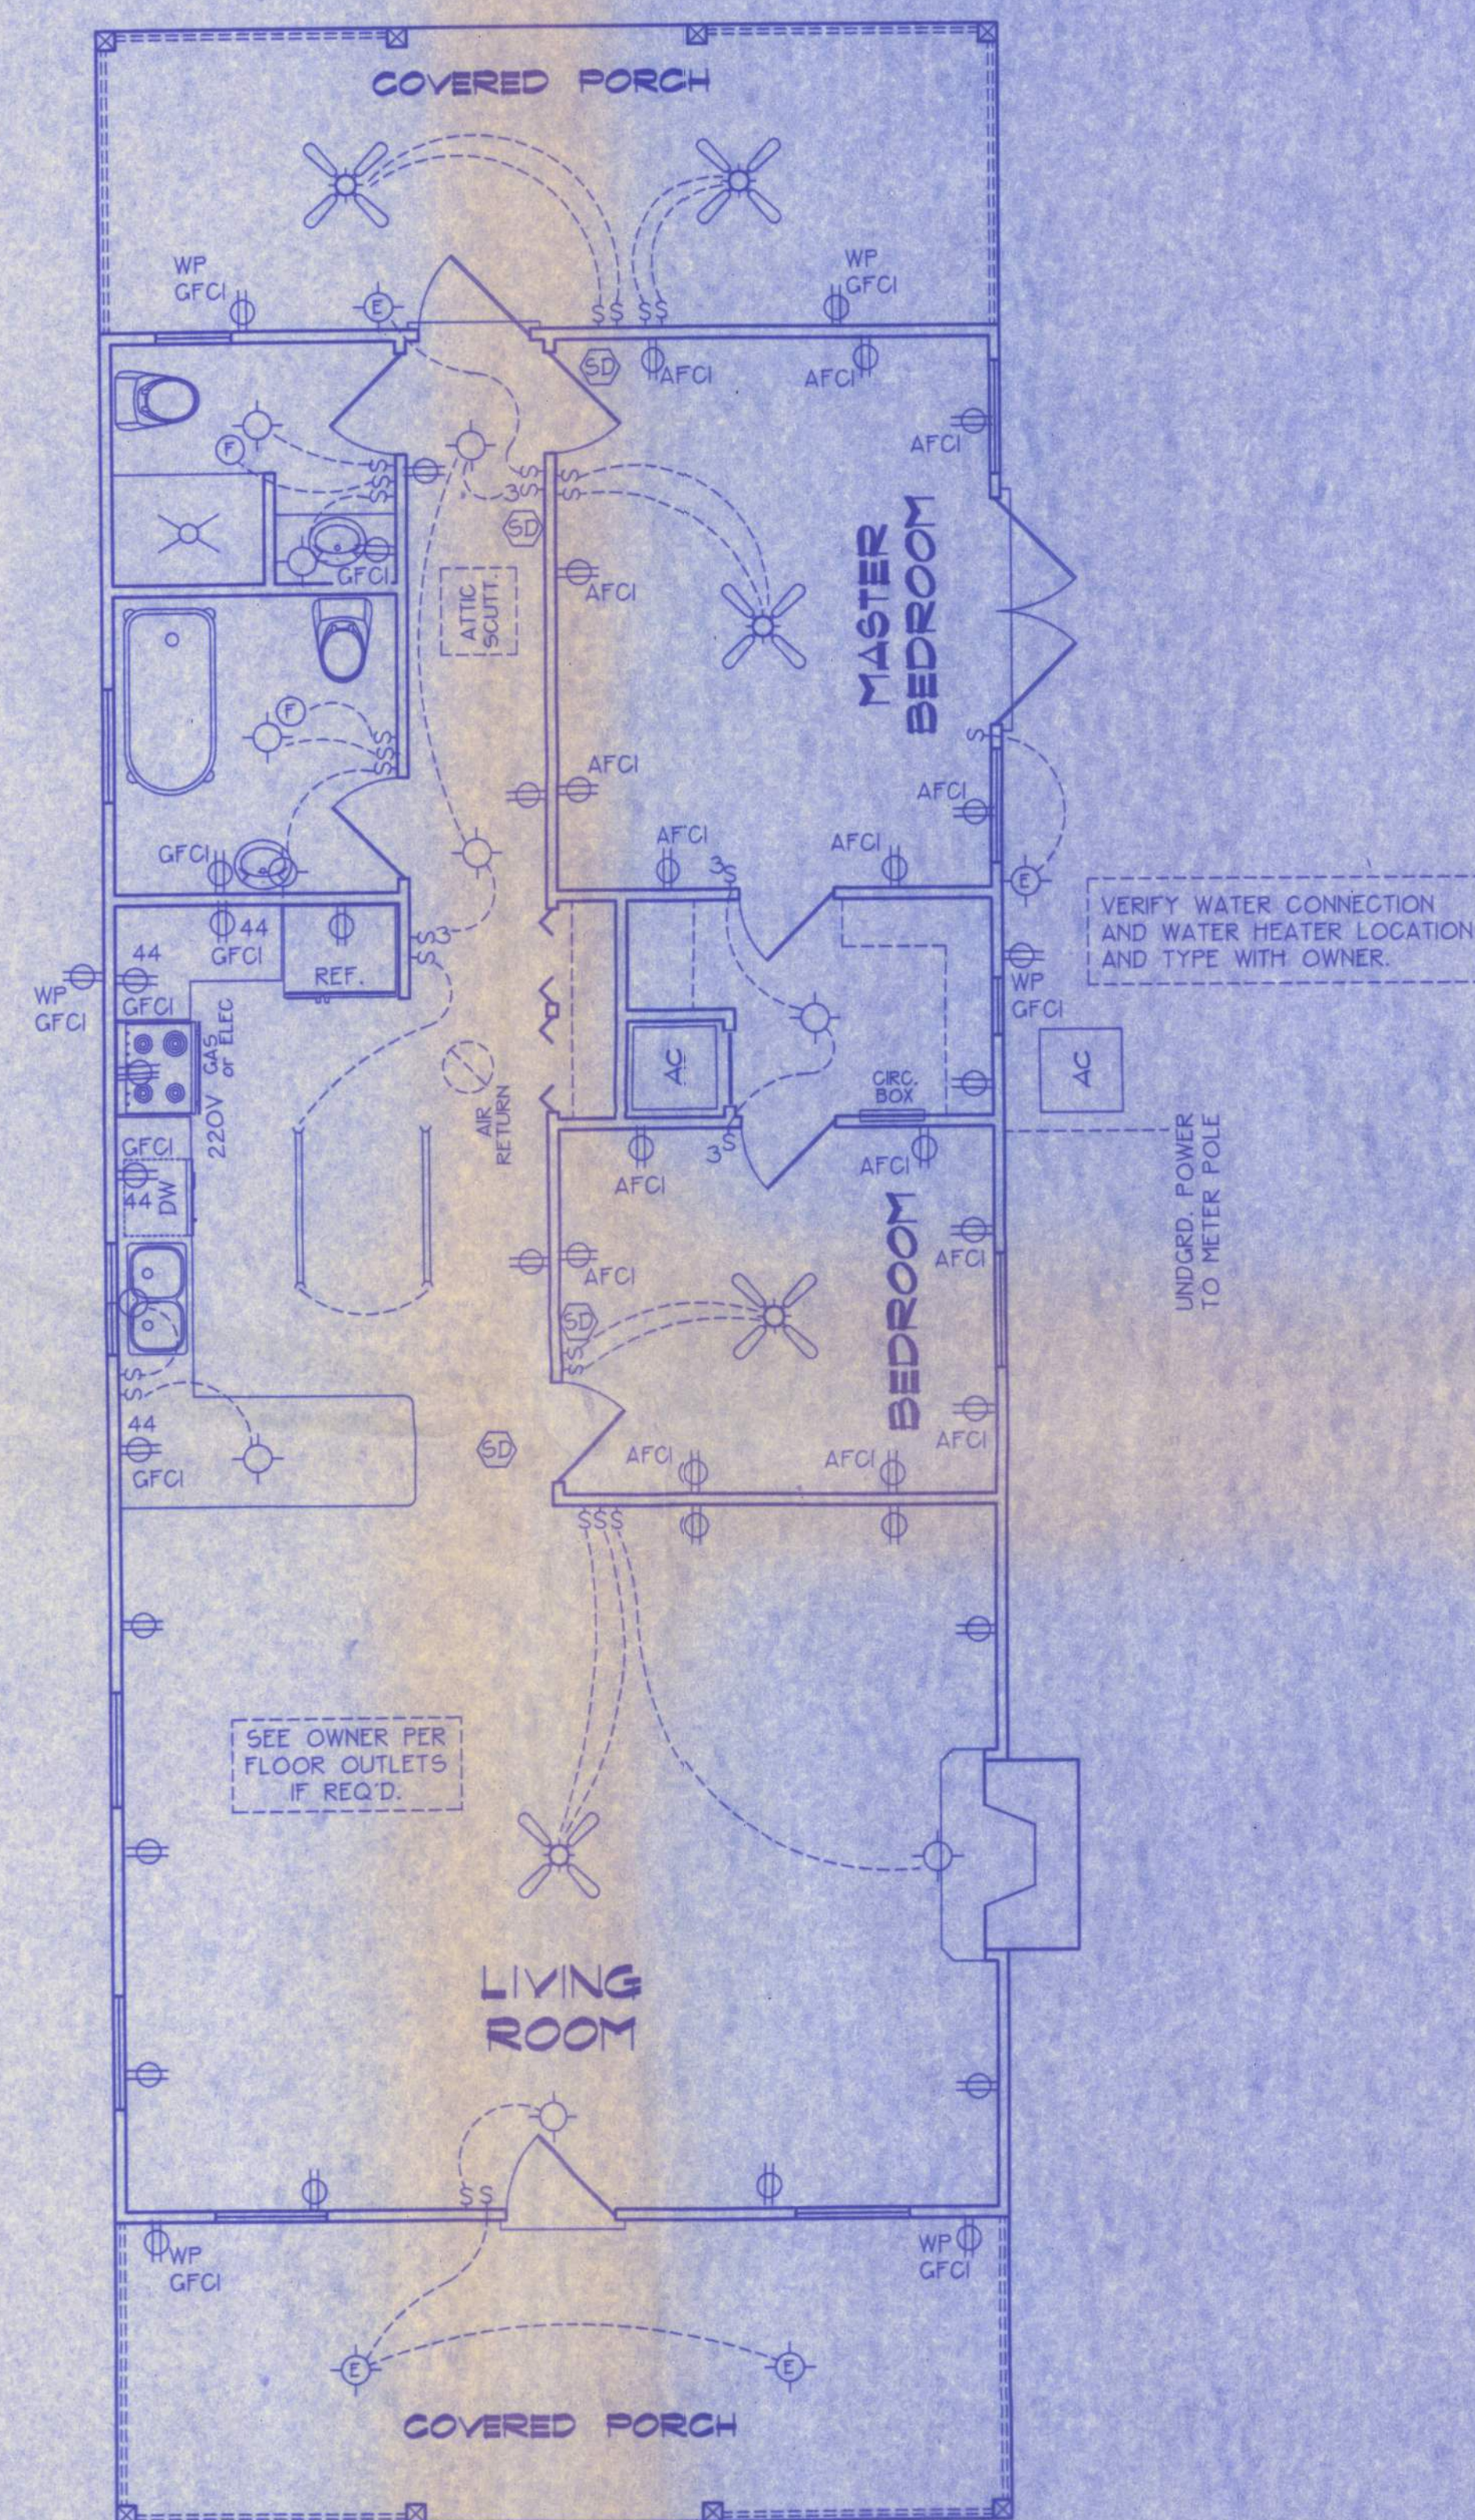

ELECTRICAL PLAN
NOT TO SCALE

ELECTRICAL SYMBOL LEGEND	
	= FLOURESCENT LIGHTING FIXTURE.
	= CEILING LIGHT FIXTURE
	= EXTERIOR LIGHTING FIXTURE
	= LIGHT SWITCH.
	= THREE-WAY SWITCH.
	= 110 V. DUPLEX OUTLET.
	= SPECIAL HEIGHT 110 V. DUPLEX OUTLET
	= GROUND FAULT CIRCUIT OUTLET
	= ARC FAULT CIRCUIT OUTLET
	= 110 V. SINGLE RECEPTACLE OUTLET.
	= 220 VOLT OUTLET (4 WIRE)
	= FAN LOCATION (CEILING)
	= FAN LOCATION (EXHAUST)
	= SMOKE DETECTOR

ELECTRICAL PLAN NOTES

- WIRE ALL APPLIANCES, HVAC UNITS AND OTHER EQUIPMENT PER MANUF. SPECIFICATIONS.
- CONSULT THE OWNER FOR THE NUMBER OF SEPERATE TELEPHONE LINES TO BE INSTALLED.
- ALL INSTALLATIONS SHALL BE PER NAT'L. ELECTRIC CODE.
- ALL SMOKE DETECTORS SHALL BE 120V W/ BATTERY BACKUP OF THE PHOTOELECTRIC TYPE, AND SHALL BE INTERLOCKED TOGETHER. INSTALL INSIDE AND NEAR ALL BEDROOMS.
- TELEPHONE, TELEVISION AND OTHER LOW VOLTAGE DEVICES OR OUTLETS SHALL BE AS PER THE OWNER'S DIRECTIONS, + IN ACCORDANCE W/ APPLICABLE SECTIONS OF NEC-LATEST EDITION.
- ELECTRICAL CONTR. SHALL BE RESPONSIBLE FOR THE DESIGN + SIZING OF ELECTRICAL SERVICE AND CIRCUITS.
- ENTRY OF SERVICE (UNDERGROUND OR OVERHEAD) TO BE DETERMINED BY POWER COMPANY.

LOT 5 "CHETUCKEE FOREST"
TRACT "B" PHASE I

A-4

FILE: 05-035	PRESTON RESIDENCE	SHEET: 4 OF 4
DATE: 7-1-05		CAD FILE: 05035
DRAWN: T A D	PREPARED BY: TIM DELBENE Drafting + Technical Services	REV:
CHECK: T A D	192 SW Segeewood Gin., Lake City, FL 32024 Phone (386) 755-5891	REV: