

HOME PLANS FOR HAMPTON RESIDENCE COLUMBIA COUNTY, FL

Plan Sheet Index:


Sheet No.	Description
1	title/index sheet
2	floor plan
3	right and rear elevations
4	left and front elevations
5	wall typical
6	roof plan
7	foundation & plumbing plan
8	electrical plan

PLANS PREPARED BY:
CHRISTOPHER Q. DICKS
4035 SE CR 252, LAKE CITY, FL 32025


HAMPTON RESIDENCE
COLUMBIA COUNTY, FLORIDA

SHEET
1
OF
8

SQUARE FOOTAGE	
HEATED AREA	1570 SF
PORCH	429 SF
TOTAL	1999 SF

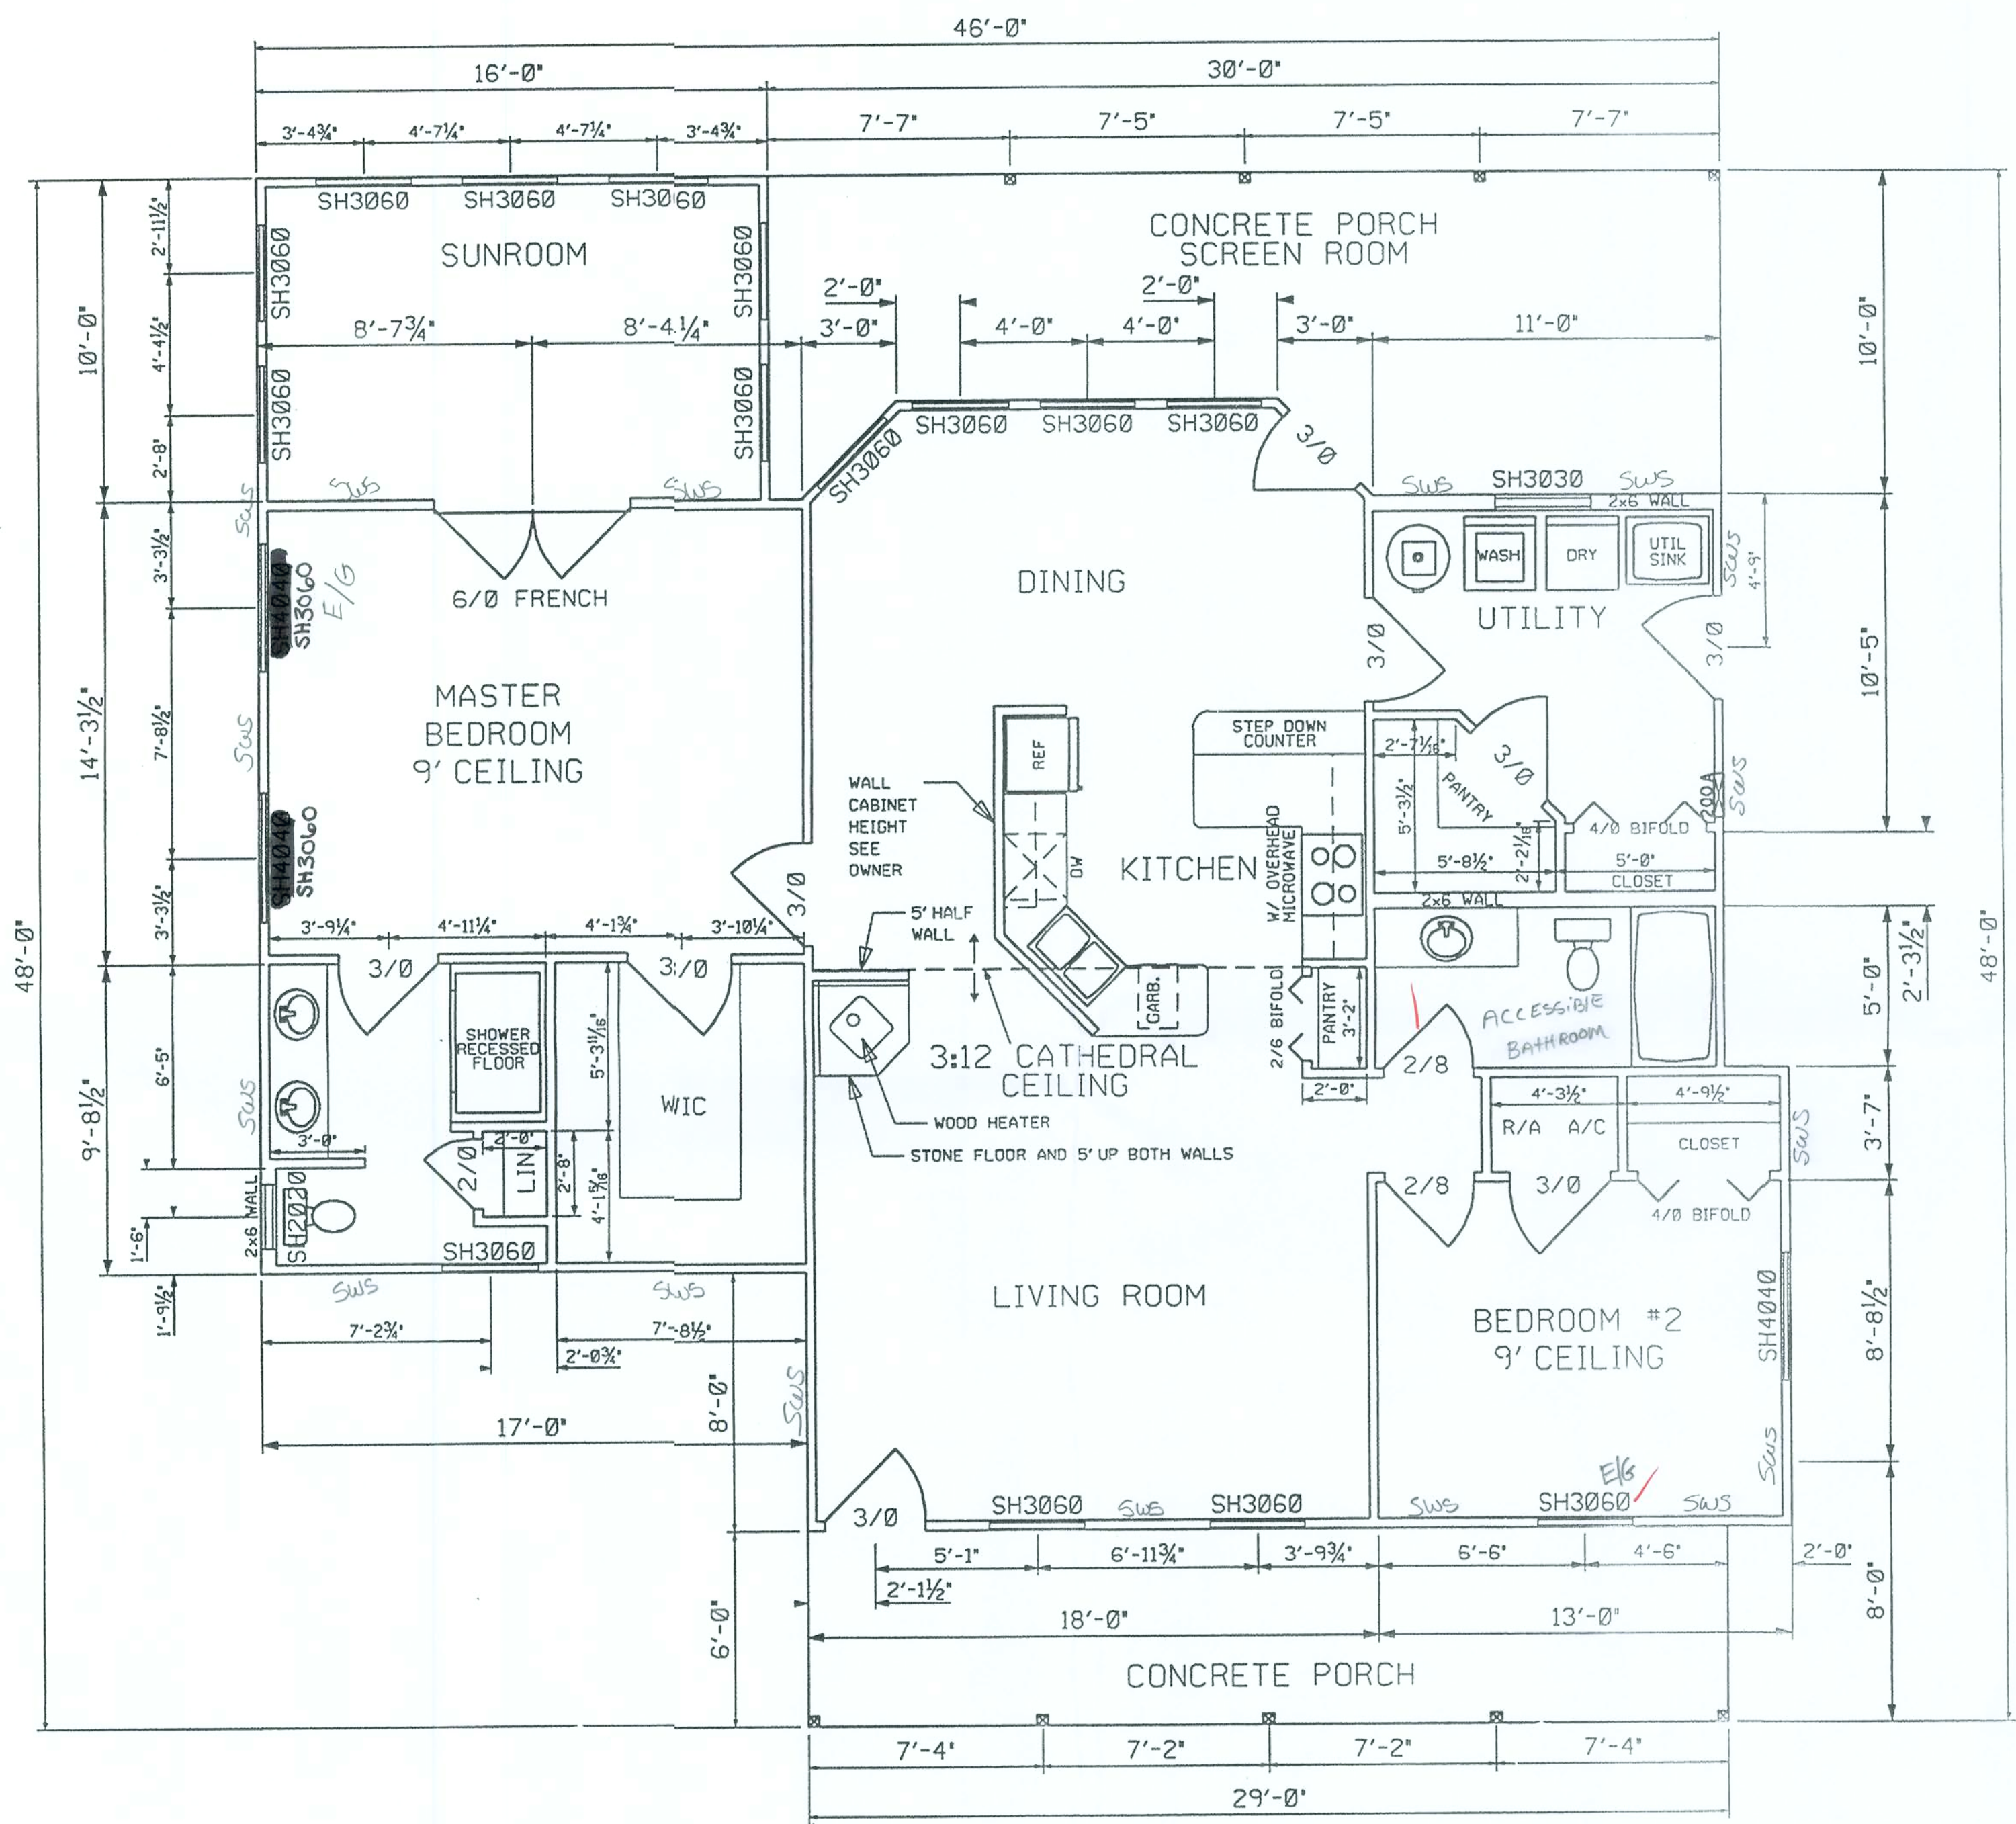


FLOOR PLAN

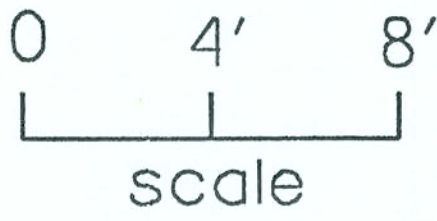


HAMPTON RESIDENCE
COLUMBIA COUNTY, FLORIDA

PLANS PREPARED BY:
CHRISTOPHER Q. DICKS
4035 SE CR 252, LAKE CITY, FL 32025

SHEET
2
OF
8

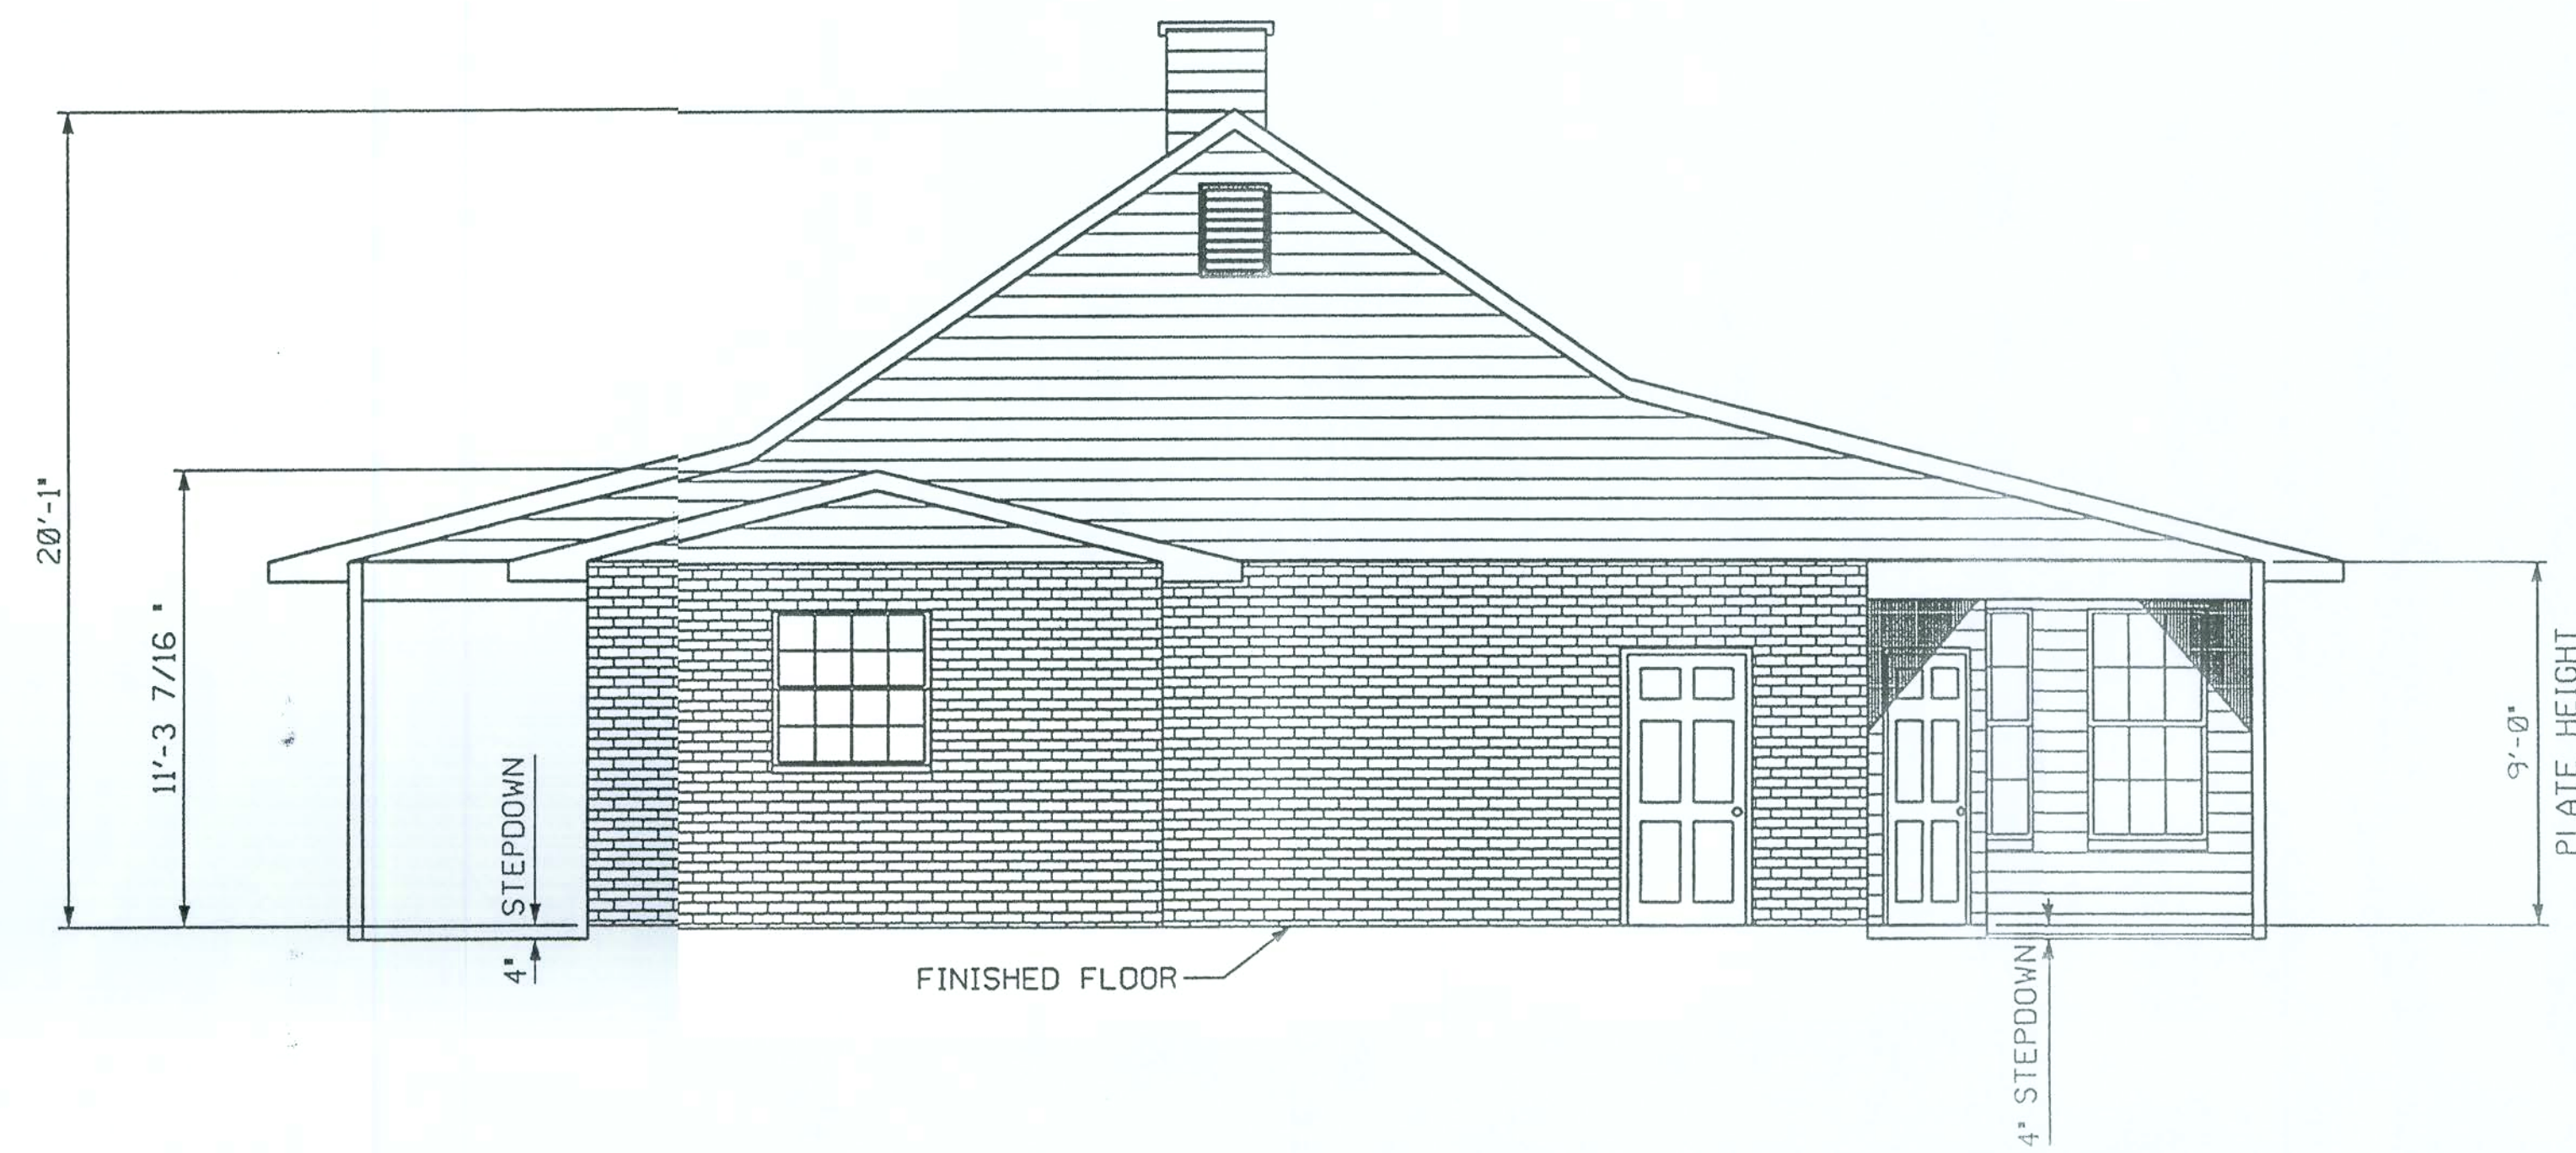


RIGHT ELEVATION

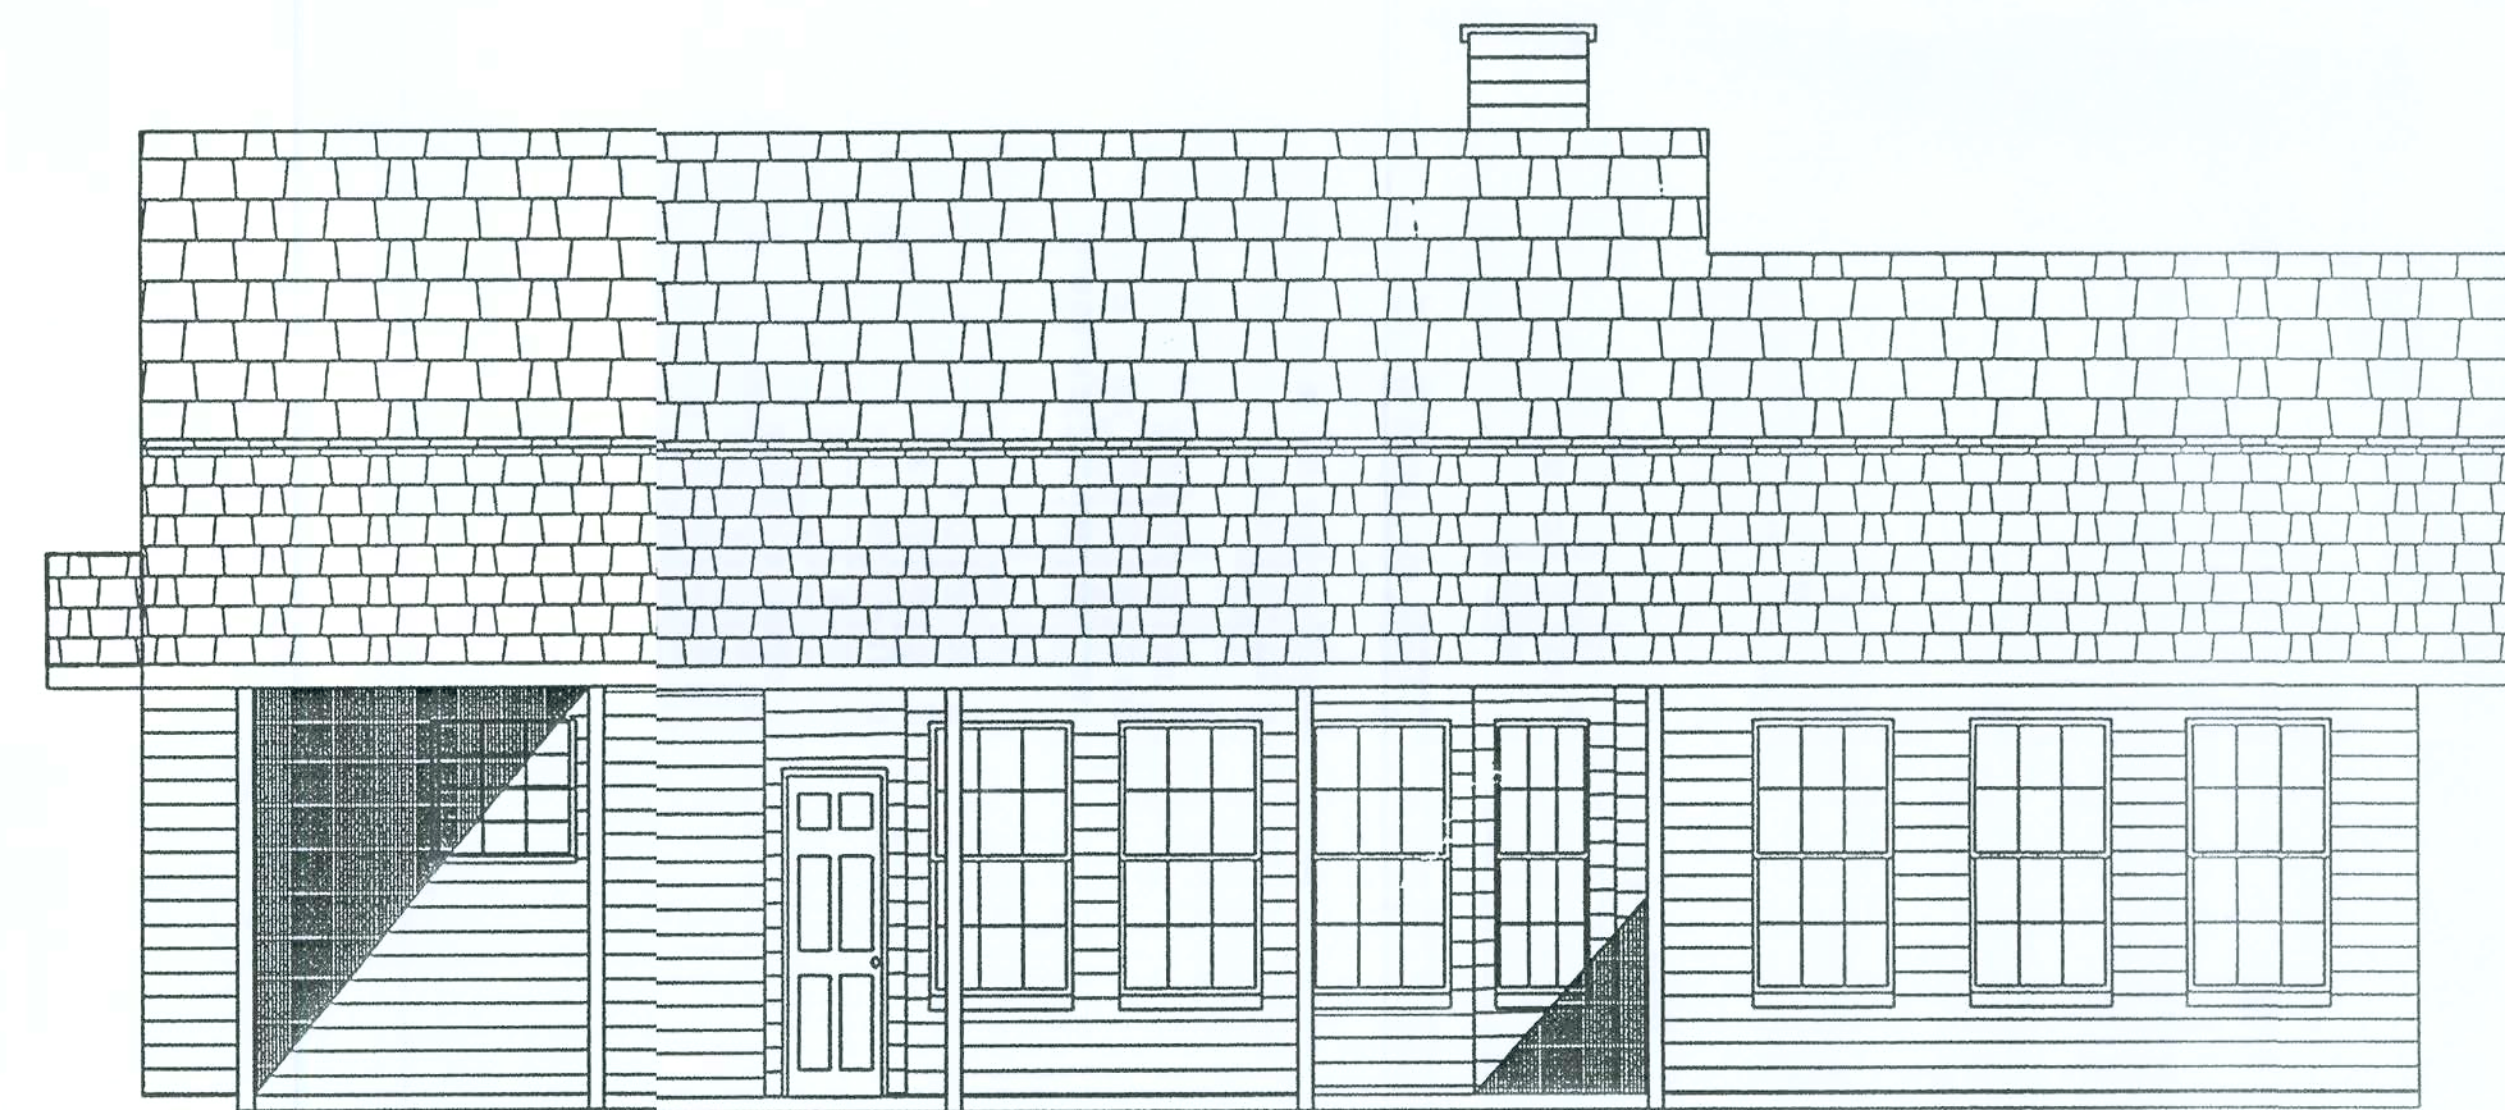


REAR ELEVATION

0 4' 8'
scale

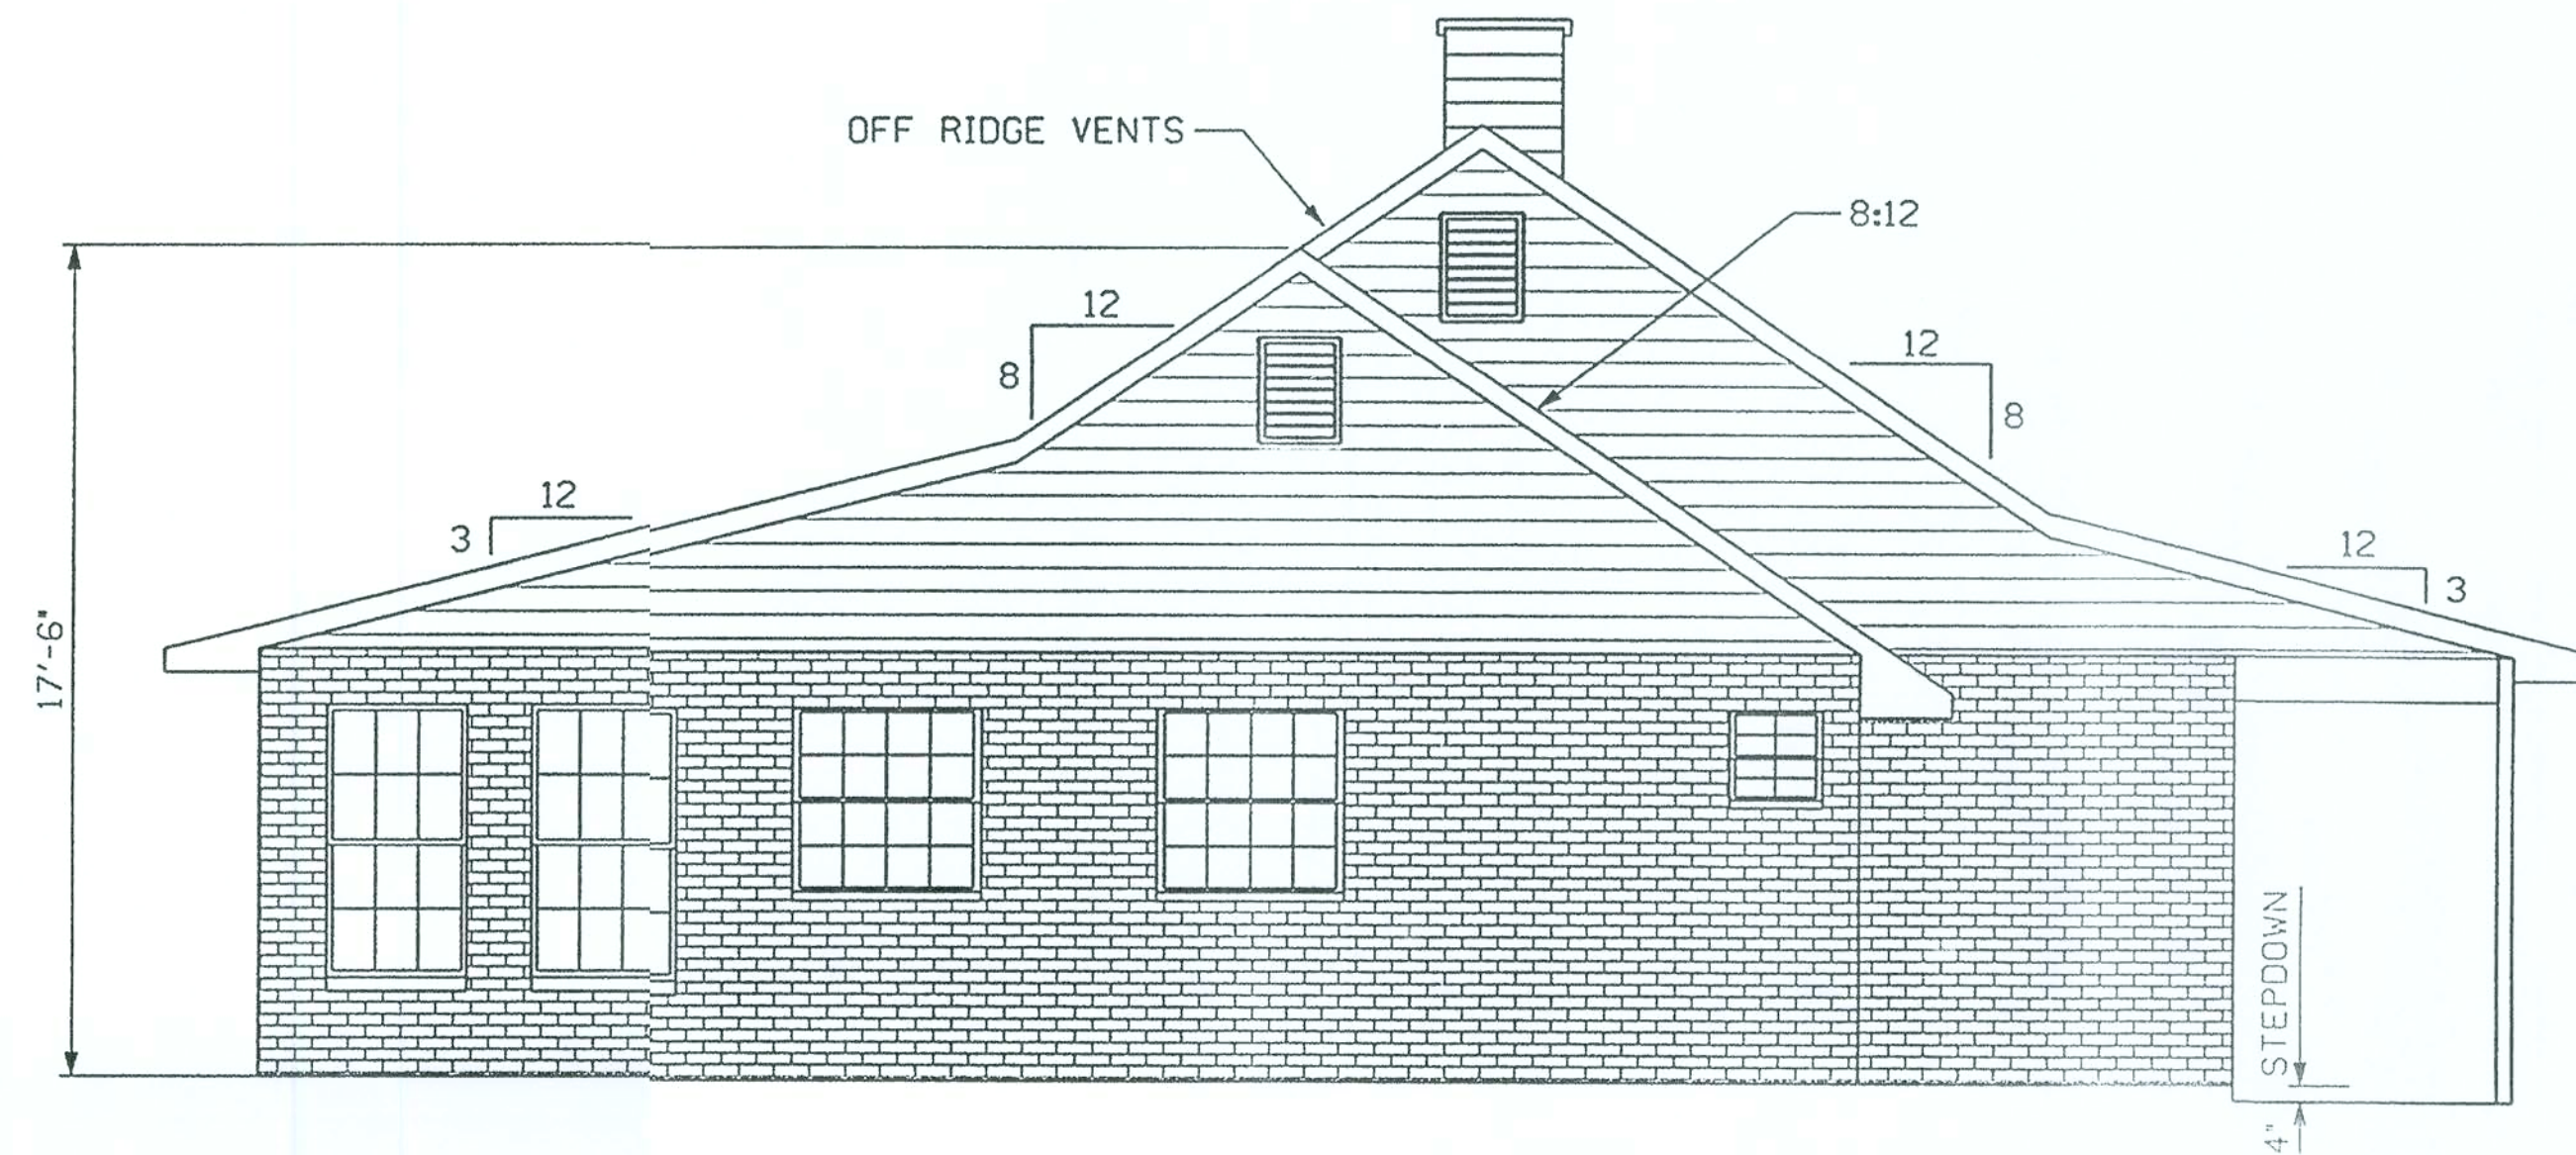

LEFT ELEVATION

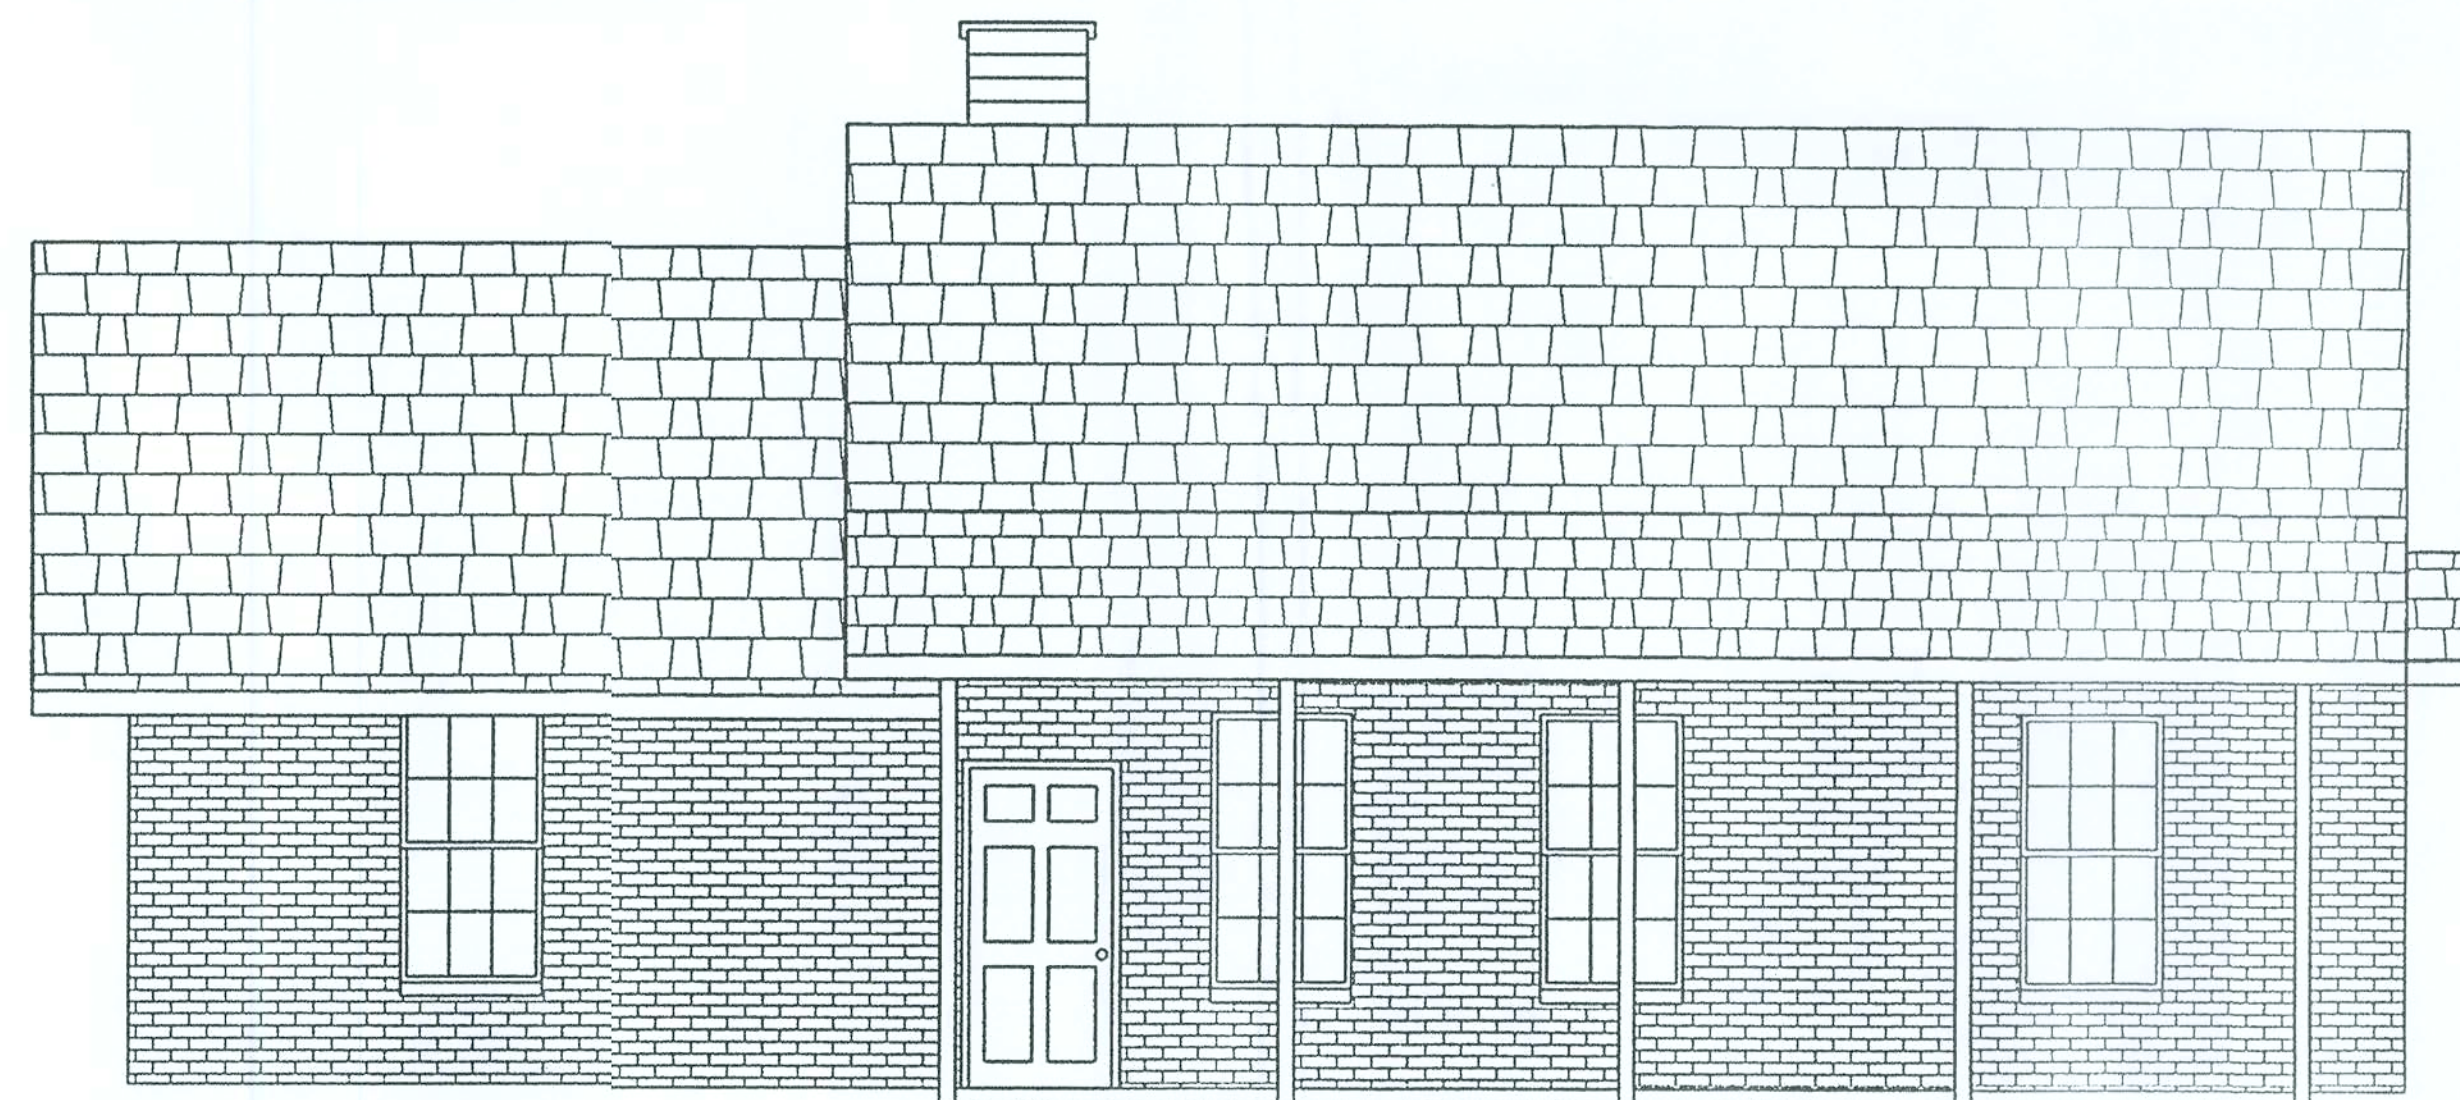

FRONT ELEVATION



0 4' 8'
scale

PLANS PREPARED BY:
CHRISTOPHER Q. DICKS
4035 SE CR 252, LAKE CITY, FL 32025

HAMPTON RESIDENCE
COLUMBIA COUNTY, FLORIDA

SHEET
4
OF
8


* Note *
See Wind Load Analysis
For Structural Detail

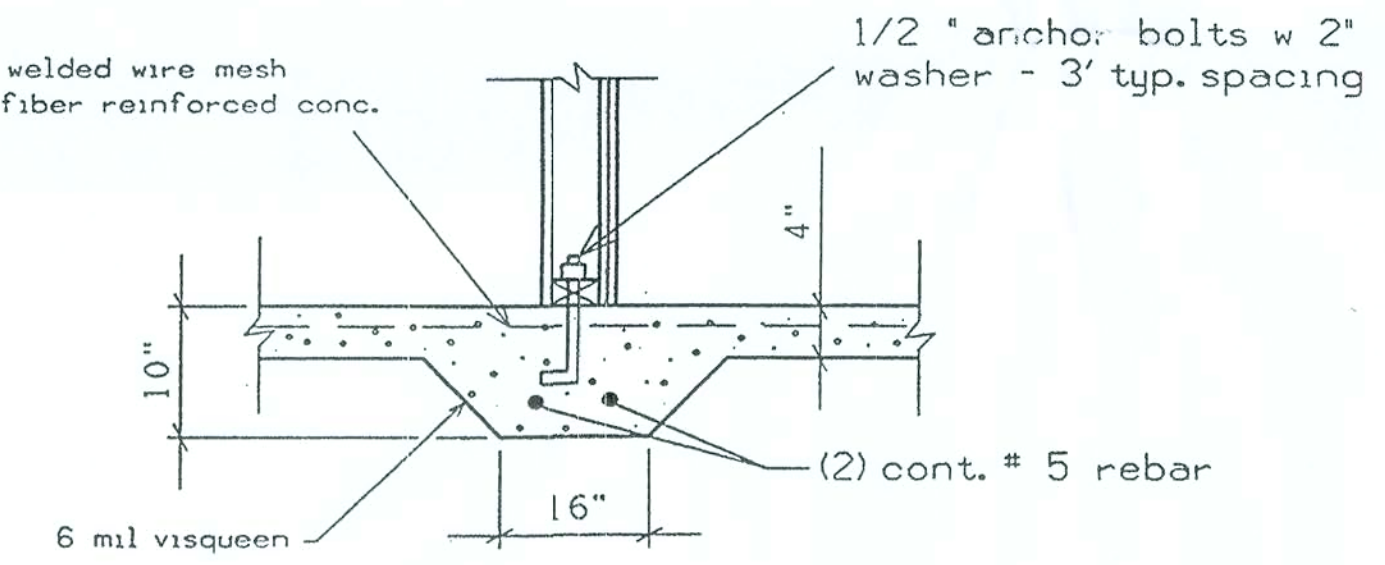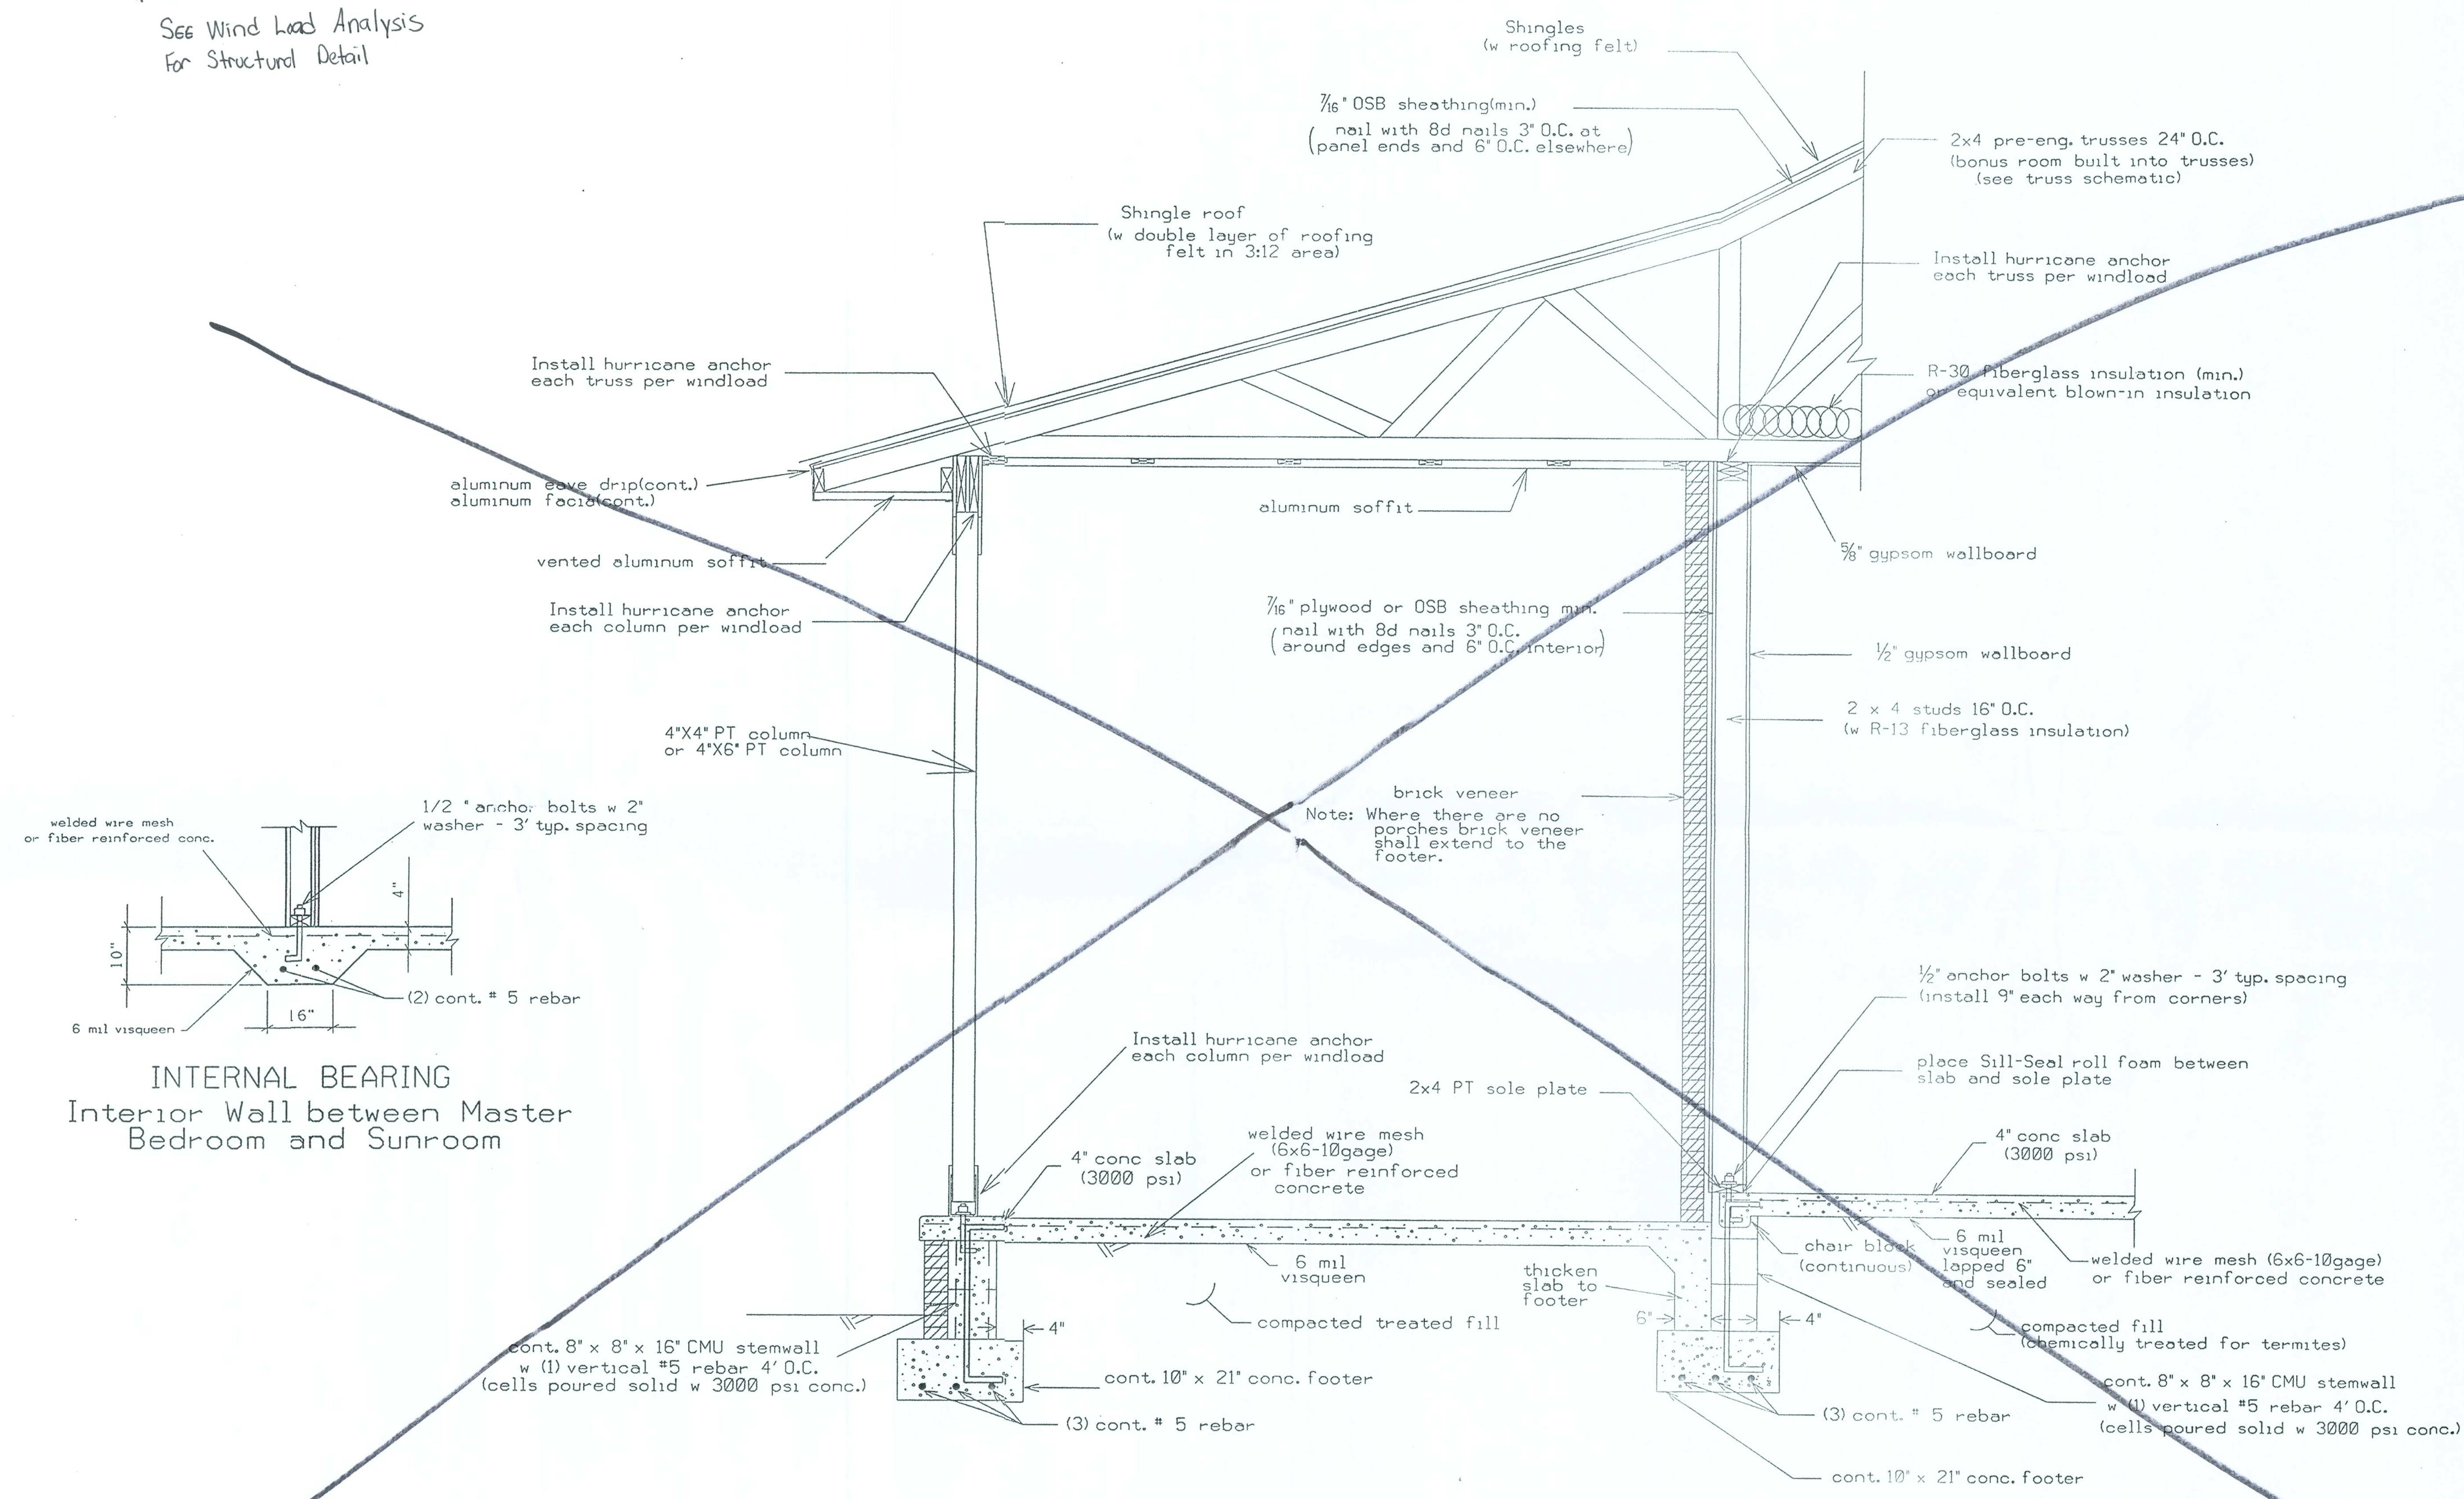


INTERNAL BEARING
Interior Wall between Master
Bedroom and Sunroom

Note: Headers for windows and doors shall be 2-2x12's (#2 SYP) with 1/2" plywood between. Porch beam shall be 2-2x10's (#2 SYP) with 1/2" plywood between.

TYPICAL WALL SECTION N.T.S.

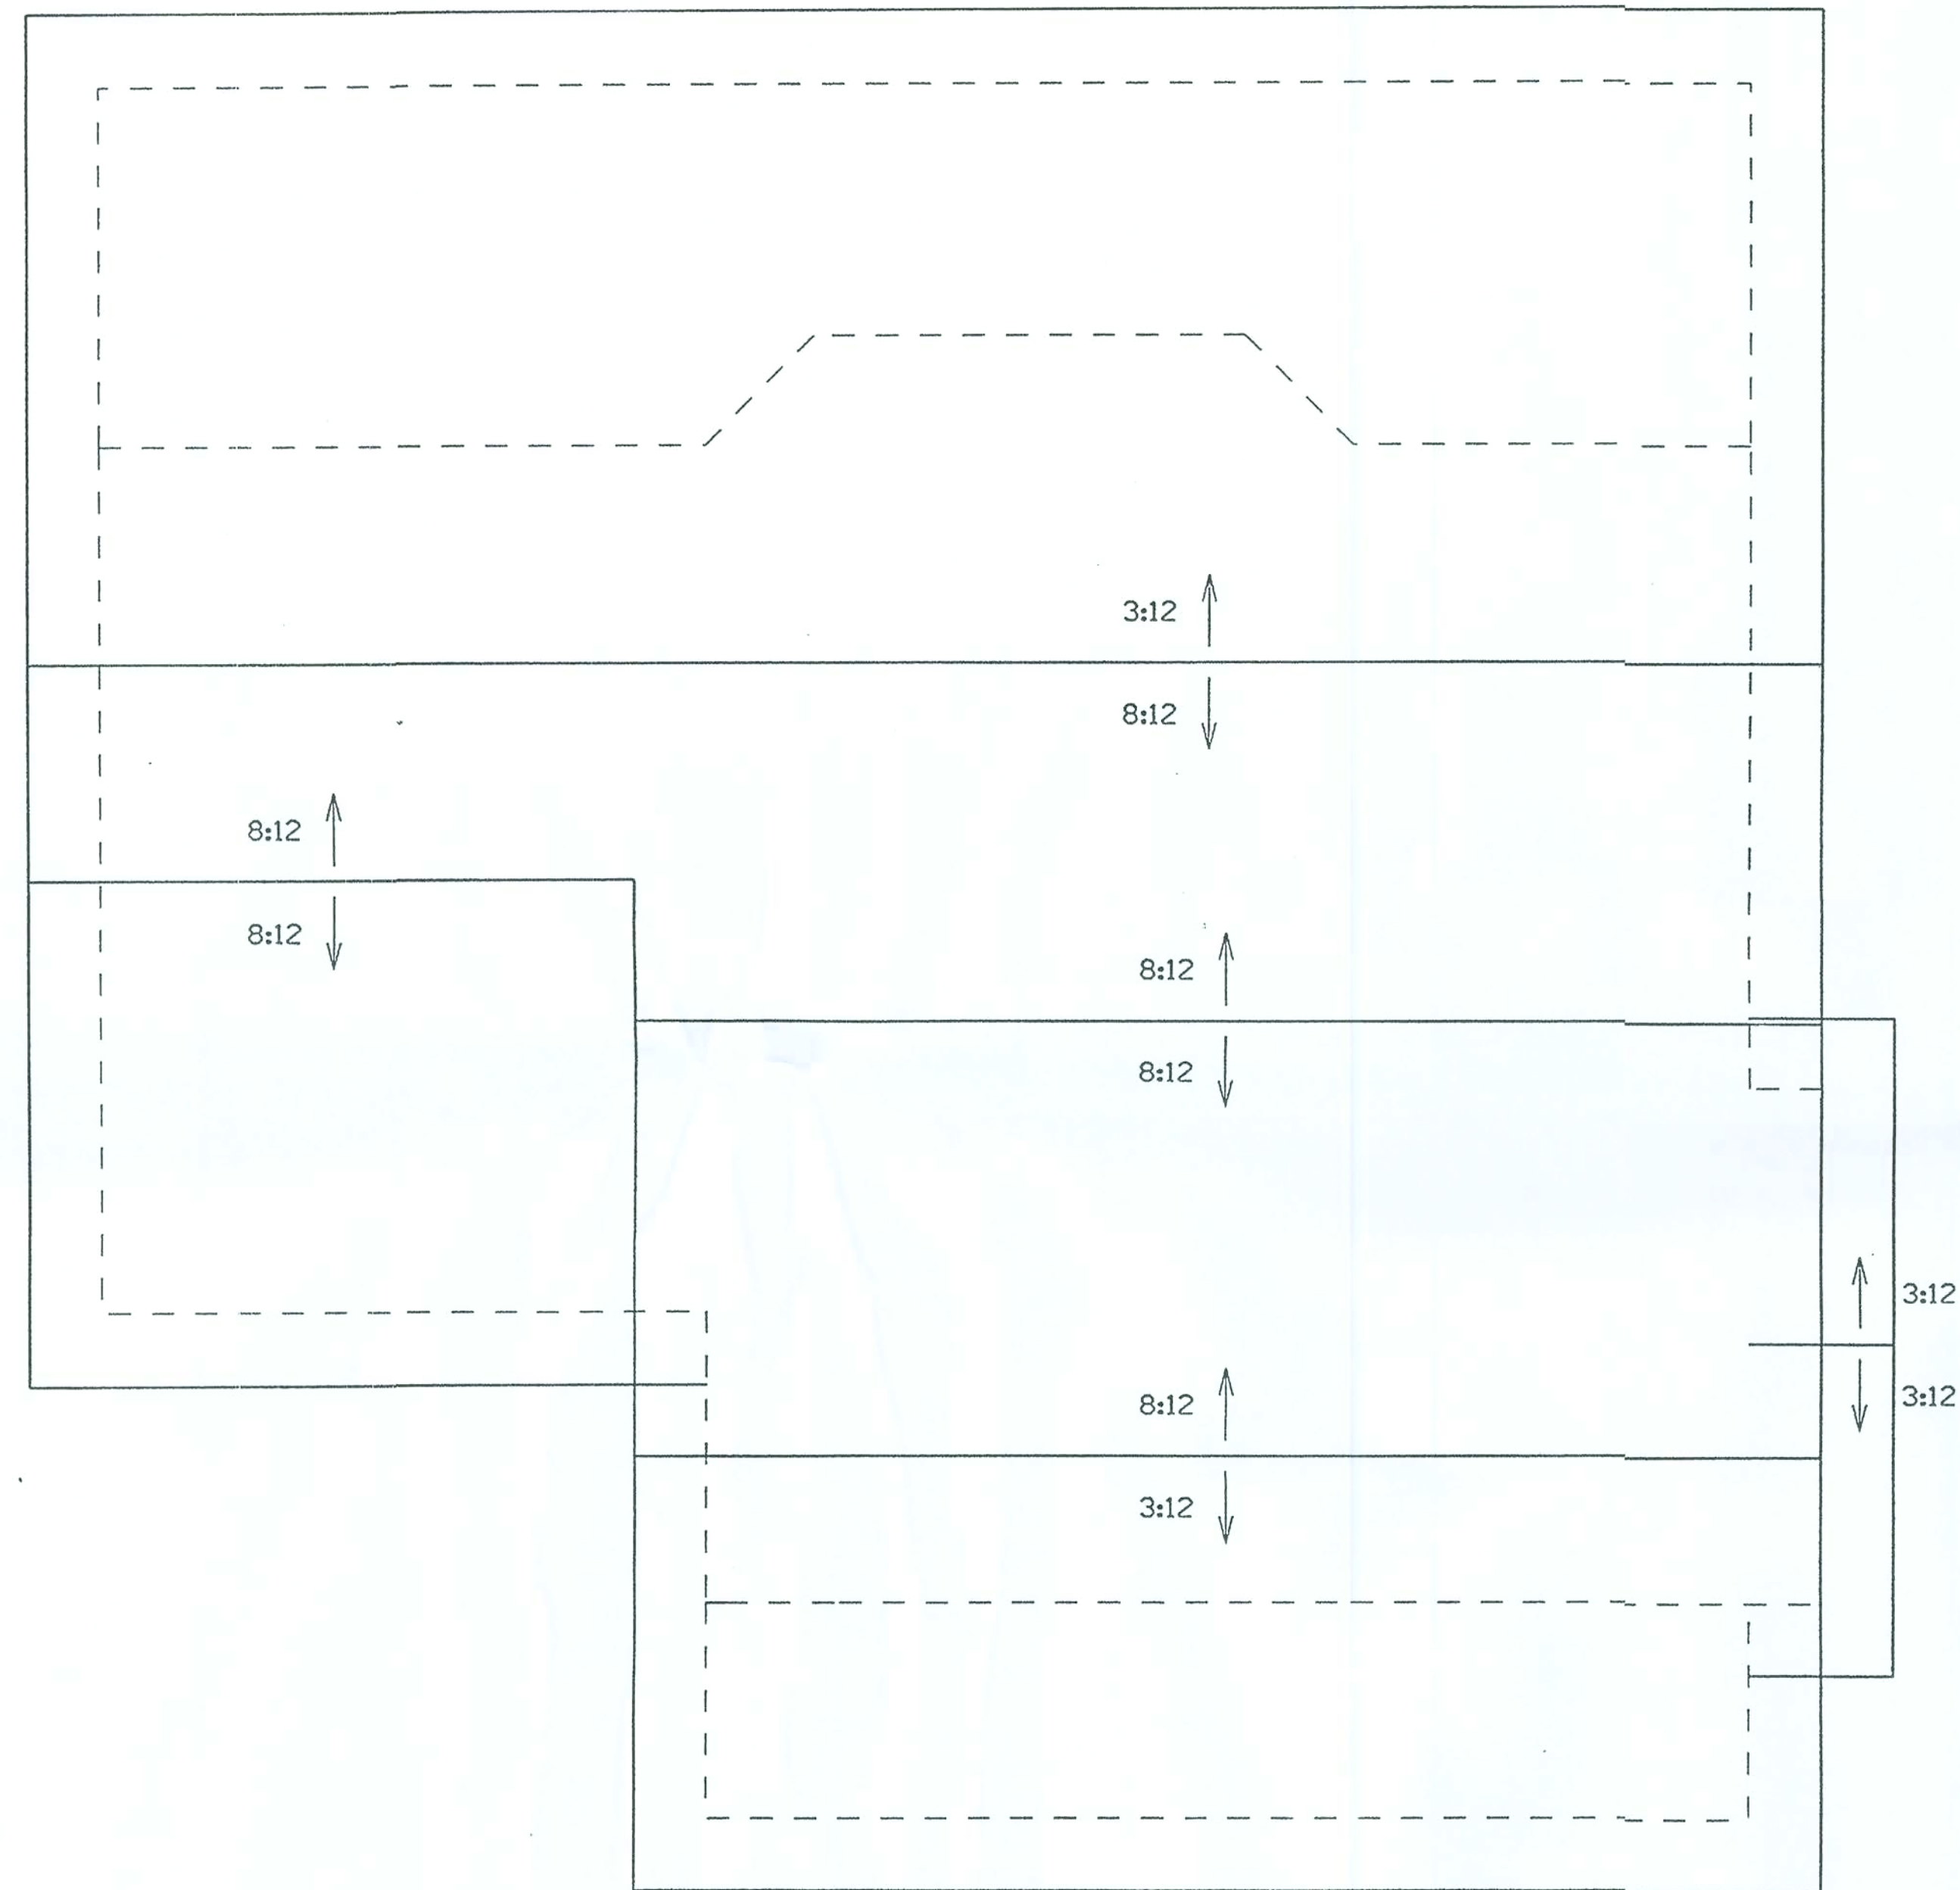

ROOF PLAN

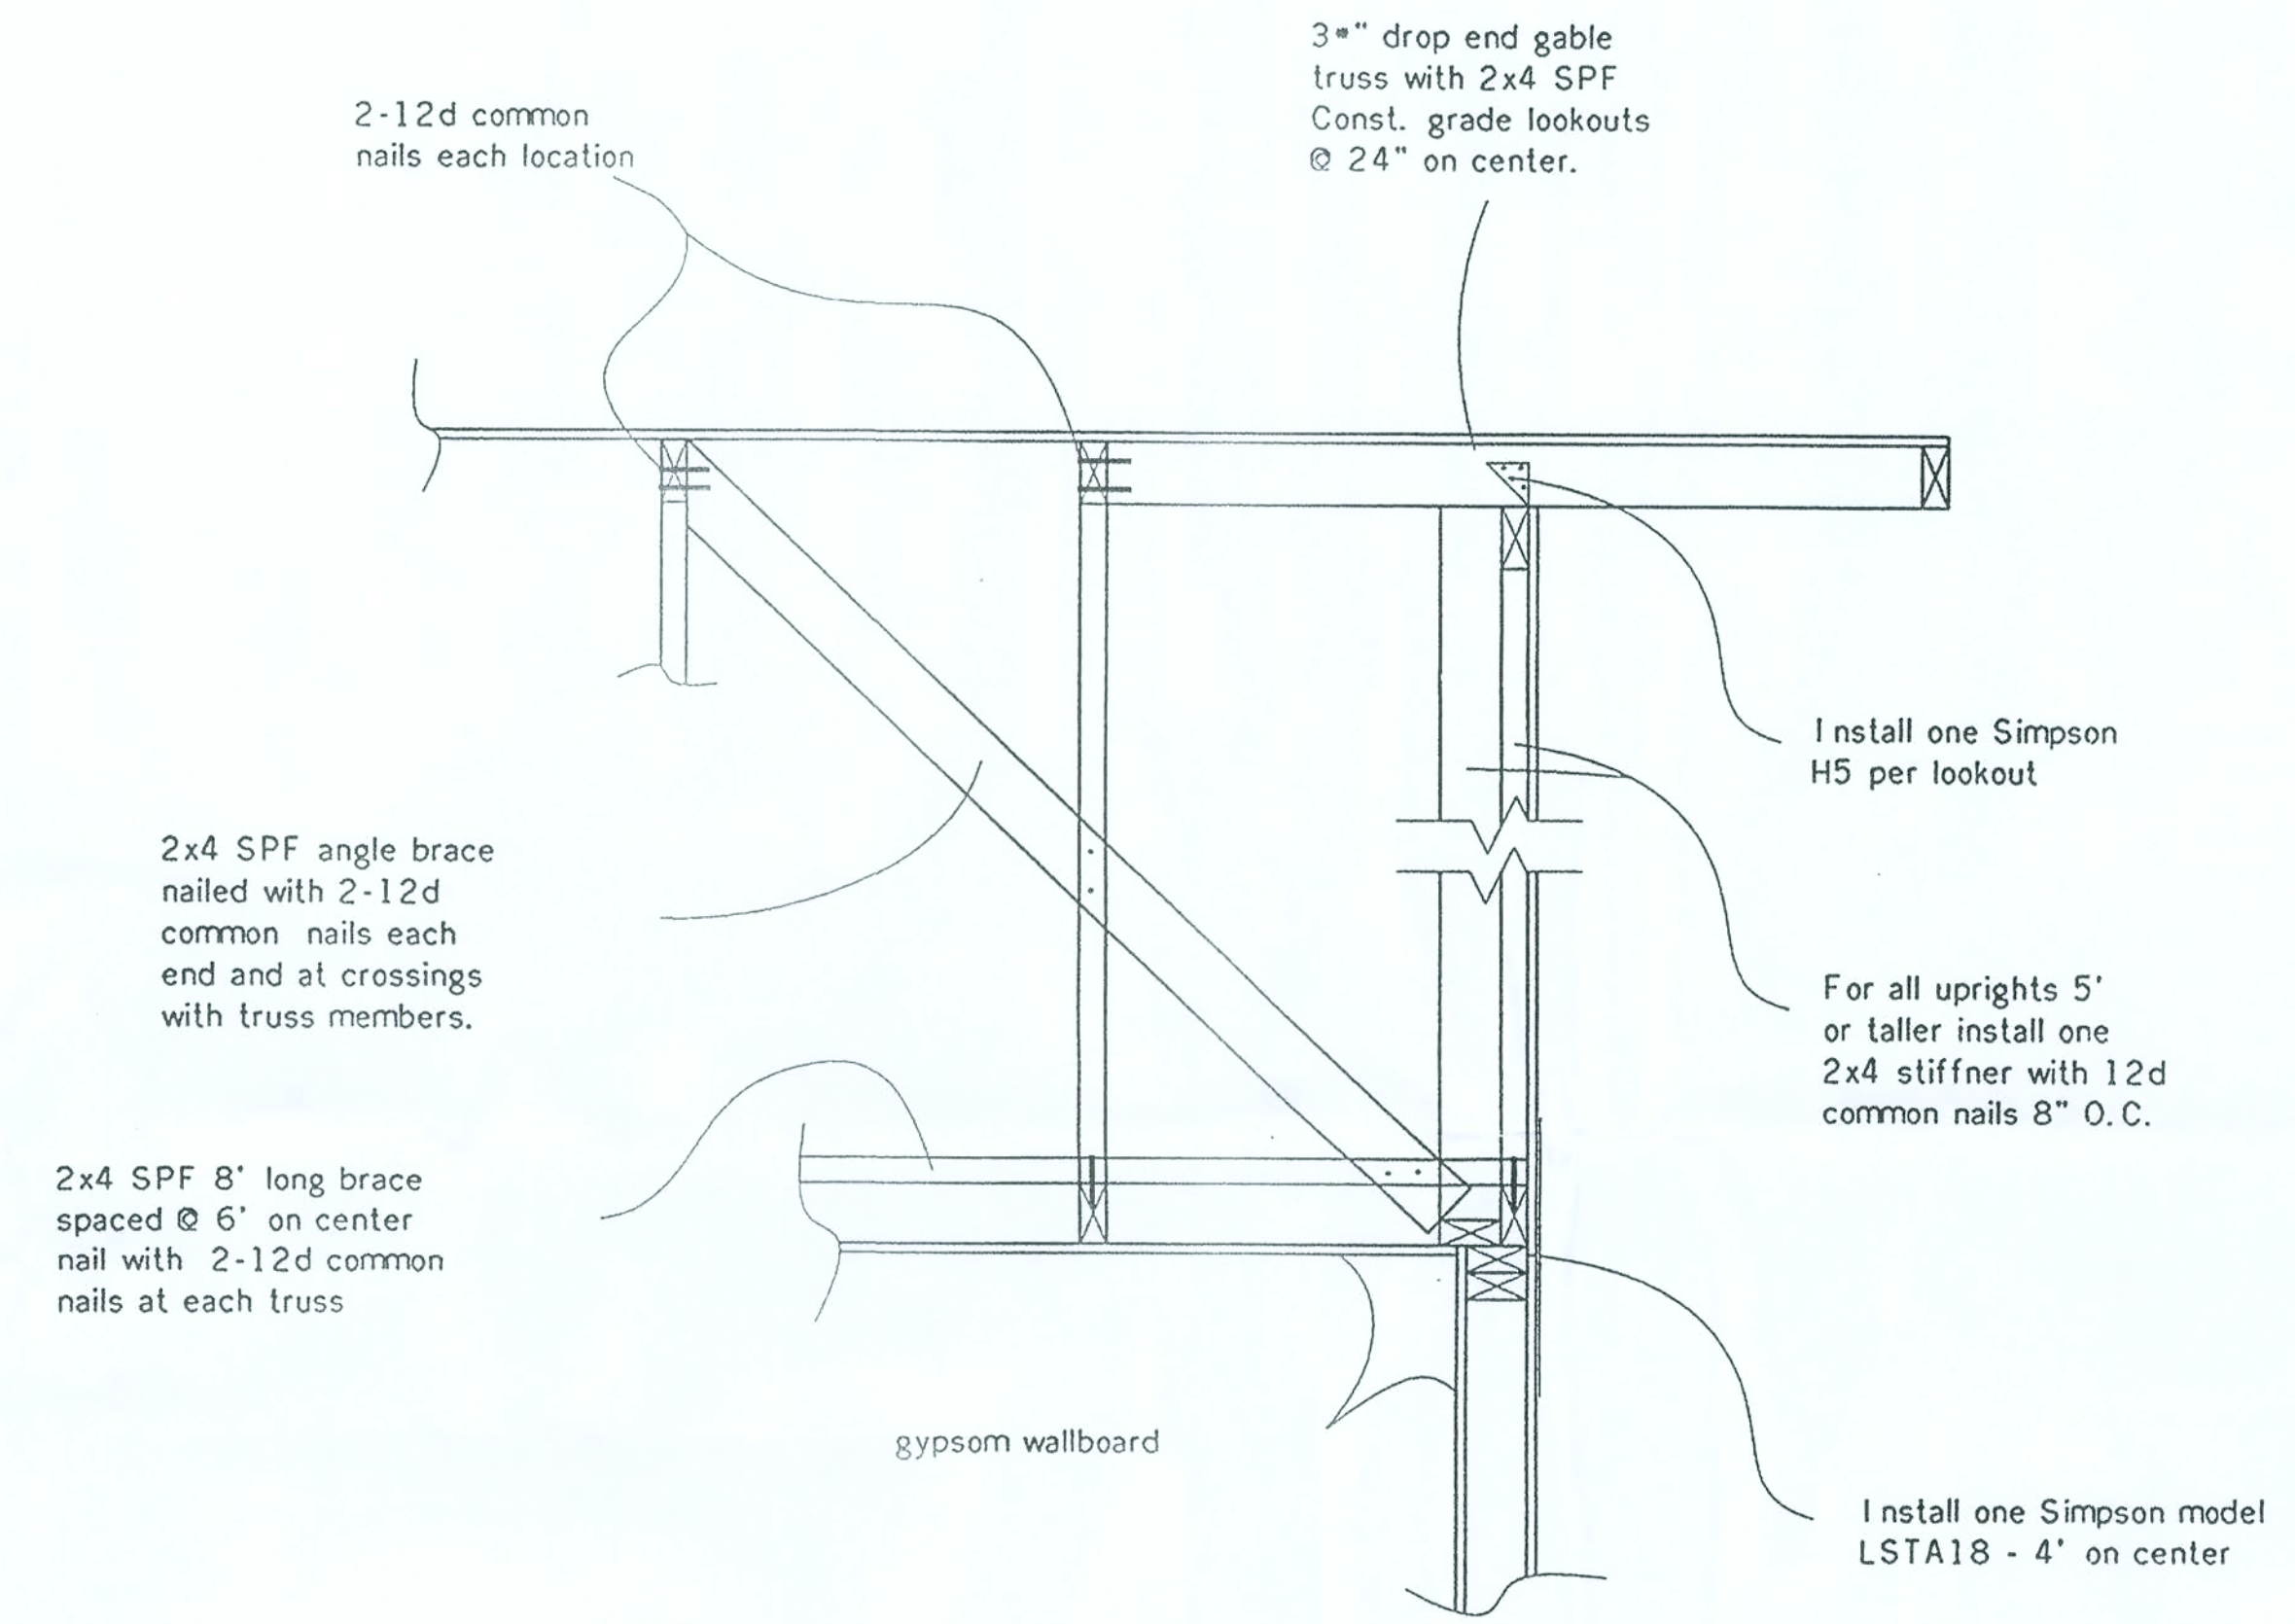


GABLE END BRACING
DETAIL (N.T.S.)

PLANS PREPARED BY:
CHRISTOPHER Q. DICKS
4035 SE CR 252, LAKE CITY, FL 32025

HAMPTON RESIDENCE
COLUMBIA COUNTY, FLORIDA

SHEET
6
OF
8

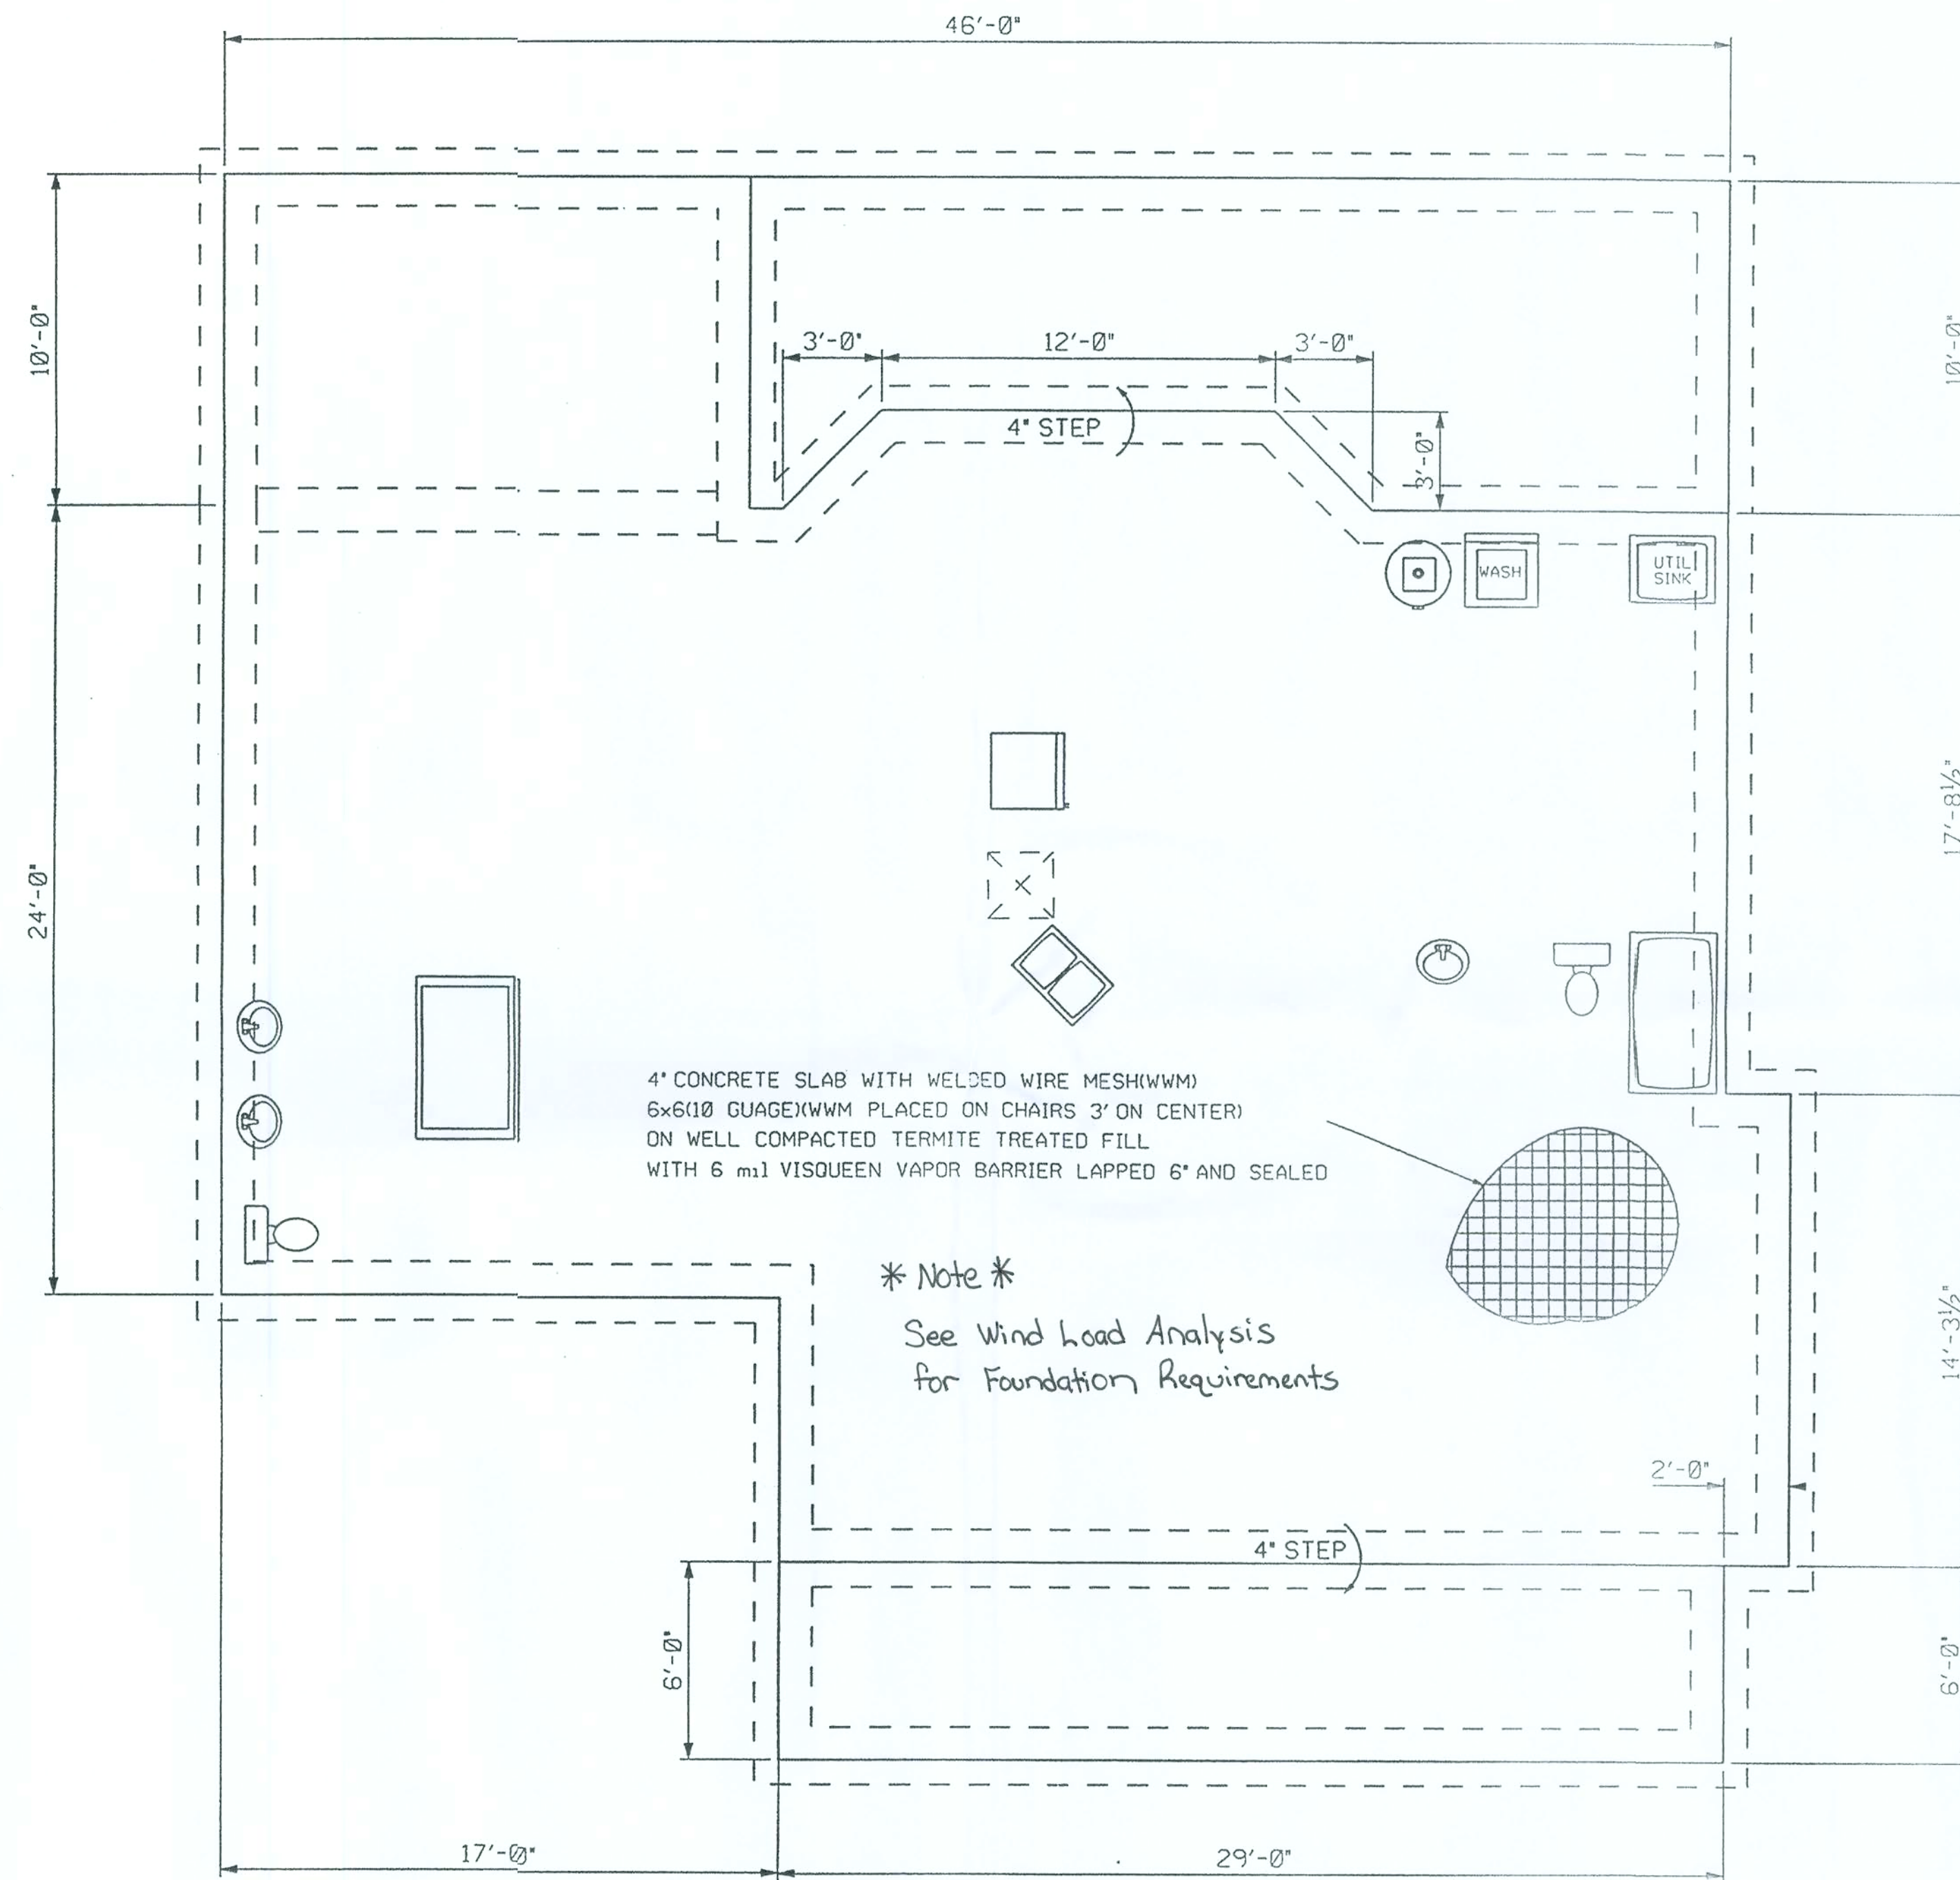

FOUNDATION & PLUMBING PLAN


0 4' 8'
scale

PLANS PREPARED BY:
CHRISTOPHER Q. DICKS
4035 SE CR 252, LAKE CITY, FL 32025

HAMPTON RESIDENCE
COLUMBIA COUNTY, FLORIDA


SHEET
7
OF
8

ELECTRICAL LEGEND

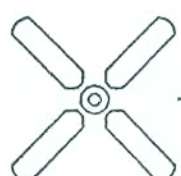
-  - CEILING FAN w LIGHTS
-  - LIGHT FIXTURE
-  - SINGLE POLE SWITCH
-  - THREE-WAY SWITCH
-  - RECEPT.
-  - GFI RECEPT OR PART OF A GFI CIRCUIT.
-  - SECURITY LIGHT
-  - EXHAUST WITH LIGHT
-  - 220 V.
-  - SMOKE DETECTOR (AC/DC and interconnected)
-  - TELEPHONE AND RG6 COAX

NOTES:

- 1.) ALL EXTERIOR RECEPTACLES SHALL BE WEATHERPROOF.
- 2.) ALL BEDROOM RECPTS SHALL BE PART OF AN AFCI CIRCUIT. EACH BEDROOM SHALL BE ON AN INDIVIDUAL AFC CIRCUIT.

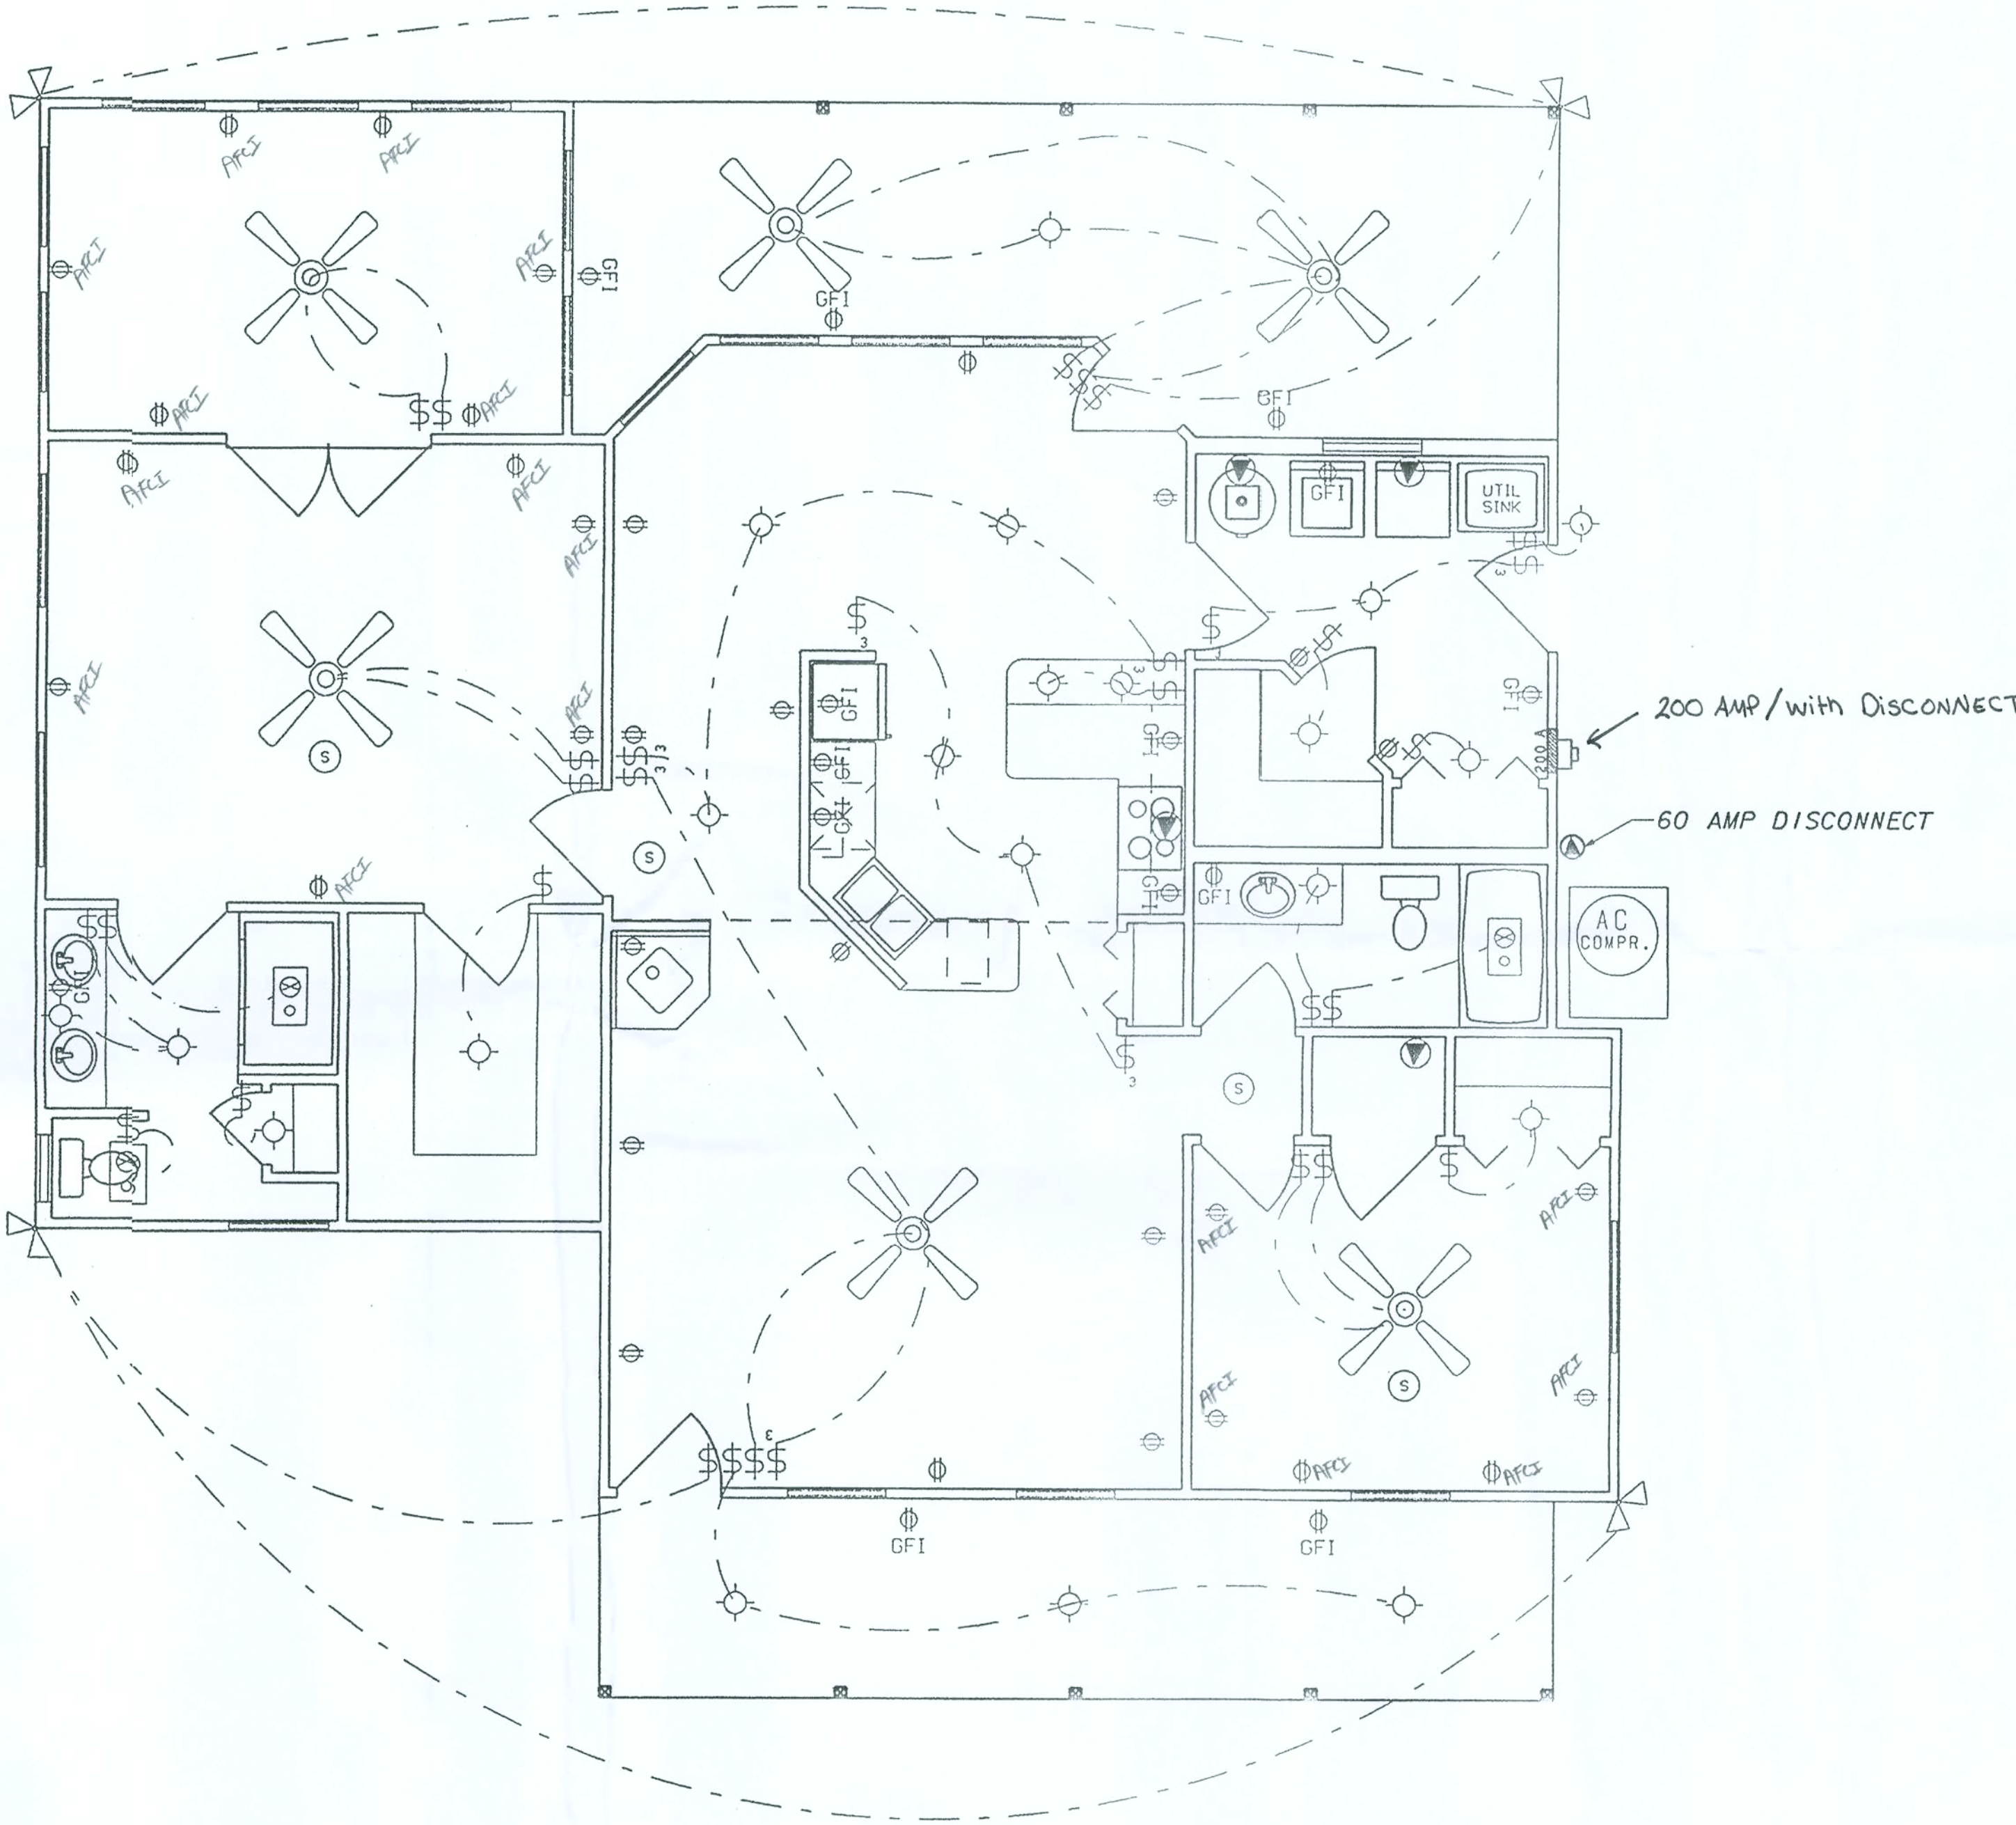

ELECTRICAL PLAN

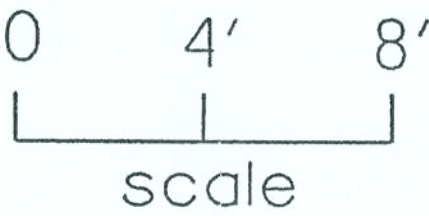

PLANS PREPARED BY:
CHRISTOPHER Q. DICKS
4035 SE CR 252, LAKE CITY, FL 32025

HAMPTON RESIDENCE
COLUMBIA COUNTY, FLORIDA

SHEET
8
OF
8