


\\Server3\engprojects\City Electric Lake City\Plan Sets\02-20-12 BID SET\01121\j.dwg - C6.10 - FDOT MOT

Plotted Feb. 20, 2012 - 11:25:55 - Tim Rodwell

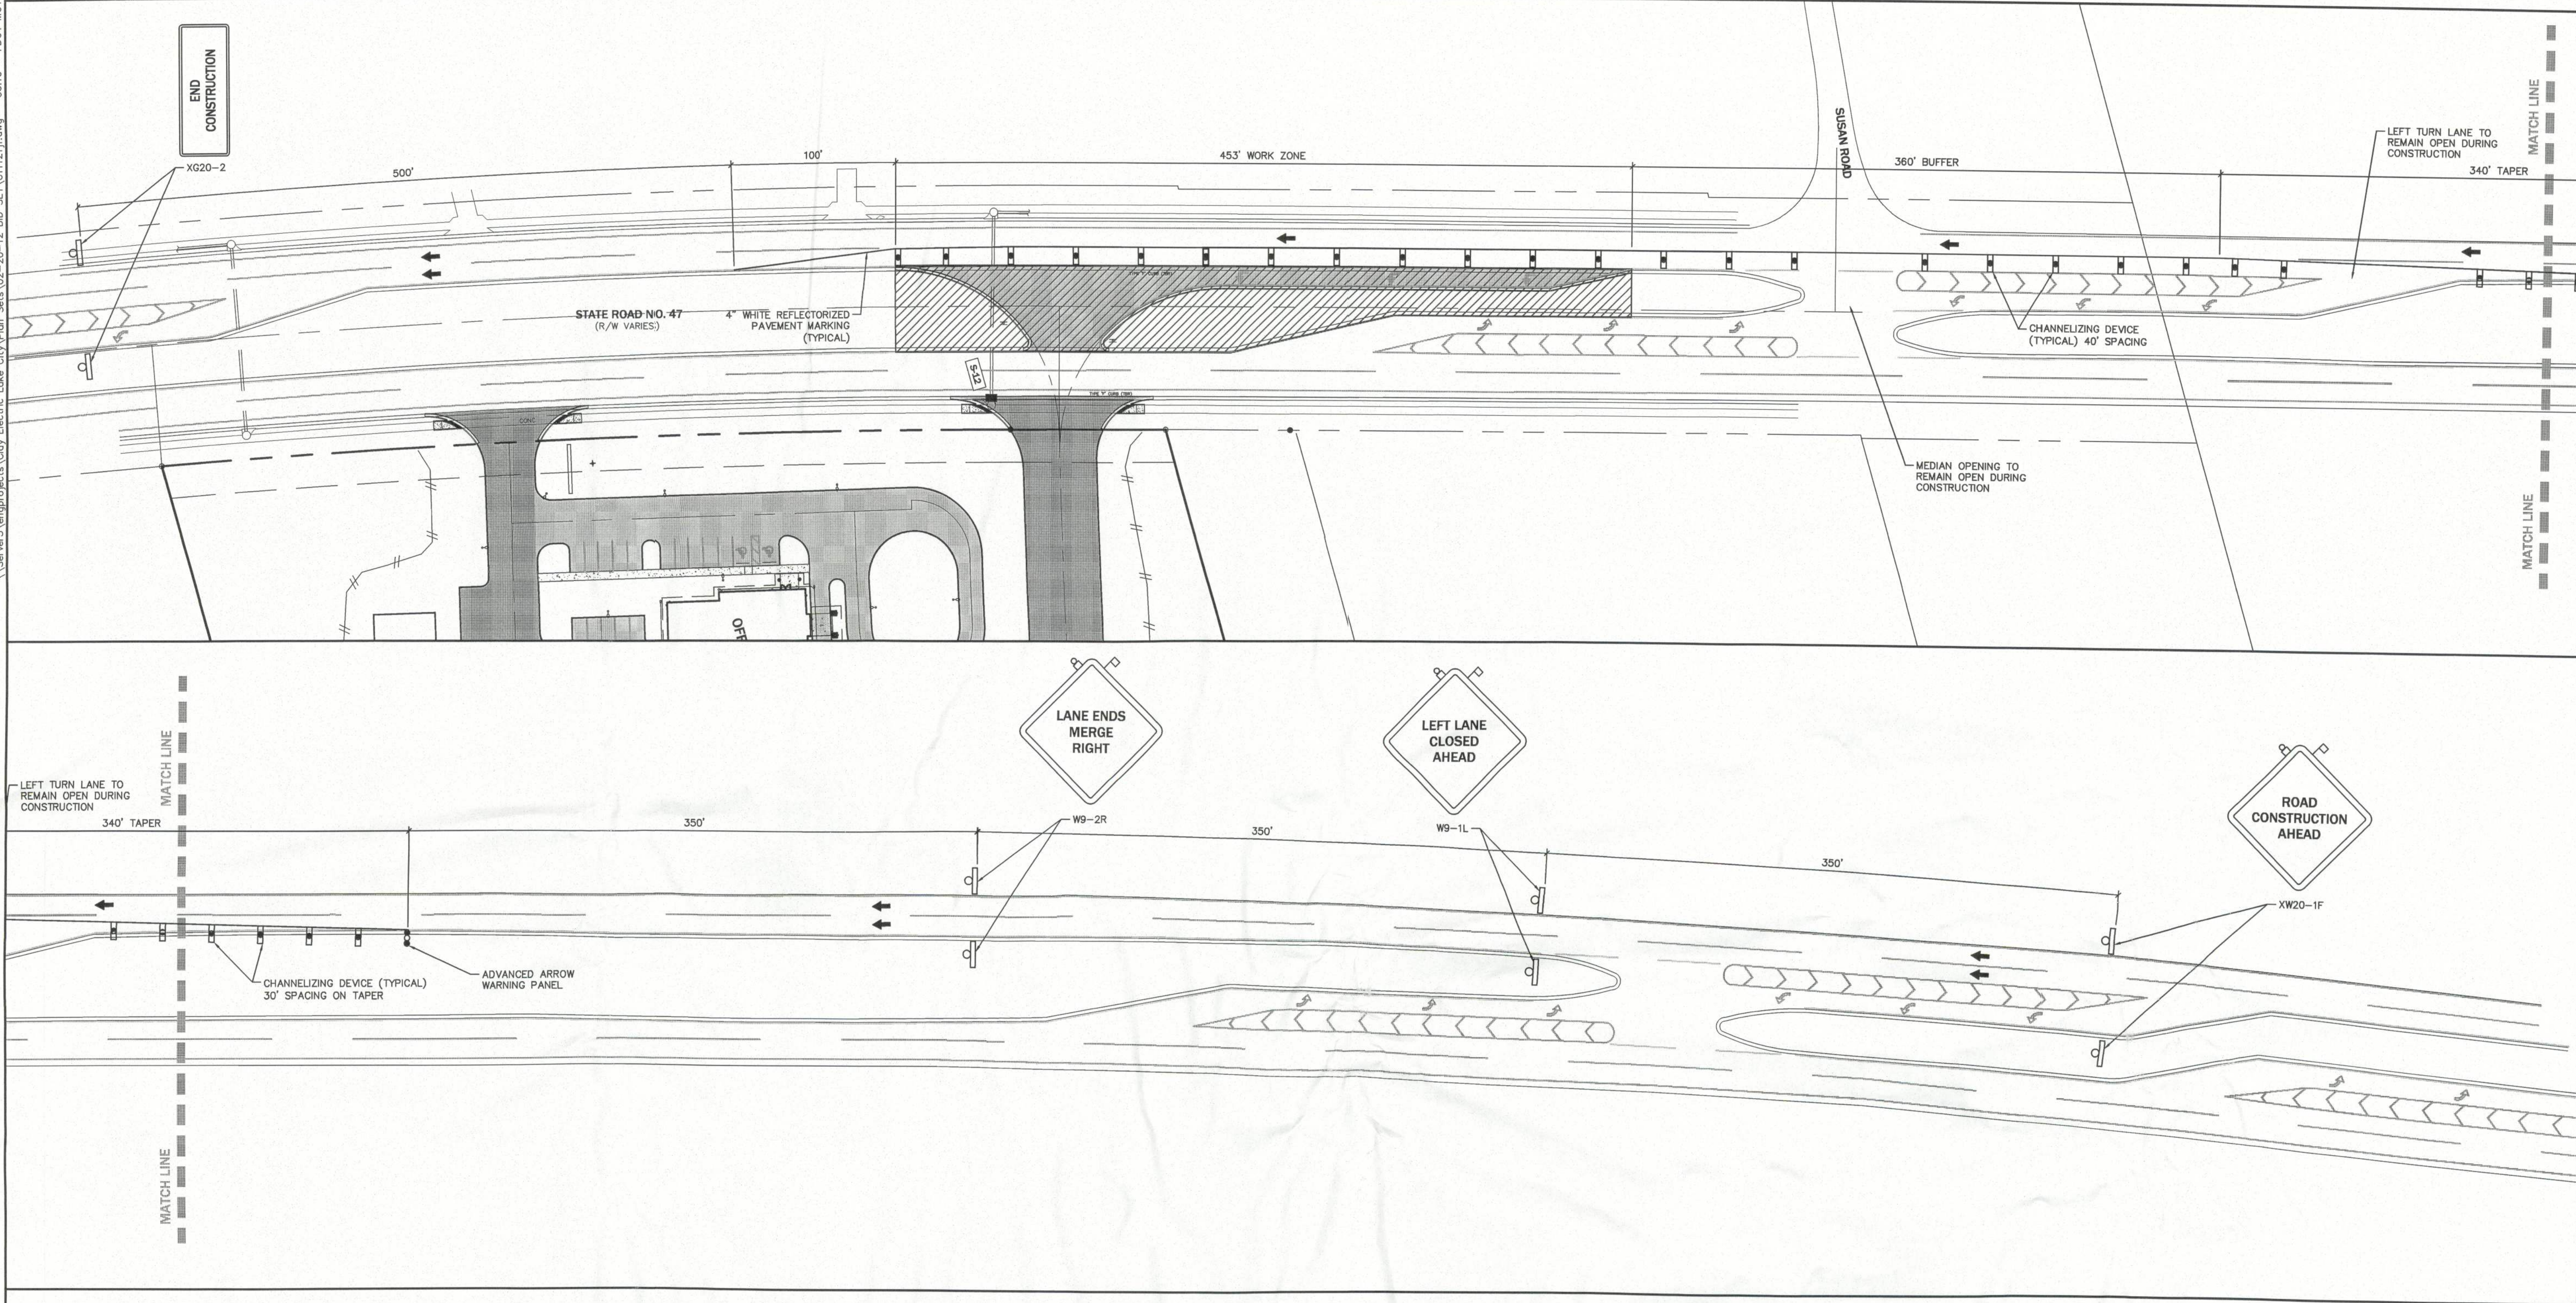

MAINTENANCE OF TRAFFIC GENERAL NOTES

1. ALL MAINTENANCE OF TRAFFIC PLANS MUST BE PERFORMED IN ACCORDANCE WITH FDOT INDEX 613 STANDARDS AND SPECIFICATIONS.
2. CONTRACTOR SHALL SUBMIT MAINTENANCE OF TRAFFIC PLANS TO ENGINEER FOR APPROVAL PRIOR TO PLACING ANY CLOSURES.

SEQUENCE OF OPERATIONS

1. CLOSE INSIDE LANE OF SOUTHBOUND STATE ROAD STATE ROAD 47.
2. CONSTRUCT PROPOSED TURN LANE.
3. MAINTAIN BOTH LANES OF TRAFFIC ON SOUTHBOUND STATE ROAD 47.

LEGEND

- LIMITS OF LANE CLOSURE PER FDOT INDEX 613
- SIGN WITH 18" x 18" (MIN.) ORANGE FLAG AND TYPE B LIGHT
- TYPE I OR TYPE II BARRICADE OR VERTICAL PANEL OR DRUM (WITH STEADY BURNING LIGHT AT NIGHT ONLY)
- WORK ZONE SIGN
- ADVANCE WARNING ARROW PANEL
- TYPE I, TYPE II OR TYPE III BARRICADE OR VERTICAL PANEL OR DRUM (WITH FLASHING LIGHT)

Project:		BID SET		Drawn: TAR	
Designed: SUR		Project No: 11-121		Date: 02/17/12	
Professional Engineer of Record:				Professional Engineer of Record:	
Sergio J. Reyes, P.E.				47311	
Engineer				Certificate No.	
Sheet No.: C6.10					

CLAY ELECTRIC COOPERATIVE
LAKE CITY DISTRICT OFFICE
COLUMBIA COUNTY, FLORIDA

S.R. 47 IMPROVEMENTS
MAINTENANCE OF TRAFFIC PLAN

WDA

ENG. DENMAN & ASSOCIATES, INC.
ENGINEERS - SURVEYORS - PLANNERS
872899 FLORIDA 35064-6602
2404 N.W. 134th ST. CANAL FLORIDA
TEL. (352) 375-3541 FAX. (352) 375-7249
E-MAIL: denman@denmaninc.net

NORTH

SCALE: 1" = 20'

20 10 0 20

GRAPHIC SCALE

No.	Date	REVISION	Comment
1.	2/10/12	A	

NOT FOR CONSTRUCTION