


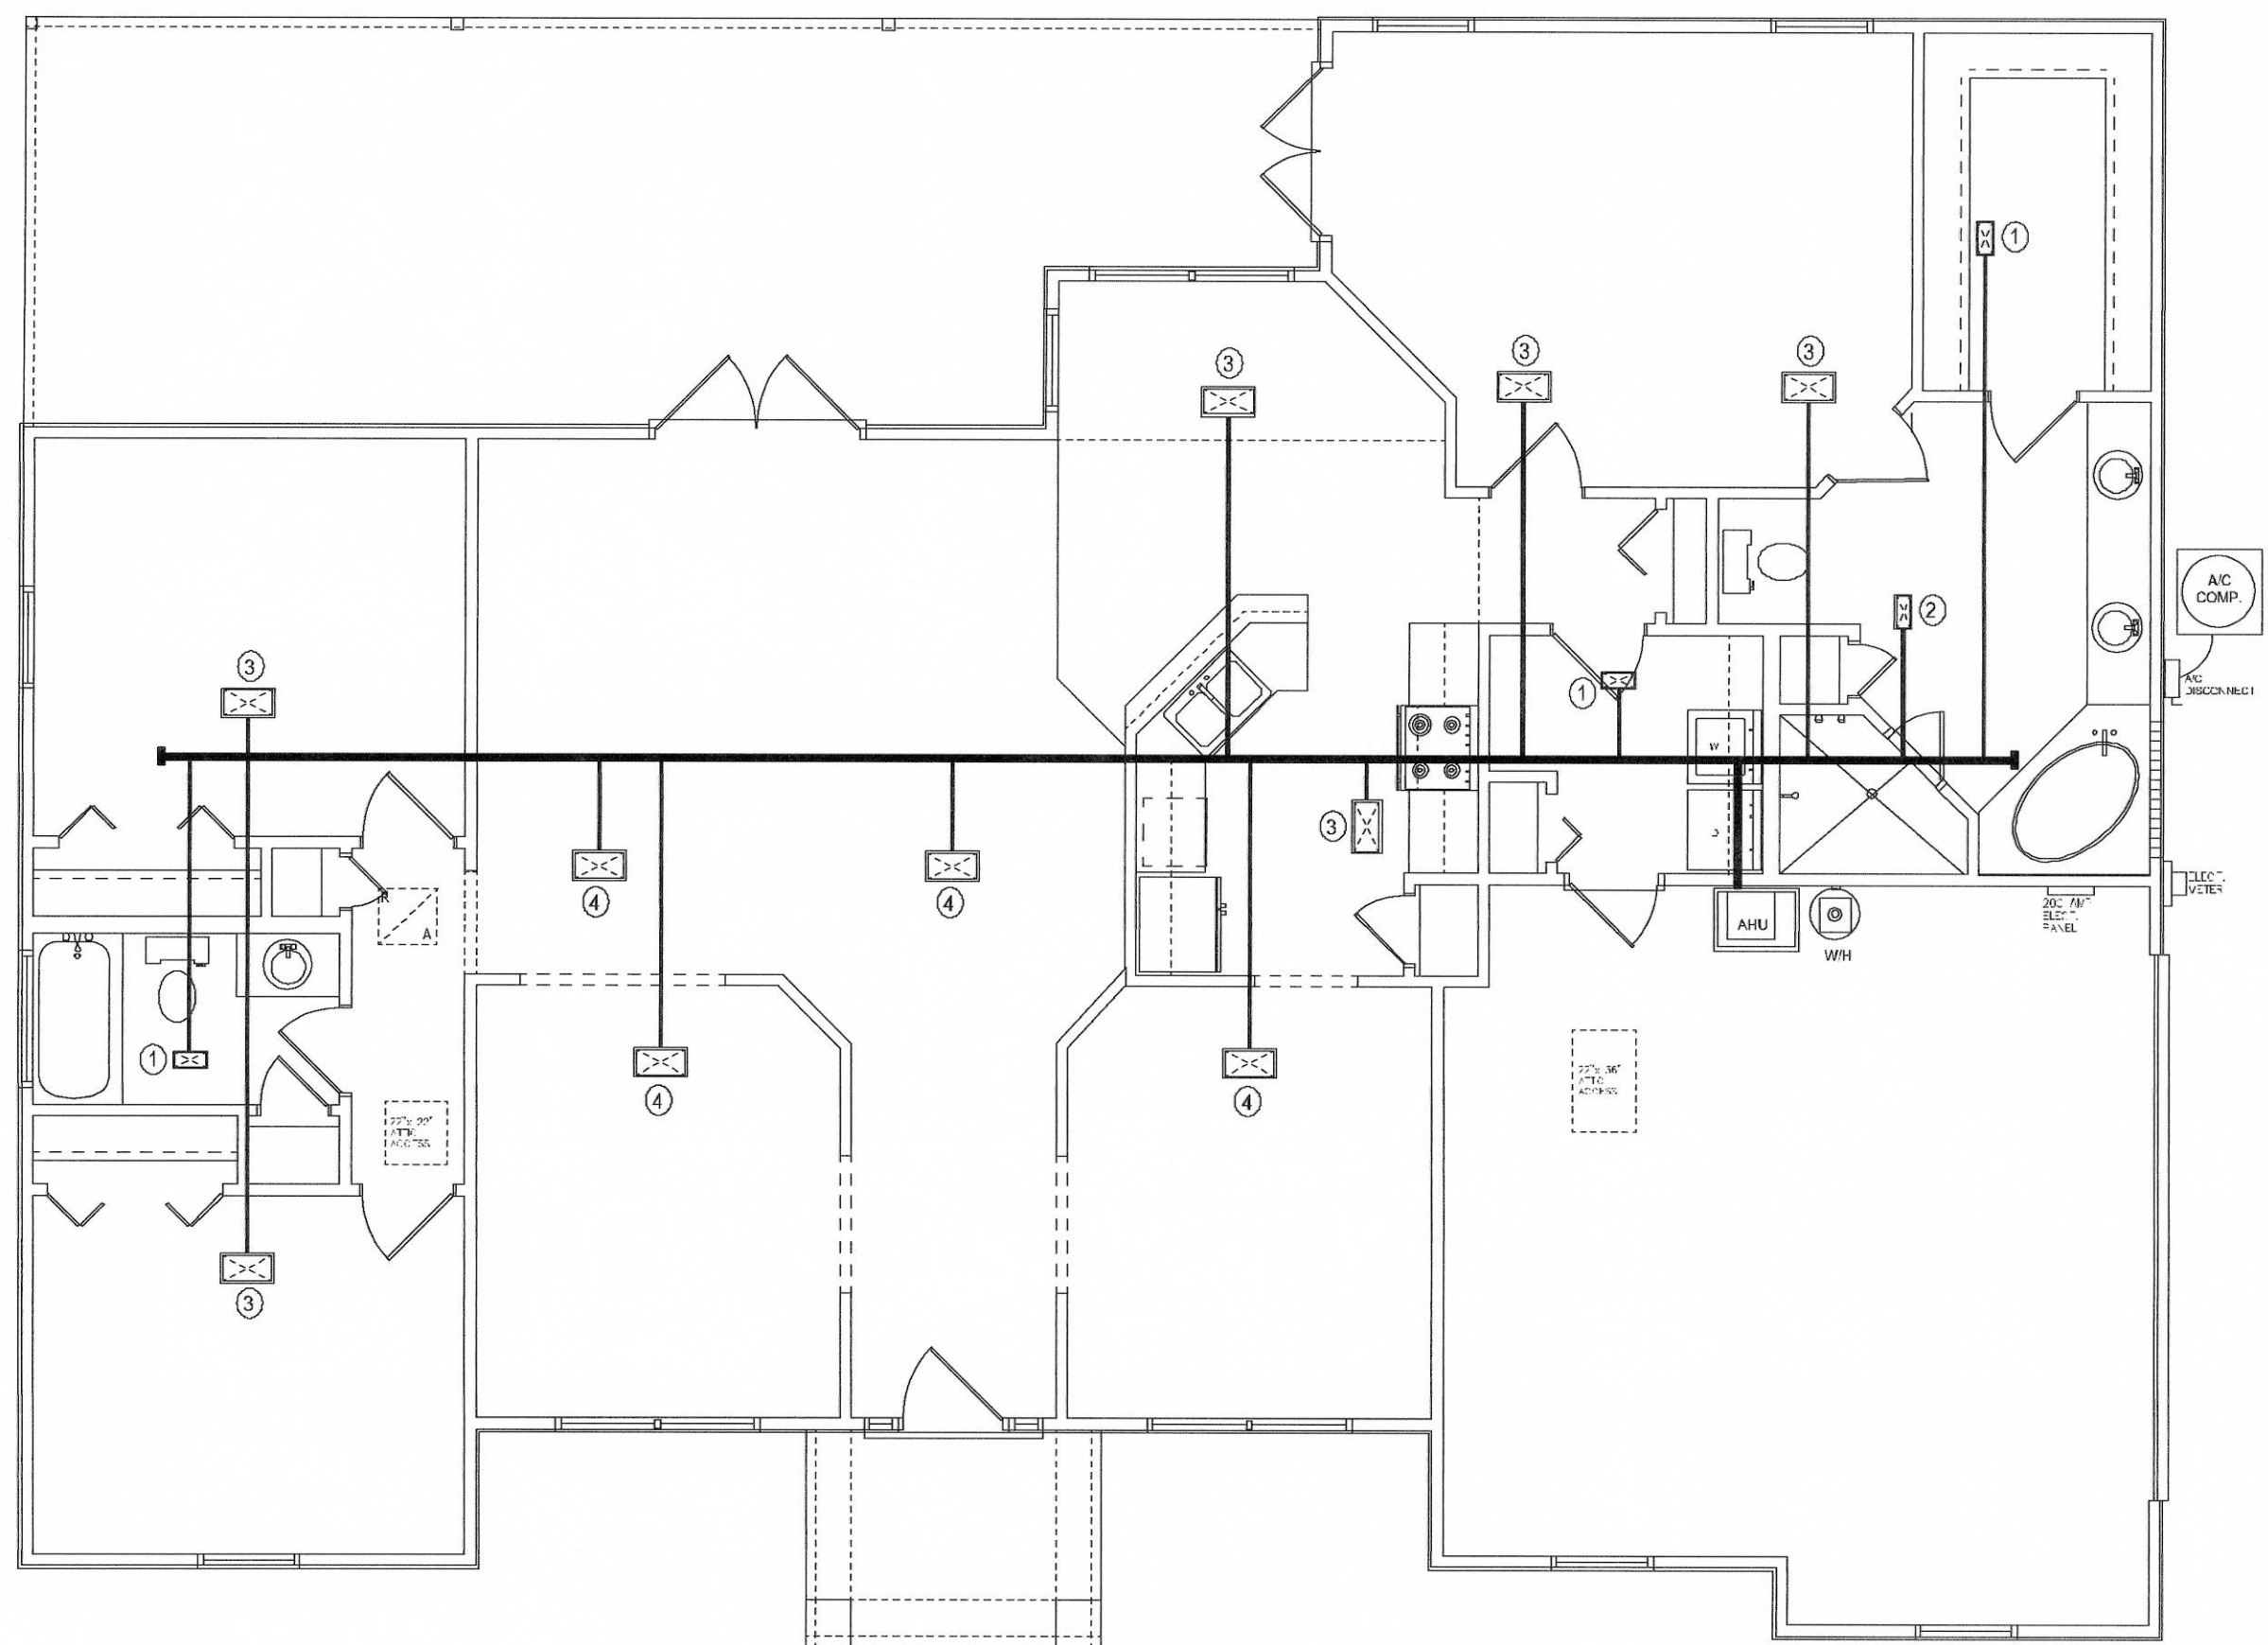


**HVAC PLAN**  
SCALE: 3/16" = 1'-0"

RETURN AIR SYSTEM TO BE  
SIZED BY A/C CONTRACTOR

| HVAC GRILLE SCHEDULE |          |         |     |  |
|----------------------|----------|---------|-----|--|
| MARK                 | SIZE     | DIAM.   | CFM |  |
| ①                    | 4" X 8"  | 4" FLEX | 55  |  |
| ②                    | 6" X 10" | 6" FLEX | 95  |  |
| ③                    | 6" X 10" | 8" FLEX | 130 |  |
| ④                    | 6" X 12" | 6" FLEX | 150 |  |
| ⑤                    | 6" X 12" | 8" FLEX | 175 |  |
| ⑥                    | 7" X 12" | 8" FLEX | 230 |  |

ALL DUCTS AND GRILLES DESIGNED IN  
ACCORDANCE WITH ACCA MANUAL D

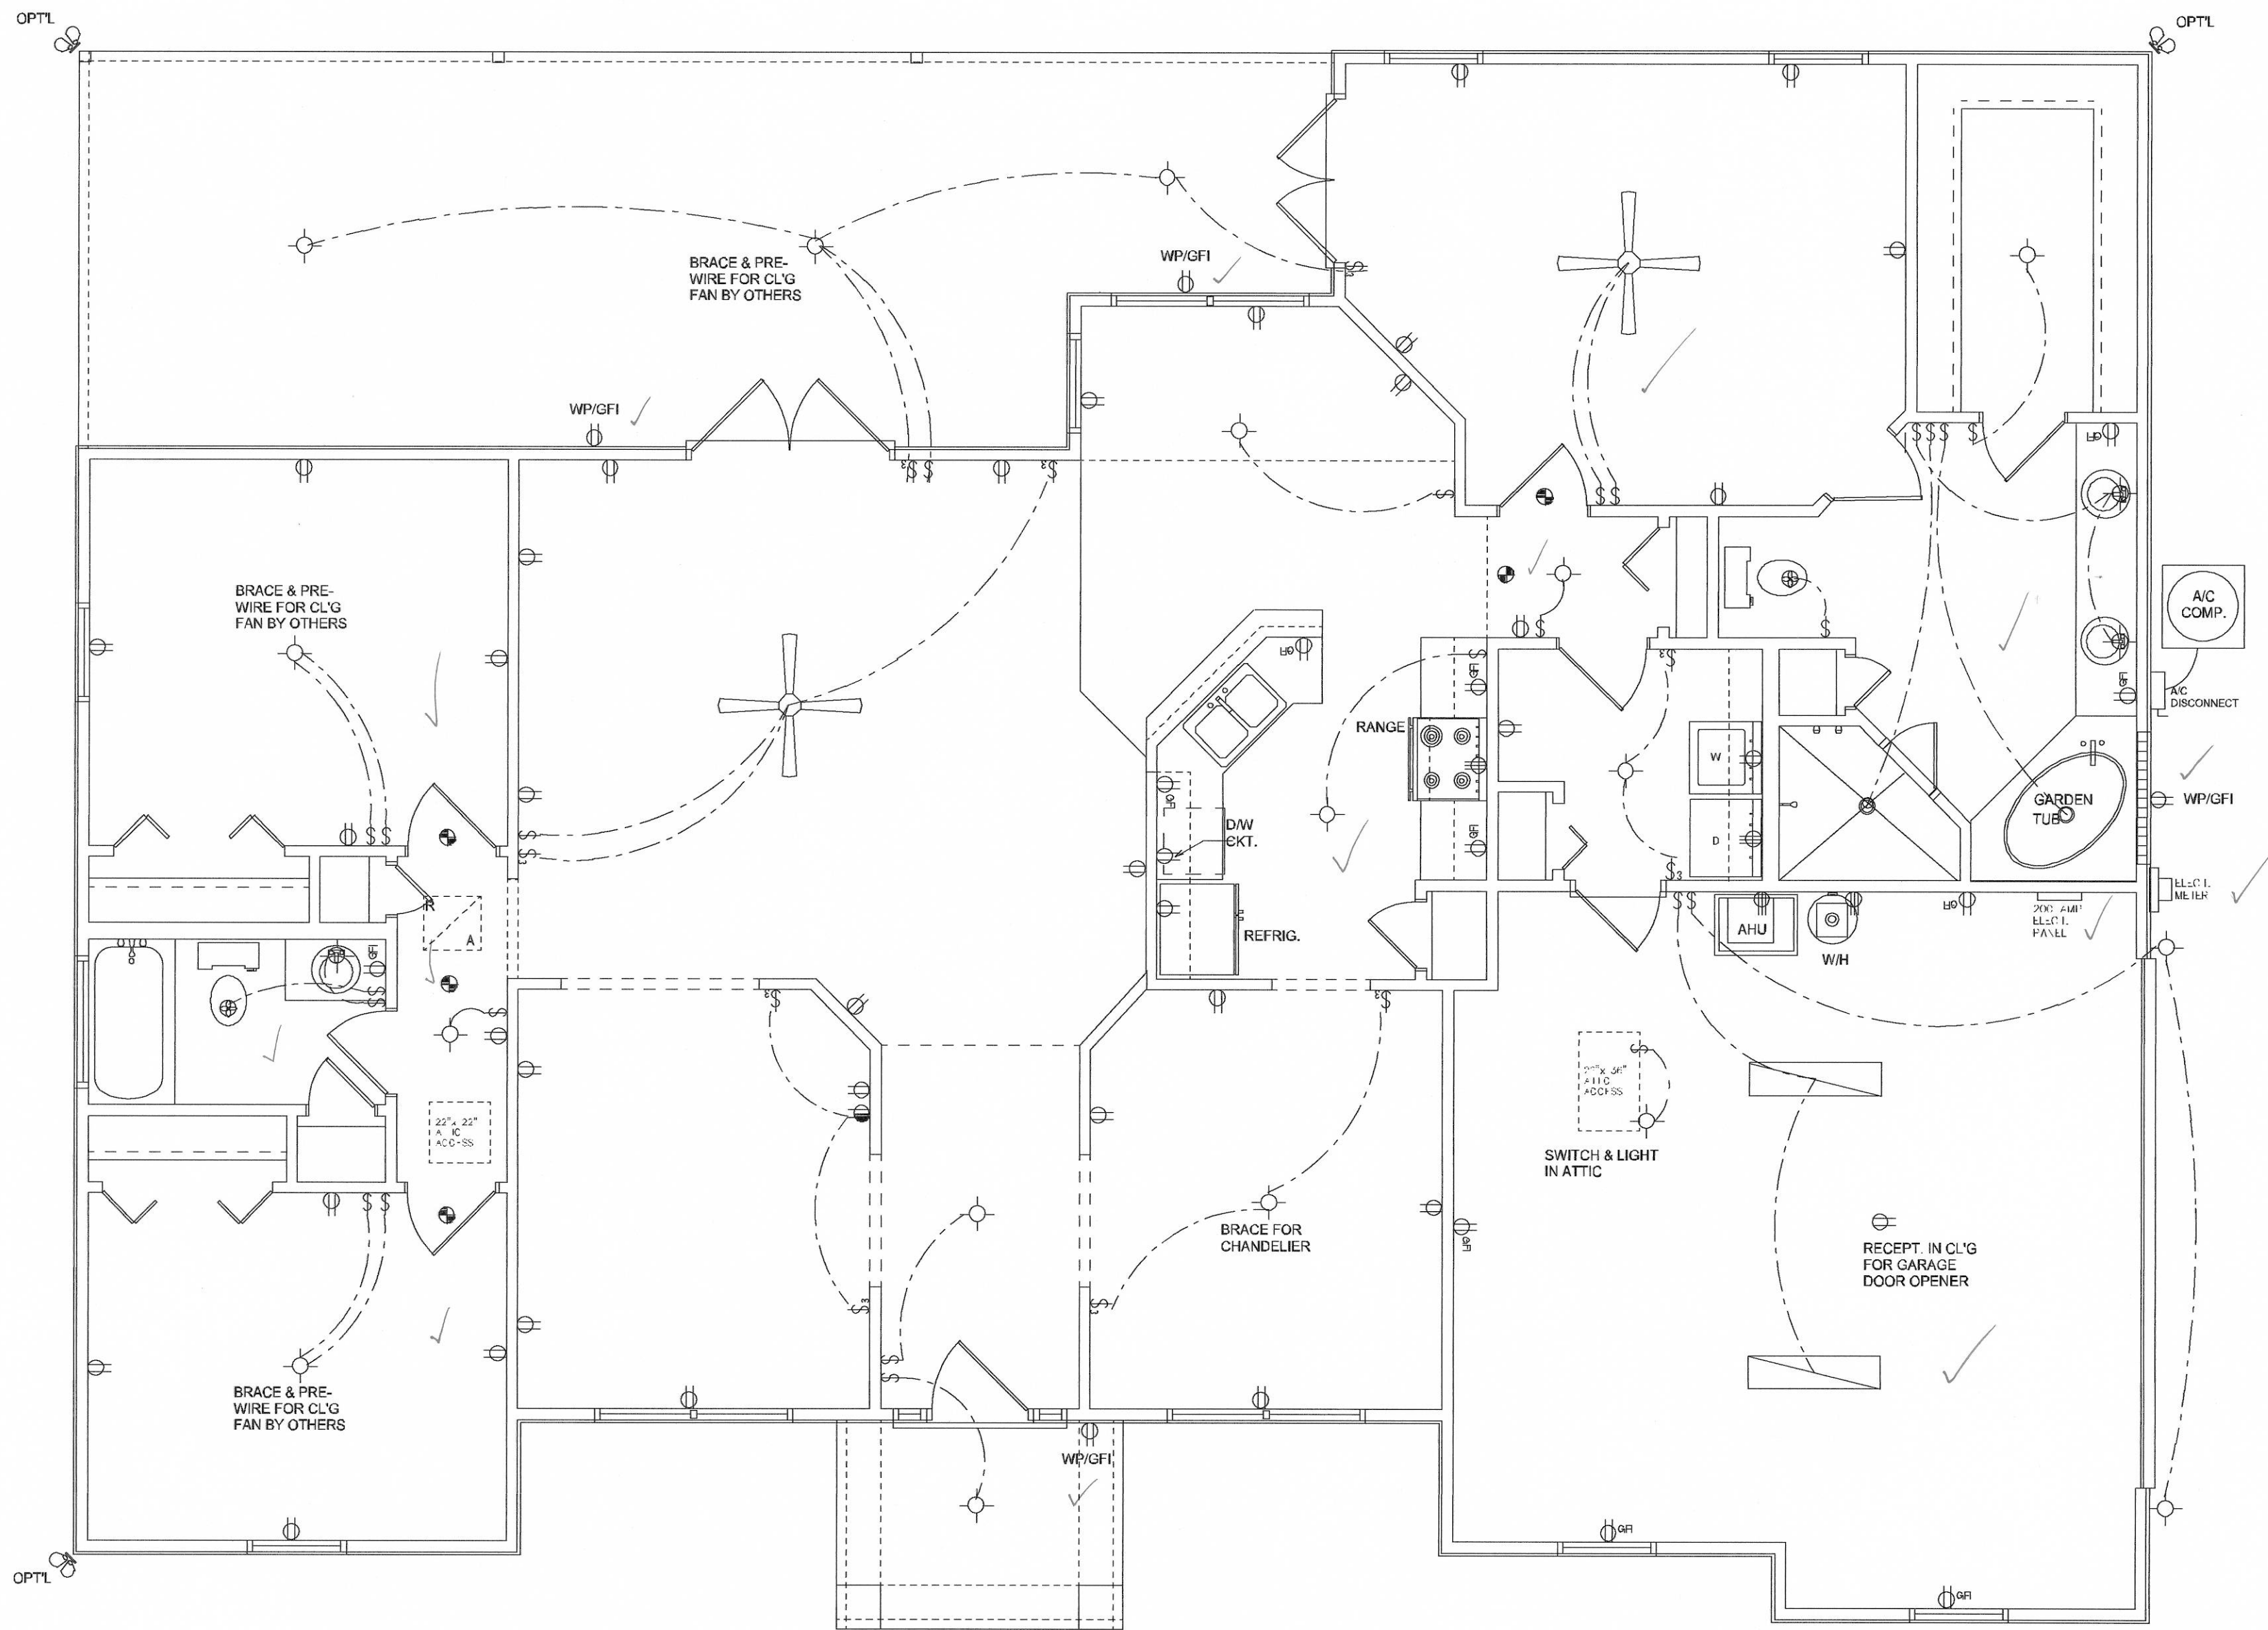

**ELECTRICAL PLAN**  
SCALE: 1/4" = 1'-0"

| ELECTRICAL LEGEND |                                            |
|-------------------|--------------------------------------------|
|                   | CEILING FAN<br>(PRE-WIRE FOR LIGHTS - 4IT) |
|                   | DOUBLE SECURITY                            |
|                   | RECESSED CAN LIGHT                         |
|                   | BATH EXHAUST FAN                           |
|                   | LIGHT SWITCH                               |
|                   | DUPLEX OUTLET                              |
|                   | 220V OUTLET                                |
|                   | GFI DUPLEX OUTLET                          |
|                   | SMOKE DETECTOR                             |
|                   | WALL SWITCH                                |
|                   | 3 WAY WALL SWITCH                          |
|                   | WATER PROOF GFI OUTLET                     |
|                   | 2 OR 4 TUB FLUORESCENT LIGHT               |

NOTE:  
ALL BEDROOM RECEPTS SHALL BE AFCI  
(ARC FAULT CIRCUIT INTERRUPT)  
ALL SMOKE DETECTORS SHALL HAVE BATTERY BACKUP POWER  
AND ALL WIRING TOGETHER SO IF ANY ONE UNIT IS ACTUATED THEY  
ALL ACTIVATE.

| REVISIONS         |
|-------------------|
| February 24, 2004 |


**SOFTPLAN**  
ARCHITECTURAL DESIGN SOFTWARE

**ELECTRICAL PLAN**  
SCALE: 1/4" = 1'-0"

**HVAC PLAN**  
SCALE: 3/16" = 1'-0"

THE EVERGREEN MODEL FOR:  
**AARON SIMQUE HOMES, INC.**  
PROJECT ADDRESS: LOT 86, CALLAWAY UNIT III, COLUMBIA COUNTY FLORIDA

©WILLIAM MYERS  
**DESIGN**  
P.O. BOX 1513  
LAKE CITY, FL 32056  
(386) 758-8406  
wlm@williamyers.net

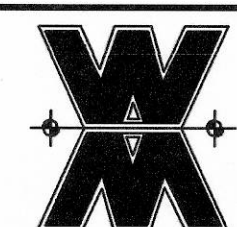

JOB NUMBER  
**040212**

SHEET NUMBER  
**A4**  
OF 4 SHEETS

*Wm Myers*