



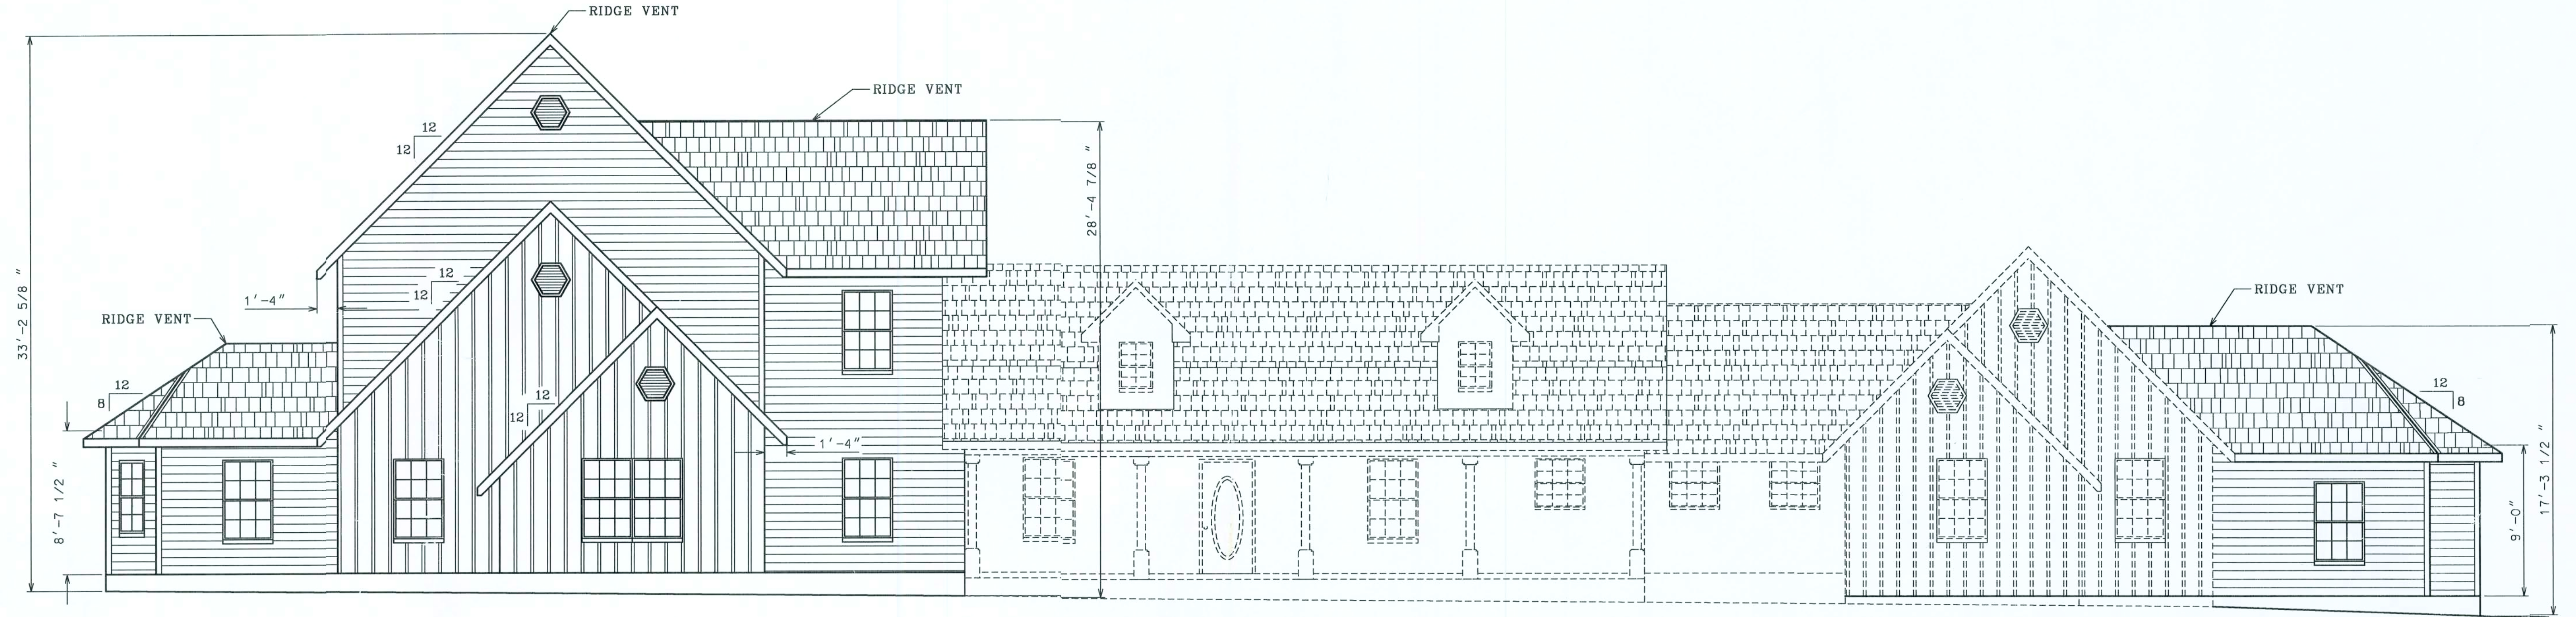

NOTE: SOLID LINES INDICATE PROPOSED CONSTRUCTION. ———
DASHED LINES INDICATE EXISTING HOME. - - - - -

FRONT ELEVATION

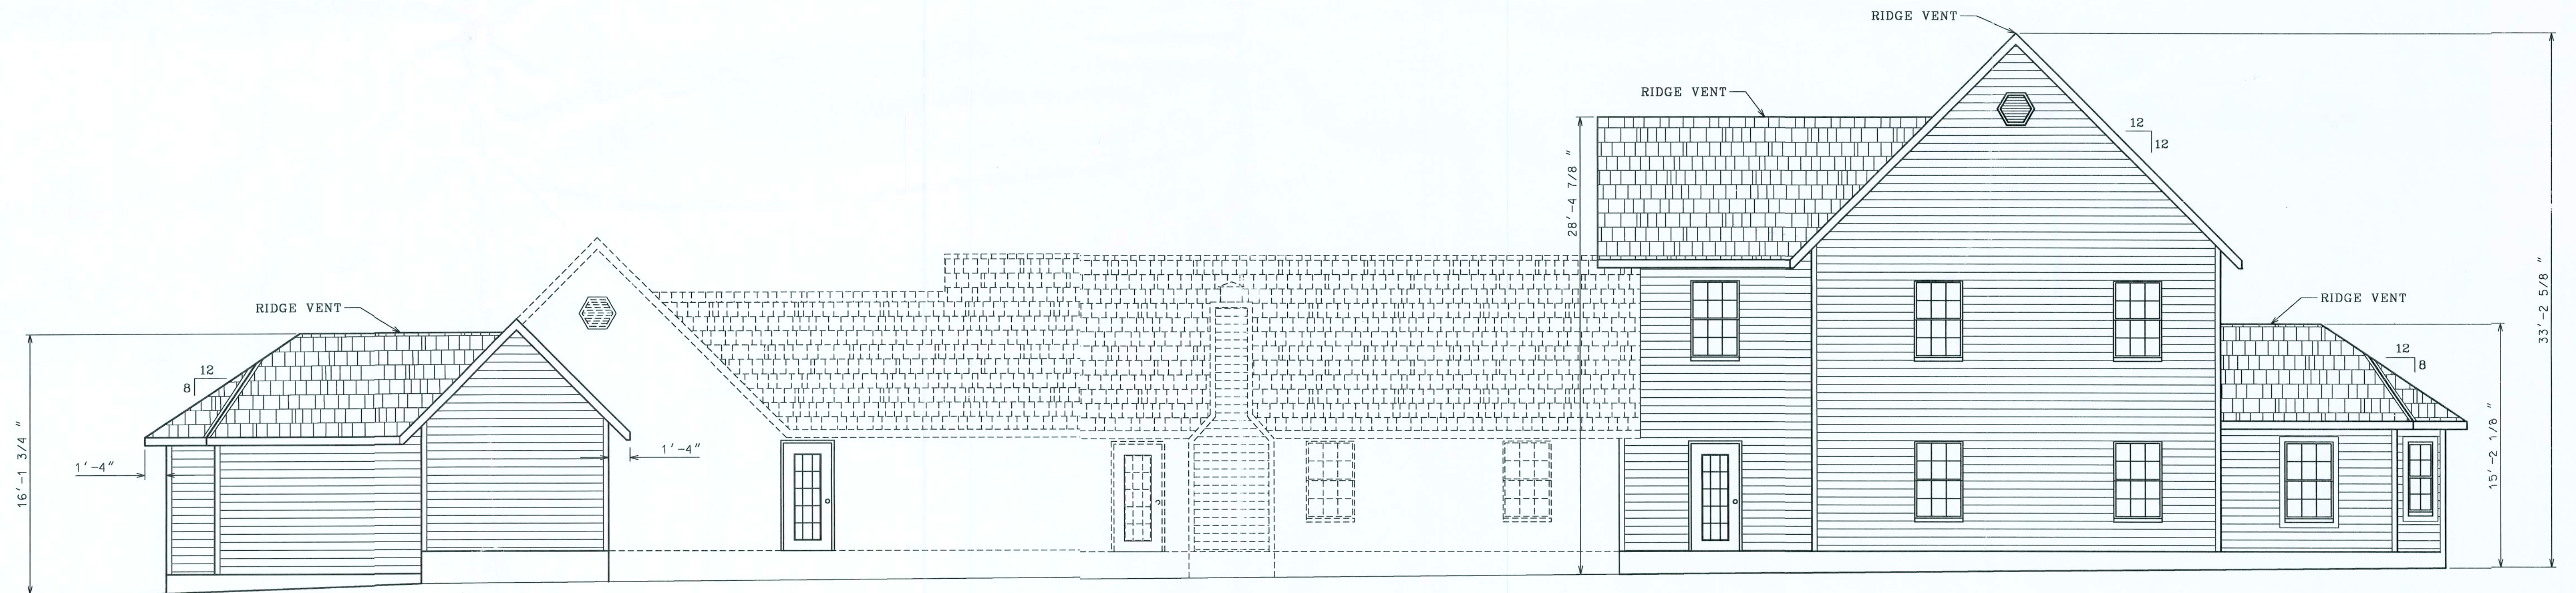

NOTE: SOLID LINES INDICATE PROPOSED CONSTRUCTION. ———
DASHED LINES INDICATE EXISTING HOME. - - - - -

REAR ELEVATION

THESE DRAWINGS, AS INSTRUMENTS OF SERVICE, ARE THE SOLE PROPERTY OF HAYGOOD HOMES, INC., AND ARE MAY NOT BE USED, COPIED OR REPRODUCED IN WHOLE OR IN PART FOR USE ON OR INCORPORATED WITHIN ANY OTHER JOB WITHOUT SPECIFIC AND INDIVIDUAL AUTHORIZATION BY HAYGOOD HOMES, INC..




HAYGOOD HOMES INC.

12592 So. U.S. HWY 441
LAKE CITY FL 32025
OFFICE (386) 752-3496
MOBILE (386) 303-1981
CR-C1326715

CURTIS AND DANA HAYNES
COLUMBIA COUNTY, FLORIDA


ELEVATION

PLAN No.	SCALE	DATE	SHEET NO.
P 0704	3/16" = 1'	08/30/07	1

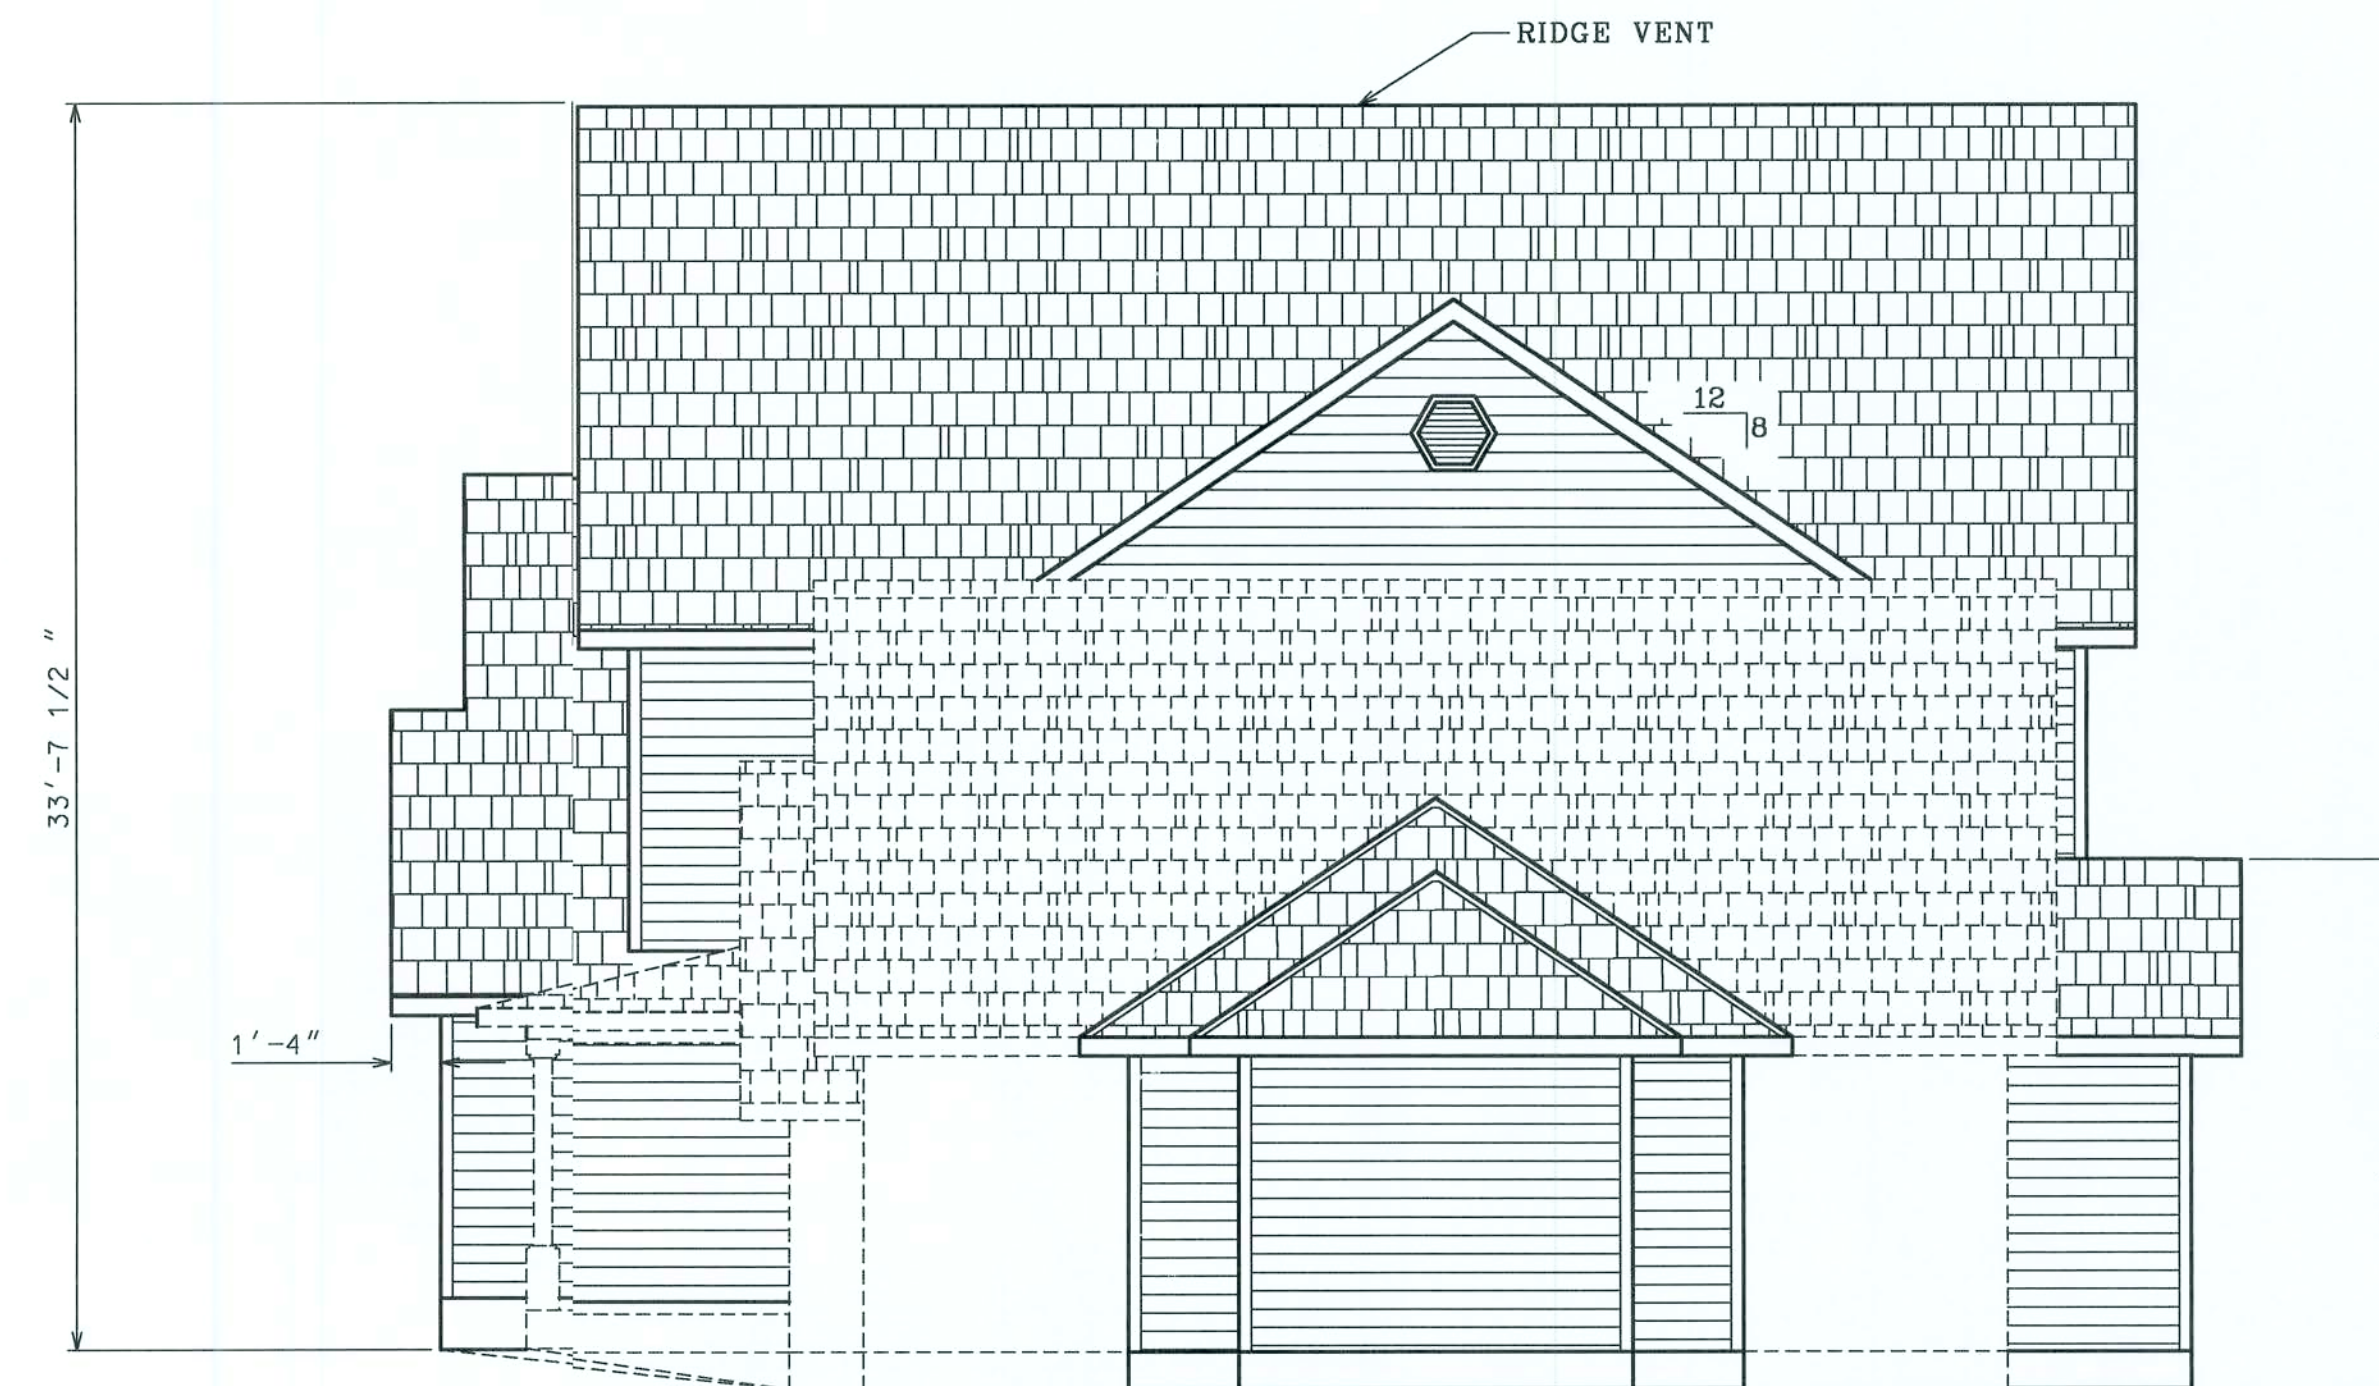

NOTE: SOLID LINES INDICATE PROPOSED CONSTRUCTION. ———
DASHED LINES INDICATE EXISTING HOME. - - - - -

RIGHT ELEVATION

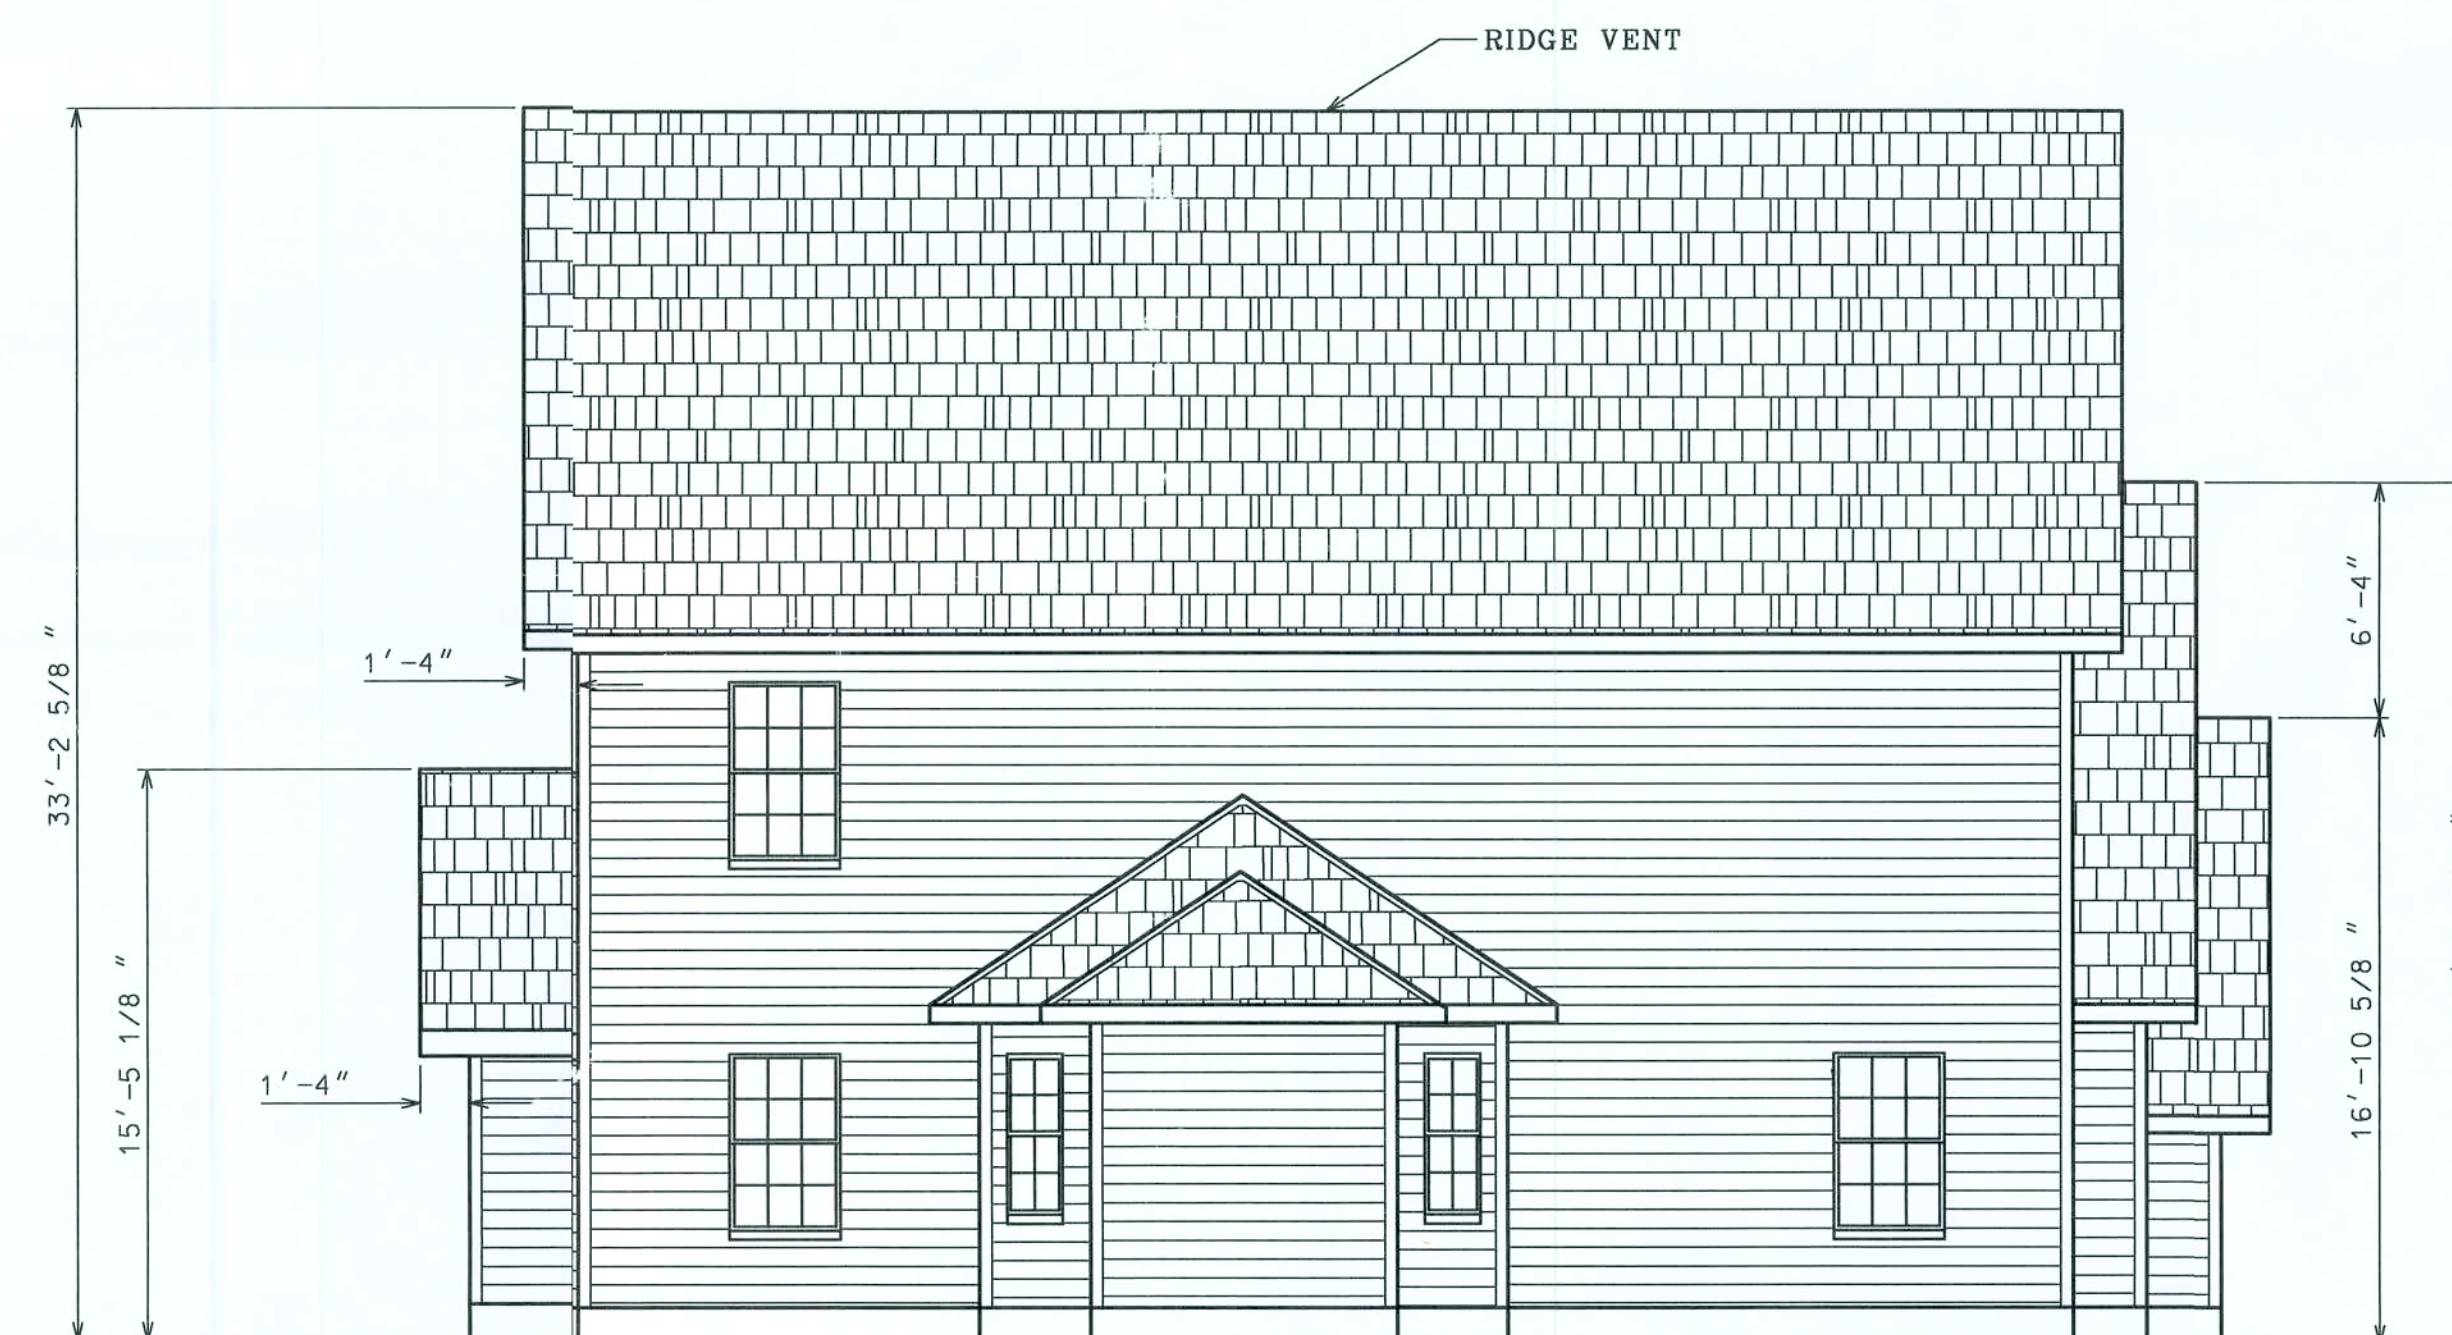

NOTE: SOLID LINES INDICATE PROPOSED CONSTRUCTION. ———
DASHED LINES INDICATE EXISTING HOME. - - - - -

LEFT ELEVATION

THESE DRAWINGS, AS INSTRUMENTS OF SERVICE, ARE THE SOLE PROPERTY OF HAYGOOD HOMES, INC., AND ARE MAY NOT BE USED, COPIED OR REPRODUCED IN WHOLE OR IN PART FOR USE ON OR INCORPORATED WITHIN ANY OTHER JOB WITHOUT SPECIFIC AND INDIVIDUAL AUTHORIZATION BY HAYGOOD HOMES, INC..





HAYGOOD HOMES INC.

12592 So. U.S. HWY 441
LAKE CITY FL. 32025
OFFICE (386) 752-3496
MOBILE (386) 303-1981
CR-C1326715

CURTIS AND DANA HAYNES
COLUMBIA COUNTY, FLORIDA

ELEVATION

PLAN No.	SCALE	DATE	SHEET NO.
P 0704	3/16" = 1'	08/30/07	2

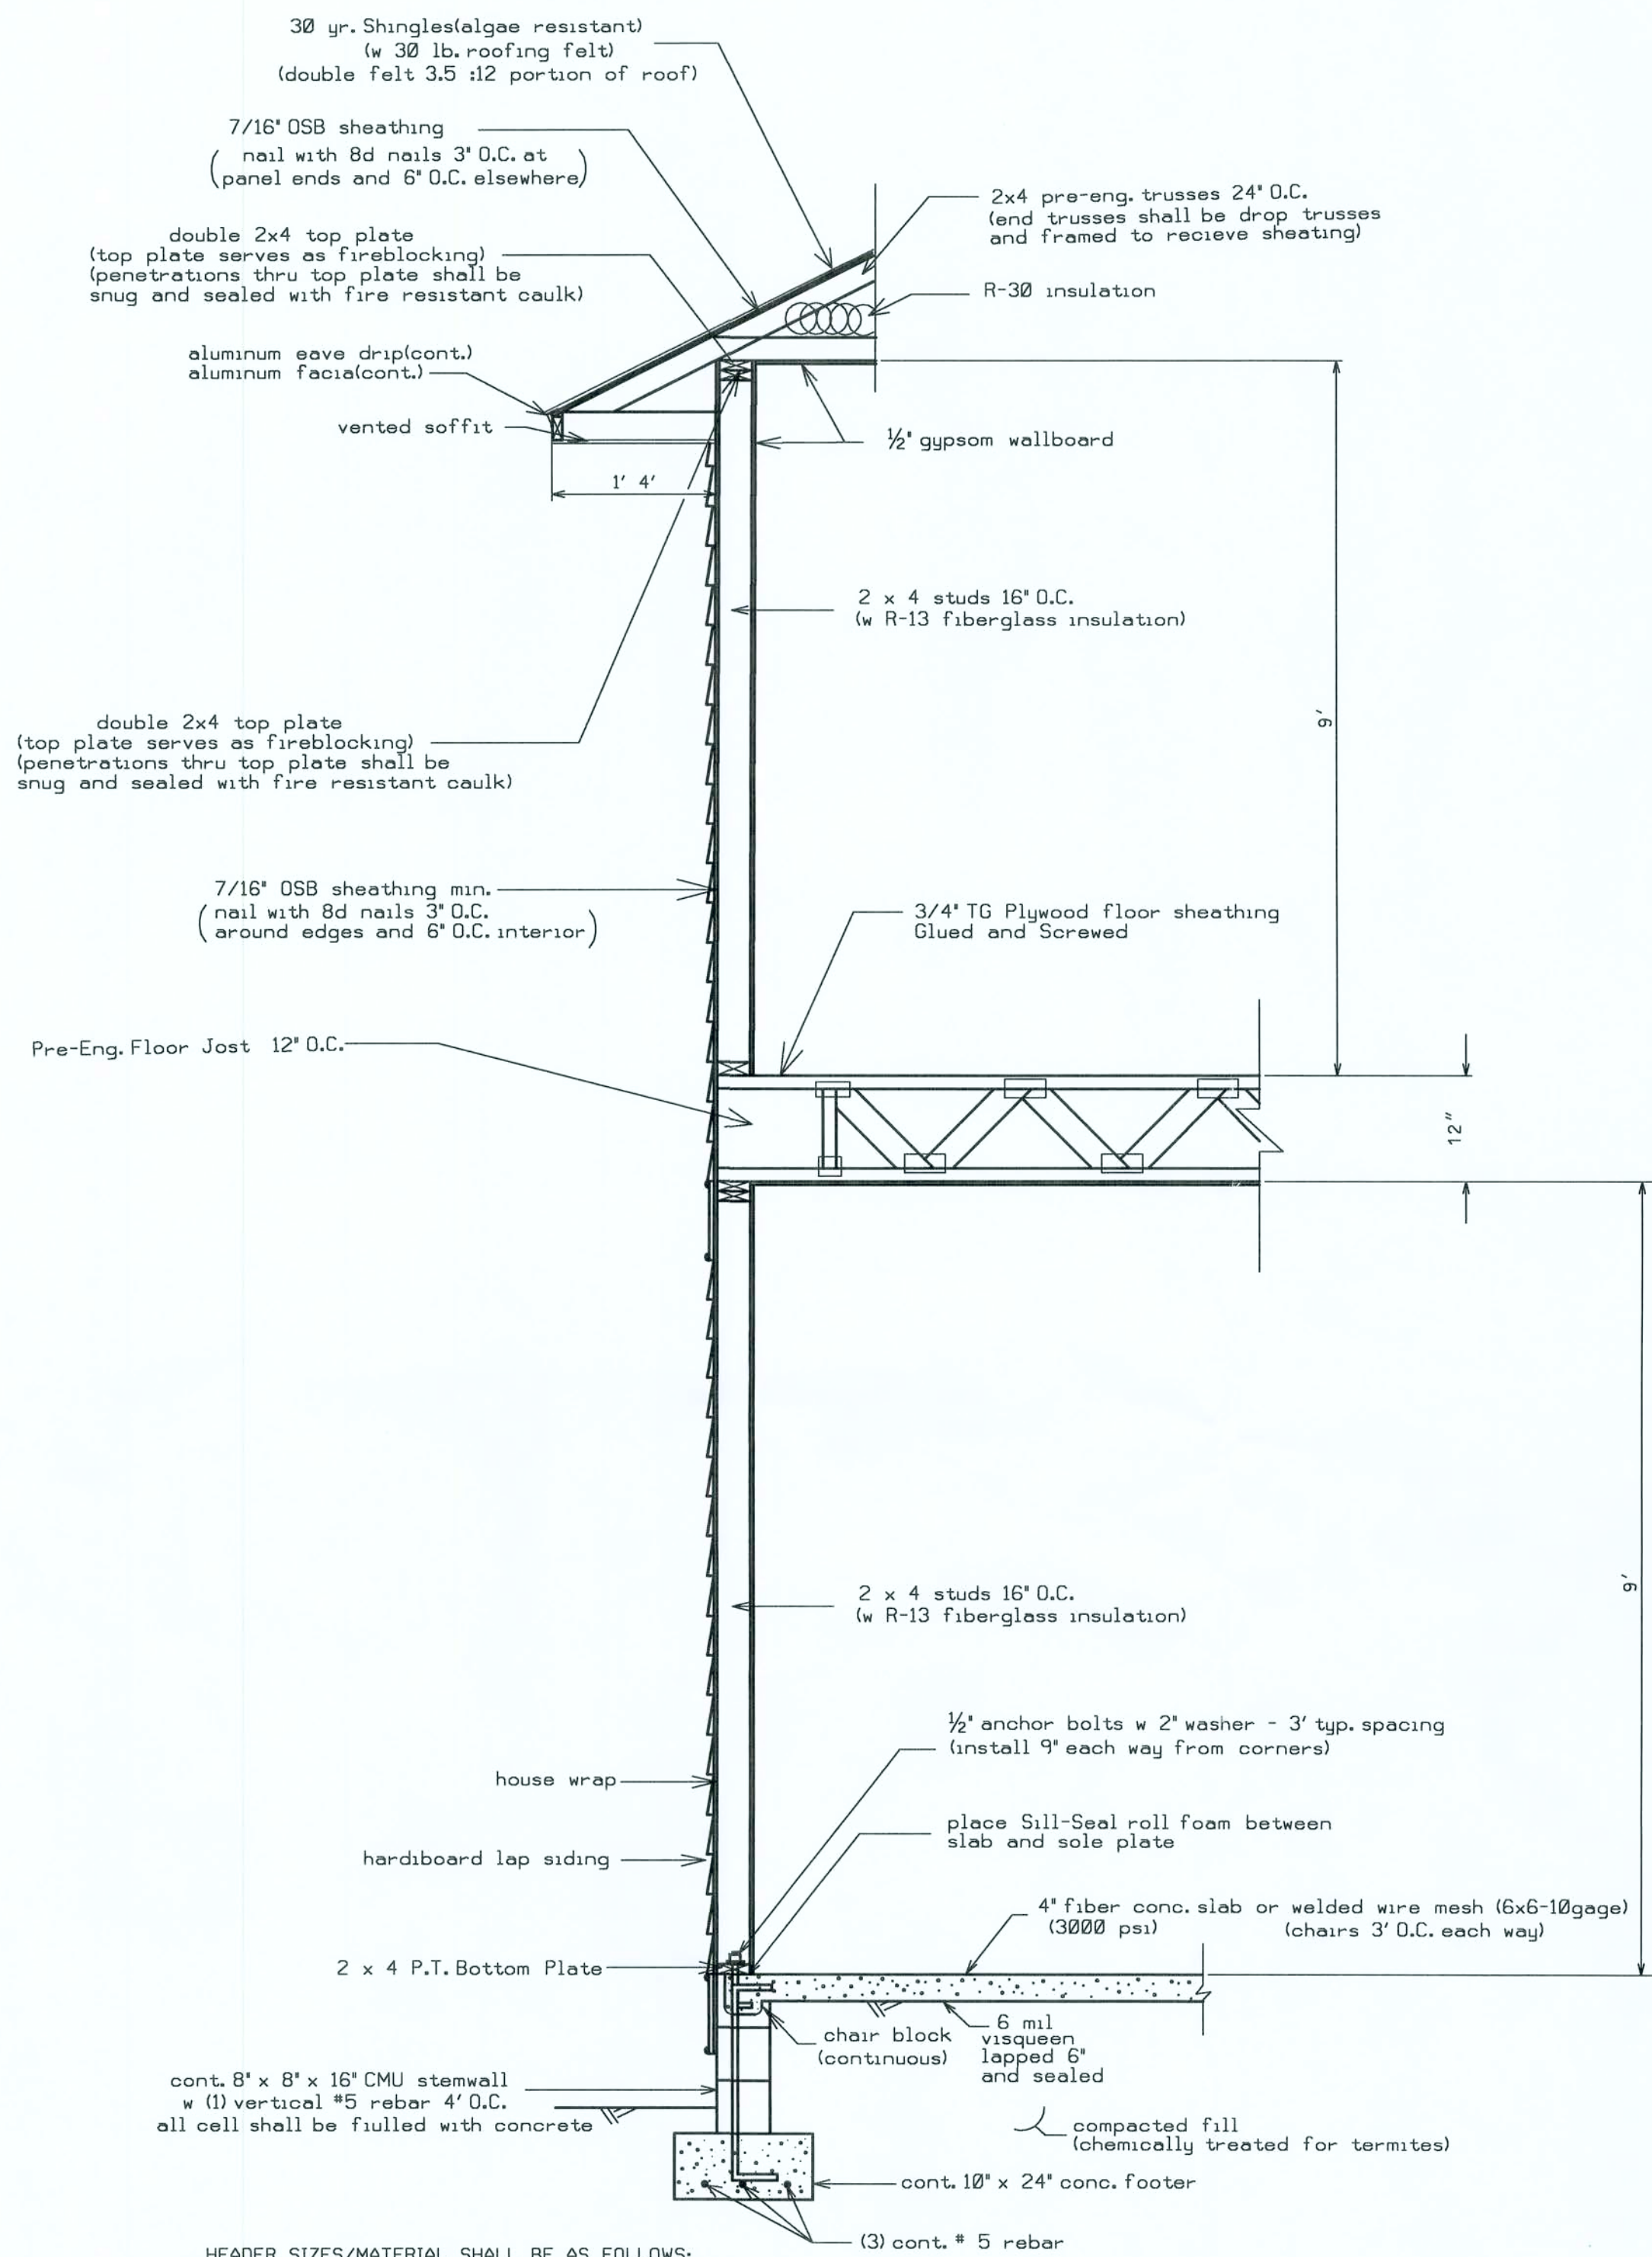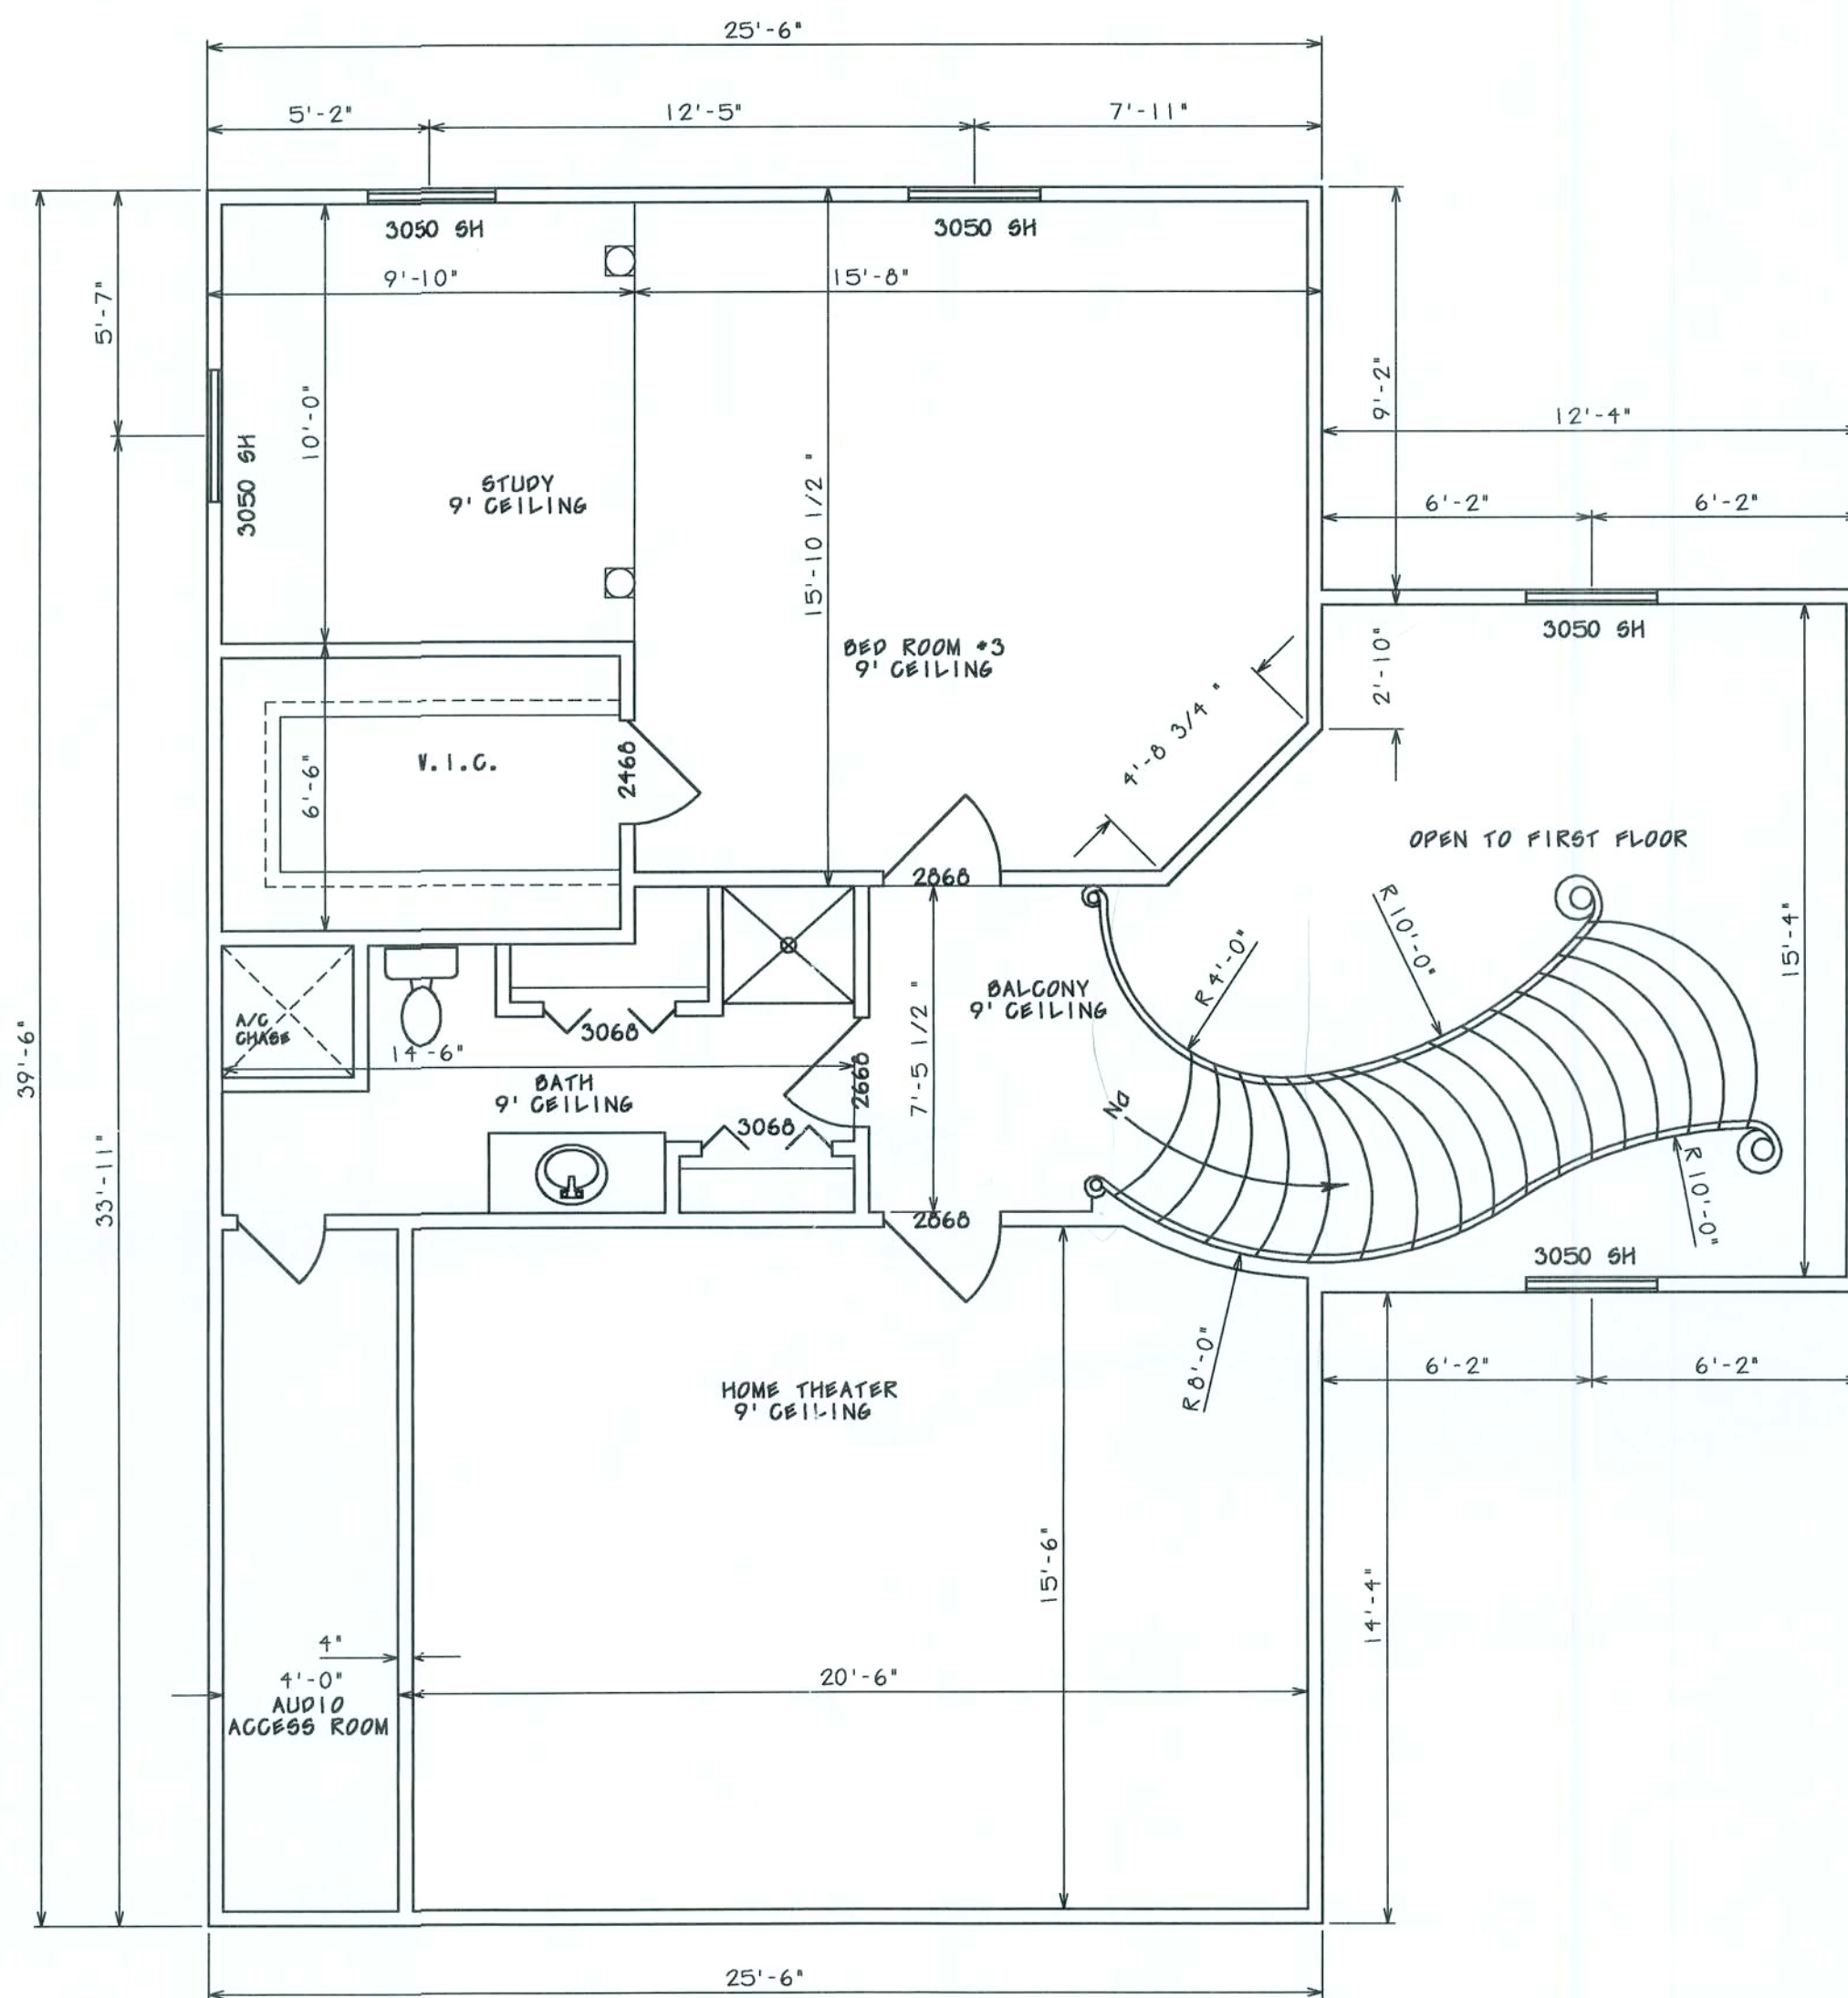

HEADER SIZES/MATERIAL SHALL BE AS FOLLOWS:
 WINDOW AND DOOR OPENINGS (2 - #2 SYP 2X12's with 1/2\"/>

WALL DETAIL (TYP.) (N.T.S.)





HAYGOOD HOMES INC.

12592 So. U.S. HWY 441
 LAKE CITY FL. 32025
 OFFICE (386) 752-3496
 MOBILE (386) 303-1981
 CR-C1326715

CURTIS AND DANA HAYNES
 COLUMBIA COUNTY, FLORIDA

SECOND FLOOR PLAN
 DETAILS

PLAN No.	SCALE	DATE	SHEET NO.
P 0704	1/4" = 1'	08/19/07	4

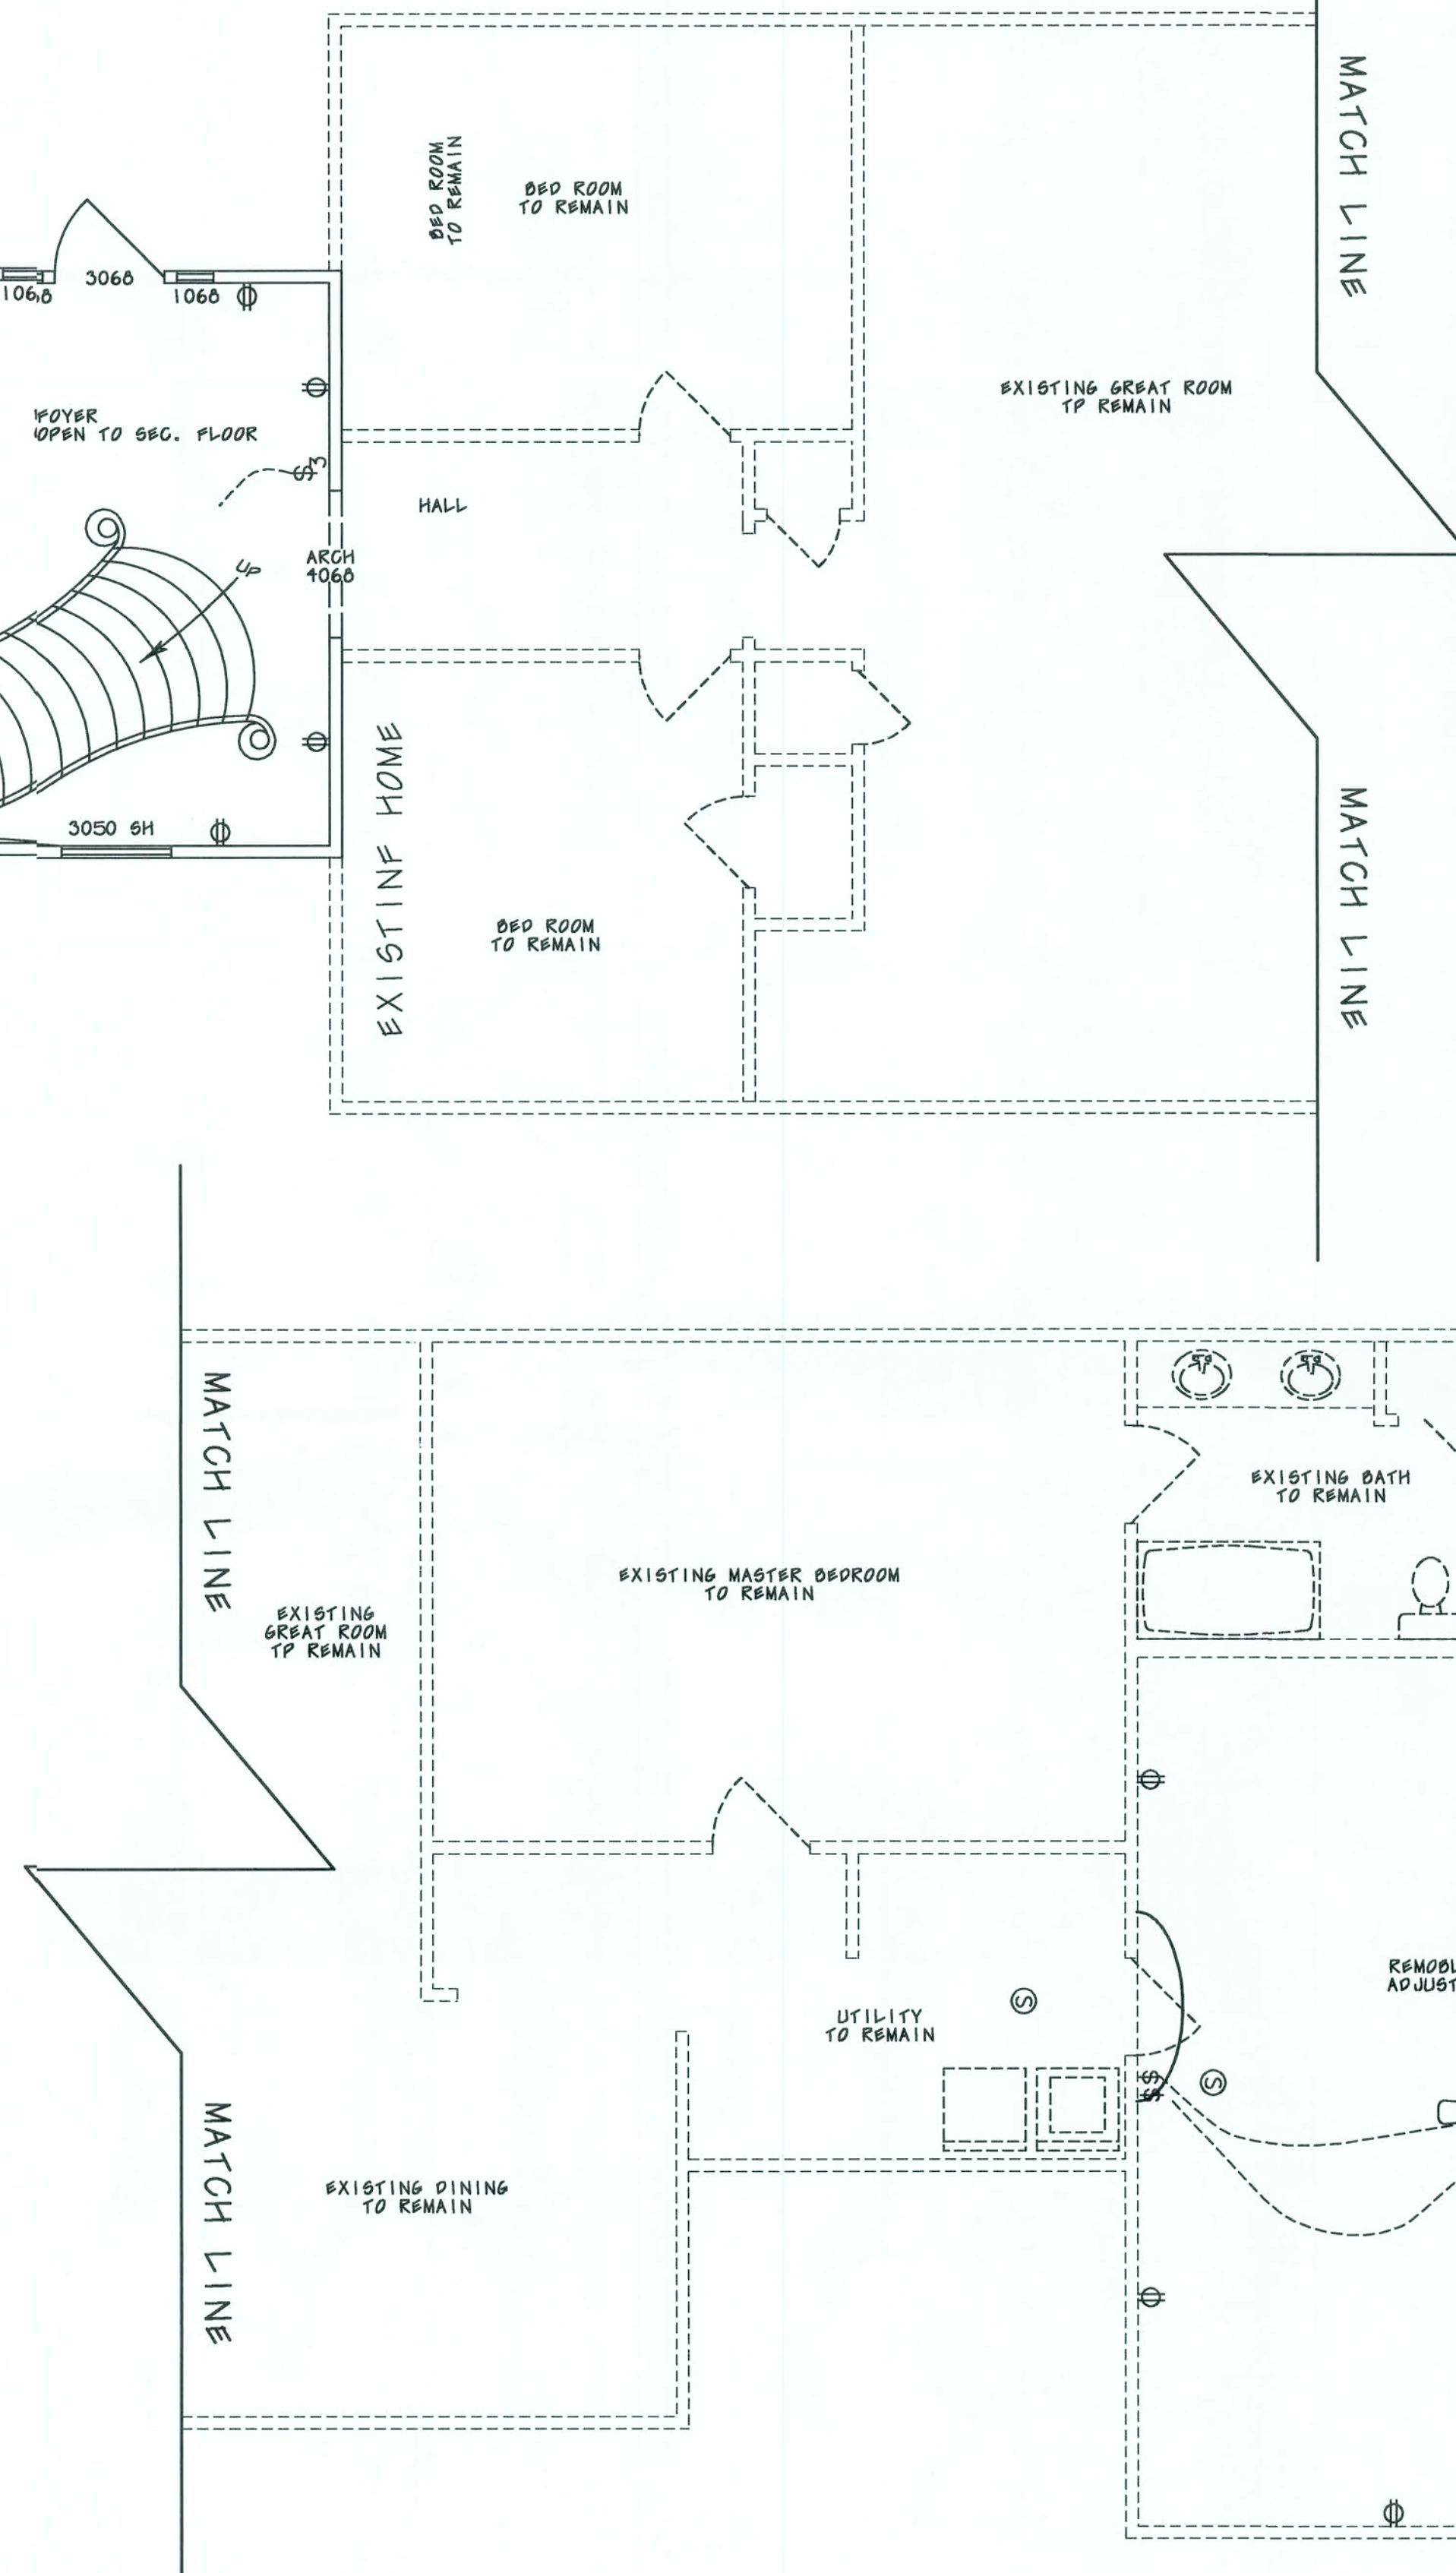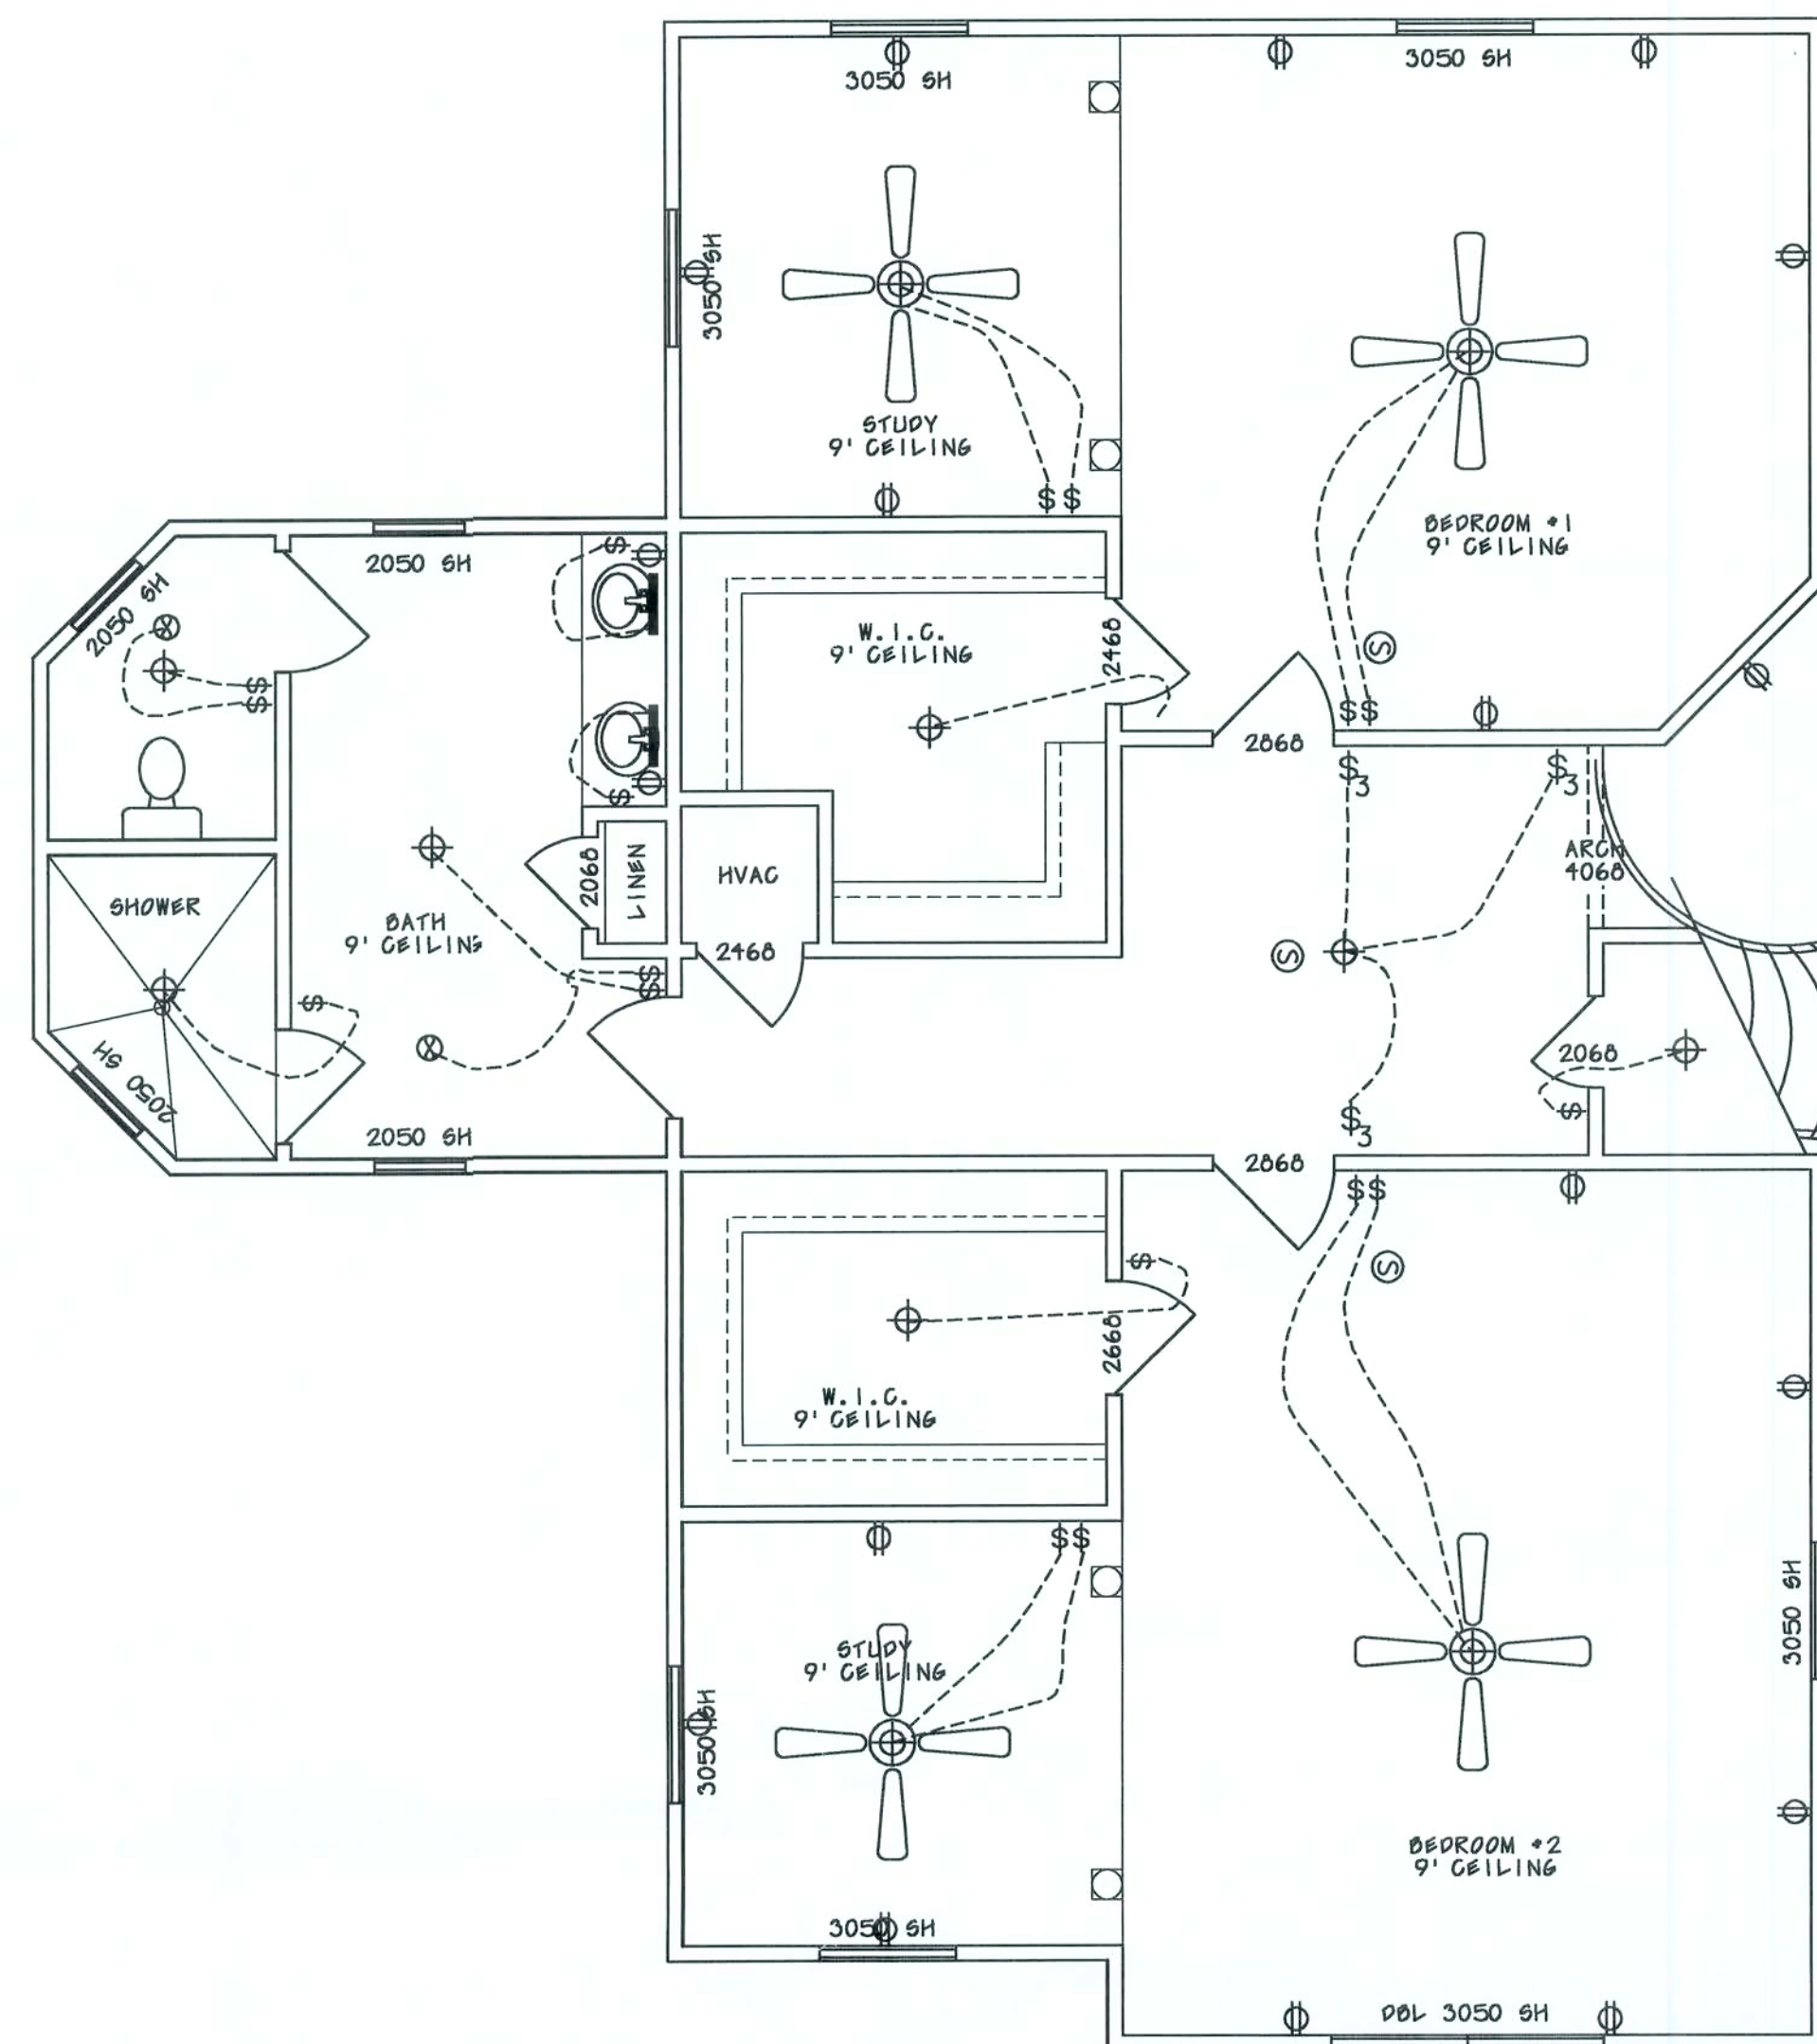

- ☐ - METER BASE
- - VANITY LIGHT AS SPECIFIED
- ⊕ - LIGHT FIXTURE
- ⊙ - LIGHT FIXTURE
- \$ - SINGLE POLE SWITCH
- \$3 - THREE-WAY SWITCH
- ⊕ - RECEPT.
- ☼ - SECURITY LIGHT
- ⊗ - EXHAUST
- ⬆ - 220 V.
- Ⓢ - SMOKE DETECTOR (AC/DC and interconnected)
- ☐ - TELEPHONE
- +TV - TELEVISION

NOTES:

- 1.) ALL EXTERIOR RECEPTACLES SHALL EITHER BE GFI OUTLETS OR PART OF A GFI CIRCUIT. ALL EXTERIOR RECEPTACLES SHALL BE WEATHERPROOF.
- 3.) ALL BATHROOM, KITCHEN, AND GARAGE RECEPTACLES SHALL BE PART OF A GFI CIRCUIT.
- 4.) ALL BEDROOM RECEPTACLES SHALL BE PART OF AN AFI CIRCUIT.

THESE DRAWINGS, AS INSTRUMENTS OF SERVICE, ARE THE SOLE PROPERTY OF HAYGOOD HOMES, INC., AND ARE NOT TO BE USED, COPIED OR REPRODUCED IN WHOLE OR IN PART FOR USE ON OR INCORPORATED WITHIN ANY OTHER JOB WITHOUT SPECIFIC AND INDIVIDUAL AUTHORIZATION BY HAYGOOD HOMES, INC.



HAYGOOD HOMES INC.

12592 So. U.S. HWY 441
LAKE CITY FL 32025
OFFICE (386) 752-3496
MOBILE (386) 303-1981
CR-C1326715

CURTIS AND DANA HAYNES
COLUMBIA COUNTY, FLORIDA

FIRST FLOOR PLAN
FIRST ELECTRICAL PLAN

PLAN No.	SCALE	DATE	SHEET NO.
P 0704	1/4" = 1'	08/19/07	5

Haynes Electrical Inc. 9/23/2007 8:33:22 PM


- METER BASE
- VANITY LIGHT AS SPECIFIED
- LIGHT FIXTURE
- LIGHT FIXTURE
- SINGLE POLE SWITCH
- THREE-WAY SWITCH
- RECEPT.
- SECURITY LIGHT
- EXHAUST
- 220 V.
- SMOKE DETECTOR (AC/DC and interconnected)
- TELEPHONE
- TELEVISION

NOTES:

1.) ALL EXTERIOR RECEPTACLES SHALL EITHER BE GFI OUTLETS OR PART OF A GFI CIRCUIT. ALL EXTERIOR RECEPTACLES SHALL BE WEATHERPROOF.

3.) ALL BATHROOM, KITCHEN, AND GARAGE RECEPTACLES SHALL BE PART OF A GFI CIRCUIT.

4.) ALL BEDROOM RECEPTACLES SHALL BE PART OF AN AFI CIRCUIT.

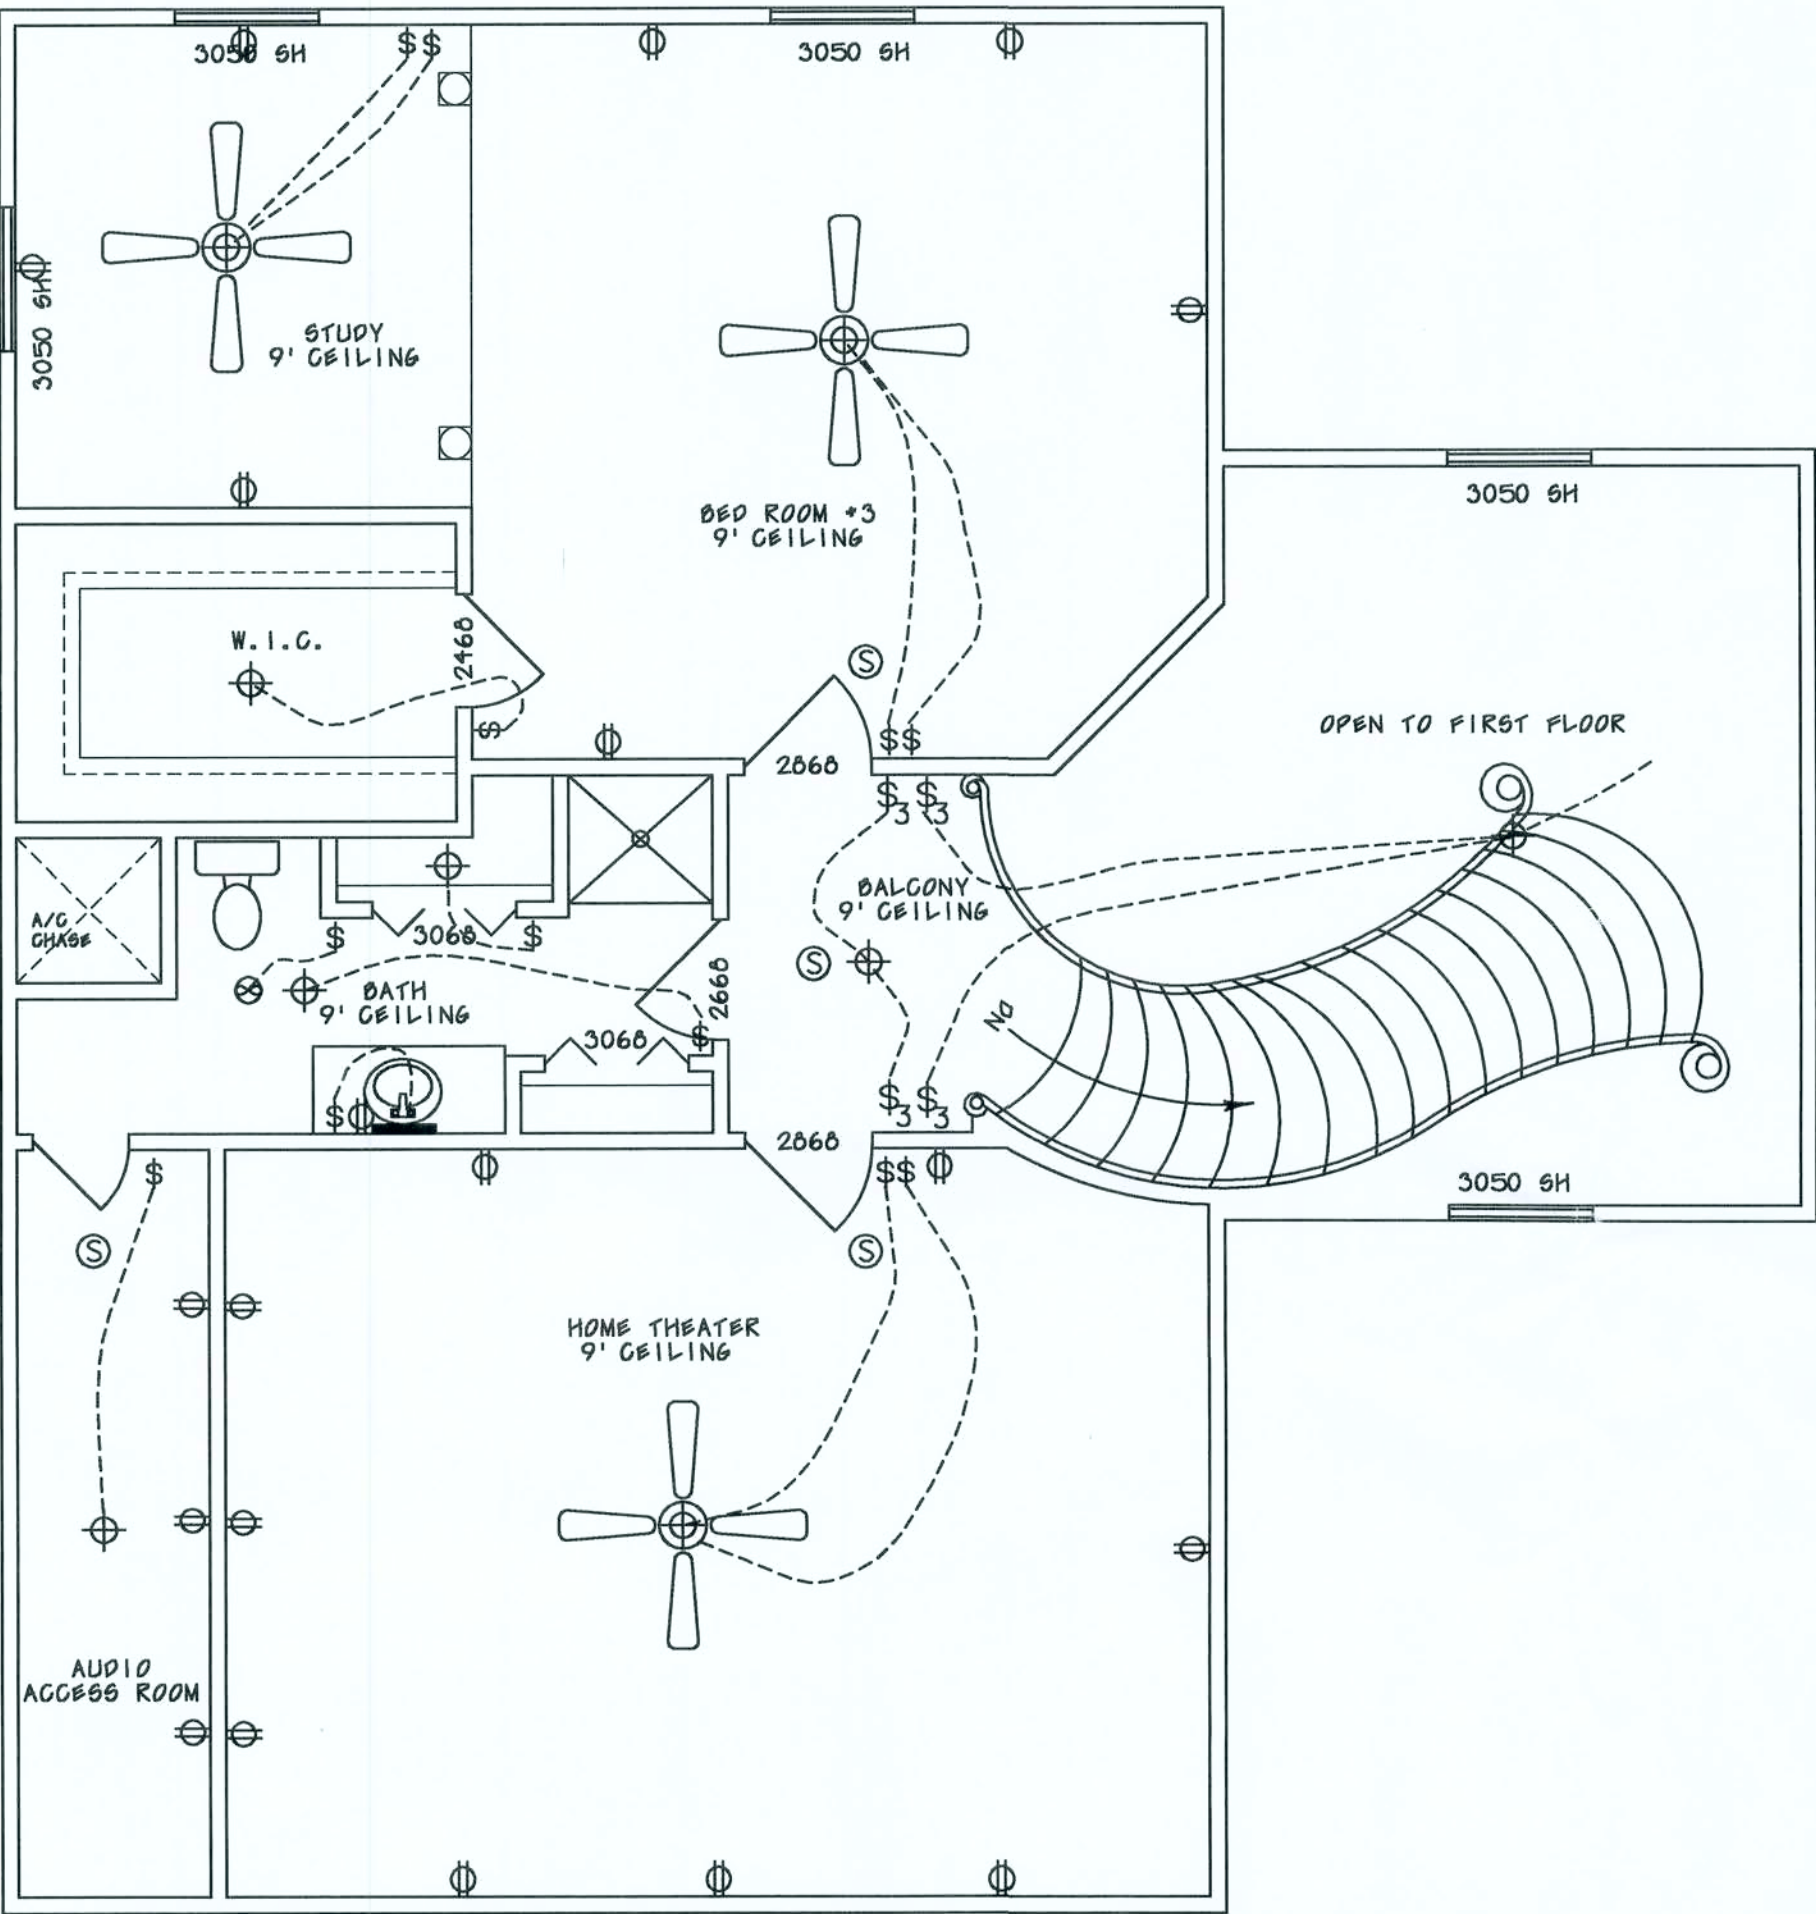

THESE DRAWINGS, AS INSTRUMENTS OF SERVICE, ARE THE SOLE PROPERTY OF HAYGOOD HOMES, INC., AND ARE NOT TO BE USED, COPIED OR REPRODUCED IN WHOLE OR IN PART FOR USE ON OR INCORPORATED WITHIN ANY OTHER JOB WITHOUT SPECIFIC AND INDIVIDUAL AUTHORIZATION BY HAYGOOD HOMES, INC.




HAYGOOD HOMES INC.

12592 So. U.S. HWY 441
LAKE CITY FL 32025
OFFICE (386) 752-3496
MOBILE (386) 303-1981
CR-C1326715

CURTIS AND DANA HAYNES
COLUMBIA COUNTY, FLORIDA

FIRST FLOOR PLAN
ELECTRICAL

PLAN No.	SCALE	DATE	SHEET NO.
P 0704	1/4" = 1'	08/15/07	6

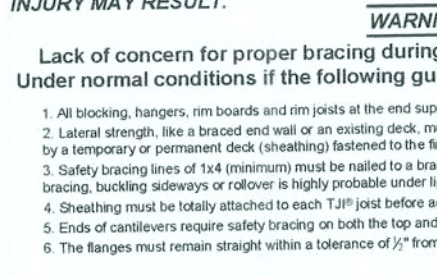

Blocking						
PlotID	Length	Product	Plies	Net	Qty	
NBk1	1' 11/16"	16" TJI®	230	1	18	
NBk3	1' 11/16"	16" TJI®	230	1	1	
NBk1	1' 15/8"	16" TJI®	230	1	1	
NBk2	11 11/16"	16" TJI®	230	1	1	
NBk1	10 3/8"	16" TJI®	230	1	1	
NBk1	10 1/16"	16" TJI®	230	1	1	
NBk1	9 9/16"	16" TJI®	230	1	1	
NBk3	9 9/16"	16" TJI®	230	1	1	
NBk1	5 1/8"	16" TJI®	230	1	1	

LEVEL AND FLOOR CONTAINER NOTES	
Current Date:	10/9/2007
File Name:	SR-104943 R07-087351.ofs
Level Name:	1st Floor
TJ-Pro Rating (Weighted Average):	60
Minimum Level TJ - Pro Rating & Joist:	TJ-Pro rating = 55, joist = N16' (i197)
Maximum Level TJ - Pro Rating & Joist:	TJ-Pro rating = 69, joist = N10' -2(i278)
Building Code - Design Methodology:	IBC 2000
Floor Container:	FC1
Floor Area Loading is:	40 Live Load & 12 Dead Load
Maximum Allowed Deflection	L/480 Live Load & L/240 Total Load
TJ-Pro Rating Information:	
Weighted Average:	60
Directly Applied Ceiling:	No
Decking Attachment:	GlueAndNail
Frameworks Floor:	No
Decking Material:	23/32"x48"x96" OSB Structurwood Edge Gold (0/24) T&G SF

