



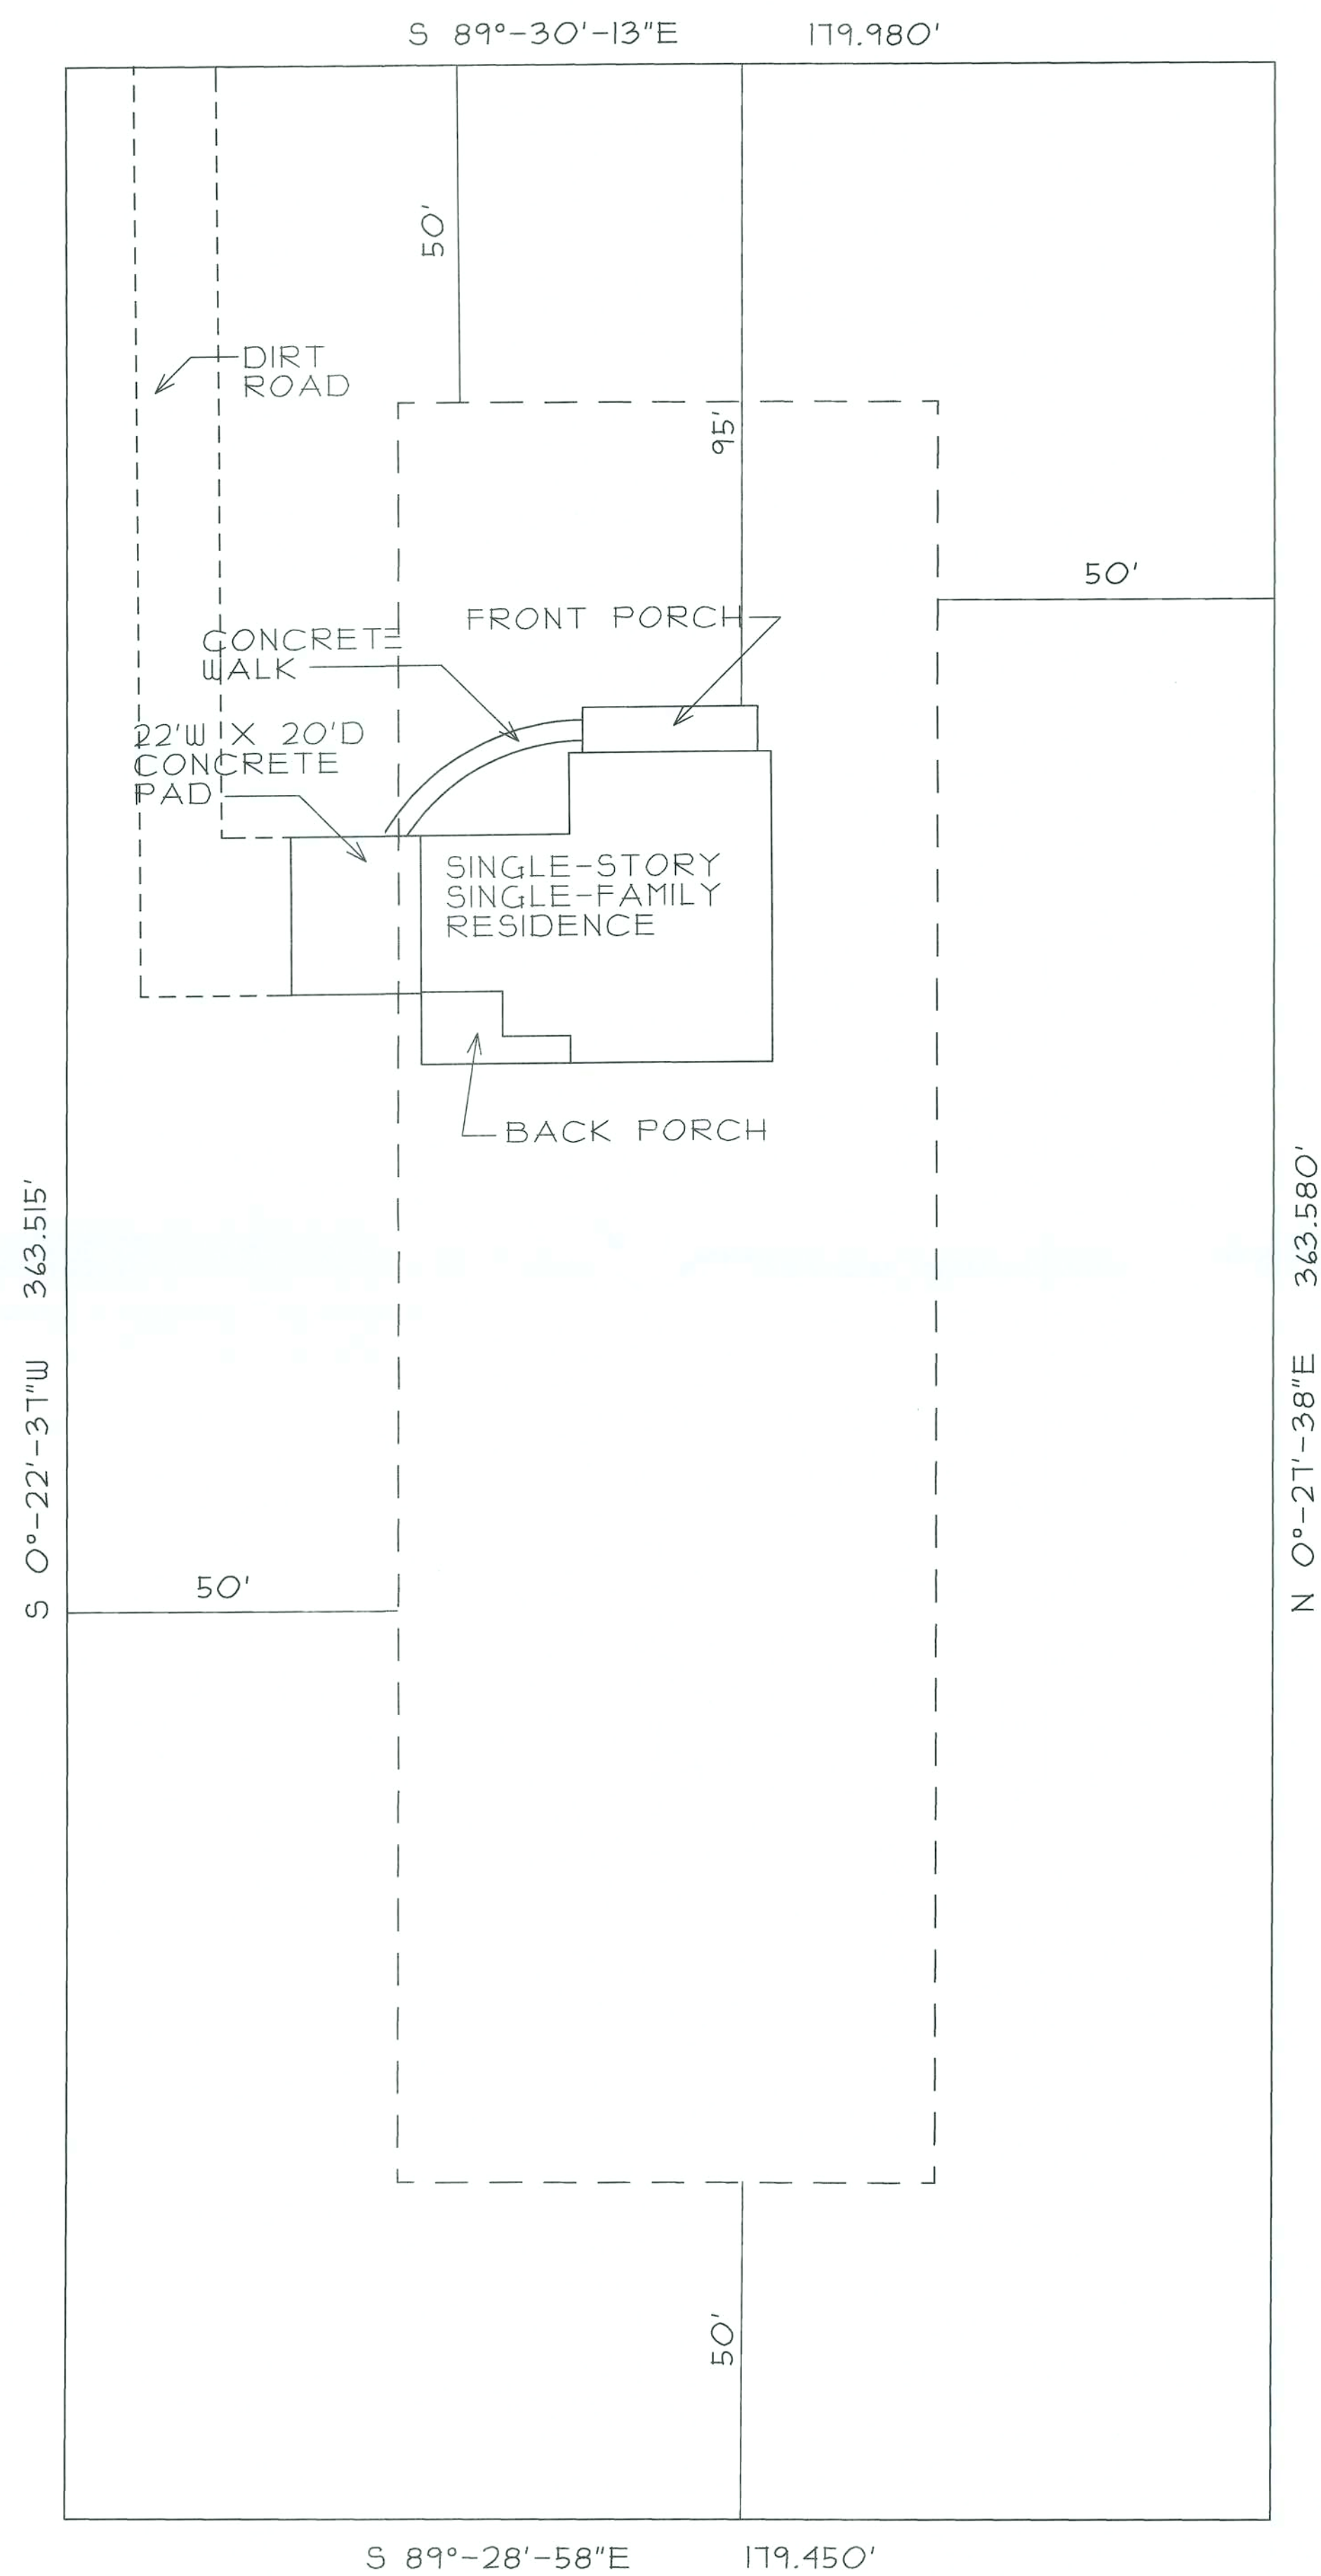

SITE PLAN
SCALE: 1" = 20'-0"

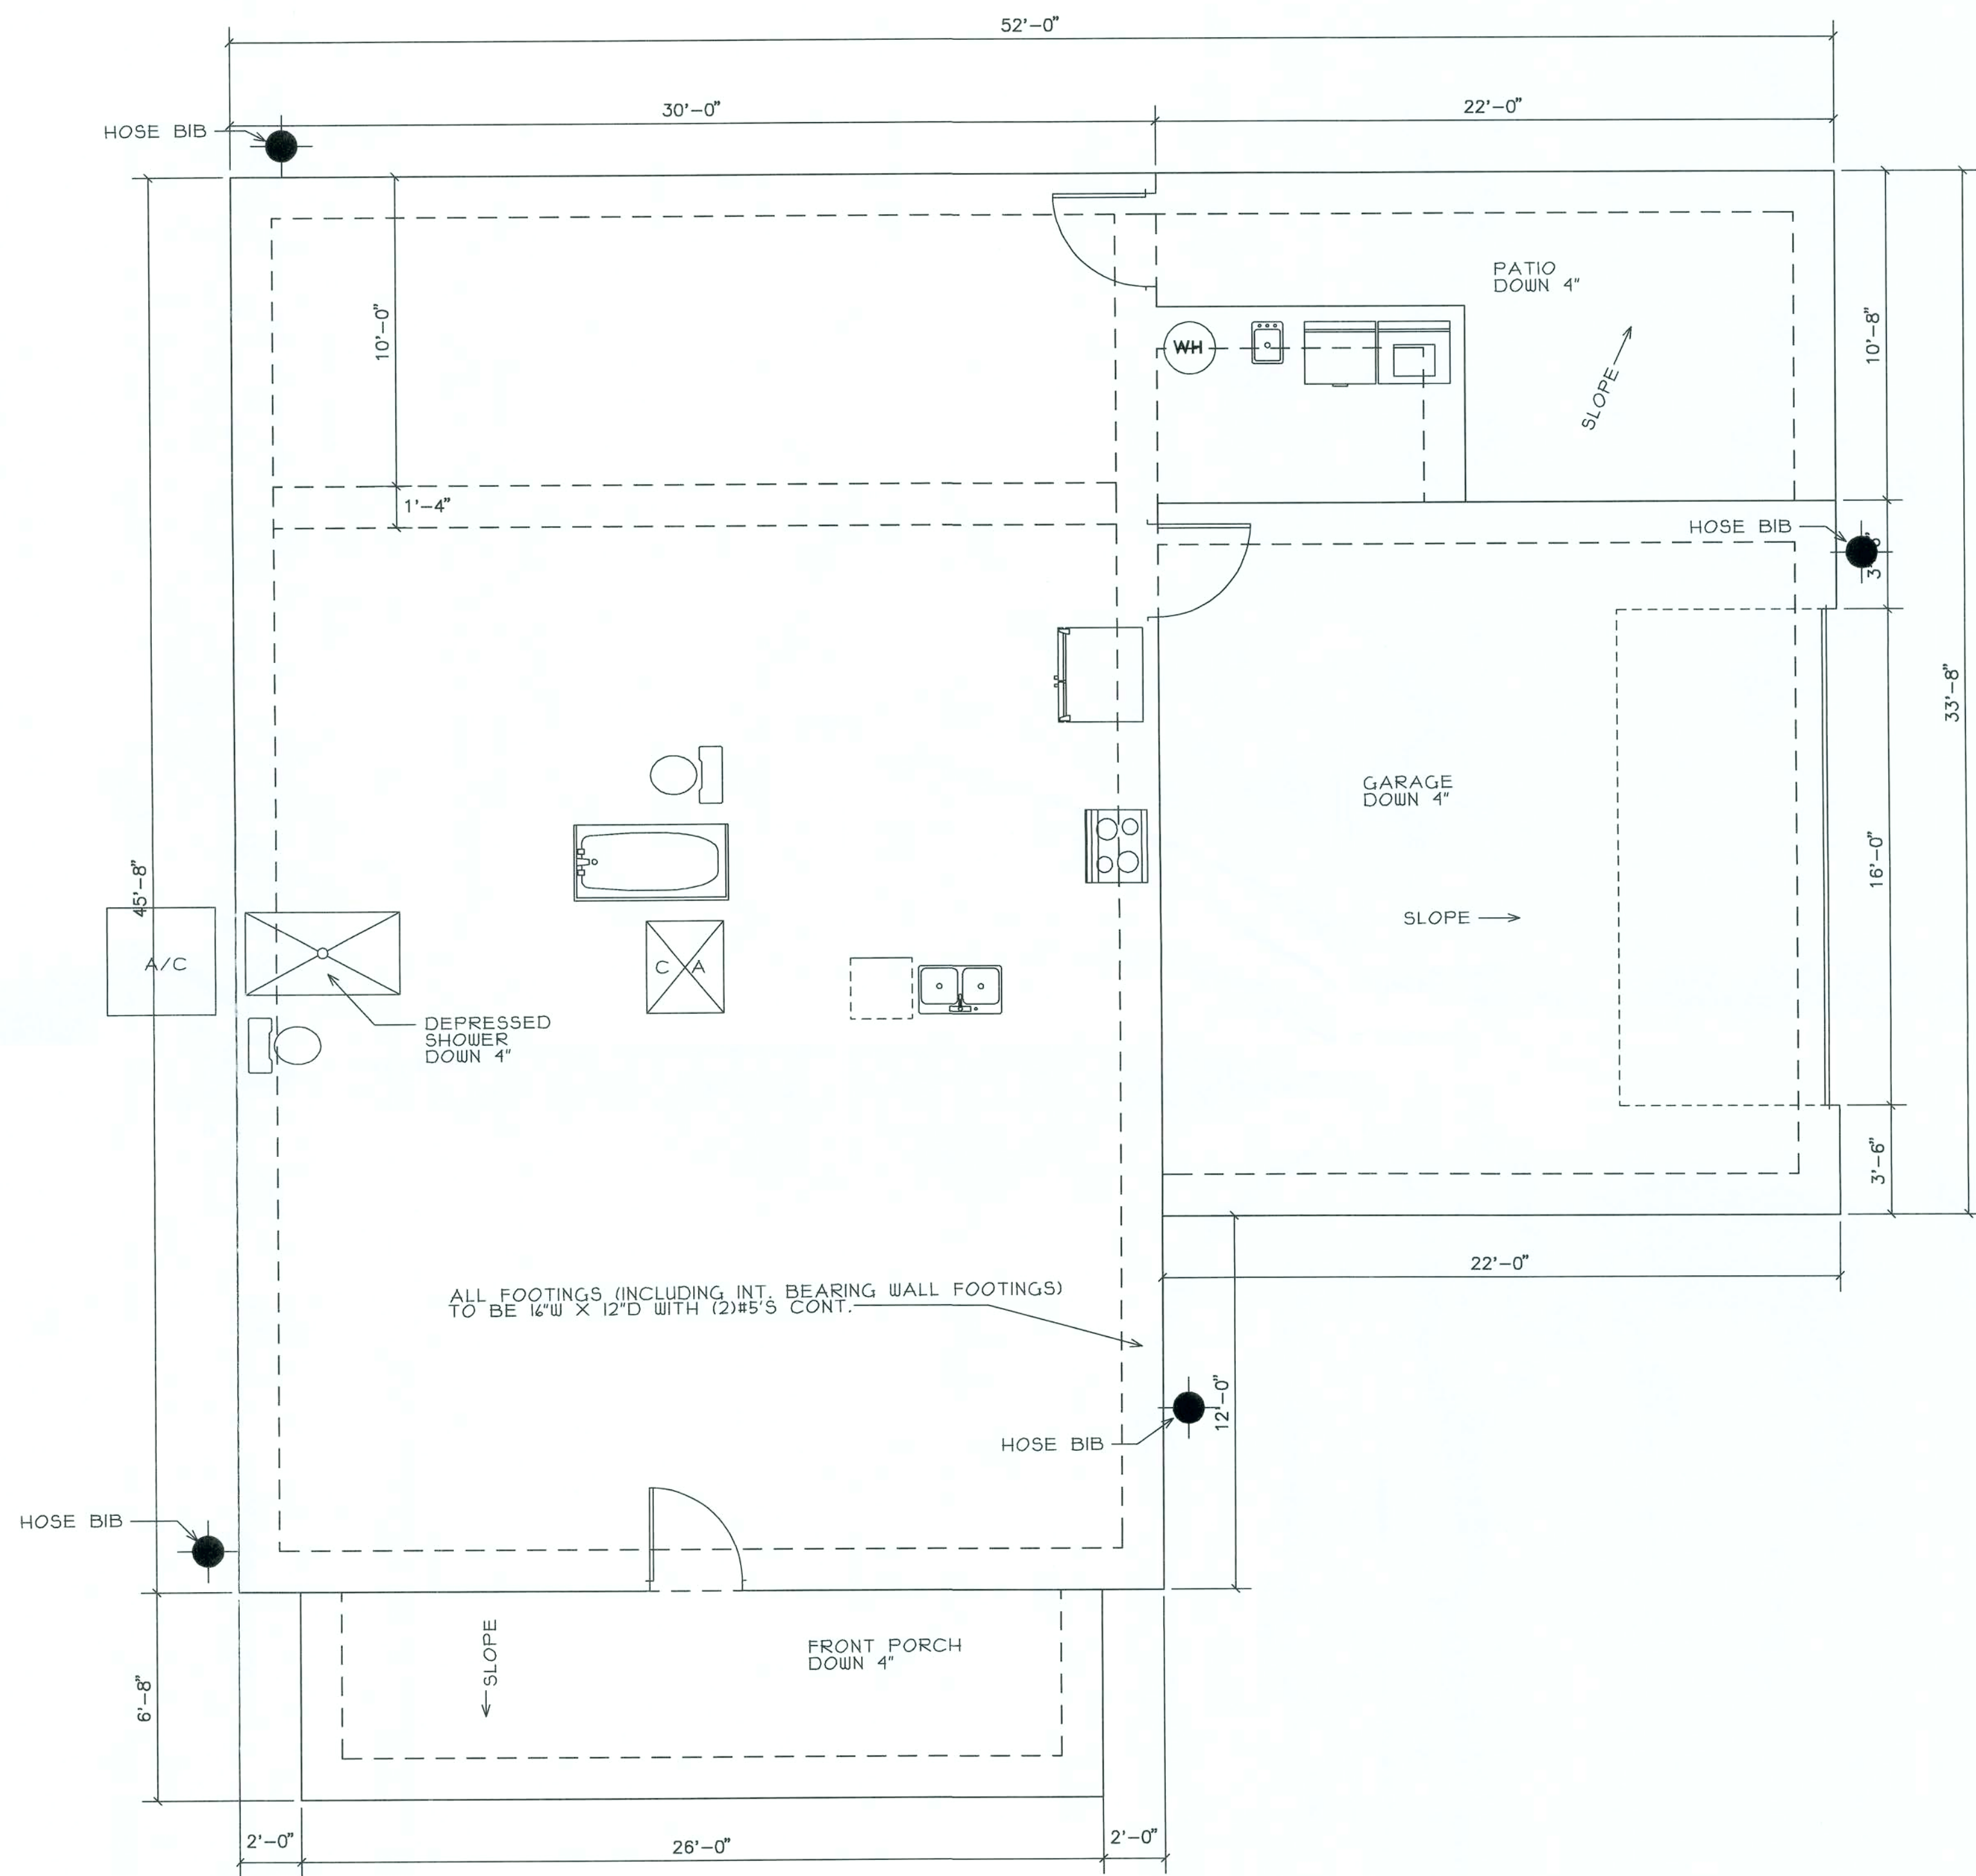

FOUNDATION PLAN
SCALE: 1/4" = 1'-0"


FOUNDATION PLAN

SCALE: 1/4" = 1'-0"
JOB #: SF-2


SANTA FE RIVER PLANTATIONS

LOT 46


G C Construction CG-0052925
P.O. Box 5893 Phone 386-418-2114
Gainesville, FL 32627 gclemon@att.net
Drawn by: Steve Rauli Architectural Drafting
16764 NW 212th Terrace
High Springs, Florida 32643
352-871-6251

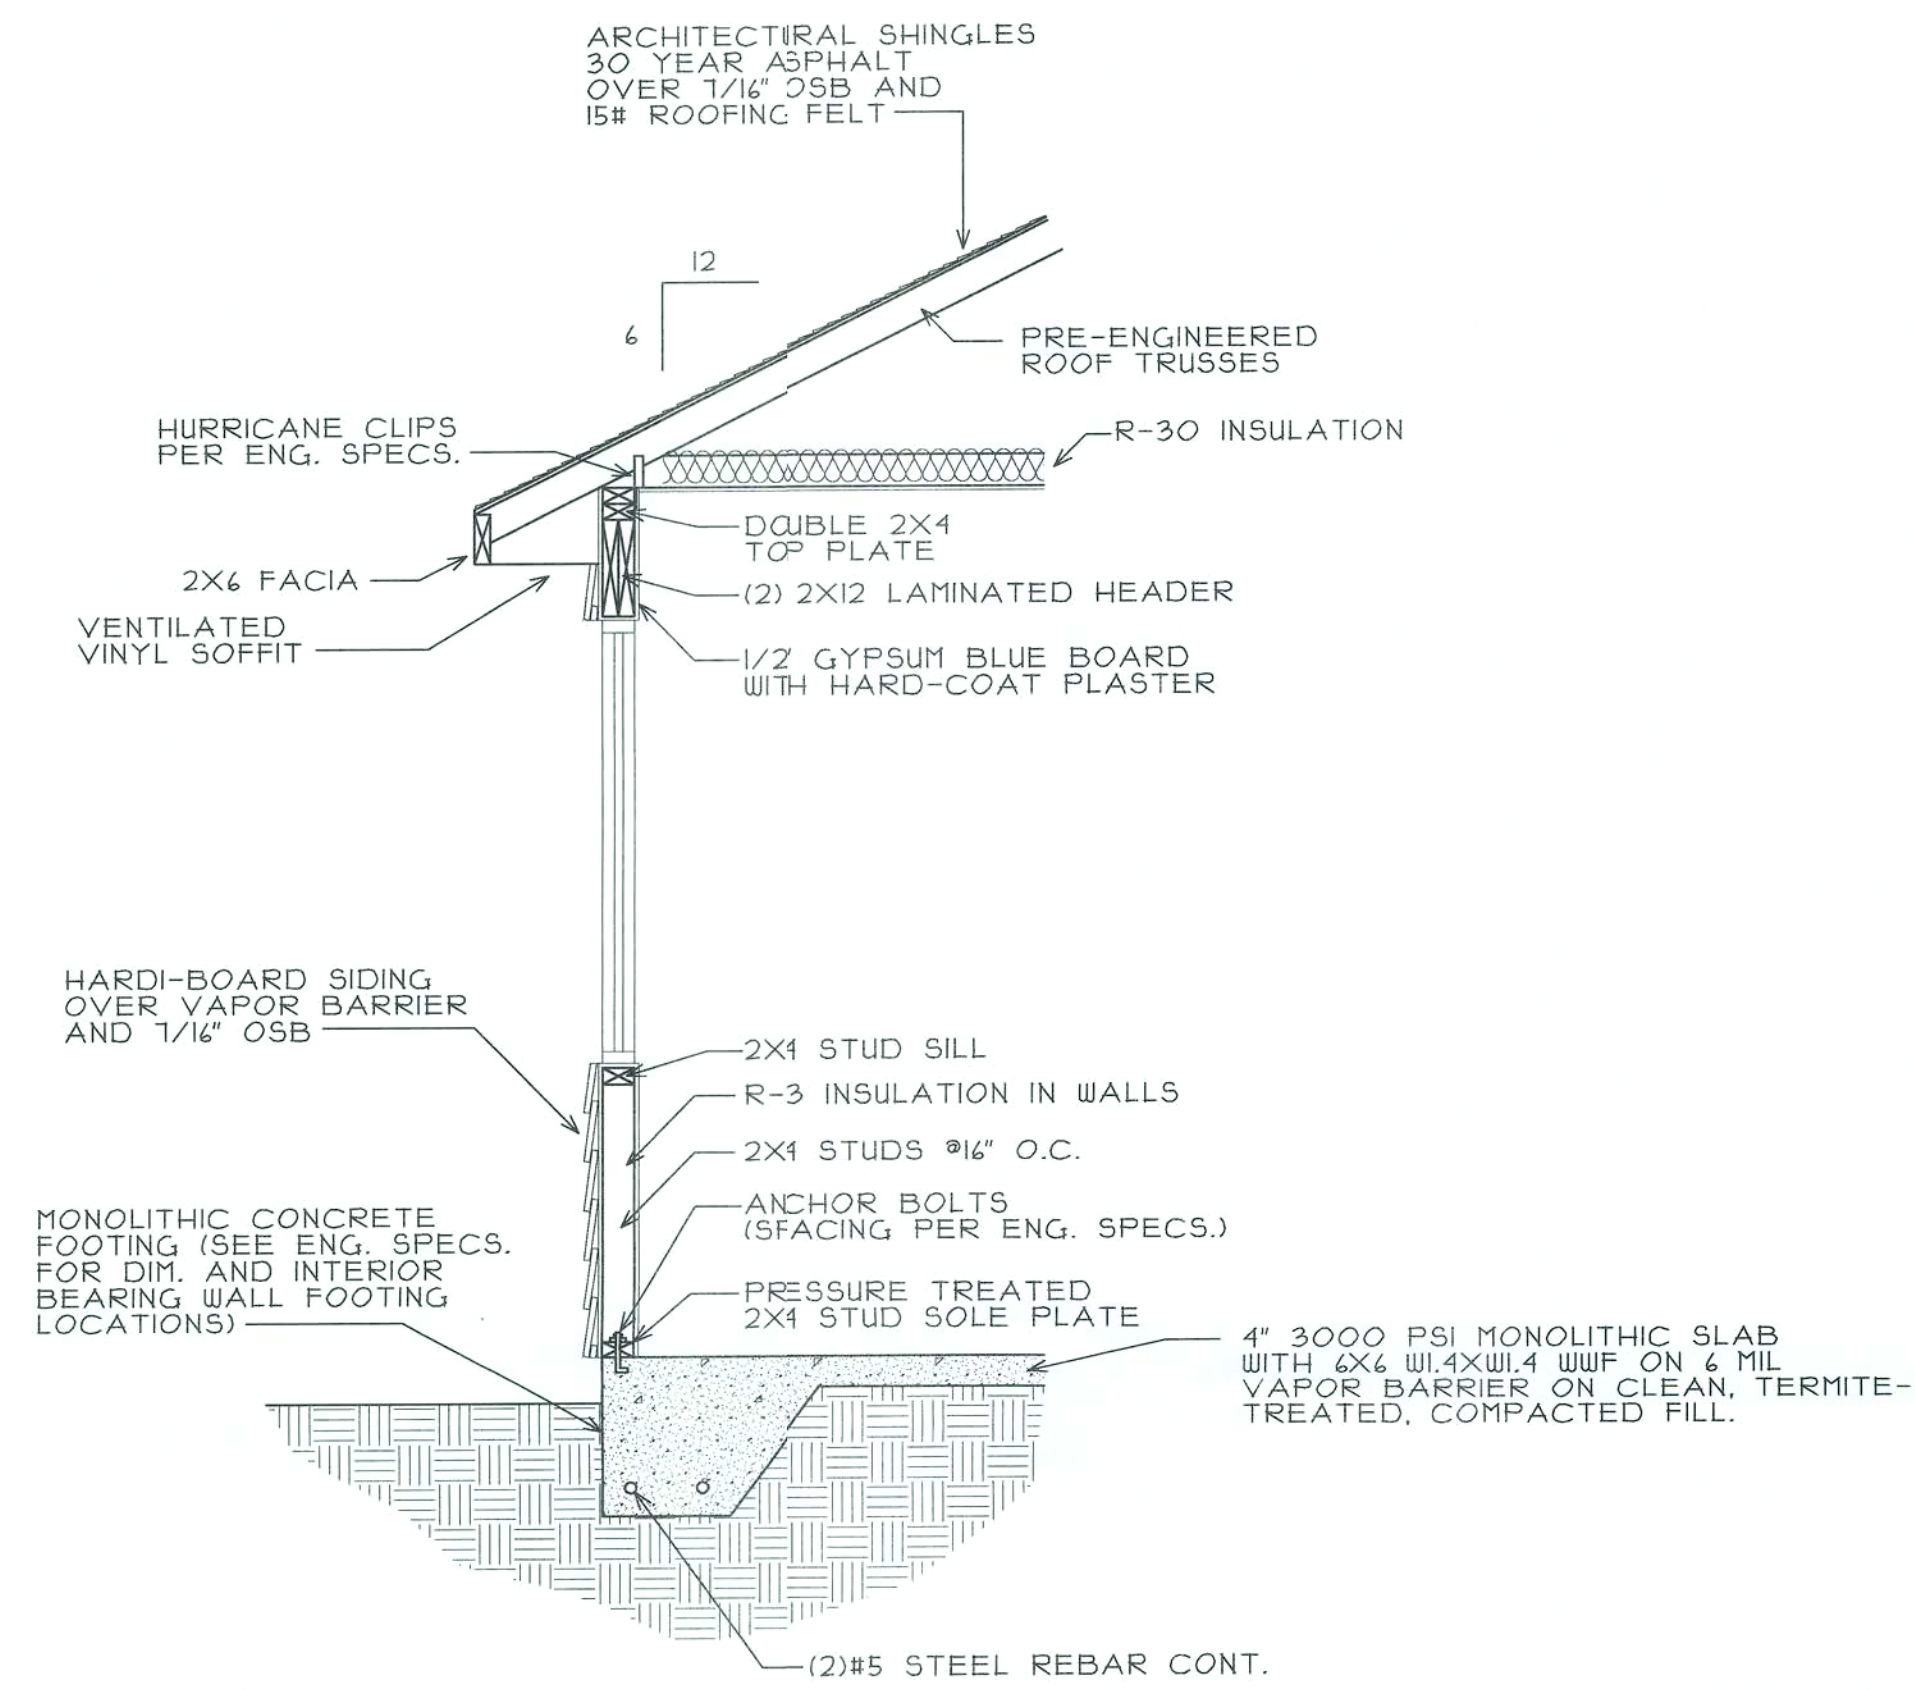

TYPICAL WALL/FOUNDATION SECTION
SCALE: 1/2" = 1'-0"

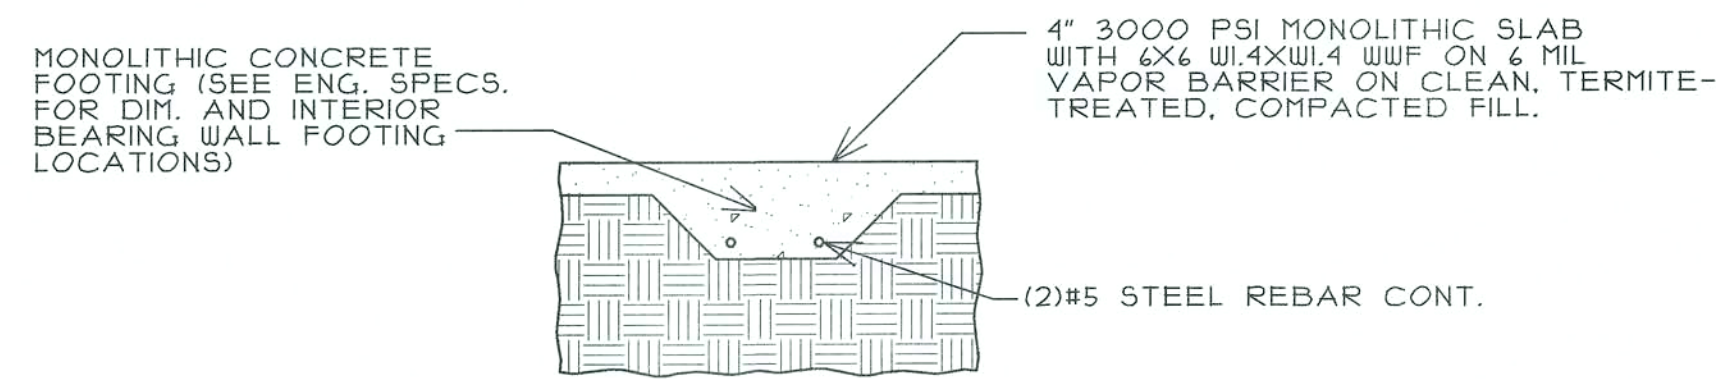

TYPICAL INTERIOR LOAD-BEARING FOOTING
SCALE: 1/2" = 1'-0"

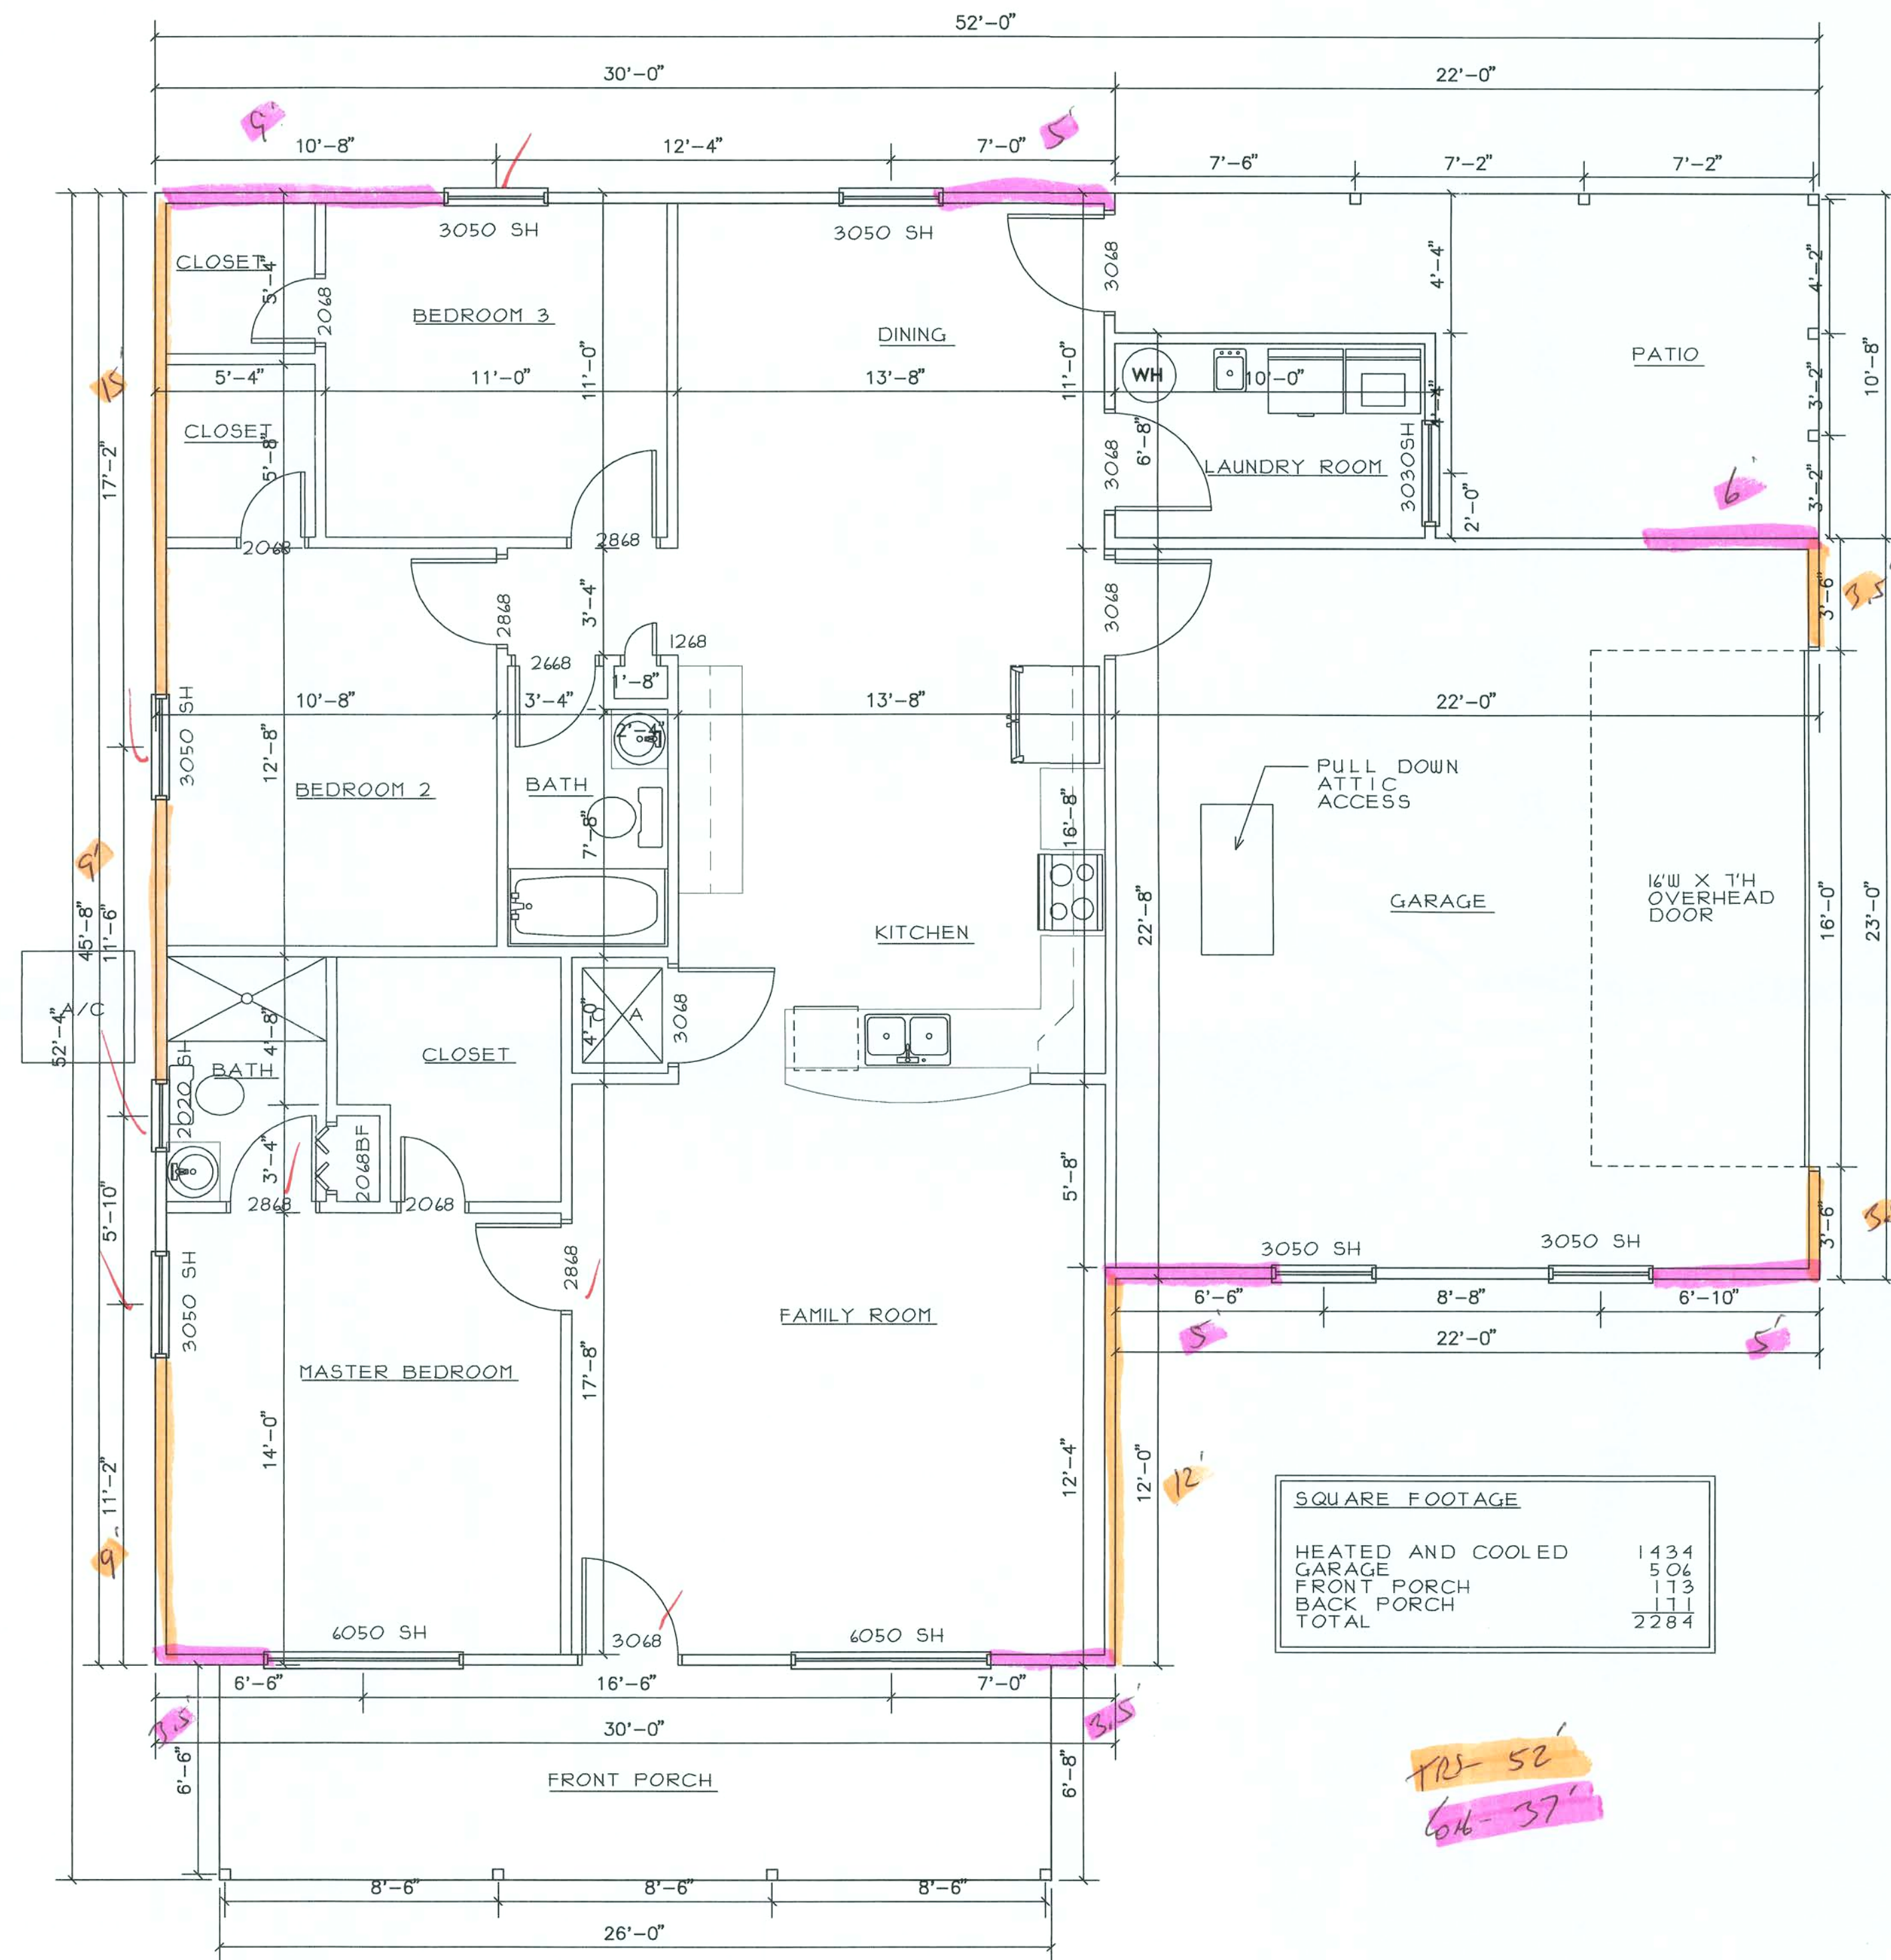

FLOOR PLAN
SCALE: 1/4" = 1'-0"

G C Construction
P.O. Box 5993
Gainesville, FL 32627
Phone 386-418-2114
gclennon@att.net

Drawn by: Steve Ryall Architectural Drafting
16794 NW 212th Terrace
High Springs, Florida 32643
352-871-6251

SANTA FE RIVER PLANTATIONS


LOT 46

FLOOR PLAN


SCALE: 1/4" = 1'-0"
JOB #: SF-2

REVISION
DATE


2

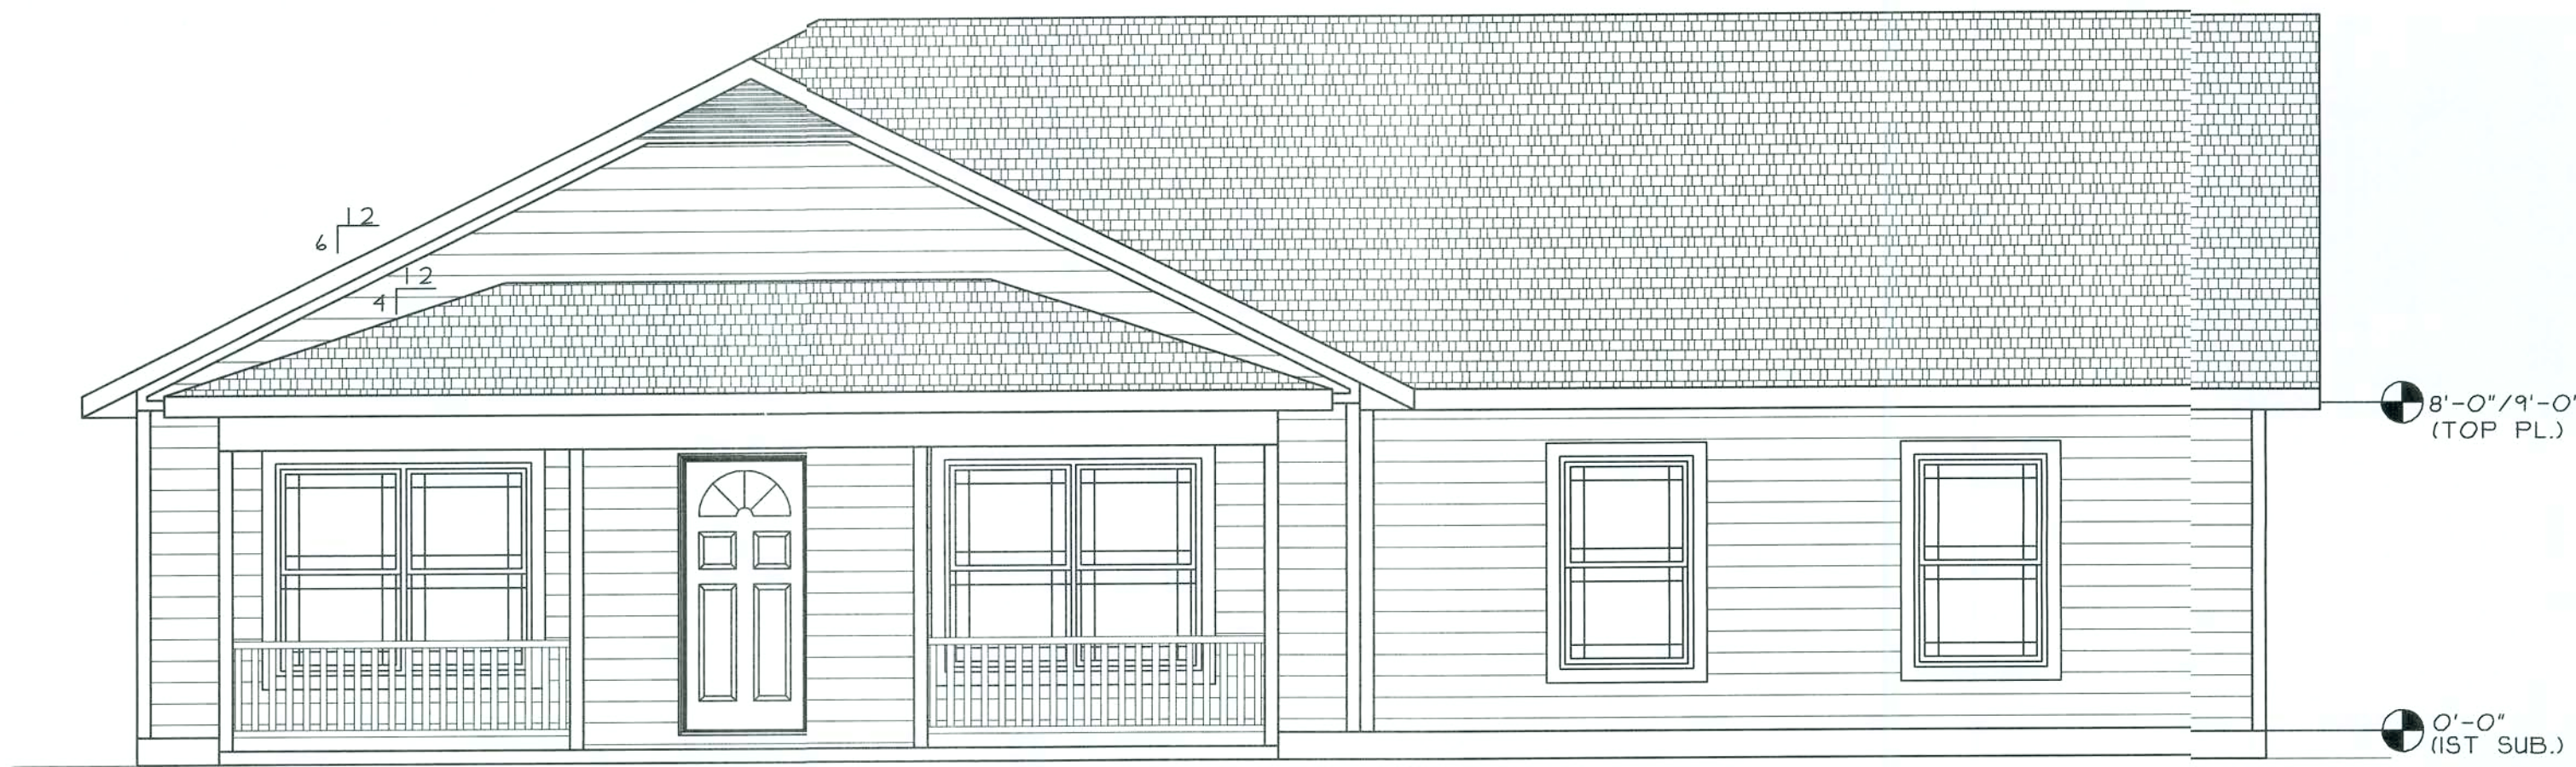


FRONT ELEVATION
SCALE: 1/4" = 1'-0"

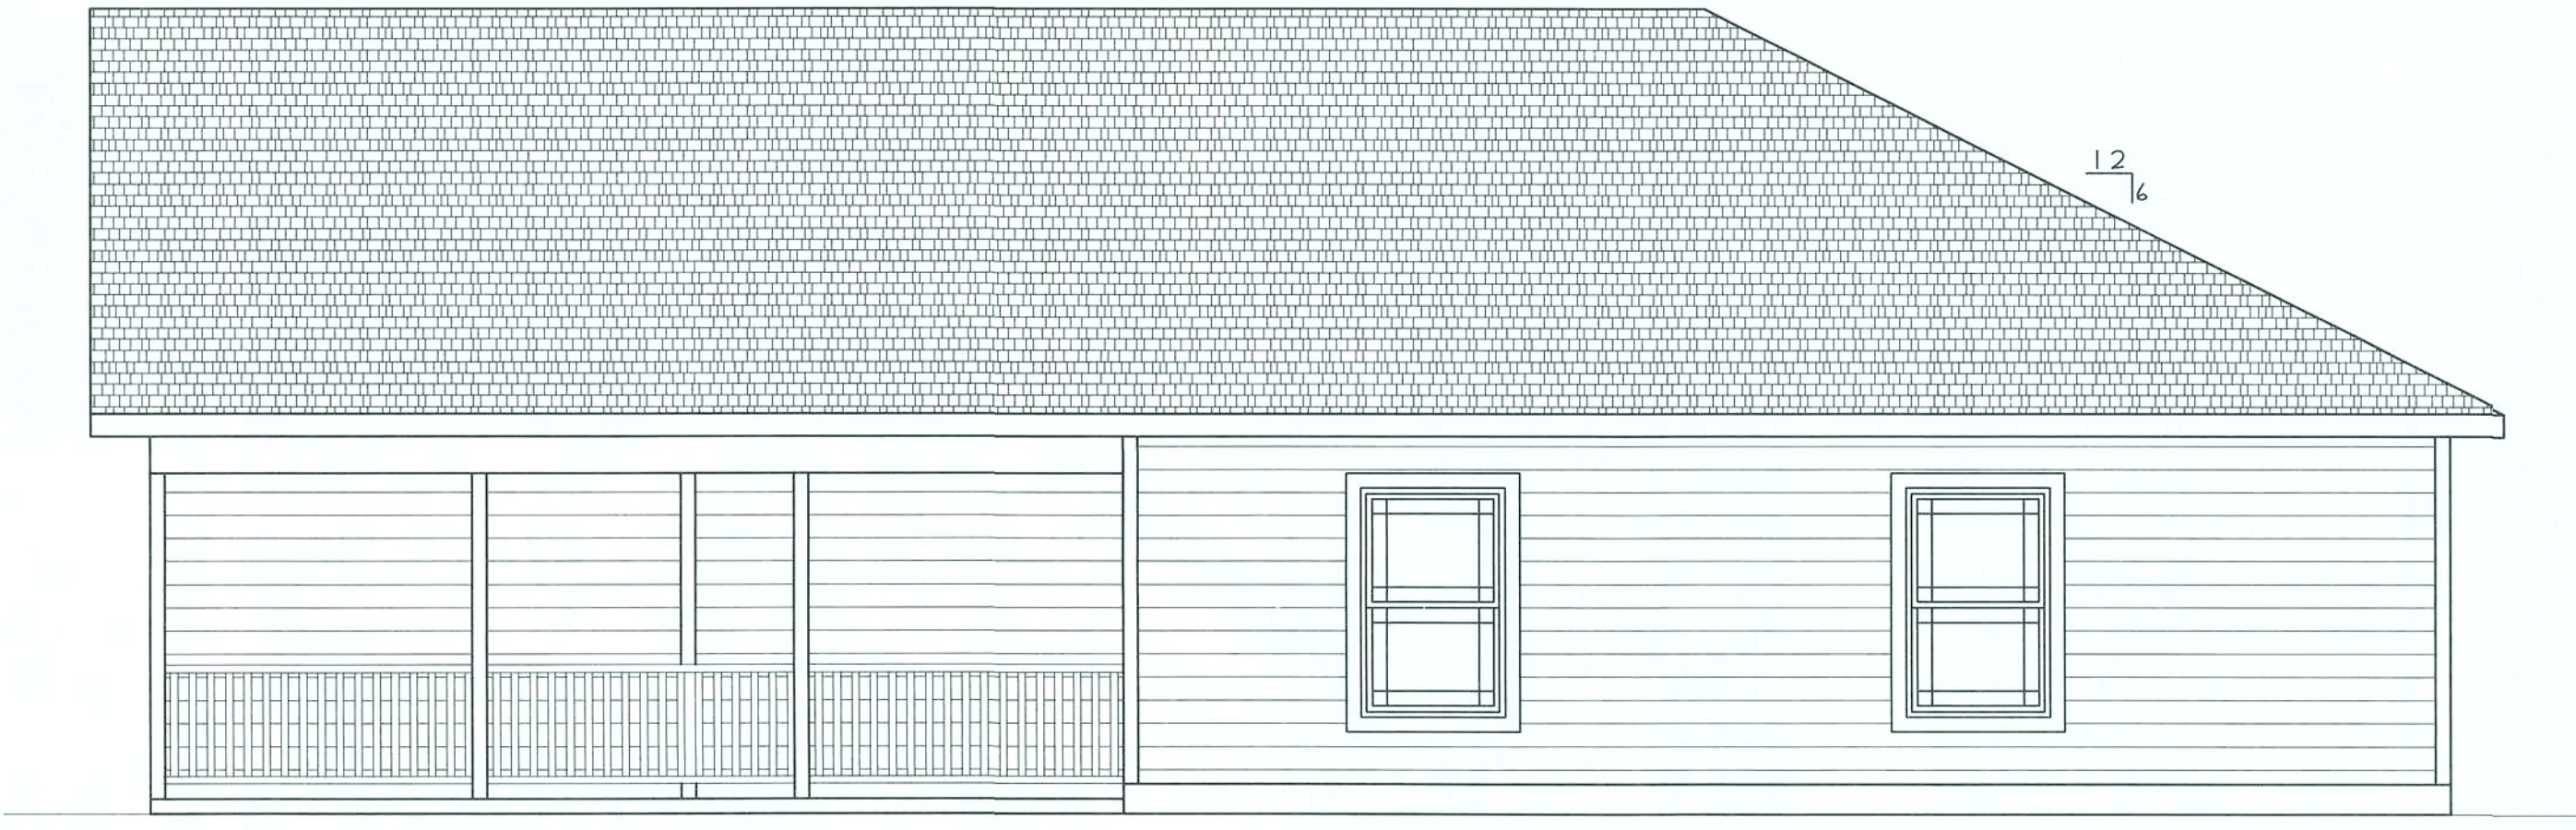

REAR ELEVATION
SCALE: 1/4" = 1'-0"

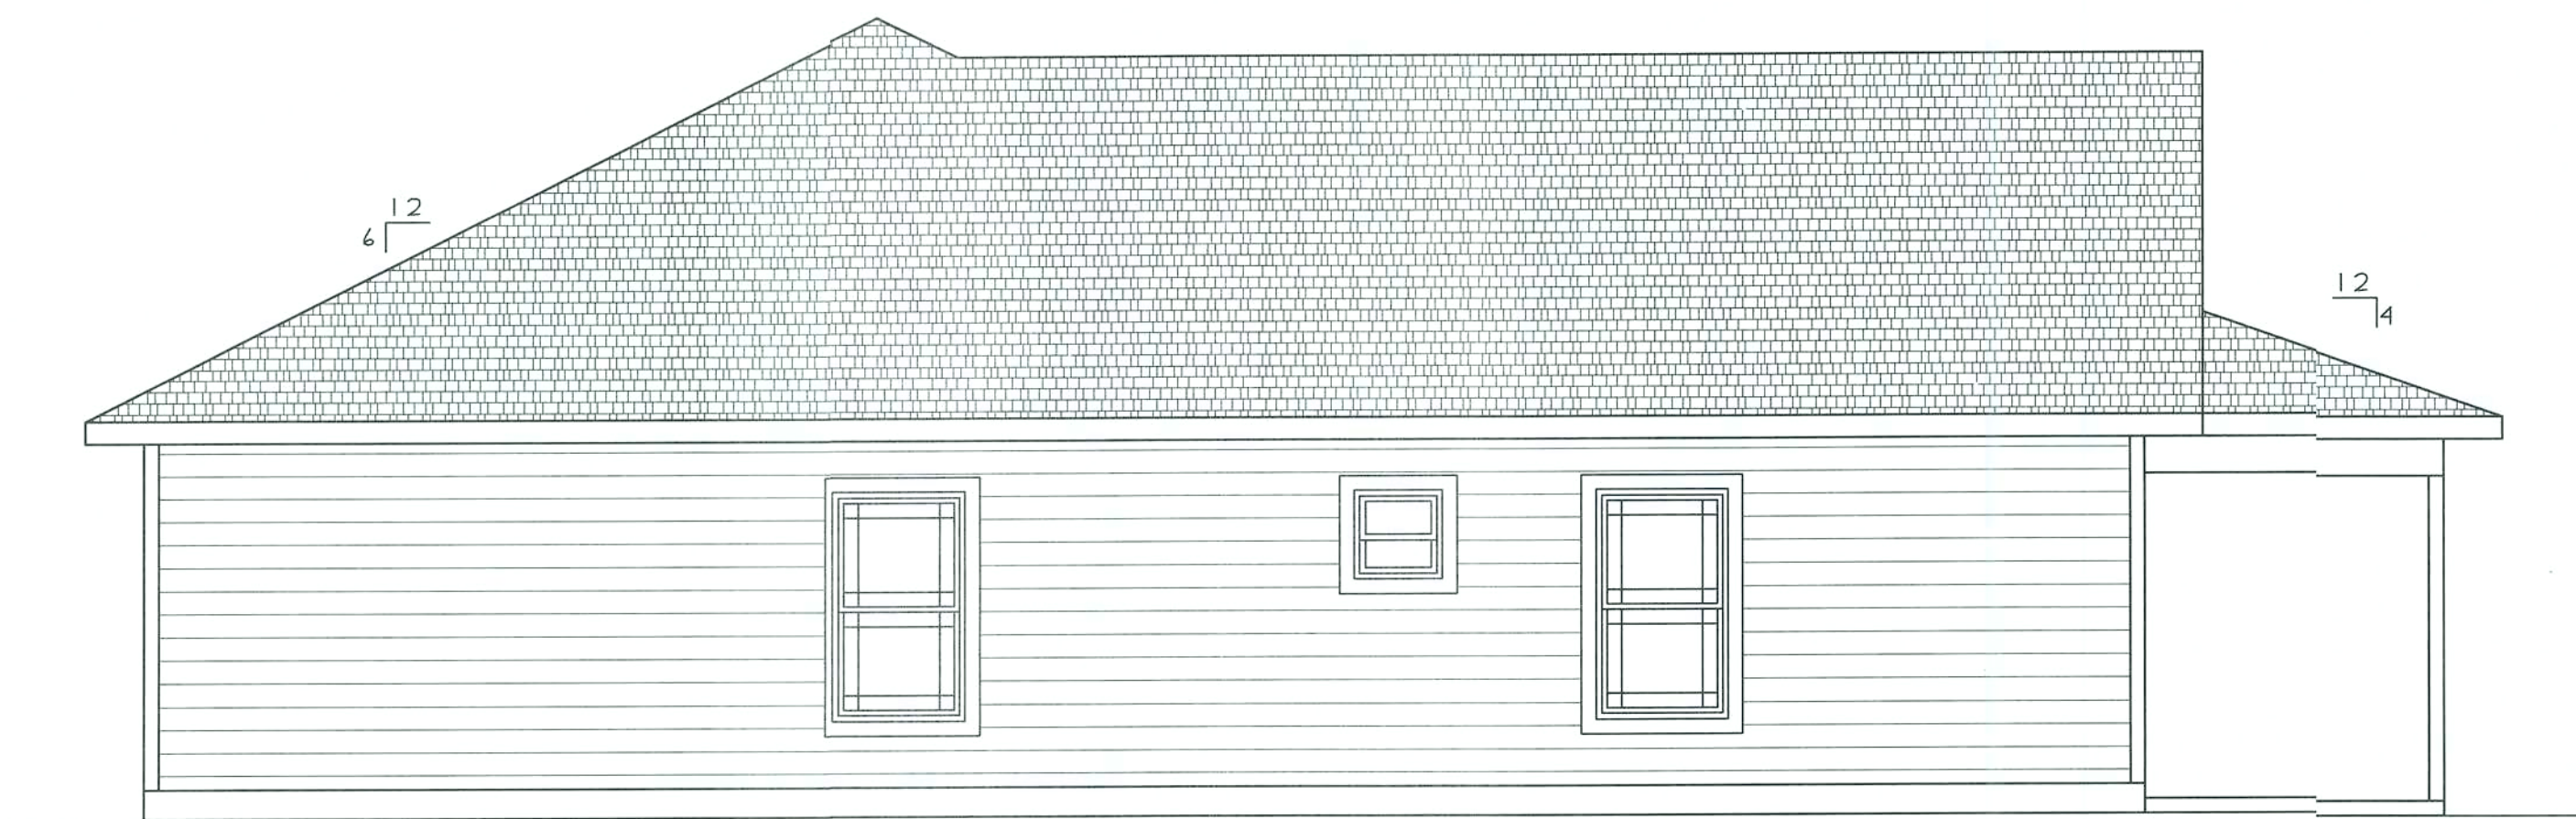

LEFT ELEVATION
SCALE: 1/4" = 1'-0"

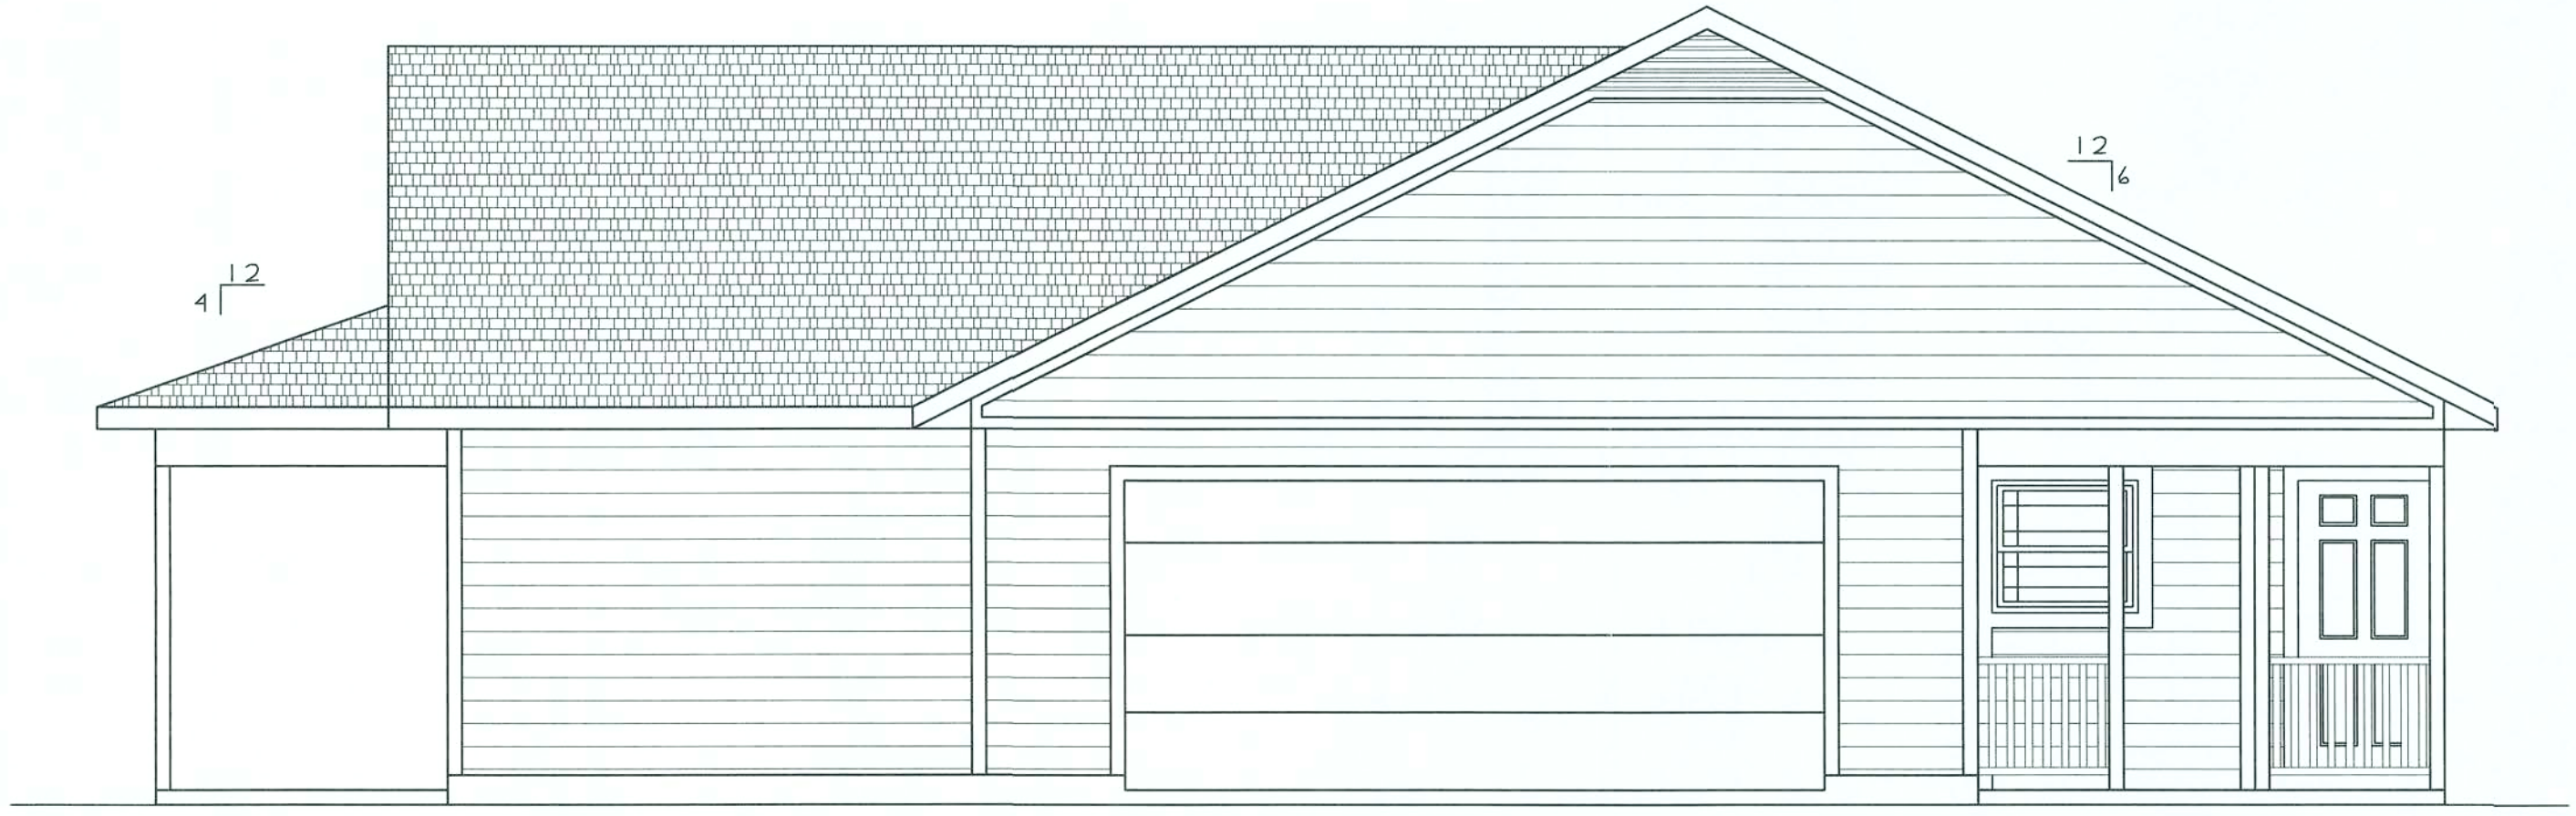

RIGHT ELEVATION
SCALE: 1/4" = 1'-0"

G C Construction CG-0032925
P.O. Box 5893 Phone 386-418-2114
Gainesville, FL 32627 galemmon@att.net
Drawn by: Steve Ryall Architectural Drafting
16794 NW 21st Terrace
Davie, Florida 32613
352-871-6251

SANTA FE RIVER PLANTATIONS

LOT 46

ELEVATIONS



SCALE: 1/4" = 1'-0"


JOB #: SF-2

REVISION

DATE

3

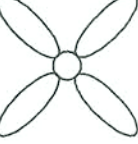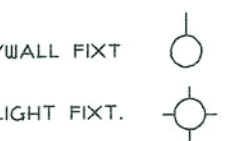ELECTRICAL KEY	
CEILING FAN WITH LIGHT FIXT.	
SMOKE DETECTOR	
RECESSED LIGHT	
SINGLE SWITCH	
2-WAY SWITCH	
DUPLEX OUTLET	
DUPLEX GFI OUTLET	
220 OUTLET	
RANGE OUTLET	
SECURITY LIGHT	
TV/CABLE OUTLET	
PHONE/ETHERNET	
EXHAUST FAN	
2X4 FLOR. FIXTURE	
COACH LT./BALL FIXT.	
HANGING LIGHT FIXT.	

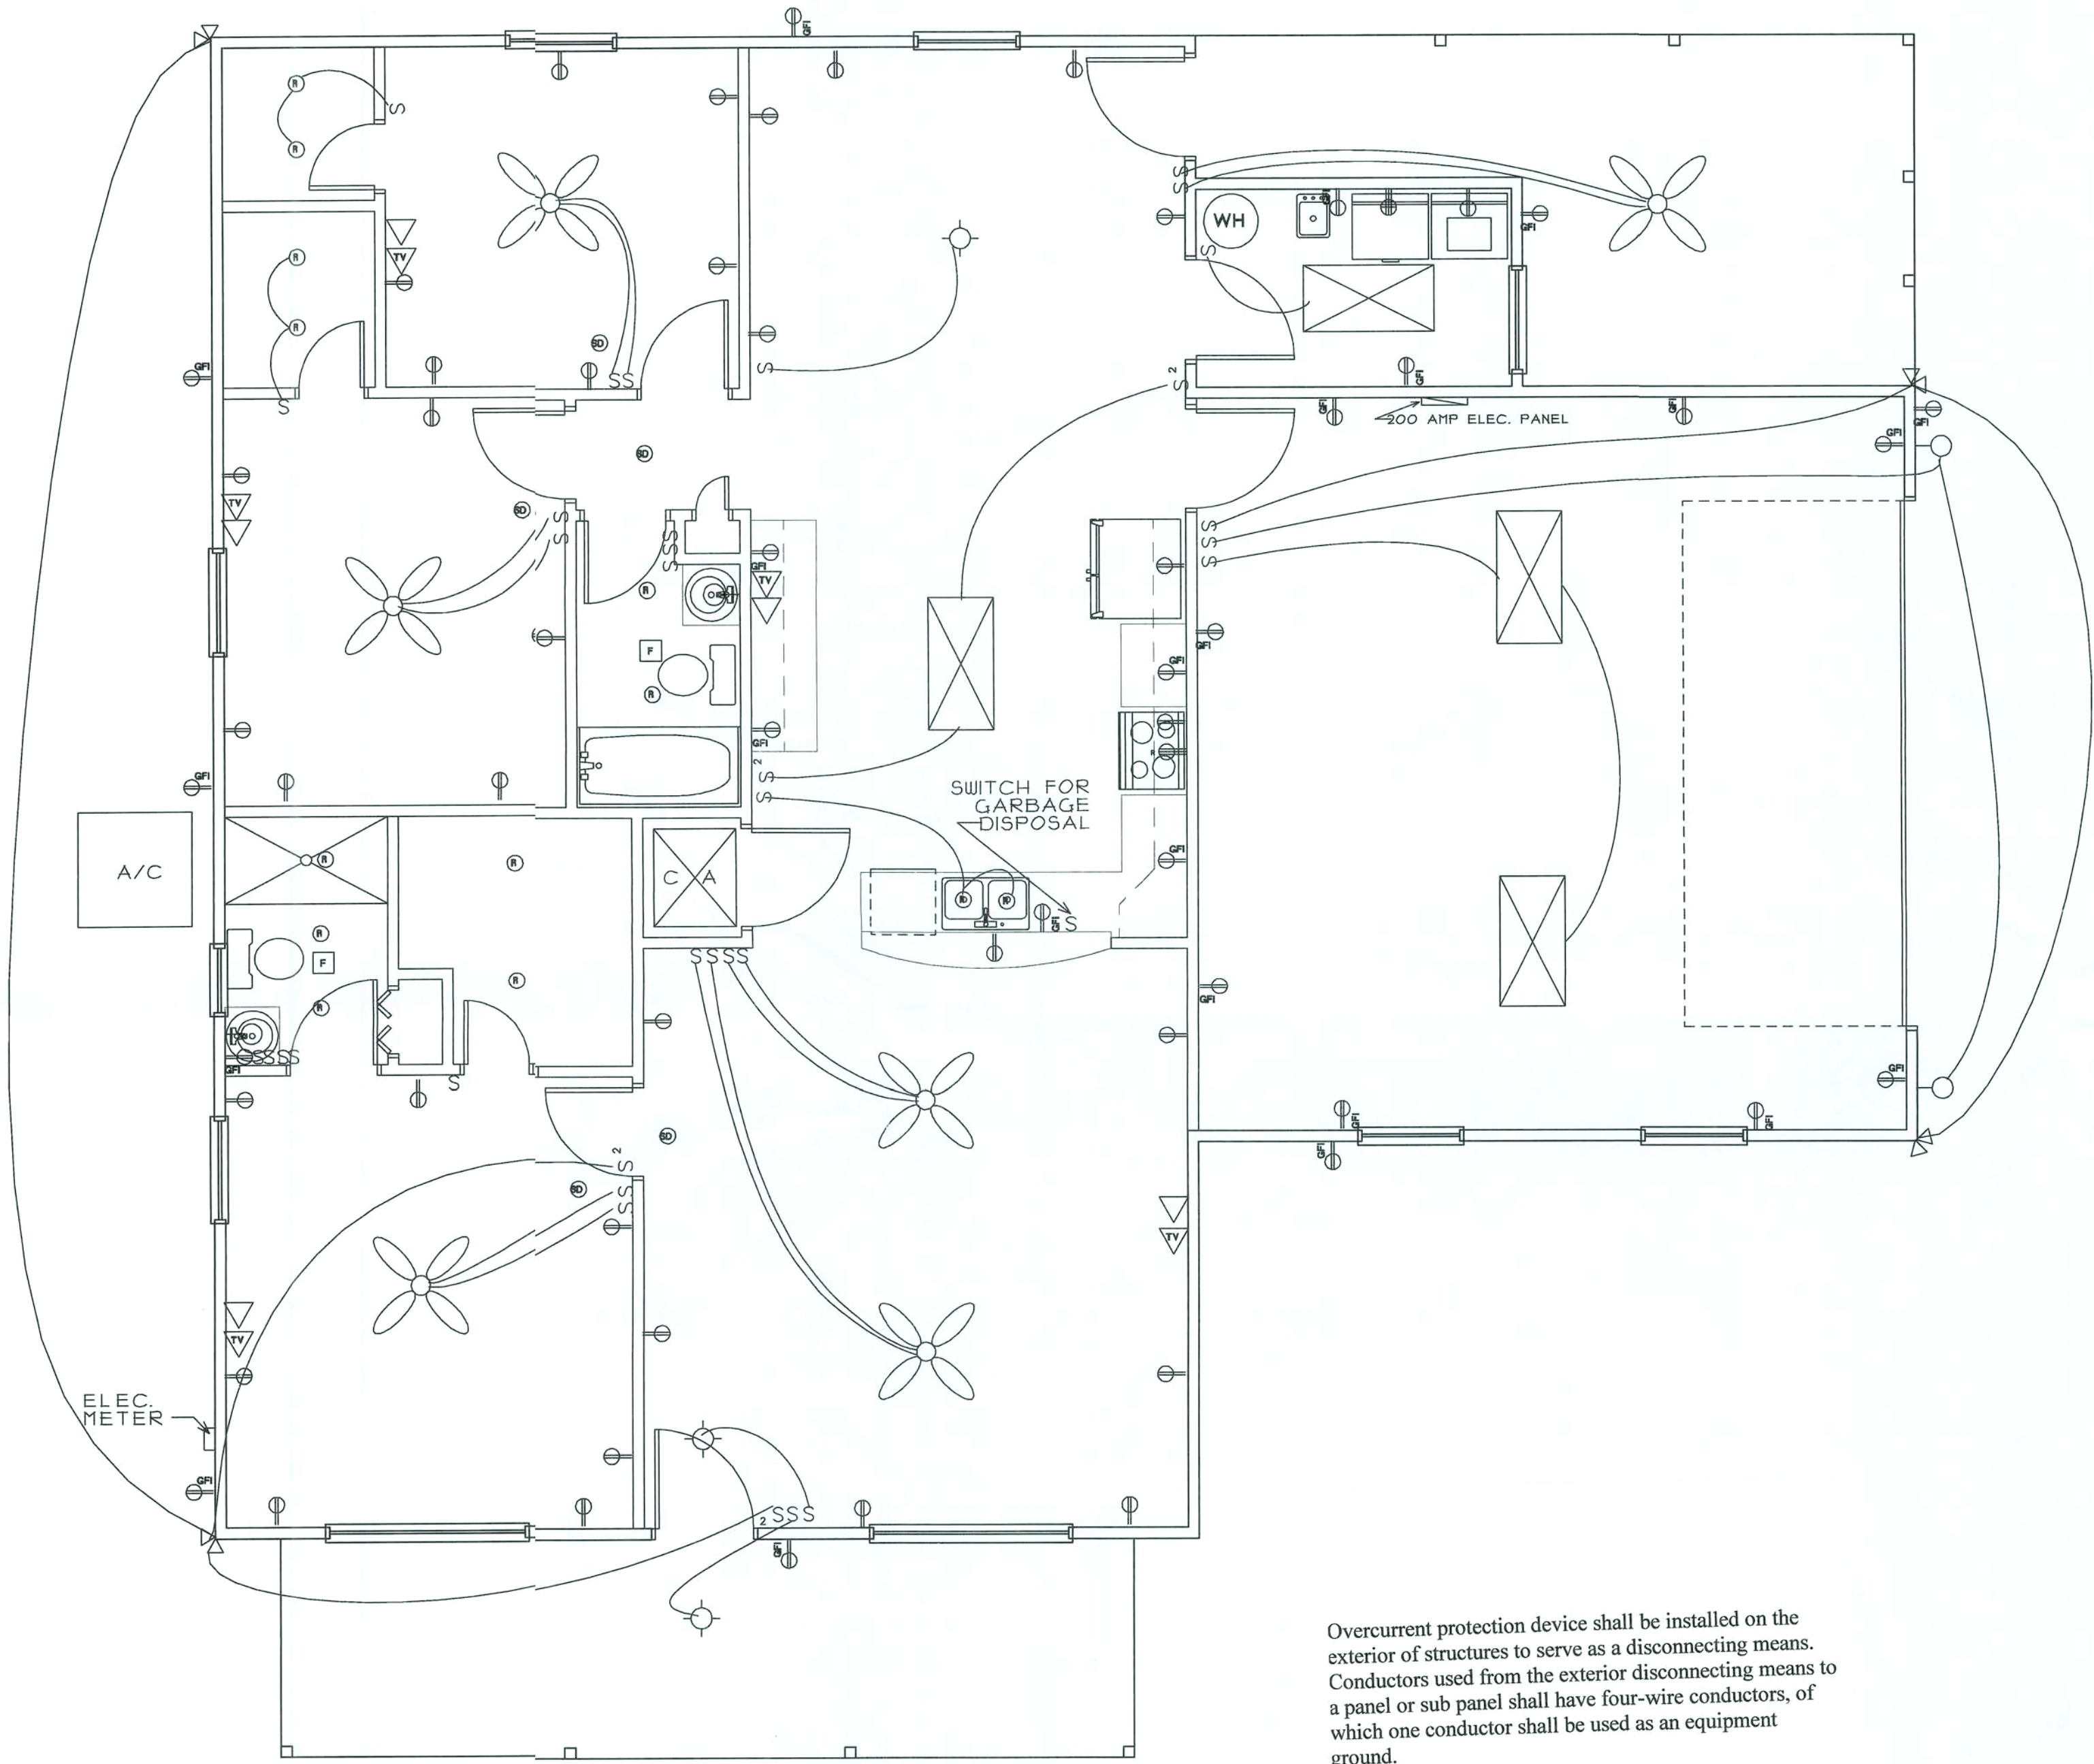

ELECTRICAL PLAN
SCALE: 1/4" = 1'-0"

4

ELECTRICAL PLAN

SCALE: 1/4" = 1'-0"

JOB #:

SF-2

REVISION

DATE

DATE

DATE

SANTA FE RIVER PLANTATIONS

LOT 46

G C Construction

CG-C052925

P.O. Box 5903

Gainesville, FL 32627

Phone 352-419-2114

gdemmon@iclat.net

Drawn by:

Steve Byall

Steve Byall Architectural Drafting

16794 NW 212th Terrace

Fort Myers, Florida 32643

352-871-6251


TRUSS NOTES:

1. ALL TRUSSES SHALL CARRY MANUFACTURERS STAMP.
2. ALL TRUSSES SHALL BE INSTALLED & BRACED TO MANUFACTURERS SPECIFICATIONS.
3. DESIGN DETAILS AND DRAWINGS FOR ALL TRUSSES SHALL BE ON-SITE FOR FRAMING INSPECTION.
4. TRUSSES SHALL NOT BE FIELD ALTERED WITHOUT PR OR BUILDING DEPT. APPROVAL OF ENG. CALCULATIONS.
5. NON-BEARING WALLS SHOULD BE HELD DOWN FROM THE TRUSS BOTTOM CHORD W/SIMPSON STC TO INSURE THE TRUSS BOTTOM CHORD WILL NOT BEAR ON THE WALL.
6. ALL CONNECTIONS OF RAFTERS, JACK OR HIP TRUSSES TO MAIN GIRDER TO BE PROVIDED BY TRUSS MANUFACTURER.
7. ALL ROOF FRAMING 24" O. C.
8. ALL ROOF PITCHES 4:12, UNLESS OTHERWISE NOTED
9. ALL OVERHANGS 16".

ATTIC VENT NOTES:

AREA/300

1. PROVIDE 1" MIN. AIR GAP AT EAVES WITH INSULATION BAFFLES TYP. AT ALL TRUSS BAYS.
2. PROVIDE GABLE VENTS AT ALL GABLE ENDS.
3. PROVIDE GALV. ROOF VENTS ON BACK SIDE OF ROOFLINE ABOVE CONDITIONED AREAS.
4. 2218 SQ. /FT. OF ATTICE SPACE/300=7.59
5. 7.59/.12=10.54
6. USE 11 4" OFF-RIDGE VENTS.

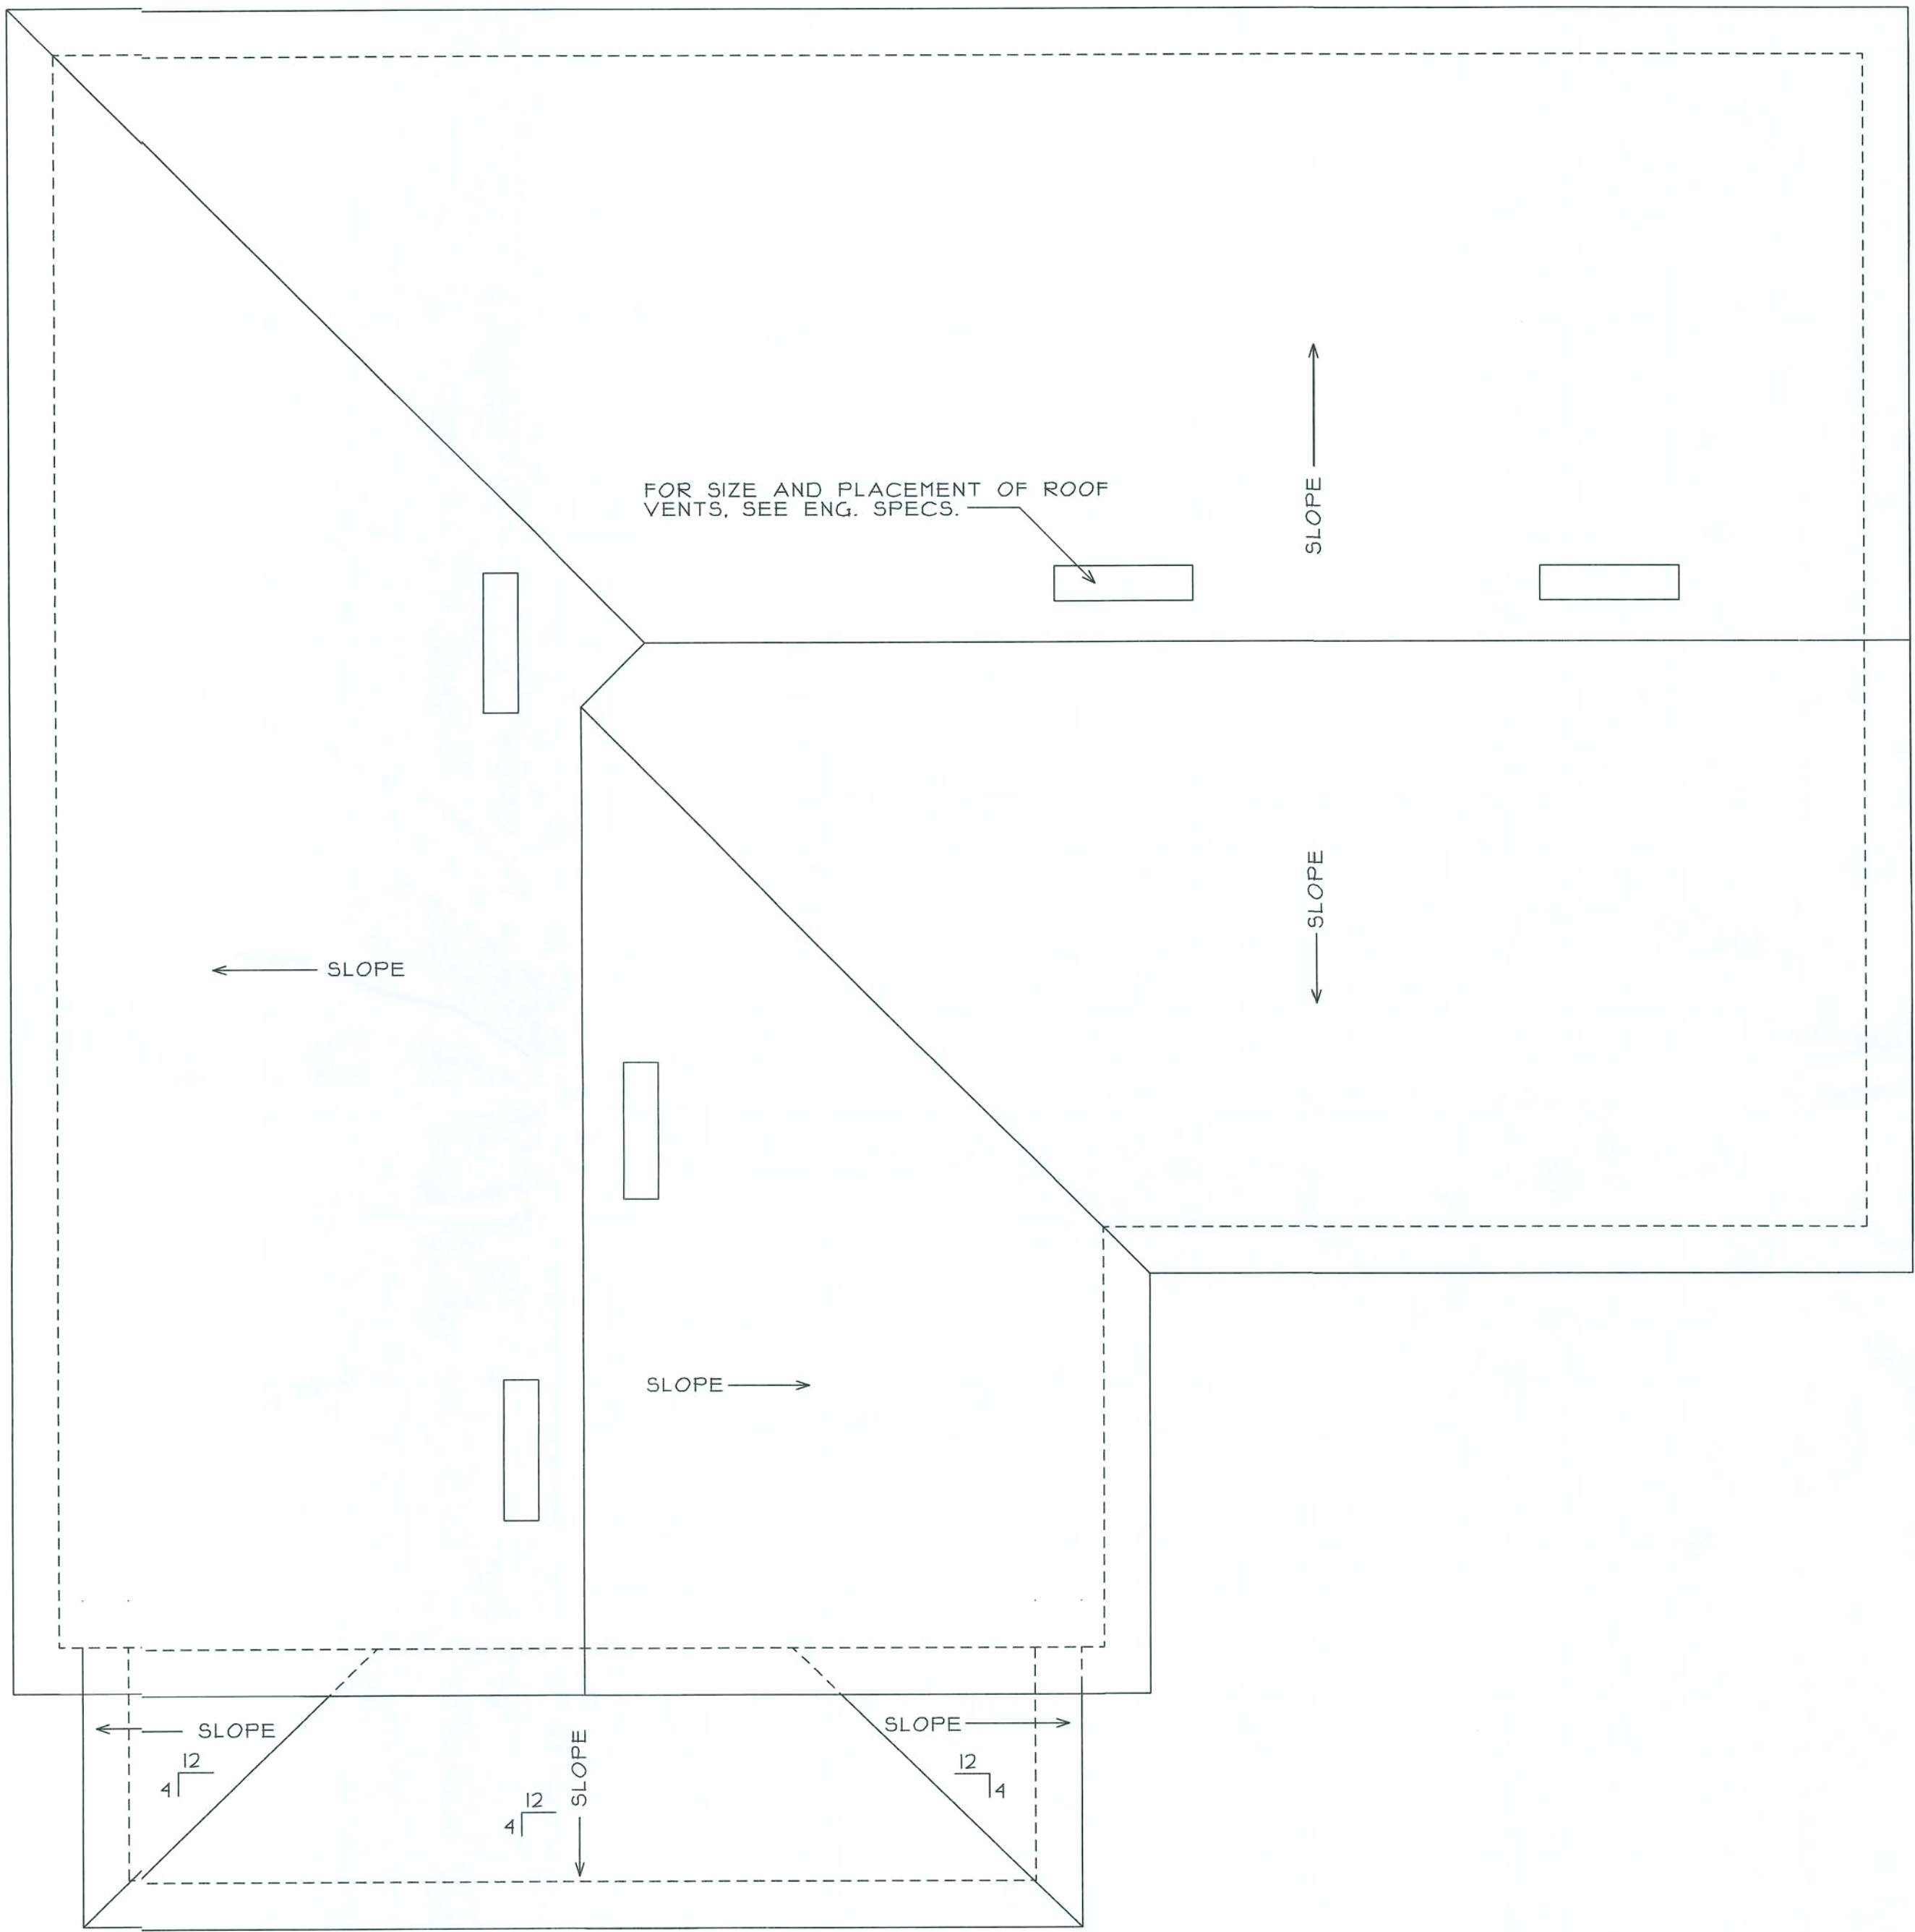

ROOF PLAN

SCALE: 1/4" = 1'-0"

ROOF PLAN

SCALE: 1/4" = 1'-0"

JOB #: SF-2

REVISION

DATE

SANTA FE RIVER PLANTATIONS

LOT 46

G C Construction CG-C052925
P.O. Box 5893 Phone 386-418-2114
Gainesville, FL 32627 gclenmon@ollet.net
Drawn by: Steve Ryall Architectural Drafting
16794 NW 212th Terrace
High Springs, Florida 32643
352-871-6251

2