

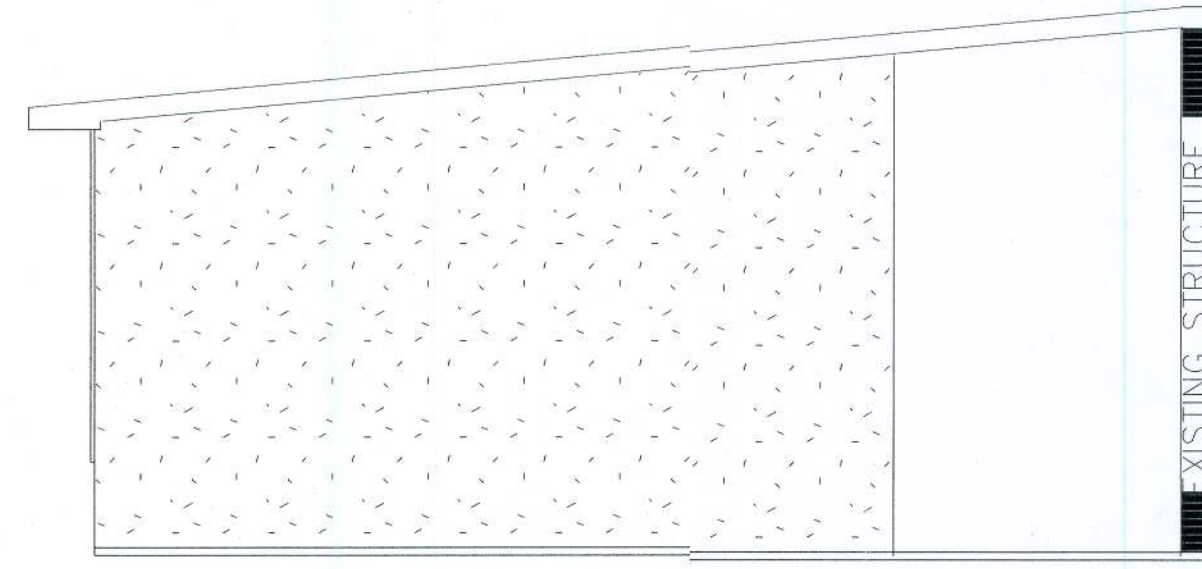


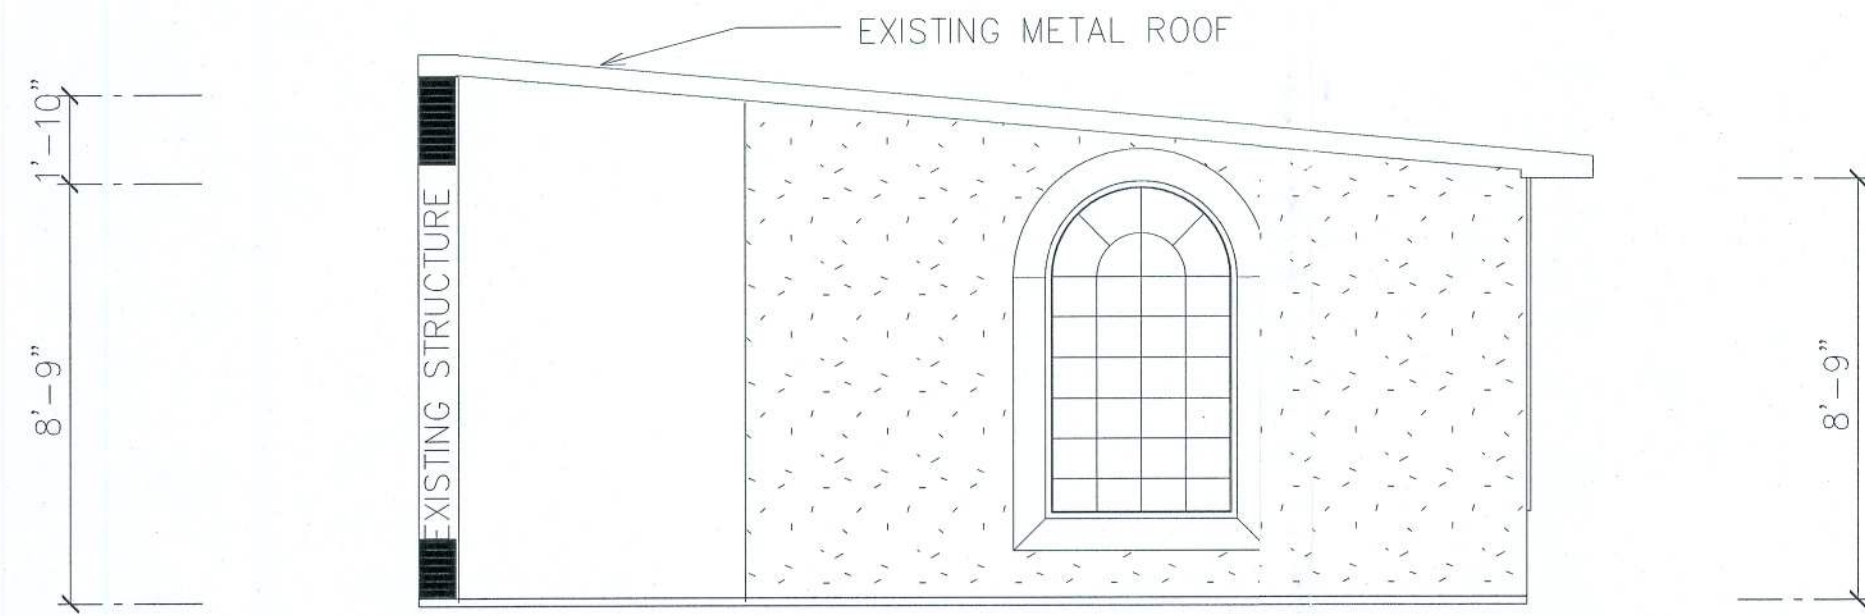

Elevation Plan

SCALE: 1/4" = 1'-0"

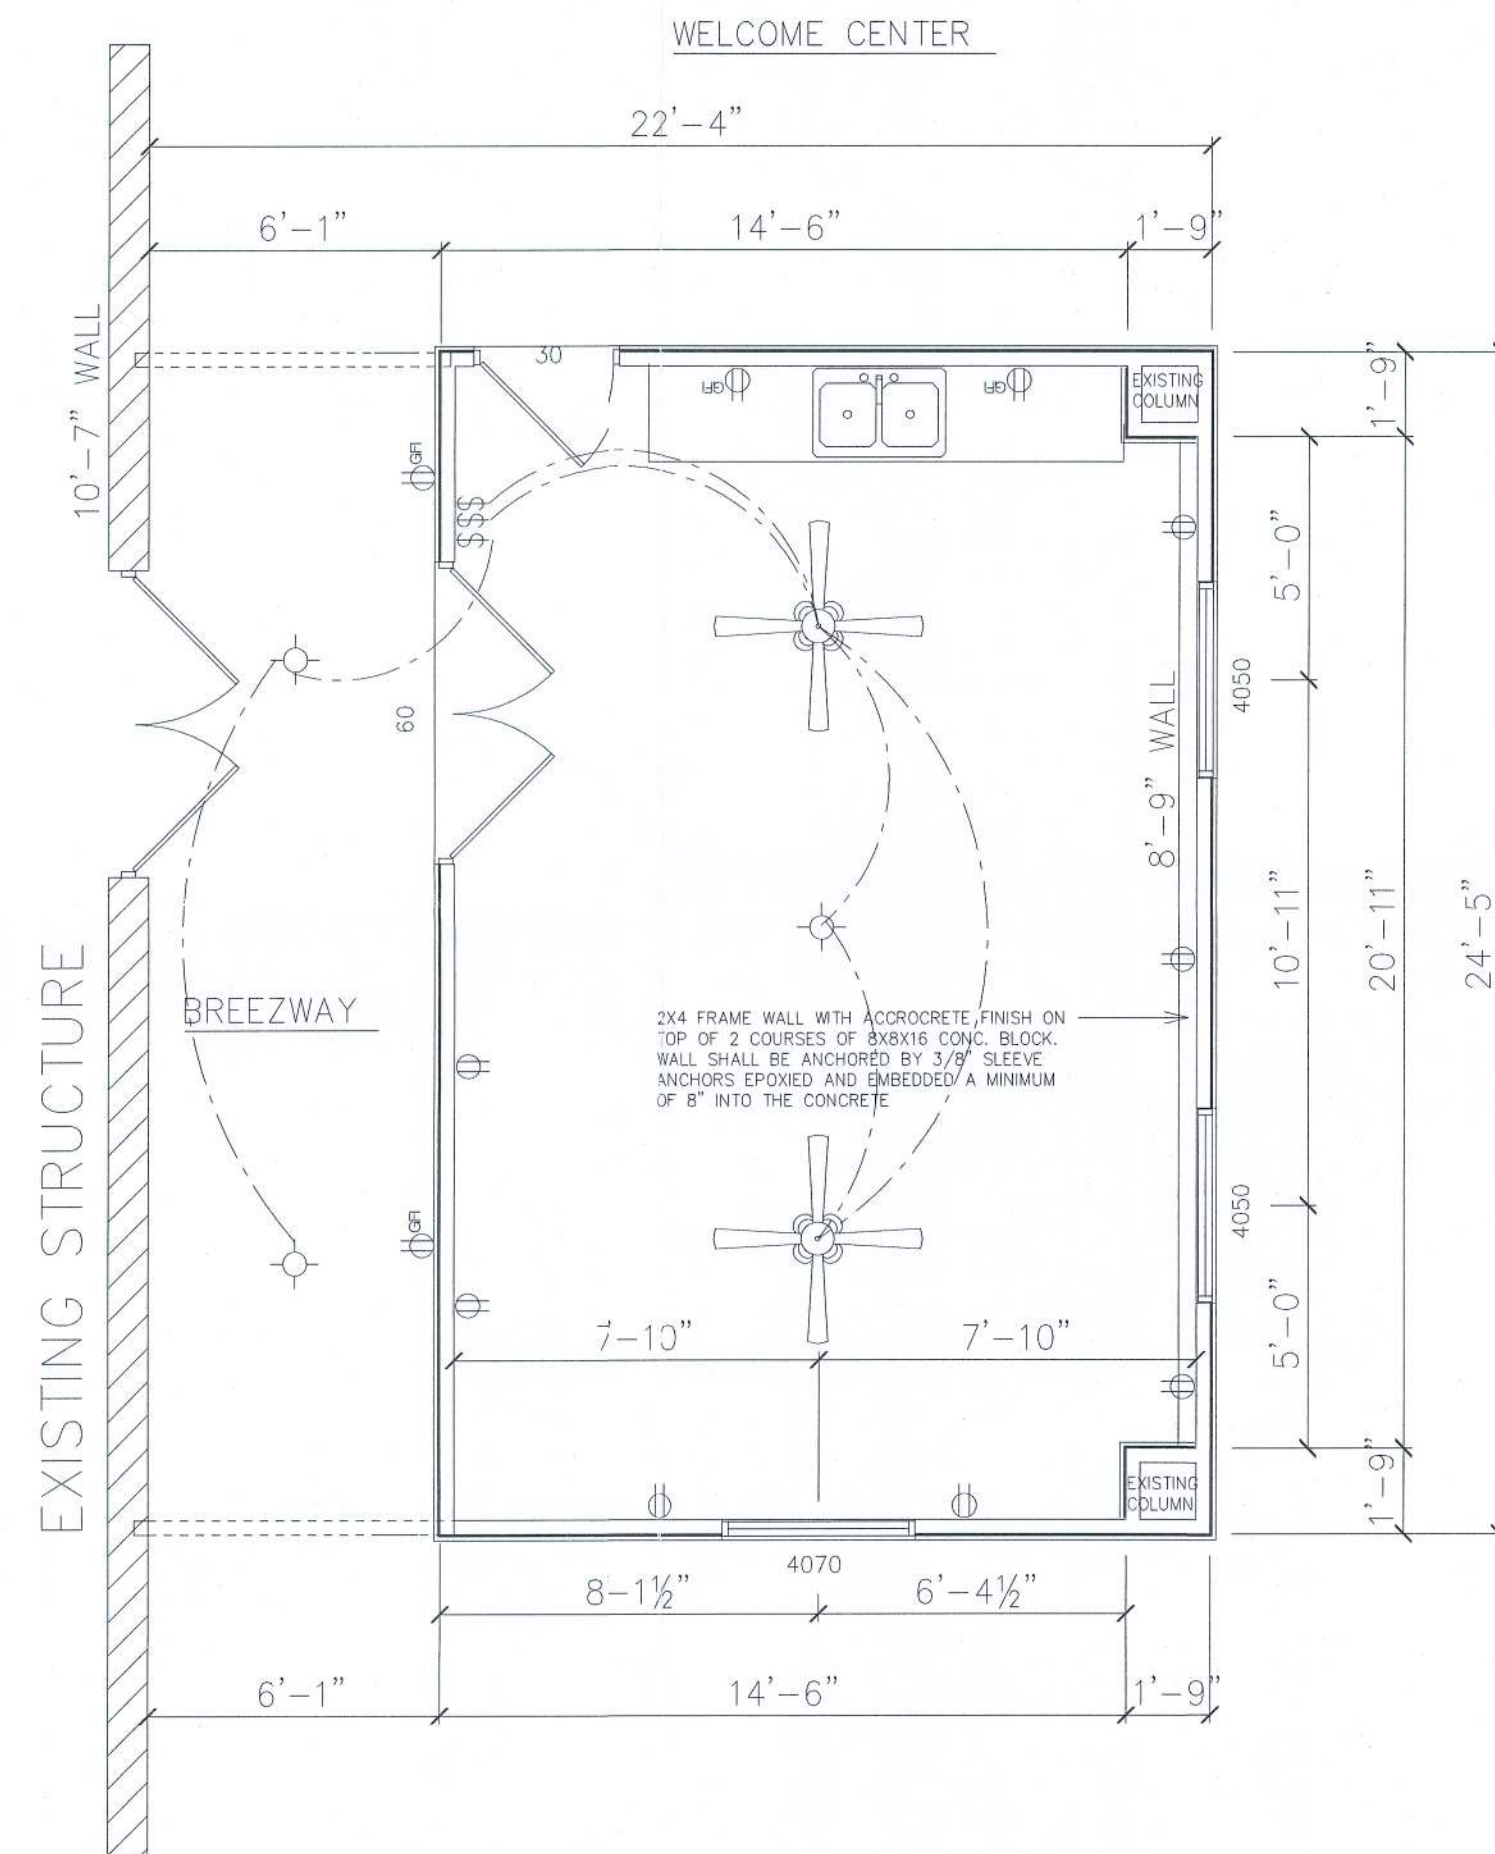

ELECTRICAL NOTES

ALL RECEPTS IN ALL BEDROOMS SHALL BE AFCI CIRCUITS.

WIRE ALL APPLIANCES, HVAC UNITS AND OTHER EQUIPMENT PER MANUF. SPECIFICATIONS.

CONSULT THE OWNER FOR THE NUMBER OF SEPARATE TELEPHONE LINES TO BE INSTALLED.


INSTALLATION SHALL BE PER NATL. ELECTRIC CODE.

ALL SMOKE DETECTORS SHALL BE 120V W/ BATTERY BACKUP OF THERMOELECTRIC TYPE, AND SHALL BE INTERLOCKED TOGETHER. INSTALL INSIDE AND NEAR ALL BEDROOMS.

TELEPHONE, TELEVISION AND OTHER LOW VOLTAGE DEVICES OR OUTLETS SHALL BE AS PER THE OWNER'S DIRECTIONS, & IN ACCORDANCE W/ APPLICABLE SECTIONS OF N.C.L.A. TEST EDITION.

ELECTRICAL CONTR. SHALL PREPARE "AS-BUILT" SHOP DWGS INDICATING ALL ELECTRICAL WORK, INCLUDING ANY CHANGES TO THE ELEC. PLAN, ADDS TO THE ELEC. PLAN, RISER DIAGRAMS-BUILT PANEL SCHEDULE W/ ALL QXTS IDENTIFIED W/ CT N., DESCRIPTION & BRKR. SERVICE ENT. & ALL UNDERGROUND WIRE LOCATIONS/ROUTING/DEPTH. RISER DIA. SHALL INCLUDE WIRE SIZES/TYPES & EQUIPMENT TYPE W/ RATINGS & LOADS. CONTRACTOR SHALL PROVIDE 1 COPY OF AS-BUILT DWGS TO OWNER & 1 COPY TO THE PERMIT ISSUING AUTHORITY.

Square footage 495

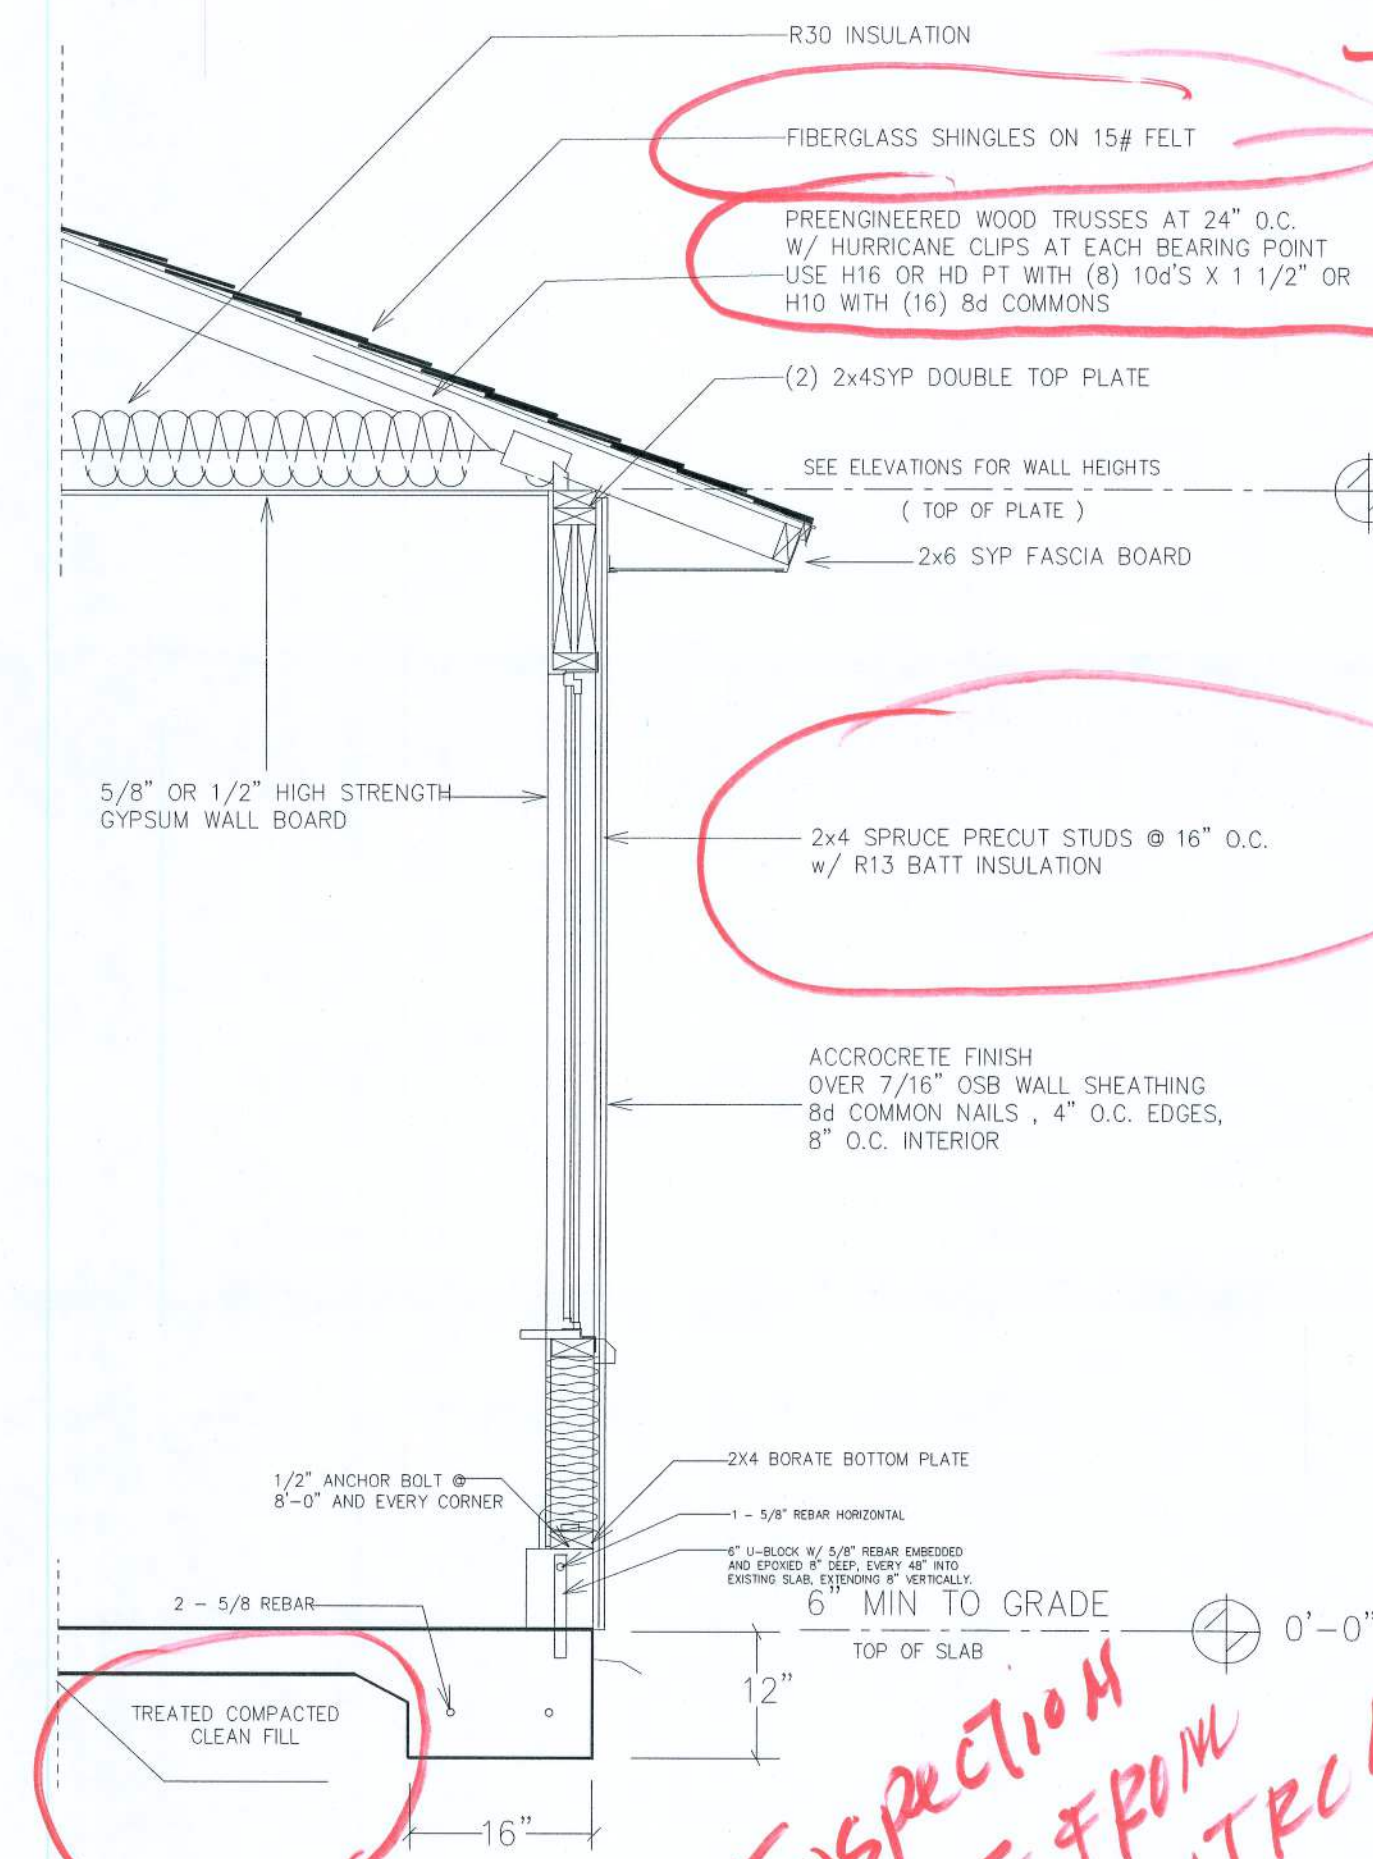

TYPICAL WALL SECTION

2 X 4 STUD WALL W/ ACCROCRETE

ADDITION FOR:
HOPEFUL BAPTIST
CHURCH

brian s. crowford
Architectural design
885 SW SISTERS WELCOME RD.
LAKE CITY, FL 32025
(386) 623-1154

WELCOME CENTER
SCALE: 1/4"=1'-0"

SHEET NUMBER

A-1

OF 1 SHEETS

APPROVED
(Subject to Revisions)
Inspection Department
Lake City Fire Dept
State Fire Inspector
License # 46544
By *Carleton Pineda* Date: 9/14/06