



DESCRIPTION
 THE SOUTH 1/2 OF THE S.E. 1/4 OF THE N.W. 1/4 OF
 SECTION 7, TOWNSHIP 4 SOUTH, RANGE 16 EAST
 COLUMBIA COUNTY FLORIDA

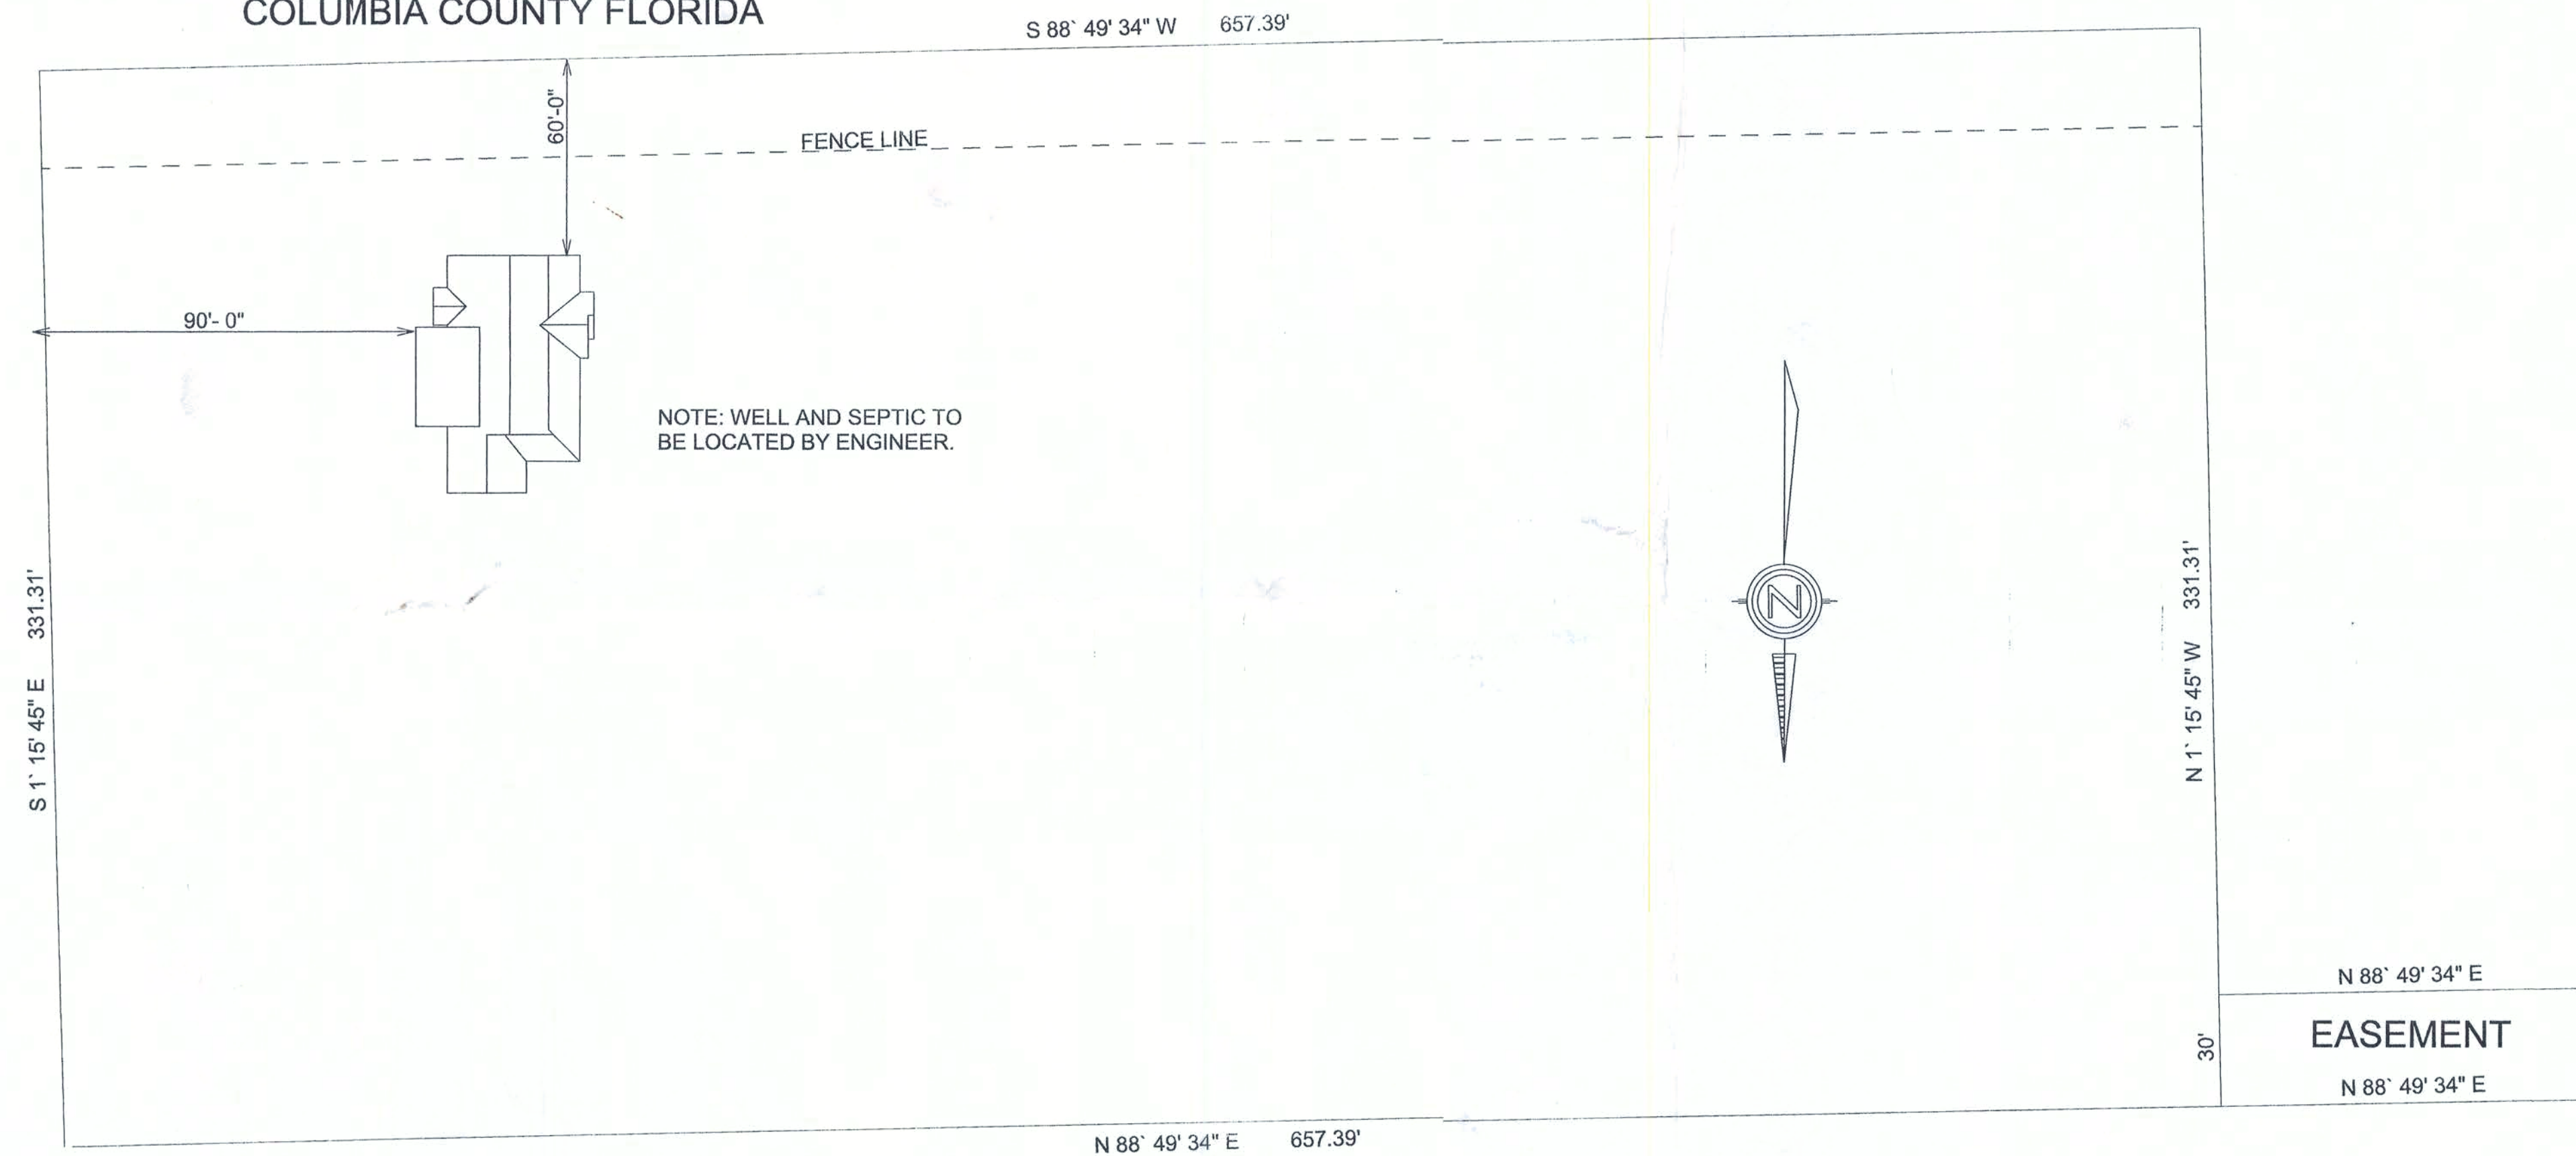

SITE PLAN
 SCALE: 1" = 40'


PRECISION DESIGN
SOLUTIONS
 DRAFTING, DESIGN &
 CONSULTING

DRAWN BY:
 ROBERT
 CULOTTI
 PH#
 (386) 623-6198

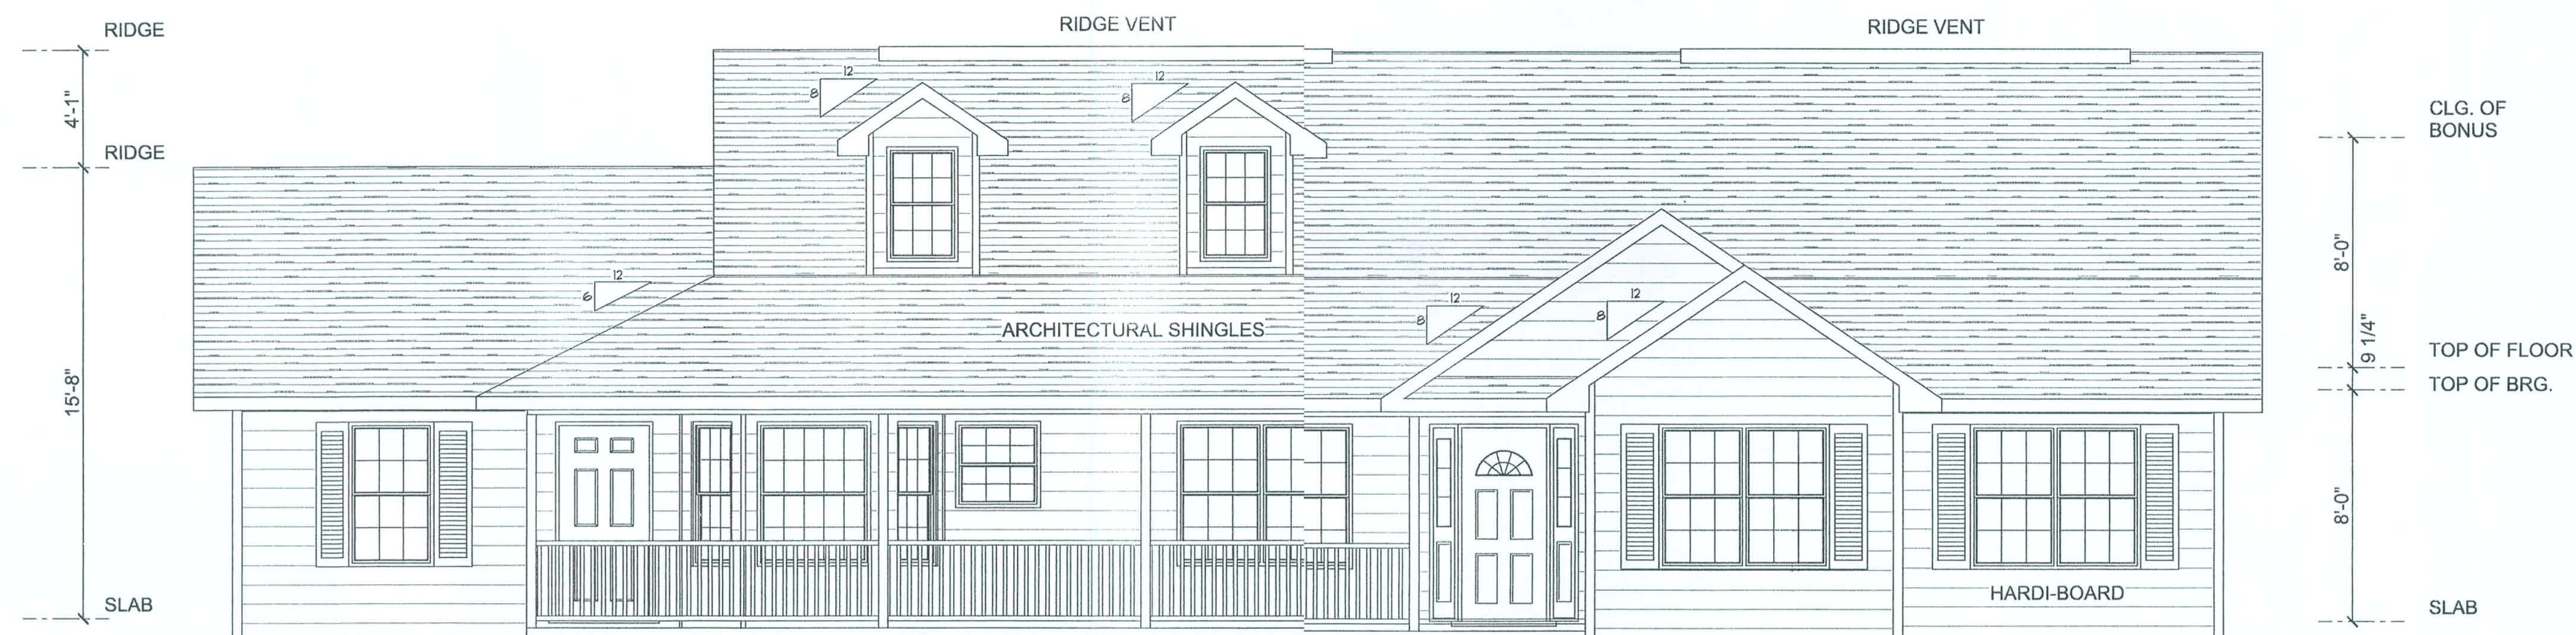

FRONT ELEVATION

SCALE: 1/4" = 1'-0"

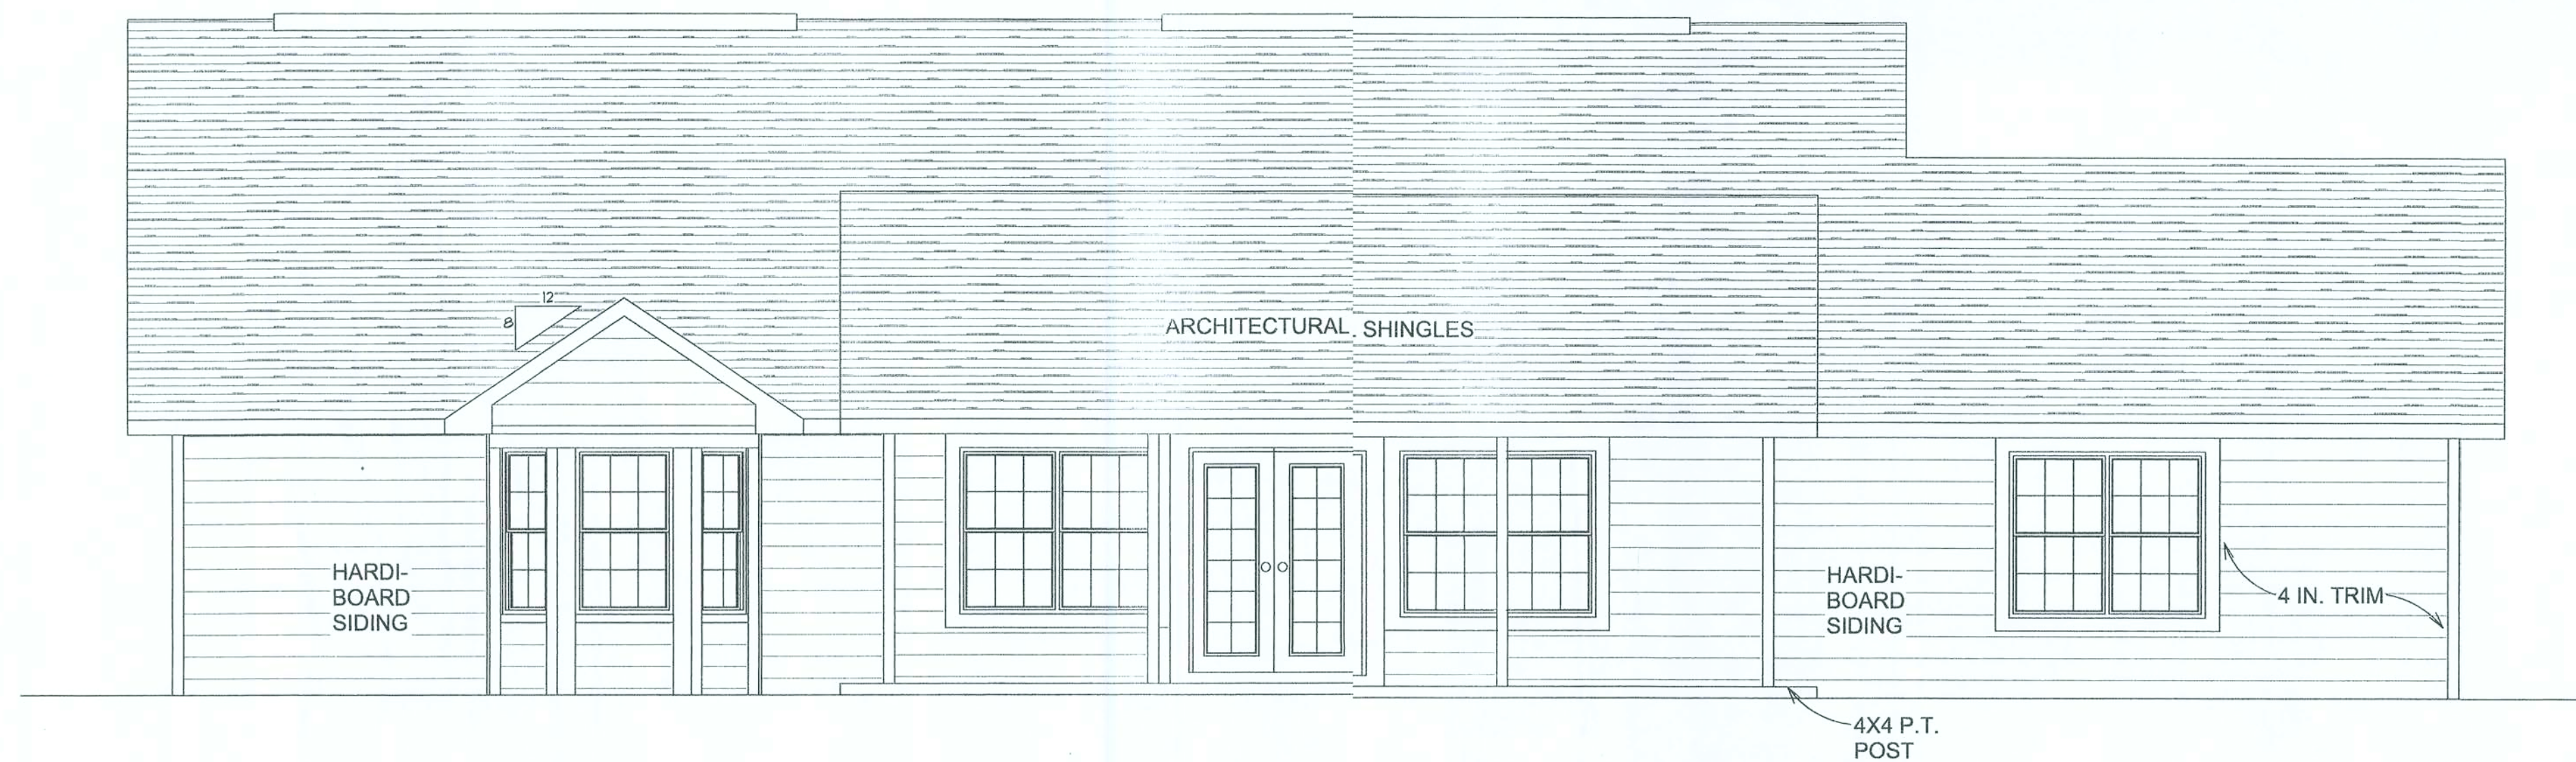

REAR ELEVATION

SCALE: 1/4" = 1'-0"

PRECISION DESIGN SOLUTIONS

DRAFTING, DESIGN &
CONSULTING

DRAWN BY:
ROBERT
CULOTTI
PH#
(386) 623-6198




PRECISION DESIGN SOLUTIONS

DRAFTING, DESIGN &
CONSULTING

DRAWN BY:
ROBERT
CULOTTI

PH#
(386) 623-6198

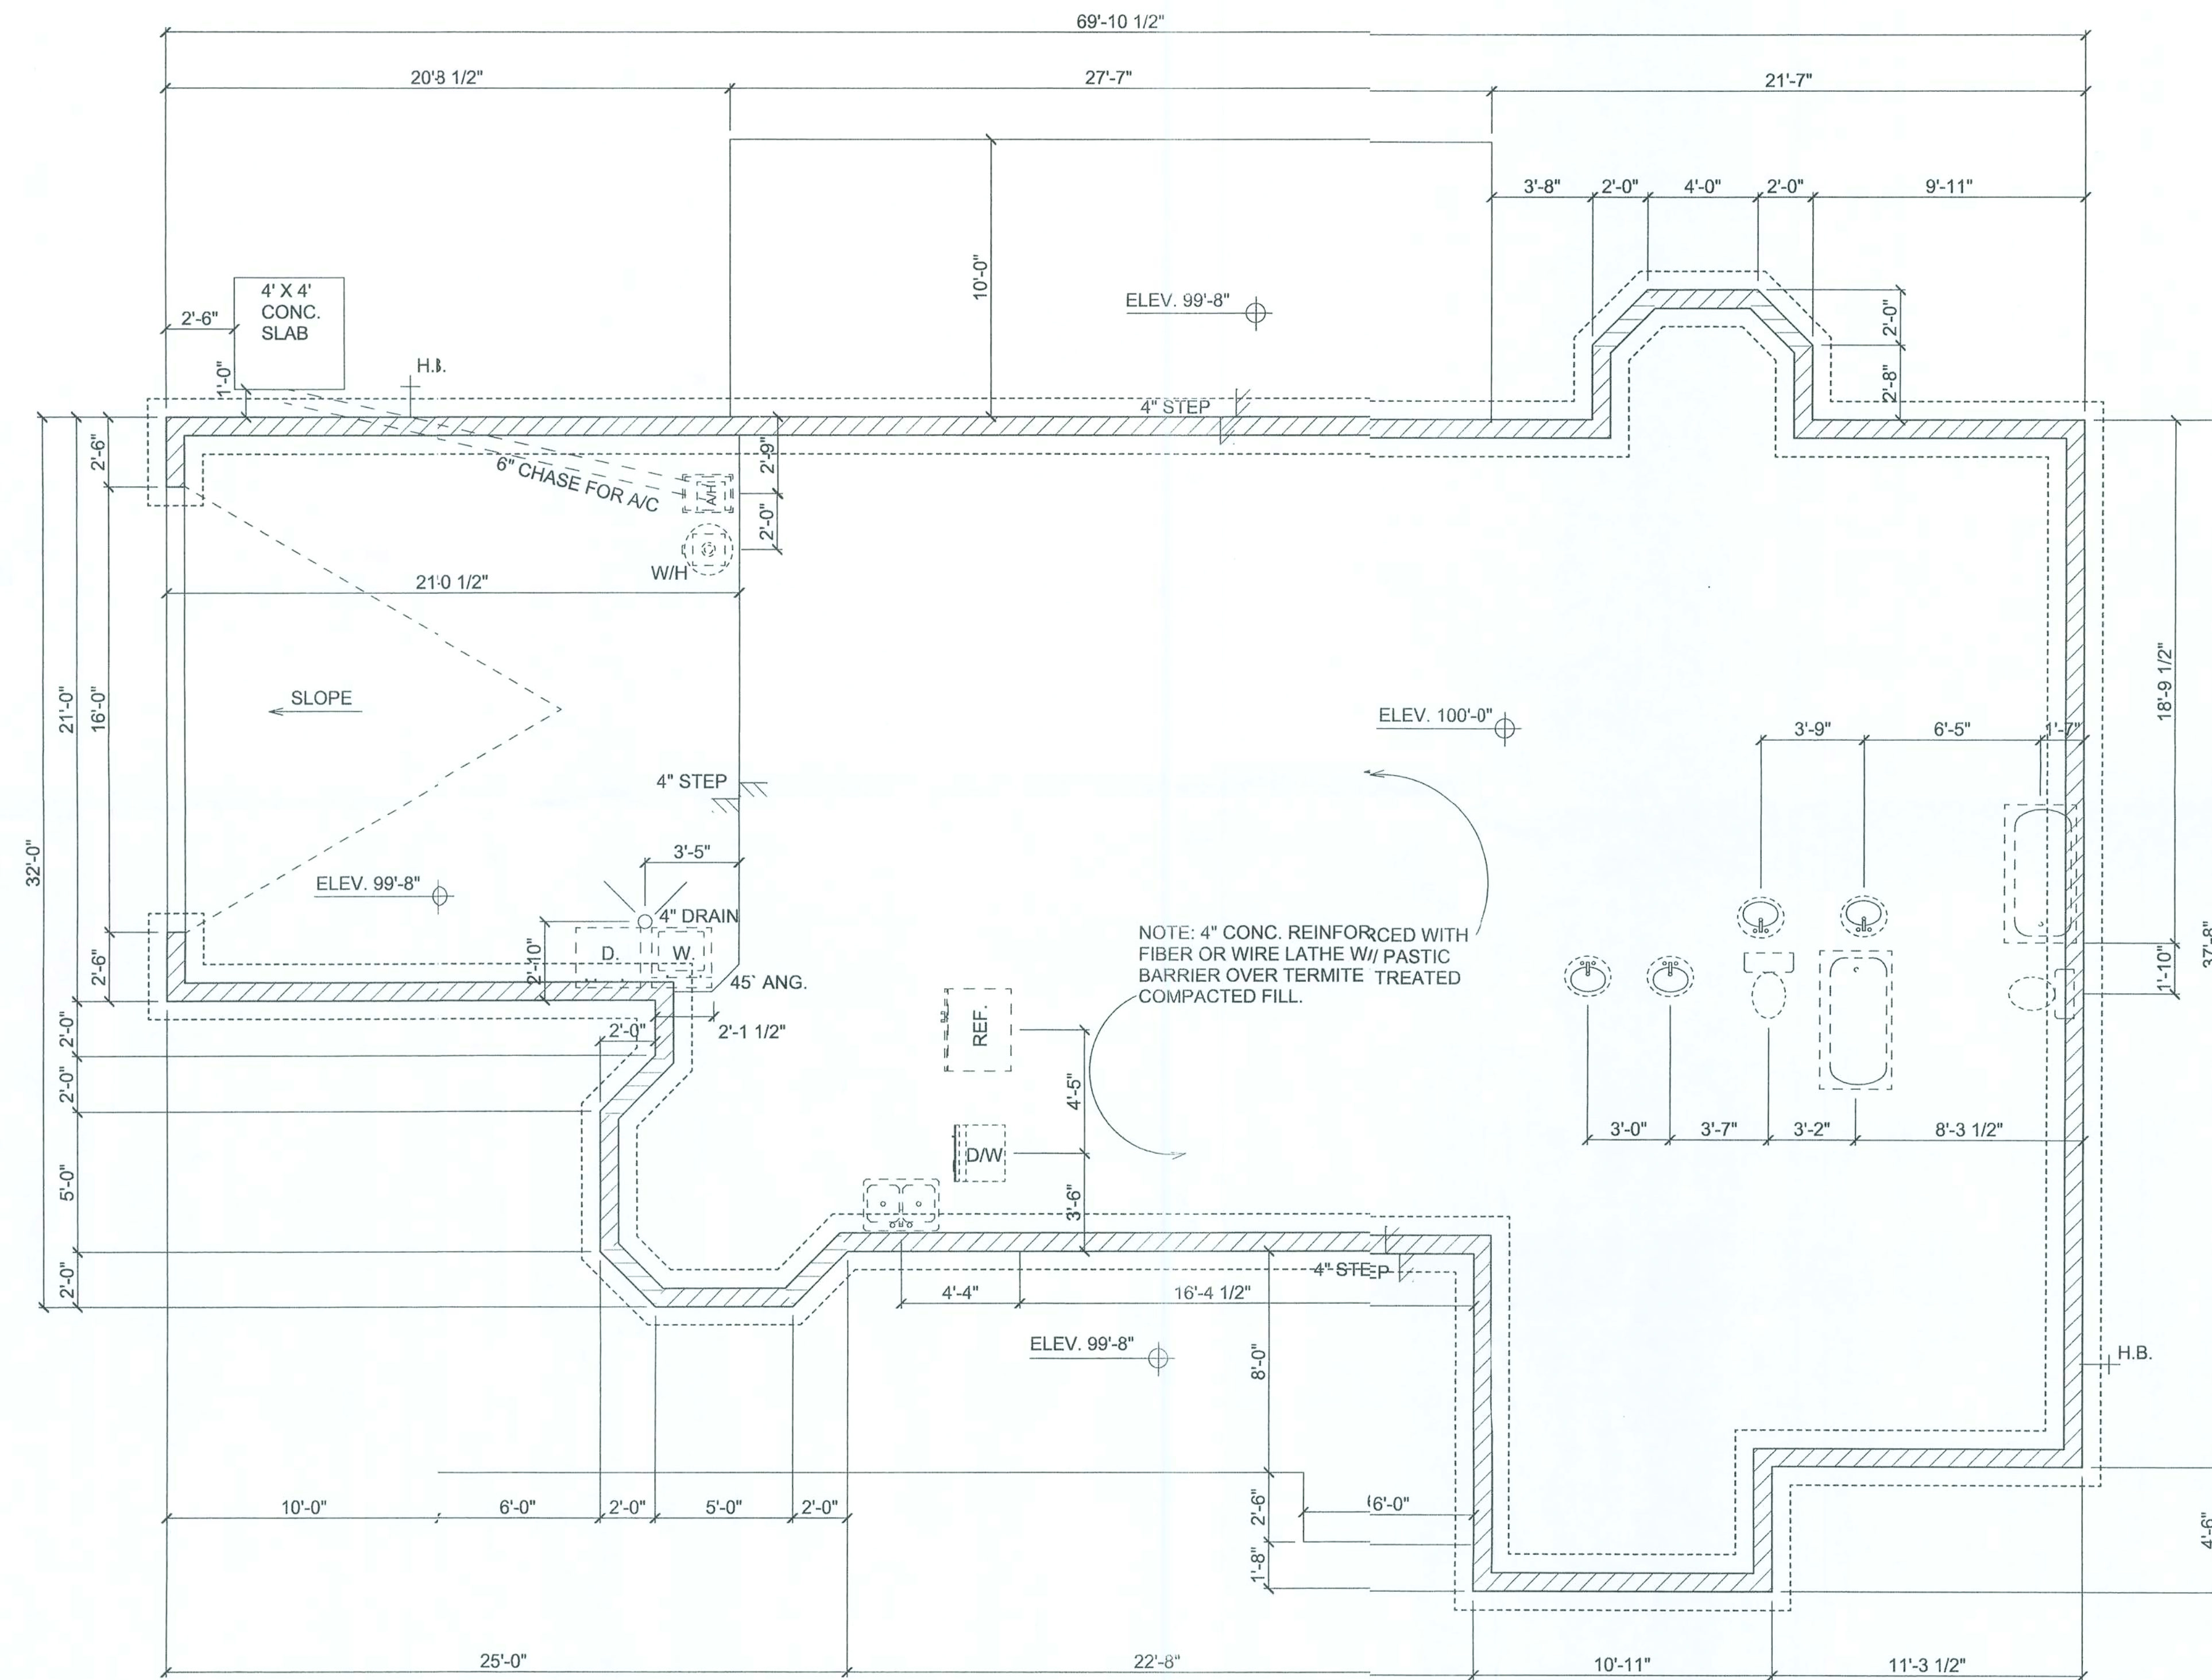

FOUNDATION PLAN


SCALE: 1/4" = 1'-0"


PRECISION DESIGN SOLUTIONS

DRAFTING, DESIGN &
CONSULTING

DRAWN BY:
ROBERT
CULOTTI

PH#
(386) 623-6198

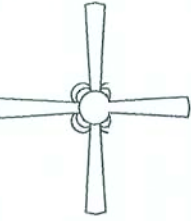ELECTRICAL	SYMBOL
ceiling fan spotlights 1	
ceiling lamp large	
chandelier	
double spotlight	
electrical panel	
light	
outlet	
outlet 220v	
outlet gfi	
smoke detector	
switch	
50 cfm fanlight	

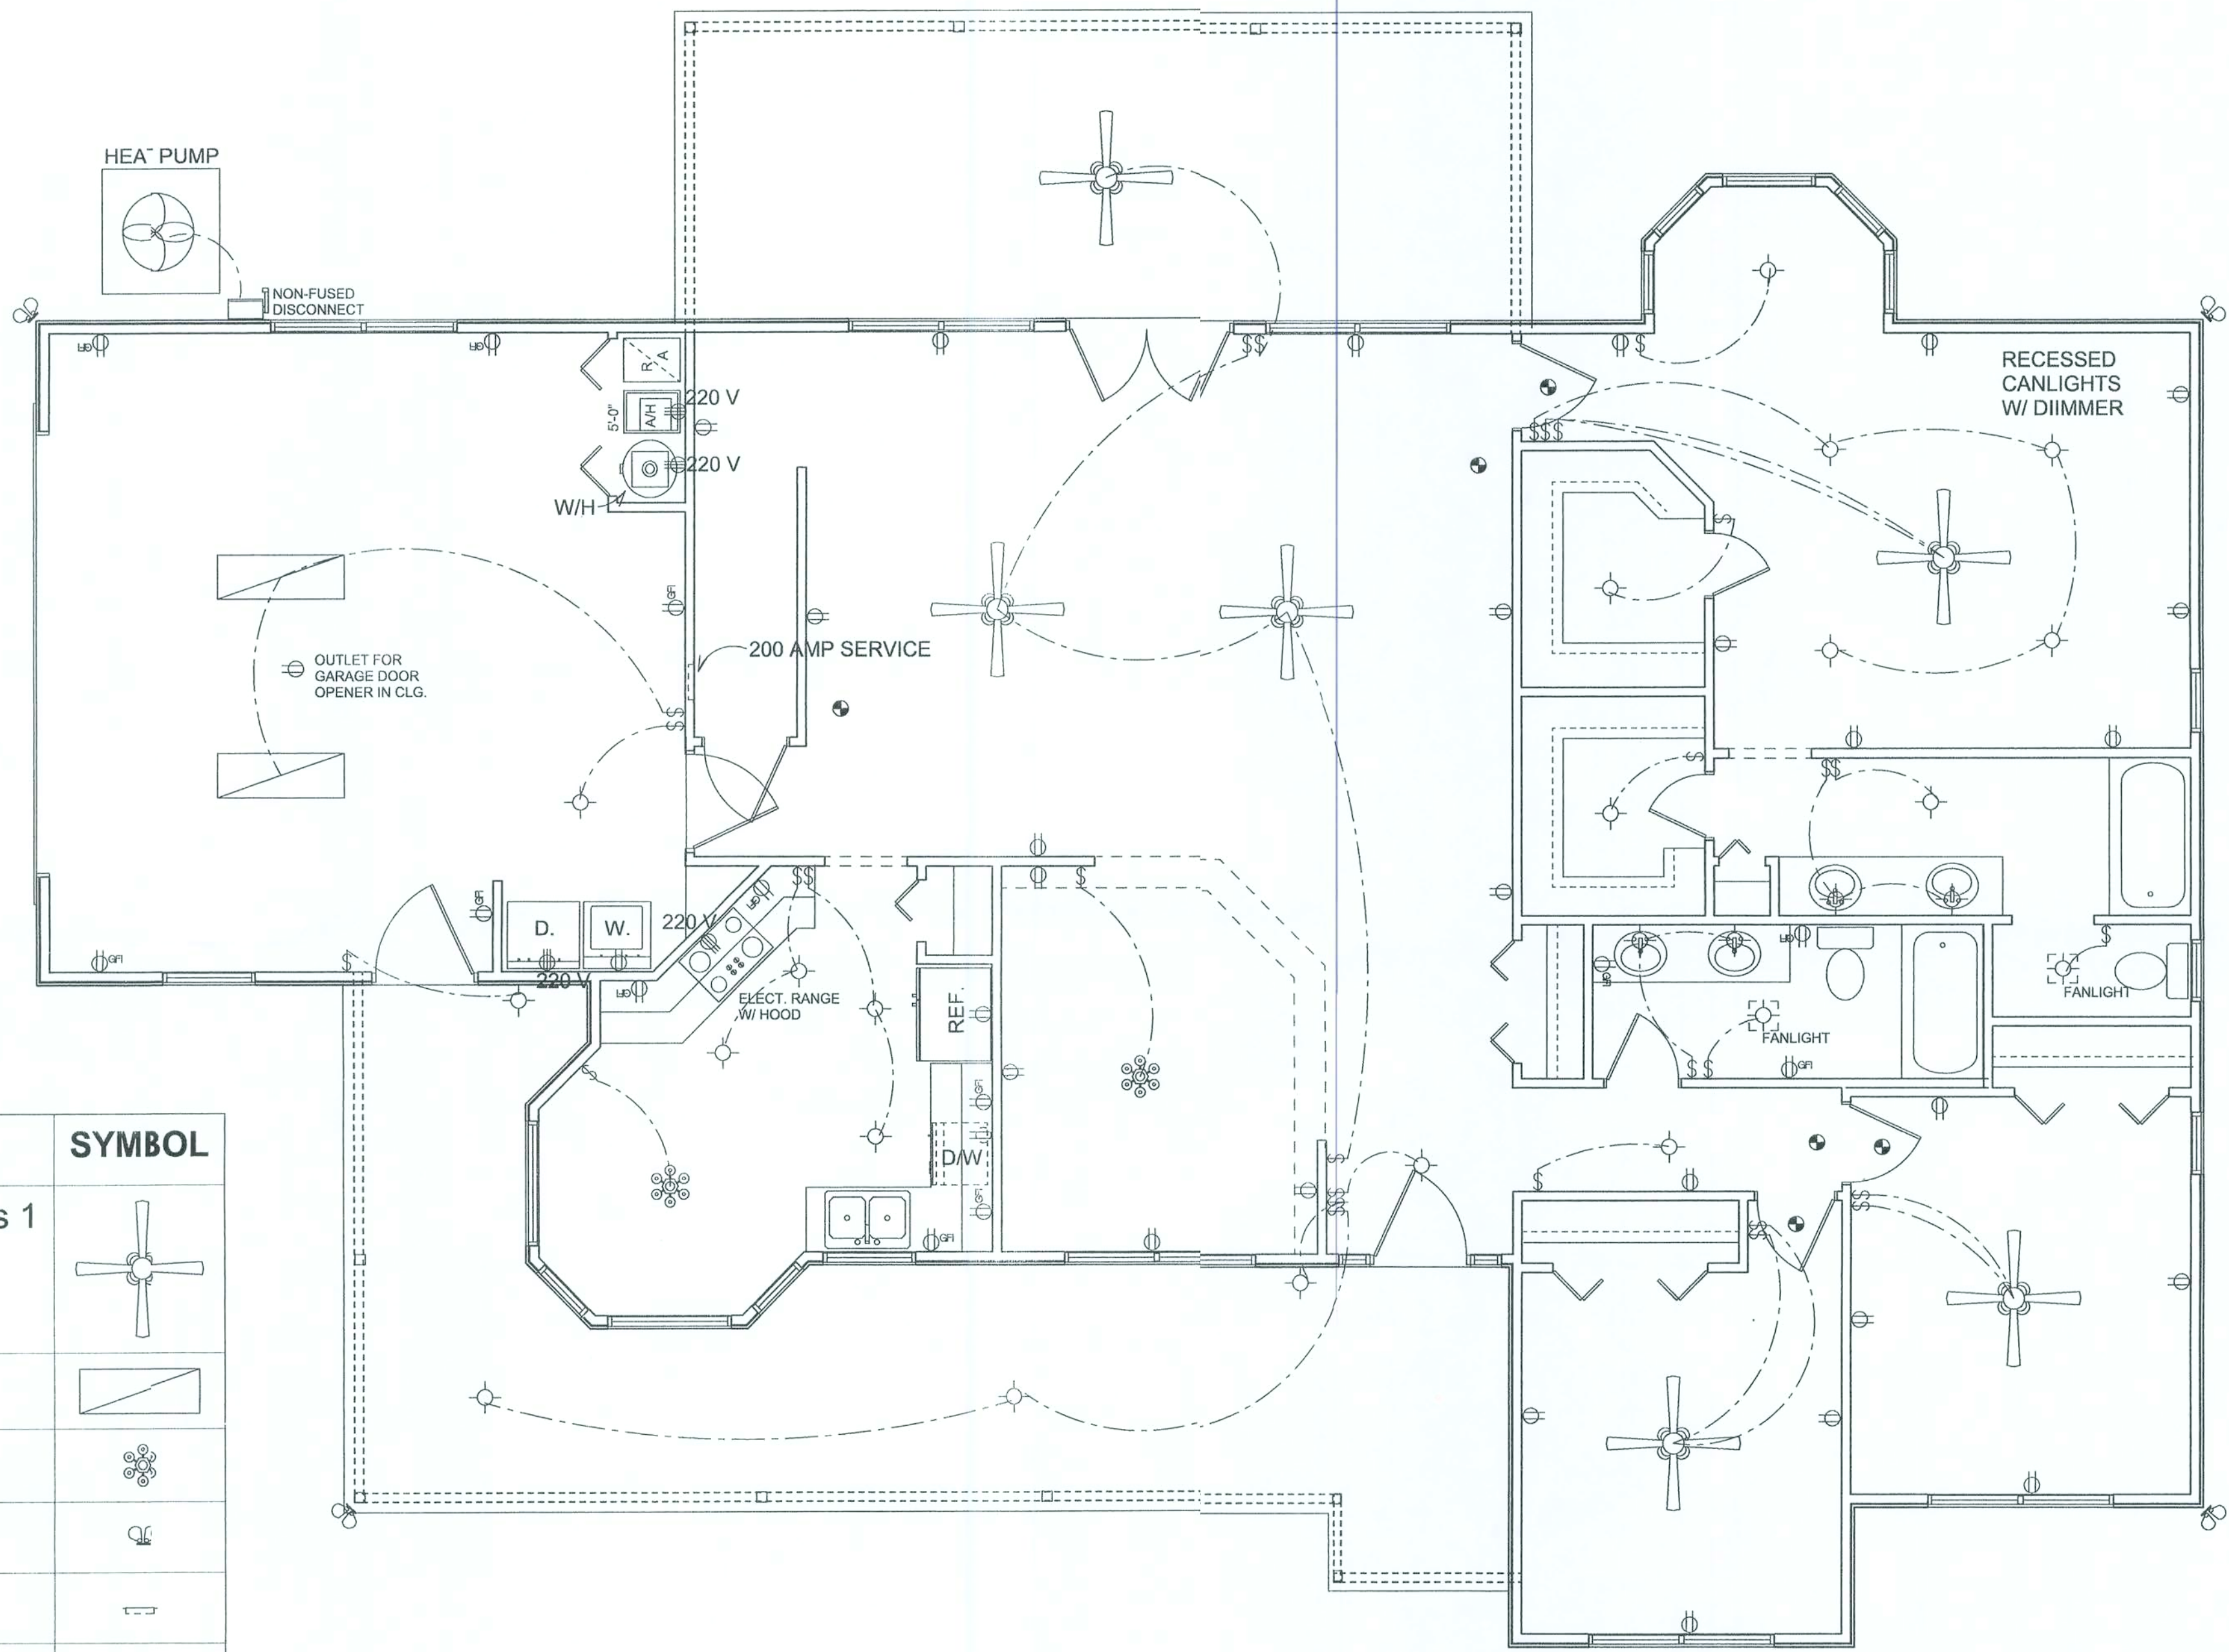

ELECTRICAL PLAN
SCALE: 1/4" = 1'-0"

PRECISION DESIGN
SOLUTIONS
DRAFTING, DESIGN &
CONSULTING
DRAWN BY:
ROBERT
CULOTTI
PH#
(386) 623-6198