




Not added

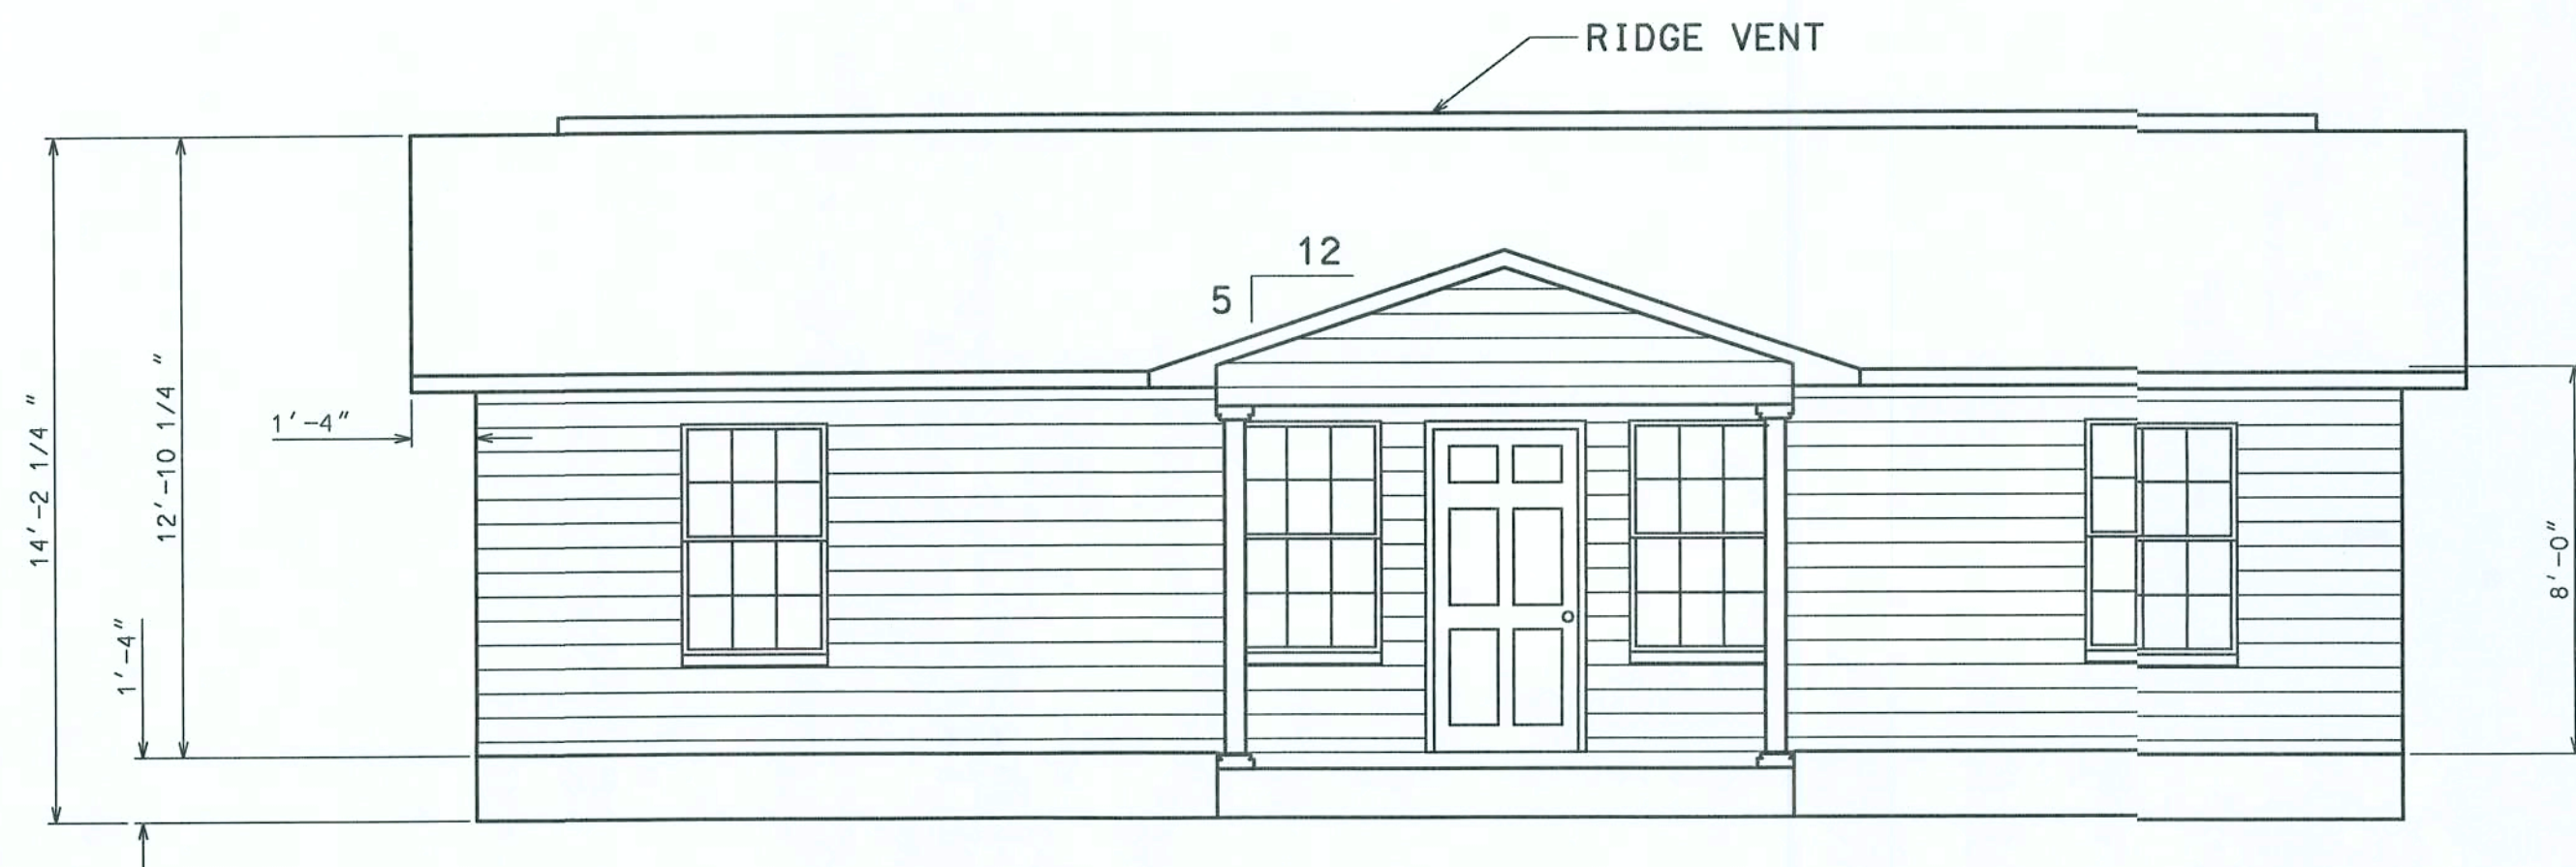


FRONT ELEVATION

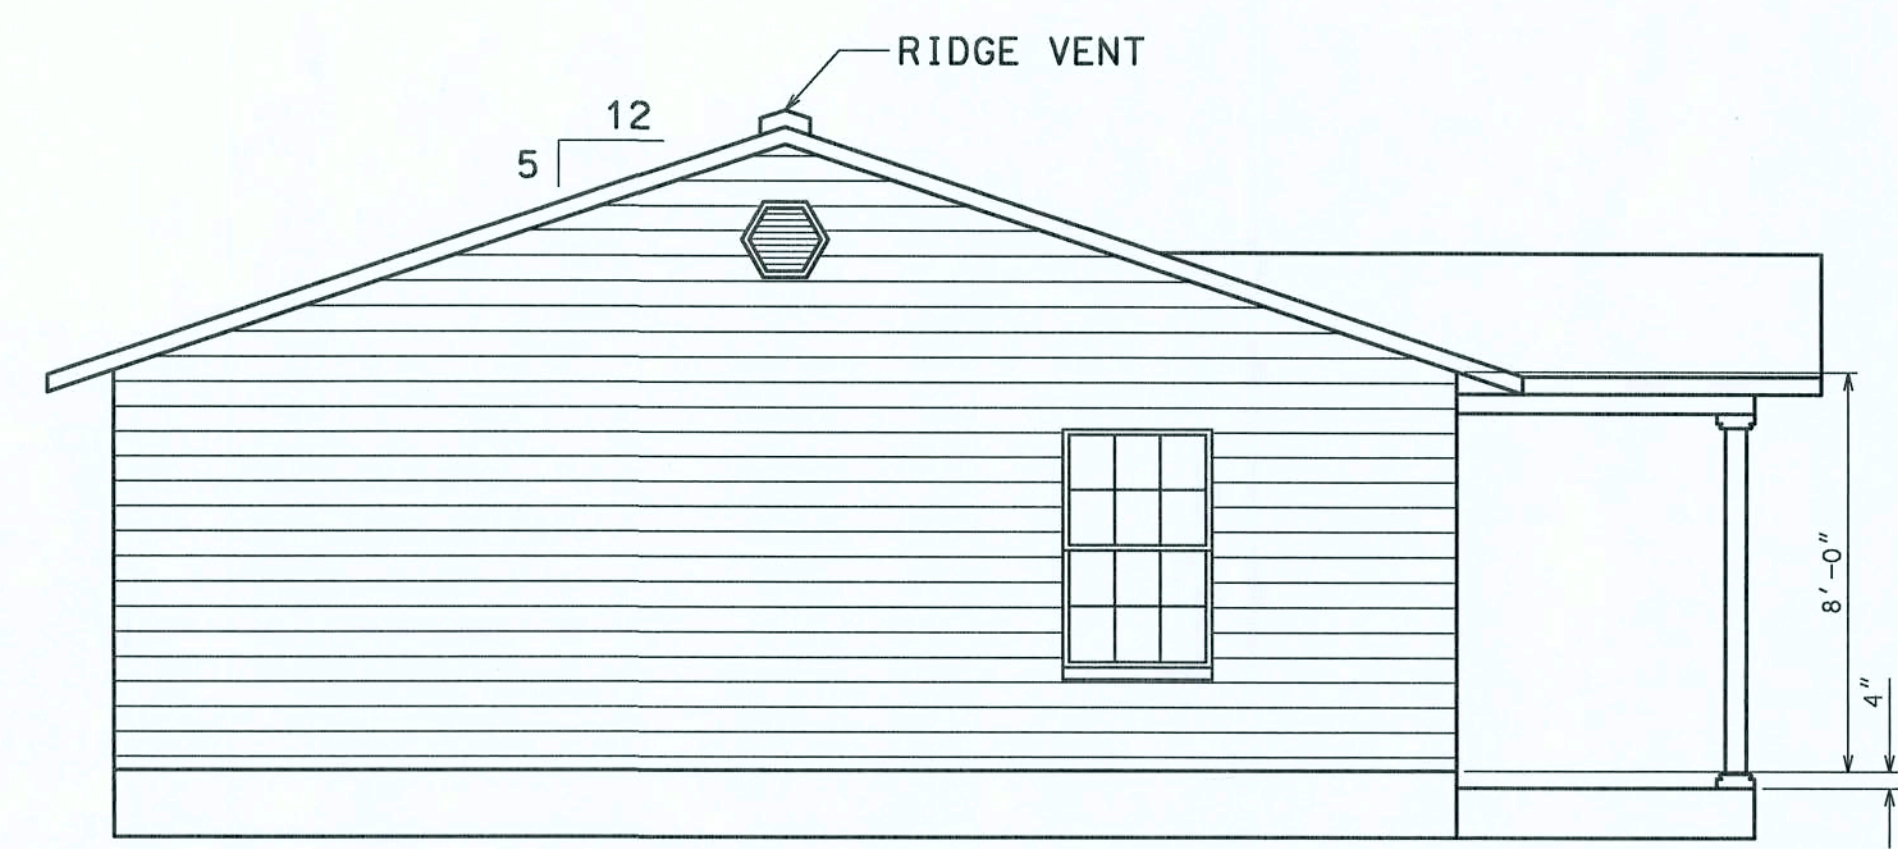

LEFT ELEVATION

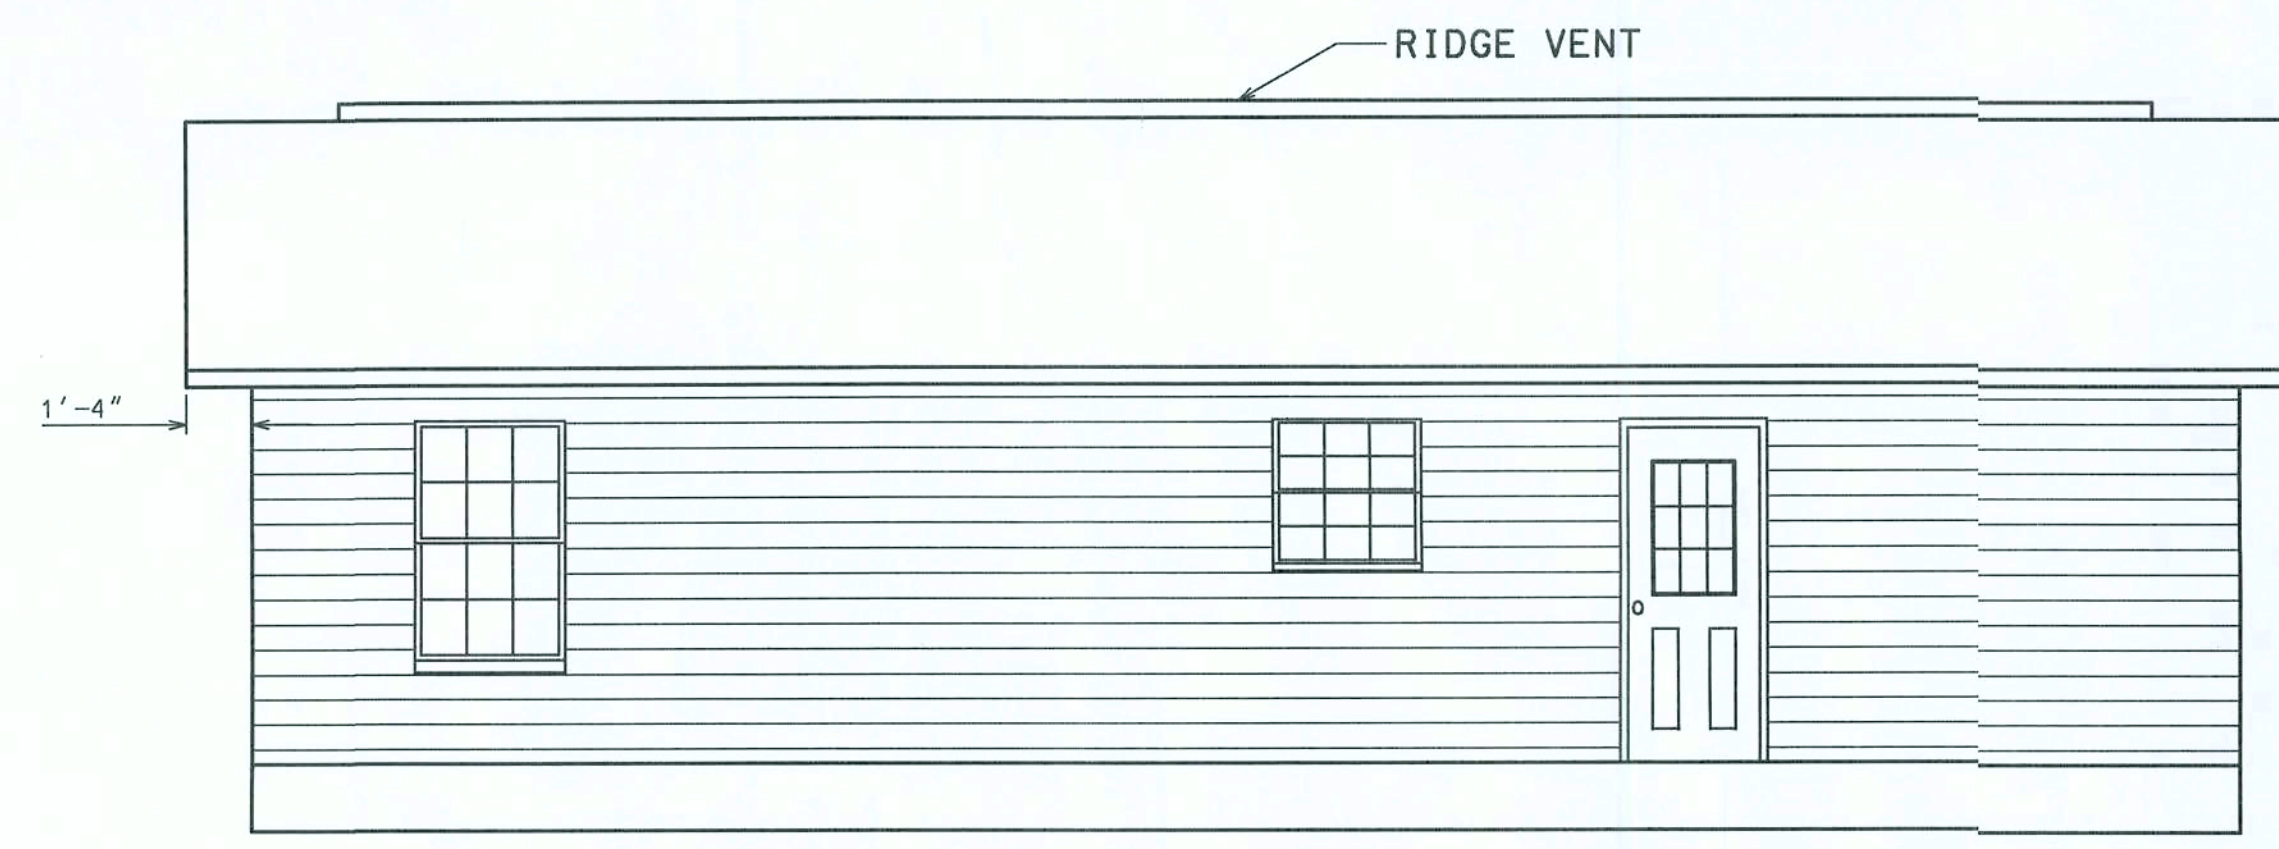

REAR ELEVATION

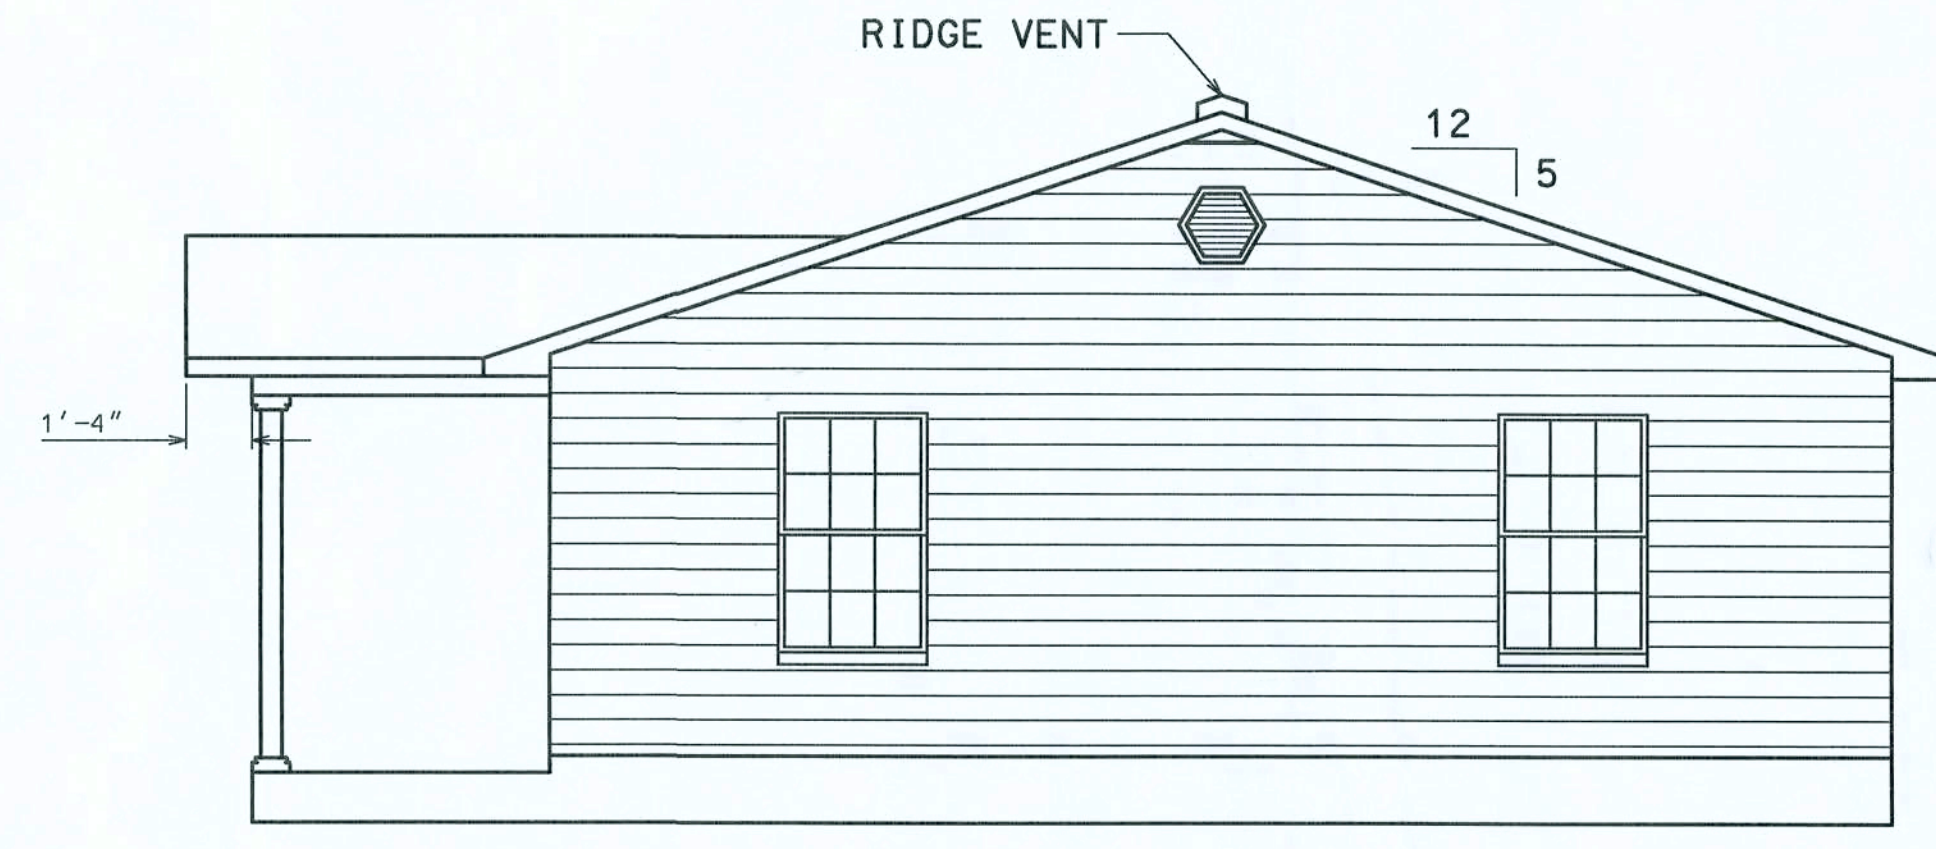

RIGHT ELEVATION



HAYGOOD HOMES INC.


12592 So. U.S. HWY 441
LAKE CITY FL. 32025
OFFICE (386) 752-3496
MOBILE (386) 303-1981
CR-C1326715

SHAWN FULWOOD
LAKE CITY FLORIDA

ELEVATIONS


PLAN No.	SCALE	DATE	SHEET NO.
P0505	1/4" = 1'	0/02/06	1

... Projects\fulwood\lake city 4/23/2006 7:00:39 PM

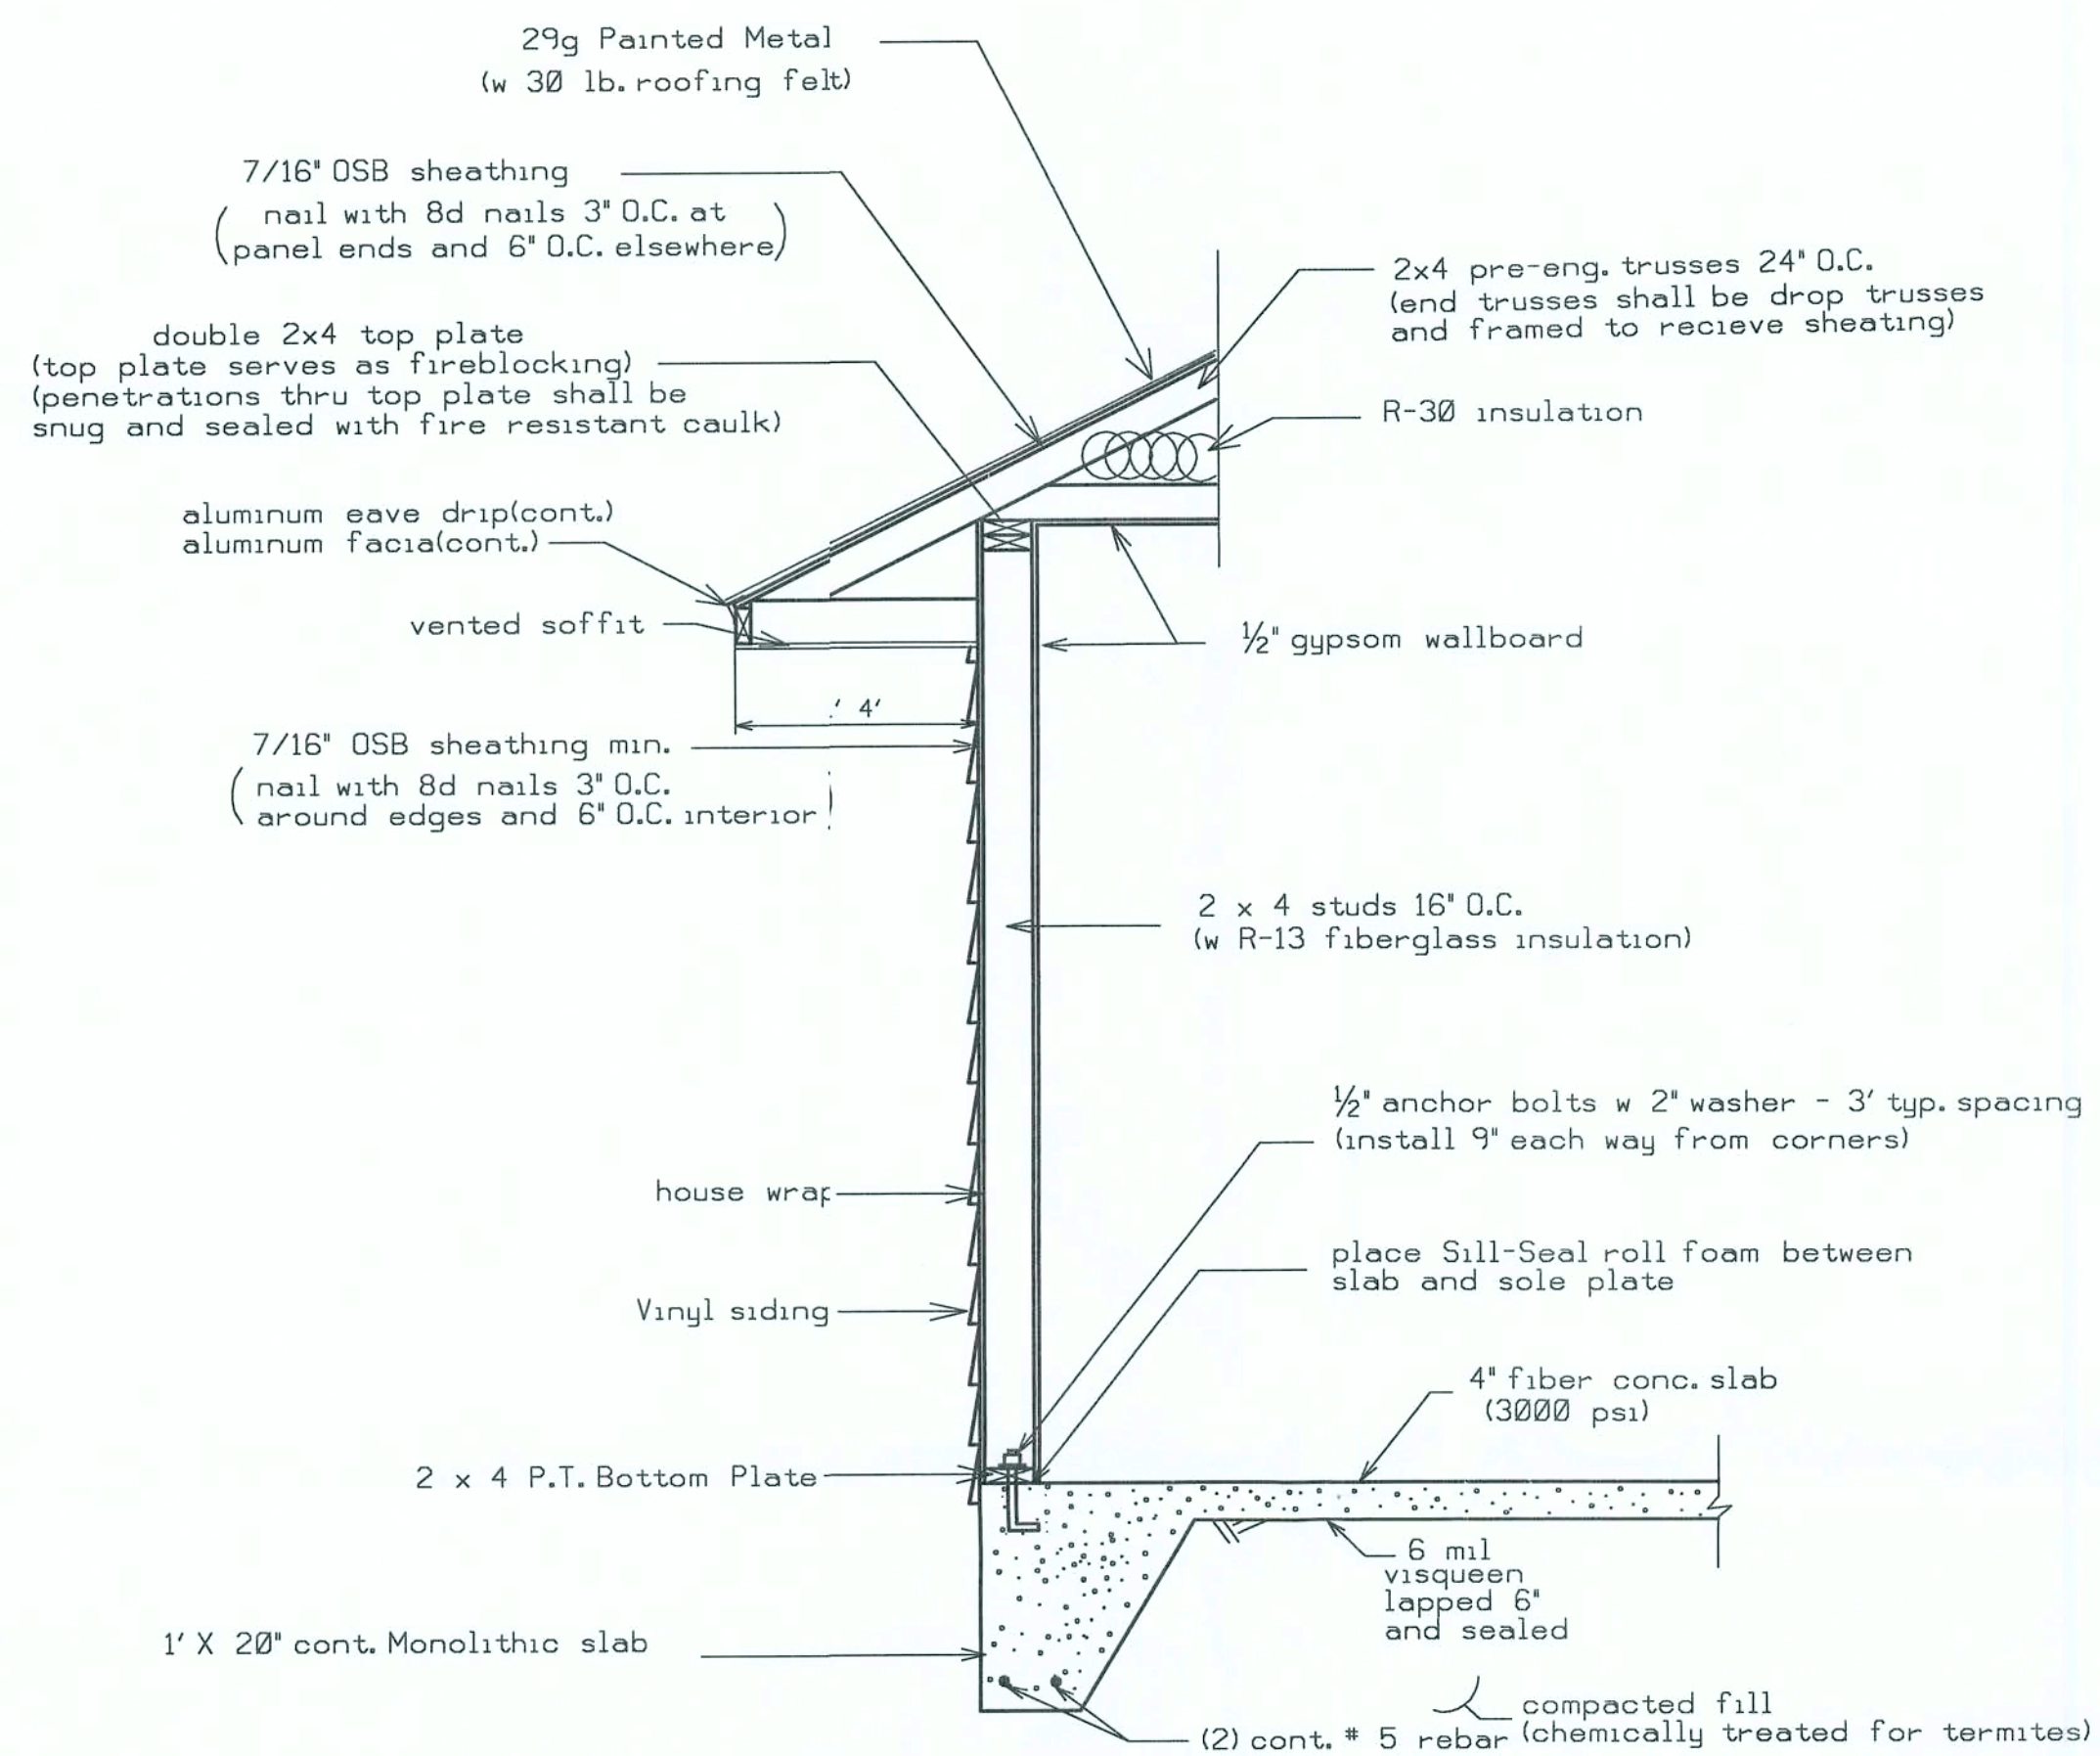

FOOTER DESIGN 1000 PSF WALL DETAIL(TYP.) (N.T.S.)

HEADER SIZES/MATERIAL SHALL BE AS FOLLOWS:
WINDOW AND DOOR OPENINGS - #2 SYP 2X12's with 1/2\"/>

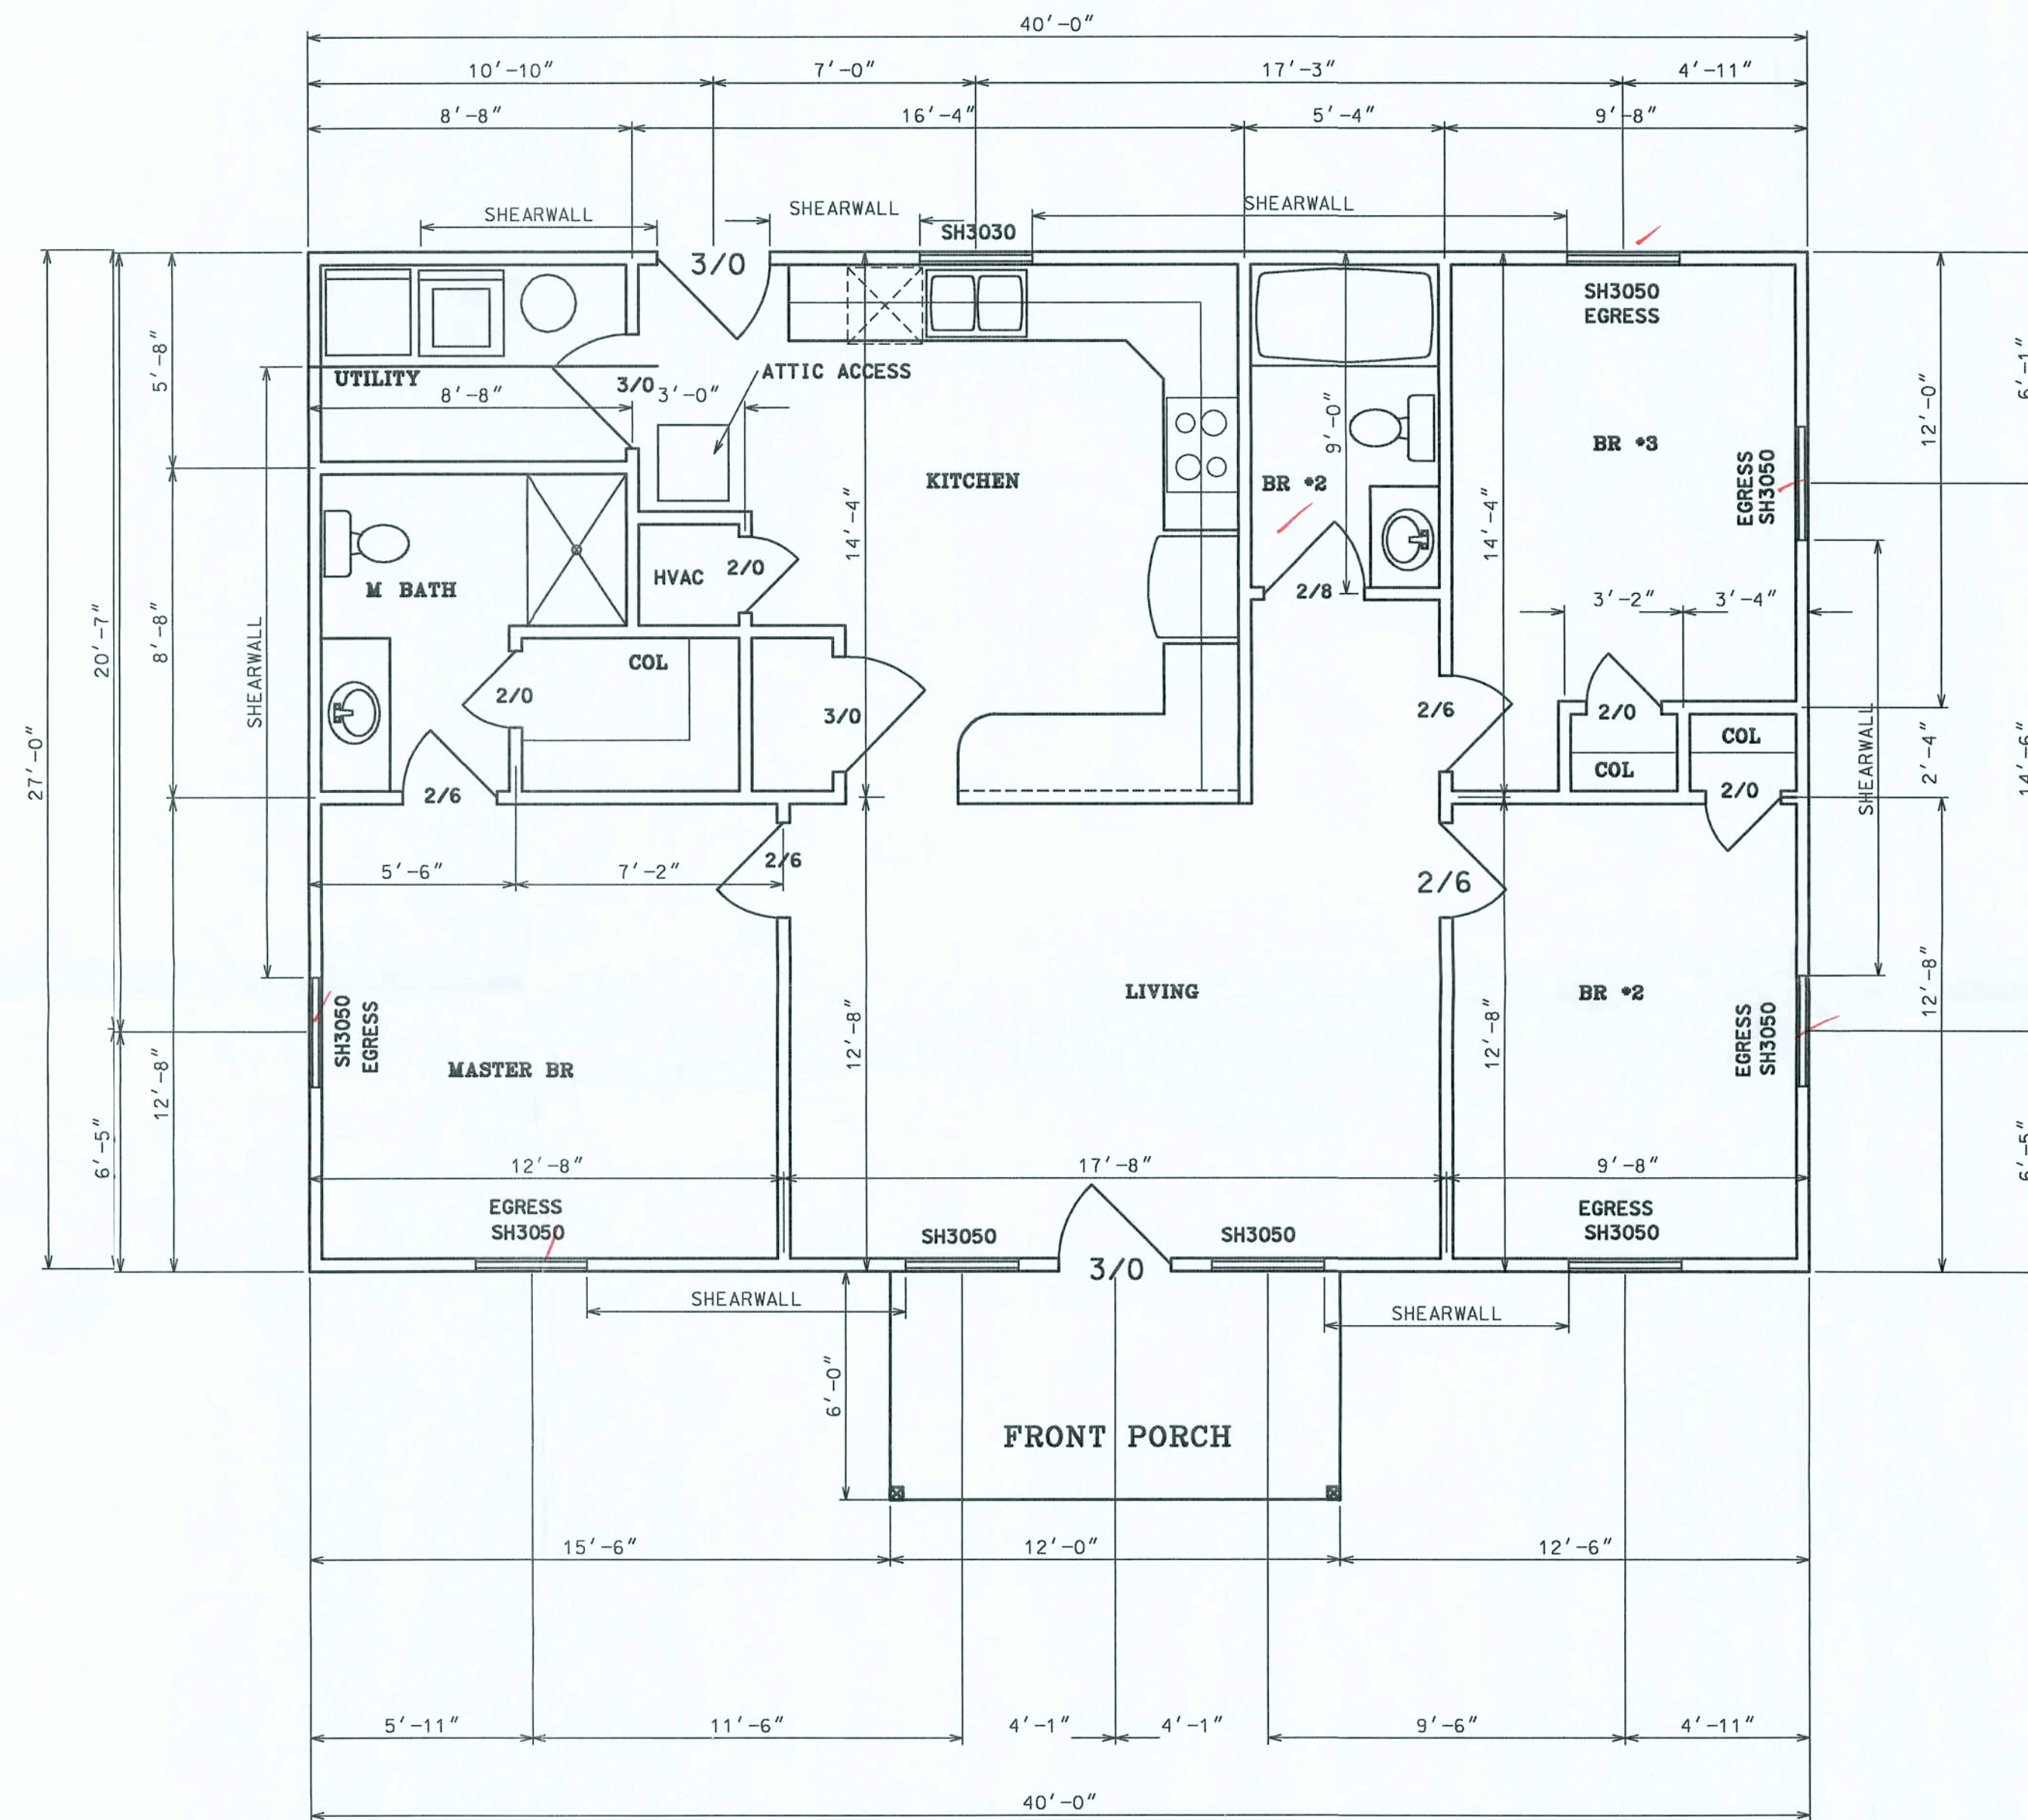

SQUARE FOOTAGE		
HEATED AREA	1080	SF
PORCHES	72	SF
TOTAL 1152 SF		





HAYGOOD HOMES INC.

12592 So. U.S. HWY 441
LAKE CITY FL 32025
OFFICE (386) 752-3496
MOBILE (386) 303-1981
CR-C1326715

SHAWN FULWOOD
LAKE CITY FLORIDA

FLOOR PLAN

PLAN No.	SCALE	DATE	SHEET NO.
P0505	1/4" = 1'	1/02/06	2

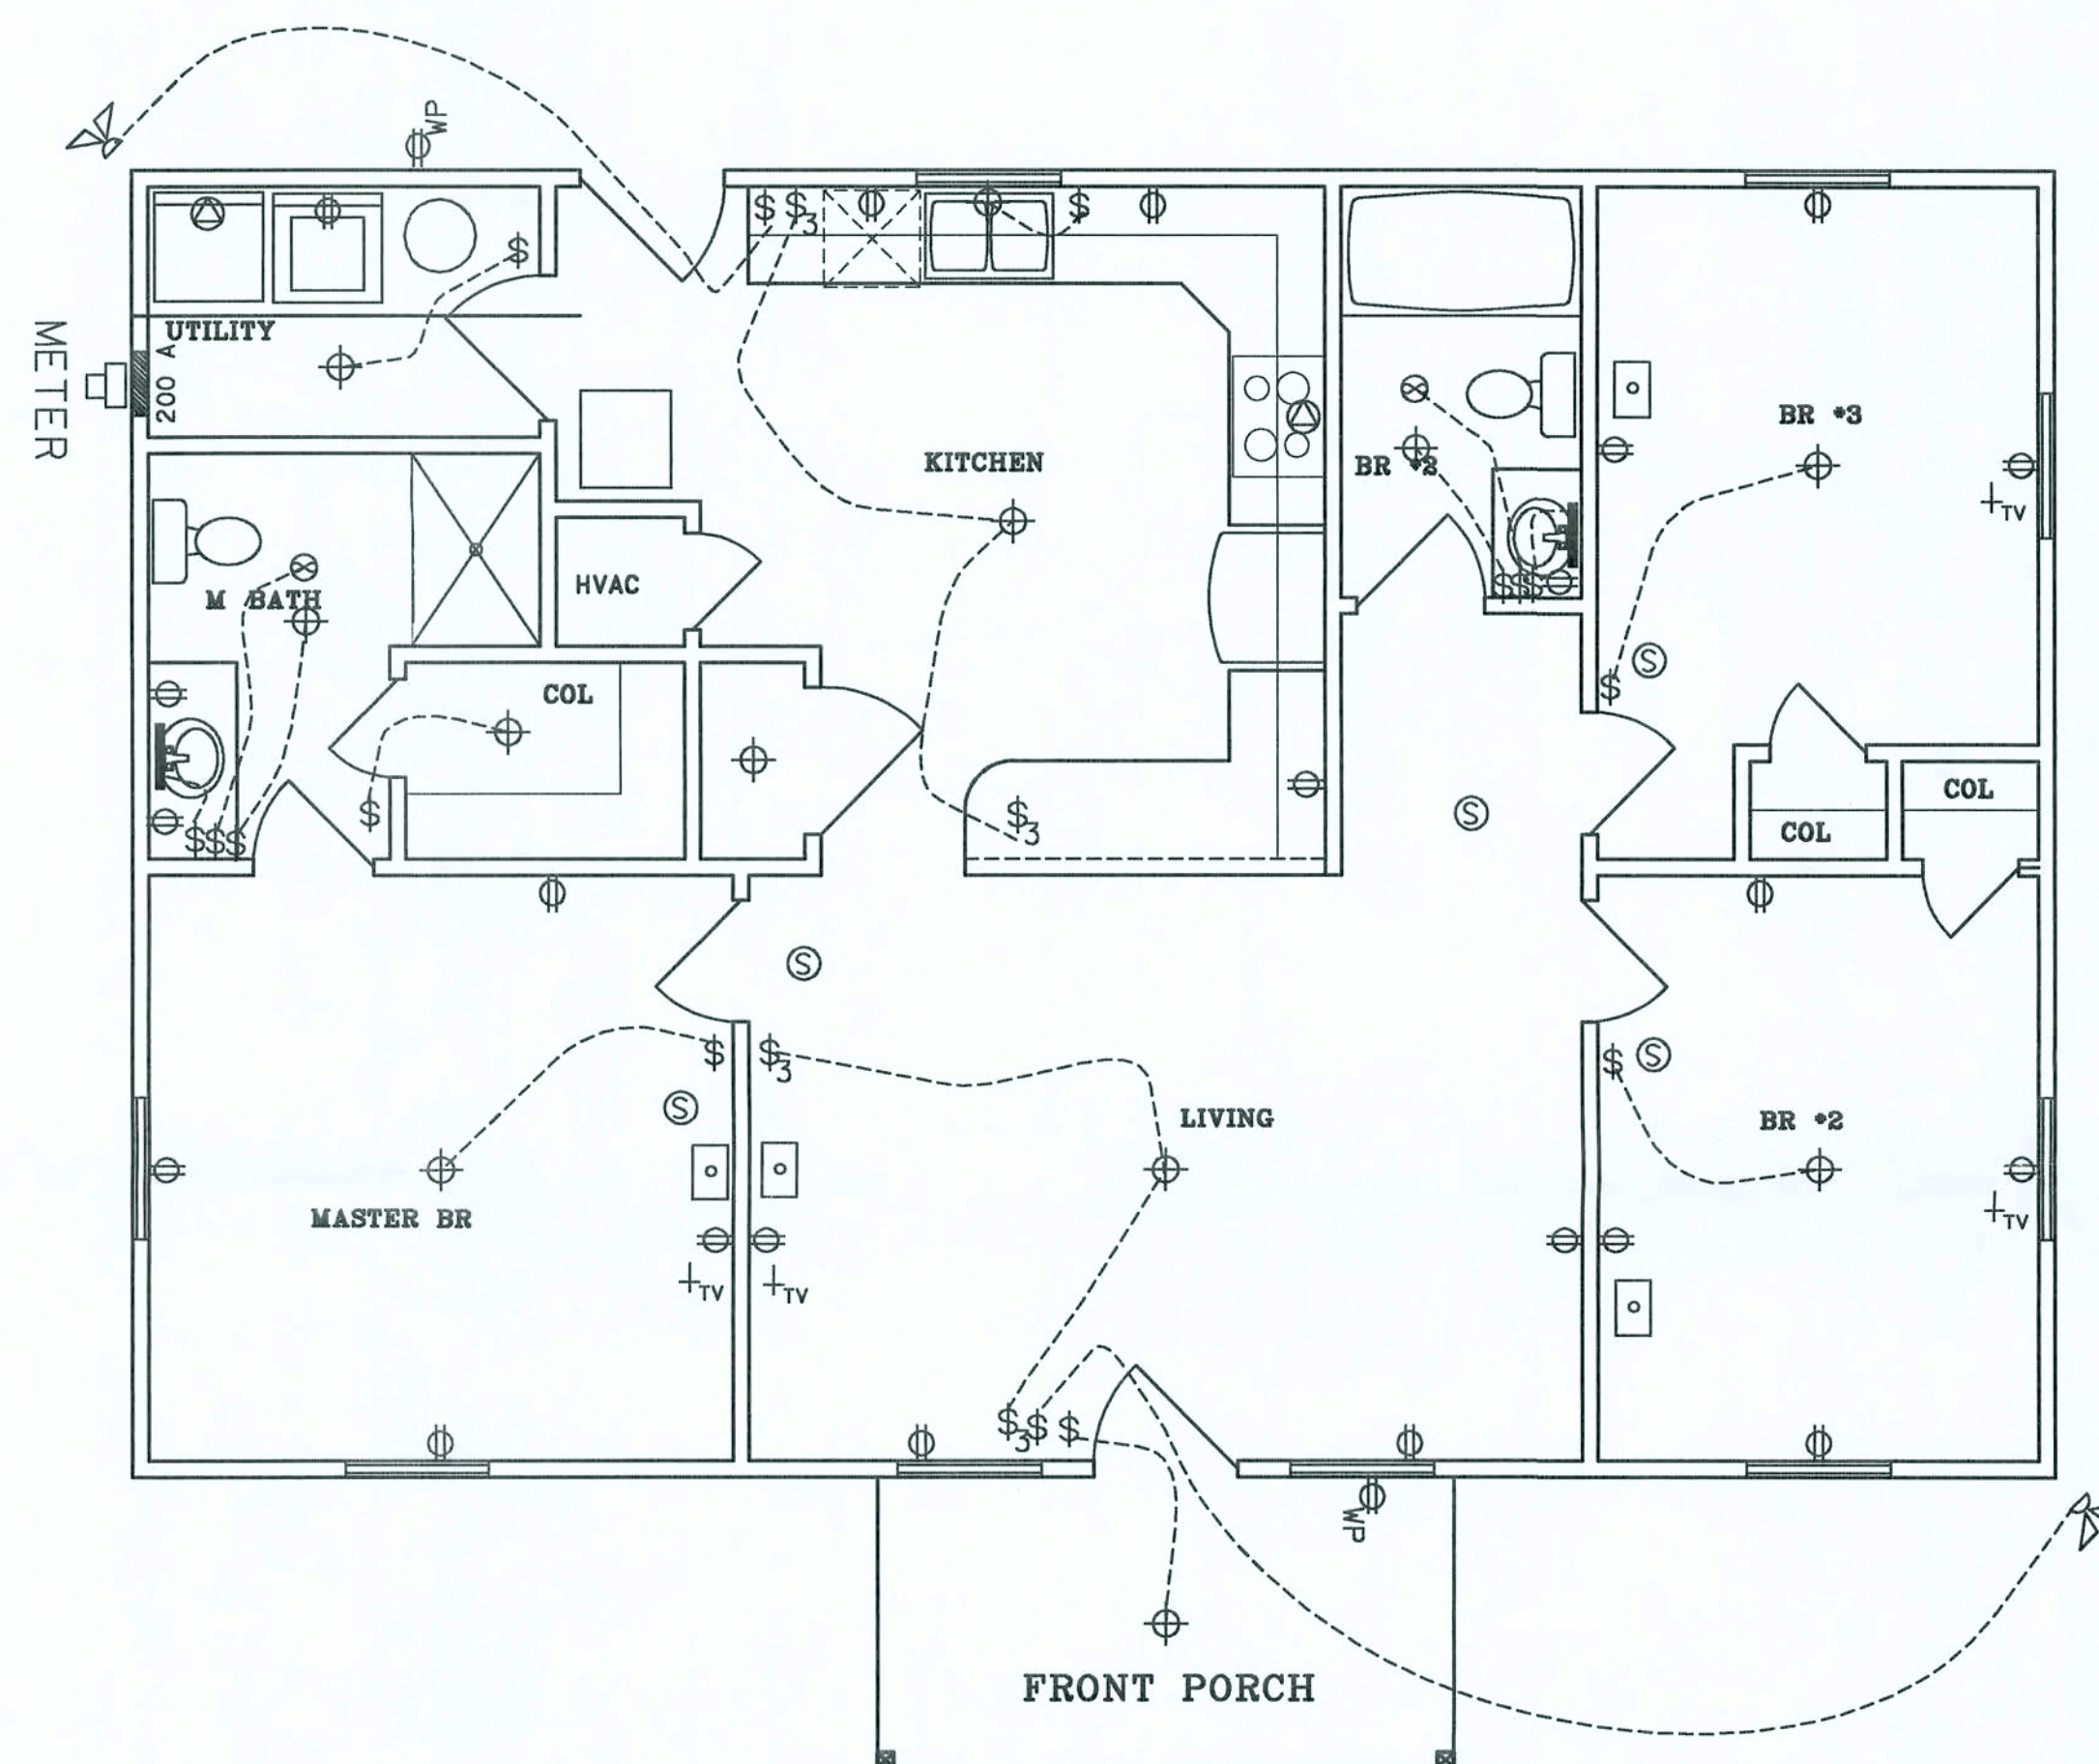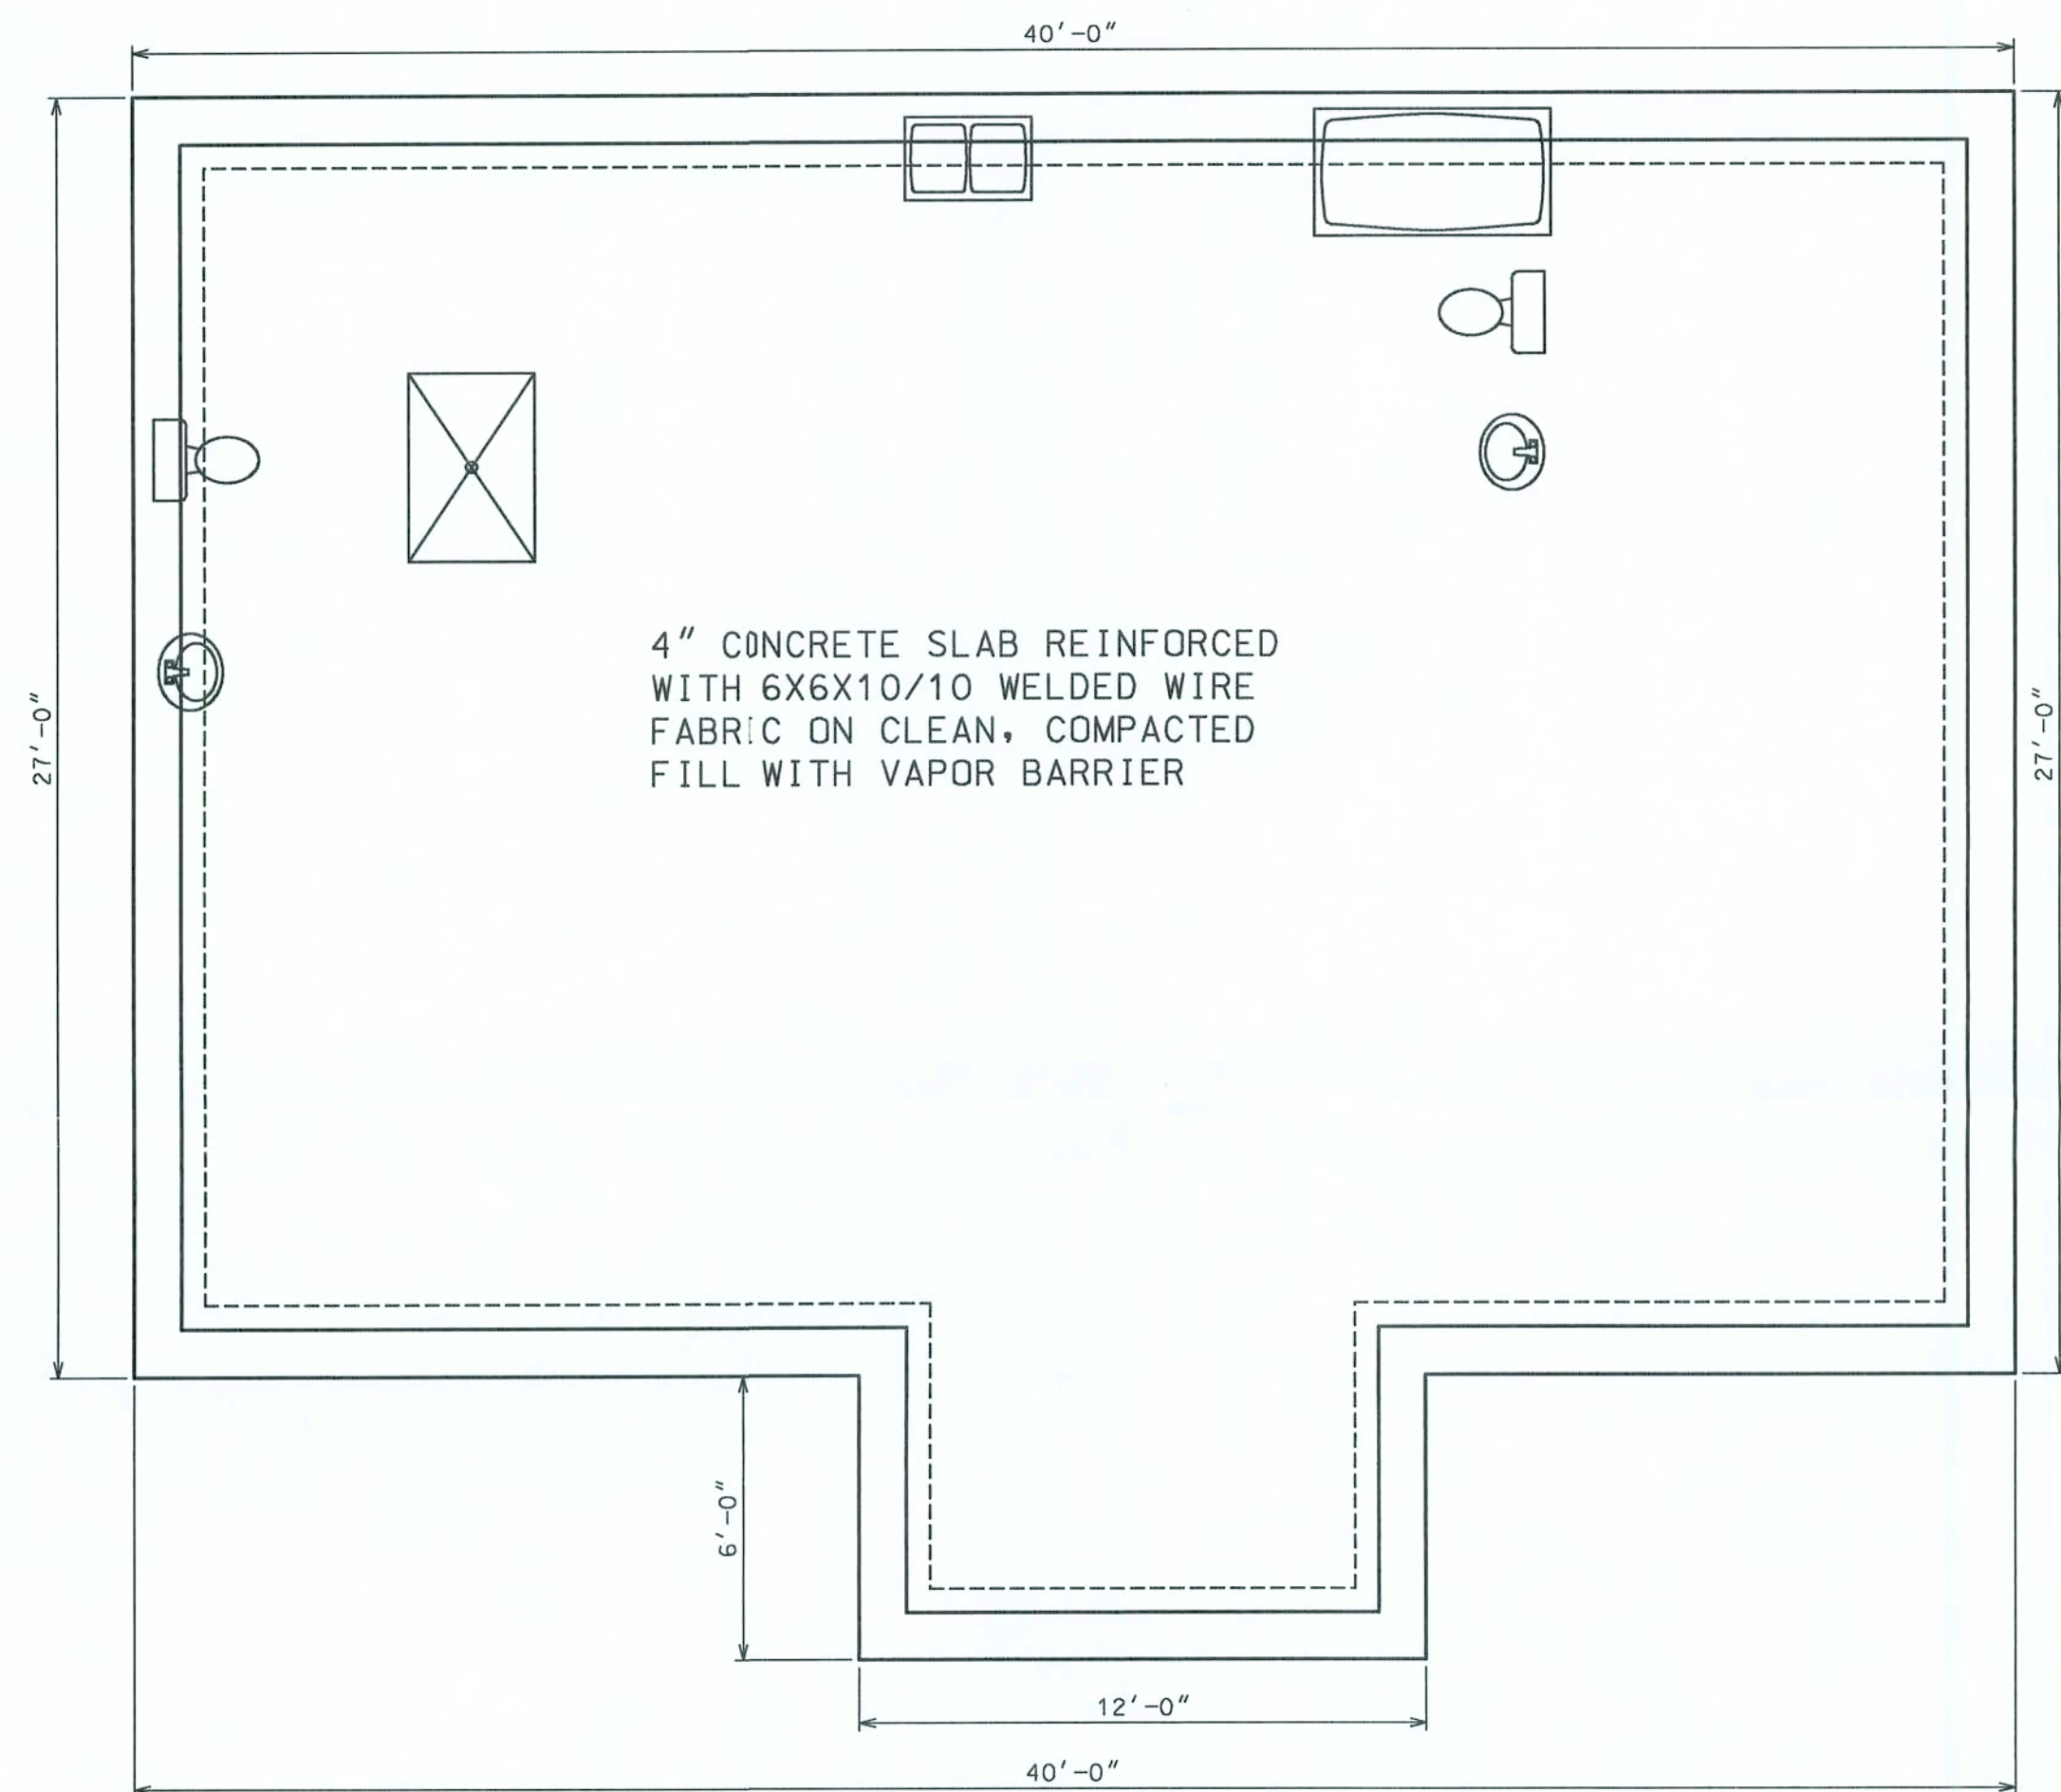

- METER BASE
- VANITY LIGHT AS SPECIFIED
- LIGHT FIXTURE
- SINGLE POLE ROCKER SWITCH
- THREE-WAY SWITCH
- RECEPT.
- SECURITY LIGHT
- EXHAUST
- 220 V.
- SMOKE DETECTOR (AC/DC and interconnected)
- COAX / TV
- TELEPHONE
- 200A SERVICE PANEL

NOTES:

- 1.) PULL HOMERUNS OF TELEPHONE CABLE AND COAX CABLE TO COMMUNICATION PANEL (NO JUNCTIONS ALLOWED IN ATTIC)
- 2.) ALL EXTERIOR RECEPTACLES SHALL EITHER BE GFI RECPTS OR PART OF A GFI CIRCUIT. ALL EXTERIOR RECEPTACLES SHALL BE WEATHERPROOF.
- 3.) ALL BATHROOM, KITCHEN, AND GARAGE RECEPTS SHALL BE PART OF A GFI CIRCUIT.
- 4.) ALL BEDROOM RECEPTS SHALL BE PART OF AN AFI CIRCUIT.

NOTE:

THE ELECTRICAL PLAN IS INTENDED TO SHOW SCHEMATICALLY THE LAYOUT OF THE ELECTRICAL COMPONENTS. FINAL LOCATIONS AND SIZING OF THE COMPONENTS SHALL BE THE RESPONSIBILITY OF A LICENSED ELECTRICAL CONTRACTOR. ALL WORK SHALL BE PERFORMED IN ACCORDANCE WITH ALL APPLICABLE CODES.



HAYGOOD HOMES INC.

12592 So. U.S. HWY 441
LAKE CITY FL 32025
OFFICE (386) 752-3496
MOBILE (386) 303-1981
CR-C1326715

SHAWN FULWOOD
LAKE CITY FLORIDA

ELECTRICAL / FOUNDATION

PLAN No.	SCALE	DATE	SHEET NO.
P0505	1/4" = 1'	1/02/06	3

...\\Projects\\Vulcan\\Vulcan.dgn 4/20/2006 7:02:17 PM