


THIS DETAIL USED FOR 4" SANITARY LINE RUN BELOW FIXTURE RACKING. SEE PLANS.


1 2-WAY YARD CLEAN OUT DETAIL
P2.C N.T.S.

PROVIDE CLEANOUT WITH ADJUSTABLE CLEANOUT TOP WITH VARIATIONS SUITABLE FOR FLOOR COVERING (CARPET MARKER, RECESSED FOR TILE, SCORIFIED FOR UNFINISHED FLOORS). CLEAN THE TOP OF EXPOSED FCO AFTER INSTALLATION.

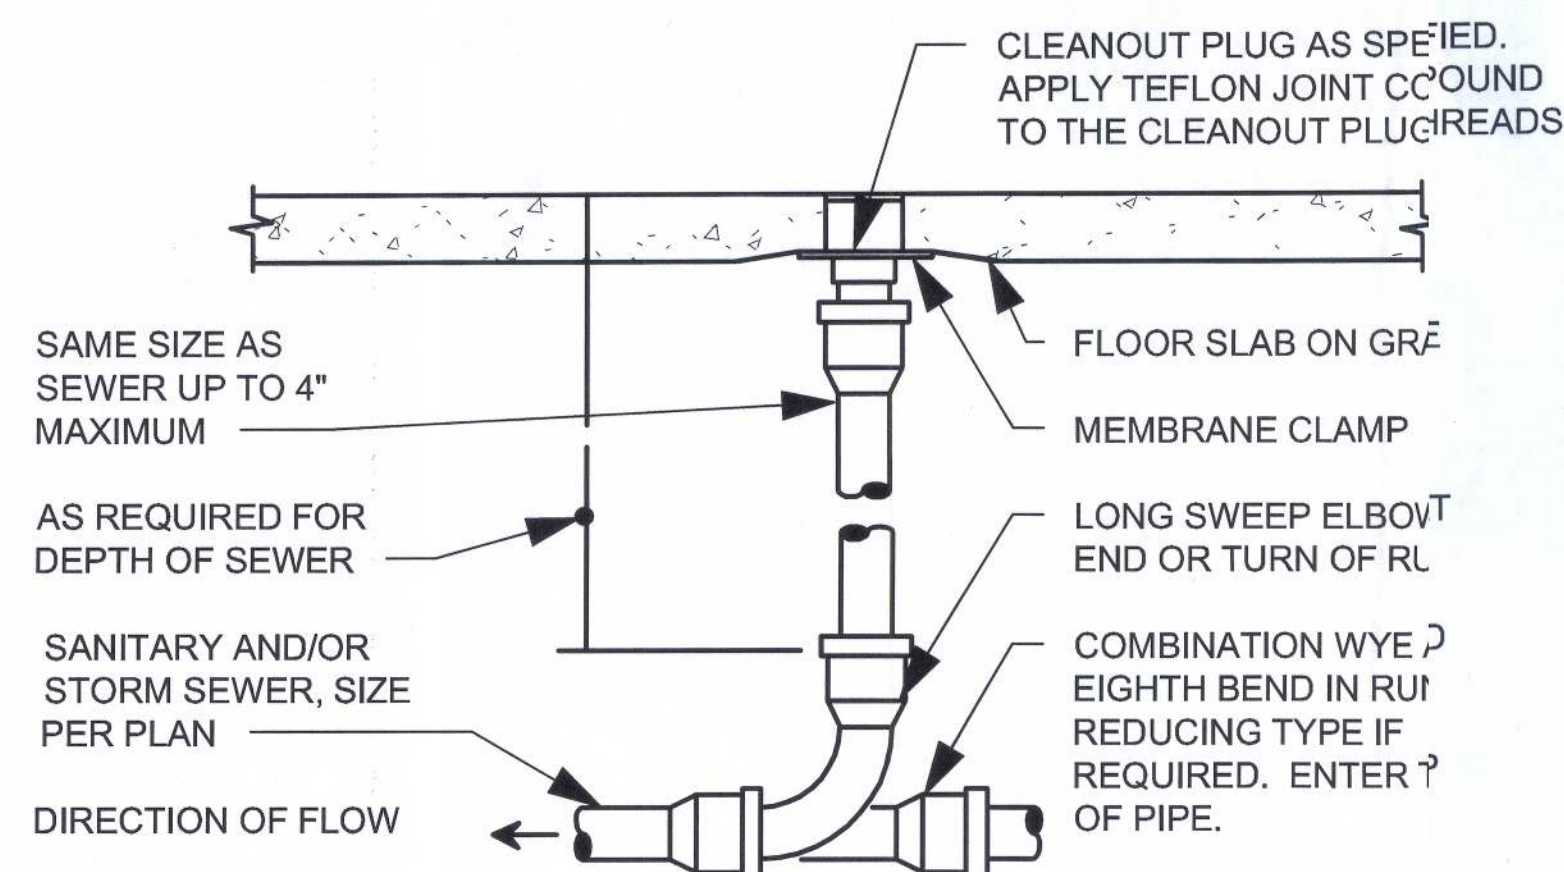


REFER TO SPECIFICATIONS AND SCHEDULE FOR MORE INFORMATION. LOCATE AT BUILDING EXIT, AT ENDS OF RUNS, AT TURNS OF PIPE GREATER THAN 45°, AT 50' INTERVALS ON STRAIGHT RUNS, AND/OR WHERE SHOWN ON PLANS AND RISERS. PROVIDE BACKFILL PER ARCHITECTURAL SPECIFICATIONS. LOCATE CLEANOUT WHERE THERE IS 18" CLEAR AROUND, FOR ACCESSIBILITY. CONSULT LOCAL CODES AND OFFICIALS FOR OTHER REQUIREMENTS.


3 FLOOR CLEAN OUT DETAIL
P2.C N.T.S.

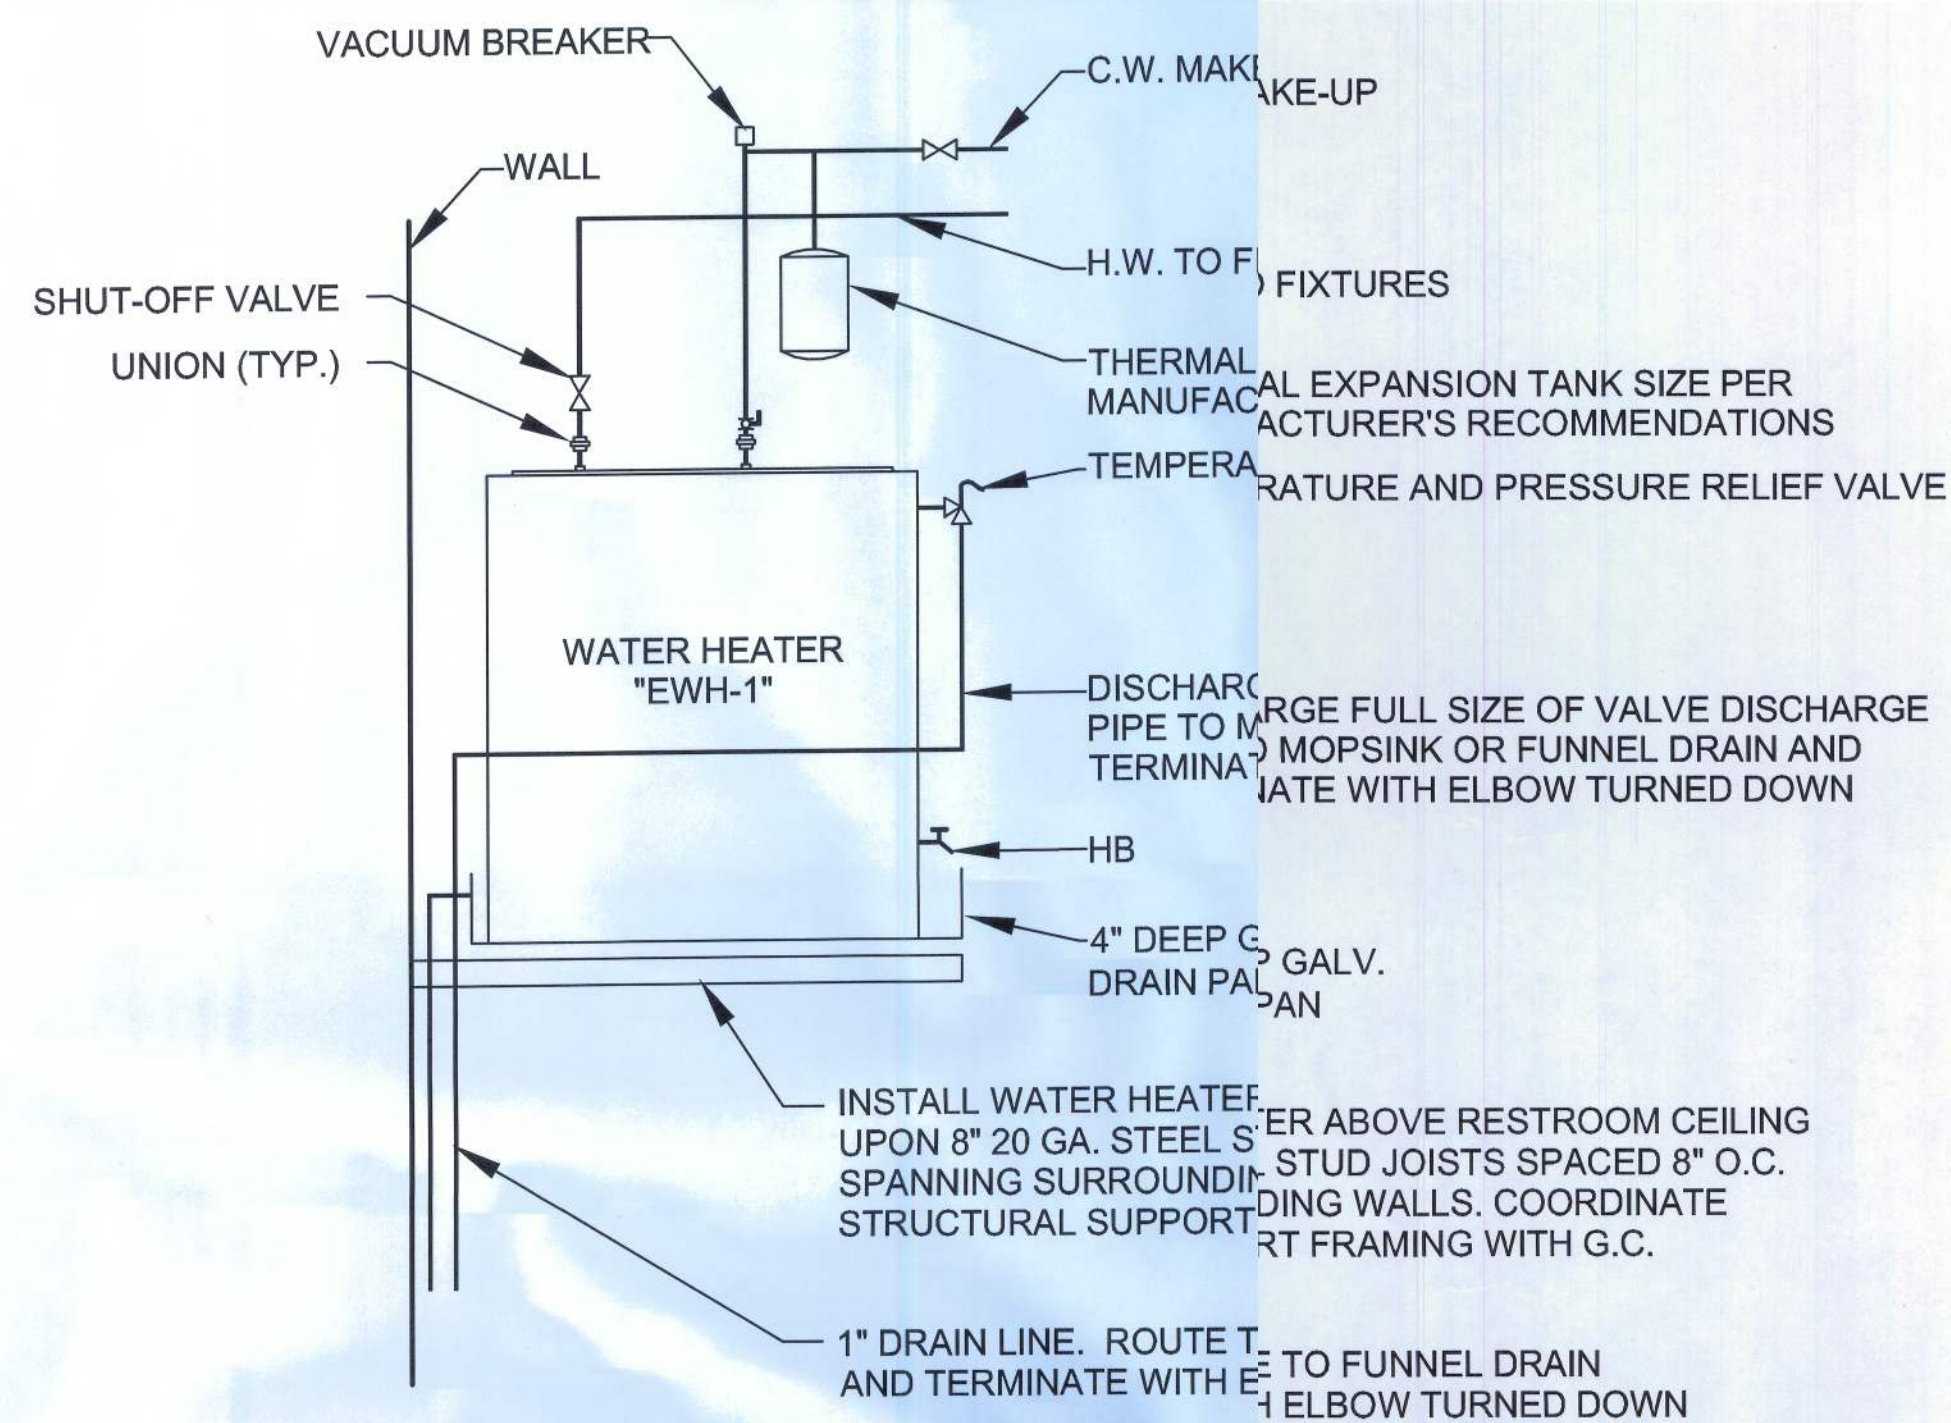


2 WATER HEATER "EWH-1" DETAIL
P2.C N.T.S.

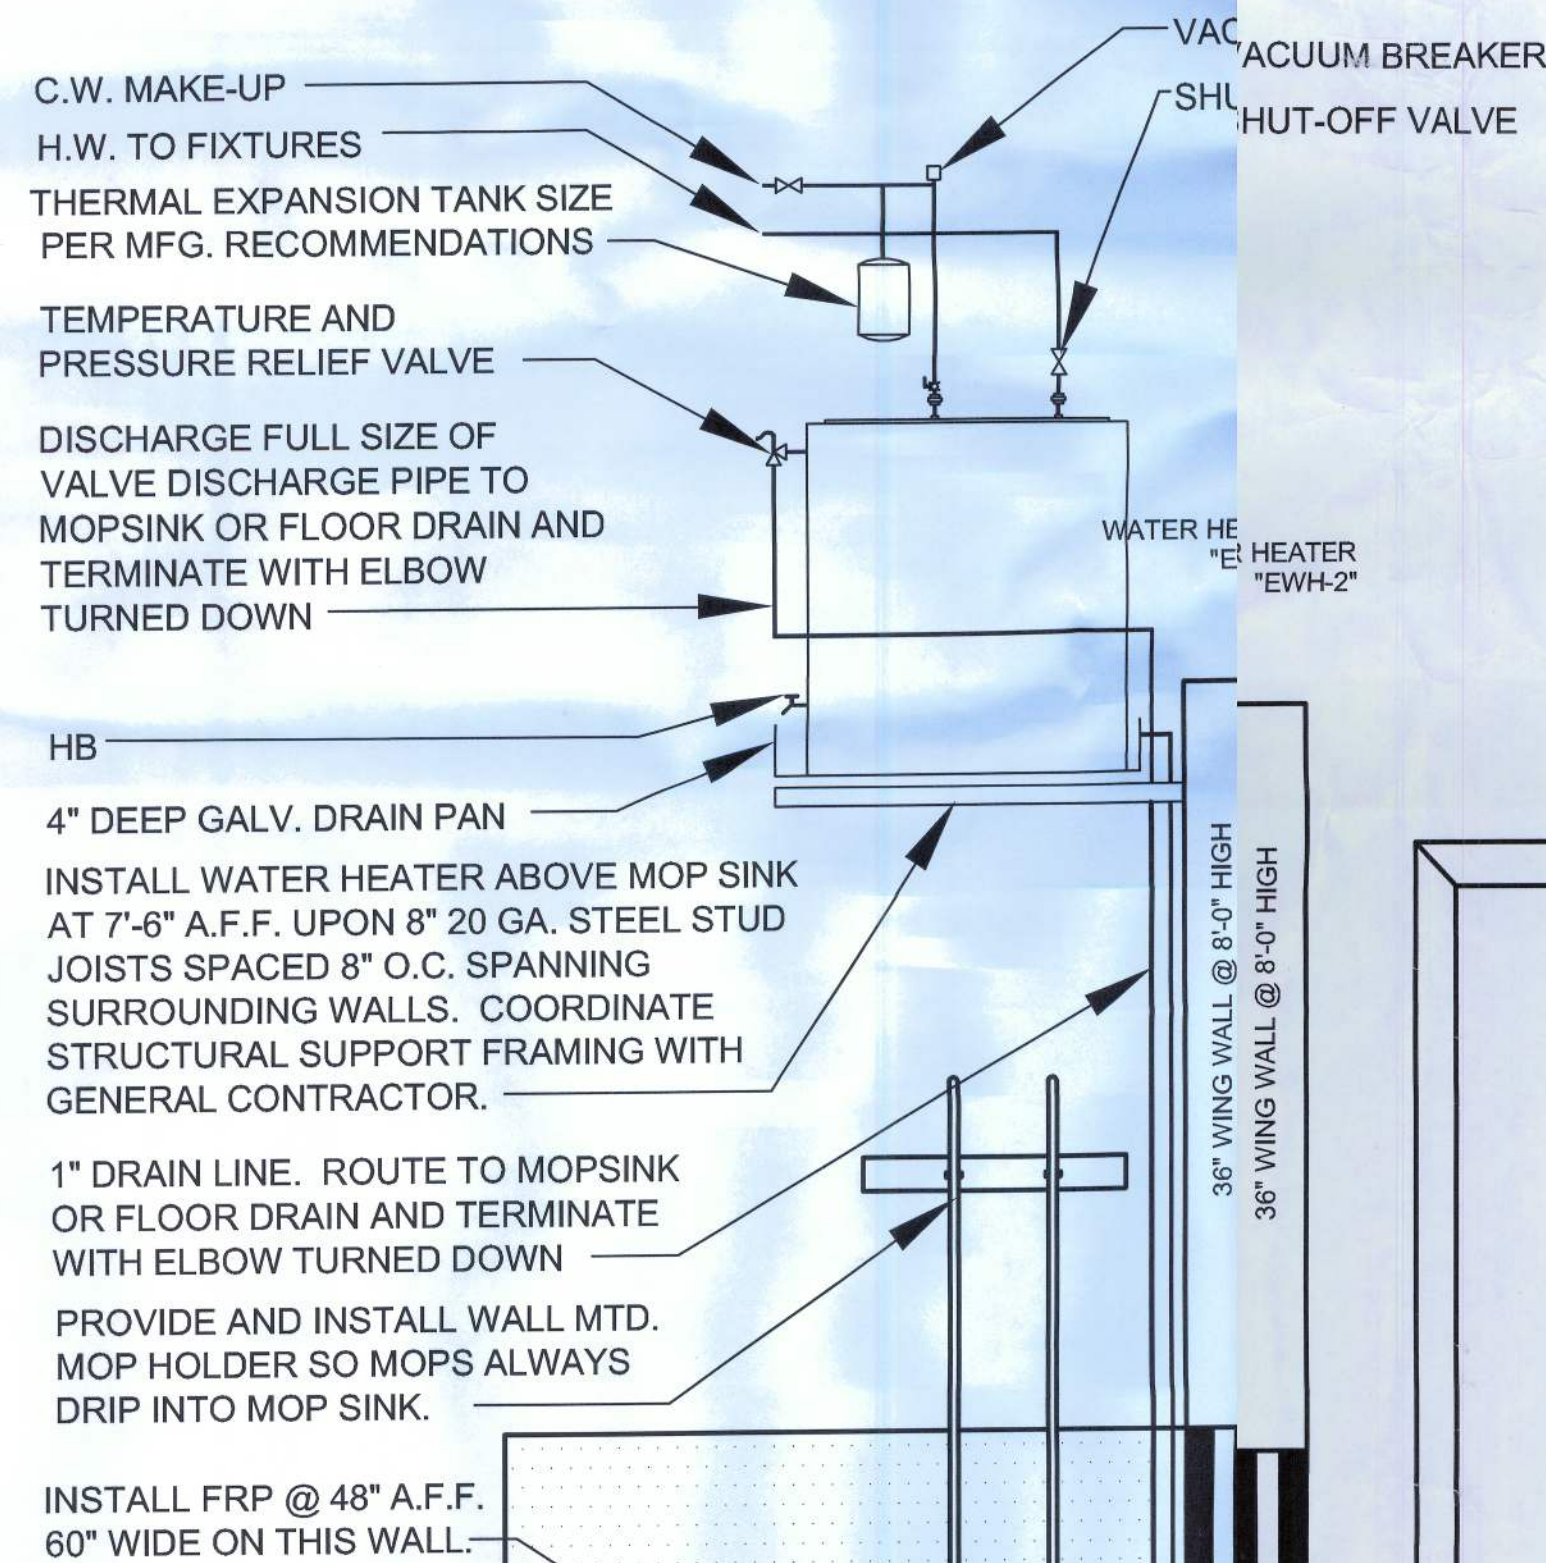

4 MOP SINK DETAIL @ RECEIVING
P2.C N.T.S.

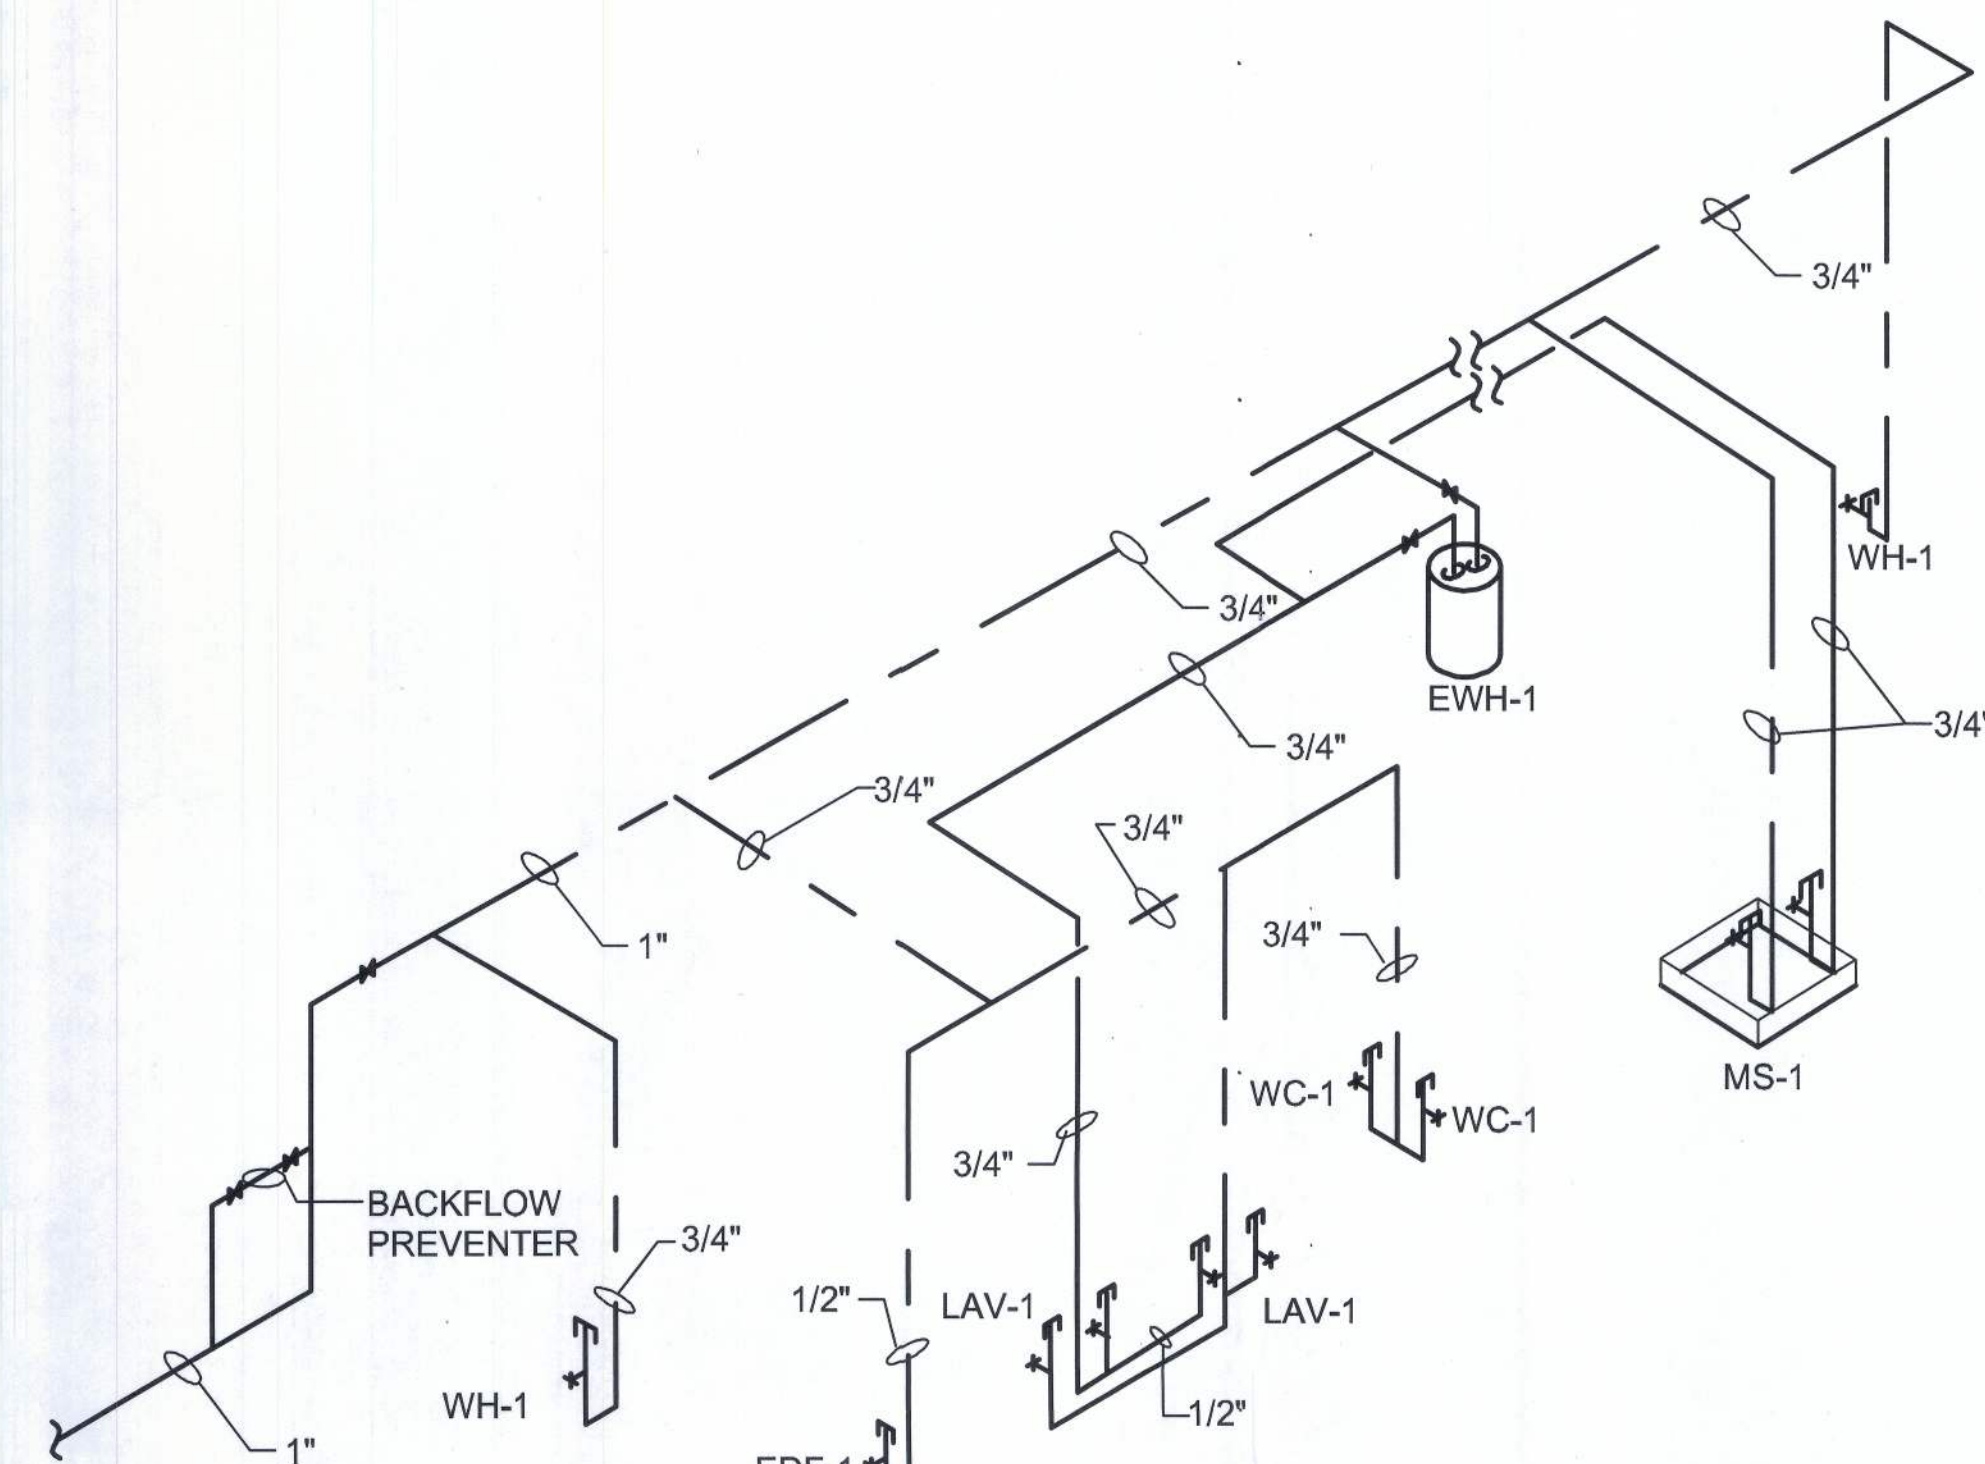

COLD & HOT WATER DIAGRAM
SEE SHEET P1.C FOR PLUMBING DEVICE CODES

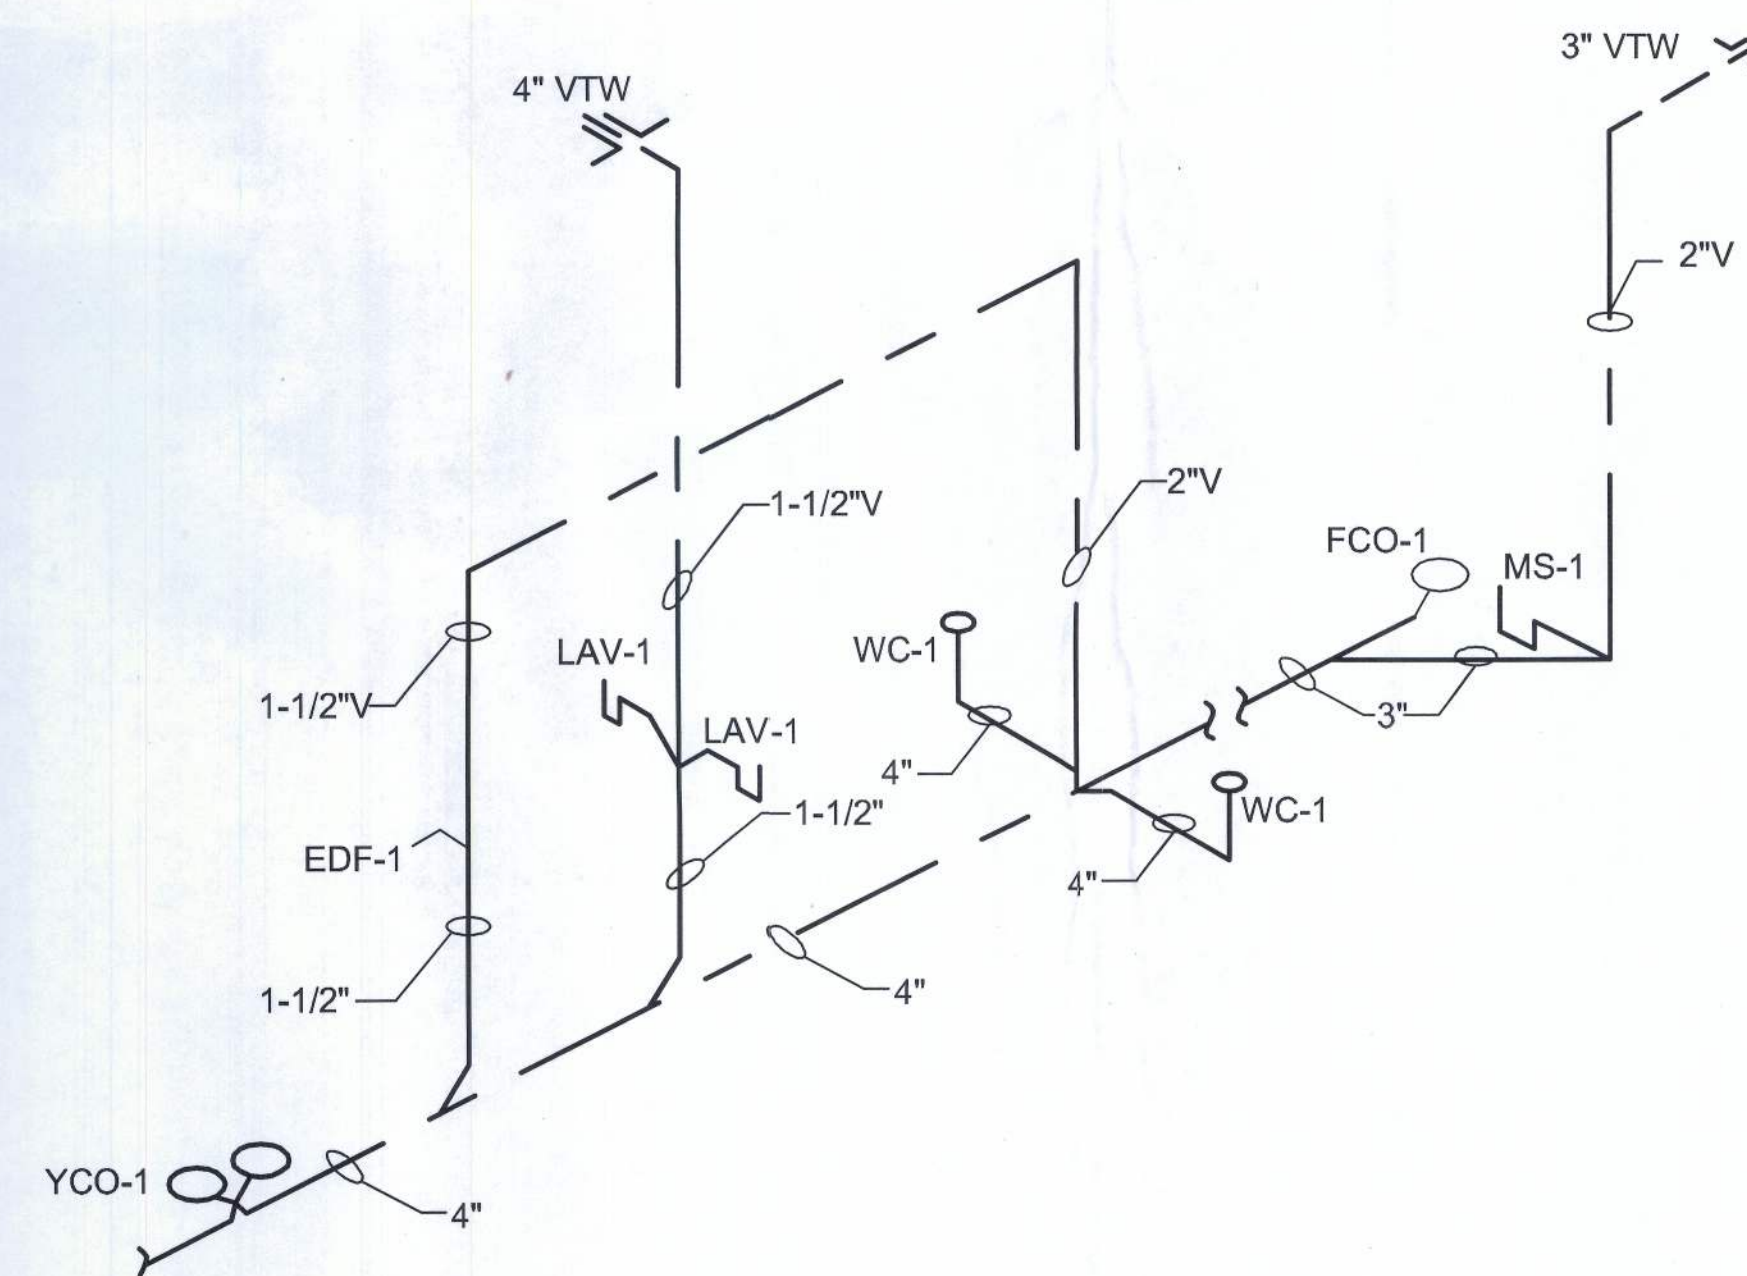

SANITARY & VENT DIAGRAM
SEE SHEET P1.C FOR PLUMBING DEVICE CODES

PLUMBING DETAILS & RISER DIAGRAMS

NE
NICHOLAS PAUL GEISLER ARCHITECT
N.C.A.R.B. Certified
10877 WATSON ROAD
LAKE CITY, FL 32055
PHONE: 386-755-9021

DATE: 3/10/2010
CDMM: AR0007005



CONCEPT CONSTRUCTION

License#: CC1515491
ph: 386-755-3887
fx: 386-755-919
295 NW Commons Loop
Suite 115-32
Lake City, FL 32055
www.conceptconstruction.net

DOLLAR GENERAL

LAKE CITY, FLORIDA
COUNTY RD 247, LAKE CITY, FL
STORE # 12851
2010 PROTOTYPE - PLAN "C" 9,100

DATE	30 MAR 2010
Design	JFB 06/10/10
Revisions	JFB 10/20/10
SHEET NUMBER	

P2.C