


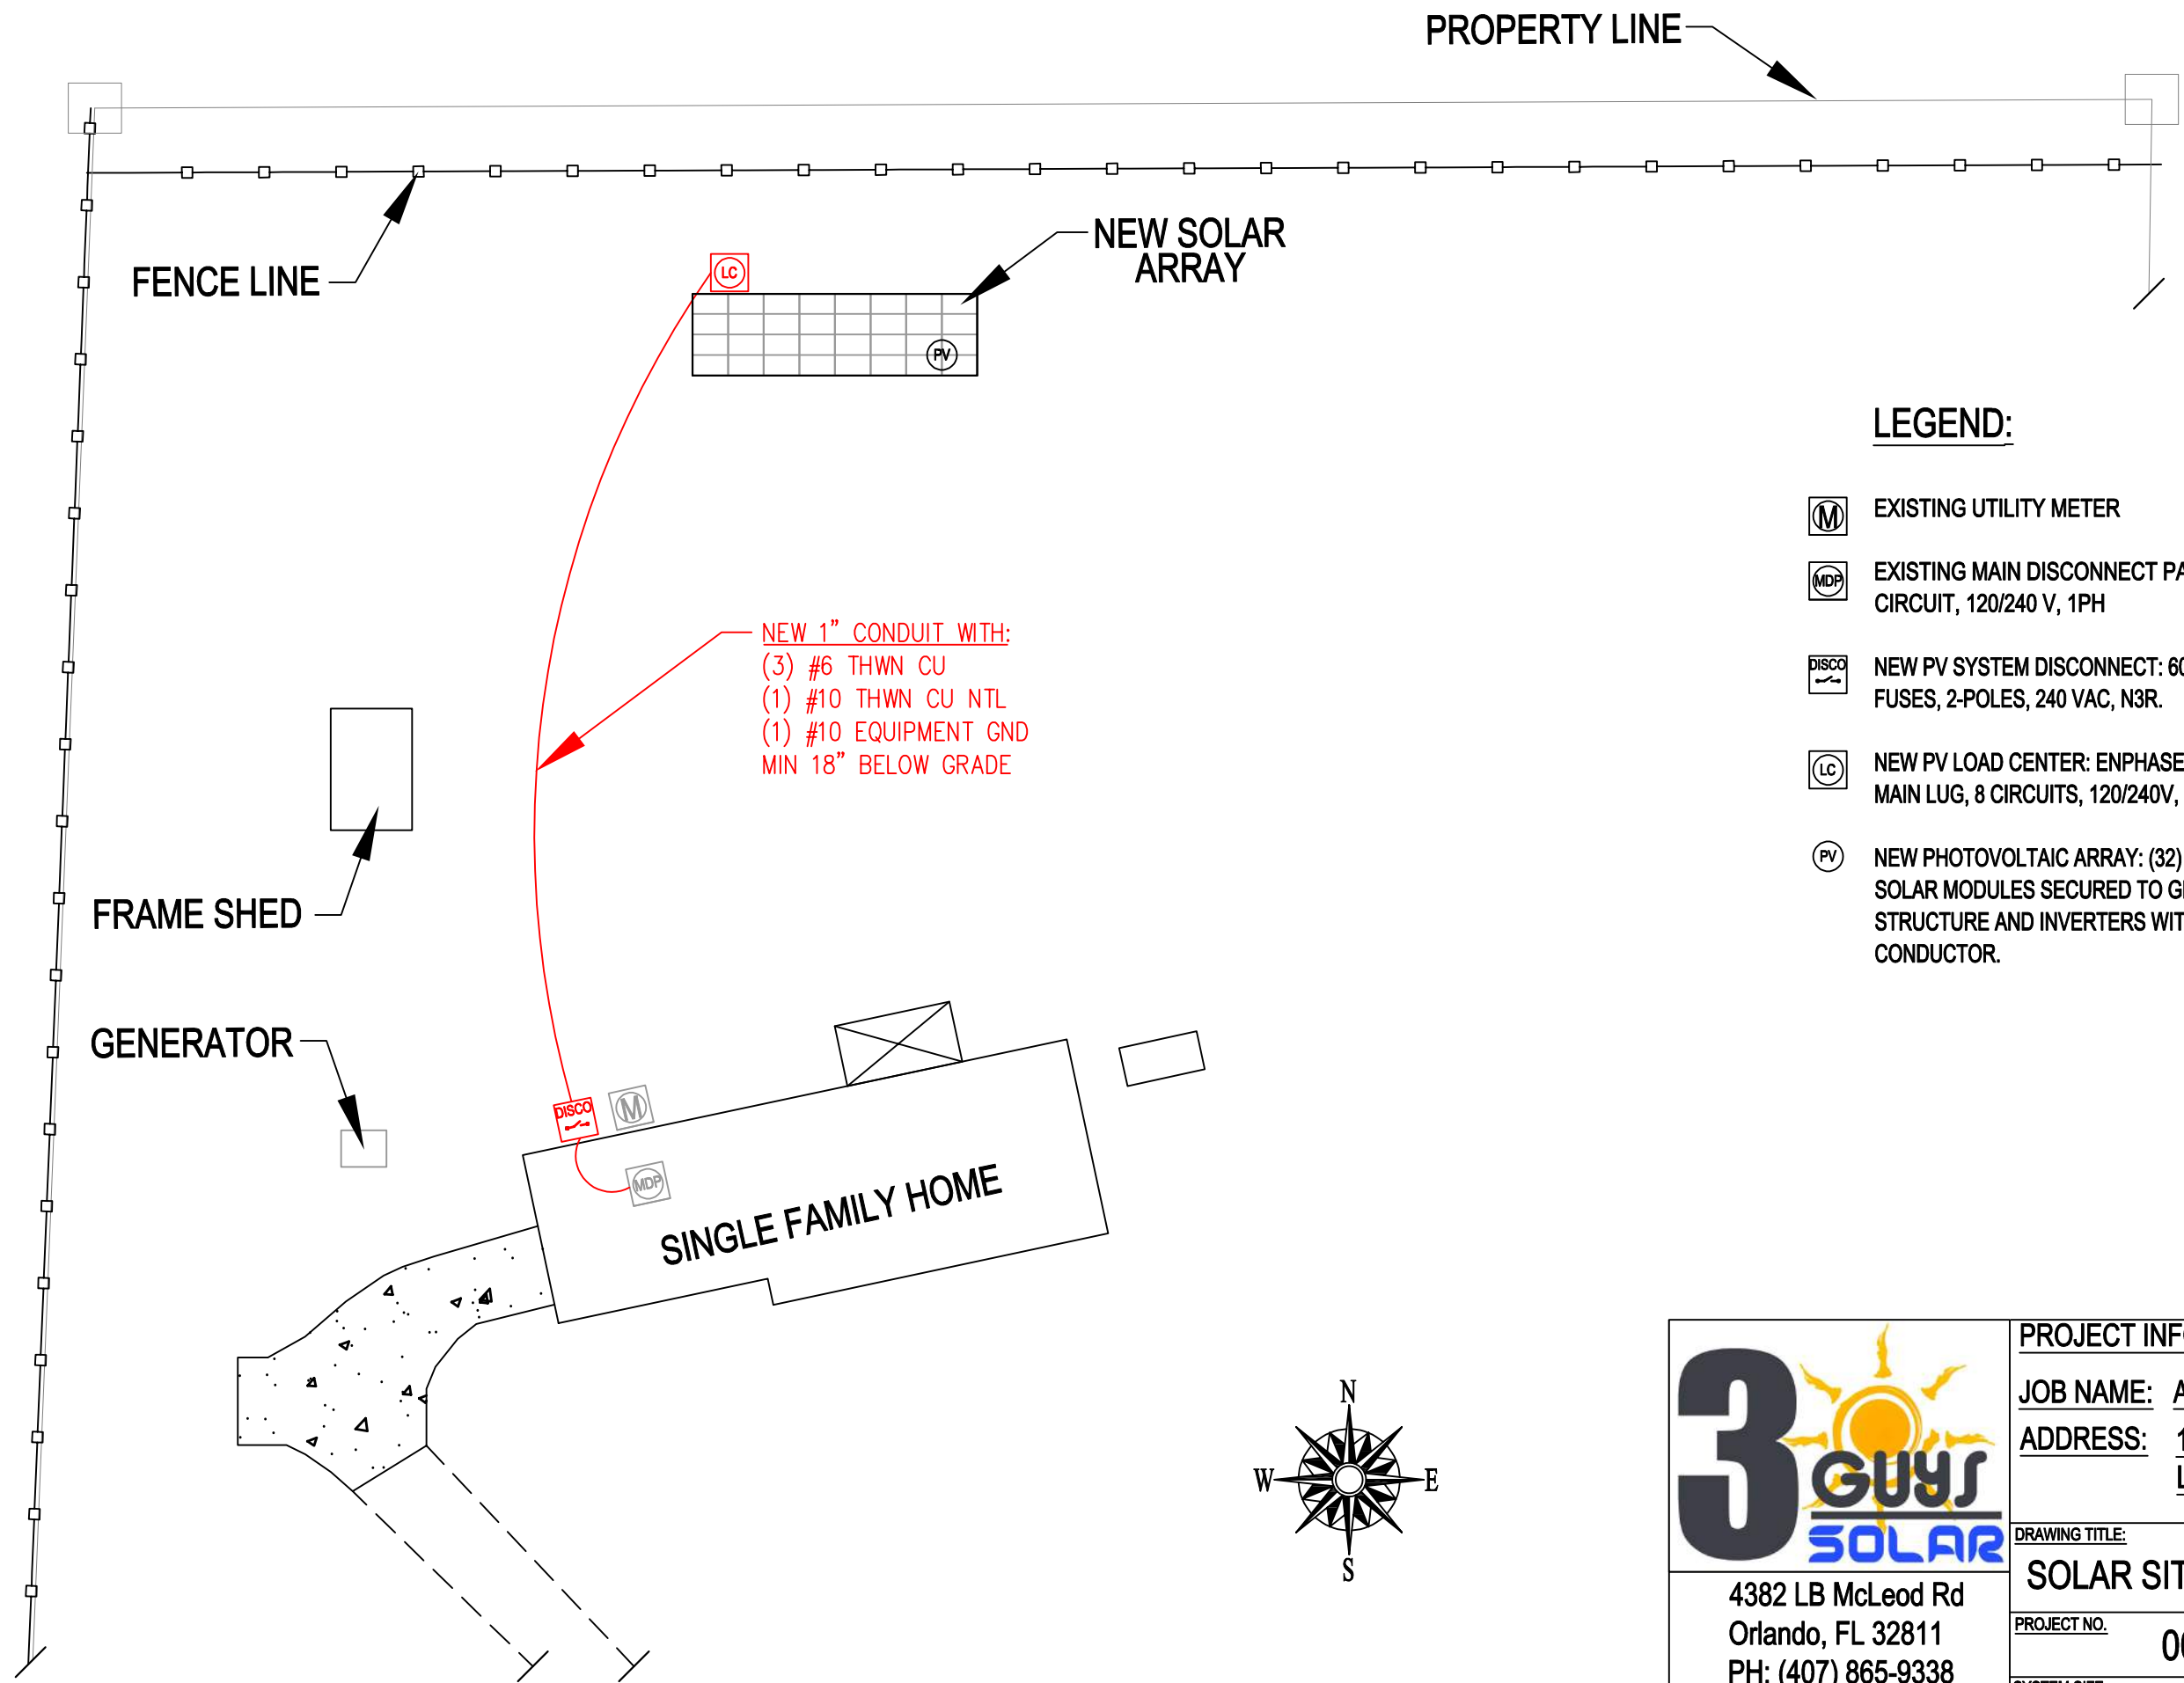

LEGEND:

- EXISTING UTILITY METER
- EXISTING MAIN DISCONNECT PANEL: 200 AMP MAIN, 30 CIRCUIT, 120/240 V, 1PH
- NEW PV SYSTEM DISCONNECT: 60 AMP RATED WITH 60AMP FUSES, 2-POLES, 240 VAC, N3R.
- NEW PV LOAD CENTER: ENPHASE IQ COMBINER, 80 AMP MAIN LUG, 8 CIRCUITS, 120/240V, 1 PH, N3R
- NEW PHOTOVOLTAIC ARRAY: (32) Q-CELLS 360W WATT SOLAR MODULES SECURED TO GROUND MOUNT RACK STRUCTURE AND INVERTERS WITH #8 SOLID COPPER CONDUCTOR.



4382 LB McLeod Rd  
Orlando, FL 32811  
PH: (407) 865-9338  
LIC: EC13002507

PROJECT INFORMATION:

JOB NAME: ARON & JENNIFER GOODENBURY

ADDRESS: 1431 SE MYRTIS RD.  
LAKE CITY, FL 32025

DRAWING TITLE:

SOLAR SITE PLAN

|              |         |        |     |
|--------------|---------|--------|-----|
| PROJECT NO.  | 0000    | SHEET: | E-1 |
| SYSTEM SIZE: | 11.52KW | SCALE: |     |
|              |         | SIZE:  | B   |