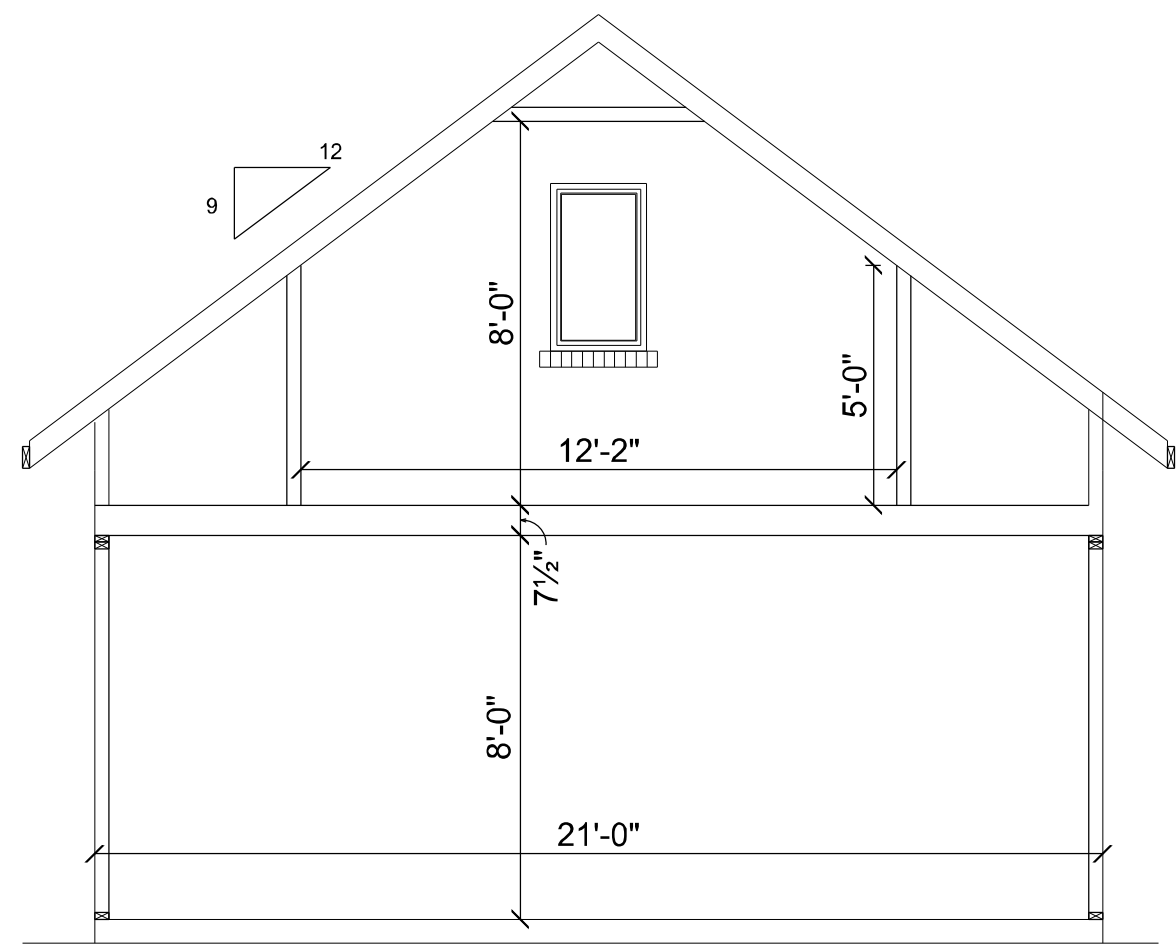
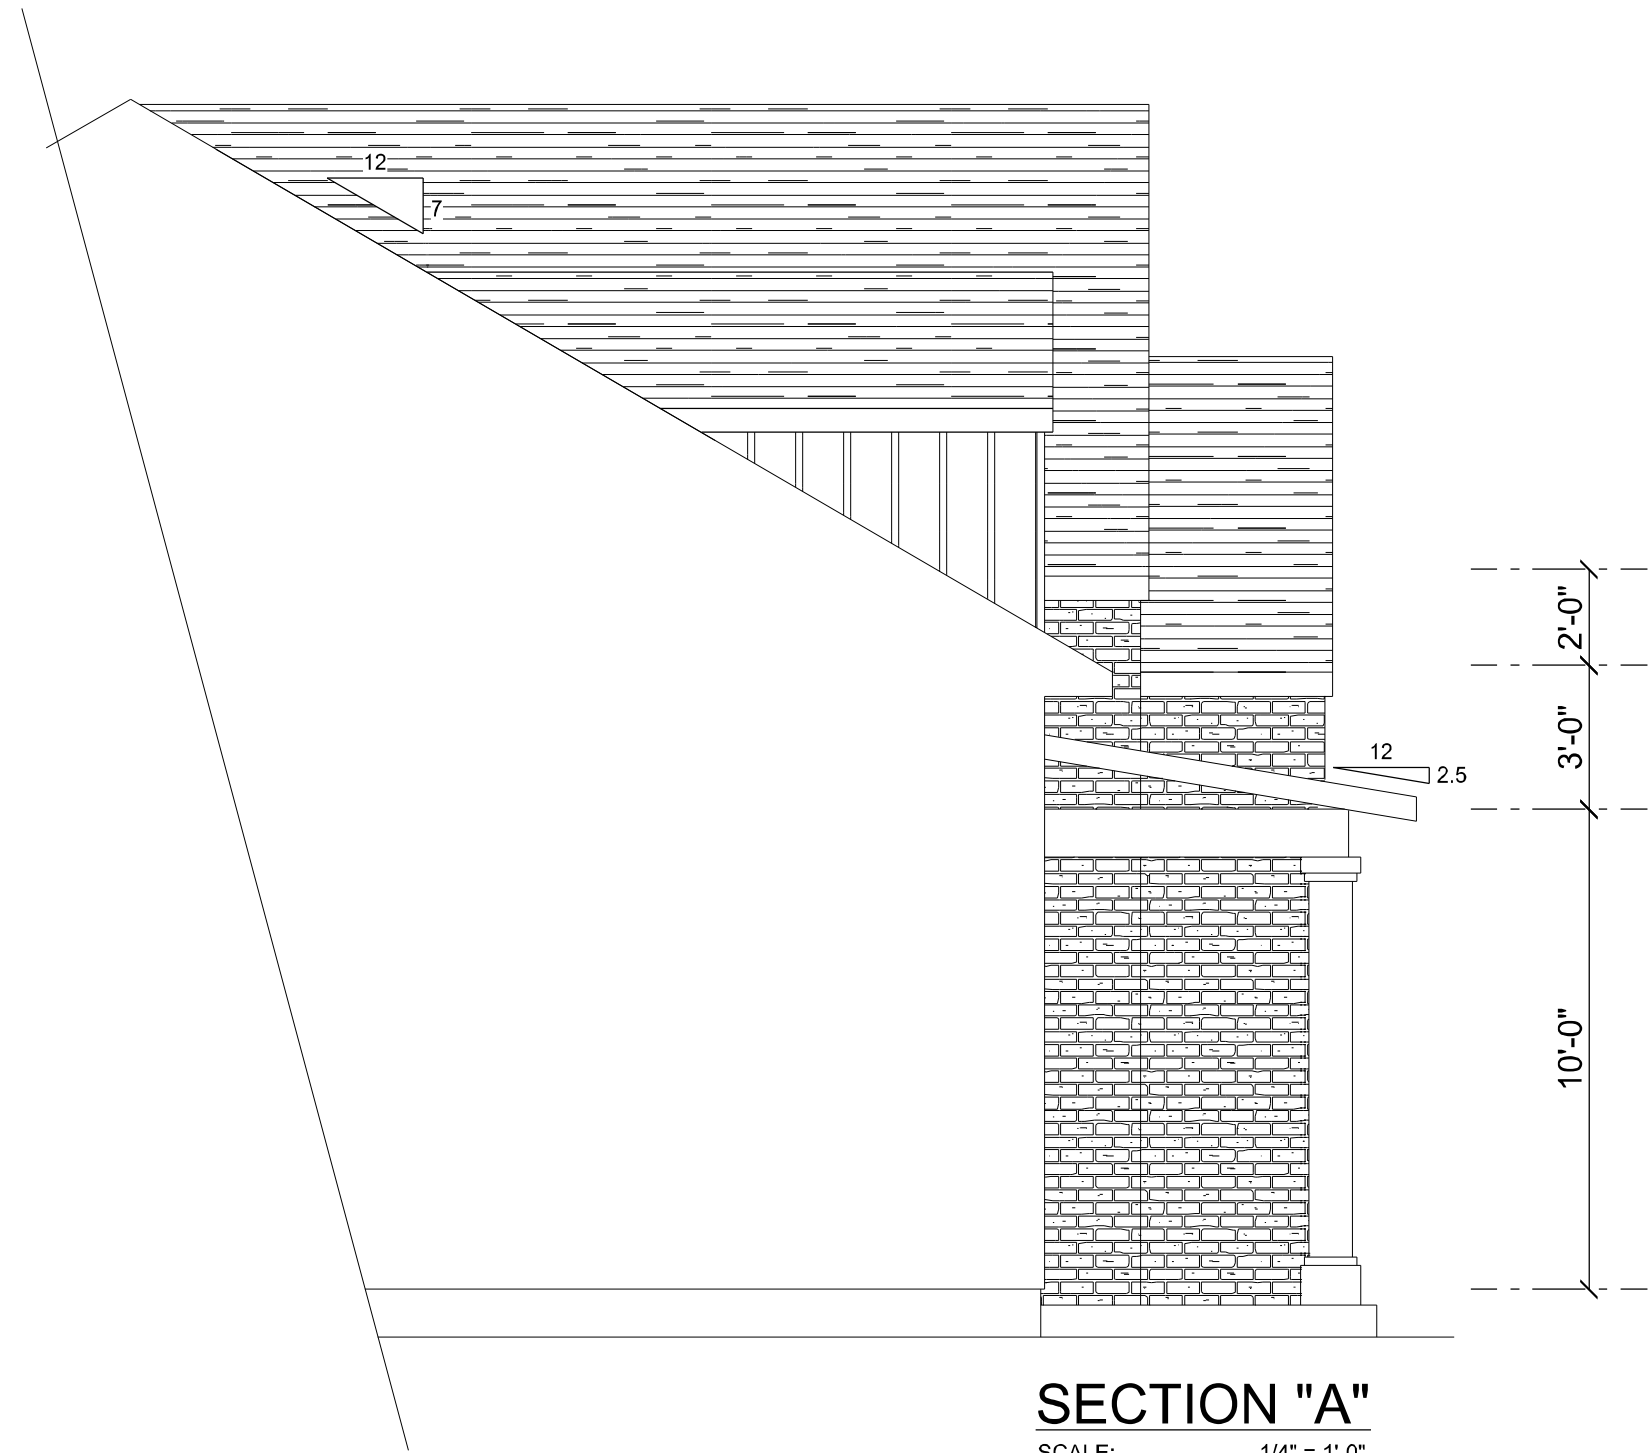




REAR ELEVATION
SCALE: 1/4" = 1'-0"



SECTION "A"
SCALE: 1/4" = 1'-0"




FRONT ELEVATION
SCALE: 1/4" = 1'-0"

REVISIONS SCHEDULE			
Aug. 4th, 2020	PROPOSAL		
Aug. 26th, 2020	REVISIONS		
Dec. 30th, 2020	REVISIONS		
Jan. 18th, 2021	FINAL DRAWINGS		
June 8th, 2021	WINDOW REVISIONS		

NEW PROPOSAL FOR:
Jon & Ashley Morris
LOT 3, HERITAGE HILLS,
312 LEGACY GLEN, LAKE CITY, FLORIDA 32025


**RIDGEPOINT
DESIGN**
366 SW ARINGTON BLVD., STE 101, LAKE CITY, FL 32025
P: 386-288-1188
E: RIDGEPOINTDESIGN@GMAIL.COM

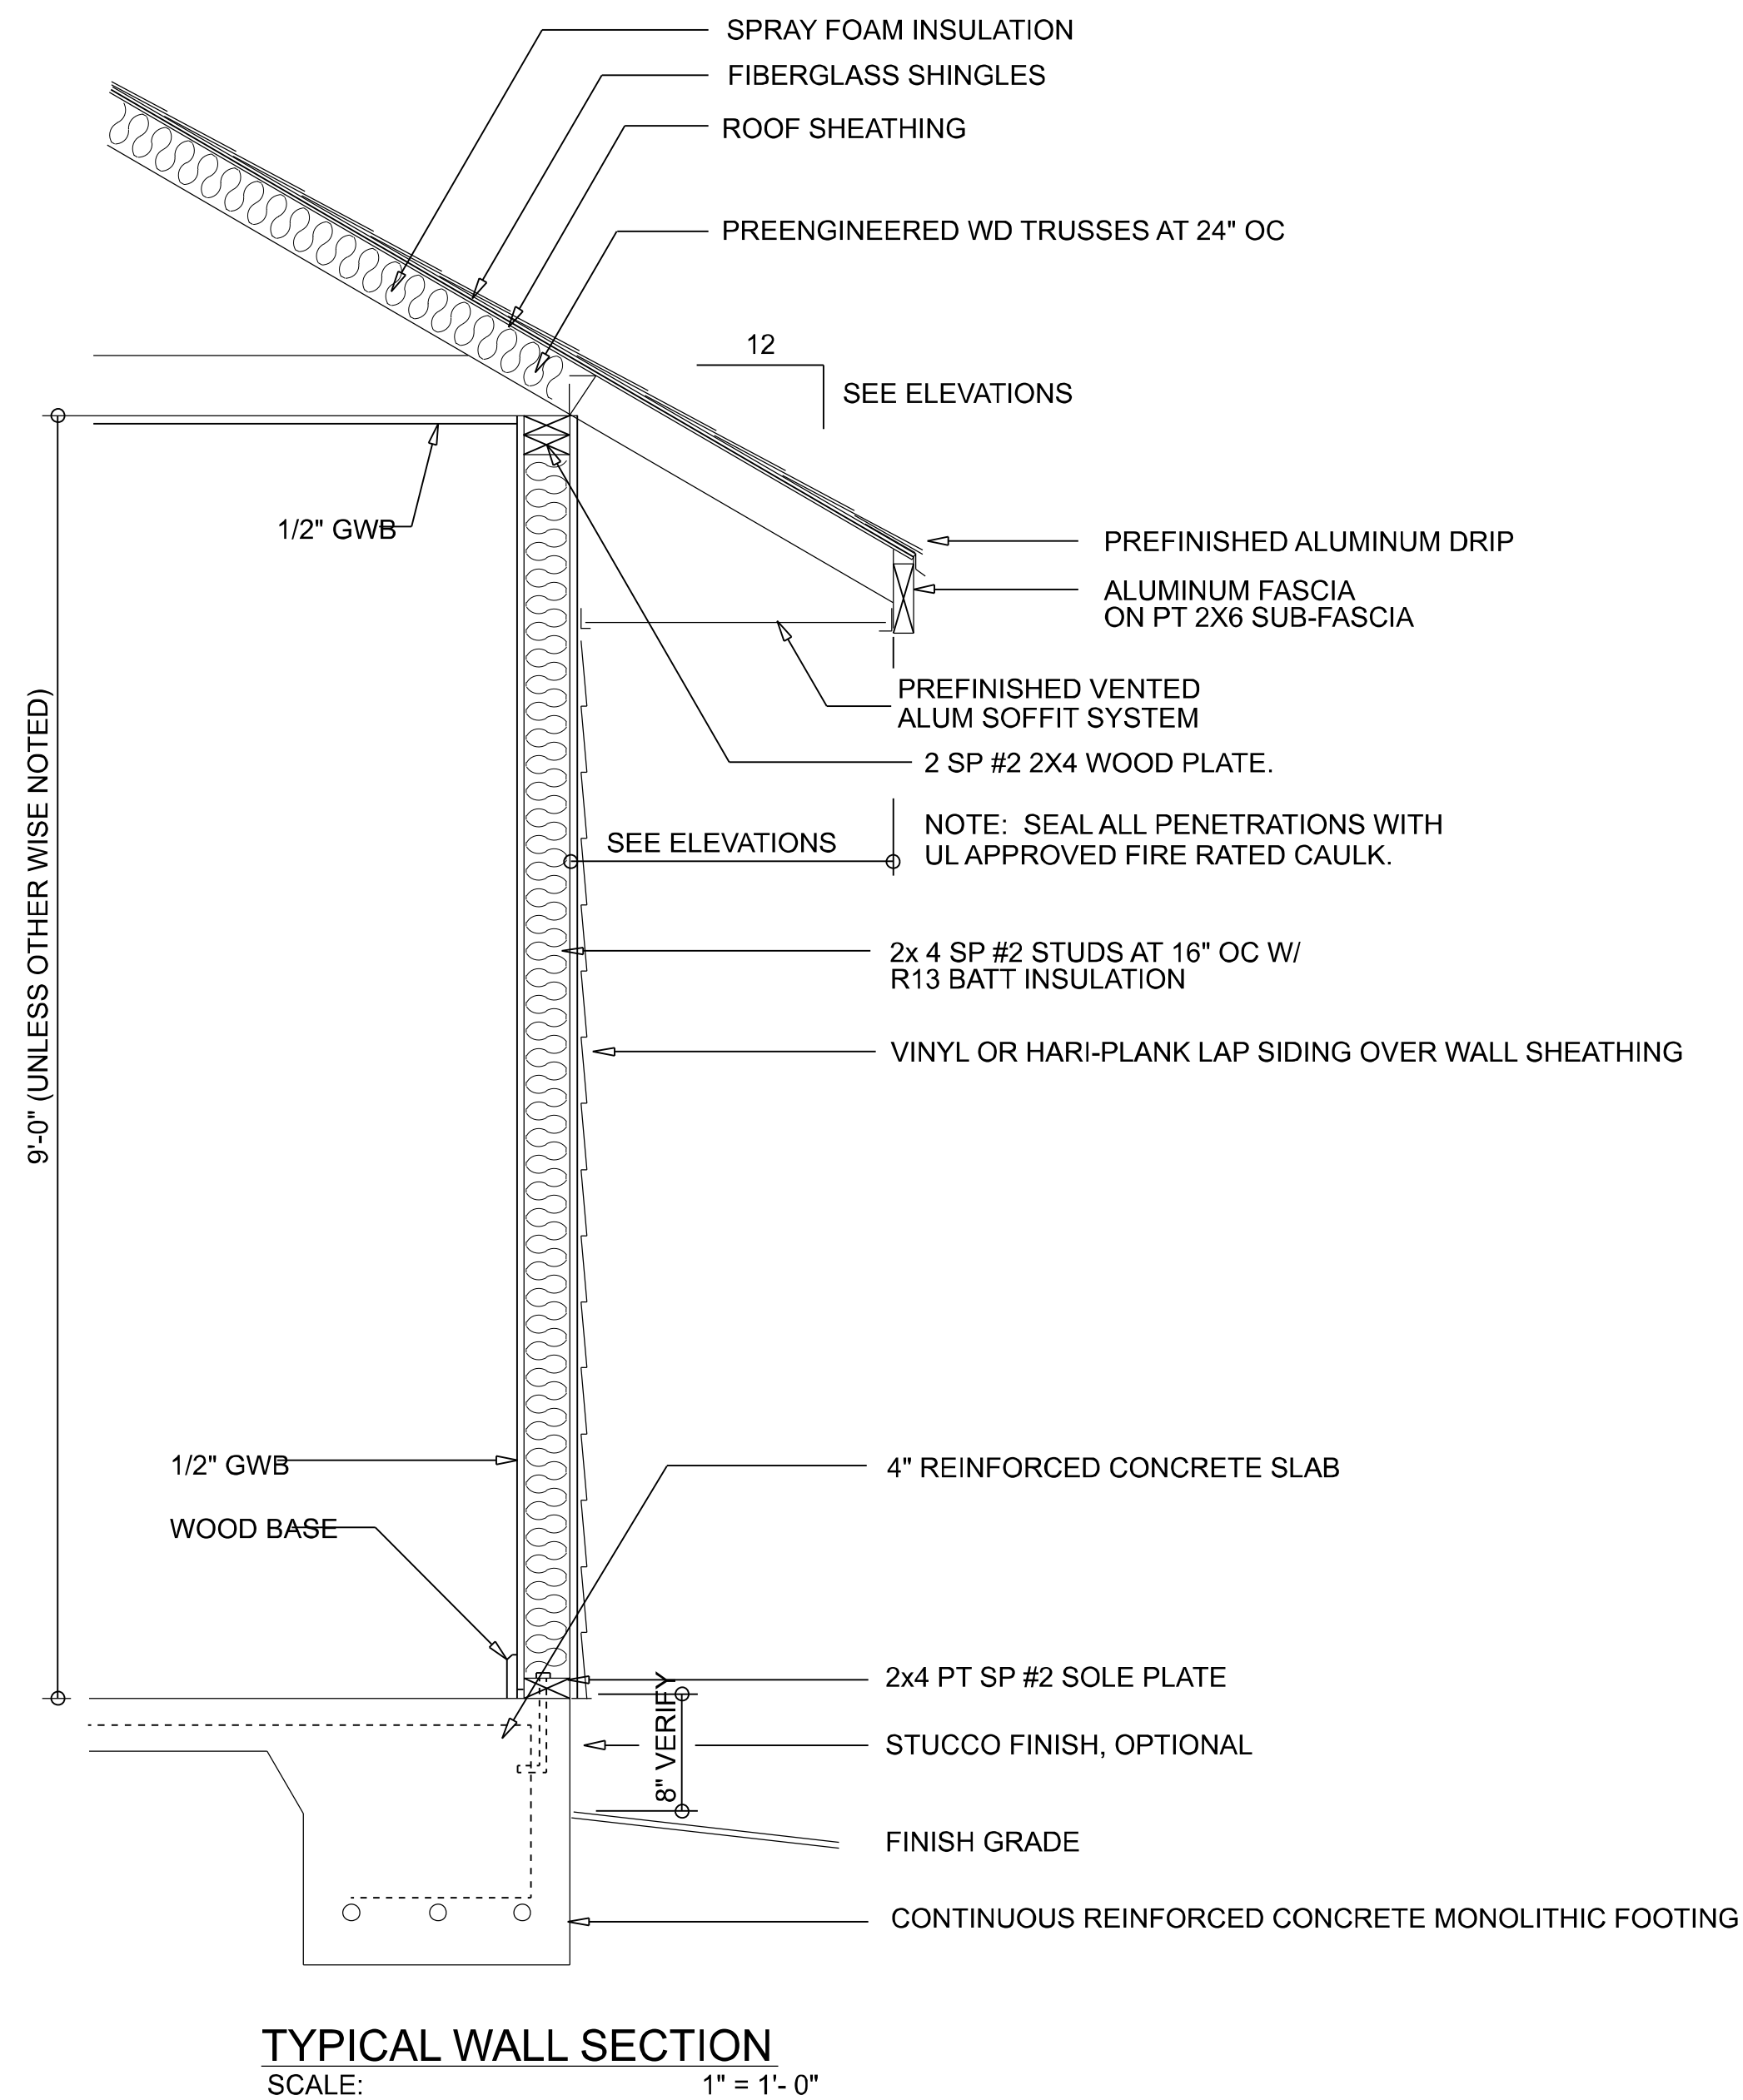SHEET NUMBER
A.1
OF 4 SHEETS



LEFT ELEVATION

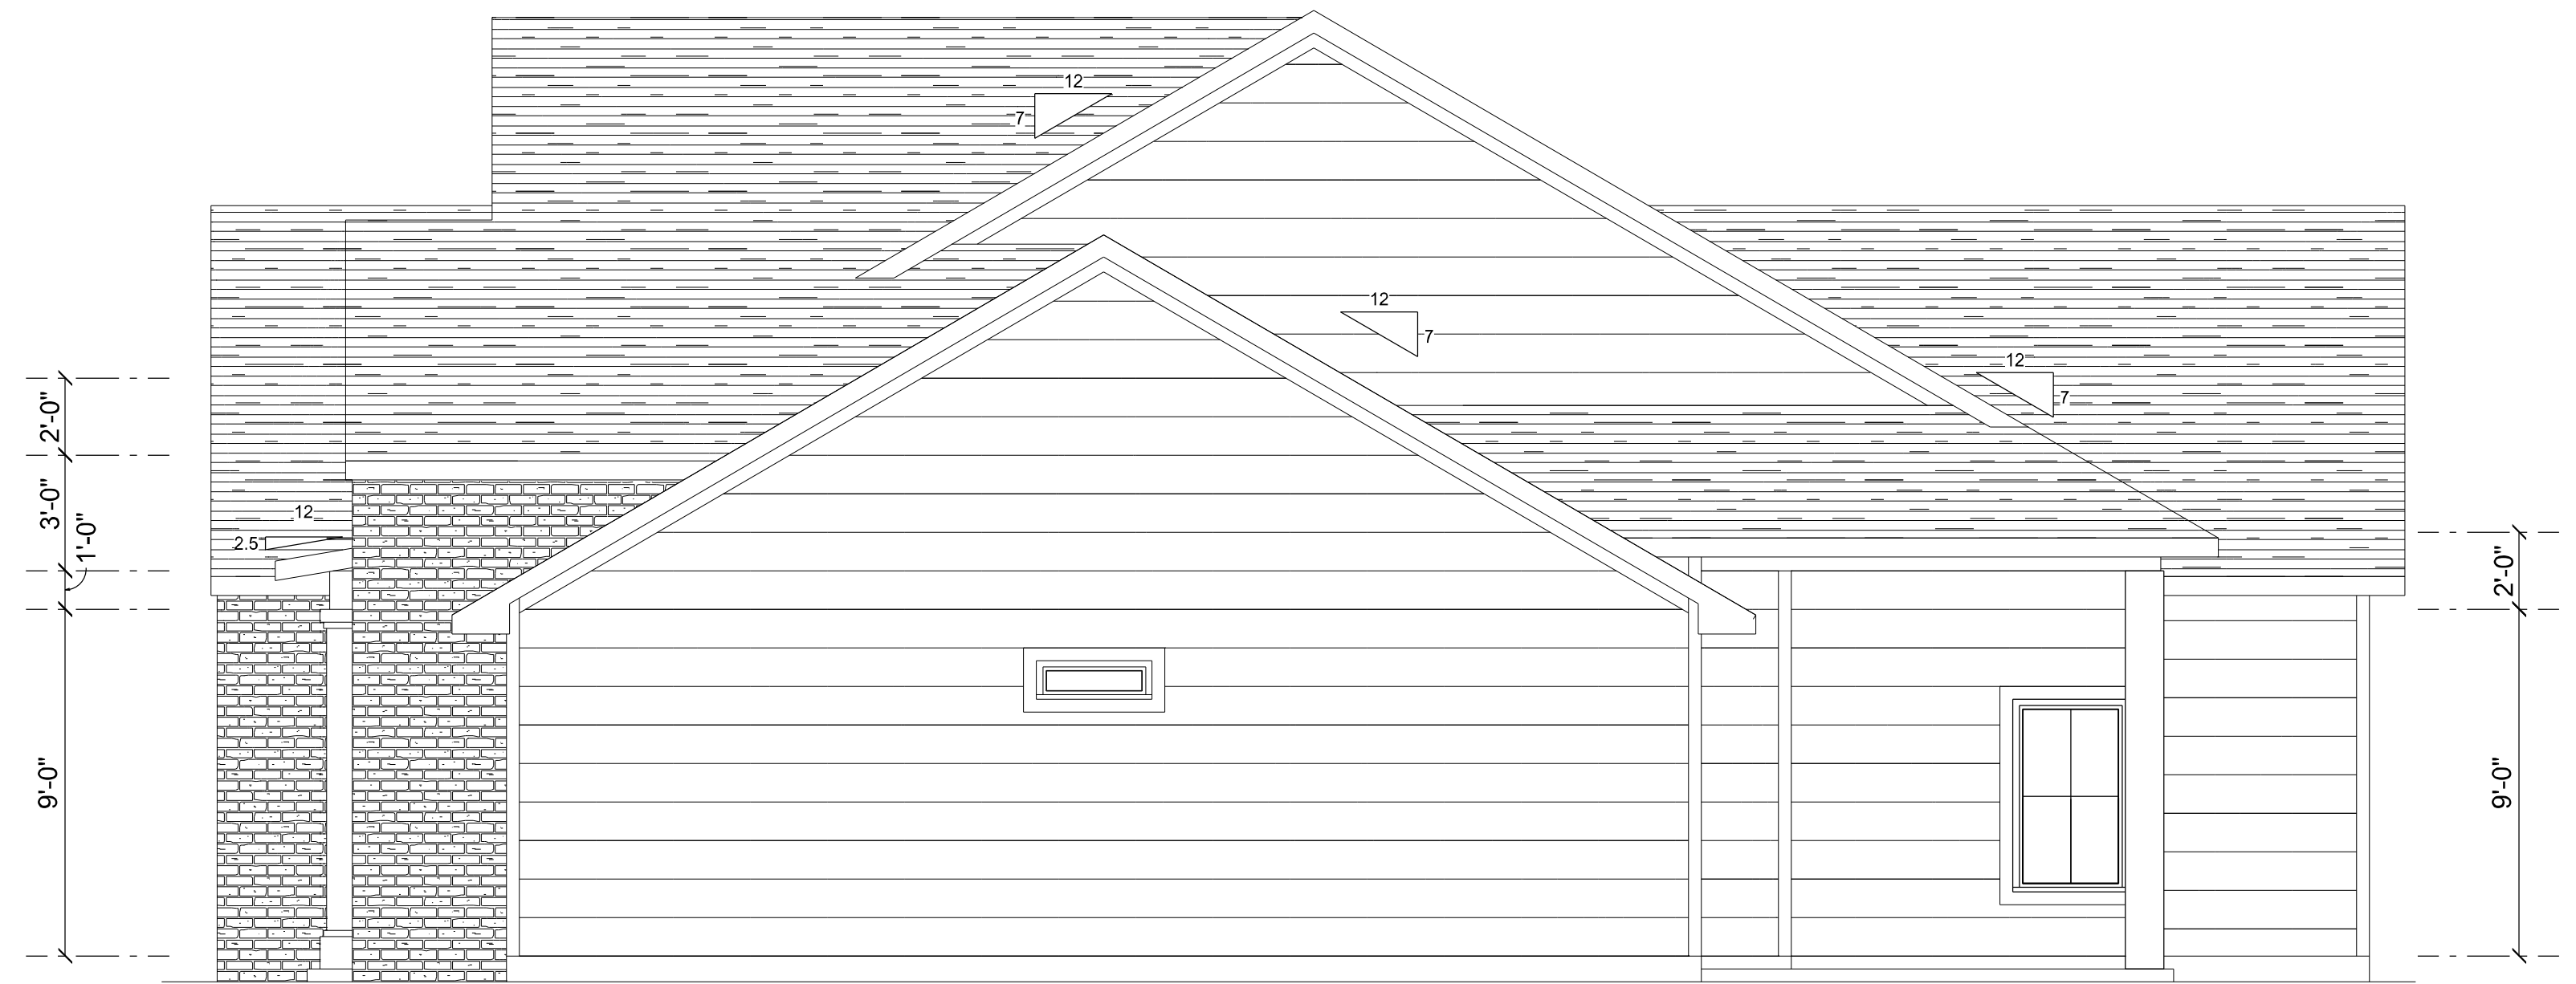SCALE: 1/4" = 1'-0"



RIGHT ELEVATION

SCALE: 1/4" = 1'-0"

REVISIONS SCHEDULE	
Aug. 4th, 2020	PROPOSAL
Aug. 26th, 2020	REVISIONS
Dec. 30th, 2020	REVISIONS
Jan. 18th, 2021	FINAL DRAWINGS
June 8th, 2021	WINDOW REVISIONS

 
 
 
 
 
 
 
NEW PROPOSAL FOR:
Jon & Ashley Morris


LOT 3, HERITAGE HILLS,
312 LEGACY GLEN, LAKE CITY, FLORIDA 32025



SHEET NUMBER
A.2
OF 4 SHEETS

A.3
OF 4 SHEETS

ELECTRICAL LEGEND		
ELECTRICAL	COUNT	SYMBOL
CEILING FAN	5	
CAN LIGHT 6inch	36	
CHANDELIER	4	
LED CEILING LIGHT 1x4	2	
PENDANT LIGHT	2	
EXTERIOR SCONCE	3	
MOTION SECURITY LIGHT	4	
ELECTRIC METER	1	
ELECTRIC PANEL	1	
AC DISCONNECT	1	
CABLE TV OUTLET	6	
CARBON DETECTOR	2	
EXHAUST FAN	1	
EXHAUST FAN & LIGHT COMBO	1	
OUTLET	43	
OUTLET 220v	4	
OUTLET GFI	18	
OUTLET WP	4	
SMOKE DETECTOR	5	
STANDARD LIGHT	10	
SWITCH	35	
SWITCH 3 WAY	19	
VANITY BAR LIGHT - SMALL	4	

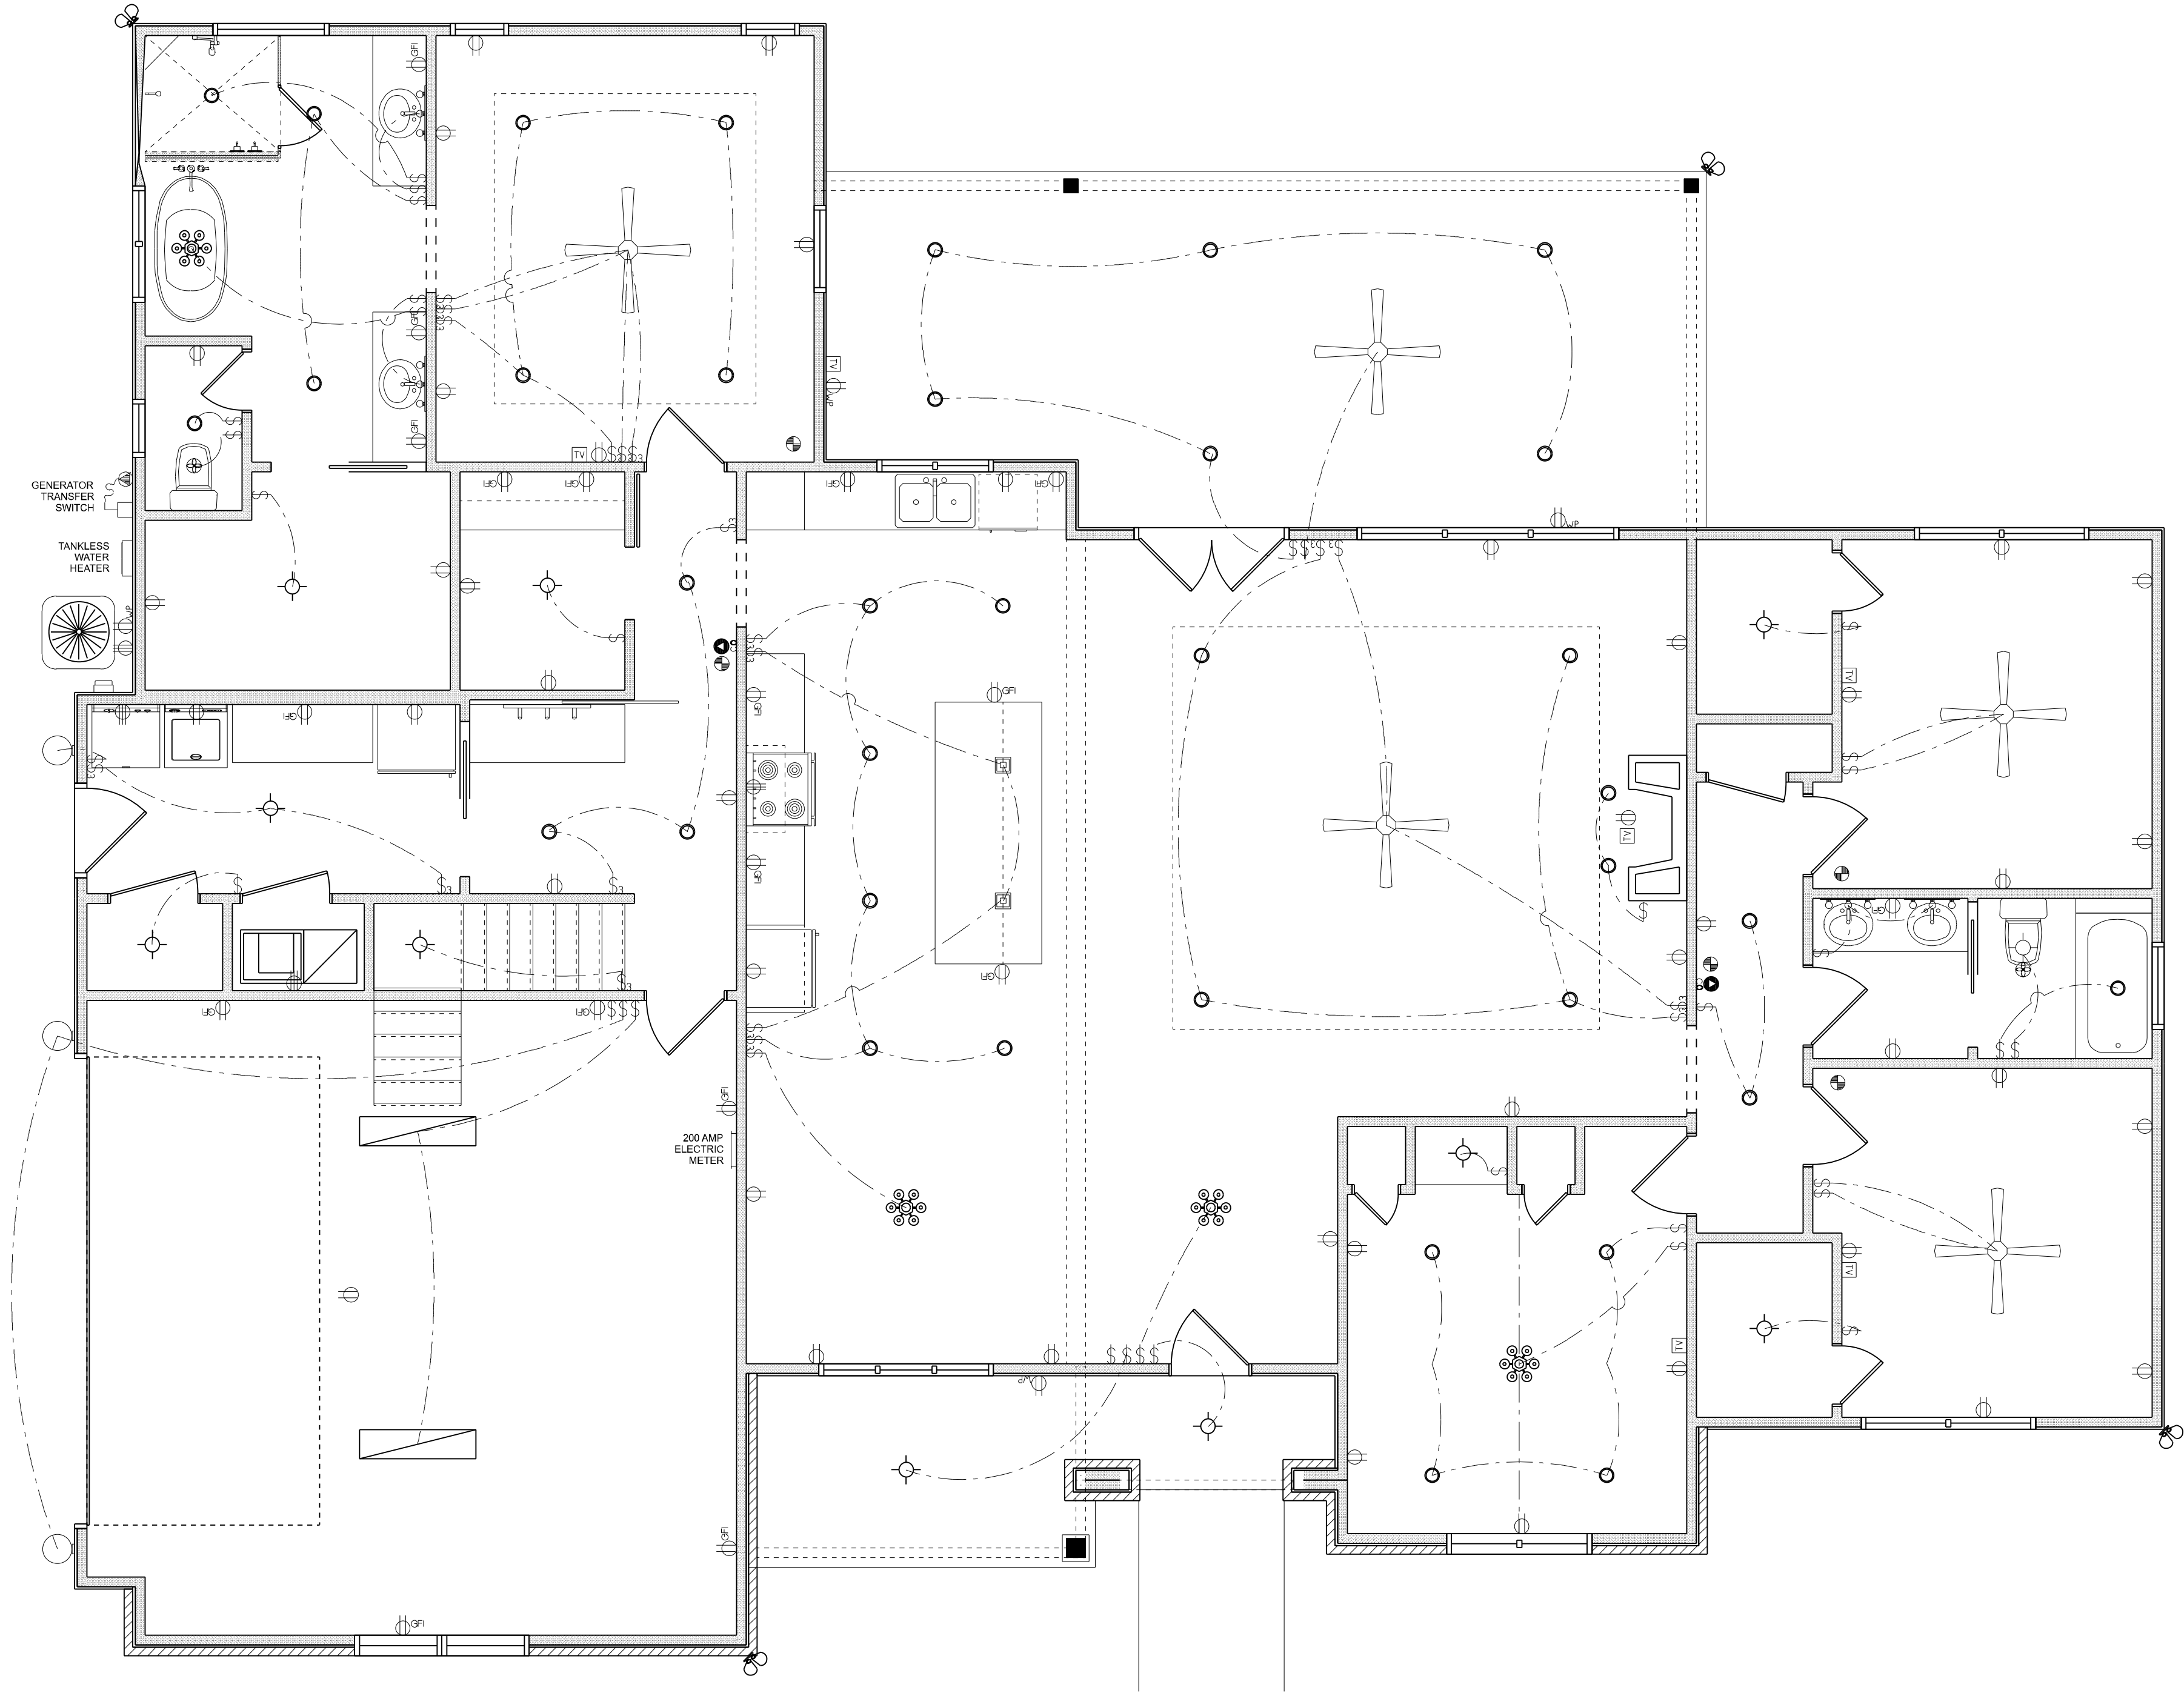

ELECTRICAL PLAN
SCALE: 1/4" = 1'-0"

ELECTRICAL PLAN NOTES:

INSTALLATION SHALL BE PER LATEST NAT'L ELECTRIC CODE.

WIRE ALL APPLIANCES, HVAC UNITS AND OTHER EQUIPMENT PER MANUF. SPECIFICATIONS

CONSULT WITH THE OWNER FOR THE NUMBER OF SEPERATE TELEPHONE LINES TO BE INSTALLED

ALL SMOKE DETECTORS SHALL BE 120v W/ BATTERY BACKUP OF THE PHOTOELECTRIC TYPE, AND SHALL BE INTERLOCKED TOGETHER. INSTALL INSIDE AND NEAR ALL BEDROOMS

TELEPHONE, TELEVISION AND OTHER LOW VOLTAGE DEVICES OR OUTLETS SHALL BE AS PER THE OWNER'S DIRECTIONS, & IN ACCORDANCE W/ APPLICABLE SECTIONS OF NEC-LATEST EDITION.

ALL RECEPTICALS, NOT OTHERWISE NOTED, SHALL BE ARC FAULT INTERRUPTER TYPE, EXCEPT DEDICATED OUTLETS

ALL RECEPTICALS IN WET AREAS SHALL BE GROUND FAULT INTERRUPTER TYPE (GFI)

ALL EXTERIOR RECEPTICALS SHALL BE WEATHERPROOF GROUD FAULT INTERRUPTER TYPE (WP/GFI)

NOTE:
ELECTRICAL CONTR SHALL PREPARE "AS-BUILT" SHOP DWGS INDICATING ALL ELECTRICAL WORK, INCLUDING ANY CHANGES TO THE ELEC. PLAN, ADDNS TO THE ELEC. PLAN, RISER DIAGRAM, AS-BUILT PANEL SCHEDULE W/ ALL CKTS IDENTIFIED W/ CKT N: DESCRIPTION & BRKR, SERVICE ENT. & ALL UNDERGROUND WIRE LOCATIONS/ROUTING / DEPTH. RISER DIA. SHALL INCLUDE WIRE SIZES/TYPE & EQUIPMENT TYPE W/ RATINGS & LOADS.
CONTRACTOR SHALL PROVIDE 1 COPY OF AS-BUILT DWGS TO OWNER & 1 COPY TO THE PERMIT ISSUING AUTHORITY