



FRONT ELEVATION
SCALE: 1/4" = 1'-0"



REAR ELEVATION
SCALE: 1/4" = 1'-0"



LEFT ELEVATION
SCALE: 1/4" = 1'-0"



RIGHT ELEVATION
SCALE: 1/4" = 1'-0"

REVISIONS
October 21, 2010


SOFTPLAN
ARCHITECTURAL DESIGN SOFTWARE

EXTERIOR ELEVATIONS
SCALE: 1/4" = 1'-0"

TYPICAL WALL SECTION
SCALE: 1" = 1'-0"

A CUSTOM RESIDENCE FOR:
MEGAN HOLLOWAY
PROJECT ADDRESS: LOT 21, RIVER RISE SQ., COLUMBIA COUNTY, FLORIDA

©WILLIAM MYERS
DESIGN INC.
P.O. BOX 151
LAKE CITY, FL 33556
(386) 758-8406
will@willmyers.com

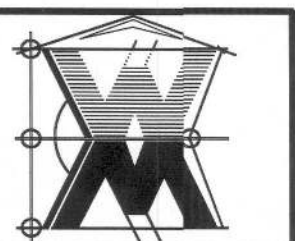


JOB NUMBER
100903

SHEET NUMBER
A.1
OF 4 SHEETS



Wm Myers

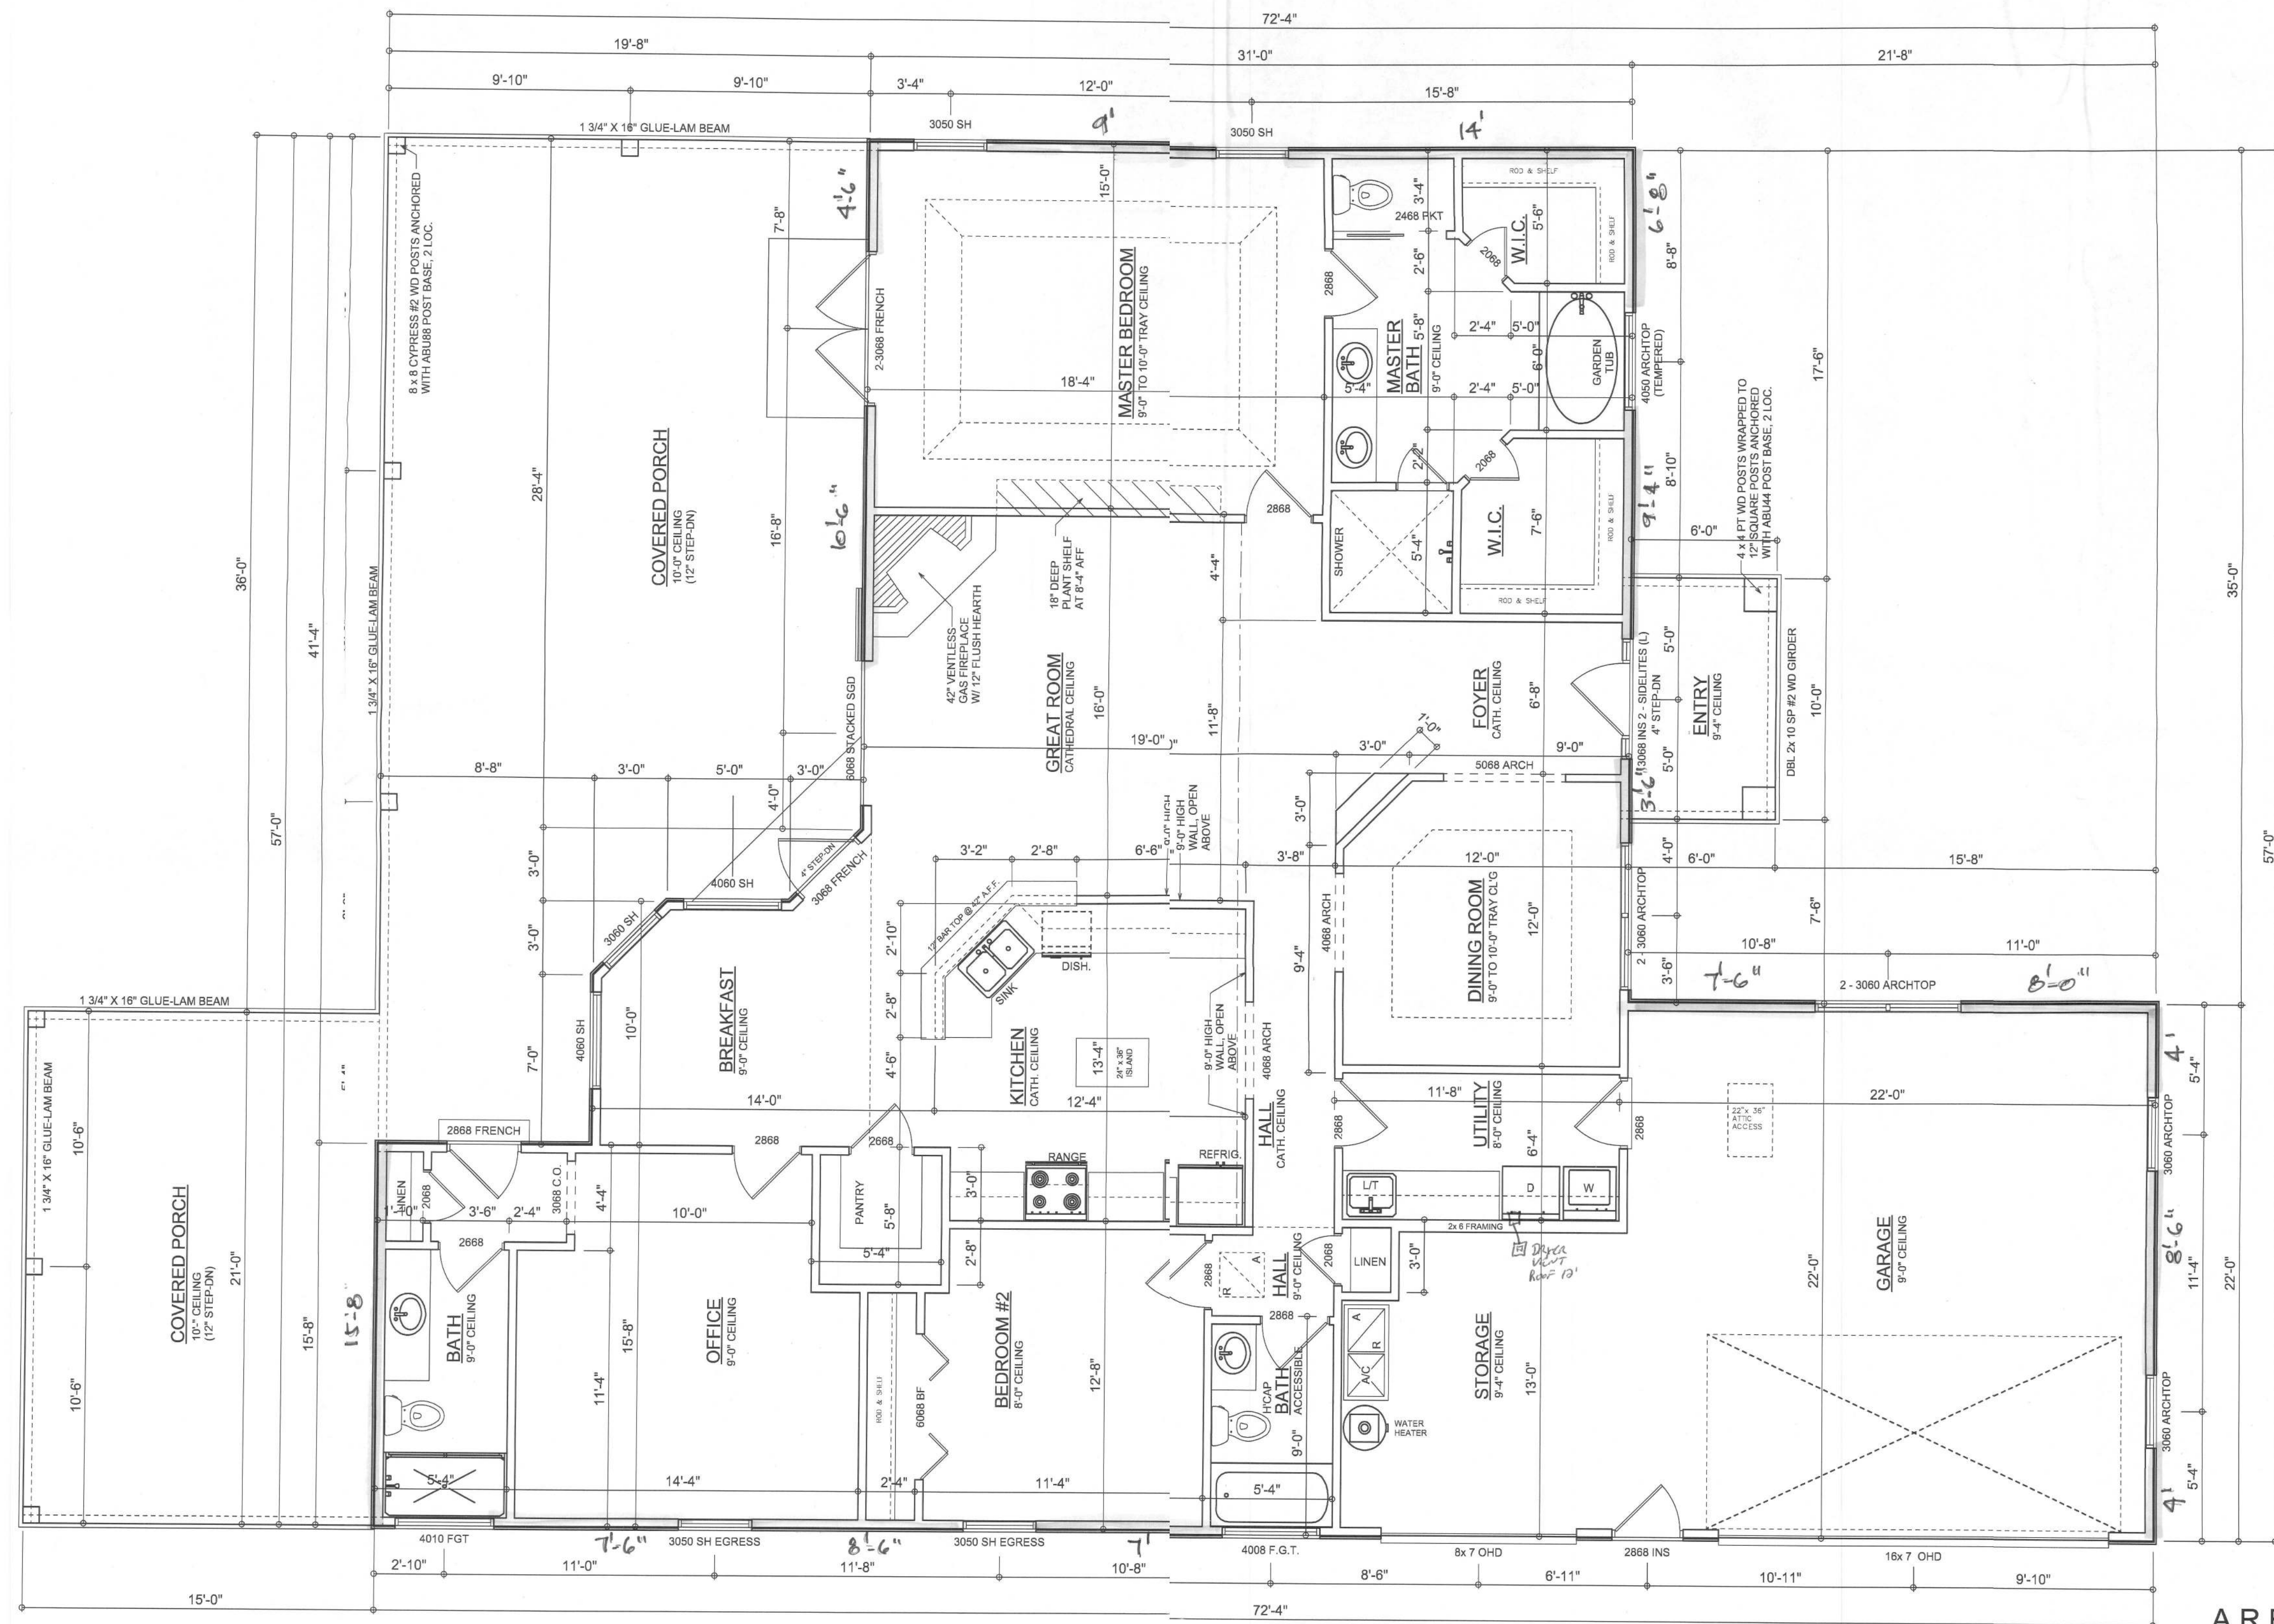

FLOOR PLAN
SCALE: 1/4" = 1'-0"
NOTE: ALL CEILINGS SHALL BE 9'-0" UNLESS OTHERWISE NOTED.

AREA SUMMARY

LIVING AREA	2038	S.F.
GARAGE AREA	624	S.F.
ENTRY PORCH AREA	60	S.F.
COVERED PORCH AREA	999	S.F.
TOTAL AREA	3,721	S.F.

Wm C. Myer


REVISIONS
October 21, 2010

SOFTPLAN
ARCHITECTURAL DESIGN SOFTWARE

FLOOR PLAN
SCALE: 1/4" = 1'-0"

A CUSTOM RESIDENCE FOR:
MEGAN HOLLOWAY
PROJECT ADDRESS: LOT 21, RIVER RISE S/D, COLUMBIA COUNTY FLORIDA


©WILLIAM MYER'S
DESIGN INC.
P.O. BOX 1513
LAKE CITY, FL 32866
(386) 758-8406
will@willmyers.net

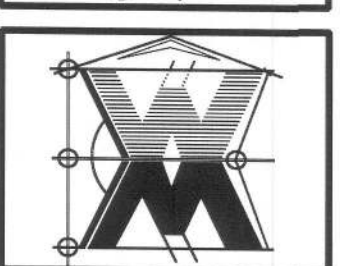

JOB NUMBER
100903

SHEET NUMBER

A.3
OF 4 SHEETS

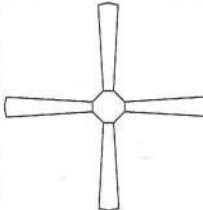
ELECTRICAL LEGEND	
	CEILING FAN (PRE-WIRE FOR LIGHT KIT)
	DOUBLE SECURITY LIGHT
	RECESSED CAN LIGHT
	BATH EXHAUST FAN
	LIGHT FIXTURE
	DUPLEX OUTLET (AFCI & TAMPER RISTANT)
	220v OUTLET
	GFI DUPLEX OUTLET (PER NEC 408.1)
	TELEVISION JACK
	TELEPHONE JACK
	SMOKE / CARBON MONOXIDE DETEOR (see note below)
	WALL SWITCH
	3 WAY WALL SWITCH
	WATER PROOF GFI OUTLET
	
48\" FLOOR	2 OR 4 TUB FLOURESCENT FIXTURE

NOTE:
ALL INTERIOR RECEPTACLES SHALL BE AFCI
(ARC FAULT CIRCUIT INTERRUPT) PER NEC 210.12 & TAMR RESISTANT PER
NEC 408.11

ALL SMOKE DETECTORS BE A COMBO SMOKE & CARBON DNOXIDE DETECTOR
AND SHALL HAVE BATTERY BACKUP POWER
AND ALL WIRED TOGETHER SO IF ANY ONE UNIT IS ACTUED THEY
ALL ACTIVATE.

THE ELECTRICAL SERVICE OVERCURRENT PROTECTION VICE SHALL BE
INSTALLED ON THE EXTERIOR OF STRUCTURES TO SERVAS A DISCONNECT MEANS.
CONDUCTORS USED FROM THE EXTERIOR DISCONNECTS MEANS TO A PANEL OR SUB
PANEL SHALL HAVE FOUR-WIRE CONDUCTORS, OF WHICONE CONDUCTOR
SHALL BE USED AS AN EQUIPMENT GROUND.

IT IS THE LICENSED ELECTRICAL CONTRACTORS RESPONSIBILITY TO INSURE THAT ALL
WORK PERFORMED AND EQUIPMENT INSTALLED MEETS & EXCEEDS THE 2008 NATIONAL
ELECTRIC CODE AND ALL OTHER LOCAL CODES AND ORBANCES.

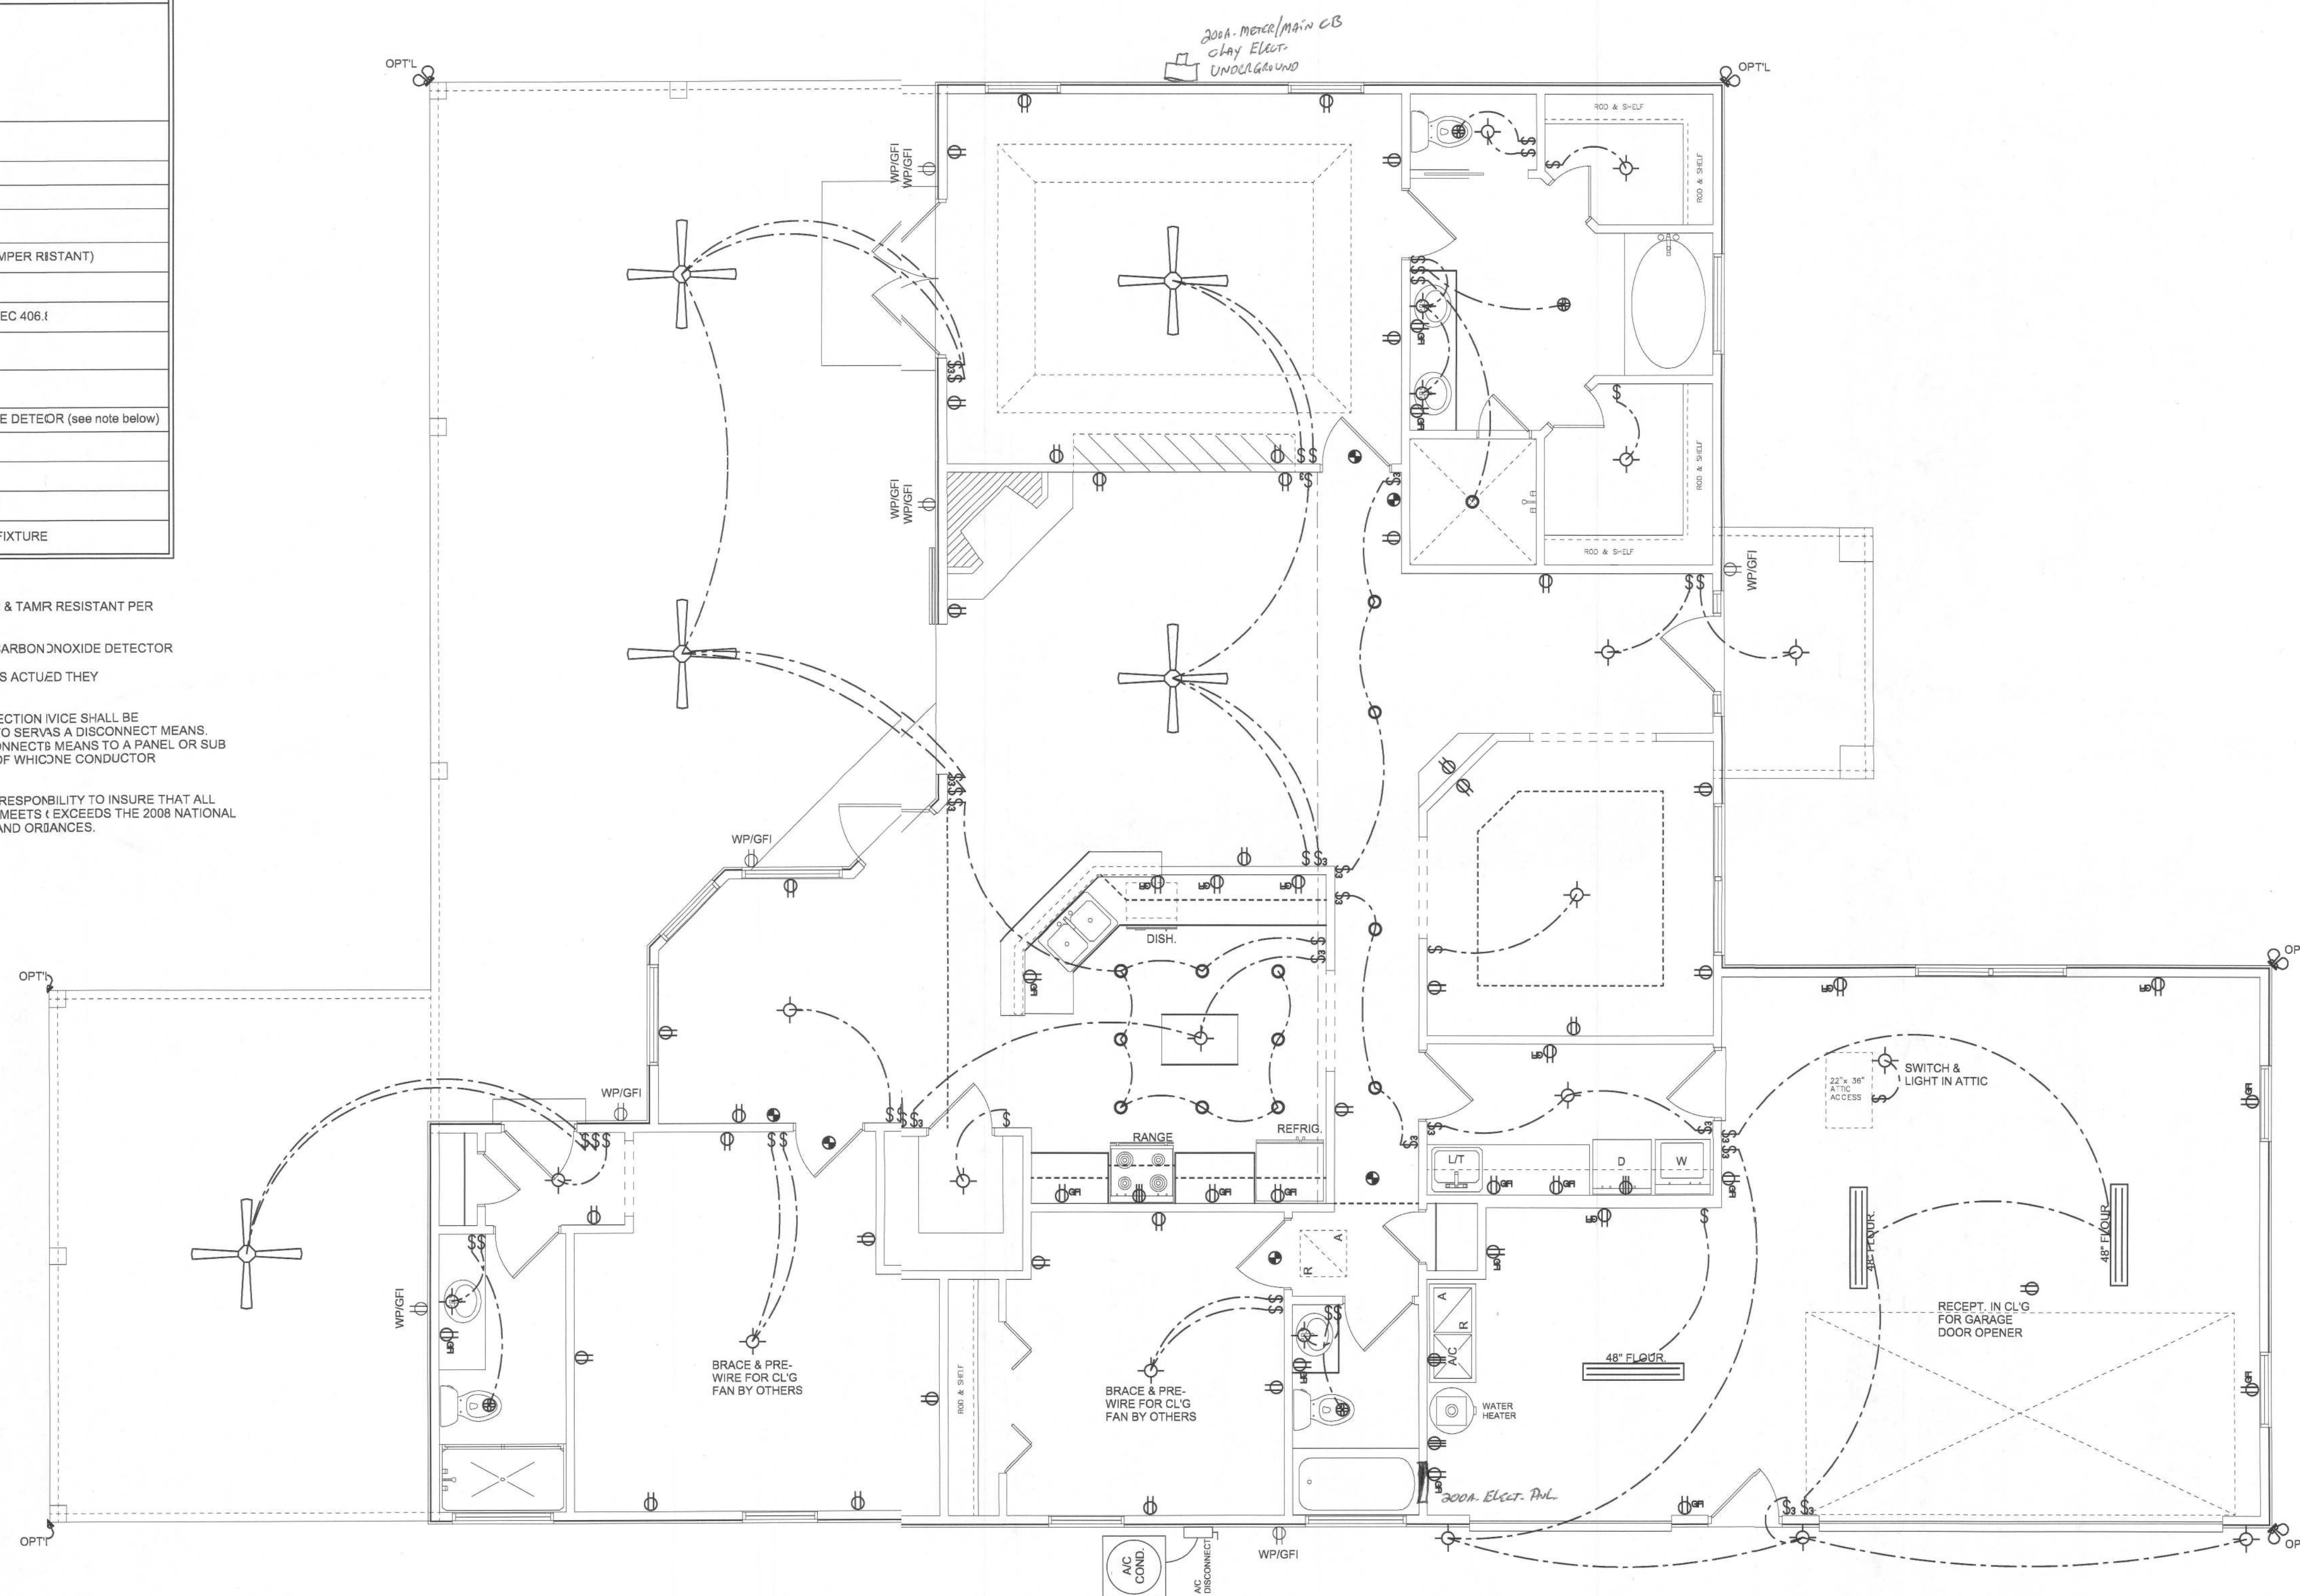

ELECTRICAL PLAN
SCALE: 1/4" = 1'-0"


REVISIONS
October 21, 2010

SOFTPLAN
ARCHITECTURAL DESIGN SOFTWARE

ELECTRICAL PLAN
SCALE: 1/4" = 1'-0"

A CUSTOM RESIDENCE FOR:
MEGAN HOLLOWAY
PROJECT ADDRESS: LOT 21, RIVER RISE S/D, COLUMBIA COUNTY FLORIDA

©WILLIAMMYERS
DESIGN INC.
P.O. BOX 1513
LAKE CITY, FL 32056
(386) 751-8406
will@willmymers.net

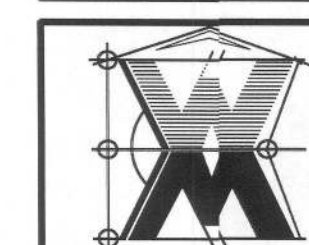

JOB NUMBER
100903

SHEET NUMBER

A.4
OF 4 SHEETS

Wm Myers