


A CUSTOM HOME FOR:

CHARLES & DORIS BUTTON

PROJECT ADDRESS:
1687 NW QUEEN RD
LAKE CITY, FLORIDA 32055
(COLUMBIA COUNTY)

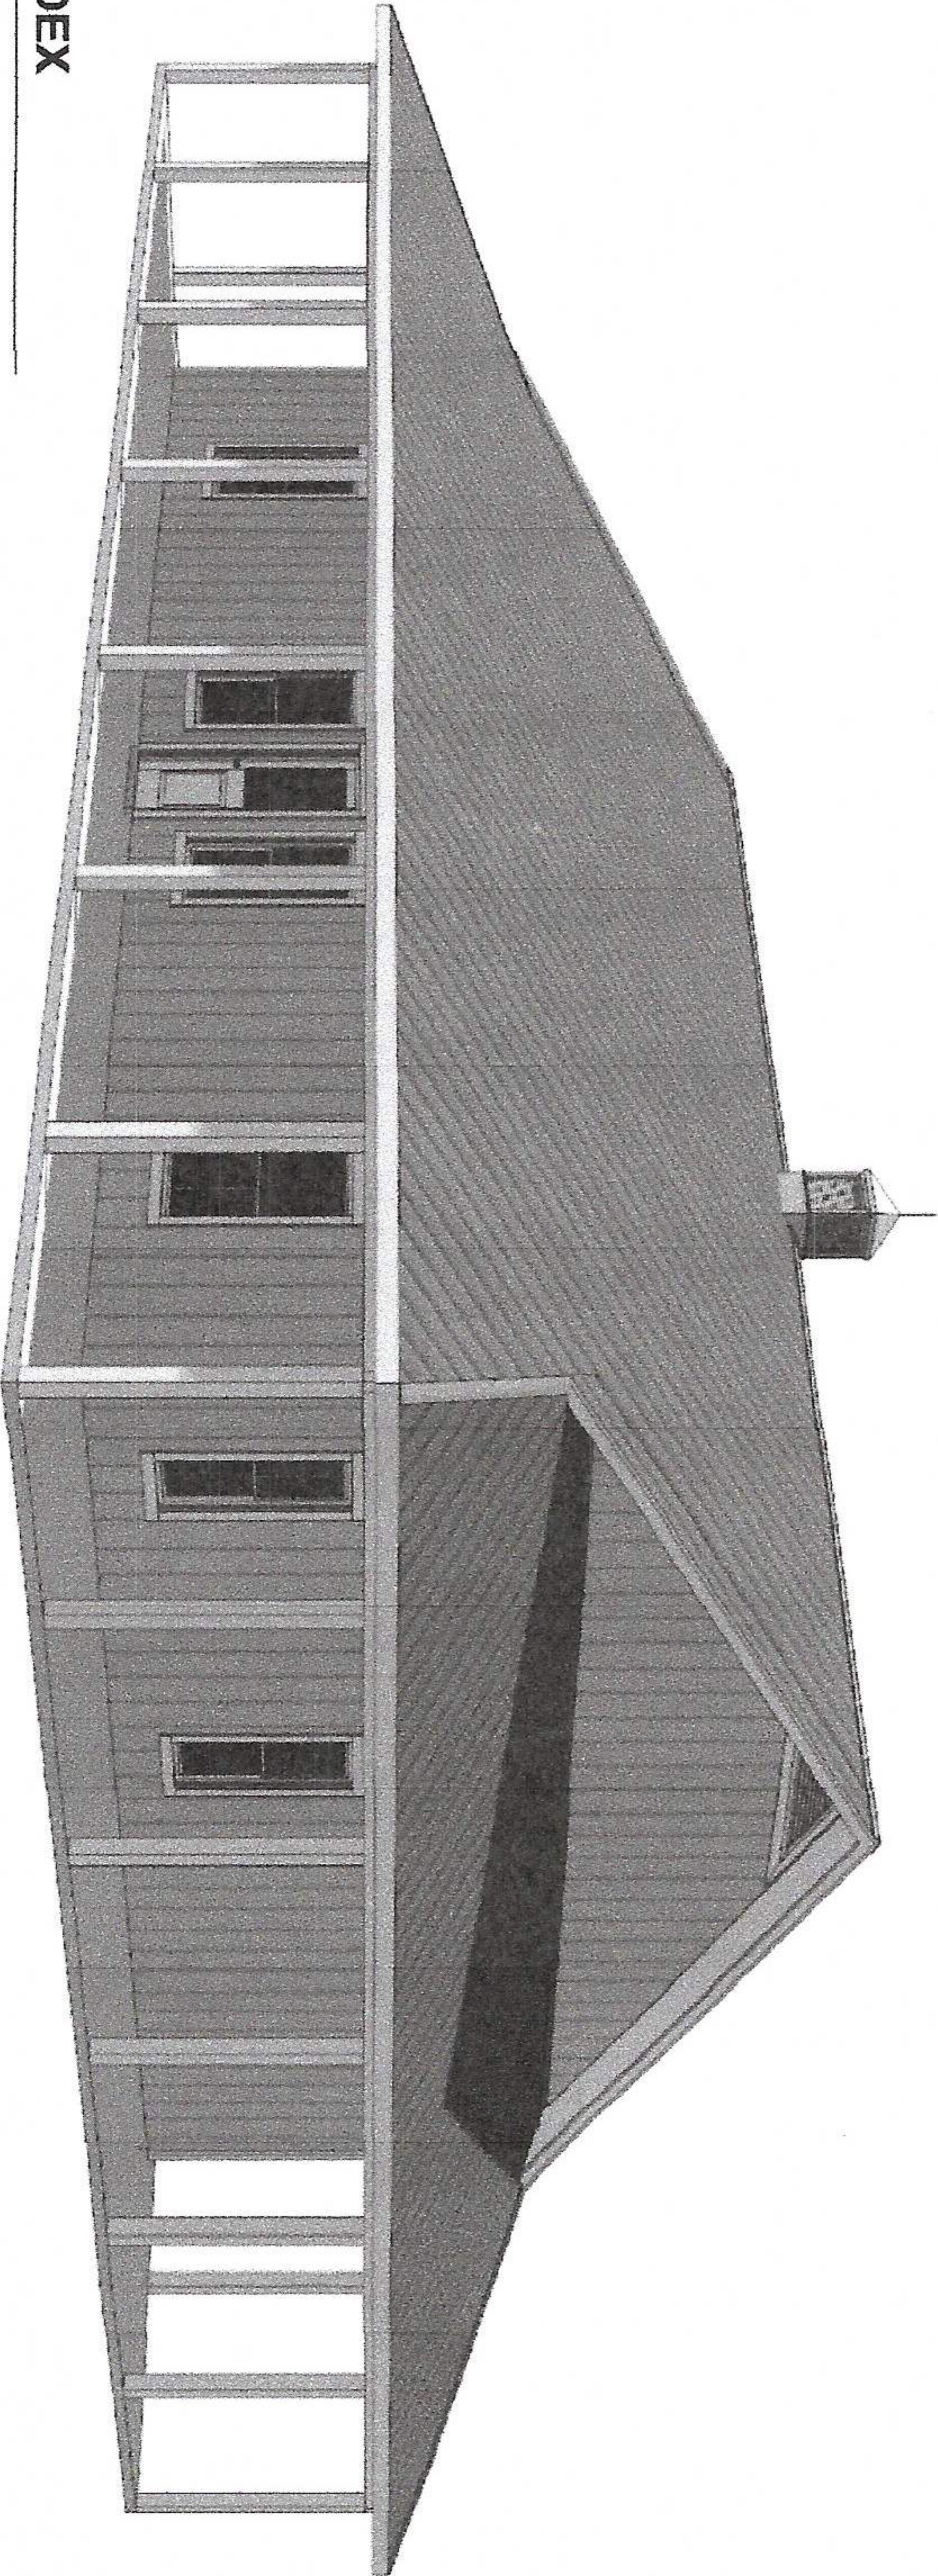

SHEET INDEX




- A1 EXTERIOR ELEVATIONS
- A2 DIMENSIONED FLOOR PLAN

NOTE: ALL DRAWINGS NOT TO BE SCALED. WRITTEN DIMENSIONS TAKE PRECEDENCE OVER SCALED DIMENSIONS

AREA SUMMARY			
LIVING AREA	1,800	S.F.	
COVERED PORCH AREA	1,632	S.F.	
TOTAL AREA	3,432	S.F.	

WML C-777D


REVISIONS <table><tr><td>August 21, 2020</td></tr><tr><td> </td></tr><tr><td> </td></tr><tr><td> </td></tr><tr><td> </td></tr></table>	August 21, 2020					COVER PAGE	A CUSTOM HOME DESIGN FOR: CHARLES & DORIS BUTTON PROJECT ADDRESS: 1687 NW QUEEN RD, LAKE CITY, FLORIDA 32055	© WML DESIGN ASSOCIATES, INC. 4240 W. WILSON AVE., SUITE 100 LAKE CITY, FLORIDA 32055 (386) 738-8406 www.wml-design.com		JOB NUMBER 20200814	SHEET NUMBER COVER
August 21, 2020											

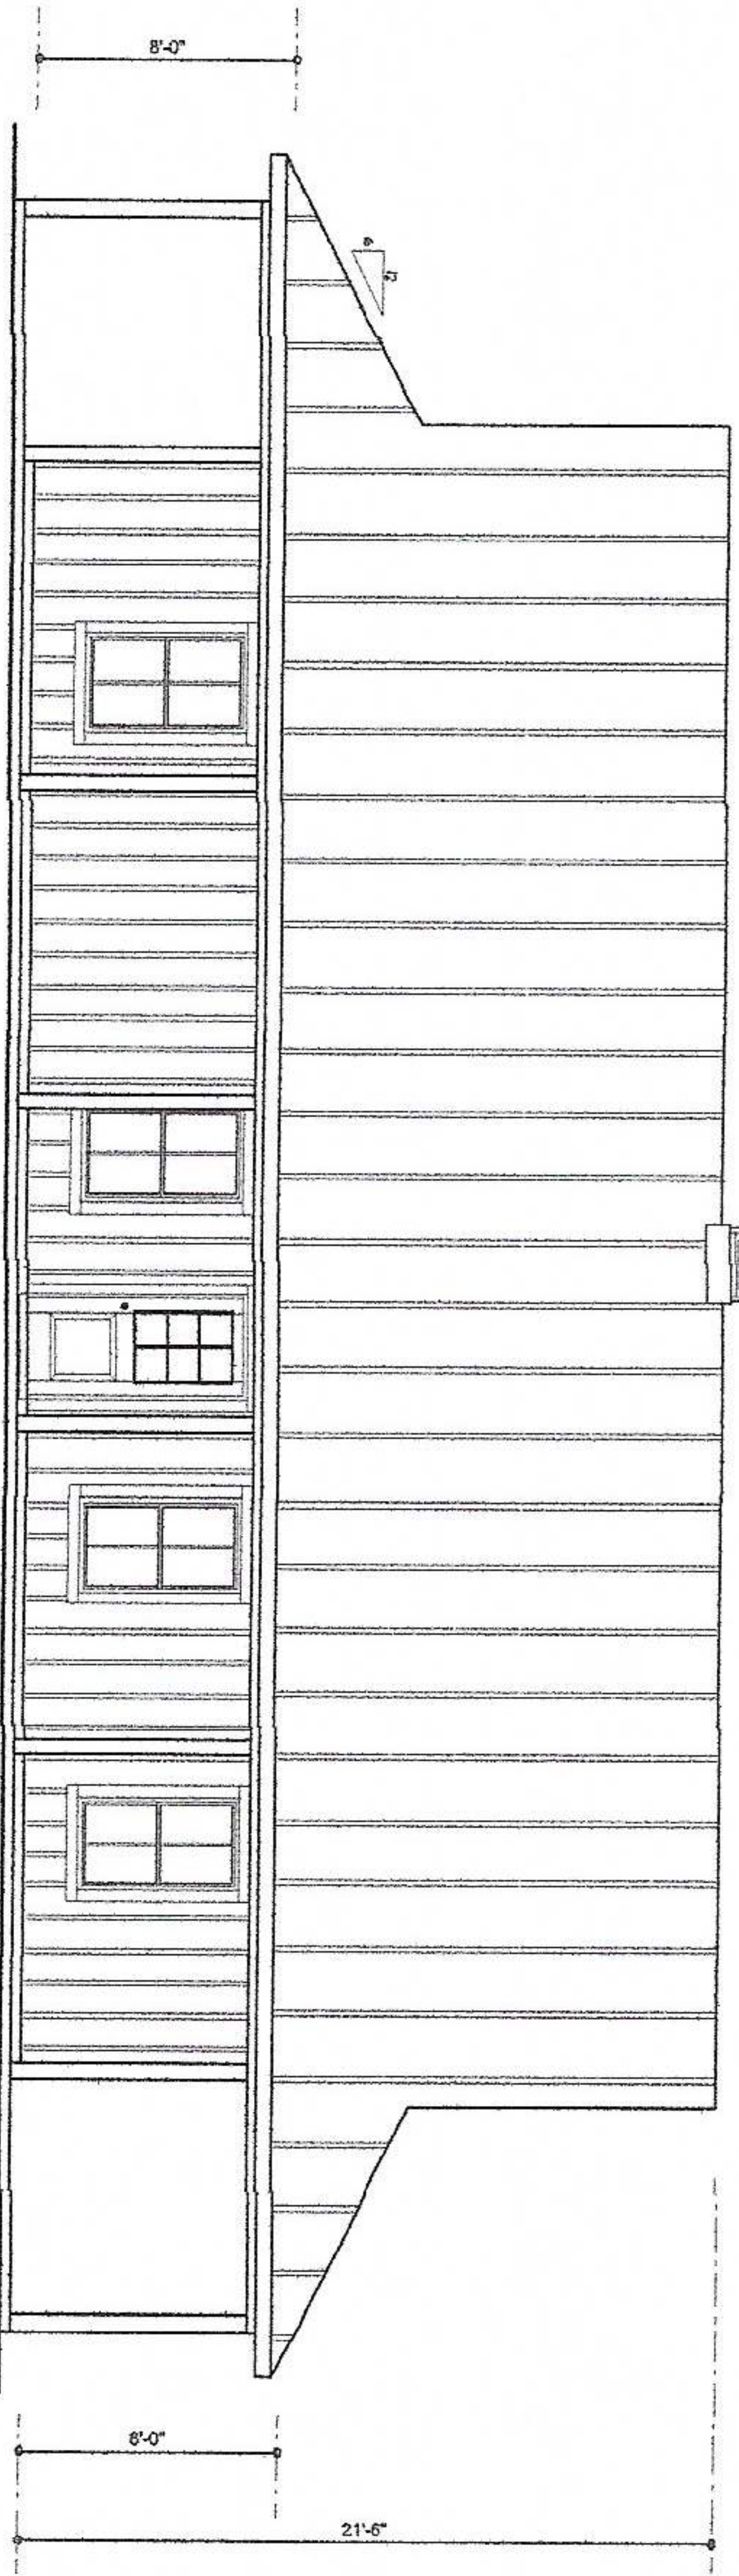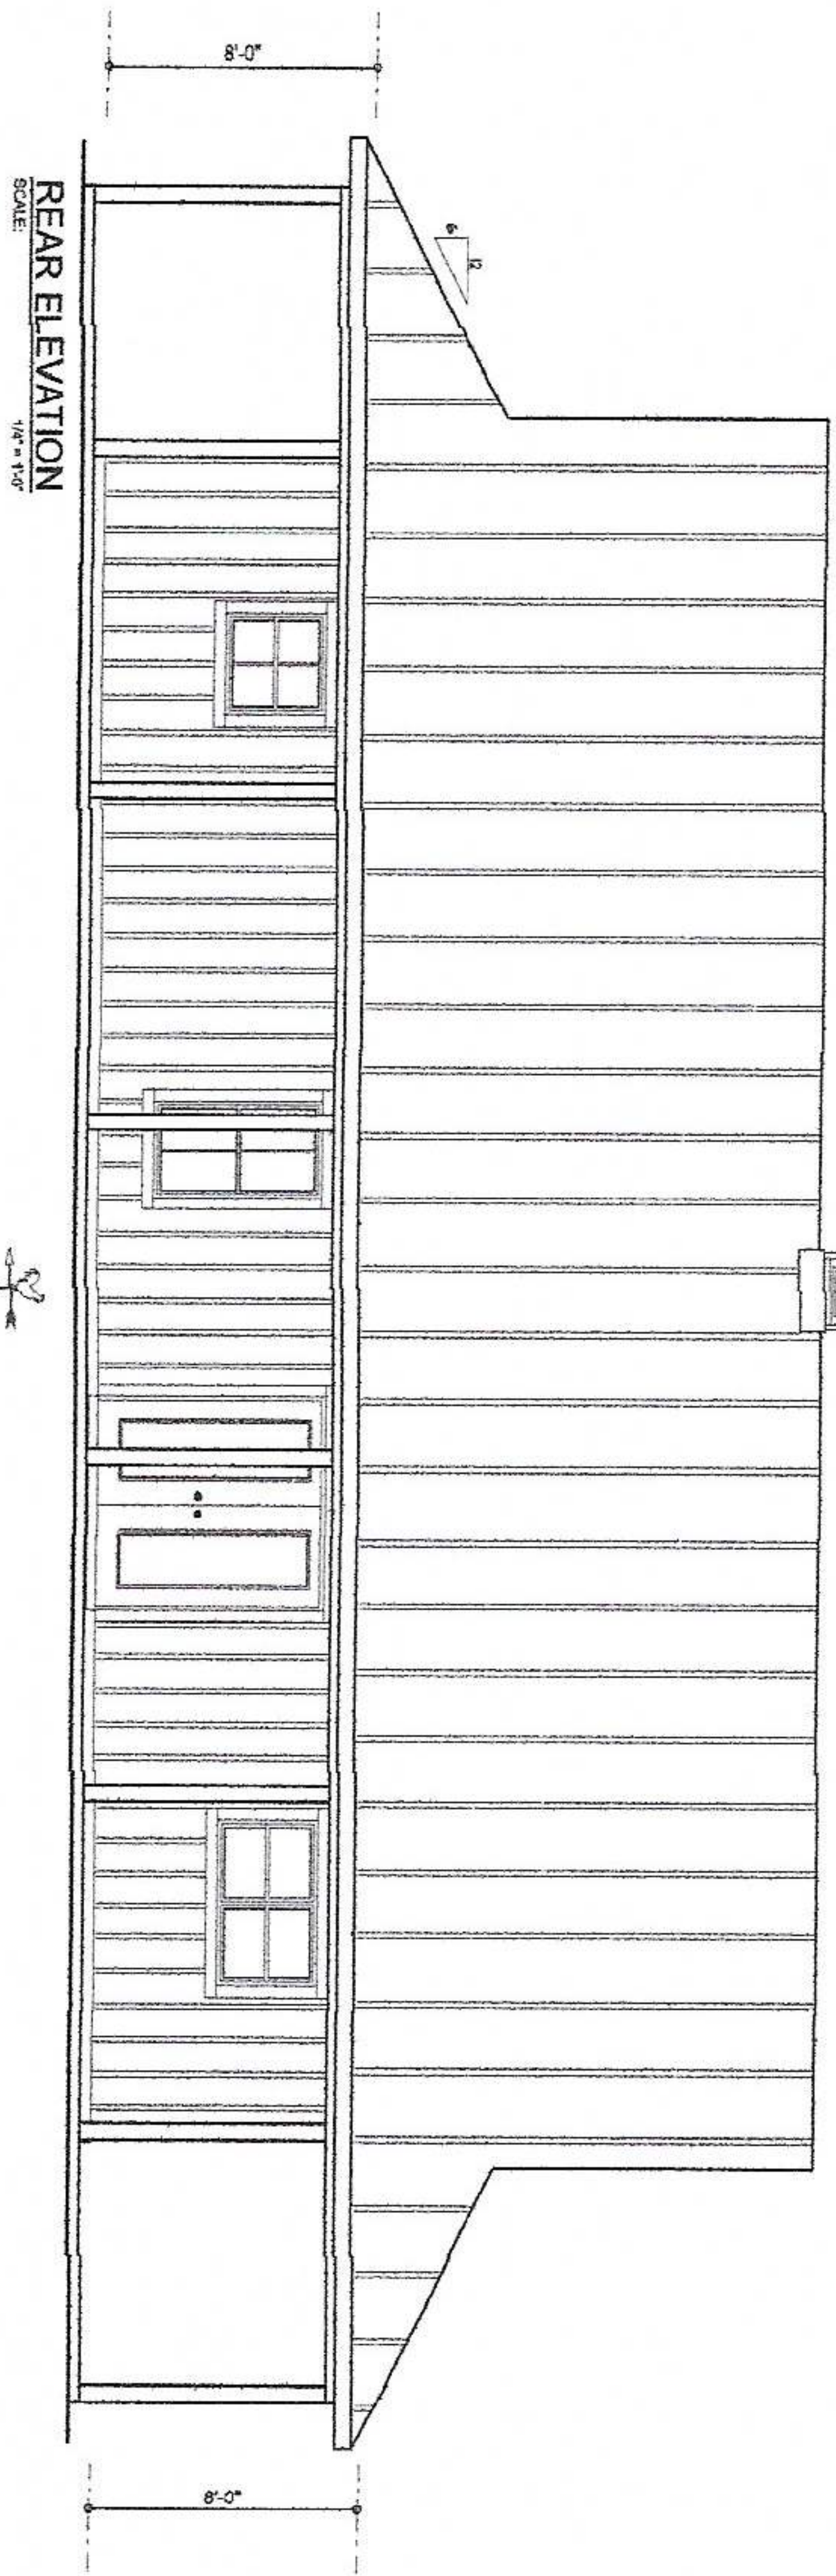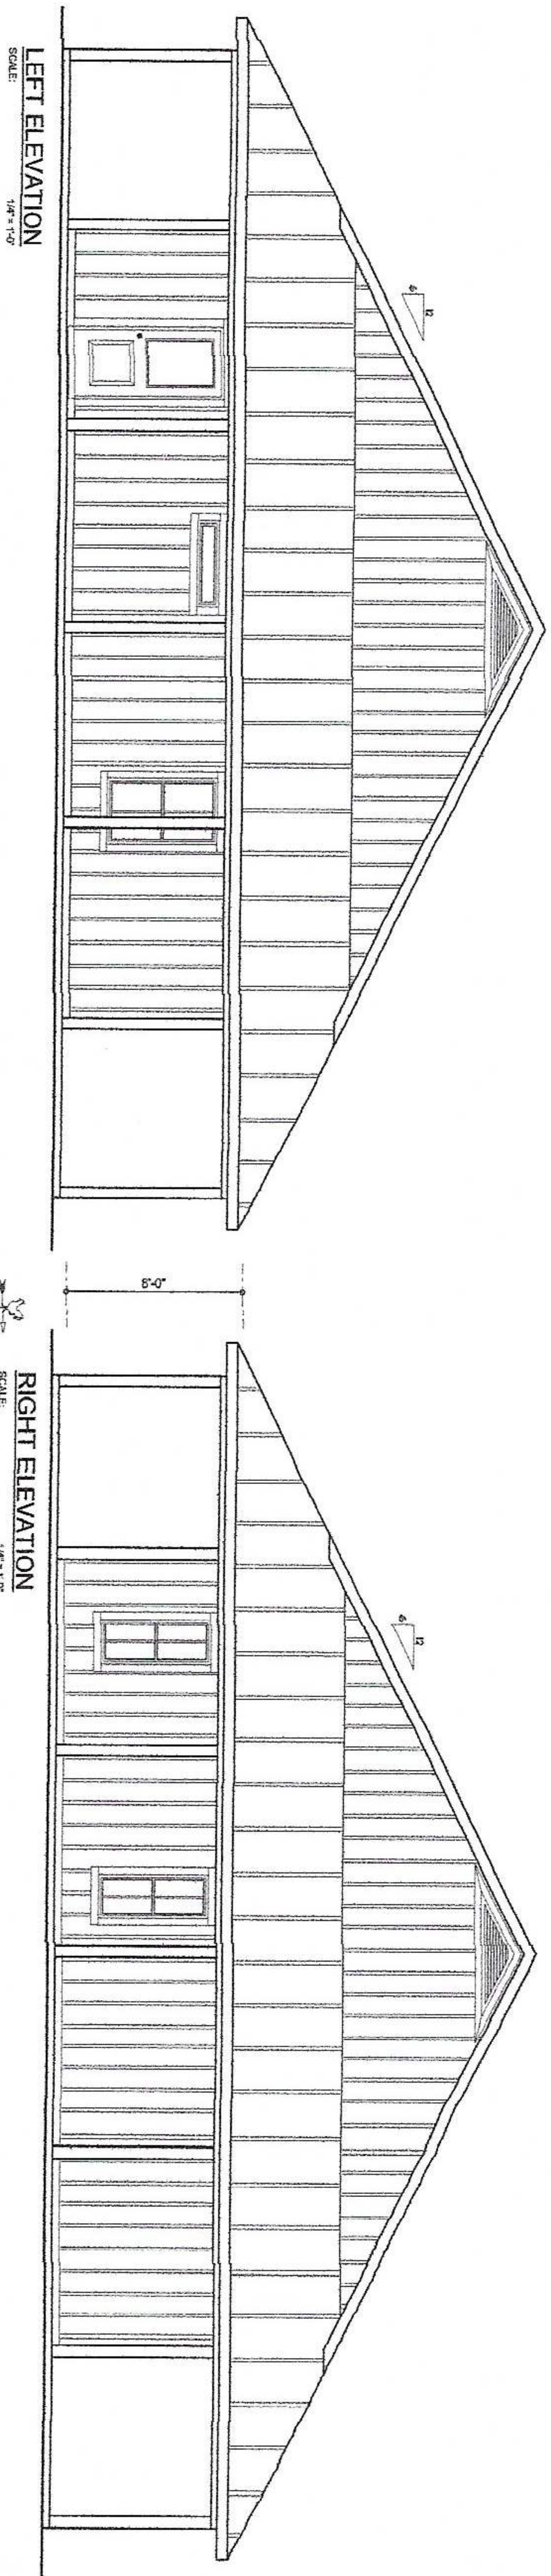

NOTE: ALL DRAWINGS NOT TO BE SCALED. WRITTEN DIMENSIONS TAKE PRECEDENCE OVER SCALED DIMENSIONS

WMC-777

	JOB NUMBER 20200814	© WMC, INC. & ASSOCIATES, INC. 3415 NW 15th Ave, Suite 100 Lake City, FL 32055 (386) 758-8108 www.wmcinc.com	A CUSTOM HOME DESIGN FOR: CHARLES & DORIS BUTTON PROJECT ADDRESS: 1687 NW QUEEN RD, LAKE CITY, FLORIDA 32055	EXTERIOR ELEVATIONS SCALE: 1/4" = 1'-0"	<table border="1"> <tr> <th>REVISIONS</th> </tr> <tr> <td>October 13, 2020</td> </tr> <tr> <td> </td> </tr> <tr> <td> </td> </tr> <tr> <td> </td> </tr> </table>	REVISIONS	October 13, 2020			
	REVISIONS									
October 13, 2020										
SHEET NUMBER A.1										

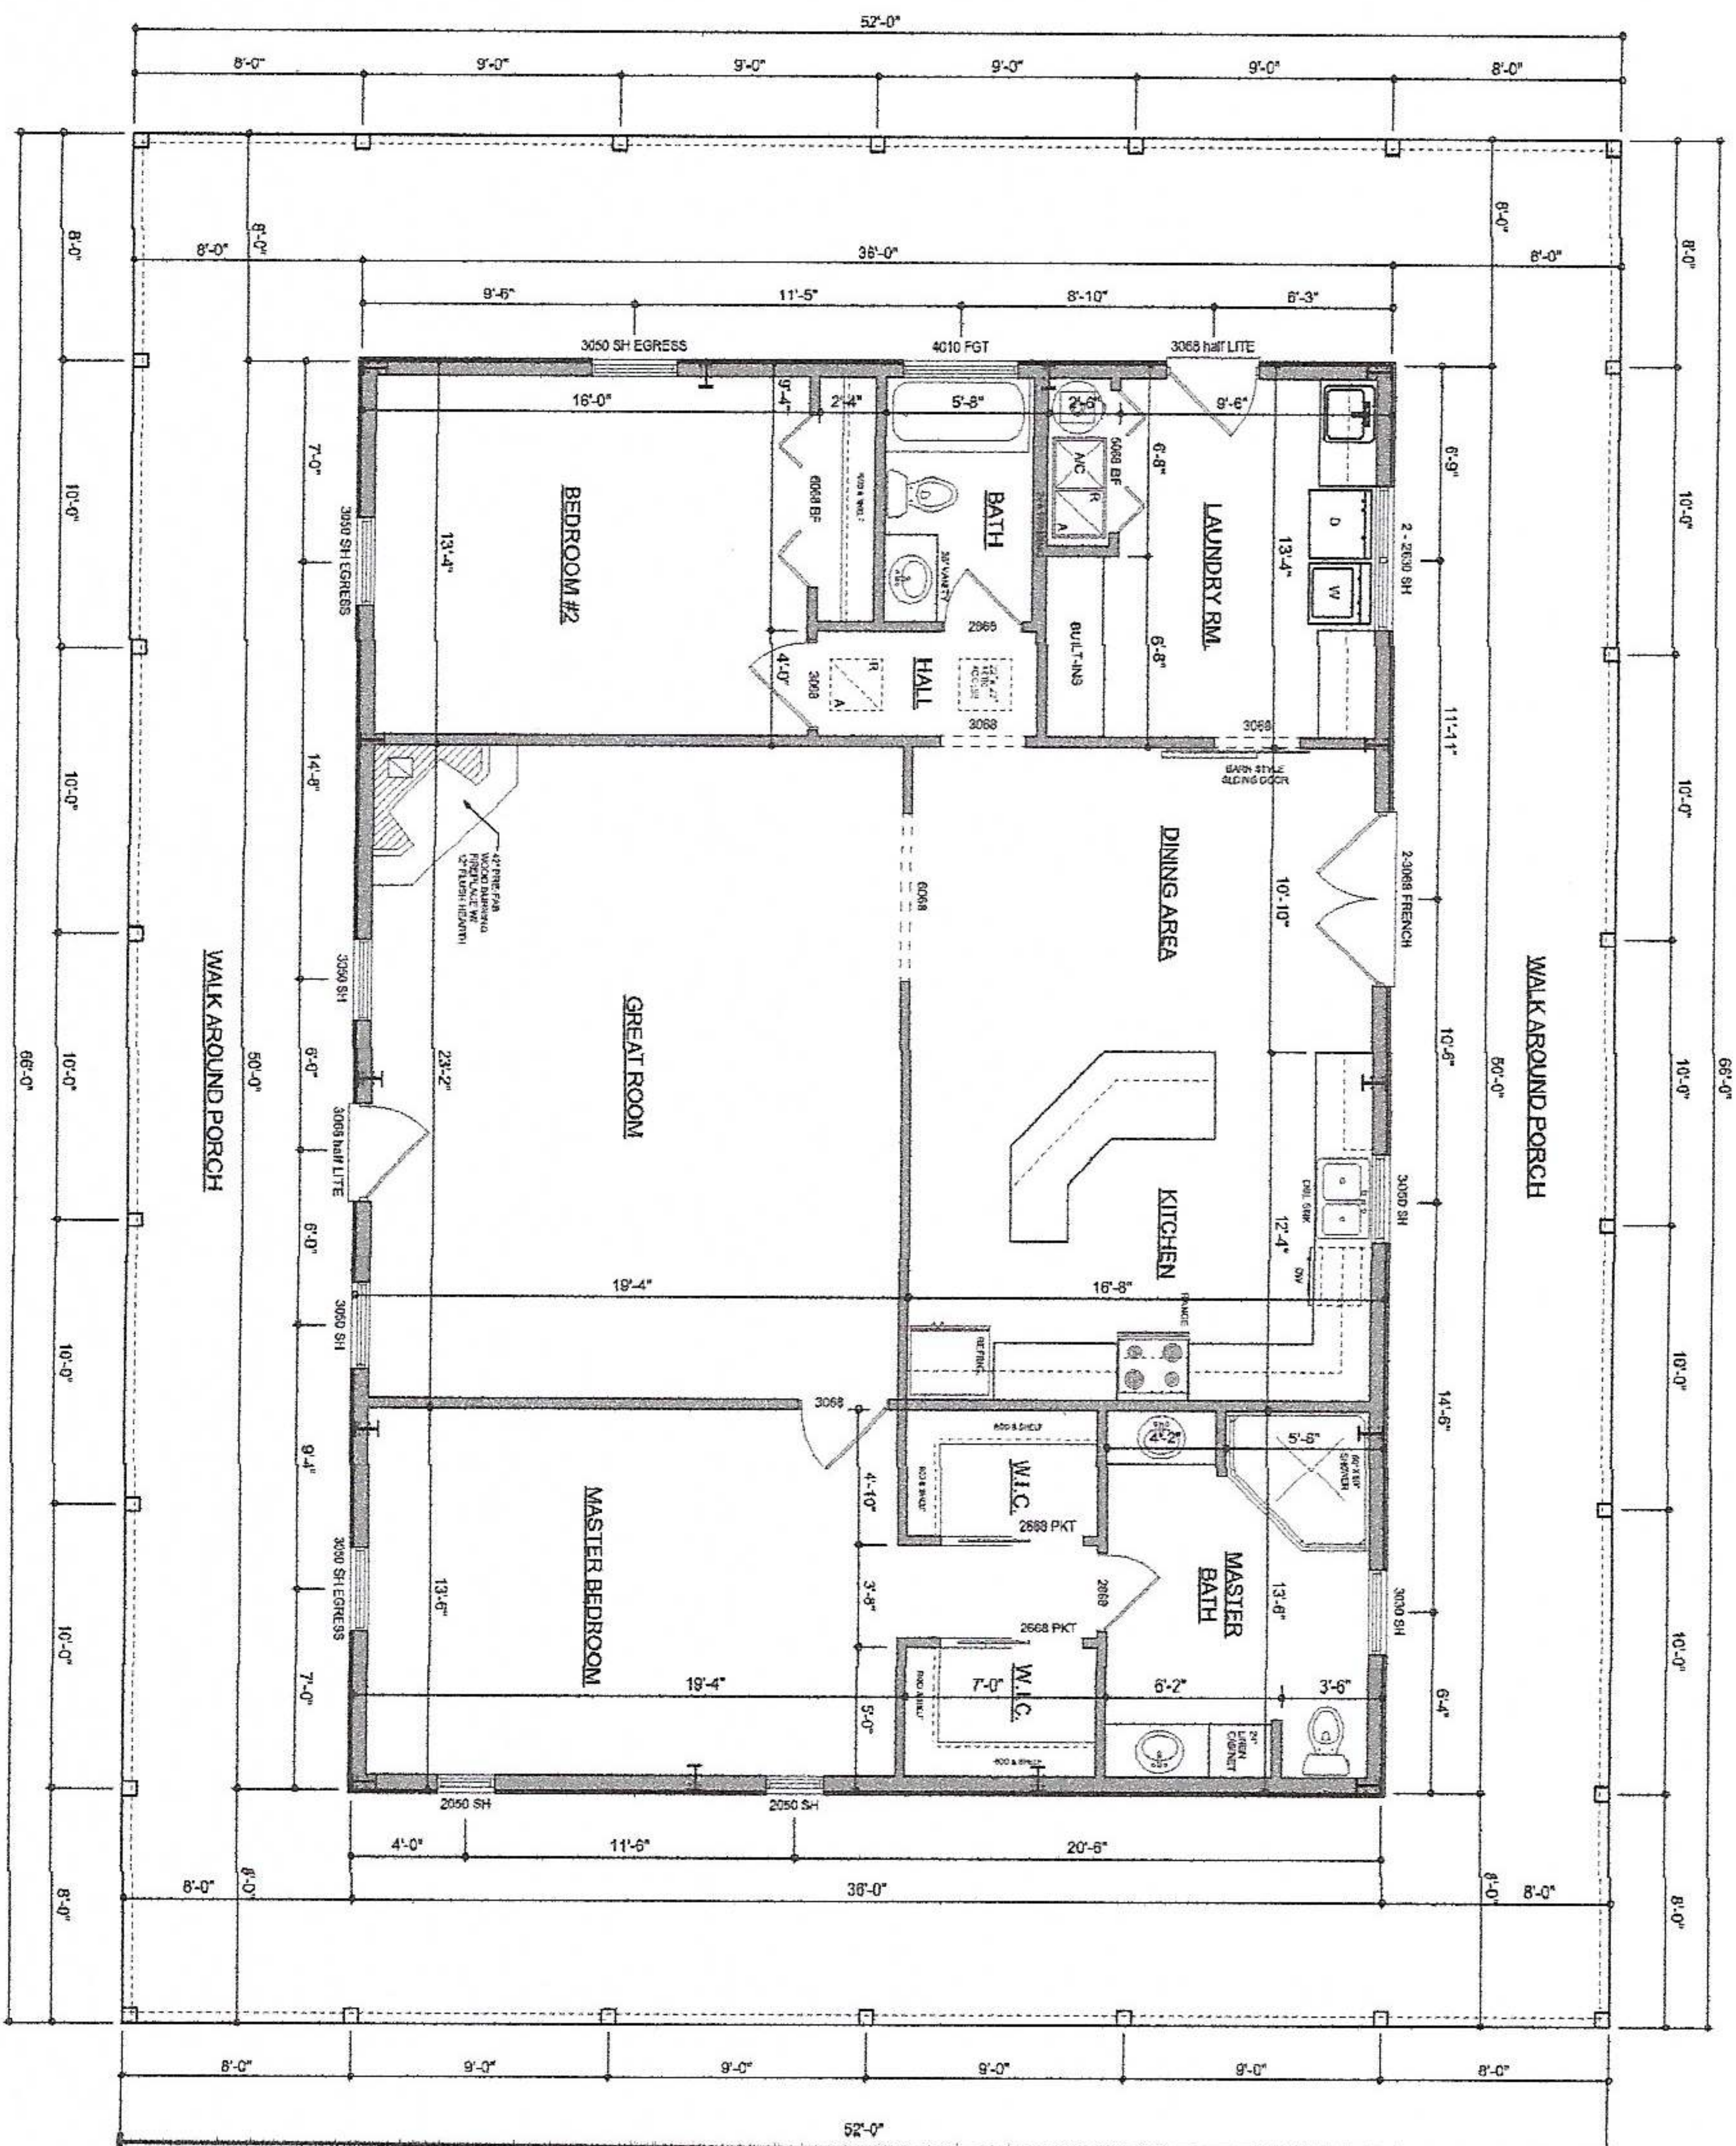

NOTE: ALL DRAWINGS NOT TO BE SCALED, WRITTEN DIMENSIONS TAKE PRECEDENCE OVER SCALED DIMENSIONS

AREA SUMMARY	
LIVING AREA	1,800 S.F.
COVERED PORCH AREA	1,632 S.F.
TOTAL AREA	3,432 S.F.

Ball C-777

SHEET NUMBER A.2	JOB NUMBER 20200814		© WARDSON & ASSOCIATES, INC. 4401 NW CHAMBERLAIN BLVD. (N) SUITE 100 (954) 758-8405 wardson@k-n.com	A CUSTOM HOME DESIGN FOR: CHARLES & DORIS BUTTON PROJECT ADDRESS: 1687 NW QUEEN RD, LAKE CITY, FLORIDA 32055	DIMENSIONED FLOOR PLAN SCALE: 1/4" = 1'-0"	SOFTPLAN SOFTWARE	REVISIONS October 13, 2020 <table border="1" style="width: 100%; border-collapse: collapse; margin-top: 5px;"> <tr><td style="height: 20px;"> </td></tr> <tr><td style="height: 20px;"> </td></tr> <tr><td style="height: 20px;"> </td></tr> <tr><td style="height: 20px;"> </td></tr> </table>				


ELECTRICAL LEGEND	
	CEILING FAN PRE-WIRE FOR LIGHT KIT
	DOUBLE SECURITY DOOR LOCK
	RECESSED CAN LIGHT
	NIGHT EXHAUST FAN
	LIGHT FIXTURE
	DUPLEX OUTLET (N.E.C. & TAMPER RESISTANT)
	220V OUTLET
	GFI DUPLEX OUTLET (PER N.E.C. 408.8)
	TELEPHONE JACK
	TELEPHONE JACK
	SMOKE (IONIZATION) DETECTOR (PER N.E.C. 760.14)
	3 WAY WALL SWITCH
	WATER PROOF GFI OUTLET
	2 OR 4 TUB FLUORESCENT FIXTURE

NOTE: ALL INTERIOR RECEPTACLES SHALL BE AFI (AFI) FAULT CIRCUIT INTERRUPTER (PER N.E.C. 210.12 & TAMPER RESISTANT PER N.E.C. 408.11)

ALL SMOKE DETECTORS ARE A COMBO SMOKE & CARBON MONOXIDE DETECTOR AND ALL WIRING TOGETHER SO IF ANY ONE UNIT IS ACTIVATED THEY ALL ACTIVATE.

THE ELECTRICAL SERVICE OVERCURRENT PROTECTION DEVICE SHALL BE INSTALLED ON THE EXTERIOR OF THE STRUCTURE TO SERVE AS A DISCONNECT MEANS. THE SERVICE SHALL BE INSTALLED IN AN EASILY ACCESSIBLE LOCATION. THE SERVICE SHALL HAVE FOUR WIRE CONDUCTORS, OF WHICH ONE CONDUCTOR SHALL BE USED AS AN EQUIPMENT GROUND.

IT IS THE LICENSED ELECTRICAL CONTRACTOR'S RESPONSIBILITY TO INSURE THAT ALL WORK PERFORMED AND EQUIPMENT INSTALLED MEETS OR EXCEEDS THE N.E.C. & NATIONAL ELECTRICAL CODE AND ALL OTHER LOCAL CODES AND ORDINANCES.

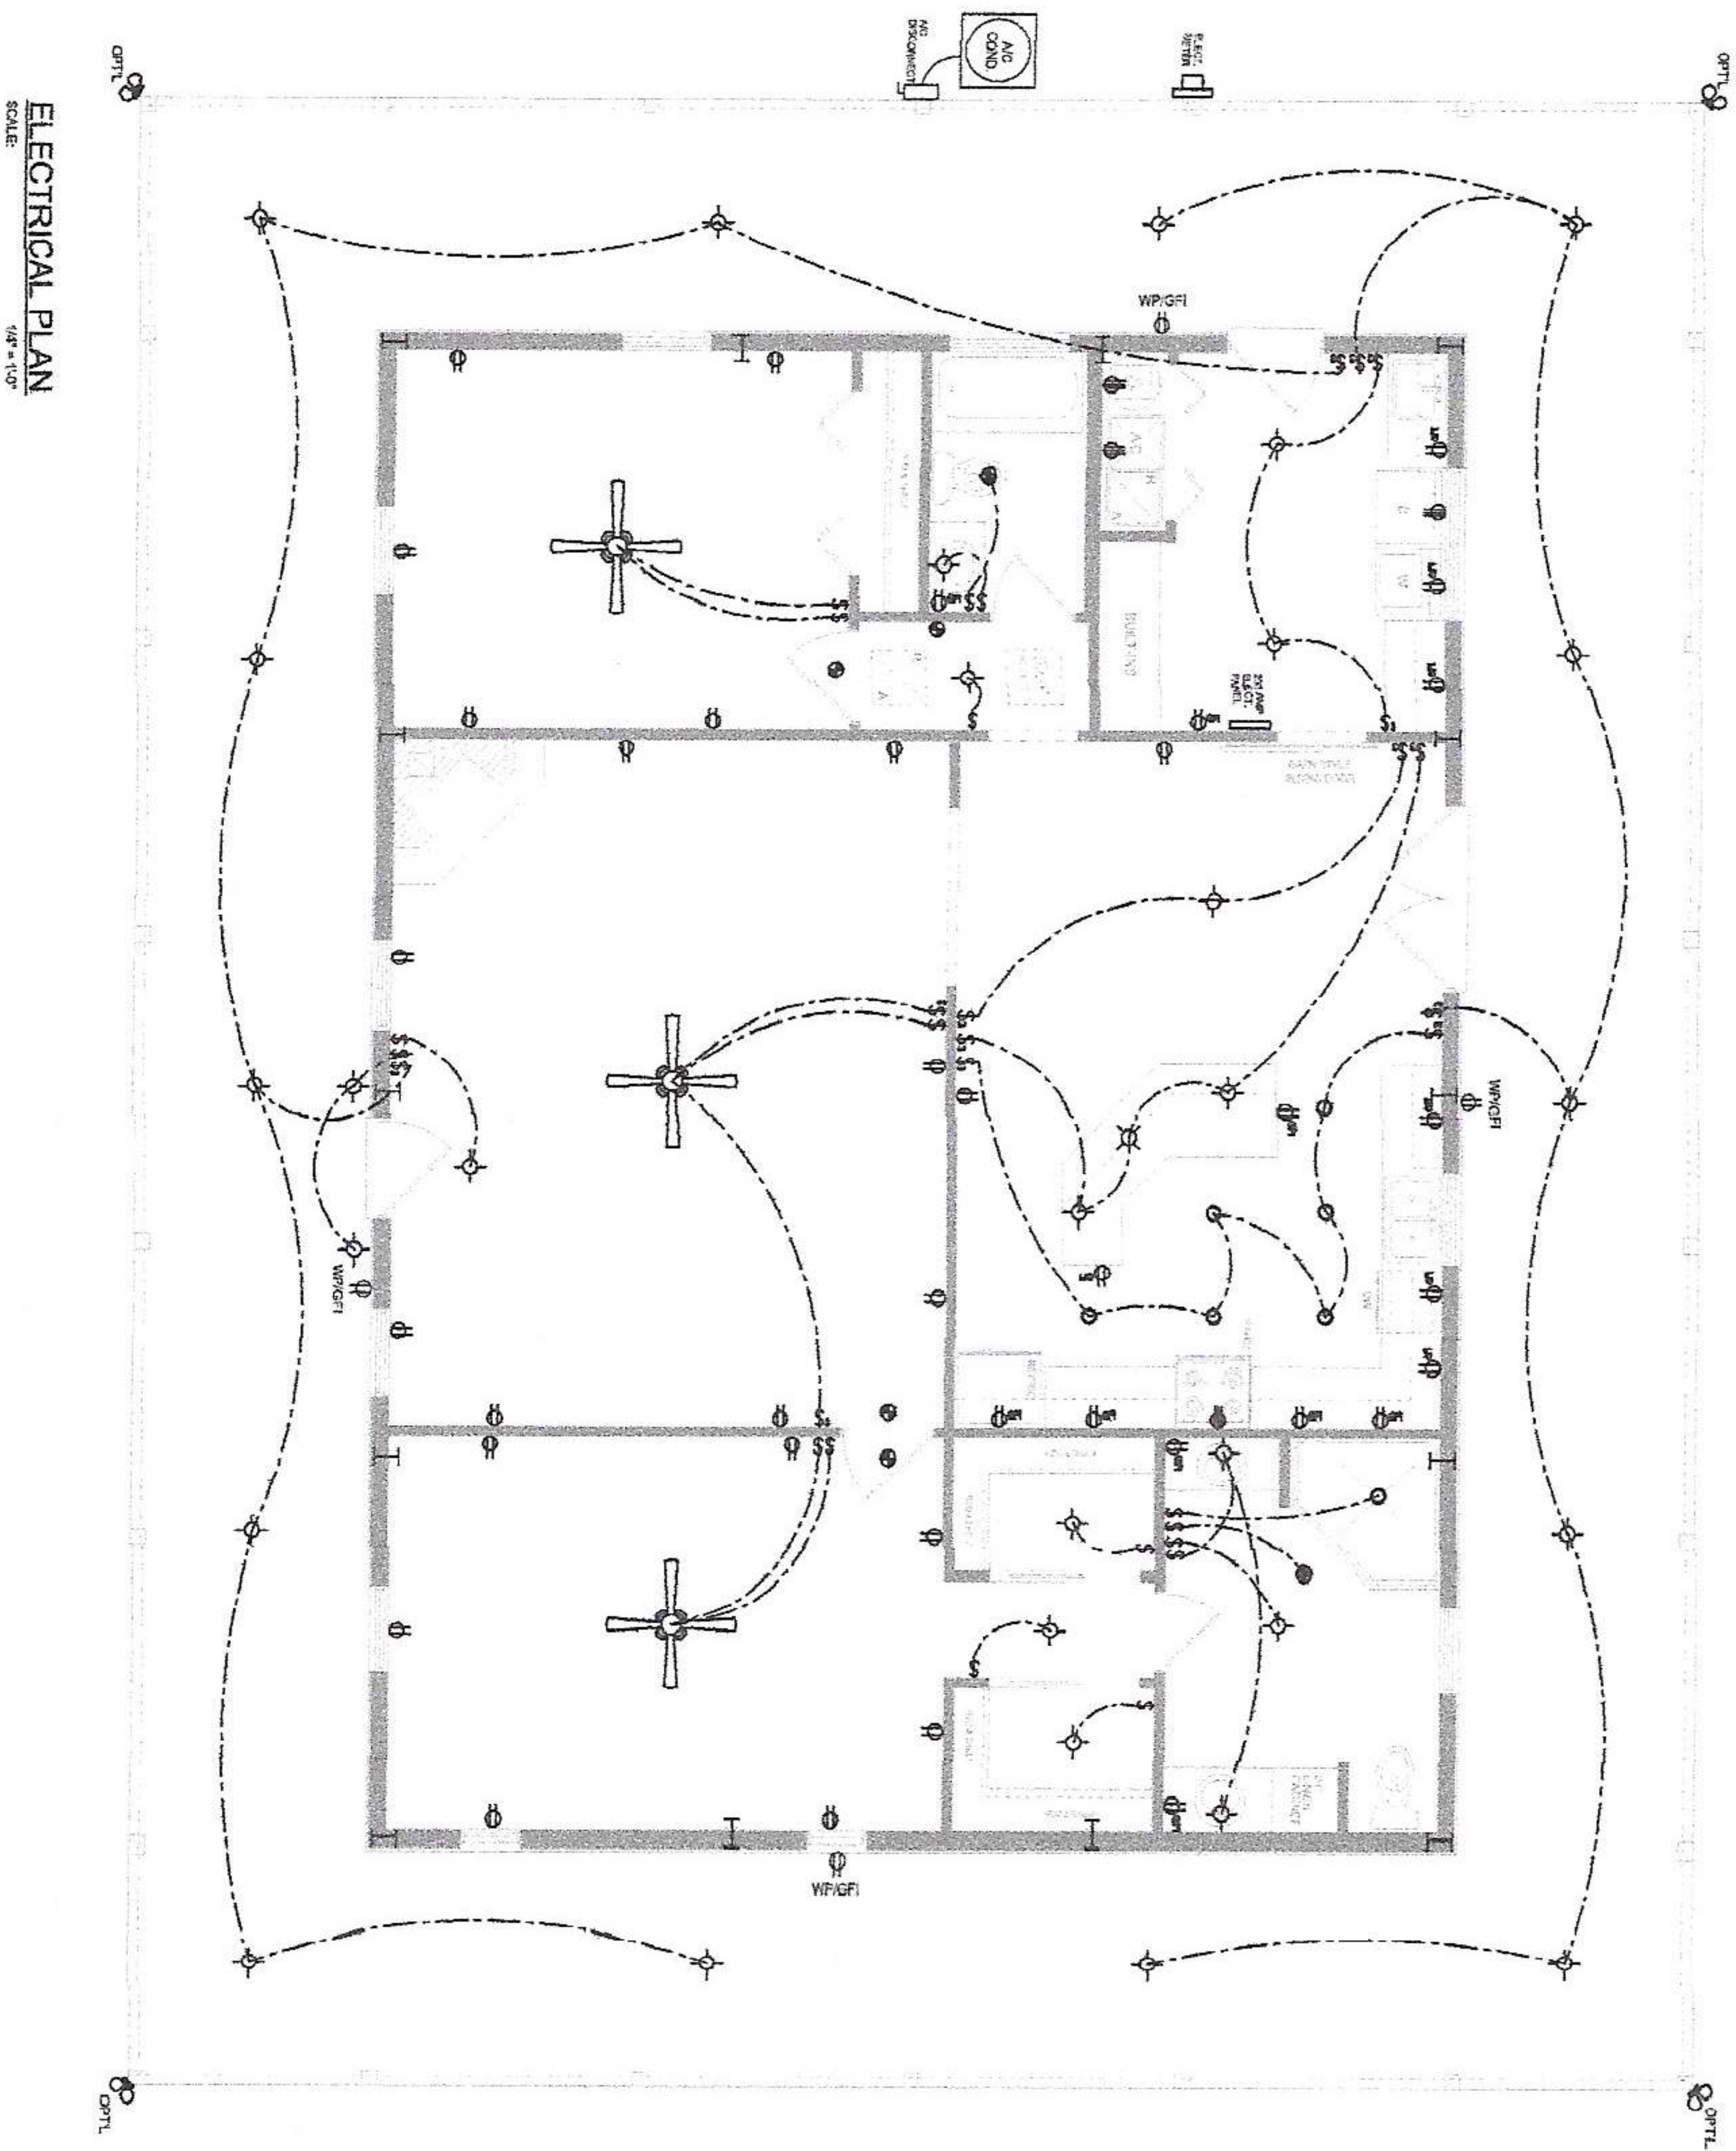

NOTE: ALL DRAWINGS NOT TO BE SCALED. WRITTEN DIMENSIONS TAKE PRECEDENCE OVER SCALED DIMENSIONS

WALC 7/10/20

	© W. J. McLEAN & ASSOCIATES, INC. 405 NW CHANDLER BLVD. STE. 200 LAKE CITY, FL 32825 (386) 758-5406 www.wjmclean.com	A CUSTOM HOME DESIGN FOR: CHARLES & DORIS BUTTON PROJECT ADDRESS: 1687 NW QUEEN RD, LAKE CITY, FLORIDA 32055	ELECTRICAL PLAN SCALE: 1/4" = 1'-0"	<table><tr><th colspan="2">REVISIONS</th></tr><tr><td></td><td>October 13, 2020</td></tr><tr><td></td><td></td></tr><tr><td></td><td></td></tr><tr><td></td><td></td></tr><tr><td></td><td></td></tr></table>	REVISIONS			October 13, 2020								
REVISIONS																
	October 13, 2020															
SHEET NUMBER A.3	JOB NUMBER 20200814															



32" X 32" X 16" DEEP CONCRETE PIER FOOTING.
REINFORCED WITH (4) #5 REBAR EACH WAY TOP AND BOTTOM.
TOP OF FOOTING SHALL BE 4" MIN. BELOW GRADE LEVEL.

[illegible]

REVISIONS
October 13, 2020

SOFTPLAN
ARCHITECTURAL DESIGN SYSTEM
WILL C. FAY

A NEW CUSTOM HOME FOR:
CHARLES & DORIS BUTTON
PROJECT ADDRESS: 1687 NW QUEEN RD, LAKE CITY, FLORIDA 32055

AR0007005

N3
NICHOLAS
PAUL
GEISLER
ARCHITECT
N.C.A.R.S. Certified

■ 1758 NW Brown Rd.
■ Lake City, FL 32055
■ (386) 305-4355

© WM DESIGN &
ASSOCIATES INC.
428 SW COMMERCE DR. STE 110
LAKE CITY, FL 32725
(386) 758-8406
with a letter to me!



JOB NUMBER
20200814

DATE:
October 13, 2020

SHEET NUMBER