



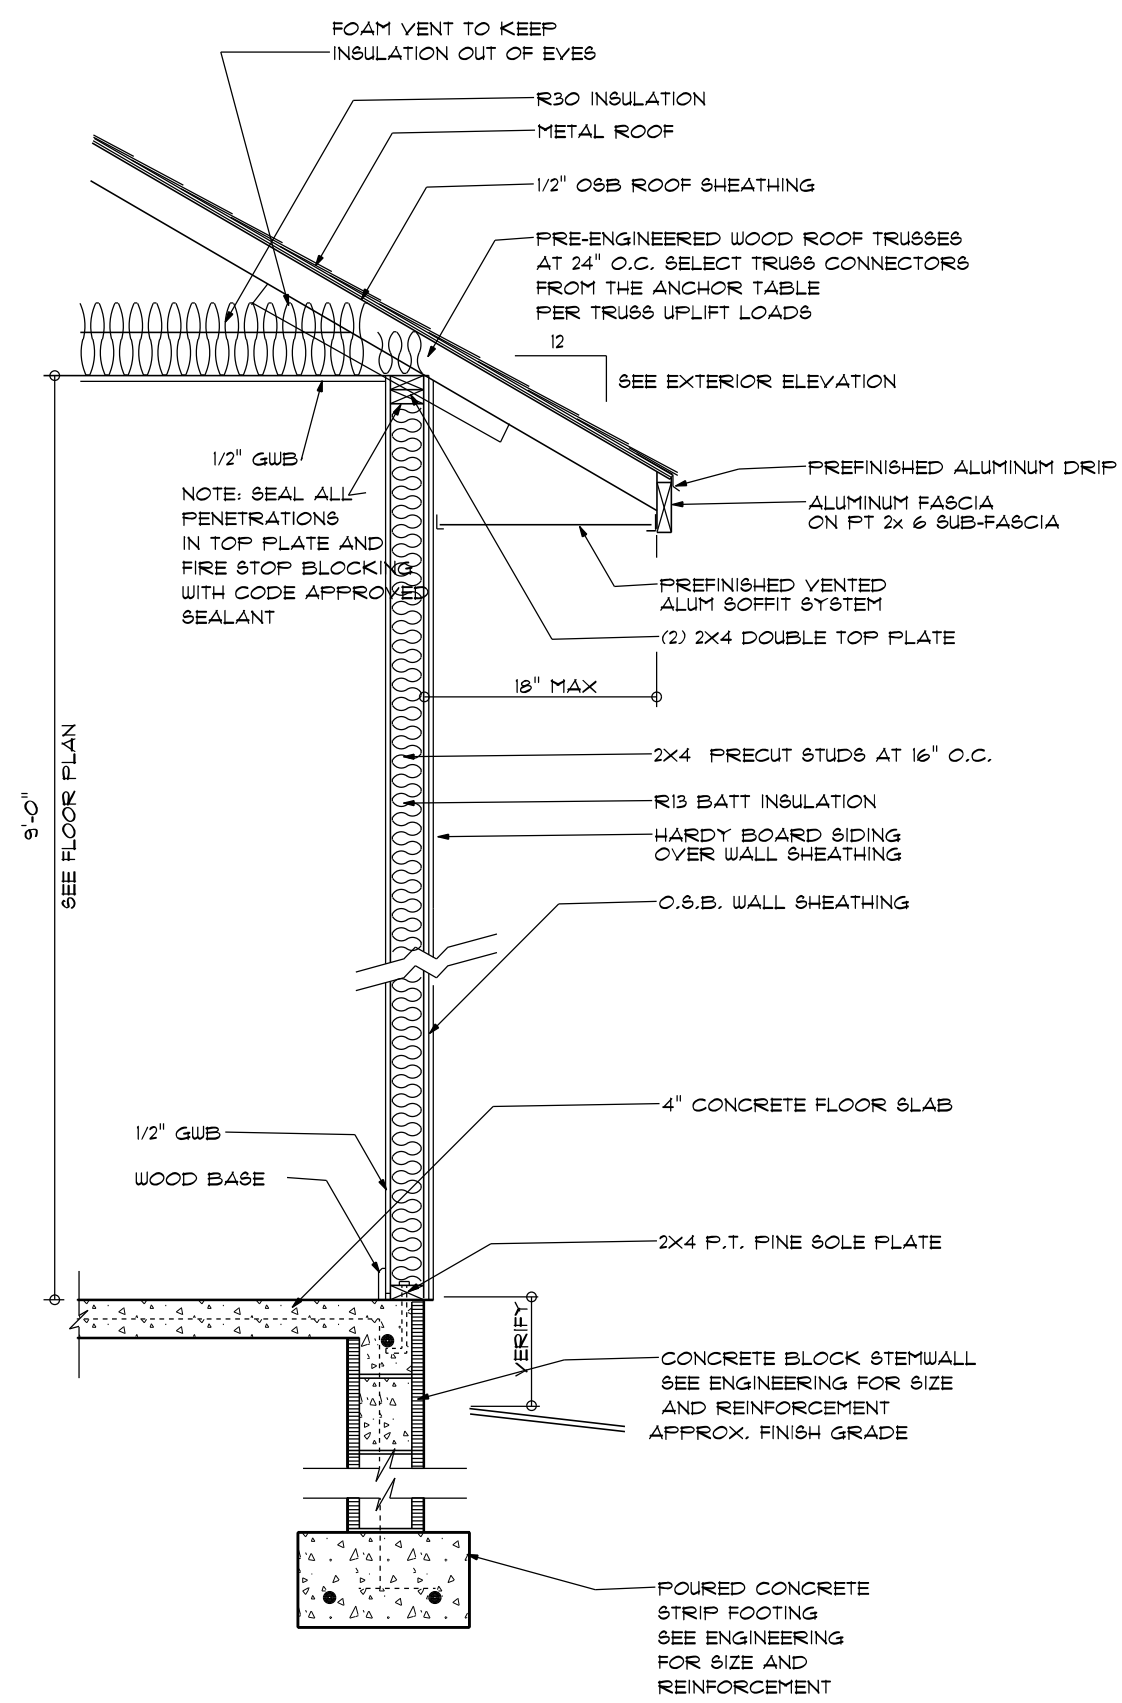

TYPICAL DESIGN WALL SECTION
NON - STRUCTURAL DATA
N.T.S.

ELECTRICAL LEGEND		
ELECTRICAL	COUNT	SYMBOL
ceiling fan globe 01	4	
pot light	13	
spotlight double	4	
Smoke Detector	4	
vanity bar light	1	
wall mount 2	2	
electrical meter	1	
electrical panel	1	
light	2	
outlet	19	
outlet 220v	5	
outlet gfi	7	
outlet wp	3	
switch	17	
switch 3 way	5	
vent light combo	1	

- ELECTRICAL PLAN NOTES**
- E-1 WIRE ALL APPLIANCES, HVAC UNITS AND OTHER EQUIPMENT PER MANUFACTURERS SPECIFICATIONS.
- E-2 ALL INSTALLATIONS SHALL BE PER NATIONAL ELECTRIC CODE.
- E-3 ALL SMOKE /CARBON MONOXIDE DETECTORS SHALL BE 120V W/BATTERY BACKUP OF THE PHOTOELECTRIC TYPE, AND SHALL BE INTERLOCKED TOGETHER. INSTALL INSIDE AND NEAR ALL BEDROOMS AS PER CODE.
- E-4 TELEPHONE, TELEVISION AND OTHER LOW VOLTAGE DEVICES OR OUTLETS SHALL BE AS PER THE OWNERS DIRECTION AND IN ACCORDANCE WITH APPLICABLE SECTIONS OF NATIONAL ELCT. CODE LATEST EDITION.
- E-5 ELECTRICAL CONTRACTOR SHALL BE RESPONSIBLE FOR THE DESIGN AND SIZING OF ELECTRICAL SERVICE AND CIRCUITS.
- E-6 ENTRY OF SERVICE UNDERGROUND OR OVERHEAD) IS TO BE DETERMINED BY THE POWER COMPANY.
- E-7 ALL BEDROOM RECEPTALS ARE TO BE AFCI (ARC FAULT CIRCUIT INTERRUPT)
- E-8 75% OF ALL PERMANENT LIGHTS TO BE ENERGY EFFICIENT.

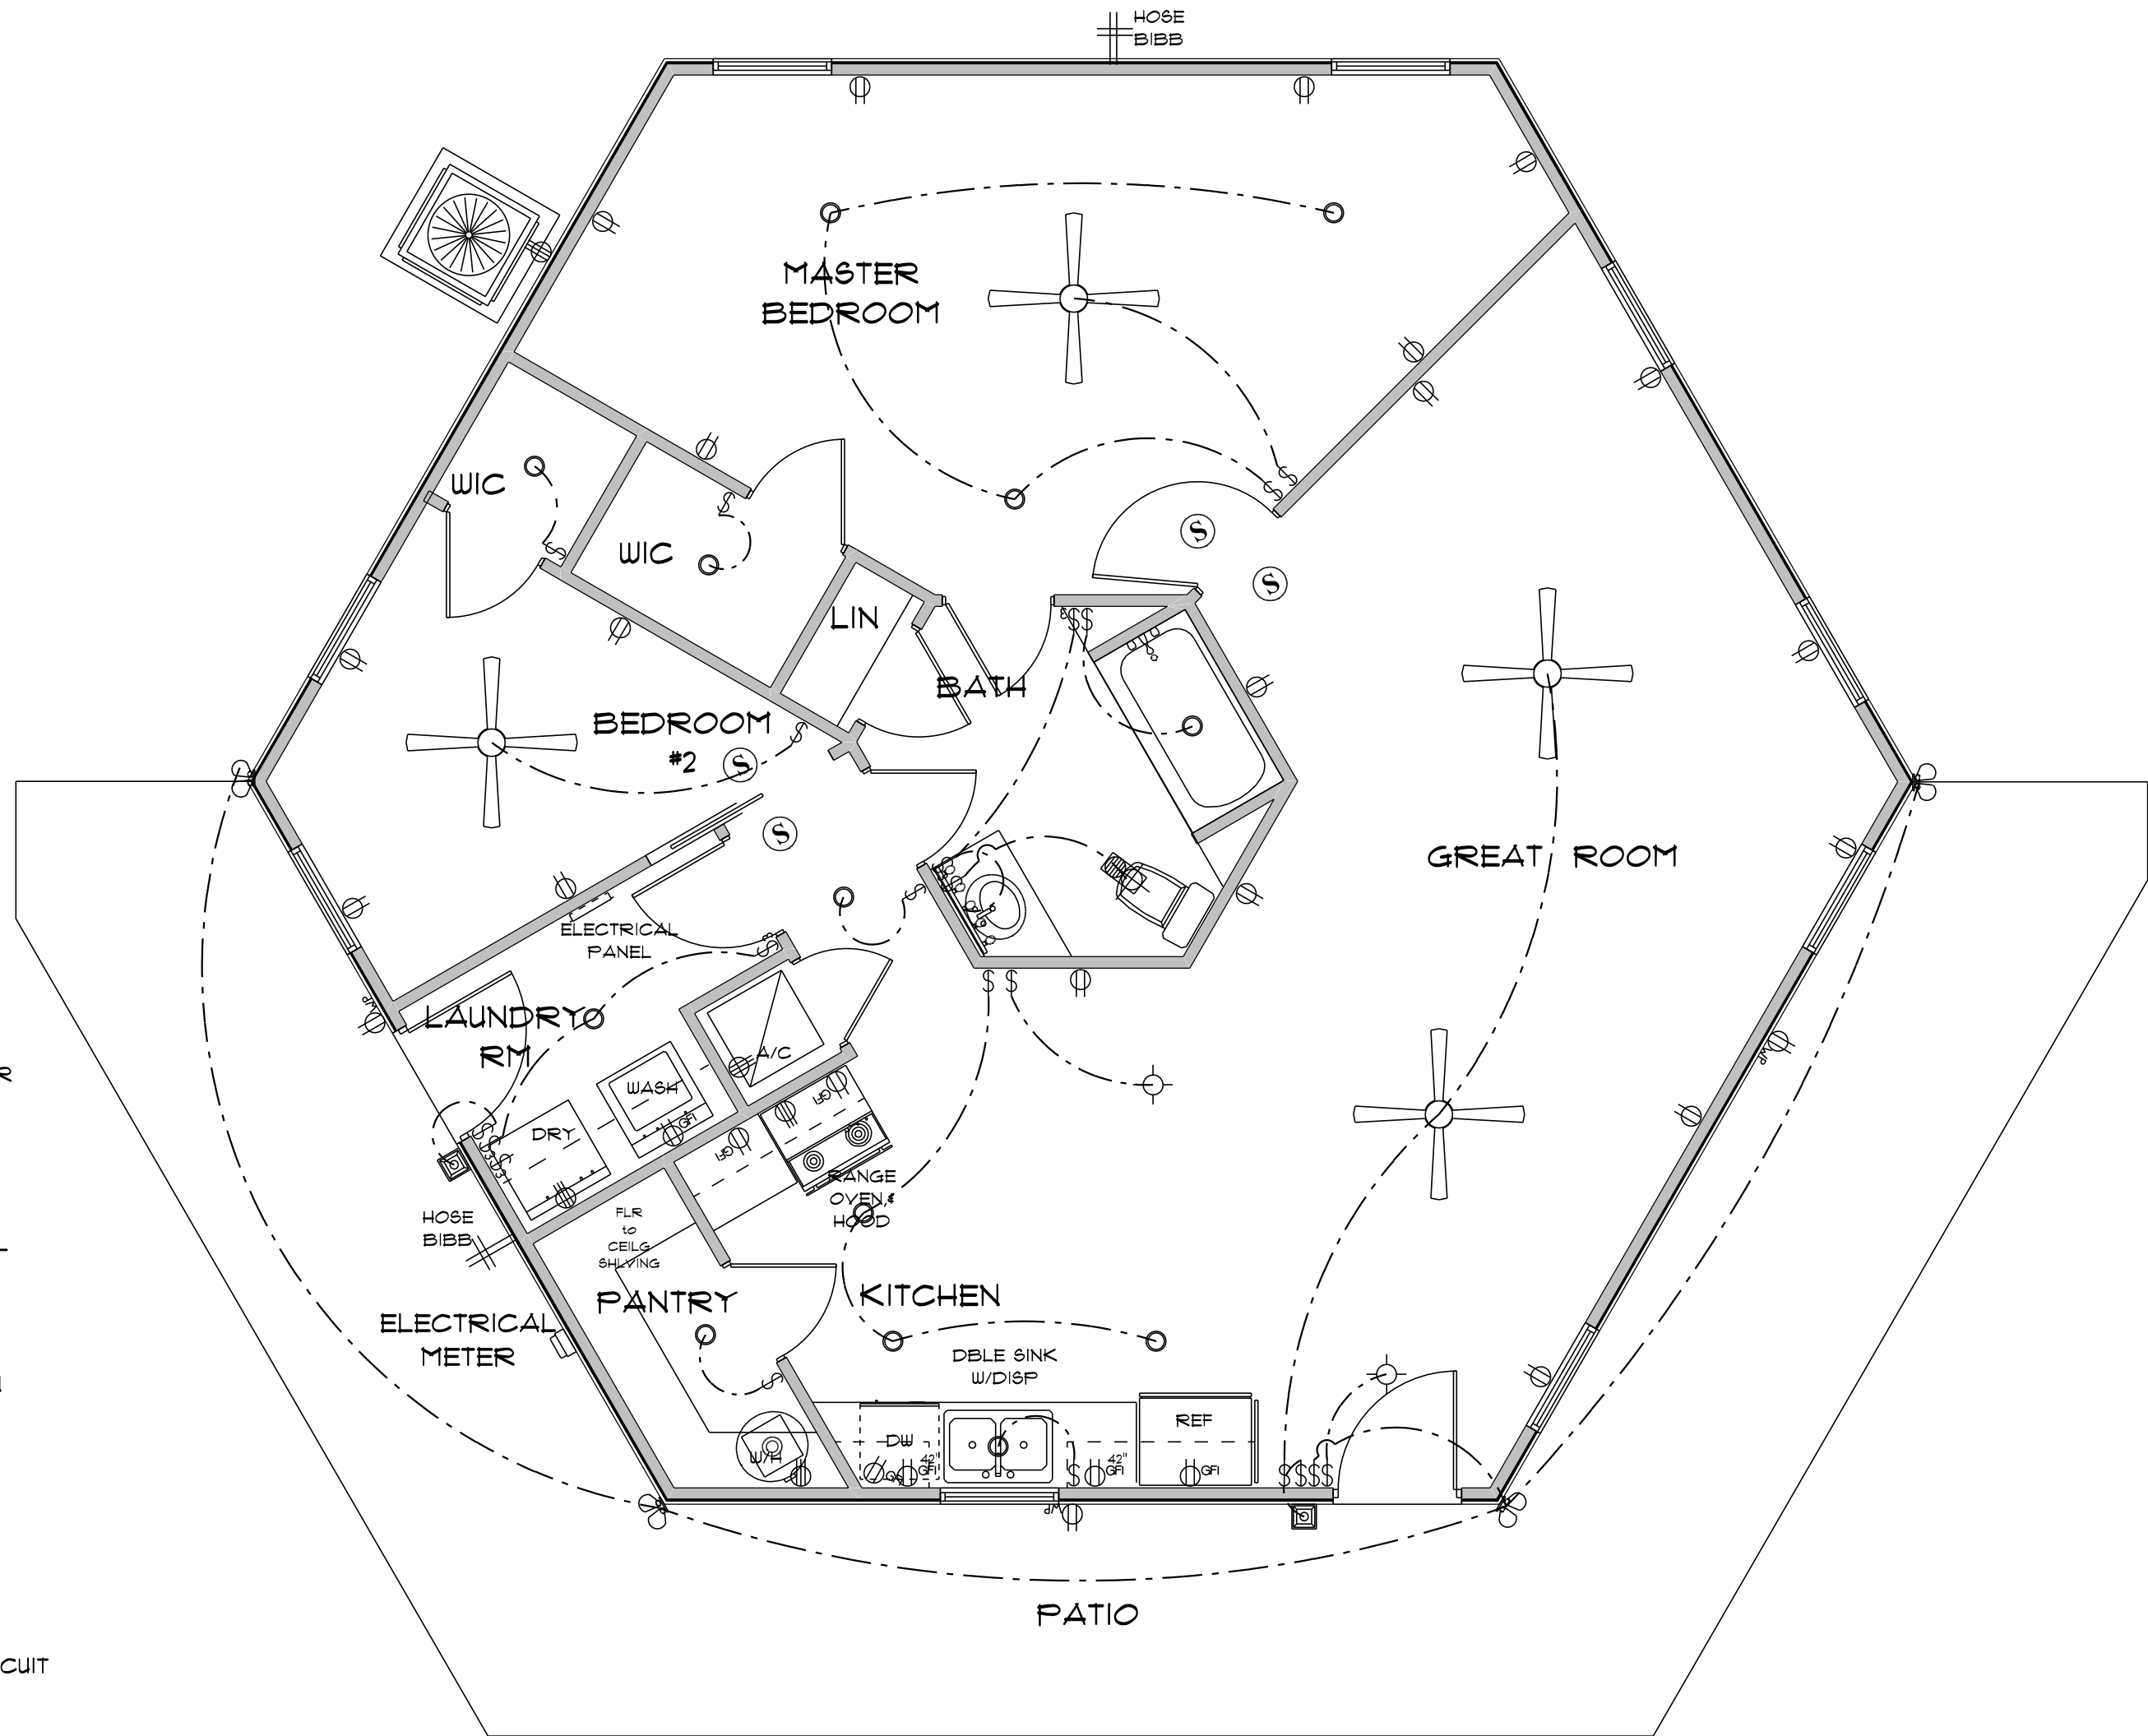

* ELECTRICAL PLAN *

SCALE : 1/8" = 1'-0"

NOTE:
USE DECORA OUTLETS AND SWITCHES
OR EQUAL

RESIDENCE
for
GUADALUPE SOTO

Teresa M. Ruffo
2925 SW 58R 47
Lake City Florida, 32025
Cell: (386) 867-1191
Email: teresaruffo@gmail.com

PRINTED DATE:
Friday, December 13, 2019

DRAWN BY: Teresa M. Ruffo CHECKED BY:

BUILDING CONTRACTOR
GLENWOOD KING

FINALS DATE:

JOB NUMBER:

DRAWING NUMBER

A-2

OF 2 SHEETS