
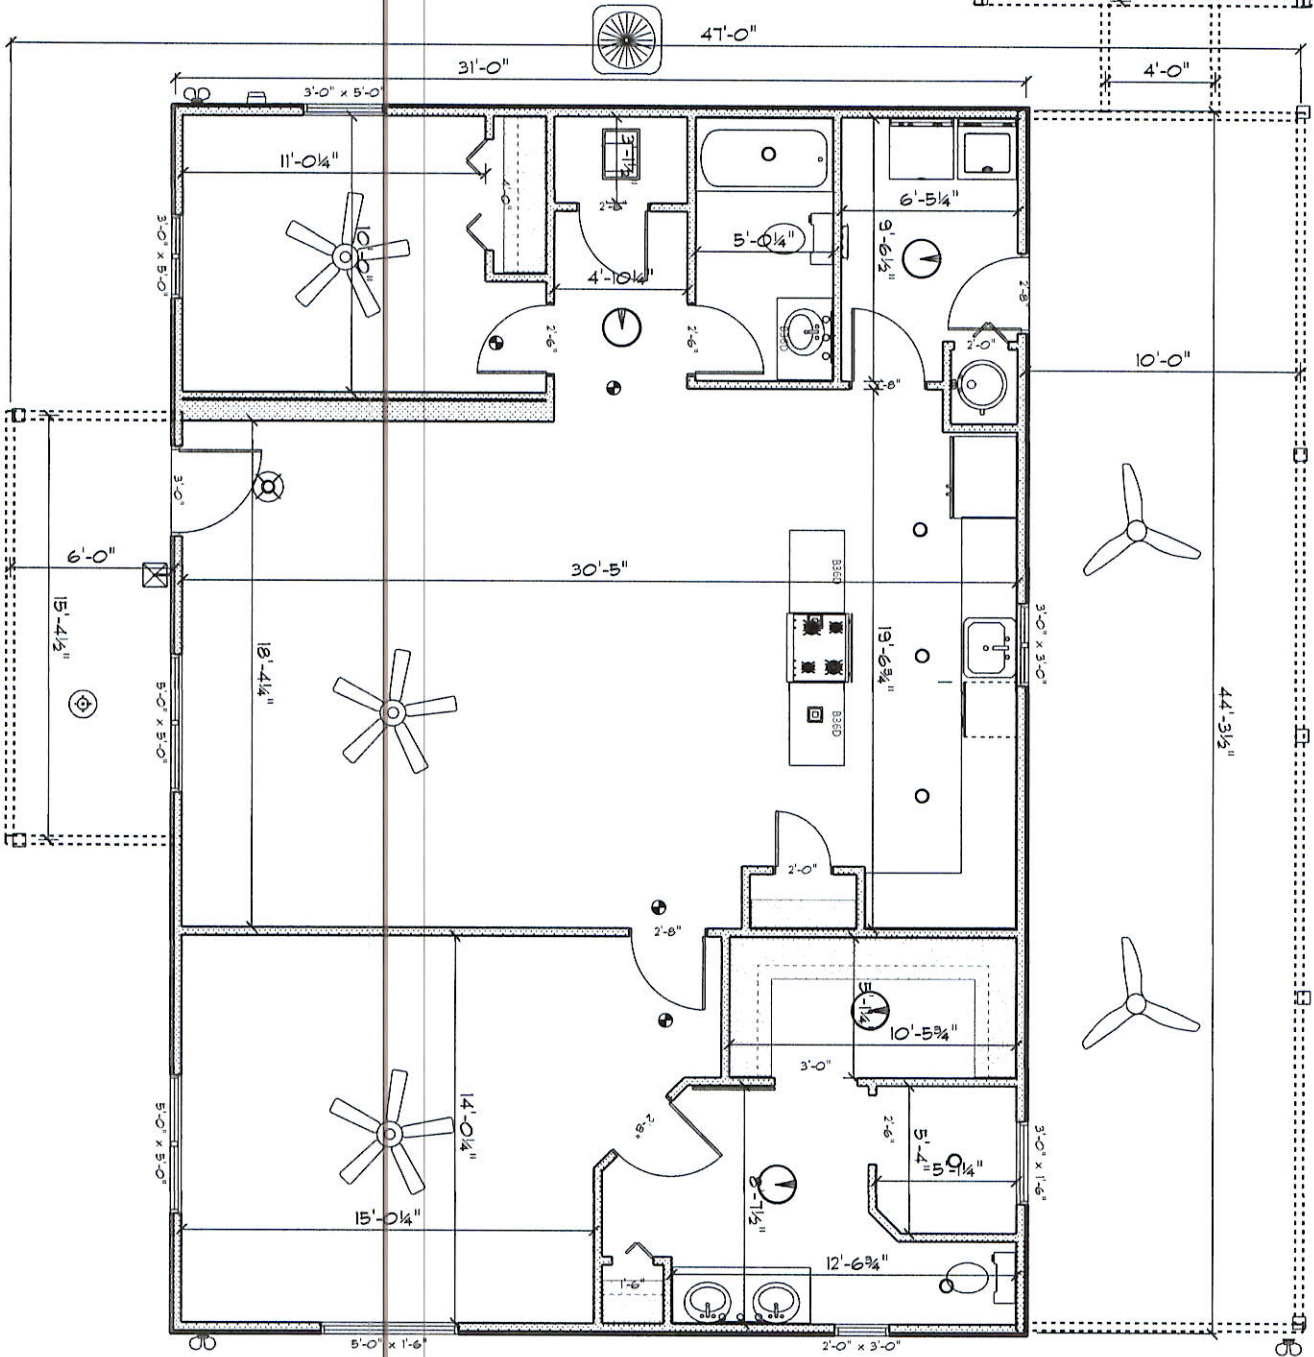


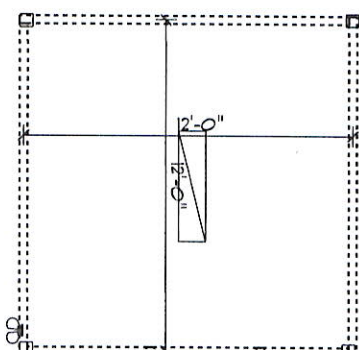


ELECTRICAL LEGEND		
ELECTRICAL	COUNT	SYMBOL
exterior ceiling fan	2	
ceiling fan 5 bladed	3	
ceiling light 5 bladed	3	
ceiling light 01	4	
ceiling light 24	1	
ceiling light 39	1	
fluorescent light 1 x 4	1	
pendant large	2	
exterior craftsman light fixture	1	
spotlight double	4	
vanity bar light 02	4	


John Norris Construction, LLC

Thomas Residence
1585 SW HWY 252B
Lake City, FL 32024


AREA SCHEDULE	
NAME	AREA
Gross Floor Area	2099.2 sq ft.
Heat and Cool	1391.9 sq ft.
Carport	167.1 sq ft.
Porches	540.7 sq ft.

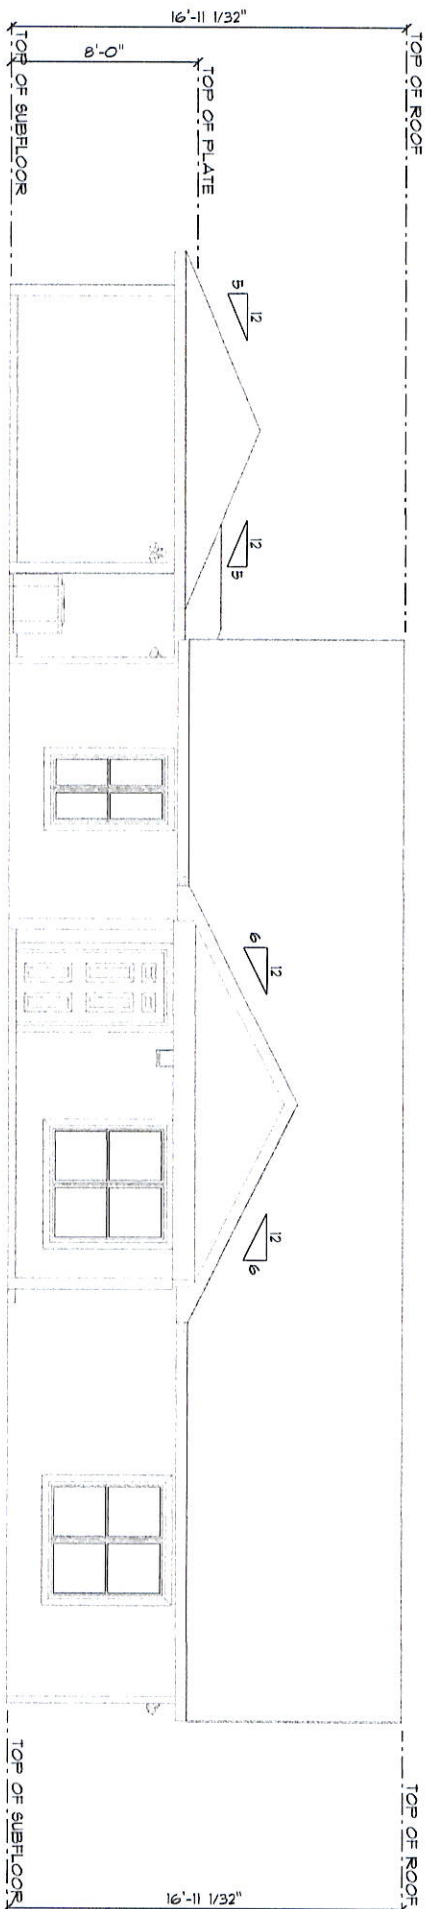


Front Elevation
SCALE: 1/8" = 1'-0"

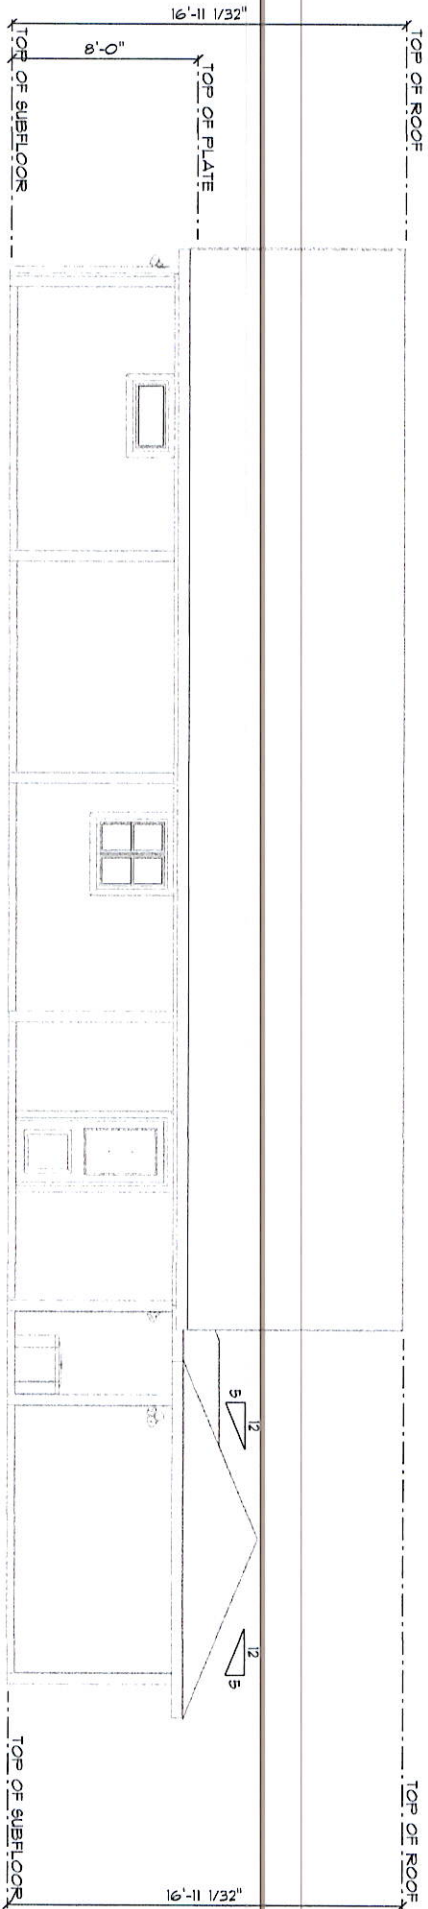

Rear Elevation
SCALE: 1/8" = 1'-0"

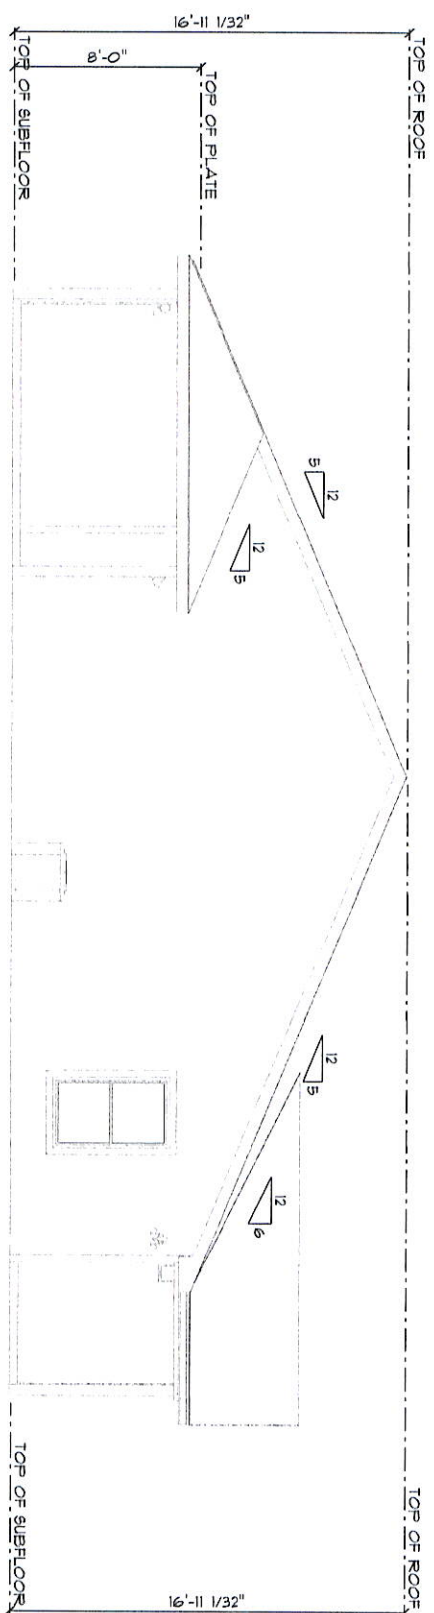

Left Elevation
SCALE: 1/8" = 1'-0"

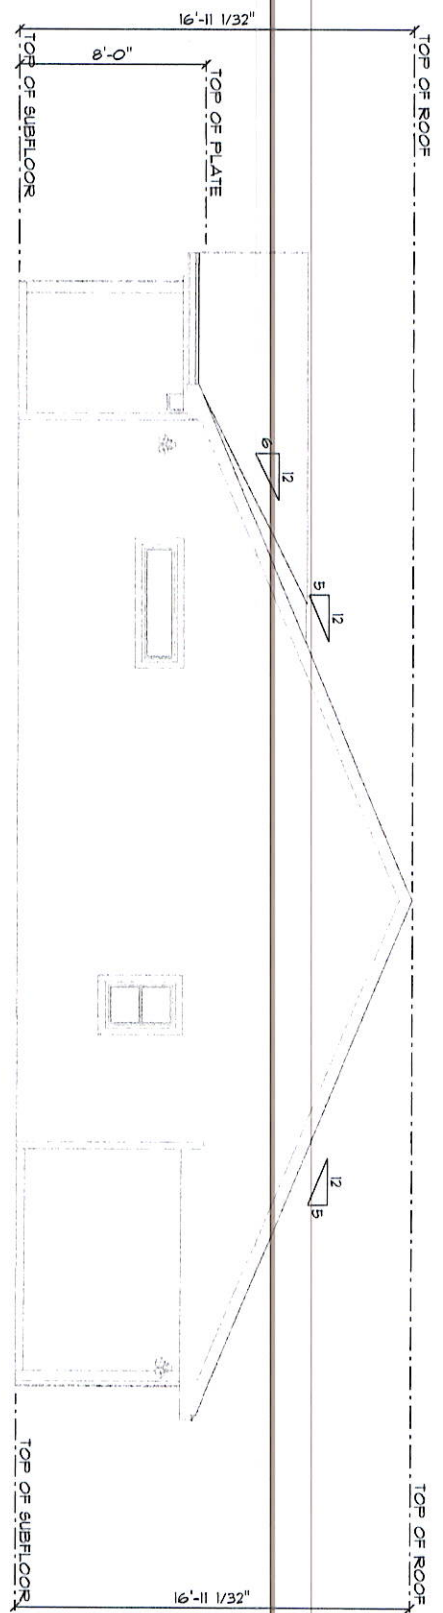

Right Elevation
SCALE: 1/8" = 1'-0"