




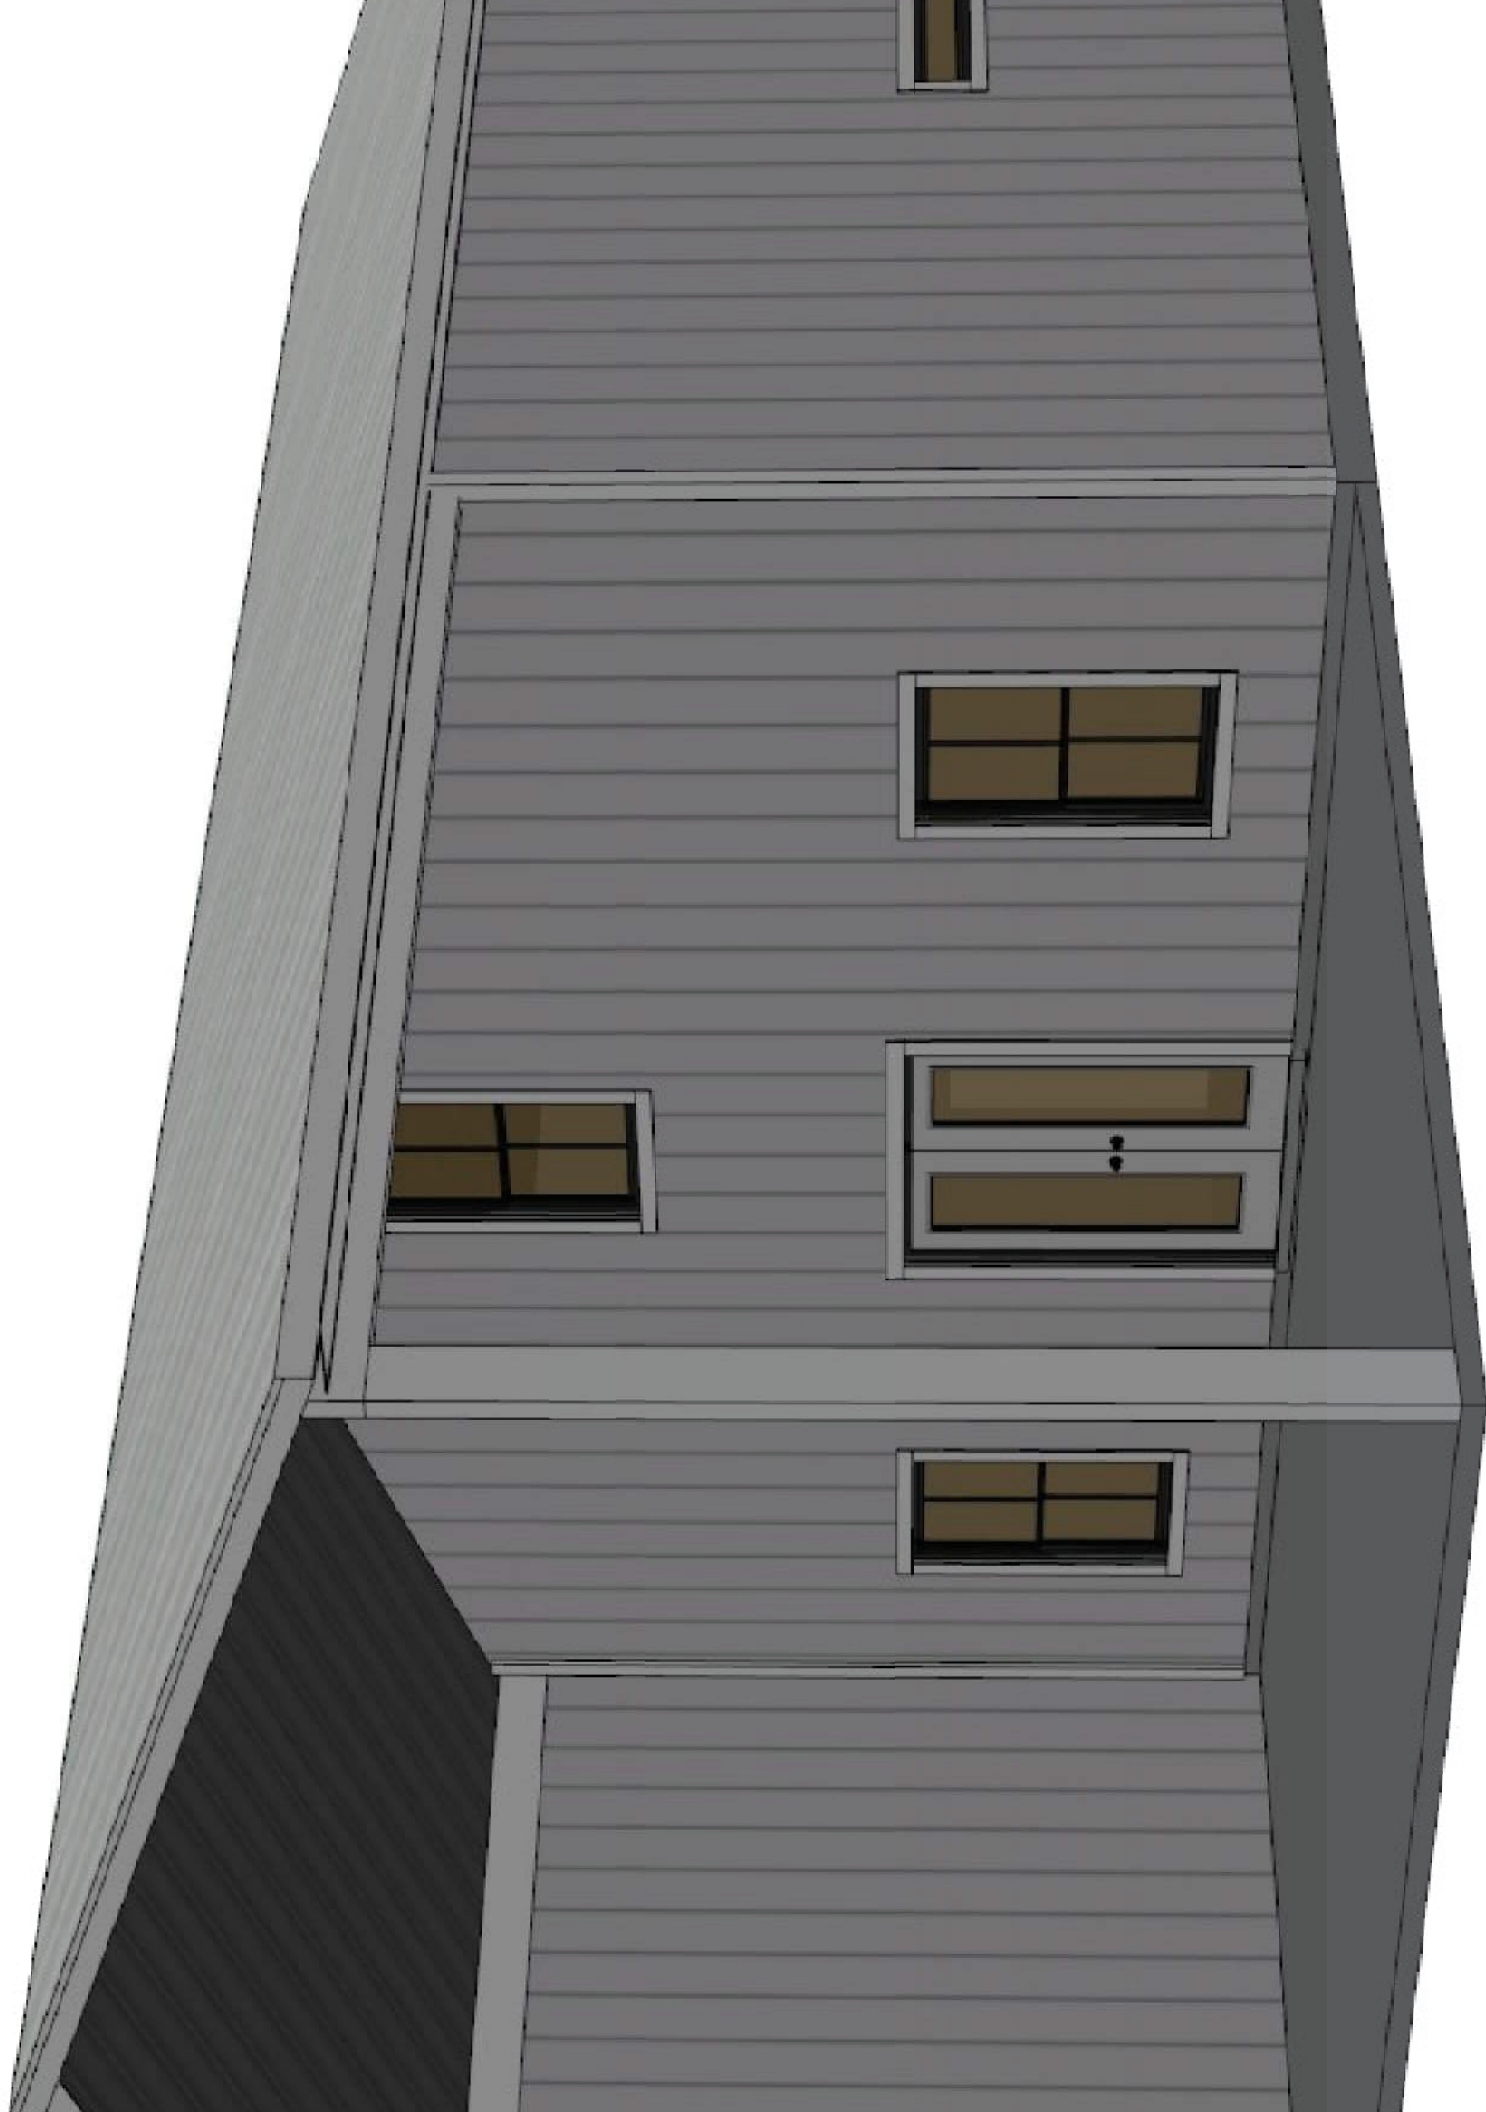


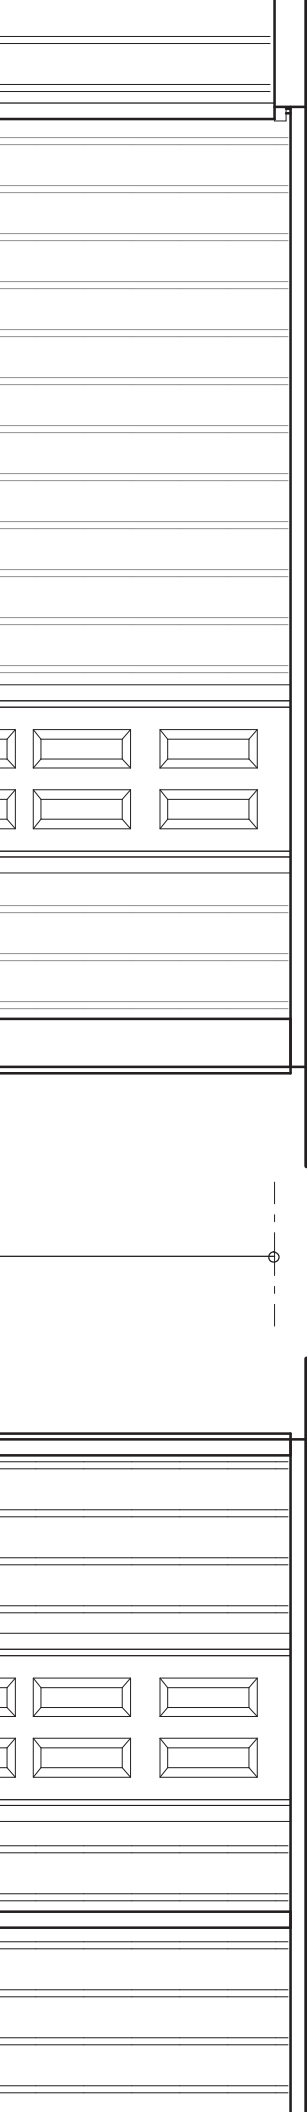

RIGHT ELEVATION

SCALE: 1/4" = 1'-0"

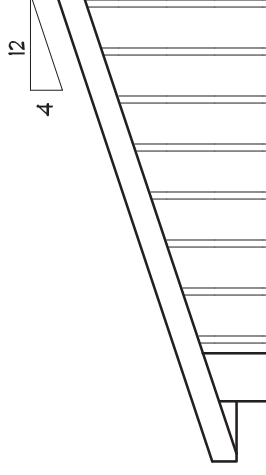


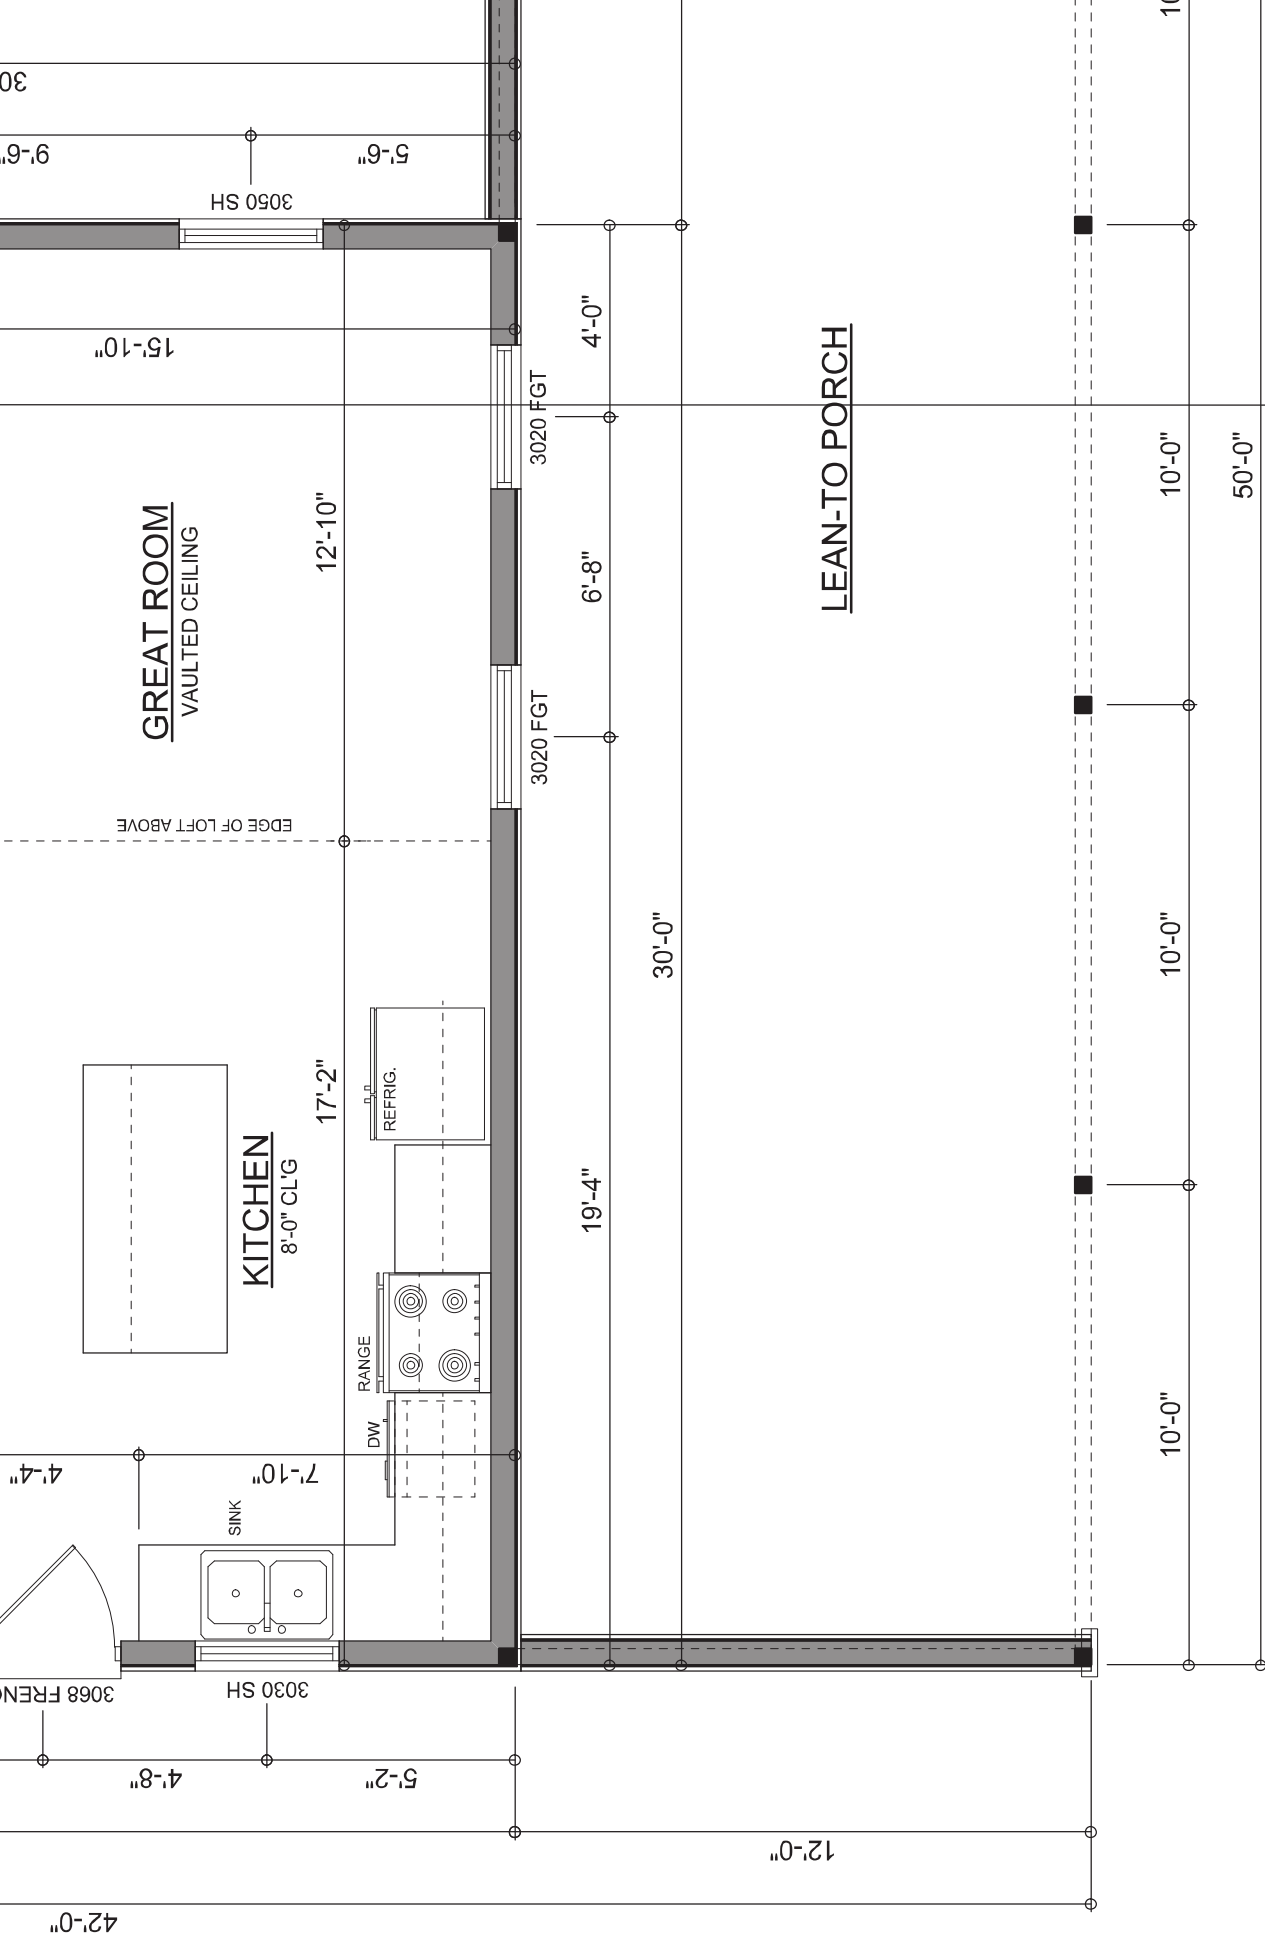

DIMENSIONED FLOOR PLAN

SCALE: 1/4" = 1'-0"




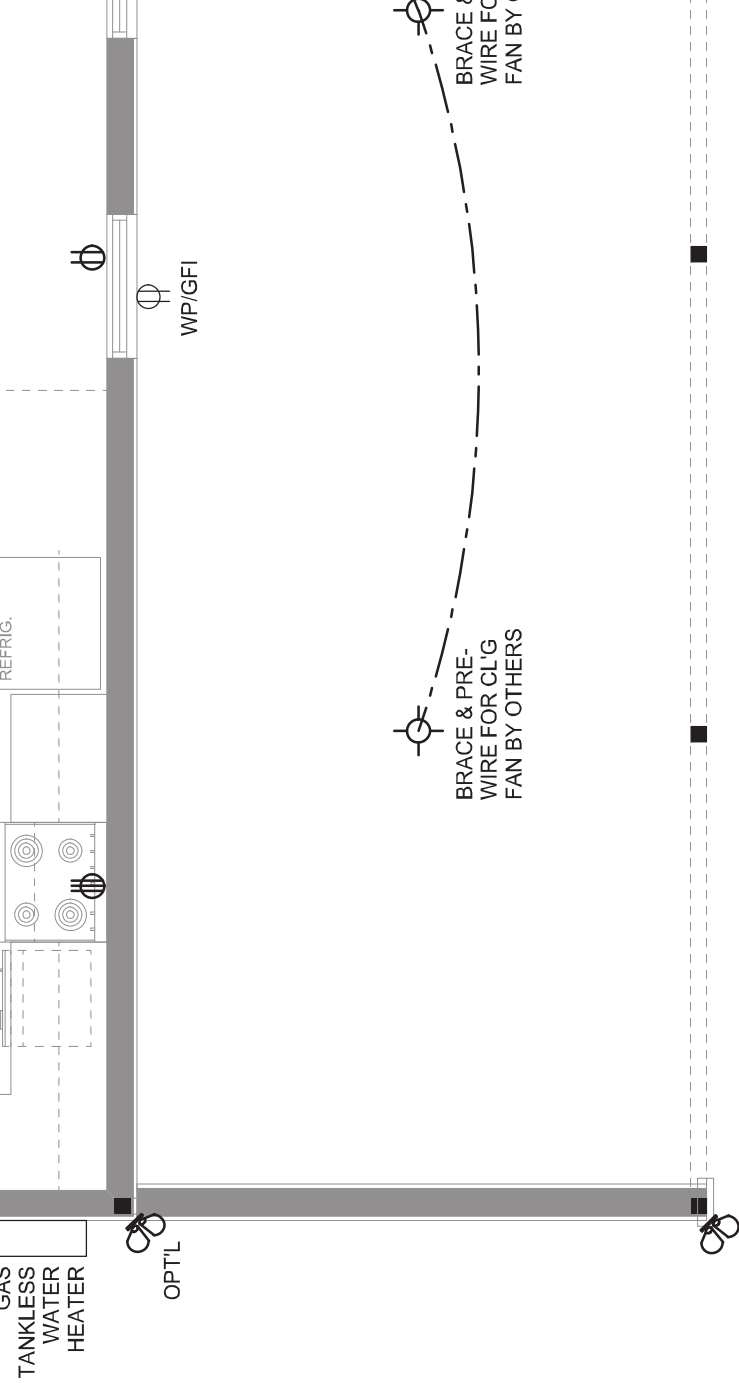


1ST FLOOR ELECTRICAL PLAN


SCALE:

1/4" = 1'-0"

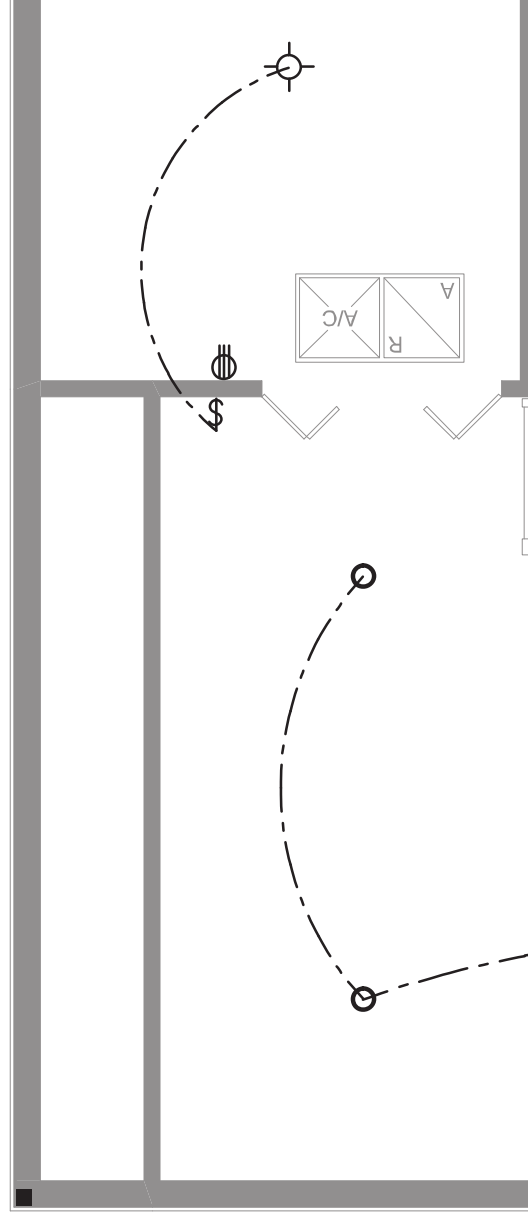


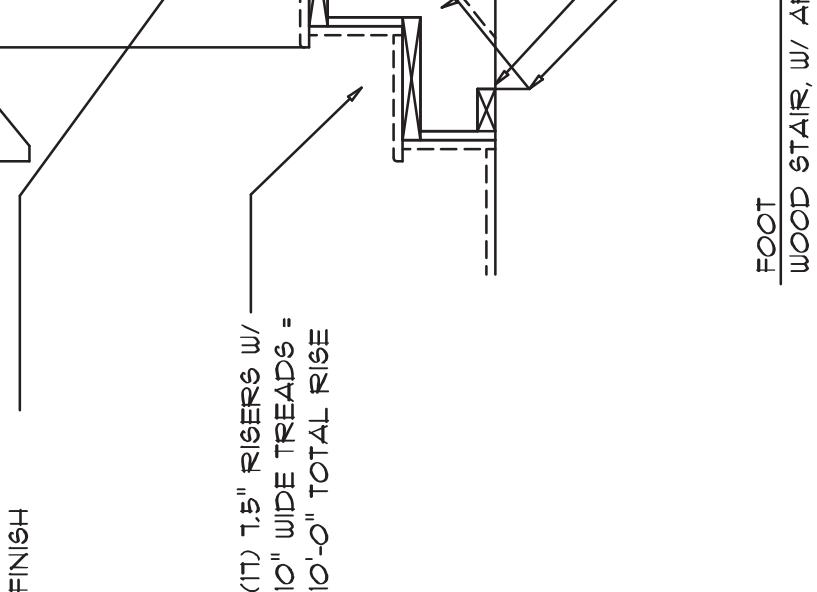

Typical Stair Detail
SCALE: 3/4" = 1'-0"

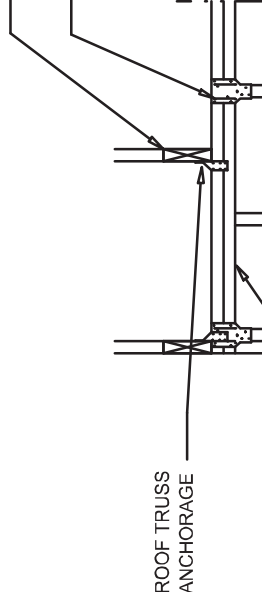

FOR EXTERIOR BEARING WALLS					
BUILDING WIDTH (FT)					
20'		28'		36'	
SPAN	# JACKS	SPAN	# JACKS	SPAN	# JACKS
3'-6"	1	3'-2"	1	2'-10"	1
5'-5"	1	4'-8"	1	4'-2"	1
6'-10"	1	5'-11"	2	5'-4"	1
8'-5"	2	7'-3"	2	6'-6"	2
9'-9"	2	8'-5"	2	7'-6"	2
8'-4"	1	7'-5"	1	6'-8"	1
10'-6"	1	9'-1"	2	8'-2"	1
12'-2"	2	10'-7"	2	9'-5"	2
9'-2"	1	8'-4"	1	9'-2"	1
11'-8"	1	10'-6"	1	9'-5"	1
14'-1"	1	12'-2"	2	10'-11"	1

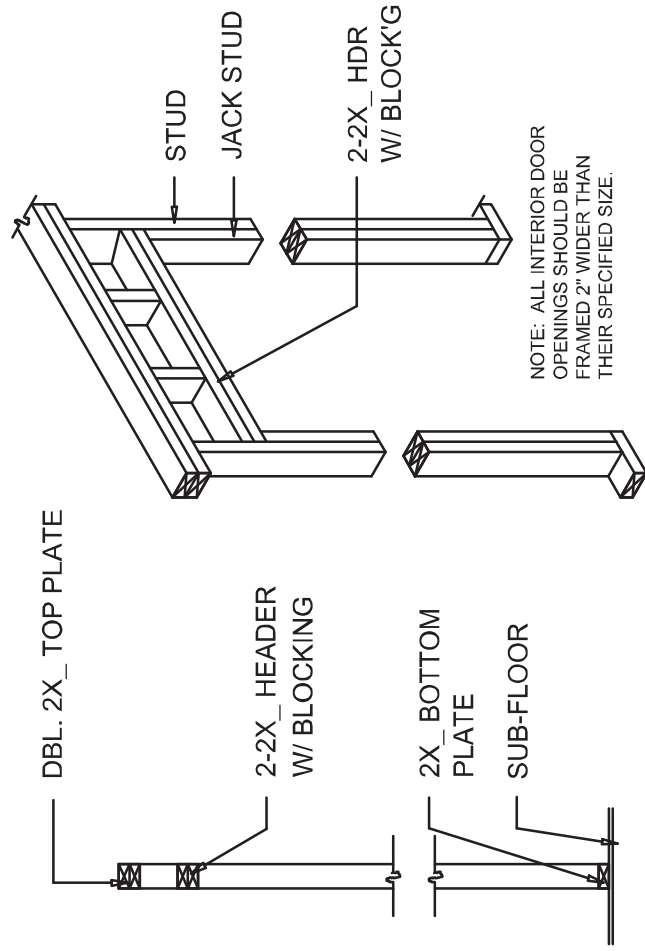

NON-BEARING WALL HEADER