


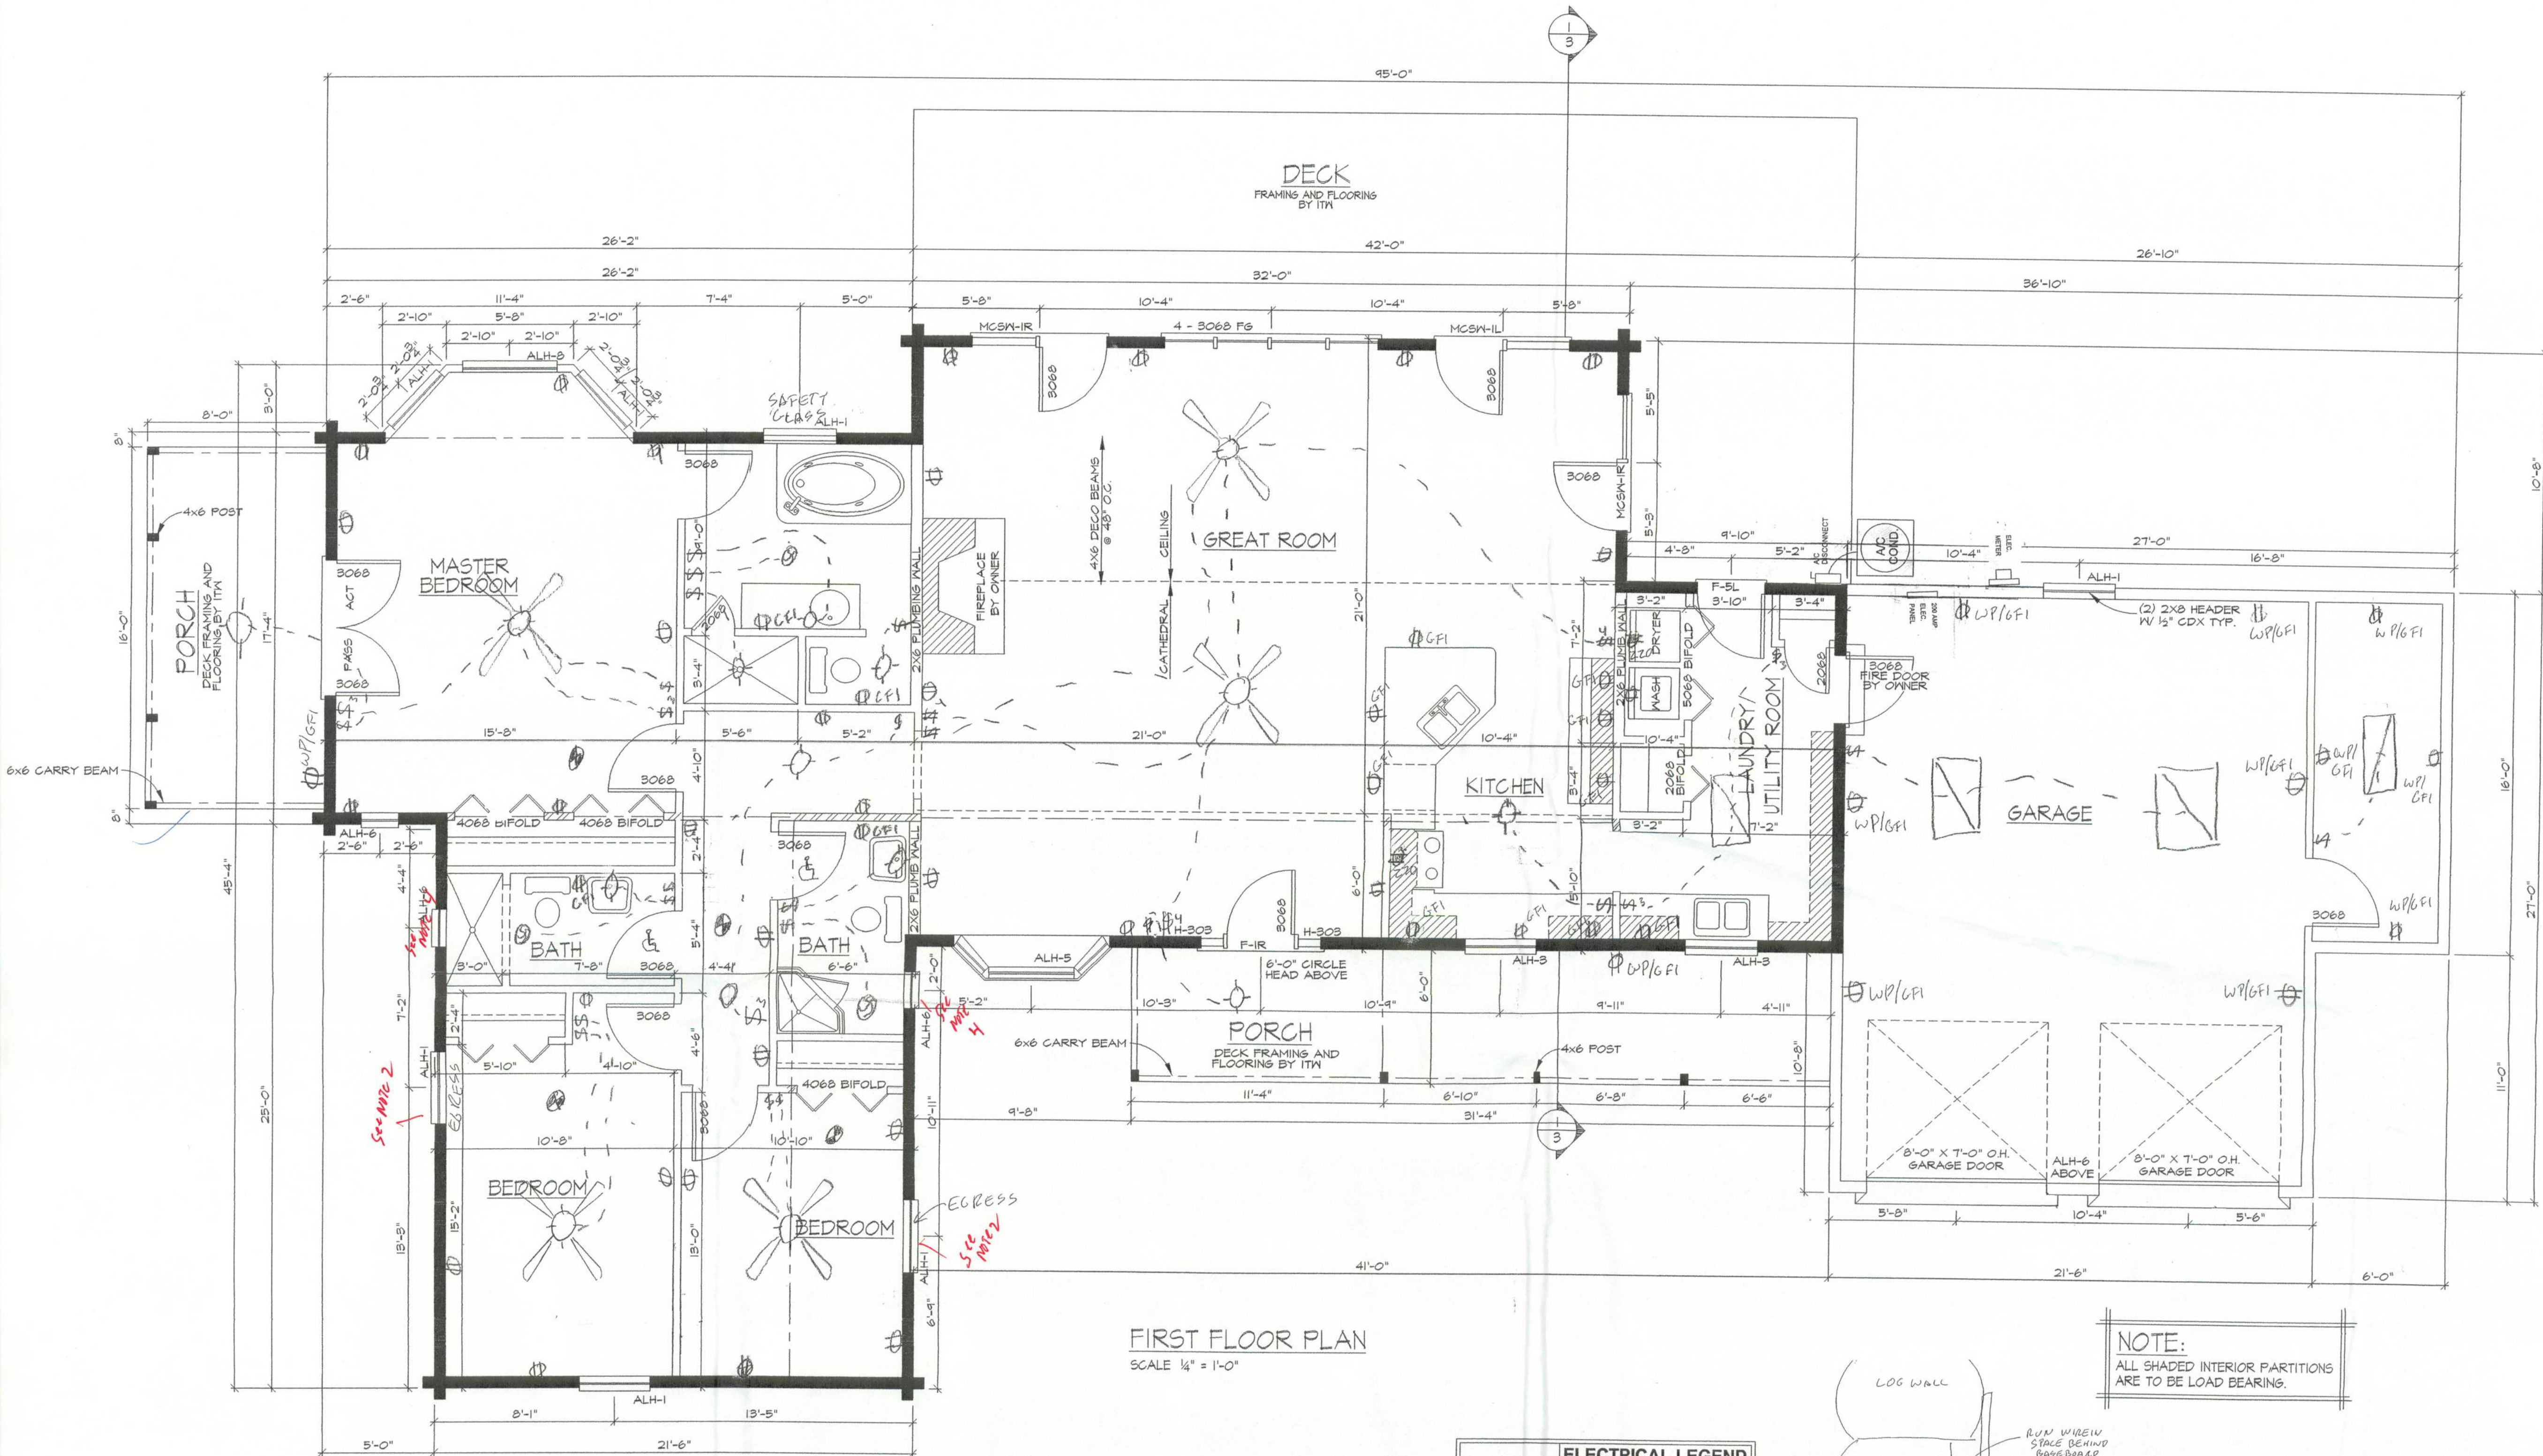


**FIRST FLOOR PLAN**  
SCALE 1/4" = 1'-0"


**ELECTRICAL PLAN NOTES**

- E-1 WIRE ALL APPLIANCES, HVAC UNITS AND OTHER EQUIPMENT PER MANUF. SPECIFICATIONS.
- E-2 CONSULT THE OWNER FOR THE NUMBER OF SEPARATE TELEPHONE LINES TO BE INSTALLED.
- E-3 ALL INSTALLATIONS SHALL BE PER NAT'L. ELECTRIC CODE.
- E-4 ALL SMOKE DETECTORS SHALL BE 120V W/ BATTERY BACKUP OF THE PHOTOELECTRIC TYPE, AND SHALL BE INTERLOCKED TOGETHER. INSTALL INSIDE AND NEAR ALL BEDROOMS.
- E-5 TELEPHONE, TELEVISION AND OTHER LOW VOLTAGE DEVICES OR OUTLETS SHALL BE AS PER THE OWNER'S DIRECTIONS & IN ACCORDANCE W/ APPLICABLE SECTIONS OF NEC-LATEST EDITION.
- E-6 ELECTRICAL CONTR SHALL BE RESPONSIBLE FOR THE DESIGN & SIZING OF ELECTRICAL SERVICE AND CIRCUITS.
- E-7 ENTRY OF SERVICE (UNDERGROUND OR OVERHEAD) TO BE DETERMINED BY POWER COMPANY.
- E-8 ALL BEDROOM RECEPTACLES SHALL BE AFCI (ARC FAULT CIRCUIT INTERRUPT)
- E-9 ALL OUTLETS TO BE LOCATED ABOVE BASE FLOOD ELEVATION


| ELECTRICAL LEGEND |                                      |
|-------------------|--------------------------------------|
|                   | CEILING FAN (PRE-WIRE FOR LIGHT KIT) |
|                   | DOUBLE SECURITY LIGHT                |
|                   | 2X4 FLUORESCENT LIGHT FIXTURE        |
|                   | BATH EXHAUST FAN                     |
|                   | LIGHT FIXTURE                        |
|                   | DUPLEX OUTLET                        |
|                   | 220V OUTLET                          |
|                   | GFI DUPLEX OUTLET                    |
|                   | SMOKE DETECTOR                       |
|                   | WALL SWITCH                          |
|                   | 3 WAY WALL SWITCH                    |
|                   | WATER PROOF GFI OUTLET               |

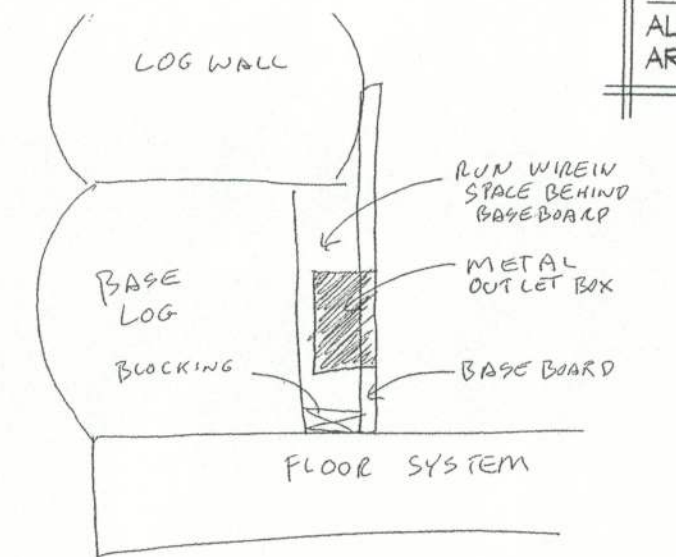

**OUTLET DETAIL**

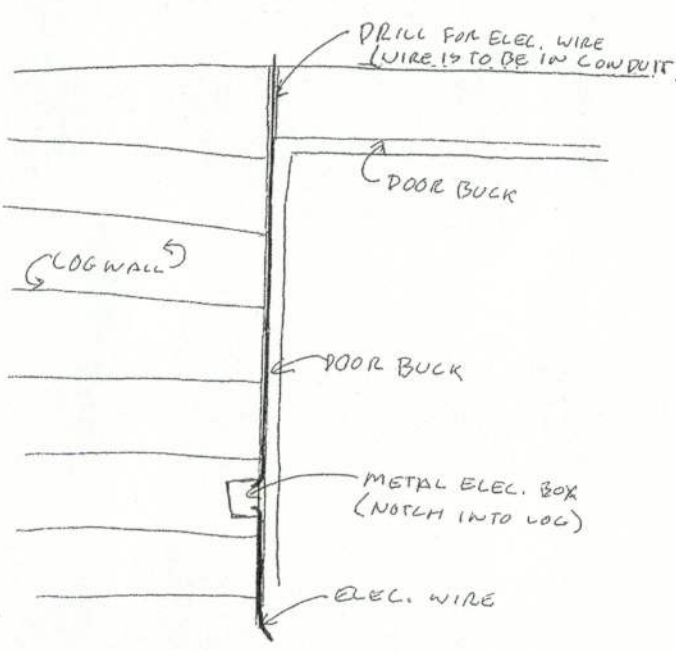

**SWITCH DETAIL**

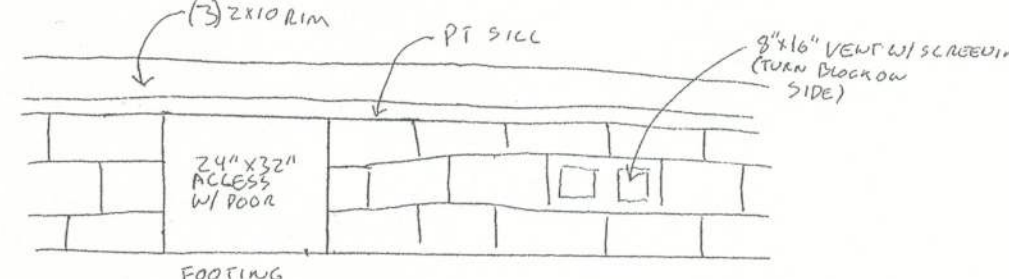

**STEM WALL DETAIL**

ITM DOES NOT CLAIM ANY RESPONSIBILITY FOR THE ACCURACY OF THE INFORMATION PROVIDED IN THESE PLANS TO ANY OF THE ESTABLISHED CODES, ORDINANCES, RULES AND OTHER LOCAL CODES. IT IS THE RESPONSIBILITY OF THE USER OF THESE PLANS TO OBTAIN ALL NECESSARY PERMITS AND APPROVALS FROM THE APPROPRIATE AGENCIES. ITM AND ITS SUBSIDIARIES ARE NOT PROVIDING ANY PROFESSIONAL ENGINEERING OR ARCHITECTURAL SERVICES. ITM AND ITS SUBSIDIARIES ARE NOT PROVIDING ANY PROFESSIONAL ENGINEERING OR ARCHITECTURAL SERVICES. ITM AND ITS SUBSIDIARIES ARE NOT PROVIDING ANY PROFESSIONAL ENGINEERING OR ARCHITECTURAL SERVICES.

**FIRST FLOOR PLAN**  
BASEMENT 2030 SQ. FT.  
GARAGE 616 SQ. FT.  
PORCH 916 SQ. FT.  
DECK 527 SQ. FT.  
ROOF FRAMING PLAN

LOG HOME PLANS FOR:  
**ANTHONY MIKULIC**  
COLUMBIA CO., FL

LOG PROFILE FOR THIS LOG HOME:  
INSIDE  
OUTSIDE  
8/8 ORIGINAL CYPRESS CLASSIC D SHAPE

**IN THE WOODS**  
Exceptional Log Homes

DATE: 12-04-01  
DRAWN BY: A. ABRAMS  
SCALE: AS NOTED  
CUST. ID #: 1251577  
REVISIONS:

SHEET NO.  
**2 OF 2**