


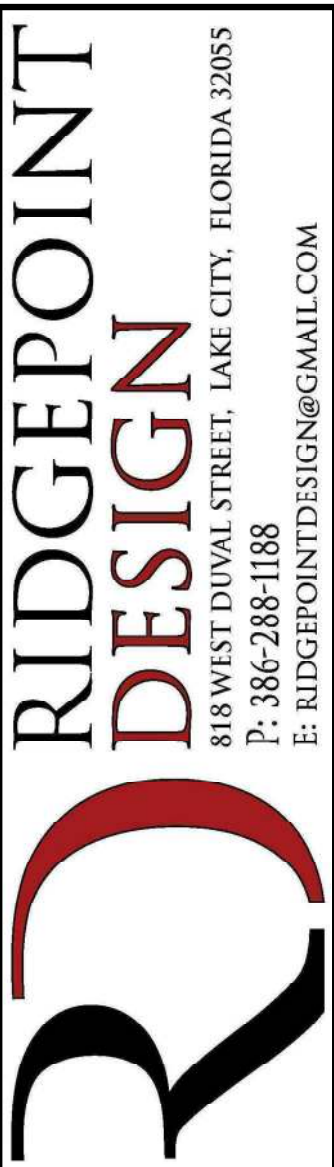

REVISIONS SCHEDULE	
Oct. 14th, 2021	Proposal Drawing
Nov. 29th, 2021	Revisions




CUSTOM HOME FOR:
MITCHELLE RESIDENCE
COLUMBIA COUNTY, FLORIDA




SHEET NUMBER

A.1
OF 4 SHEETS

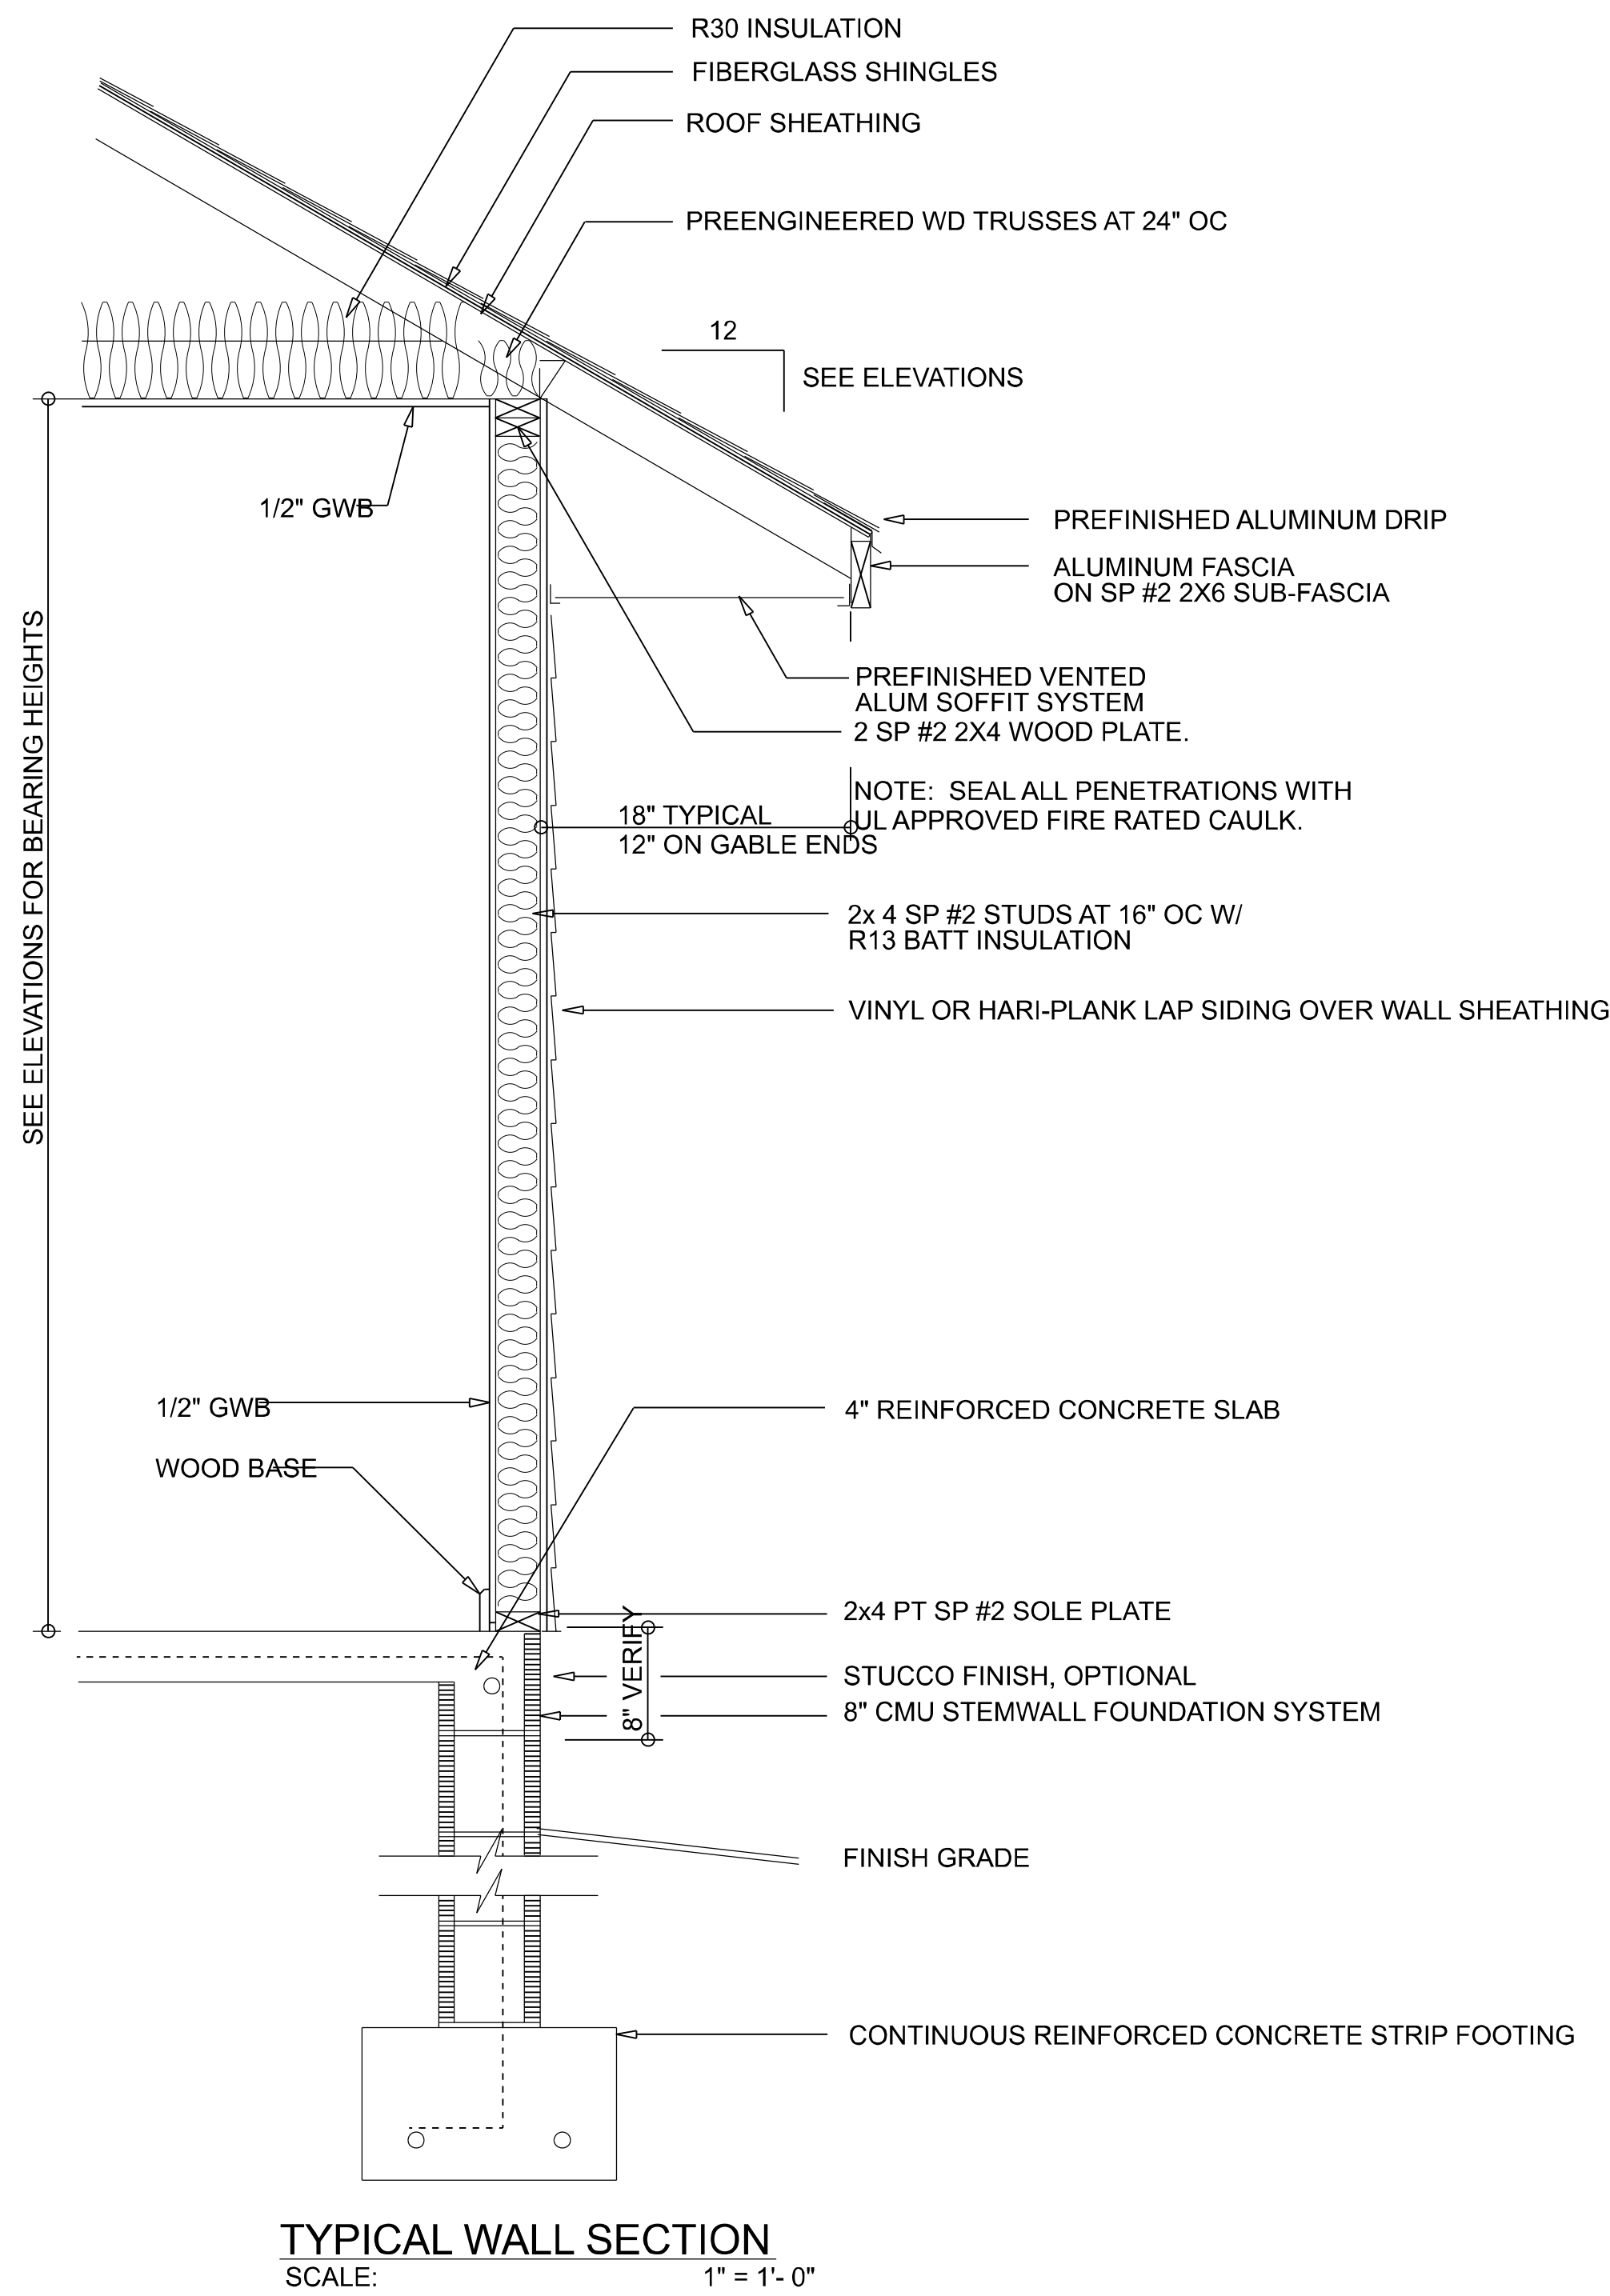

RIGHT ELEVATION
SCALE: 1/4" = 1'-0"

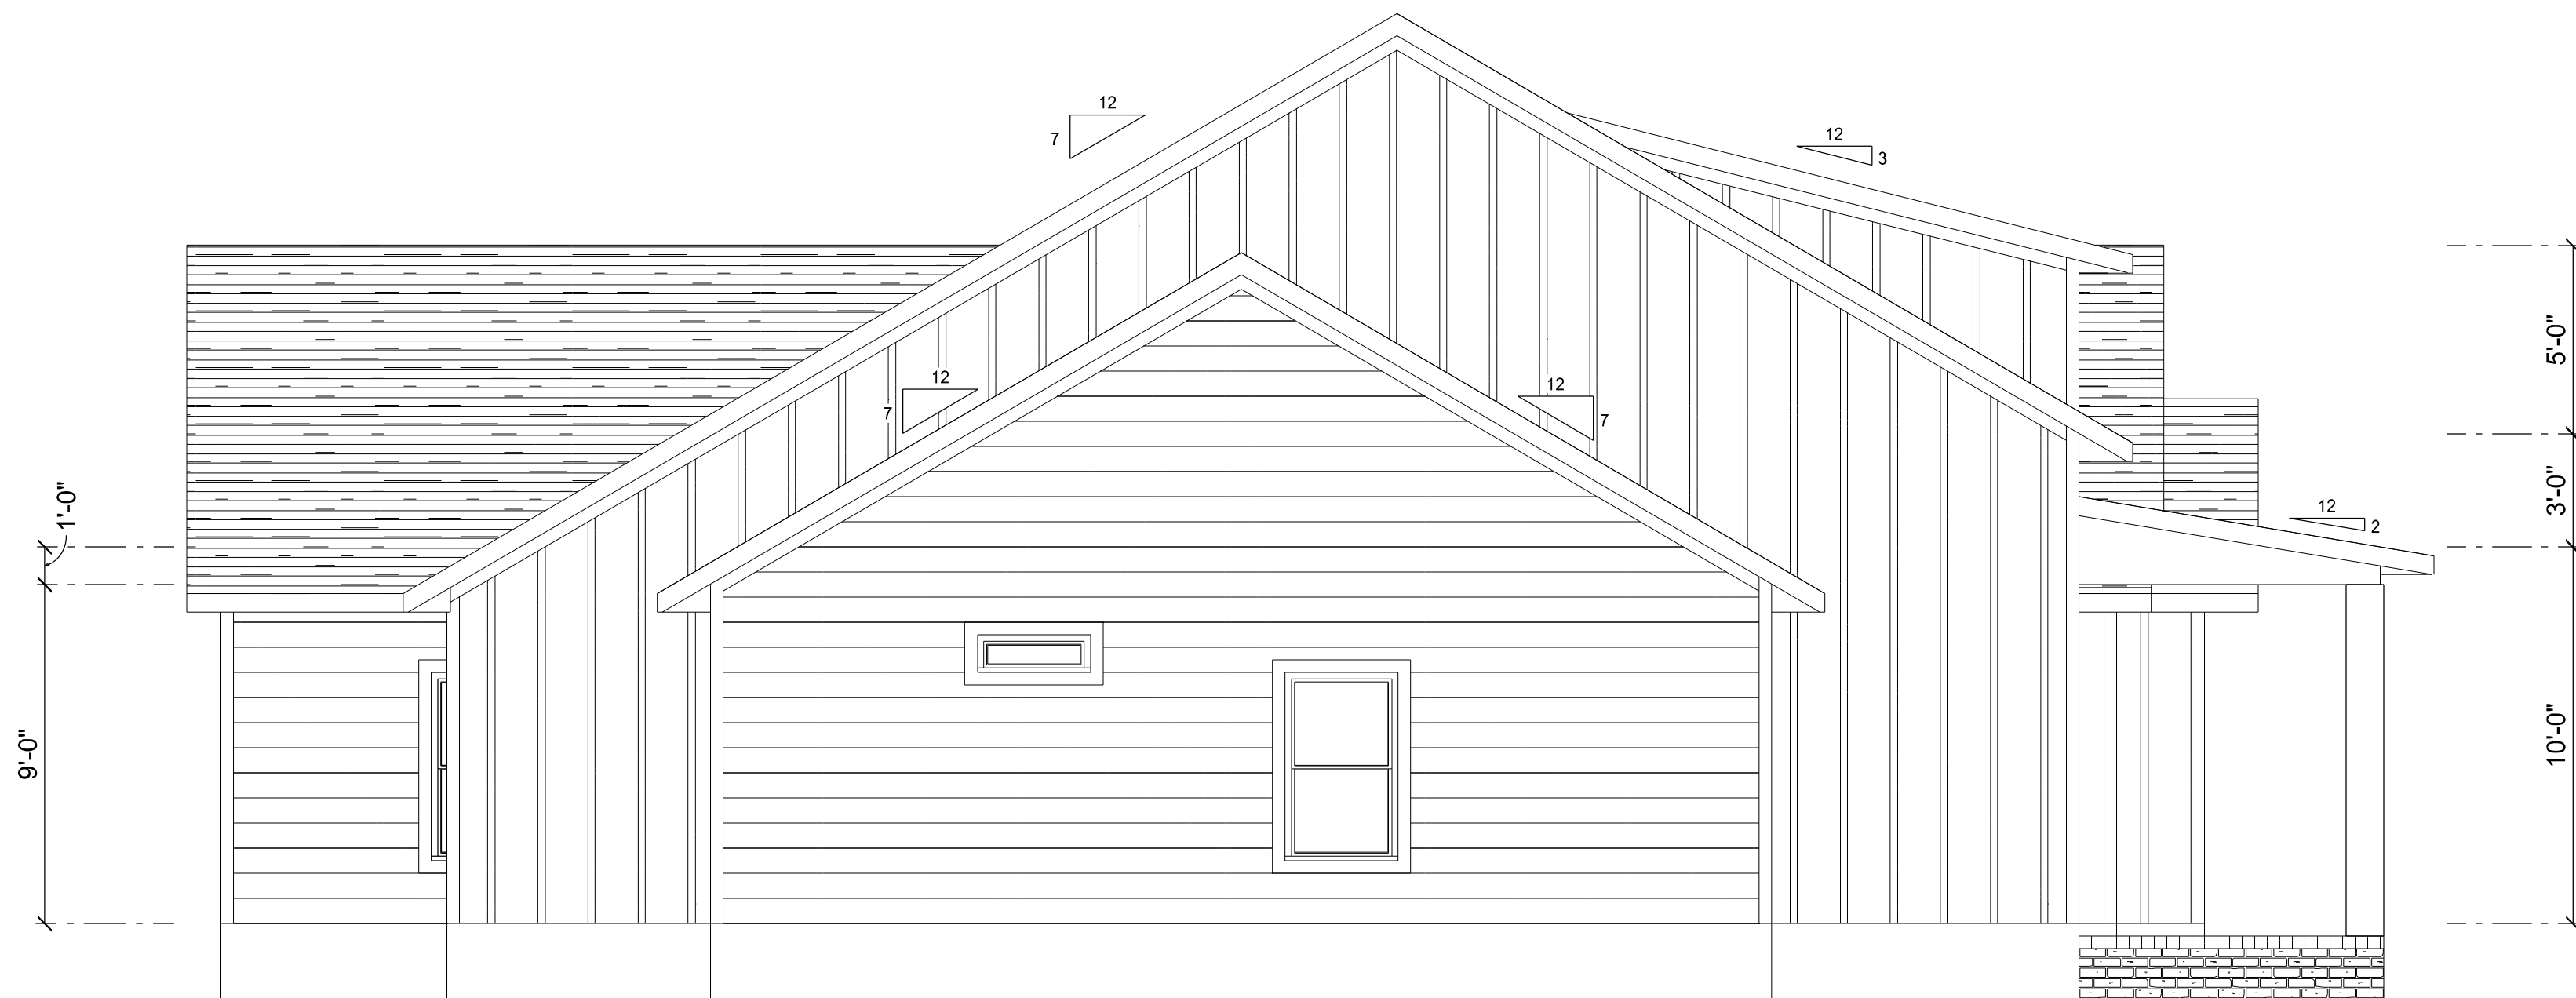


LEFT ELEVATION
SCALE: 1/4" = 1'-0"


REVISIONS SCHEDULE	
Oct. 14th, 2021	Proposal Drawing
Nov. 29th, 2021	Revisions



CUSTOM HOME FOR:
MITCHELLE RESIDENCE
COLUMBIA COUNTY, FLORIDA

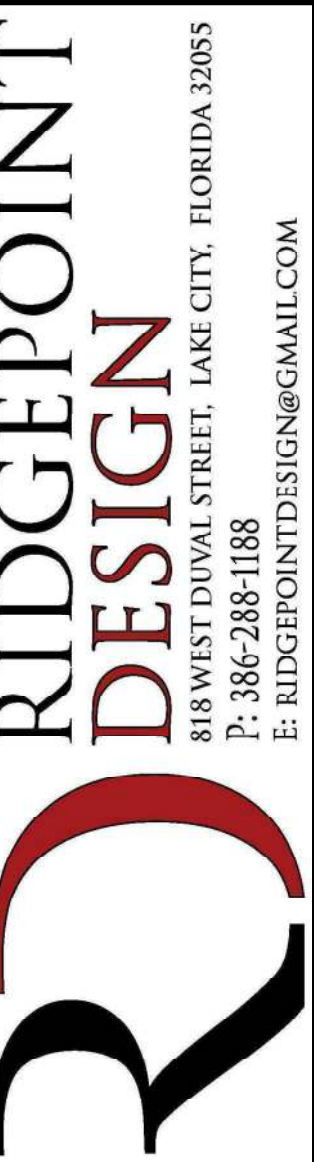

SHEET NUMBER
A.2
OF 4 SHEETS

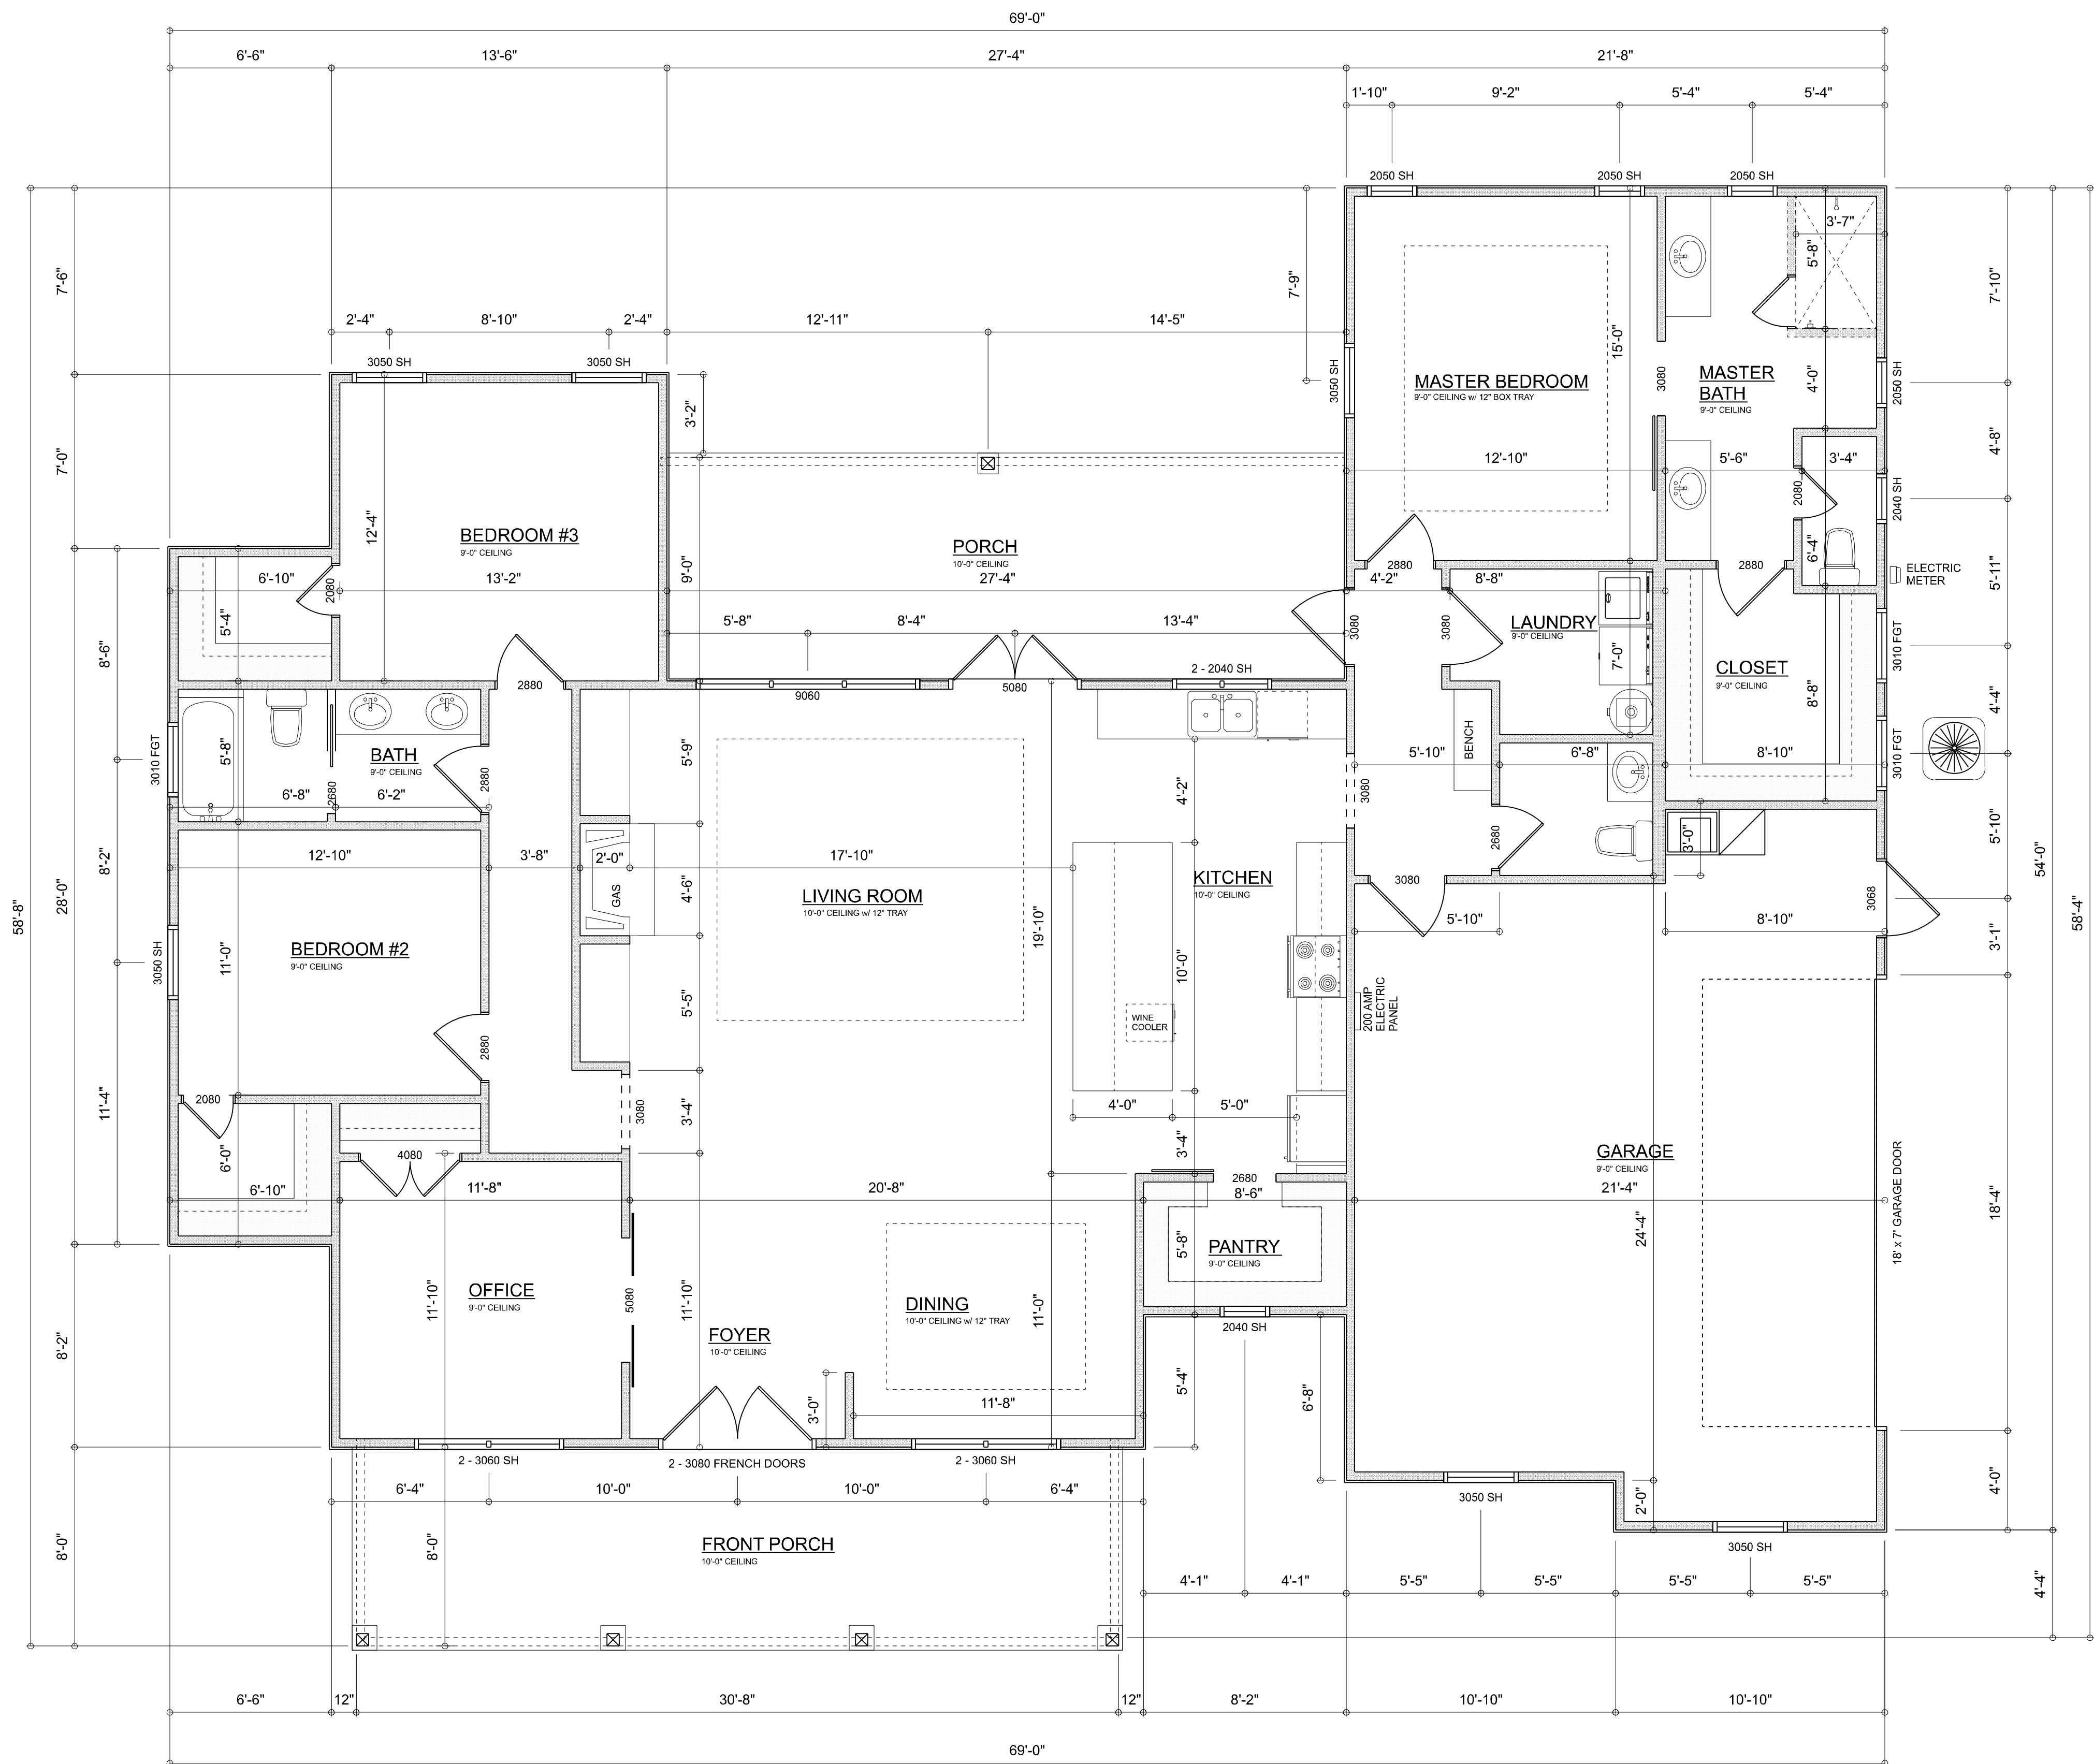

DEMENSIONED FLOOR PLAN
SCALE: 1/4" = 1'-0"

AREA SUMMARY

LIVING	2,153	S.F.
ENTRY PORCH	245	S.F.
COVERED PORCH	246	S.F.
GARAGE	566	S.F.
TOTAL AREA	3,210	S.F.

TOTAL CUBIC FOOTAGE OF CONDITIONED SPACE: 21,530

REVISIONS SCHEDULE	
Oct. 14th, 2021	Proposal Drawing
Nov. 29th, 2021	Revisions

Construction LLC
Residential • Commercial • Remodels
818 W DUVAL ST., LAKE CITY, FL 32055


 
CUSTOM HOME FOR:
MITCHELLE RESIDENCE
COLUMBIA COUNTY, FLORIDA

RIDGEPOINT
DESIGN
818 WEST DUVAL STREET, LAKE CITY, FLORIDA 32055
P: 386-288-1188
E: RIDGEPOINTDESIGN@GMAIL.COM

SHEET NUMBER

A.3

OF 4 SHEETS

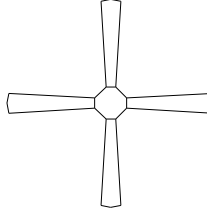ELECTRICAL LEGEND		
ELECTRICAL	COUNT	SYMBOL
CEILING FAN	6	
CAN LIGHT 6inch	16	
CHANDELIER	1	
LED CEILING LIGHT 1x4	2	
PENDANT LIGHT	2	
EXTERIOR SCONCE	2	
MOTION SECURITY LIGHT	4	
ELECTRIC METER	1	
CABLE TV OUTLET	5	
EXHAUST FAN	2	
OUTLET	42	
OUTLET 220v	5	
OUTLET GFI	15	
OUTLET WP	4	
SMOKE DETECTOR	4	
STANDARD LIGHT	13	
SWITCH	26	
SWITCH 3 WAY	16	
VANITY BAR LIGHT - SMALL	3	
AC DISCONNECT	1	
floor receptacle GFI duplex	2	

ELECTRICAL PLAN NOTES:

INSTALLATION SHALL BE PER LATEST NAT'L ELECTRIC CODE.

WIRE ALL APPLIANCES, HVAC UNITS AND OTHER EQUIPMENT PER MANUF. SPECIFICATIONS

CONSULT WITH THE OWNER FOR THE NUMBER OF SEPERATE TELEPHONE LINES TO BE INSTALLED

ALL SMOKE DETECTORS SHALL BE 120v W/ BATTERY BACKUP OF THE PHOTOELECTRIC TYPE, AND SHALL BE INTERLOCKED TOGETHER. INSTALL INSIDE AND NEAR ALL BEDROOMS


TELEPHONE, TELEVISION AND OTHER LOW VOLTAGE DEVICES OR OUTLETS SHALL BE AS PER THE OWNER'S DIRECTIONS, & IN ACCORDANCE W/ APPLICABLE SECTIONS OF NEC-LATEST EDITION.

ALL RECEPTICALS, NOT OTHERWISE NOTED, SHALL BE ARC FAULT INTERRUPTER TYPE, EXCEPT DEDICATED OUTLETS

ALL RECEPTICALS IN WET AREAS SHALL BE GROUND FAULT INTERRUPTER TYPE (GFI)

ALL EXTERIOR RECEPTICALS SHALL BE WEATHERPROOF GROUD FAULT INTERRUPTER TYPE (WP/GFI)

NOTE:
ELECTRICAL CONTR'R SHALL PREPARE "AS-BUILT" SHOP DWGS INDICATING ALL ELECTRICAL WORK, INCLUDING ANY CHANGES TO THE ELEC. PLAN, ADD'NS TO THE ELEC. PLAN, RISER DIAGRAM, AS-BUILT PANEL SCHEDULE W/ ALL CKTS IDENTIFIED W/ CKT N°. DESCRIPTION & BRKR, SERVICE ENT. & ALL UNDERGROUND WIRE LOCATIONS/ROUTING / DEPTH. RISER DIA. SHALL INCLUDE WIRE SIZES/TYPE & EQUIPMENT TYPE W/ RATINGS & LOADS.
CONTRACTOR SHALL PROVIDE 1 COPY OF AS-BUILT DWGS TO OWNER & 1 COPY TO THE PERMIT ISSUING AUTHORITY

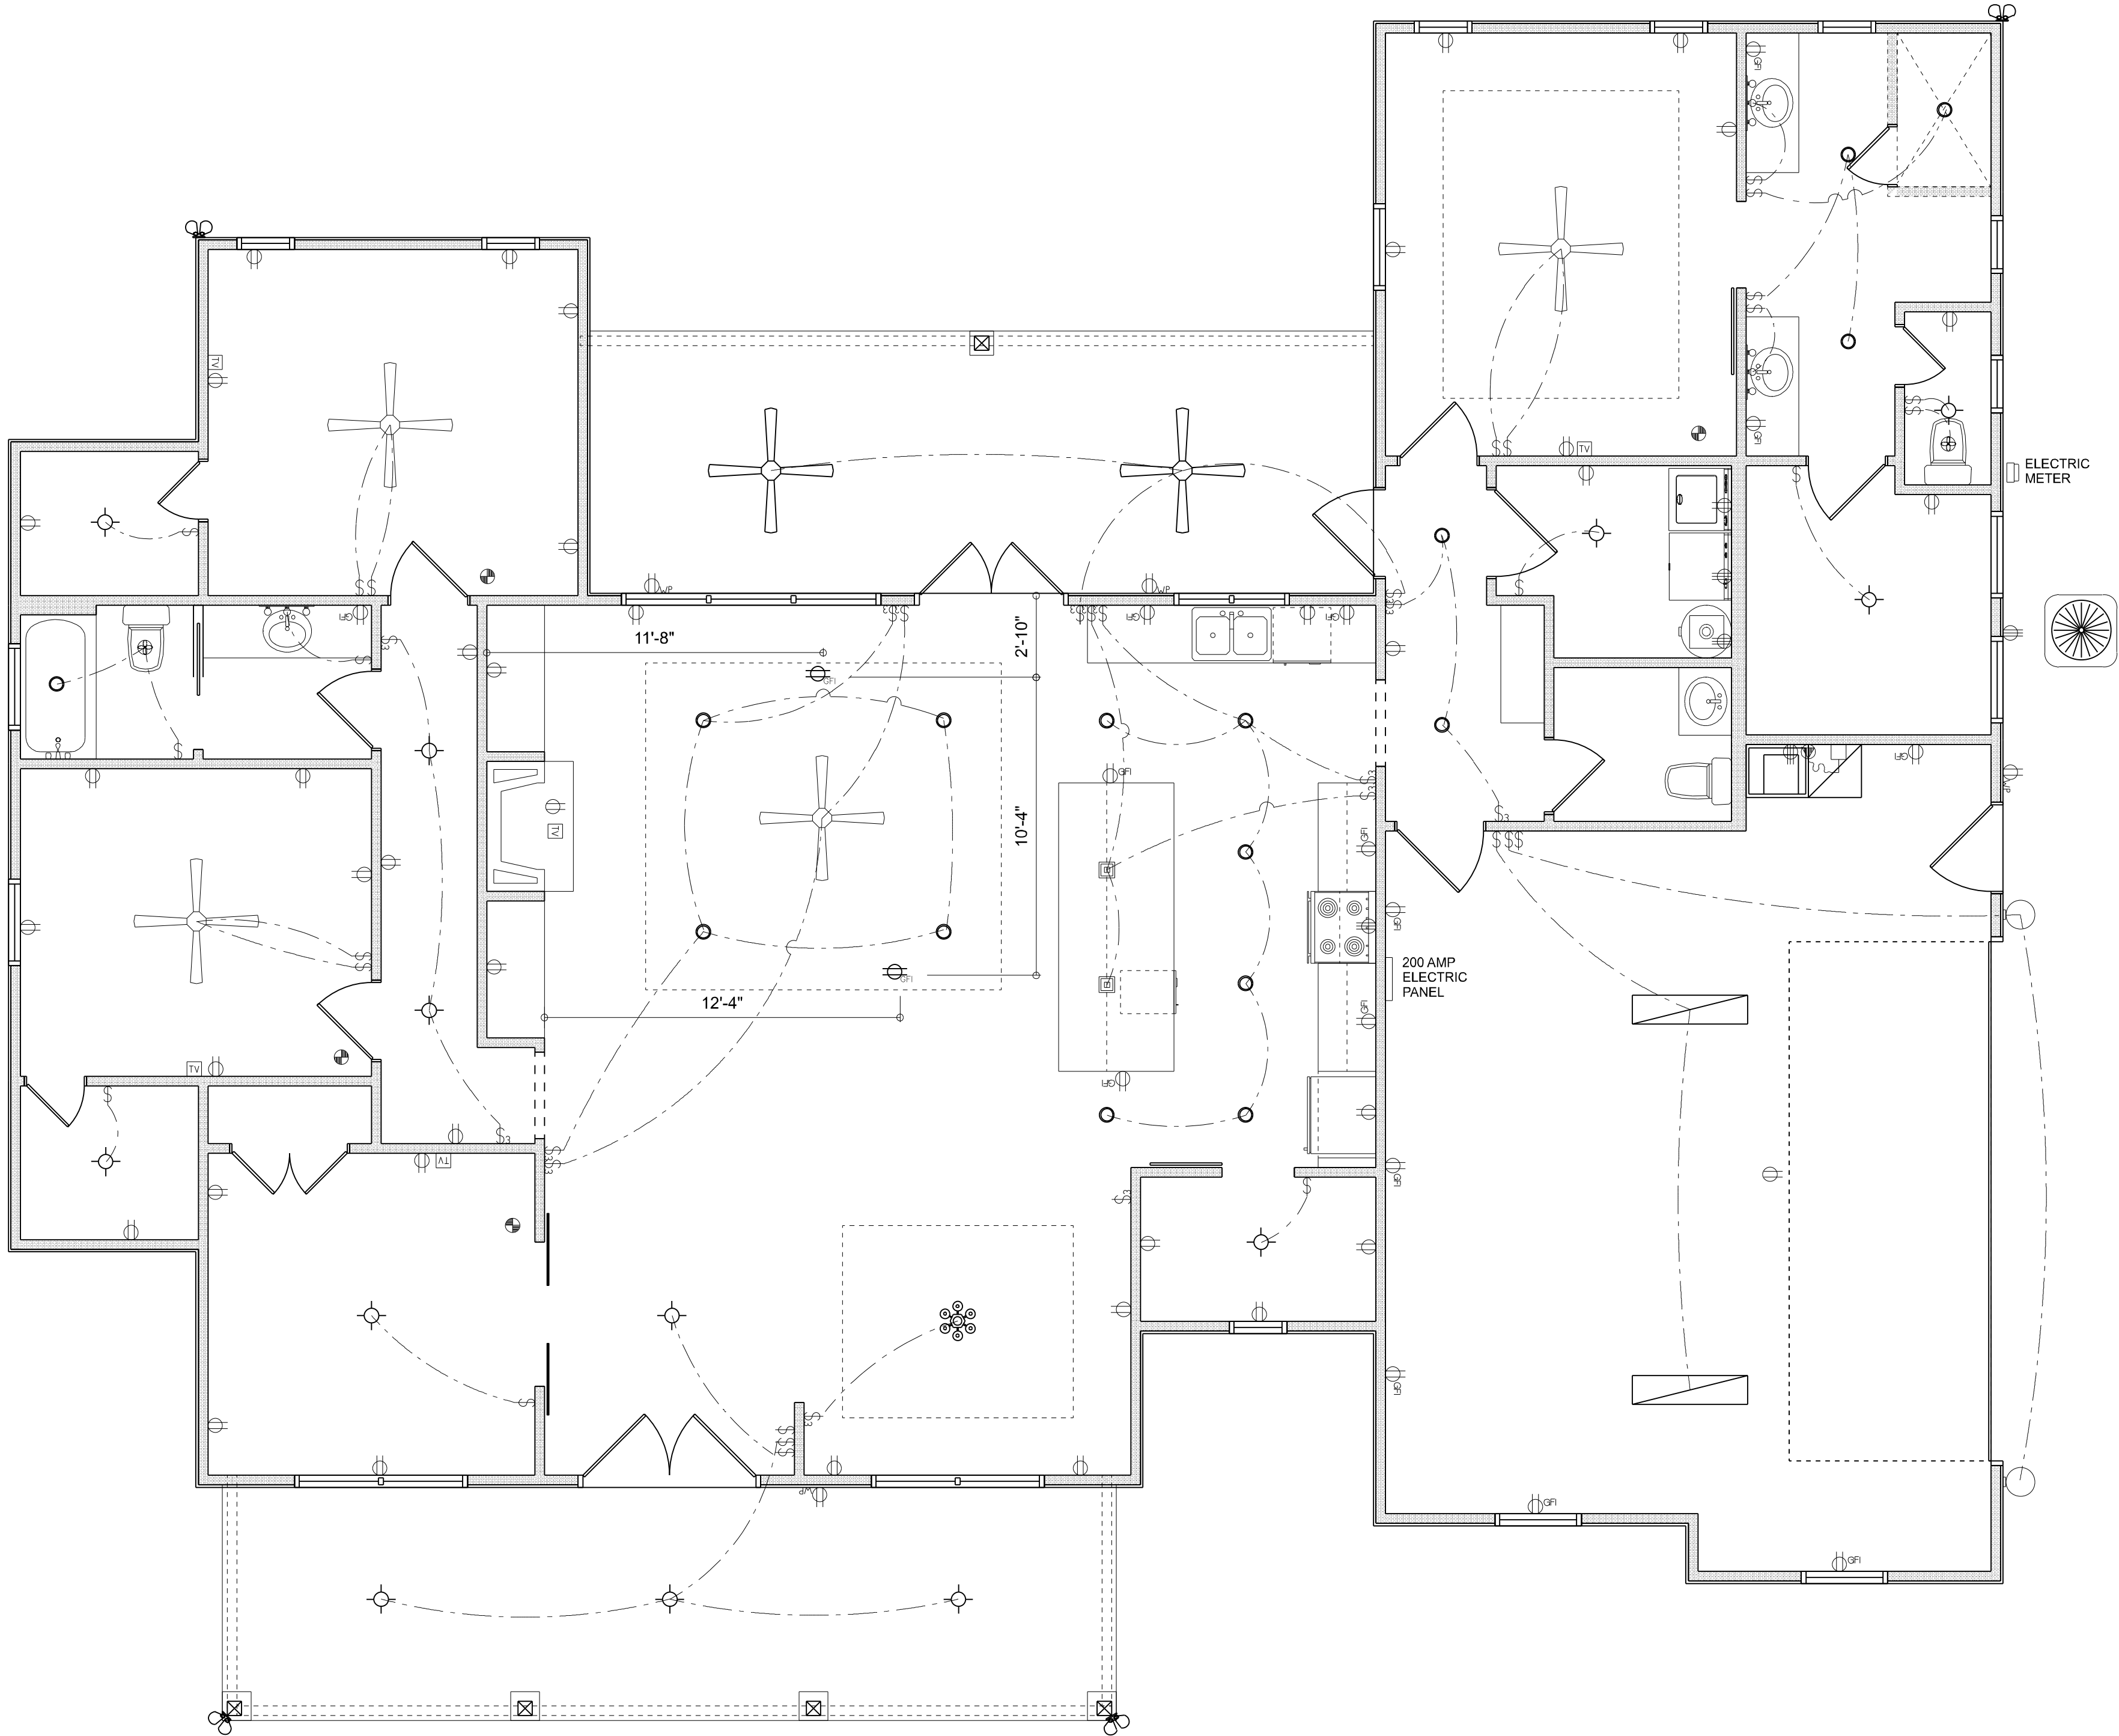


REVISIONS SCHEDULE	
Oct. 14th, 2021	Proposal Drawing
Nov. 29th, 2021	Revisions



Construction LLC
Residential • Commercial • Remodels
818 W DUVAL ST, LAKE CITY, FL 32055

CUSTOM HOME FOR:
MITCHELLE RESIDENCE
COLUMBIA COUNTY, FLORIDA

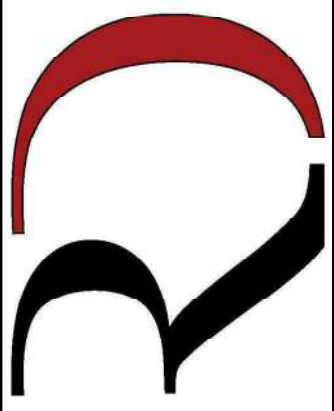

**RIDGEPOINT
DESIGN**
818 WEST DUVAL STREET, LAKE CITY, FLORIDA 32055
P: 386-288-1188
E: RIDGEPOINTDESIGN@GMAIL.COM

SHEET NUMBER
A.4
OF 4 SHEETS