



RIGHT ELEVATION
SCALE: 1/4" = 1'-0"




LEFT ELEVATION
SCALE: 1/4" = 1'-0"



FRONT ELEVATION
SCALE: 1/4" = 1'-0"



REAR ELEVATION
SCALE: 1/4" = 1'-0"

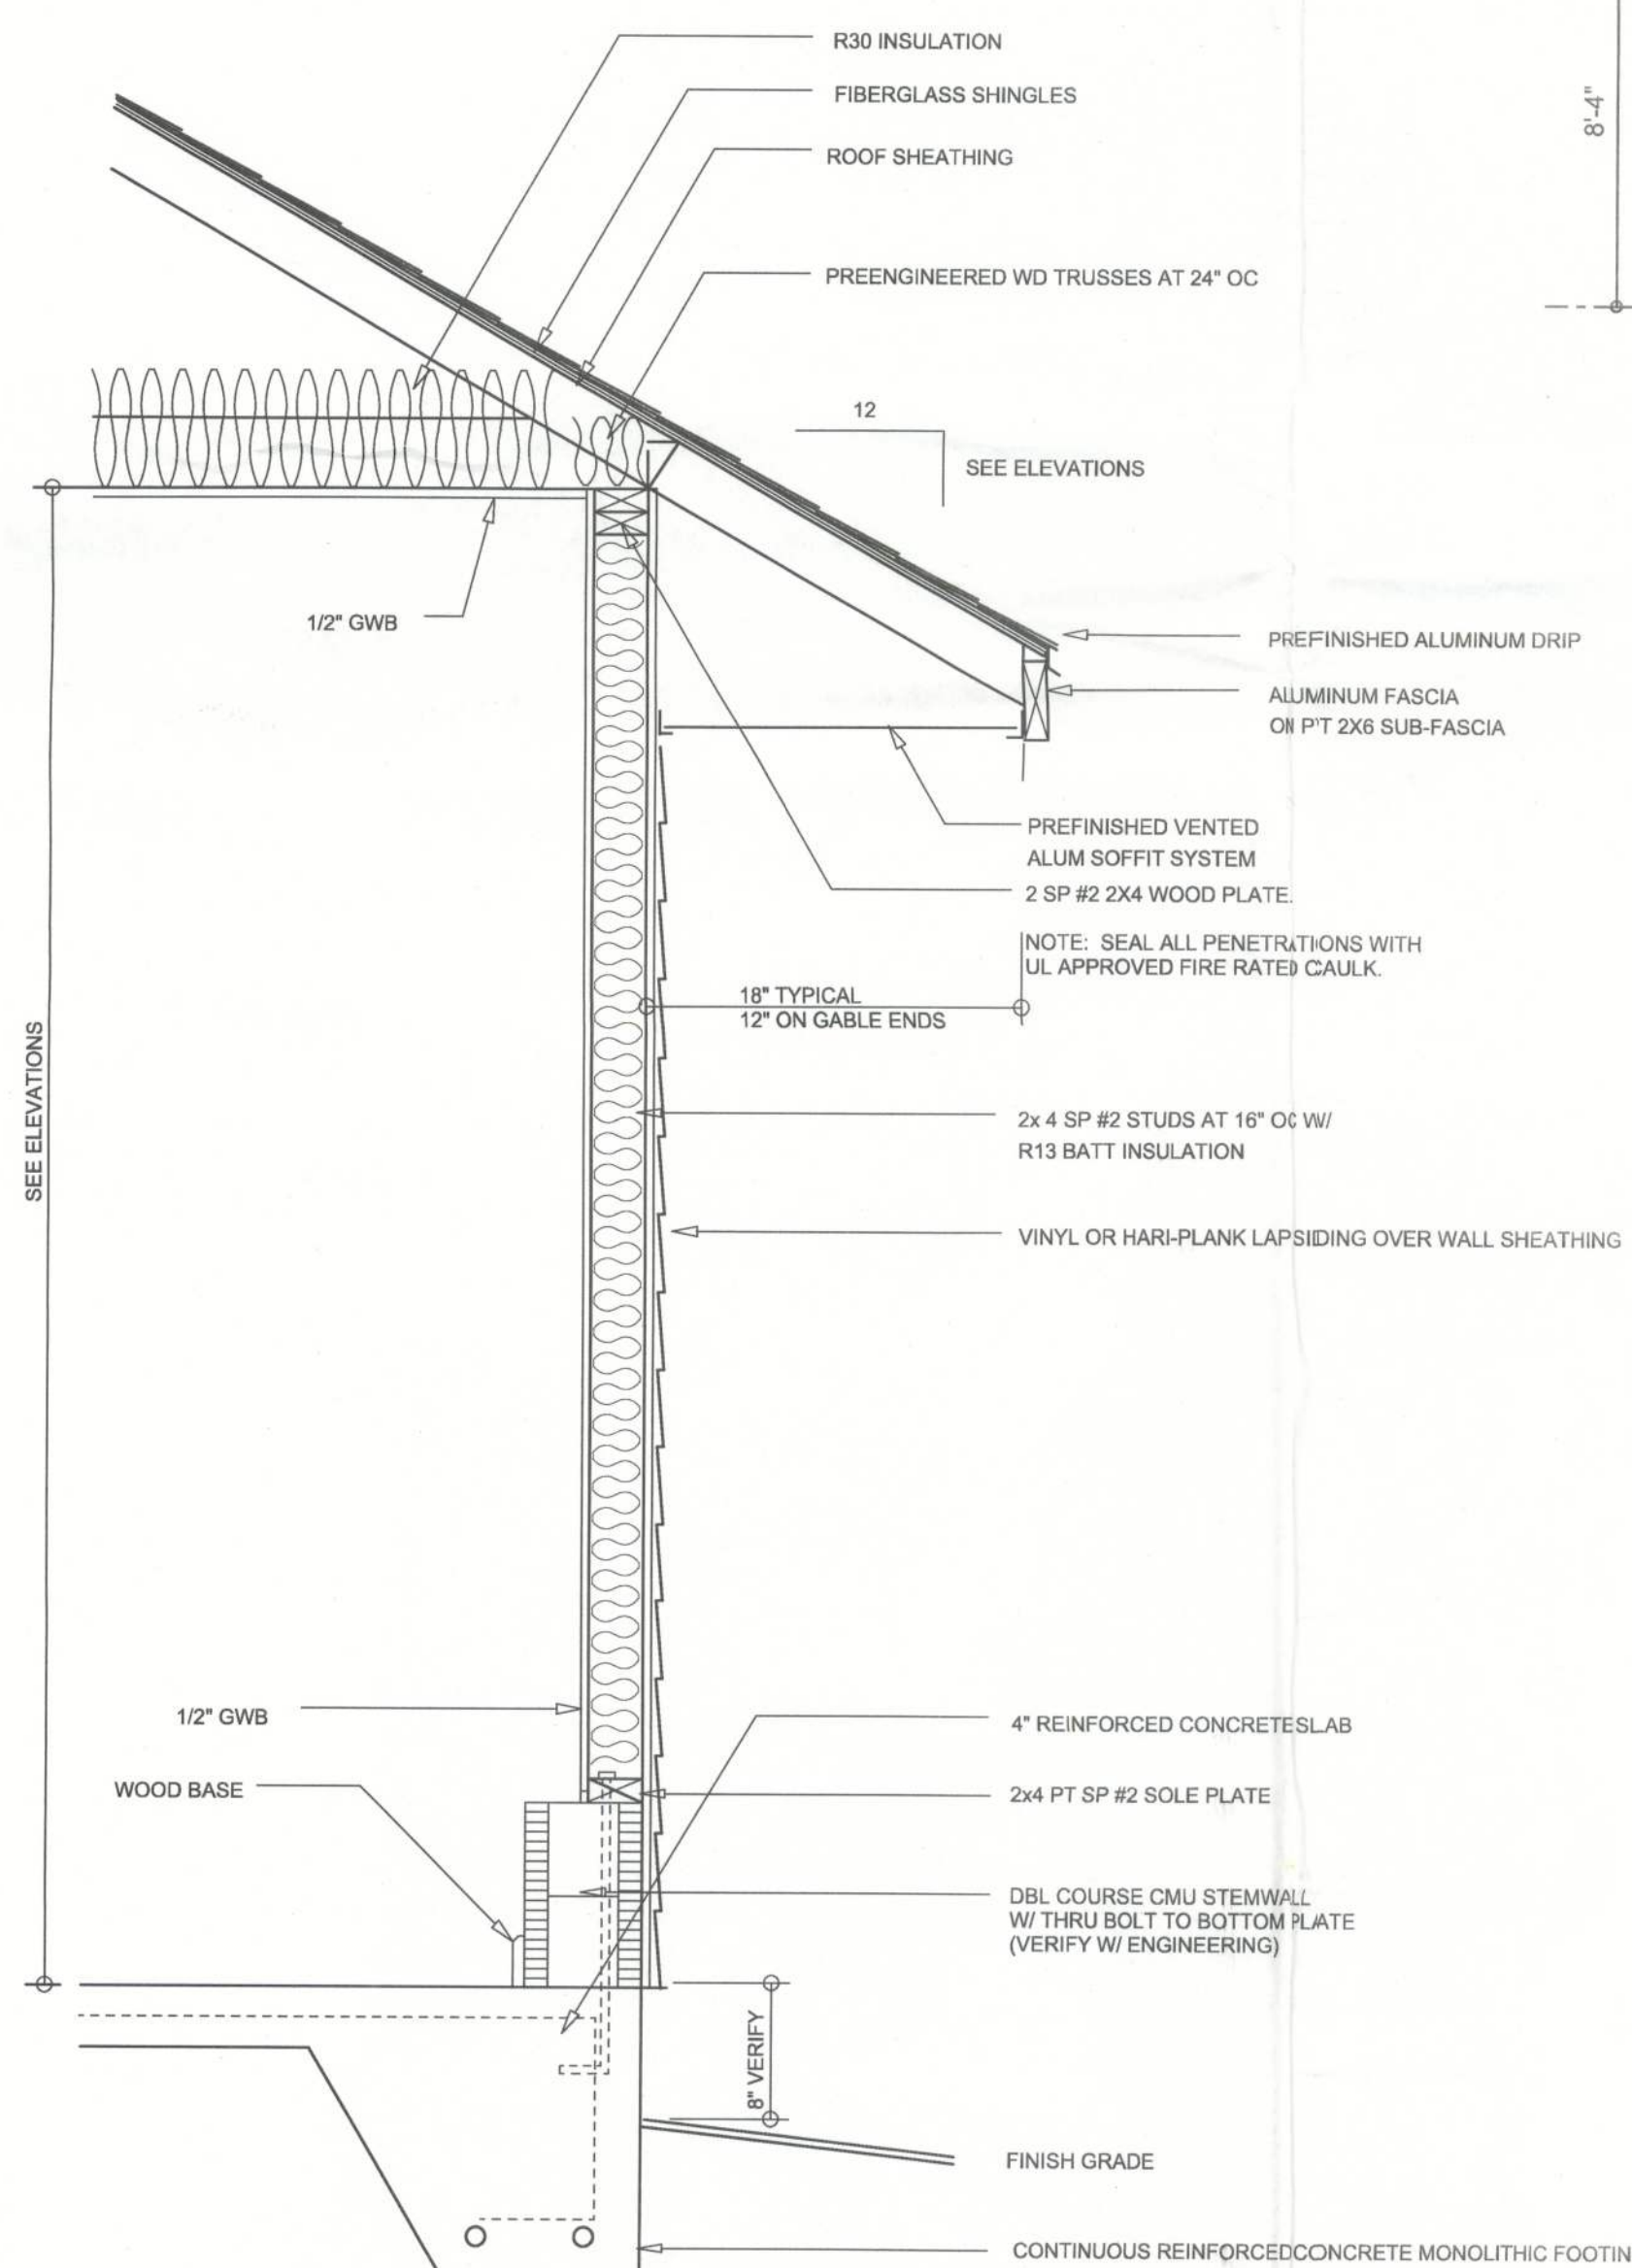


TYPICAL WALL SECTION
SCALE: 1" = 1'-0"

ELECTRICAL LEGEND	
	CEILING FAN (PRE-WIRE FOR LIGHT KIT)
	DOUBLE SECURITY LIGHT
	RECESSED CAN LIGHT
	BATH EXHAUST FAN
	LIGHT FIXTURE
	DUPLEX OUTLET
	220v OUTLET
	GFI DUPLEX OUTLET
	SMOKE DETECTOR (see note below)
	C.M.D. CARBON MONOXIDE DETECTOR
	WALL SWITCH
	3 WAY WALL SWITCH
	WATER PROOF GFI OUTLET
	2 OR 4 TUB FLUORESCENT FIXTURE

NOTE:
ALL BEDROOM RECEPTACLES SHALL BE AFCI
(ARC FAULT CIRCUIT INTERRUPT)

ALL SMOKE DETECTORS SHALL HAVE BATTERY BACKUP POWER
AND ALL WIRED TOGETHER SO IF ANY ONE UNIT IS ACTUATED THEY
ALL ACTIVATE.

NOTE!
UFER grounding required per N.E.C.
Arc fault breakers required per N.E.C.
GFCI breakers required per N.E.C.
Tamper resistant receptacles required per N.E.C.

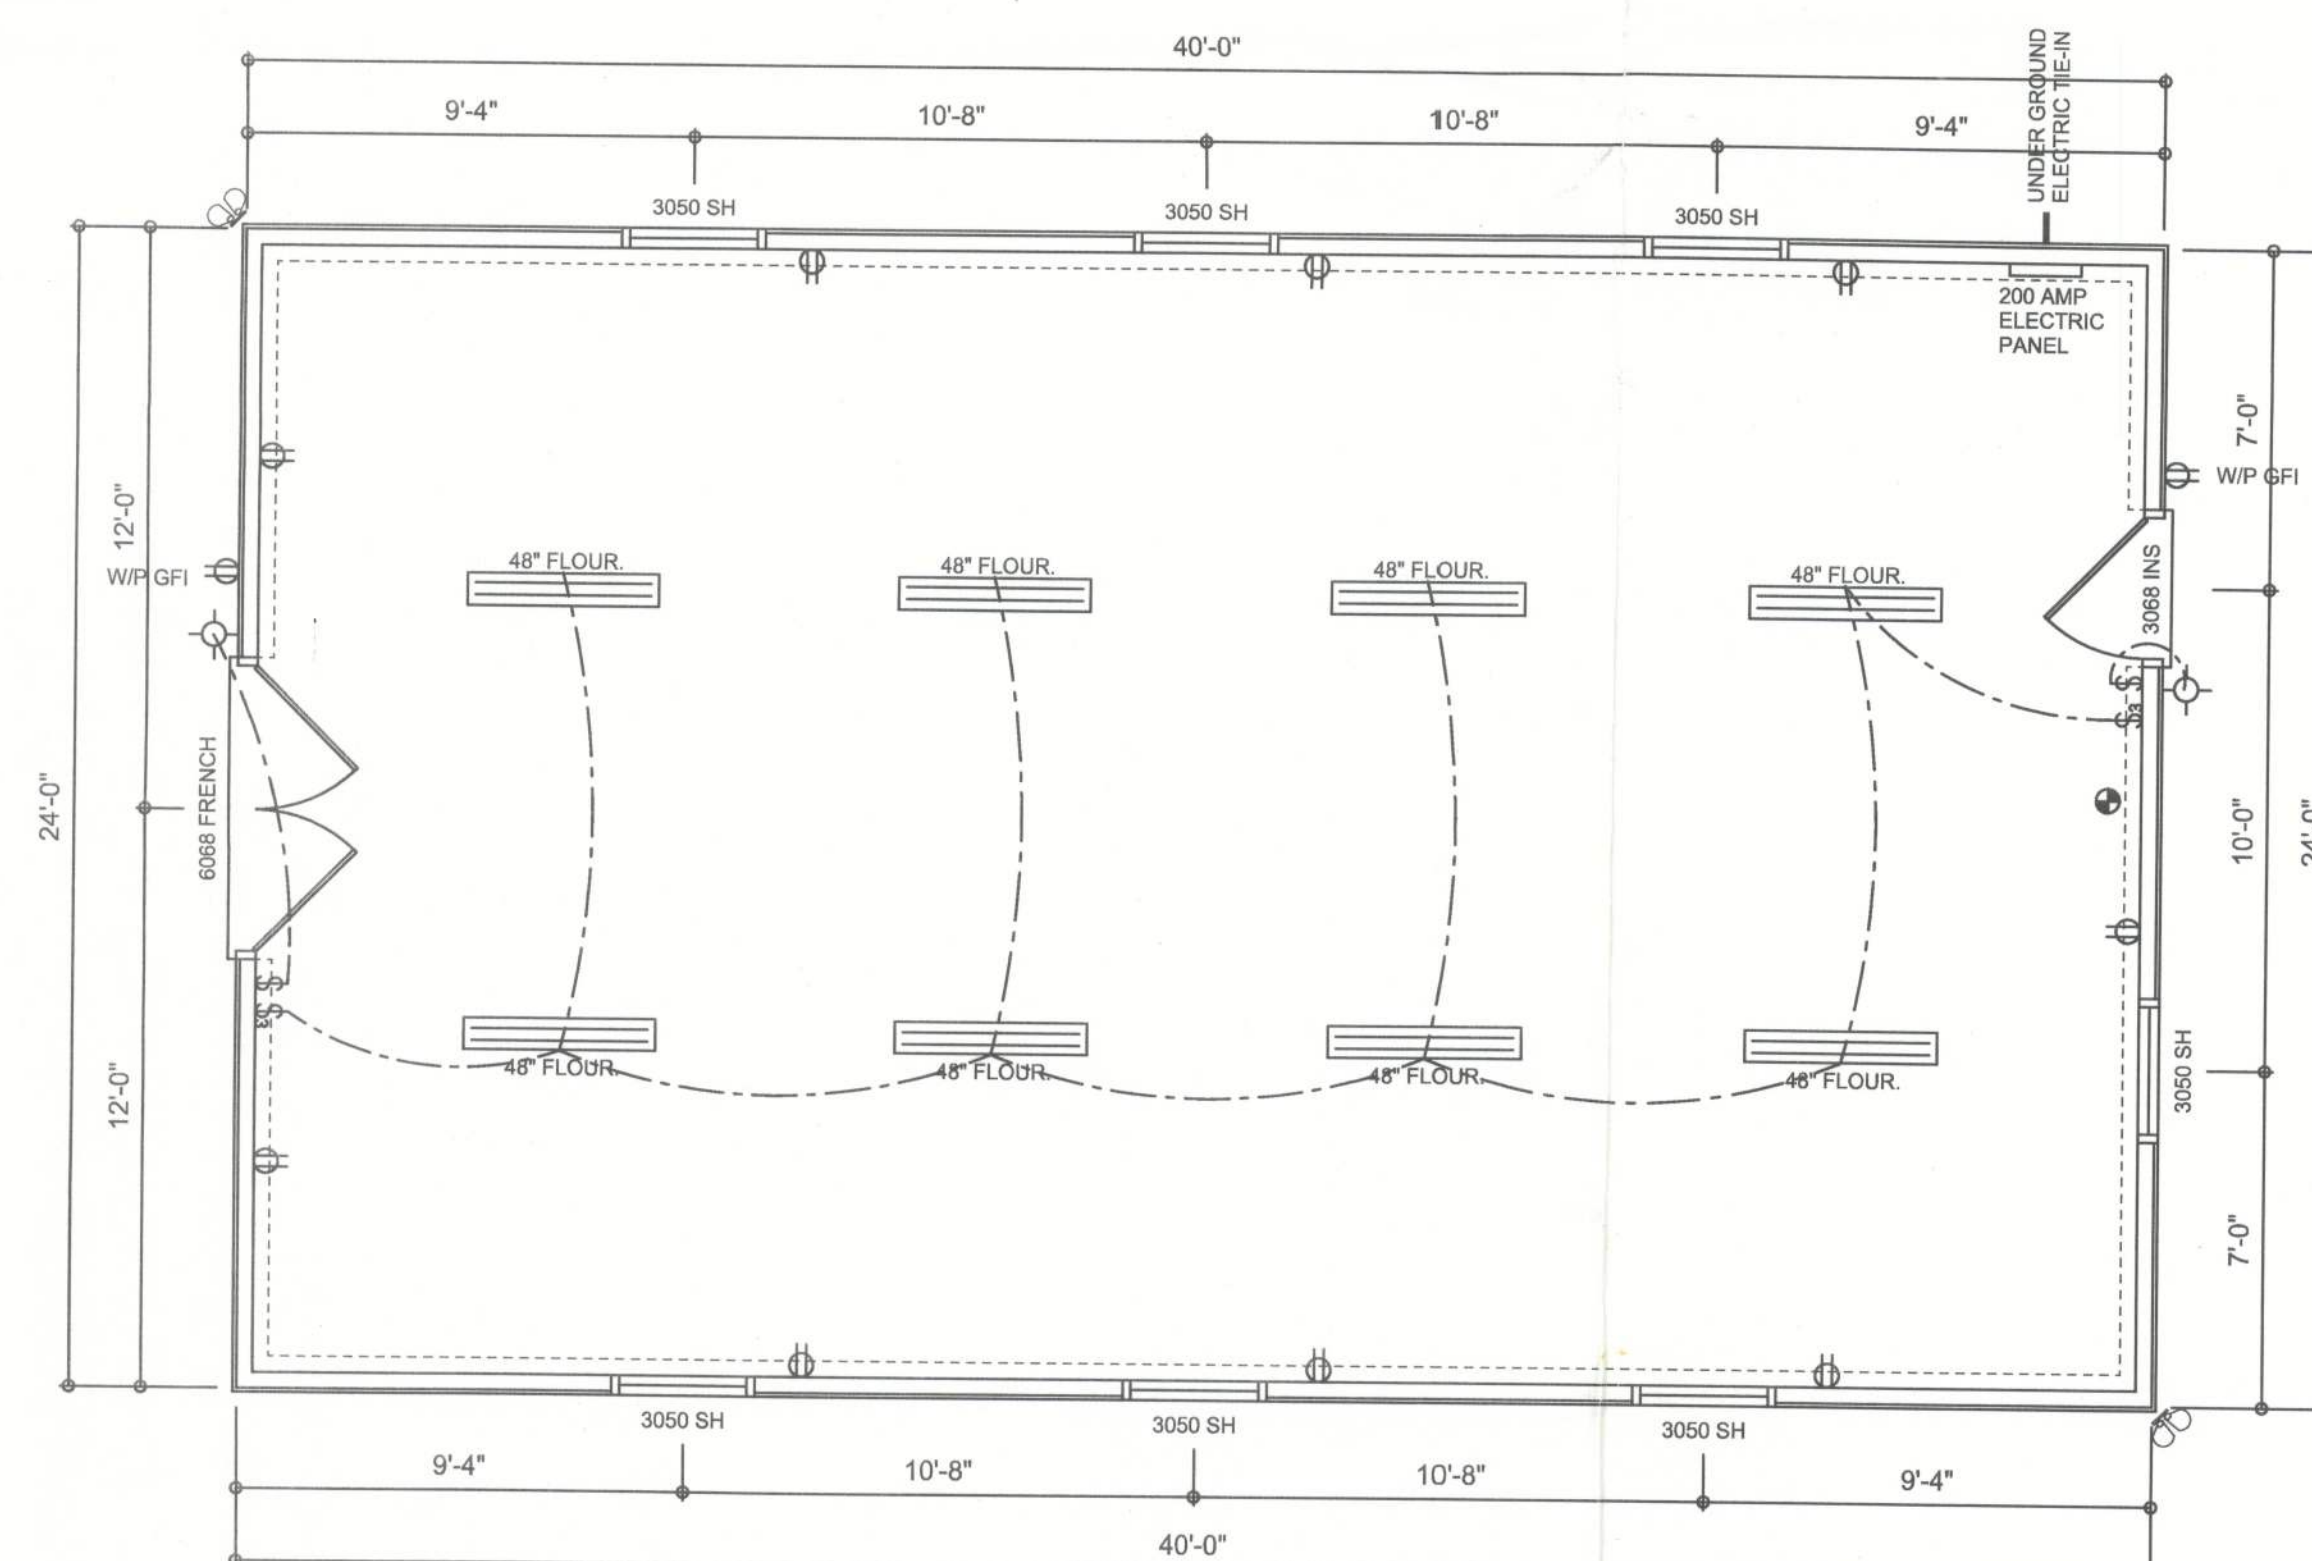

DIMENSIONED FLOOR PLAN
SCALE: 1/4" = 1'-0"

AREA SUMMARY

TOTAL AREA 960 S.F.

REVISIONS SCHEDULE	

A CUSTOM DESIGN FOR:
WEAVER RESIDENCE

JONATHAN MORRIS
DRAFTING SERVICES
283 SW 8TH AVE
LAKE CITY, FLORIDA
(386) 288 - 1188
jmorris99@aol.net

SHEET NAME
P.1
OF 1 SHEETS



29930